


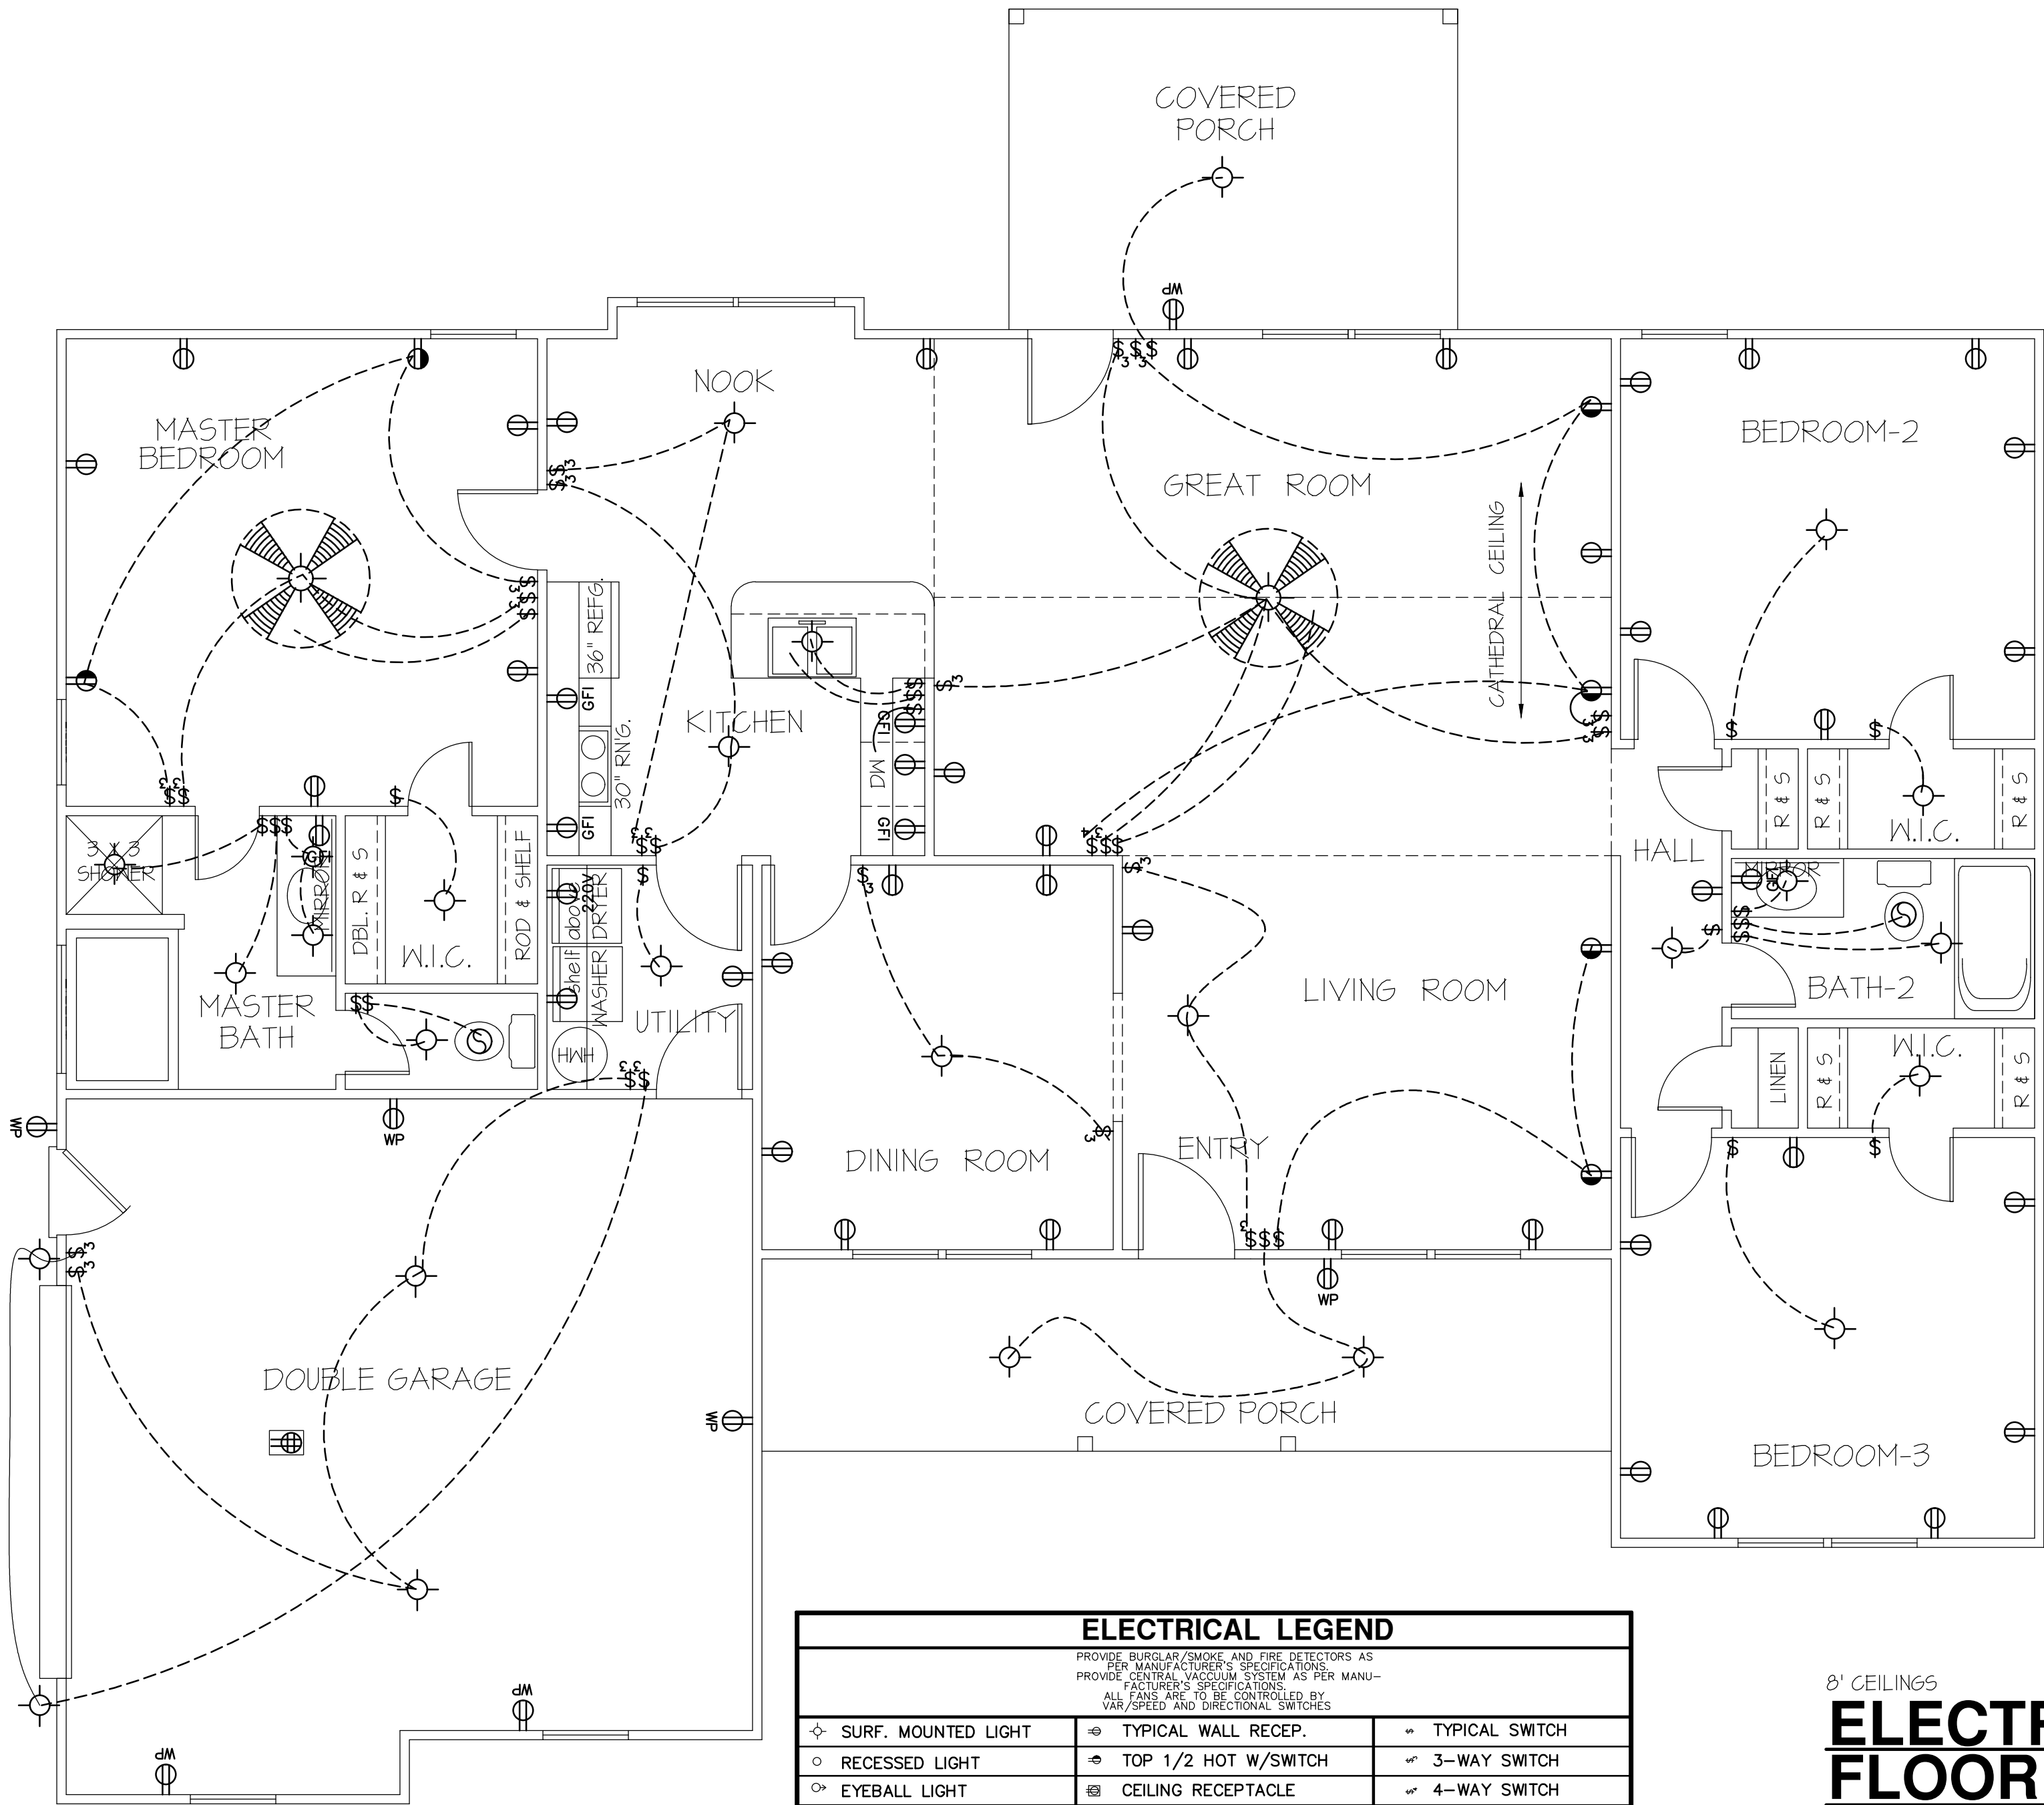


| ELECTRICAL LEGEND                                                                                                                                                                                                            |                        |                     |
|------------------------------------------------------------------------------------------------------------------------------------------------------------------------------------------------------------------------------|------------------------|---------------------|
| PROVIDE BURGLAR/SMOKE AND FIRE DETECTORS AS PER MANUFACTURER'S SPECIFICATIONS.<br>PROVIDE CENTRAL VACUUM SYSTEM AS PER MANUFACTURER'S SPECIFICATIONS.<br>ALL FANS ARE TO BE CONTROLLED BY VAR/SPEED AND DIRECTIONAL SWITCHES |                        |                     |
| ⬡ SURF. MOUNTED LIGHT                                                                                                                                                                                                        | ⬢ TYPICAL WALL RECEP.  | ⬢ TYPICAL SWITCH    |
| ○ RECESSED LIGHT                                                                                                                                                                                                             | ⬢ TOP 1/2 HOT W/SWITCH | ⬢ 3-WAY SWITCH      |
| ⬢ EYEBALL LIGHT                                                                                                                                                                                                              | ⬢ CEILING RECEPTACLE   | ⬢ 4-WAY SWITCH      |
| ⬢ FAN/LIGHT COMB.                                                                                                                                                                                                            | ○ FLOOR RECEPTACLE     | ⬢ DIMMER SWITCH     |
| — FLUORESCENT TUBE                                                                                                                                                                                                           | ⬢ WATERPROOF RECEP.    | ⬢ ELEC. PANEL BOX   |
| □ FLUOR. LIGHT FIXTURE                                                                                                                                                                                                       | ⬢ GROUND FAULT         | ⬢ T.V. CABLE RECEP. |
| ⬢ EXHAUST FAN                                                                                                                                                                                                                | ⬢ DISPOSAL UNIT        | ⬢ TELEPHONE JACK    |
| ⬢ CL'G. FAN                                                                                                                                                                                                                  | ⬢ 220 VOLT RECEPTACLE  | ⬢ COMPUTER JACK     |
| ⬢ FLOOD LIGHT                                                                                                                                                                                                                |                        |                     |

8' CEILINGS  
**ELECTRICAL FLOOR PLAN**  
SCALE: 1/4"=1'-0"  
TOTAL FLOOR = 1819 SQUARE FEET ( HEATED - FRAME )  
159 SQUARE FEET ( FRONT PORCH )  
140 SQUARE FEET ( REAR PORCH )  
461 SQUARE FEET ( DOUBLE GARAGE )

DATE:  
JAN. 8, 2025

**FREEDOM FAMILY HOMES**  
P.O. BOX 608  
DUNN, N.C. - 28335  
O: (910) 892-1231 FAX: (910) 892-5680  
© 2025, FREEDOM FAMILY HOMES

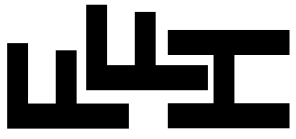

EXCLUSIVE PLAN FOR  
**FREEDOM FAMILY HOMES**  
**Mary Green & Edward Green**  
**BURLINGTON**

PLAN:

SHEET NO.

4