



AXONOMETRIC VIEW



SYMBOLS LEGEND

	SECTION MARKER		SOIL
	ELEVATION MARKER		CONCRETE
	INTERIOR ELEVATIONS		BRICK
	DETAIL CALLOUT		CMU BLOCK
	DATUM MARKER		RIGID INSULATION
	SLOPE MARKER		BATT INSULATION
	COMPASS (TRUE NORTH)		DIMENSIONAL LUMBER
	WINDOW CALLOUT		ELECTRIC OUTLET
	DOOR CALLOUT		SWITCH
			CEILING LIGHT
			RECESSED LIGHT
			WALL-MOUNTED LIGHT
			CEILING FAN

SHEET INDEX

- A-000 COVER PAGE
- A-001 GROUND FLOOR PLAN
- A-002 SECOND FLOOR PLAN
- A-003 ELEVATIONS
- A-004 ELEVATIONS
- B-101 FOUNDATION PLAN I
- B-102 FOUNDATION PLAN OPT II
- B-103 FOUNDATION PLAN OPT III
- B-104 DETAILED GROUND FLOOR PLAN
- B-105 DETAILED SECOND FLOOR PLAN
- B-106 DETAILED ELEVATIONS
- B-107 DETAILED ELEVATIONS
- B-108 ELECTRICAL PLANS
- B-109 ROOF PLAN
- B-110 ROOF FRAMING PLAN
- B-111 SECTION DETAIL
- B-112 DETAILS
- B-113 DETAILS
- C-101 DOOR SCHEDULE
- C-102 WINDOW SCHEDULE

LICENSE & DISCLAIMER

1. THE WORK INCLUDED WITHIN THESE DRAWINGS DOES NOT REPRESENT A LEGAL CONTRACT; NOR DOES IT CONSTITUTE ARCHITECTURAL SERVICES. NO PERSON OR ORGANIZATION MAKES ANY WARRANTY, EXPRESS OR IMPLIED, REGARDING THE INFORMATION PROVIDED. THE CRATORS DISCLAIM LIABILITY FOR ANY DAMAGES THAT MAY RESULT FROM THE USE OF THESE DRAWINGS.

2. THIS PLAN HAS BEEN PREPARED TO MEET PROFESSIONAL STANDARDS AND PRACTICES. HOWEVER, BUILDING CODE REQUIREMENTS VARY WITH LOCATION AND CHANGE FROM TIME TO TIME. BEFORE STARTING CONSTRUCTION THE CONTRACTOR MUST REVIEW AND BE RESPONSIBLE FOR ALL DIMENSIONS AND OTHER DETAILS AND SHOULD REVIEW PLANS TO INSURE THEY MEET CURRENT REQUIREMENTS. THE CONTRACTOR ASSUMES FULL RESPONSIBILITY TO VERIFY THE CONDITIONS, DIMENSIONS, AND STRUCTURAL DETAILS OF THE BUILDING, AND ASSUMES FULL LIABILITY FOR ANY PROBLEMS THAT MAY ARISE DUE TO POSSIBLE ERRORS ON THESE PLANS. ALL FEDERAL, STATE AND LOCAL CODES, ORDINANCES, REGULATIONS, ETC., SHALL BE CONSIDERED AS PART OF SPECIFICATIONS FOR THIS BUILDING AND SHALL TAKE PRECEDENCE OVER ANYTHING SHOWN, DESCRIBED OR IMPLIED WHERE SAME ARE AT VARIANCE. USE OF THESE PLANS CONSTITUTES COMPLIANCE WITH THE ABOVE TERMS.

3. THESE PLANS ARE OWNED AND COPYRIGHTED BY BUILDBLUEPRINT AND ARE INTENDED FOR PERSONAL USE ONLY. COPYING OR DISTRIBUTING WITHOUT PERMISSION IS ILLEGAL AND CAN RESULT UP TO FINES OF \$100,000 BY COURT. THESE PLANS ARE NOT INTENDED FOR COMMERCIAL USE, AND CANNOT BE DISTRIBUTED FOR CAPITAL GAINS.



THIS REVIEW IS VALID ONLY IF ALL NOTES MADE ON THIS PLAN ARE ADHERED TO.

NOTES

1. DRAWINGS SHOULD BE PRINTED ON ANSI C SIZE PAPER TO ENSURE ACCURATE SCALE PRINTING
2. CONSTRUCTION DETAILS ILLUSTRATED IN THIS SET ARE TYPICAL, CONSULT WITH YOUR BUILDER FOR DETAILS THAT MEETS YOUR LOCAL BUILDING CODE.
3. MATERIALS AND FINISHES ILLUSTRATED IN THIS SET ARE TYPICAL, AND SHOULD BE VERIFIED BY YOUR BUILDER OR DESIGNER BEFORE CONSTRUCTION.
4. THIS DRAWING SET IS NOT INTENDED FOR PERMITTING OR CONSTRUCTION. CONSULT WITH YOUR LOCAL BUILDING DEPARTMENT FOR BUILDING CODE REQUIREMENTS.

No.	Description	Date

28x24 HONEYCREEK CABIN

COVER PAGE


Project number	BB-HP0032
Date	
Drawn by	B.B
Checked by	J.L

A-000

Sheet Number	
Scale	

NOTES

1. DRAWINGS SHOULD BE PRINTED ON ANSI C SIZE PAPER TO ENSURE ACCURATE SCALE PRINTING 1/4" = 1'-0"
2. CONSTRUCTION DETAILS ILLUSTRATED IN THIS SET ARE TYPICAL, CONSULT WITH YOUR BUILDER FOR DETAILS THAT MEETS YOUR LOCAL BUILDING CODE.
3. MATERIALS AND FINISHES ILLUSTRATED IN THIS SET ARE TYPICAL, AND SHOULD BE VERIFIED BY YOUR BUILDER OR DESIGNER BEFORE CONSTRUCTION.
4. THIS DRAWING SET IS NOT INTENDED FOR PERMITTING OR CONSTRUCTION. CONSULT WITH YOUR LOCAL BUILDING DEPARTMENT FOR BUILDING CODE REQUIREMENTS.

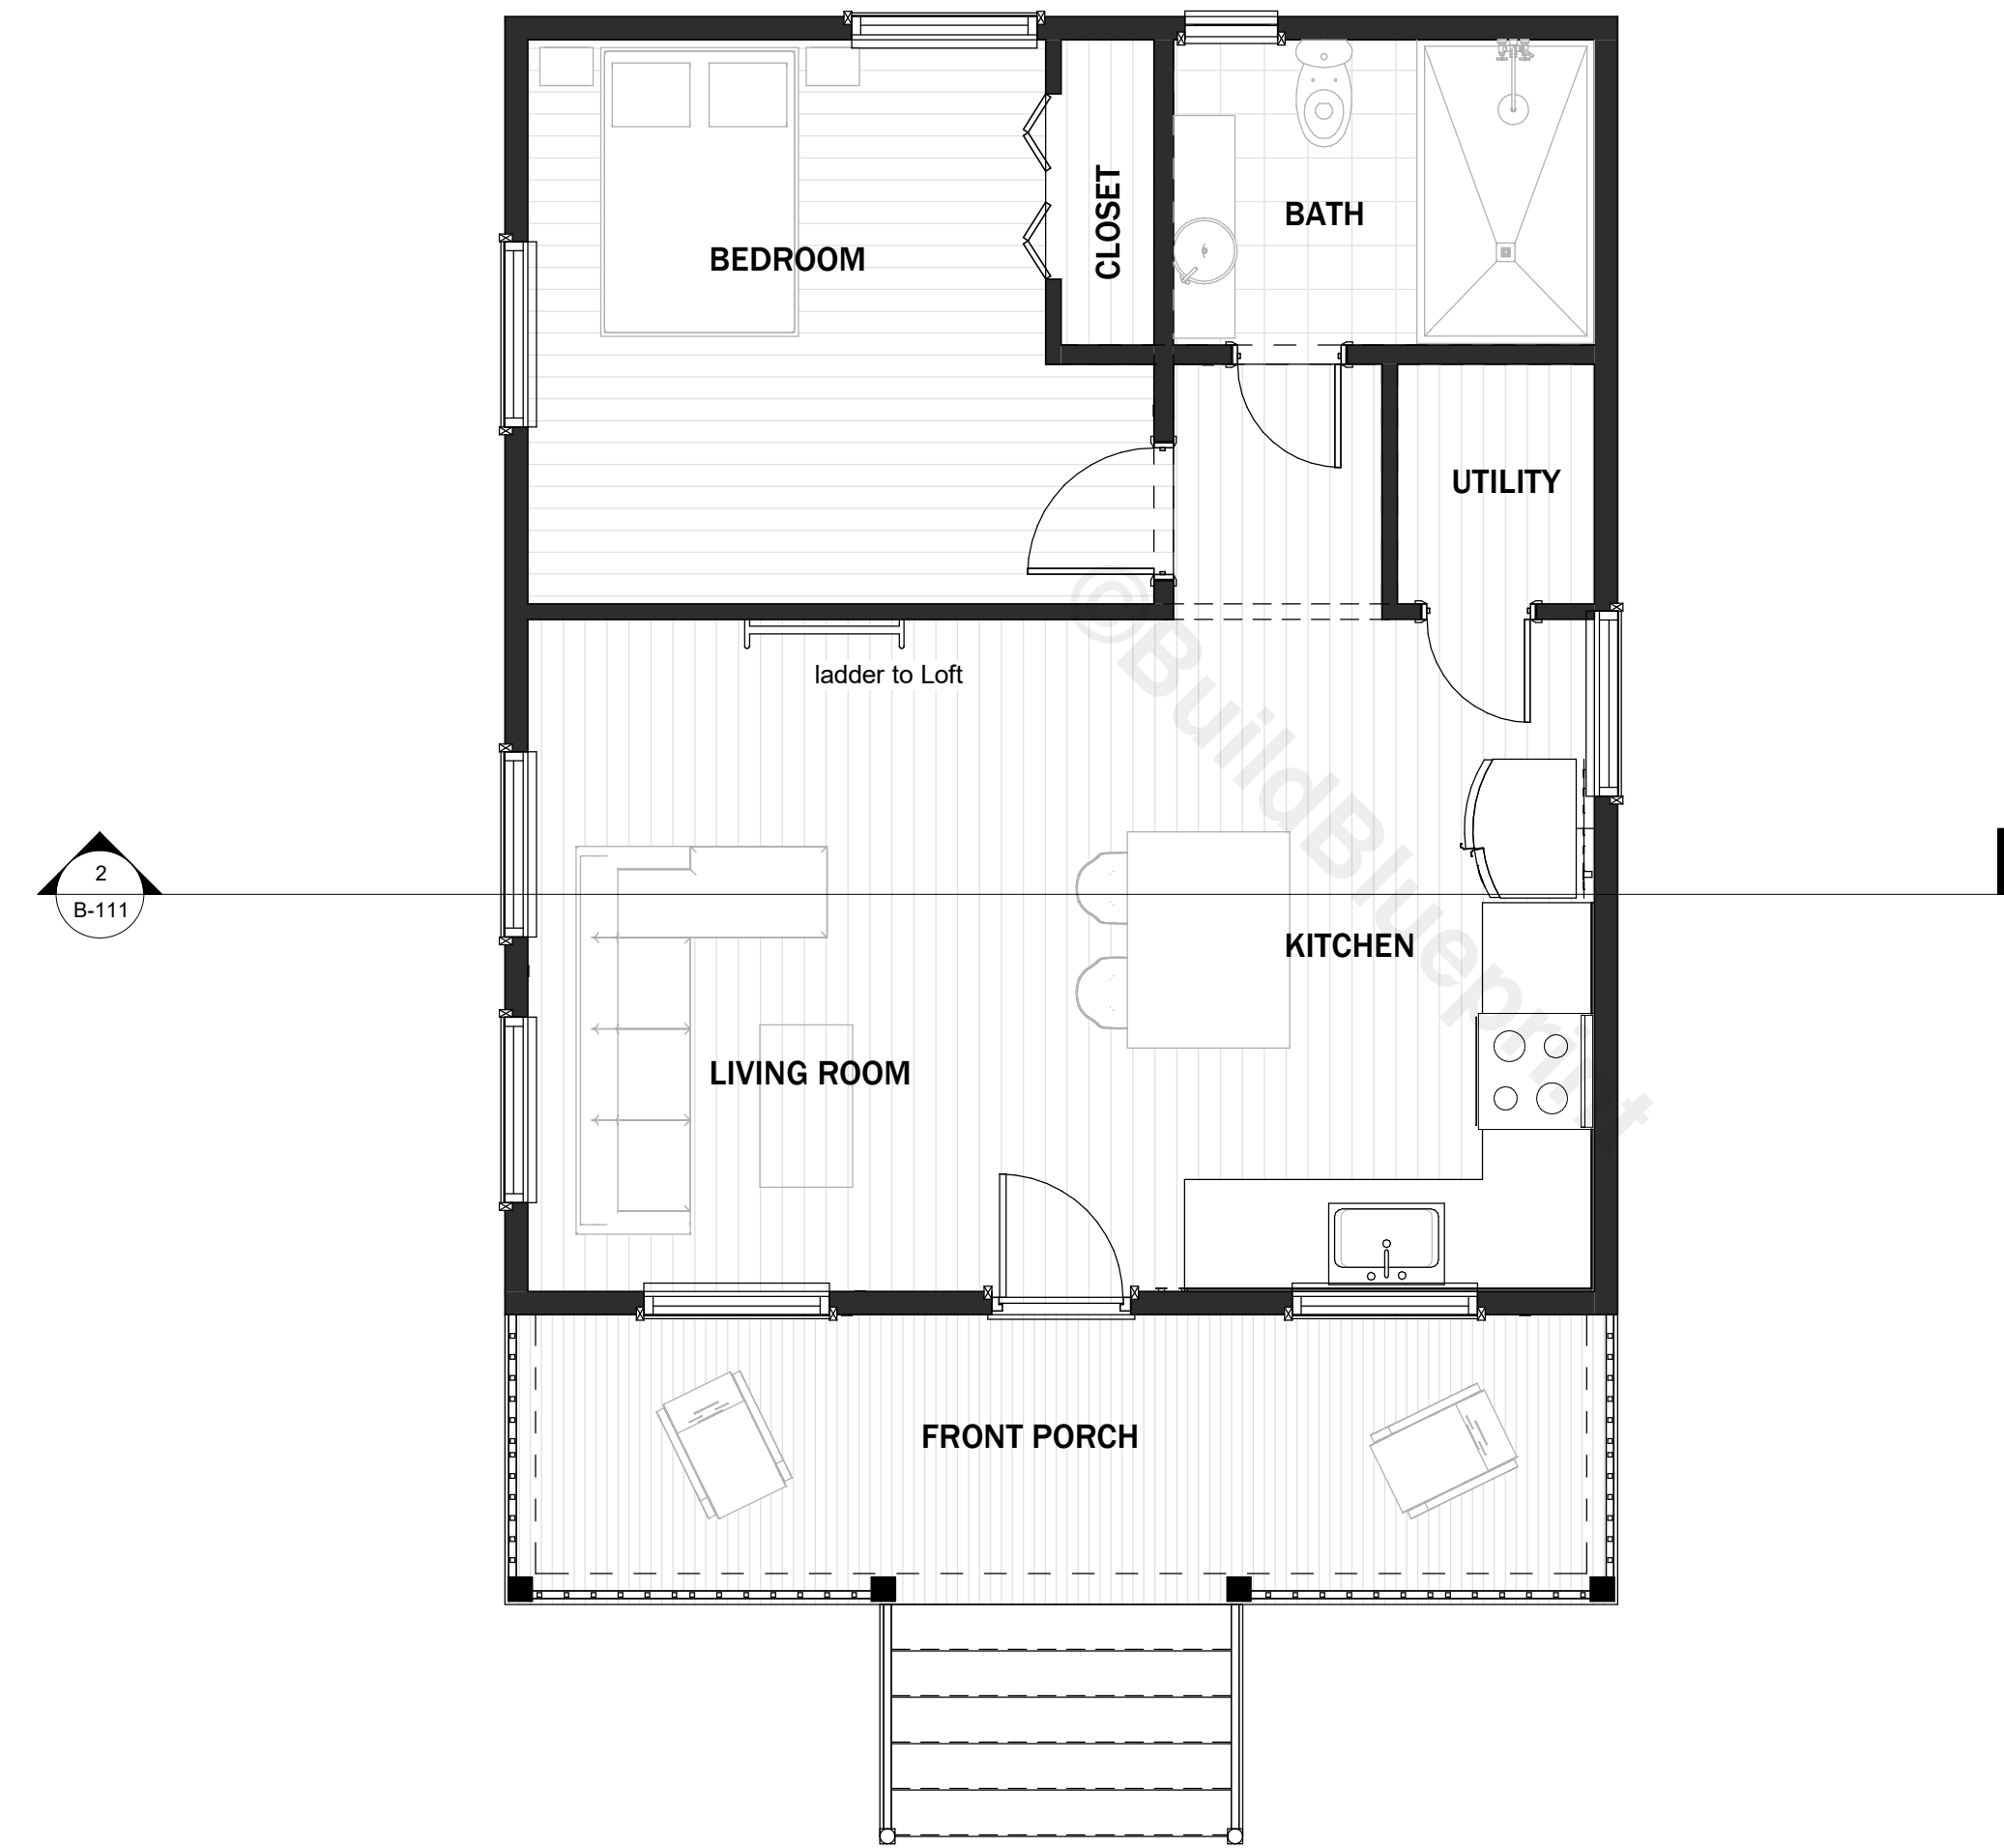

GROUND FLOOR PLAN

SCALE = 1/4" : 1' - 0"

No.	Description	Date

28x24 HONEYCREEK CABIN

GROUND FLOOR PLAN


Project number	BB-HP0032
Date	
Drawn by	B.B
Checked by	J.L

A-001

Sheet Number	
Scale	1/4" = 1'-0"

NOTES

- 1. DRAWINGS SHOULD BE PRINTED ON ANSI C SIZE PAPER TO ENSURE ACCURATE SCALE PRINTING 1/4" = 1'-0"
- 2. CONSTRUCTION DETAILS ILLUSTRATED IN THIS SET ARE TYPICAL, CONSULT WITH YOUR BUILDER FOR DETAILS THAT MEETS YOUR LOCAL BUILDING CODE.
- 3. MATERIALS AND FINISHES ILLUSTRATED IN THIS SET ARE TYPICAL, AND SHOULD BE VERIFIED BY YOUR BUILDER OR DESIGNER BEFORE CONSTRUCTION.
- 4. THIS DRAWING SET IS NOT INTENDED FOR PERMITTING OR CONSTRUCTION. CONSULT WITH YOUR LOCAL BUILDING DEPARTMENT FOR BUILDING CODE REQUIREMENTS.

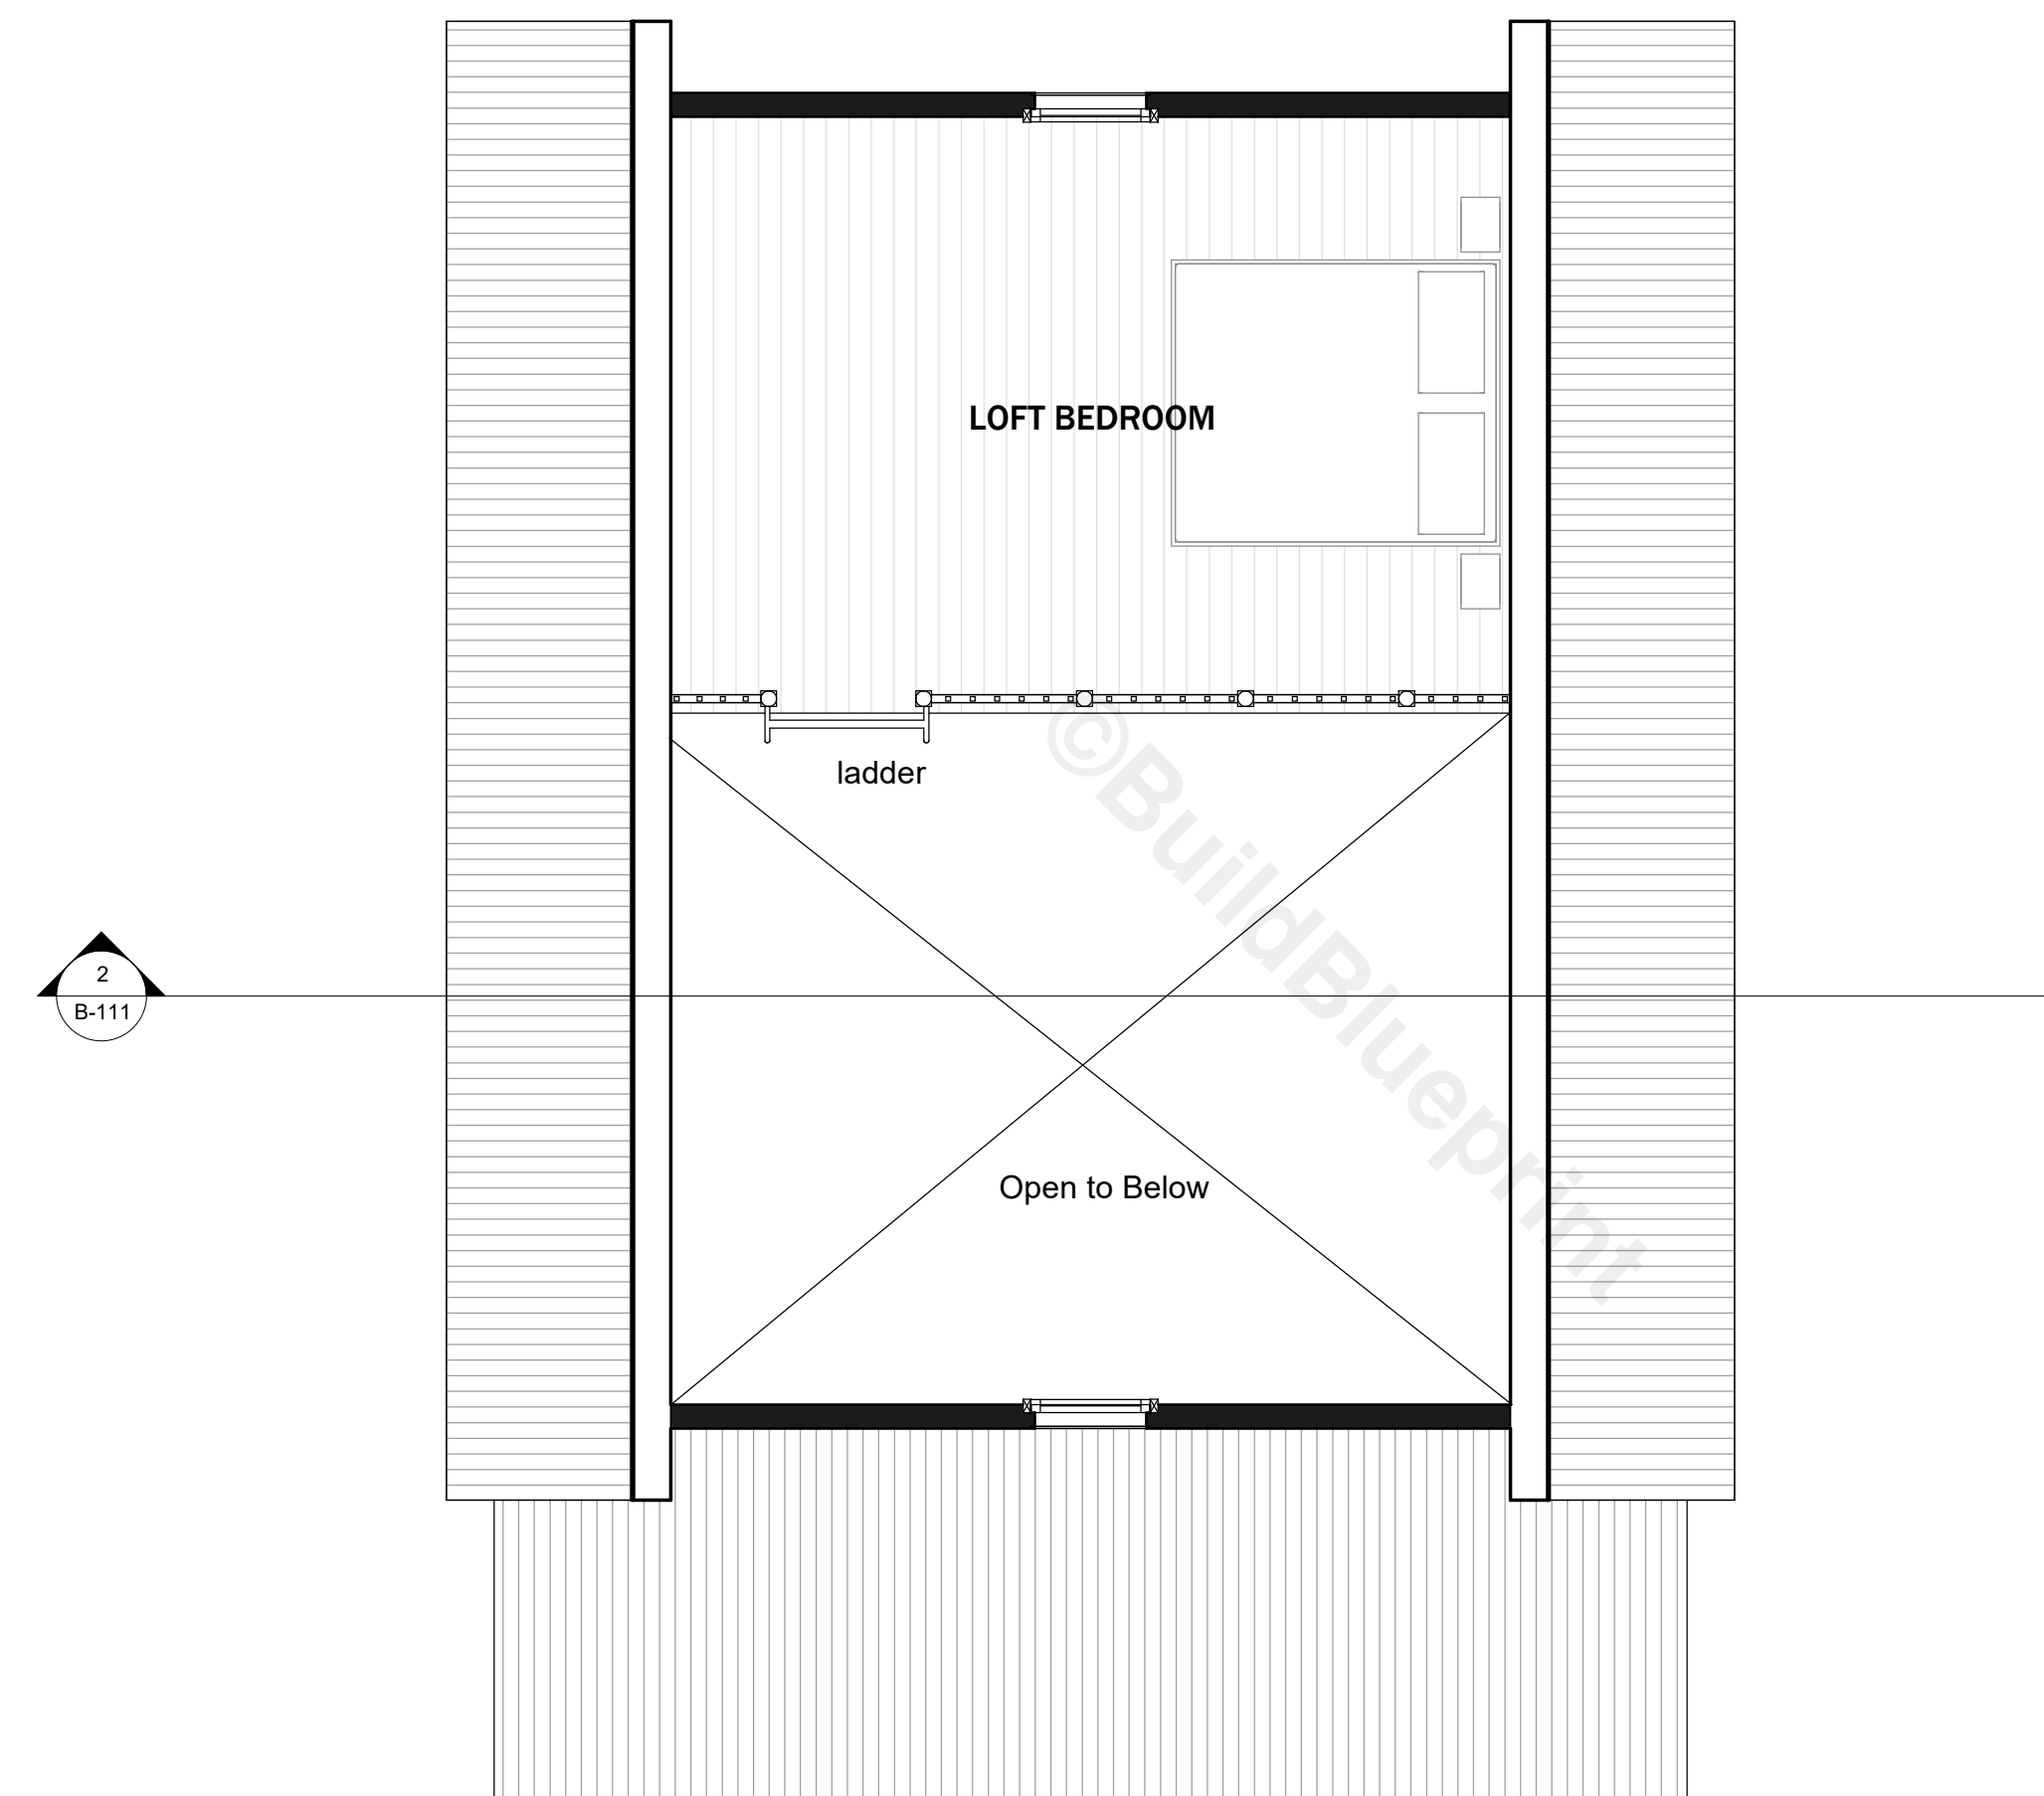

GROUND FLOOR PLAN

SCALE = 1/4" : 1' - 0"

No.	Description	Date

28x24 HONEYCREEK CABIN

SECOND FLOOR PLAN

Project number **BB-HP0032**

Date

Drawn by **B.B**

Checked by **J.L**

A-002

Sheet Number

Scale **1/4" = 1'-0"**



SOUTH EXTERIOR ELEVATION

SCALE = 1/4" : 1' - 0"



NORTH EXTERIOR ELEVATION

SCALE = 1/4" : 1' - 0"

NOTES

1. DRAWINGS SHOULD BE PRINTED ON ANSI C SIZE PAPER TO ENSURE ACCURATE SCALE PRINTING 1/4" = 1'-0"
2. CONSTRUCTION DETAILS ILLUSTRATED IN THIS SET ARE TYPICAL, CONSULT WITH YOUR BUILDER FOR DETAILS THAT MEETS YOUR LOCAL BUILDING CODE.
3. MATERIALS AND FINISHES ILLUSTRATED IN THIS SET ARE TYPICAL, AND SHOULD BE VERIFIED BY YOUR BUILDER OR DESIGNER BEFORE CONSTRUCTION.
4. THIS DRAWING SET IS NOT INTENDED FOR PERMITTING OR CONSTRUCTION. CONSULT WITH YOUR LOCAL BUILDING DEPARTMENT FOR BUILDING CODE REQUIREMENTS.

No.	Description	Date

28x24 HONEYCREEK CABIN

ELEVATION I

Project number **BB-HP0032**

Date

Drawn by **B.B**

Checked by **J.L**


A-003

Sheet Number

Scale **1/4" = 1'-0"**


NOTES

1. DRAWINGS SHOULD BE PRINTED ON ANSI C SIZE PAPER TO ENSURE ACCURATE SCALE PRINTING 1/4" = 1'-0"
2. CONSTRUCTION DETAILS ILLUSTRATED IN THIS SET ARE TYPICAL, CONSULT WITH YOUR BUILDER FOR DETAILS THAT MEETS YOUR LOCAL BUILDING CODE.
3. MATERIALS AND FINISHES ILLUSTRATED IN THIS SET ARE TYPICAL, AND SHOULD BE VERIFIED BY YOUR BUILDER OR DESIGNER BEFORE CONSTRUCTION.
4. THIS DRAWING SET IS NOT INTENDED FOR PERMITTING OR CONSTRUCTION. CONSULT WITH YOUR LOCAL BUILDING DEPARTMENT FOR BUILDING CODE REQUIREMENTS.

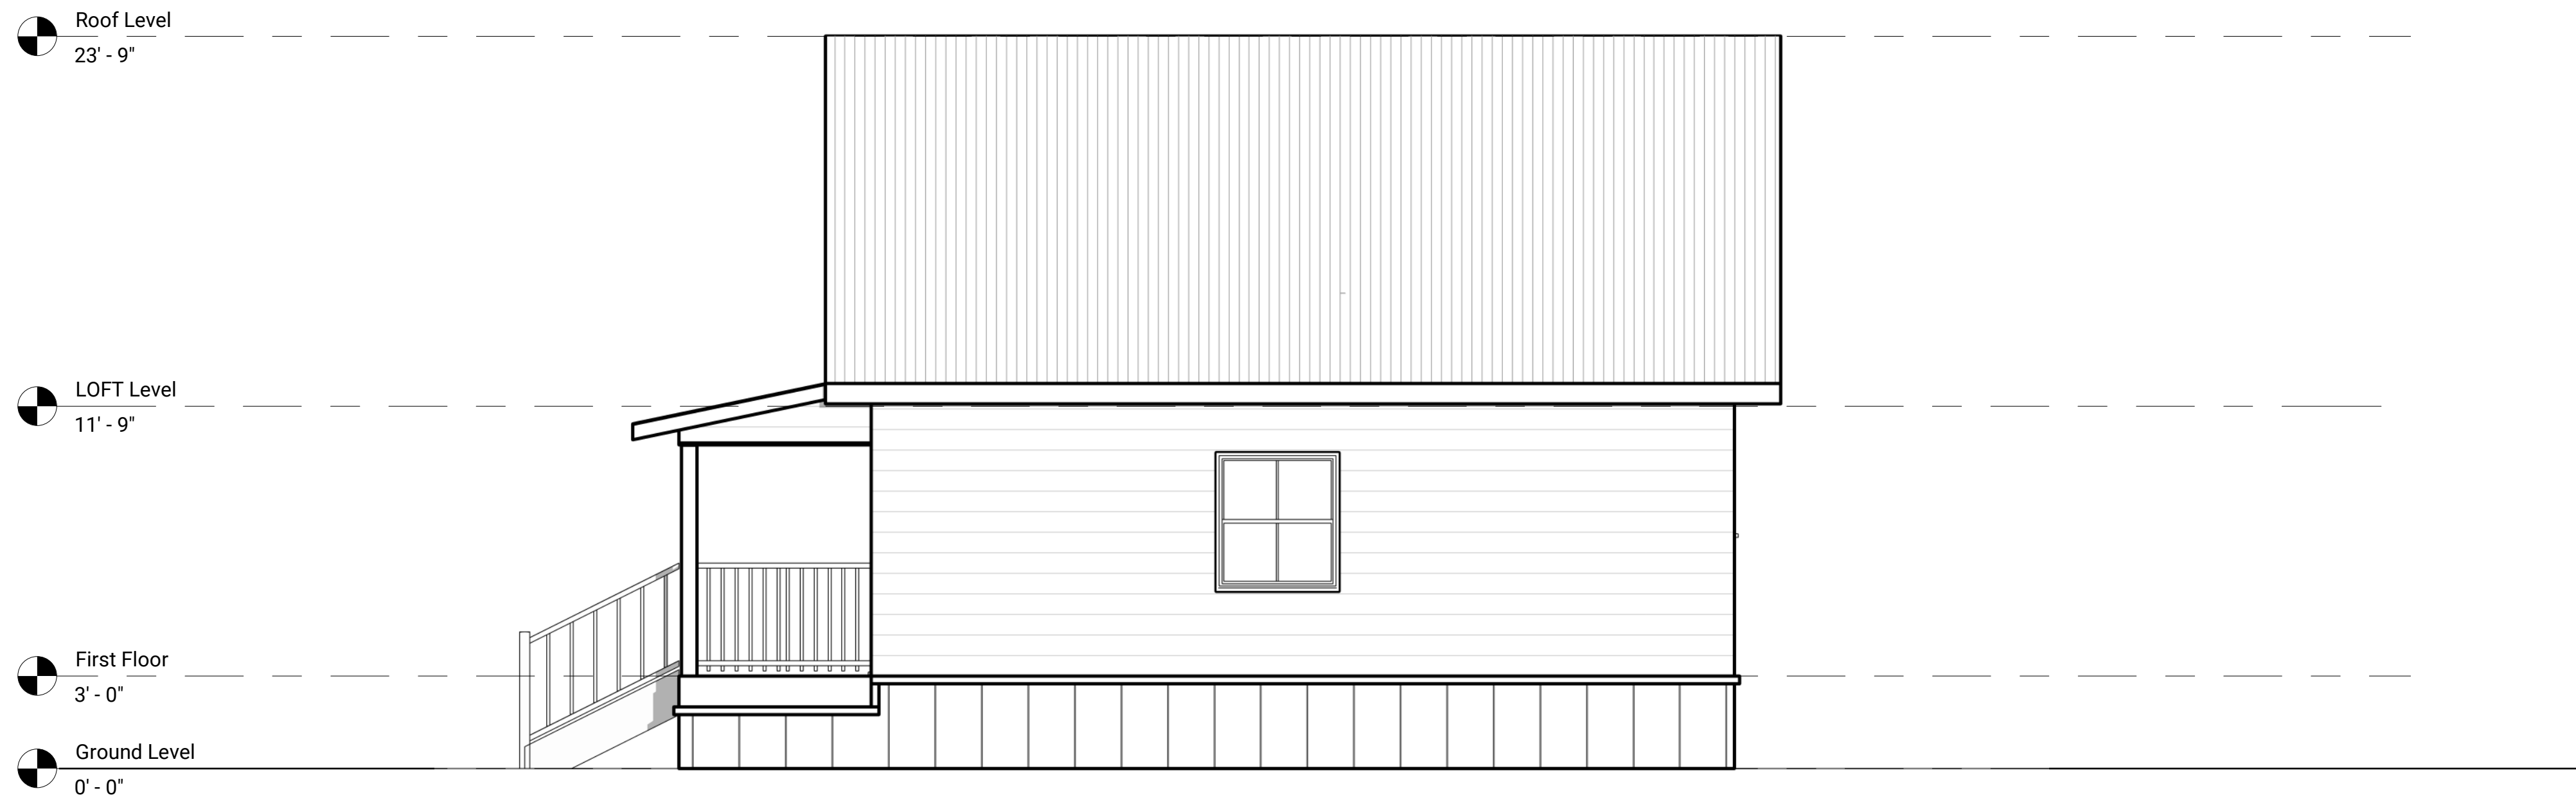

EAST EXTERIOR ELEVATION

SCALE = 1/4" : 1' - 0"

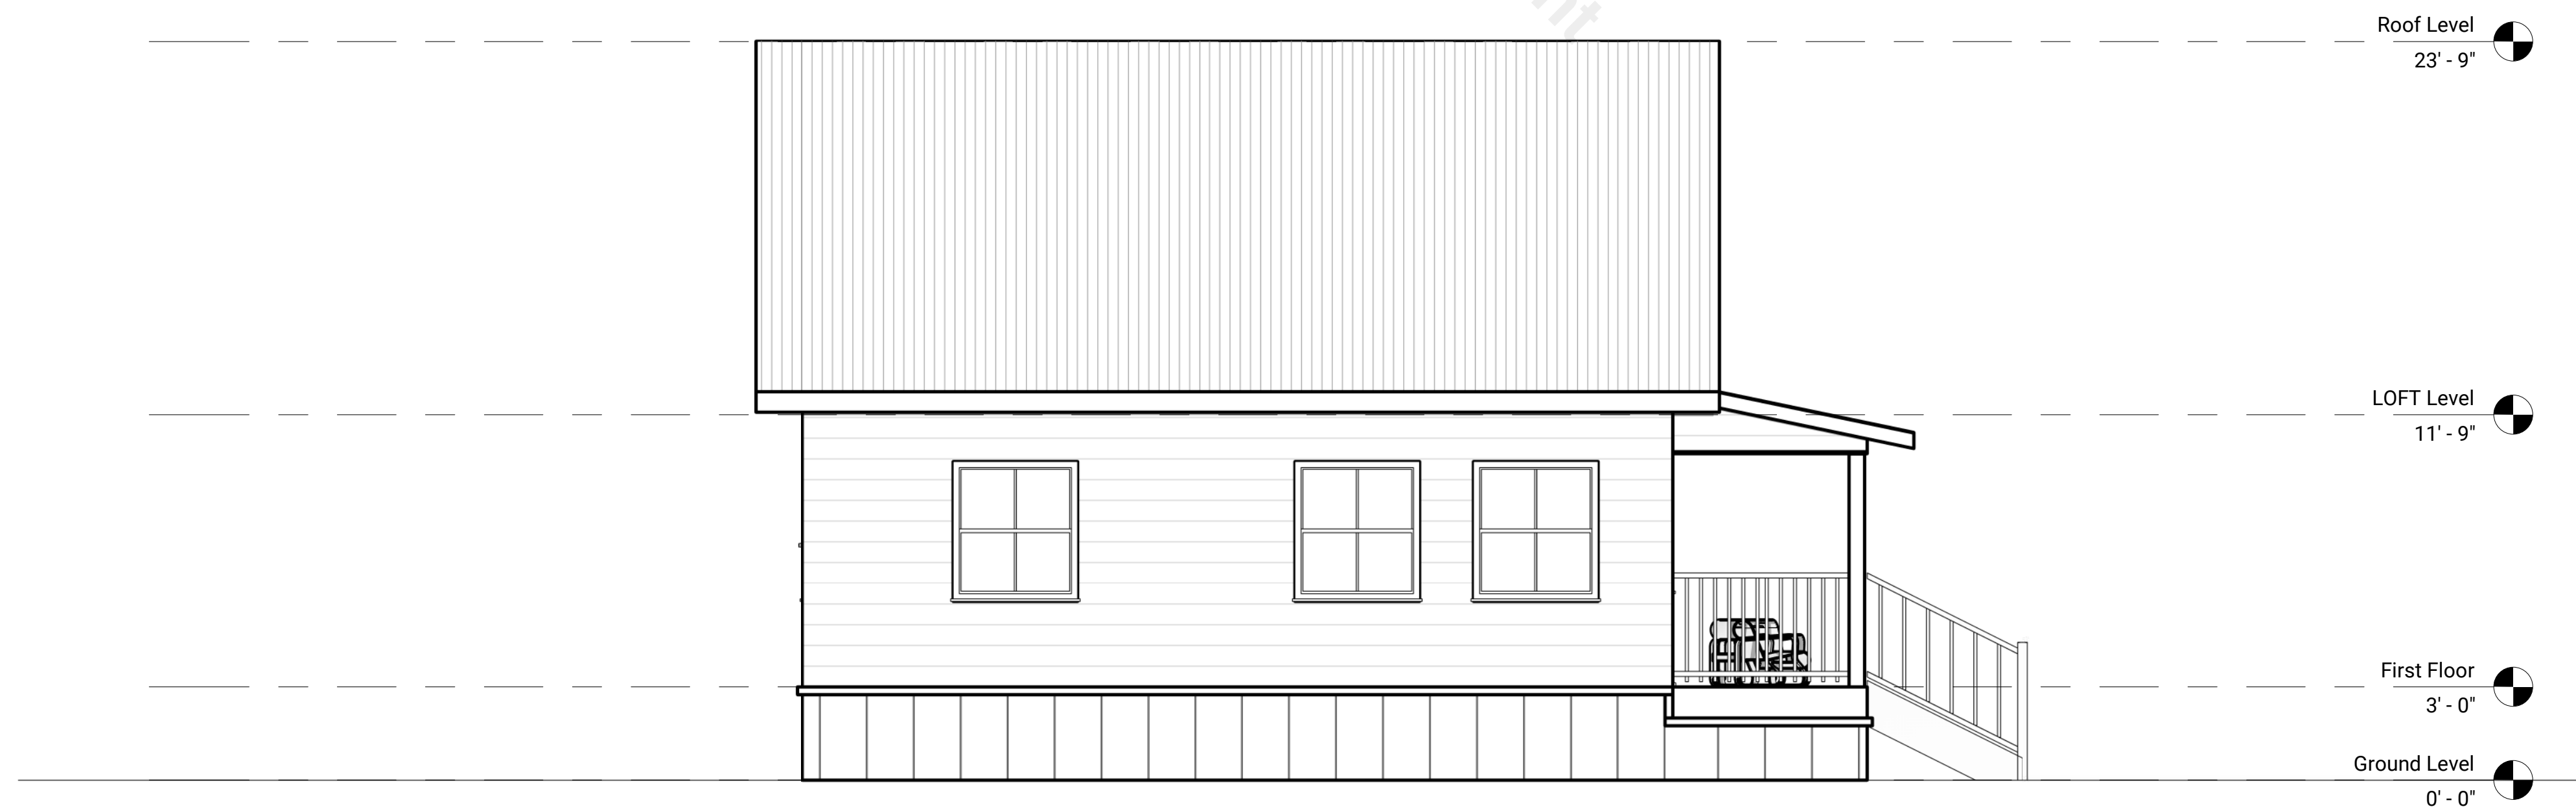

WEST EXTERIOR ELEVATION

SCALE = 1/4" : 1' - 0"

No.	Description	Date

28x24 HONEYCREEK CABIN


ELEVATIONS II

Project number	BB-HP0032
Date	
Drawn by	B.B
Checked by	J.L

A-004


Sheet Number	
Scale	1/4" = 1'-0"

N

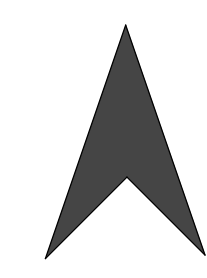

NOTES

1. DRAWINGS SHOULD BE PRINTED ON ANSI C SIZE PAPER TO ENSURE ACCURATE SCALE PRINTING 1/4" = 1'-0"
2. CONSTRUCTION DETAILS ILLUSTRATED IN THIS SET ARE TYPICAL, CONSULT WITH YOUR BUILDER FOR DETAILS THAT MEETS YOUR LOCAL BUILDING CODE.
3. MATERIALS AND FINISHES ILLUSTRATED IN THIS SET ARE TYPICAL, AND SHOULD BE VERIFIED BY YOUR BUILDER OR DESIGNER BEFORE CONSTRUCTION.
4. THIS DRAWING SET IS NOT INTENDED FOR PERMITTING OR CONSTRUCTION. CONSULT WITH YOUR LOCAL BUILDING DEPARTMENT FOR BUILDING CODE REQUIREMENTS.

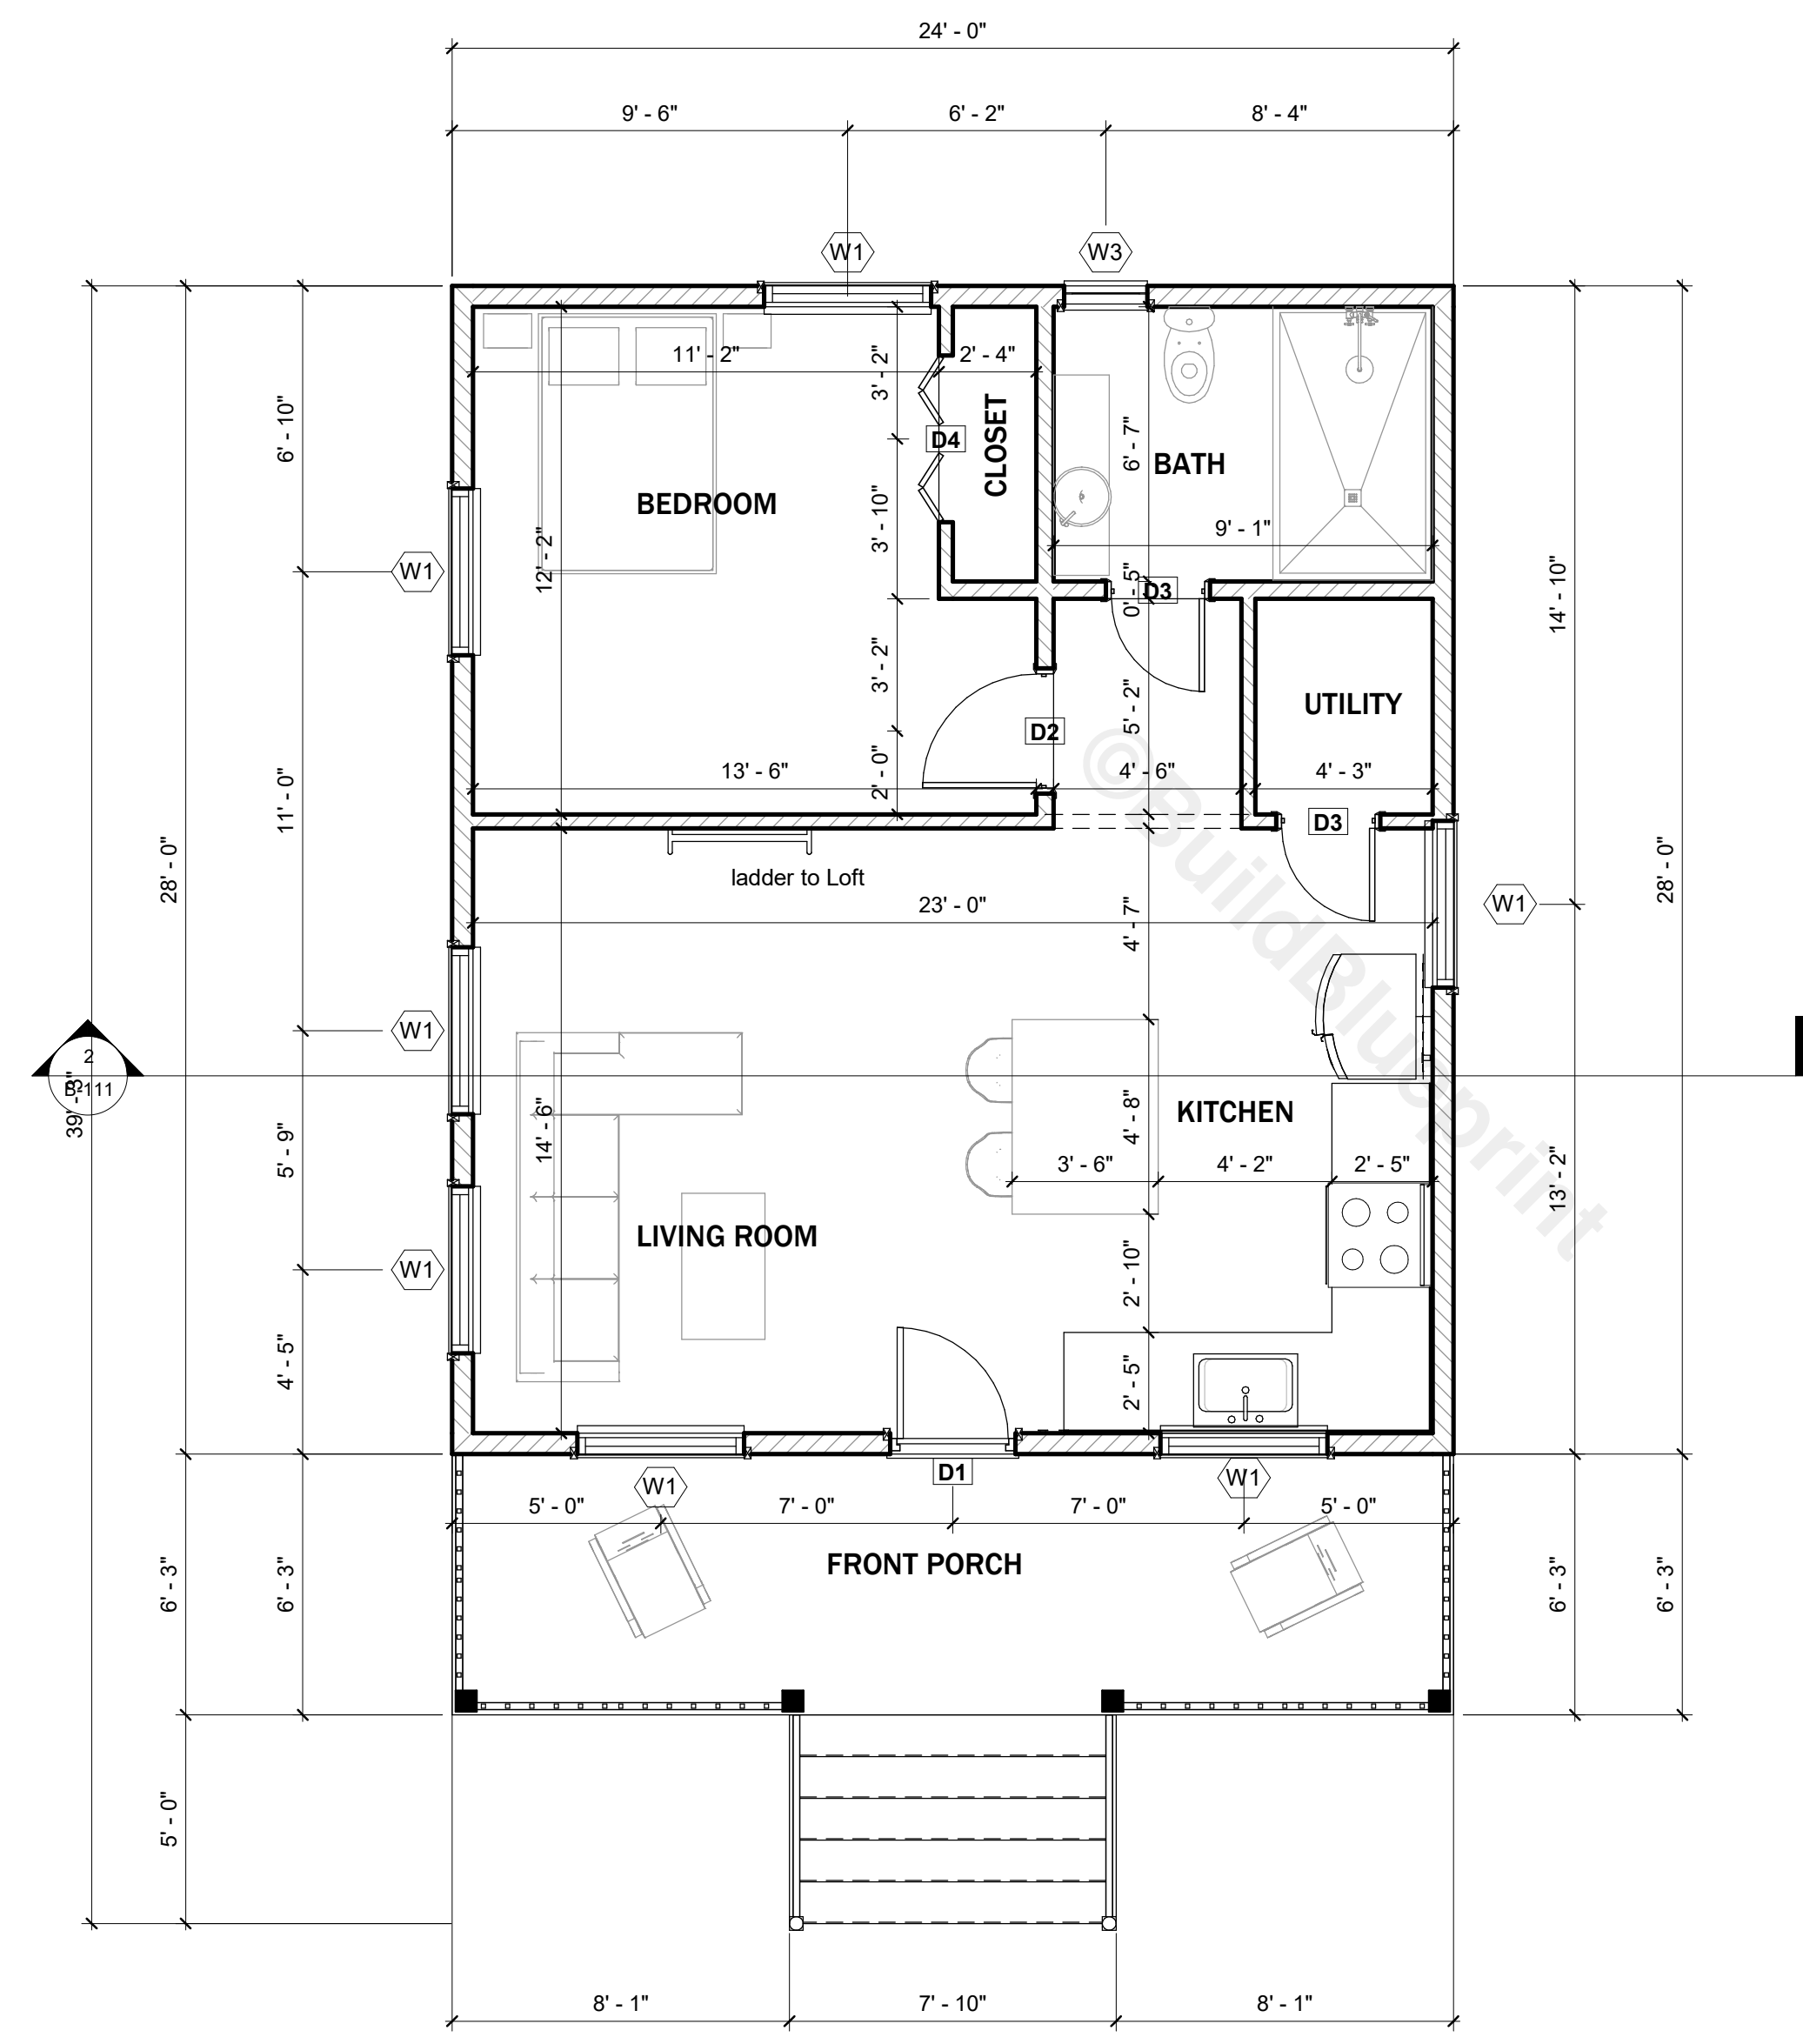

GROUND FLOOR PLAN

SCALE = 1/4" : 1' - 0"

No.	Description	Date

28x24 HONEYCREEK CABIN

GROUND FLOOR


Project number	BB-HP0032
Date	
Drawn by	B.B
Checked by	J.L

B-104

Sheet Number	
Scale	1/4" = 1'-0"

NOTES

1. DRAWINGS SHOULD BE PRINTED ON ANSI C SIZE PAPER TO ENSURE ACCURATE SCALE PRINTING 1/4" = 1'-0"
2. CONSTRUCTION DETAILS ILLUSTRATED IN THIS SET ARE TYPICAL, CONSULT WITH YOUR BUILDER FOR DETAILS THAT MEETS YOUR LOCAL BUILDING CODE.
3. MATERIALS AND FINISHES ILLUSTRATED IN THIS SET ARE TYPICAL, AND SHOULD BE VERIFIED BY YOUR BUILDER OR DESIGNER BEFORE CONSTRUCTION.
4. THIS DRAWING SET IS NOT INTENDED FOR PERMITTING OR CONSTRUCTION. CONSULT WITH YOUR LOCAL BUILDING DEPARTMENT FOR BUILDING CODE REQUIREMENTS.

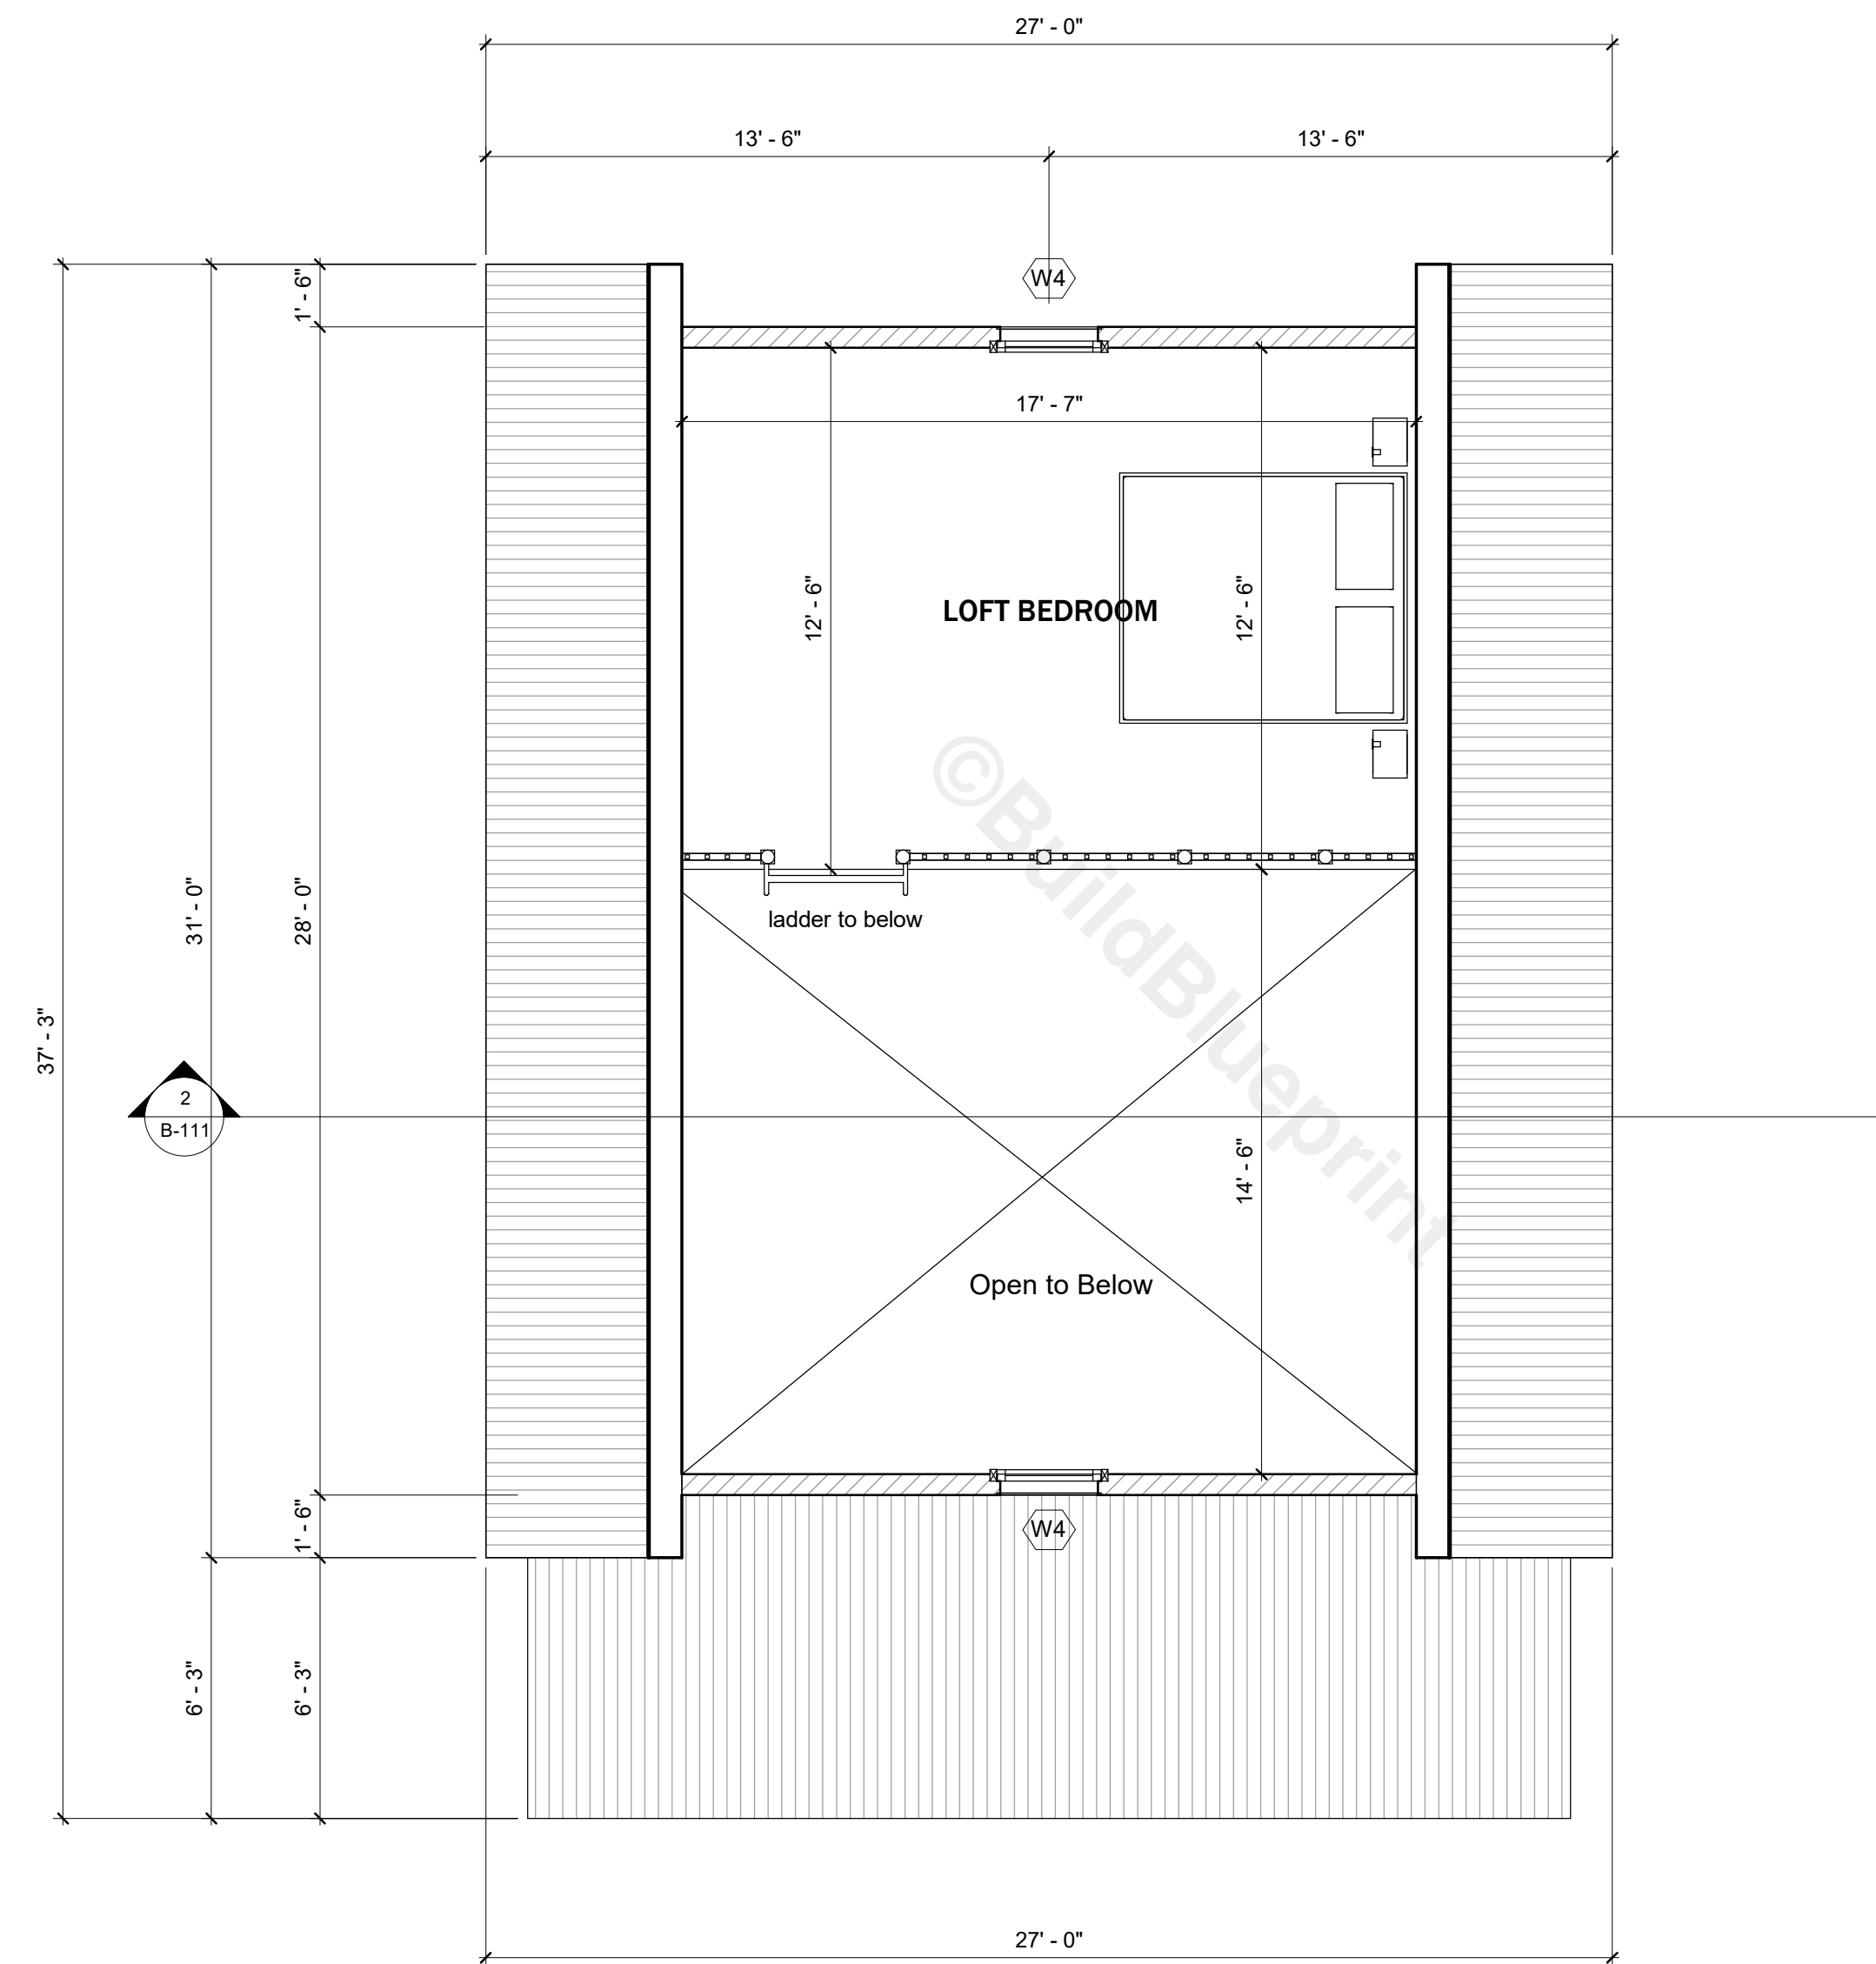

GROUND FLOOR PLAN

SCALE = 1/4" : 1' - 0"

No.	Description	Date

28x24 HONEYCREEK CABIN

SECOND FLOOR


Project number	BB-HP0032
Date	
Drawn by	B.B
Checked by	J.L

B-105


Sheet Number	
Scale	1/4" = 1'-0"

NOTES

1. DRAWINGS SHOULD BE PRINTED ON ANSI C SIZE PAPER TO ENSURE ACCURATE SCALE PRINTING 1/4" = 1'-0"
2. CONSTRUCTION DETAILS ILLUSTRATED IN THIS SET ARE TYPICAL, CONSULT WITH YOUR BUILDER FOR DETAILS THAT MEETS YOUR LOCAL BUILDING CODE.
3. MATERIALS AND FINISHES ILLUSTRATED IN THIS SET ARE TYPICAL, AND SHOULD BE VERIFIED BY YOUR BUILDER OR DESIGNER BEFORE CONSTRUCTION.
4. THIS DRAWING SET IS NOT INTENDED FOR PERMITTING OR CONSTRUCTION. CONSULT WITH YOUR LOCAL BUILDING DEPARTMENT FOR BUILDING CODE REQUIREMENTS.

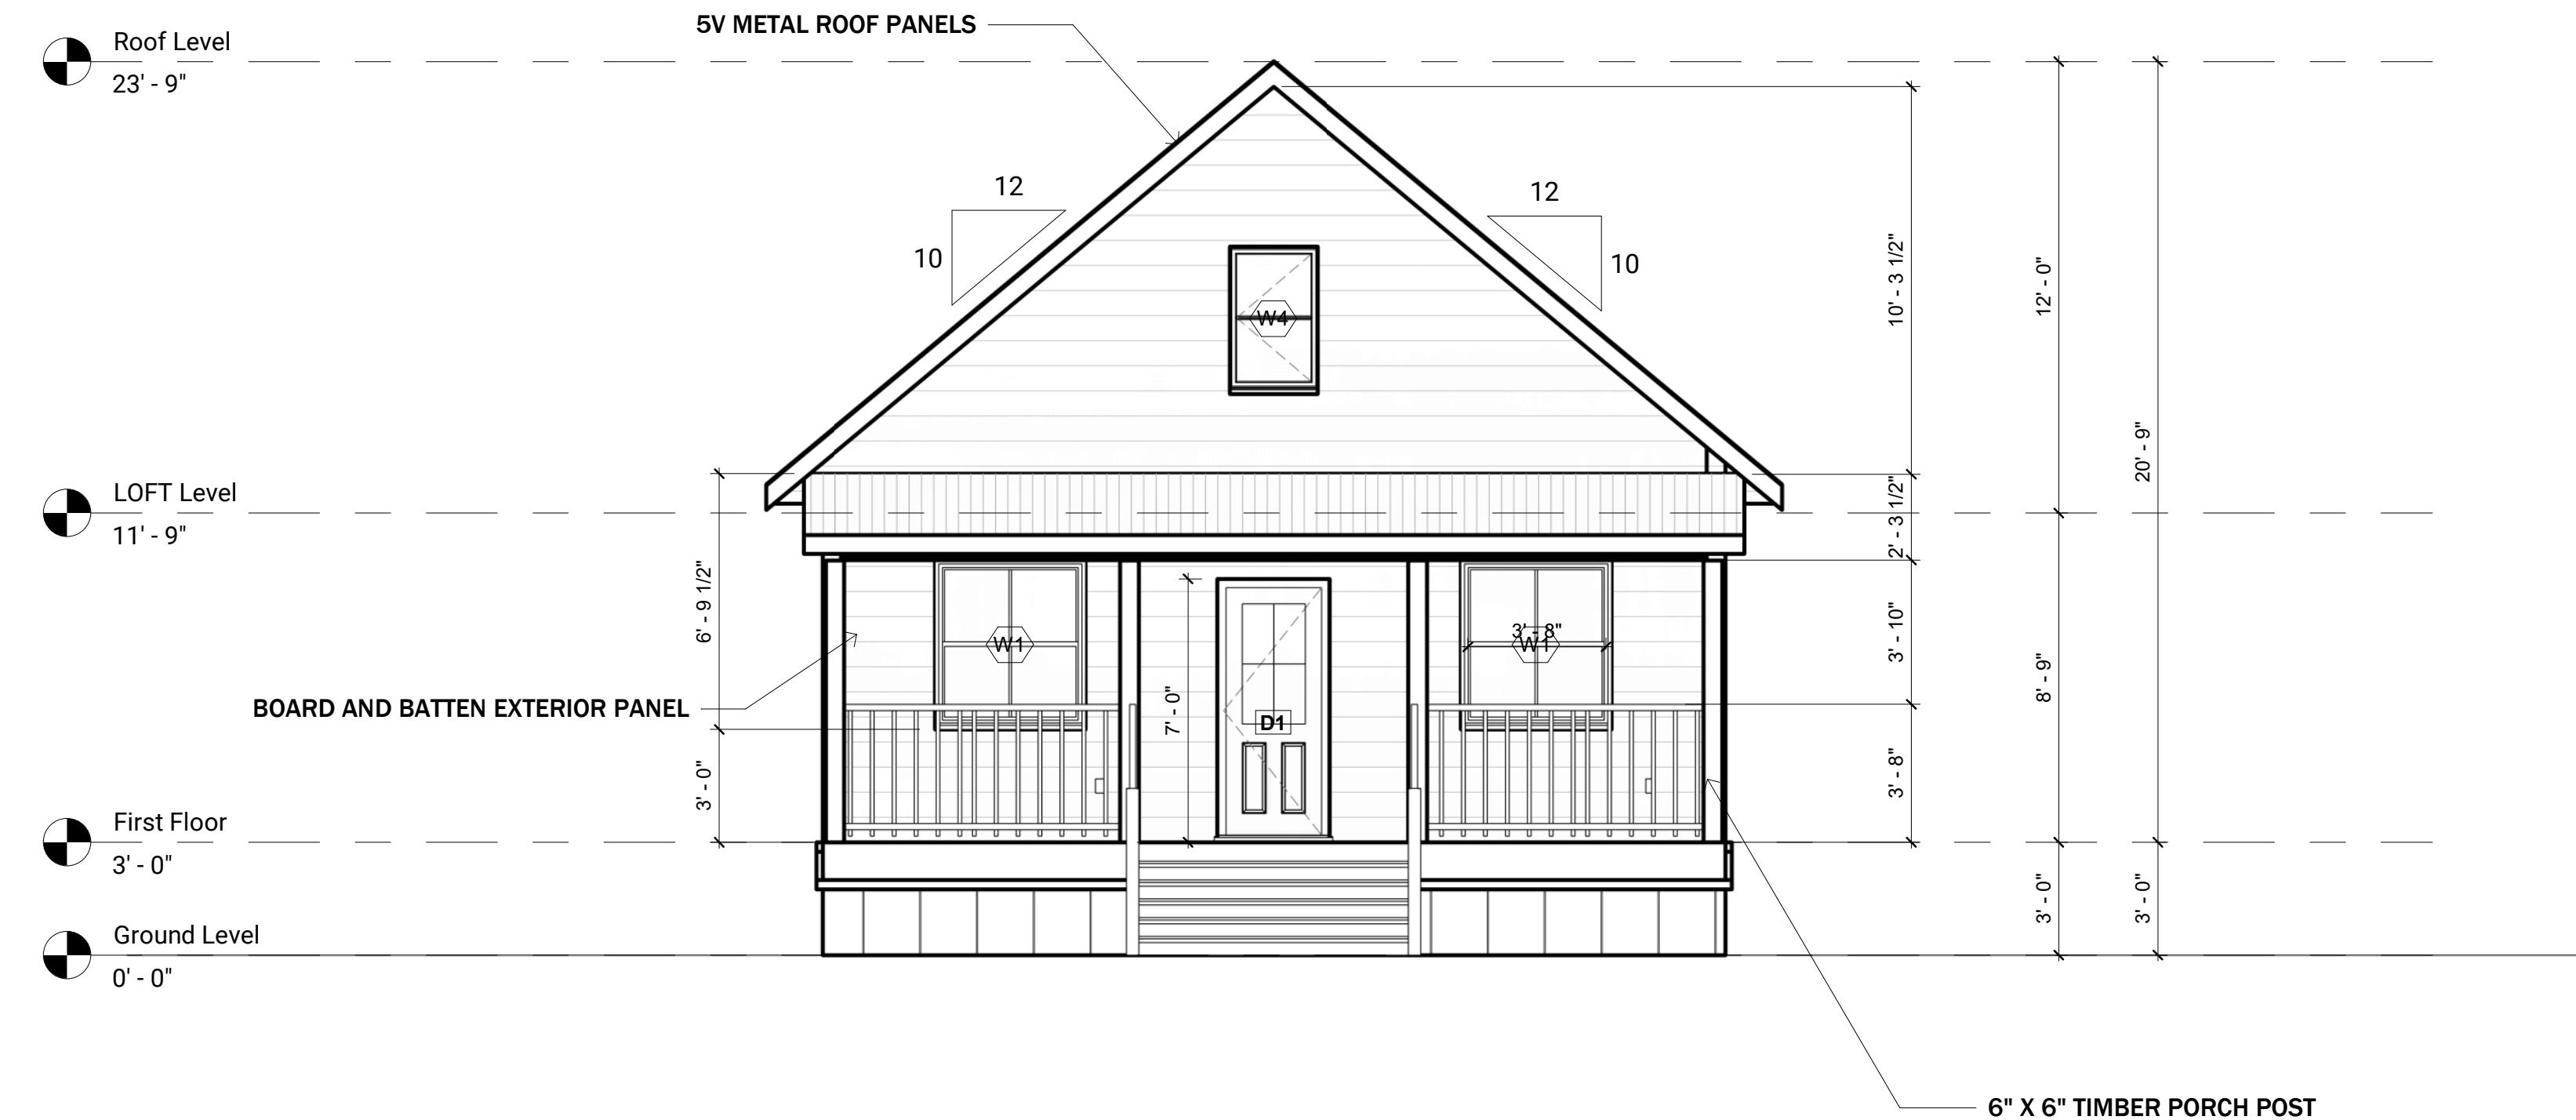

SOUTH EXTERIOR ELEVATION
SCALE = 1/4" : 1' - 0"

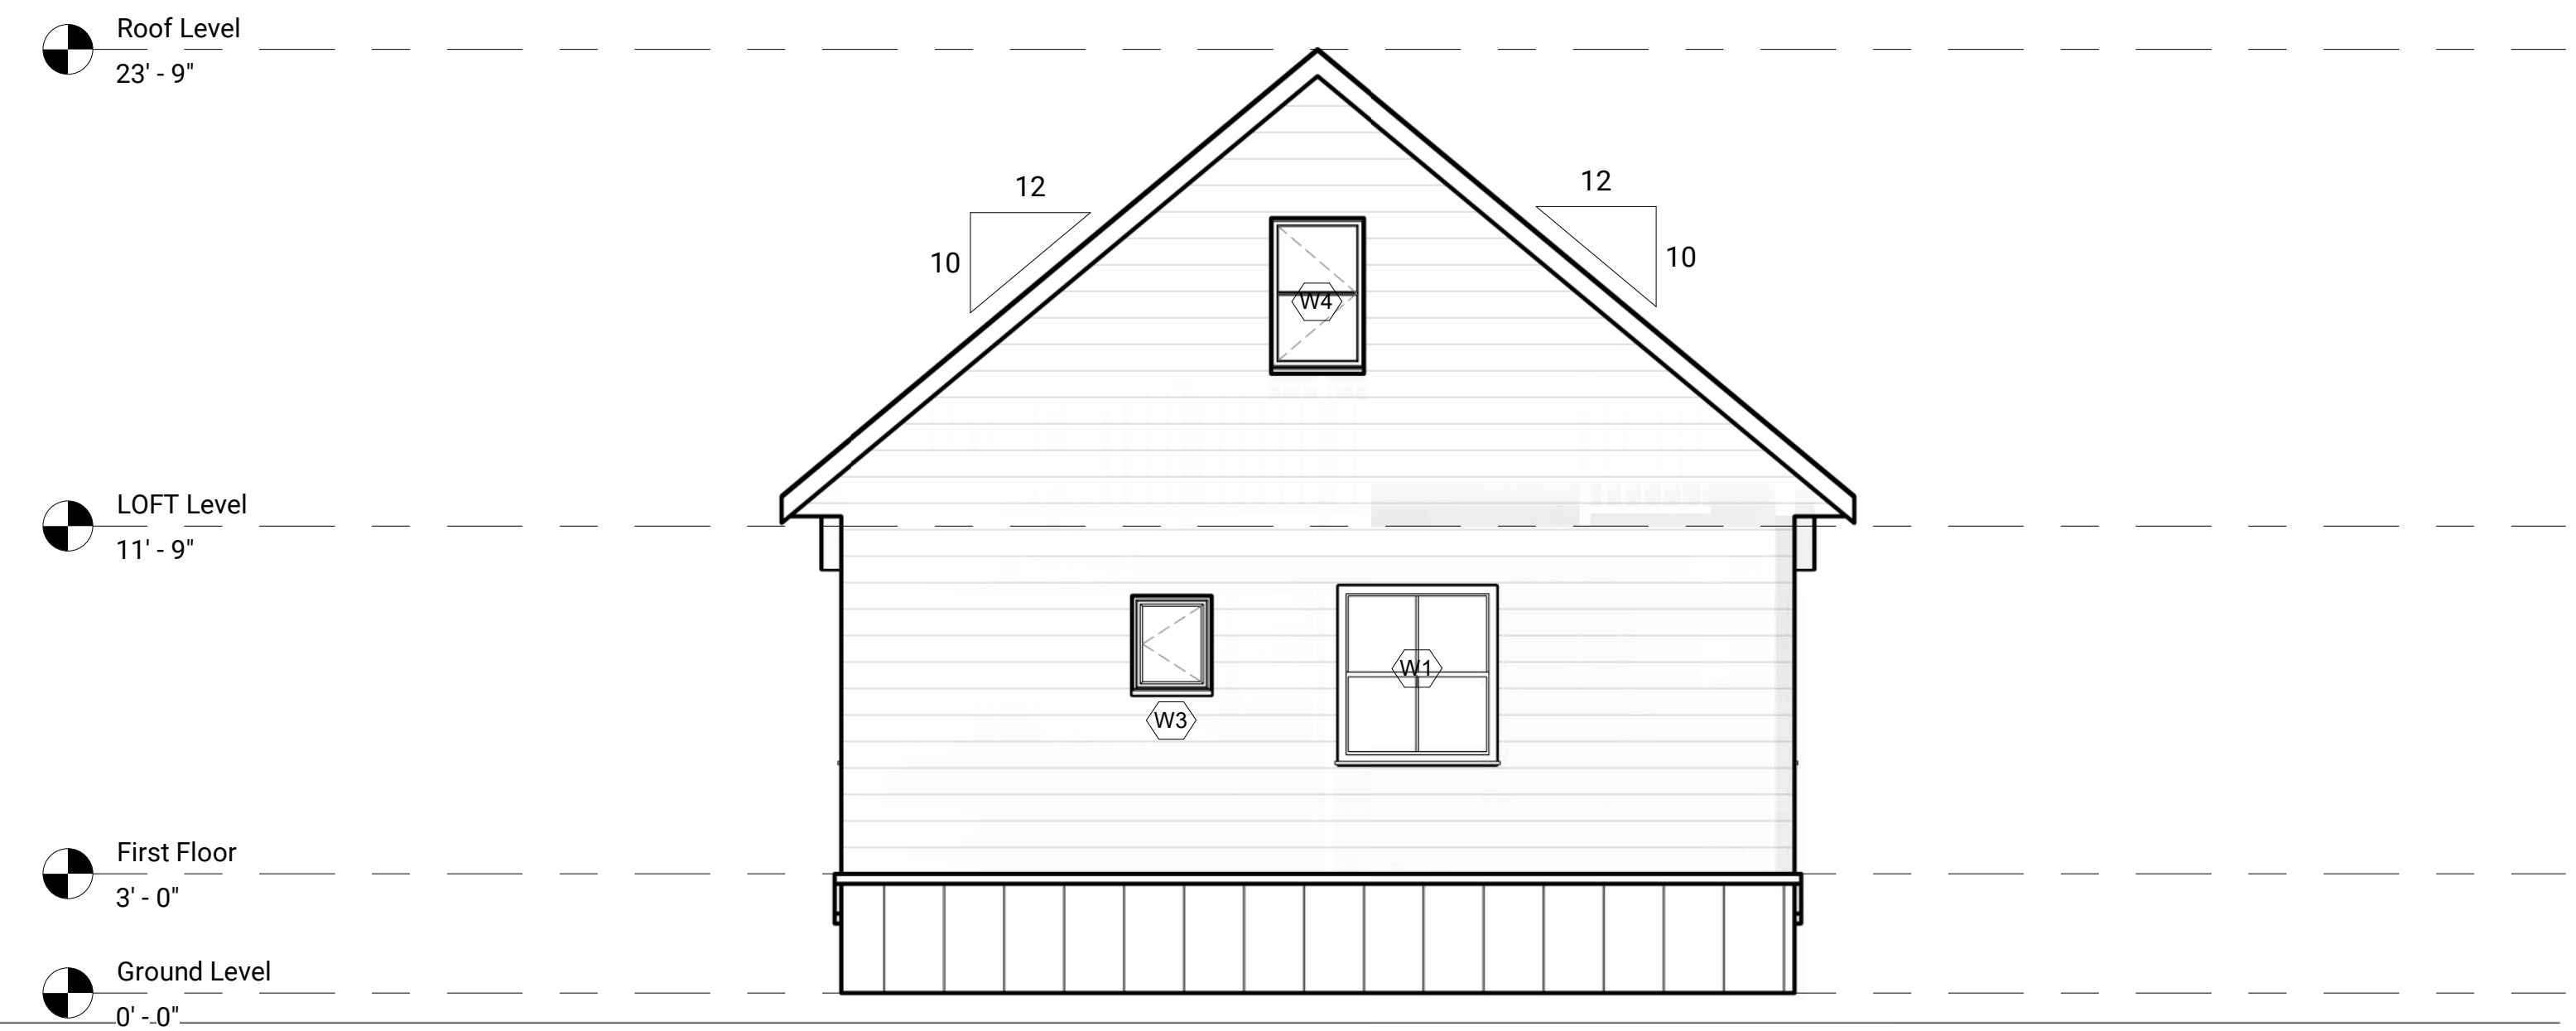

NORTH EXTERIOR ELEVATION
SCALE = 1/4" : 1' - 0"

No.	Description	Date

28x24 HONEYCREEK CABIN

NORTH & SOUTH ELEVATION


Project number	BB-HP0032
Date	
Drawn by	B.B
Checked by	J.L

B-106

Sheet Number	
Scale	1/4" = 1'-0"


NOTES

1. DRAWINGS SHOULD BE PRINTED ON ANSI C SIZE PAPER TO ENSURE ACCURATE SCALE PRINTING 1/4" = 1'-0"
2. CONSTRUCTION DETAILS ILLUSTRATED IN THIS SET ARE TYPICAL, CONSULT WITH YOUR BUILDER FOR DETAILS THAT MEETS YOUR LOCAL BUILDING CODE.
3. MATERIALS AND FINISHES ILLUSTRATED IN THIS SET ARE TYPICAL, AND SHOULD BE VERIFIED BY YOUR BUILDER OR DESIGNER BEFORE CONSTRUCTION.
4. THIS DRAWING SET IS NOT INTENDED FOR PERMITTING OR CONSTRUCTION. CONSULT WITH YOUR LOCAL BUILDING DEPARTMENT FOR BUILDING CODE REQUIREMENTS.

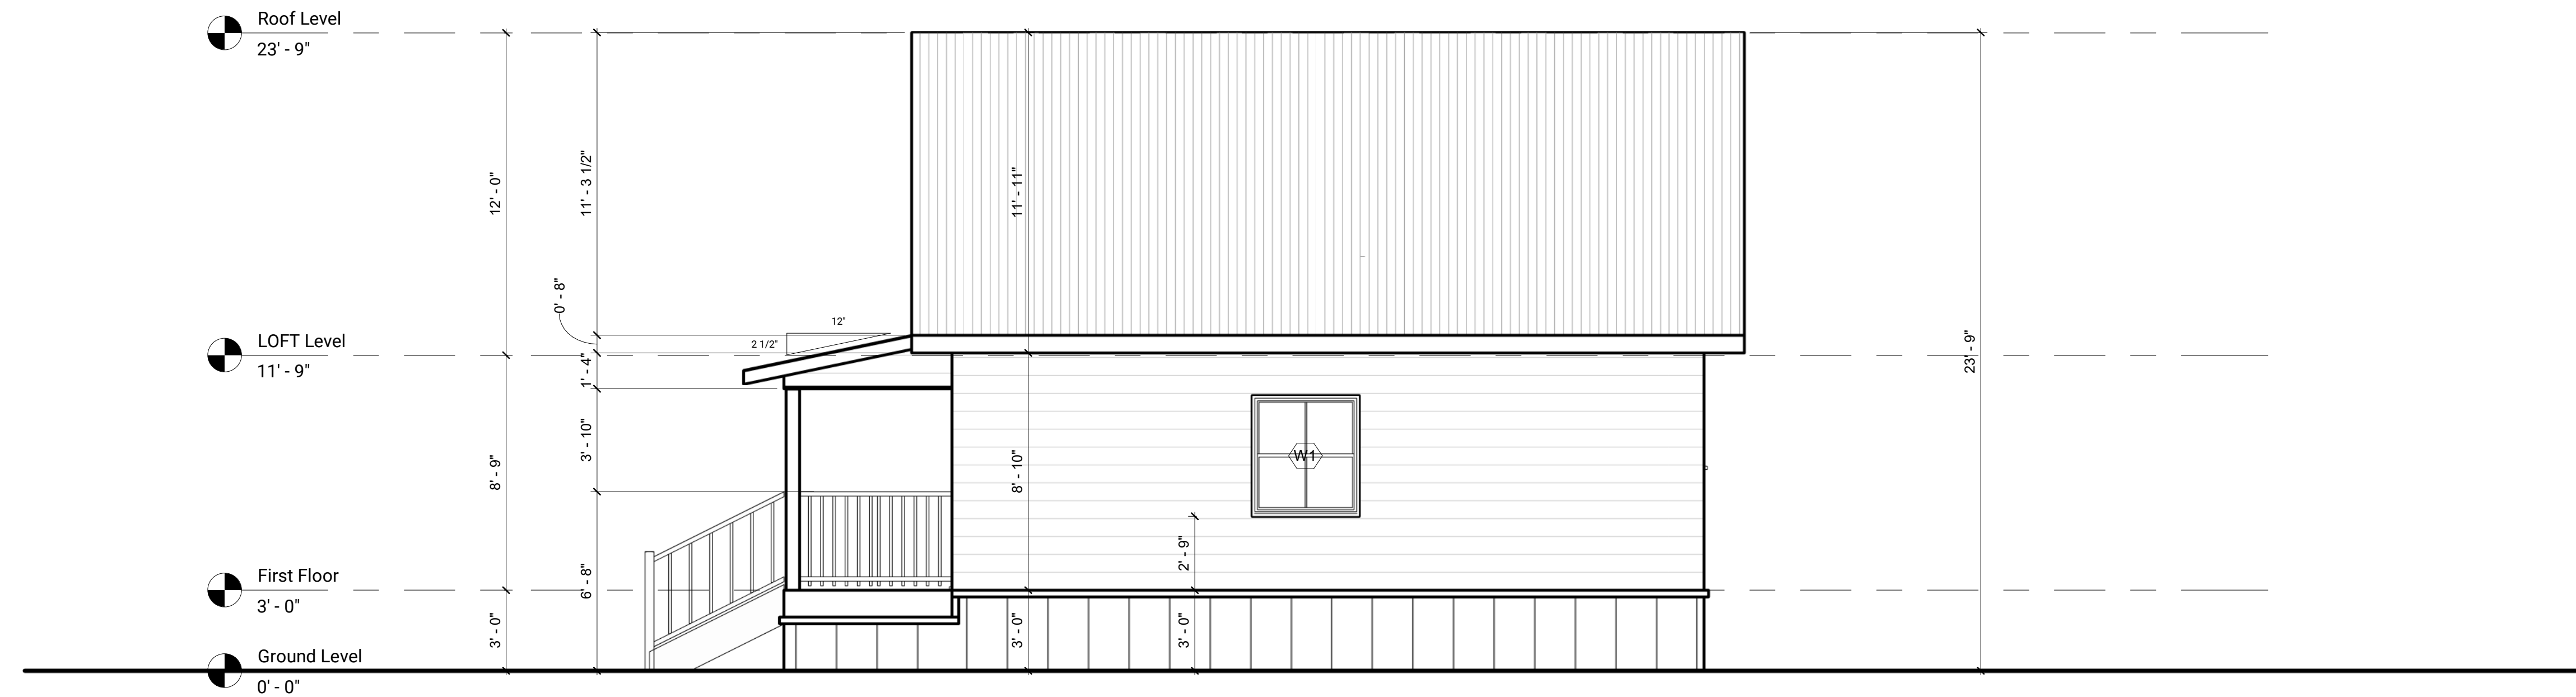

EAST EXTERIOR ELEVATION

SCALE = 1/4" : 1' - 0"

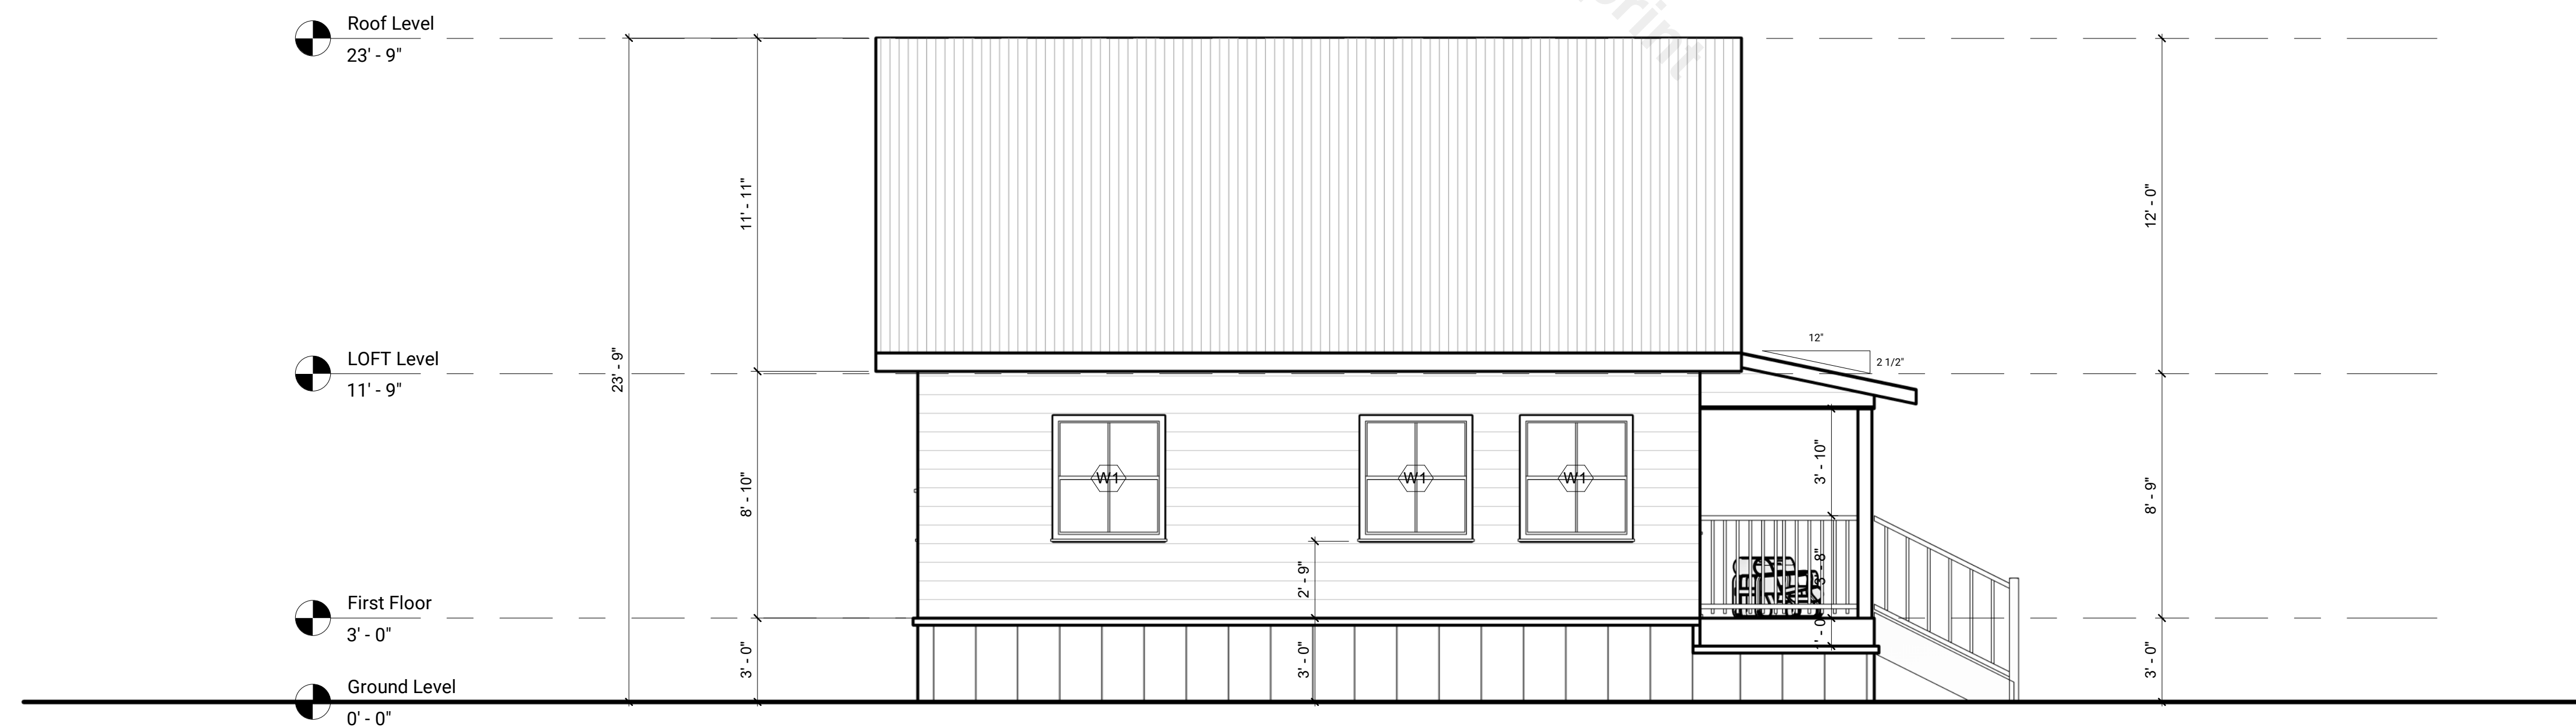

WEST EXTERIOR ELEVATION

SCALE = 1/4" : 1' - 0"

No.	Description	Date

28x24 HONEYCREEK CABIN

EAST & WEST ELEVATION


Project number	BB-HP0032
Date	
Drawn by	B.B
Checked by	J.L

B-107

Sheet Number	
Scale	1/4" = 1'-0"


NOTES

1. DRAWINGS SHOULD BE PRINTED ON ANSI C SIZE PAPER TO ENSURE ACCURATE SCALE PRINTING 3/8" = 1'-0"
2. CONSTRUCTION DETAILS ILLUSTRATED IN THIS SET ARE TYPICAL, CONSULT WITH YOUR BUILDER FOR DETAILS THAT MEETS YOUR LOCAL BUILDING CODE.
3. MATERIALS AND FINISHES ILLUSTRATED IN THIS SET ARE TYPICAL, AND SHOULD BE VERIFIED BY YOUR BUILDER OR DESIGNER BEFORE CONSTRUCTION.
4. THIS DRAWING SET IS NOT INTENDED FOR PERMITTING OR CONSTRUCTION. CONSULT WITH YOUR LOCAL BUILDING DEPARTMENT FOR BUILDING CODE REQUIREMENTS.

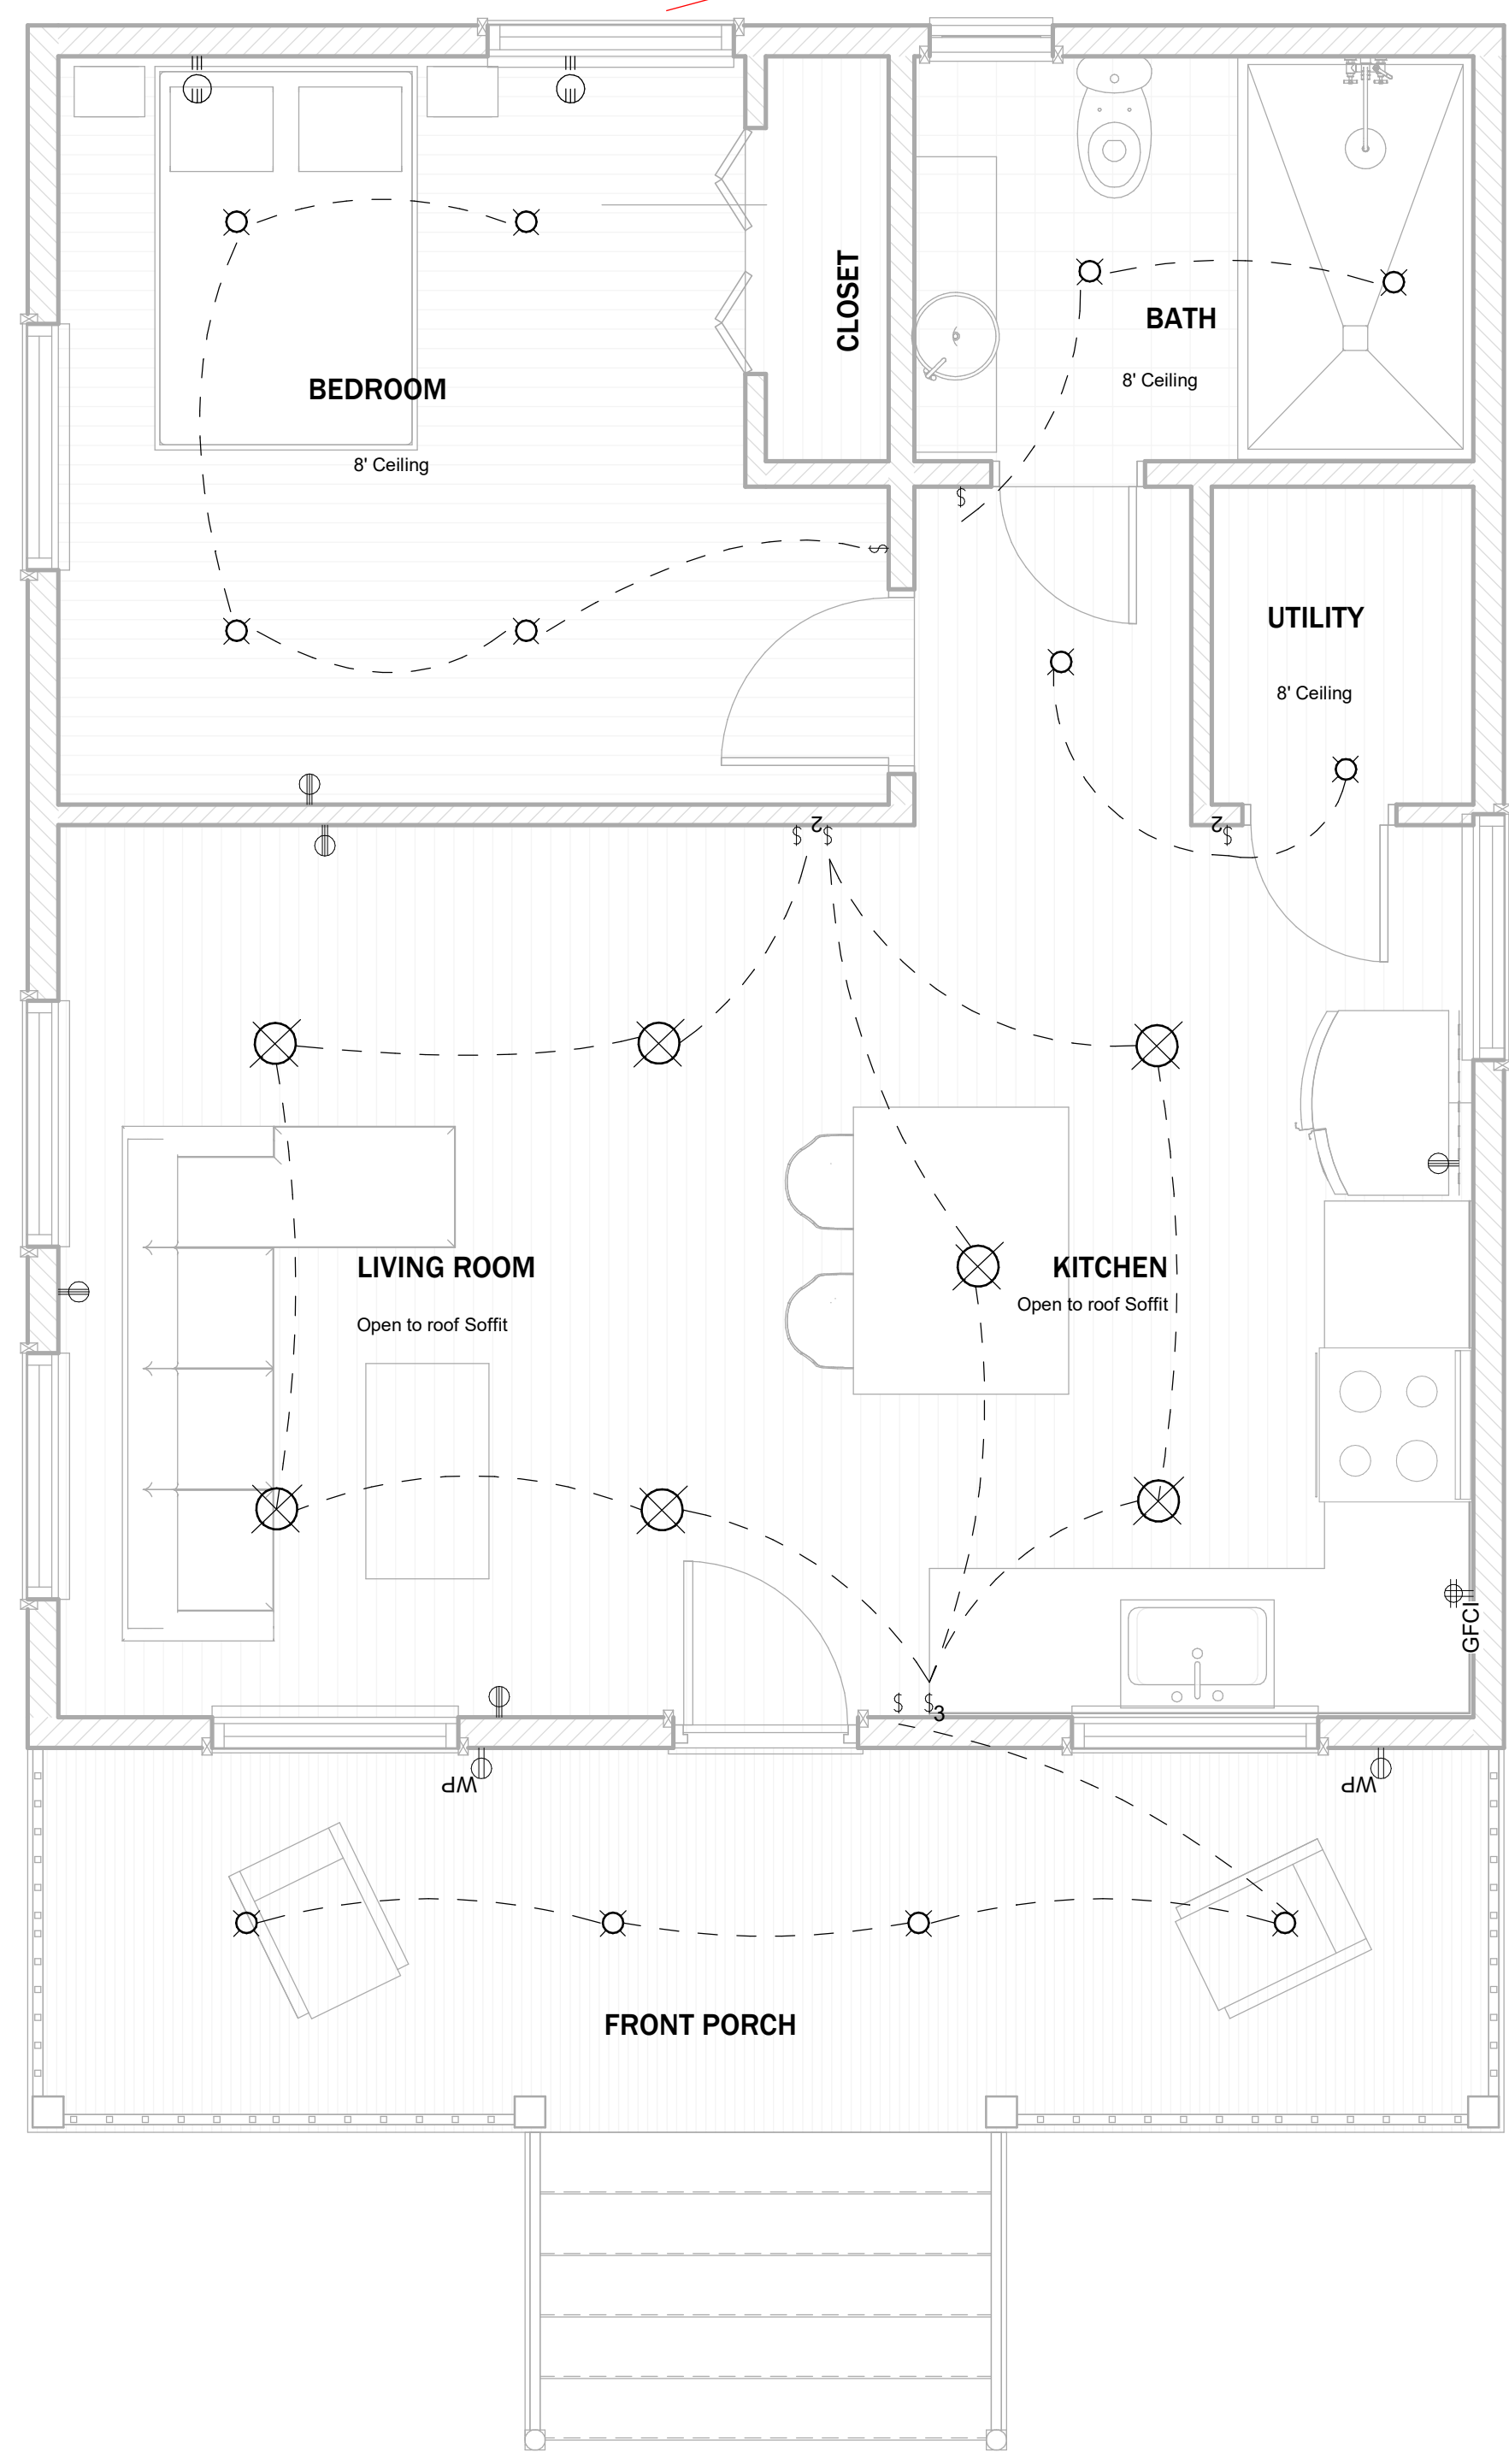

GROUND FLOOR ELECTRICAL PLAN
SCALE = 3/8" : 1' - 0"

These windows shall meet egress requirements

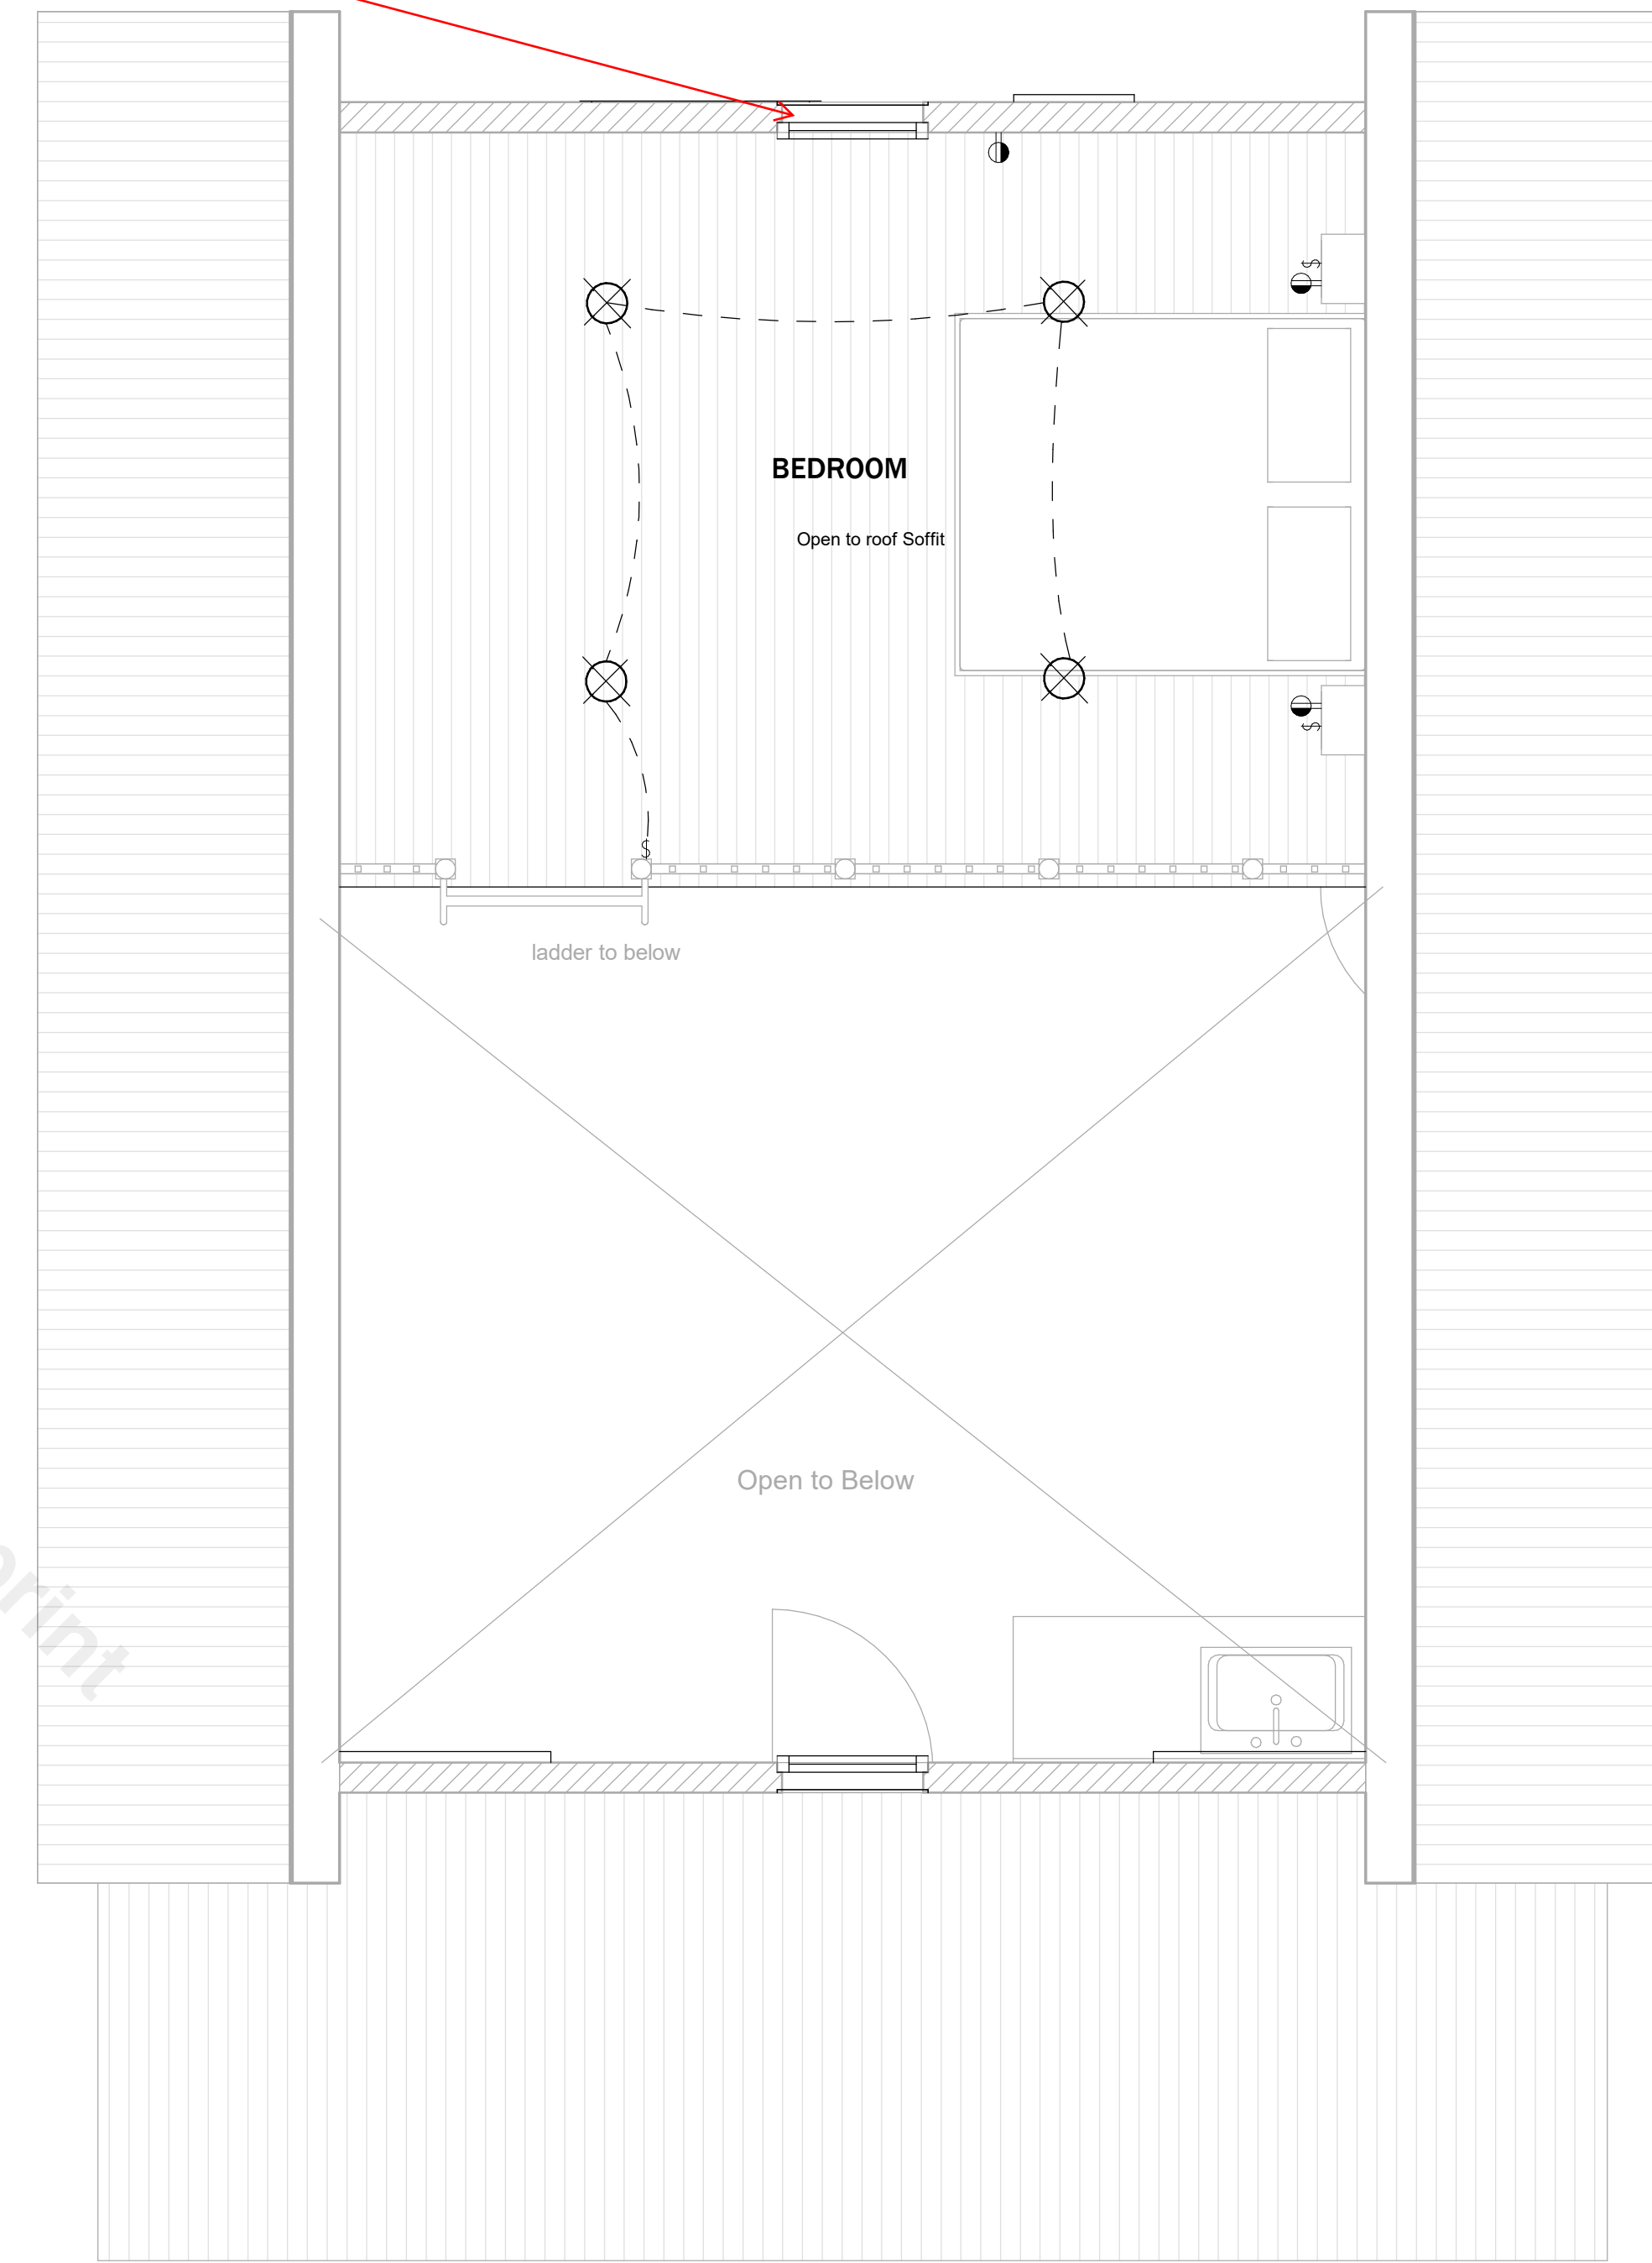

LOFT ELECTRICAL PLAN
SCALE = 3/8" : 1' - 0"

No.	Description	Date

28x24 HONEYCREEK CABIN

ELECTRICAL PLAN


Project number	BB-HP0032
Date	
Drawn by	B.B
Checked by	J.L

B-108

Sheet Number	
Scale	3/8" = 1'-0"

NOTES

1. DRAWINGS SHOULD BE PRINTED ON ANSI C SIZE PAPER TO ENSURE ACCURATE SCALE PRINTING 1/4" = 1'-0"
2. CONSTRUCTION DETAILS ILLUSTRATED IN THIS SET ARE TYPICAL, CONSULT WITH YOUR BUILDER FOR DETAILS THAT MEETS YOUR LOCAL BUILDING CODE.
3. MATERIALS AND FINISHES ILLUSTRATED IN THIS SET ARE TYPICAL, AND SHOULD BE VERIFIED BY YOUR BUILDER OR DESIGNER BEFORE CONSTRUCTION.
4. THIS DRAWING SET IS NOT INTENDED FOR PERMITTING OR CONSTRUCTION. CONSULT WITH YOUR LOCAL BUILDING DEPARTMENT FOR BUILDING CODE REQUIREMENTS.

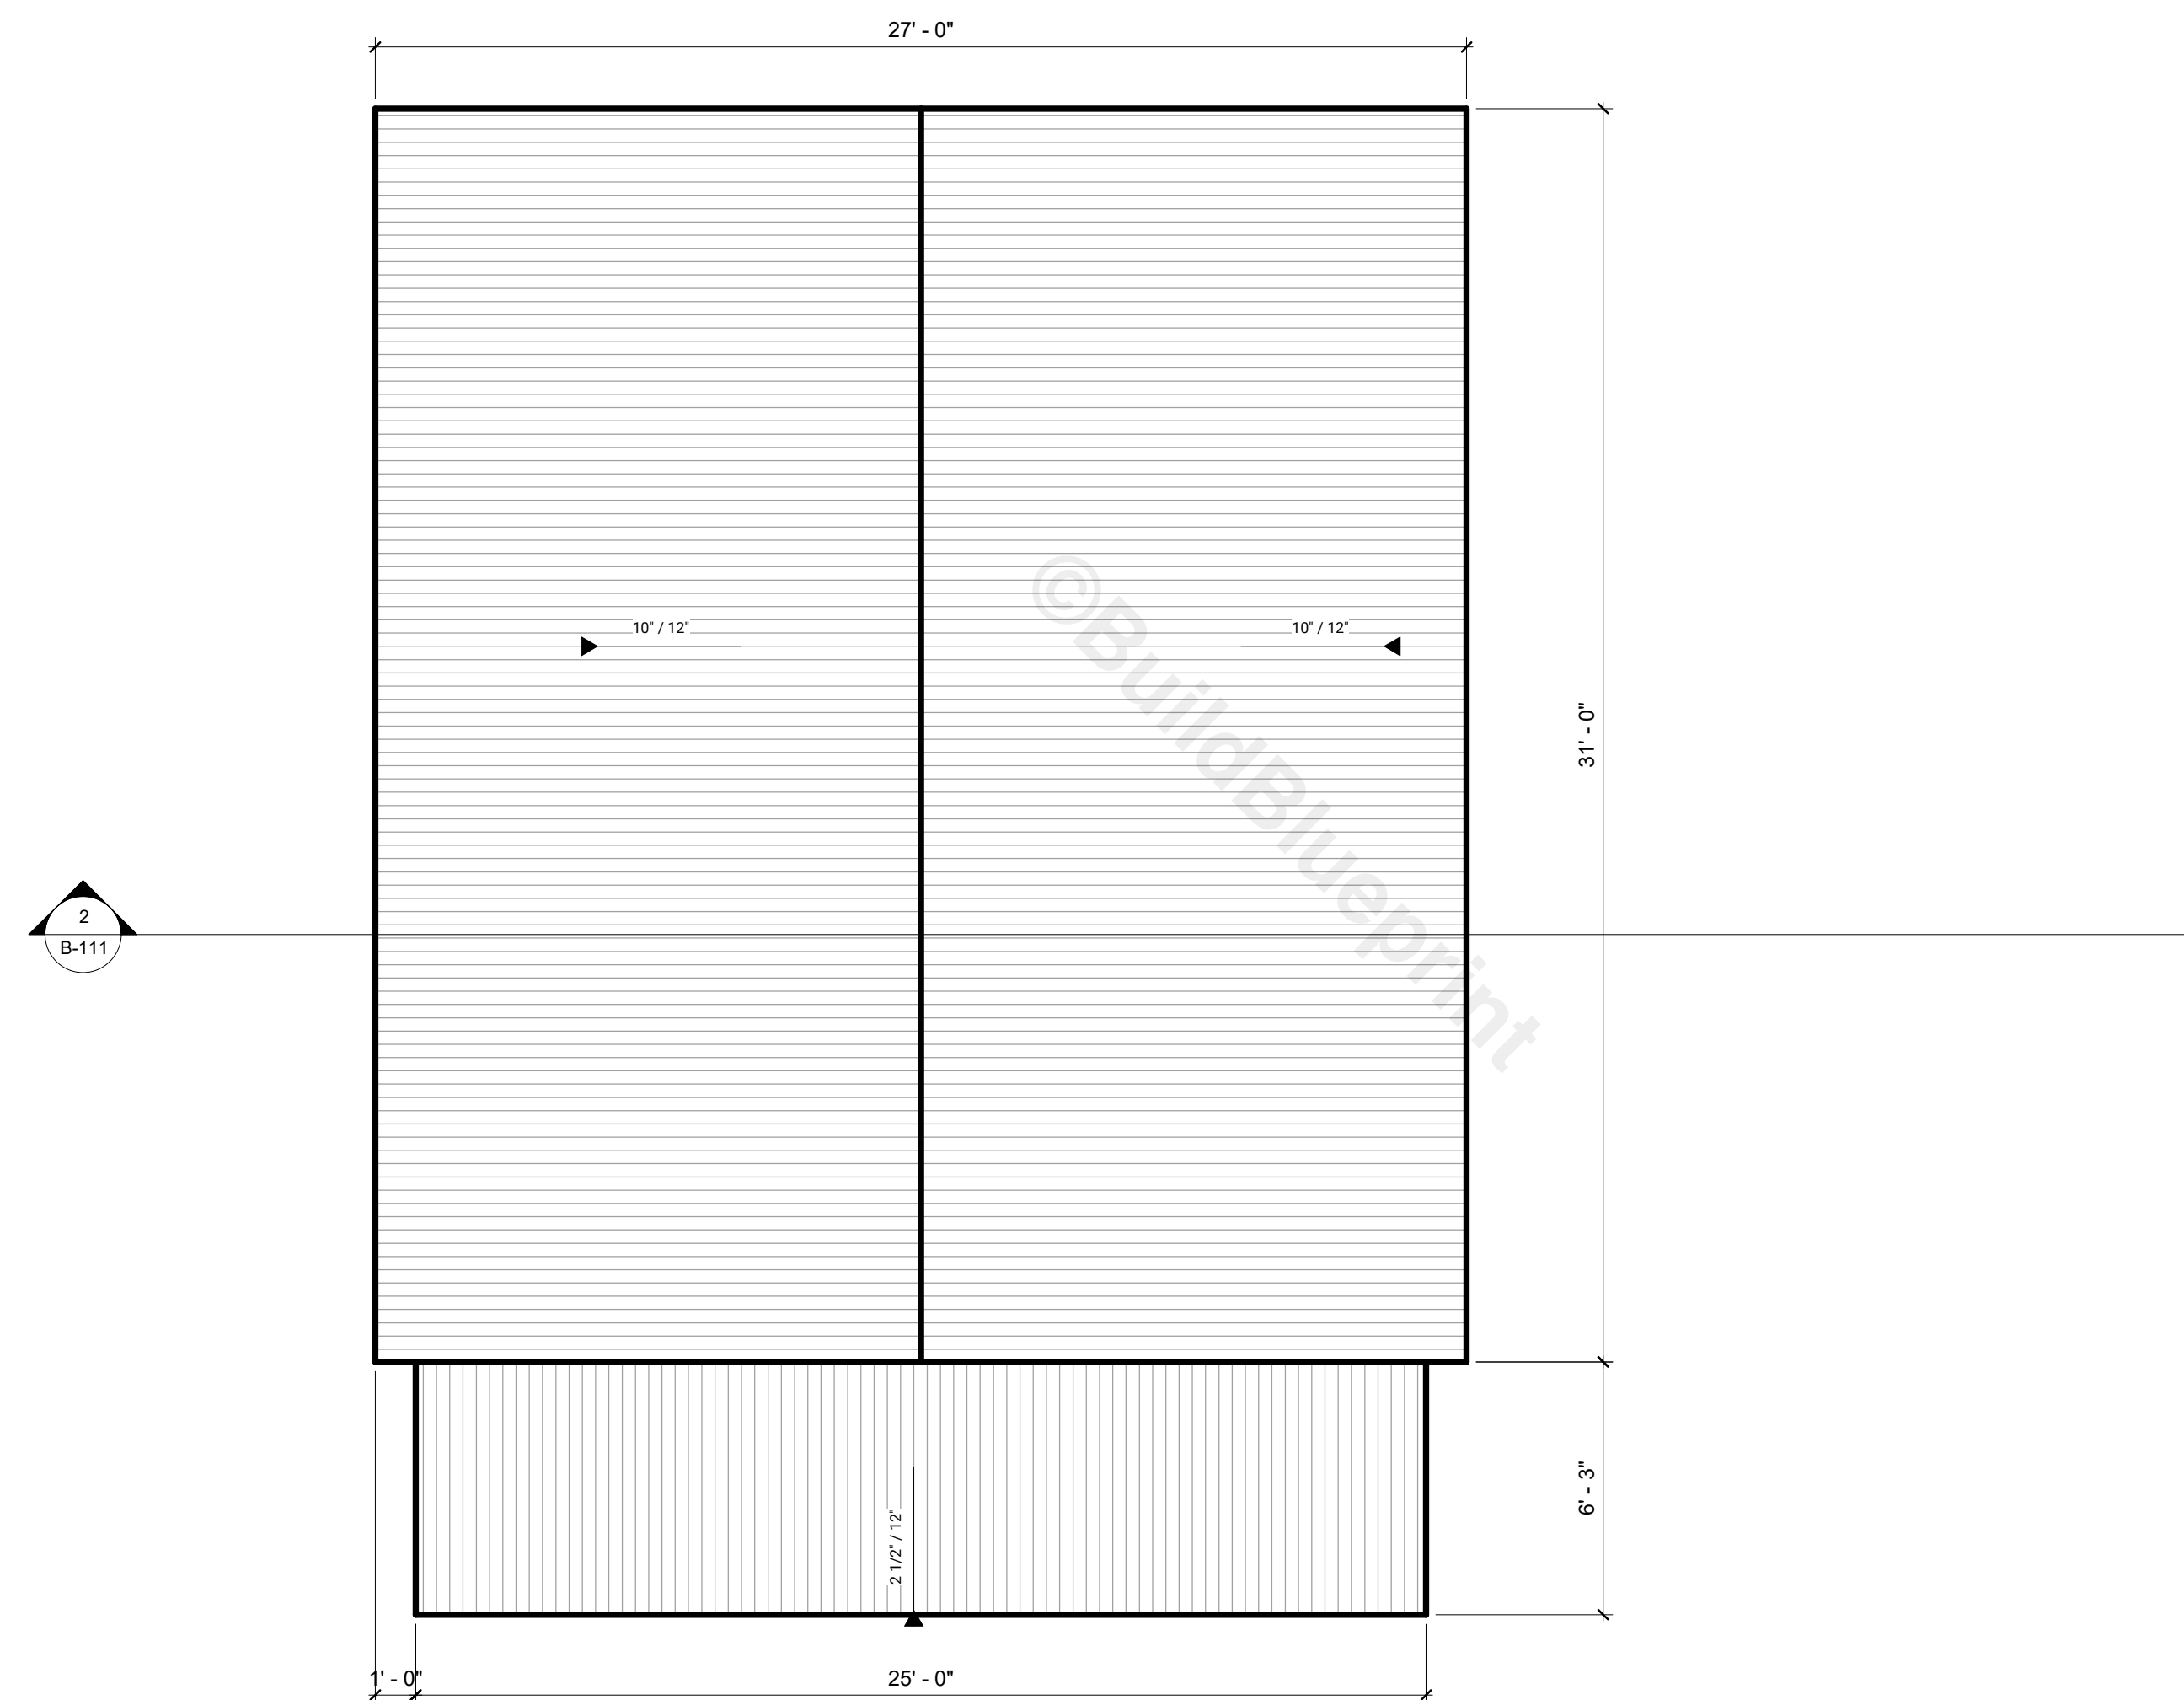

ROOF PLAN

SCALE = 3/16" : 1' - 0"

No.	Description	Date

28x24 HONEYCREEK CABIN

ROOF PLAN


Project number	BB-HP0032
Date	
Drawn by	B.B
Checked by	J.L

B-109

Sheet Number	
Scale	1/4" = 1'-0"

NOTES

1. DRAWINGS SHOULD BE PRINTED ON ANSI C SIZE PAPER TO ENSURE ACCURATE SCALE PRINTING 1/4" = 1'-0"
2. CONSTRUCTION DETAILS ILLUSTRATED IN THIS SET ARE TYPICAL, CONSULT WITH YOUR BUILDER FOR DETAILS THAT MEETS YOUR LOCAL BUILDING CODE.
3. MATERIALS AND FINISHES ILLUSTRATED IN THIS SET ARE TYPICAL, AND SHOULD BE VERIFIED BY YOUR BUILDER OR DESIGNER BEFORE CONSTRUCTION.
4. THIS DRAWING SET IS NOT INTENDED FOR PERMITTING OR CONSTRUCTION. CONSULT WITH YOUR LOCAL BUILDING DEPARTMENT FOR BUILDING CODE REQUIREMENTS.

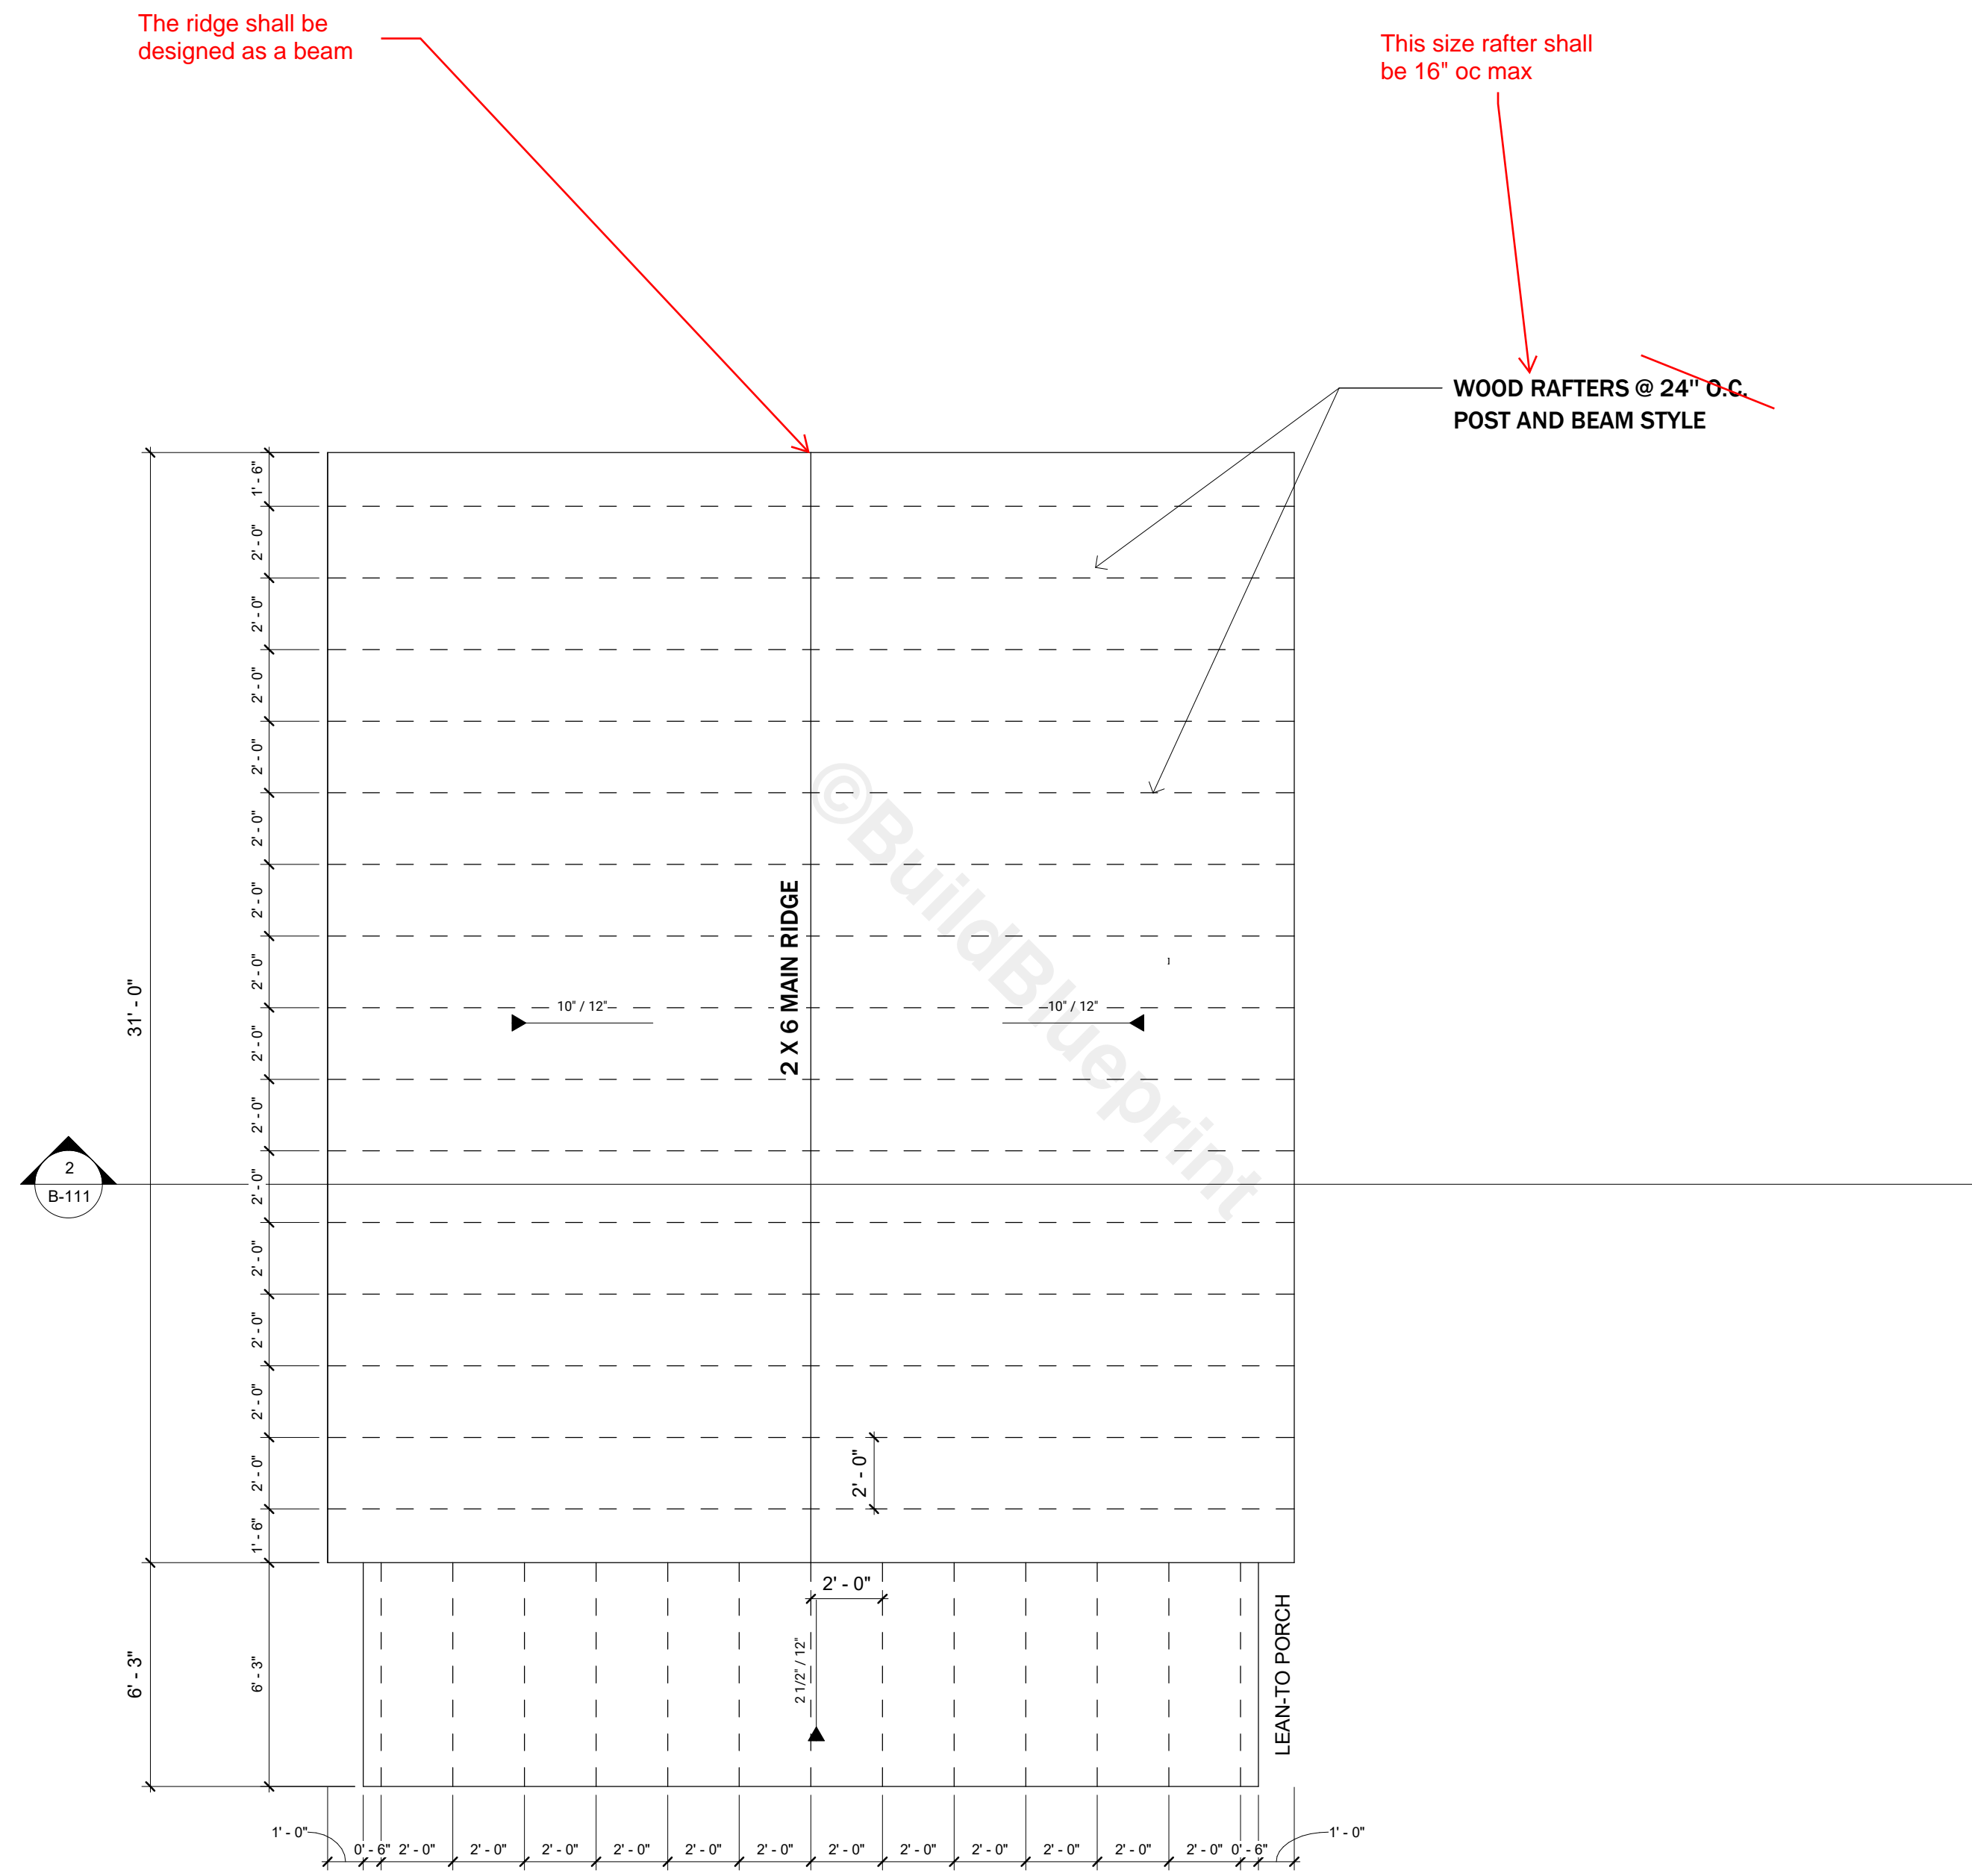

ROOF FRAMING PLAN

SCALE = 1/4" : 1' - 0"

No.	Description	Date

28x24 HONEYCREEK CABIN

ROOF FRAMING PLAN


Project number	BB-HP0032
Date	
Drawn by	B.B
Checked by	J.L

B-110

Sheet Number	
Scale	1/4" = 1'-0"

NOTES

1. DRAWINGS SHOULD BE PRINTED ON ANSI C SIZE PAPER TO ENSURE ACCURATE SCALE PRINTING 3/8" = 1'-0"
2. CONSTRUCTION DETAILS ILLUSTRATED IN THIS SET ARE TYPICAL, CONSULT WITH YOUR BUILDER FOR DETAILS THAT MEETS YOUR LOCAL BUILDING CODE.
3. MATERIALS AND FINISHES ILLUSTRATED IN THIS SET ARE TYPICAL, AND SHOULD BE VERIFIED BY YOUR BUILDER OR DESIGNER BEFORE CONSTRUCTION.
4. THIS DRAWING SET IS NOT INTENDED FOR PERMITTING OR CONSTRUCTION. CONSULT WITH YOUR LOCAL BUILDING DEPARTMENT FOR BUILDING CODE REQUIREMENTS.

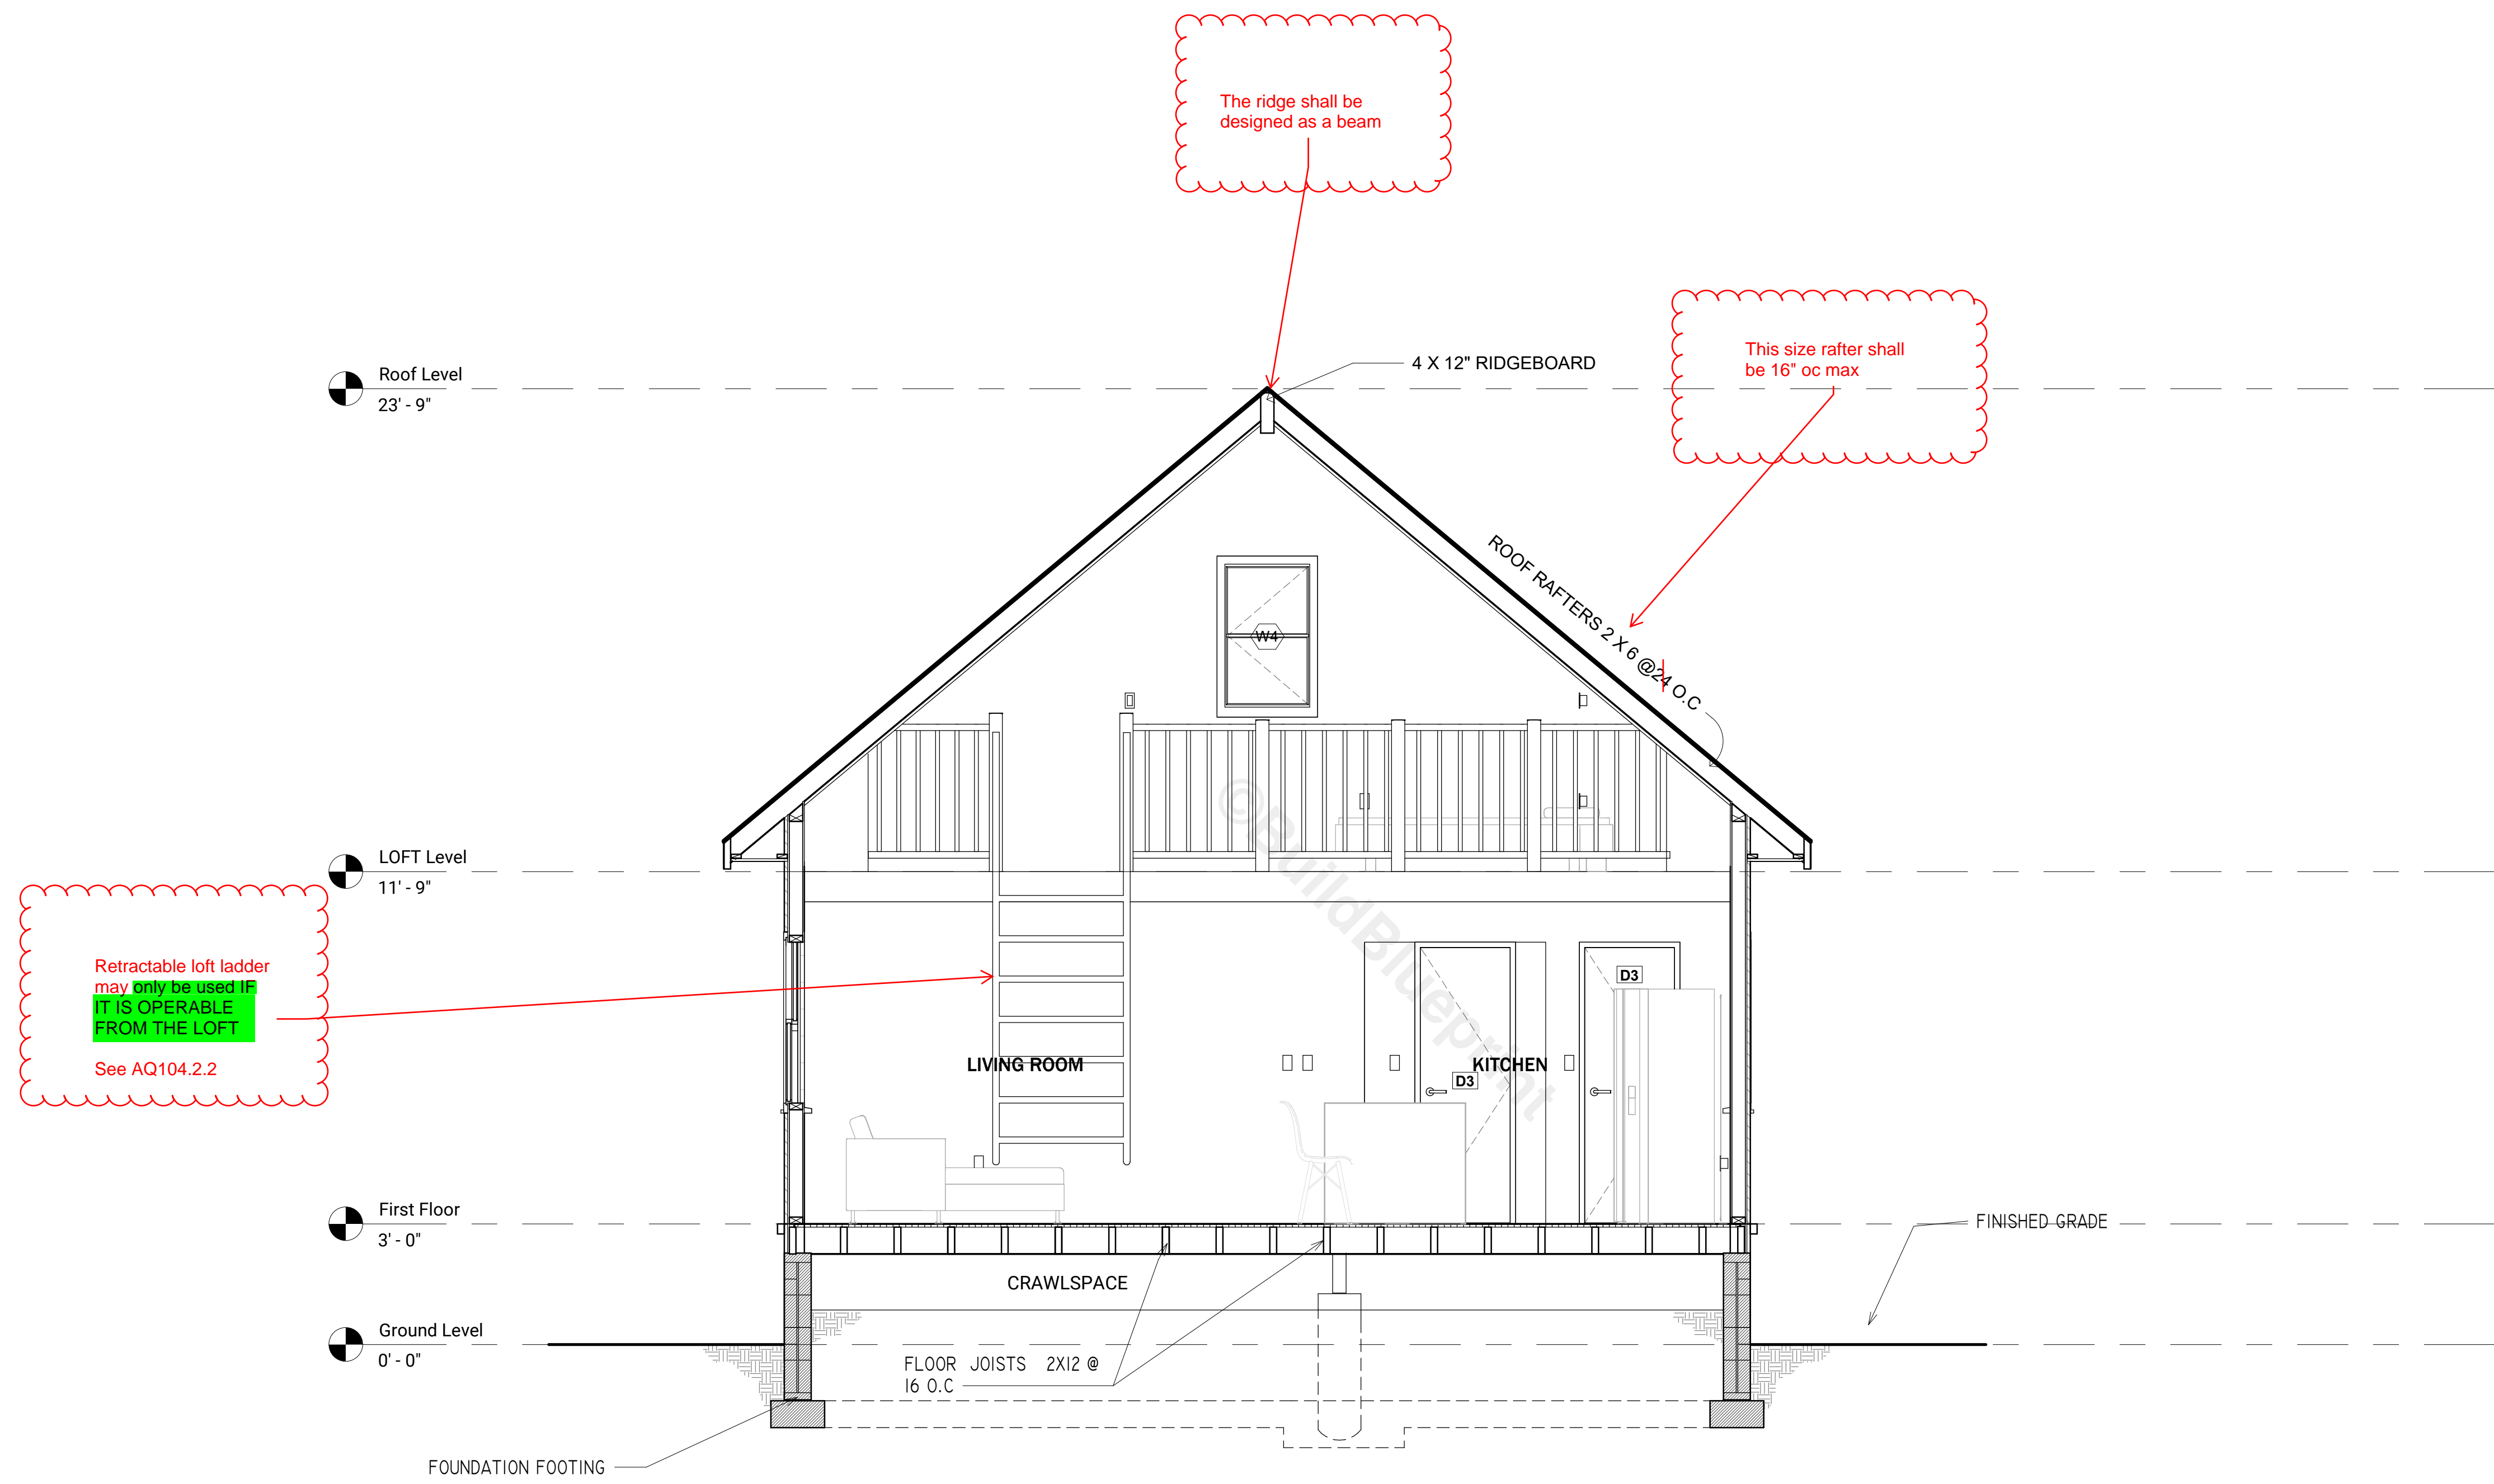

SECTION

SCALE = 3/8" : 1' - 0"

No.	Description	Date

28x24 HONEYCREEK CABIN


SECTION DETAIL

Project number	BB-HP0032
Date	
Drawn by	B.B
Checked by	J.L

B-111

Sheet Number	
Scale	3/8" = 1'-0"

ALL DIMENSIONS TO BE VERIFIED ON SITE

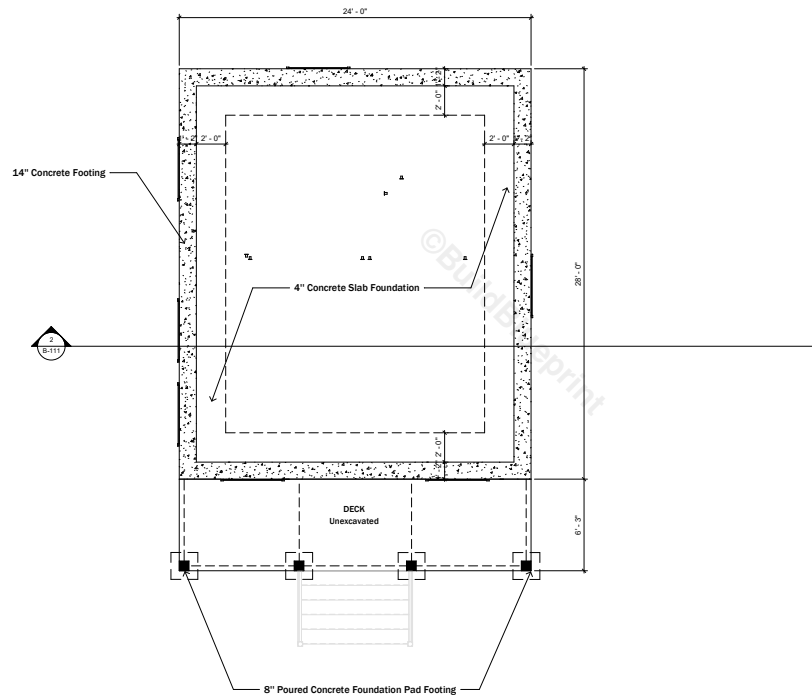

FOUNDATION PLAN (Concrete Block)
SCALE = 1/4" : 1' - 0"

NOTES

1. DRAWINGS SHOULD BE PRINTED ON ANSI C SIZE PAPER TO ENSURE ACCURATE SCALE PRINTING 1/4" = 1'-0"
2. CONSTRUCTION DETAILS ILLUSTRATED IN THIS SET ARE TYPICAL. CONSULT WITH YOUR BUILDER FOR DETAILS THAT MEETS YOUR LOCAL BUILDING CODE.
3. MATERIALS AND FINISHES ILLUSTRATED IN THIS SET ARE TYPICAL AND SHOULD BE VERIFIED BY YOUR BUILDER OR DESIGNER BEFORE CONSTRUCTION.
4. THIS DRAWING SET IS NOT INTENDED FOR PERMITTING OR CONSTRUCTION. CONSULT WITH YOUR LOCAL BUILDING DEPARTMENT FOR BUILDING CODE REQUIREMENTS.

No.	Description	Date

28x24 HONEYCREEK CABIN

FOUNDATION III- SLAB

Project number **BB-HP0032**
Date
Drawn by **B.B**
Checked by **J.L**


 
 
 
B-103

Sheet Number
Scale **1/4" = 1'-0"**

NOTES

1. DRAWINGS SHOULD BE PRINTED ON ANSI C SIZE PAPER TO ENSURE ACCURATE SCALE PRINTING 3/8" = 1'-0"
2. CONSTRUCTION DETAILS ILLUSTRATED IN THIS SET ARE TYPICAL. CONSULT WITH YOUR BUILDER FOR DETAILS THAT MEETS YOUR LOCAL BUILDING CODE.
3. MATERIALS AND FINISHES ILLUSTRATED IN THIS SET ARE TYPICAL AND SHOULD BE VERIFIED BY YOUR BUILDER OR DESIGNER BEFORE CONSTRUCTION.
4. THIS DRAWING SET IS NOT INTENDED FOR PERMITTING OR CONSTRUCTION. CONSULT WITH YOUR LOCAL BUILDING DEPARTMENT FOR BUILDING CODE REQUIREMENTS.

DOOR SCHEDULE

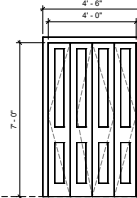

FL						
Mark/Tag	D1	D2	D3	D4		
Quantity	1	2	2	1		
Location	Entrance(Living Room)	Bedroom	Utility Baths	Closet		
Description	Timber Panel Door External Door Paint Finished	Timber Flush door Interior Door Plywood Sheath Finished	Timber Flush door Interior Door Plywood Sheath Finished	Bifold Door 4 Panel Interior Door Paint Finished		

No.	Description	Date

28x24 HONEYCREEK CABIN

DOOR SCHEDULES

Project number **BB-HP0032**
Date
Drawn by **B.B**
Checked by **J.L**

 
 


C-101

Sheet Number
Scale **3/8" = 1'-0"**

NOTES

- DRAWINGS SHOULD BE PRINTED ON ANSI C SIZE PAPER TO ENSURE ACCURATE SCALE PRINTING 3/8" = 1'-0"
- CONSTRUCTION DETAILS ILLUSTRATED IN THIS SET ARE TYPICAL, CONSULT WITH YOUR BUILDER FOR DETAILS THAT MEETS YOUR LOCAL BUILDING CODE.
- MATERIALS AND FINISHES ILLUSTRATED IN THIS SET ARE TYPICAL, AND SHOULD BE VERIFIED BY YOUR BUILDER OR DESIGNER BEFORE CONSTRUCTION.
- THIS DRAWING SET IS NOT INTENDED FOR PERMITTING OR CONSTRUCTION, CONSULT WITH YOUR LOCAL BUILDING DEPARTMENT FOR BUILDING CODE REQUIREMENTS.

WINDOWS SCHEDULE

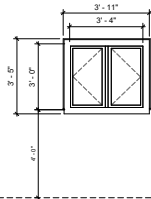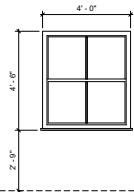

FL						
Mark/Tag	W1	W2	W3	W4		
Quantity	6	1	1	2		
Location	Living Room Bedroom Kitchen	Kitchen Window	Bath	Loft (Upper Levels)		
Description	Double Casement Window with Exterior trim Double glazed Wood frame	Double Casement Window with Exterior trim Double glazed Wood frame	Single Casement Window Double glazed Wood frame	Hung Window Double glazed Wood frame		

No.	Description	Date

28x24 HONEYCREEK CABIN

WINDOW SCHEDULE

Project number **BB-HP0032**

Date _____


Drawn by **B.B**

Checked by **J.L**


C-102

Sheet Number _____

Scale **3/8" = 1'-0"**

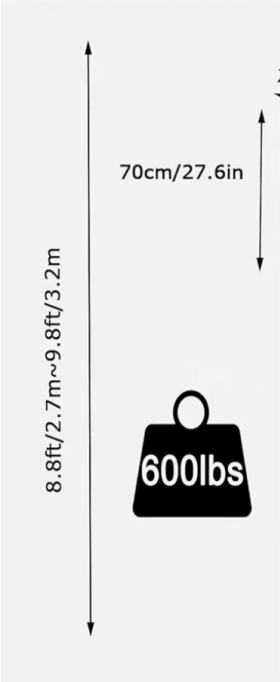

70cm/27.6in

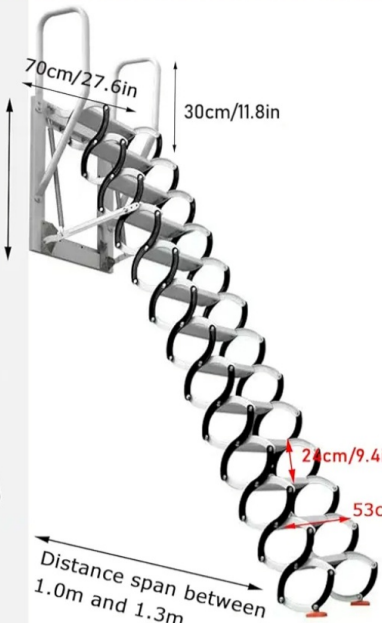

Retractable Loft Access Ladder, Wide 27.6in attic Ladder Pull Down System, Wall Mounted Telescoping Staircase for Wall Height 8.8~9.8ft, for Home/Garage/loft Storage, 660lb Capacit (12 Steps)

