



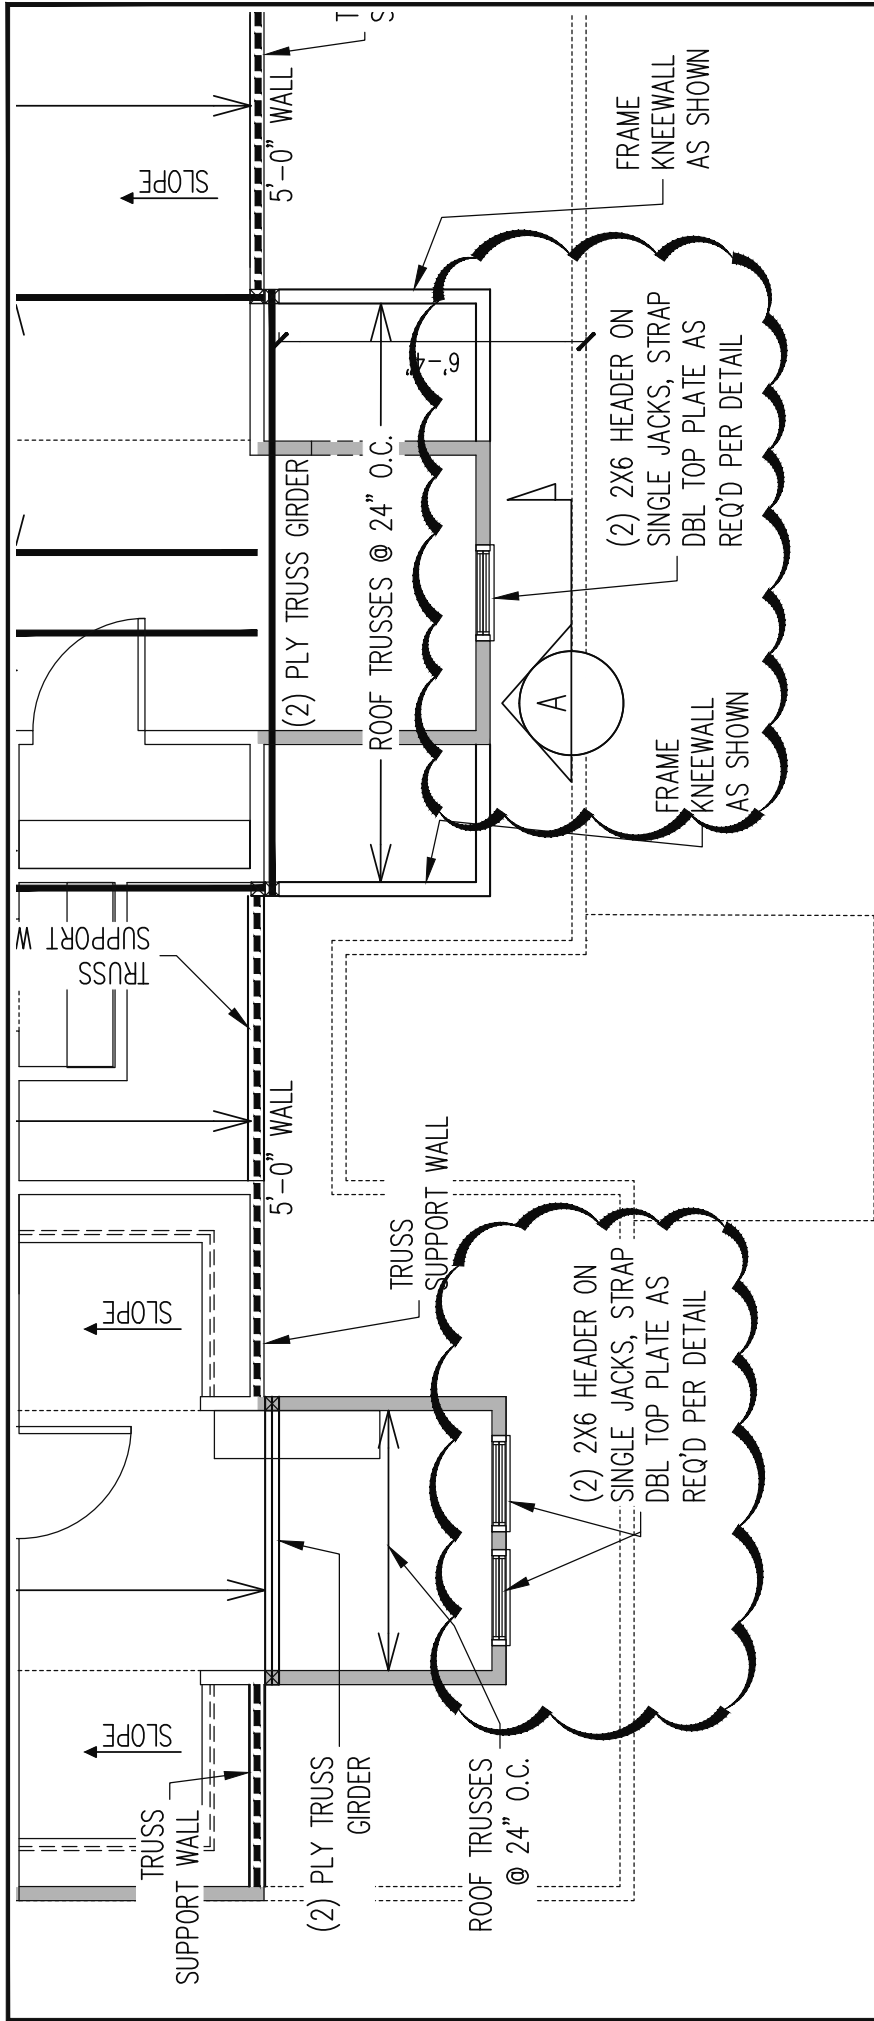

2ND FLOOR FRAMING PLAN

WALLS AND CEILING - 1/4" = 1'-0"

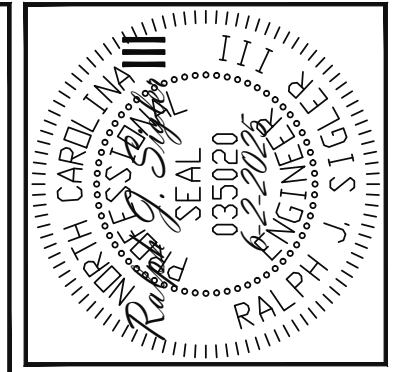

Engineering Tech
ASSOCIATES, P.A.

STRUCTURAL ENGINEERS
License No. C-3870
318 W Millbrook Rd. Unit 201
Raleigh, North Carolina 27609
Phone (919) 844-1661



NEW HOME INC			
SCOPE	HEADER SWAP, DESIGN ONLY		
LOC	103 DUNCAN'S CREEK	REV #	REF PROJ #
		DATE	

ENG	RJS/MEB
DATE	6-2-2025

PARENT
24-65-400_131

PROJECT NO.
25-75-582

SHEET NO.
SL1
1 of 2

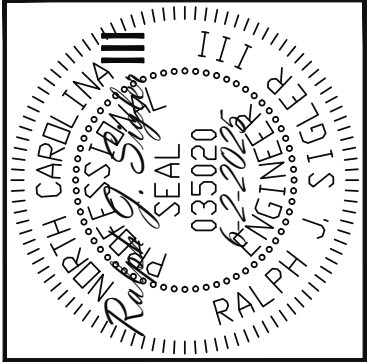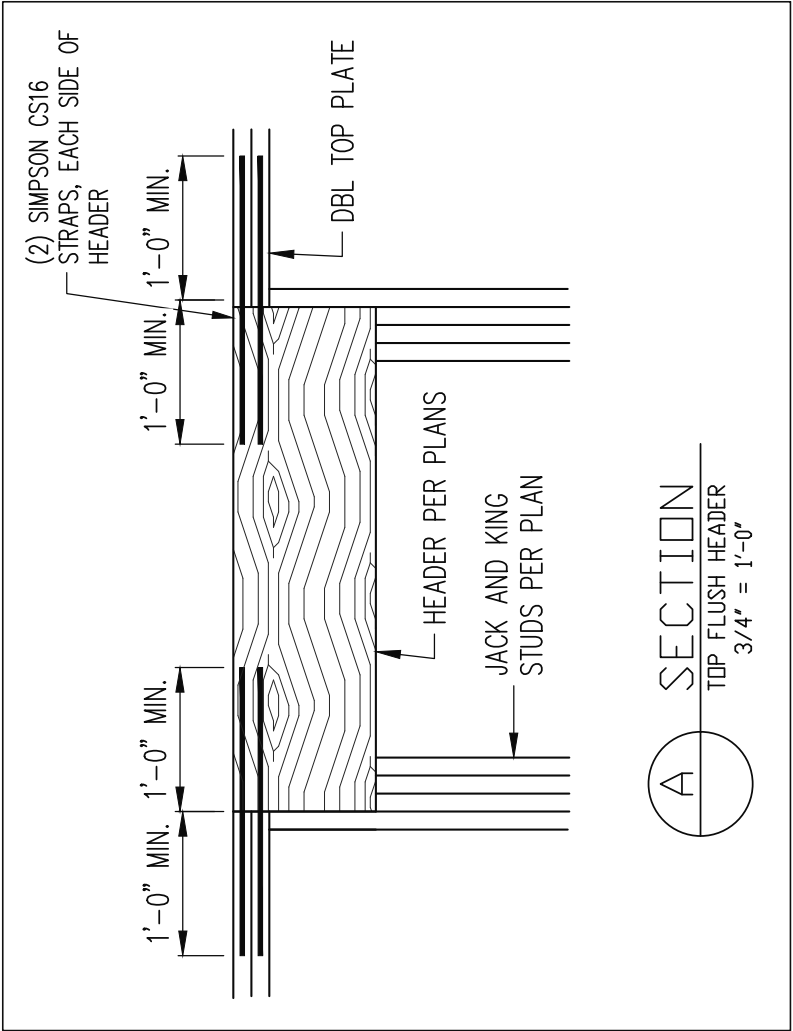

Engineering
Lech
ASSOCIATES, P.A.

STRUCTURAL ENGINEERS
License No. C-3870
318 W Millbrook Rd. Unit 201
Raleigh, North Carolina 27609
Phone (919) 844-1661

NEW HOME INC			
SCOPE:	HEADER SWAP, DESIGN ONLY		
LOC:	103 DUNCAN'S CREEK	REV #	REF PROJ #
			DATE

ENG:	RJS/MEB
DATE:	6-2-2025

PARENT
24-65-400_131

PROJECT NO.
25-75-582

SHEET NO.
SL2
2 of 2