


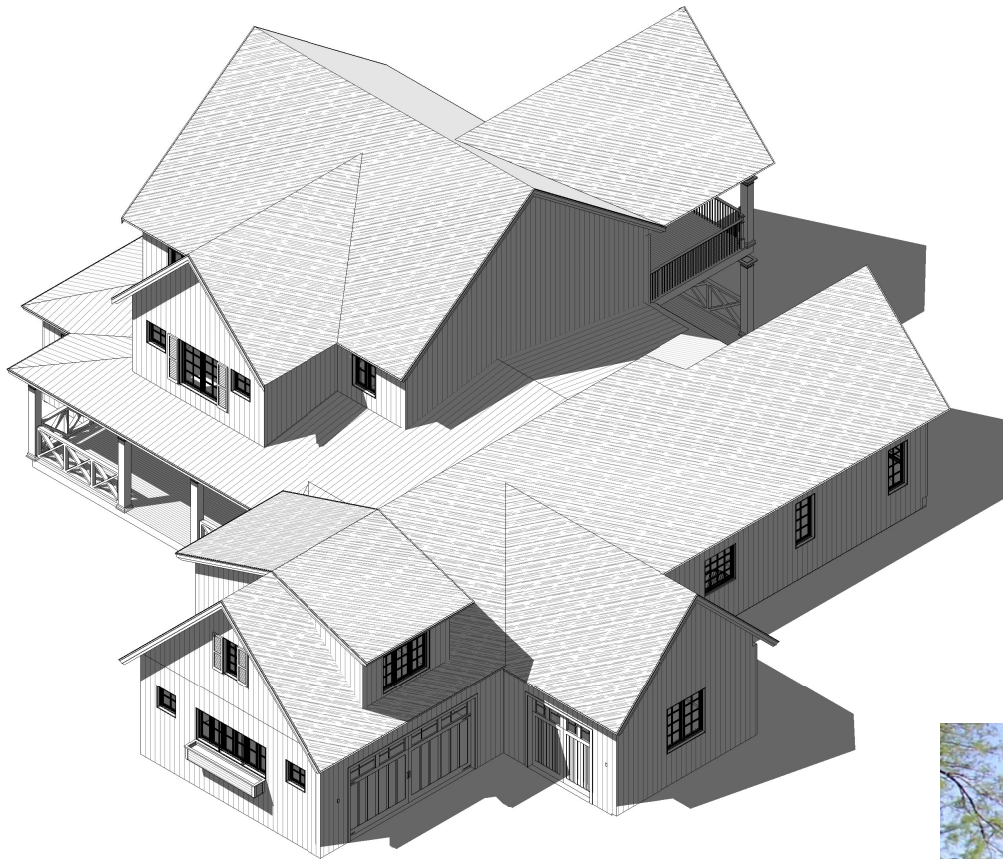

1 AERIAL

FIRST FLOOR HEATED SF - 2,935 SF
SECOND FLOOR HEATED SF - 1,150 SF
BONUS ROOM - 355 SF
GARAGE - 980 SF
FRONT PORCH - 258 SF
REAR PORCH - 285 SF
DECK - 115 SF



dowds
DESIGN COLLECTION, LLC



1331 SAINT ANDREWS DR.
MEBANE, NC 27302
PHONE: 919-563-1818
LAURADOWDS@LIVE.COM
WWW.DOWDSDESIGNCOLLECTION.COM



BRIAN J. PILLING, AIA
78 RIDGE POINT DRIVE
CORDELLA, NC 27827
PHONE 252-202-7590
bjaarchitect@gmail.com
www.intelligenthouseplans.com

LOCAL PROFESSIONAL'S SEAL

PLAN #71120

ARIAL VIEW

EVERY ATTEMPT HAS BEEN MADE IN THE PREPARATION OF THESE DRAWINGS TO ACCURATELY REPRESENT THE CLIENT'S REQUIREMENTS. THE CLIENTS ACCEPTS THE RESPONSIBILITY FOR THE ACCURACY OF THE INFORMATION PROVIDED AND THE DESIGNER'S LIABILITY FOR ANY ERRORS OR OMISSIONS IN THESE DRAWINGS.

ALL DRAWINGS SHOULD BE REVIEWED BY LOCAL PROFESSIONAL TO ASSURE COMPLIANCE WITH LOCAL & STATE CODES. MODIFICATIONS TO THESE DRAWINGS ARE THE RESPONSIBILITY OF THE CLIENT.


REVISIONS	
NO.	DATE/DESCRIPTION

DATE
PLAN NUMBER

SHEET NUMBER

CS

THESE DRAWINGS CAN NOT BE USED, COPIED, REPRODUCED, IN WHOLE OR PART OR MANNER WHAT SO EVER WITHOUT PERMISSION FROM BRIAN J. PILLING, AIA

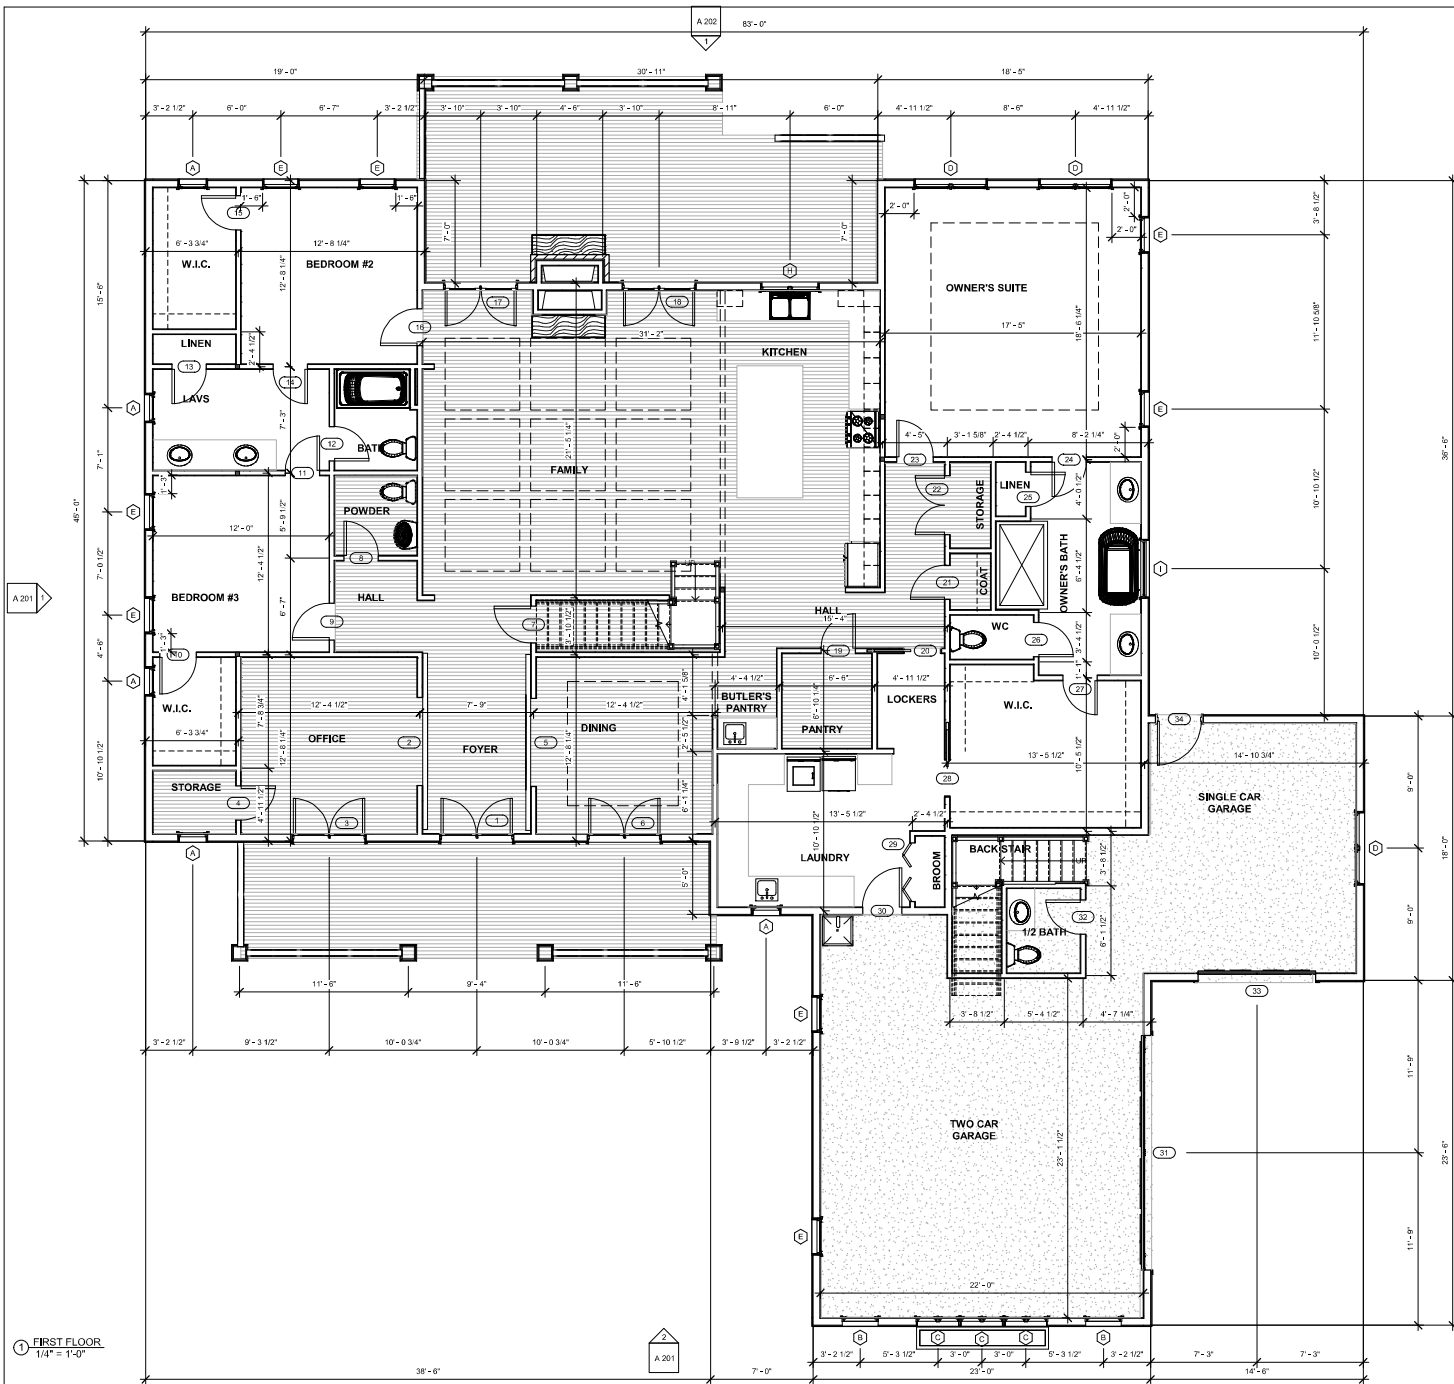

dowds
DESIGN COLLECTION, LLC

1331 SAINT ANDREWS DR.
MEBANE, NC 27302
PHONE: 919-563-1818
LAURADOWDS@LIVE.COM
WWW.DOWDSDESIGNCOLLECTION.COM



BRIAN J. PILLING, AIA
738 RIDGE POINT DRIVE
CORDELLA, NC 27827
PHONE 252-202-7590
bjarichitect@gmail.com
www.intelligenthouseplans.com

LOCAL PROFESSIONAL'S SEAL

PLAN #71120

FIRST FLOOR PLAN

Door Schedule			
Mark	Type	Width	Height
1	5068 FRENCH	5'-0"	6'-8"
2	BARN	6'-0"	6'-8"
3	5068 FRENCH	5'-0"	6'-8"
4	2468	2'-4"	6'-8"
5	BARN	6'-0"	6'-8"
6	5068 FRENCH	5'-0"	6'-8"
7	2668	2'-6"	6'-8"
8	2468	2'-4"	6'-8"
9	2668	2'-6"	6'-8"
10	2668	2'-6"	6'-8"
11	2468	2'-4"	6'-8"
12	2468	2'-4"	6'-8"
13	2468	2'-4"	6'-8"
14	2468	2'-4"	6'-8"
15	2468	2'-4"	6'-8"
16	2668	2'-6"	6'-8"
17	5068 FRENCH	5'-0"	6'-8"
18	5068 FRENCH	5'-0"	6'-8"
19	2468	2'-4"	6'-8"
20	2668 POCKET	2'-6"	6'-8"
21	2468	2'-4"	6'-8"
22	4068 DOUBLE	4'-0"	6'-8"
23	2668	2'-6"	6'-8"
24	2468	2'-4"	6'-8"
25	2468	2'-4"	6'-8"
26	2468	2'-4"	6'-8"
27	2468	2'-4"	6'-8"
28	2668 POCKET	2'-6"	6'-8"
29	4068 BIFOLD	4'-0"	6'-8"
30	2868	2'-8"	6'-8"
31	16'0"x8'0"	16'-0"	8'-0"
32	2468	2'-4"	6'-8"
33	8'0"x8'0"	8'-0"	8'-0"
34	3068 ENTRY	3'-0"	6'-8"
35	BARN	3'-6"	6'-8"
36	5068 FRENCH	5'-0"	6'-8"
37	5068 FRENCH	5'-0"	6'-8"
38	2668	2'-6"	6'-8"
39	2468	2'-4"	6'-8"
40	2468	2'-4"	6'-8"
41	2068	2'-0"	6'-8"
42	264POCKET	2'-4"	6'-8"
43	2668	2'-6"	6'-8"
44	4068 DOUBLE	4'-0"	6'-8"

Window Schedule			
Type Mark	Rough Width	Rough Height	Type
A	2'-0 1/2"	4'-0 1/2"	2040 CASEMENT
B	2'-6 1/2"	2'-6 1/2"	2626
C	3'-0 1/2"	3'-6 1/2"	2-1636 CASEMENT
D	5'-0 1/2"	5'-0 1/2"	2-2650 CASEMENT
E	2'-6 1/2"	5'-0 1/2"	2650 CASEMENT
F	2'-6 1/2"	4'-0 1/2"	2640 CASEMENT
G	6'-0 1/2"	5'-0 1/2"	3-2050 CASEMENT
H	4'-0 1/2"	4'-0 1/2"	2-2040 CASEMENT
I	4'-0 1/2"	4'-0 1/2"	4040 FIXED



EVERY ATTEMPT HAS BEEN MADE IN THE PREPARATION OF THESE DRAWINGS TO AVOID NEGLIGENCE AND OVERSIGHT. THE ARCHITECTS WILL NOT BE HELD LIABLE FOR ANY NEGLIGENCE OR OVERSIGHT IN THESE DRAWINGS.

ALL DIMENSIONS SHOWN ARE IN FEET AND INCHES. DIMENSIONS ARE GIVEN TO THE CENTERLINE UNLESS OTHERWISE NOTED. THE ARCHITECTS WILL NOT BE HELD LIABLE FOR ANY NEGLIGENCE OR OVERSIGHT IN THESE DRAWINGS.


REVISIONS	
NO.	DATE/DESCRIPTION

DATE
PLAN NUMBER


SHEET NUMBER

A 101

THESE DRAWINGS CAN NOT BE USED, COPIED, TRACED OR REPRODUCED, IN WHOLE OR PART OR MANNER WHAT SO EVER WITHOUT PERMISSION FROM BRIAN J. PILLING, AIA

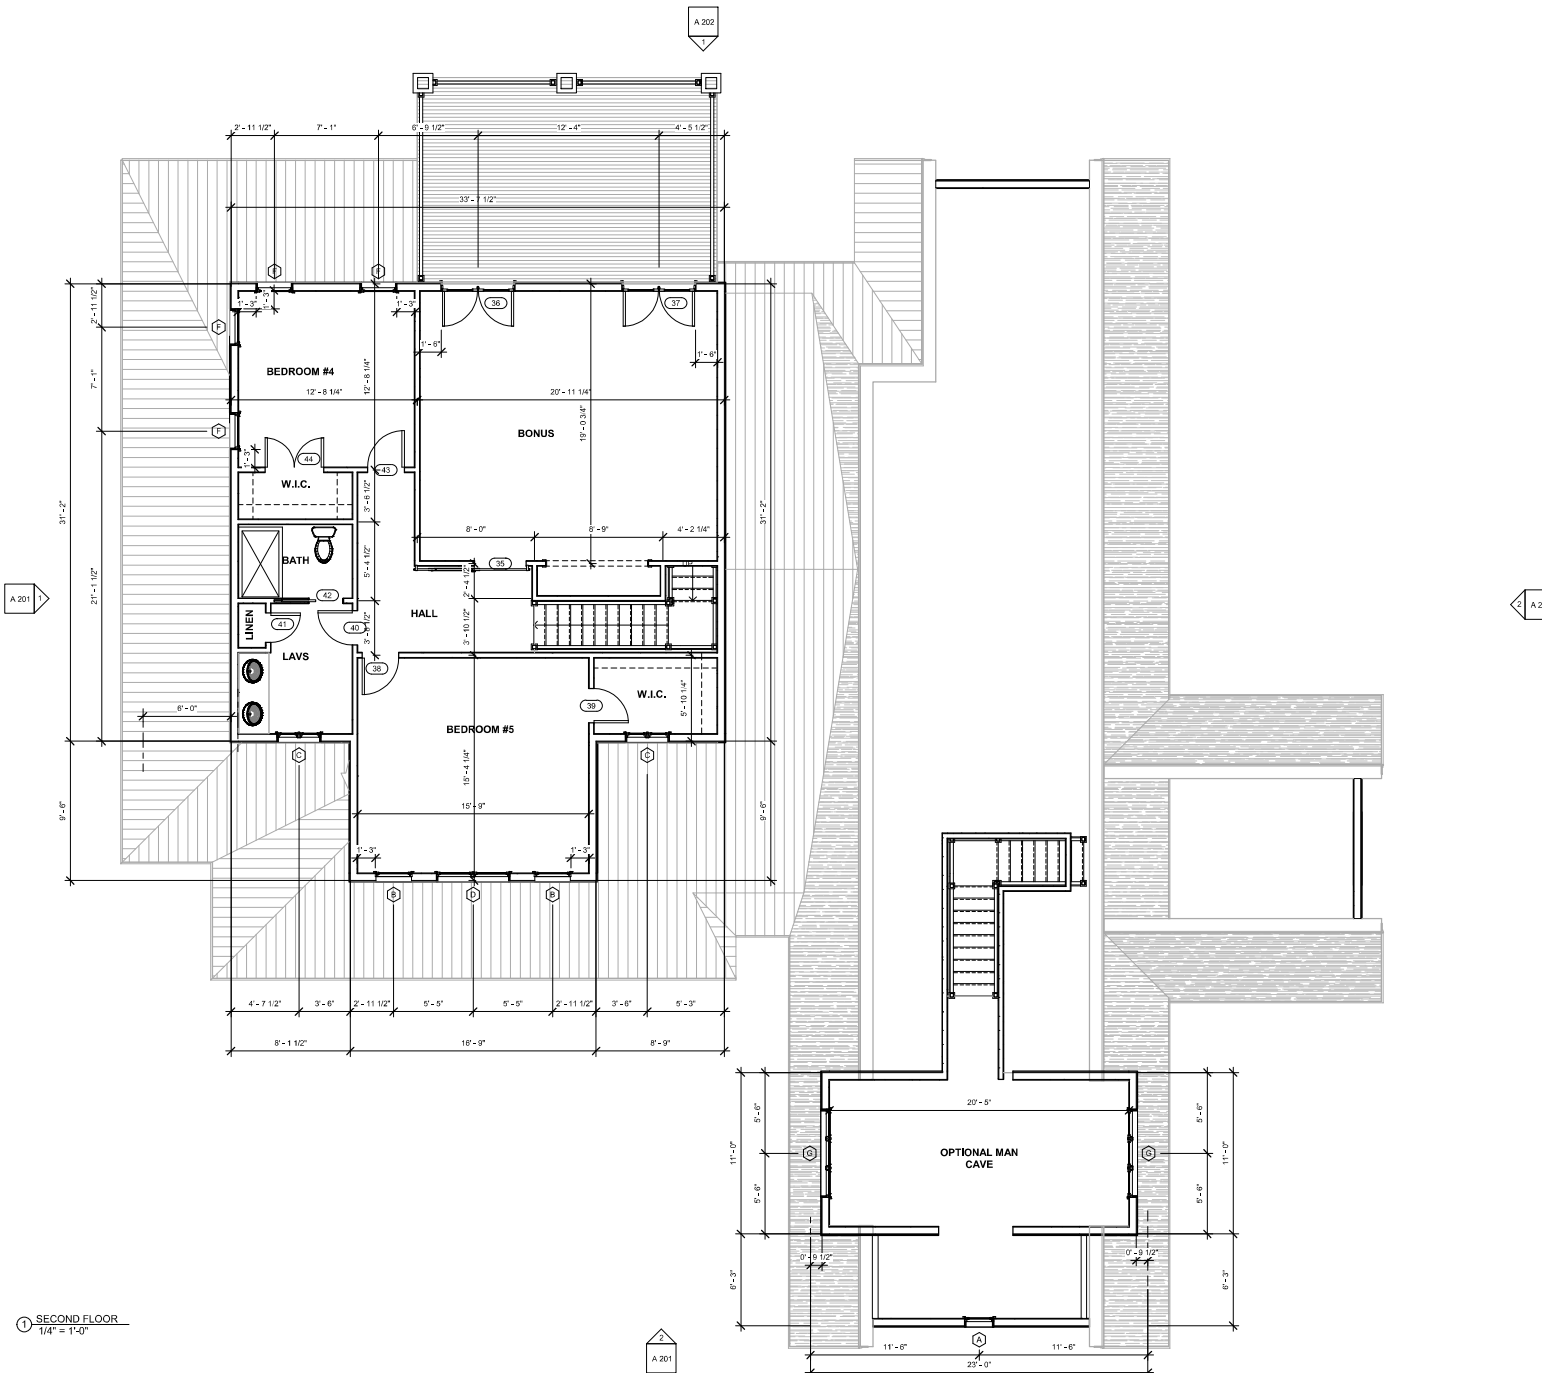

1 SECOND FLOOR
1/4" = 1'-0"

 

dowds
DESIGN COLLECTION, LLC

1331 SAINT ANDREWS DR.
MEBANE, NC 27302
PHONE: 919-563-1818
LAURADOWDS@LIVE.COM
WWW.DOWDSDESIGNCOLLECTION.COM

BRIAN J. PILLING, AIA
736 RIDGE POINT DRIVE
CORDELLA, NC 27527
PHONE 252-202-7590
bjaarchitect@gmail.com
www.intelligenthouseplans.com

LOCAL PROFESSIONAL'S SEAL

PLAN #71120

SECOND FLOOR PLAN

EACH ATTORNEY HAS BEEN MADE IN THE PREPARATION OF THESE DRAWINGS TO AVOID REPEATED AND UNNECESSARY COSTS TO THE CLIENTS. THE CLIENTS WILL NOT BE HELD LIABLE FOR ANY DAMAGES OR LOSSES IN THESE DRAWINGS.


ALL DIMENSIONS SHOWN ARE IN FEET AND INCHES. DIMENSIONS ARE APPROXIMATE AND SHOULD BE CONFIRMED WITH LOCAL BUILDING DEPARTMENT. THE RESPONSIBILITY OF THE CLIENT.

REVISIONS	
NO.	DATE/DESCRIPTION

DATE
PLAN NUMBER

SHEET NUMBER
A 102

 
① CRAWL SPACE
1/4" = 1'-0"



1331 SAINT ANDREWS DR.
MEBANE, NC 27302
PHONE: 919-563-1818
LAURADOWDS@LIVE.COM
WWW.DOWSDSDESIGNCOLLECTION.COM



 LOCAL PROFESSIONAL'S SEAL



FOUNDATION PLAN

ALL DRAWINGS SHOULD BE
REVIEWED BY LOCAL PROFESSIONALS
TO ASSURE CONFORMANCE WITH
LOCAL & STATE CODES.
ADDITIONAL ENGINEERING WORK IS
THE RESPONSIBILITY OF THE
CLIENT.

DATE
PLAN NUMBER

SHEET NUMBER


1000

S 101

THESE DRAWINGS CAN NOT BE USED, COPIED, REPRODUCED, IN WHOLE OR PART OR MANNER WHAT SO EVER WITHOUT PERMISSION FROM BRIAN J. PILLING, AIA

1 ROOF PLAN
1/4" = 1'-0"

A 201

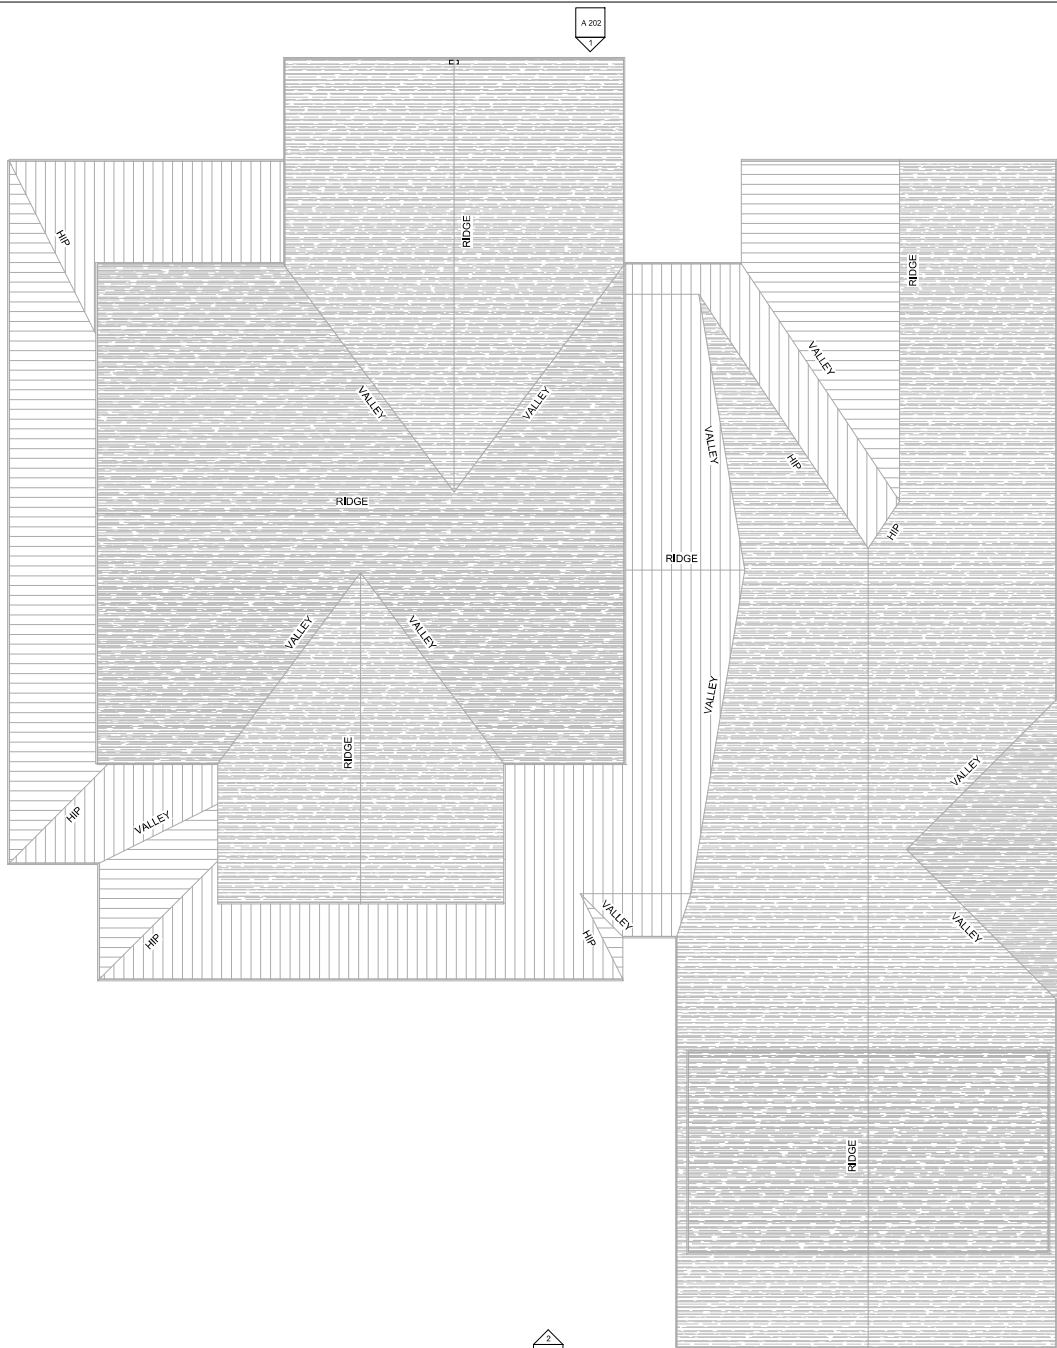

A 203



FIRE BLOCKING
PROVIDE FIREBLOCKING AS PER BUILDING CODE
MAXIMUM AREA OF CONCEALED SPACE IS TO BE 1000 SQ. FT.
PROVIDE FIRE BLOCKING IN CONCEALED SPACES OF STUDS
VERTICALLY AT CEILING AND FLOOR LEVELS
HORIZONTALLY AT INTERVALS NOT EXCEEDING 10'-0"
AT ALL INTERCONNECTIONS BETWEEN CONCEALED VERTICAL AND HORIZONTAL SPACES
IN SPACES BETWEEN STAIR STRINGERS AT TOP AND BOTTOM OF RUN
AT OPENINGS AROUND VENTS, PIPES AND DUCTS AT CEILING AND FLOOR LEVELS

NOTE:
ALL RIDGE, VALLEY AND RAFTER BRACING
TO BEAR ON LOAD BEARING WALLS
DESIGNED TO CARRY LOAD THROUGH ALL
LEVELS AND TERMINATE AT FOUNDATION
DESIGNED TO CARRY LOAD.

NOTE:
FIELD VERIFY ALL BEARING HEIGHTS

NOTE:
SEE SHEET S105 FOR ROOF
FRAMING SIZES (STICK BUILT)

NOTE:
ROOF OVERHANG IS 1'-4"
UNLESS NOTED OTHERWISE

NOTE:
VENTILATION SHALL COMPLY WITH CODE.
ENCLOSED ATTICS AND ENCLOSED
RAFTER SPACES FORMED WHERE CEILINGS
ARE APPLIED DIRECTLY TO THE UNDERSIDE
OF ROOF RAFTERS SHALL HAVE CROSS
VENTILATION FOR EACH SEPARATE SPACE
BY VENTILATION OPENINGS PROTECTED
AGAINST THE ENTRANCE OF RAIN OR SNOW.
VENTILATING OPENINGS SHALL BE PROVIDED
WITH CORROSION-RESISTANT WIRE MESH.

NOTE:
PROVIDE RIDGE VENTS AS
CALCULATED TO MEET CODE

dowds

DESIGN COLLECTION, LLC

A

1331 SAINT ANDREWS DR.

MEBANE, NC 27302

PHONE: 919-563-1818

LAURADOWDS@LIVE.COM

WWW.DOWDSDESIGNCOLLECTION.COM

intelligent
houseplans

BRIAN J. PILLING, AIA

738 RIDGE POINT DRIVE

COROLLA, NC 27827

PHONE 252-202-7590

obarchitect@gmail.com

www.intelligenthouseplans.com

LOCAL PROFESSIONAL'S SEAL

PLAN #71120

ROOF PLAN

EVERY ATTEMPT HAS BEEN MADE IN
THE PREPARATION OF THESE
DRAWINGS TO AVOID NEGLIGENCE
AND OVERSIGHT. THE ARCHITECTS
WILL NOT BE HELD LIABLE FOR ANY
MISTAKES OR OMISSIONS IN THESE
DRAWINGS.

ALL DRAWINGS SHOULD BE
REVIEWED BY LOCAL PROFESSIONALS
TO ASSURE CONFORMANCE WITH
LOCAL & STATE CODES.
NOTHING IN THESE DRAWINGS SHALL
IMPLY THE RESPONSIBILITY OF THE
CLIENT.

REVISIONS

NO.	DATE/DESCRIPTION

DATE

PLAN NUMBER

\$-SET NUMBER

A 103

REVISIONS	
NO.	DATE/DESCRIPTION



DATE	PLAN NUMBER

SHEET NUMBER



② FRONT ELEVATION
1/4" = 1'-0"

Window Schedule			
Type Mark	Rough Width	Rough Height	Type
A	2' - 0 1/2"	14' - 0 1/2"	2040 CASEMENT
B	2' - 6 1/2"	2' - 6 1/2"	2626
C	3' - 0 1/2"	2' - 6 1/2"	2-1636 CASEMENT
D	5' - 0 1/2"	5' - 0 1/2"	2-2650 CASEMENT
E	2' - 6 1/2"	5' - 0 1/2"	2650 CASEMENT
F	2' - 6 1/2"	4' - 0 1/2"	2640 CASEMENT
G	6' - 0 1/2"	5' - 0 1/2"	3-2050 CASEMENT
H	4' - 0 1/2"	4' - 0 1/2"	2-2040 CASEMENT
I	4' - 0 1/2"	4' - 0 1/2"	4040 FIXED

 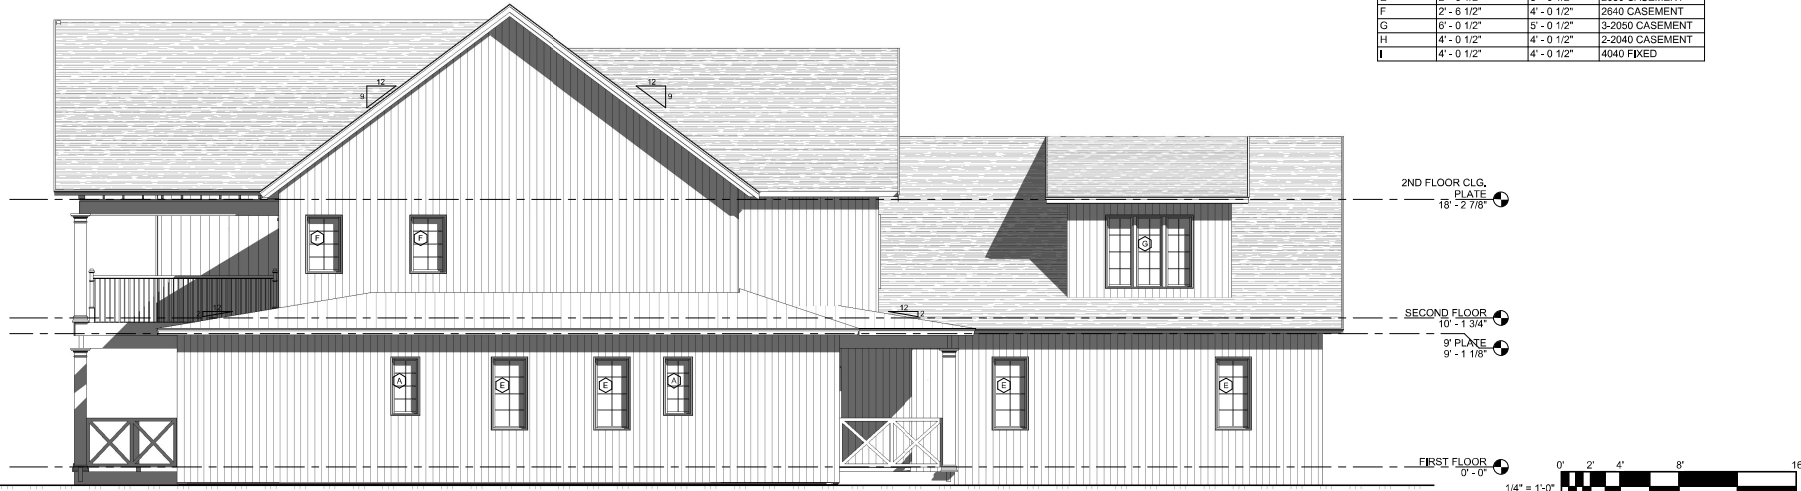

THESE DRAWINGS ARE NOT TO BE USED, COPIED, TRACED OR REPRODUCED IN WHOLE OR PART OR MANNER WHAT SO EVER WITHOUT PERMISSION FROM BRIAN J. PILLING, AIA



① REAR ELEVATION
1/4" = 1'-0"



② RIGHT ELEVATION
1/4" = 1'-0"



dowds
DESIGN COLLECTION, LLC

1331 SAINT ANDREWS DR.
MEBANE, NC 27302
PHONE: 919-563-1818
LAURADOWDS@LIVE.COM
WWW.DOWDSDESIGNCOLLECTION.COM



BRIAN J. PILLING, AIA
736 RIDGE POINT DRIVE
CORDELLA, NC 27827
PHONE 252-202-7550
bjarichitect@gmail.com
www.intelligenthouseplans.com



PLAN #71120

EXTERIOR ELEVATIONS

EVERY ATTEMPT HAS BEEN MADE IN THE PREPARATION OF THESE DRAWINGS TO AVOID ERRORS. HOWEVER, THE ARCHITECTS AND ENGINEERS ASSOCIATES SHALL NOT BE HELD LIABLE FOR ANY ERRORS OR OMISSIONS IN THESE DRAWINGS.

ALL DRAWINGS SHALL BE REVIEWED BY A LOCAL PROFESSIONAL ENGINEER OR ARCHITECT. THE ARCHITECTS AND ENGINEERS ASSOCIATES SHALL NOT BE HELD LIABLE FOR ANY ERRORS OR OMISSIONS IN THESE DRAWINGS.

REVISIONS	
NO.	DATE/DESCRIPTION


DATE
PLAN NUMBER

SHEET NUMBER

A 202



① FRONT PERSPECTIVE

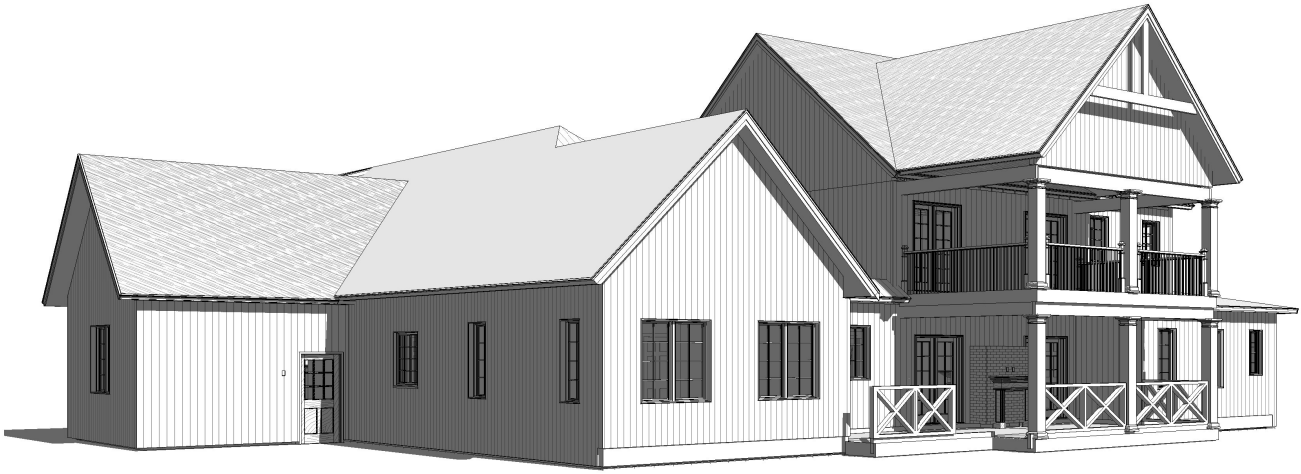

② REAR PERSPECTIVE

dowds
DESIGN COLLECTION, LLC

1331 SAINT ANDREWS DR.
MEBANE, NC 27302
PHONE: 919-563-1818
LAURADOWDS@LIVE.COM
WWW.DOWDSDESIGNCOLLECTION.COM

intelligent
houseplans
BRIAN J. PILLING, AIA
78 RIDGE POINT DRIVE
COROLLA, NC 27827
PHONE 252-202-7590
bjaarchitect@gmail.com
www.intelligenthouseplans.com

LOCAL PROFESSIONAL'S SEAL

PLAN #71120
EXTERIOR PERSPECTIVES

EVERY ATTEMPT HAS BEEN MADE IN THE PREPARATION OF THESE DRAWINGS TO ACCURATELY REPRESENT THE PROJECT. THE ARCHITECT ASSUMES NO LIABILITY FOR ANY ERRORS OR OMISSIONS IN THESE DRAWINGS.

REVISIONS	
NO.	DATE/DESCRIPTION


DATE
PLAN NUMBER

SHEET NUMBER
A 203


THESE DRAWINGS CAN NOT BE USED, COPIED, REPRODUCED, TRACED OR REPRODUCED IN WHOLE OR PART OR MANNER WHAT SO EVER WITHOUT PERMISSION FROM BRIAN J. PILLING, AIA



1 BUILDING SECTION
1/4" = 1'-0"

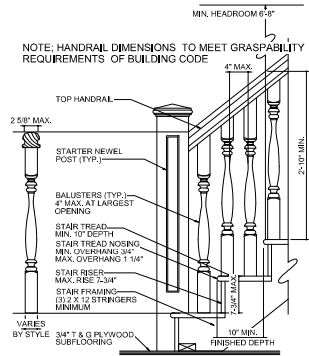

2 TYPICAL STAIR DETAIL
1" = 1'-0"

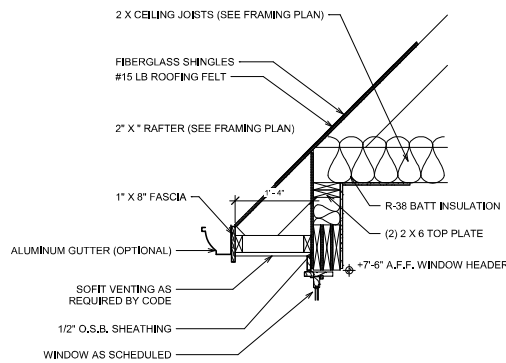

3 EAVE DETAIL
1" = 1'-0"



PLAN #71120
BUILDING SECTION

EVERY ATTEMPT HAS BEEN MADE IN THE PREPARATION OF THESE DRAWINGS TO AVOID MISREPRESENTATION, FOR ANY ERRORS OR OMISSIONS, THE ARCHITECT SHALL NOT BE HELD LIABLE FOR ANY DAMAGE OR LOSSES IN THESE DRAWINGS.

ALL DIMENSIONS SHOWN ARE TO UNLESS OTHERWISE NOTED. ALL DIMENSIONS TO FACE UNLESS OTHERWISE NOTED. ALL DIMENSIONS TO FACE UNLESS OTHERWISE NOTED. ALL DIMENSIONS TO FACE UNLESS OTHERWISE NOTED.

REVISIONS	
NO.	DATE/DESCRIPTION

DATE
PLAN NUMBER


SHEET NUMBER

A 301


THESE DRAWINGS CAN NOT BE USED, COPIED, REPRODUCED, IN WHOLE OR PART OR MANNER WHAT SO EVER WITHOUT PERMISSION FROM BRIAN J. PILLING, AIA

NOTE: REVIEW WITH OWNER CABINETRY & COUNTERTOP SELECTIONS FOR FINISHES STYLES & ACCESSORIES

NOTE: REVIEW WITH OWNER LOCATIONS FOR CROWN MOLDING, WAINSCOT, CHAIR RAIL, BUILT-INS & SIMILAR ITEMS

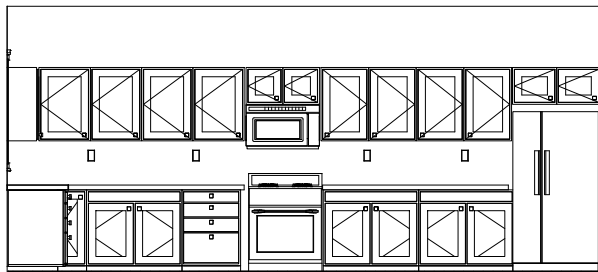


① KITCHEN ELEVATION "A"
1/2" = 1'-0"

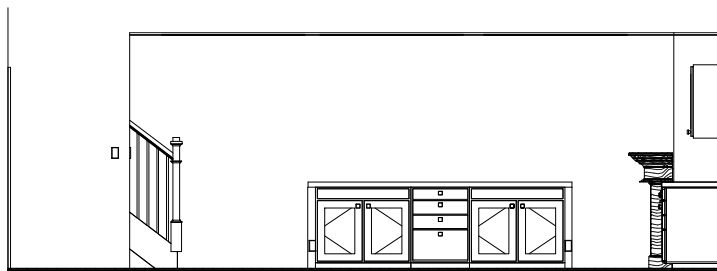

② KITCHEN ELEVATION "B"
1/2" = 1'-0"



④ INTERIOR PERSPECTIVE - GREAT ROOM

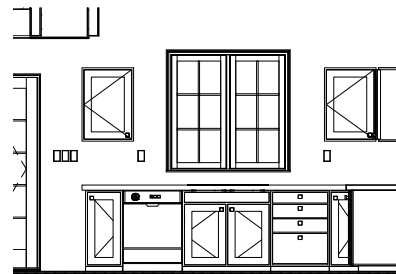

③ KITCHEN ELEVATION "C"
1/2" = 1'-0"

dowds
DESIGN COLLECTION, LLC

1331 SAINT ANDREWS DR.
MEBANE, NC 27302
PHONE: 919-563-1818
LAURADOWDS@LIVE.COM
WWW.DOWDSDESIGNCOLLECTION.COM

intelligent
houseplans

BRIAN J. PILLING, AIA
736 RIDGE POINT DRIVE
CORDELLA, NC 27827
PHONE 252-202-7550
bjararchitect@gmail.com
www.intelligenthouseplans.com

LOCAL PROFESSIONAL'S SEAL

PLAN #71120
INTERIOR ELEVATIONS & PERSPECTIVES

EVERY ATTEMPT HAS BEEN MADE IN THE PREPARATION OF THESE DRAWINGS TO AVOID NEGLIGENCE AND OVERSIGHT. THE ARCHITECTS WILL NOT BE HELD LIABLE FOR ANY ERRORS OR OMISSIONS IN THESE DRAWINGS.

ALL DIMENSIONS SHOWN ARE TO FACE UNLESS OTHERWISE NOTED. THE ARCHITECTS SHALL BE RESPONSIBLE FOR THE ACCURACY OF THE DIMENSIONS.

REVISIONS	
NO.	DATE/DESCRIPTION


DATE
PLAN NUMBER

SHEET NUMBER

A 401

THESE DRAWINGS CAN NOT BE USED, COPIED, REPRODUCED, IN WHOLE OR PART OR MANNER WHAT SO EVER WITHOUT PERMISSION FROM BRIAN J. PILLING, AIA

1 FIRST FLOOR ELECTRICAL PLAN
1/4" = 1'-0"

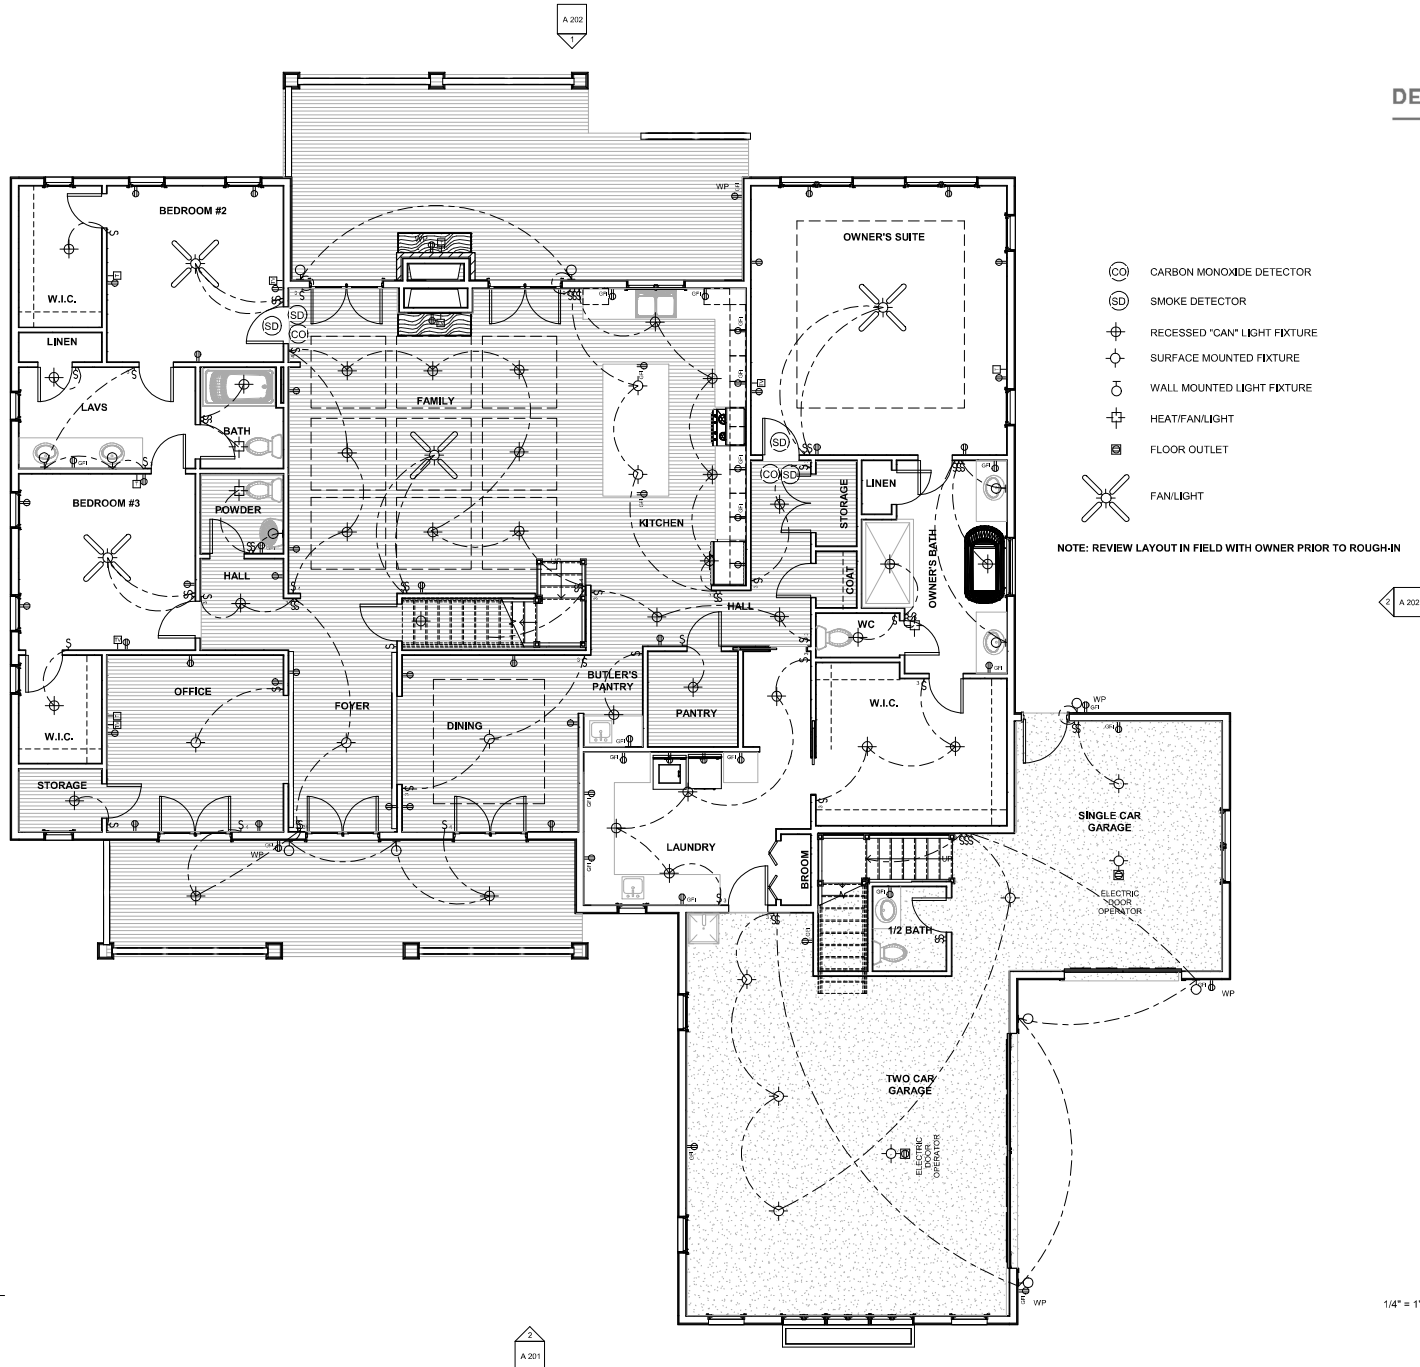

dowds
DESIGN COLLECTION, LLC
1331 SAINT ANDREWS DR.
MEBANE, NC 27302
PHONE: 919-563-1818
LAURADOWDS@LIVE.COM
WWW.DOWDSDESIGNCOLLECTION.COM



BRIAN J. PILLING, AIA
78 RIDGE POINT DRIVE
CORDELLA, NC 27827
PHONE 252-202-7590
bjararchitect@gmail.com
www.intelligenthouseplans.com

LOCAL PROFESSIONAL'S SEAL

PLAN #71120
FIRST FLOOR ELECTRICAL PLAN

EVERY ATTEMPT HAS BEEN MADE IN THE PREPARATION OF THESE DRAWINGS TO AVOID NEGLIGENCE AND OVERSIGHT. THE ARCHITECTS WILL NOT BE HELD LIABLE FOR ANY ERRORS OR OMISSIONS IN THESE DRAWINGS.

ALL DIMENSIONS SHOWN ARE TO FACE UNLESS OTHERWISE NOTED. THE ARCHITECTS SHALL BE RESPONSIBLE FOR THE ACCURACY OF THE DIMENSIONS SHOWN IN THESE DRAWINGS.

REVISIONS	
NO.	DATE/DESCRIPTION

 

DATE
PLAN NUMBER

SHEET NUMBER

E 101

THESE DRAWINGS CAN NOT BE USED, COPIED, TRACED OR REPRODUCED IN WHOLE OR PART OR MANNER WHAT SO EVER WITHOUT PERMISSION FROM BRIAN J. PILLING, AIA

1 SECOND FLOOR ELECTRICAL PLAN
1/4" = 1'-0"

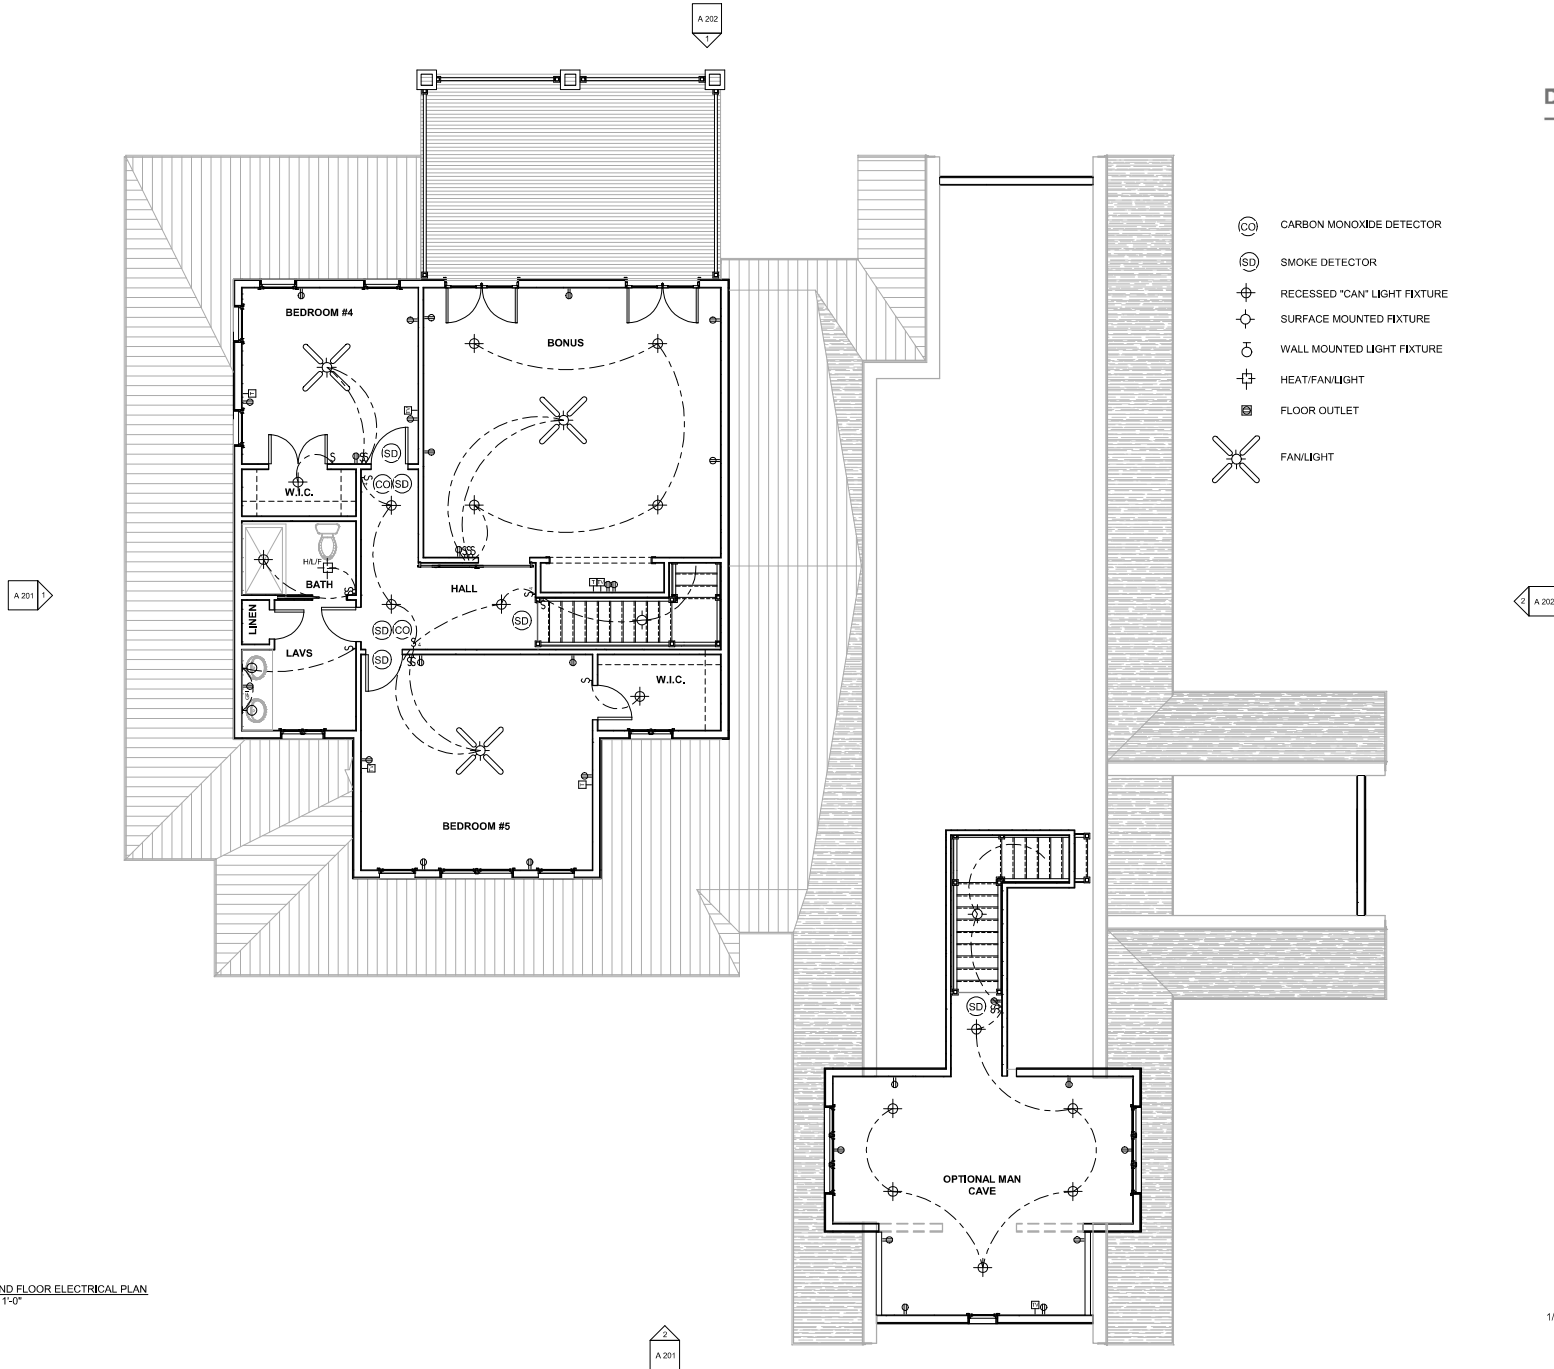

dowds
DESIGN COLLECTION, LLC

1331 SAINT ANDREWS DR.
MEBANE, NC 27302
PHONE: 919-563-1818
LAURADOWDS@LIVE.COM
WWW.DOWDSDESIGNCOLLECTION.COM



BRIAN J. PILLING, AIA
736 RIDGE POINT DRIVE
CORDELLA, NC 27827
PHONE 252-202-7590
bjaarchitect@gmail.com
www.intelligenthouseplans.com

LOCAL PROFESSIONAL'S SEAL

PLAN #71120
SECOND FLOOR ELECTRICAL PLAN

EVERY ATTEMPT HAS BEEN MADE IN THE PREPARATION OF THESE DRAWINGS TO AVOID NEGLIGENCE AND OVERSIGHT. THE ARCHITECTS WILL NOT BE HELD LIABLE FOR ANY ERRORS OR OMISSIONS IN THESE DRAWINGS.

ALL DIMENSIONS SHOWN ARE TO UNLESS OTHERWISE NOTED. THE ARCHITECTS WILL NOT BE HELD LIABLE FOR ANY ERRORS OR OMISSIONS IN THESE DRAWINGS.


REVISIONS	
NO.	DATE/DESCRIPTION

DATE
PLAN NUMBER

SHEET NUMBER

E 102

THESE DRAWINGS CAN NOT BE USED, COPIED, REPRODUCED, IN WHOLE OR PART OR MANNER WHAT SO EVER WITHOUT PERMISSION FROM BRIAN J. PILLING, AIA

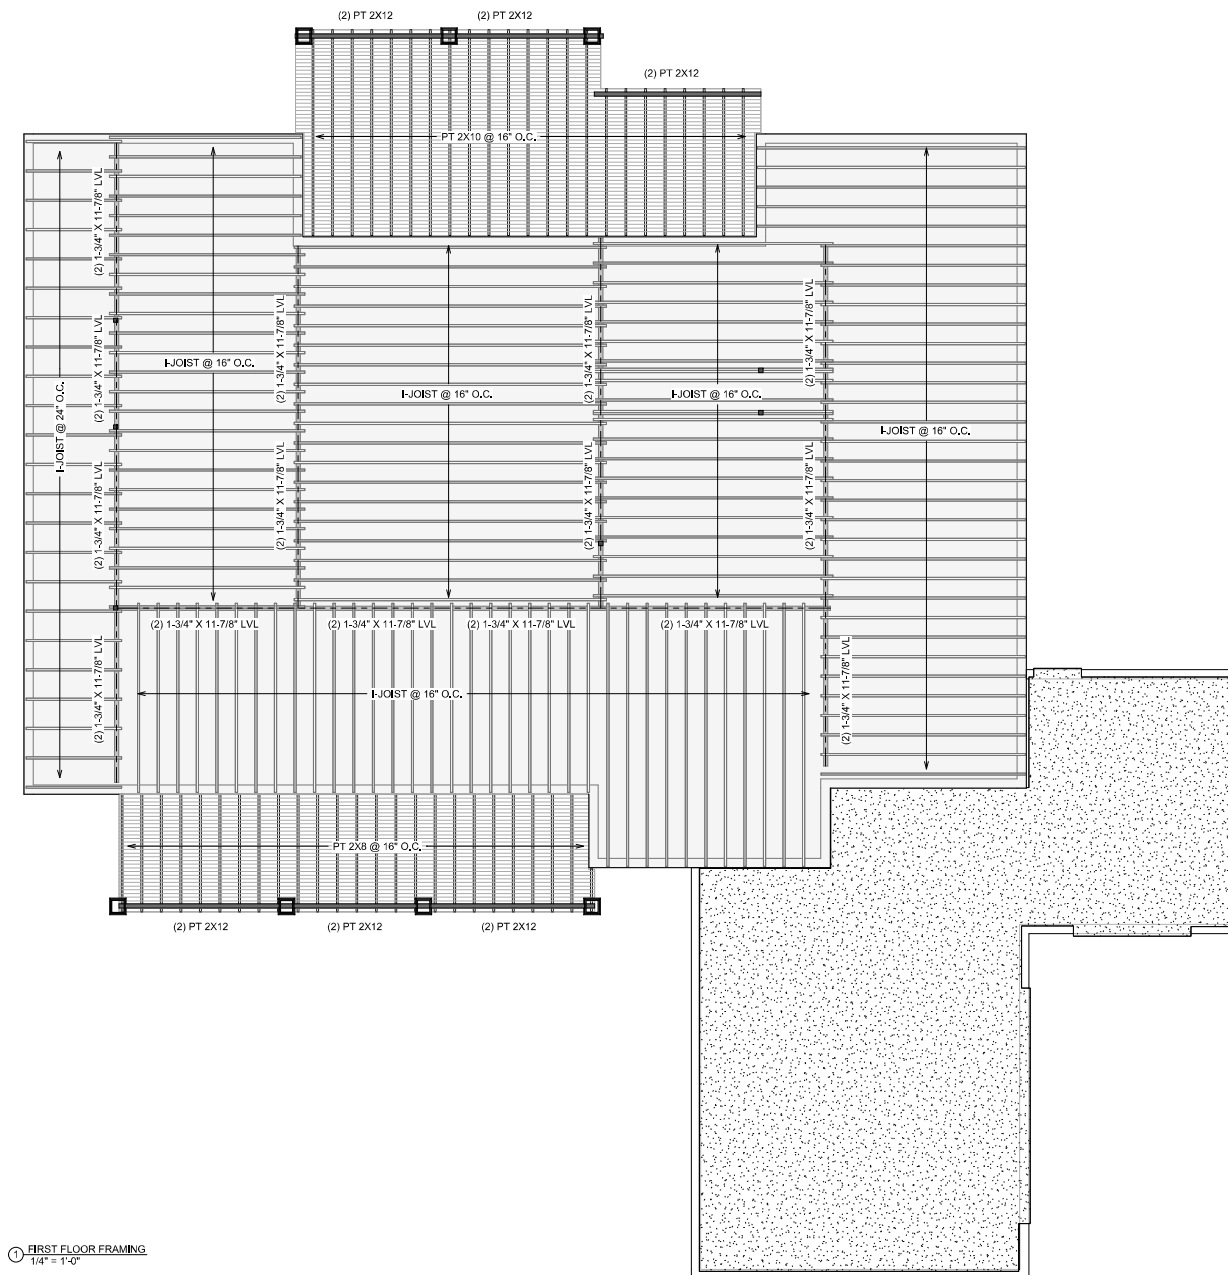

1 FIRST FLOOR FRAMING
1/4" = 1'-0"

L/480 Live Load Deflection

Depth	T/I**	40 PSF Live Load / 10 PSF Dead Load				40 PSF Live Load / 20 PSF Dead Load			
		12" o.c.	16" o.c.	19.2" o.c.	24" o.c.	12" o.c.	16" o.c.	19.2" o.c.	24" o.c.
9'6"	110	16'-11"	15'-6"	14'-7"	13'-7"	16'-11"	15'-6"	14'-3"	12'-9"
	210	17'-9"	16'-3"	15'-4"	14'-3"	17'-9"	16'-3"	15'-4"	14'-0"
	230	18'-3"	16'-8"	15'-9"	14'-8"	18'-3"	16'-8"	15'-9"	14'-8"
	380	20'-2"	18'-5"	17'-4"	15-9/16"	20'-2"	17'-8"	16'-11/16"	14'-4-1/2"
11'6"	110	21'-1"	19'-3"	18'-2"	16'-11"	21'-1"	19'-3"	17'-8"	15-9/16"
	210	21'-8"	19'-10"	18'-8"	17'-5"	21'-8"	19'-10"	18'-7"	16'-7/16"
	230	22'-11"	20'-11"	19'-8"	18'-4"	22'-11"	20'-11"	19'-8"	17'-10-1/16"
	380	26'-1"	23'-8"	22'-4"	20'-9"	26'-1"	23'-8"	22'-4"	20'-9/16"
14'	110	22'-10"	20'-11"	19'-2"	17'-2-1/2"	22'-2"	19'-2"	17'-6-1/2"	15'-0-1/2"
	210	23'-11"	21'-10"	20'-8"	18'-10-1/2"	23'-11"	21'-1"	19'-2-1/2"	16'-7-1/2"
	230	24'-8"	22'-9"	21'-2"	19'-9-1/2"	24'-8"	22'-2"	20'-3-1/2"	17'-10-1/2"
	380	26'-0"	23'-8"	22'-4"	20'-9"	26'-0"	23'-8"	22'-4"	20'-9-1/2"
16'	110	29'-6"	26'-10"	25'-4"	23'-6"	29'-6"	26'-10"	25'-4"	23'-11-1/2"
	210	26'-6"	24'-3"	22'-6-1/2"	19'-11-1/2"	26'-0"	22'-6-1/2"	20'-7-1/2"	16'-7-1/2"
	230	27'-3"	24'-10"	23'-6"	21'-3-1/2"	27'-3"	23'-9"	21'-8-1/2"	17'-10-1/2"
	380	29'-9"	26'-3"	24-5/8"	21-5/8"	29-9"	26'-3"	24-5/8"	21-10-1/8"

L/360 Live Load Deflection (Minimum Criteria per Code)

Depth	T/I**	40 PSF Live Load / 10 PSF Dead Load				40 PSF Live Load / 20 PSF Dead Load			
		12" o.c.	16" o.c.	19.2" o.c.	24" o.c.	12" o.c.	16" o.c.	19.2" o.c.	24" o.c.
9'6"	110	18'-9"	17'-2"	15'-8"	14'-0"	18'-1"	15'-8"	14'-3"	12'-9"
	210	19'-8"	18'-0"	17'-0"	15'-4"	19'-8"	17'-2"	15'-8"	14'-0"
	230	20'-3"	18'-6"	17'-5"	16'-2"	20'-3"	18'-1"	16'-6"	14'-9"
	380	22'-3"	19'-4"	17'-8"	15-9/16"	20'-5"	17'-8"	16'-1"	14'-4-1/2"
11'6"	110	23'-4"	21'-2"	19'-4"	17'-3-1/2"	22'-4"	19'-4"	17'-8"	15'-9/16"
	210	24'-0"	21'-11"	20'-5"	18'-3"	23'-2"	20'-5"	18'-7"	16'-7/16"
	230	24'-8"	22'-11"	21'-10"	20'-4-1/2"	23'-2"	20'-5"	18'-7"	16'-7/16"
	380	25'-4"	23'-2"	21'-10"	20'-4-1/2"	25'-4"	23'-2"	21'-10-1/16"	17'-10-1/16"
14'	110	28'-10"	26'-3"	24'-9"	23'-9"	28'-10"	26'-3"	24'-9"	20'-11-1/2"
	210	24'-4"	21'-6"	19'-2"	17'-2-1/2"	22'-2"	19'-2"	17'-6-1/2"	15'-0-1/2"
	230	26'-6"	23'-1"	21'-1"	18'-10-1/2"	24'-4"	21'-1"	19'-2-1/2"	16'-7-1/2"
	380	27'-3"	24'-4"	22'-2"	19'-10-1/2"	25'-4"	22'-2"	20'-3-1/2"	17'-10-1/2"
16'	110	28'-9"	26'-3"	24'-9"	23'-9"	28'-9"	26'-3"	24'-9"	20'-11-1/2"
	210	26'-6"	24'-8"	22'-6-1/2"	19'-11-1/2"	26'-0"	22'-6-1/2"	20'-7-1/2"	16'-7-1/2"
	230	27'-1"	24'-0"	22'-9"	21'-3-1/2"	27'-4"	23'-9"	21'-8-1/2"	17'-10-1/2"
	380	31'-0"	29'-0"	26'-10-1/2"	21'-5-1/2"	31'-10"	28'-10-1/2"	27'-4-1/2"	17'-10-1/2"

(1) Web stiffeners are required at intermediate supports of continuous-span joists when the intermediate bearing length is less than 16" and the span on either side of the intermediate bearing is greater than the following spans:

T/I**	40 PSF Live Load / 10 PSF Dead Load				40 PSF Live Load / 20 PSF Dead Load			
	12" o.c.	16" o.c.	19.2" o.c.	24" o.c.	12" o.c.	16" o.c.	19.2" o.c.	24" o.c.
110	N.A.	N.A.	N.A.	15'-4"	N.A.	N.A.	16'-0"	12'-9"
210	N.A.	N.A.	21'-4"	17'-0"	N.A.	21'-4"	17'-9"	14'-2"
230	N.A.	N.A.	N.A.	19'-2"	N.A.	N.A.	19'-11"	15'-11"
380	N.A.	N.A.	24'-5"	19'-6"	N.A.	24'-5"	20'-4"	16'-3"
580	N.A.	N.A.	29'-10"	23'-10"	N.A.	29'-10"	24'-10"	19'-10"

* Long-term deflection under dead load, which includes the effect of creep, has not been considered. **Italic** spans reflect initial load deflection exceeding 0.33".



EVERY ATTEMPT HAS BEEN MADE IN THE PREPARATION OF THESE DRAWINGS TO AVOID MISTAKES. THESE DRAWINGS ARE NOT TO BE USED WITHOUT THE SIGNATURE OF THE DESIGNER. THE USER ASSUMES RESPONSIBILITY FOR THE ACCURACY OF THE INFORMATION CONTAINED HEREIN. THE USER ASSUMES RESPONSIBILITY FOR THE ACCURACY OF THE INFORMATION CONTAINED HEREIN.

ALL DIMENSIONS SHOWN ARE UNLESS OTHERWISE SPECIFIED. ALL DIMENSIONS SHOWN ARE UNLESS OTHERWISE SPECIFIED. ALL DIMENSIONS SHOWN ARE UNLESS OTHERWISE SPECIFIED. ALL DIMENSIONS SHOWN ARE UNLESS OTHERWISE SPECIFIED.


REVISIONS	
NO.	DATE/DESCRIPTION

DATE
PLAN NUMBER

SHEET NUMBER

THESE DRAWINGS CAN NOT BE USED, COPIED, TRACED OR REPRODUCED, IN WHOLE OR PART OR MANNER WHAT SO EVER WITHOUT PERMISSION FROM BRIAN J. PILLING, AIA

1 SECOND FLOOR FRAMING
1/4" = 1'-0"

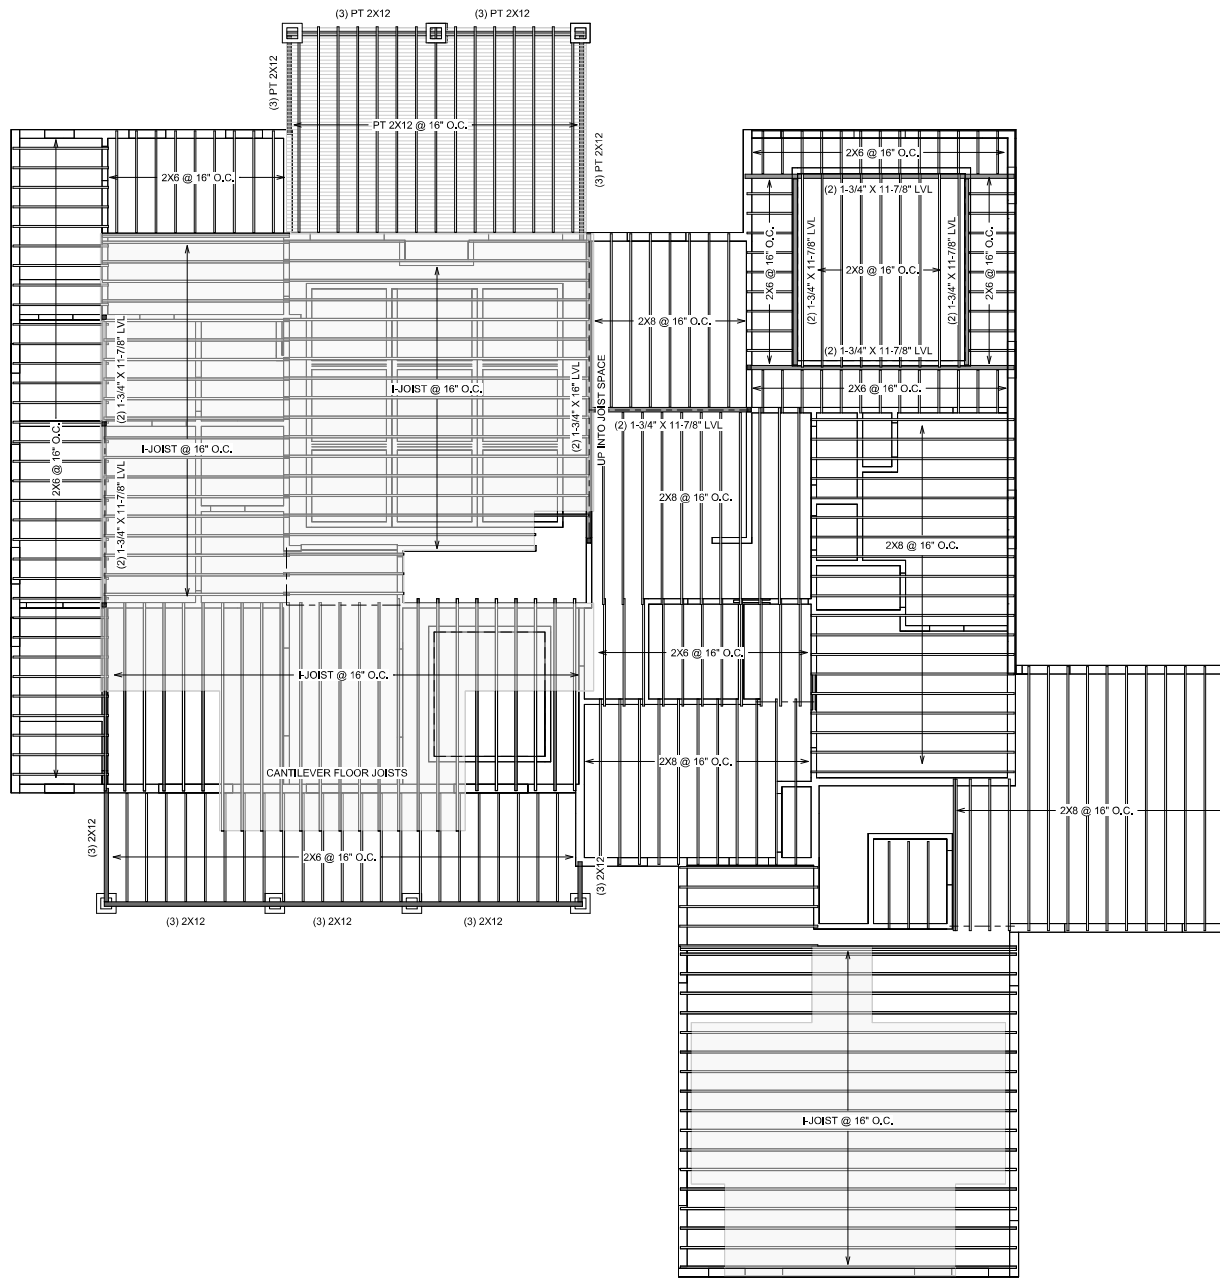

dowds
DESIGN COLLECTION, LLC

1331 SAINT ANDREWS DR.
MEBANE, NC 27302
PHONE: 919-563-1818
LAURADOWDS@LIVE.COM
WWW.DOWDSDESIGNCOLLECTION.COM



BRIAN J. PILLING, AIA
78 RIDGE POINT DRIVE
CORDELLA, NC 27527
PHONE 252-202-7590
bjarichitect@gmail.com
www.intelligenthouseplans.com

LOCAL PROFESSIONAL'S SEAL

PLAN #71120
SECOND FLOOR FRAMING PLAN

EVERY ATTEMPT HAS BEEN MADE IN THE PREPARATION OF THESE DRAWINGS TO AVOID NEGLIGENCE AND OVERSIGHT. THE ARCHITECTS WILL NOT BE HELD LIABLE FOR ANY DAMAGE OR INCONVENIENCE IN THESE DRAWINGS.

ALL DIMENSIONS SHOWN ARE TO UNLESS OTHERWISE NOTED. THE ARCHITECTS WILL NOT BE HELD LIABLE FOR ANY DAMAGE OR INCONVENIENCE IN THESE DRAWINGS.



REVISIONS	
NO.	DATE/DESCRIPTION

DATE
PLAN NUMBER

SHEET NUMBER

S 103

THESE DRAWINGS CAN NOT BE USED, COPIED, TRACED OR REPRODUCED, IN WHOLE OR PART OR MANNER WHAT SO EVER WITHOUT PERMISSION FROM BRIAN J. PILLING, AIA

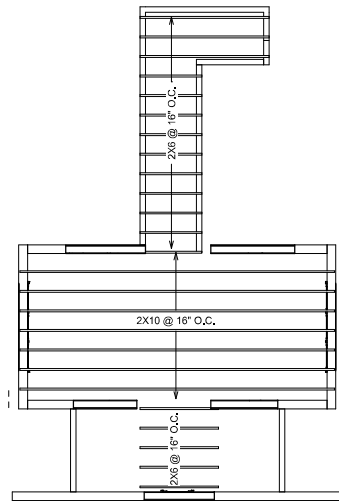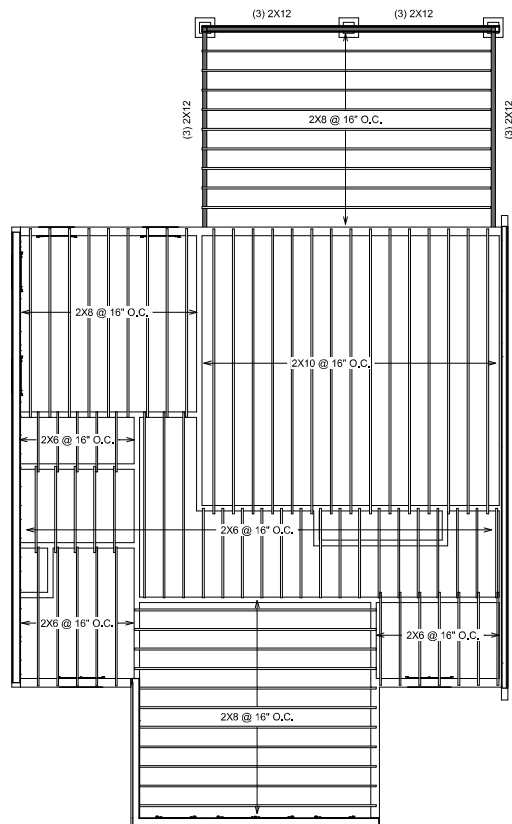

SECOND FLOOR CEILING FRAMING PLAN
1/4" = 1'-0"

dowds

DESIGN COLLECTION, LLC

1331 SAINT ANDREWS DR.
MEBANE, NC 27302
PHONE: 919-563-1818
LAURADOWDS@LIVE.COM
WWW.DOWDSDESIGNCOLLECTION.COM

intelligent
houseplans

BRIAN J. PILLING, AIA
738 RIDGE POINT DRIVE
COROLLA, NC 27827
PHONE 252-202-7590
obarchitect@gmail.com
www.intelligenthouseplans.com

LOCAL PROFESSIONAL'S SEAL

CEILING JOISTS
20# LIVE LOAD 10# DEAD LOAD L/360
Table C-1
Design Criteria: Strength - 20 lbs. per sq. ft. live load, plus 10 lbs. per sq. ft. dead load.
Deflection - Limited in span in inches divided by 360 for live load only.

Species or Group		Span (feet and inches)															
		2 x 4				2 x 6				2 x 8							
		spacing on center															
		12'	16'	19.2'	24'	12'	16'	19.2'	24'	12'	16'	19.2'	24'				
Douglas Fir- Larch	Sel. Spec.	9-1	8-3	7-9	7-3	14-4	13-0	12-3	11-4	18-10	17-2	16-1	15-0	24-1	21-0	20-2	19-4
	No. 1 & Btr.	8-11	8-1	7-8	7-1	14-1	12-9	12-0	11-2	18-6	16-10	15-10	14-8	23-4	21-6	20-2	18-9
	No. 2	8-9	8-0	7-6	7-0	13-8	12-6	11-9	10-11	18-2	16-8	15-6	14-2	23-2	21-5	19-6	17-4
	No. 3	8-7	7-10	7-4	6-10	13-6	12-3	11-7	10-8	17-10	15-1	13-6	12-9	23-0	20-8	19-2	17-1
Douglas Fir- South	Sel. Spec.	8-3	7-6	7-0	6-6	12-11	11-9	11-1	10-3	12-0	10-8	10-2	9-6	21-9	19-8	18-7	17-3
	No. 1	8-0	7-3	6-10	6-4	12-7	11-5	10-9	10-0	11-7	10-4	9-8	9-2	21-6	19-5	18-4	17-0
	No. 2	7-10	7-1	6-8	6-2	12-3	11-2	10-6	9-9	11-2	10-0	9-4	8-8	21-4	19-8	17-3	16-0
	No. 3	7-7	6-8	6-1	5-5	11-9	9-8	9-10	7-11	11-2	10-0	9-4	8-8	21-0	19-4	17-3	16-2
Hem-Fir	Sel. Spec.	8-2	7-10	7-4	6-10	13-6	12-3	11-7	10-9	17-10	16-2	15-3	14-2	22-8	20-8	19-6	18-0
	No. 1 & Btr.	8-5	7-8	7-2	6-8	13-3	12-0	11-4	10-6	17-5	16-10	15-11	14-10	22-2	20-2	19-0	17-1
	No. 2	8-5	7-8	7-2	6-8	13-3	12-0	11-4	10-6	17-5	16-10	15-11	14-10	22-1	20-2	19-0	17-1
	No. 3	8-0	7-3	6-10	6-4	12-7	11-5	10-9	10-0	11-7	10-4	9-8	9-2	21-3	19-3	17-10	16-0
Spruce- Pine-Fir (South)	Sel. Spec.	8-0	7-3	6-10	6-4	12-7	11-5	10-9	10-0	11-7	10-4	9-8	9-2	21-4	19-3	18-1	16-10
	No. 1	7-10	7-1	6-8	6-2	12-3	11-2	10-6	9-9	11-2	10-0	9-4	8-8	21-4	18-9	17-3	16-3
	No. 2	7-7	6-11	6-6	6-0	11-11	10-10	10-2	9-4	10-9	9-8	9-2	8-6	21-3	18-9	17-1	16-1
	No. 3	7-3	6-4	5-9	5-2	10-8	9-3	8-5	7-6	10-6	9-5	8-7	8-0	21-0	18-4	17-0	15-8
Western Woods	Sel. Spec.	7-10	7-1	6-8	6-2	12-3	11-2	10-6	9-9	11-2	10-0	9-4	8-8	21-4	18-9	17-3	16-5
	No. 1	7-7	6-11	6-6	6-0	11-11	10-10	10-2	9-4	10-9	9-8	9-2	8-6	21-1	18-8	17-1	16-1
	No. 2	7-4	6-8	6-2	5-10	11-7	10-8	10-0	9-2	10-6	9-5	8-7	8-0	21-0	18-5	16-1	14-8
	No. 3	6-8	5-9	5-3	4-8	9-8	8-5	7-8	6-10	10-4	9-3	8-5	7-8	21-0	18-0	15-10	13-7

CEILING JOISTS
10# LIVE LOAD 10# DEAD LOAD L/360
Table C-2
Design Criteria: Strength - 10 lbs. per sq. ft. live load, plus 10 lbs. per sq. ft. dead load.
Deflection - Limited in span in inches divided by 360 for live load only.

Species or Group		Span (feet and inches)											
		2 x 4				2 x 6				2 x 8			
		spacing on center											
Grade		12'	16'	19.2'	24'	12'	16'	19.2'	24'	12'	16'	19.2'	24'
Douglas Fir-Larch	Sel. Spec.	11-6	10-5	9-10	8-1	18-0	16-4	15-6	14-4	23-9	21-7	20-4	18-10
	No. 1 & Btr.	11-3	10-3	9-8	8-11	17-8	16-1	15-2	14-1	23-4	21-2	19-11	18-6
	No. 2	11-1	10-0	9-5	8-9	17-4	15-9	14-10	13-9	22-11	20-10	19-5	17-5
	No. 3	10-10	9-10	8-5	8-7	17-0	15-6	14-7	13-0	22-5	20-3	18-5	16-6
Douglas Fir-South	Sel. Spec.	10-4	9-5	8-10	8-3	16-3	14-9	13-11	12-11	21-5	19-6	18-4	17-0
	No. 1	10-1	9-2	8-8	8-0	16-1	14-5	12-7	12-7	20-11	19-0	17-11	16-7
	No. 2	9-10	8-11	8-5	7-10	15-8	14-1	13-3	12-3	20-5	18-6	17-5	16-0
	No. 3	9-5	8-2	7-5	6-8	15-9	11-11	10-10	9-6	17-5	16-1	15-9	12-4
Hem-Fir	Sel. Spec.	10-10	9-10	8-3	8-7	17-0	15-6	14-7	13-0	22-5	20-3	18-5	16-6
	No. 1 & Btr.	10-7	9-8	9-1	8-5	16-8	15-2	14-3	13-3	21-11	19-11	18-9	17-2
	No. 2	10-1	9-2	8-8	8-0	16-1	14-5	12-7	12-7	20-11	19-0	17-11	16-7
	No. 3	9-5	8-2	7-5	6-8	15-9	11-11	10-10	9-6	17-5	16-1	15-9	12-4
Spruce-Pine-Fir (South)	Sel. Spec.	10-7	9-2	8-8	8-0	16-1	14-5	12-7	12-7	20-11	19-0	17-11	16-7
	No. 1	9-10	8-11	8-5	7-10	15-8	14-1	13-3	12-3	20-5	18-6	17-5	16-0
	No. 2	9-7	8-8	8-2	7-7	15-9	13-8	12-10	11-11	19-10	18-0	16-11	15-4
	No. 3	8-11	7-9	7-0	6-4	15-6	14-3	13-0	9-3	16-6	14-3	13-0	11-8
Western Woods	Sel. Spec.	9-10	8-11	8-5	7-10	15-8	14-1	13-3	12-3	20-5	18-6	17-5	16-0
	No. 1	9-7	8-8	8-2	7-7	15-9	13-8	12-10	11-11	19-10	18-0	16-11	15-4
	No. 2	9-3	8-5	7-11	7-4	14-7	13-3	12-5	11-3	19-2	17-5	16-0	14-3
	No. 3	8-2	7-0	6-5	5-9	11-11	10-4	9-5	8-5	15-1	13-0	11-11	10-6



PLAN #71120
CEILING FRAMING PLAN

REVISIONS


NO.	DATE	DESCRIPTION

DATE
PLAN NUMBER

SHEET NUMBER

S 104

THESE DRAWINGS CAN NOT BE USED, COPIED, TRACED OR REPRODUCED, IN WHOLE OR PART OR MANNER WHAT SO EVER WITHOUT IT PERMISSION FROM BRIAN J. PILLING, AIA

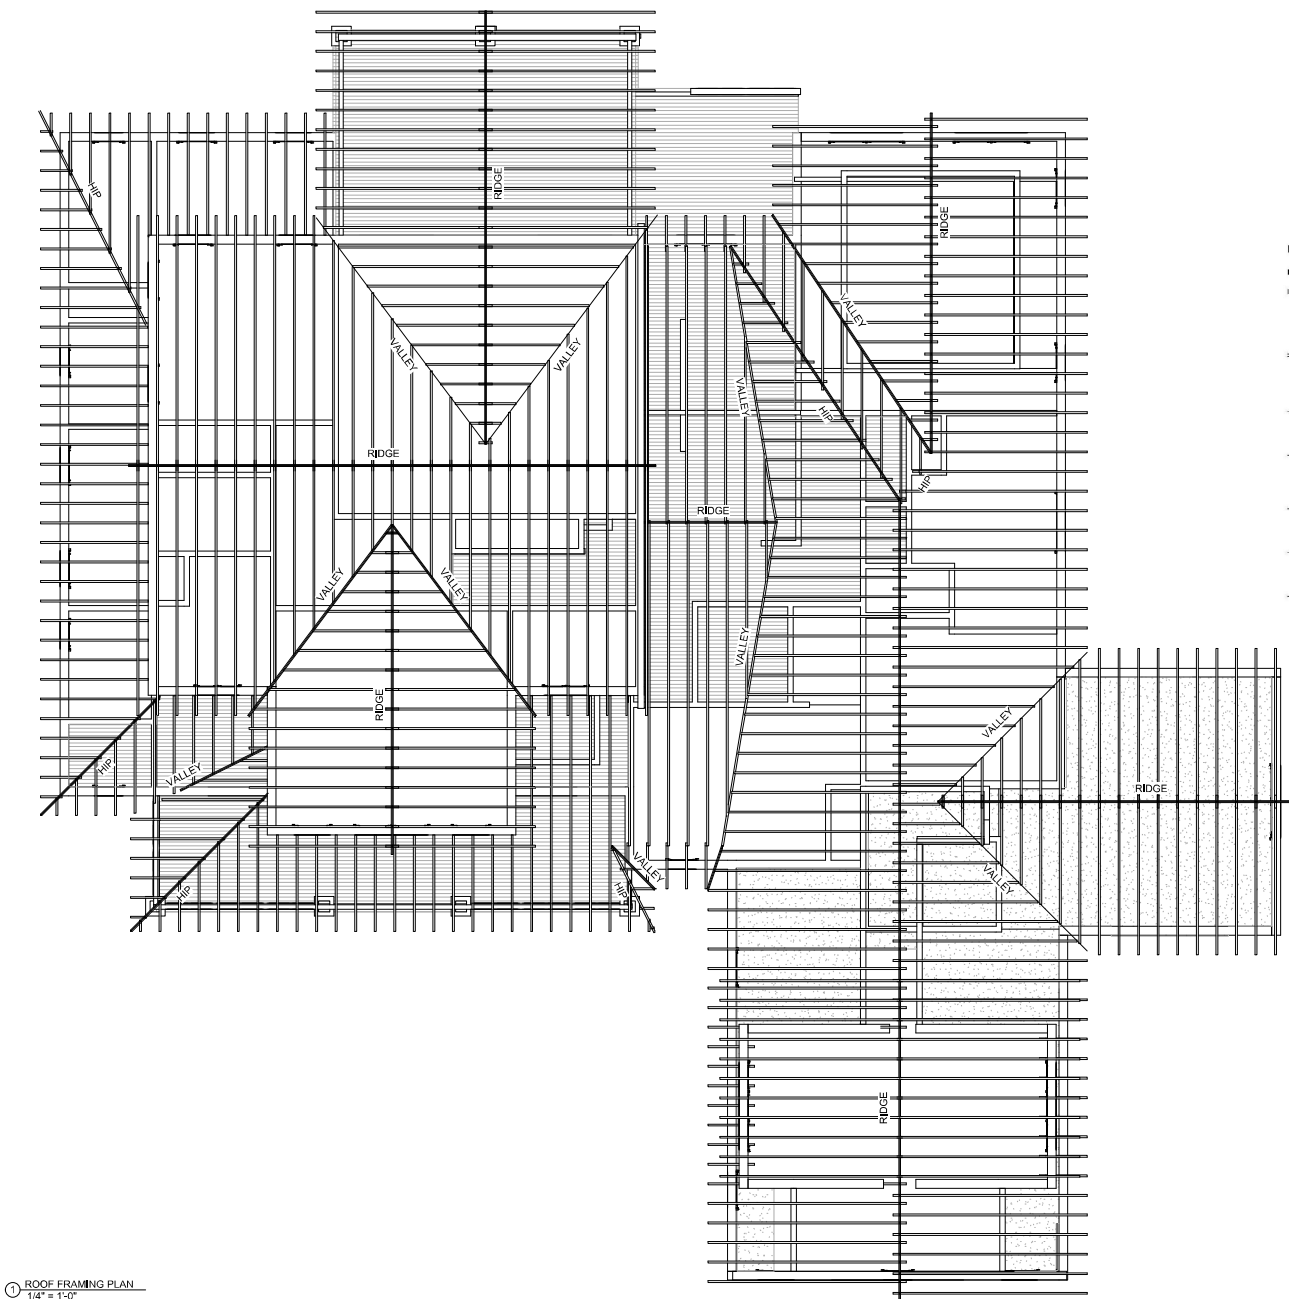


ROOF FRAMING PLAN
1/4" = 1'-0"



1331 SAINT ANDREWS DR.
MEBANE, NC 27302
PHONE: 919-563-1818
LAURADOWDS@LIVE.COM
WWW.DOWDSDESIGNCOLLECTION.COM

ROOF RAFTERS
Design Criteria: Strength - 20 lbs. per sq. ft. snow load, plus 15 lbs. per sq. ft. dead load.
Deflection - Limited in span in inches divided by 360 for live load only.

		Span (feet and inches)															
Species or Group	Grade	2 x 6				2 x 8				2 x 10				2 x 12			
		spacing on center															
		12'	16'	19.2'	24'	12'	16'	19.2'	24'	12'	16'	19.2'	24'	12'	16'	19.2'	24'
Douglas Fir-Larch	Sel. Slic.	14.4	13.0	12.3	11.4	18.0	15.2	14.1	13.0	24.1	21.10	20.7	19.3	29.3	26.7	25.0	23.3
	No. 1 & Btr.	14.1	12.9	12.0	11.2	16.0	13.0	12.0	11.0	23.8	21.0	20.2	18.9	28.1	25.7	24.5	21.0
	No. 1	13.9	12.6	11.9	10.7	15.2	12.6	11.6	10.4	23.2	21.1	19.3	17.3	28.2	24.5	22.4	20.0
	No. 2	13.6	12.3	11.7	10.7	15.0	12.4	11.4	10.4	22.9	20.0	18.3	16.4	27.9	24.1	22.1	19.5
	No. 3	11.5	9.10	8.0	6.1	14.5	12.6	11.5	10.3	17.6	15.3	13.1	12.6	20.5	17.9	16.2	14.6
Douglas Fir-South	Sel. Slic.	12.11	11.9	11.1	10.3	17.0	15.6	14.7	13.6	21.9	19.9	18.7	17.3	26.6	24.0	22.7	21.0
	No. 1	12.1	11.5	10.9	10.0	16.7	15.1	14.2	13.2	21.2	19.3	18.1	16.7	25.9	23.6	21.6	19.2
	No. 2	12.3	11.2	10.6	9.9	16.2	14.8	13.10	12.10	20.9	18.9	17.8	16.5	25.7	23.2	21.2	18.9
	No. 3	11.2	9.8	8.10	7.10	14.1	12.2	11.2	10.0	17.3	14.1	13.7	12.2	20.0	17.3	15.9	14.1
	Hem-Fir	Sel. Slic.	13.6	12.3	11.7	10.9	17.10	16.2	15.3	14.2	22.9	20.8	19.6	18.4	27.8	25.7	23.7
No. 1 & Btr.		13.3	12.0	11.4	10.6	17.5	15.10	14.11	13.10	22.3	20.2	19.0	17.8	27.1	24.9	22.8	20.5
No. 1		13.3	12.0	11.4	10.6	17.5	15.10	14.11	13.10	22.3	20.2	19.0	17.70	27.1	24.2	22.0	19.9
No. 2		12.7	11.5	10.9	10.0	16.7	15.1	14.2	13.0	21.2	19.3	17.9	16.10	25.9	23.6	20.7	18.5
No. 3		11.2	9.8	8.10	7.10	14.1	12.2	11.2	10.0	17.3	14.1	13.7	12.2	20.0	17.3	15.9	14.1
Spruce-Pine-Fir (West)	Sel. Slic.	12.7	11.5	10.9	10.0	16.7	15.1	14.2	13.2	21.2	19.3	18.1	16.10	25.9	23.5	22.1	20.6
	No. 1	12.3	11.2	10.6	9.9	16.2	14.8	13.10	12.10	20.9	18.9	17.8	16.10	25.7	23.0	20.1	18.8
	No. 2	11.11	10.10	10.2	9.6	15.9	14.3	13.6	12.5	20.7	18.3	16.11	15.2	24.8	21.6	19.8	17.7
	No. 3	10.7	9.2	8.4	7.6	13.4	11.7	10.7	9.5	16.4	14.2	12.11	11.7	23.2	20.1	18.4	16.8
	Western Woods	Sel. Slic.	12.7	11.2	10.6	9.9	16.2	14.8	13.10	12.10	20.9	18.9	17.8	16.4	25.7	22.9	21.2
No. 1		11.11	10.10	10.2	9.2	15.9	14.2	12.11	11.7	20.0	17.4	15.10	14.2	23.2	20.1	18.4	16.5
No. 2		11.7	10.6	9.10	8.2	15.3	13.10	12.11	11.7	19.6	17.4	15.10	14.2	23.2	20.1	18.4	16.1
No. 3		9.8	8.4	7.7	6.10	12.2	10.7	9.8	8.8	14.11	12.11	11.9	10.7	21.3	19.0	17.3	15.9

 

BRIAN J. PILLING, AIA
738 RIDGE POINT DRIVE
COROLLA, NC 27827
PHONE 252-202-7590
brian@intelligenthouseplans.com
www.intelligenthouseplans.com

LOCAL PROFESSIONAL'S SEAL

PLAN #71120

ROOF FRAMING PLAN

EITHER ATTORNEY HAS BEEN MADE IN THE PRESENCE OF THIS PLAN OR THE PLAN HAS BEEN MADE BY THE ARCHITECT OR ARCHITECTURAL FIRM. THE ARCHITECT OR ARCHITECTURAL FIRM SHALL NOT BE HELD LIABLE FOR ANY ERRORS OR OMISSIONS IN THESE DRAWINGS.

ALL DIMENSIONS SHOWN ARE IN FEET AND INCHES. DIMENSIONS IN PARENTHESES ARE IN FEET AND INCHES. DIMENSIONS IN PARENTHESES ARE IN FEET AND INCHES. DIMENSIONS IN PARENTHESES ARE IN FEET AND INCHES.

NO. DATE DESCRIPTION

DATE PLAN NUMBER

1" = 1'-0"

S 105