

Residence for
Adams Homes AEC, LLC
Plan 2408 "B" FE L KC015

GENERAL NOTES:

- 1. ALL WORK IS TO BE DONE IN STRICT ACCORDANCE WITH NORTH CAROLINA STATE RESIDENTIAL BUILDING CODE, 2018 EDITION (HEREWITH SHOWN AS N.C.S.R.B.C.).
- 2. DIMENSIONS SHOWN ON DRAWINGS GOVERN OVER SCALE..
- 3. STUD WALL DESIGN SHALL CONFORM TO ALL N.C.S.R.B.C. REQUIREMENTS.
- 4. CONTRACTOR SHALL USE TEMPERED SAFETY GLASS IN ALL LOCATIONS AS REQUIRED BY N.C.S.R.B.C., SECTION R302.4
- 5. ANY HABITABLE ROOM SHALL MEET ALL LIGHT/VENTILATION AND EGRESS AS REQUIRED BY N.C.S.R.B.C., SECTIONS R-303.1 AND R-310.1
- 6. ALL WALLS SHOWN ON FLOOR PLANS ARE 2x4 FRAME UNLESS NOTED OTHERWISE.
- 7. ALL ANGLED WALLS SHOWN ON FLOOR PLANS ARE 45° UNLESS NOTED OTHERWISE.
- 8. ALL WINDOWS SHALL HAVE A MINIMUM DPI RATING OF .25. BUILDER SHALL VERIFY WITH WINDOW MANUFACTURER THAT UNITS INSTALLED MEET THESE REQUIREMENTS AS PER N.C.S.R.B.C., TABLE 301.2(6).
- 9. ENERGY EFFICIENCY REQUIREMENTS FOR THE SPECIFIC CLIMATE ZONE WHERE STRUCTURE IS BEING BUILT SHALL BE IN ACCORDANCE WITH CHAPTER 11 OF THE NORTH CAROLINA RESIDENTIAL BUILDING CODE, AS SHOWN IN TABLES N1101.2 AND N1102.1.
- 10. TERMITE TREATMENT - BORATE APPLIED TO ALL FRAME MEMBERS WITHIN 24" AFF.

INDEX TO DRAWINGS:

- COVER SHEET

1 FRONT AND LEFT SIDE ELEVATIONS

2 REAR AND RIGHT SIDE ELEVATIONS

3 FIRST FLOOR PLAN

4 SECOND FLOOR PLAN

5 FIRST FLOOR ELECTRICAL PLAN

6 SECOND FLOOR ELECTRICAL PLAN

OPT1 FLOOR PLAN OPTIONS

D1 CONSTRUCTION DETAILS
- SI MONO SLAB FOUNDATION PLAN

S2 FIRST FLOOR CEILING FRAMING PLAN

S3 SECOND FLOOR CEILING FRAMING PLAN

S4 ROOF FRAMING PLAN

SD1 STRUCTURAL DETAILS

SPEC STRUCTURAL SPECIFICATIONS

S7 PLAN OPTIONS

RESIDENTIAL BUILDING CODE SUMMARY

- 1. PLANS ARE DESIGNED TO THE 2018 NORTH CAROLINA RESIDENTIAL BUILDING CODE.
- 2. HOUSE IS DESIGNED FOR 120 MPH, 3 SECOND GUST (93 MPH FASTEST WIND), EXPOSURE B.
- 3. ANCHOR BOLTS SHALL BE MIN. 1/2" DIAMETER WITH STANDARD WASHER AND NUT AND SHALL EXTEND 7" MIN. INTO MASONRY OR CONCRETE. BOLTS TO BE NO MORE THAN 6' O.C. AND WITHIN 12" OF CORNERS. ALTERNATE ANCHOR STRAPS CAN BE USED INSTEAD OF ANCHOR BOLTS SPACED AT THE EQUIVALENT SPACING AND INSTALLED PER MANUFACTURER'S SPECIFICATIONS EXCEPT AT GARAGE LUGS FTG.
- 4. MEAN ROOF HEIGHT: 24'-4"
- 5. COMPONENT & CLADDING DESIGNED FOR THE FOLLOWING LOADS:
MEAN ROOF HG1: UP TO 30' 30'-1" TO 35' 35'-1" TO 40' 40'-1" TO 45'
ZONE 1 16.5, -18.0 17.3, -18.9 18.0, -19.6 18.5, -20.2
ZONE 2 16.5, -21.0 17.3, -22.1 18.0, -22.9 18.5, -23.5
ZONE 3 16.5, -21.0 17.3, -22.1 18.0, -22.9 18.5, -23.5
ZONE 4 18.0, -19.5 18.9, -20.5 19.6, -21.3 20.2, -21.8
ZONE 5 18.0, -24.1 18.9, -25.3 19.6, -26.3 20.2, -27.0
- 6. MINIMUM VALUES FOR ENERGY COMPLIANCE: ZONE 4
- 7. MAXIMUM GLAZING U-FACTOR: 0.35
- 8. INSULATING VALUES: CEILING: R-30* / WALLS: R-15 / FLOOR: R-19 / SLABS: R-10. CODE REFERENCE: TABLE N1102.1 (*R-30 ONLY IF UNCOMPRESSED, R-38 REQUIRED IF COMPRESSED)
- 9. FLASHING SHALL BE INSTALLED IN ACCORDANCE WITH SECTION R103.8 OF THE N.C.R.B.C.
- 10. FIREBLOCKING SHALL BE INSTALLED IN ACCORDANCE WITH SECTION R602.8 OF THE N.C.R.B.C.
- 11. DRAFTSTOPPING SHALL BE INSTALLED IN ACCORDANCE WITH SECTION R302.12 OF THE N.C.R.B.C.

AREA CALCULATIONS

1ST FLOOR:	990	GARAGE:	411
2ND FLOOR:	1418	FRONT PORCH:	48
REC. ROOM:	0	COV. PATIO:	107
TOTAL:	2408	BRICK:	0
		TOTAL:	566
WIDTH:	29'-0"		
DEPTH:	56'-0"	COV. PORCH OPT:	0

FOUNDATION VENTING CALCULATIONS

NOT NEEDED WITH SLAB FOUNDATION

ATTIC VENTILATION REQUIREMENTS

NATURAL ROOF VENTILATION	MECHANICAL ROOF VENTILATOR
1556 SQ. FT.	1566 SQ. FT.
150 = 10.37 SQ. FT. VENT REQ'D.	300 = 5.22 SQ. FT. VENT REQ'D.
BUILDER TO PROVIDE APPROPRIATE VENTILATING AS REQUIRED PER CODE	

MATERIALS LEGEND



EARTH/COMPACT FILL	FINISH WOOD
CONCRETE	ROUGH WOOD
BRICK	BLOCKING
CONCRETE BLOCK/STONE	PLYWOOD
STEEL	BATT INSULATION
ALUMINUM	RIGID INSULATION

TOILET ACCESSORIES LEGEND

PROVIDE 2x4 BLOCKING IN THE WALL FOR THE FOLLOWING:

TB	TOWEL BAR
TP	TOILET PAPER HOLDER
TR	TOWEL RING
MC	MEDICINE CABINET
MR	MAGAZINE RACK


THE PURPOSE OF THESE DRAWINGS IS TO SHOW THE INTENT OF THE DESIGN AND CONSTRUCTION OF THIS HOME. ANY ERRORS AND/OR OMISSIONS FOUND IN THIS SET SHOULD IMMEDIATELY BE REPORTED TO ADAMS HOMES FOR CLARIFICATION OR CORRECTION. THE CONTRACTOR SHOULD VERIFY ALL CONDITIONS AND DIMENSIONS PRIOR TO CONSTRUCTION.

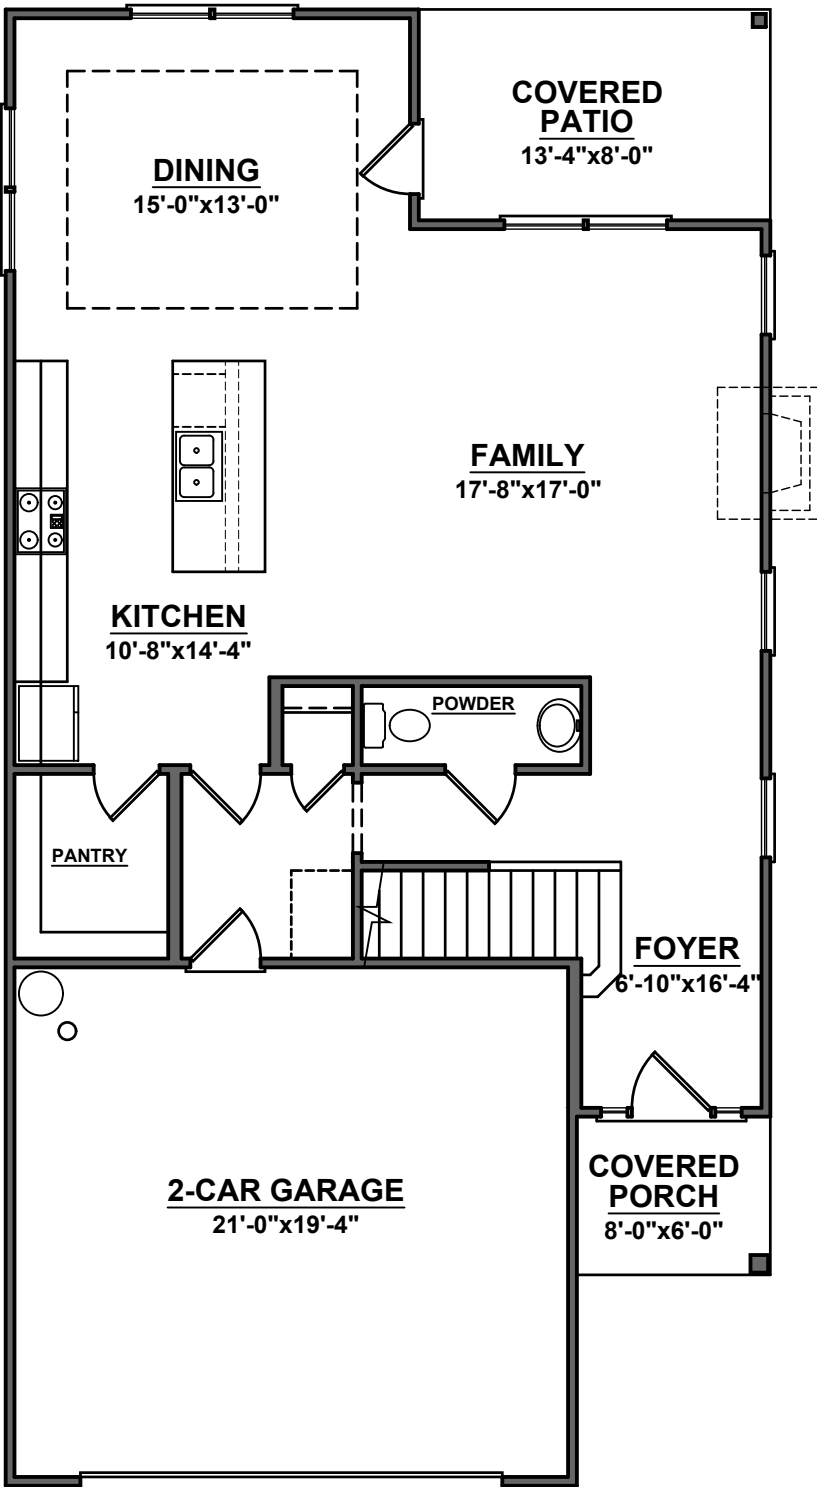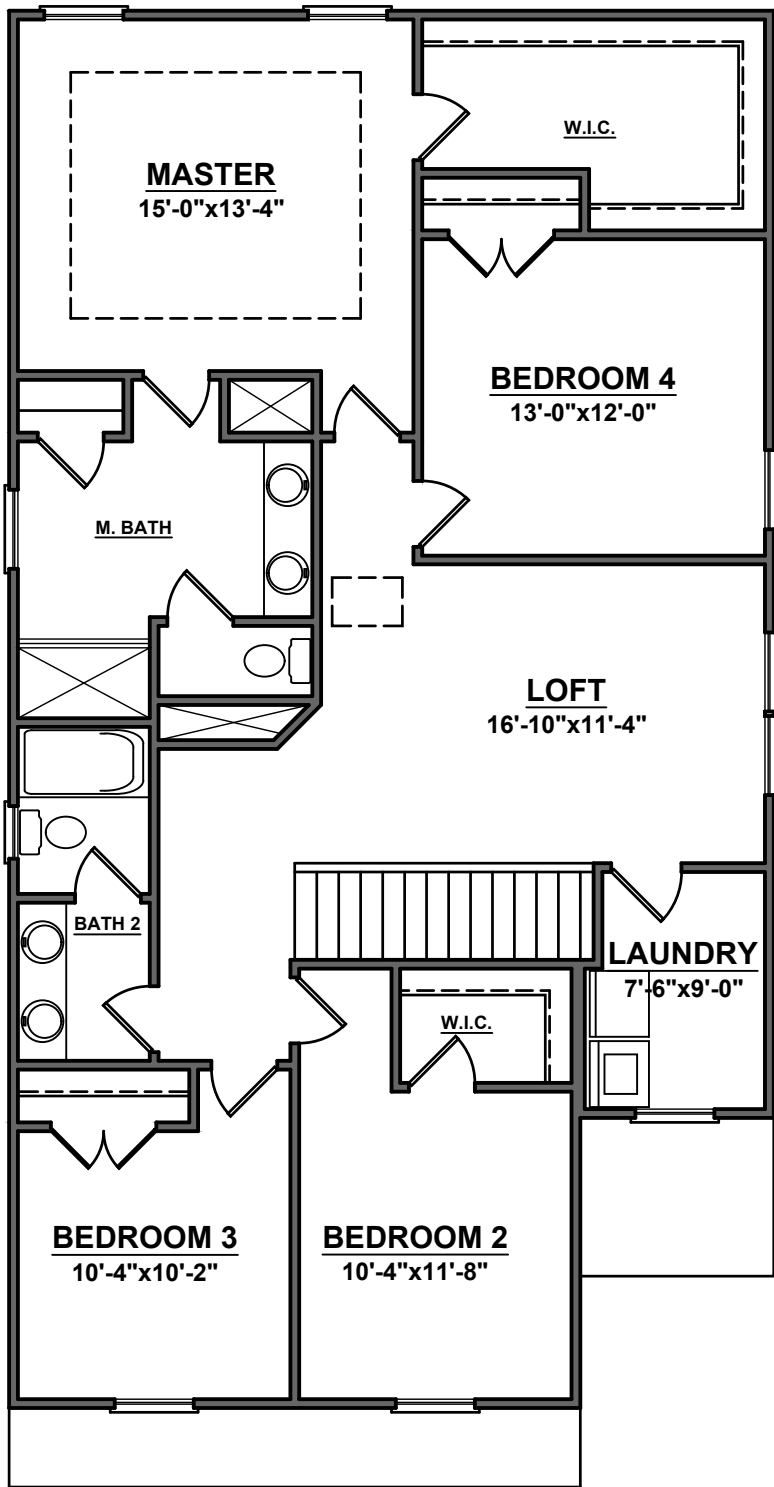

7379




HOMES AEC, LLC

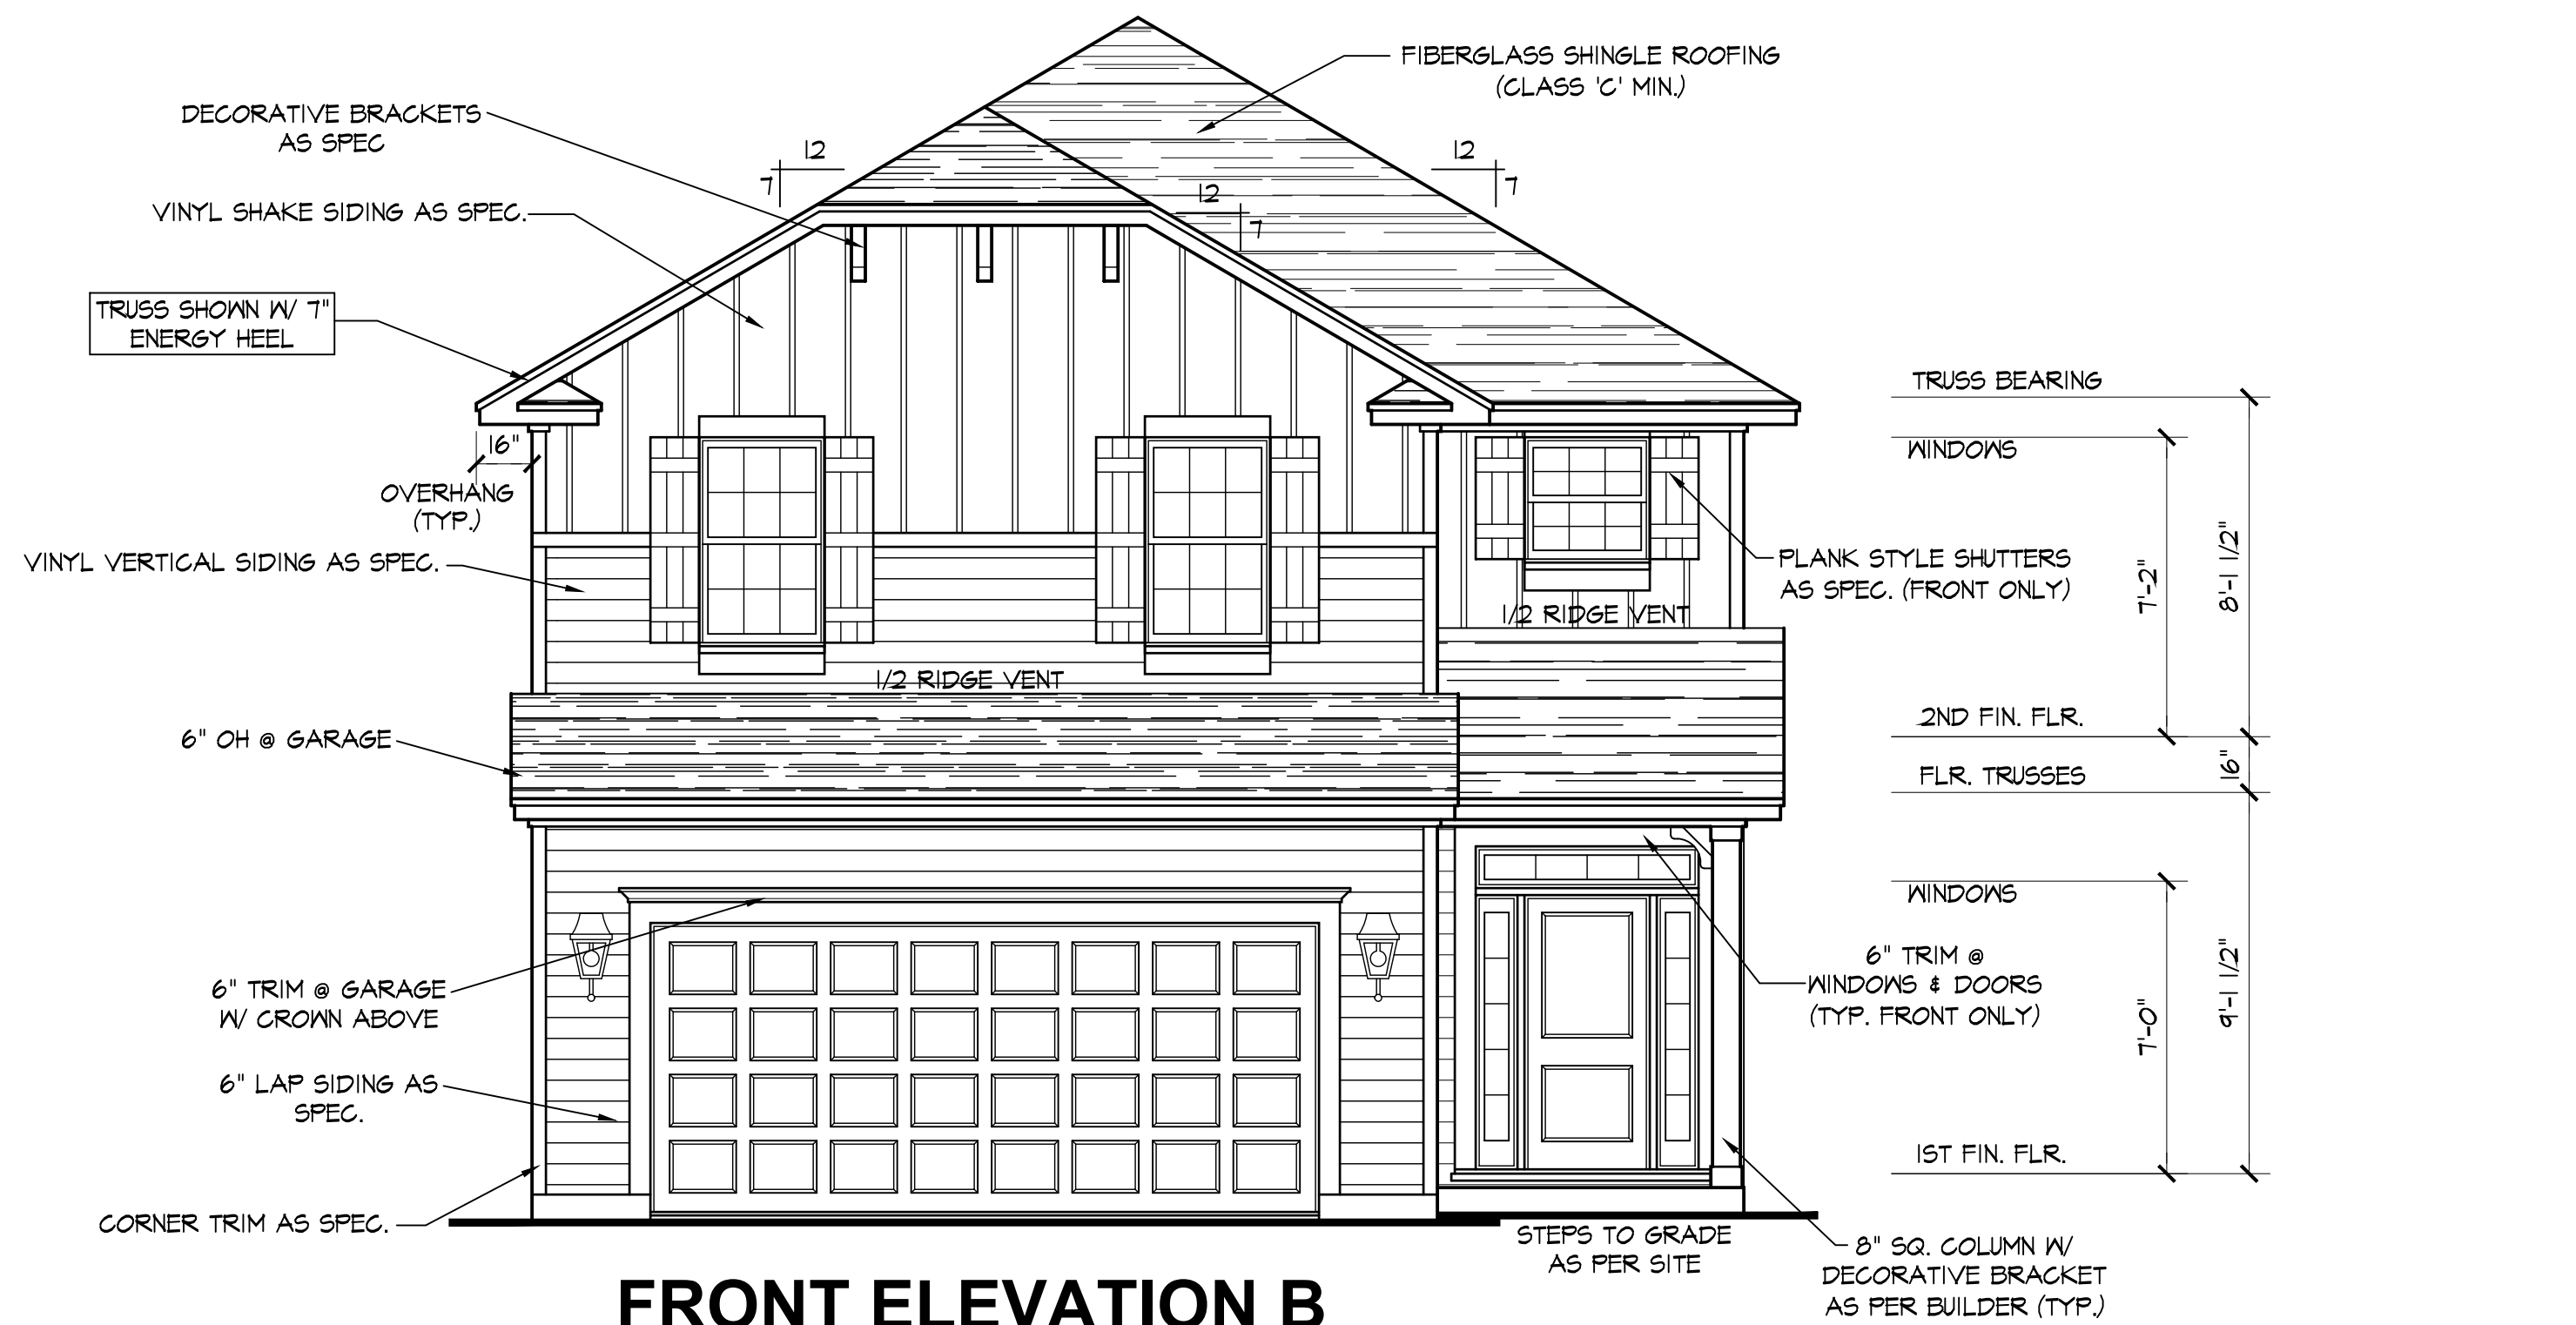

FRONT ELEVATION B

SCALE: 1/4"=1'-0"


NOTE - SLOPE ALL GRADES AWAY FROM HOUSE FOR POSITIVE DRAINAGE

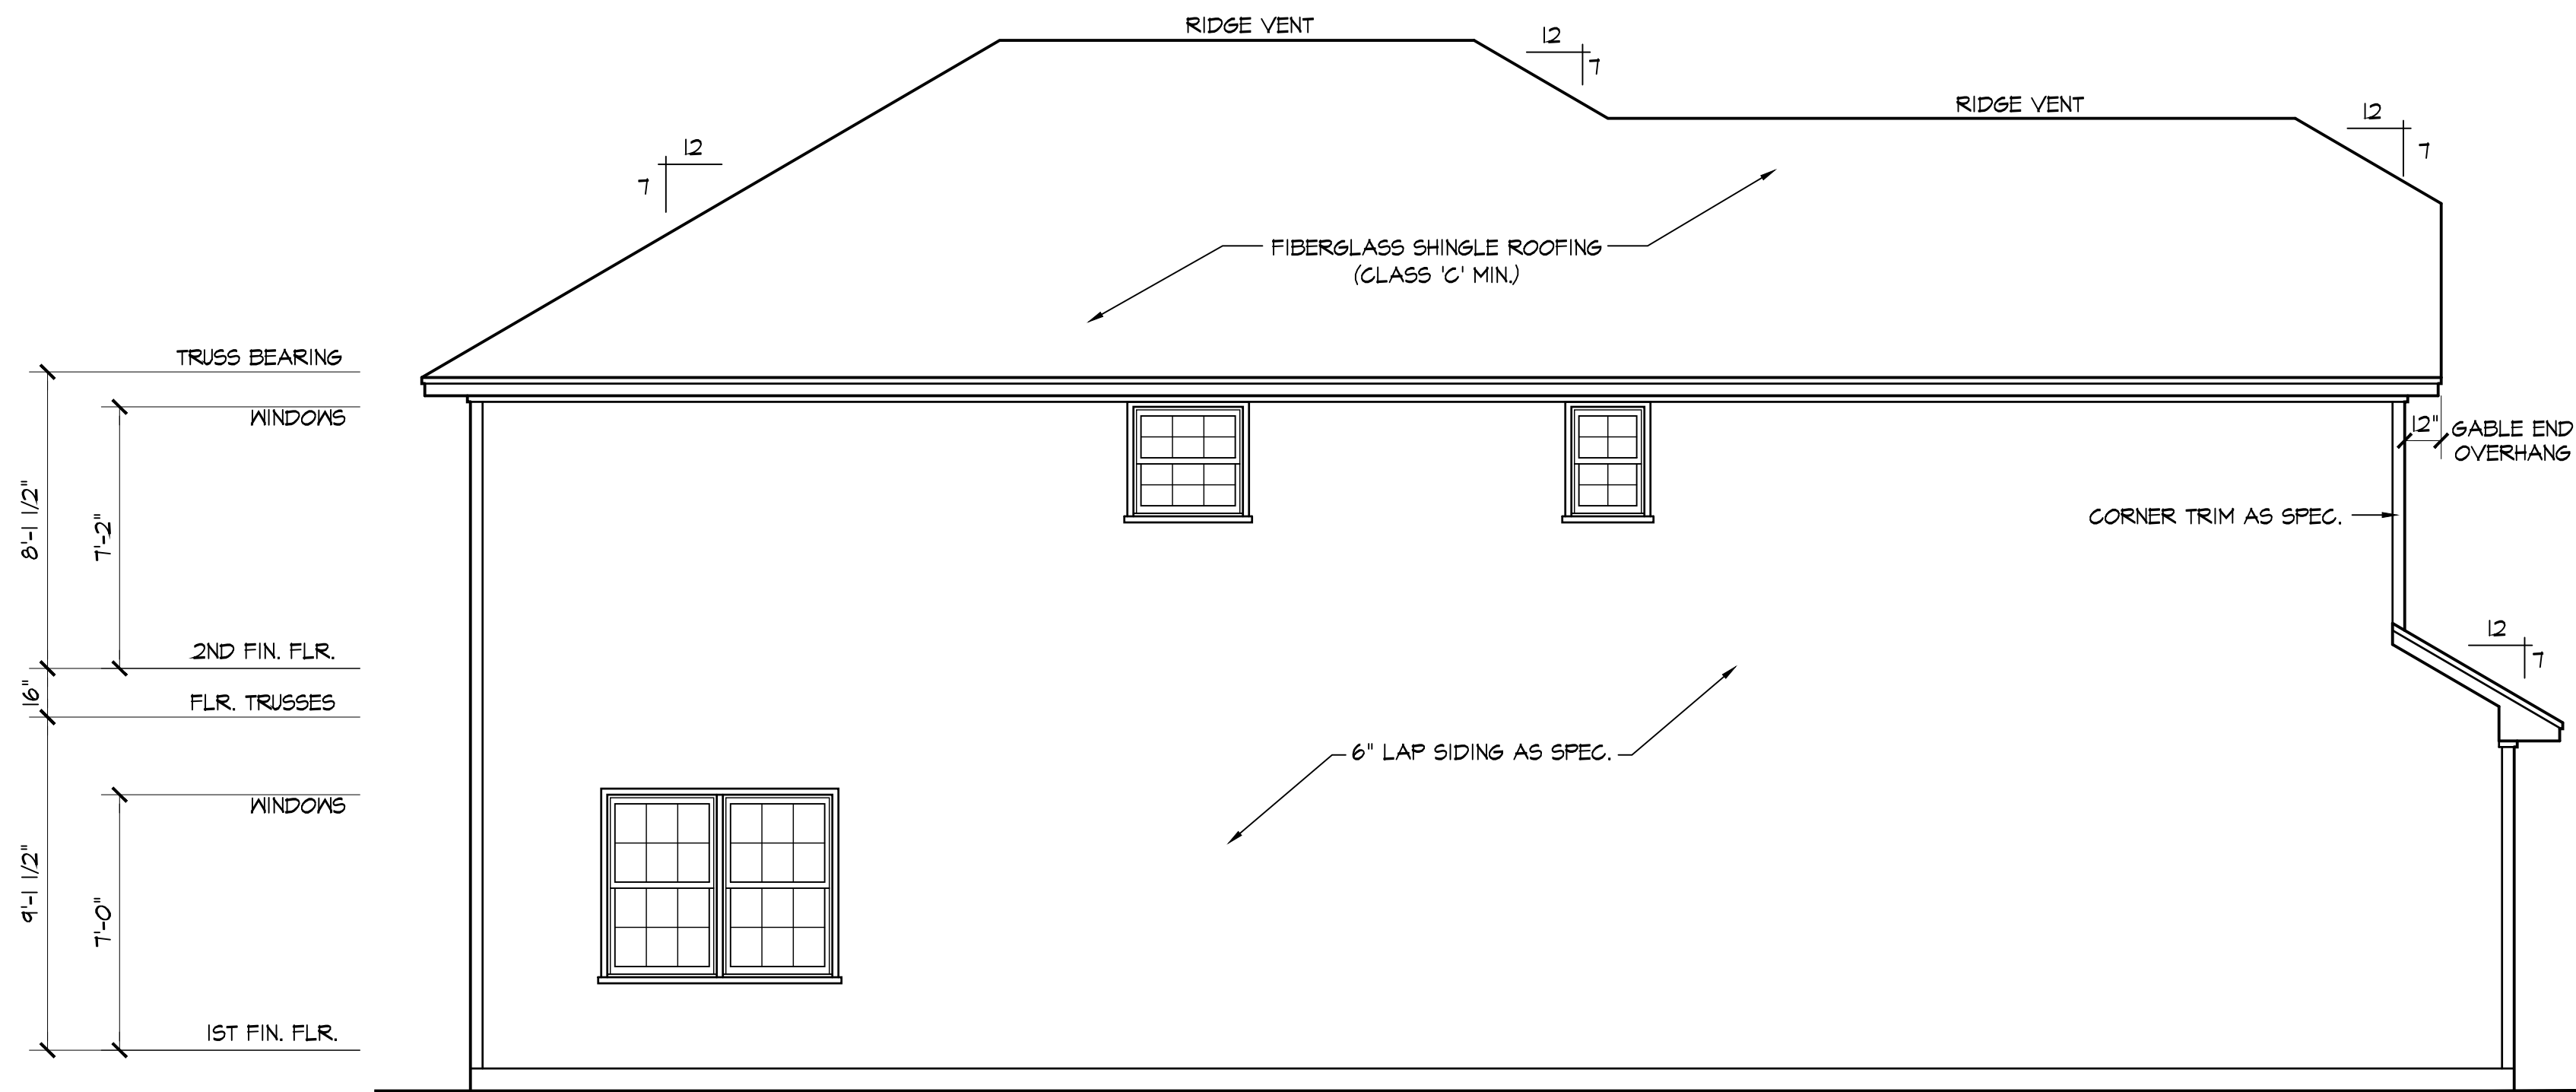

LEFT SIDE ELEVATION


SCALE: 1/4"=1'-0"

DATE DRAWN
2/11/2025
PROJECT
7379
REVISIONS

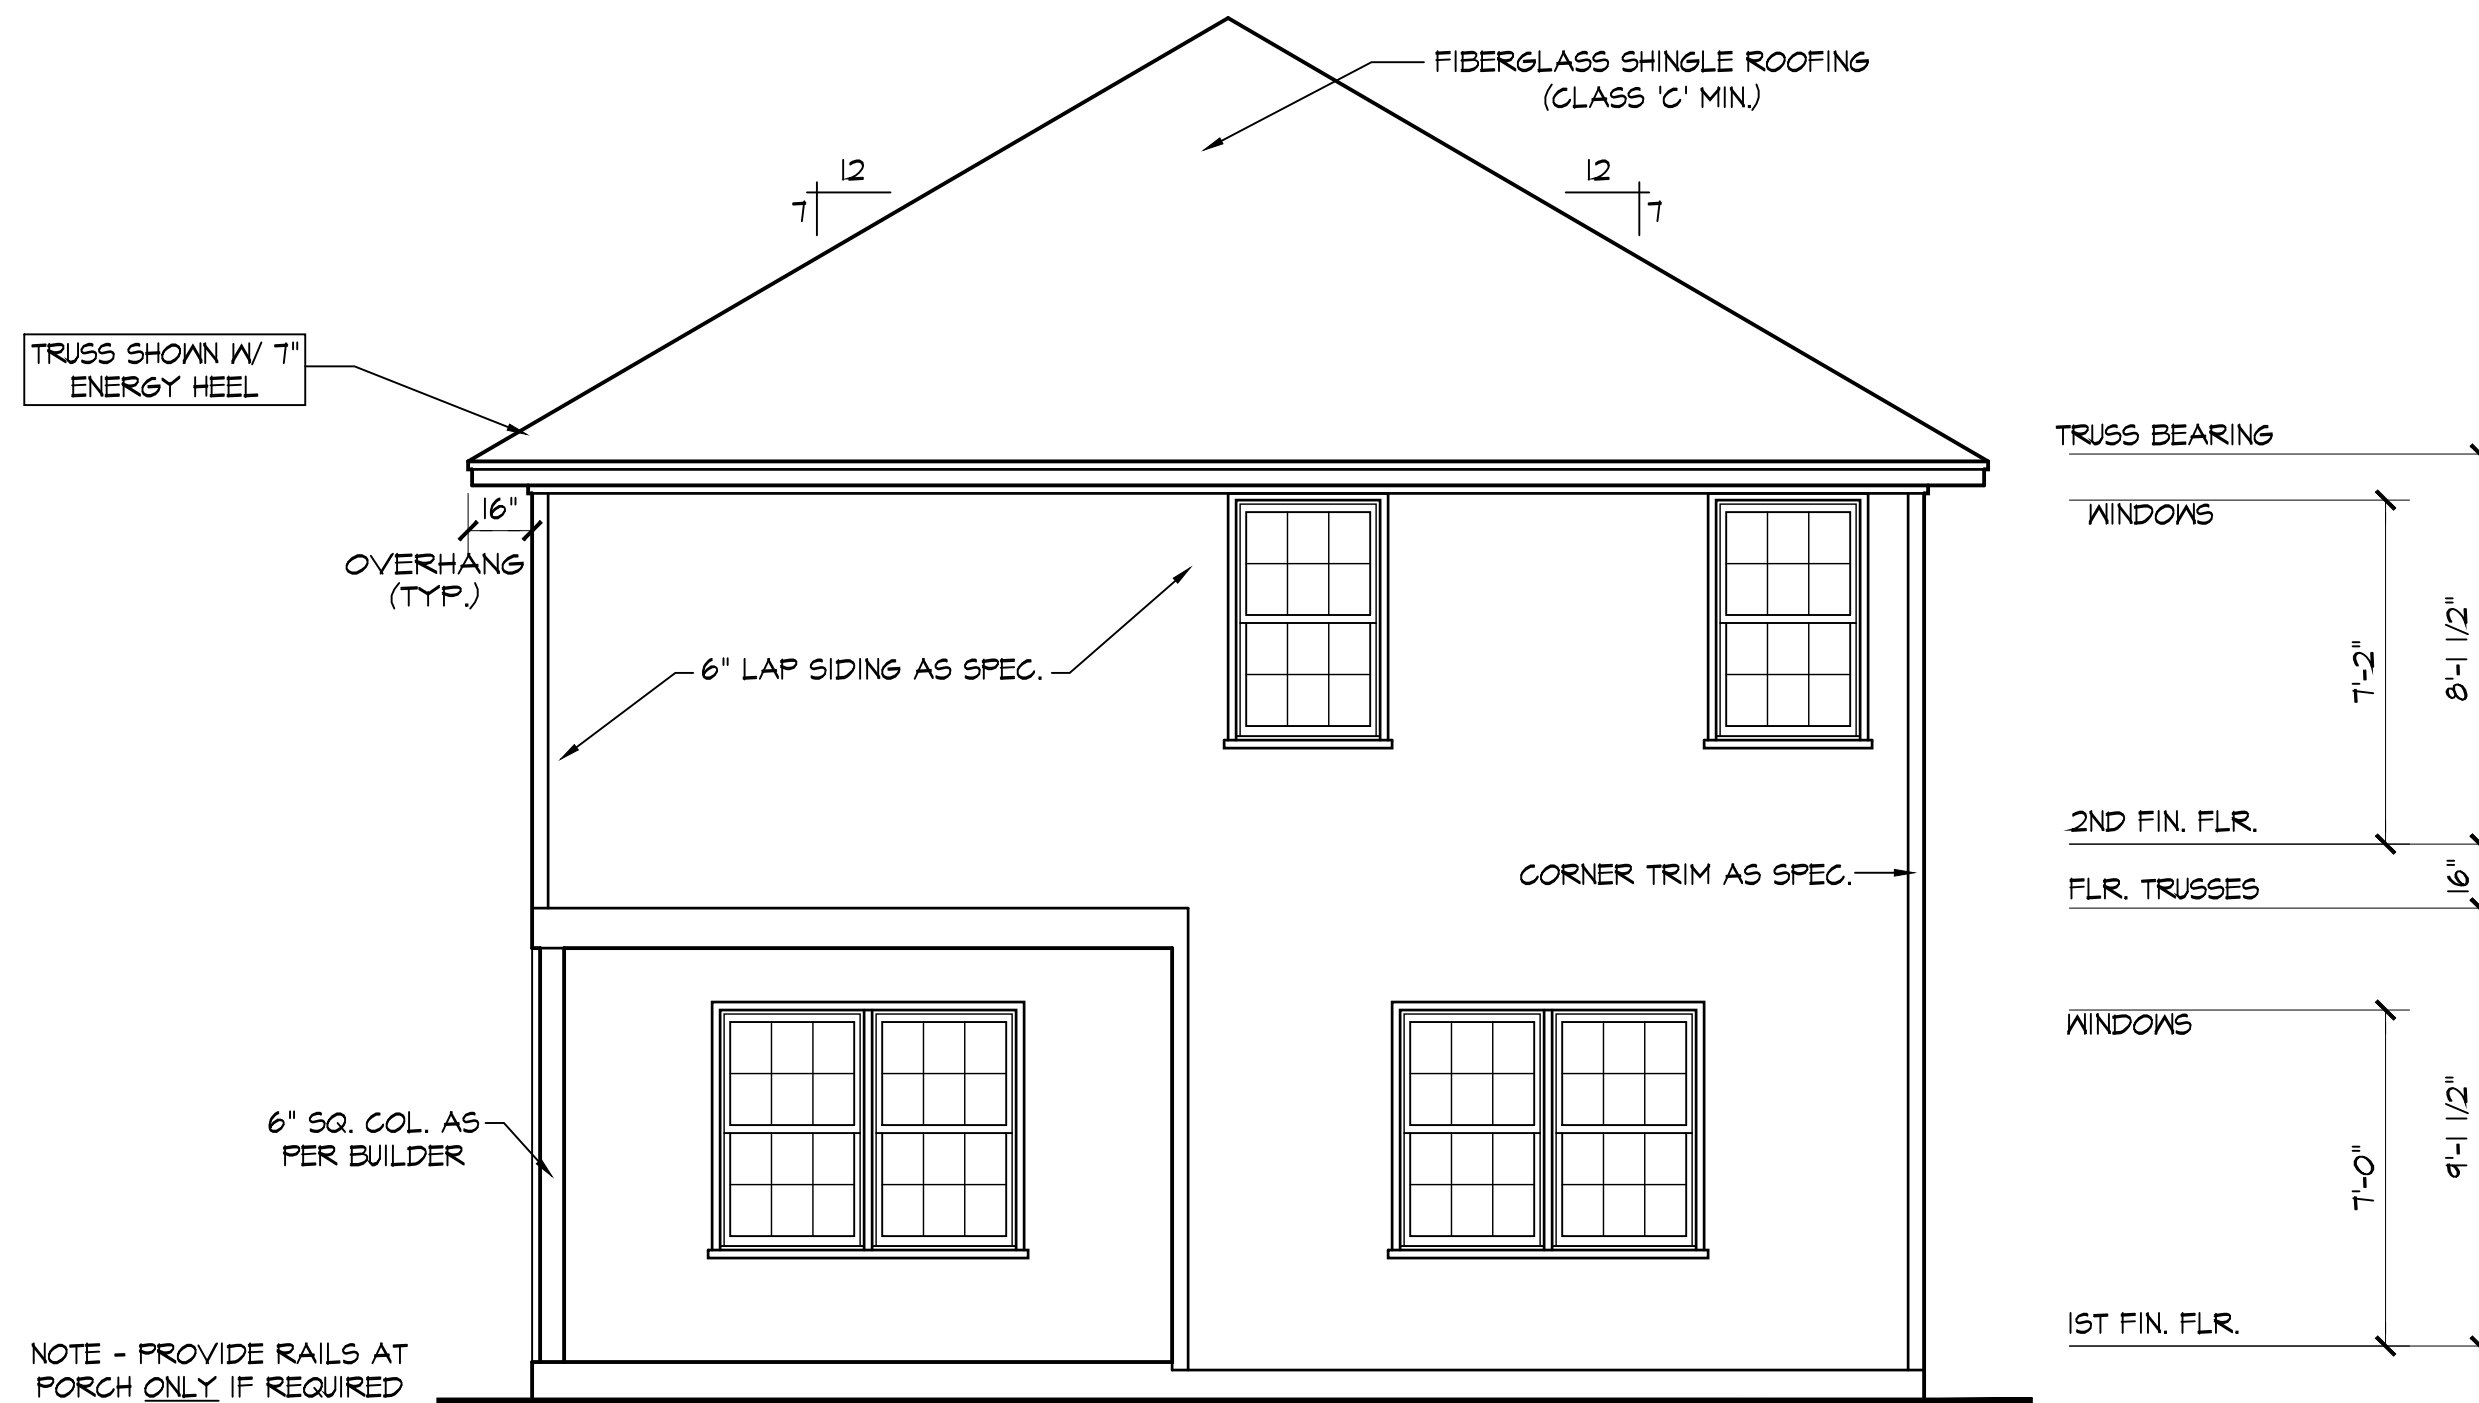



REAR ELEVATION

SCALE: 1/4"=1'-0"
NOTE - SLOPE ALL GRADES AWAY FROM HOUSE FOR POSITIVE DRAINAGE

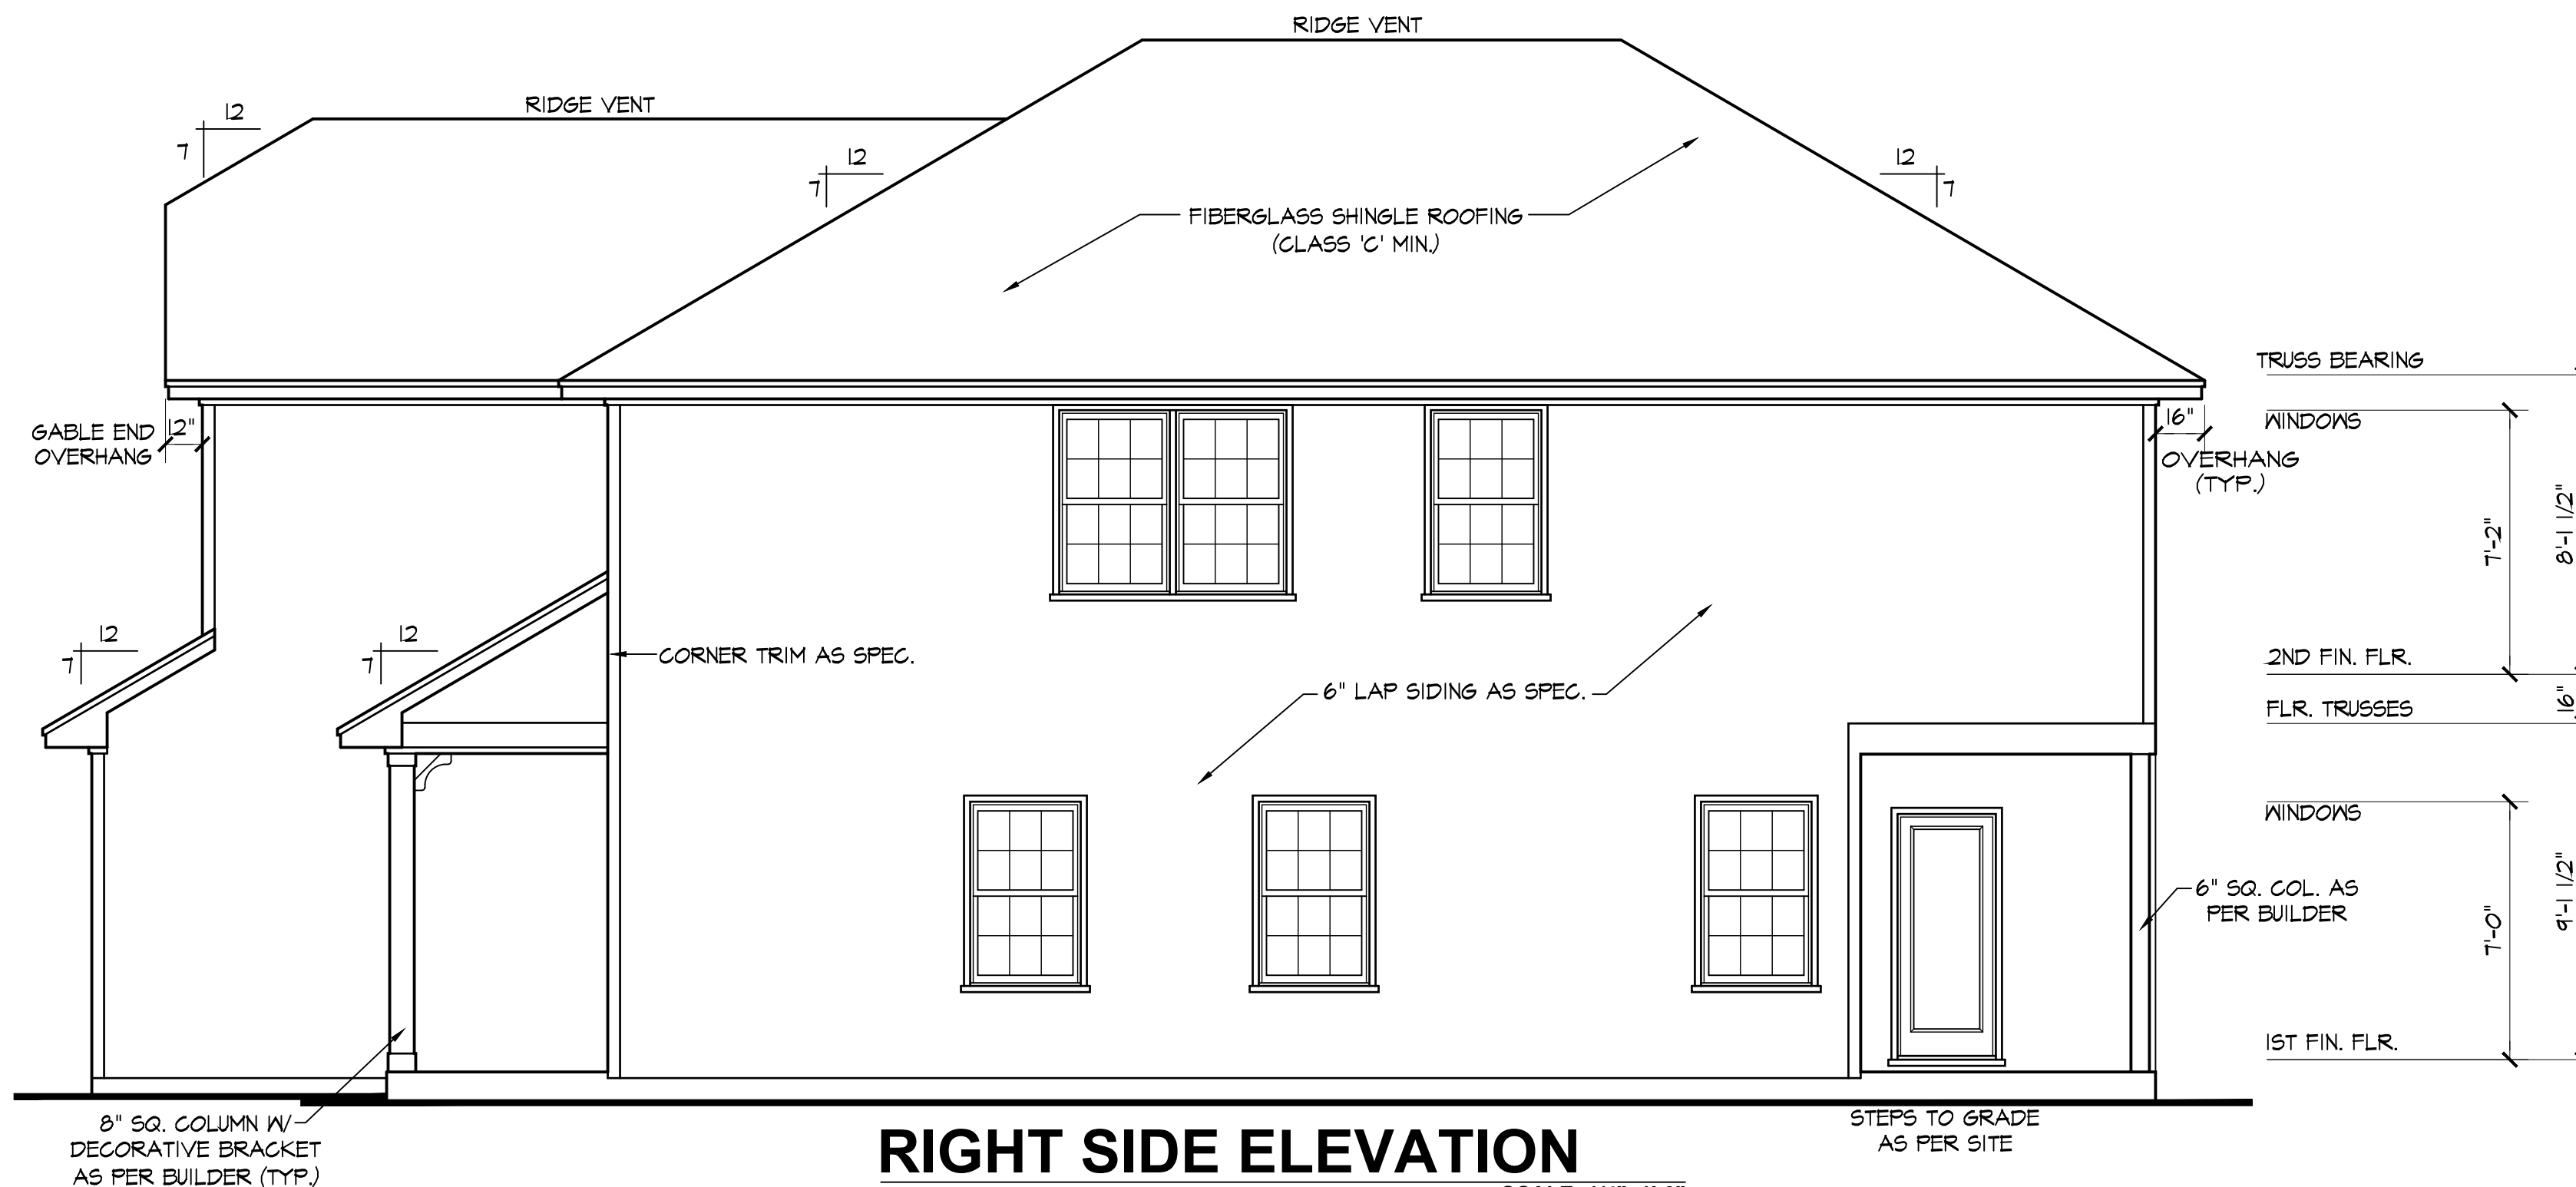

RIGHT SIDE ELEVATION

SCALE: 1/4"=1'-0"

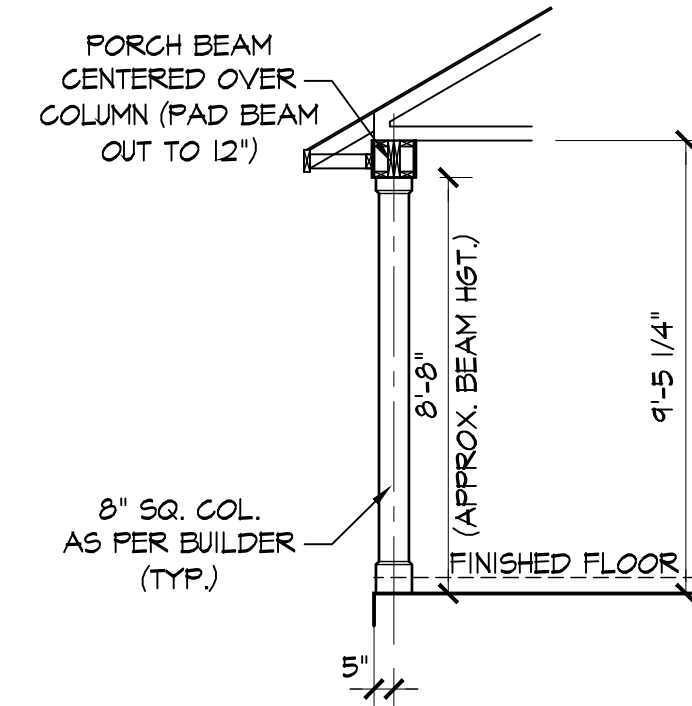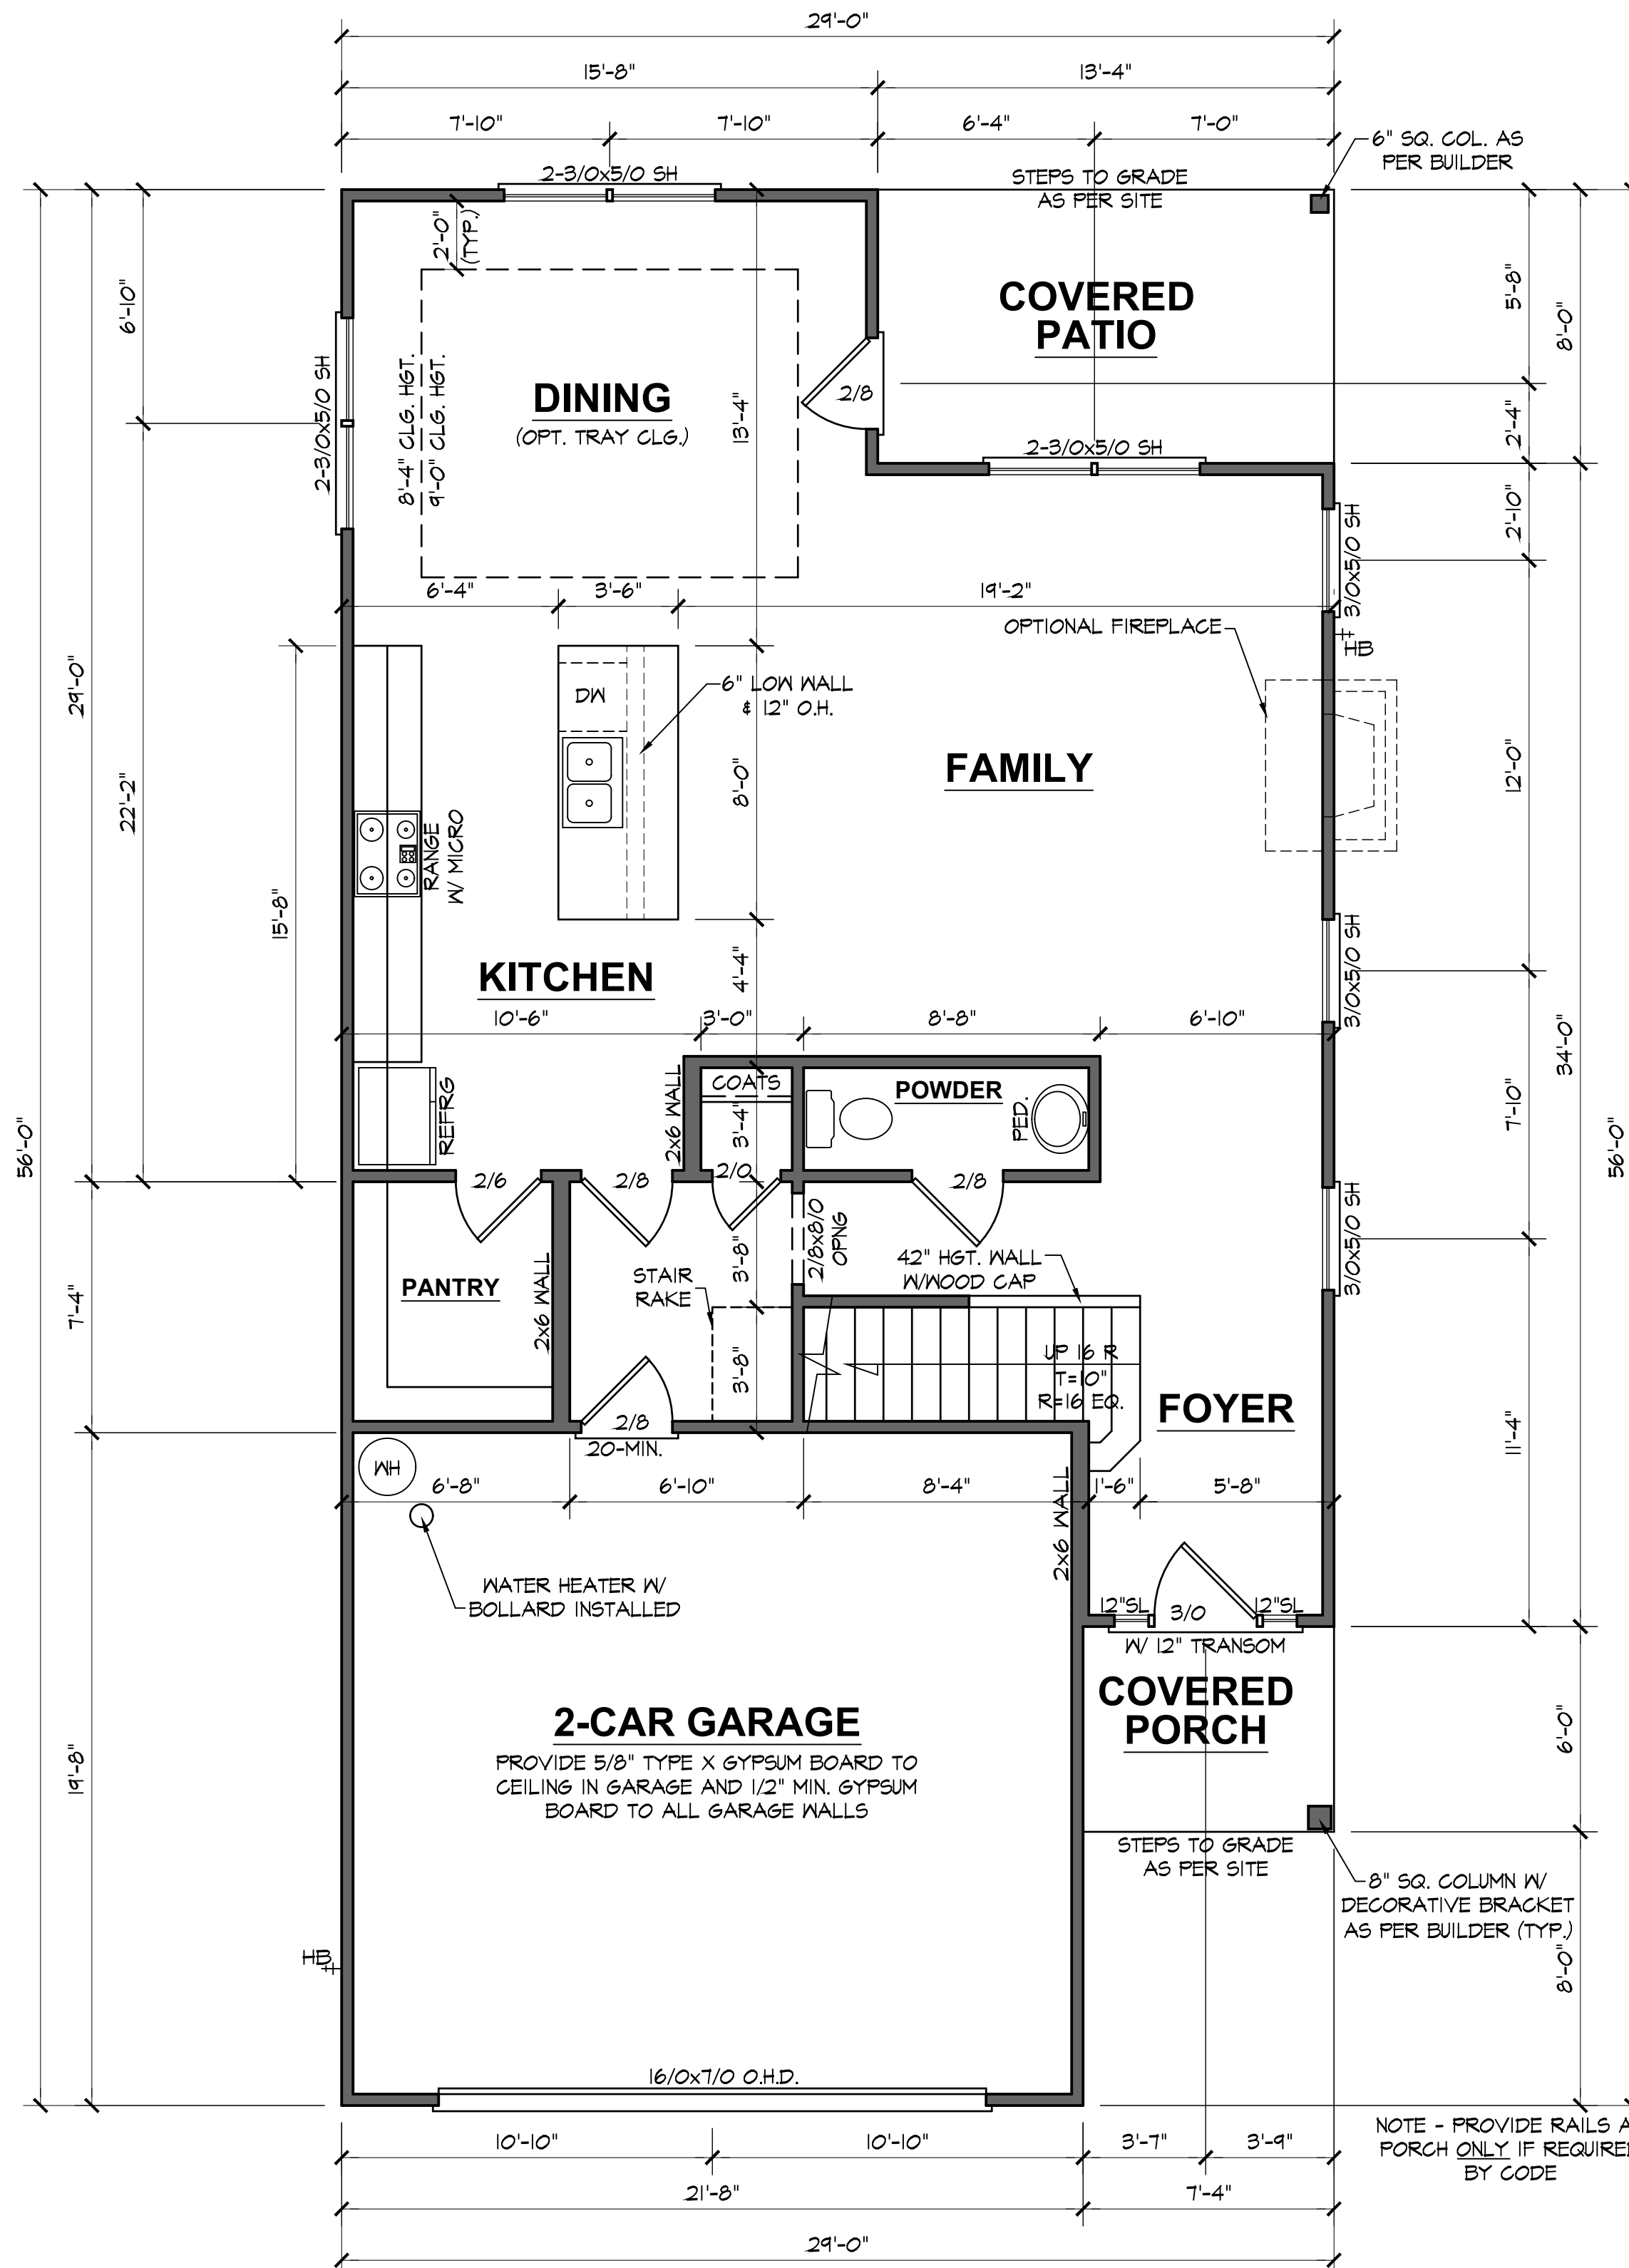

PORCH COLUMN DETAIL


2408 "B" FE L KC015

DATE DRAWN
2/11/2025
PROJECT
7379
REVISIONS

ELECTRICAL LEGEND

-  - LIGHT FIXTURE
-  - FAN/LIGHT
-  - WATERPROOF OUTLET
-  - RECESSED LIGHTING
-  - SINGLE PULL SWITCH
-  - 3-WAY SWITCH
-  - 4-WAY SWITCH
-  - DIMMER SWITCH
-  - SMOKE DETECTOR
-  - TROUGH LIGHTS
-  - EYEBALL SPOTS
-  - DUPLEX RECEPTACLE (110V)
-  - 220 VOLT RECEPTACLE
-  - SWITCHED RECEPTACLE (TOP WIRE ONLY)
-  - GROUND FAULT CIRCUIT INTERRUPTOR
-  - CLG FAN/LIGHTS
-  - TRACK LIGHTS
-  - FLUORESCENT LIGHTING
-  - CABLE OUTLET
-  - TELEPHONE OUTLET
-  - COMPUTER DATA OUTLET
-  - BURGLAR ALARM
-  - INTERCOM

NOTE: ALL ELECTRICAL TO BE VERIFIED BY OWNER/BUILDER BEFORE ROUGH-IN.

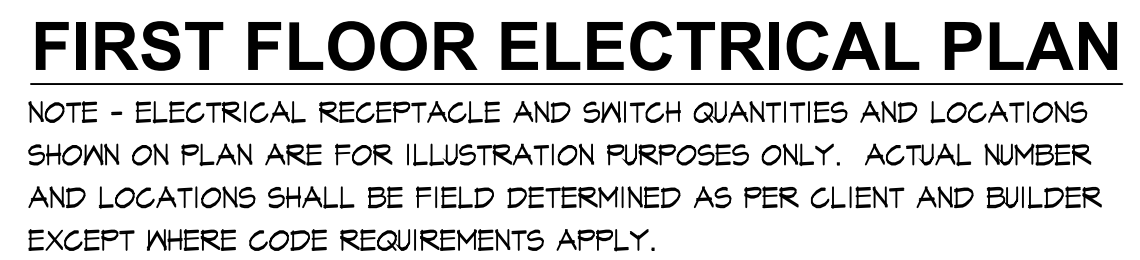

2408 "B" FE L KC015

SHEET

5

ELECTRICAL LEGEND

- LIGHT FIXTURE

- FAN/LIGHT

- WATERPROOF OUTLET

- RECESSED LIGHTING

- SINGLE FULL SWITCH

- 3-WAY SWITCH

- 4-WAY SWITCH

- DIMMER SWITCH

- SMOKE DETECTOR

- FLOOD LIGHTS

- EYEBALL SPOTS

- DUPLEX RECEPTACLE (110V)

- 220 VOLT RECEPTACLE

- SWITCHED RECEPTACLE (TOP WIRE ONLY)

- GROUND FAULT CIRCUIT INTERRUPTOR

- CL6 FAN/LIGHTS

- TRACK LIGHTS

- FLUORESCENT LIGHTING

- CABLE OUTLET


- TELEPHONE OUTLET

- COMPUTER DATA OUTLET

- BURGLAR ALARM

- INTERCOM

NOTE: ALL ELECTRICAL TO BE
VERIFIED BY OWNER/BUILDER
BEFORE ROUGH-IN.

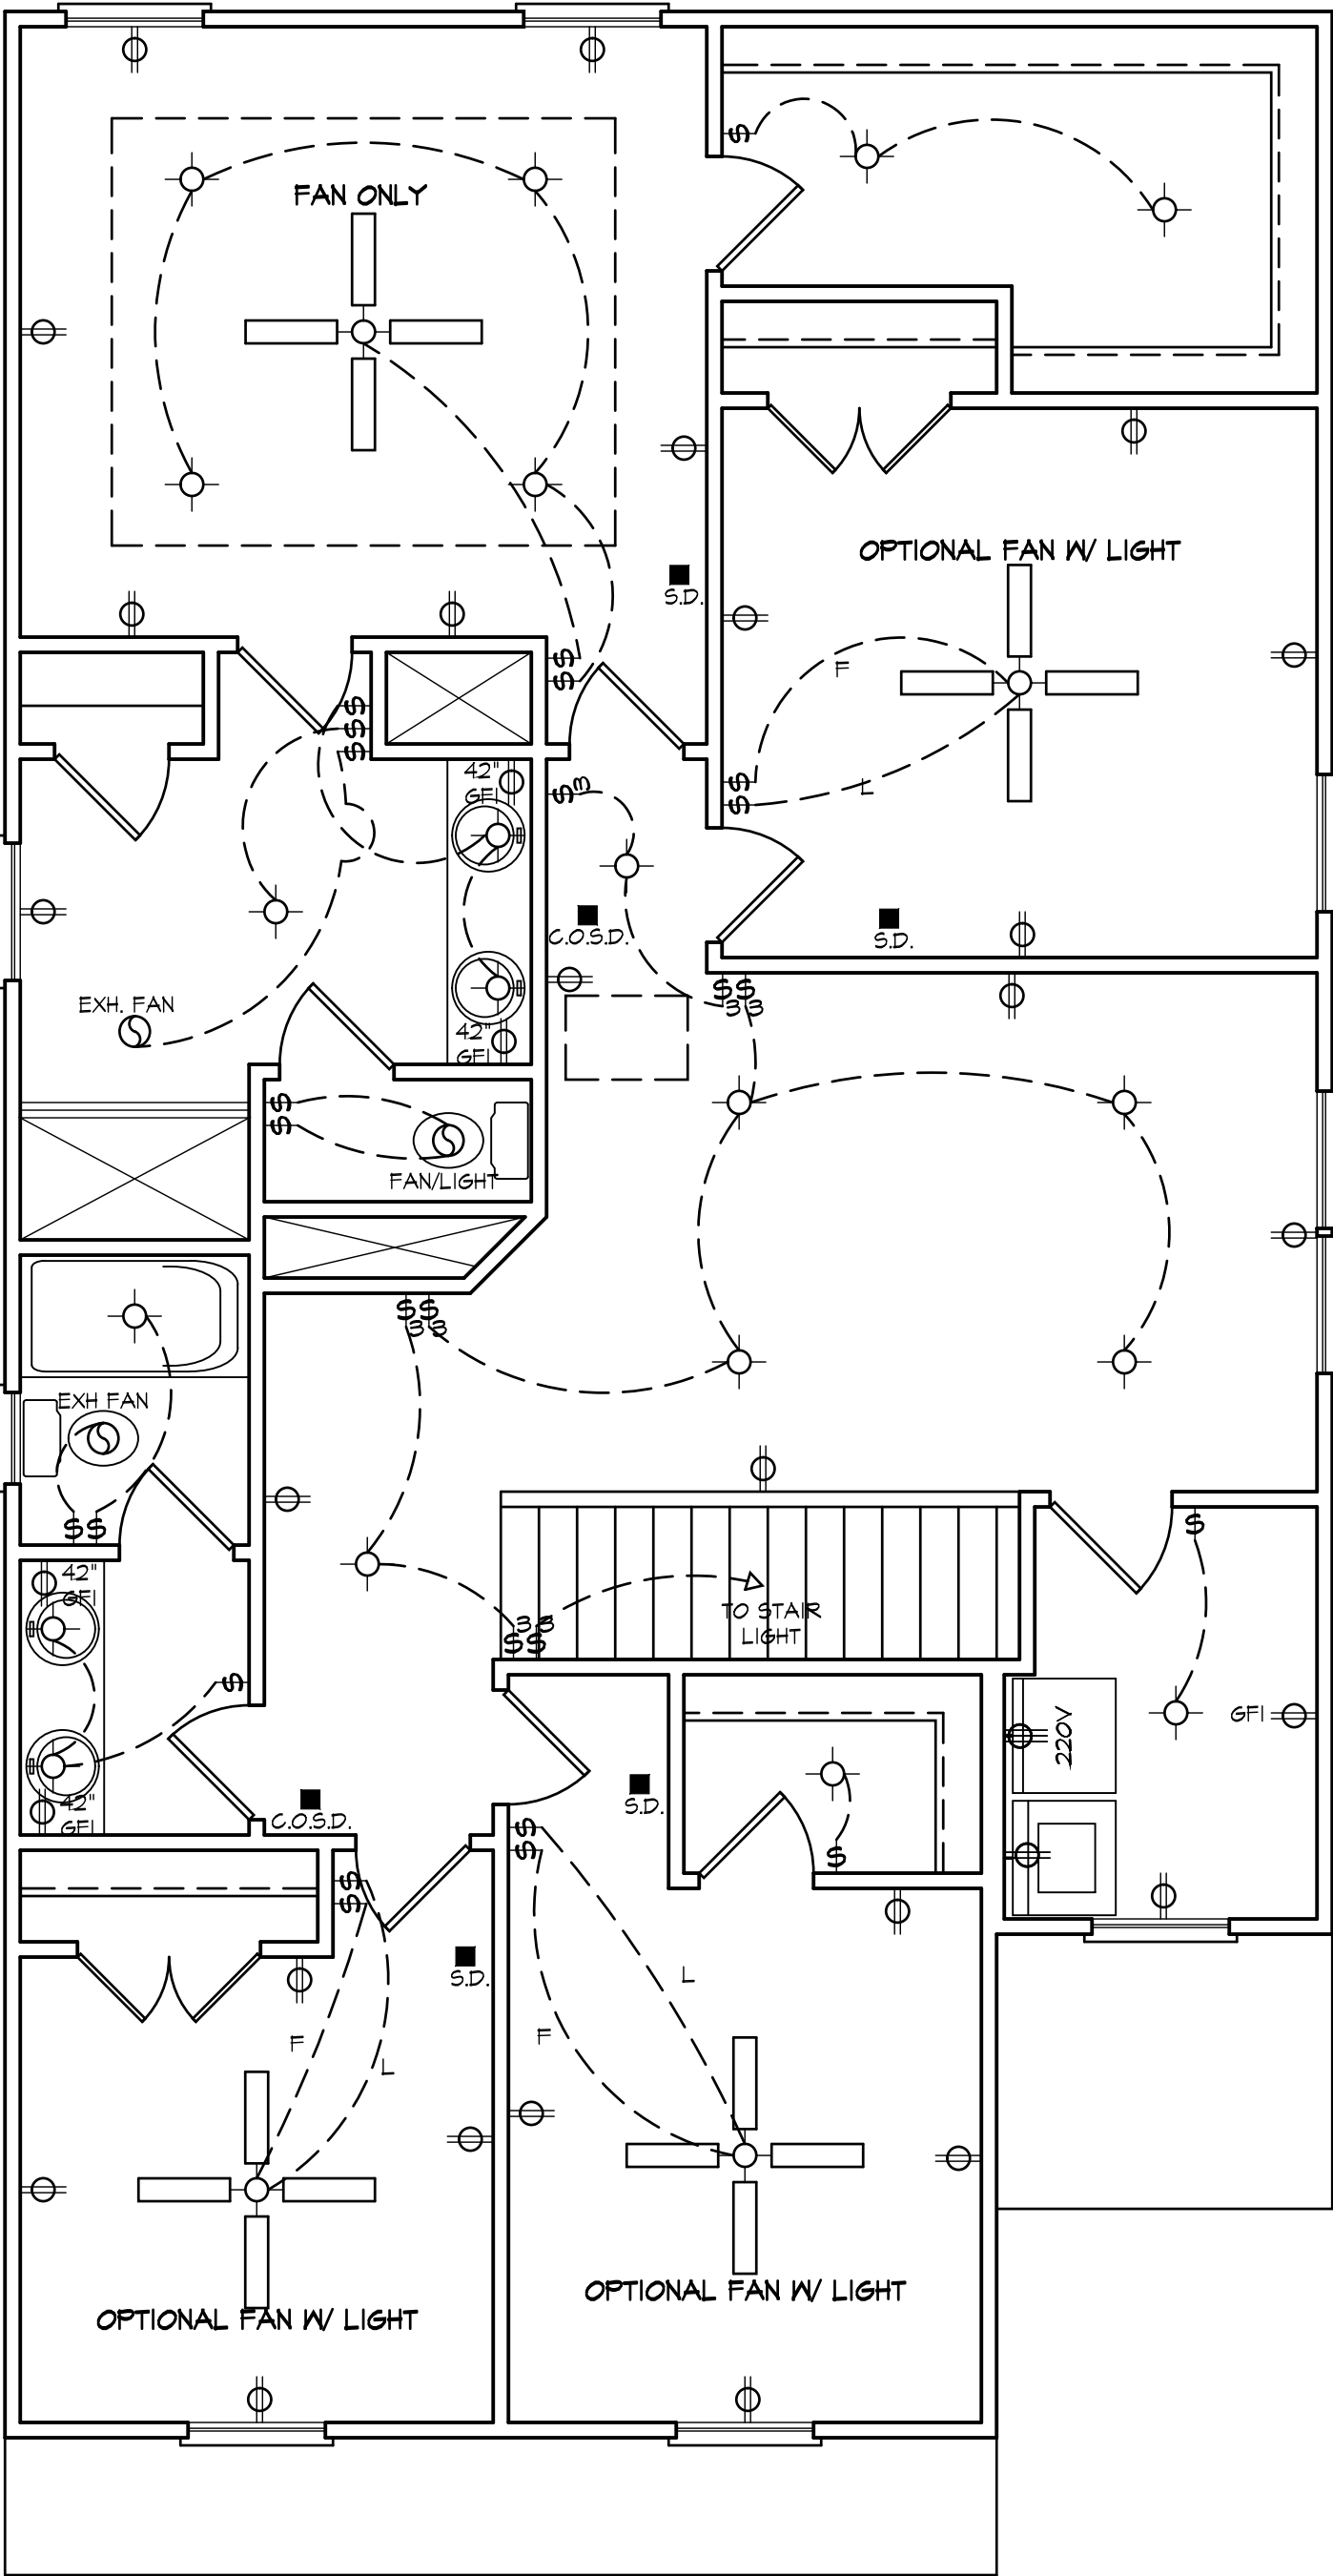

SECOND FLOOR ELECTRICAL PLAN


NOTE - ELECTRICAL RECEPTACLE AND SWITCH QUANTITIES AND LOCATIONS SHOWN ON PLAN ARE FOR ILLUSTRATION PURPOSES ONLY. ACTUAL NUMBER AND LOCATIONS SHALL BE FIELD DETERMINED AS PER CLIENT AND BUILDER EXCEPT WHERE CODE REQUIREMENTS APPLY.

2408 "B" FE L KC015

DATE DRAWN
2/11/2025
PROJECT
7379
REVISIONS

SHEET
6



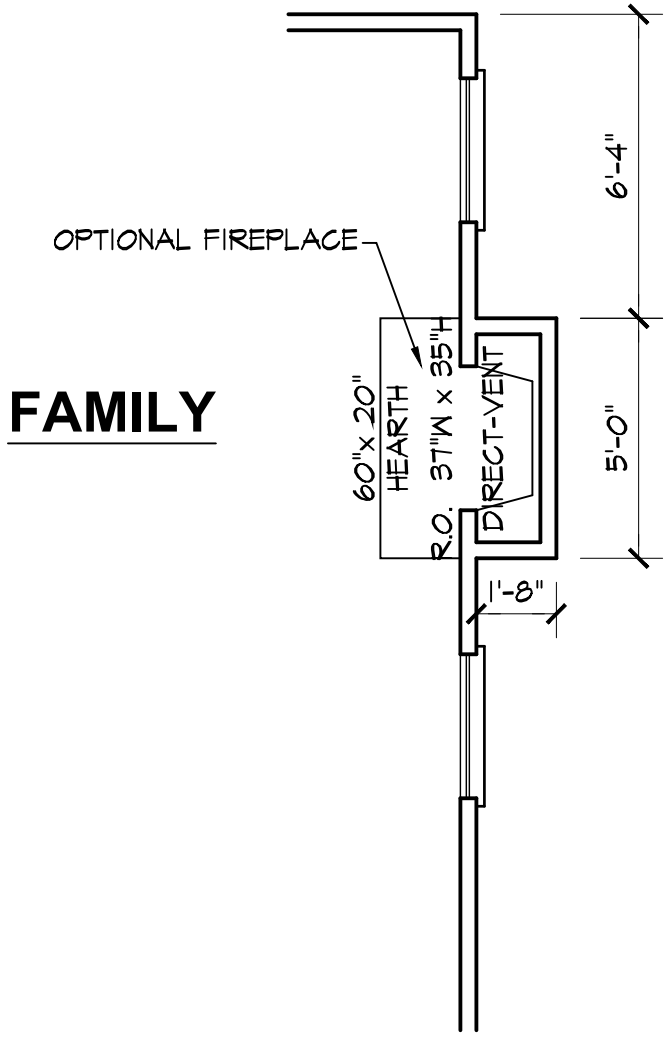

FAMILY

OPTIONAL FIREPLACE
SEE FLOOR PLAN FOR TYPICAL NOTES & DIMENSIONS



FLOOR PLAN OPTION SHEET

2408 "B" FE L KC015



DATE DRAWN
2/11/2025
PROJECT
7379
REVISIONS

SHEET
opt1





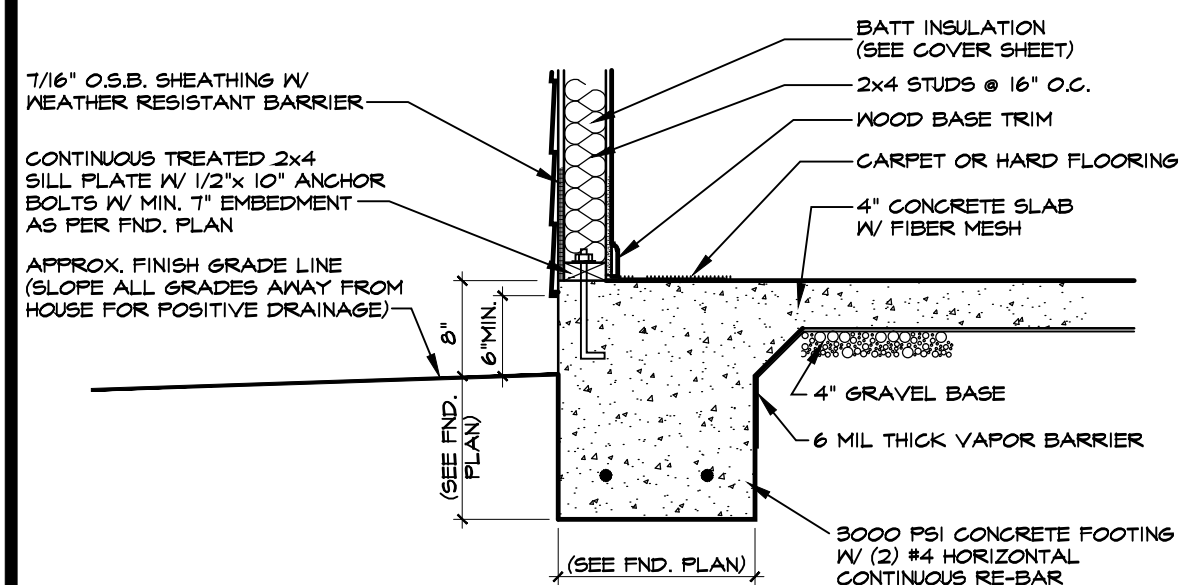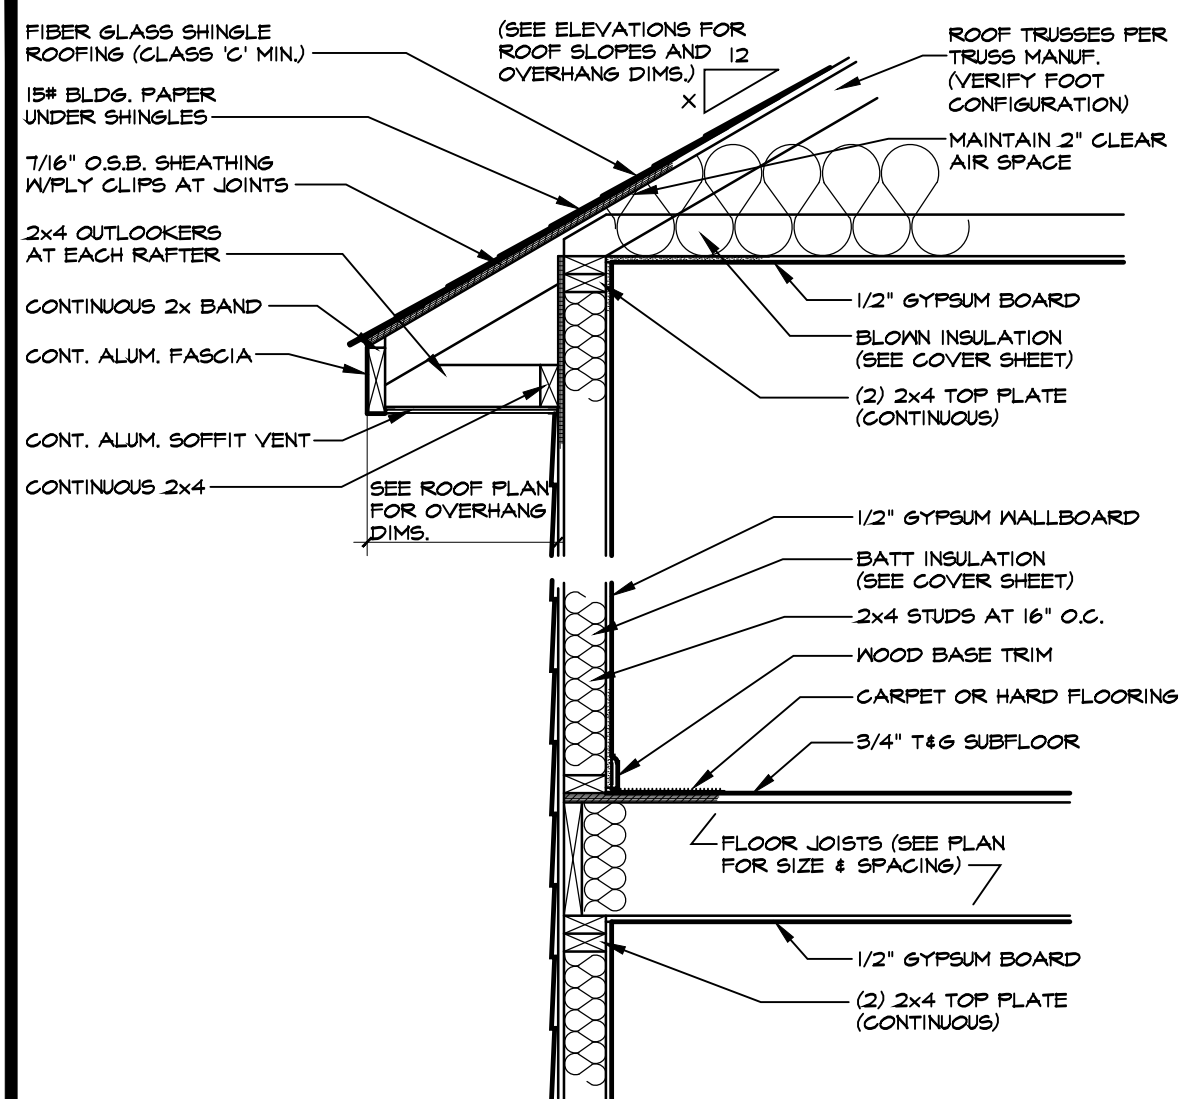


1 TWO-STORY WALL SECTION W/SIDING
SCALE: 3/4"=1'-0"

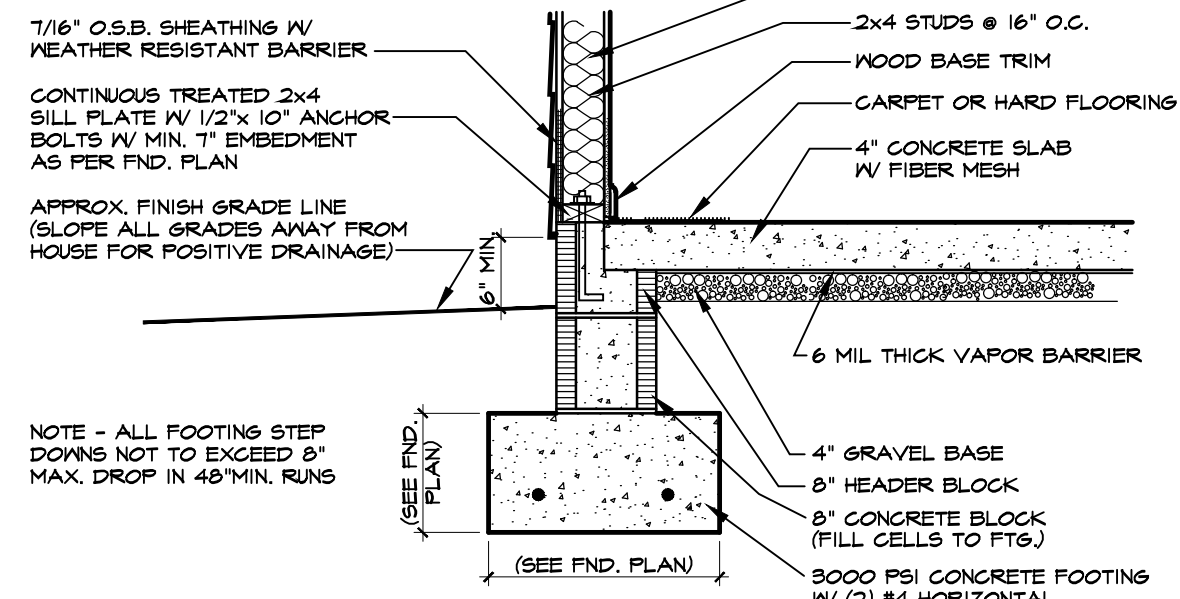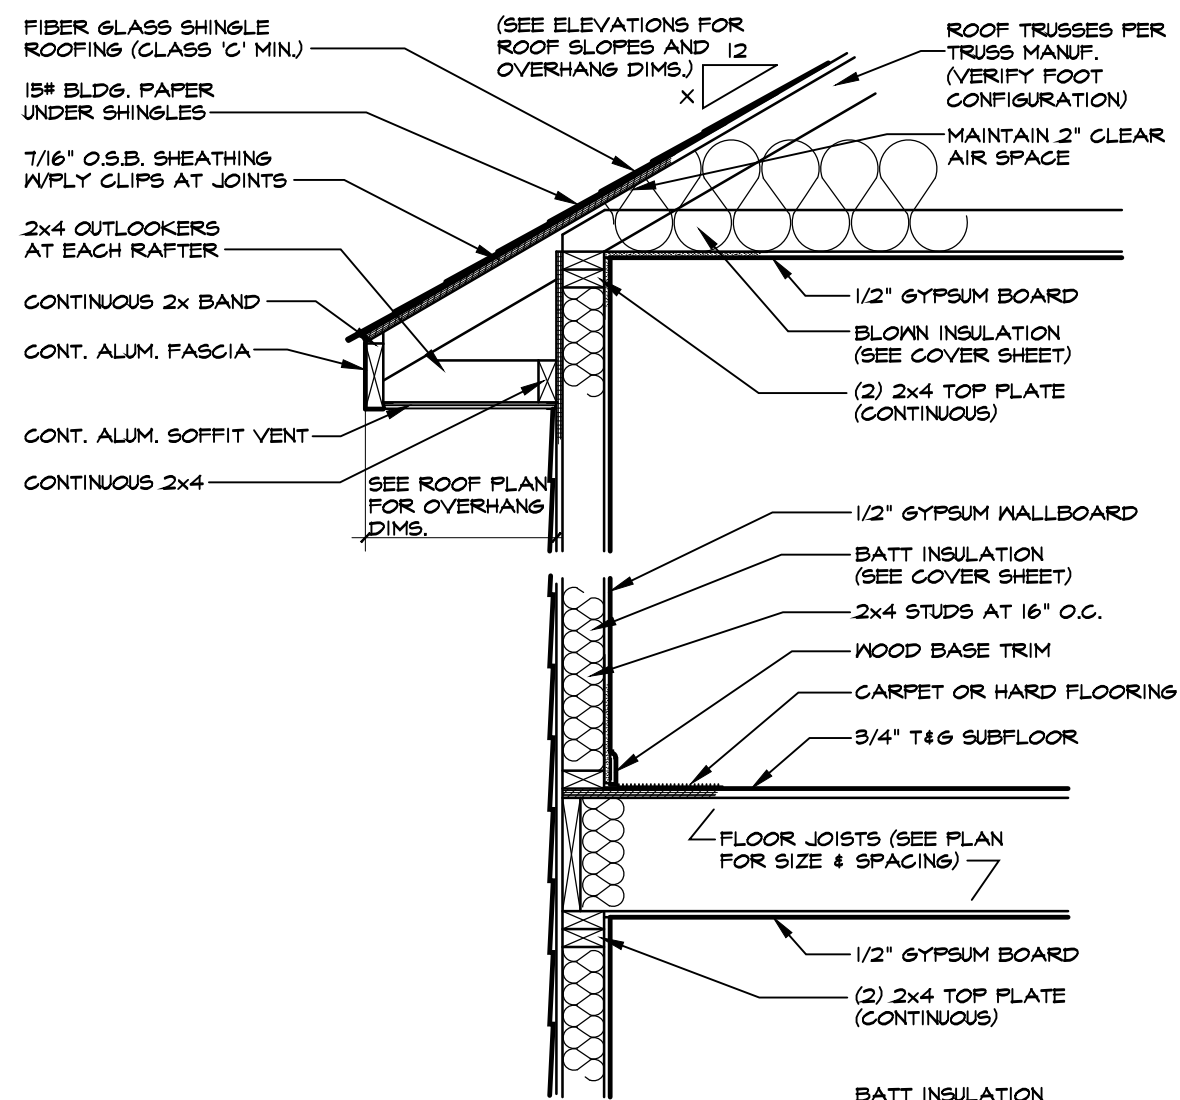


2 TWO-STORY WALL SECTION W/SIDING
SCALE: 3/4"=1'-0"

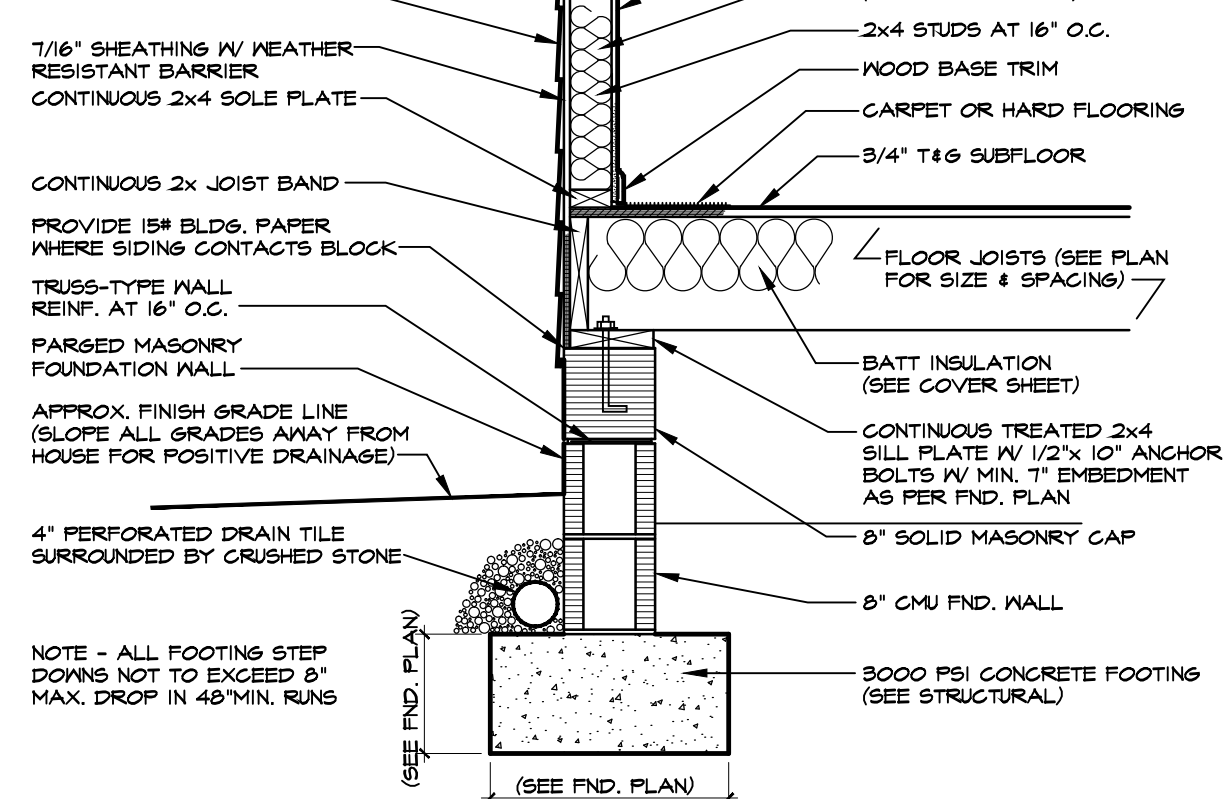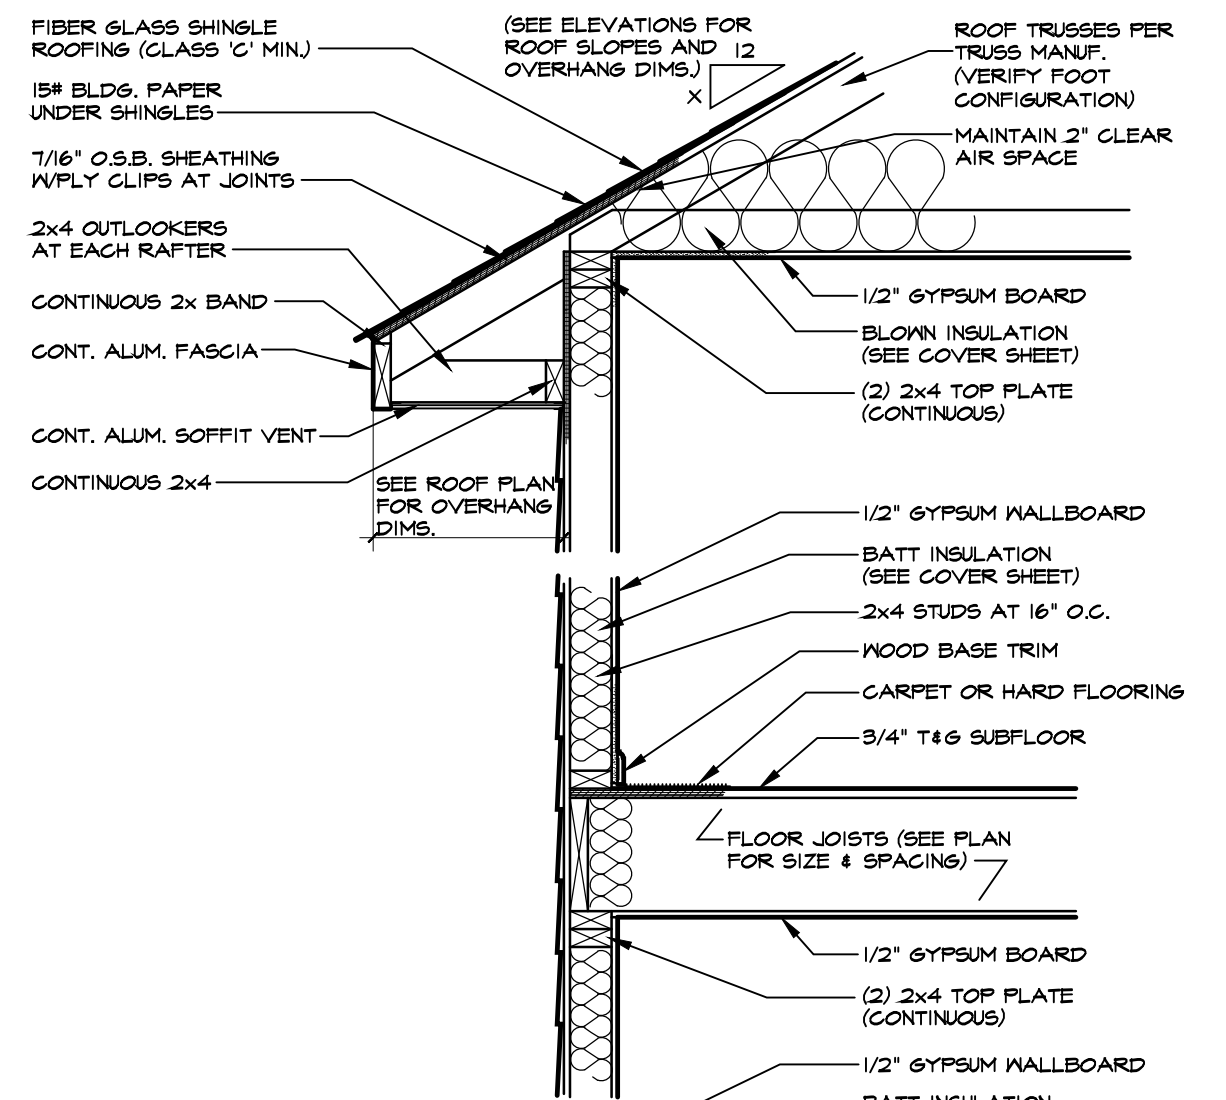

3 TWO-STORY WALL SECTION W/SIDING


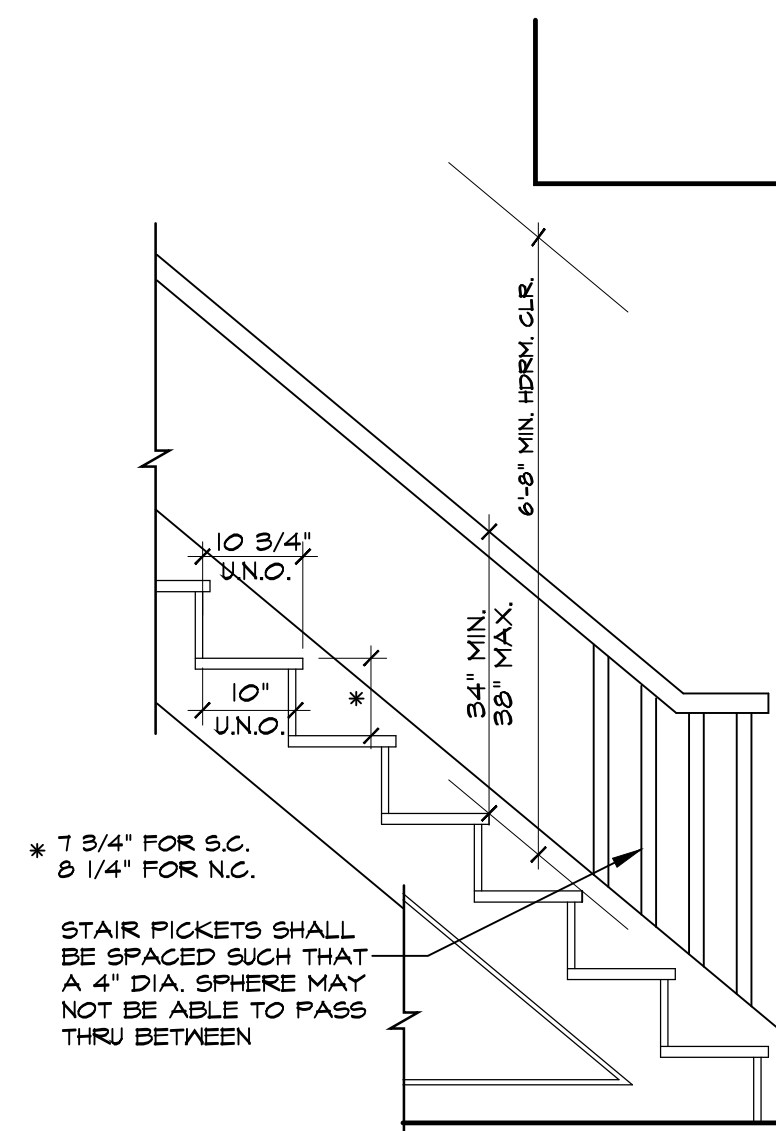


4 TYPICAL STAIR DETAIL

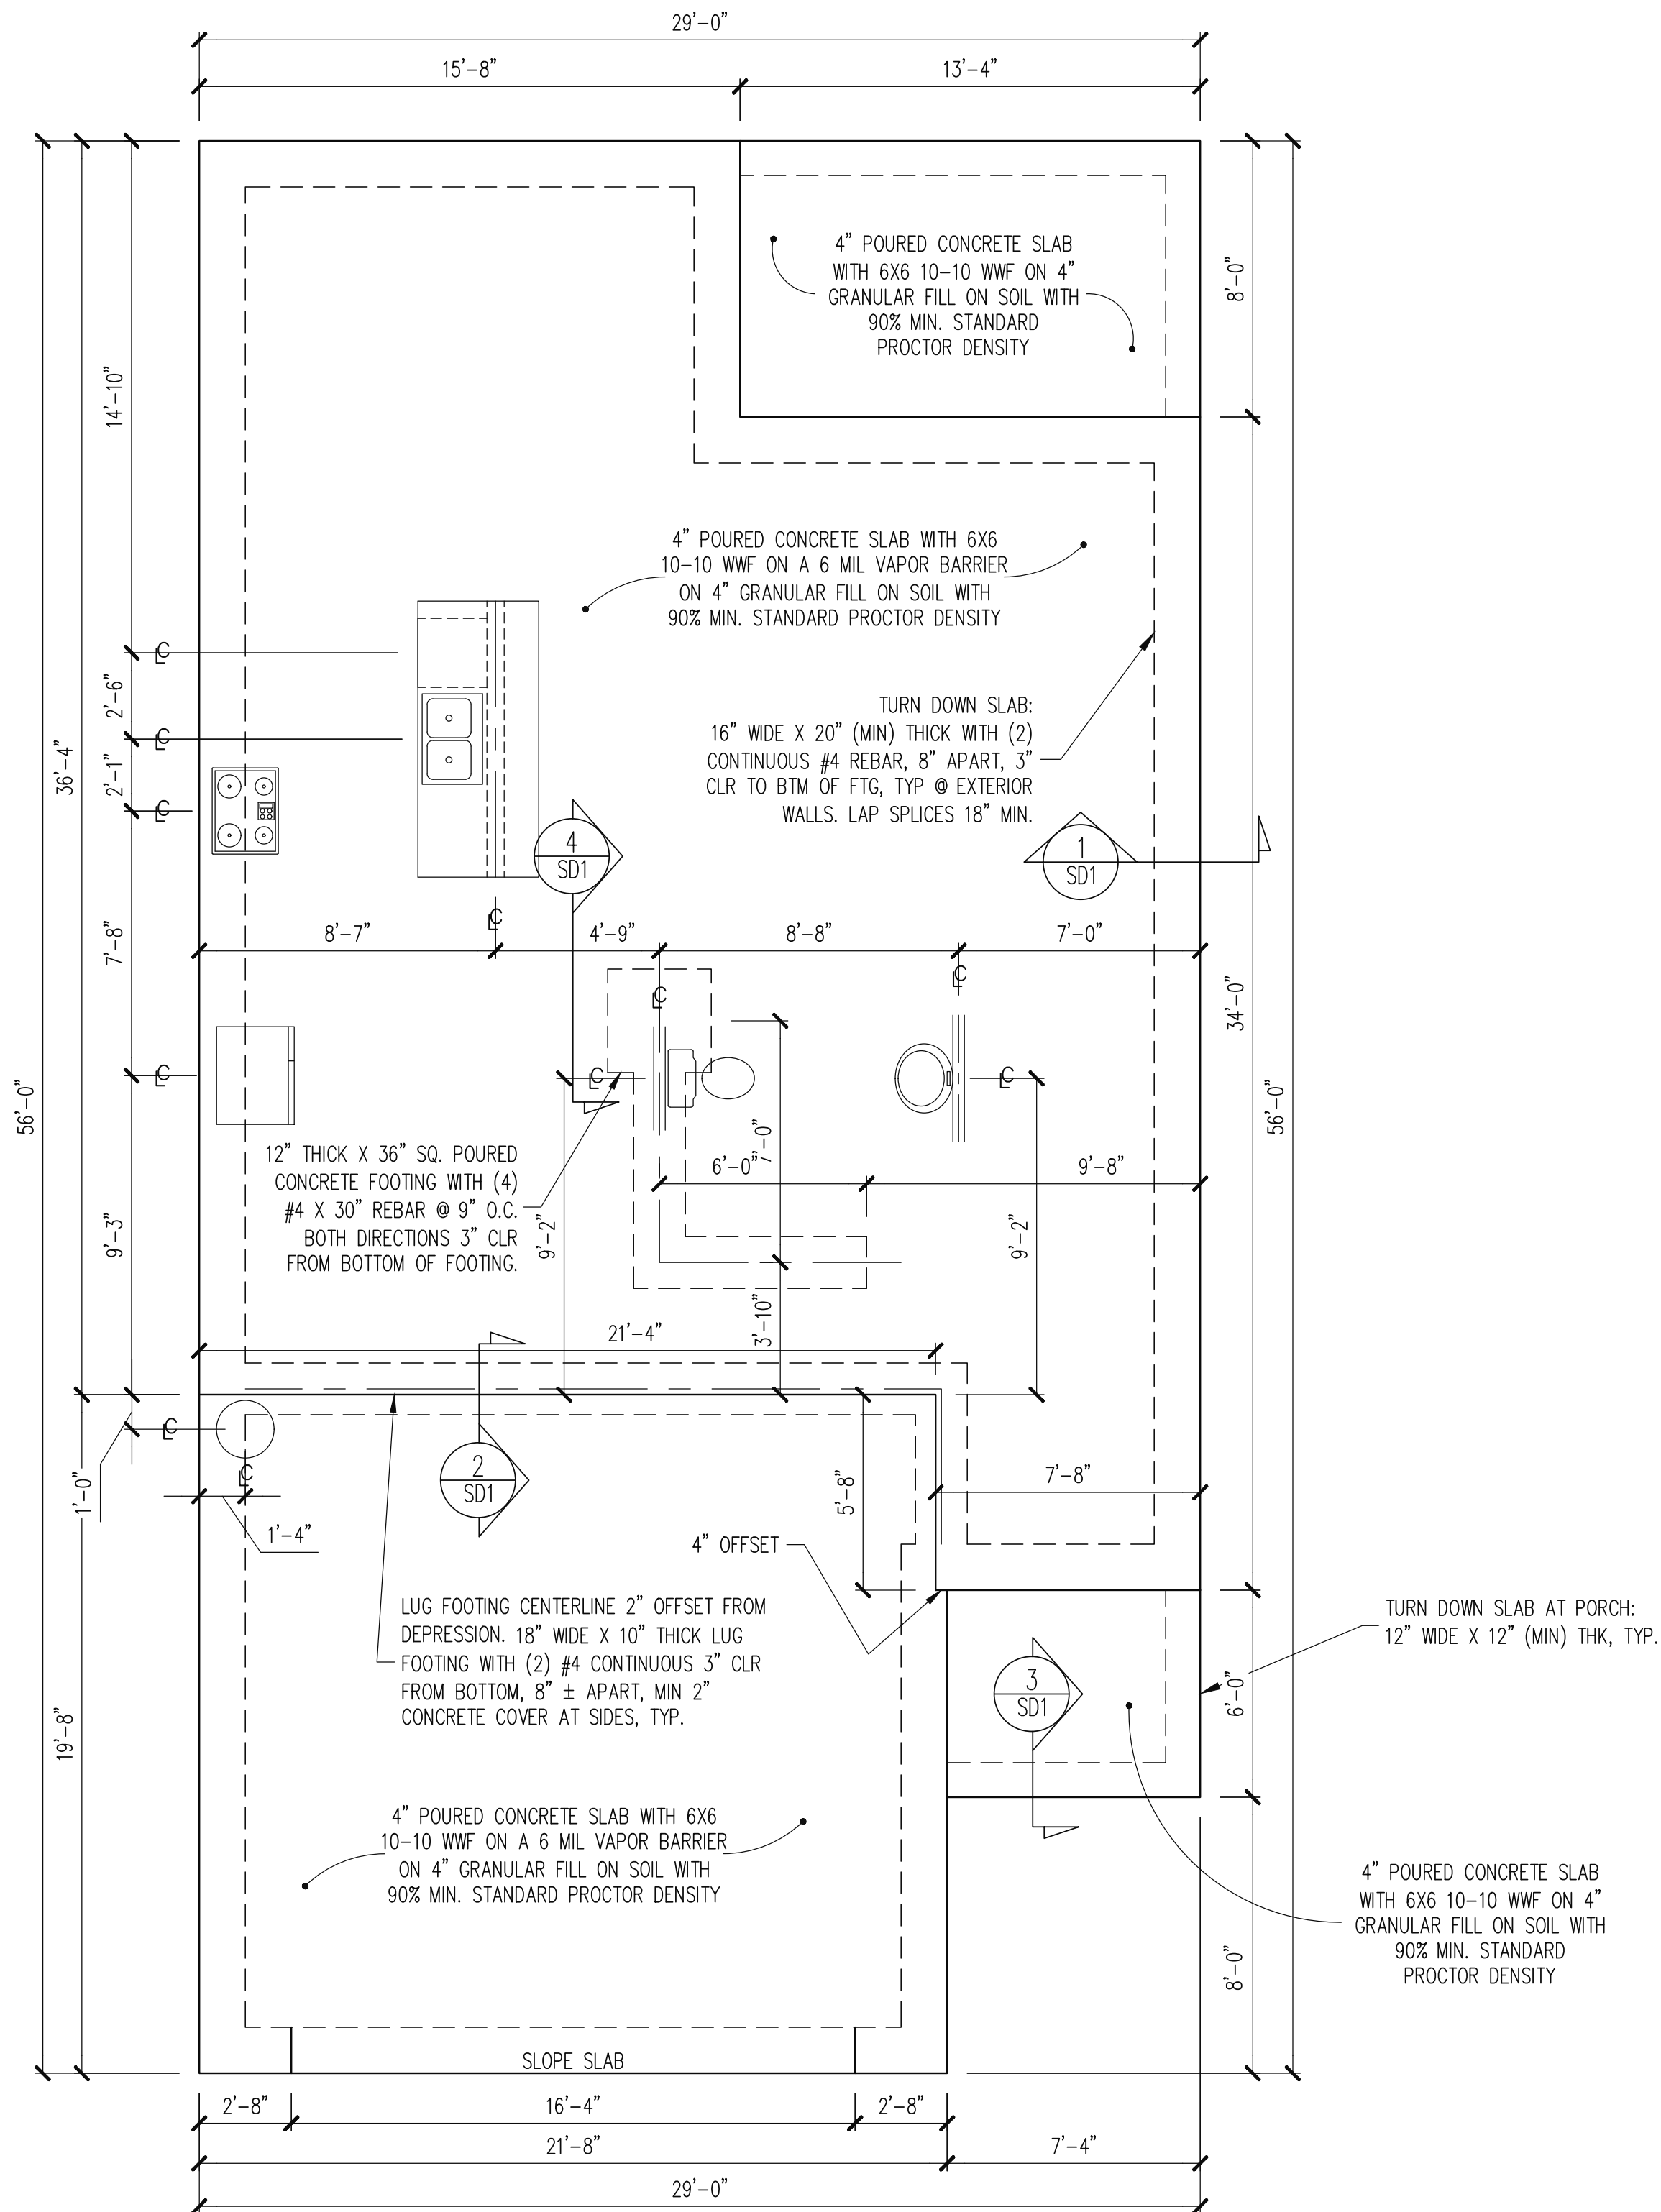

The structural design of this plan is the property of Engineering Tech Associates, P.A. These plans are for the one time use at the location and for the client listed. Engineering Tech Associates, P.A. assumes no liability for these plans if they are reproduced, in whole or in part, for construction at any other location without written permission from Engineering Tech Associates, P.A.

STRUCTURAL ENGINEERS
License No. C-3870
318 W Millbrook Road, Unit 201
Raleigh, North Carolina 27609
Phone: (919) 844-1661

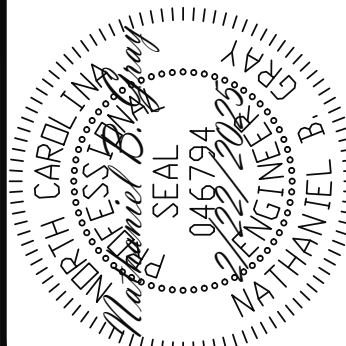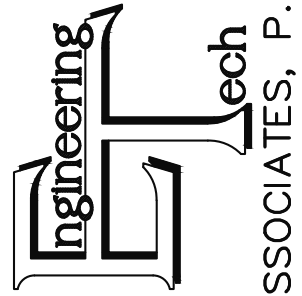

PLAN DESIGNED UNDER
2018 NORTH CAROLINA
RESIDENTIAL CODE

- NOTES:
- HEIGHT AND BACKFILL LIMITATIONS FOR FOUNDATION WALLS ARE TO BE GOVERNED BY THE NCSBC, LATEST EDITION.
 - FIBER MESH REINFORCED CONCRETE MAY BE USED IN LIEU OF WELDED WIRE FABRIC. SEE SECTION 6.01 OF THE CONSTRUCTION SPECIFICATIONS FOR ALLOWABLE SUBSTITUTION DETAILS.
 - ALL APPLIANCE AND PLUMBING LOCATIONS ARE FOR REFERENCE ONLY. FINAL LOCATIONS MUST BE VERIFIED WITH ARCHITECTURAL FLOOR PLANS.


FOUNDATION PLAN
MONO SLAB OPTION
1/4" = 1'-0"

ADAMS HOMES			
STRUCTURAL ADDENDUM			
SCOPE:	LOT #:	15 KIPLING CREEK	ENG: NBG
			REV:
	2408 MASTER		DATE: 2/22/2025

PLAN NO.
2408

PROJECT NO.
25-18-075

SHEET NO.
S1
1 of 7

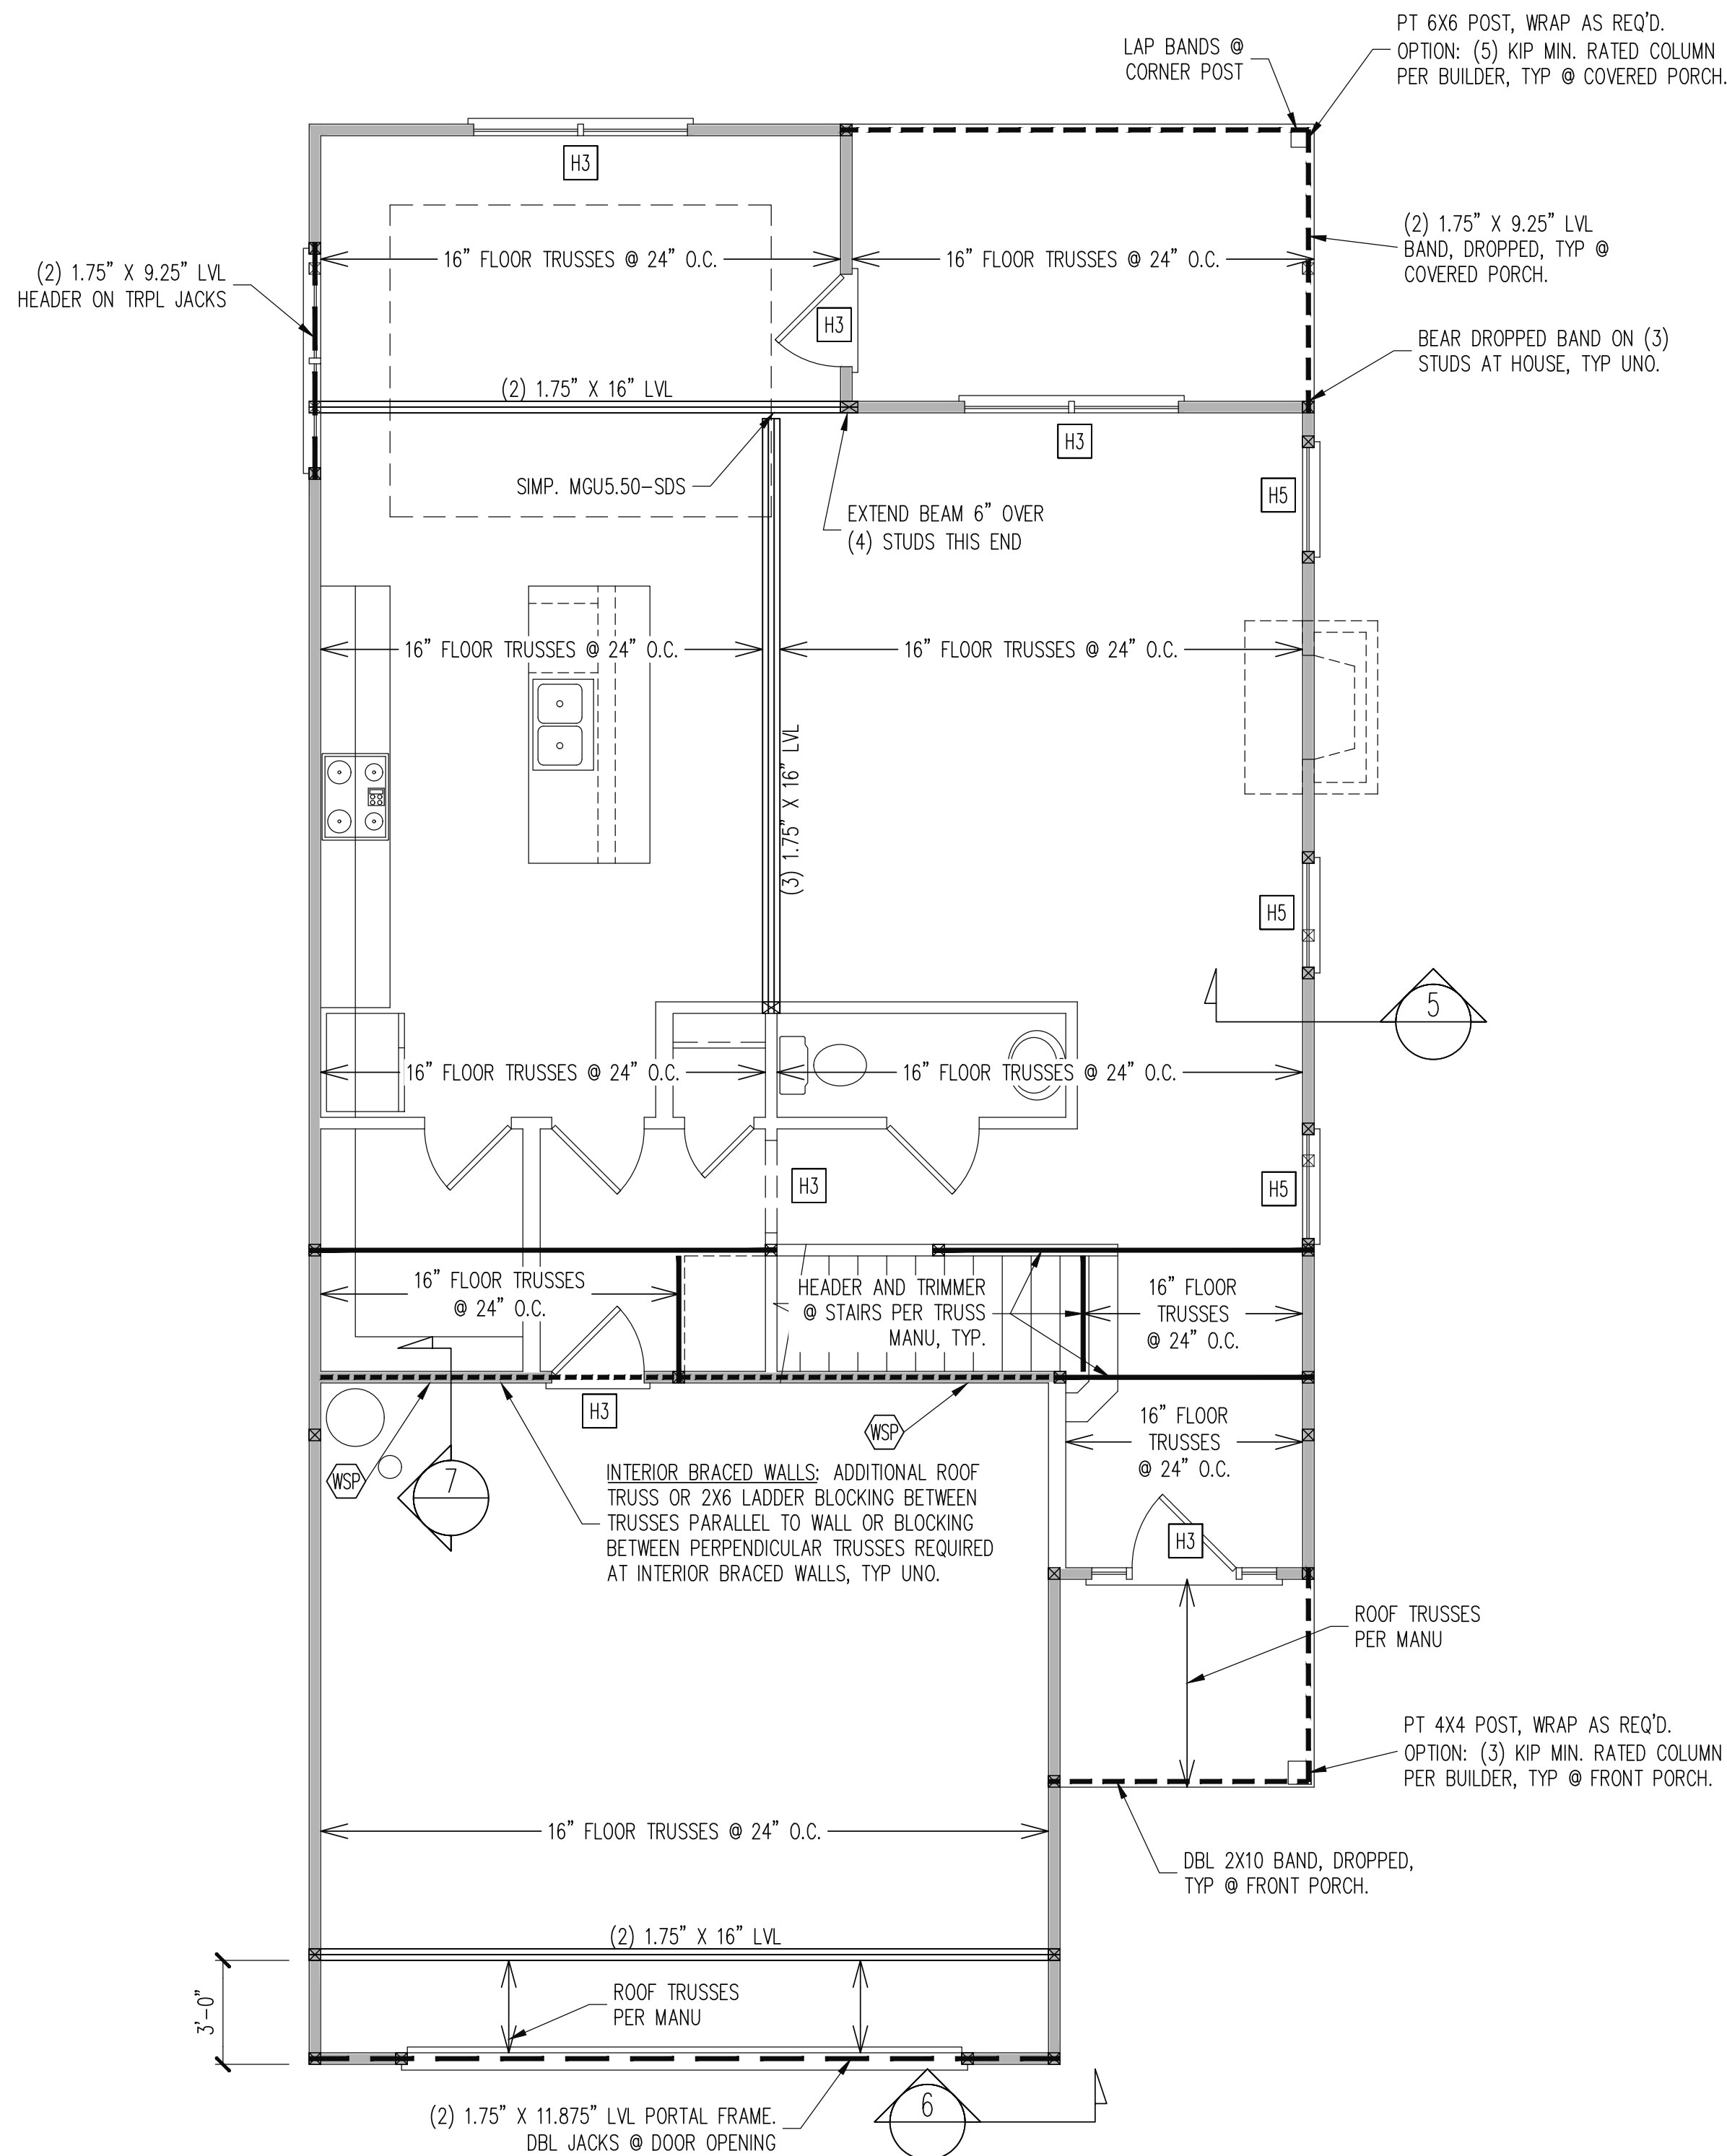

REQUIRED STUDS FOR BEAM SUPPORT

REFER TO SECTIONS 5.02 – 5.06 OF THE
CONSTRUCTION SPECIFICATIONS FOR REQUIRED
NUMBER OF STUDS FOR BEAM SUPPORT, TYP UNO.

HEADER SCHEDULE

- H1 SINGLE 2X4 TURNED FLAT (A)
H2 (2) 2X4'S ON SINGLE JACKS (B)
H3 (2) 2X10'S ON SINGLE JACKS (C)
H4 (2) 1.75" X 9.25" LVL'S ON DBL JACKS
H5 (2) 2X10'S ON DBL JACKS

- (A) TYPICAL FOR INTERIOR NON LOAD BEARING
WALLS ONLY, ROUGH OPENING 38" MAX.
(B) TYPICAL FOR INTERIOR NON LOAD BEARING
WALLS ONLY, ROUGH OPNG 38" TO 74" MAX.
(C) TYPICAL FOR ALL CONDITIONS NOT LISTED
IN (A) OR (B) UNO.

NOTES:

- HEADERS IN NON LOAD BEARING INTERIOR
WALLS ARE NOT LABELED.
- KING STUDS EXTERIOR WALLS:
SINGLE KING STUDS FOR 6' MAX OPENINGS.
DBL KING STUDS FOR 10' MAX OPENINGS.
TRPL KING STUDS FOR 14' MAX OPENINGS.
QUAD KING STUDS FOR 18' MAX OPENINGS.
FOR 2X6 WALLS, ONE HALF THE AMOUNT OF
KING STUDS REQUIRED (ROUND UP) UNO

WALL BRACING

ALL EXTERIOR STUD WALLS ARE TO BE
CONTINUOUSLY SHEATHED WITH 7/16 APA RATED
OSB NAILED TO STUDS WITH 8d NAILS @ 6" O.C. AT
PANEL EDGES, 12" O.C. IN PANEL FIELD.

SINGLE JOIST, CONTINUOUS RIM JOIST, OR BLOCKING
OF EQUAL DEPTH IS REQUIRED ABOVE AND BELOW
ALL BRACED WALLS. NAIL BLOCKING ABOVE WALL TO
TOP PLATE WITH 8d TOE NAILS @ 6" O.C. NAIL
SOLE PLATE OF BRACED WALL TO BLOCKING BELOW
WITH (3) 16d NAILS @ 16" O.C. BLOCKING AT
HORIZONTAL JOINTS IN BRACED WALL LINES ONLY
REQUIRED AT SHADED WALLS, UNO.

SHADED WALLS:

WSP – INTERIOR BRACED WALL WITH $\frac{3}{8}$ " MIN.
THICKNESS WOOD STRUCTURAL PANELING, (1)
SIDE. ATTACH WSP TO STUD WALL WITH 8d
NAILS @ 6" O.C. AT PANEL EDGES, 12" O.C. IN
PANEL FIELD. BLOCK AT ALL PANEL EDGES.

PROVIDED CONTINUOUS SHEATHING = 168' MIN.

–WALL BRACING IS BY ENGINEERED DESIGN AND
NOT PRESCRIPTIVE PER SECTION 602.10 OF THE
2018 NCR. CONTINUOUS SHEATHING HAS BEEN
PROVIDED, ALONG WITH ALTERNATIVE METHODS TO
INSURE THE MINIMUM INTENT OF SECTION 602.10 OF
THE 2018 NCR HAS BEEN MET AND EXCEEDED.


–BRACED WALL PANELS SHALL BE FASTENED IN
ACCORDANCE WITH TABLE 602.3(1) TO PROVIDE
CONTINUOUS PANEL UPLIFT RESISTANCE AND
COMPLIANCE WITH NCRBC R602.3.5 AND R802.11
UNLESS NOTED OTHERWISE ON STRUCTURAL PLANS.

1ST FLOOR FRAMING PLAN


WALLS AND CEILING

$\frac{1}{4}" = 1'-0"$

STRUCTURAL ENGINEERS
License No. C-3870
318 W Millbrook Road, Unit 201
Raleigh, North Carolina 27609
Phone: (919) 844-1661

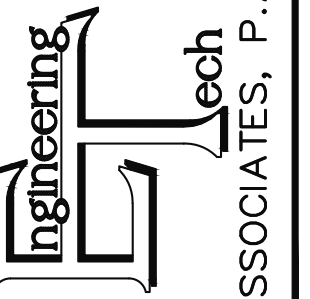

ASSOCIATES, P.A.

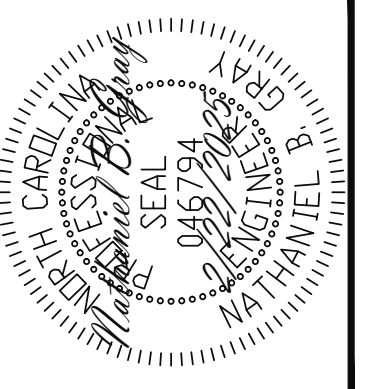

ADAMS HOMES

STRUCTURAL ADDENDUM

ENG: NBG

REV:

DATE: 2/22/2025

15 KIPLING CREEK

2408 MASTER

PLAN NO.

2408


PROJECT NO.

25-18-075

SHEET NO.

S2

2 of 7

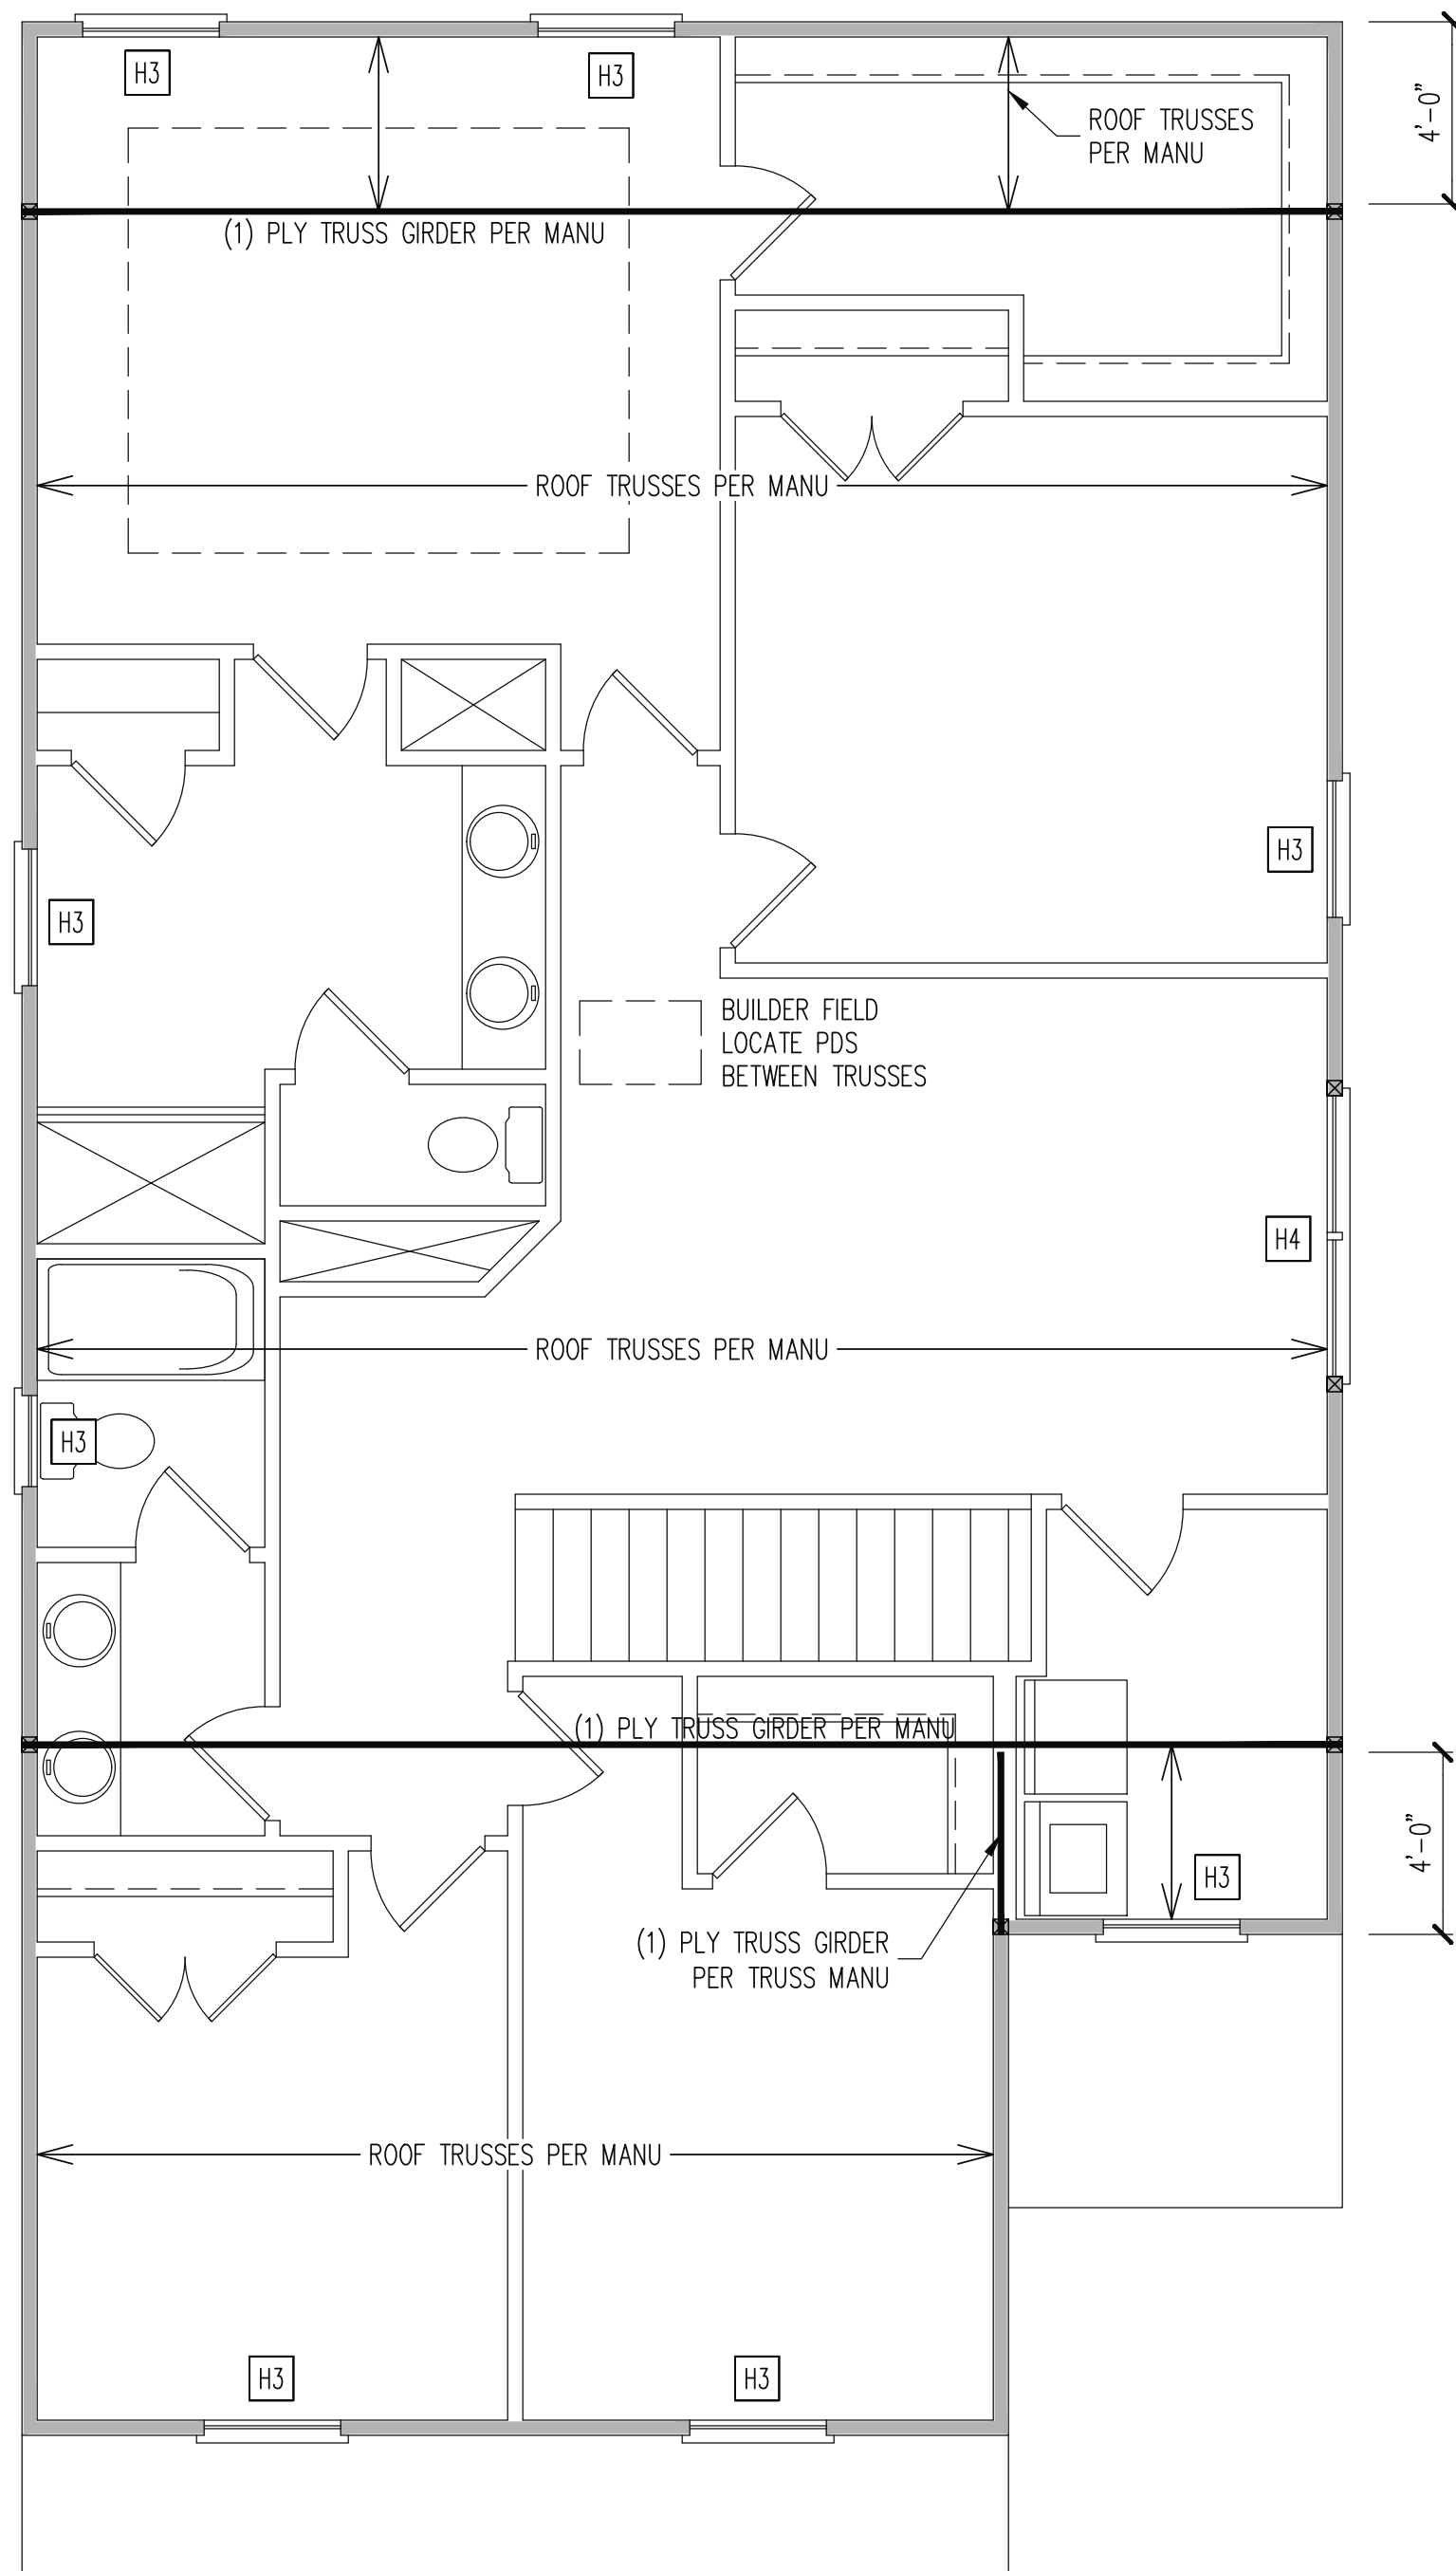

REQUIRED STUDS FOR
BEAM SUPPORT

REFER TO SECTIONS 5.02 – 5.06 OF THE
CONSTRUCTION SPECIFICATIONS FOR REQUIRED
NUMBER OF STUDS FOR BEAM SUPPORT, TYP UNO.

- HEADER SCHEDULE
- H1 SINGLE 2X4 TURNED FLAT (A)
- H2 (2) 2X4'S ON SINGLE JACKS (B)
- H3 (2) 2X10'S ON SINGLE JACKS (C)
- H4 (2) 1.75" X 9.25" LVL'S ON DBL JACKS
-
- (A) TYPICAL FOR INTERIOR NON LOAD BEARING
WALLS ONLY, ROUGH OPENING 38" MAX.
- (B) TYPICAL FOR INTERIOR NON LOAD BEARING
WALLS ONLY, ROUGH OPNG 38" TO 74" MAX.
- (C) TYPICAL FOR ALL CONDITIONS NOT LISTED
IN (A) OR (B) UNO.

NOTES:

–HEADERS IN NON LOAD BEARING INTERIOR
WALLS ARE NOT LABELED.

–KING STUDS EXTERIOR WALLS:

SINGLE KING STUDS FOR 6' MAX OPENINGS.

DBL KING STUDS FOR 10' MAX OPENINGS.

TRPL KING STUDS FOR 14' MAX OPENINGS.

QUAD KING STUDS FOR 18' MAX OPENINGS.

FOR 2X6 WALLS, ONE HALF THE AMOUNT OF
KING STUDS REQUIRED (ROUND UP) UNO

WALL BRACING

ALL EXTERIOR STUD WALLS ARE TO BE
CONTINUOUSLY SHEATHED WITH 7/16 APA RATED
OSB NAILED TO STUDS WITH 8d NAILS @ 6" O.C. AT
PANEL EDGES, 12" O.C. IN PANEL FIELD.

SINGLE JOIST, CONTINUOUS RIM JOIST, OR BLOCKING
OF EQUAL DEPTH IS REQUIRED ABOVE AND BELOW
ALL BRACED WALLS. NAIL BLOCKING ABOVE WALL TO
TOP PLATE WITH 8d TOE NAILS @ 6" O.C. NAIL
SOLE PLATE OF BRACED WALL TO BLOCKING BELOW
WITH (3) 16d NAILS @ 16" O.C. BLOCKING AT
HORIZONTAL JOINTS IN BRACED WALL LINES ONLY
REQUIRED AT SHADED WALLS, UNO.

SHADED WALLS:

PROVIDED CONTINUOUS SHEATHING = 162' MIN.

–WALL BRACING IS BY ENGINEERED DESIGN AND
NOT PRESCRIPTIVE PER SECTION 602.10 OF THE
2018 NCR. CONTINUOUS SHEATHING HAS BEEN
PROVIDED, ALONG WITH ALTERNATIVE METHODS TO
INSURE THE MINIMUM INTENT OF SECTION 602.10 OF
THE 2018 NCR HAS BEEN MET AND EXCEEDED.

–BRACED WALL PANELS SHALL BE FASTENED IN
ACCORDANCE WITH TABLE 602.3(1) TO PROVIDE
CONTINUOUS PANEL UPLIFT RESISTANCE AND
COMPLIANCE WITH NCRBC R602.3.5 AND R802.11
UNLESS NOTED OTHERWISE ON STRUCTURAL PLANS.

2ND FLOOR FRAMING PLAN

WALLS AND CEILING

1/4" = 1'-0"

STRUCTURAL ENGINEERS
License No. C-3870
318 W Millbrook Road, Unit 201
Raleigh, North Carolina 27609
Phone: (919) 844-1661

Engineering Tech
ASSOCIATES, P.A.


ADAMS HOMES	
STRUCTURAL ADDENDUM	
SCOPE	15 KIPLING CREEK
LOT #:	ENG: NRG REV:
2408 MASTER	
DATE: 2/22/2025	

PLAN NO.	
2408	

PROJECT NO.	
25-18-075	

SHEET NO.	
S3	
3 of 7	

ELEVATION B

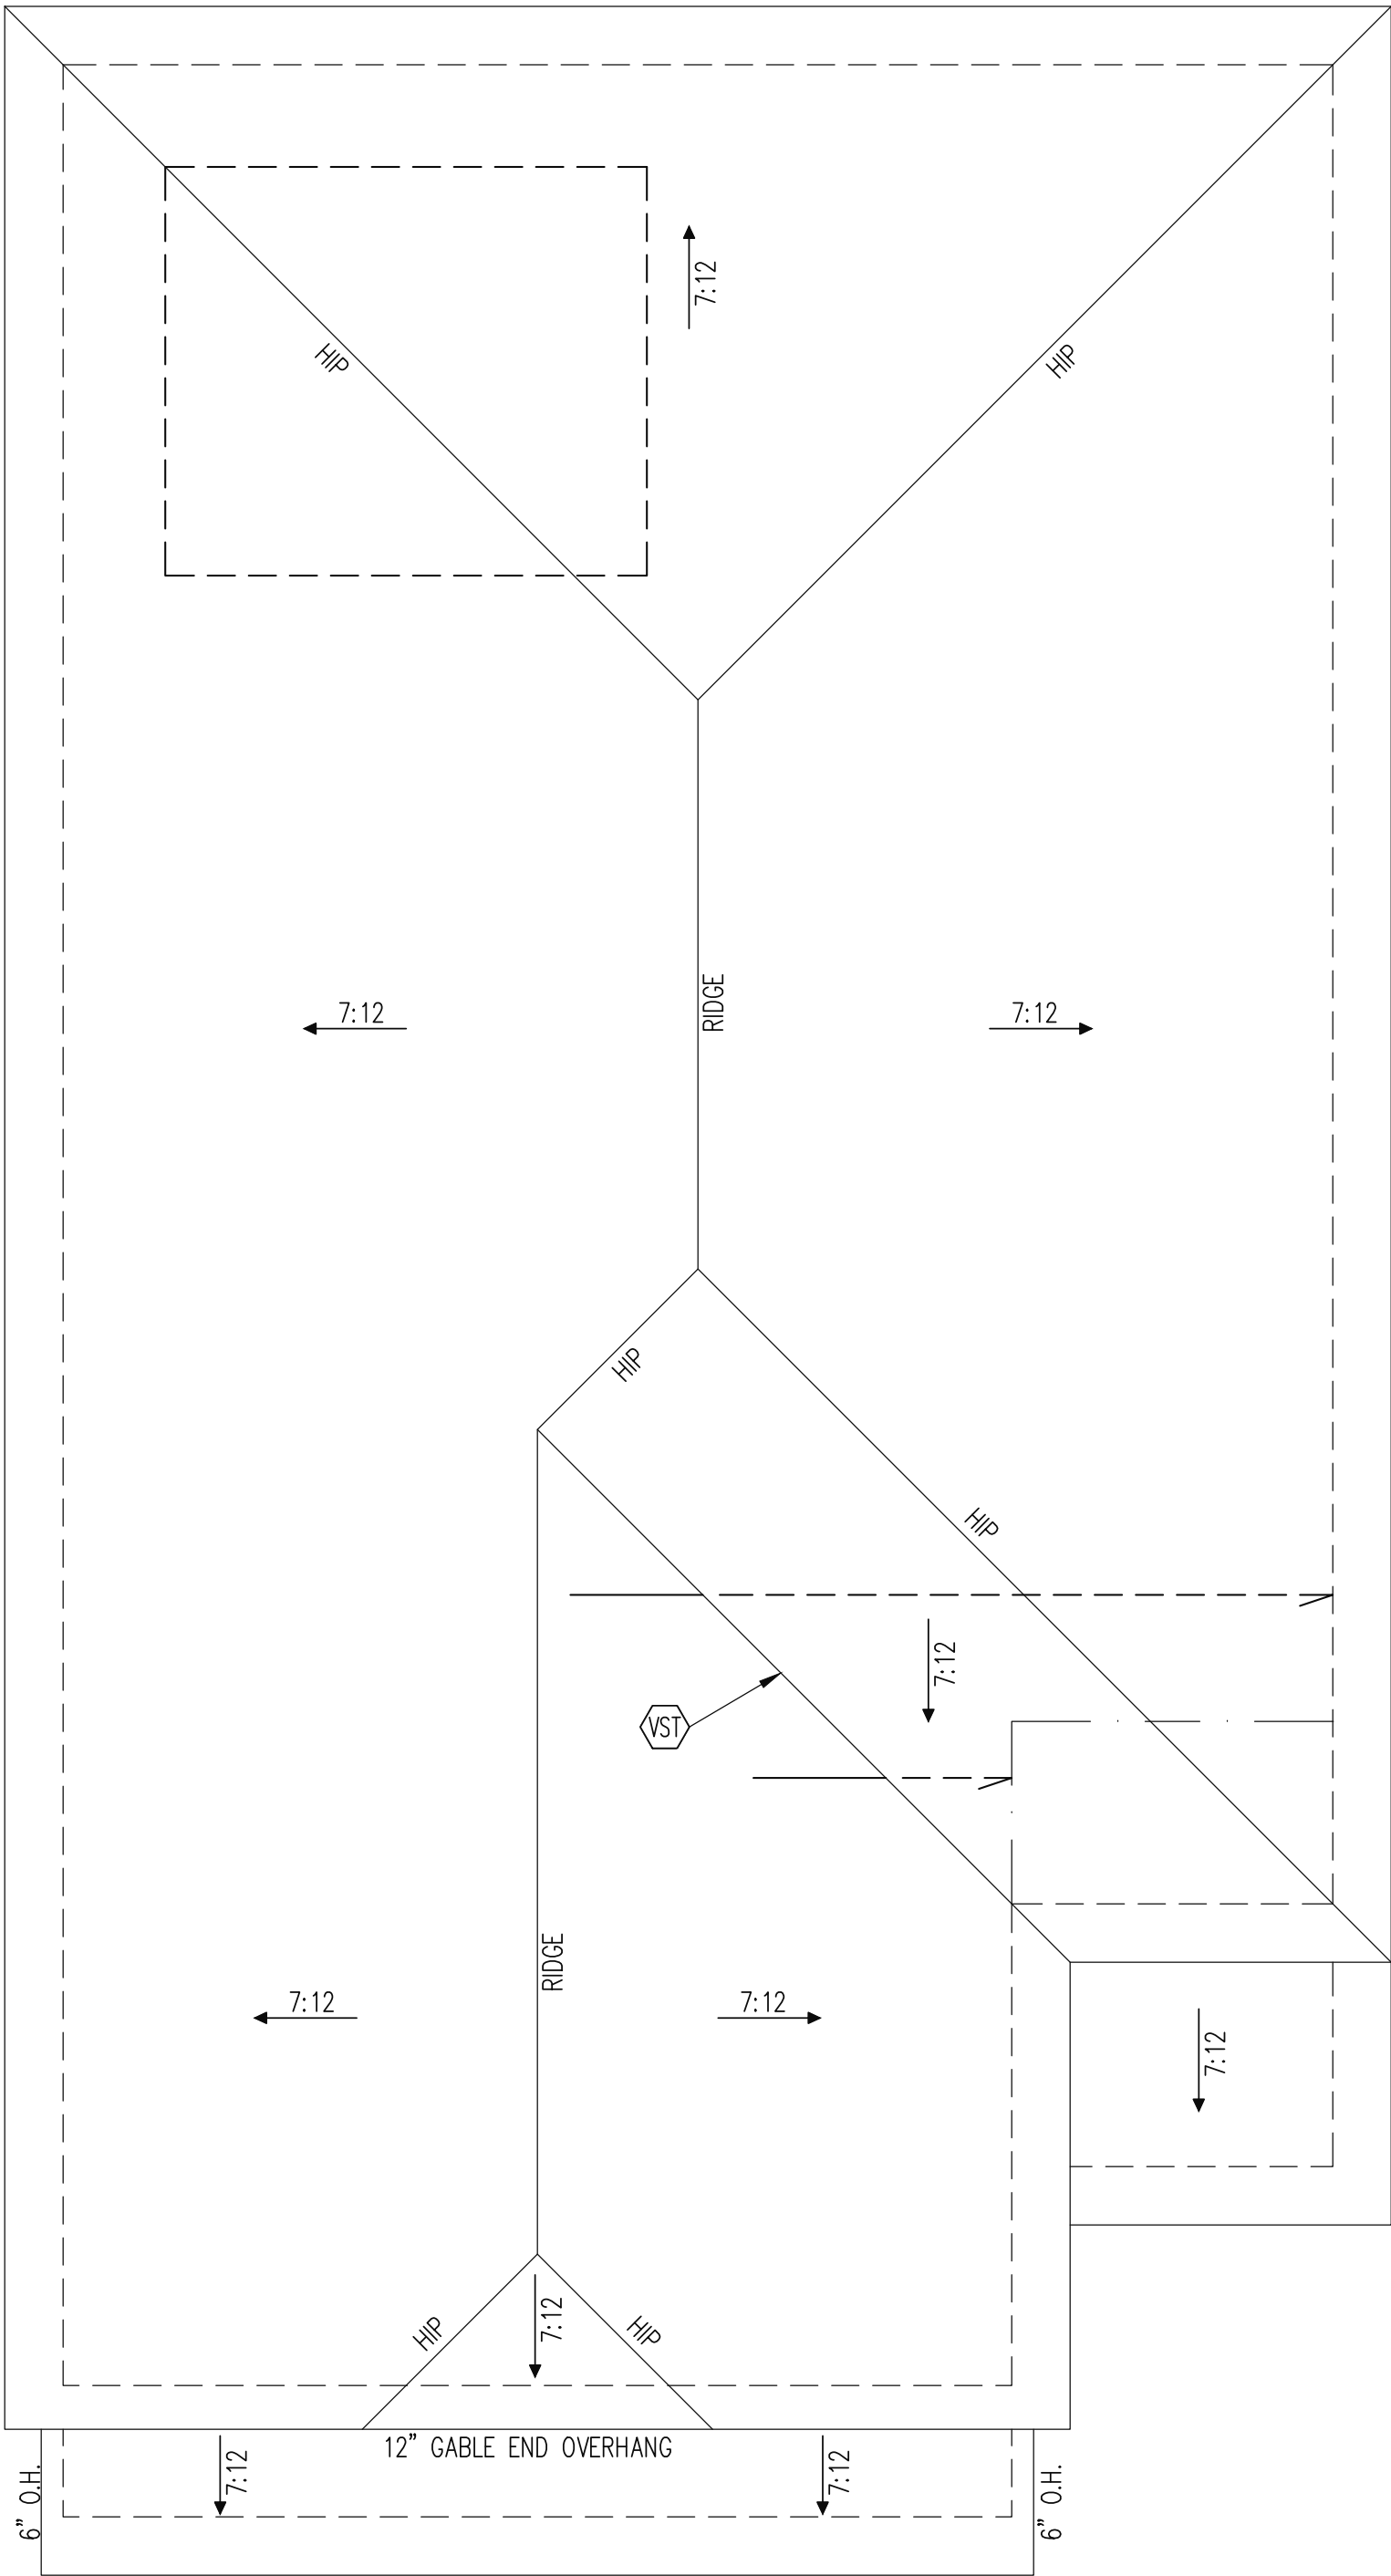

The structural design of this plan is the property of Engineering Tech Associates, P.A. These plans are for the one time use at the location and for the client listed. Engineering Tech Associates, P.A. assumes no liability for these plans if they are reproduced, in whole or in part, for construction at any other location without written permission from Engineering Tech Associates, P.A.

TRUSS UPLIFT CONNECTORS

EXPOSURE B, 120 MPH, ANY PITCH
24" O.C. MAX ROOF TRUSS SPACING

TRUSSES SHALL BE ATTACHED TO SUPPORT WALL FOR UPLIFT RESISTANCE. CONTINUOUS OSB WALL SHEATHING BELOW PROVIDES CONTINUOUS UPLIFT RESISTANCE TO FOUNDATION. ALL TRUSSES SUPPORTED BY INTERMEDIATE SUPPORT WALLS, KNEEWALLS OR BEAMS SHALL BE ATTACHED TO SUPPORTING MEMBER PER SCHEDULE BELOW.

ROOF SPAN IS MEASURED HORIZONTALLY BETWEEN FURTHEST SUPPORT POINTS.

<u>ROOF SPAN</u> UP TO 18'	<u>CONNECTOR</u> NAILING PER TABLE 602.3(1) NCRBC 2018 EDITION
OVER 18'	(1) SIMPSON H2.5A HURRICANE CLIP TO DBL TOP PLATE OR BEAM

FRAMING SCHEDULE

ROOF ONLY	
AN	SUPPORT BRICK VENEER WITH ANGLE ATTACHED TO MODIFIED STUD WALL
BR	SUPPORT BRICK VENEER PER SECT.703.7 OF THE NCRC, LATEST EDITION.
VST	VALLEY SET TRUSSES PER MANU
SK	DBL 2X4 STIFF KNEE
SS	SUPPORT/SPLICE TRUSSES ON KNEEWALL BELOW



FRAMING NOTES

- ROOF ONLY
- ROOF TRUSSES PER MANU. TYPICAL U.N.O.
 - ROOF PITCHES 7:12 TYP U.N.O.
 - VERIFY ALL KNEEWALL HEIGHTS, ROOF PITCHES, AND ARCHITECTURAL OVERHANGS PRIOR TO CONSTRUCTION

ROOF FRAMING PLAN

1/4" = 1'-0"

STRUCTURAL ENGINEERS
License No. C-3870
318 W Millbrook Road, Unit 201
Raleigh, North Carolina 27609
Phone: (919) 844-1661




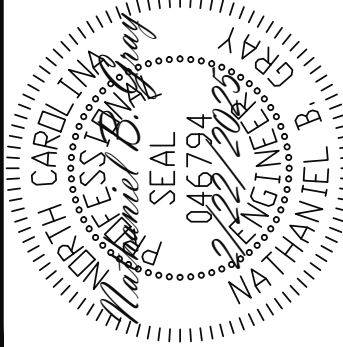
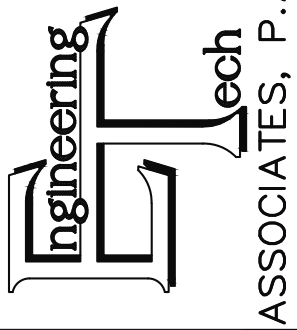


ADAMS HOMES	
STRUCTURAL ADDENDUM	
SCOPE	15 KIPLING CREEK
LOT #:	ENG: NBG
	REV:
	DATE: 2/22/2025

PLAN NO.
2408

PROJECT NO.
25-18-075

SHEET NO.
S4
4 of 7

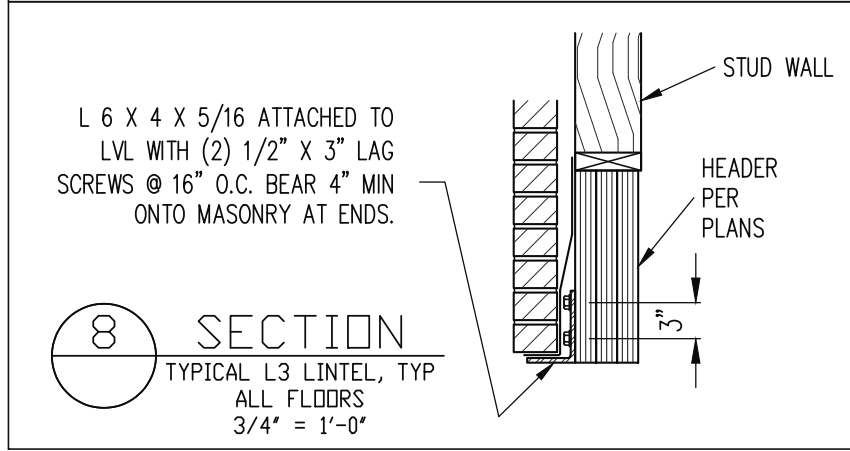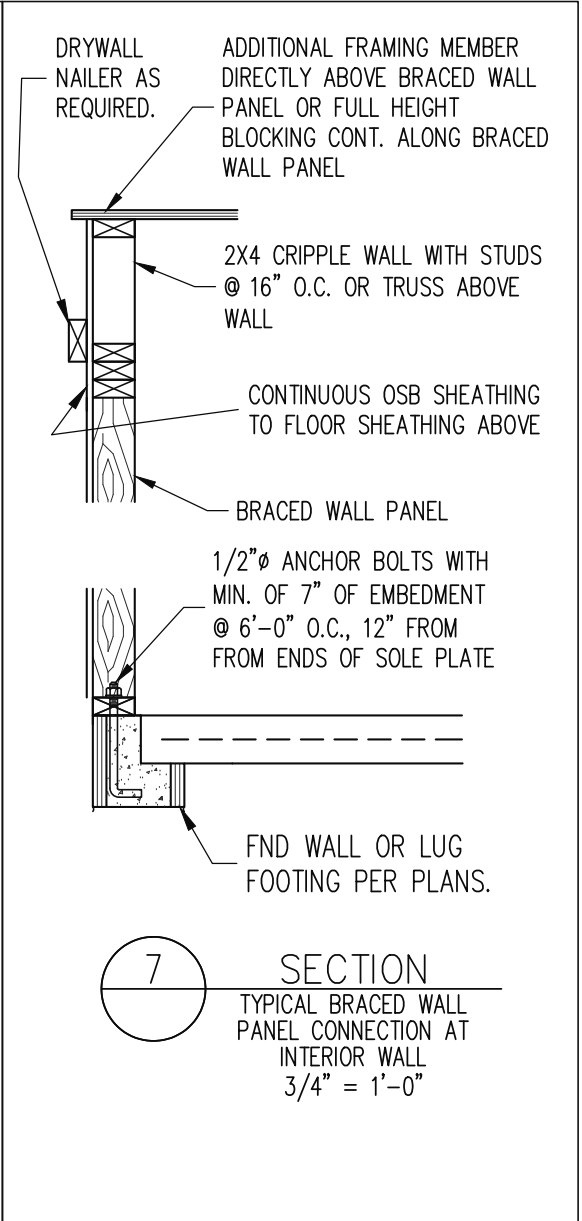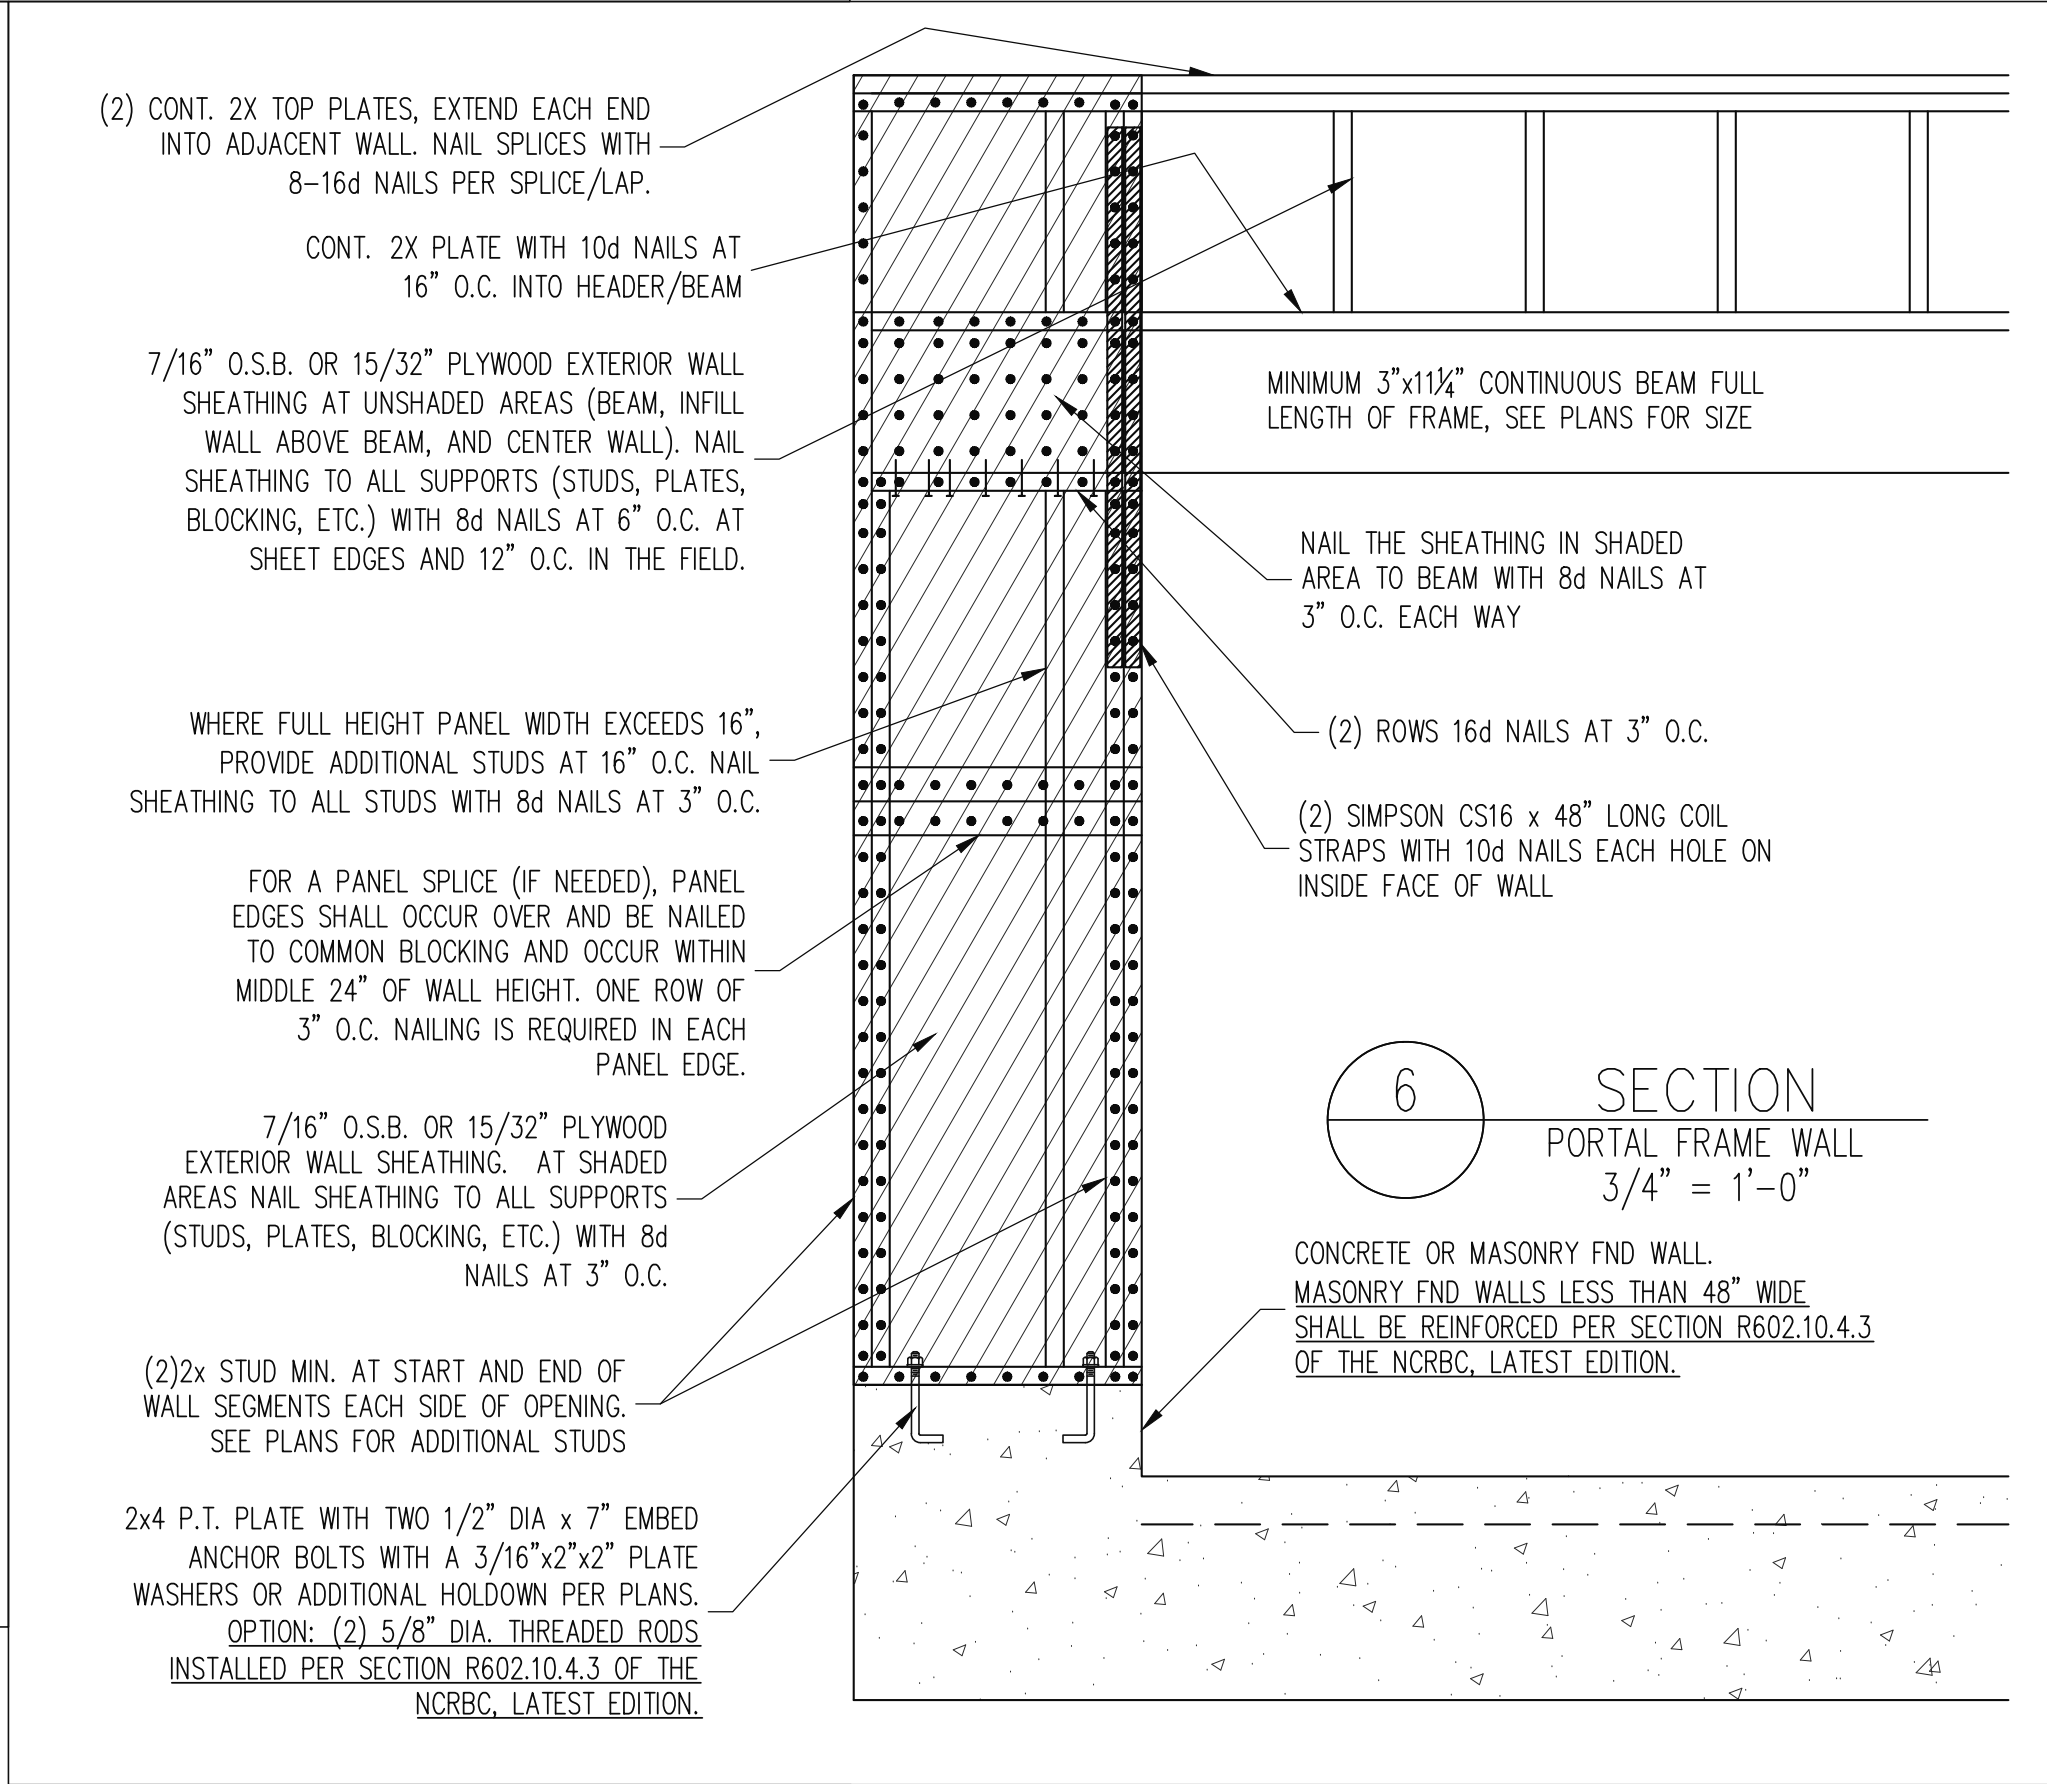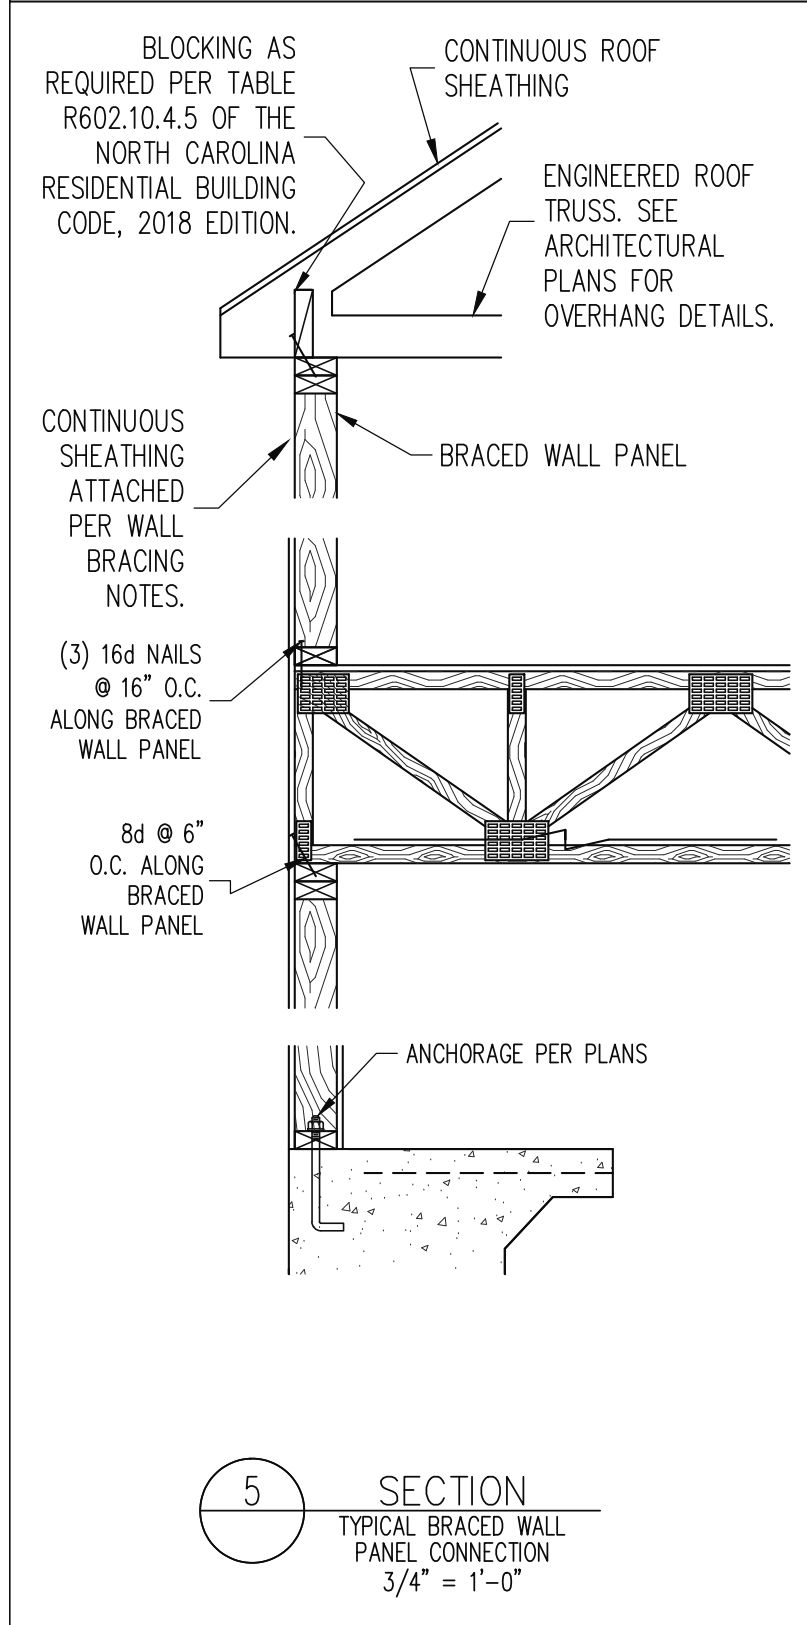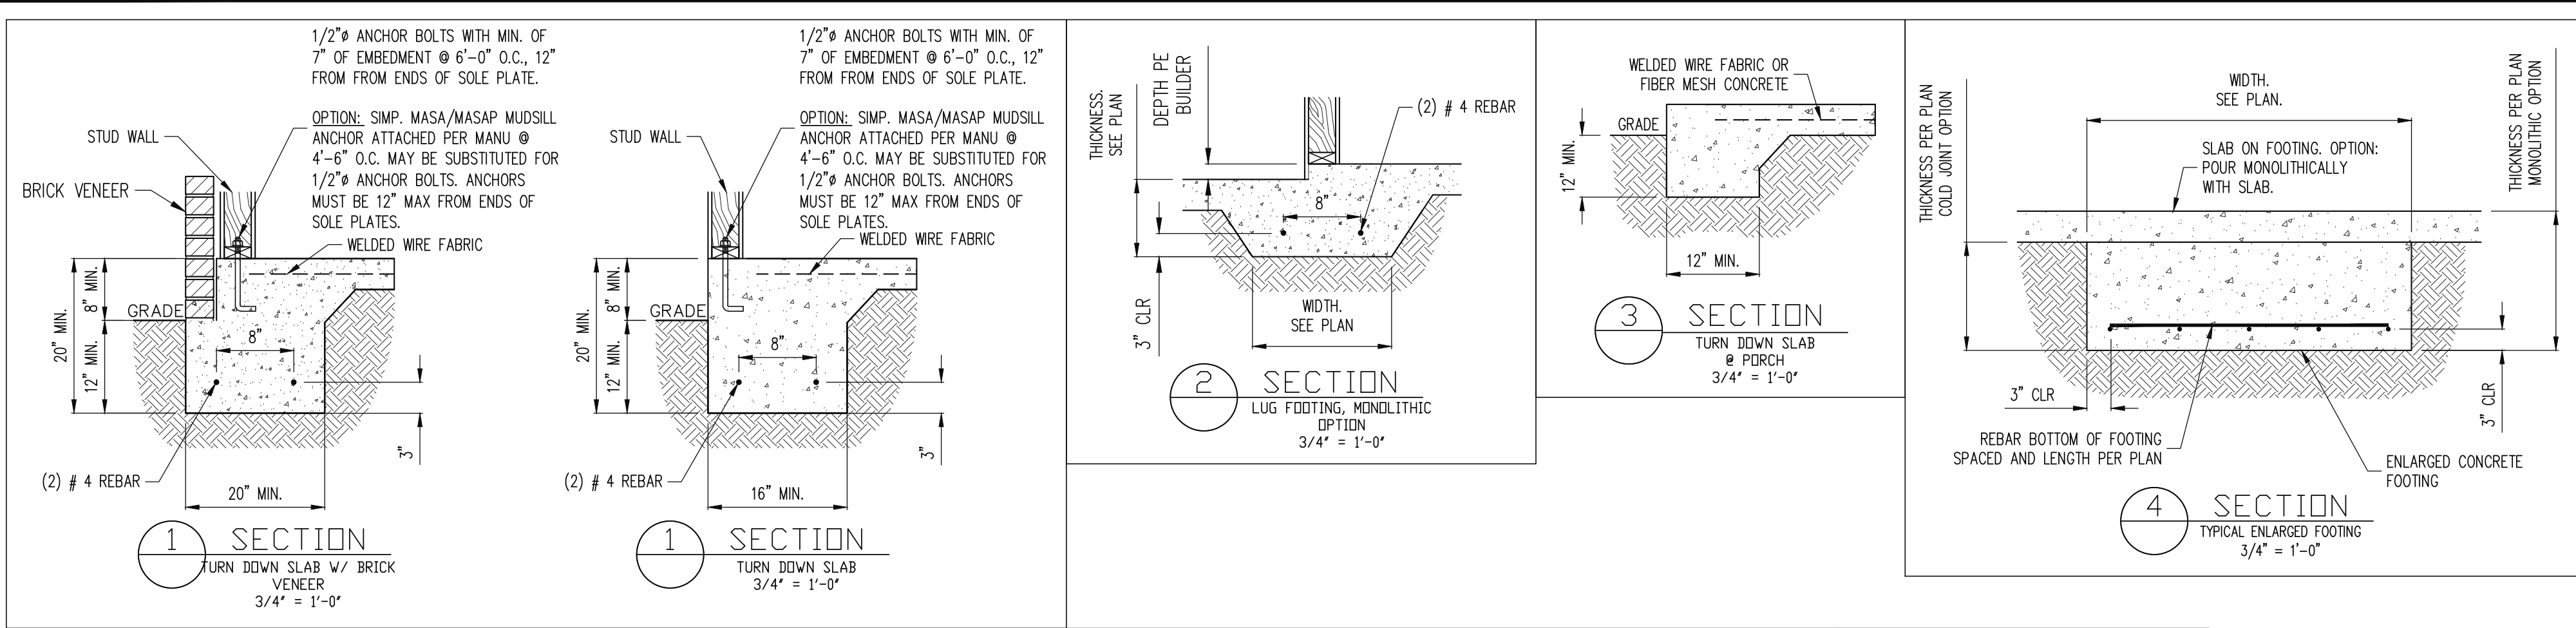

MONOSLAB

STRUCTURAL ENGINEERS
License No. C-3870
318 W Millbrook Road, Unit 201
Raleigh, North Carolina 27609
Phone: (919) 844-1661

Engineering Tech
ASSOCIATES, P.A.


ADAMS HOMES	
SCOPE	STRUCTURAL ADDENDUM
LOT #:	15 KIPLING CREEK
ENG:	NBG
REV:	
DATE:	2/22/2025
2408 MASTER	

PLAN NO.
2408


PROJECT NO.
25-18-075

SHEET NO.
SD1


5 of 7

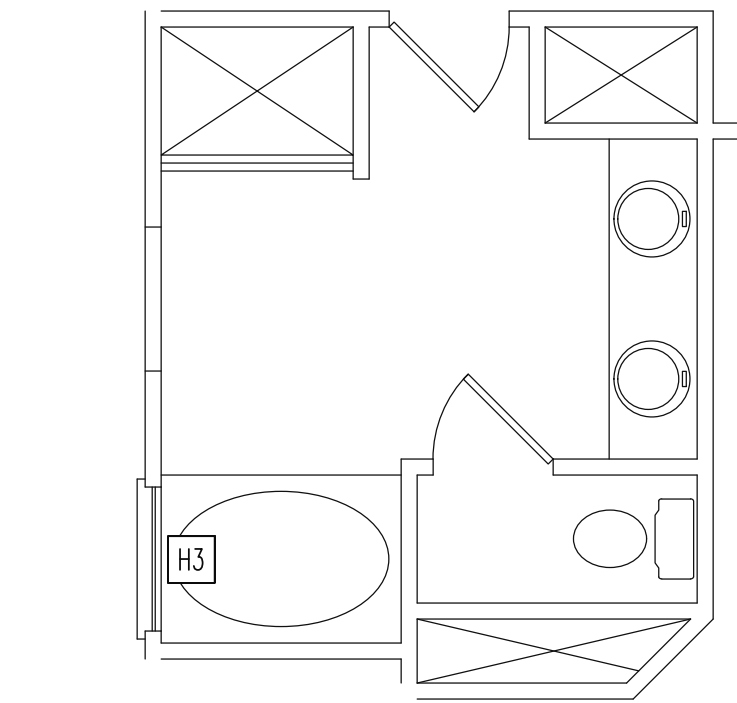

OPTIONAL MASTER BATH

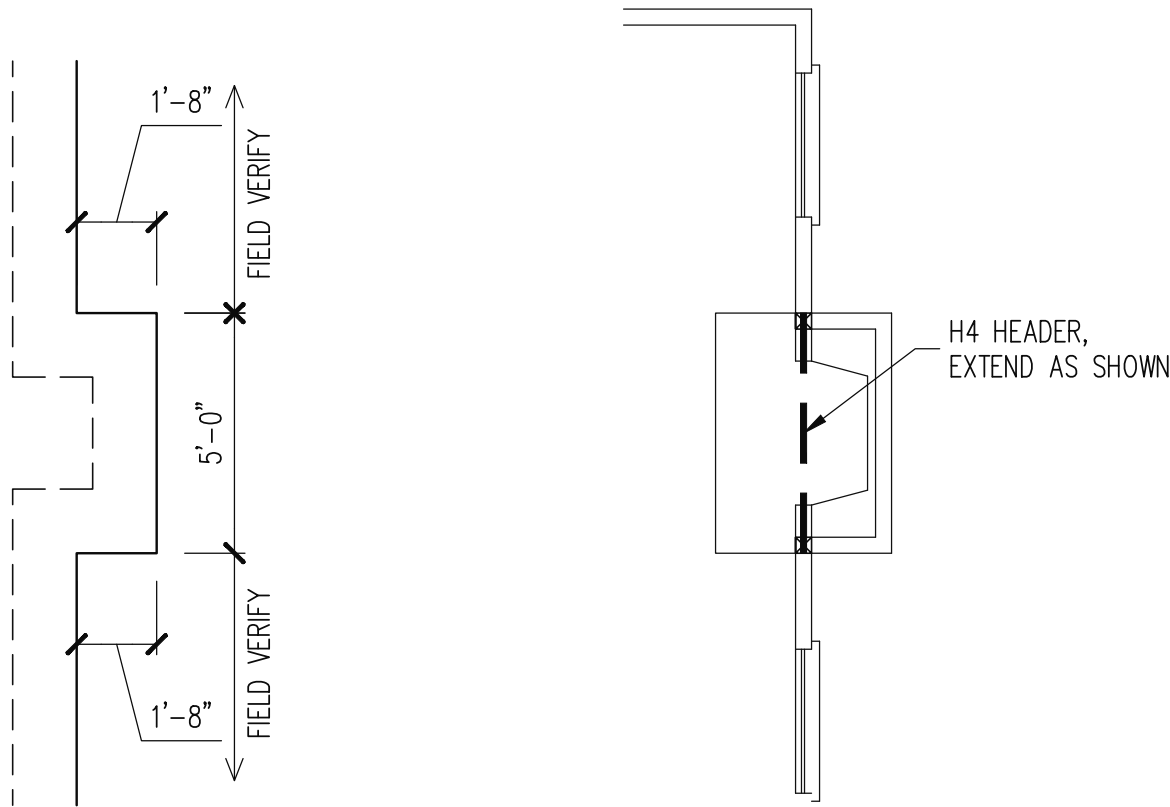

OPTIONAL FIREPLACE

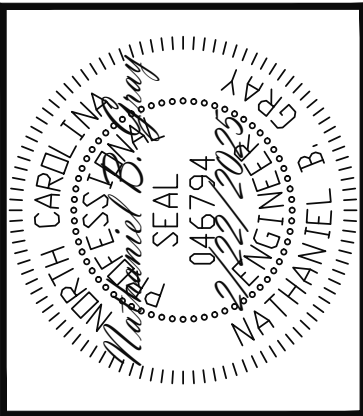

Engineering

Associates, P.A.

Tech

STRUCTURAL ENGINEERS
License No. C-3870
318 W Millbrook Road, Unit 201
Raleigh, North Carolina 27609
Phone: (919) 844-1661

ADAMS HOMES			
SCOPE	STRUCTURAL ADDENDUM		
LOT #:	15 KIPLING CREEK	ENG:	NBG
		REV:	
	2408 MASTER	DATE	2/22/2025

PLAN NO.
2408

PROJECT NO.
25-18-075

SHEET NO.
S7
7 of 7