

GENERAL NOTES

This plan was designed and drafted BY Advanced House Plans to meet average conditions and codes in the State of Nebraska at the time it was designed. Because codes and requirements can change and may vary from jurisdiction to jurisdiction, AHP cannot warrant compliance with any specific code or regulation. Consult your local building official to determine the suitability of these plans for your specific site and application. This plan can be adapted to your local building codes and requirements, however, it is the responsibility of the purchaser and/or builder of this plan to see that the structure is built in strict compliance with all governing municipal codes (city, county, state and federal). The purchaser and/or builder of this plan releases the designer from any claims or lawsuits that may arise during the construction of this structure or anytime thereafter.

\* If the contractor or sub-contractor, in the course of their work finds any discrepancies between the plan and the physical conditions of the site or structure, or any errors in the plans or specifications, it shall be their responsibility to immediately inform AHP, who will promptly verify and if necessary correct the working drawings. Any work done after such discovery will be done at the contractor's expense.

\* Only the purchaser of this plan has permission to build this plan. The purchaser is given permission to reproduce the drawings only as required for such construction. The purchaser also has permission to modify this plan. No permission is given to any party to claim copyright on the original or modified plan. The modified plans shall remain subject to the license and may not be sold, distributed or otherwise transferred without the express written consent of Advanced House Plans. Infringing upon Advanced House Plans' copyright through reproduction, distribution or construction or rebuilding a design is punishable by law with fine up to \$150,000 as defined by architectural copyright laws.

DESIGN LOADS:

\* Ultimate design wind speed: 115 mph, Exposure Category: B

\* Seismic Design Category A

\* Floor: 40 psf. live 30 psf. live 10 psf. live  
15 psf. dead 10 psf. dead 5 psf. dead

\* Soil bearing Capacity - 1500 psf.

\* Live loads, dead loads, wind loads, snow loads, lateral loads, seismic zoning and any specialty loading conditions will need to be confirmed before construction and adjustments to plans made accordingly. See your local building officials for verification of your specific load data, zoning restrictions and site conditions.

CONCRETE AND FOUNDATIONS:

- \* All foundation walls and slabs on grade shall be 3000 PSI (28-day compressive strength concrete), unless noted otherwise.
- \* All interior slabs on grade shall bear on 4" compacted granular fill with 6 mil. polyethylene vapor barrier underneath.
- \* Provide proper expansion and control joints as per local requirements.
- \* All 36" x 36" x 18" concrete pade to have (3) #5 rods each way.
- \* All 48" x 48" x 24" concrete pade to have (4) #5 rods each way.
- \* Foundation walls are not to be backfilled until properly braced.
- \* Verify depth of frost footings with your local codes.
- \* Provide termite protection as required by HUD minimum property standards.
- \* Foundation bolts must be anchored to sill plate with 5/8" bolts embedded 15" in concrete walls.
- \* For window openings in conc. wall, provide #5 bars #4" o.c. (two total) w/2" clearance from top & sides of opg. for jamb & lintel reinforcing. Extend reinforcing a minimum of 2 past opening edges.

STEEL:

- \* All structural steel for beams and plates shall comply with ASTM specification A-36.
- \* All structural steel for steel columns shall comply with ASTM specification A-53 Grade B or A-501.
- \* All reinforcing steel for concrete shall comply with ASTM specification A-615 Grade 60.
- \* Provide steel shims in all beam pockets.
- \* Steel columns are to be 3" I.D. (inside diameter) unless noted otherwise.

FRAMING MEMBERS:

- \* Unless noted otherwise, all framing lumber shall have the following characteristics:  
F<sub>b</sub> = 1000 psi E = 1,400,000 psi  
S<sub>b</sub> = 1200 psi
- \* Contractor to confirm the size, spacing and stress characteristics of all framing and structural members to meet your local code requirements.
- \* Wall bracing method assumed as CS-WSP. Since braced wall line spacing and braced wall panel calculations vary by location, purchaser will need to consult a local professional for specific wall bracing calculations and diagrams.
- \* Hole sizes and locations in Glulam or laminated Veneered Lumber (L.V.L.) members are to be confirmed by a professional engineer.
- \* Any structural or framing members not indicated on the plan are to be sized by contractor.
- \* Double floor joists under all partition walls, unless noted otherwise.
- \* All sheathing is assumed to be 3/4" thick, glued & nailed.
- \* All exterior walls are dimensioned to outside of 1/2" sheathing.
- \* Calculated dimensions take precedence over scaled dimensions.
- \* All angled walls on floor plans are at 45 degree angle, unless otherwise noted.
- \* Laterally unsupported walls 12'-0" high or higher shall be 2x6 and balloon framed unless noted otherwise.
- \* Unless noted otherwise, above all openings that are:  
(1) Load bearing and less than or equal to 3 ft. ....use 4x6.  
(2) Load bearing and more than 3 ft. ....use (2) 2x12 with 1/2" Plywood between.  
(3) Non-load bearing and less than or equal to 6 ft. ....use 4x6.  
(4) Non-load bearing and more than 6 ft. ....use (2) 2x12 with 1/2" Plywood between.
- \* (5) All exterior openings use (2) 2x12 with 1/2" Plywood between.
- \* All trusses to be engineered by truss manufacturer according to the loading indicated on this plan.
- \* All exterior corners shall be braced in each direction with let-in diagonal bracing or plywood.
- \* Place (1) row of 1" x 3" cross-bridging on all spans over 8'-0" and (2) rows of 1" x 3" cross-bridging on all spans over 16'-0".
- \* Collar ties are to be spaced 4'-0" o.c.
- \* All purlins and kickers are to be 2x6's, unless noted otherwise.
- \* Any hip or valley rafters over a 28'-0" span are to be Laminated Veneer Lumber (L.V.L.).

MISC. NOTES:

- \* Prefabricated fireplaces and flues are to be U.L. approved and installed as per manufacturer's specifications.
- \* All materials, supplies and equipment to be installed as per manufacturer's specifications and per local codes and requirements.
- \* Provide proper insulation for all plumbing.
- \* 1/2" water-resistant drywall around showers, tubs and whirlpools.
- \* 1/2" drywall on interior walls and ceilings.
- \* 5/8" type "X" fire code drywall on garage walls and ceilings.
- \* When no brand is specified windows are called out by glass size only.
- \* In dwelling units, where the top of the sill of an operable window opening unit is located less than 24 inches above the finished floor and greater than 12 inches above the finished grade, fall protection must comply with R312.2.1.
- \* Window opening control devices on windows serving as a required emergency escape and rescue shall comply with ASTM F2092.
- \* Windows, if not noted, are assumed to be casements.
- \* Window header heights are 6'-8" unless noted otherwise.
- \* Header heights are labeled to bottom of arched transoms.
- \* Confirm window openings for your local egress requirements and minimum light and ventilation requirements.
- \* Headroom at stairs shall have a minimum clearance of 6'-8" high.
- \* Provide proper handrails at stairs per local codes.
- \* The mechanical and electrical layouts are suggested only. Consult your mechanical and electrical contractors for exact specifications, locations and sizes.
- \* Jog flue to rear of ridge as necessary.
- \* Provide proper wiring for all electrical appliances, mechanical equipment and whirlpools per manufacturer's specifications.
- \* Air conditioner locations may vary depending on restrictive covenants and codes.

SCAN TO CONNECT WITH  
ADVANCED HOUSE PLANS



SCAN TO RECEIVE  
OUR LATEST DESIGNS



SCAN TO VISIT  
OUR WEBSITE



PRELIM  
FINAL  
3/27/23  
REVISION

Fleetwood  
Reverse Slab



ADVANCED HOUSE PLANS IS A PROFESSIONAL RESIDENTIAL DESIGN FIRM  
LOCATION: OMAHA, NE BECAUSE SITE CONDITIONS VARY, AHP CANNOT  
WARRANT THAT THESE PLANS WILL BE SUITABLE FOR YOUR SITE. THE  
CONSTRUCTION OF THESE PLANS SHOULD NOT BE UNDERTAKEN WITHOUT THE  
CONSULTATION OF A PROFESSIONAL ENGINEER OR ARCHITECT. MATERIALS, FINISHES,  
AND METHODS OF CONSTRUCTION ARE NOT SPECIFIED IN THESE PLANS.  
CODE & SITE REQUIREMENTS PRIOR TO CONSTRUCTION  
MAY VARY FROM THOSE SHOWN ON THESE PLANS. THE BUYER  
MAY OCCUR DURING OR AFTER THE BUILDING PROCESS.

© 2023


30244

SHEET  
1  
OF  
1

20% SCALE = 24" X 36"

The purchaser of these plans is given the limited license to reproduce these plans for construction purposes only and further distribution is illegal. Do not scale prints - see dimensions.



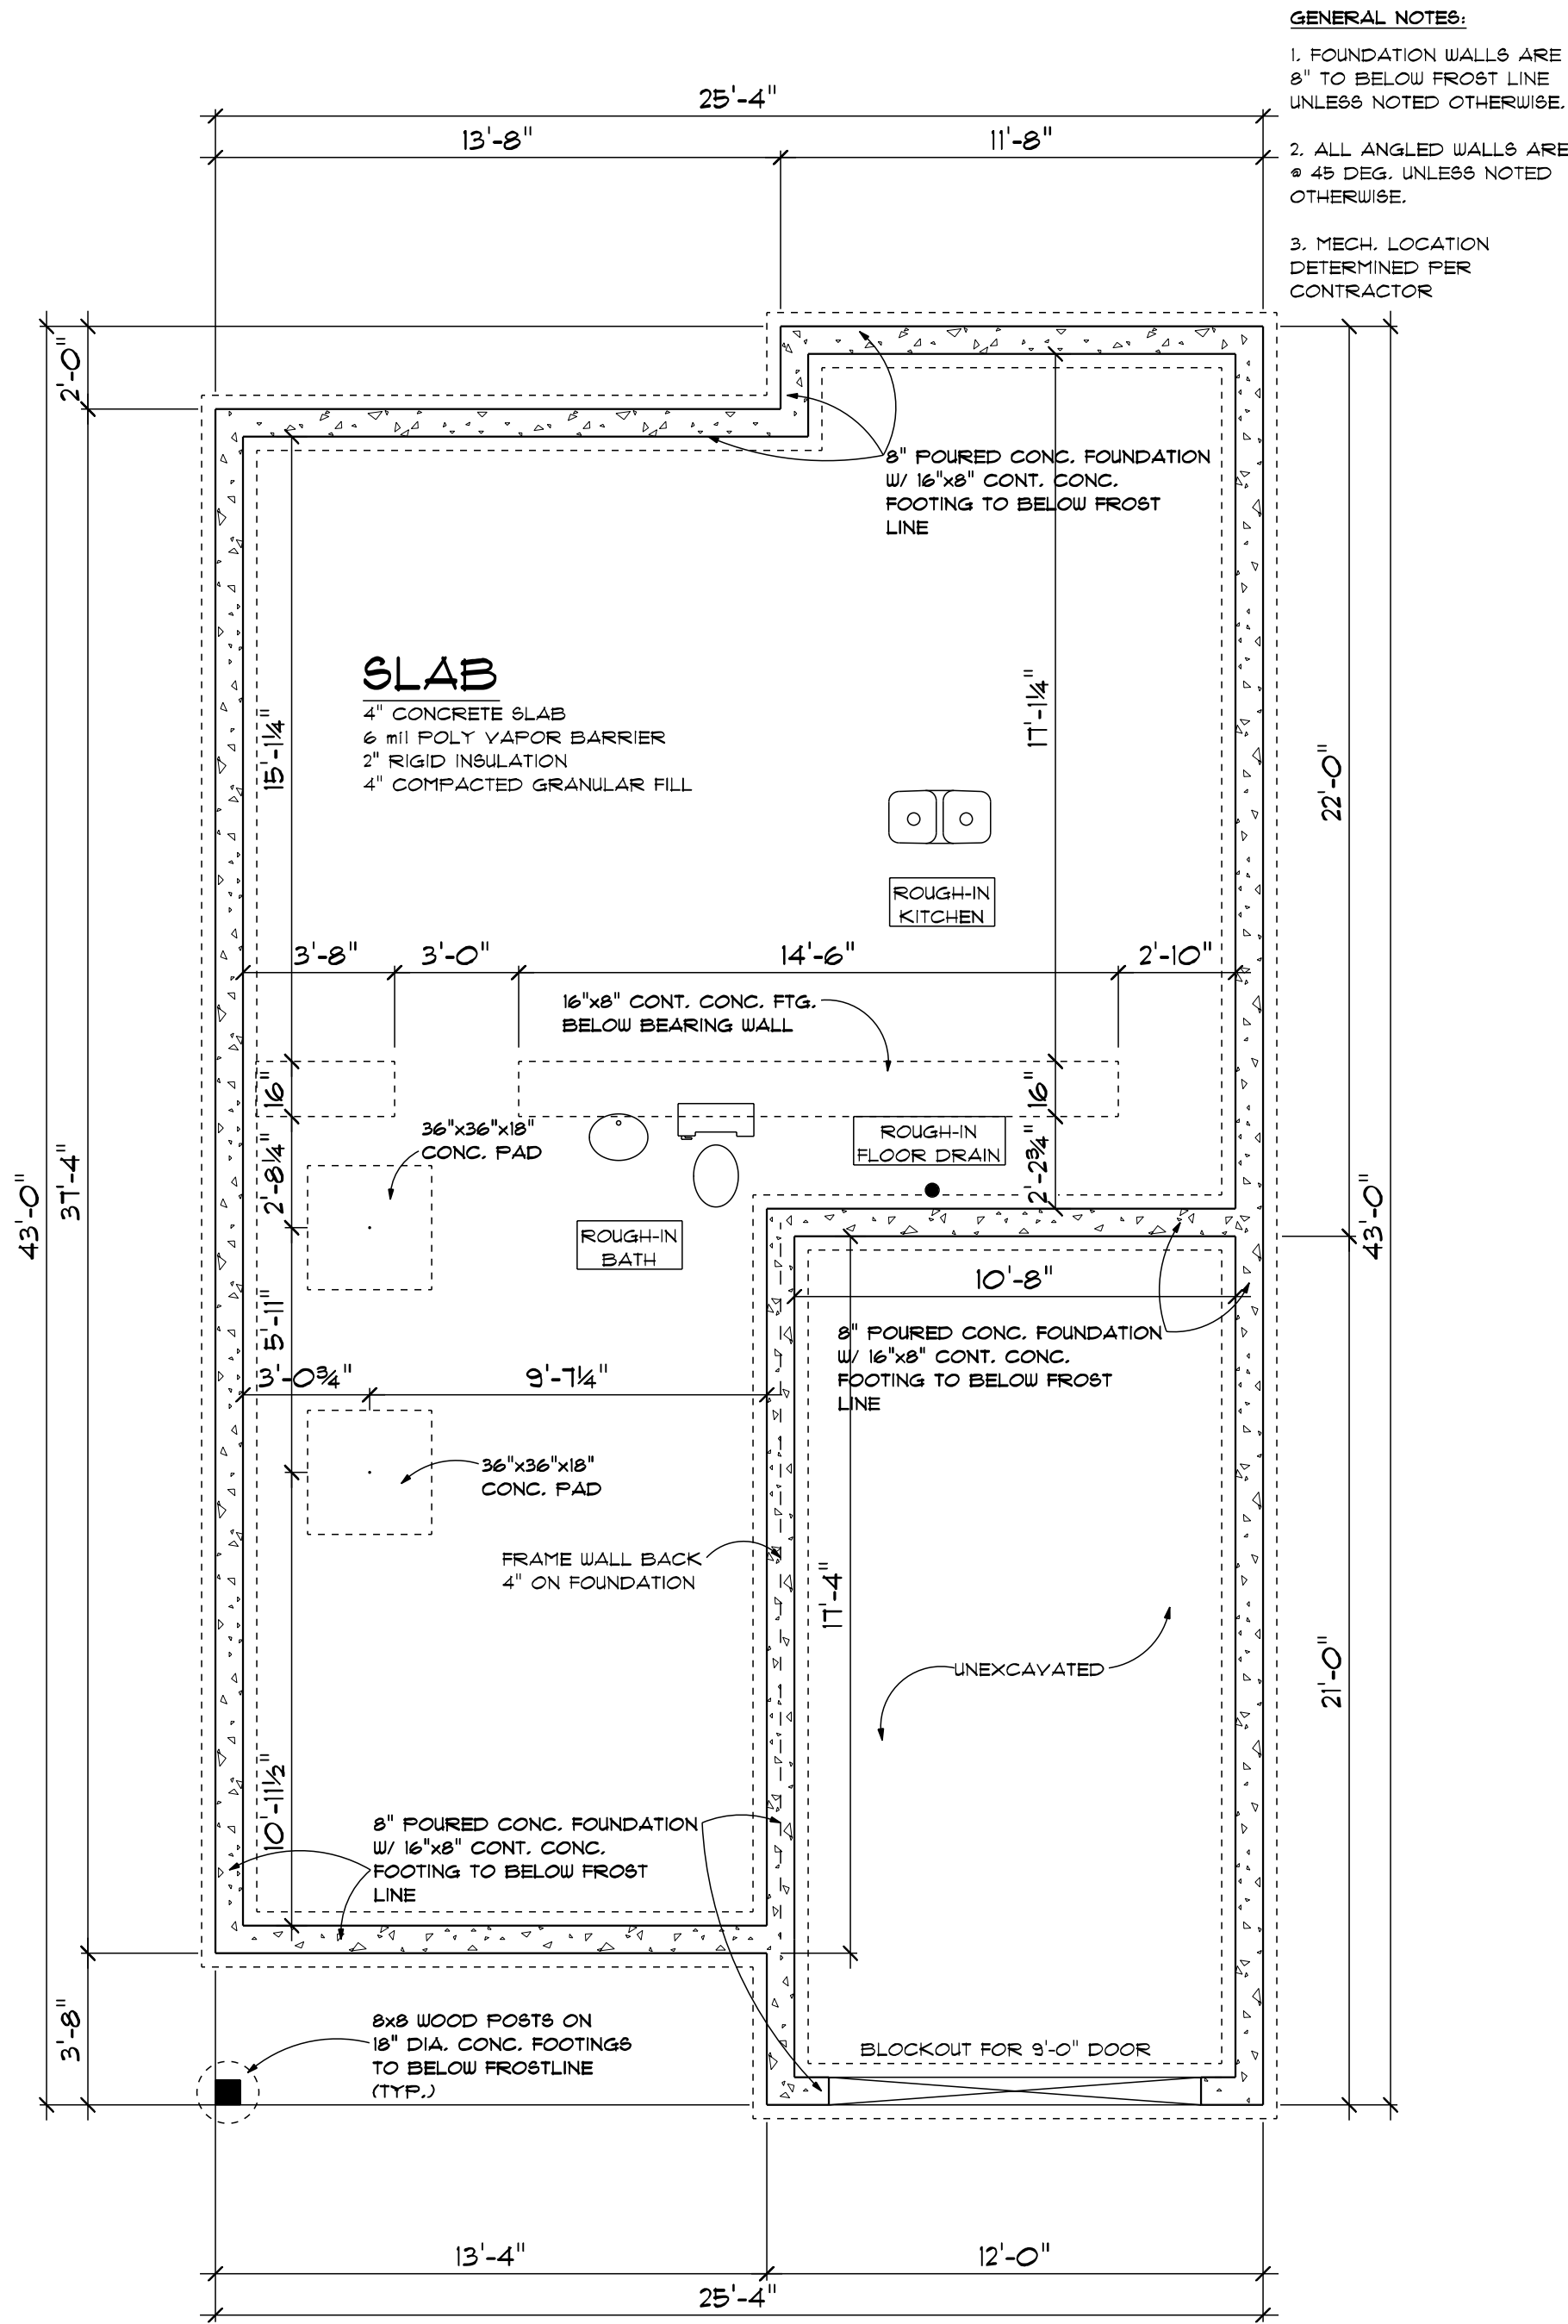

FOUNDATION PLAN

SCALE: 1/4" = 1'-0"



|          |
|----------|
| PRELIM   |
| FINAL    |
| 3/27/23  |
| REVISION |

Fleetwood  
Reverse Slab




ADVANCED HOUSE PLANS IS A PROFESSIONAL RESIDENTIAL DESIGN FIRM  
LOCATION, ORIGIN, NE BECAUSE SITE CONDITIONS VARY, AND CANNOT  
GUARANTEE THE ACCURACY OF THESE PLANS. THE USER ASSUMES ALL  
CONSTRUCTION FROM THESE PLANS SHOULD NOT BE UNDERTAKEN WITHOUT THE  
CONSULTATION OF A PROFESSIONAL ENGINEER OR ARCHITECT.  
PLEASE VERIFY ALL DIMENSIONS, MATERIALS, FINISHES, ETC.  
THAT MAY OCCUR DURING OR AFTER THE BUILDING PROCESS.

© 2023

30244


SHEET  
3  
OF  
1

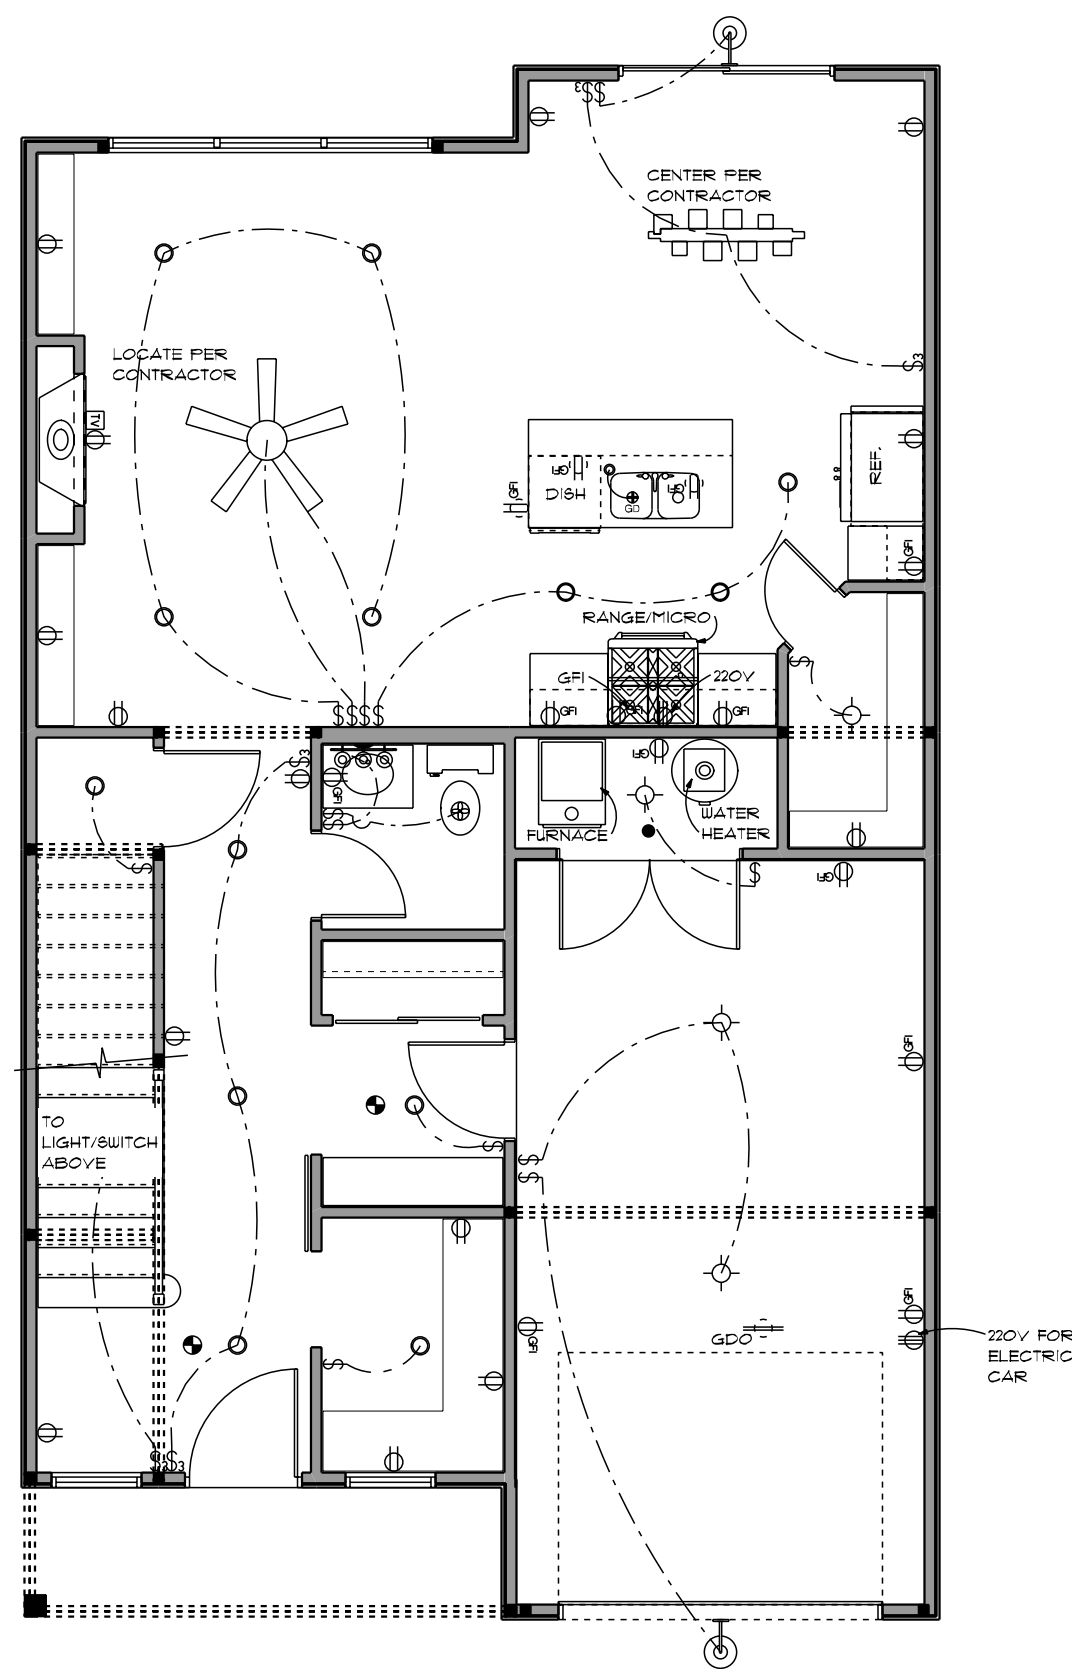

MAIN LEVEL ELECTRICAL PLAN  
SCALE: 3/16" = 1'-0"

| ELECTRICAL LEGEND          |       |        |
|----------------------------|-------|--------|
| ELECTRICAL                 | COUNT | SYMBOL |
| Ceiling fan w/ blades on 4 | 1     |        |
| can light 6 inch           | 13    |        |
| wall mount saving          | 2     |        |
| GARAGE DOOR OUTLET         | 1     |        |
| GARAGE DISPOSAL            | 1     |        |
| PLUNGER SWITCH             | 1     |        |
| cable tv outlet            | 1     |        |
| tv                         | 1     |        |
| light                      | 4     |        |
| outlet                     | 14    |        |
| outlet 220v                | 2     |        |
| outlet gfi                 | 13    |        |
| smoke detector             | 2     |        |
| baton                      | 14    |        |
| baton 3 way                | 5     |        |
| wall mounted 03 3 lights   | 1     |        |
| main box chandelier        | 1     |        |

| OPENING SCHEDULE |              |                        |                |       |
|------------------|--------------|------------------------|----------------|-------|
| OPENING ID       | TYPE         | PRODUCT CODE           | SIZE           | COUNT |
| 1                | WINDOW       | 30X48 CASEMENT 1       | 2'-6" x 4'-0"  | 2     |
| 2                | WINDOW       | 108X12 CASEMENT 3      | 9'-0" x 6'-0"  | 1     |
| A                | DOOR         | 24X80 1                | 2'-0" x 6'-8"  | 1     |
| B                | GARAGE       | 108X84 STABLE          | 9'-0" x 11'-0" | 1     |
| C                | DOOR         | 36X80 GLASS 1          | 3'-0" x 6'-8"  | 1     |
| D                | SLIDING DOOR | 32X80 DOUBLE BARN DOOR | 2'-8" x 6'-8"  | 1     |
| E                | DOOR         | 28X80 1                | 2'-4" x 6'-8"  | 1     |
| F                | DOOR         | 32X80 1                | 2'-8" x 6'-8"  | 2     |
| G                | SLIDING DOOR | 48X80 SLIDING 2        | 4'-0" x 6'-8"  | 1     |
| H                | DOOR         | 60X80 2                | 5'-0" x 6'-8"  | 1     |
| J                | SLIDING DOOR | 72X80 SLIDING GLASS 2  | 6'-0" x 6'-8"  | 1     |

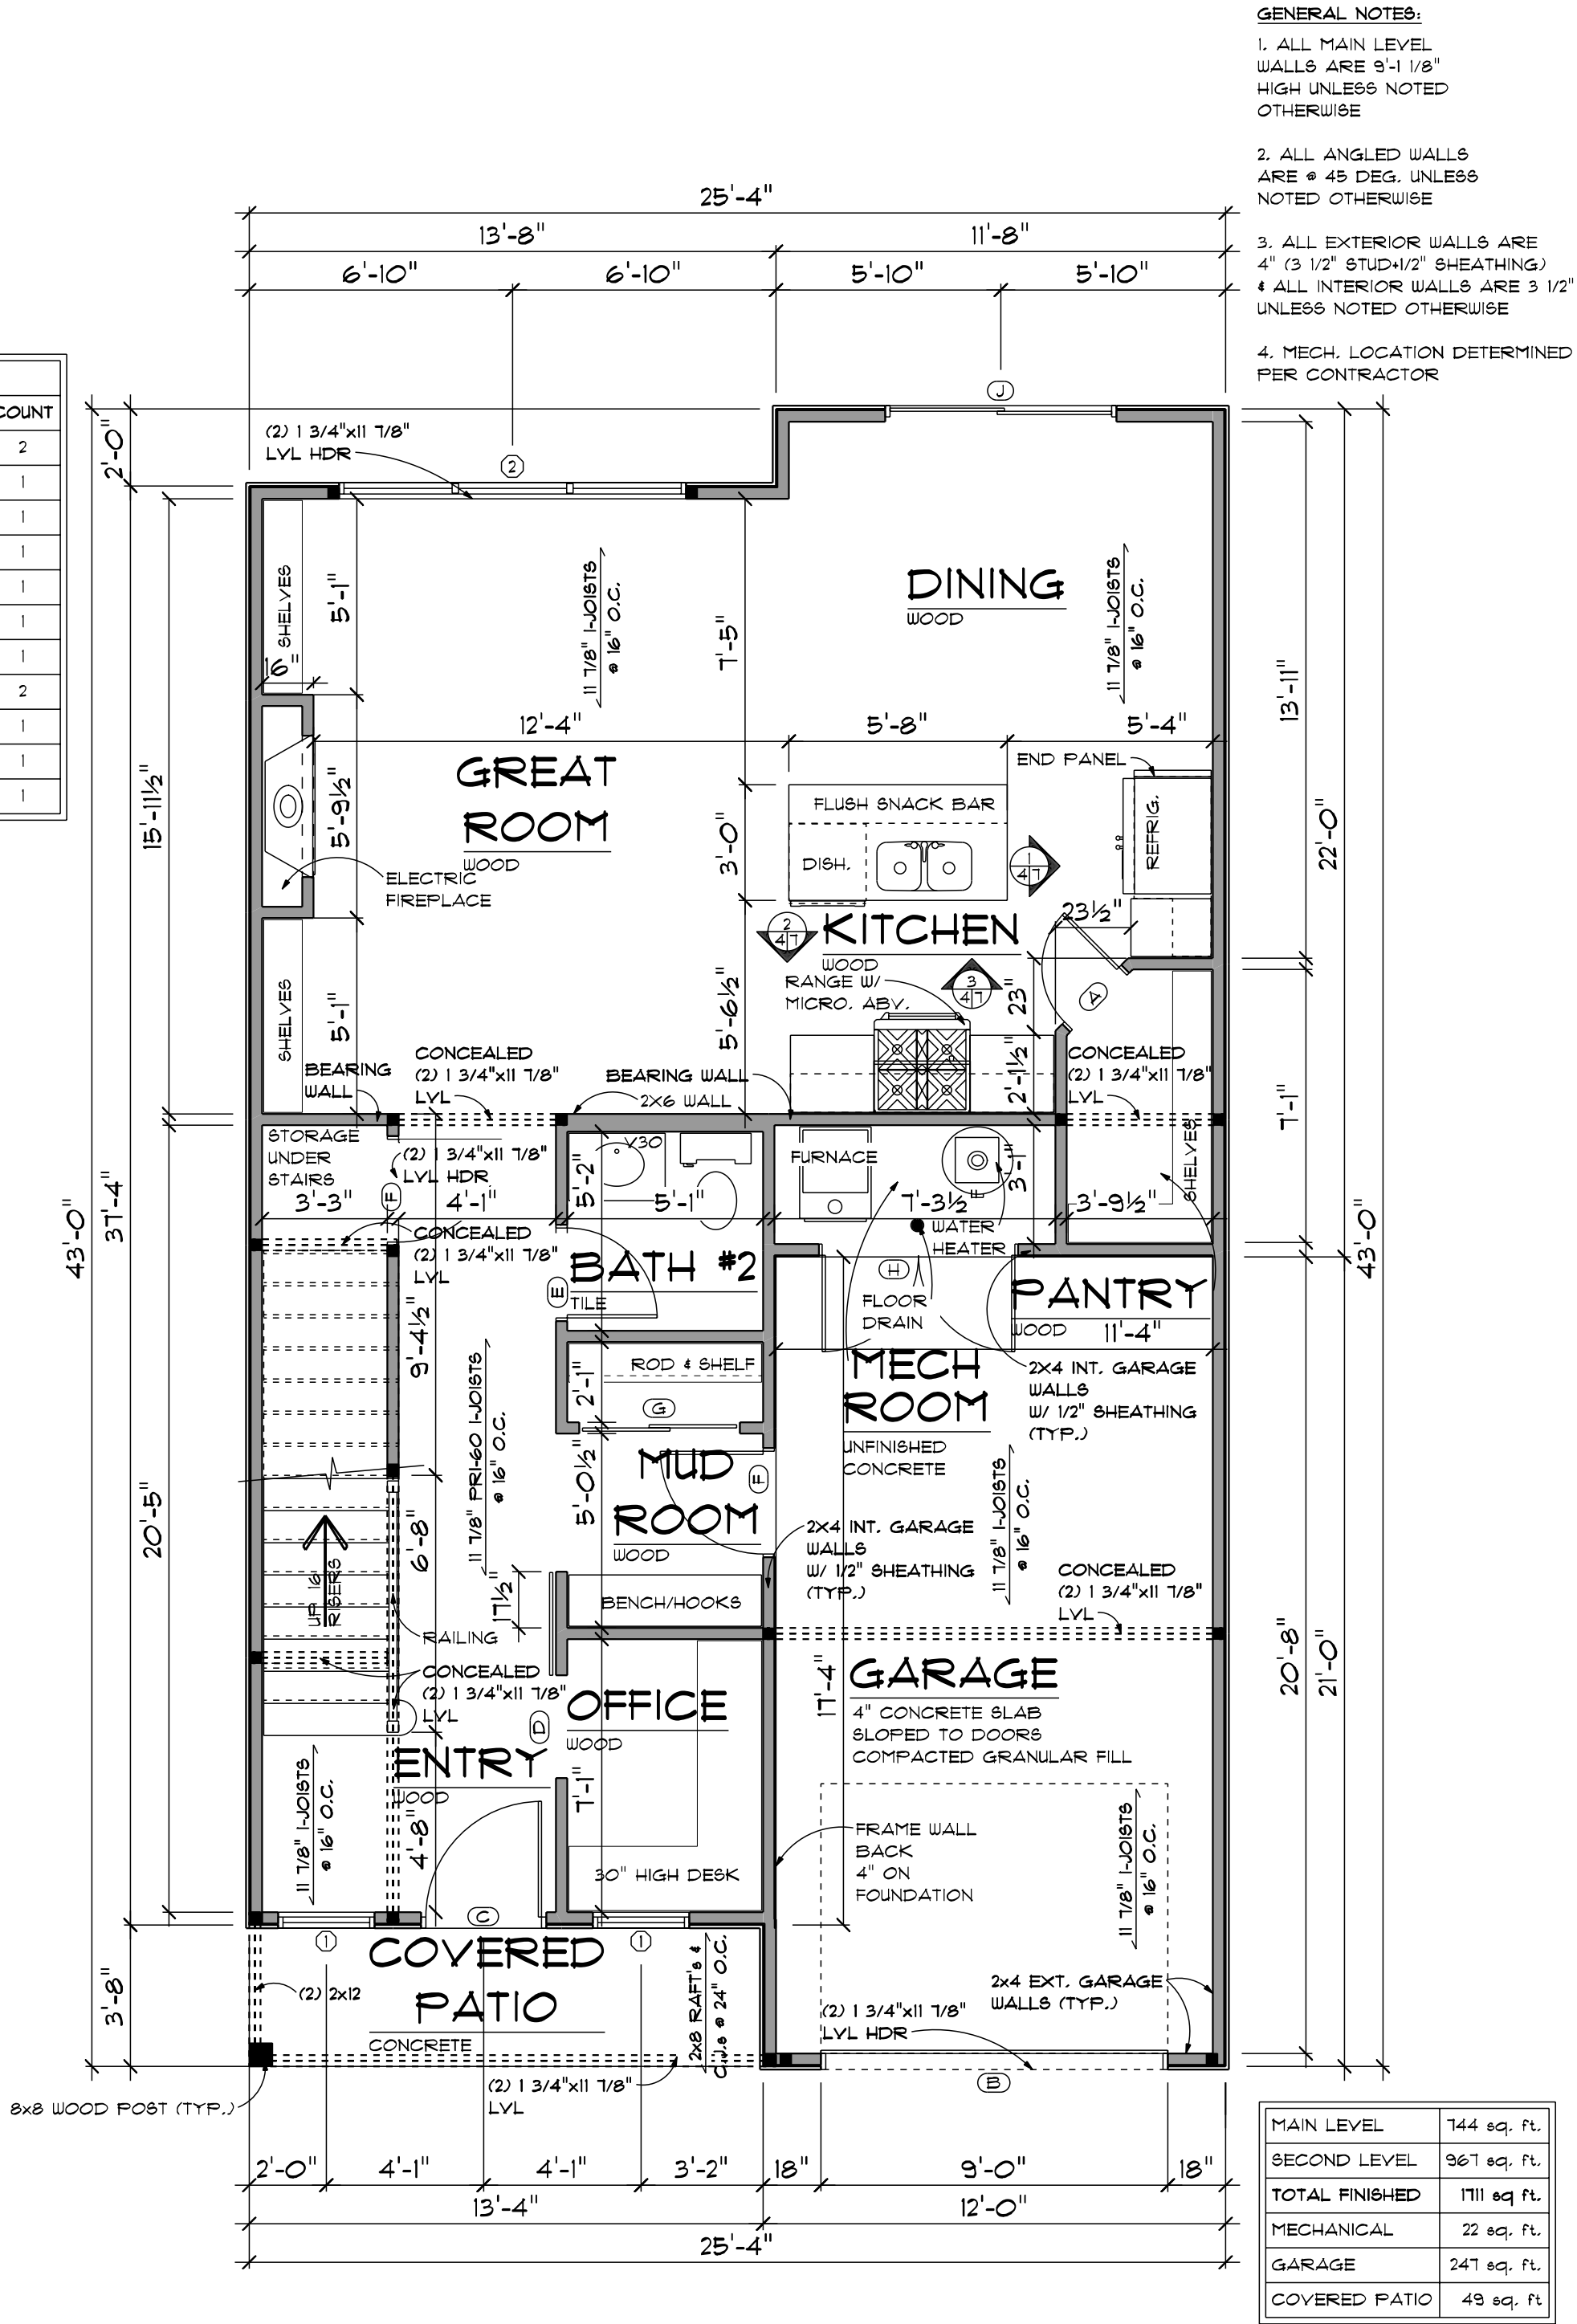

- GENERAL NOTES:
1. ALL MAIN LEVEL WALLS ARE 5'-1 1/8" HIGH UNLESS NOTED OTHERWISE
  2. ALL ANGLED WALLS ARE @ 45 DEG. UNLESS NOTED OTHERWISE
  3. ALL EXTERIOR WALLS ARE 4" (3 1/2" STUD/2" SHEATHING)
  4. ALL INTERIOR WALLS ARE 3 1/2" UNLESS NOTED OTHERWISE
  4. MECH. LOCATION DETERMINED PER CONTRACTOR

|                |              |
|----------------|--------------|
| MAIN LEVEL     | 744 sq. ft.  |
| SECOND LEVEL   | 961 sq. ft.  |
| TOTAL FINISHED | 1705 sq. ft. |
| MECHANICAL     | 22 sq. ft.   |
| GARAGE         | 247 sq. ft.  |
| COVERED PATIO  | 49 sq. ft.   |

MAIN LEVEL FLOOR PLAN  
SCALE: 1/4" = 1'-0"



PRELIM  
FINAL  
3/27/23  
REVISION

Fleetwood  
Reverse Slab



IF THIS IS NOT RED  
DO NOT COPY

advancedhouseplans  
www.advancedhouseplans.com | 844.675.9838

ADVANCED HOUSE PLANS IS A PROFESSIONAL RESIDENTIAL DESIGN FIRM  
LOCATION, CLIMATE, NEARBY SITE CONDITIONS VARY, AND CANNOT  
GUARANTEE THE ACCURACY OF THESE PLANS. THESE PLANS SHOULD NOT BE USED FOR  
CONSTRUCTION WITHOUT THE PROFESSIONAL DESIGNER'S REVIEW AND  
APPROVAL. THE PURCHASER OF THESE PLANS SHALL BE RESPONSIBLE FOR  
OBTAINING ALL NECESSARY PERMITS AND REGULATIONS PRIOR TO CONSTRUCTION.  
THESE PLANS ARE PROVIDED AS A GUIDE ONLY. THE PURCHASER SHALL  
VERIFY ALL DIMENSIONS, MATERIALS, FINISHES, AND CONSTRUCTION  
METHODS PRIOR TO CONSTRUCTION. THE PURCHASER SHALL BE RESPONSIBLE  
FOR OBTAINING ALL NECESSARY PERMITS AND REGULATIONS PRIOR TO CONSTRUCTION.

© 2023

30244


SHEET  
4

1 OF 1

20% SCALE = 3/4" = 1'-0"


The purchaser of these plans is given the limited license to reproduce these plans for construction purposes only and further distribution is illegal. Do not scale prints - see dimensions.

| ELECTRICAL LEGEND          |       |        |
|----------------------------|-------|--------|
| ELECTRICAL                 | COUNT | SYMBOL |
| ceiling fan 5 blade d14    | 3     |        |
| CAN LIGHT WATERPROOF 6INCH | 2     |        |
| can light 6inch            | 1     |        |
| ceiling tv outlet          | 3     |        |
| fan                        | 2     |        |
| outlet                     | 20    |        |
| outlet 220v                | 1     |        |
| outlet gfi                 | 4     |        |
| smoke detector             | 5     |        |
| switch                     | 11    |        |
| switch 3 way               | 5     |        |
| vanity bar light d1        | 1     |        |
| wall mounted d3 3 lights   | 1     |        |
| switch 4 way               | 3     |        |

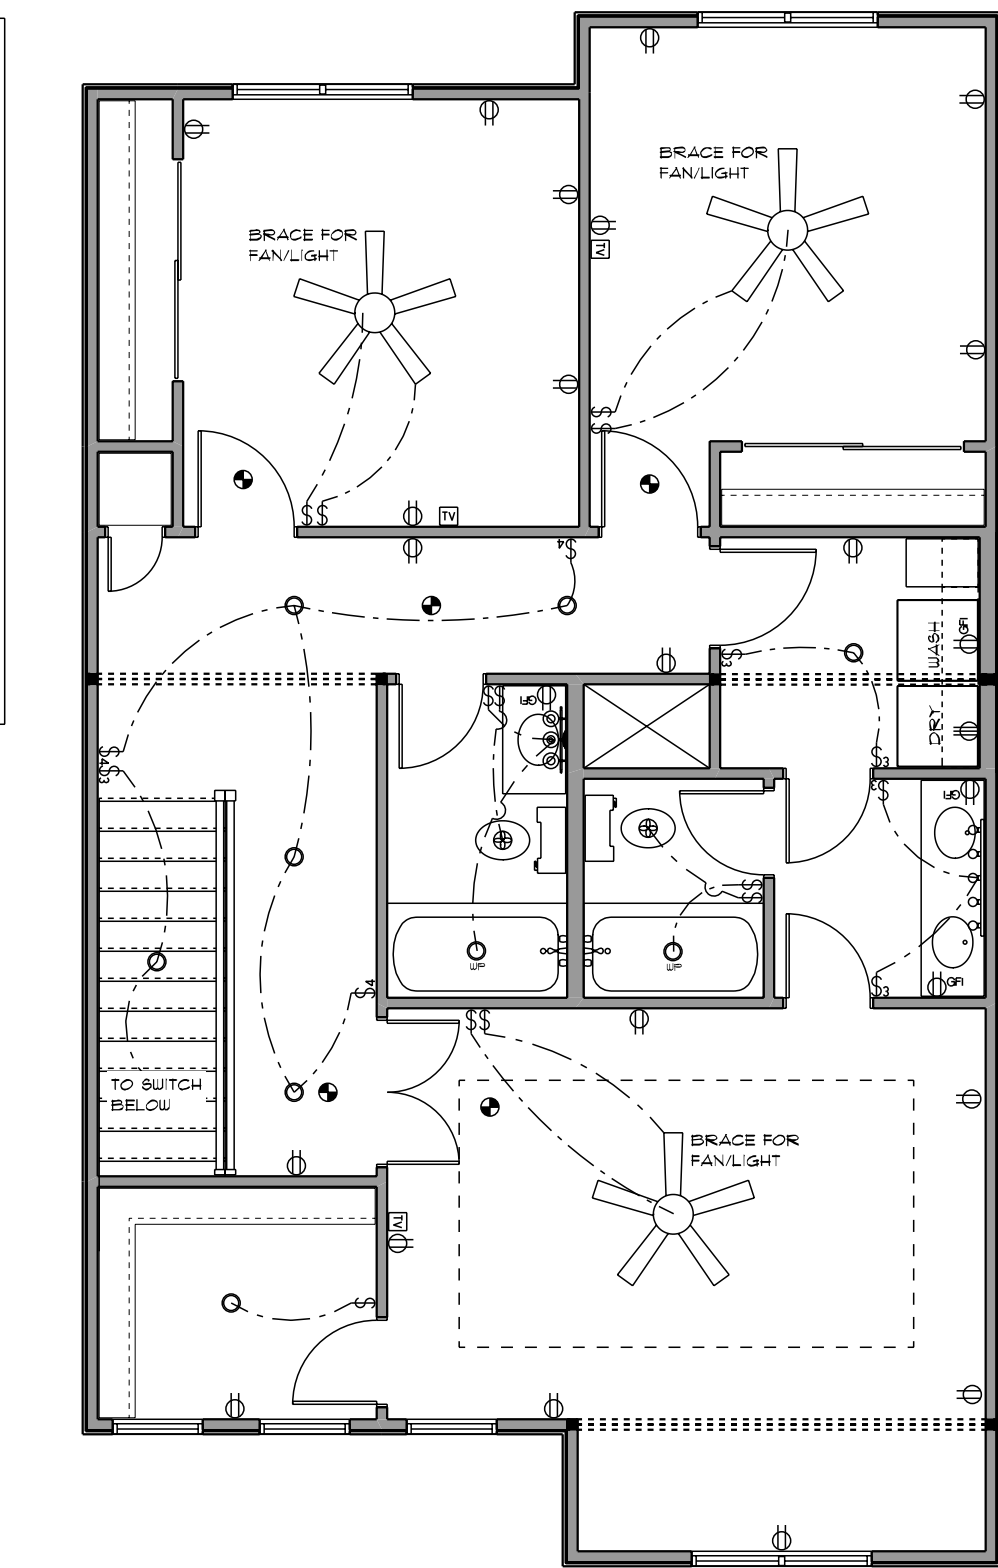

SECOND LEVEL ELECTRICAL PLAN  
SCALE: 3/16" = 1'-0"

| OPENING SCHEDULE |              |                  |               |       |
|------------------|--------------|------------------|---------------|-------|
| OPENING ID       | TYPE         | PRODUCT CODE     | SIZE          | COUNT |
| I                | WINDOW       | 30X48 CASEMENT 1 | 2'-6" x 4'-0" | 3     |
| 3                | WINDOW       | 60X60 CASEMENT 2 | 5'-0" x 5'-0" | 3     |
| L                | DOOR         | 30X80 1          | 2'-8" x 6'-8" | 3     |
| M                | DOOR         | 28X80 1          | 2'-4" x 6'-8" | 5     |
| N                | DOOR         | 48X80 2          | 4'-0" x 6'-8" | 1     |
| O                | SLIDING DOOR | 12X80 SLIDING 2  | 6'-0" x 6'-8" | 2     |
| P                | DOOR         | 18X80 1          | 1'-6" x 6'-8" | 1     |

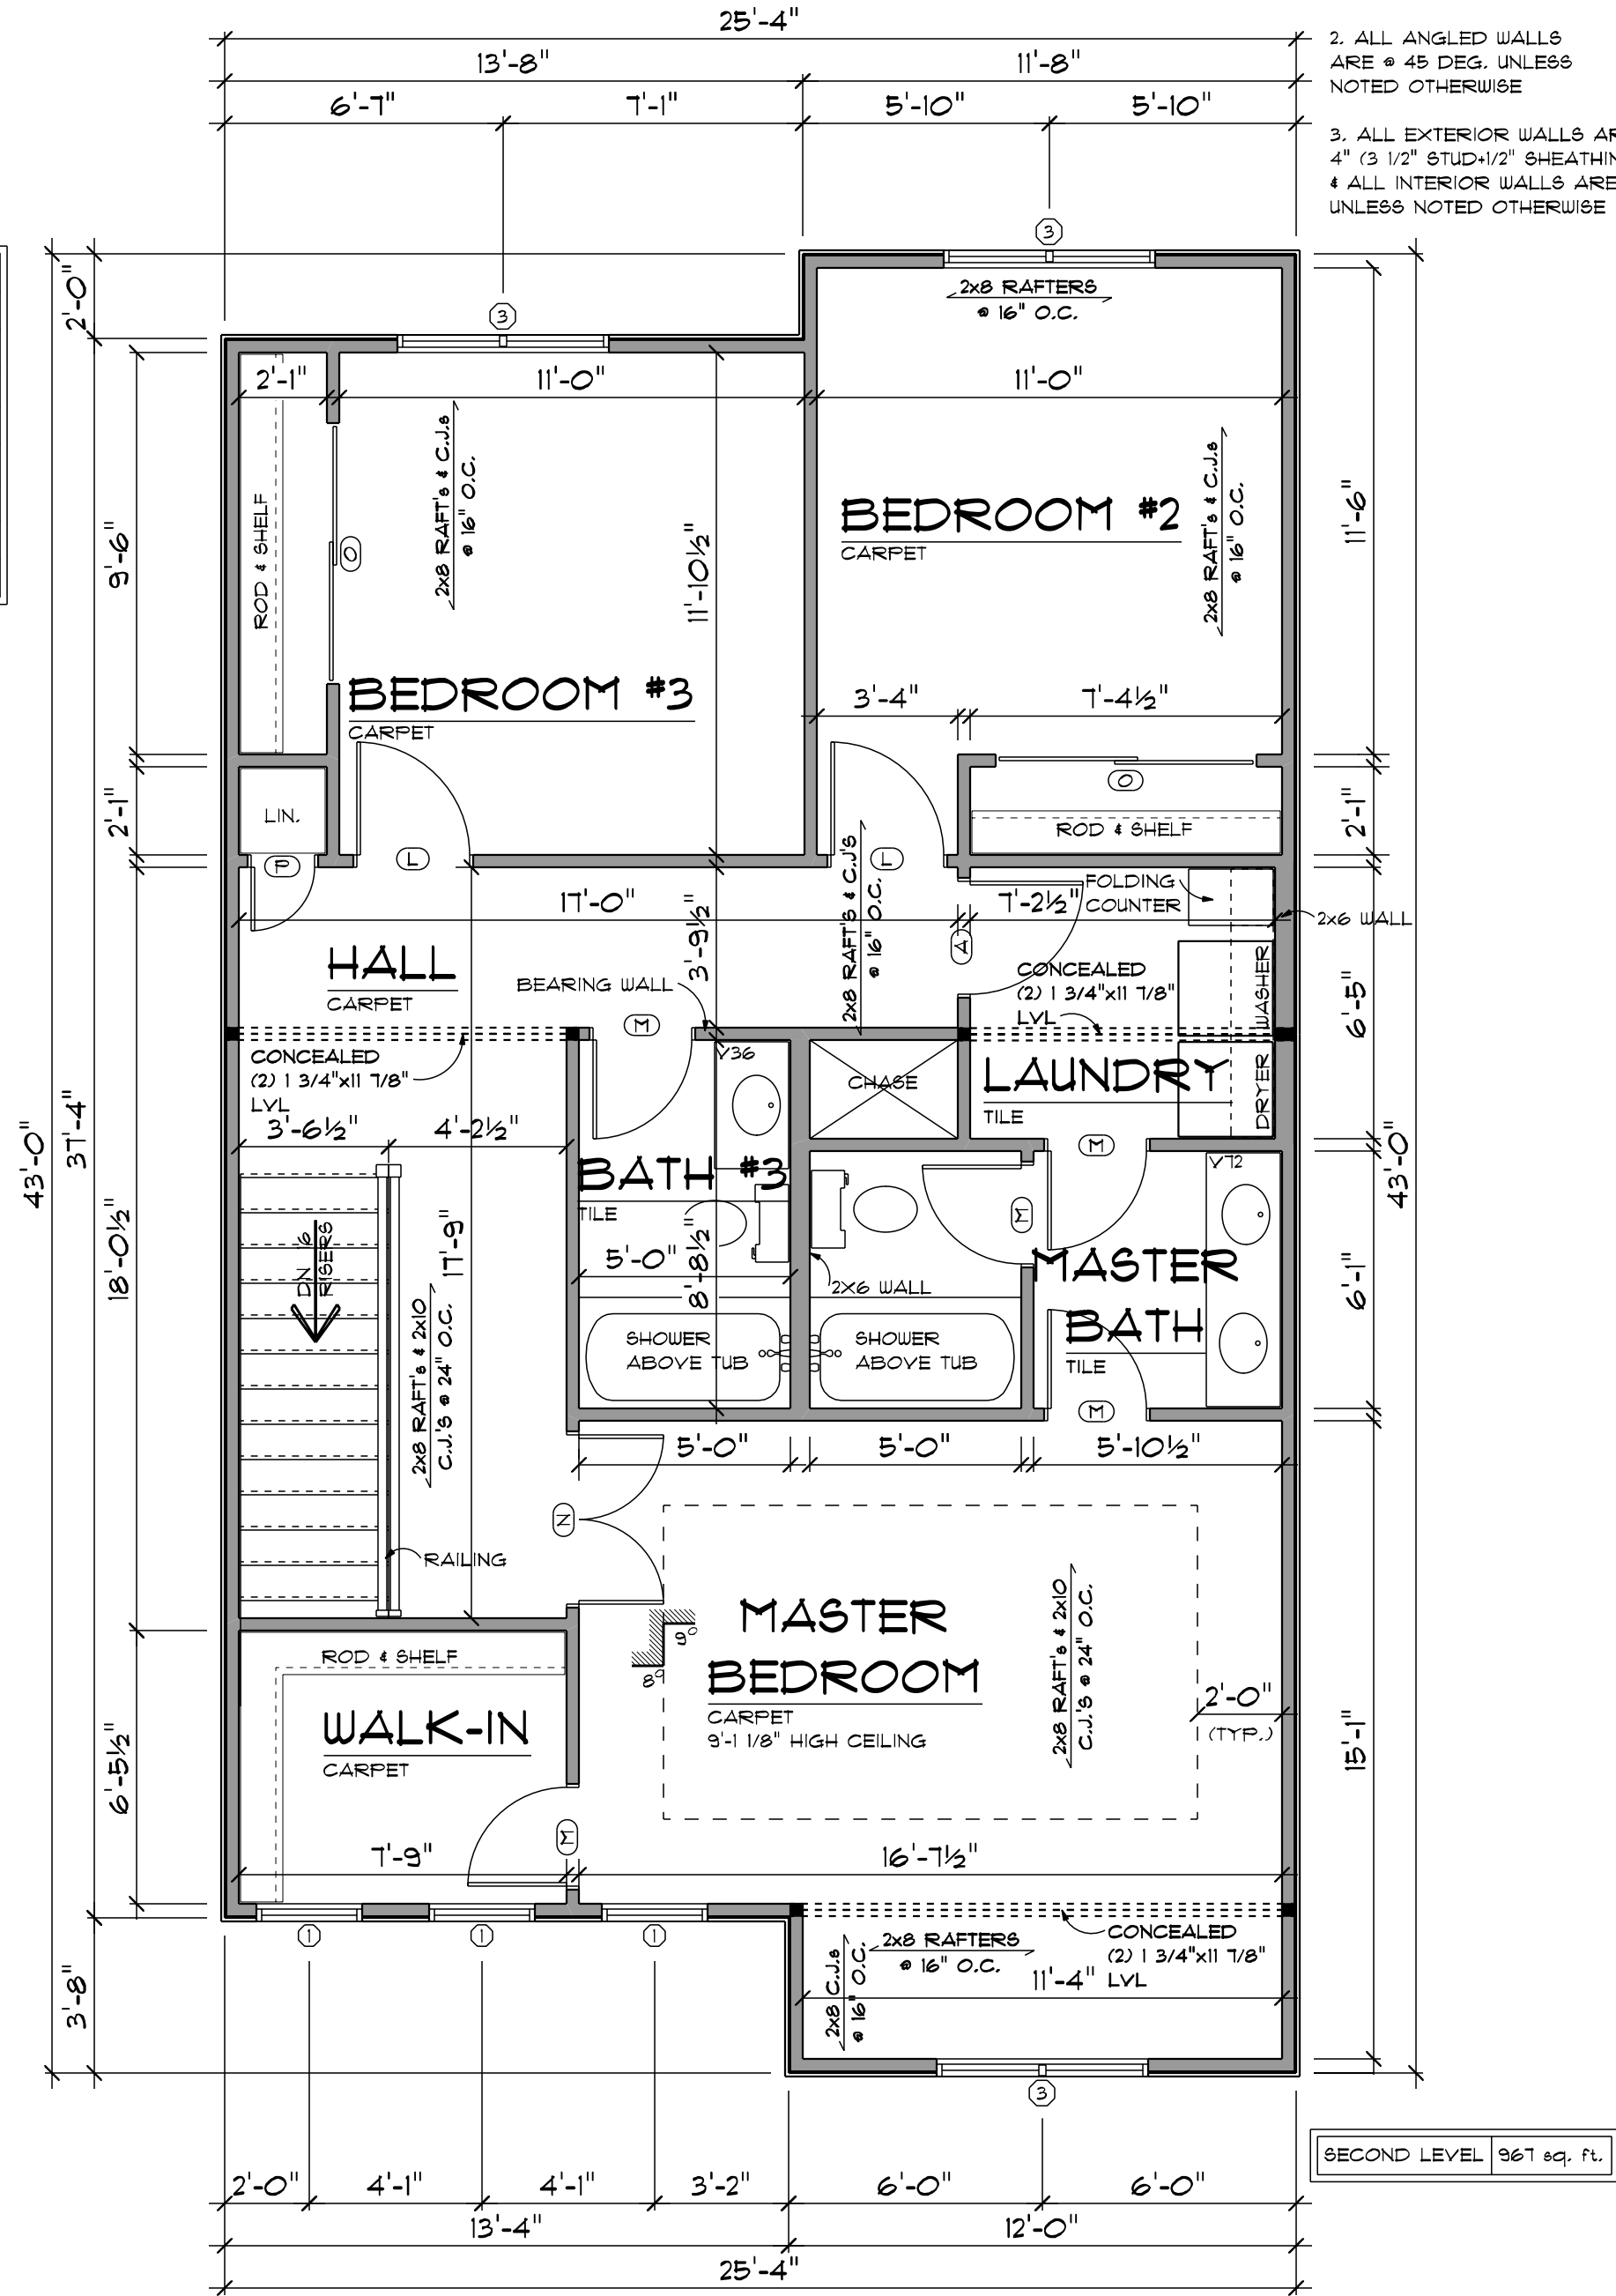

SECOND LEVEL FLOOR PLAN  
SCALE: 1/4" = 1'-0"

- GENERAL NOTES:
1. ALL SECOND LEVEL WALLS ARE 8'-1 1/8" HIGH UNLESS NOTED OTHERWISE
  2. ALL ANGLED WALLS ARE # 45 DEG. UNLESS NOTED OTHERWISE
  3. ALL EXTERIOR WALLS ARE 4" (3 1/2" STUD/1/2" SHEATHING)
  4. ALL INTERIOR WALLS ARE 3 1/2" UNLESS NOTED OTHERWISE



|          |
|----------|
| PRELIM   |
| FINAL    |
| 3/27/23  |
| REVISION |

Fleetwood  
Reverse Slab



advancedhouseplans  
www.advancedhouseplans.com | 844.675.9838


ADVANCED HOUSE PLANS IS A PROFESSIONAL RESIDENTIAL DESIGN FIRM  
LOCATION, ORIGIN, NE, BECAUSE SITE CONDITIONS VARY, ANY CANNOT  
CONSTRUCTION FROM THESE PLANS SHOULD NOT BE UNDERTAKEN WITHOUT THE  
DESIGNER'S REVIEW AND APPROVAL. ALL DIMENSIONS, MATERIALS, FINISHES, ETC.  
CODE & SITE REQUIREMENTS PRIOR TO CONSTRUCTION.  
THAT MAY OCCUR DURING OR AFTER THE BUILDING PROCESS.

© 2023  
30244

SHEET  
1 OF 1


20% SCALE = 24"x36"

The purchaser of these plans is given the limited license to reproduce these plans for construction purposes only and further distribution is illegal. Do not scale prints - see dimensions.

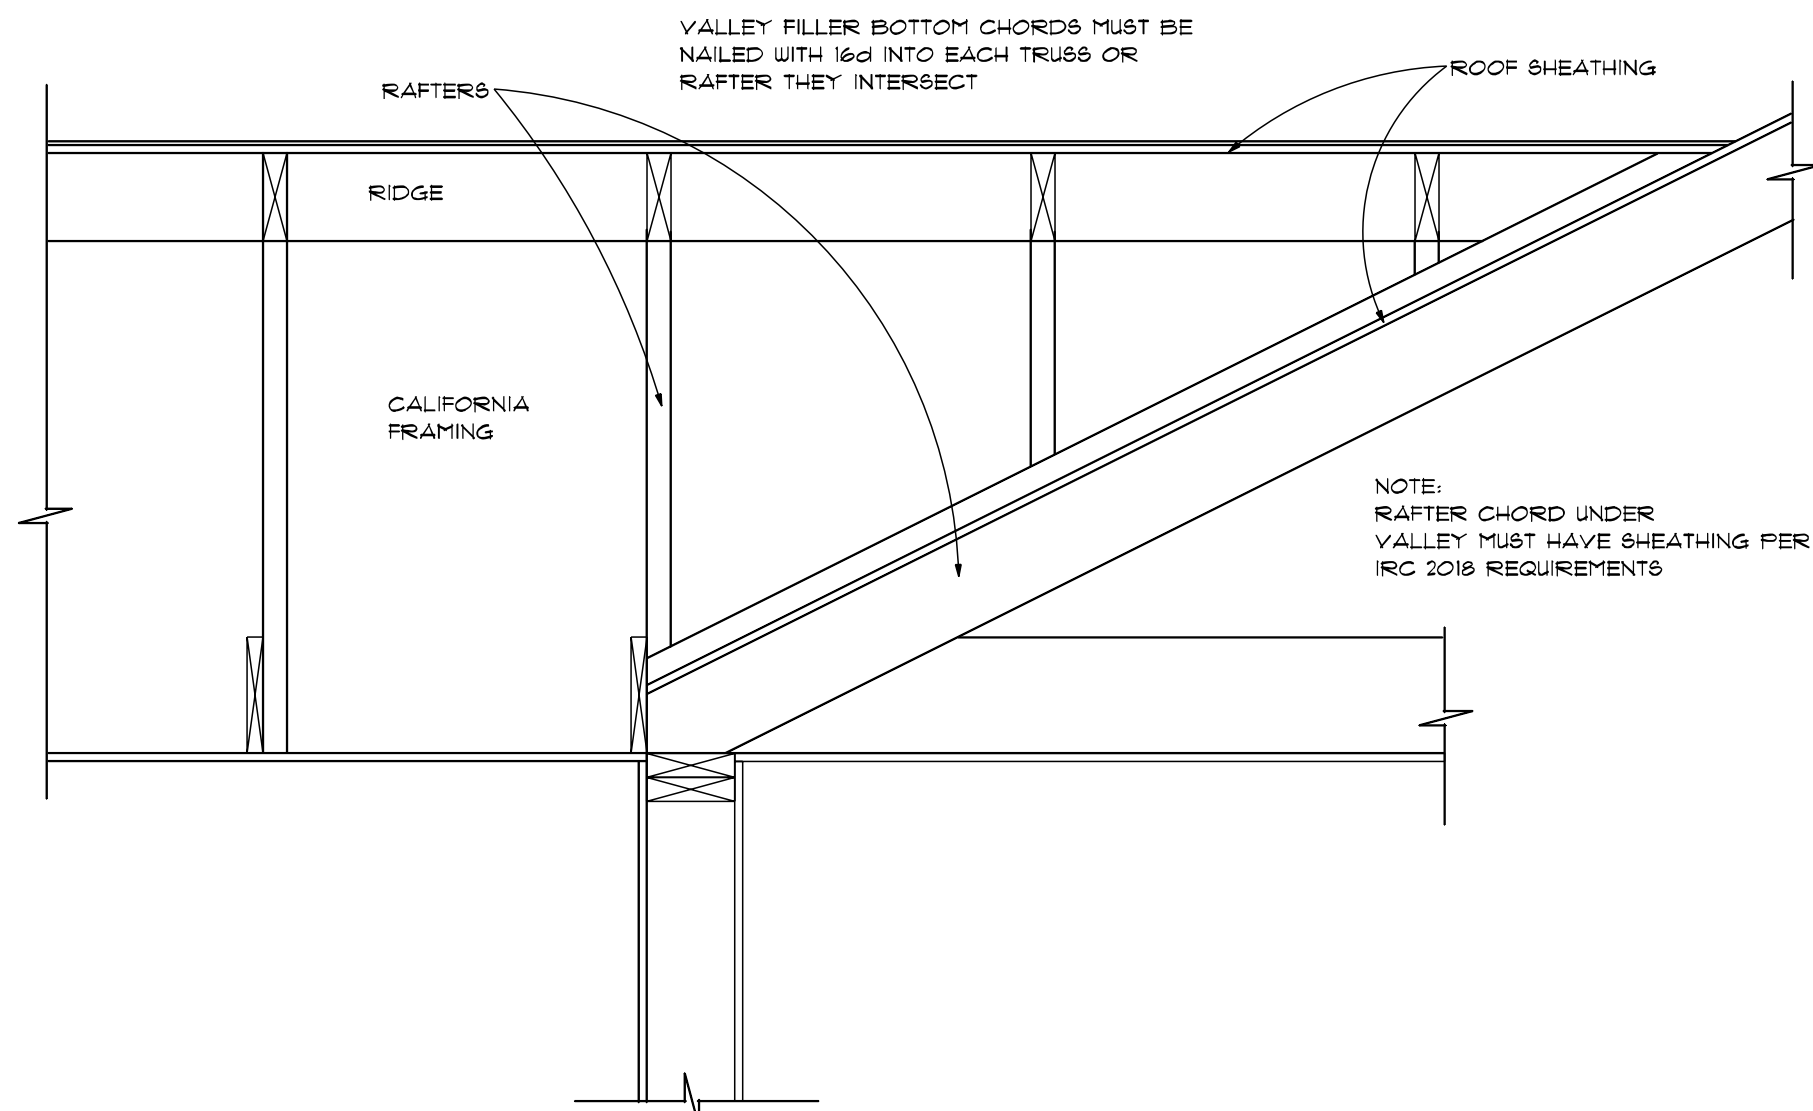


ROOF OVERFRAMING

SCALE: 1/4"=1'-0"

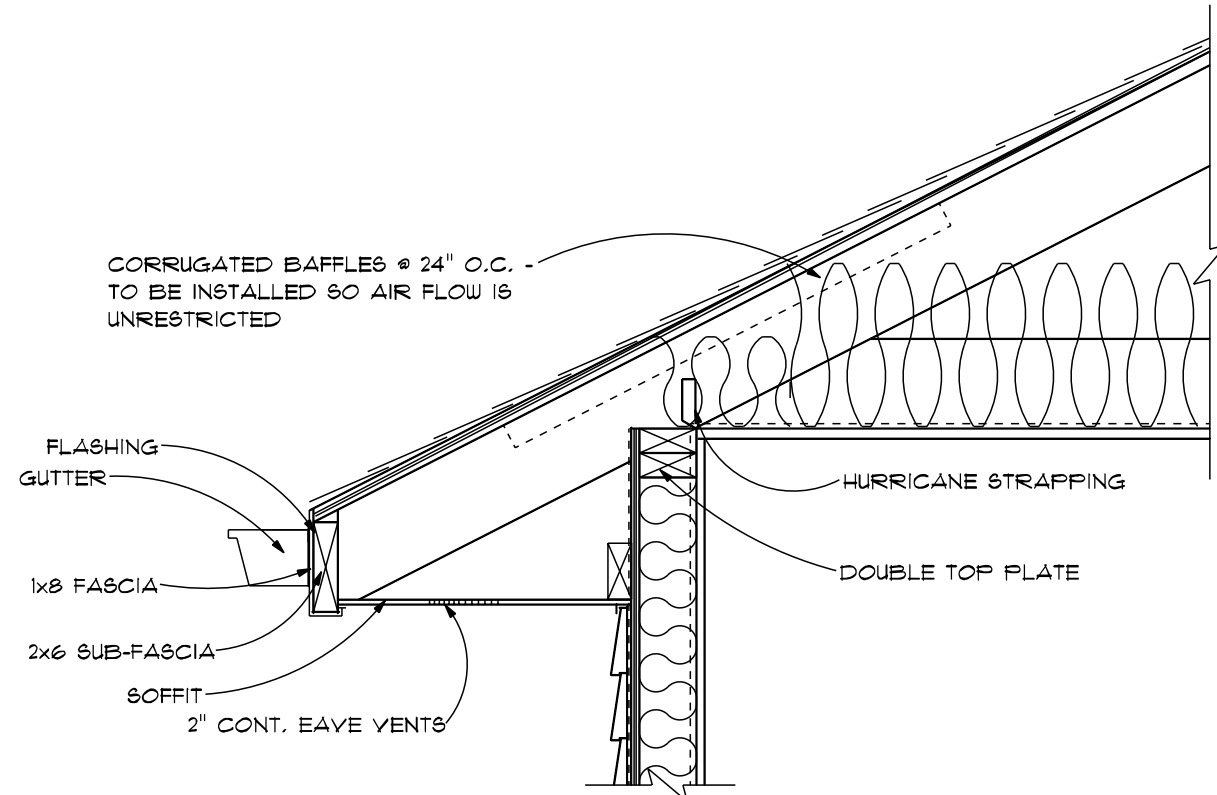


EAVE VENT

SCALE: 1/4"=1'-0"

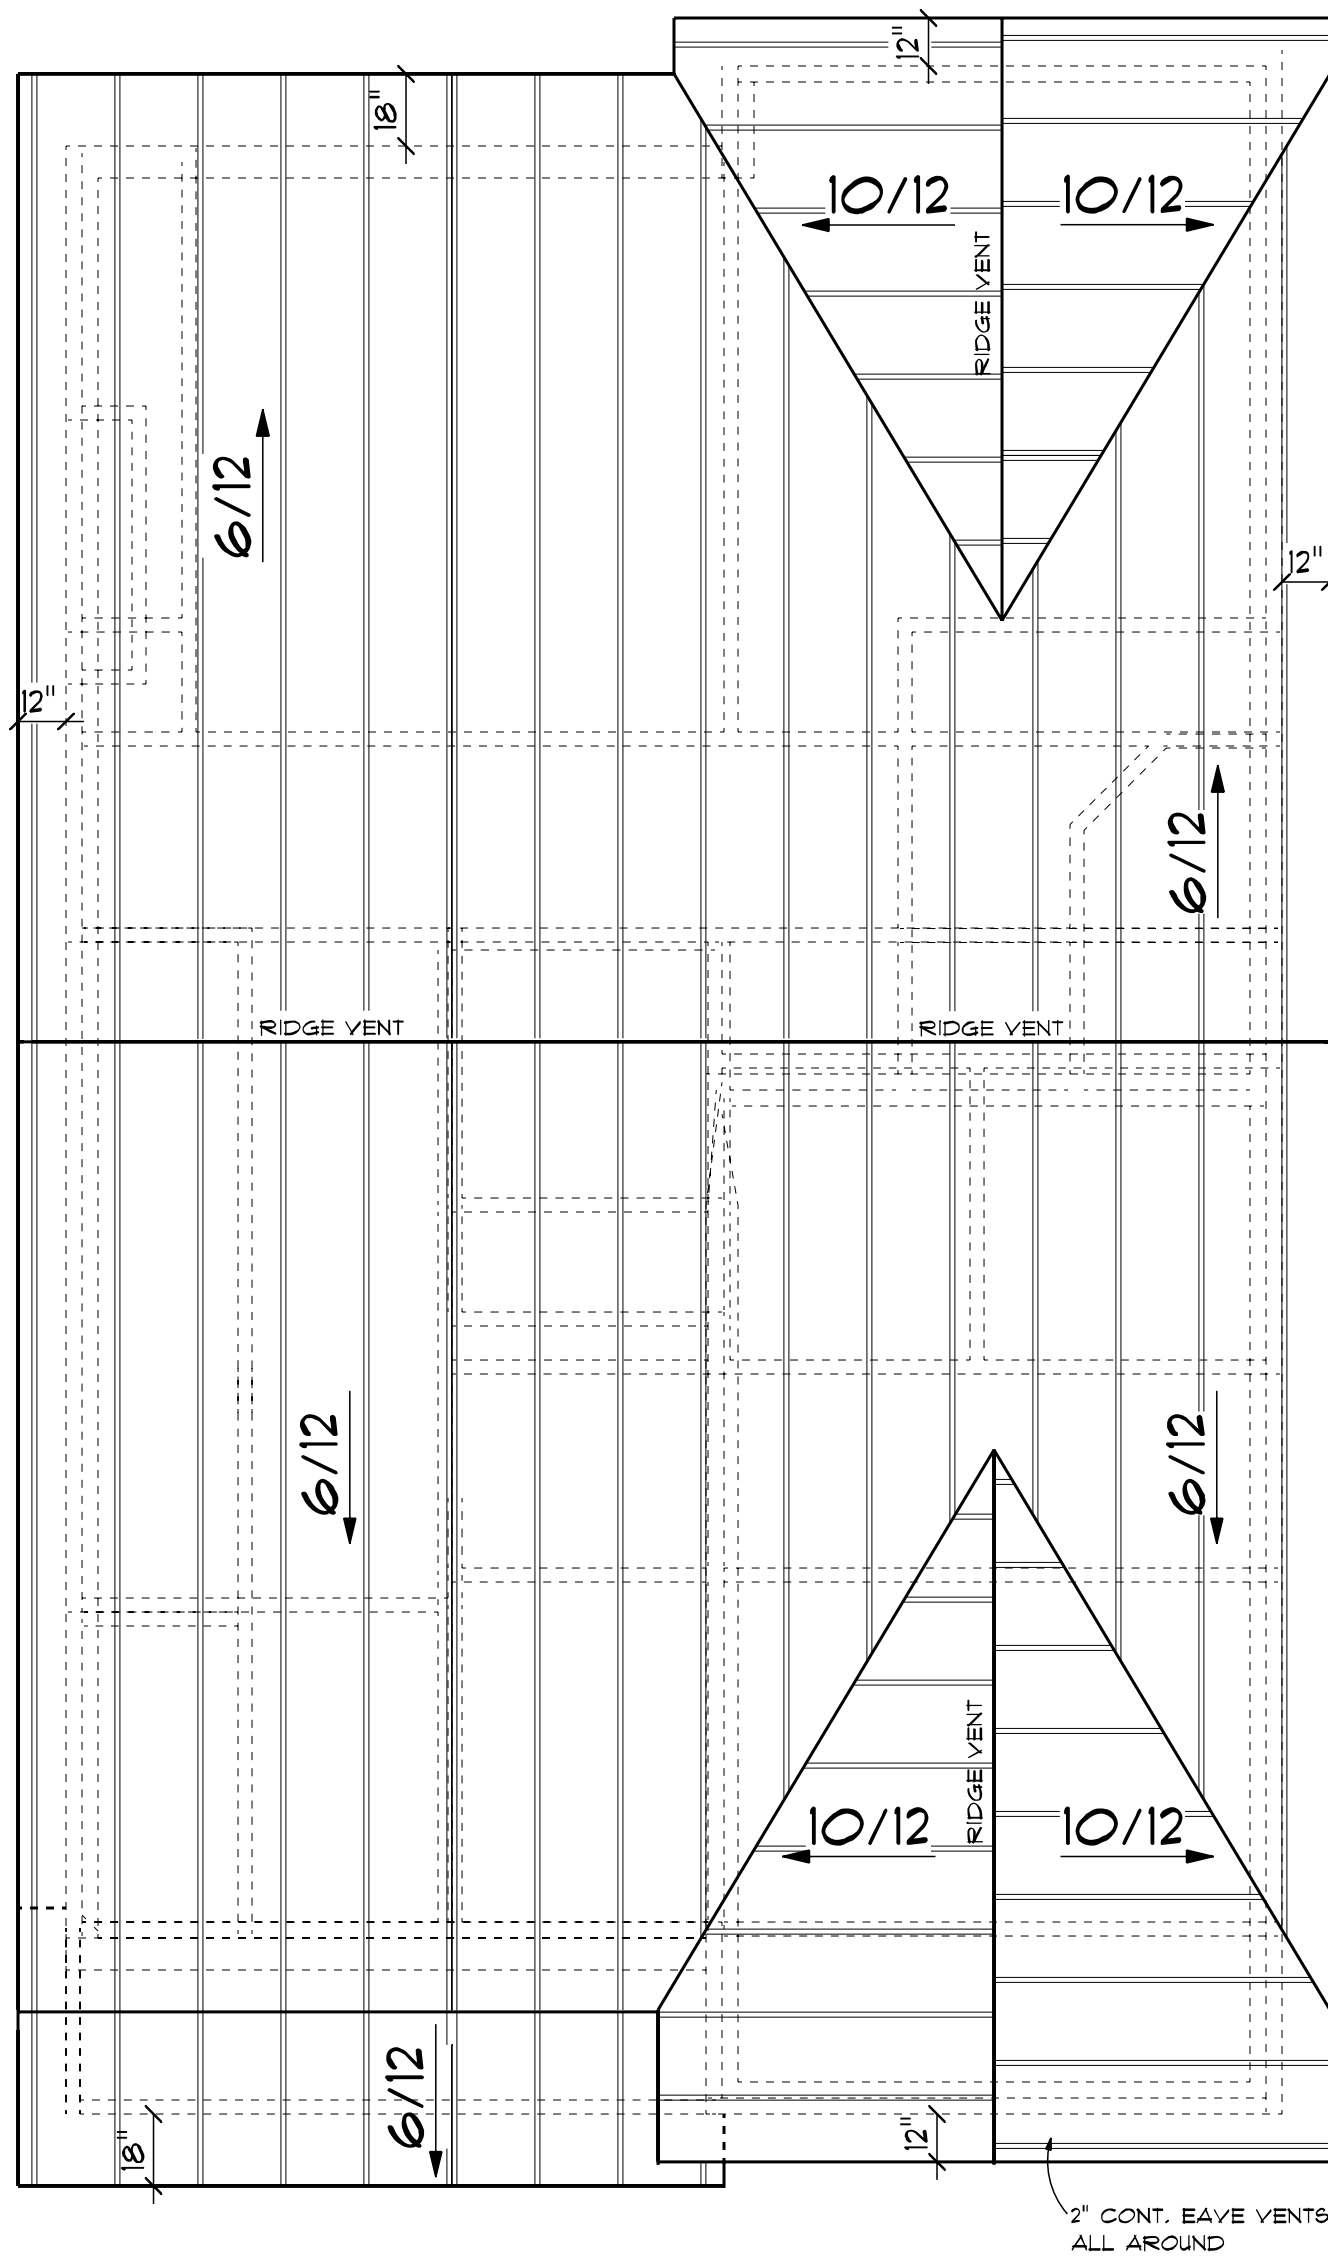


ROOF PLAN

SCALE: 1/4" = 1'-0"  
NOTE: ALL ROOFS STANDING SEAM METAL

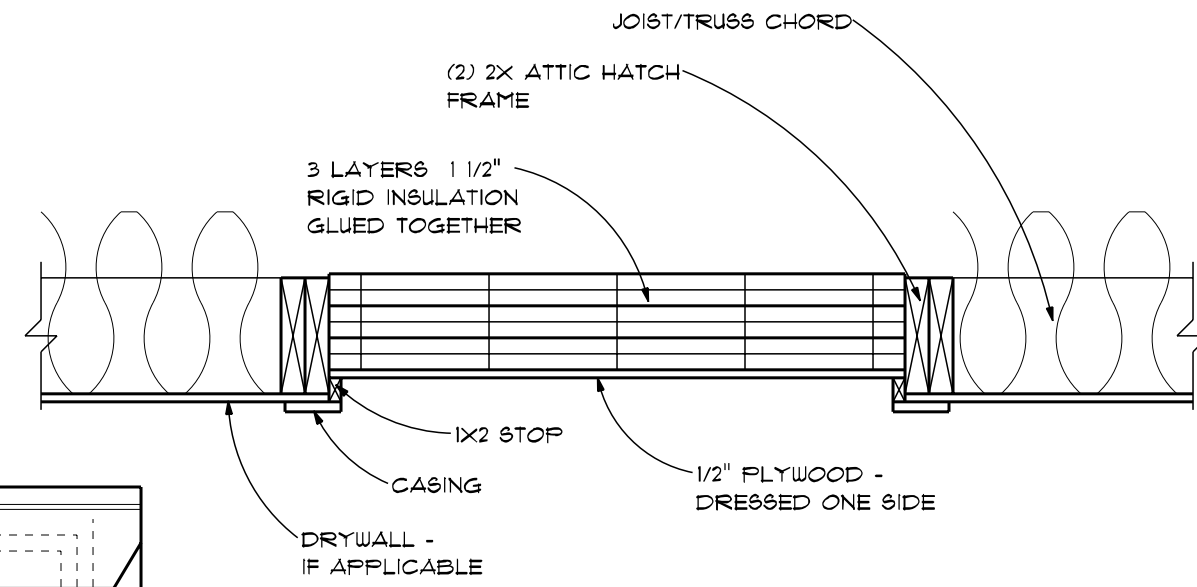

ATTIC HATCH

SCALE: 1/4"=1'-0"

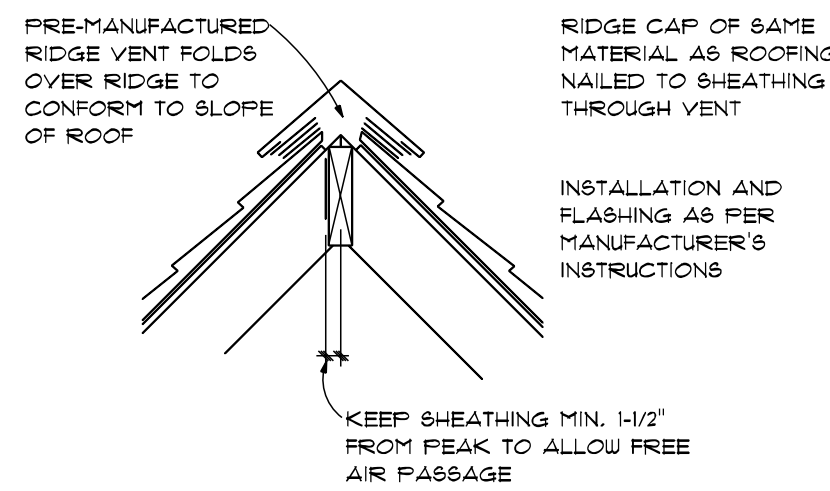

RIDGE VENT

SCALE: 1/4"=1'-0"



|          |
|----------|
| PRELIM   |
| FINAL    |
| 3/27/23  |
| REVISION |

Fleetwood  
Reverse Slab



ADVANCED HOUSE PLANS IS A PROFESSIONAL RESIDENTIAL DESIGN FIRM LOCATED IN OHIO. WE BECAUSE SITE CONDITIONS VARY, ANY CANNOT GUARANTEE THE ACCURACY OF THESE PLANS. WE DO NOT BE RESPONSIBLE FOR CONSTRUCTION FROM THESE PLANS SHOULD NOT BE UNDERTAKEN WITHOUT THE ASSISTANCE OF A PROFESSIONAL ARCHITECT OR ENGINEER. WE DO NOT PROVIDE "FAST TRACK" REVIEW. ALL DIMENSIONS, MATERIALS, FINISHES, ETC. MUST BE THOROUGHLY REVIEWED PRIOR TO CONSTRUCTION. WE DO NOT PROVIDE "FAST TRACK" REVIEW. ALL DIMENSIONS, MATERIALS, FINISHES, ETC. MUST BE THOROUGHLY REVIEWED PRIOR TO CONSTRUCTION. WE DO NOT PROVIDE "FAST TRACK" REVIEW. ALL DIMENSIONS, MATERIALS, FINISHES, ETC. MUST BE THOROUGHLY REVIEWED PRIOR TO CONSTRUCTION.

