



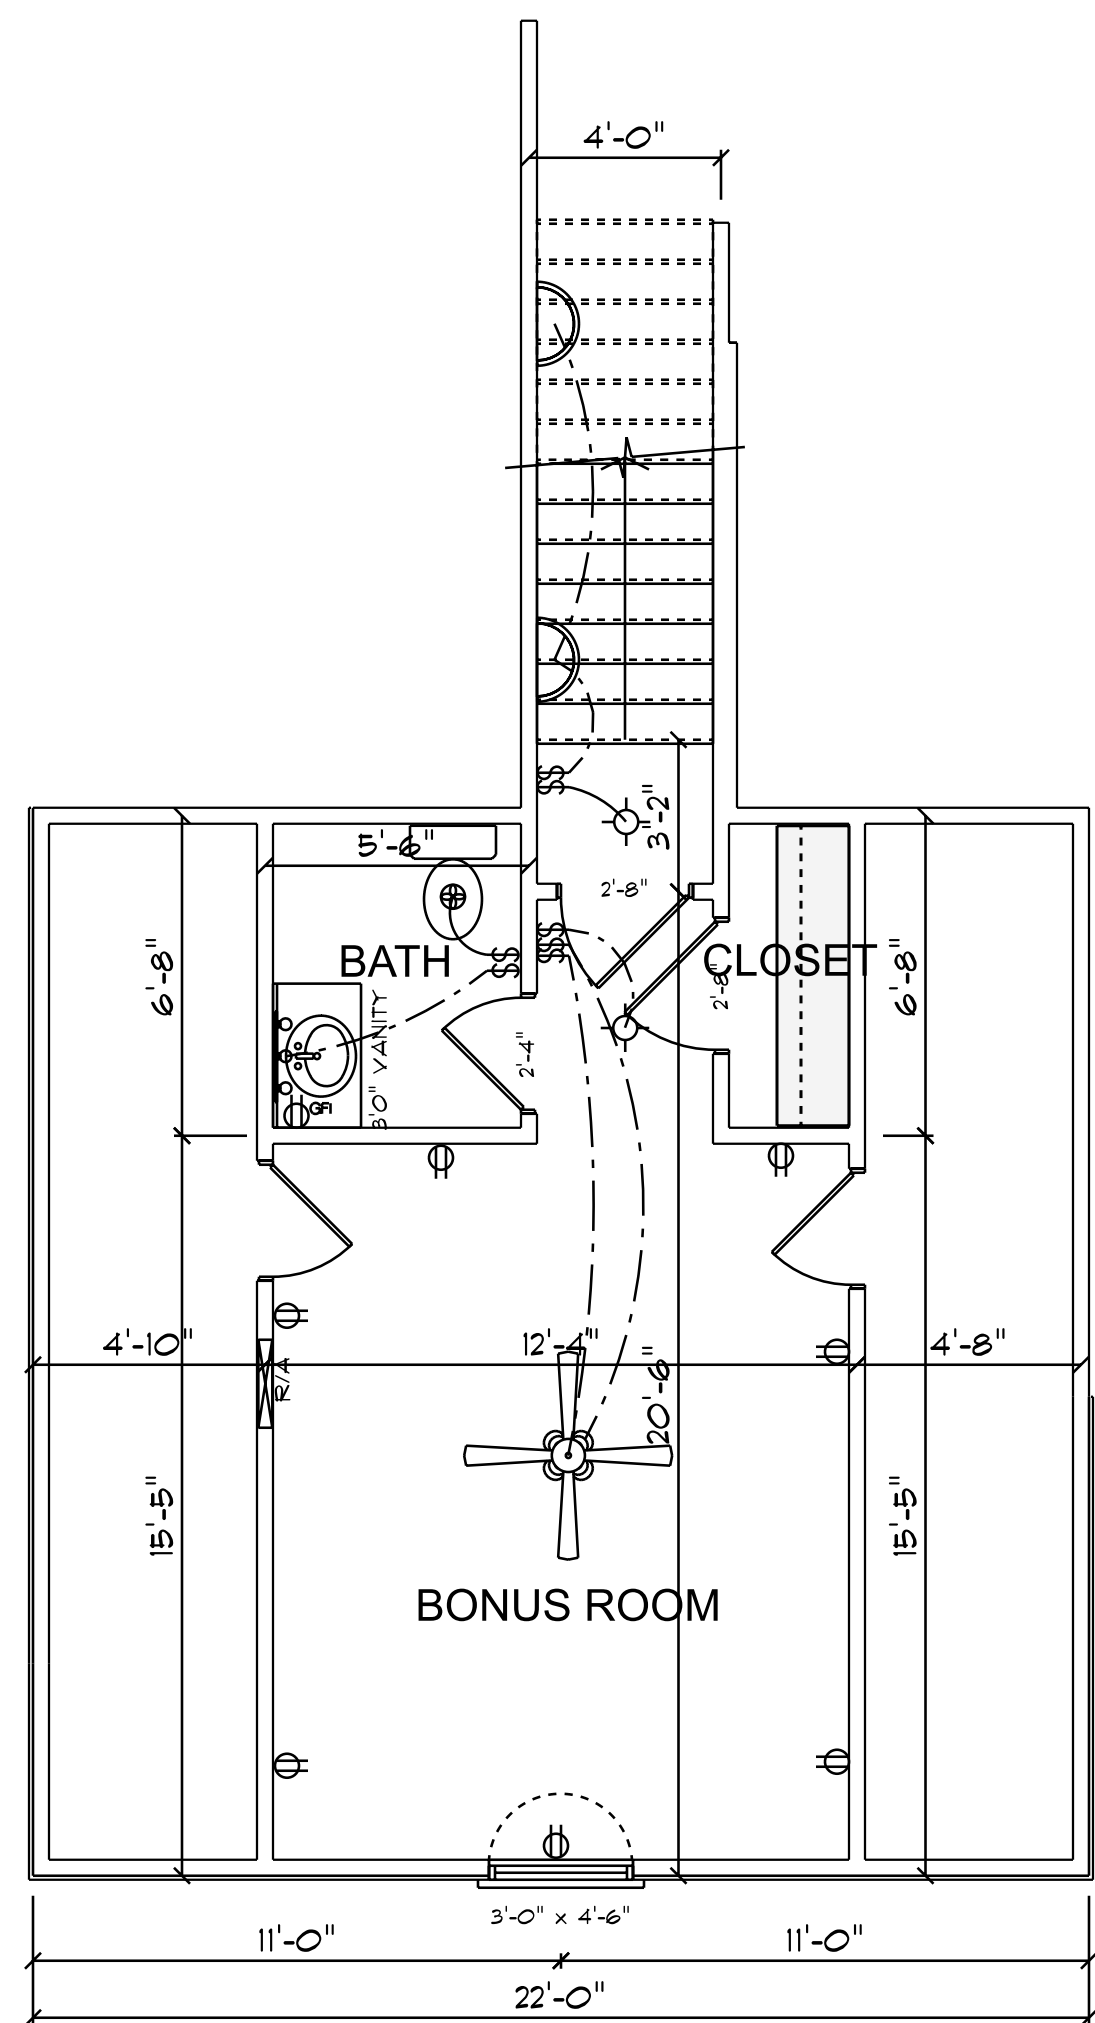

BONUS ROOM 299 S/F IN BONUS ROOM
SCALE: 1/4" = 1'0"

ELECTRICAL CONTRACTOR TO CONFIRM LOCATION
OF OUTLET AND FIXTURES. SEE HOME OWNER FOR
TYPE AND STYLE OF ELECTRICAL FIXTURES

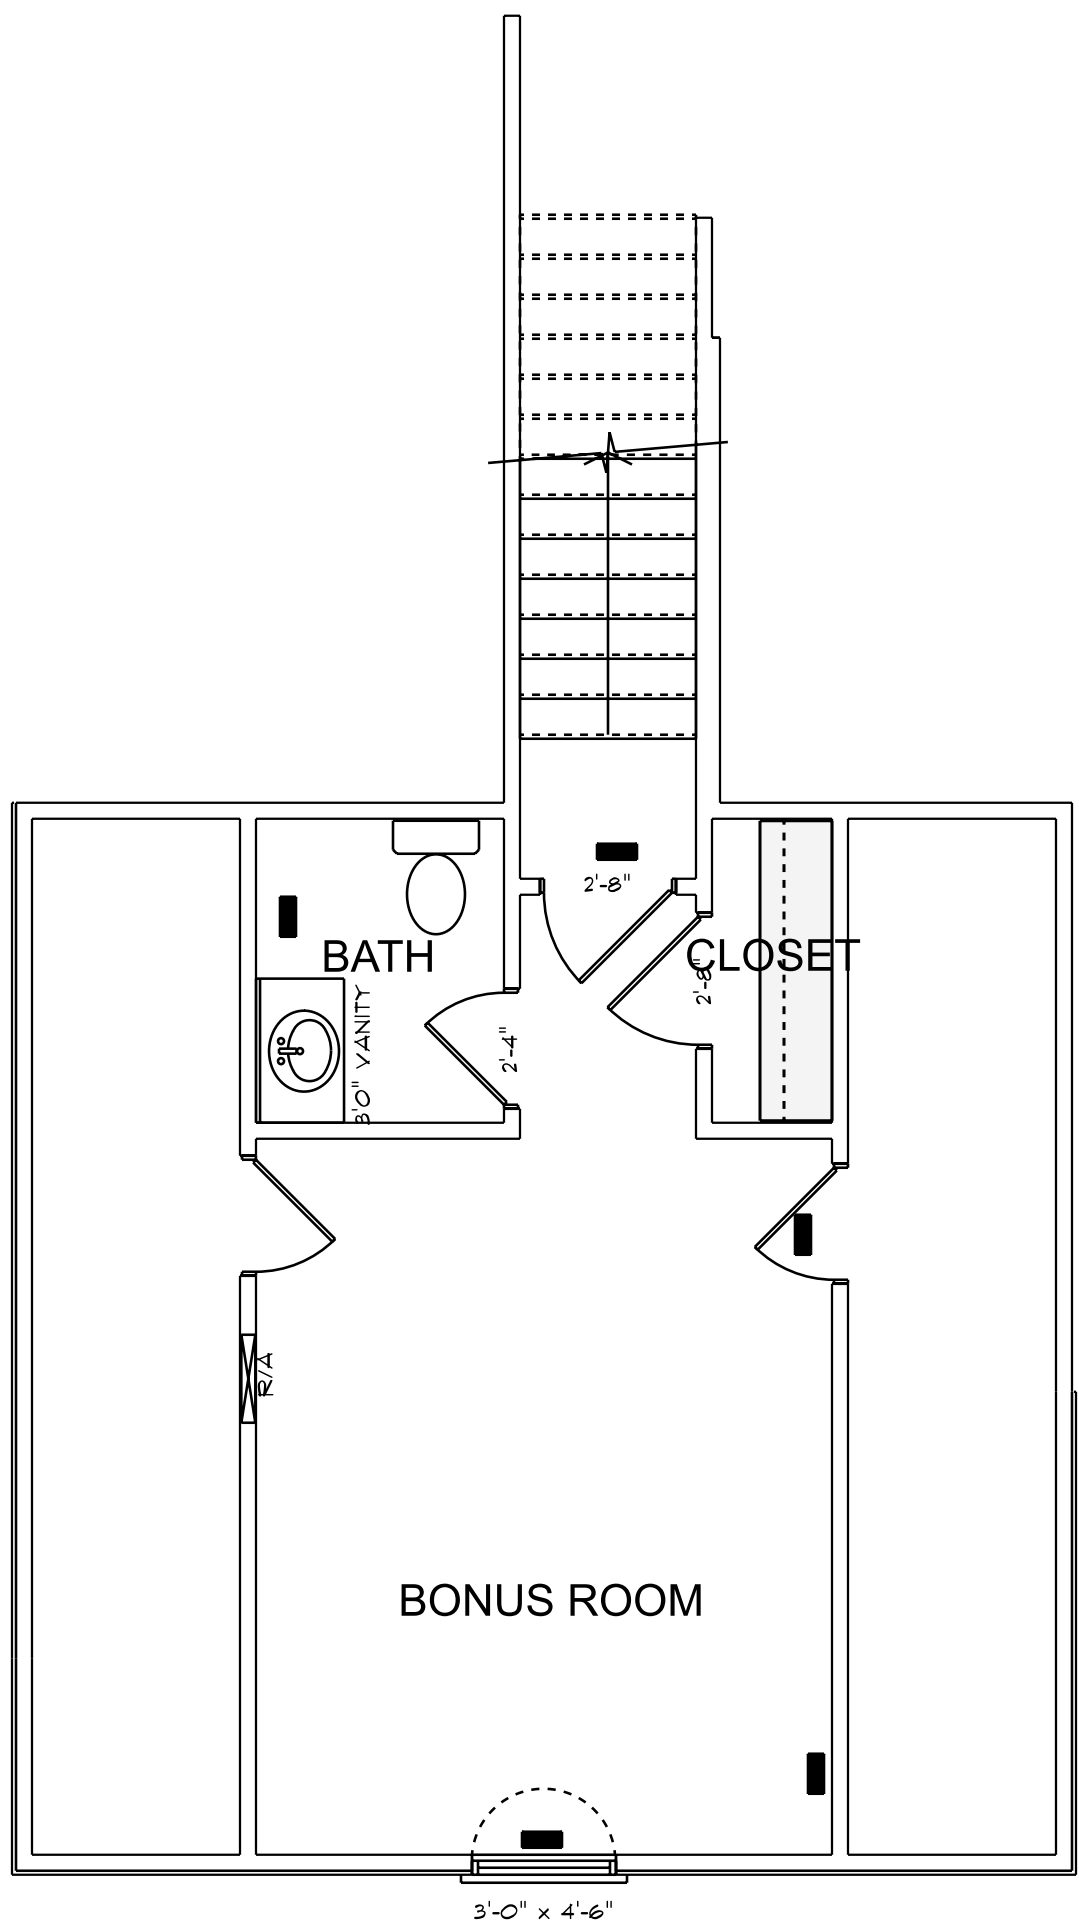

 
HVAC PLAN
BONUS ROOM 299 S/F IN BONUS ROOM
SCALE: 1/4" = 1'0"

HVAC CONTRACTOR TO CONFIRM
VENT LOCATION AND SIZE OF UNIT

LANDRY
HOMES
LLC.

NOTES:

1. ALL MATERIALS ARE TO BE CHOSEN BY THE HOME OWNER AND / OR BUILDER.
2. FINAL NUMBER OF EXTERIOR STEPS WILL BE DETERMINED ON SITE BY GRADE CONDITIONS.
3. ALL DIMENSIONS ARE TO FACE UNLESS OTHERWISE NOTED.
4. DESIGNER ASSUMES NO RESPONSIBILITY FOR CHANGES TO DRAWINGS BY OTHERS DURING CONSTRUCTION.
5. ALL DIMENSIONS ARE TO FACE UNLESS OTHERWISE NOTED.
6. CONTRACTOR SHALL HAVE REFERENCE PURPOSES ONLY.
7. CONTRACTOR SHALL HAVE REFERENCE PURPOSES ONLY.
8. CONTRACTOR SHALL HAVE REFERENCE PURPOSES ONLY.
100. CONTRACTOR SHALL HAVE REFERENCE PURPOSES ONLY.



GCP Designs Group LLC
Designs You Can Trust

DATE: 12-30-23
SUBDIVISION:
BUILDER:

LANDRY
HOMES
LLC.

NOTE:
BUILDING CONTRACTOR TO MEET LOCAL WIND LOADS
PER LOCAL CODE AS IT PERTAINS TO LOCATION OF HOUSE
100, 110, 120, 990, 1000.