


TABLE OF CONTENTS

SYMBOLS

SHEET #:
G0.01

- 1) HIP AND VALLEY RAFTERS SHALL BE SUPPORTED AT RIDGE DOWN TO BEARING PARTITION. CUT ENDS OF RAFTERS SHALL BE FULLY SUPPORTED WALL AND RIDGE.
- 2) REQUIRED VENTILATION AREAS CALCULATED AT 1/300 RATIO.

ELECTRICAL PLANS DESIGNED TO MEET OR EXCEED MINIMUM
CODE REQUIREMENTS OF 2020 N.E.C.

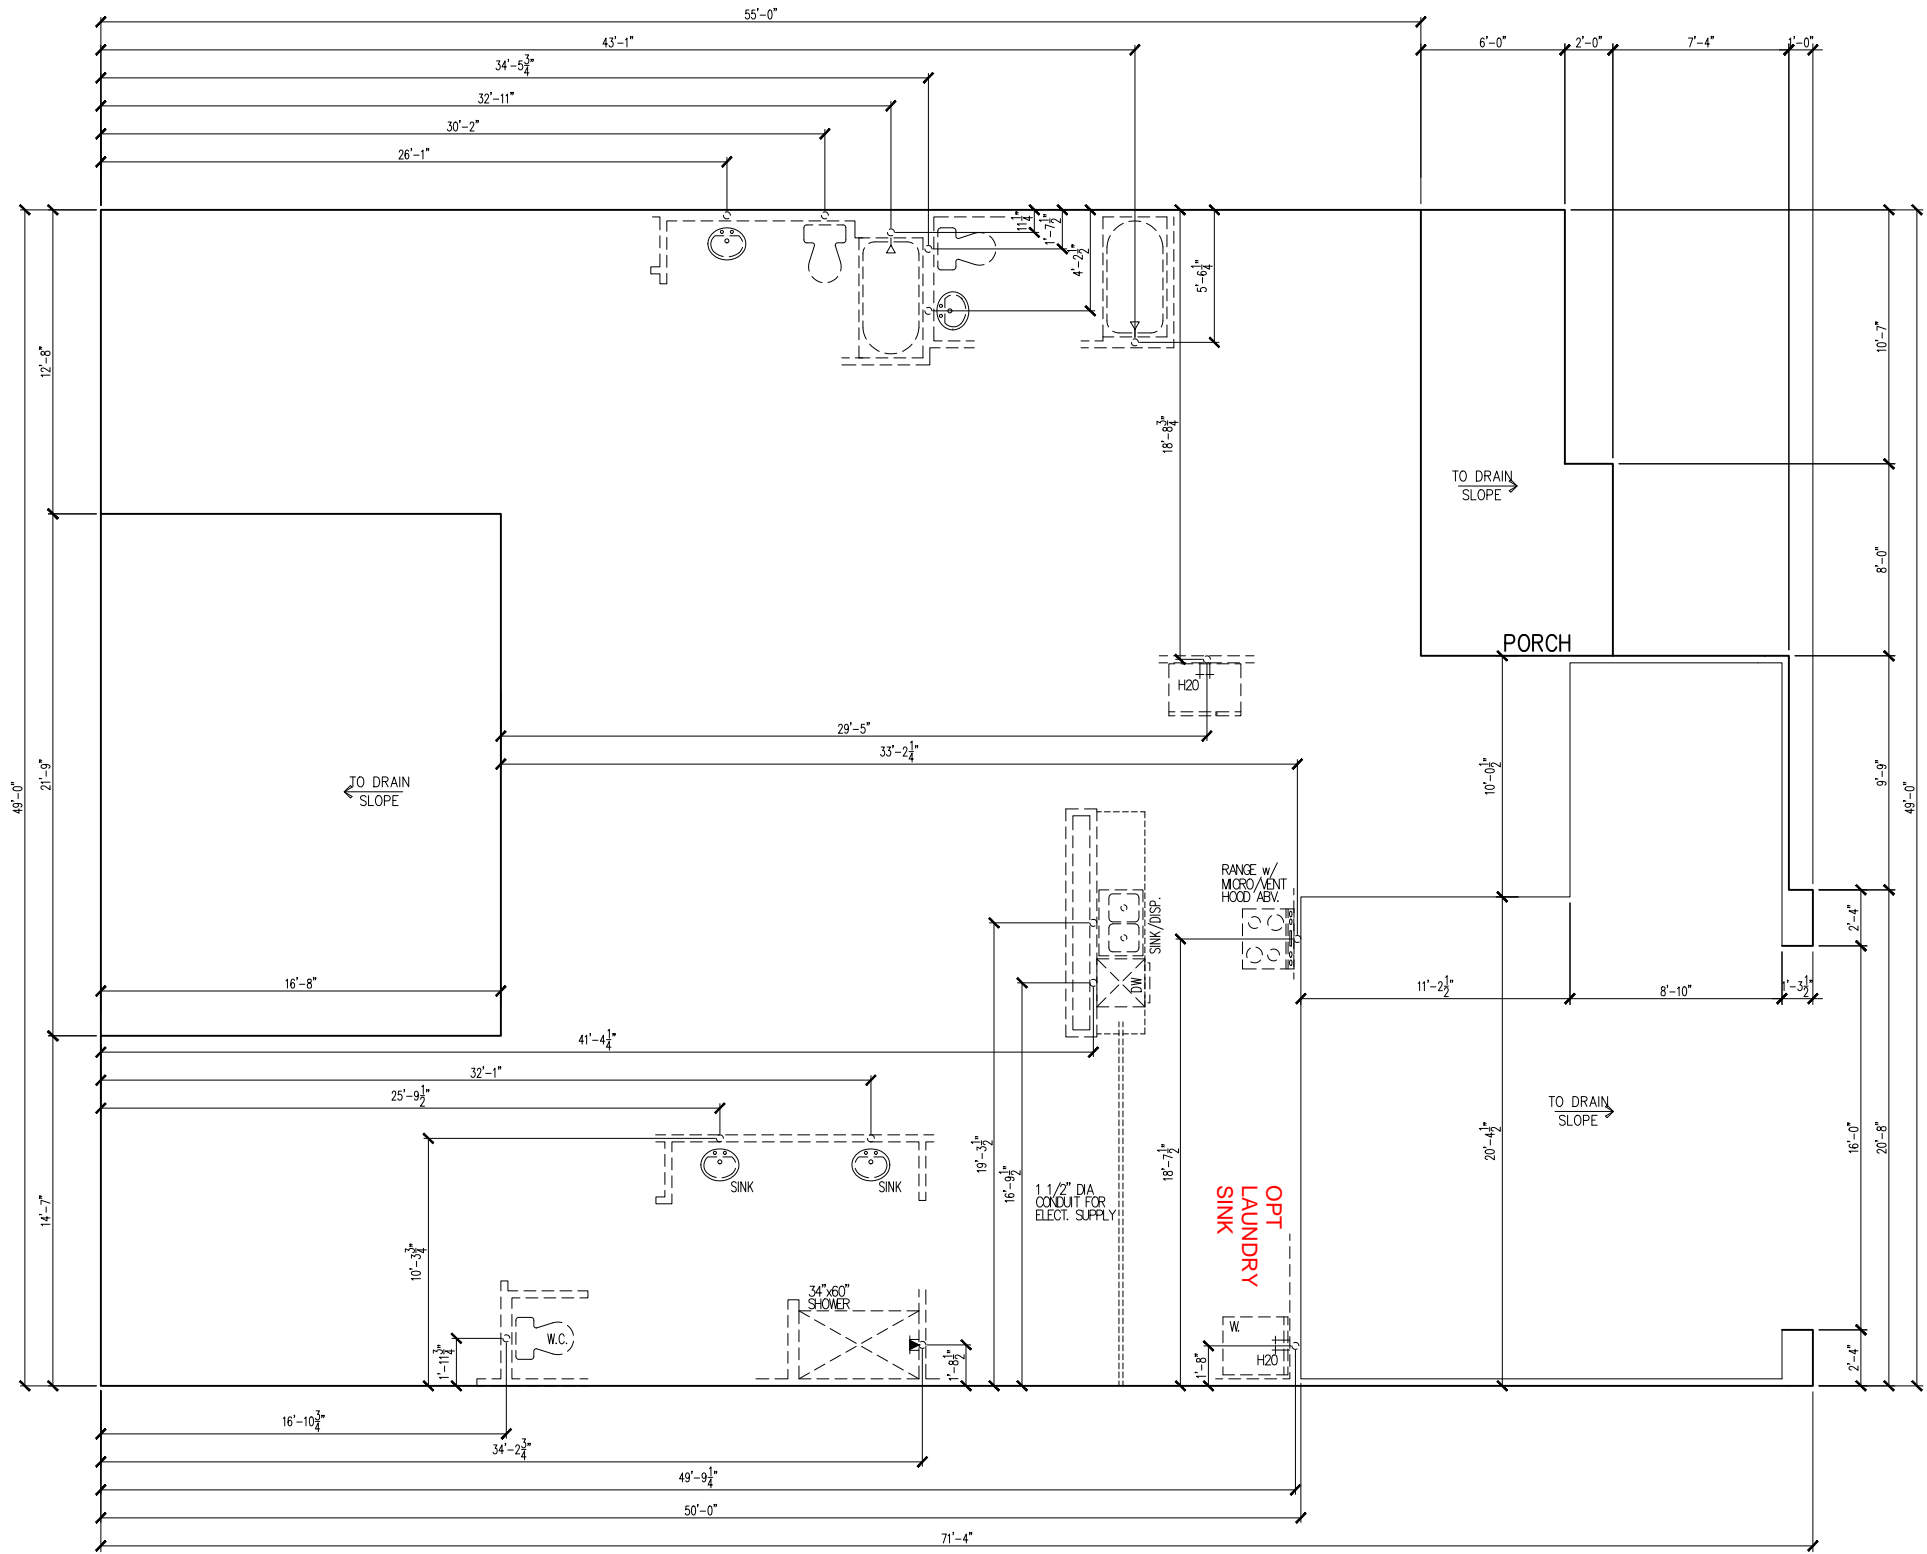

BASE FOUNDATION PLAN

SUBDIVISION: ALTIS @ SERENITY
ADDRESS: 45 FIREFLY LANE
LOT: 333

Issue Date: 10-01-24
Drawn By: ACC

PLAN #:
5921-08


PLAN NAME:
FOXTAIL MANOR

SHEET #:
S1.10A


Business Operations
5440 Wade Park Blvd
Suite 400
Raleigh, NC 27607

© 2022

tri pointe
H O M E S
5440 WADE PARK BLVD, SUITE 400, RALEIGH, NC 27607

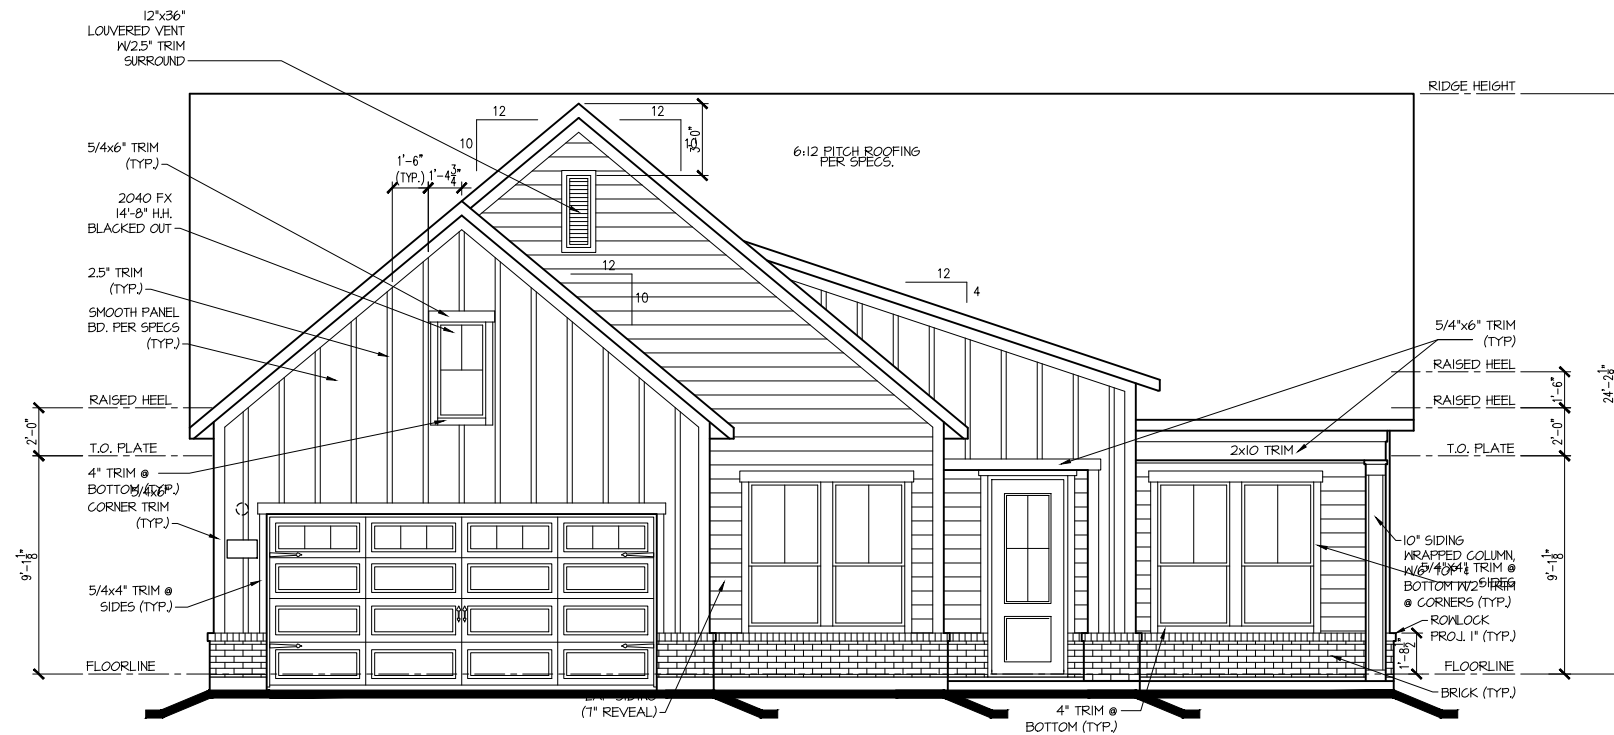

FRONT ELEV. "A"
1/8"=1'-0"

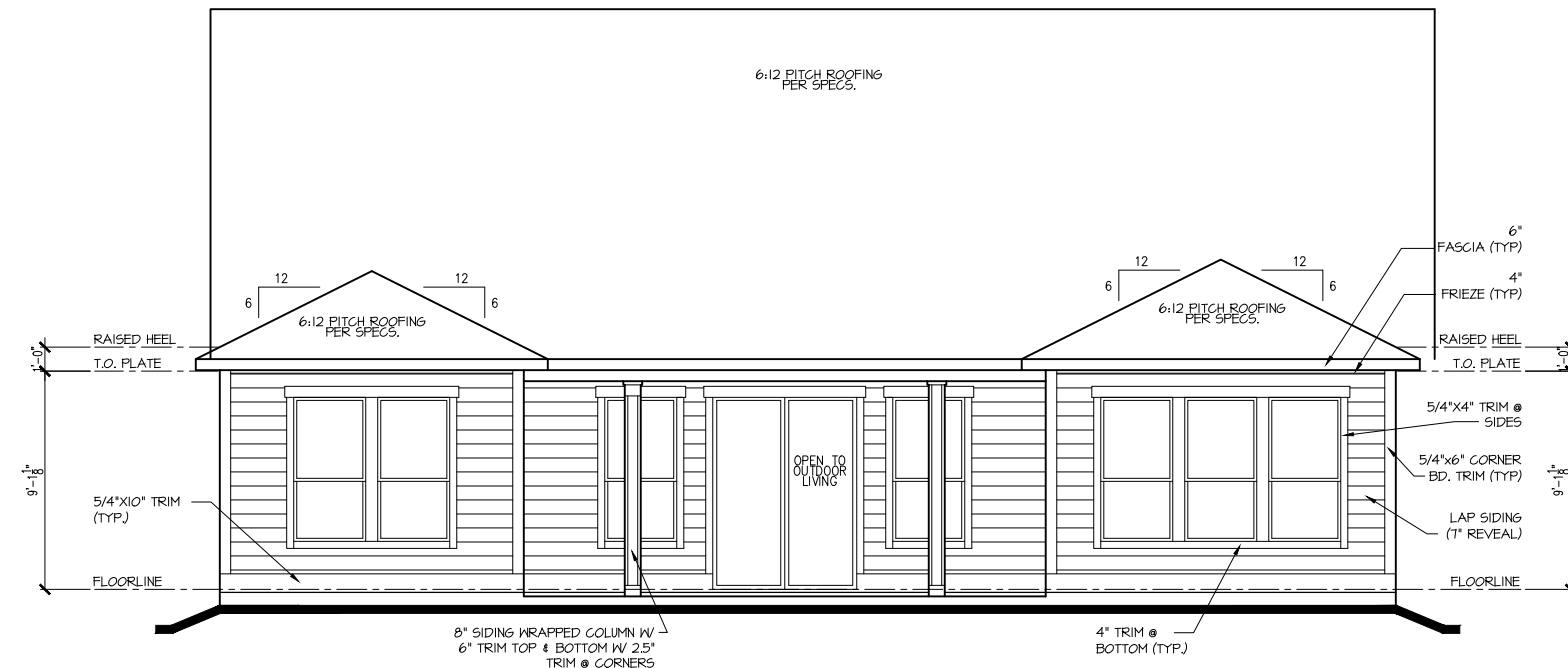

REAR ELEV. "A"
1/8"=1'-0"

tri pointe
H O M E S

5440 WADE PARK BLVD, SUITE 400, RALEIGH, NC 27607

Business Operations
5440 Wade Park Blvd
Suite 400
Raleigh, NC 27607

© 2022

EXTERIOR ELEVATIONS


SUBDIVISION: ALTIS @ SERENITY
ADDRESS: 45 FIREFLY LANE
LOT: 333

Issue Date: 10-01-24
Drawn By: ACC


PLAN #:
5921-08

PLAN NAME:
FOXTAIL MANOR

SHEET #:
A2.01A

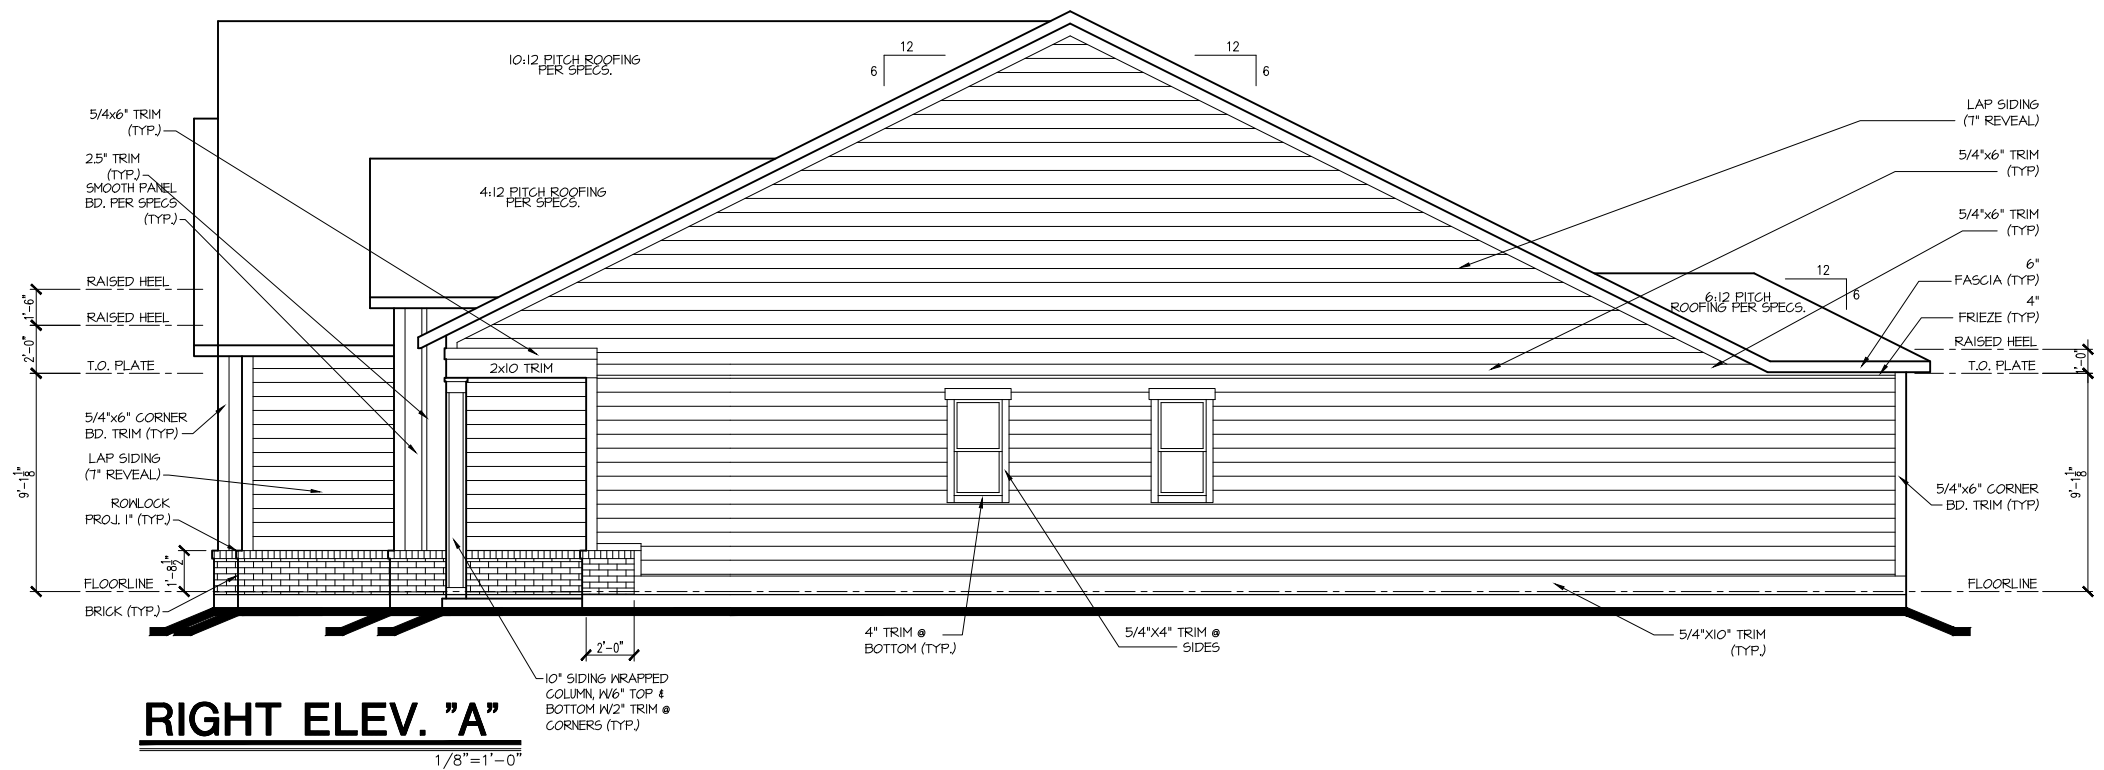

RIGHT ELEV. "A"
1/8"=1'-0"

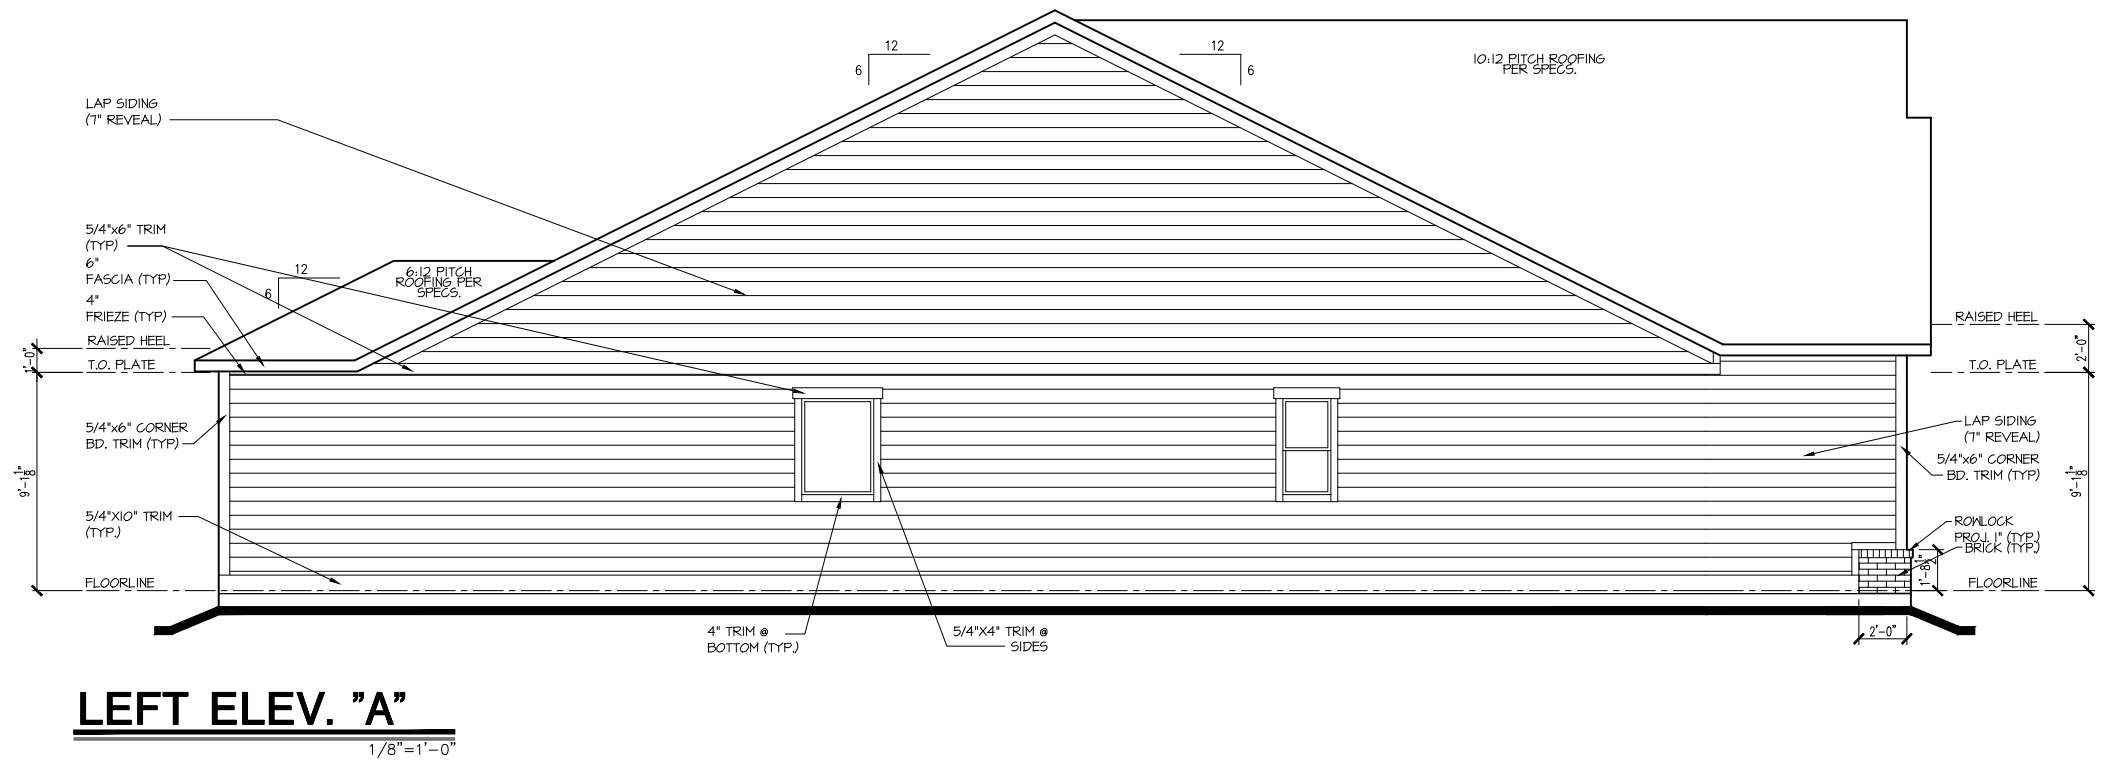

LEFT ELEV. "A"
1/8"=1'-0"

tri pointe
HOMES

5440 WADE PARK BLVD, SUITE 400, RALEIGH, NC 27607

Business Operations
5440 Wade Park Blvd
Suite 400
Raleigh, NC 27607

© 2022

EXTERIOR ELEVATIONS

SUBDIVISION: ALTIS @ SERENITY
ADDRESS: 45 FIREFLY LANE
LOT: 333

Issue Date: 10-01-24
Drawn By: ACC


PLAN #:
5921-08

PLAN NAME:
FOXTAIL MANOR

SHEET #:
A2.02A

Attic Venting Calculations Elev. "A"	
ROOF INFORMATION	BASE
TOTAL SF ROOF AREA	3384
AVAILABLE L.F. ROOF SOFFIT	100
AVAILABLE L.F. ROOF RIDGE	93
VENT TYPES	QTY VENTS REQ'D
LOWER VENTS CONTINUOUS SOFFIT VENTING @ 5 S/LF	162 LF
UPPER VENTS SLANT 150 VENTS @ 150 S/LVENT	5
UPPER VENTS RIDGE VENTS @ 72 S/LVENT	11

NOTE:
QTY OF UPPER VENTS SHOWN COVERS 100% OF UPPER VENTING. NO MIXING
OF VENT TYPES FOR UPPER VENTING IS FIGURED FOR IN THIS TABLE.

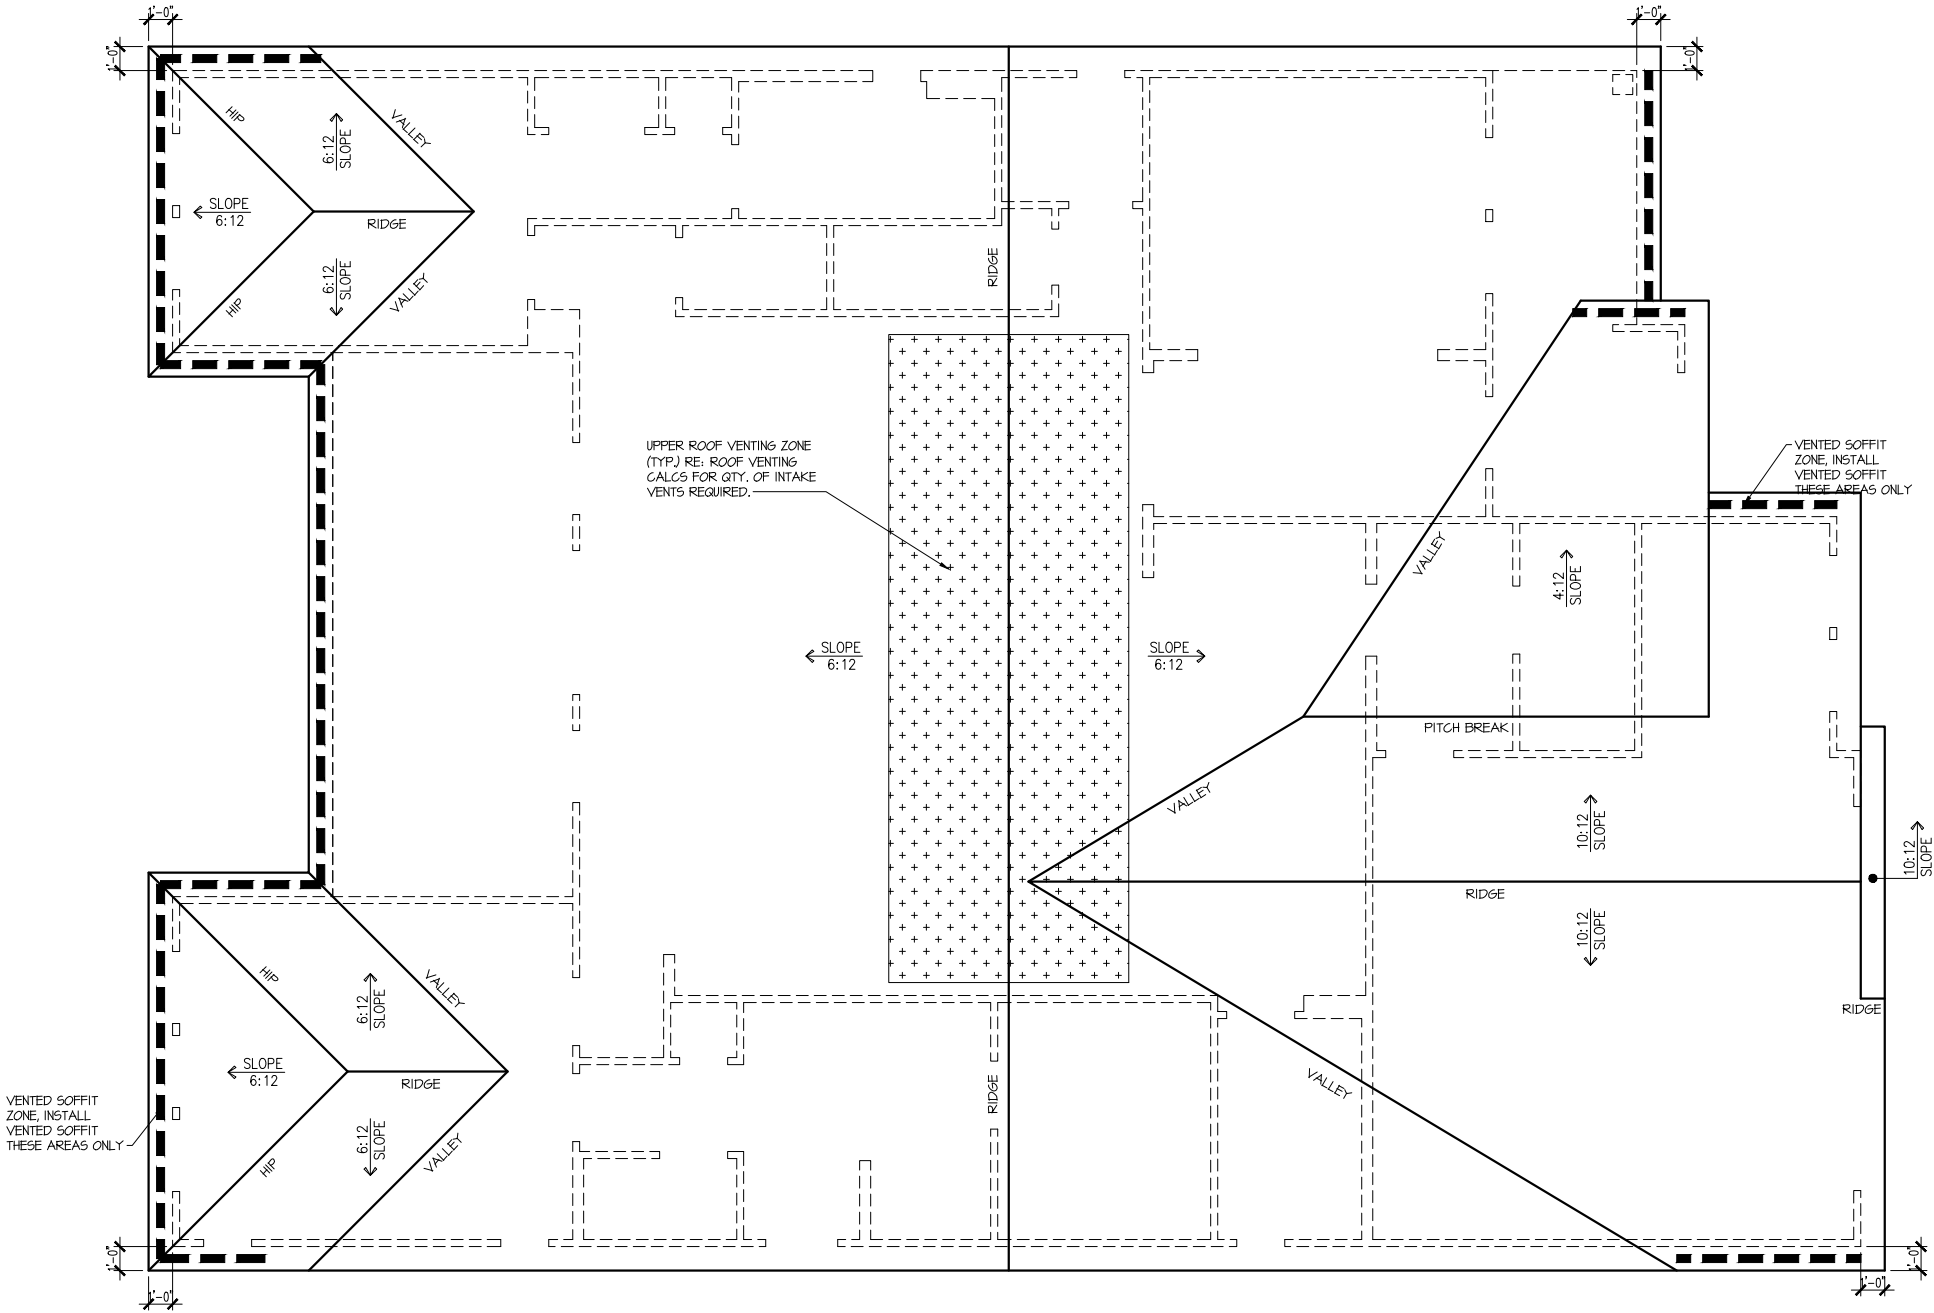

ROOF PLAN 'A'
SCALE: 1/8" = 1'-0"

ROOF PLAN

SUBDIVISION: ALTIS @ SERENITY
ADDRESS: 45 FIREFLY LANE
LOT: 333

Issue Date: 10-01-24
Drawn By: ACC

PLAN #:
5921-08

PLAN NAME:
FOXTAIL MANOR


SHEET #:
A3.01A

Business Operations
5440 Wade Park Blvd
Suite 400
Raleigh, NC 27607


© 2022

tri pointe
H O M E S


5440 WADE PARK BLVD, SUITE 400, RALEIGH, NC 27607

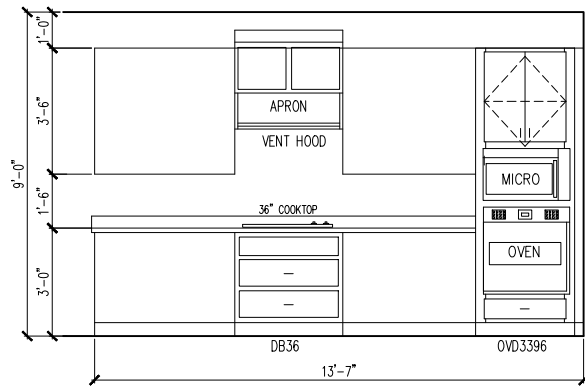


1 KITCHEN

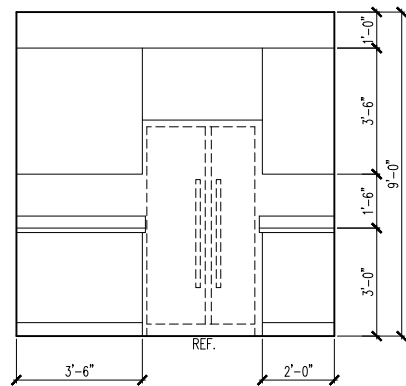


2 KITCHEN

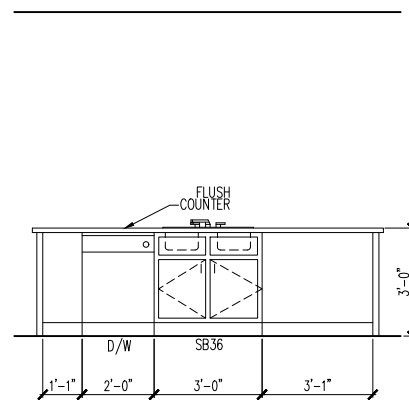

3 KITCHEN ISLAND

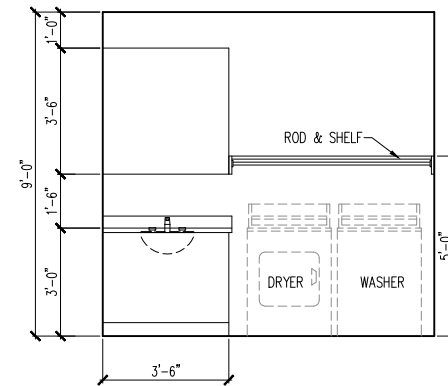


4 LAUNDRY ROOM

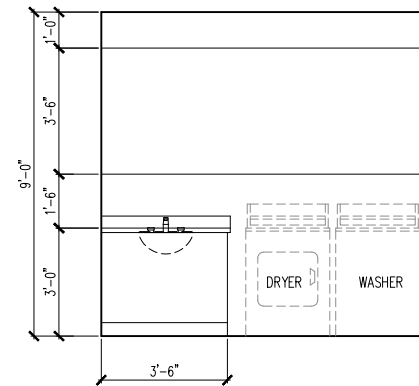


4 LAUNDRY ROOM
WALL CABINET OPT.


FRONT VIEW

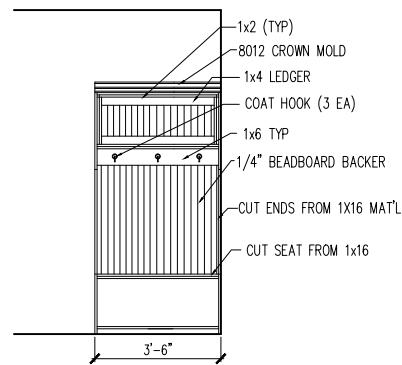


SIDE VIEW

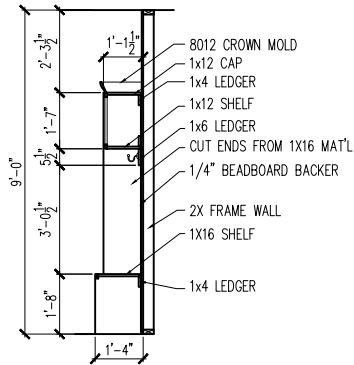


5 TYPICAL BENCH DETAIL (DROP ZONE)

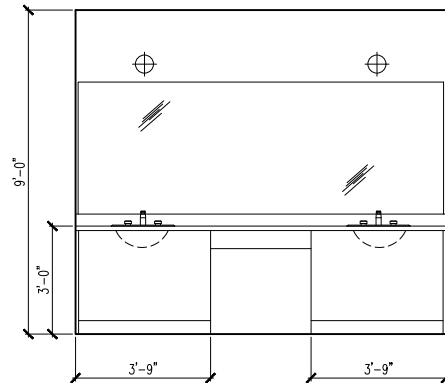


6 PRIMARY BATH

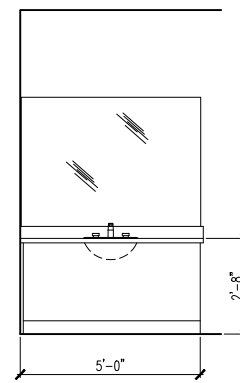

7 BATH 2

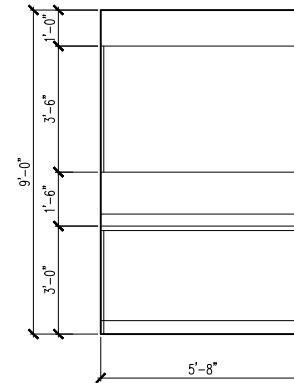

8 GARAGE ENTRY

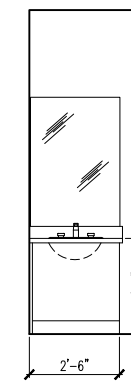

9 BATH 3

INTERIOR DETAIL SHEET

SUBDIVISION: ALTIS @ SERENITY

ADDRESS: 45 FIREFLY LANE

LOT: 333

Issue Date: 10-01-24
Drawn By: ACC

PLAN #:
5921-08

PLAN NAME:
FOXTAIL MANOR

SHEET #:
A4.01

Business Operations
5440 Wade Park Blvd
Suite 400
Raleigh, NC 27607

© 2022

tri pointe
HOMES
5440 WADE PARK BLVD, SUITE 400, RALEIGH, NC 27607

ELECTRICAL FIXTURE SCHEDULE	
DESCRIPTION	SYMBOL
110V OUTLET	⌀
220V OUTLET	⌀ 220
1/2 HOT OUTLET	⌀
GFI OUTLET	⌀ GFI
WP GFI OUTLET	⌀ WP/GFI
GARAGE DOOR OPENER OUTLET	⌀ GDO
SECURITY SYSTEM	⌀ SEC SYS
DISHWASHER	⬤ DW
JUNCTION BOX	⌀
CEILING MOUNTED LIGHT	⌀
CEILING FAN w/ LIGHT KIT	⌀ PROVIDE BRACING
RECESSED CEILING LIGHT	⌀
RECESSED WATER PROOF LIGHT	⌀ WP
WALL MOUNTED LIGHT	⌀
WALL MOUNTED PUSH BUTTON	⌀ PB
TWO WAY SWITCH	⌀
THREE WAY SWITCH	⌀
FOUR WAY SWITCH	⌀
DIMMER SWITCH	⌀ DIM
EXHAUST VENTS	⌀ VENT TO EXT
LOW VOLTAGE PANEL	⌀
PHONE OUTLET	⌀ PH
TV OUTLET	⌀ TV
DATA & RG6 COMBO BOX	⌀
SMOKE DETECTOR	⌀
CARBON MONOXIDE SMOKE DETECTOR COMBO	⌀ CM/SD
DOOR CHIMES	CHIMES
ELECTRICAL PANEL	⌀ EP
SURFACE MOUNT LED	⌀
EXTERIOR WALL MOUNT UPLIGHT	⌀
SOFFIT MOUNT FLOOD LIGHT	⌀
UNDER COUNTER LIGHTING	⌀ UCL
SMURF TUBE


ELECTRICAL NOTES:

1. PROVIDE AND INSTALL LOCALLY CERTIFIED SMOKE AND CARBON MONOXIDE DETECTORS AS REQUIRED BY NATIONAL FIRE PROTECTION ASSOCIATION (NFPA) AND MEETING THE REQUIREMENTS OF ALL GOVERNING CODES
2. PROVIDE AND INSTALL GROUND FAULT CIRCUIT-INTERRUPTERS (GFI) AS REQUIRED BY NATIONAL ELECTRIC CODE (NEC) AND MEETING THE REQUIREMENTS OF ALL GOVERNING CODES.
3. ELECTRICAL CONTRACTOR TO PROVIDE REQUIRED DIRECT HOOK-UPS/CUTOFFS.
4. HVAC CONTRACTOR TO VERIFY THERMOSTAT LOCATIONS.
5. ALL ELECTRICAL AND MECHANICAL EQUIPMENT (I.E. FURNACES, A/C UNITS, ELECTRICAL PANELS, SANITARY SUMP PITS, DRAIN TILE SUMP, AND WATER HEATERS) ARE SUBJECT TO RELOCATION DUE TO FIELD CONDITIONS.

ELECTRICAL DEVICES: ABOVE FINISHED FLOOR:
SWITCHES OVER COUNTER. 48". TO CL
WALL OUTLETS OVER COUNTER.
+42" TO BOTTOM OF HORIZONTAL OUTLET(TYP. @ COUNTER)
REMAINING SWITCHES. 48". TO CL
WALL OUTLETS. 12". TO CL
BATH VANITY BRACKET OUTLET. 1.2
(1" ABOVE TOP OF VANITY)
WATER SOFTENER AND SUMP OUTLETS. . . . 48" TO CL
EXTERIOR GFI OUTLETS. 12". TO CL
GARAGE GFI (ABOVE GARAGE FLOOR). . . . 48" TO CL
FRONT DOOR COACH LIGHT.80". TO CL
GARAGE DOOR COACH LIGHT. 84". TO CL
(ABOVE GARAGE FLOOR).
THERMOSTAT. 54". TO CL
DOORBELL CHIMES. 84". TO CL

LEVEL W/ DR HANDLE
DOORBELL BUTTON.
KITCHEN HOOD FAN "WHIP". 66". TO CL
KITCHEN WALL HUNG MICROWAVE OUTLET . . . 72". TO CL
KITCHEN DISHWASHER RECEPTACLE. . . . UNDER SINK
KITCHEN RANGE. 24". TO CL
KITCHEN REFRIGERATOR. 48". TO CL
WASHER/DRYER OUTLET. 48". TO CL

CL = CENTER LINE
1 = FIELD VERIFY
2 = MASTER BATH STANDARD 30" HIGH
VANITY TO BE RAISED 4"

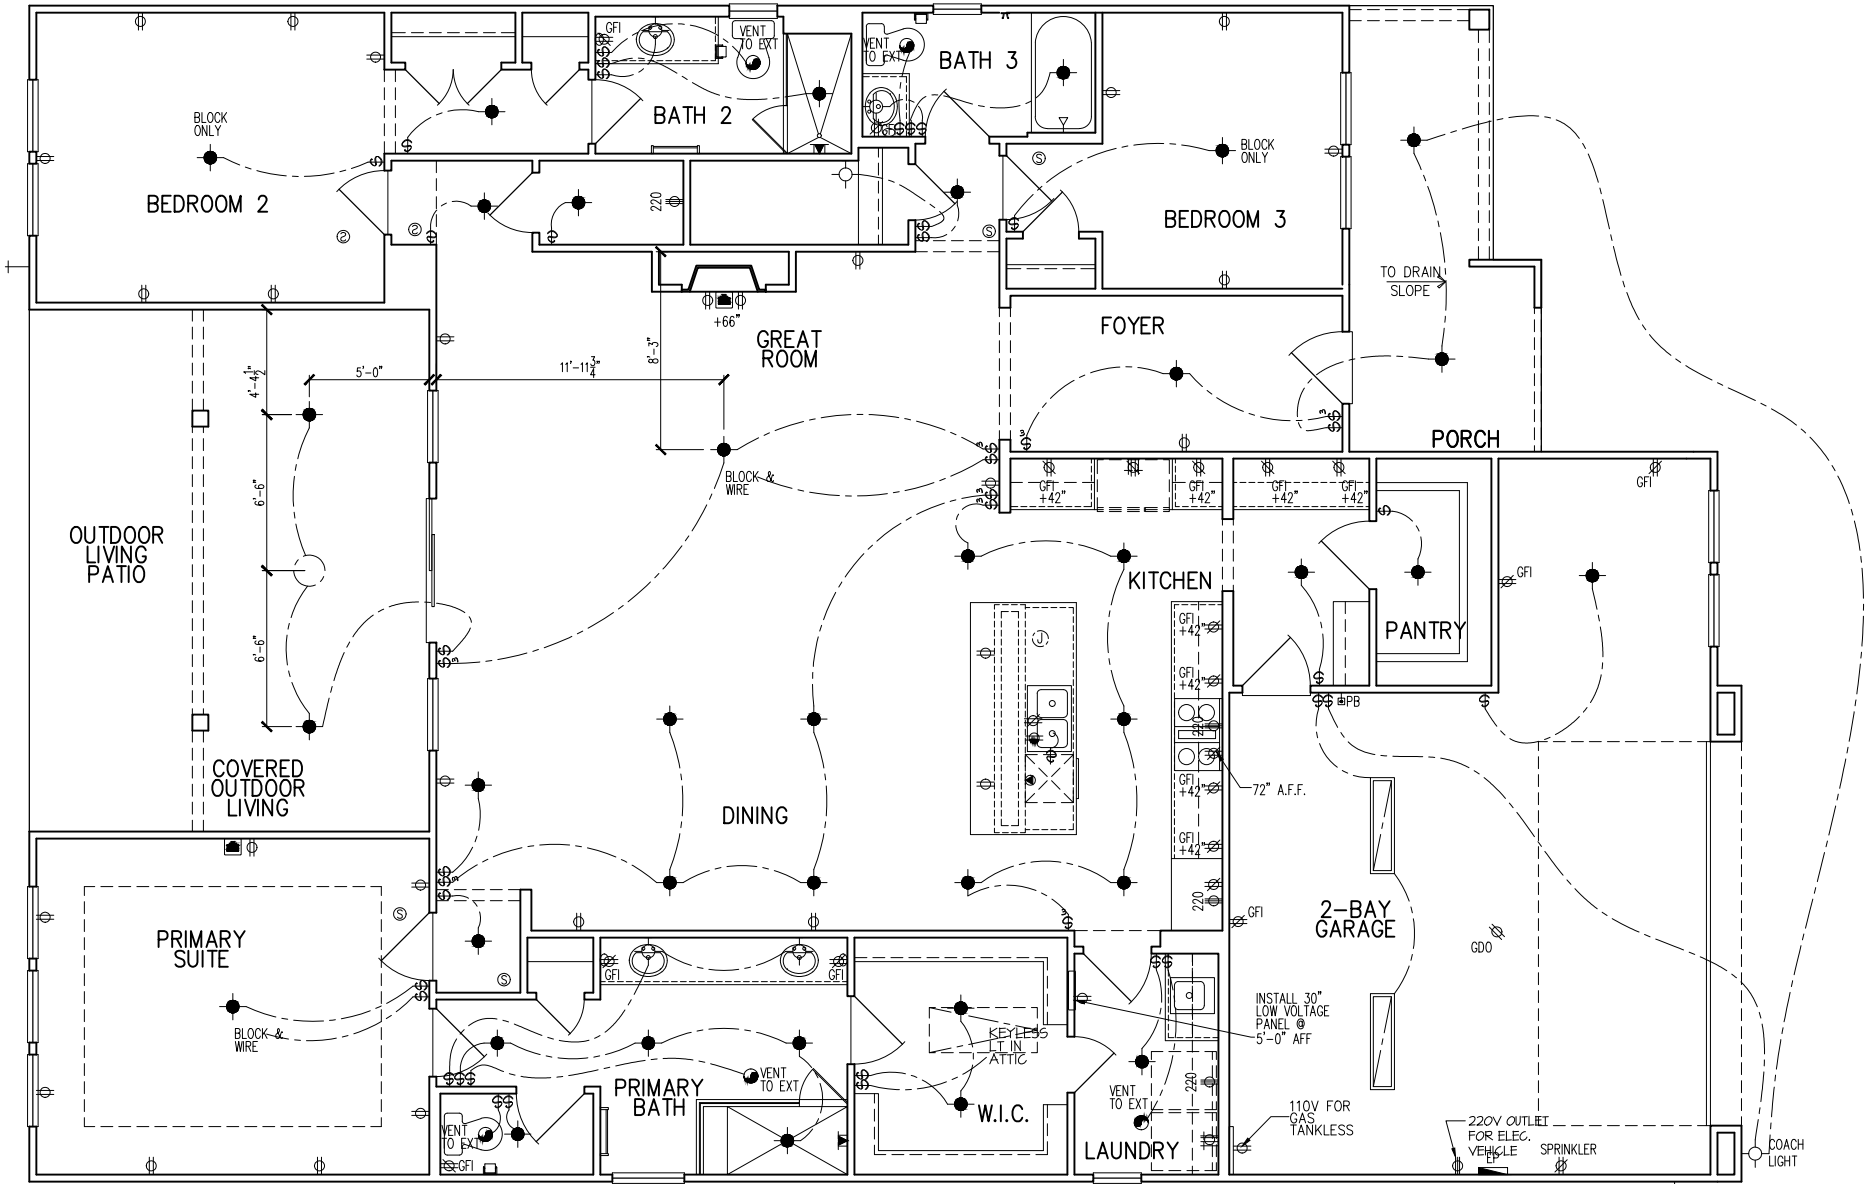

INCLUDE USB/USBC OUTLET
AT KITCHEN ISLAND

tri pointe
HOMES

5440 WADE PARK BLVD, SUITE 400, RALEIGH, NC 27607

Business Operations
5440 Wade Park Blvd
Suite 400
Raleigh, NC 27607

© 2022

1st FLOOR ELECTRICAL PLAN

SUBDIVISION: ALTIS @ SERENITY
ADDRESS: 45 FIREFLY LANE
LOT: 333

Issue Date: 10-01-24
Drawn By: ACC

PLAN #:
5921-08

PLAN NAME:
FOXTAIL MANOR

SHEET #:
E1.10A


ELECTRICAL FIXTURE SCHEDULE	
DESCRIPTION	SYMBOL
110V OUTLET	⌀
220V OUTLET	⌀ 220
1/2 HOT OUTLET	⌀
GFI OUTLET	⌀ GFI
WP GFI OUTLET	⌀ WP/GFI
GARAGE DOOR OPENER OUTLET	⌀ GDO
SECURITY SYSTEM	⌀ SEC SYS
DISHWASHER	⌀ DW
JUNCTION BOX	⌀
CEILING MOUNTED LIGHT	⌀
CEILING FAN w/ LIGHT KIT	⌀ PROVIDE BRACING
RECESSED CEILING LIGHT	⌀
RECESSED WATER PROOF LIGHT	⌀ WP
WALL MOUNTED LIGHT	⌀
WALL MOUNTED PUSH BUTTON	⌀ PB
TWO WAY SWITCH	⌀
THREE WAY SWITCH	⌀
FOUR WAY SWITCH	⌀
DIMMER SWITCH	⌀ DIM
EXHAUST VENTS	⌀ VENT TO EXT
LOW VOLTAGE PANEL	⌀
PHONE OUTLET	⌀ PH
TV OUTLET	⌀ TV
DATA & RG6 COMBO BOX	⌀
SMOKE DETECTOR	⌀
CARBON MONOXIDE SMOKE DETECTOR COMBO	⌀ CM/SD
DOOR CHIMES	CHIMES
ELECTRICAL PANEL	⌀ EP
SURFACE MOUNT LED	⌀
EXTERIOR WALL MOUNT UP LIGHT	⌀
SOFFIT MOUNT FLOOD LIGHT	⌀
UNDER COUNTER LIGHTING	⌀ UCL
SMURF TUBE	⌀

ELECTRICAL NOTES:

1. PROVIDE AND INSTALL LOCALLY CERTIFIED SMOKE AND CARBON MONOXIDE DETECTORS AS REQUIRED BY NATIONAL FIRE PROTECTION ASSOCIATION (NFPA) AND MEETING THE REQUIREMENTS OF ALL GOVERNING CODES
2. PROVIDE AND INSTALL GROUND FAULT CIRCUIT-INTERRUPTERS (GFI) AS REQUIRED BY NATIONAL ELECTRIC CODE (NEC) AND MEETING THE REQUIREMENTS OF ALL GOVERNING CODES.
3. ELECTRICAL CONTRACTOR TO PROVIDE REQUIRED DIRECT HOOK-UPS/CUTOFFS.
4. HVAC CONTRACTOR TO VERIFY THERMOSTAT LOCATIONS.
5. ALL ELECTRICAL AND MECHANICAL EQUIPMENT (I.E. FURNACES, A/C UNITS, ELECTRICAL PANELS, SANITARY SUMP PITS, DRAIN TILE SUMP, AND WATER HEATERS) ARE SUBJECT TO RELOCATION DUE TO FIELD CONDITIONS.

ELECTRICAL DEVICES: ABOVE FINISHED FLOOR:
SWITCHES OVER COUNTER 48" TO CL
WALL OUTLETS OVER COUNTER 42" TO BOTTOM OF HORIZONTAL OUTLET(TYP. @ COUNTER)
REMAINING SWITCHES 48" TO CL
WALL OUTLETS 12" TO CL
BATH VANITY BRACKET OUTLET 1,2 (1" ABOVE TOP OF VANITY)
WATER SOFTENER AND SUMP OUTLETS 48" TO CL
EXTERIOR GFI OUTLETS 12" TO CL
GARAGE GFI (ABOVE GARAGE FLOOR) 48" TO CL
FRONT DOOR COACH LIGHT 80" TO CL
GARAGE DOOR COACH LIGHT, (ABOVE GARAGE FLOOR) 84" TO CL
THERMOSTAT 54" TO CL
DOORBELL CHIMES 84" TO CL
DOORBELL BUTTON LEVEL W/ DR. HANDLE
KITCHEN HOOD FAN "WHIP" 66" TO CL
KITCHEN WALL HUNG MICROWAVE OUTLET 72" TO CL
KITCHEN DISHWASHER RECEPTACLE UNDER SINK
KITCHEN RANGE 24" TO CL
KITCHEN REFRIGERATOR 48" TO CL
WASHER/DRYER OUTLET 48" TO CL

CL = CENTER LINE
1 = FIELD VERIFY
2 = MASTER BATH STANDARD 30" HIGH VANITY TO BE RAISED 4"

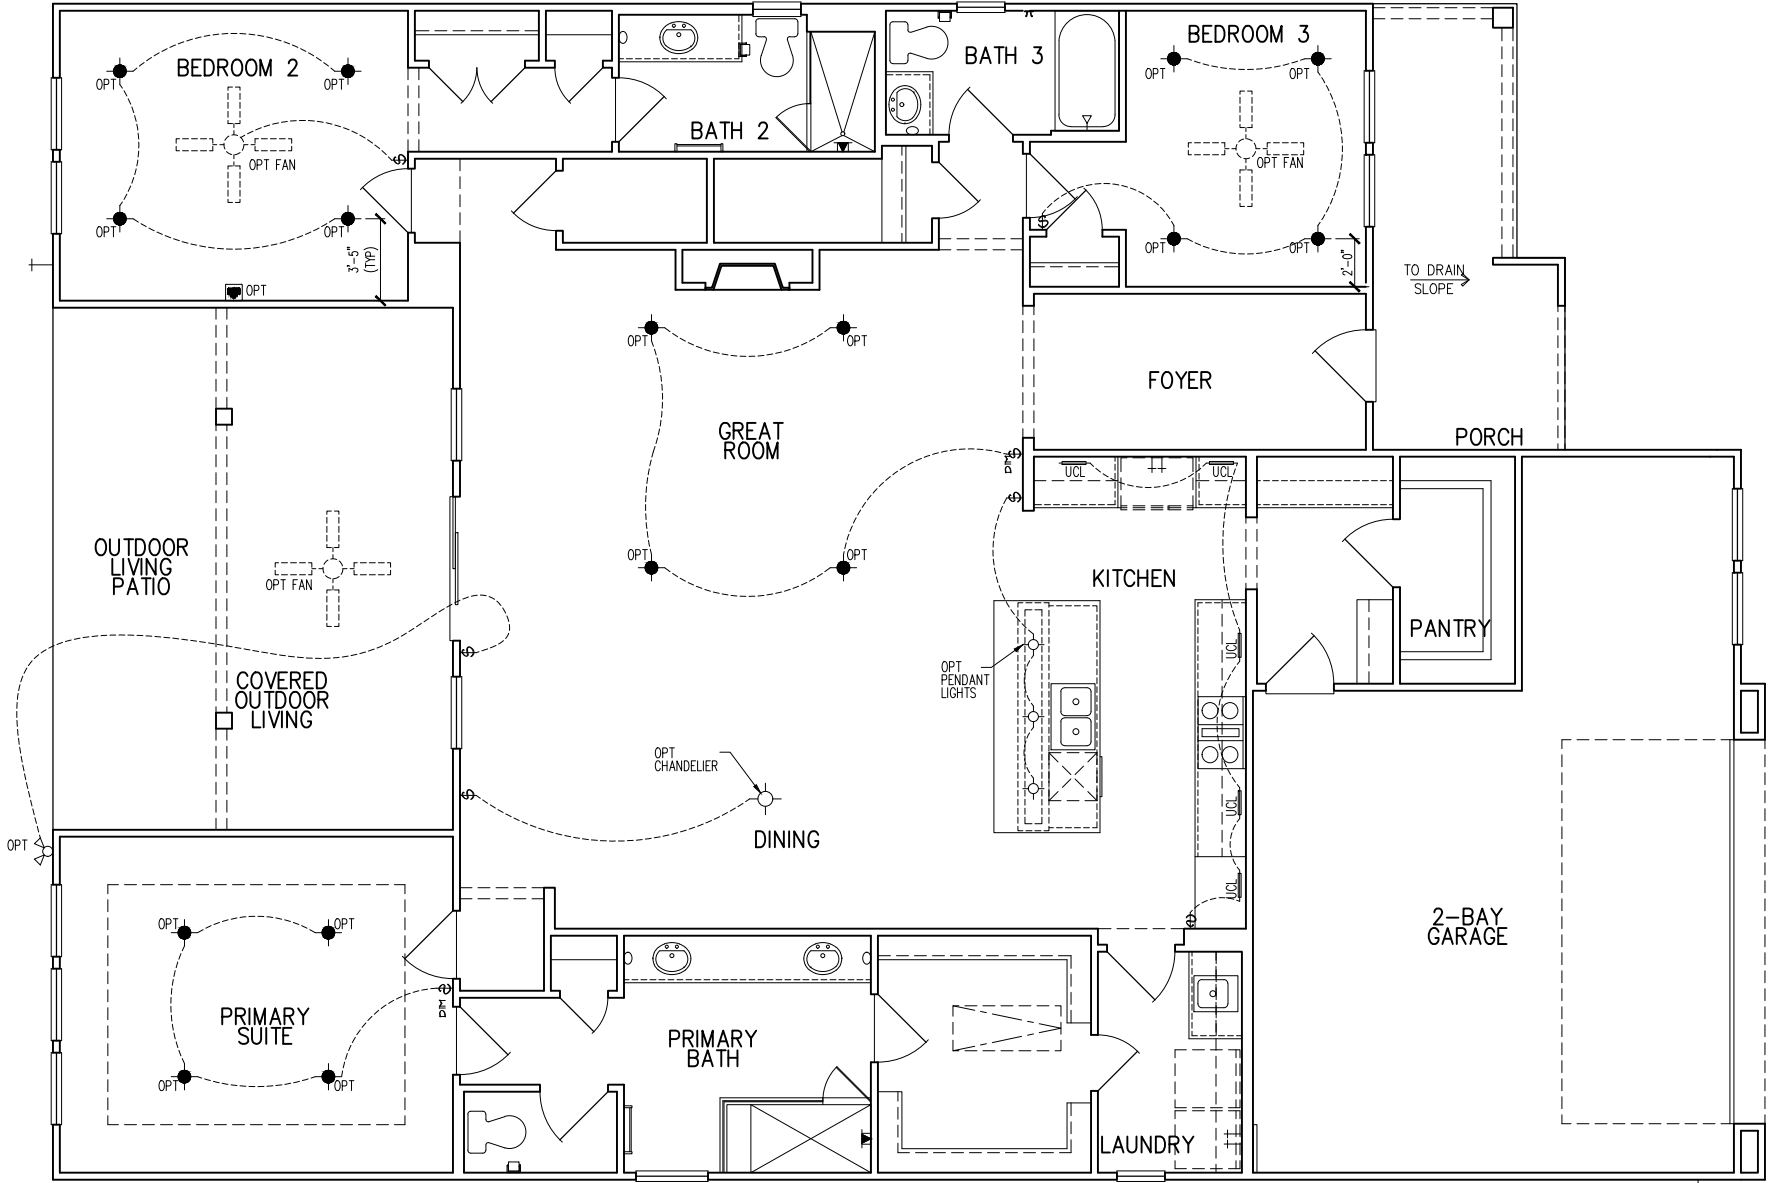

tri pointe
H O M E S
5440 WADE PARK BLVD, SUITE 400, RALEIGH, NC 27607

Business Operations
5440 Wade Park Blvd
Suite 400
Raleigh, NC 27607
© 2022

1st FLOOR ELEC. PLAN - OPITONS
SUBDIVISION: ALTIS @ SERENITY
ADDRESS: 45 FIREFLY LANE
LOT: 333

Issue Date: 10-01-24
Drawn By: ACC

PLAN #:
5921-08

PLAN NAME:
FOXTAIL MANOR

SHEET #:
E1.11A

GENERAL STRUCTURAL NOTES
FLOOR FRAMING
<ul style="list-style-type: none">• I-JOISTS/TRUSSES SHALL BE DESIGNED BY MANUF. TO MEET OR EXCEED L/480 LIVE LOAD DEFLECTION CRITERIA. (EXCLUDES STONE/MARBLE OR NET BED CONSTRUCTED FLOORS - CONTACT MKK FOR EXCLUDED FLOOR DESIGNS)• PER THE GUIDELINES OF THE TILE COUNCIL OF NORTH AMERICA (TCNA HANDBOOK), IT SHALL BE THE FLOOR FINISH INSTALLER'S RESPONSIBILITY TO VERIFY THAT THE FINISHES TO BE INSTALLED MATCH THE DESIGN CRITERIA NOTED ABOVE (UNDER "DESIGN LOADS").• FLOOR SYSTEMS & SHEATHING HAVE BEEN DESIGNED TO SUPPORT ADDITIONAL DEAD LOAD FROM CERAMIC TILE (EXCLUDING MARBLE OR STONE). HOWEVER, IT SHALL BE THE FLOOR FINISH INSTALLER'S RESPONSIBILITY TO PROVIDE PROPER UNDERLAYMENT, UNCOUPLING MEMBRANE AND MORTAR/GROUT PER THE ASSEMBLY DESIGNATIONS IN THE TCNA HANDBOOK (TILE COUNCIL OF NORTH AMERICA).• AT I-JOIST FLOORS, PROVIDE 1 1/8" MIN. OSB RIM BOARD.• METAL HANGERS SHALL BE SPECIFIED BY MANUFACTURER, U.N.O.• I-JOIST/TRUSS SHOP DWGS. SHALL BE SUBMITTED TO ARCH. & ENG. FOR REVIEW AND APPROVAL PRIOR TO FABRICATION OR DELIVERY.• FLOOR SHEATHING SHALL BE 23/32" A.P.A. RATED "STURD-I-FLOOR" 24" O.C. EXPOSURE 1 (OR APPROVED EQUAL) WITH TONGUE AND GROOVE EDGES. FASTEN TO FRAMING MEMBERS W/ GLUE AND<ul style="list-style-type: none">- 2 1/2" x 0.131" NAILS @ 6" o.c. @ PANEL EDGES @ 12" o.c. FIELD.- 2 3/8" x 0.120" NAILS @ 4" O.C. @ PANEL EDGES @ 8" O.C. FIELD.- 2 3/8" x 0.113" NAILS @ 3" O.C. @ PANEL EDGES @ 6" O.C. IN FIELD.
ROOF FRAMING
<ul style="list-style-type: none">• ROOF SHEATHING SHALL BE 7/16" A.P.A. RATED SHEATHING 24/16 EXPOSURE 1 (OR APPROVED EQUAL). FASTEN TO FRAMING MEMBERS<ul style="list-style-type: none">- W/ 2 1/2" x 0.131" NAILS @ 6" o.c. @ PANEL EDGES @ 12" O.C. FIELD.- W/ 2 3/8" x 0.120" NAILS @ 4" o.c. @ PANEL EDGES @ 8" O.C. FIELD.- W/ 2 3/8" x 0.113" NAILS @ 3" o.c. @ PANEL EDGES @ 6" O.C. FIELD.• WITHIN 48" OF ALL ROOF EDGES, RIDGES, & HIPS FASTEN ROOF SHEATHING FIELDS PER EDGE NAILING SPEC.• FASTEN EACH ROOF TRUSS TO TOP PLATE W/ SIMPSON H2.5T CLIP (OR APPROVED EQUAL) @ ALL BEARING POINTS. PROVIDE (2) H2.5T CLIPS AT 2-PLY GIRDER TRUSSES, (3) H2.5T CLIPS AT 3-PLY GIRDER TRUSSES & ROOF BEAMS - AT ALL BEARING POINTS.• METAL HANGERS SHALL BE SPECIFIED BY THE MANUFACTURER, U.N.O.• ROOF TRUSS SHOP DWGS. SHALL BE SUBMITTED TO ARCH & ENG. FOR REVIEW AND APPROVAL PRIOR TO FABRICATION OR DELIVERY.• ERECT AND INSTALL ROOF TRUSSES PER ITCA & TP1'S BC51 I "GUIDE TO GOOD PRACTICE FOR HANDLING, INSTALLING & BRACING OF METAL PLATE CONNECTED WOOD TRUSSES."• SUPPORT SHORT SPAN ROOF TRUSSES W/2x4 LEDGER FASTENED TO FRAMING W/ (2) 3" x 0.120" NAILS @ 16" O.C. (UP TO 1" SPAN).

MMK STD. - MAR 2016

CONNECTION SPECIFICATIONS (TYP. U.N.O.)

DESCRIPTION OF BLDG. ELEMENT	3"x0.131" NAILS	3"x0.120" NAILS
JOIST TO SOLE PLATE	(3) TOENAILS	(3) TOENAILS*
SOLE PL. TO JOIST/RIM OR BLK'G STUD TO PLATE	NAILS @ 4" o.c.	NAILS @ 4" o.c.
RIM TO TOP PLATE	(4) TOENAILS/ (3) END NAILS	(4) TOENAILS/ (4) END NAILS*
BLK'G, BTWN. JOISTS TO TOP PL.	TOENAILS @ 6" o.c.	TOENAILS @ 4" o.c.*
DOUBLE STUD	(3) TOENAILS EA. END	(3) TOENAILS EA. END*
DOUBLE TOP PLATE	NAILS @ 16" o.c.	NAILS @ 16" o.c.
DOUBLE TOP PLATE LAP SPLICE	NAILS @ 12" o.c.	NAILS @ 8" o.c.
TOP PLATE LAP @ CORNERS & INTERSECTING WALLS	(12) NAILS IN LAPPED AREA (24" MIN.)	(15) NAILS IN LAPPED AREA (24" MIN.)
RAFTER/TRUSS TO TOP PLATE	(3) NAILS	(3) NAILS
GAB. END TRUSS TO DBL. TOP PL.	(4) TOENAILS + (1) SIMPSON H2.5T TOENAILS @ 8" o.c.	(4) TOENAILS + (1) SIMPSON H2.5T TOENAILS @ 6" o.c.
R.T. w/ HEEL HT. 9 1/4" TO 12"	2x10 BLK EVERY 3RD BAY FASTENED TO DBL. TOP PLATE W/ TOENAILS @ 6" O.C.	2x10 BLK EVERY 3RD BAY FASTENED TO DBL. TOP PLATE W/ TOENAILS @ 4" O.C.
R.T. w/ HEEL HT. 12" TO 16"	2x12 BLK EVERY 3RD BAY FASTENED TO DBL. TOP PLATE W/ TOENAILS @ 6" O.C.	2x12 BLK EVERY 3RD BAY FASTENED TO DBL. TOP PLATE W/ TOENAILS @ 4" O.C.
R.T. w/ HEEL HT. UP TO 24"	LAP WALL SHTG. w/ DBL. TOP PL. & INSTALL ON TRUSS VERT. - FASTEN W/ NAILS @ 6" O.C.	LAP WALL SHTG. w/ DBL. TOP PL. & INSTALL ON TRUSS VERT. - FASTEN W/ NAILS @ 6" O.C.*
R.T. w/ HEEL HT. 24" TO 48"	LAP WALL SHTG. w/ DBL. TOP PL. & INSTALL ON TRUSS VERT. - FASTEN W/ NAILS @ 6" O.C. PROVIDE 2x BLK @ EA. BAY AT TOP OF HEEL	LAP WALL SHTG. w/ DBL. TOP PL. & INSTALL ON TRUSS VERT. - FASTEN W/ NAILS @ 6" O.C. PROVIDE 2x BLK @ EA. BAY AT TOP OF HEEL.*
WALL TO FOUNDATION	WALL SHTG. LAP W/ SILL PL. & FASTENED PER SHEAR WALL FASTENING SPEC.	

* 2 1/2"x0.113 IS AN ACCEPTABLE ALTERNATIVE TO A 3"x0.120", SAME SPACING OR NUMBER OF NAILS. (ONLY ACCEPTABLE WHERE * ARE SHOWN)

GENERAL STRUCTURAL NOTES
DESIGN LOADING
<ul style="list-style-type: none">• DESIGN IS BASED ON 2018 NORTH CAROLINA STATE BUILDING CODE: RESIDENTIAL CODE.• WOOD FRAME ENGINEERING IS BASED ON NDS, "NATIONAL DESIGN SPECIFICATION FOR WOOD CONSTRUCTION" - LATEST EDITION.• DESIGN LOADS:<ul style="list-style-type: none">ROOF<ul style="list-style-type: none">SNOW = 15 PSF (12 PSF GROUND SNOW, TRUSSES)LIVE = 20 PSF (REDUCIBLE BASED ON ROOF PITCH)DEAD = 1 PSF T.C., 10 PSF B.C.LOAD DURATION FACTOR = 1.25FLOOR<ul style="list-style-type: none">LIVE = 40 PSF (30 PSF @ SLEEPING AREAS)DEAD = 10 PSF (1-JOISTS), 15 PSF (FLOOR TRUSSES)ADDL 10 PSF @ CERAMIC TILE IN KITCHEN, SUNROOMS, BATHS, FOYER, LAUND. & MUDRMSSOIL 2,000 PSF ASSUMED ALLOWABLE BEARING PRESSURE (TO BE VERIFIED BY BUILDER)WIND 115 MPH, EXPOSURE B

GENERAL FRAMING

- ALL TYP. NAIL FASTENER REQUIREMENTS ARE NOTED IN STANDARD CONNECTIONS TABLE (IRC TABLE R602.3.11) OR ON PLANS. ALL NAILS SPECIFIED ARE MIN DIAMETER AND LENGTH REQUIRED FOR CONNECTION. ALL HANGER NAILS SHALL BE INSTALLED PER MANUFACTURER'S REQUIREMENTS FOR MAX CHARTED CAPACITY. NOTE: HANGERS USE COMMON NAIL DIAMETERS NOT TYPICAL FRAMING GUN NAILS.
- EXT. & INT. BEARING WALLS SHALL BE 2x4 OR 2x6 (AS SHOWN ON PLANS) @ 16" O.C. SPP/SP #2 GRADE LUMBER, OR BETTER, U.N.O..
 - WALLS OVER 12' TALL SHALL BE PER PLAN.
- ALL INTERIOR BEARING WALLS ARE ASSUMED TO BE SHEATHED W/ GYP WALL BOARD (ONE SIDE MIN.) OR PROVIDE MID HT. BLOCKING.
- ALL HEADERS, BEAMS & OTHER STRUCTURAL MEMBERS SHALL BE SPRUCE-PINE-FIR #2 (SPF) OR SOUTHERN PINE #2 (SP) LUMBER, OR BETTER. SUPPORT ALL HEADERS/ BEAMS W/ (1)2x JACK STUD & (1)2x KING STUD, MINIMUM.
 - THE NUMBER OF STUDS SPECIFIED AT A SUPPORT INDICATES THE NUMBER OF JACK STUDS REQUIRED, U.N.O..
- ALL NON-BEARING INTERIOR STUD WALLS SHALL BE CONSTRUCTED WITH 2x STUD/ GRADE MEMBERS SPACED @ 24" O.C. (MAX., U.N.O.)
 - HEADERS IN NON-LOAD BEARING WALLS SHALL BE: (1)2x4/6 FLAT @ OPENINGS UP TO 4'; (2)2x4/6 FLAT UP TO 8'.
- ALL FRAMING LUMBER SHALL BE DRIED TO 15% MC (KD-15).
- ENGINEERED LUMBER BEAMS TO MEET OR EXCEED THE FOLLOWING:
 - LVL' - Fb=2600 psi; Fv=285 psi; E=2.0x10⁶ psi
- ENGINEERED LUMBER POSTS TO MEET OR EXCEED THE FOLLOWING:
 - LVL' - Fb=2400 psi; FcII=2500 psi; E=1.8x10⁶ psi
- FOR 2 & 3 PLY BEAMS OF EQUAL 1 3/4" MAX. WIDTH, FASTEN PLIES TOGETHER WITH 3 ROWS OF 3"x0.120" NAILS @ 8" O/C OR 2 ROWS 1/2"x3/8" SIMPSON SDS SCREWS (OR 3/4" TRUSSLOK SCREWS) @ 16" O/C. USE A MINIMUM OF 4 ROWS FOR BEAM DEPTHS OF 14" OR GREATER. APPLY FASTENING AT BOTH FACES FOR 3-PLY CONDITION. LOCATE TOP & BOTTOM NAILS/SCREWS 2" FROM EDGE. SOLID 3 1/2" OR 5 1/4" BEAMS ARE ACCEPTABLE. USE 2 ROWS OF NAILS FOR 2x6 & 2x8 MEMBERS.
- FOR 4 PLY BEAMS OF EQUAL 1 3/4" MAX. WIDTH, FASTEN PLIES TOGETHER WITH 3 ROWS OF 1/2"x6" SIMPSON SDS SCREWS (OR 6 3/4" TRUSSLOK SCREWS) @ 16" O/C. USE A MINIMUM OF 4 ROWS FOR BEAM DEPTHS OF 14" OR GREATER. APPLY FASTENING AT BOTH FACES (ONE SIDE ONLY FOR TRUSSLOK SCREWS). LOCATE TOP AND BOTTOM SCREWS 2" FROM EDGE. A SOLID 1" BEAM IS ACCEPTABLE.
- PROVIDE SOLID BLOCKING IN FLOOR SYSTEM UNDER ALL POSTS CONTINUOUS TO FND/BEARINGS. BLOCKING TO MATCH POST ABOVE.
- ALL EXTERIOR 4x4 WOOD POSTS SHALL HAVE SIMPSON BC52-2/4 CAP & ABW44 BASE, U.N.O.
- CORROSION NOTES:
 - BUILDER RESPONSIBLE TO DETERMINE CORROSION-RESISTANCE REQUIREMENTS AND COMPATIBILITY OF HARDWARE, FASTENERS AND CONNECTORS FOR ENVIRONMENTAL EXPOSURE AND IN CONTACT W/ PRESERVATIVE-TREATED WOOD OF ACTUAL FINAL CONDITIONS AND SOURCED MATERIALS. CONTACT LUMBER & HARDWARE SUPPLIERS TO COORD.

GENERAL STRUCTURAL NOTES

FOUNDATION

- DESIGN IS BASED ON 2018 NORTH CAROLINA STATE BUILDING CODE: RESIDENTIAL CODE.
- FOOTING DESIGN - 2,000 PSF ALLOWABLE SOIL BEARING PRESSURE IS ASSUMED. BUILDER/CONTRACTOR MUST VERIFY.
- FASTEN 2x4/6 SILL PLATES TO CONC FND WITH A MINIMUM OF 2 ANCHORS PER PLATE, 12" MAX. FROM PLATE ENDS - UTILIZING:
 - 1/2" DIA. ANCHOR BOLTS @ 6'-0" O.C." MIN. EMBEDMENT
 - 1/2" DIA. x 6" LONG SIMPSON TITEN HD @ 6'-0" O.C.
 - SIMPSON MASA ANCHOR STRAPS @ 6'-0" O.C. (CONCRETE)
- ALL LUMBER EXPOSED TO WEATHER OR IN CONTACT W/ PERIMETER FOUNDATION SHALL BE PRESERVATIVE TREATED SOUTHERN PINE #2.
- BUILDER TO VERIFY CORROSION-RESISTANCE COMPATIBILITY OF HARDWARE & FASTENERS IN CONTACT W/ PRESERVATIVE-TREATED WOOD. CONTACT LUMBER & HARDWARE SUPPLIERS TO COORD.
- FOOTINGS SHALL BE PLAIN CONCRETE, U.N.O.
- CONCRETE DESIGN BASED ON ACI 318. CONCRETE SHALL ATTAIN THE FOLLOWING MIN. COMPRESSIVE STRENGTHS IN 28 DAYS, U.N.O.:
 - Fc = 3,000 psi: FOOTINGS & INTERIOR SLABS ON GRADE 3,500 psi: GARAGE & EXTERIOR SLABS ON GRADE fy = 60,000 psi
- ALL CONCRETE EXPOSED TO THE WEATHER SHALL NOT HAVE LESS THAN 5% OR MORE THAN 1% AIR ENTRAINMENT.
- ALL FOOTINGS SHALL BEAR BELOW FROST LINE (TYP.) OR 12" MIN IN REGIONS WHERE CODE FROST DEPTH IS NOT APPLICABLE. CONSULT SOILS REPORT OR BUILDING DEPT. FOR MINIMUM DEPTH BELOW GRADE.
- FOOTINGS AND SLABS ON GRADE SHALL BEAR ON VIRGIN SOIL OR 95% COMPACTED FILL.
- PROVIDE CONTROL JOINTS AT ALL INSIDE CORNERS OF SLAB EDGES, AND OTHER LOCATIONS WHERE SLAB CRACKS ARE LIKELY TO DEVELOP.
 - JOINTS SHALL BE LOCATED @ 10'-0" O.C. (RECOMMENDED) OR 15'-0" O.C. (MAXIMUM)
 - JOINT GRID PATTERN SHALL BE AS CLOSE TO SQUARES AS POSSIBLE (1:1 RATIO), WITH A MAXIMUM OF 1:1.5 RATIO
 - CONTROL JOINTS SHALL NOT BE INSTALLED IN STRUCTURAL SLABS
- DIMENSIONS BY OTHERS, BUILDER TO VERIFY.

MMK STD. - MAY 2002

HOLD-DOWN SCHEDULE

SYMBOL	SPECIFICATION
▶ HD-1	SIMPSON C516 STRAP TIE W/ 14" END LENGTH
▶ HD-2	SIMPSON MSTC66 STRAP TIE W/ 24" END LENGTH
▶ HD-3	SIMPSON HTT4 HOLD-DOWN *
▶ HD-4	SIMPSON HDU5-SDS2.5 HOLD-DOWN *
▶ HD-5	SIMPSON STDH4RJ HOLD-DOWN *
* UTILIZE SIMPSON "SET-36" EPOXY SYSTEM TO FASTEN 3/8" DIA. THREADED ROD INTO CONCRETE FOUNDATION. PROVIDE 12" MIN. EMBEDMENT INTO CONCRETE. INSTALL PER MANUF. RECOMMENDATIONS. DO NOT LOCATE ANCHORS WITHIN 1 3/4" OF EDGE OF FOUNDATION.	

MEANS & METHODS NOTES

THE STRUCTURE IS DESIGNED TO BE SELF SUPPORTING AND STABLE AFTER THE BUILDING IS FINISHED AND ALL PLAN, DETAIL, AND NOTE SPECIFICATIONS HAVE BEEN COMPLETED. IT IS THE CONTRACTOR'S SOLE RESPONSIBILITY TO DETERMINE THE ERECTION PROCEDURES AND SEQUENCE TO INSURE THE SAFETY OF THE BUILDING AND ITS COMPONENTS DURING CONSTRUCTION. THIS INCLUDES, BUT IS NOT LIMITED TO, THE ADDITION OF NECESSARY SHORING, SHEETING, TEMPORARY BRACING, GUYS, AND TIE-DOWNS. CONTRACTOR SHALL BE RESPONSIBLE FOR ALL SHORING AND BRACING REQUIRED TO STABILIZE AND PROTECT EXISTING AND ADJACENT STRUCTURES AND SYSTEMS DURING COURSE OF DEMOLITION AND CONSTRUCTION OF THE PROJECT.

STRUCTURAL DESIGN AND SPECIFICATIONS ASSUME THAT ALL SUPPORTING AND NON-SUPPORTING ELEMENTS IN CONTACT WITH FLOOR FRAMING ARE LEVEL, INCLUDING, BUT NOT LIMITED TO: FOUNDATIONS, SLABS ON GRADE, BEAMS, WALLS, AND NON-BEARING ELEMENTS. IT IS THE CONTRACTOR'S RESPONSIBILITY TO VERIFY LEVELNESS AND MAKE ADJUSTMENTS AS NECESSARY, INCLUDING CONSIDERATION OF THOSE AREAS THAT MAY BE WITHIN CONTRACTUAL, INDUSTRY, OR WARRANTY TOLERANCES.

VENEER LINTEL SCHEDULE

SPAN (MAX)	HEIGHT OF VENEER ABOVE LINTEL	STEEL ANGLE SIZE
3'-0"	20 FT. MAX	L3"x3"x1/4"
6'-0"	3 FT. MAX	L3"x3"x1/4"
	12 FT. MAX	L4"x3"x1/4"
8'-0"	20 FT. MAX	L5"x3 1/2"x3/8"
	12 FT. MAX	L4"x4"x1/4" *
10'-0"	12 FT. MAX	L5"x3 1/2"x3/8"
	16 FT. MAX	L6"x3 1/2"x3/8"
9'-6"	12 FT. MAX	L6"x3 1/2"x3/8"
16'-0"	2 FT. MAX	L7"x4"x1/2" **
	3 FT. MAX	L8"x4"x1/2" **

ALL LINTELS:
- SHALL SUPPORT 2 3/8" - 3 1/2" VENEER W/ 40 psf MAXIMUM HEIGHT.
- 6" SHALL HAVE 4" MIN BEARING
- 10" SHALL HAVE 8" MIN BEARING
- 16" SHALL NOT BE FASTENED BACK TO HEADER
- 16" SHALL BE FASTENED BACK TO WOOD HEADER IN WALL @ 48" o.c. W/ 1/2" DIA. x 3 1/2" LONG LAG SCREWS IN 2" LONG VERTICALLY SLOTTED HOLES.
- MAX. VENEER HT. APPLIES TO ANY PORTION OF BRICK OVER THE OPENING.
- ALL LINTELS SHALL BE LONG LESS VERTICAL
- WHEN SUPPORTING VENEER < 3" WIDE THE EXTERIOR TOE OF THE HORIZONTAL LEG MAY BE CUT IN THE FIELD TO BE 3 1/2" WIDE OVER THE BEARING LENGTH ONLY. THIS IS TO ALLOW FOR MORTAR JOINT FINISHING.
- SEE STRUCTURAL PLANS FOR ANY LINTEL CONDITION NOT ENCOMPASSED BY THE ABOVE PARAMETERS.
* FOR GREEN VENEER USE 1/4"x3/4"
** FOR 3 1/2" VENEER ONLY, SEE PLAN FOR VENEER SUPPORT IF VENEER < 3/8" THICK.

MMK STD. - MAY 2016

ADDITIONAL NOTES FOR TRUSS & I-JOIST MANUFACTURER

ROOF TRUSS, FLOOR TRUSS AND ENGINEERED JOISTS SHALL BE DESIGNED TO MEET THE DEFLECTION CRITERIA BELOW, UNLESS NOTED OTHERWISE ON PLAN. MULHERN & KULP CANNOT BE HELD RESPONSIBLE FOR ANY STRUCTURAL ISSUES RELATED TO ANY BUILDING COMPONENT IF COMPONENT SHOP DRAWINGS ARE NOT SUBMITTED TO MKK FOR REVIEW PRIOR TO FABRICATION, DELIVERY, OR INSTALLATION.

TRUSSES/JOISTS SHALL BE DESIGNED SO THAT DIFFERENTIAL DEFLECTION BETWEEN ADJACENT PARALLEL TRUSSES/JOISTS OR GIRDER TRUSSES/FLUSH BEAMS DO NOT EXCEED THE FOLLOWING:
A. ROOF TRUSSES:
1/4" DEAD LOAD
B. FLOOR TRUSSES, ATTIC TRUSSES, & I-JOISTS:
1/8" DEAD LOAD
ABSOLUTE DEAD LOAD DEFLECTION OF FLOOR TRUSSES/ATTIC TRUSSES WHEN ADJACENT TO FLOOR FRAMING BY OTHERS SHALL BE LIMITED TO 3/16". (NOT DIFFERENTIAL DEFLECTION)

FLOOR JOIST NOTES

- ALL FLOOR JOISTS SHALL BE THE DEPTH SPECIFIED ON PLAN
- FLOOR JOISTS SERIES & SPACING IS PER THE FLOOR JOIST MANUF.
 - SPACING SHALL NOT EXCEED 19.2" O.C. (MAX.)
 - @ LOCATION OF TILE: SPACING SHALL NOT EXCEED 16" O.C. (MAX.)

LATERAL/WALL BRACING & WALL SHEATHING SPECIFICATIONS

THIS MODEL HAS BEEN DESIGNED TO RESIST LATERAL FORCES RESULTING FROM:
115 MPH WIND IN 2018 NCSEBG:RC
(115 MPH WIND SPEED IN ASCE 7-10 WIND MAP, PER IRC R301.2.1.1) EXP. B, RISK CAT. 2 & SEISMIC CAT. A/B.

THE DESIGN WAS COMPLETED PER 2015 IBC (SECTION 1609) & ASCE 7-10, AS PERMITTED BY R301.1.3 OF THE 2018 NCSEBG:RC. ACCORDINGLY, THIS MODEL, AS DOCUMENTED AND DETAILED HEREIN, IS ADEQUATE TO RESIST THE CODE REQUIRED LATERAL FORCES.

DESIGN WIND UPLIFT LOADS HAVE BEEN CALCULATED UTILIZING ASCE 7-10 (ACCEPTED ENGINEERING PRACTICE) AS ALLOWED PER 2018 NCSEBG:RC SECTION R802.11.1.1. THIS MODEL HAS BEEN DETAILED WHERE REQUIRED & ENGINEERED TO RESIST THE WIND UPLIFT LOAD PATH PER SECTIONS R602.3.5 & R802.11.

EXT. WALL SHEATHING SPECIFICATION

- 7/16" OSB OR 15/32" PLYWOOD:
FASTEN SHEATHING W/ 2 3/8"x0.113 NAILS @ 6" O.C. AT EDGES & @ 12" O.C. IN THE PANEL FIELD. (TYP, U.N.O.)
- ALL SHEATHING PANELS SHALL BE ORIENTED VERTICALLY (LONG DIRECTION PARALLEL TO STUDS) AND INSTALLED FULL HEIGHT OF SHEAR WALL - OR - 2x HORIZONTAL BLOCKING SHALL BE PROVIDED TO SUPPORT ALL UNSUPPORTED PANEL EDGES & EDGE FASTENING.
- ALL EXT. WALLS SHALL BE CONTINUOUSLY SHEATHED AND ARE CONSIDERED SHEAR WALLS.
- ALT. STAPLE CONNECTION SPEC: 1 3/4" 16 GA STAPLES (1/6" CROWN) @ 3" O.C. AT EDGES & @ 6" O.C. IN FIELD.

3" O.C. EDGE NAILING

- AT DESIGNATED AREAS - FASTEN PANEL EDGES OF WOOD STRUCTURAL WALL SHEATHING TO FRAMING W/ 2 3/8" x 0.113" NAILS @ 3" O.C. AND 12" O.C. IN THE PANEL FIELD NO STAPLE ALTERNATIVE AVAILABLE AT THIS SPEC. ALL SHEATHING PANELS SHALL BE ORIENTED VERTICALLY (LONG DIRECTION PARALLEL TO STUD) AND INSTALLED FULL HEIGHT OF SHEAR WALL - OR - 2x HORIZONTAL BLOCKING SHALL BE PROVIDED TO SUPPORT UNSUPPORTED PANEL EDGES AND 3" O.C. EDGE FASTENING.

TYP. UNIT SEPARATION WALL SHEATHING SPECIFICATION

- 1/2" OR 5/8" GYPSUM WALL BOARD:
FASTEN GWB SHEATHING TO FRAMING W/ 1 5/8"x0.086" COOLER NAILS OR 1 1/4" DRYWALL SCREWS @ 1" O.C. TO PANEL EDGES & PANEL FIELD (INCLUDING T&B PLATES).

NOTES

- SEE CONNECTION SPECIFICATIONS CHART FOR STANDARD SHEAR TRANSFER DETAILING. IF ADDITIONAL CAPACITY IS REQUIRED BY DESIGN, IT WILL BE SPECIFICALLY NOTED ON PLAN.
- DESIGN ASSUMES 16" O.C. MAX. STUD SPACING, U.N.O.
- ALL STRUCTURAL PANELS ARE TO BE DIRECTLY APPLIED TO STUD FRAMING.
- PRE-MANUFACTURED PANELIZED WALLS:
FASTEN TOGETHER END STUDS OF WALL PANELS SHEATHED W/ OSB OR PLYWOOD W/ 3" x 0.120" NAILS @ 4" O.C. (THRU ONE SIDE ONLY)

--- INDICATES EXTENT OF INT. OSB SHEARWALL, BLOCKED PANEL EDGES, AND/OR 3" O.C. EDGE NAILING
▶ INDICATES HOLDDOWN

MMK STD. - MAR 2016



MULHERN+KULP
RESIDENTIAL STRUCTURAL ENGINEERING
3605 Boulevard Parkway, Suite 250 • Alpharetta, GA 30022
p 770-777-4874 • mulhern@mulhernkulp.com
NC License # C-3625



Mulhern+Kulp project number:

243-24034

project mgr: **SMK**
drawn by: **SMM/FC**
issue date: **11-07-2024**

REVISIONS:
date: 05/15/2025 initial: JPP
desc: ARCH UPDATES

tri pointe
HOMES


GENERAL NOTES

5921-08 MODEL

SERENITY
MASTER SET
RALEIGH, NC

sheet:

S0.0

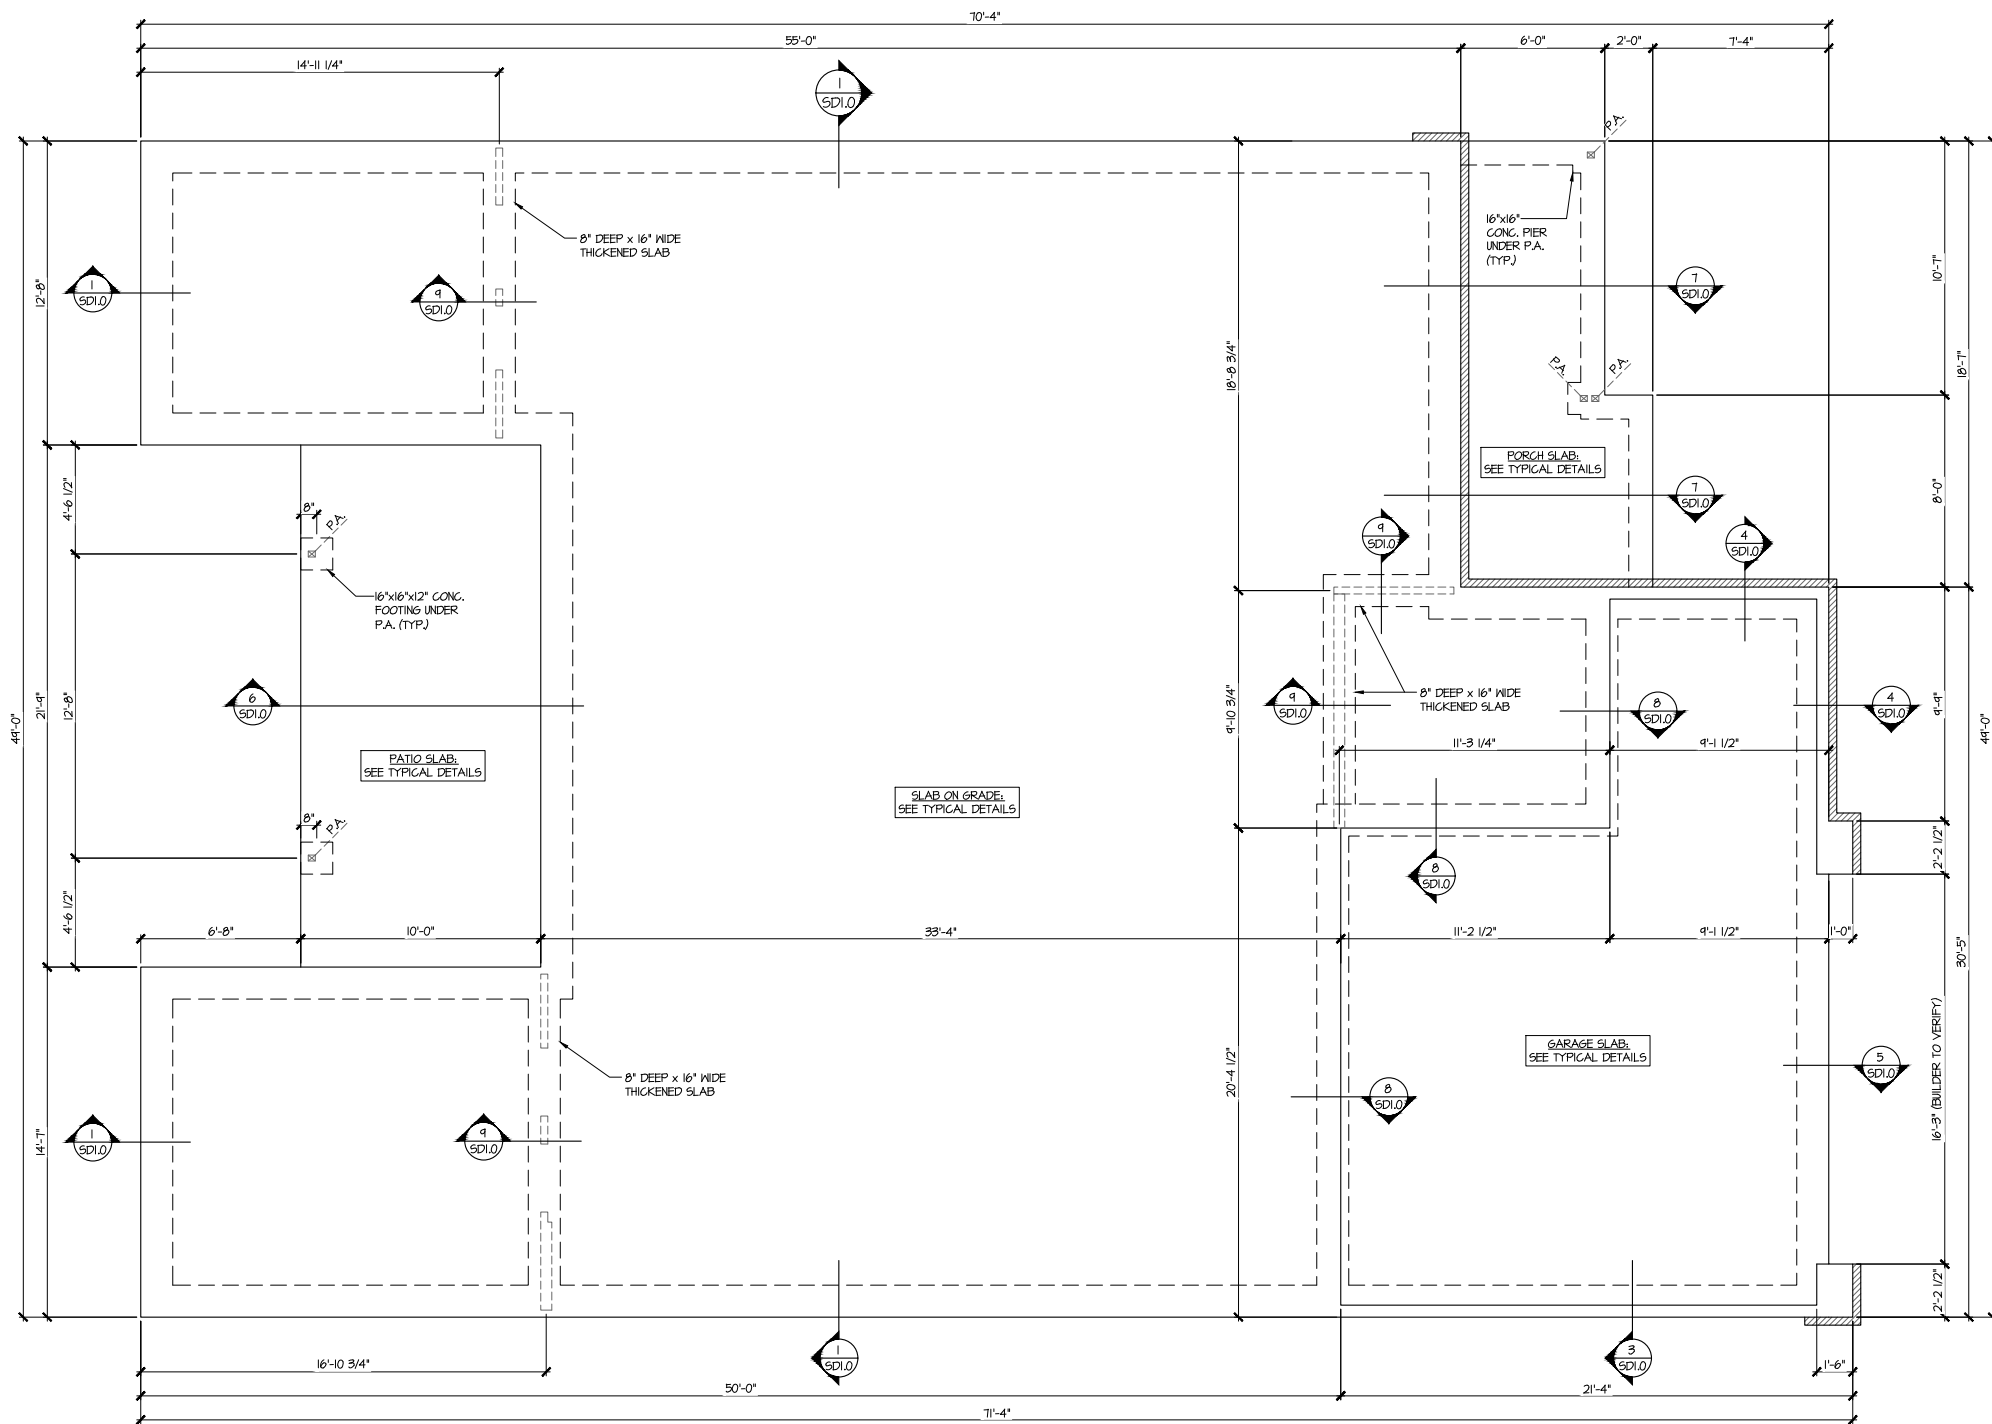


SLAB FOUNDATION PLAN
SCALE: 1/4"=1'-0" (22x24 SHEET)
1/8"=1'-0" (11x17 SHEET)
ELEV. A

LEGEND

- INTERIOR BEARING WALL
- BEARING WALL ABOVE (B.W.A.)
- BEAM / HEADER
- INDICATES EXTENT OF INT. OSB SHEARWALL AND/OR 3" O.C. EDGE NAILING
- EXTENT OF VALLEY TRUSS OVERFRAMING @ 24" O.C. (MAX.)
- EXTENT OF FLOOR SYSTEM TO BE DESIGNED FOR TILE
- INDICATES HOLDOWN
- METAL HANGER
- INDICATES POST ABOVE. PROVIDE SOLID BLOCKING UNDER POST OR JAMB ABOVE.

REFER TO S.O. FOR
TYPICAL STRUCTURAL NOTES
& SCHEDULES

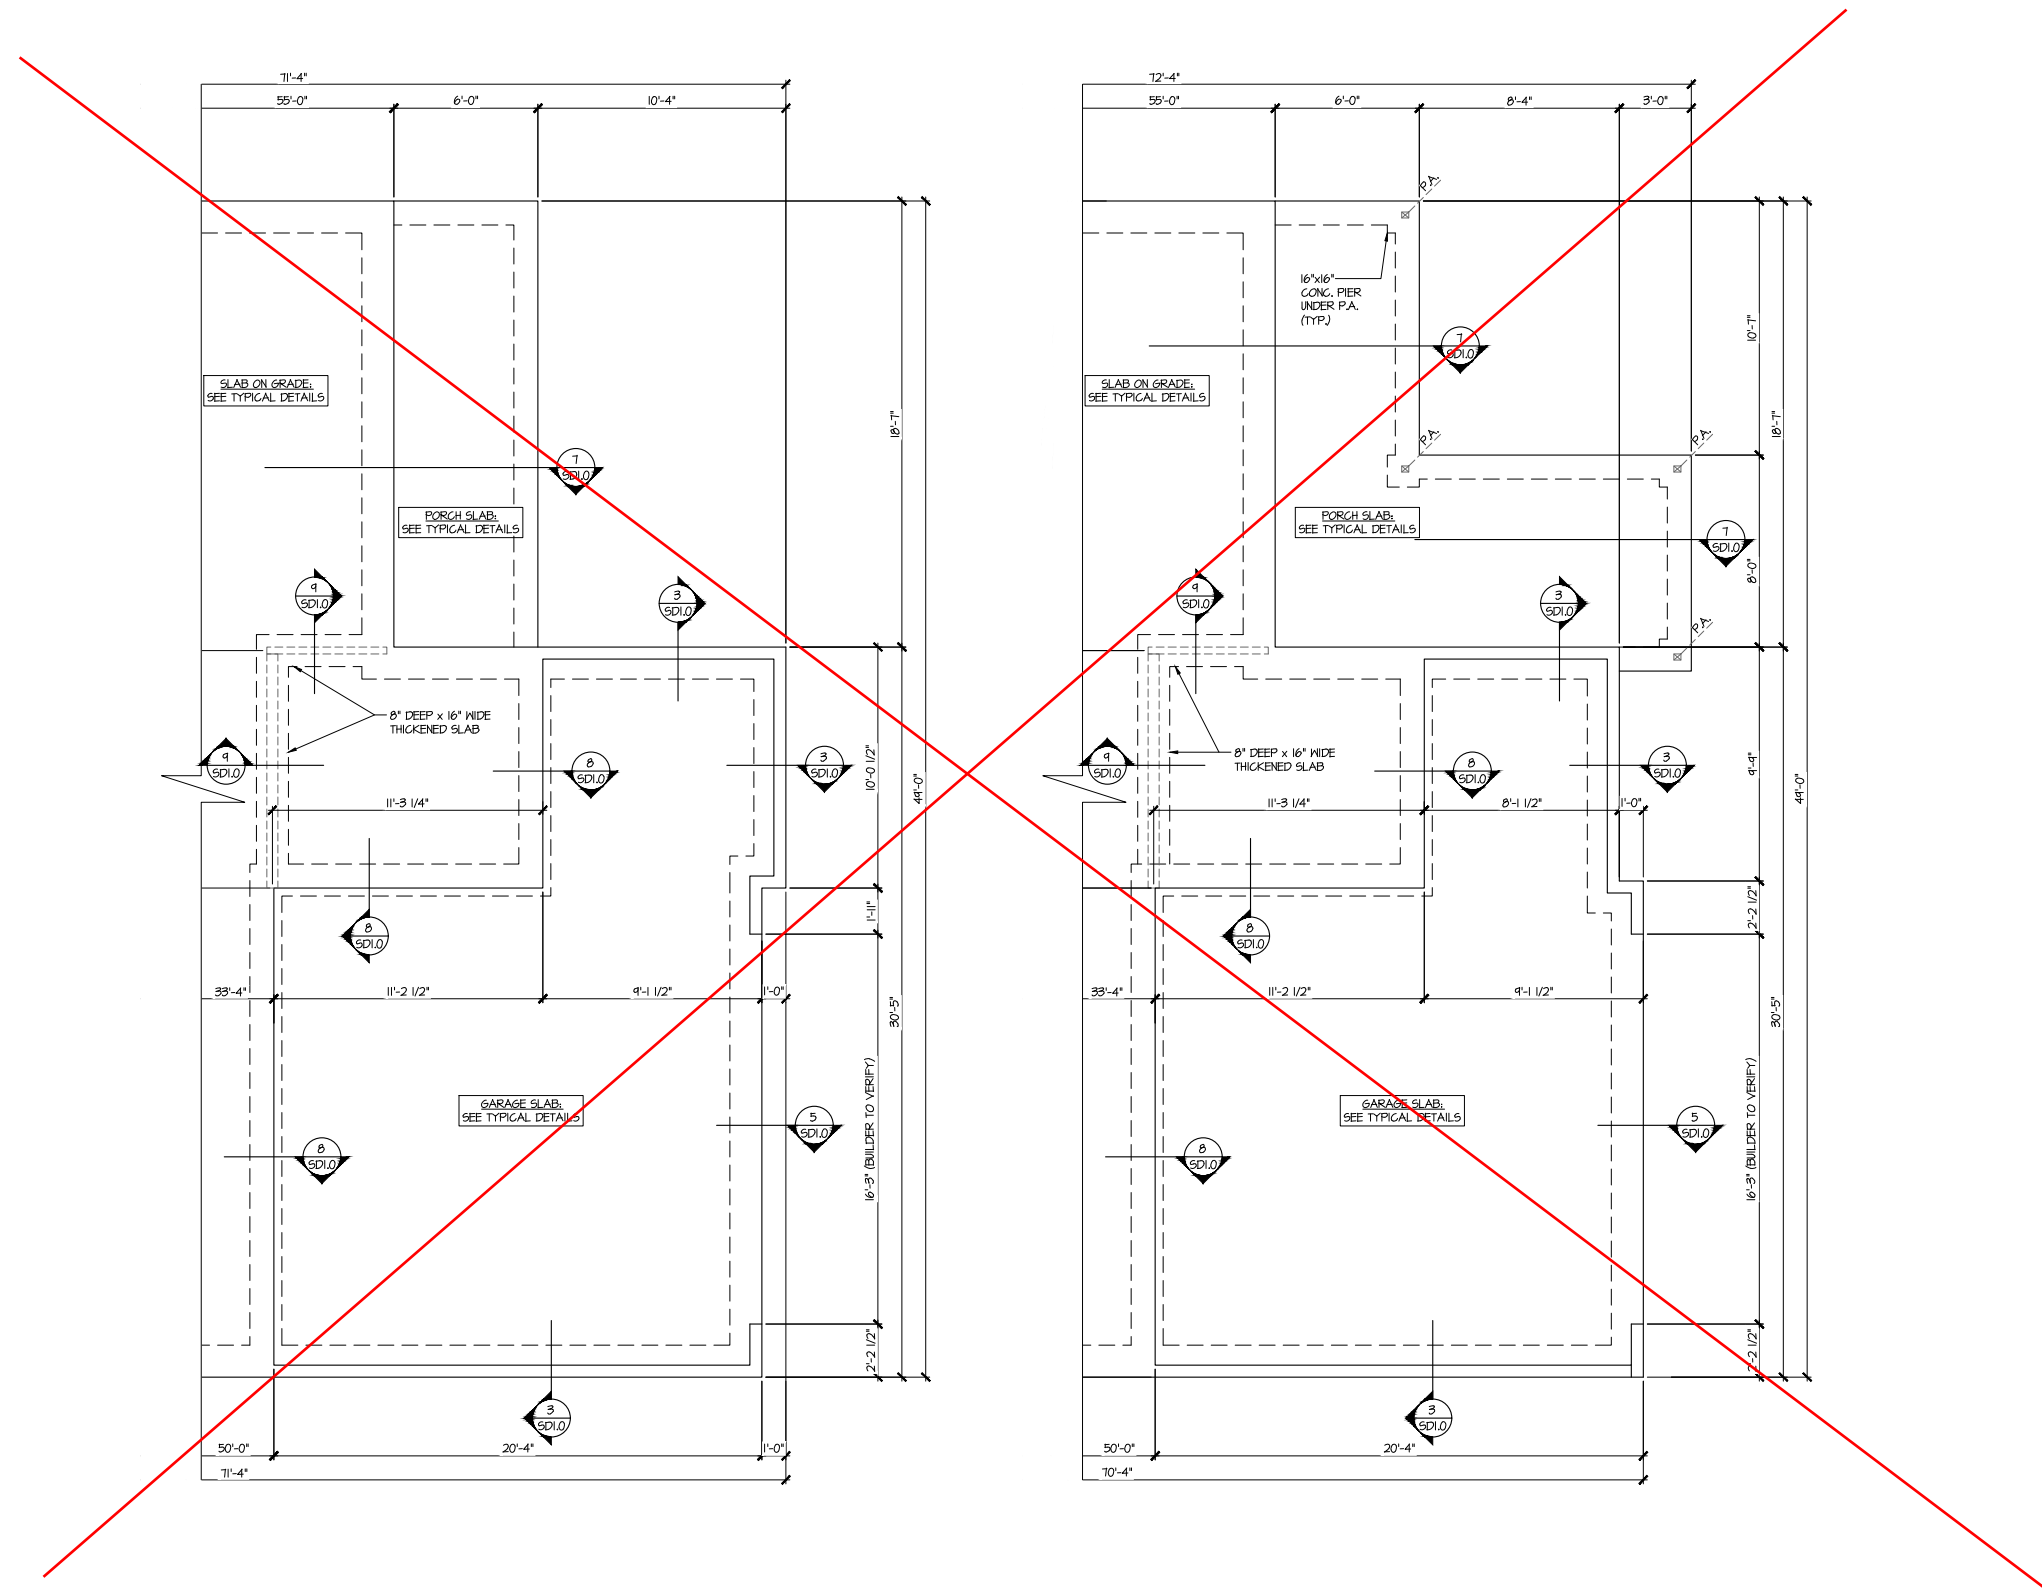

PARTIAL SLAB FOUNDATION PLAN
SCALE: 1/4"=1'-0" (22x24 SHEET)
1/8"=1'-0" (11x17 SHEET)
ELEV. B
SEE ELEV. A FOR MORE INFO

PARTIAL SLAB FOUNDATION PLAN
SCALE: 1/4"=1'-0" (22x24 SHEET)
1/8"=1'-0" (11x17 SHEET)
ELEV. C
SEE ELEV. A FOR MORE INFO

REFER TO S.O. FOR
TYPICAL STRUCTURAL NOTES
& SCHEDULES

LEGEND	
	INTERIOR BEARING WALL
	BEARING WALL ABOVE (B.M.A.)
	BEAM / HEADER
	INDICATES EXTENT OF INT. OSB SHEARWALL AND/OR 3\"/>
	EXTENT OF VALLEY TRUSS OVERFRAMING @ 24\"/>
	EXTENT OF FLOOR SYSTEM TO BE DESIGNED FOR TILE
	INDICATES HOLDDOWN
	METAL HANGER
	INDICATES POST ABOVE. PROVIDE SOLID BLOCKING UNDER POST OR JAMB ABOVE.

seal: 5/19/25

MULHERN+KULP
RESIDENTIAL STRUCTURAL ENGINEERING
3855 Brookside Parkway, Suite 250 - Alpharetta, GA 30022
9776-777-8874 • mulhern+kulp.com
NC License # C-3625

Mulhern+Kulp project number:
243-24034



project mgr: SMK
drawn by: SMM/FC
issue date: 11-07-2024

REVISIONS:
date: 05/15/2025 initial: JPP
DESC: ARCH UPDATES

FOUNDATION PLAN

5921-08 MODEL
SERENITY
MASTER SET
RALEIGH, NC

sheet:
S1.1M

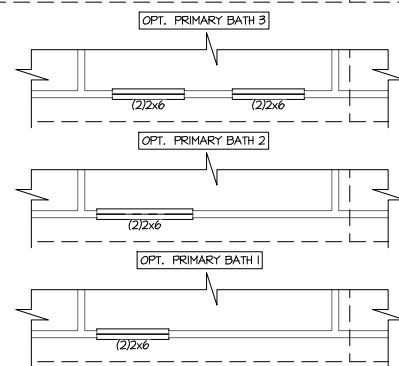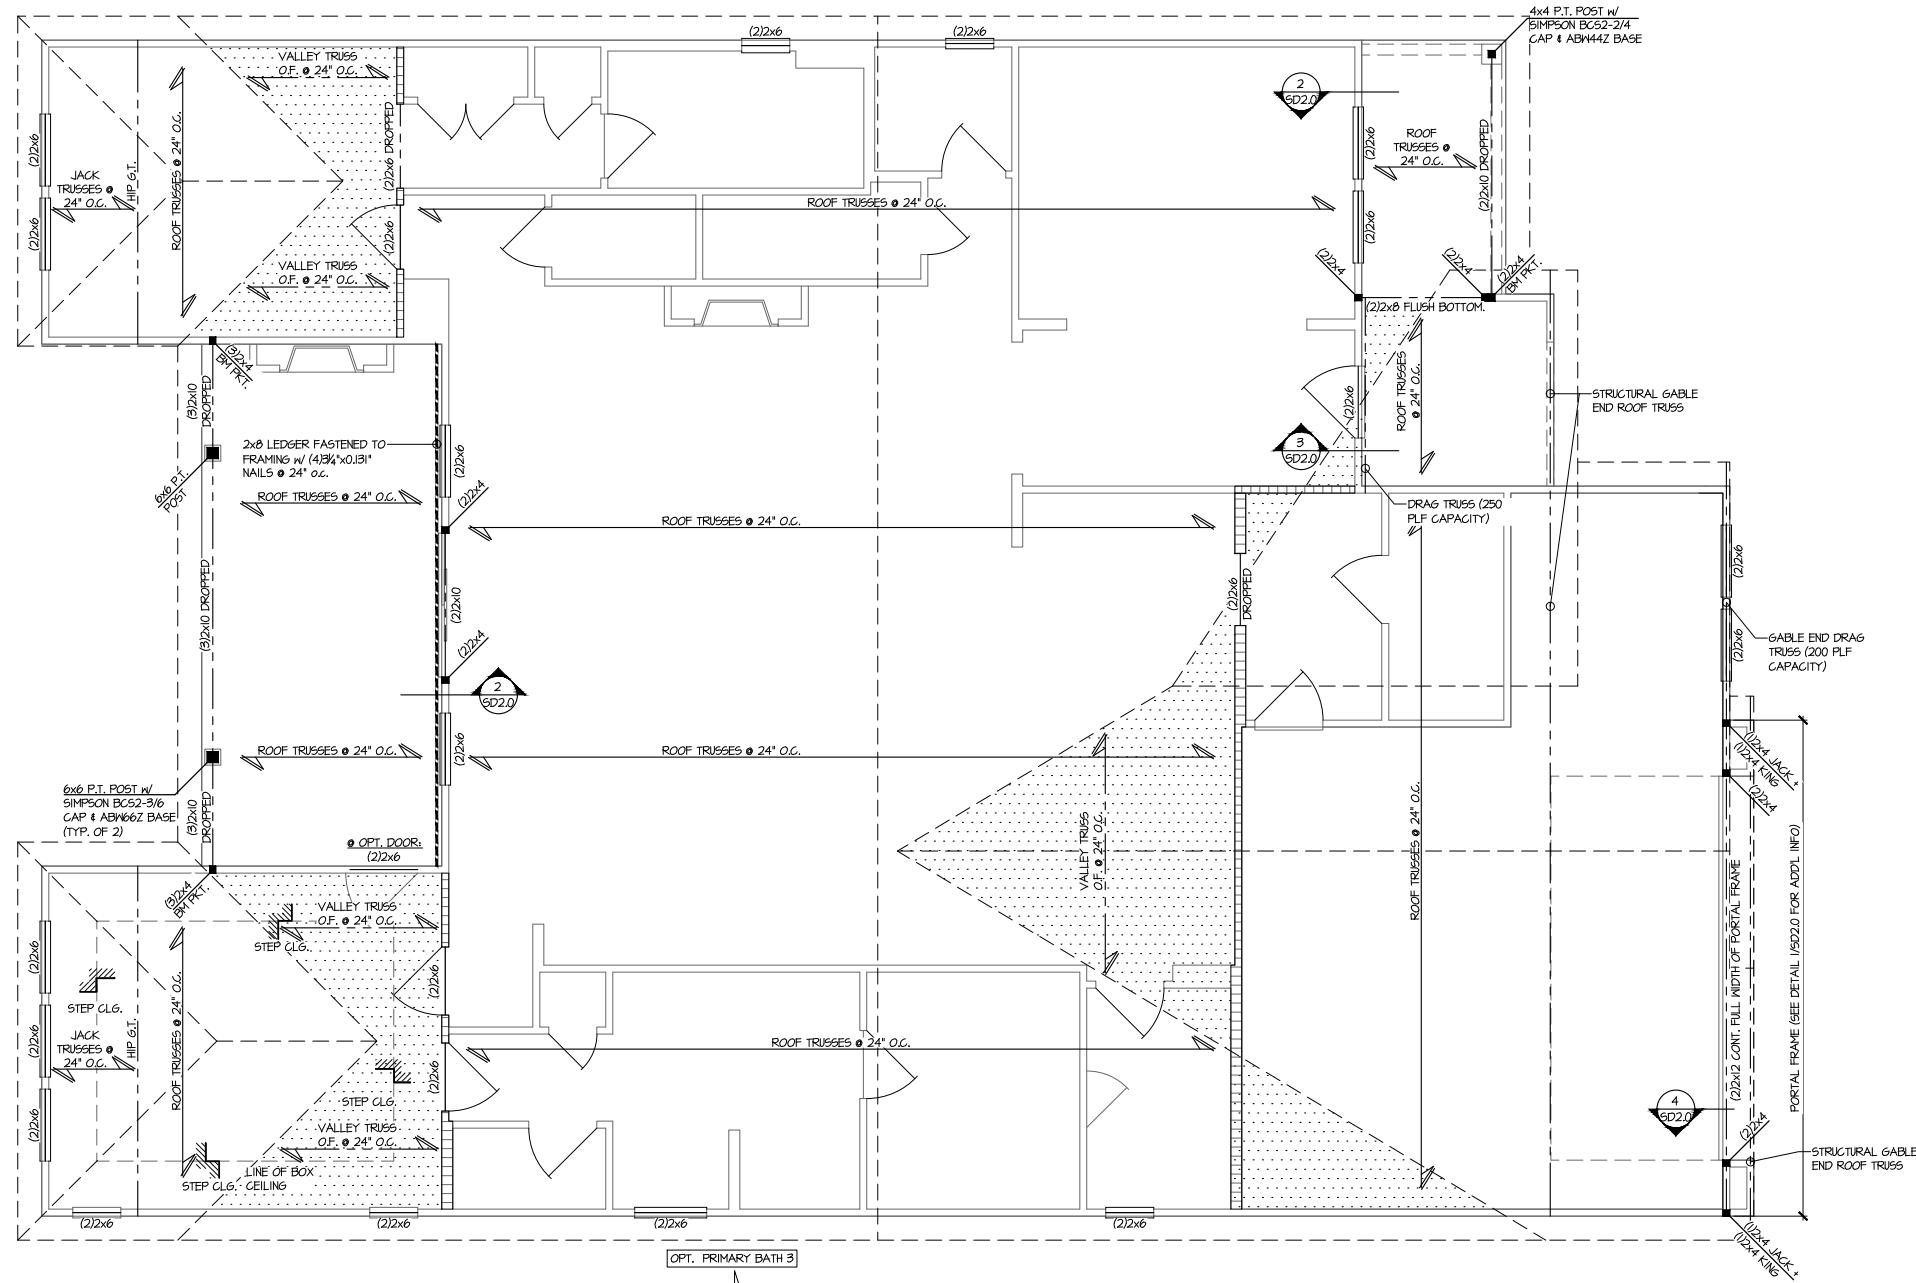

1 ROOF FRAMING PLAN
SCALE: 1/4"=1'-0" (22x24 SHEET) ELEV. A
1/8"=1'-0" (11x17 SHEET) OPT. OUTDOOR LIVING PATIO SIM.

THIS LEVEL HAS BEEN DESIGNED
FOR 9'-1" PLATE HEIGHT

LEGEND	
	INTERIOR BEARING WALL
	BEARING WALL ABOVE (B.W.A.)
	BEAM / HEADER
	INDICATES EXTENT OF INT. OSB SHEARWALL AND/OR 3" O.C. EDGE NAILING
	EXTENT OF VALLEY TRUSS OVERFRAMING @ 24" O.C. (MAX.)
	EXTENT OF FLOOR SYSTEM TO BE DESIGNED FOR TILE
	INDICATES HOLDDOWN
	METAL HANGER
	INDICATES POST ABOVE. PROVIDE SOLID BLOCKING UNDER POST OR JAMB ABOVE.

REFER TO S.O. FOR
TYPICAL STRUCTURAL NOTES
& SCHEDULES

seal: 5/19/25

MULHERN+KULP
RESIDENTIAL STRUCTURAL ENGINEERING
3855 Brookside Parkway, Suite 250 - Alpharetta, GA 30022
9776-777-8874 • mulhern+kulp.com
NC License # C-3625

Mulhern + Kulp project number:
243-24034

project mgr: **SMK**
drawn by: **SMM/FC**
issue date: **11-07-2024**


REVISIONS:
date: 05/15/2025 initial: JPP
DESC: ARCH UPDATES

ROOF FRAMING PLAN


5921-08 MODEL
SERENITY
MASTER SET
RALEIGH, NC

sheet:

S2.0M

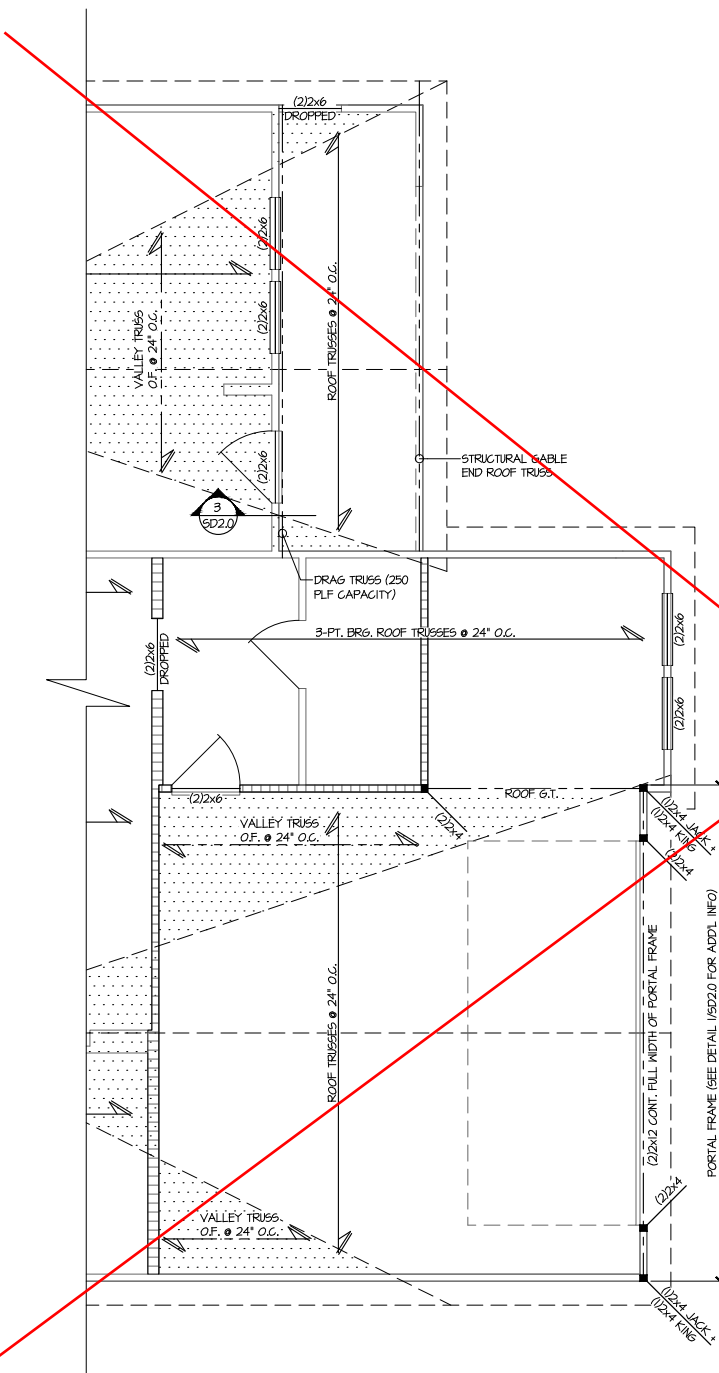

1 PARTIAL ROOF FRAMING PLAN
SCALE: 1/4"=1'-0" (22x24 SHEET)
1/8"=1'-0" (11x17 SHEET)
ELEV. B
SEE ELEV. A FOR MORE INFO

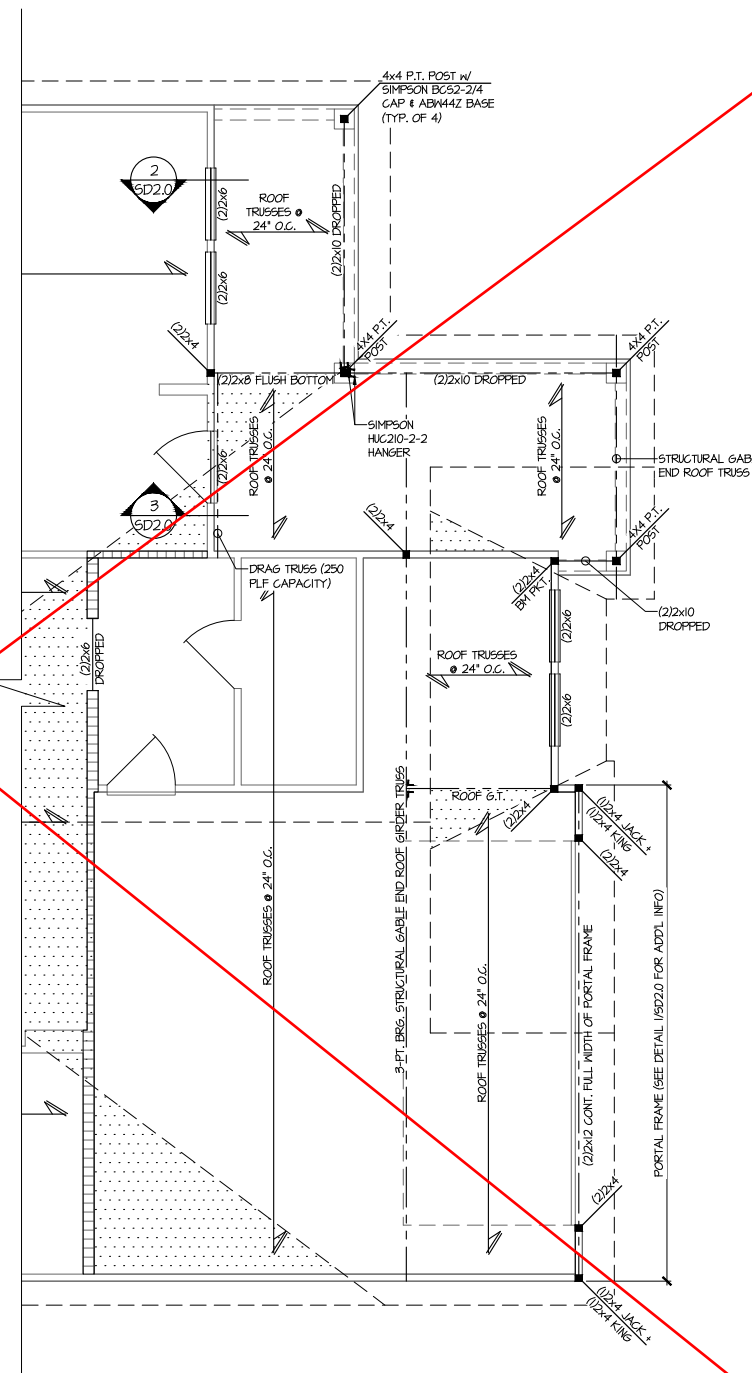

2 PARTIAL ROOF FRAMING PLAN
SCALE: 1/4"=1'-0" (22x24 SHEET)
1/8"=1'-0" (11x17 SHEET)
ELEV. C
SEE ELEV. A FOR MORE INFO

THIS LEVEL HAS BEEN DESIGNED
FOR 9'-1" PLATE HEIGHT

REFER TO 50.0 FOR
TYPICAL STRUCTURAL NOTES
& SCHEDULES

LEGEND	
	INTERIOR BEARING WALL
	BEARING WALL ABOVE (B.W.A.)
	BEAM / HEADER
	INDICATES EXTENT OF INT. OSB SHEARWALL AND/OR 3" O.C. EDGE NAILING
	EXTENT OF VALLEY TRUSS OVERFRAMING @ 24" O.C. (MAX.)
	EXTENT OF FLOOR SYSTEM TO BE DESIGNED FOR TILE
	INDICATES HOLDOWN
	METAL HANGER
	INDICATES POST ABOVE. PROVIDE SOLID BLOCKING UNDER POST OR JAMB ABOVE.

seal: 5/19/25

MULHERN+KULP
RESIDENTIAL STRUCTURAL ENGINEERING

3805 Brookside Parkway, Suite 250 - Alpharetta, GA 30022
9776-777-8874 • mulhern+kulp.com
NC License # C-3625

Mulhern+Kulp project number:
243-24034


project mgr: SMK
drawn by: SMM/FC
issue date: 11-07-2024

REVISIONS:
date: 05/15/2025 initial: JPP
DESC: ARCH UPDATES

ROOF FRAMING PLAN

5921-08 MODEL
SERENITY
MASTER SET
RALEIGH, NC

sheet:
S2.1M

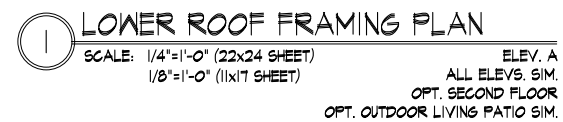

REFER TO 50.0 FOR
TYPICAL STRUCTURAL NOTES
& SCHEDULES

sheet:

S3.0M


MULHERN+KULP
RESIDENTIAL STRUCTURAL ENGINEERING

3055 Brookside Parkway, Suite 250 • Alpharetta, GA 30022
p 770-771-9874 • mulhern+kulp.com
NC License # C-3925



date:	initial:
05/15/2025	JPP
MSC. ARCH UPDATES	

tri pointe.
HOMES

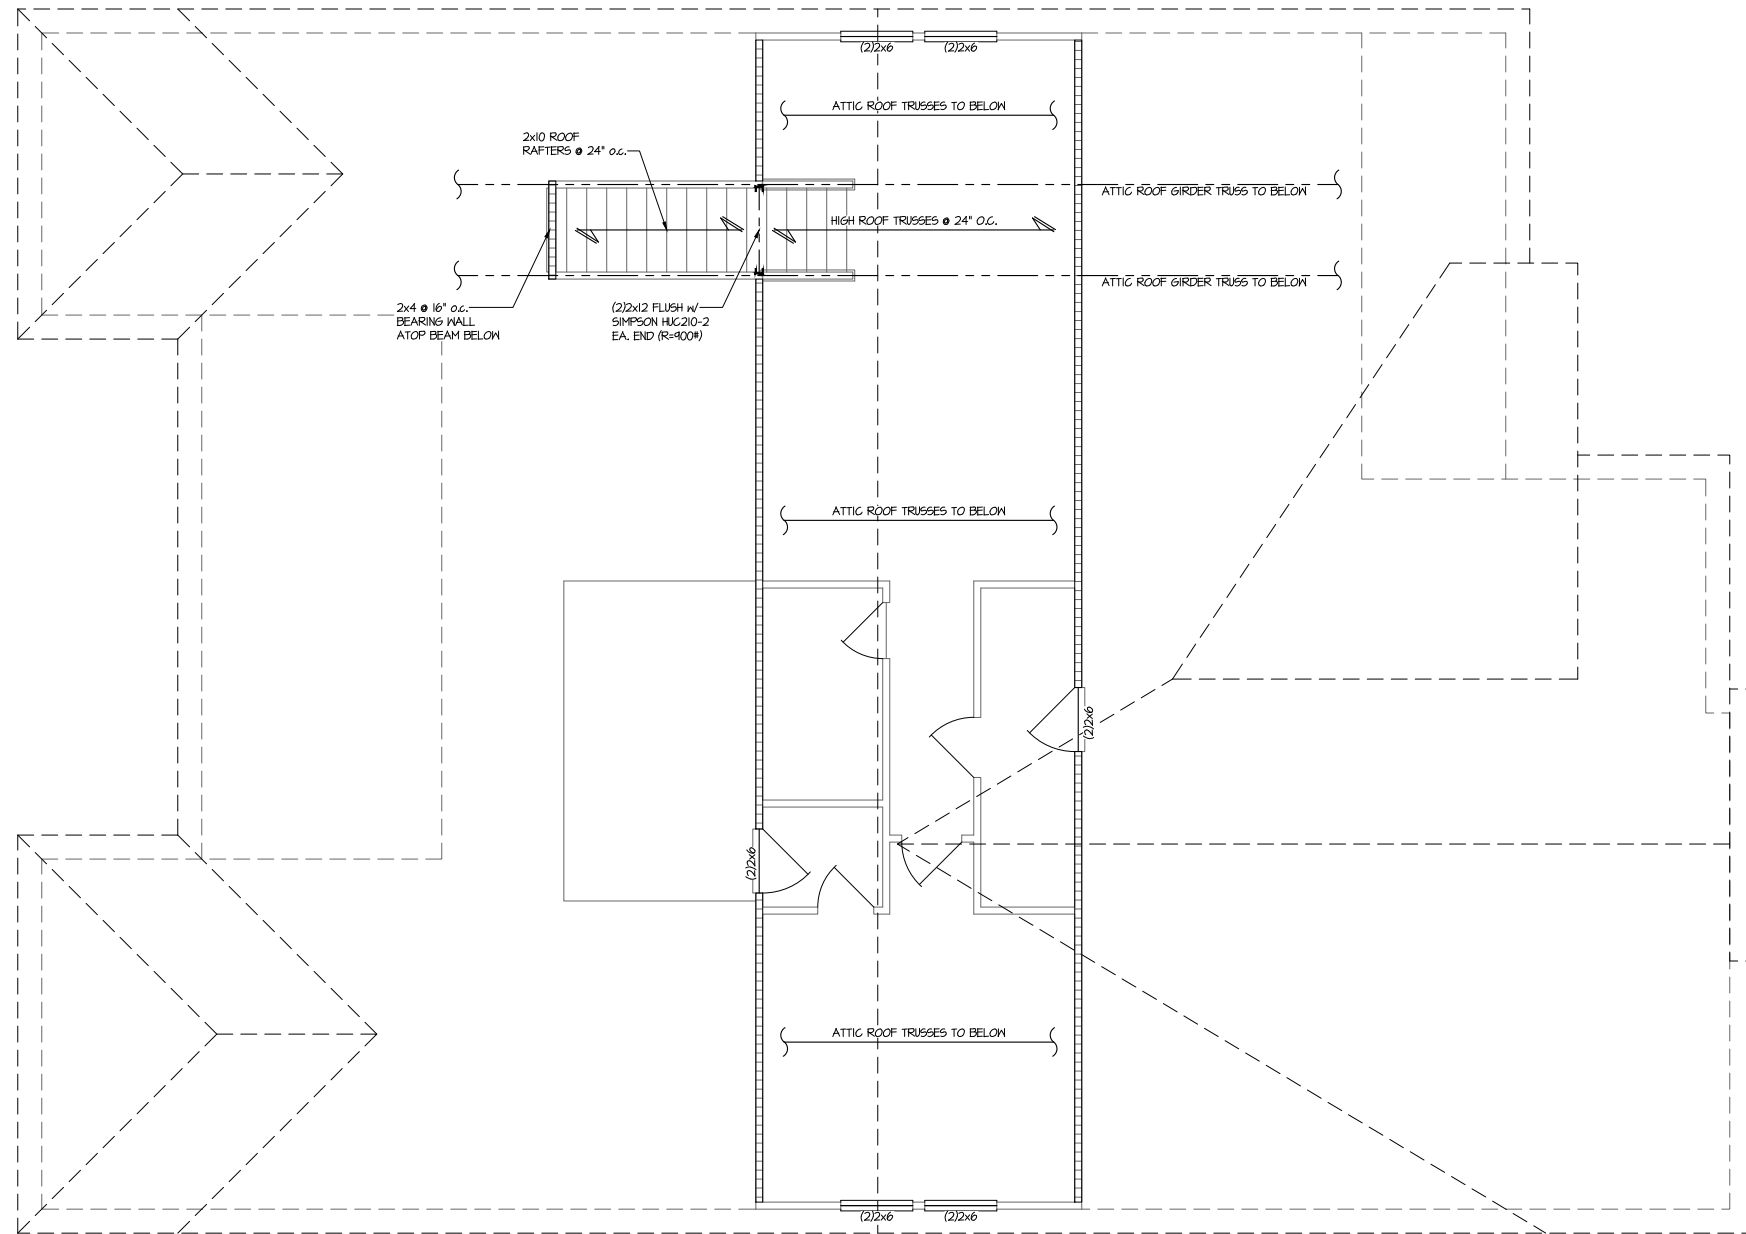

1 UPPER ROOF FRAMING PLAN
SCALE: 1/4"=1'-0" (22x24 SHEET)
1/8"=1'-0" (11x17 SHEET)
ELEV. A
ALL ELEV. S.M.
OPT. SECOND FLOOR

LEGEND	
• [Symbol]	INTERIOR BEARING WALL
• [Symbol]	BEARING WALL ABOVE (B.W.A.)
• [Symbol]	BEAM / HEADER
• [Symbol]	INDICATES EXTENT OF INT. OSB SHEARWALL AND/OR 3" O.C. EDGE NAILING
• [Symbol]	EXTENT OF VALLEY TRUSS OVERFRAMING @ 24" O.C. (MAX.)
• [Symbol]	EXTENT OF FLOOR SYSTEM TO BE DESIGNED FOR TILE
▶	INDICATES HOLDOWN
HL	METAL HANGER
✱	INDICATES POST ABOVE. PROVIDE SOLID BLOCKING UNDER POST OR JAMB ABOVE.

REFER TO S.O. FOR
TYPICAL STRUCTURAL NOTES
& SCHEDULES

seal: 5/19/25
NORTH CAROLINA
REGISTERED PROFESSIONAL
ENGINEER
SEAL
017622
STALIN KREIDEL
© MULHERN + KULP
Structural Engineering, Inc.

MULHERN+KULP
RESIDENTIAL STRUCTURAL ENGINEERING
3905 Brookside Parkway, Suite 250 • Alpharetta, GA 30022
970-777-8874 • mulhern+kulp.com
NC License # C-3625

Mulhern+Kulp project number:
243-24034



project mgr: SMK
drawn by: SMM/FC
issue date: 11-07-2024

REVISIONS:
date: 05/15/2025 initial: JPP
DESC: ARCH UPDATES


tri pointe
HOMES

UPPER ROOF FRAMING PLAN
5921-08 MODEL
SERENITY
MASTER SET
RALEIGH, NC

sheet:
S4.0M

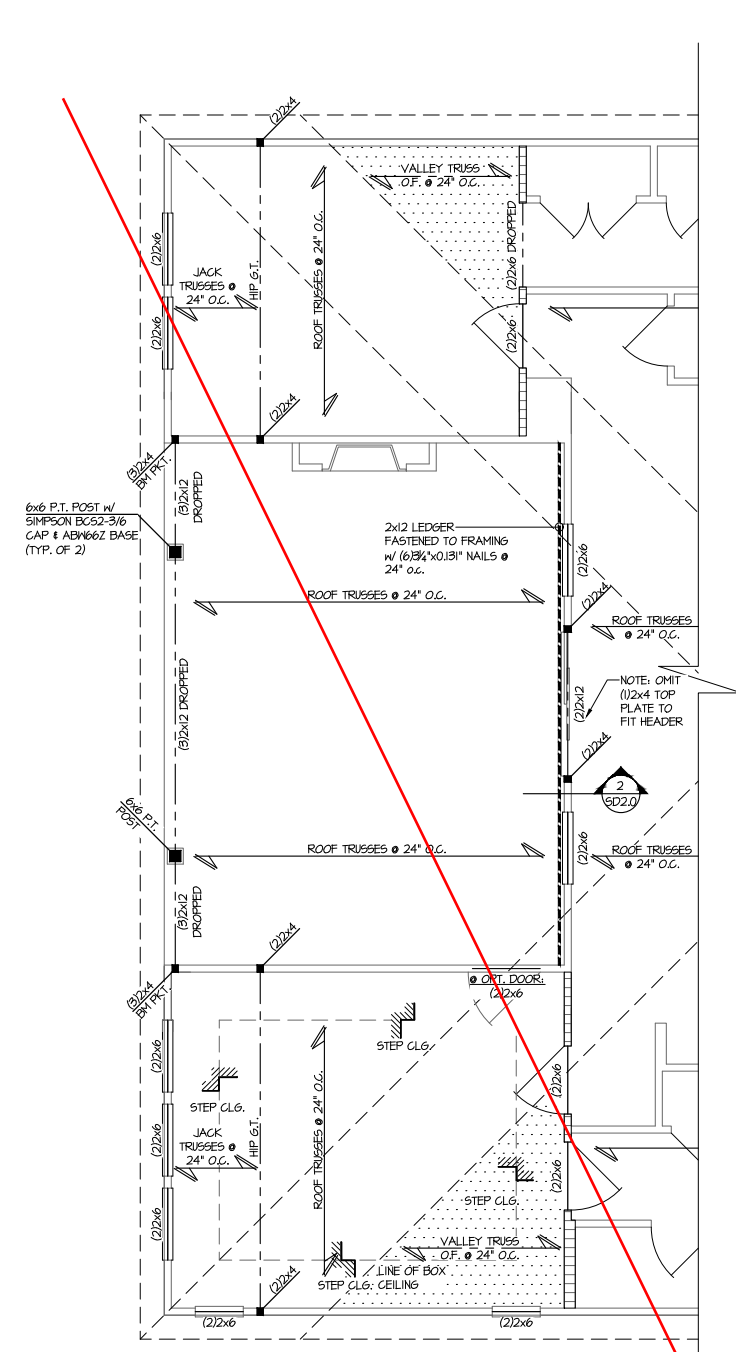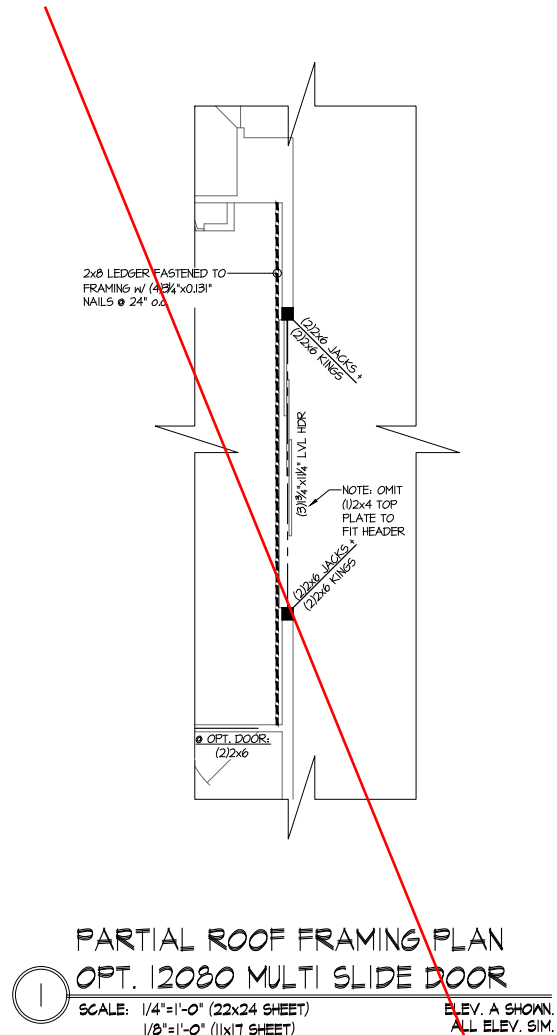

2 PARTIAL ROOF FRAMING PLAN
OPT. EXT. COVERED PORCH
SCALE: 1/4"=1'-0" (22x24 SHEET)
1/8"=1'-0" (11x17 SHEET)
ELEV. A
ALL ELEV. SIM.

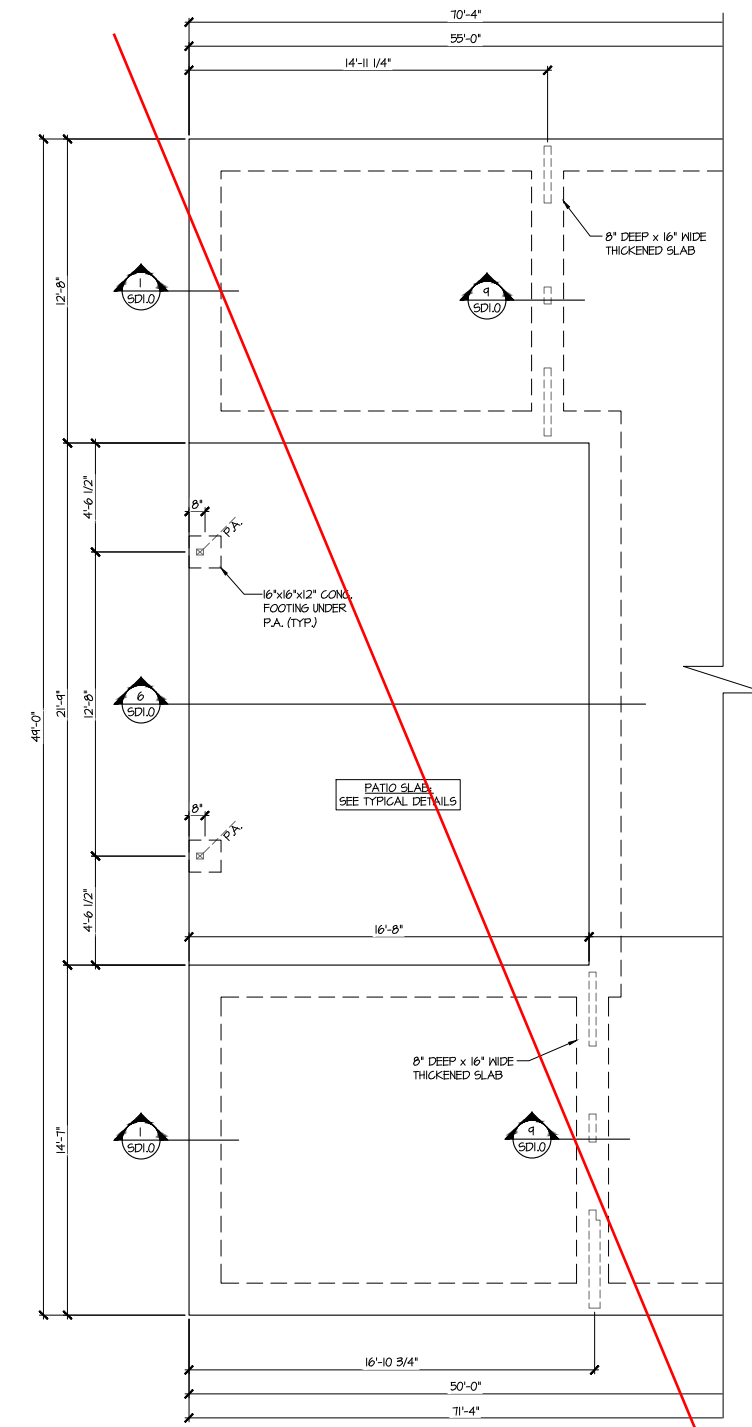

3 PARTIAL SLAB FOUNDATION PLAN
OPT. EXT. COVERED PORCH
SCALE: 1/4"=1'-0" (22x24 SHEET)
1/8"=1'-0" (11x17 SHEET)
ELEV. A
ALL ELEV. SIM.

THIS LEVEL HAS BEEN DESIGNED FOR 9'-1" PLATE HEIGHT

LEGEND

- INTERIOR BEARING WALL
- BEARING WALL ABOVE (B.W.A.)
- BEAM / HEADER
- INDICATES EXTENT OF INT. OSB SHEARWALL AND/OR 3" O.C. EDGE NAILING
- EXTENT OF VALLEY TRUSS OVERFRAMING 24" O.C. (MAX.)
- EXTENT OF FLOOR SYSTEM TO BE DESIGNED FOR TILE
- INDICATES HOLDOWN
- METAL HANGER
- INDICATES POST ABOVE. PROVIDE SOLID BLOCKING UNDER POST OR JAMB ABOVE.







REFER TO S.O. FOR
TYPICAL STRUCTURAL NOTES
& SCHEDULES






REFER TO SO.0 FOR
TYPICAL STRUCTURAL NOTES
& SCHEDULES



5921-08 MODEL
SERENITY
MASTER SET
RALEIGH, NC

S5.1M

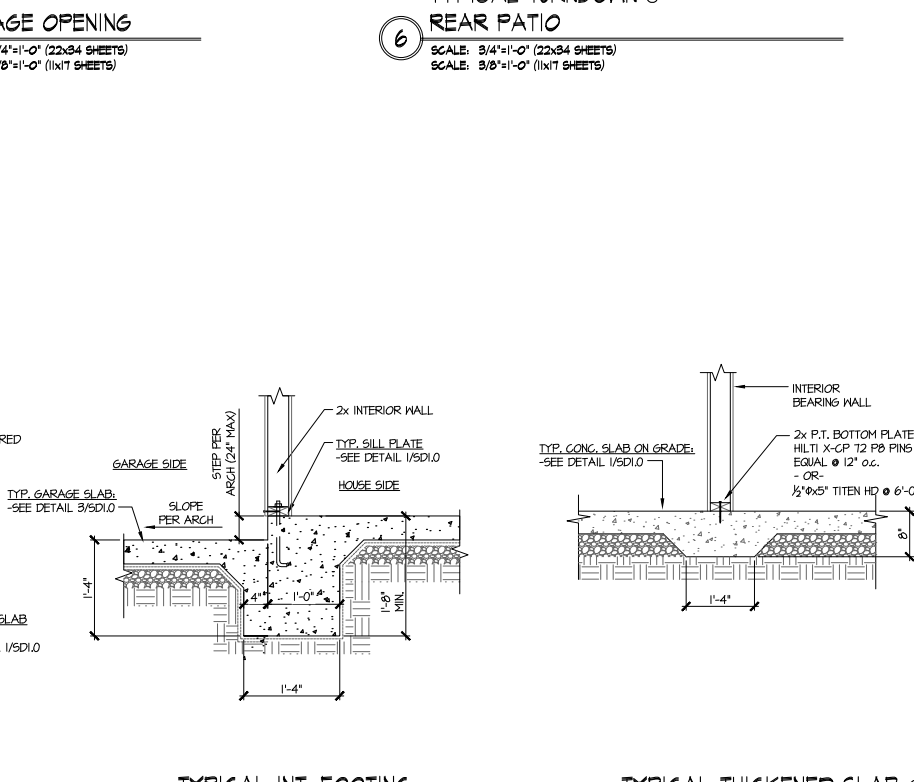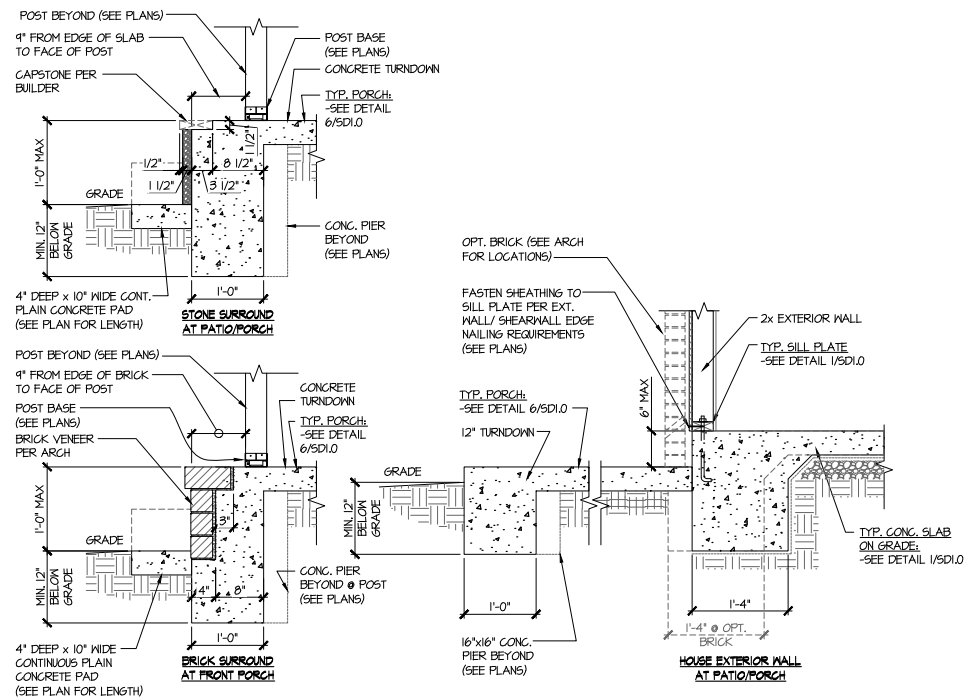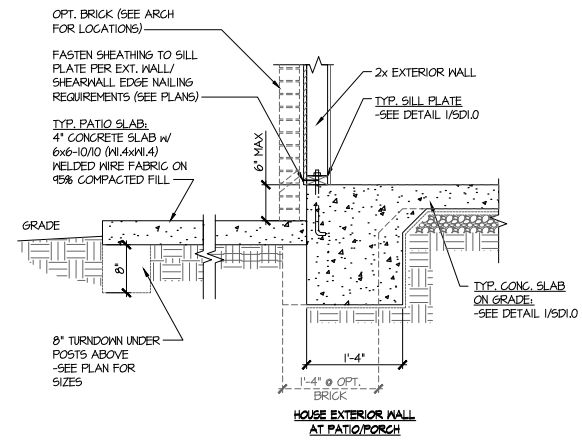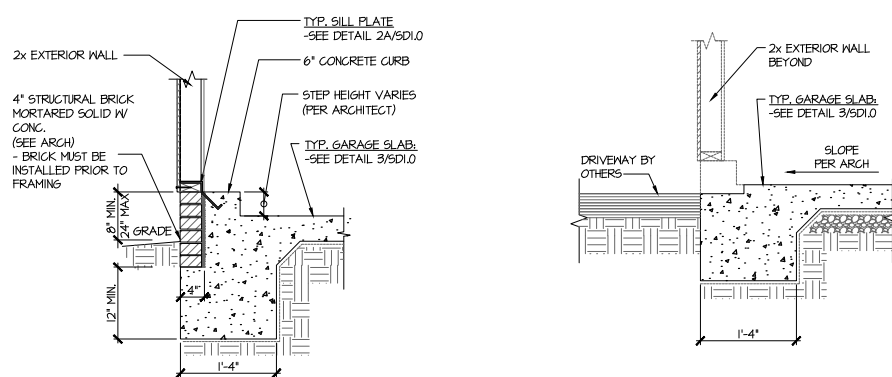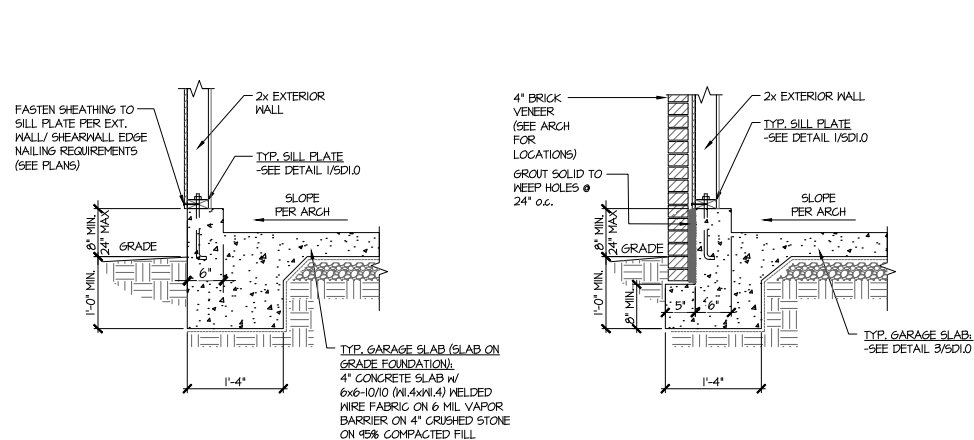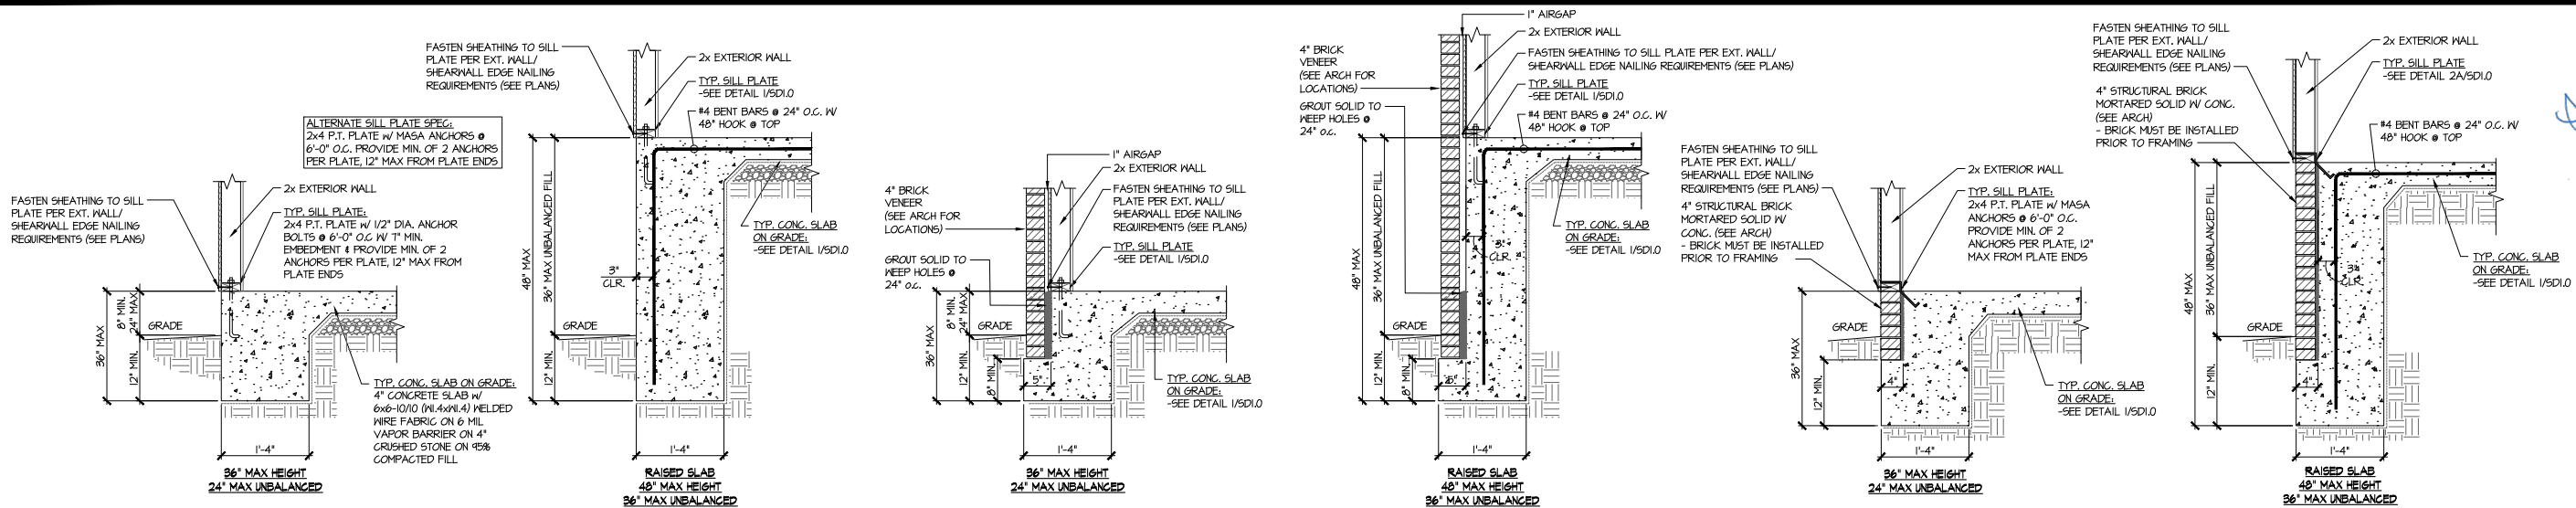


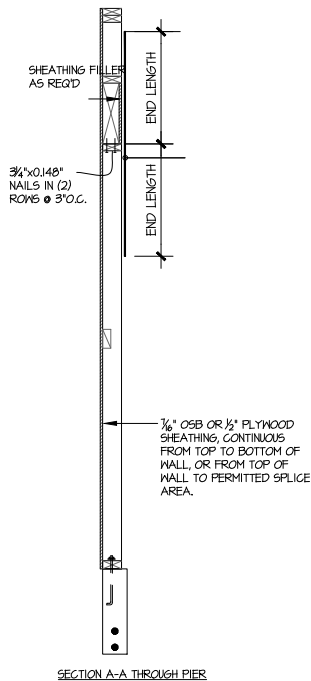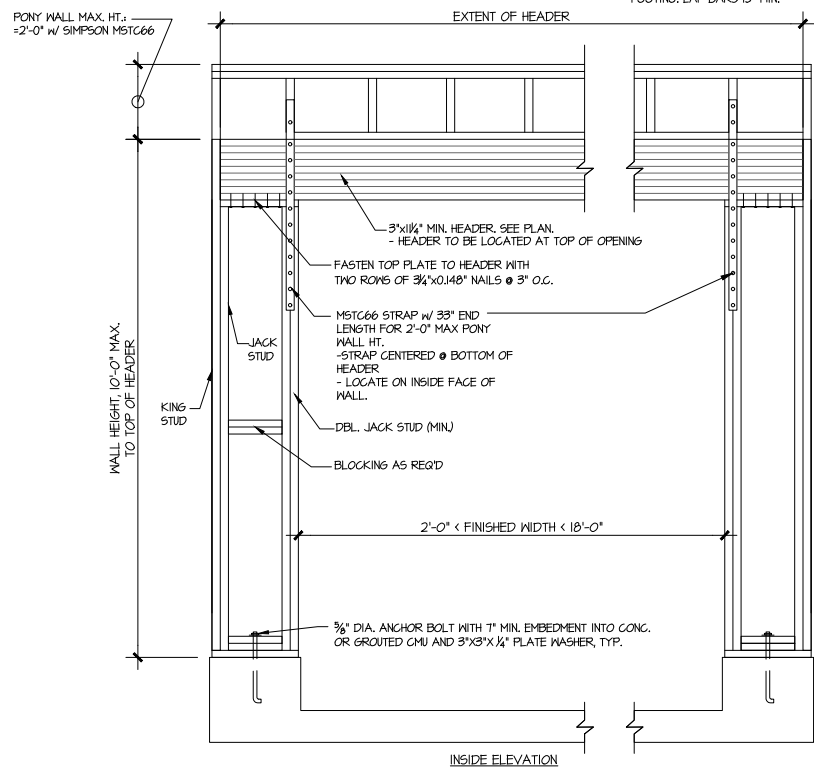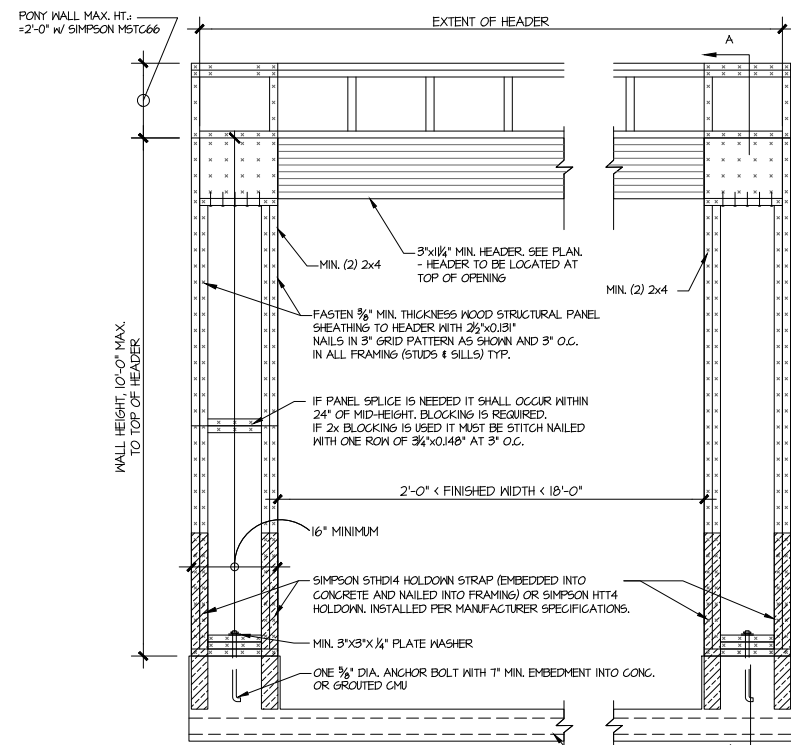


WALL FRAMING SPECIFICATION:
 @ 2x4 WALL: USE HF #2 GRADE STUDS (OR BETTER)
 @ 2x6 WALL: USE SFF #10 GRADE STUDS (OR BETTER)

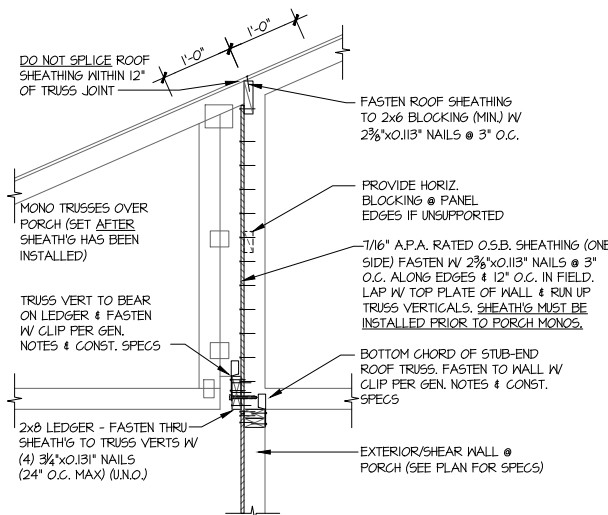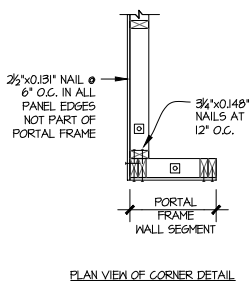

2 SHEAR TRANSFER DETAIL @ BREAK IN TRUSSES OVER SHEAR WALL
 SCALE: 3/4"=1'-0" - 22x34
 3/8"=1'-0" - 11x17



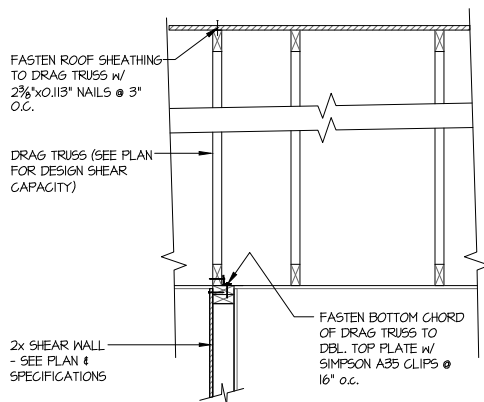


4 DRAG TRUSS DETAIL
 SCALE: 3/4"=1'-0"

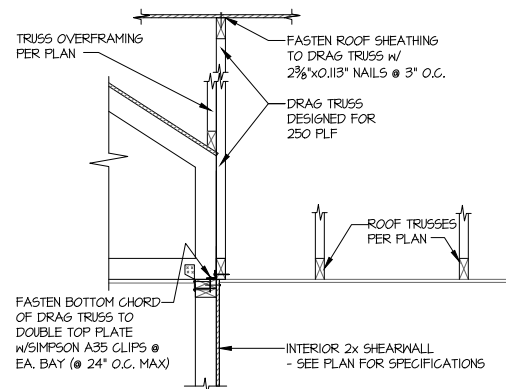


3 SHEAR TRANSFER DETAIL @ INTERIOR SHEARWALL BELOW
 SCALE: 3/4"=1'-0"

1 APA PORTAL FRAME DETAIL WITH HOLDDOWNS
 SCALE: N.T.S. BOTH SIDES OF GARAGE DOOR

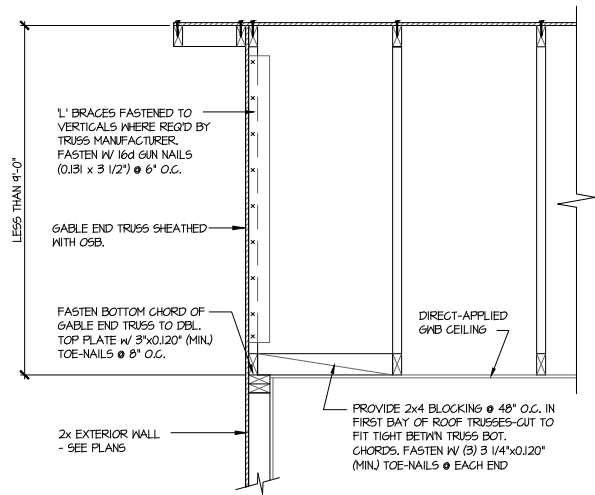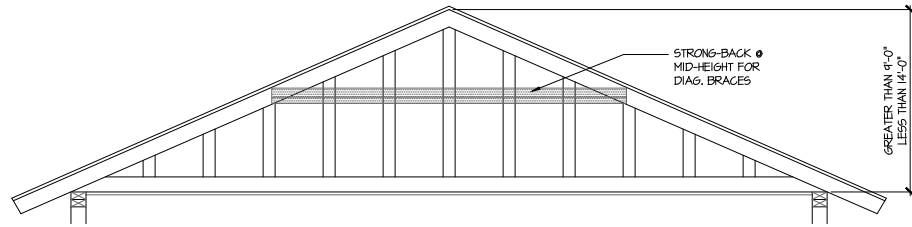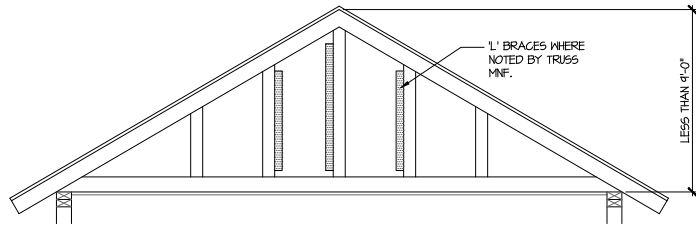

A TYPICAL GABLE END BRACING DETAIL
SCALE: NONE
REQ'D @ GABLE END TRUSS
HEIGHT UP TO 9'-0"

BRACE GABLE END TRUSSES PER ABOVE DETAIL WHEN GABLE HEIGHT IS LESS THAN 9'-0". 1" BRACES REQUIRED WHERE NOTED BY TRUSS MANUFACTURER.

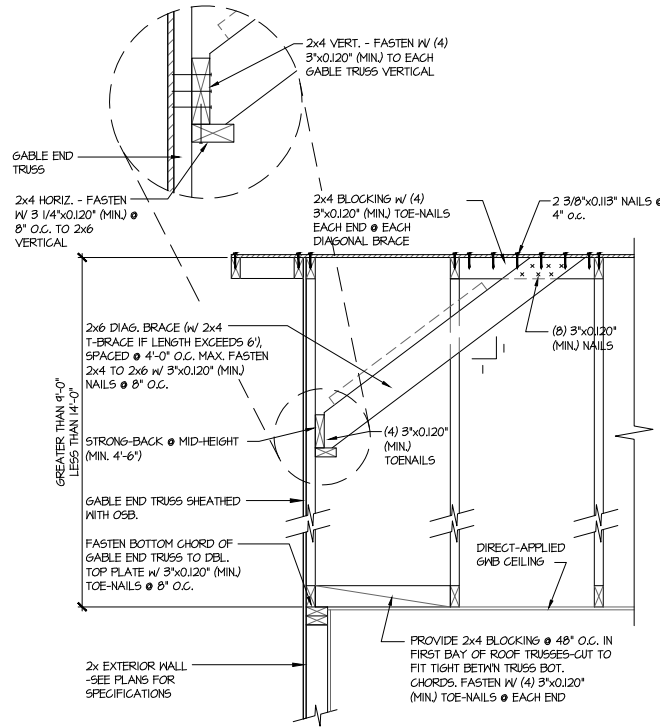

B TYPICAL GABLE END BRACING DETAIL
SCALE: NONE
REQ'D @ GABLE END TRUSS
HEIGHT BETWEEN 9'-0" TO 14'-0"

BRACE GABLE END TRUSSES PER ABOVE DETAIL WHEN GABLE HEIGHT EXCEEDS 9'-0". 1" BRACES NOT REQUIRED.



MULHERN+KULP
RESIDENTIAL STRUCTURAL ENGINEERING

3855 Brookside Parkway, Suite 250 - Alpharetta, GA 30022
970-777-8874 • mulhern+kulp.com
NC License # C-3825

Mulhern+Kulp project number:
243-24034

project mgr: **SMK**
drawn by: **SMM/FC**
issue date: **11-07-2024**

REVISIONS:	
date:	initial:
05/15/2025	JFP
MISC. ARCH UPDATES	



FRAMING DETAILS

5921-08 MODEL
SERENITY
MASTER SET
RALEIGH, NC

sheet:
SD2.1