

Residence for

Adams Homes AEC, LLC

Plan 2604 "A" FE (R) KC057

GENERAL NOTES:

- ALL WORK IS TO BE DONE IN STRICT ACCORDANCE WITH NORTH CAROLINA STATE RESIDENTIAL BUILDING CODE, 2018 EDITION (HEREIN SHOWN AS N.C.S.R.B.C.).
- DIMENSIONS SHOWN ON DRAWINGS GOVERN OVER SCALE.
- STUD WALL DESIGN SHALL CONFORM TO ALL N.C.S.R.B.C. REQUIREMENTS.
- CONTRACTOR SHALL USE TEMPERED SAFETY GLASS IN ALL LOCATIONS AS REQUIRED BY N.C.S.R.B.C., SECTION R308.4
- ANY HABITABLE ROOM SHALL MEET ALL LIGHT/VENTILATION AND EGRESS AS REQUIRED BY N.C.S.R.B.C., SECTIONS R-303.1 AND R-310.1
- ALL WALLS SHOWN ON FLOOR PLANS ARE 2x4 FRAME UNLESS NOTED OTHERWISE.
- ALL ANGLED WALLS SHOWN ON FLOOR PLANS ARE 45° UNLESS NOTED OTHERWISE.
- ALL WINDOWS SHALL HAVE A MINIMUM DPI RATING OF 25. BUILDER SHALL VERIFY WITH WINDOW MANUFACTURER THAT UNITS INSTALLED MEET THESE REQUIREMENTS AS PER N.C.S.R.B.C., TABLE 301.2(6).
- ENERGY EFFICIENCY REQUIREMENTS FOR THE SPECIFIC CLIMATE ZONE WHERE STRUCTURE IS BEING BUILT SHALL BE IN ACCORDANCE WITH CHAPTER 11 OF THE NORTH CAROLINA RESIDENTIAL BUILDING CODE, AS SHOWN IN TABLES N1101.2 AND N1102.1.
- TERMITE TREATMENT - BORATE APPLIED TO ALL FRAME MEMBERS WITHIN 24" AFF.

INDEX TO DRAWINGS:

- COVER SHEET
- FRONT AND LEFT SIDE ELEVATIONS
 - REAR AND RIGHT SIDE ELEVATIONS
 - BASEMENT PLAN
 - FIRST FLOOR PLAN
 - SECOND FLOOR PLAN
 - BASEMENT ELECTRICAL PLAN
 - FIRST FLOOR ELECTRICAL PLAN
 - SECOND FLOOR ELECTRICAL PLAN
 - FLOOR PLAN OPTIONS
 - REAR PORCH OPTION
 - CONSTRUCTION DETAILS
- S1.0 BASEMENT FOUNDATION PLAN
S1.1 BASEMENT FRAMING PLAN
S2 FIRST FLOOR CEILING FRAMING PLAN
S3 SECOND FLOOR CEILING FRAMING PLAN
S4 ROOF FRAMING PLAN
SD1 STRUCTURAL DETAILS
SPEC STRUCTURAL SPECIFICATIONS
S7 PLAN OPTIONS

RESIDENTIAL BUILDING CODE SUMMARY

- PLANS ARE DESIGNED TO THE 2018 NORTH CAROLINA RESIDENTIAL BUILDING CODE.
- HOUSE IS DESIGNED FOR 120 MPH, 3 SECOND GUST (93 MPH FASTEST WIND), EXPOSURE B.
- ANCHOR BOLTS SHALL BE MIN. 1/2" DIAMETER WITH STANDARD WASHER AND NUT AND SHALL EXTEND 7" MIN. INTO MASONRY OR CONCRETE. BOLTS TO BE NO MORE THAN 6' O.C. AND WITHIN 12" OF CORNERS. ALTERNATE ANCHOR STRAPS CAN BE USED INSTEAD OF ANCHOR BOLTS SPACED AT THE EQUIVALENT SPACING AND INSTALLED PER MANUFACTURER'S SPECIFICATION'S EXCEPT AT GARAGE LUG FTG.
- MEAN ROOF HEIGHT: 17'-6"
- COMPONENT & CLADDING DESIGNED FOR THE FOLLOWING LOADS:
MEAN ROOF HGT: UP TO 30' 30'-1" TO 35' 35'-1" TO 40' 40'-1" TO 45'
ZONE 1 16.5, -18.0 17.3, -18.9 18.0, -19.6 18.5, -20.2
ZONE 2 16.5, -21.0 17.3, -22.1 18.0, -22.9 18.5, -23.5
ZONE 3 16.5, -21.0 17.3, -22.1 18.0, -22.9 18.5, -23.5
ZONE 4 18.0, -19.5 18.9, -20.5 19.6, -21.3 20.2, -21.8
ZONE 5 18.0, -24.1 18.9, -25.3 19.6, -26.3 20.2, -27.0
- MINIMUM VALUES FOR ENERGY COMPLIANCE: ZONE 4
- MAXIMUM GLAZING U-FACTOR: 0.35
- INSULATING VALUES: CEILING: R-30* / WALLS: R-15 / FLOOR: R-19 / SLABS: R-10. CODE REFERENCE: TABLE N1102.1 (*R-30 ONLY IF UNCOMPRESSED, R-38 REQUIRED IF COMPRESSED)
- FLASHING SHALL BE INSTALLED IN ACCORDANCE WITH SECTION R703.8 OF THE N.C.R.B.C.
- FIREBLOCKING SHALL BE INSTALLED IN ACCORDANCE WITH SECTION R602.8 OF THE N.C.R.B.C.
- DRAFTSTOPPING SHALL BE INSTALLED IN ACCORDANCE WITH SECTION R302.12 OF THE N.C.R.B.C.

AREA CALCULATIONS

BASEMENT:	1274	GARAGE:	533
1ST FLOOR:	1987	FRONT PORCH:	68
2ND FLOOR:	617	DECK:	140
TOTAL:	3878	TOTAL:	741

WIDTH:	49'-0"	UNF. BASEMENT:	649
DEPTH:	55'-10"	LOWER PATIO:	140
		COV. PORCH OPTION:	224

FOUNDATION VENTING CALCULATIONS

NOT NEEDED WITH SLAB FOUNDATION

ATTIC VENTILATION REQUIREMENTS

NATURAL ROOF VENTILATION	MECHANICAL ROOF VENTILATOR
2500 SQ. FT.	2500 SQ. FT.
150 = 17.25 SQ. FT. VENT REQ'D	300 = 8.63 SQ. FT. VENT REQ'D
BUILDER TO PROVIDE APPROPRIATE VENTILATING AS REQUIRED PER CODE	

MATERIALS LEGEND


	EARTH/COMPACT FILL		FINISH WOOD
	CONCRETE		ROUGH WOOD
	BRICK		BLOCKING
	CONCRETE BLOCK/STONE		PLYWOOD
	STEEL		BATT INSULATION
	ALUMINUM		RIGID INSULATION

TOILET ACCESSORIES LEGEND

PROVIDE 2x4 BLOCKING IN THE WALL FOR THE FOLLOWING:

TB	TOWEL BAR
TP	TOILET PAPER HOLDER
TR	TOWEL RING
MC	MEDICINE CABINET
MR	MAGAZINE RACK


THE PURPOSE OF THESE DRAWINGS IS TO SHOW THE INTENT OF THE DESIGN AND CONSTRUCTION OF THIS HOME. ANY ERRORS AND/OR OMISSIONS FOUND IN THIS SET SHOULD IMMEDIATELY BE REPORTED TO ADAMS HOMES FOR CLARIFICATION OR CORRECTION. THE CONTRACTOR SHOULD VERIFY ALL CONDITIONS AND DIMENSIONS PRIOR TO CONSTRUCTION.

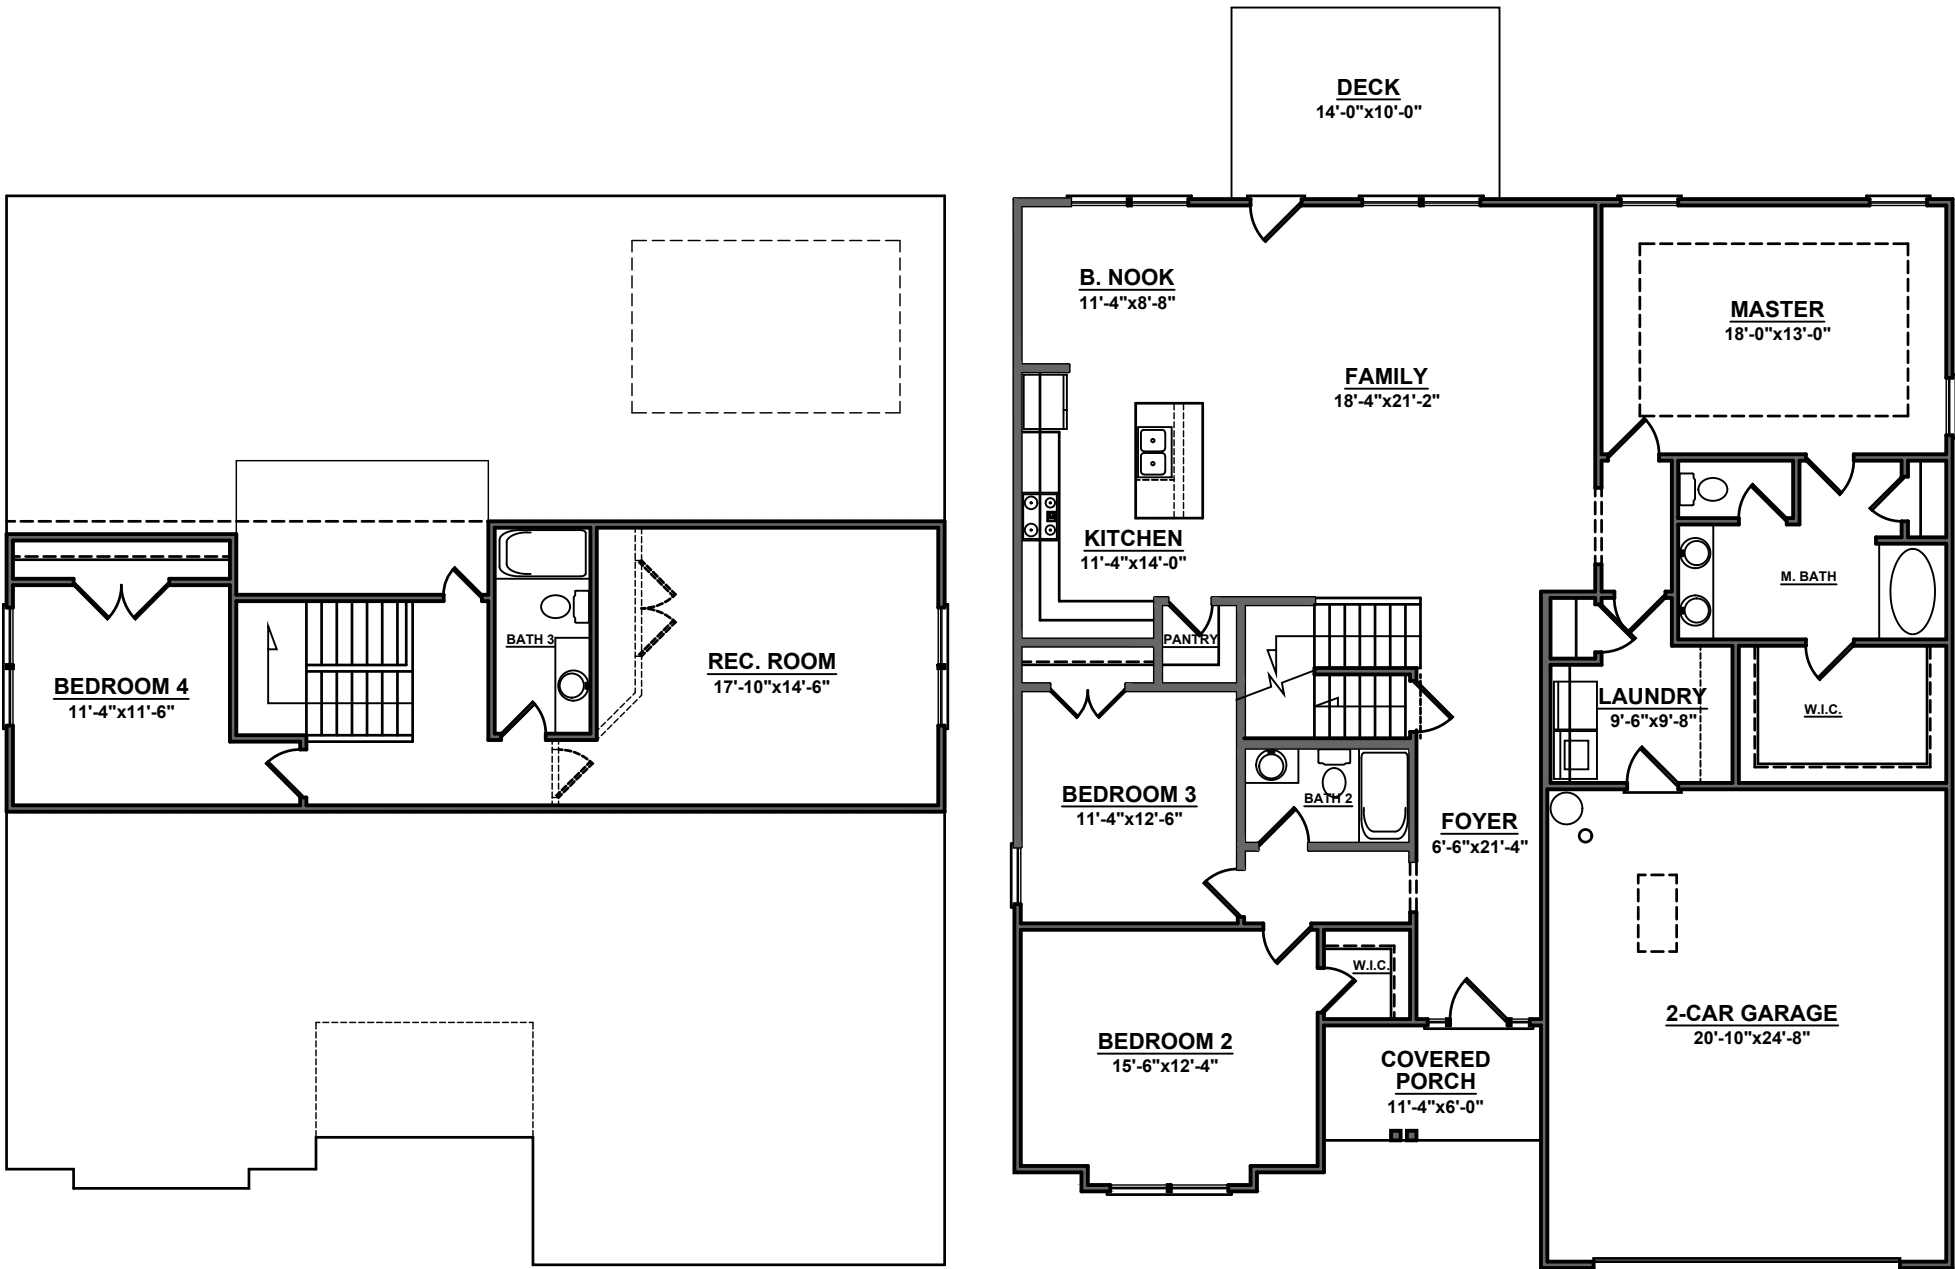


HOMES

AEC, LLC

7592


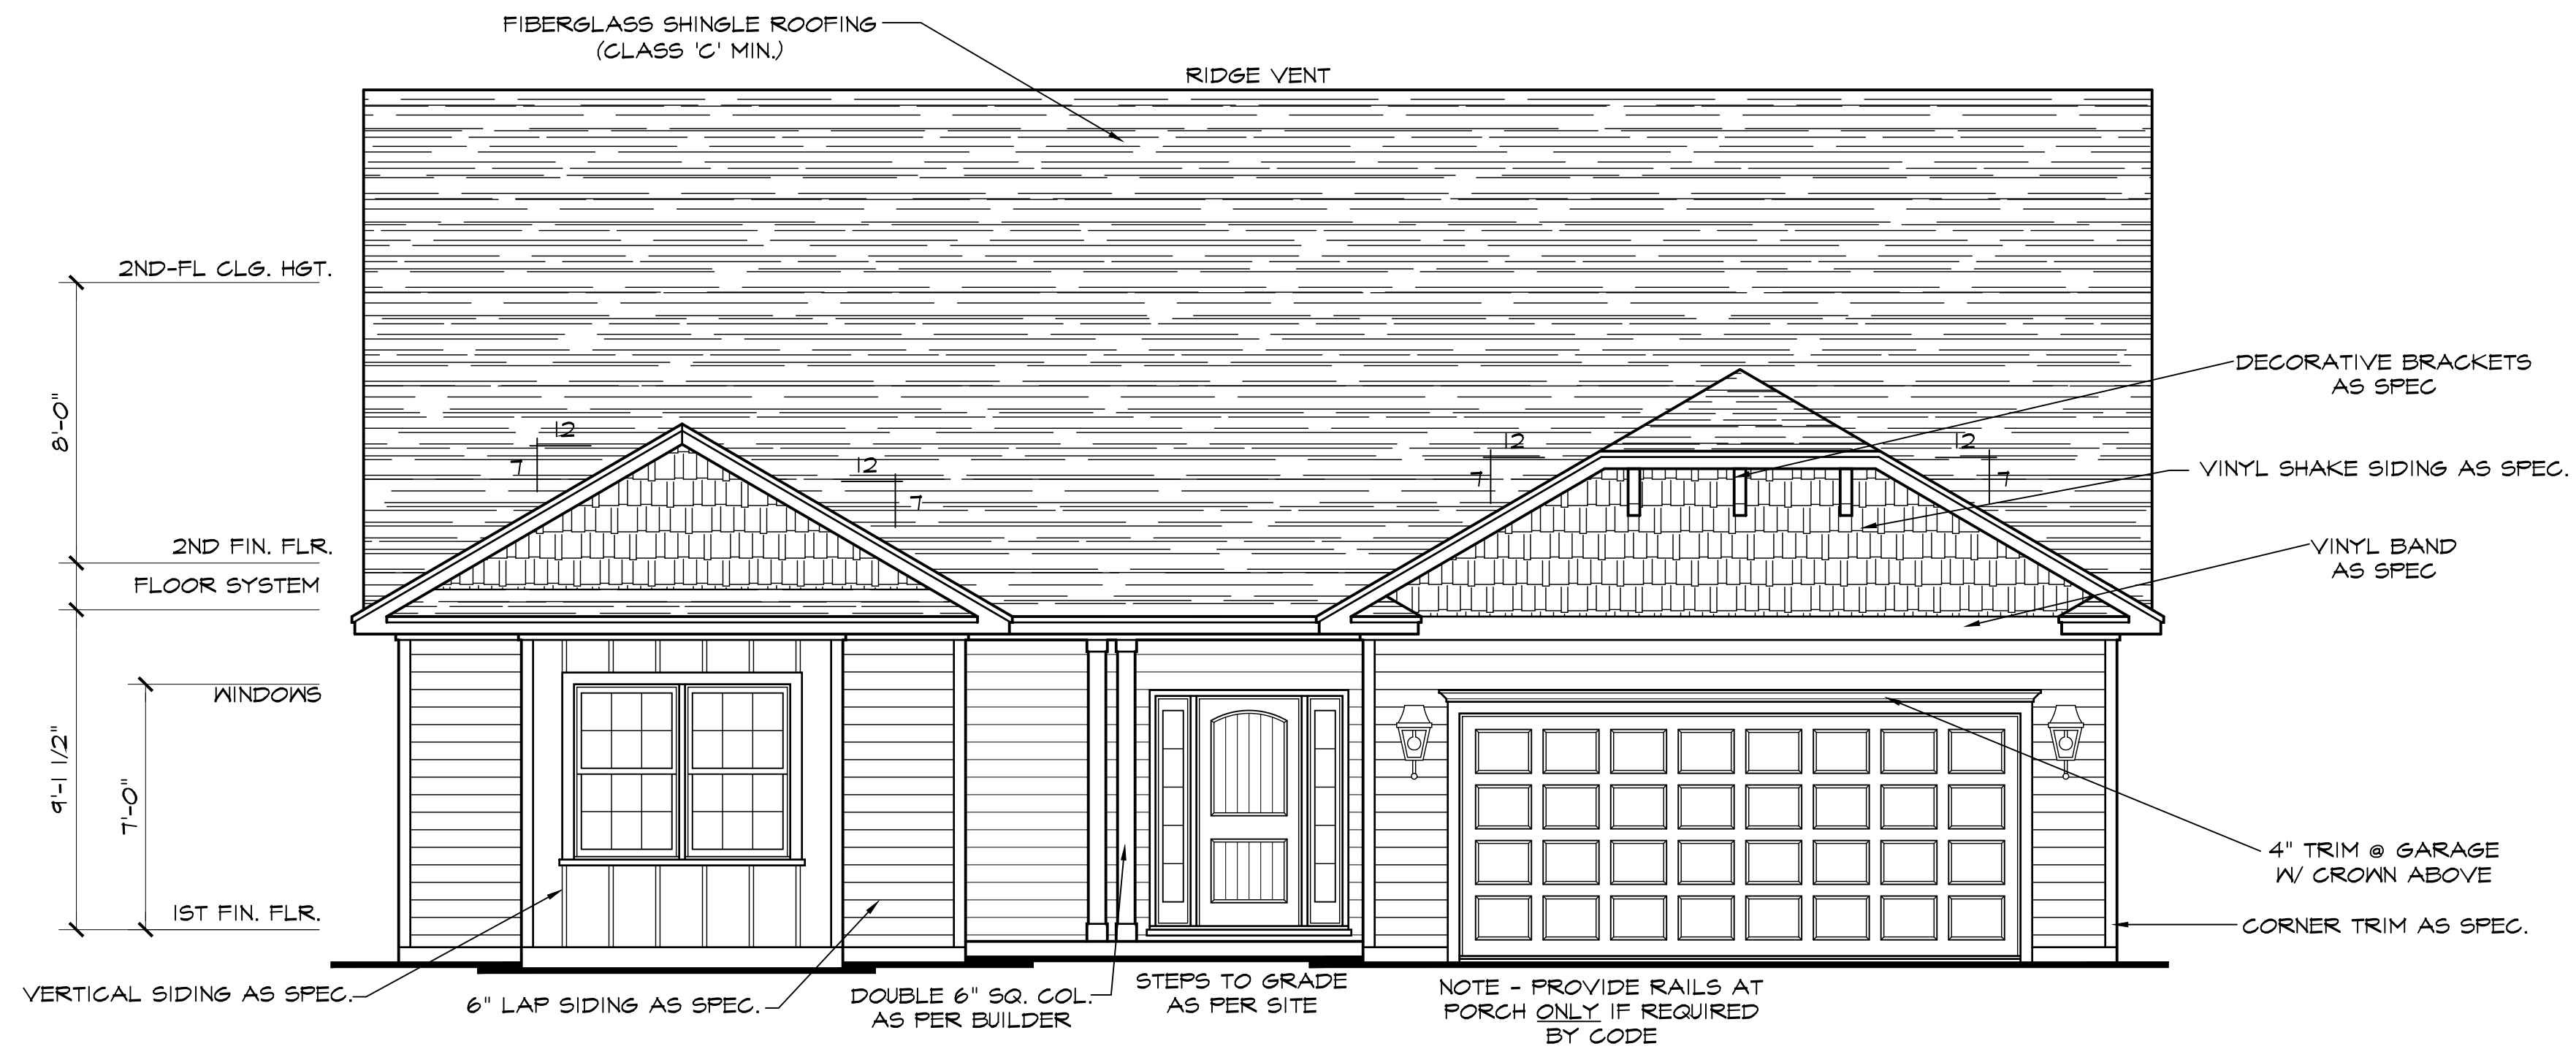


FRONT ELEVATION A SCALE: 1/4"=1'-0"
NOTE - SLOPE ALL GRADES AWAY FROM HOUSE FOR POSITIVE DRAINAGE

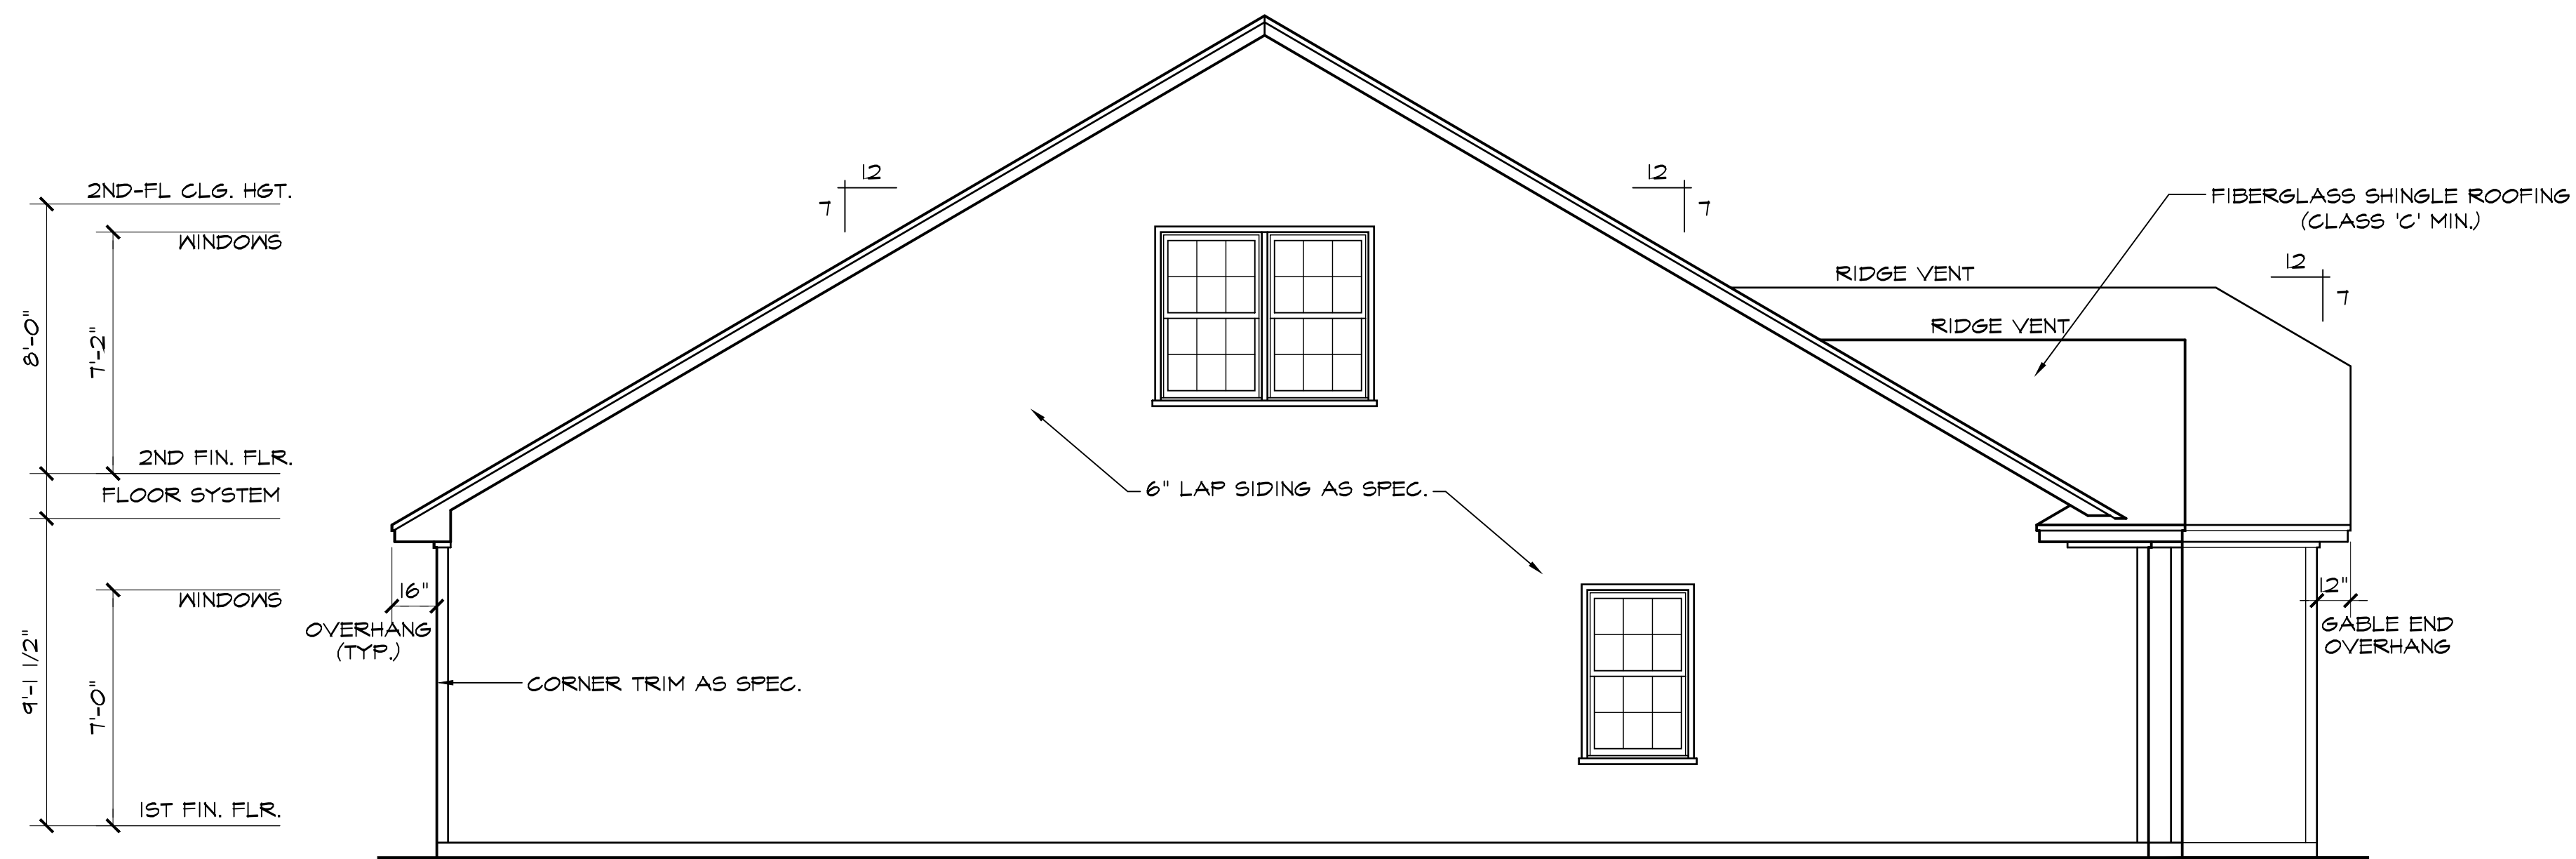

LEFT SIDE ELEVATION SCALE: 1/4"=1'-0"


DATE DRAWN
5/1/2025
PROJECT
7592
REVISIONS

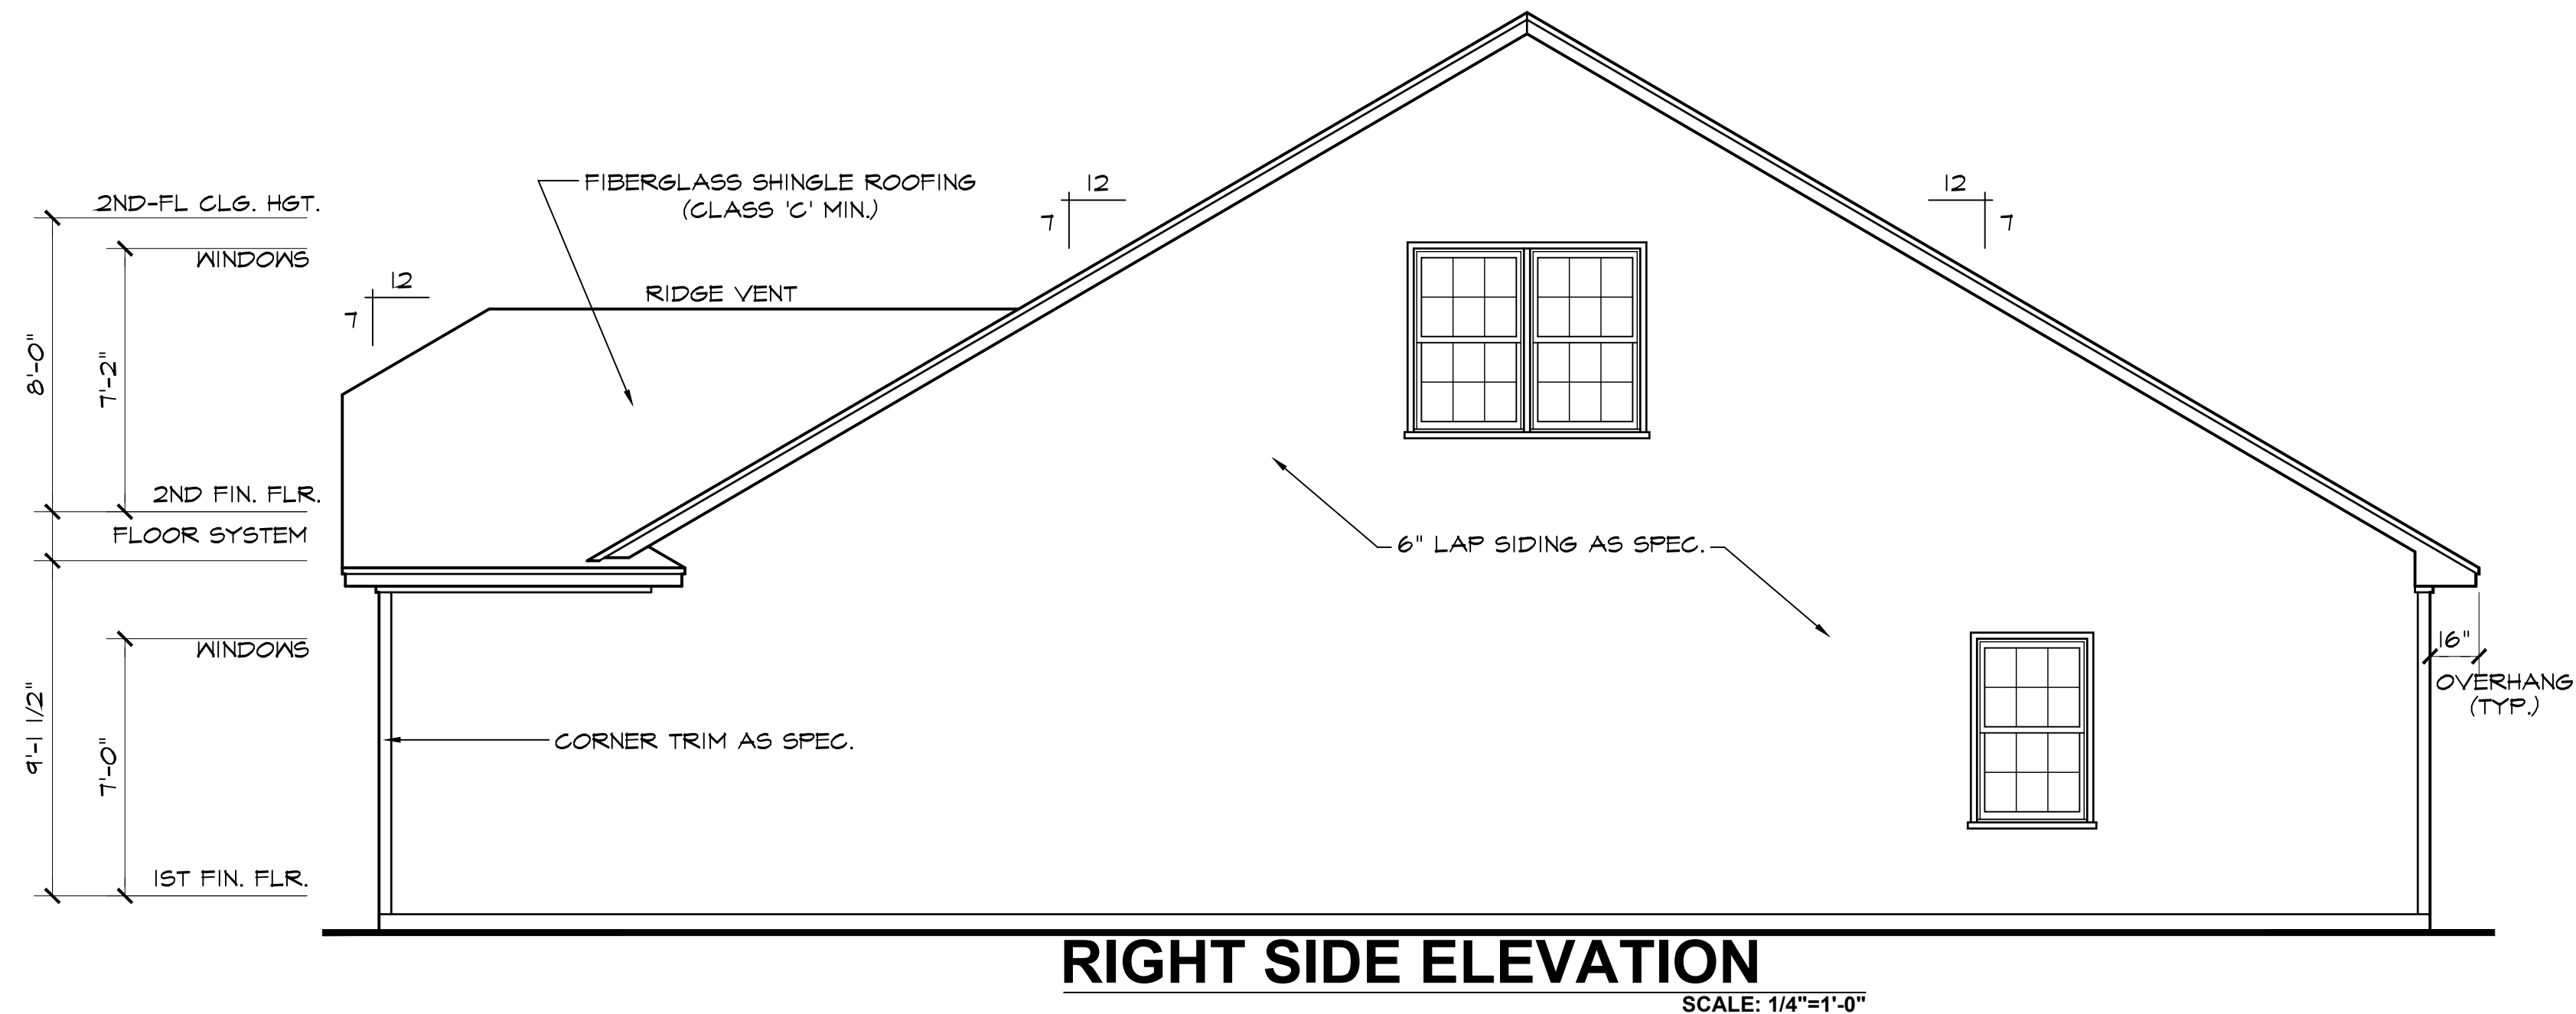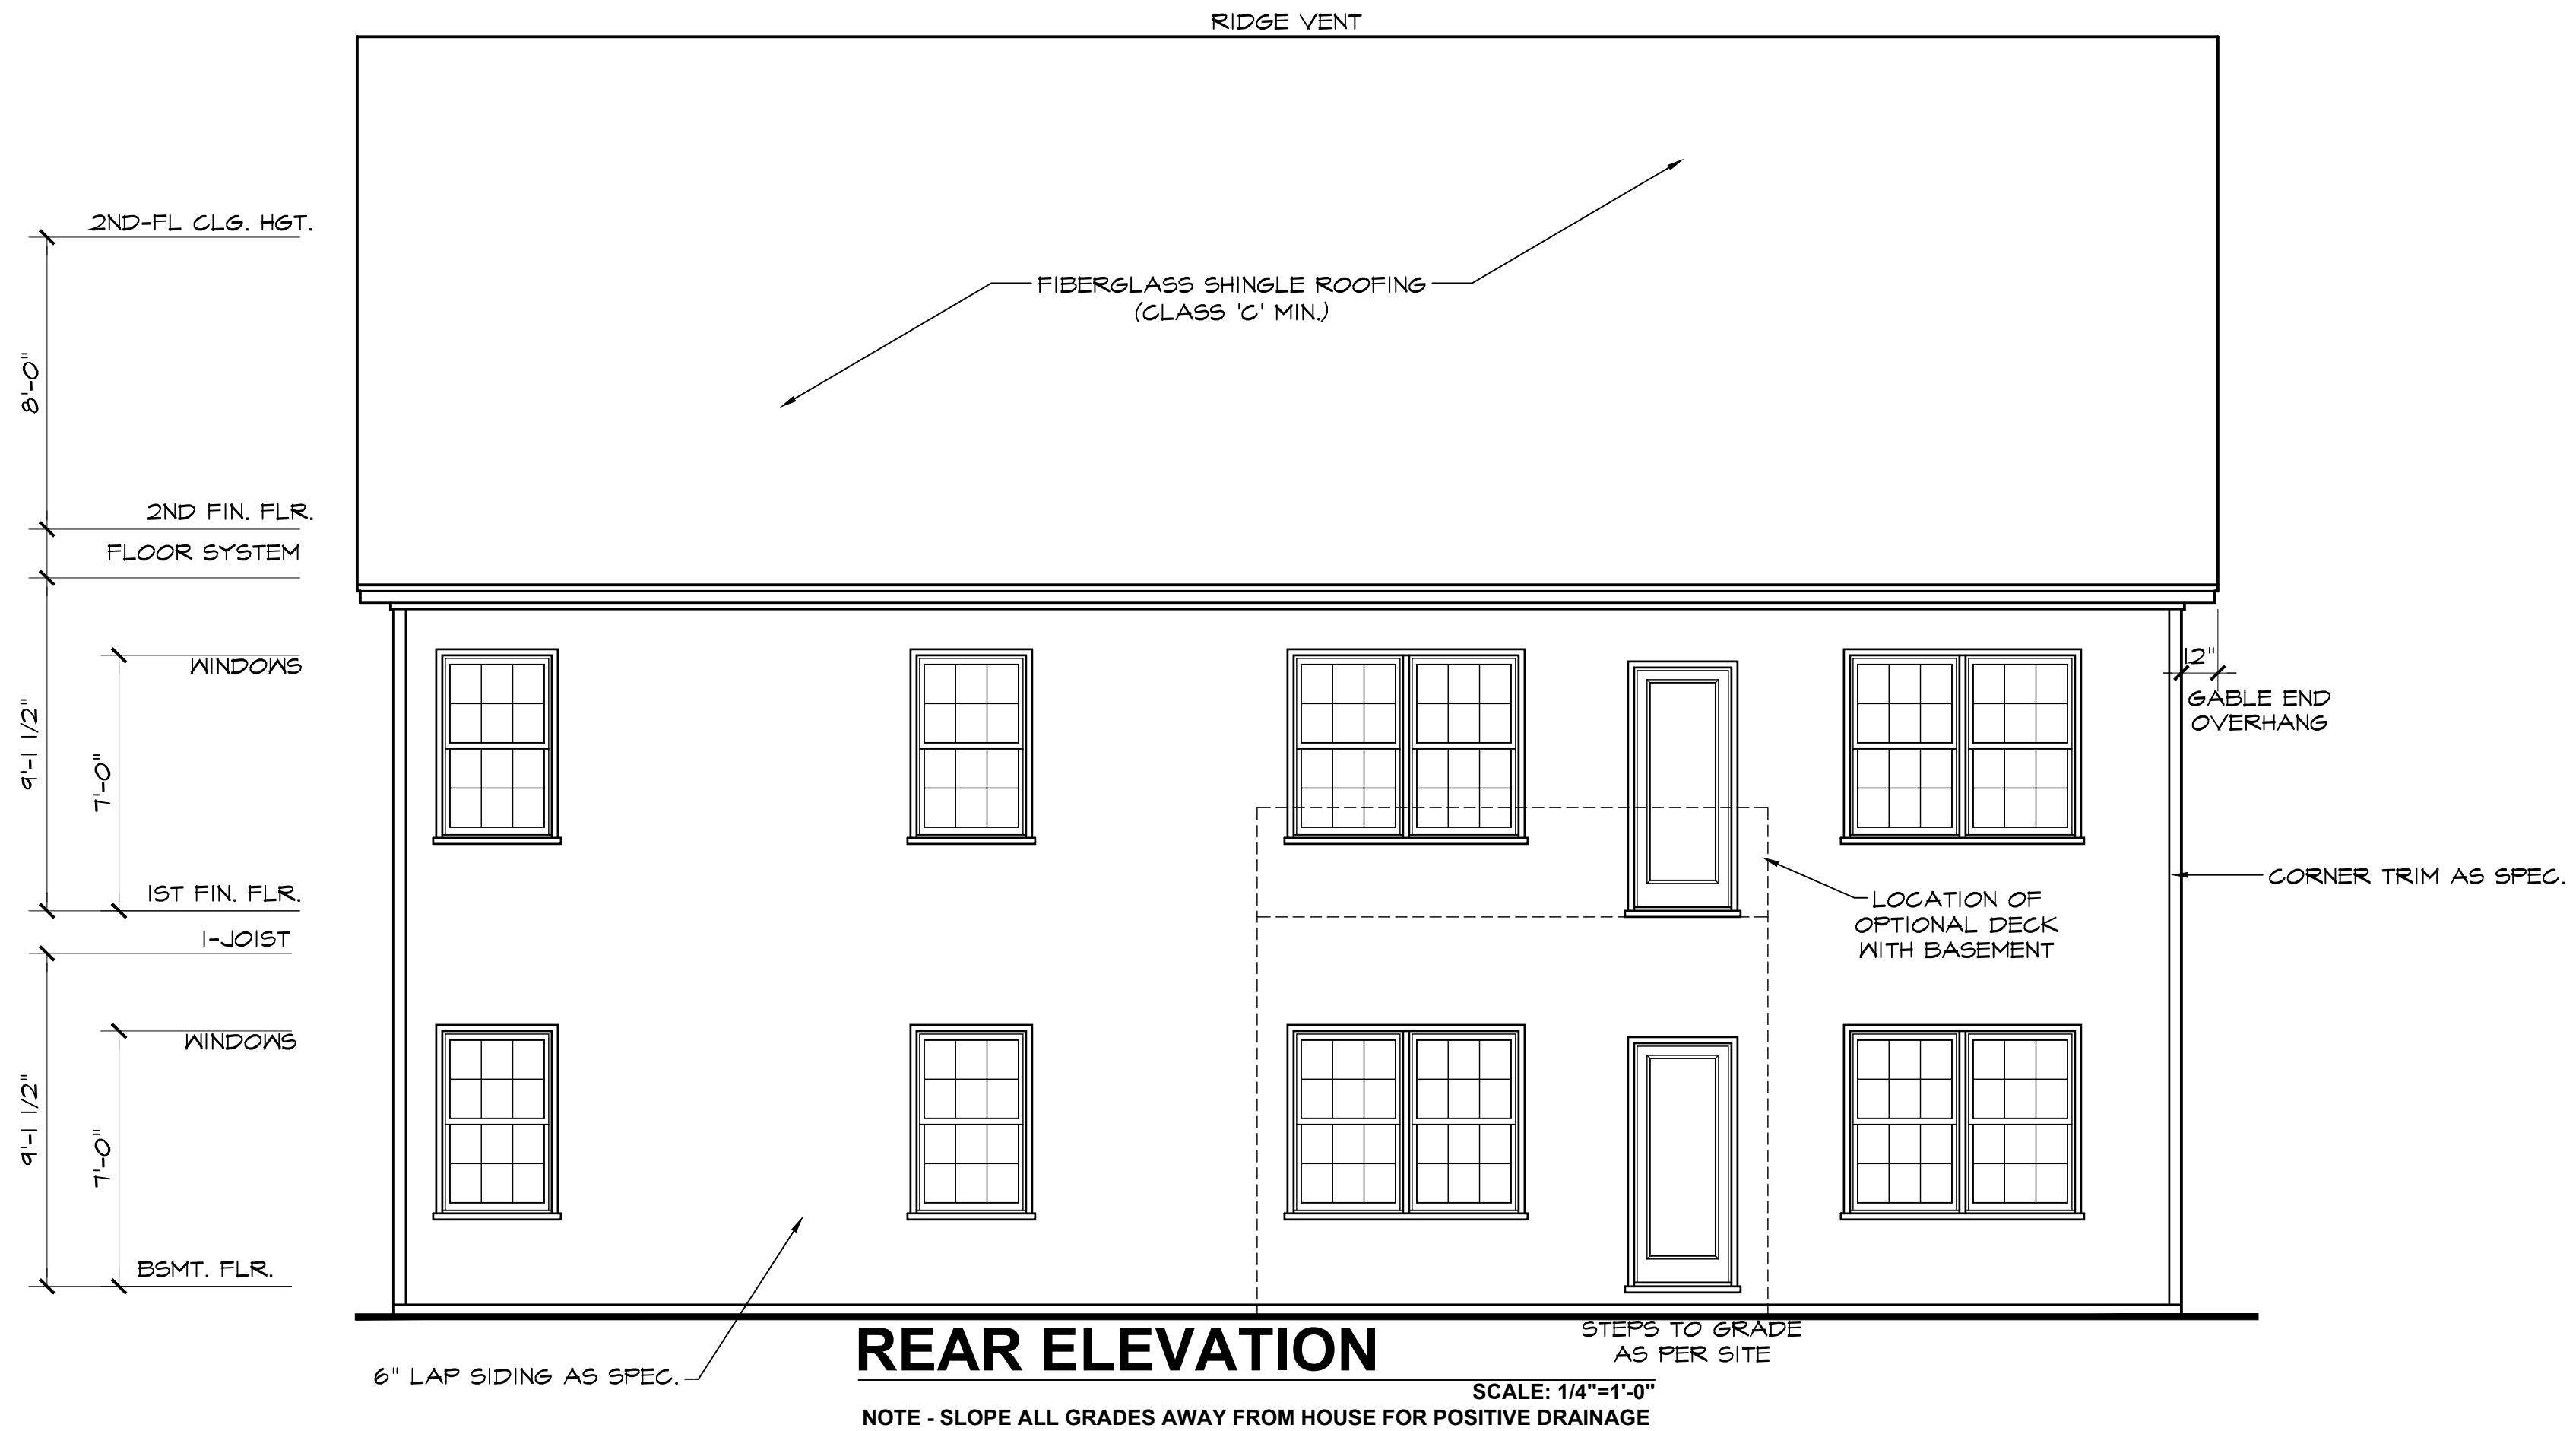

2604 "A" FE (R) KC057

DATE DRAWN
5/1/2025
PROJECT
7592
REVISIONS



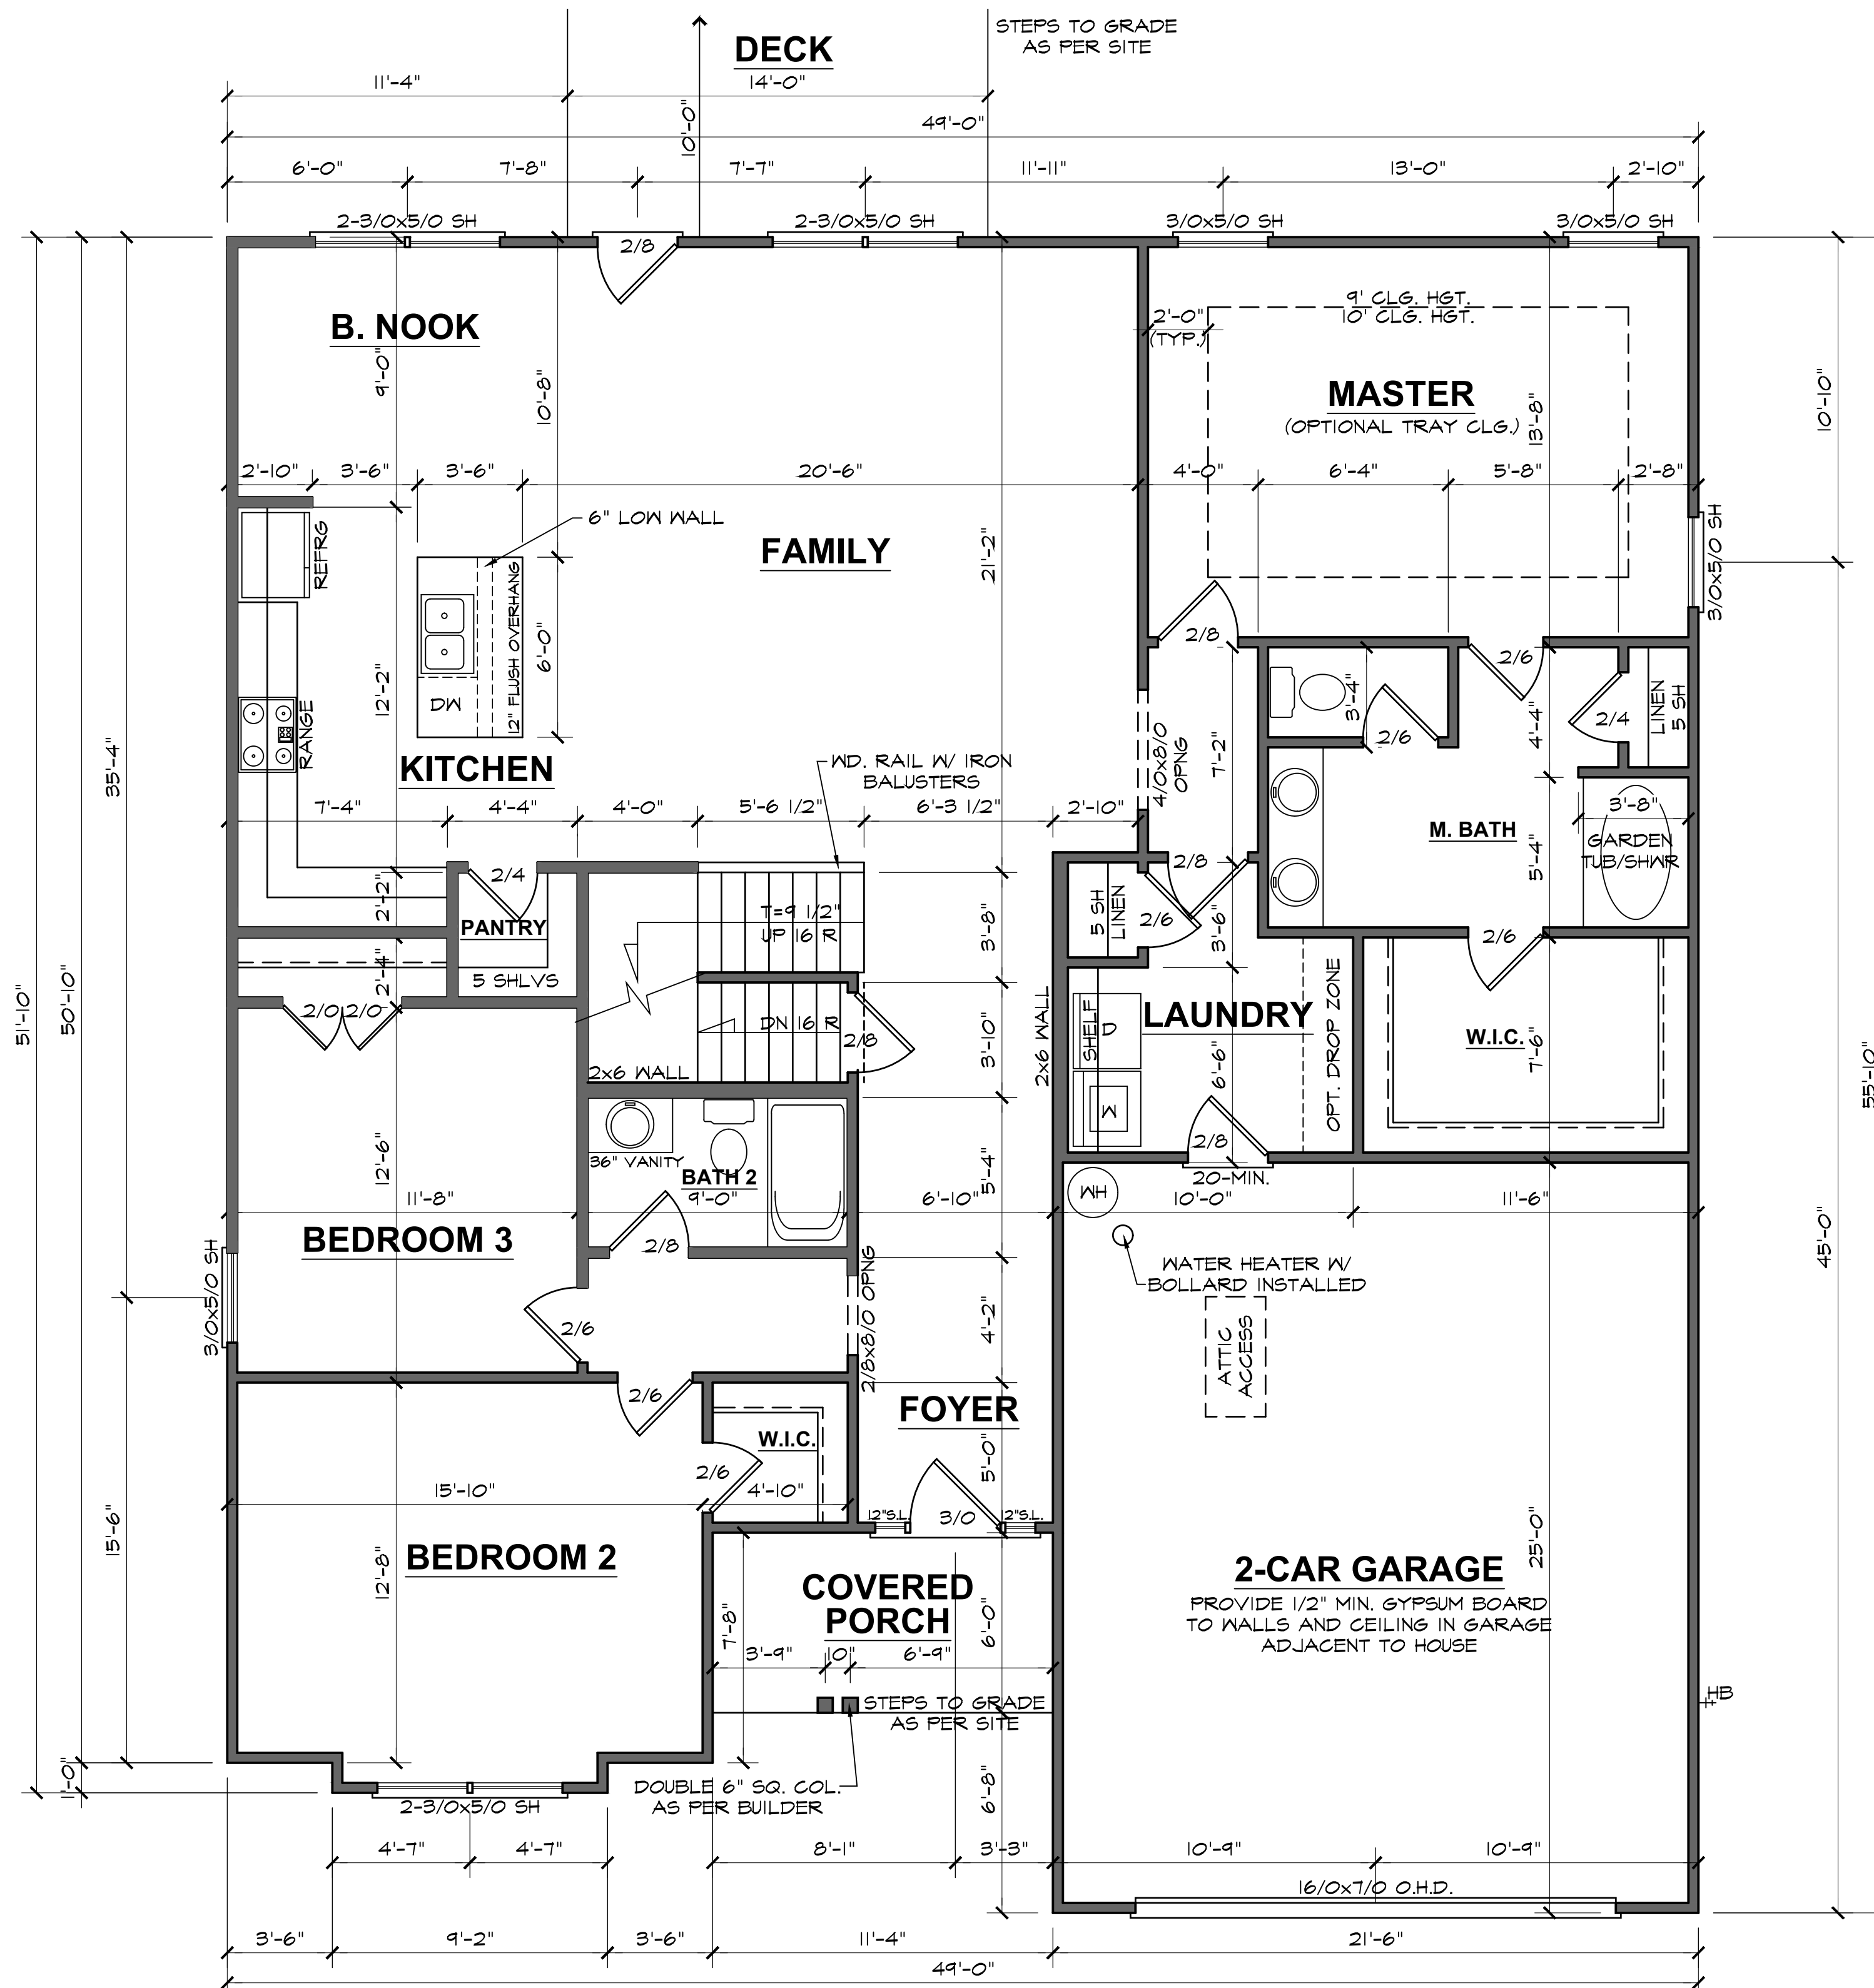

FIRST FLOOR PLAN
9'-0" (NOM.) CLG. HGT. U.N.O. SCALE: 1/4"=1'-0"
SET WINDOWS @ 7'-0" U.N.O.

2604 "A" FE (R) KC057


DATE DRAWN
5/1/2025
PROJECT
7592
REVISIONS



SHEET

2604 "A" FE (R) KC057



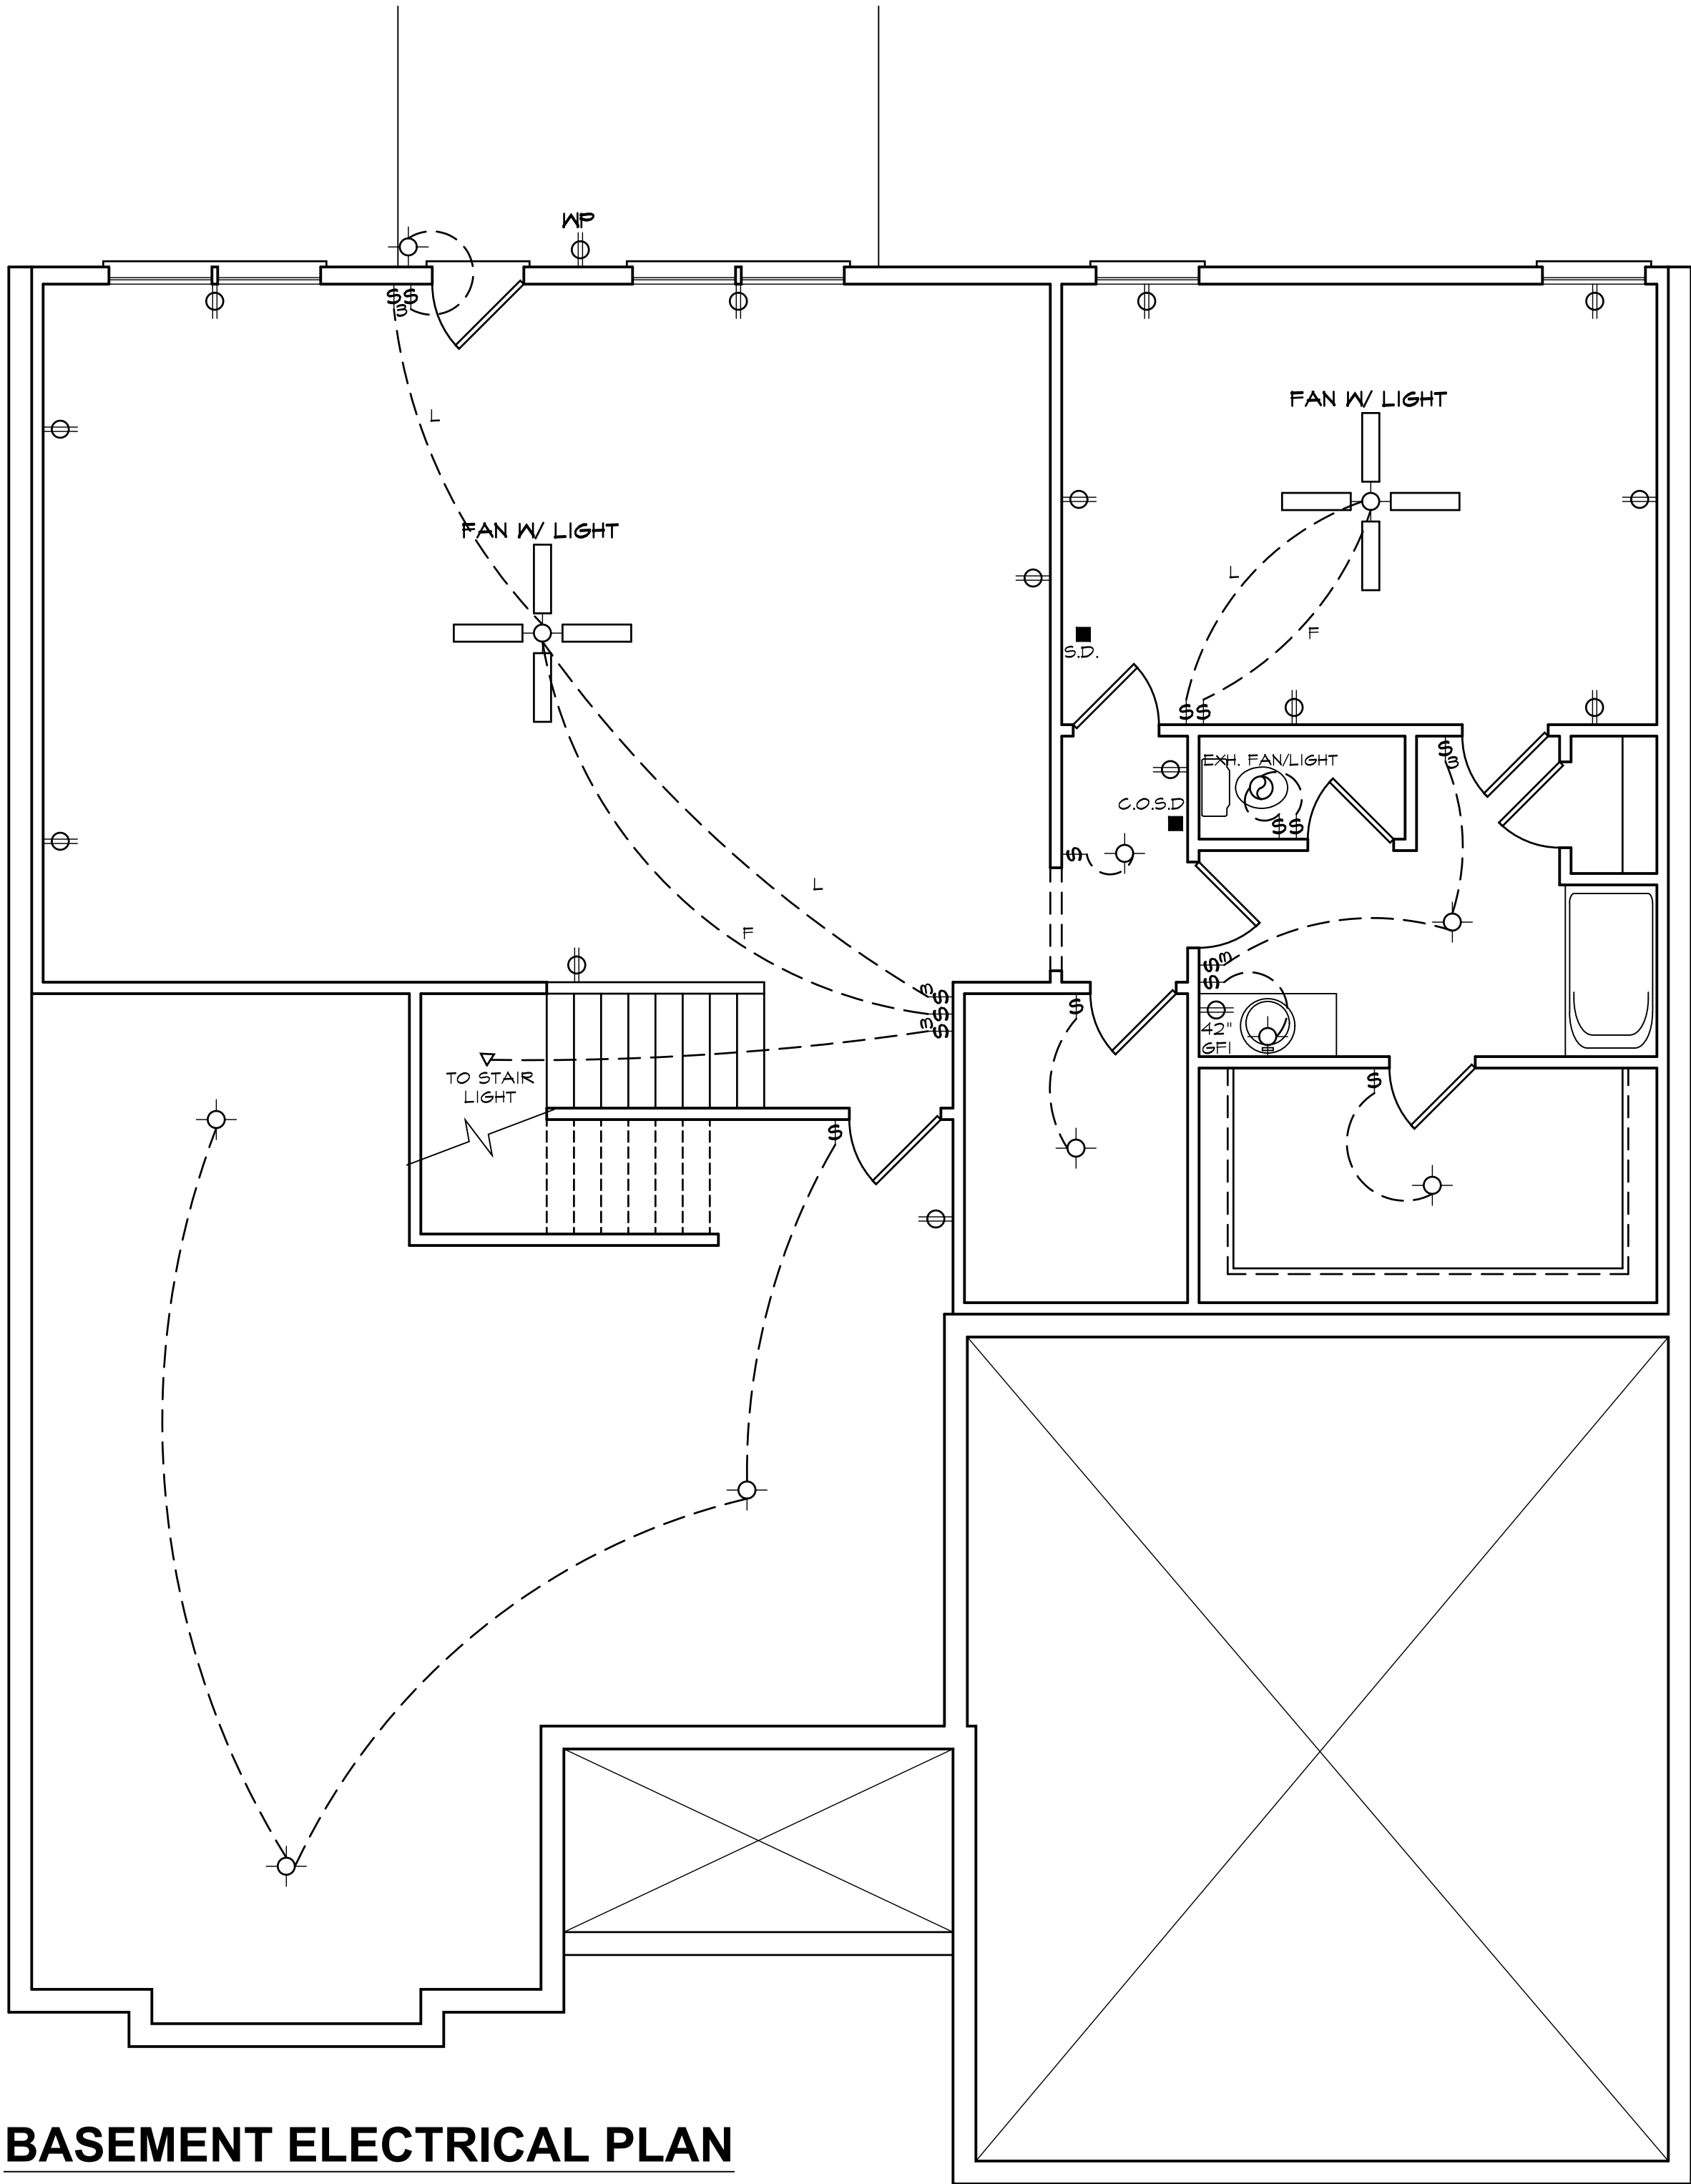

BASEMENT ELECTRICAL PLAN

NOTE - ELECTRICAL RECEPTACLE AND SWITCH QUANTITIES AND LOCATIONS SHOWN ON PLAN ARE FOR ILLUSTRATION PURPOSES ONLY. ACTUAL NUMBER AND LOCATIONS SHALL BE FIELD DETERMINED AS PER CLIENT AND BUILDER EXCEPT WHERE CODE REQUIREMENTS APPLY.

ELECTRICAL LEGEND

- LIGHT FIXTURE

- FAN/LIGHT

- WATERPROOF OUTLET

- RECESSED LIGHTING

- SINGLE PULL SWITCH

- 3-WAY SWITCH

- 4-WAY SWITCH

- DIMMER SWITCH

- SMOKE DETECTOR

- FLOOD LIGHTS

- EYEBALL SPOTS

- DUPLEX RECEPTACLE (110V)

- 220 VOLT RECEPTACLE

- SWITCHED RECEPTACLE (TOP WIRE ONLY)

- GROUND FAULT CIRCUIT INTERRUPTOR

- CL6 FAN/LIGHTS

- TRACK LIGHTS

- FLUORESCENT LIGHTING

- CABLE OUTLET

- TELEPHONE OUTLET

- COMPUTER DATA OUTLET

- BURGLAR ALARM


- INTERCOM

NOTE: ALL ELECTRICAL TO BE VERIFIED BY OWNER/BUILDER BEFORE ROUGH-IN.

2604 "A" FE (R) KC057

DATE DRAWN
5/1/2025
PROJECT
7592
REVISIONS

SHEET
6

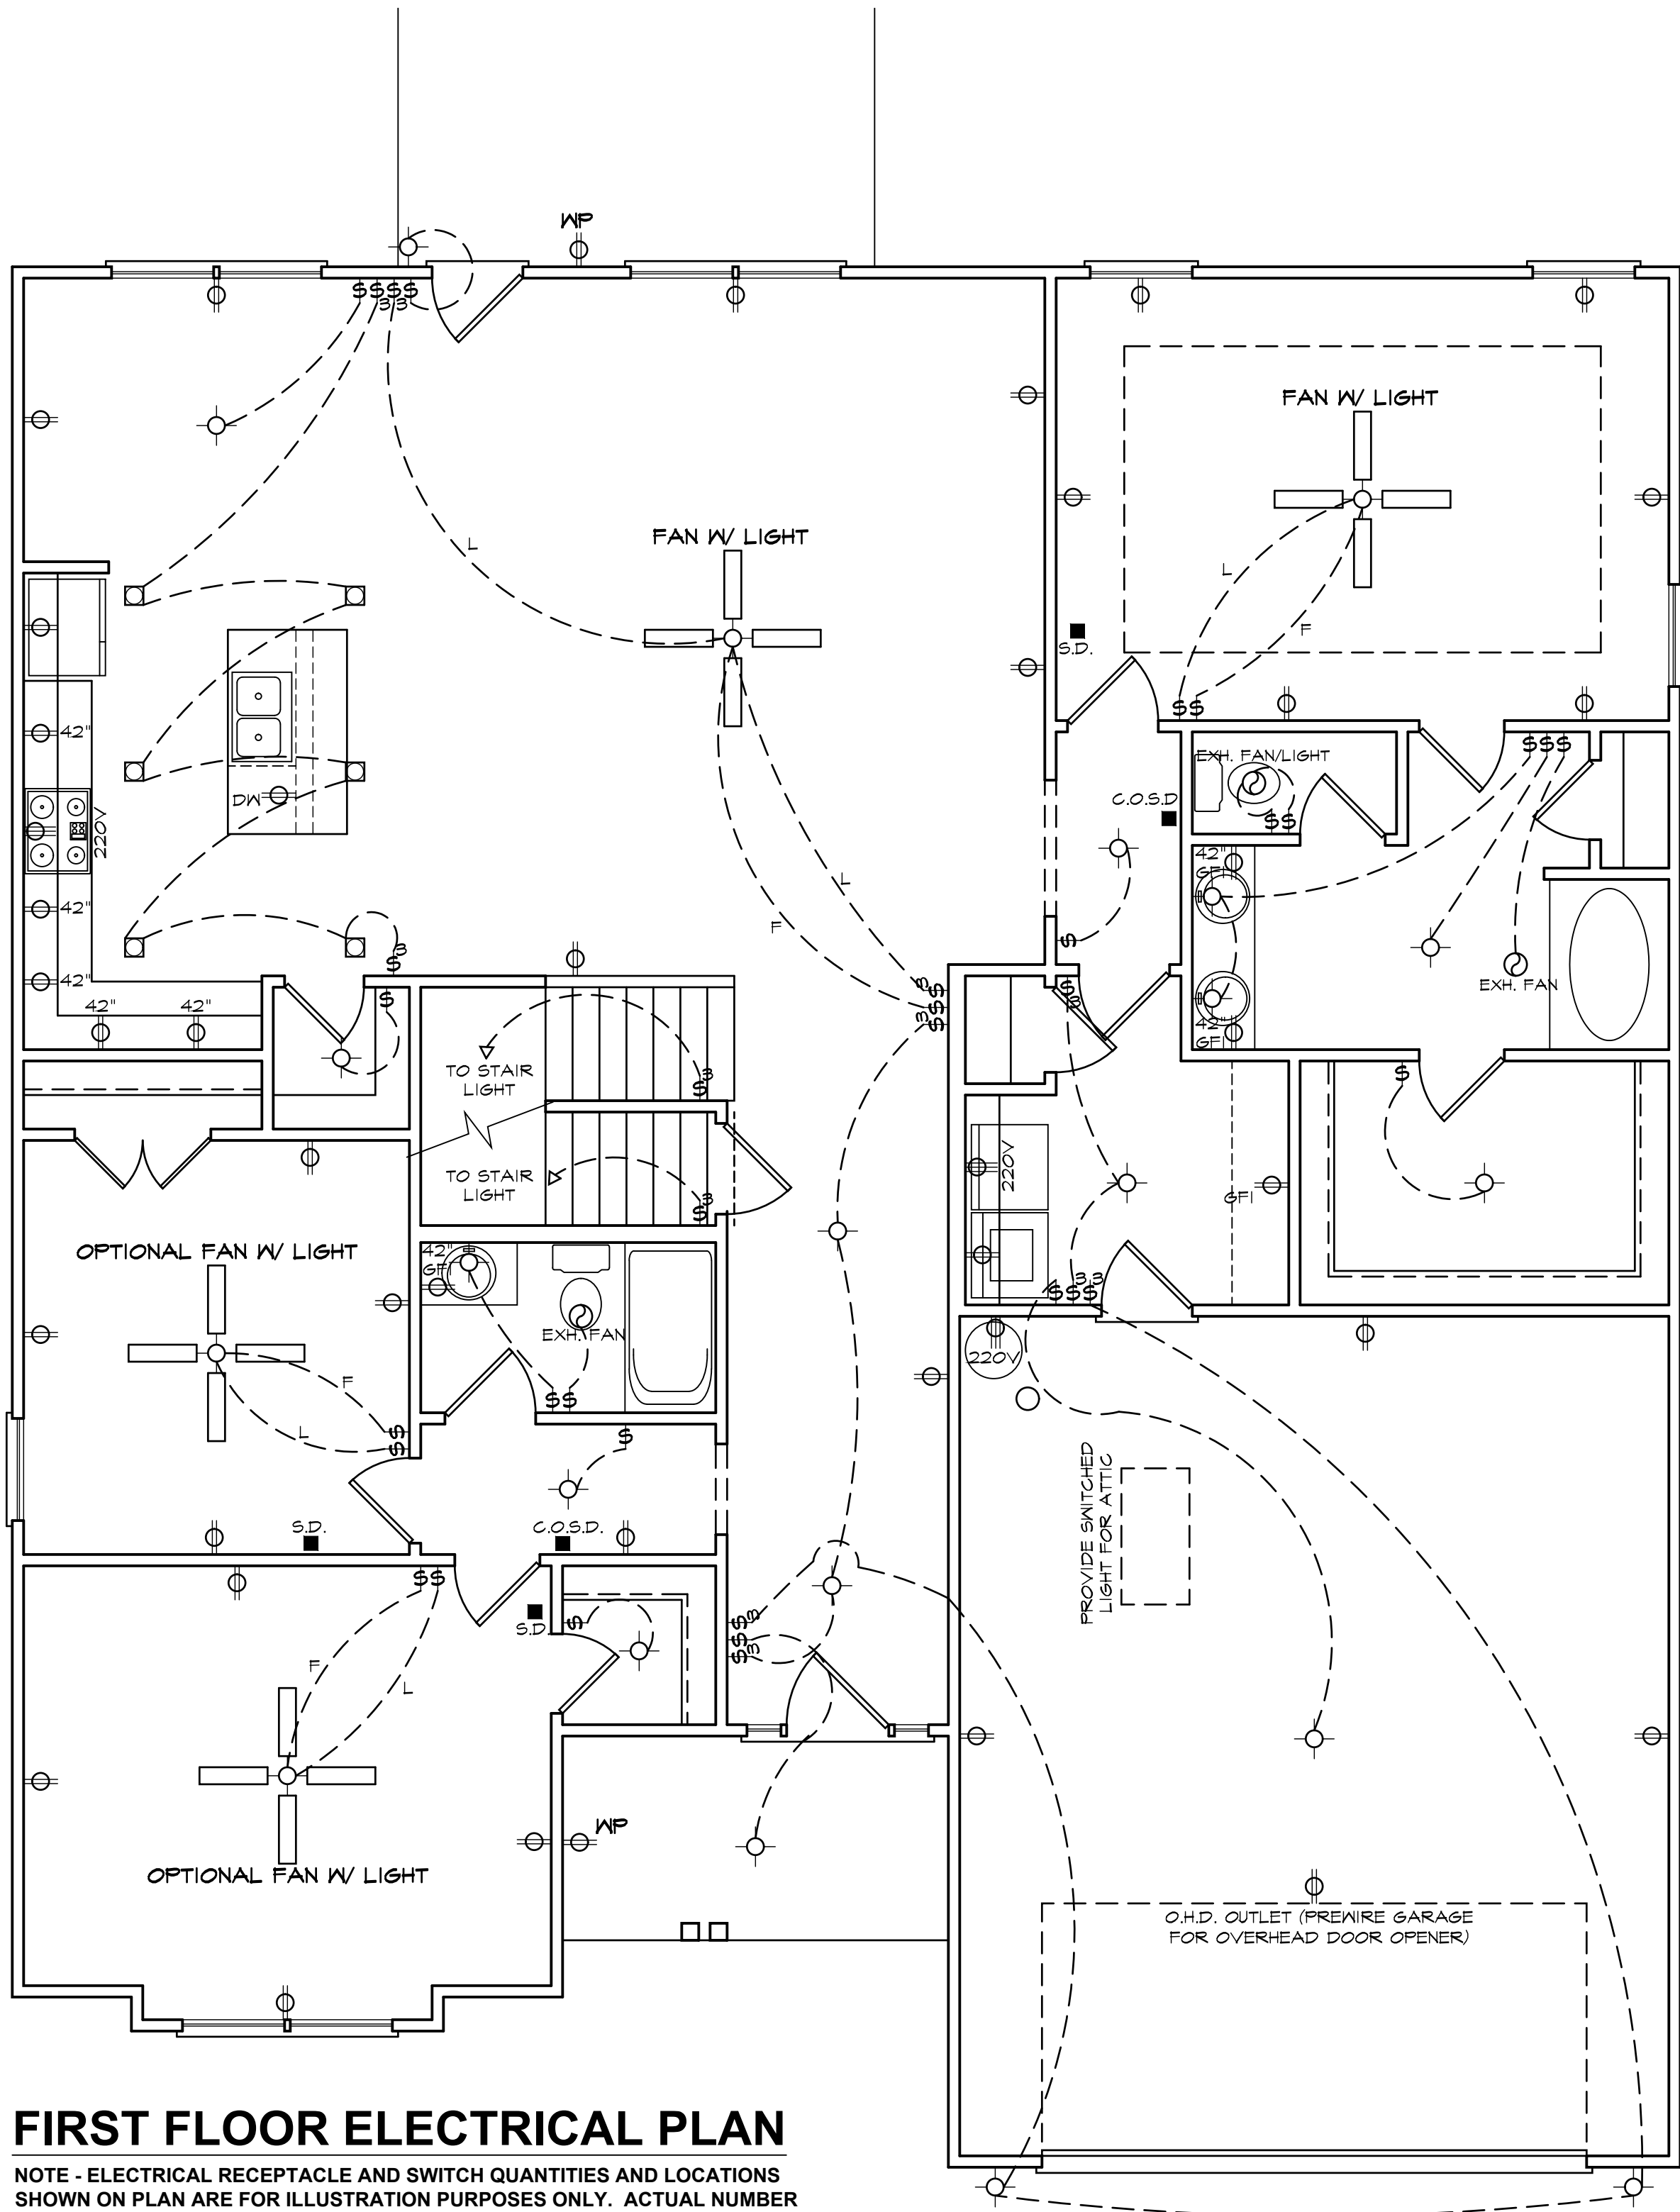

FIRST FLOOR ELECTRICAL PLAN

NOTE - ELECTRICAL RECEPTACLE AND SWITCH QUANTITIES AND LOCATIONS SHOWN ON PLAN ARE FOR ILLUSTRATION PURPOSES ONLY. ACTUAL NUMBER AND LOCATIONS SHALL BE FIELD DETERMINED AS PER CLIENT AND BUILDER EXCEPT WHERE CODE REQUIREMENTS APPLY.

ELECTRICAL LEGEND

- LIGHT FIXTURE

- FAN/LIGHT

- WATERPROOF OUTLET

- RECESSED LIGHTING

- SINGLE PULL SWITCH

- 3-WAY SWITCH

- 4-WAY SWITCH

- DIMMER SWITCH

- SMOKE DETECTOR

- FLOOD LIGHTS

- EYEBALL SPOTS

- DUPLEX RECEPTACLE (110V)

- 220 VOLT RECEPTACLE

- SWITCHED RECEPTACLE (TOP WIRE ONLY)

- GROUND FAULT CIRCUIT INTERRUPTOR

- CL6 FAN/LIGHTS

- TRACK LIGHTS

- FLUORESCENT LIGHTING

- CABLE OUTLET

- TELEPHONE OUTLET

- COMPUTER DATA OUTLET

- BURGLAR ALARM


- INTERCOM

NOTE: ALL ELECTRICAL TO BE VERIFIED BY OWNER/BUILDER BEFORE ROUGH-IN.

2604 "A" FE (R) KC057

DATE DRAWN
5/1/2025
PROJECT
7592
REVISIONS

SHEET
7

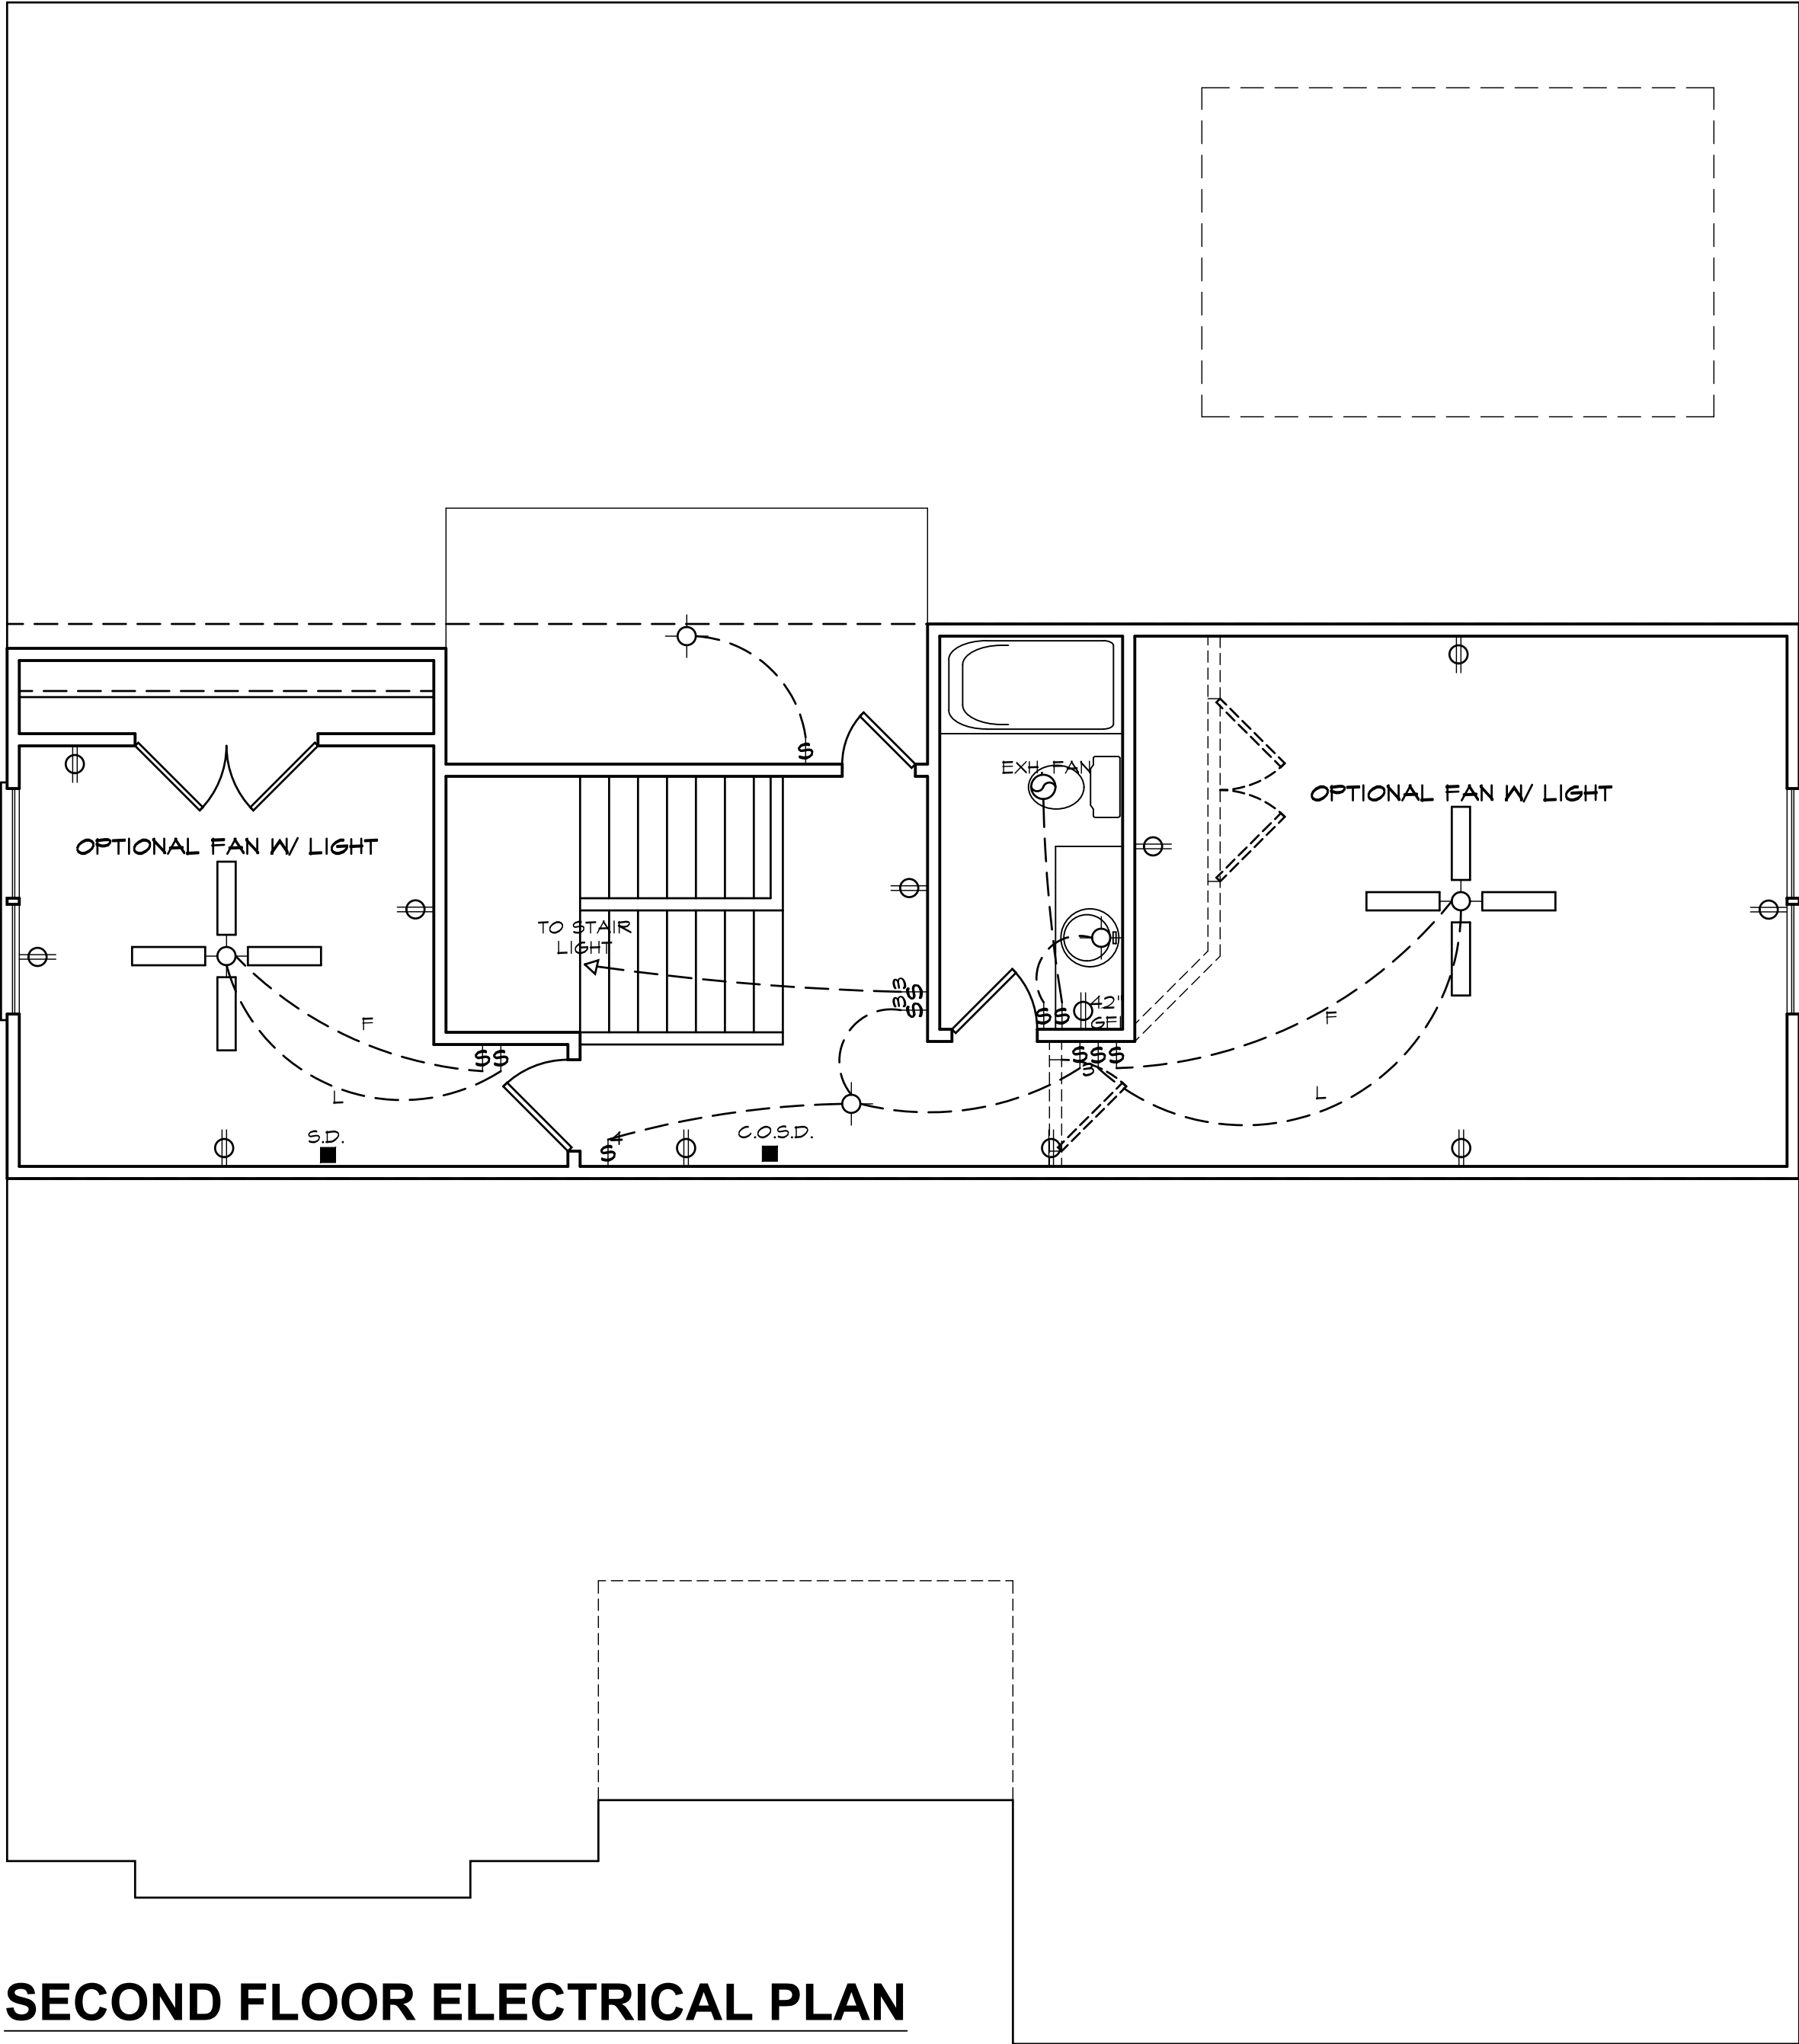

SECOND FLOOR ELECTRICAL PLAN

NOTE - ELECTRICAL RECEPTACLE AND SWITCH QUANTITIES AND LOCATIONS SHOWN ON PLAN ARE FOR ILLUSTRATION PURPOSES ONLY. ACTUAL NUMBER AND LOCATIONS SHALL BE FIELD DETERMINED AS PER CLIENT AND BUILDER EXCEPT WHERE CODE REQUIREMENTS APPLY.

ELECTRICAL LEGEND

 - LIGHT FIXTURE

 - FAN/LIGHT

 WP - WATERPROOF OUTLET

 - RECESSED LIGHTING

 - SINGLE PULL SWITCH

 - 3-WAY SWITCH

 - 4-WAY SWITCH

 - DIMMER SWITCH

 - SMOKE DETECTOR

 - FLOOD LIGHTS

 - EYEBALL SPOTS

 - DUPLEX RECEPTACLE (110V)

 - 220 VOLT RECEPTACLE

 - SWITCHED RECEPTACLE (TOP WIRE ONLY)

 - GROUND FAULT CIRCUIT INTERRUPTOR

 - CL6 FAN/LIGHTS

 - TRACK LIGHTS

 - FLUORESCENT LIGHTING

 - CABLE OUTLET

 - TELEPHONE OUTLET

 - COMPUTER DATA OUTLET

 - BURGLAR ALARM

 - INTERCOM

NOTE: ALL ELECTRICAL TO BE VERIFIED BY OWNER/BUILDER BEFORE ROUGH-IN.


2604 "A" FE (R) KC057

DATE DRAWN
5/1/2025
PROJECT
7592
REVISIONS


SHEET
8



Y	N	OPTIONAL MASTER BATH
		4' X 3' (1) PC. FIBERGLASS SHOWER IN LIEU OF LINEN CLOSET
		4' X 4' FIXED OBSCURED GLASS WINDOW

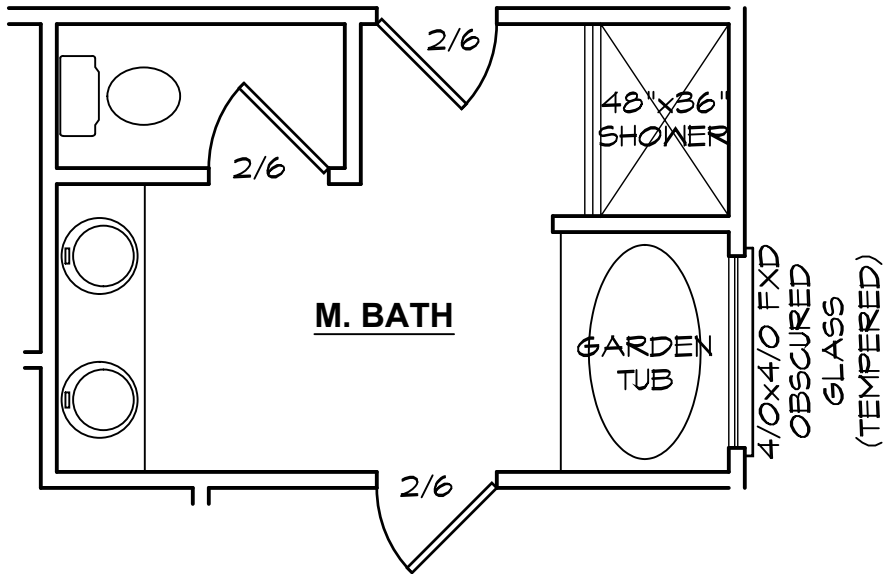

OPTIONAL MASTER BATH
SEE FLOOR PLAN FOR TYPICAL NOTES & DIMENSIONS

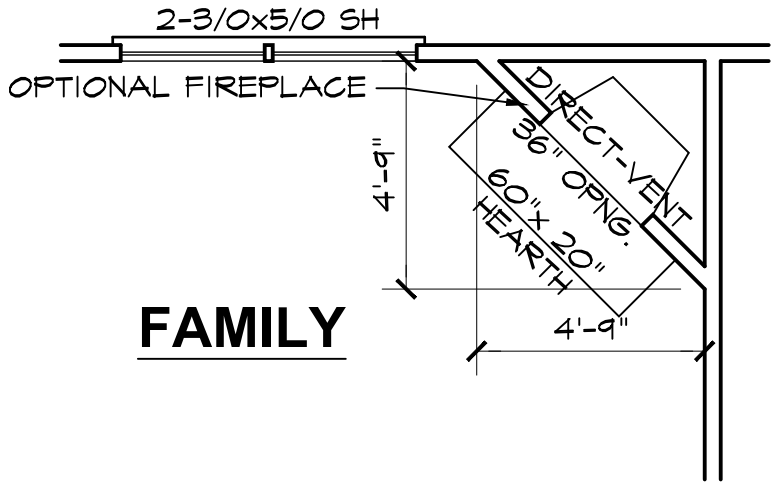

OPTIONAL FIREPLACE


FLOOR PLAN OPTION SHEET

2604 "A" FE (R) KC057


DATE DRAWN
5/1/2025
PROJECT
7592
REVISIONS

SHEET
opt1




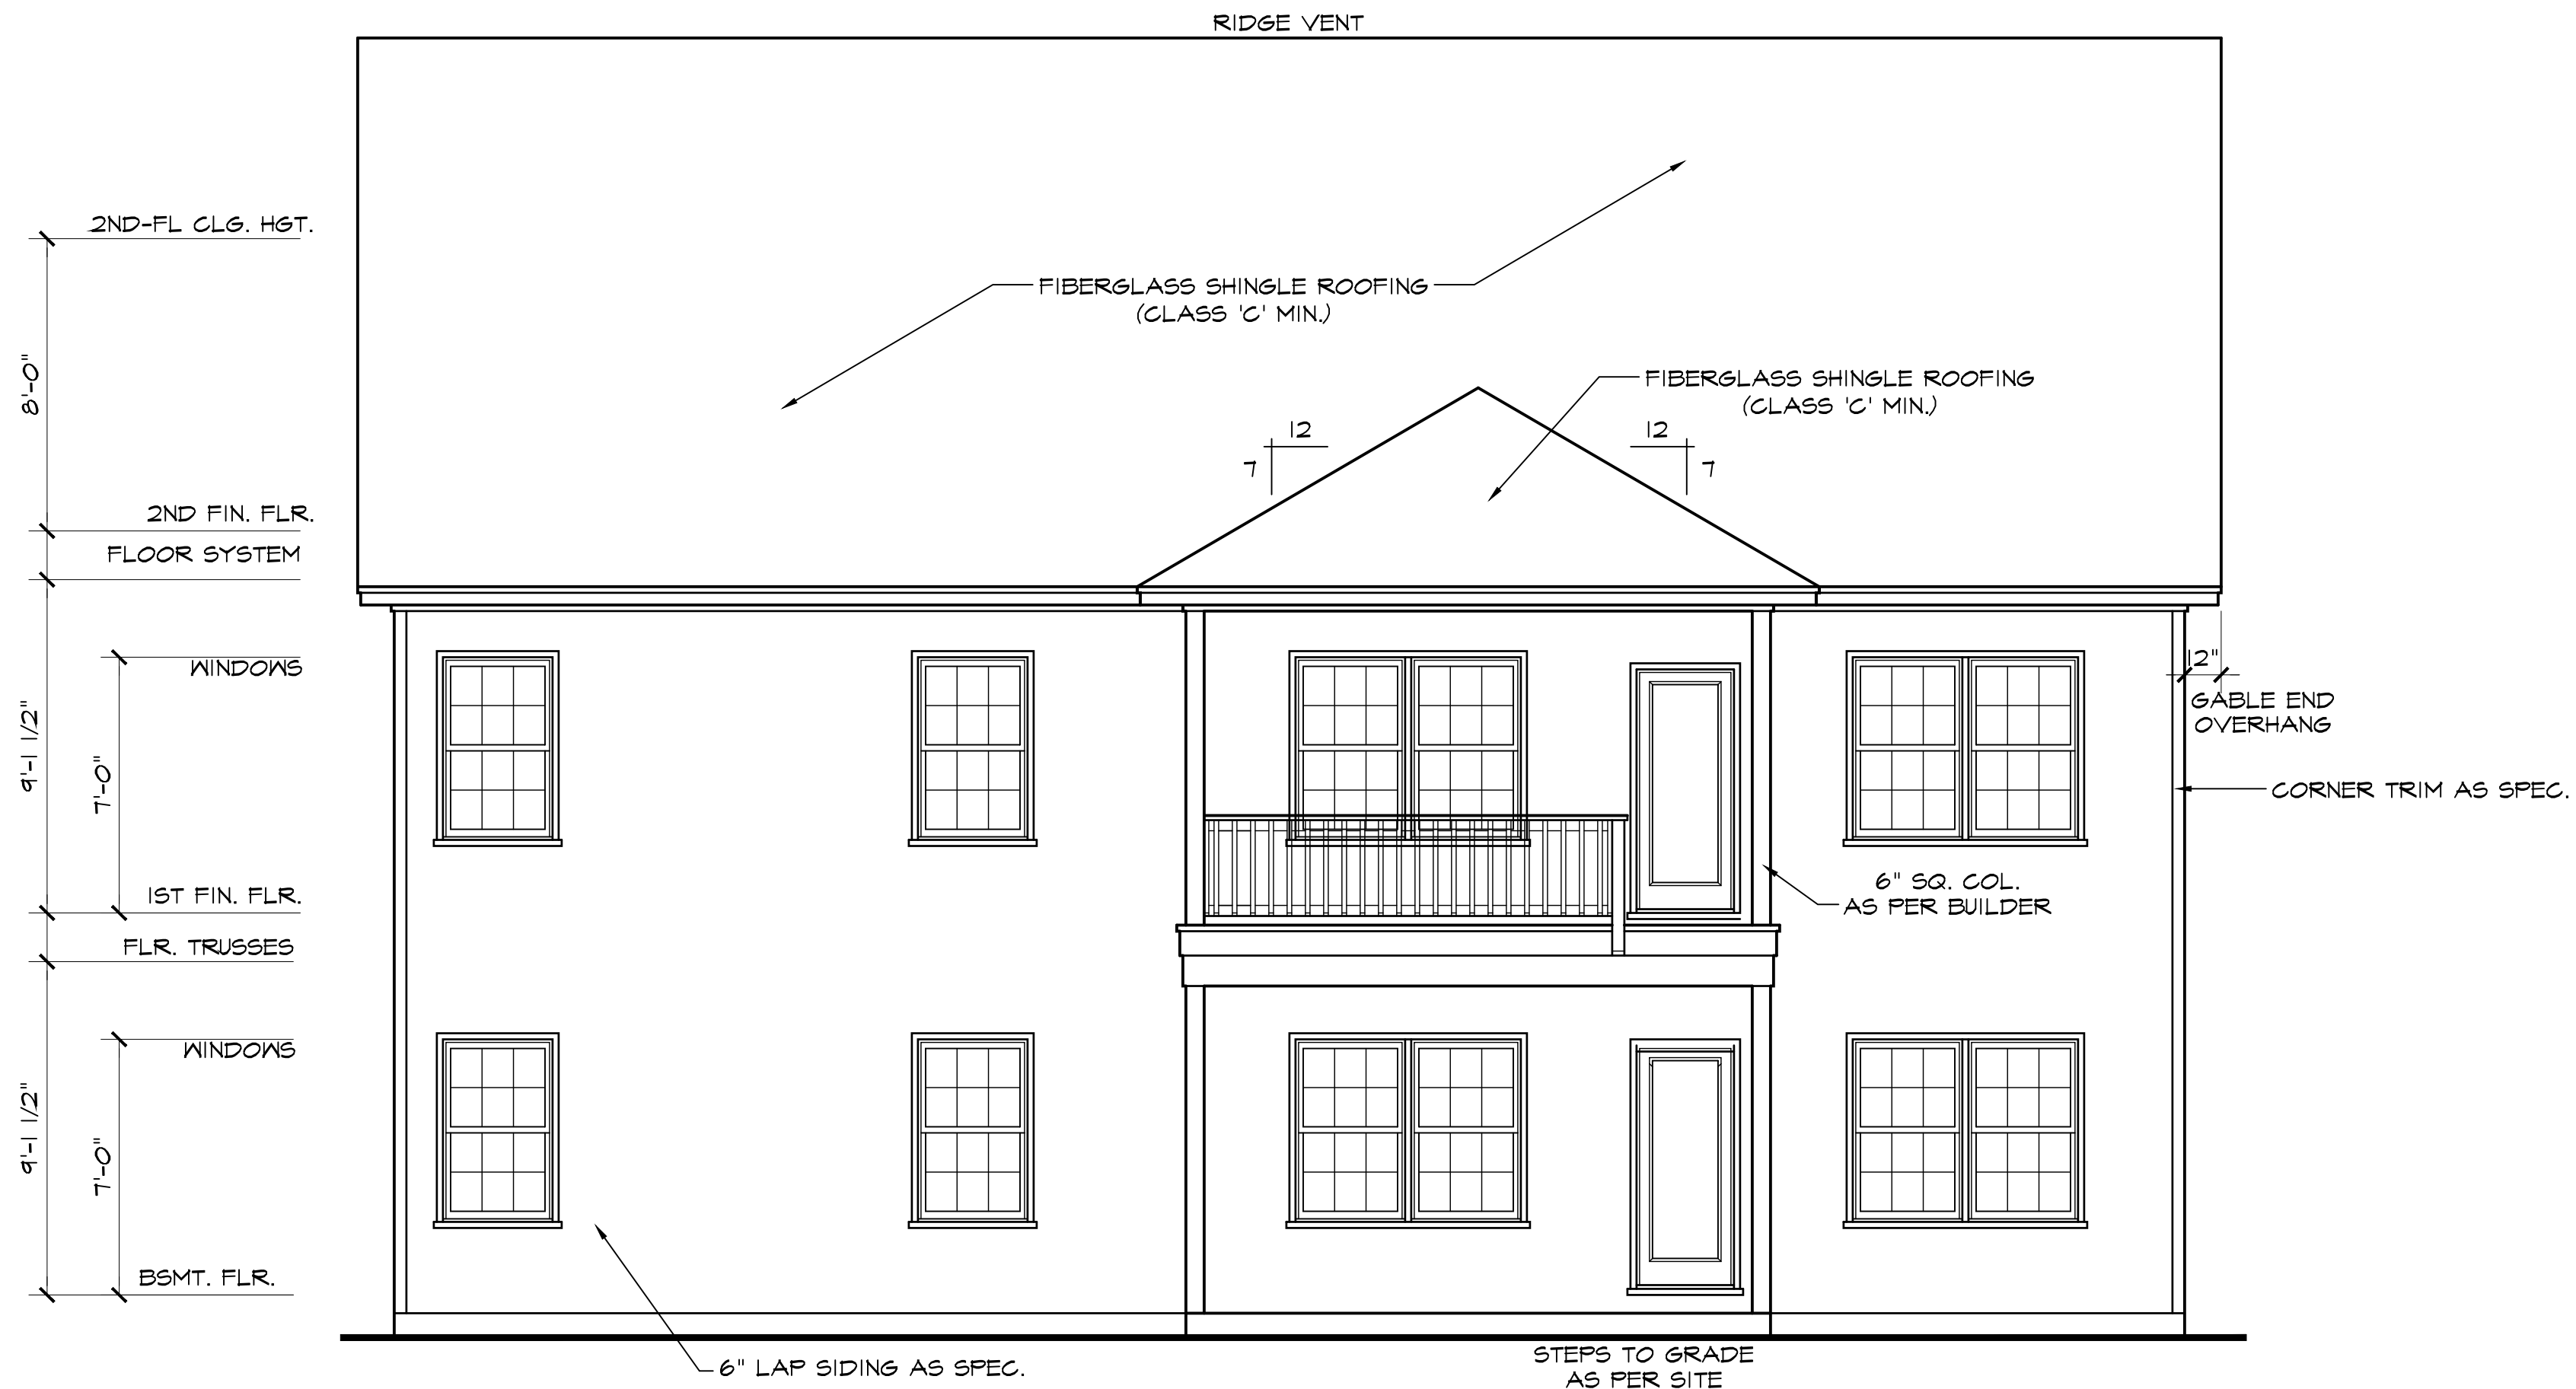

REAR ELEVATION SCALE: 1/4"=1'-0"
NOTE - SLOPE ALL GRADES AWAY FROM HOUSE FOR POSITIVE DRAINAGE

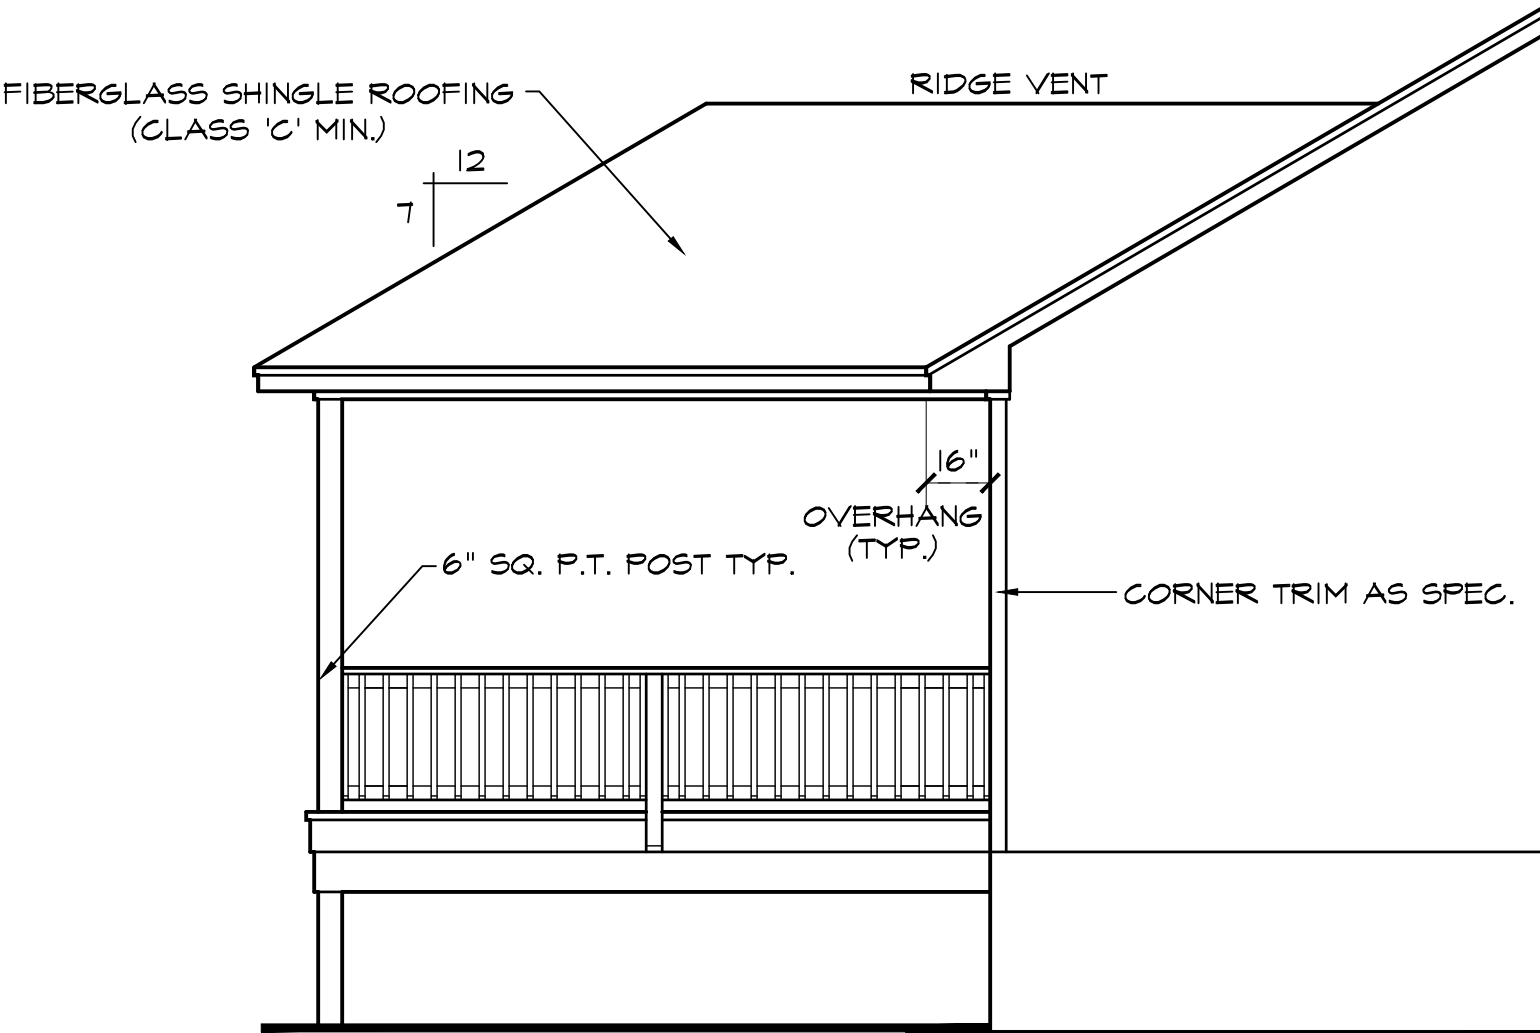

LEFT SIDE ELEVATION SCALE: 1/4"=1'-0"

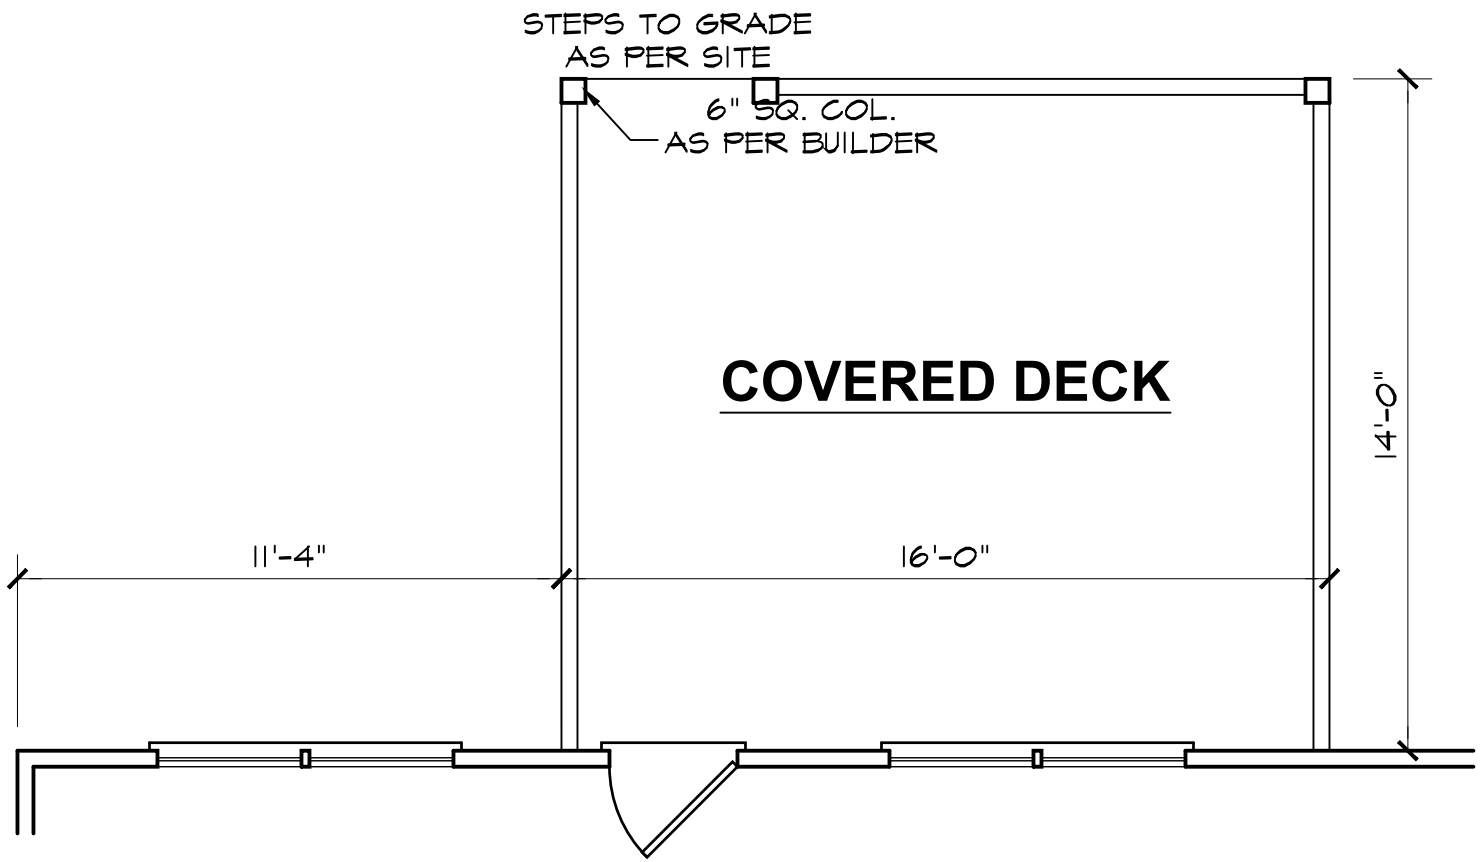

COVERED PORCH SCALE: 1/4"=1'-0"

REAR PORCH OPTION SHEET


2604 "A" FE (R) KC057

DATE DRAWN
5/1/2025
PROJECT
7592
REVISIONS

SHEET

opt2



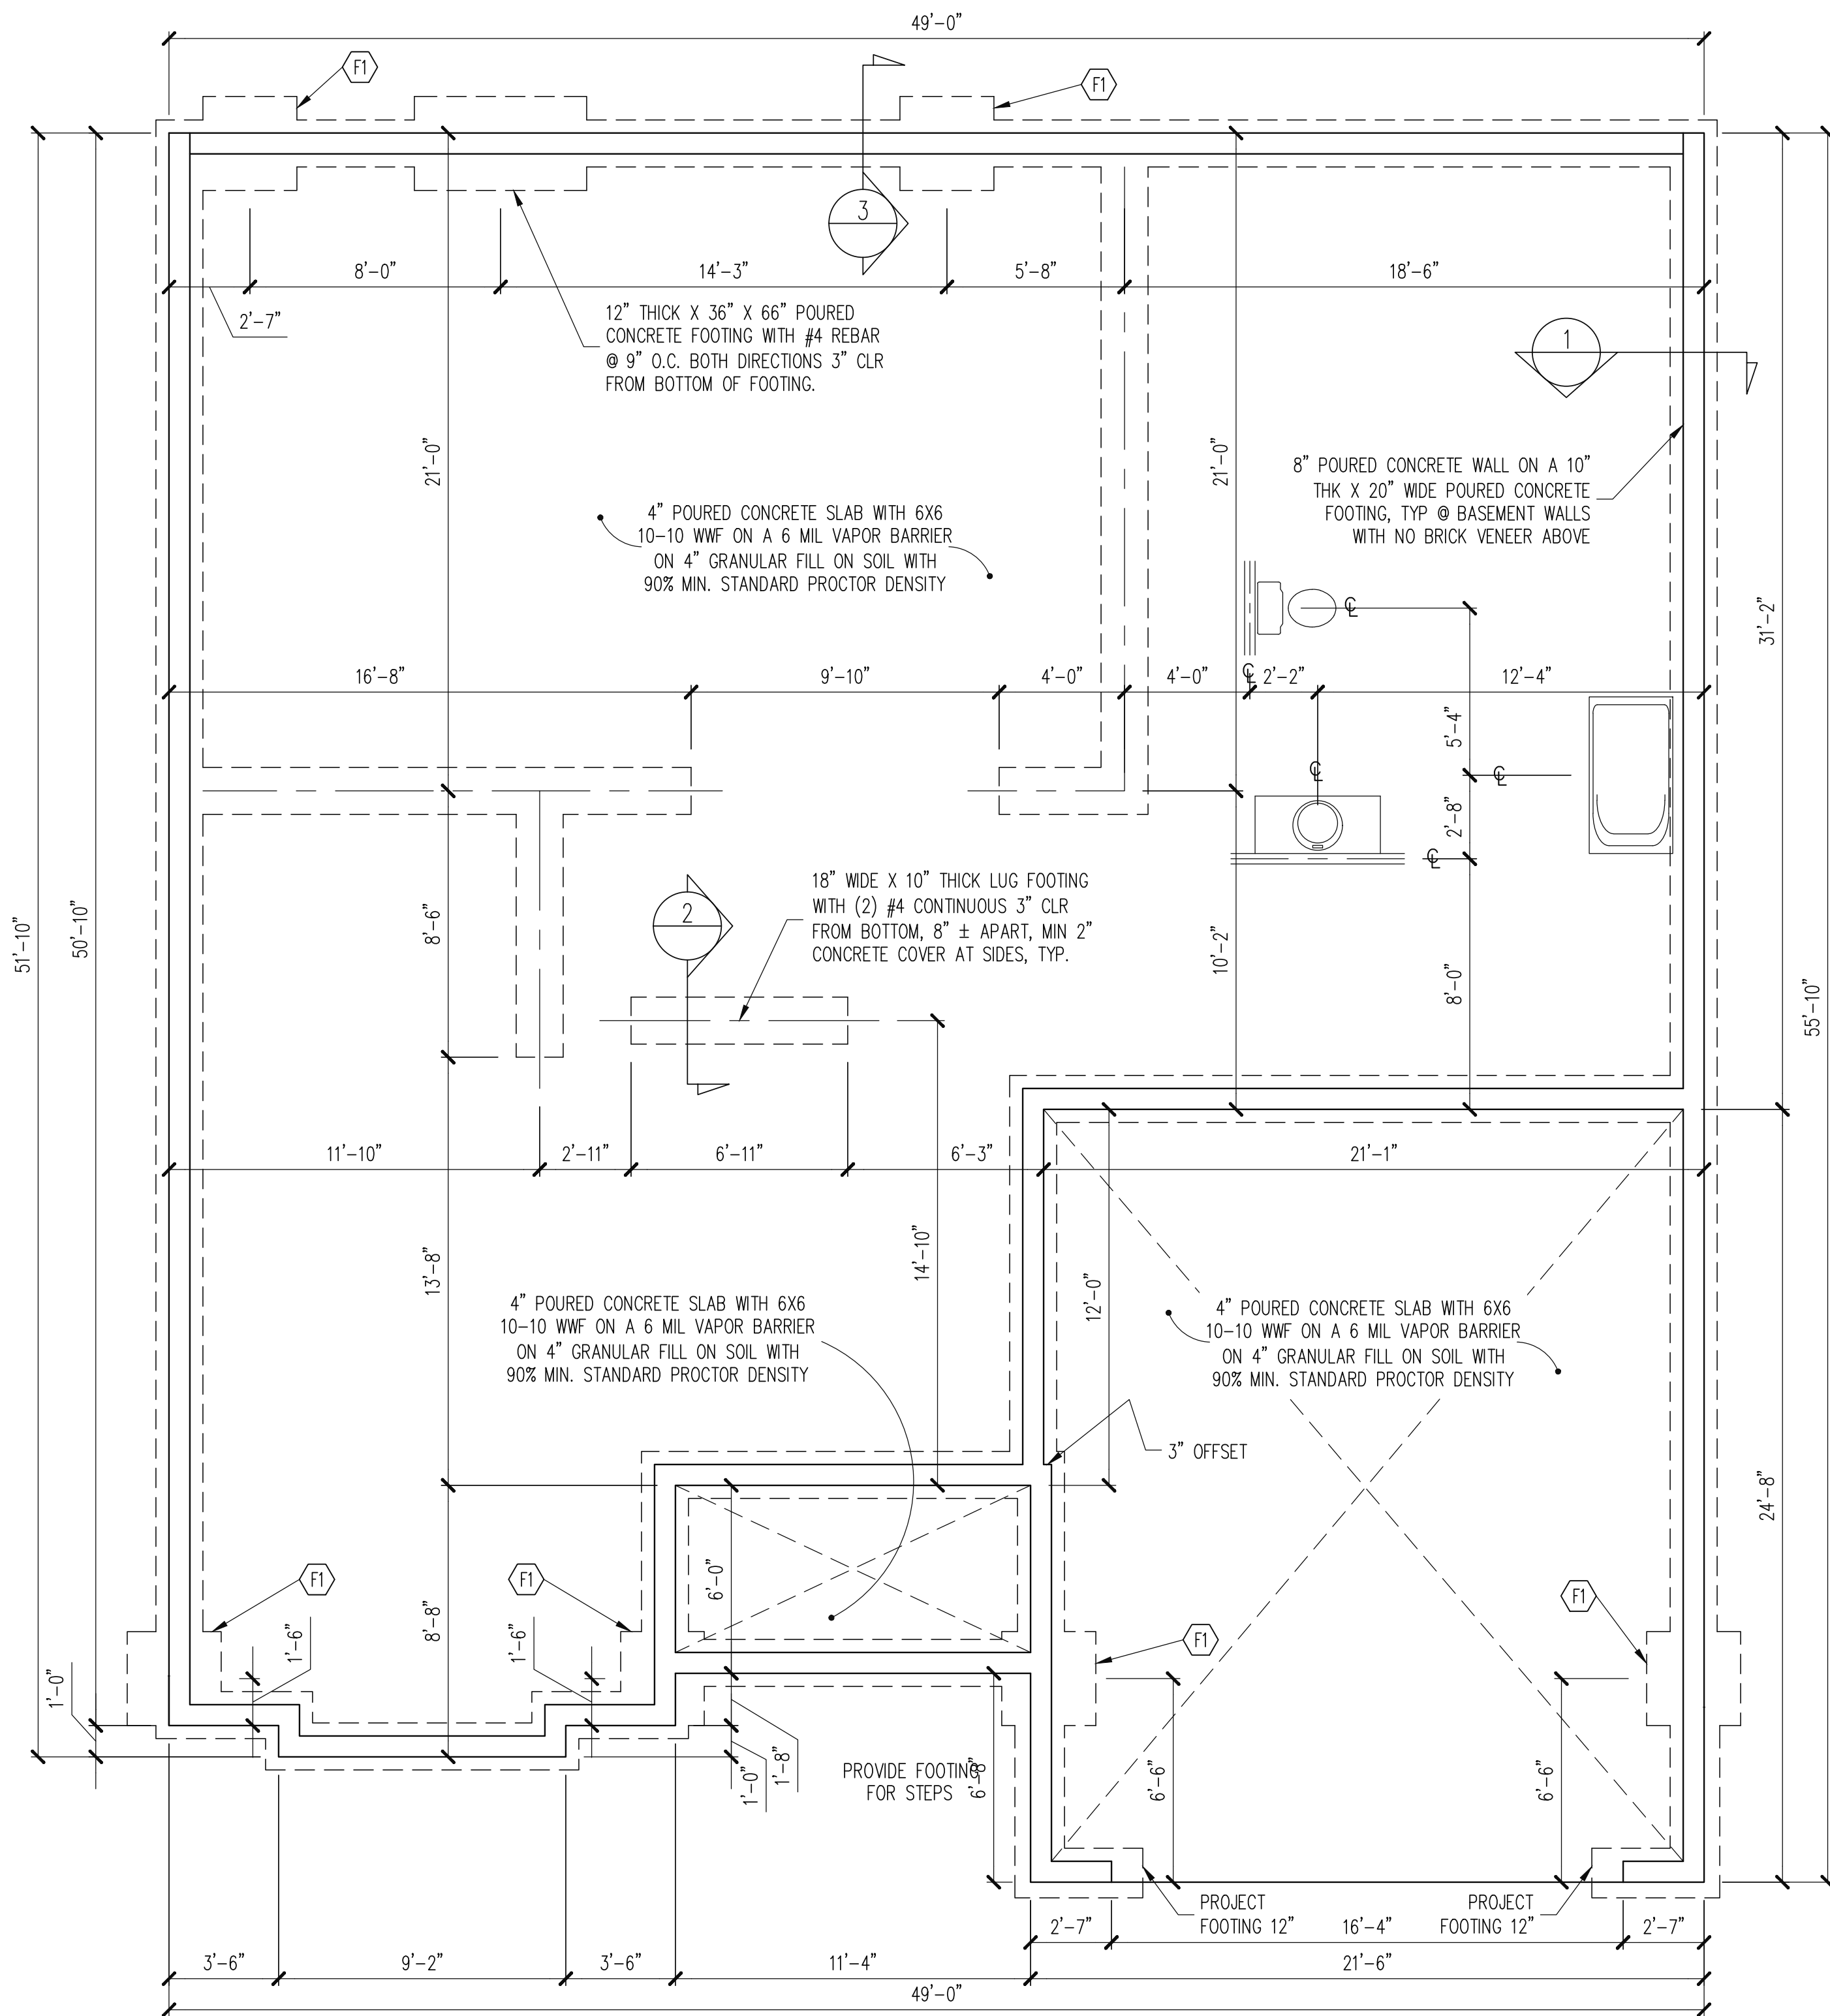

The structural design of this plan is the property of Engineering Tech Associates, P.A. These plans are for the one time use at the location and for the client listed. Engineering Tech Associates, P.A. assumes no liability for these plans if they are reproduced, in whole or in part, for construction at any other location without written permission from Engineering Tech Associates, P.A.

PLAN DESIGNED UNDER
2018 NORTH CAROLINA
RESIDENTIAL CODE


- NOTES:
- HEIGHT AND BACKFILL LIMITATIONS FOR FOUNDATION WALLS ARE TO BE GOVERNED BY THE NCSBC, LATEST EDITION.
 - FIBER MESH REINFORCED CONCRETE MAY BE USED IN LIEU OF WELDED WIRE FABRIC. SEE SECTION 6.01 OF THE CONSTRUCTION SPECIFICATIONS FOR ALLOWABLE SUBSTITUTION DETAILS.
 - ALL APPLIANCE AND PLUMBING LOCATIONS ARE FOR REFERENCE ONLY. FINAL LOCATIONS MUST BE VERIFIED WITH ARCHITECTURAL FLOOR PLANS.

FOUNDATION PLAN
BASEMENT OPTION

1/4" = 1'-0"

STRUCTURAL ENGINEERS
License No. C-3870
318 W Millbrook Road, Unit 201
Raleigh, North Carolina 27609
Phone: (919) 844-1661

Engineering
Tech
ASSOCIATES, P.A.

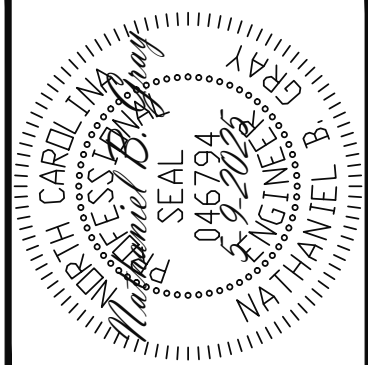


ADAMS HOMES				
STRUCTURAL ADDENDUM				
SCOPE:	57 KIPLING CREEK		ENG:	NBC/TSP
LOT #:			REV:	
	2604 MASTER		DATE:	5-9-2025

PLAN NO.
2604

PROJECT NO.
25-18-256

SHEET NO.
S1.0

1.0 of 7

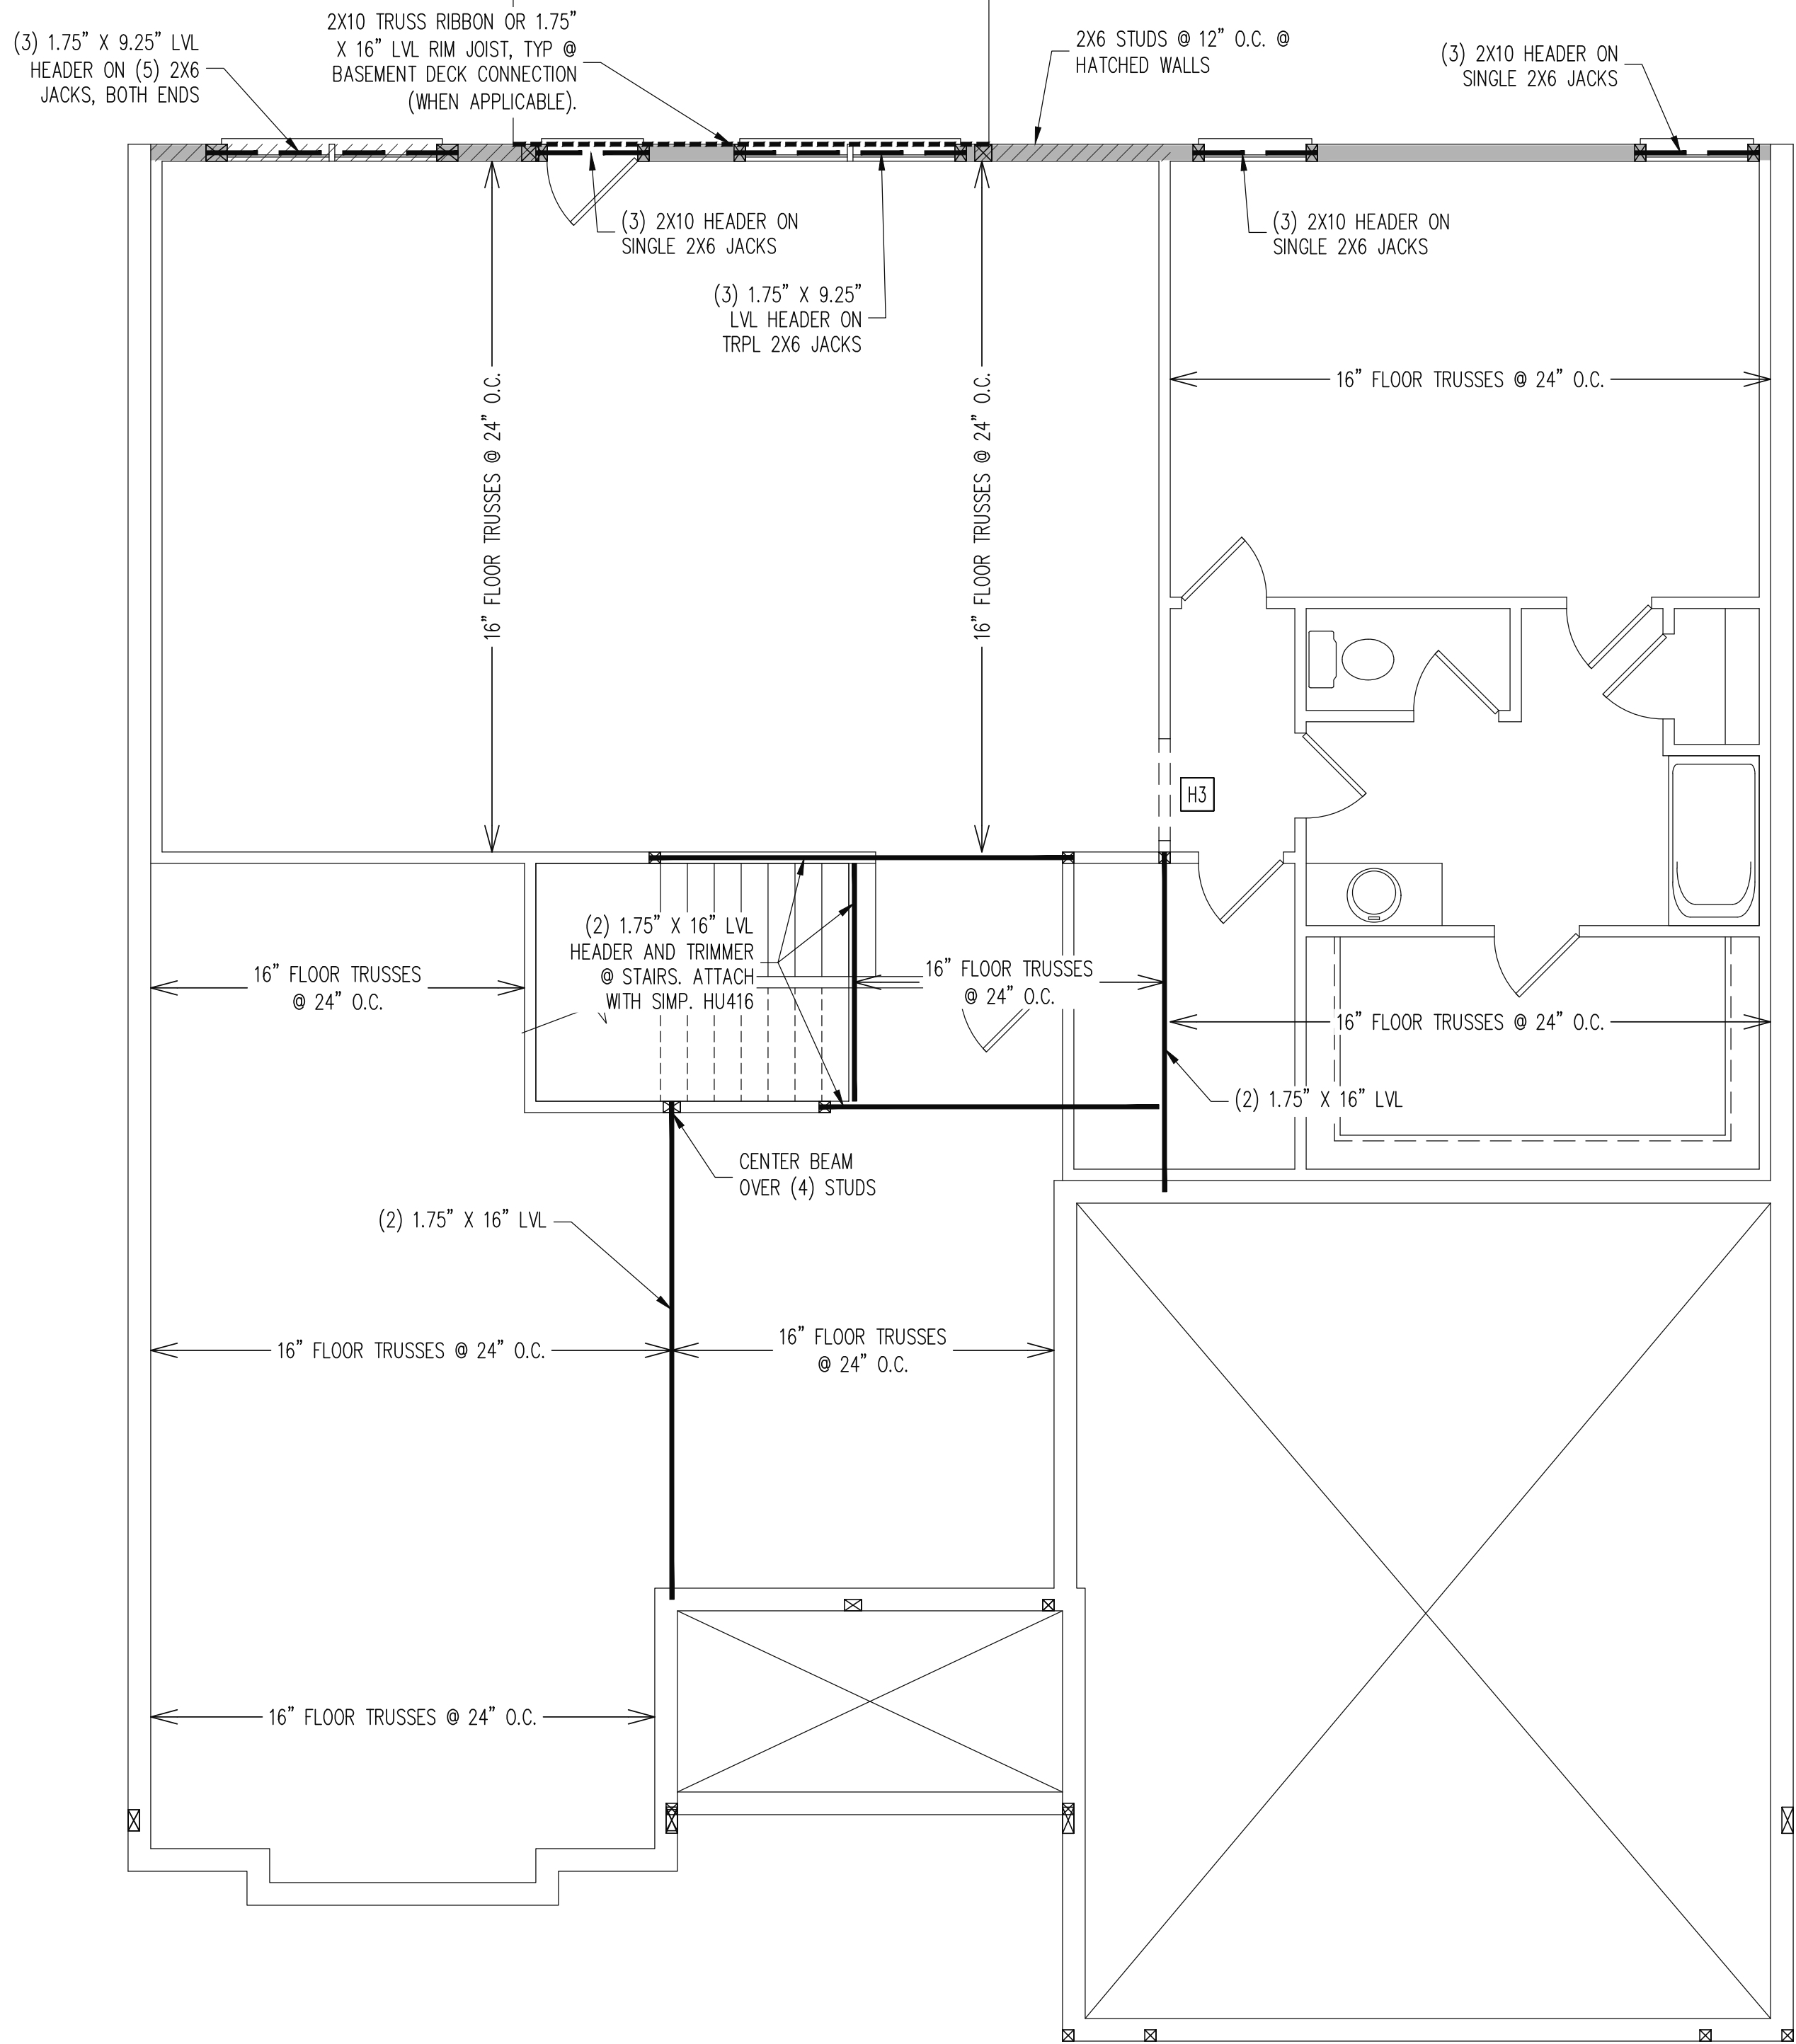

**REQUIRED STUDS FOR
BEAM SUPPORT**

REFER TO SECTIONS 5.02 – 5.06 OF THE
CONSTRUCTION SPECIFICATIONS FOR REQUIRED
NUMBER OF STUDS FOR BEAM SUPPORT, TYP UNO.

HEADER SCHEDULE	
H1	SINGLE 2X4 TURNED FLAT (A)
H2	(2) 2X4'S ON SINGLE JACKS (B)
H3	(2) 2X10'S ON SINGLE JACKS (C)
H4	(2) 1.75" X 9.25" LVL'S ON DBL JACKS

(A)	TYPICAL FOR INTERIOR NON LOAD BEARING WALLS ONLY, ROUGH OPENING 38" MAX.
(B)	TYPICAL FOR INTERIOR NON LOAD BEARING WALLS ONLY, ROUGH OPNG 38" TO 74" MAX.
(C)	TYPICAL FOR ALL CONDITIONS NOT LISTED IN (A) OR (B) UNO.
NOTES:	
-HEADERS IN NON LOAD BEARING INTERIOR WALLS ARE NOT LABELED.	
-KING STUDS EXTERIOR WALLS:	
SINGLE KING STUDS FOR 6' MAX OPENINGS.	
DBL KING STUDS FOR 10' MAX OPENINGS.	
TRPL KING STUDS FOR 14' MAX OPENINGS.	
QUAD KING STUDS FOR 18' MAX OPENINGS.	
FOR 2X6 WALLS, ONE HALF THE AMOUNT OF KING STUDS REQUIRED (ROUND UP) UNO	

WALL BRACING

ALL EXTERIOR STUD WALLS ARE TO BE CONTINUOUSLY SHEATHED WITH 7/16 APA RATED OSB NAILED TO STUDS WITH 8d NAILS @ 6" O.C. AT PANEL EDGES, 12" O.C. IN PANEL FIELD.

SINGLE JOIST, CONTINUOUS RIM JOIST, OR BLOCKING OF EQUAL DEPTH IS REQUIRED ABOVE AND BELOW ALL BRACED WALLS. NAIL BLOCKING ABOVE WALL TO TOP PLATE WITH 8d TOE NAILS @ 6" O.C. NAIL SOLE PLATE OF BRACED WALL TO BLOCKING BELOW WITH (3) 16d NAILS @ 16" O.C. BLOCKING AT HORIZONTAL JOINTS IN BRACED WALL LINES ONLY REQUIRED AT SHADED WALLS, UNO.

SHADED WALLS:

PROVIDED CONTINUOUS SHEATHING = 30' MIN.

-WALL BRACING IS BY ENGINEERED DESIGN AND NOT PRESCRIPTIVE PER SECTION 602.10 OF THE 2018 NCRC. CONTINUOUS SHEATHING HAS BEEN PROVIDED, ALONG WITH ALTERNATIVE METHODS TO INSURE THE MINIMUM INTENT OF SECTION 602.10 OF THE 2018 NCRC HAS BEEN MET AND EXCEEDED.


-BRACED WALL PANELS SHALL BE FASTENED IN ACCORDANCE WITH TABLE 602.3(1) TO PROVIDE CONTINUOUS PANEL UPLIFT RESISTANCE AND COMPLIANCE WITH NCRBC R602.3.5 AND R802.11 UNLESS NOTED OTHERWISE ON STRUCTURAL PLANS.


**2ND FLOOR
FRAMING PLAN**

WALLS AND CEILING

1/4" = 1'-0"

STRUCTURAL ENGINEERS
License No. C-3870
318 W Millbrook Road, Unit 201
Raleigh, North Carolina 27609
Phone: (919) 844-1661

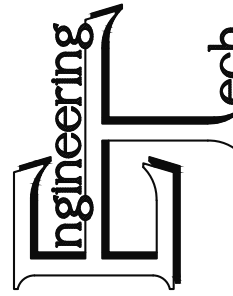
Engineering
Tech
ASSOCIATES, P.A.

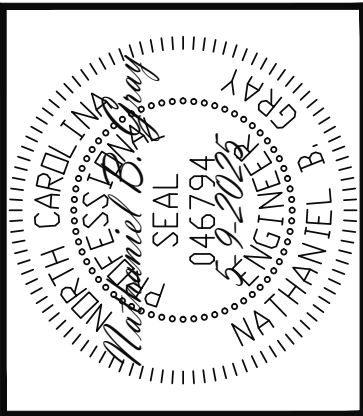

ADAMS HOMES		DATE	
SCOPE	STRUCTURAL ADDENDUM	ENG	5-9-2025
	LOT #:	REV:	
57 KIPLING CREEK		2604 MASTER	

PLAN NO.

2604

PROJECT NO.

25-18-256

SHEET NO.

S1.1

1.1 of 7

(2) 1.75" X 9.25" LVL
HEADER ON (3) JACKS B.E.

ATTACH GIRDER WITH SIMP.
TBE4, BEAR ON (4) STUDS

ROOF TRUSSES
PER MANU

ATTACH GIRDER WITH SIMP.
TBE4, BEAR ON (4) STUDS

TRUSS GIRDER PER
MANU

SIMP. LUS210-2

2X10 @ 16" O.C.

(2) 2X10

(2) 2X10

TRUSS GIRDER PER MANU

TRUSS GIRDER PER MANU

ROOF TRUSSES
PER MANU

ATTACH GIRDER WITH
SIMP. LGT3, BEAR ON
(5) CRIPPLE STUDS
ABOVE HEADER

(3) JACKS

(5) JACKS

(2) 1.75" X 11.875" LVL
HEADER

BUILDER FIELD
LOCATE PDS
BETWEEN TRUSSES

(2) 1.75" X 9.25" LVL COLUMN.
BEAR TRUSS DIRECTLY ON LVL
COLUMN, BEARING ENHANCER
PER MANU., BOTH ENDS.

(3) PLY TRUSS GIRDER PER MANU

ROOF TRUSSES PER MANU

(2) 1.75" X 14" LVL PORTAL FRAME.
DBL STUDS @ DOOR OPENINGS

ATTACH TRUSSES WITH SIMP.
H1 AND BEAR ON (2) STUDS
@ HATCHED WALL

NOTE ALL EXTERIOR WALLS
ARE BRACED WALLS PER
WALL BRACING NOTES

REQUIRED STUDS FOR BEAM SUPPORT

REFER TO SECTIONS 5.02 - 5.06 OF THE
CONSTRUCTION SPECIFICATIONS FOR REQUIRED
NUMBER OF STUDS FOR BEAM SUPPORT, TYP UNO.

HEADER SCHEDULE

H1 SINGLE 2X4 TURNED FLAT (A)

H2 (2) 2X4'S ON SINGLE JACKS (B)

H3 (2) 2X10'S ON SINGLE JACKS (C)

H4 (2) 1.75" X 9.25" LVL'S ON DBL JACKS

H5 (2) 2X10 HEADER ON DBL JACKS

(A) TYPICAL FOR INTERIOR NON LOAD BEARING
WALLS ONLY, ROUGH OPENING 38" MAX.

(B) TYPICAL FOR INTERIOR NON LOAD BEARING
WALLS ONLY, ROUGH OPNG 38" TO 74" MAX.

(C) TYPICAL FOR ALL CONDITIONS NOT LISTED
IN (A) OR (B) UNO.

NOTES:

-HEADERS IN NON LOAD BEARING INTERIOR
WALLS ARE NOT LABELED.

-KING STUDS EXTERIOR WALLS:

SINGLE KING STUDS FOR 6' MAX OPENINGS.

DBL KING STUDS FOR 10' MAX OPENINGS.

TRPL KING STUDS FOR 14' MAX OPENINGS.

QUAD KING STUDS FOR 18' MAX OPENINGS.

FOR 2X6 WALLS, ONE HALF THE AMOUNT OF
KING STUDS REQUIRED (ROUND UP) UNO

WALL BRACING

ALL EXTERIOR STUD WALLS ARE TO BE
CONTINUOUSLY SHEATHED WITH 7/16 APA RATED
OSB NAILED TO STUDS WITH 8d NAILS @ 6" O.C. AT
PANEL EDGES, 12" O.C. IN PANEL FIELD.

SINGLE JOIST, CONTINUOUS RIM JOIST, OR BLOCKING
OF EQUAL DEPTH IS REQUIRED ABOVE AND BELOW
ALL BRACED WALLS. NAIL BLOCKING ABOVE WALL TO
TOP PLATE WITH 8d TOE NAILS @ 6" O.C. NAIL
SOLE PLATE OF BRACED WALL TO BLOCKING BELOW
WITH (3) 16d NAILS @ 16" O.C. BLOCKING AT
HORIZONTAL JOINTS IN BRACED WALL LINES ONLY
REQUIRED AT SHADED WALLS, UNO.


SHADED WALLS:

PROVIDED CONTINUOUS SHEATHING = 230' MIN.


-WALL BRACING IS BY ENGINEERED DESIGN AND
NOT PRESCRIPTIVE PER SECTION 602.10 OF THE
2018 NCR. CONTINUOUS SHEATHING HAS BEEN
PROVIDED, ALONG WITH ALTERNATIVE METHODS TO
INSURE THE MINIMUM INTENT OF SECTION 602.10 OF
THE 2018 NCR HAS BEEN MET AND EXCEEDED.

-BRACED WALL PANELS SHALL BE FASTENED IN
ACCORDANCE WITH TABLE 602.3(1) TO PROVIDE
CONTINUOUS PANEL UPLIFT RESISTANCE AND
COMPLIANCE WITH NCRBC R602.3.5 AND R802.11
UNLESS NOTED OTHERWISE ON STRUCTURAL PLANS.

STRUCTURAL ENGINEERS
License No. C-3870
318 W Millbrook Road, Unit 201
Raleigh, North Carolina 27609
Phone: (919) 844-1661

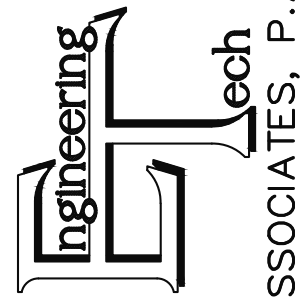

ASSOCIATES, P.A.

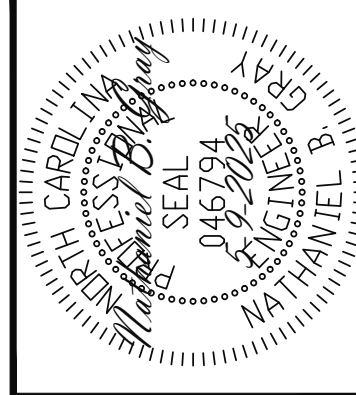

ADAMS HOMES			
STRUCTURAL ADDENDUM			
SCOPE	LOT #:	ENG	REV:
	57 KIPLING CREEK	NBC/TSP	
2604 MASTER		DATE	5-9-2025

PLAN NO.

2604

PROJECT NO.

25-18-256

SHEET NO.

S2


2 of 7

SIDING
OPTION

1ST FLOOR FRAMING PLAN

WALLS AND CEILING

1/4" = 1'-0"

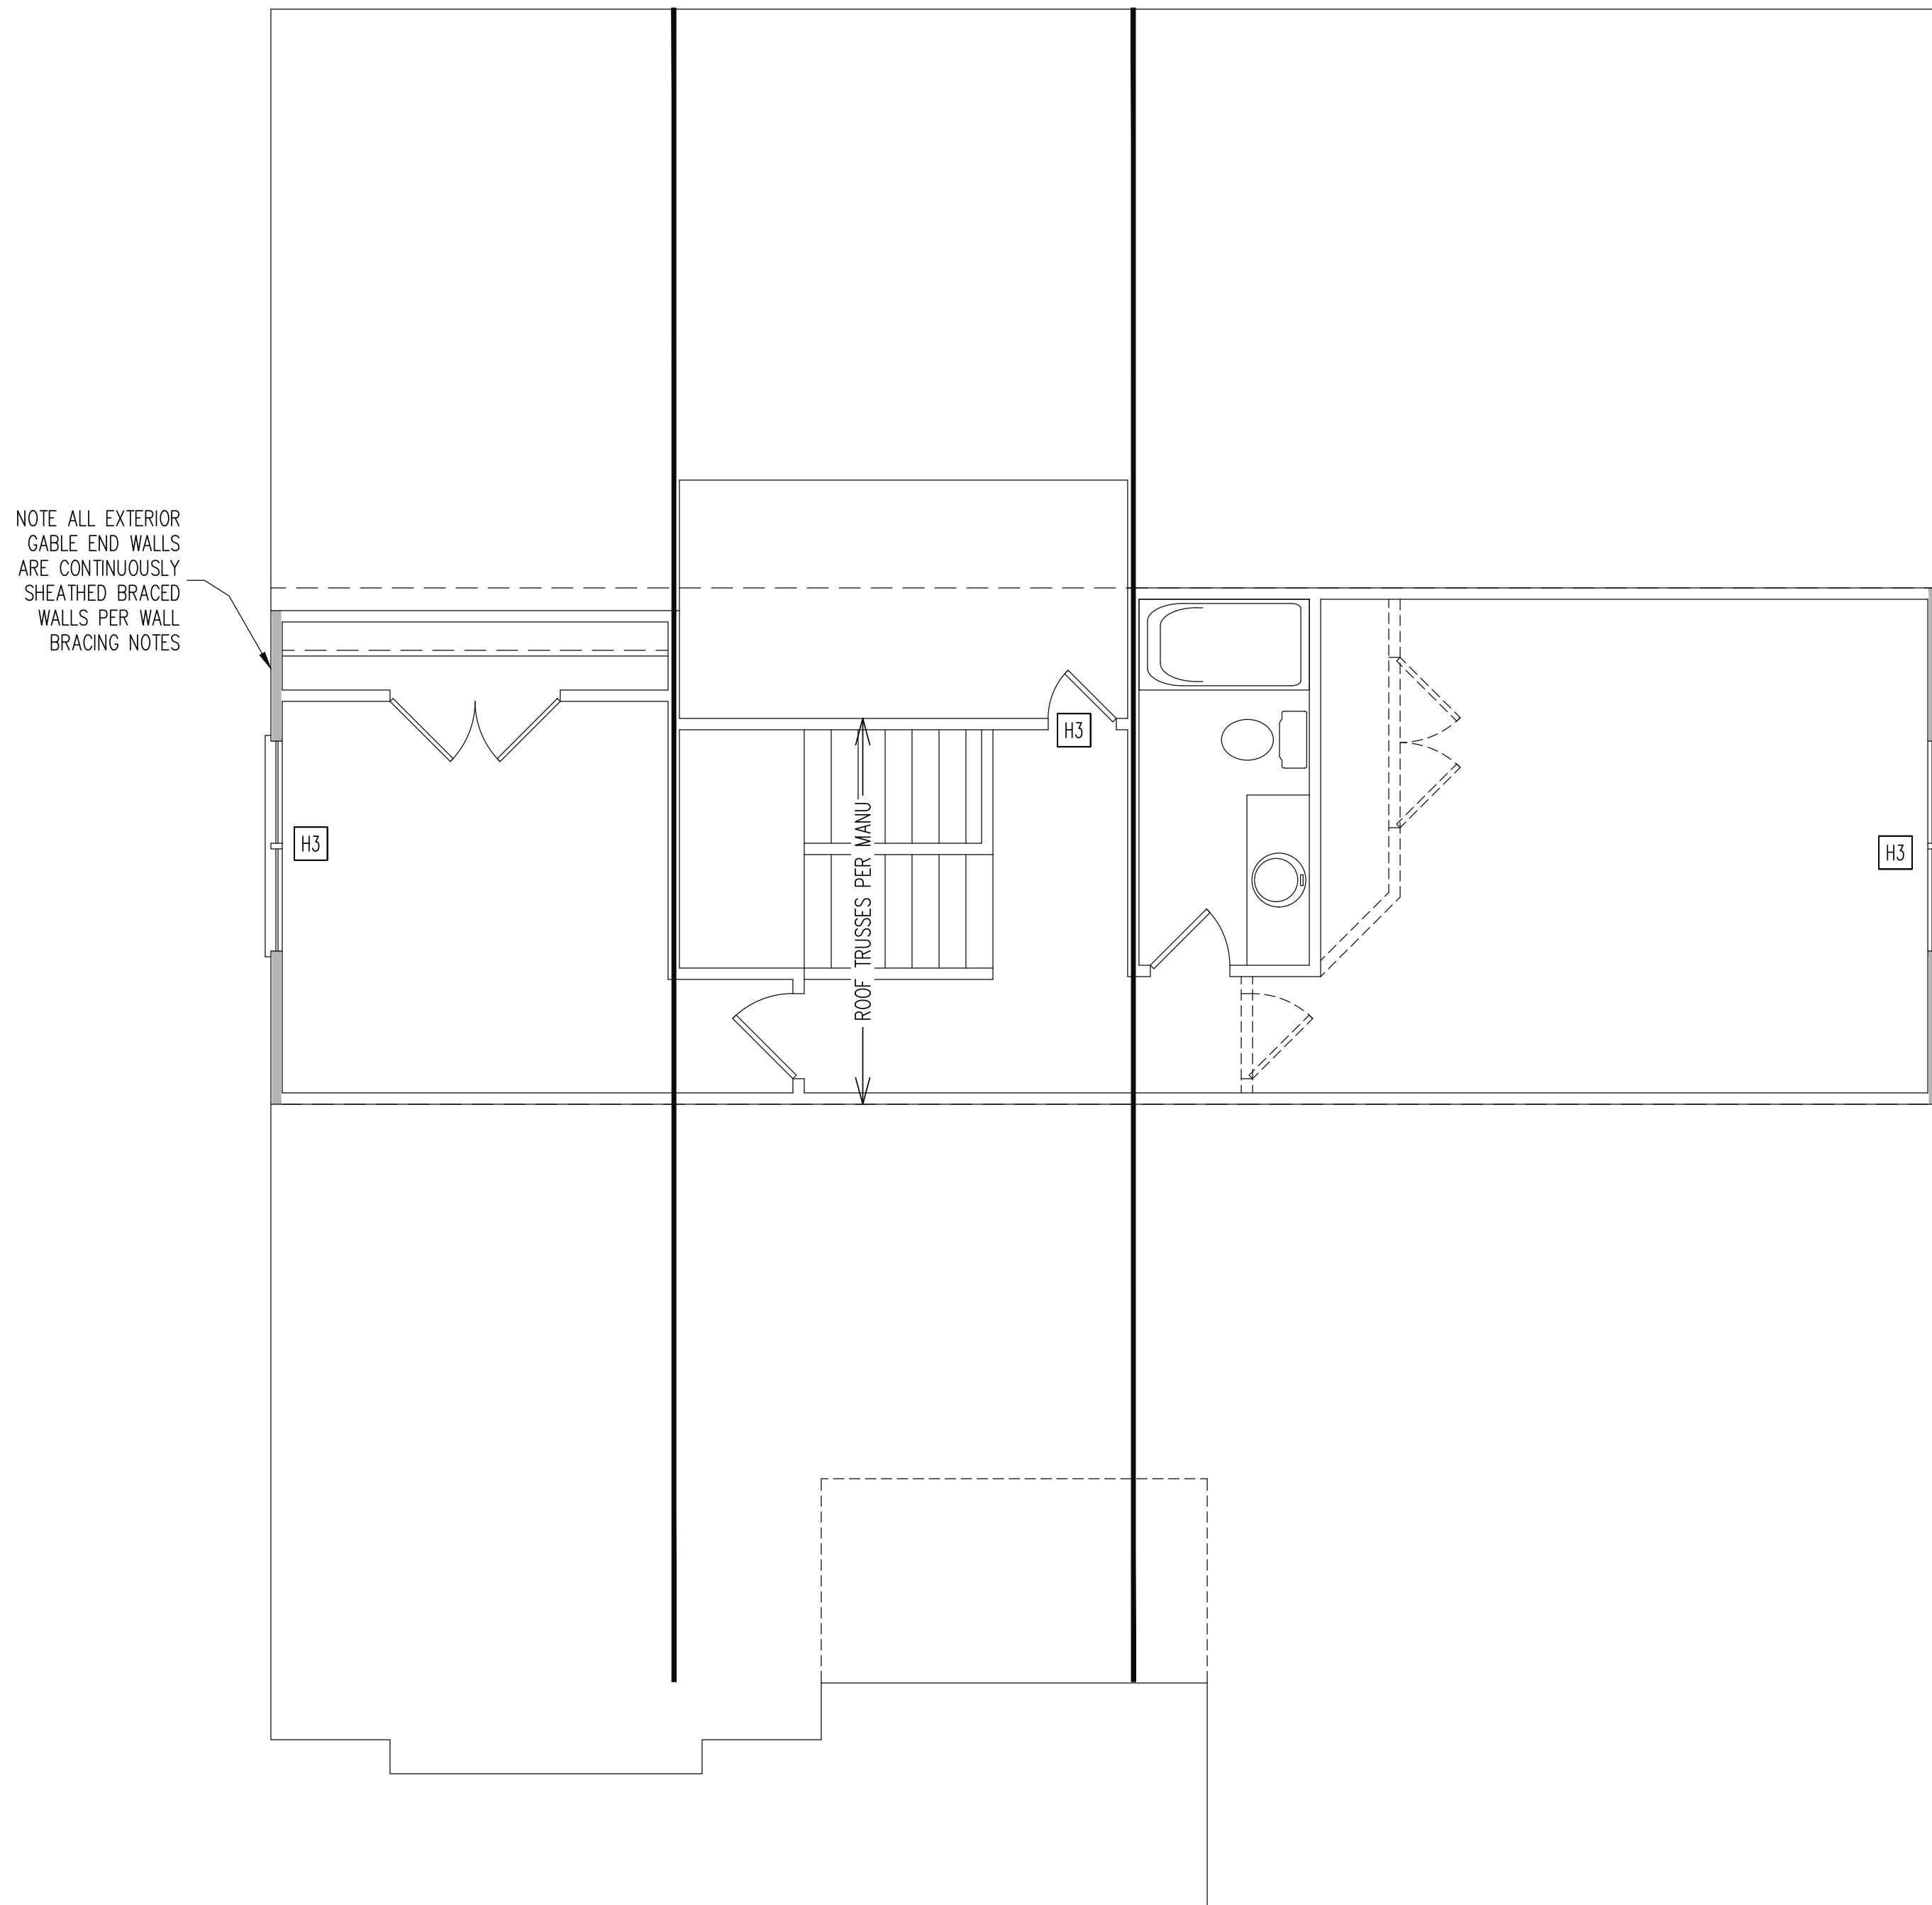

REQUIRED STUDS FOR BEAM SUPPORT

HEADER SCHEDULE

- (A) TYPICAL FOR INTERIOR NON LOAD BEARING WALLS ONLY, ROUGH OPENING 38" MAX.
- (B) TYPICAL FOR INTERIOR NON LOAD BEARING WALLS ONLY, ROUGH OPNG 38" TO 74" MAX.
- (C) TYPICAL FOR ALL CONDITIONS NOT LISTED IN (A) OR (B) UNO.

NOTES:

WALL BRACING



SINGLE JOIST, CONTINUOUS RIM JOIST, OR BLOCKING OF EQUAL DEPTH IS REQUIRED ABOVE AND BELOW ALL BRACED WALLS. NAIL BRACING ABOVE WALL TO TOP PLATE WITH 8d TOE NAILS @ 6" O.C. NAIL SOLE PLATE OF BRACED WALL TO BLOCKING BELOW WITH (3) 16d NAILS @ 16" O.C. BLOCKING AT HORIZONTAL JOINTS IN BRACED WALL LINES ONLY REQUIRED AT SHADED WALLS, UNO.

SHADED WALLS:

PROVIDED CONTINUOUS SHEATHING = 30' MIN.

—BRACED WALL PANELS SHALL BE FASTENED IN ACCORDANCE WITH TABLE 602.3(1) TO PROVIDE CONTINUOUS PANEL UPLIFT RESISTANCE AND COMPLIANCE WITH NCRBC R602.3.5 AND R802.11 UNLESS NOTED OTHERWISE ON STRUCTURAL PLANS.

WALLS AND CEILING
1/4" = 1'-0"

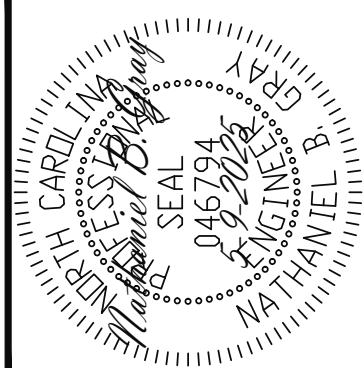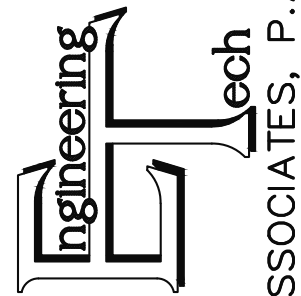


ADAMS HOMES	
STRUCTURAL ADDENDUM	
SCOPE:	
LOT #:	57 KIPLING CREEK
	ENG: NBC/TSP
	REV:
	DATE: 5-9-2025

2604

25-18-256

S3

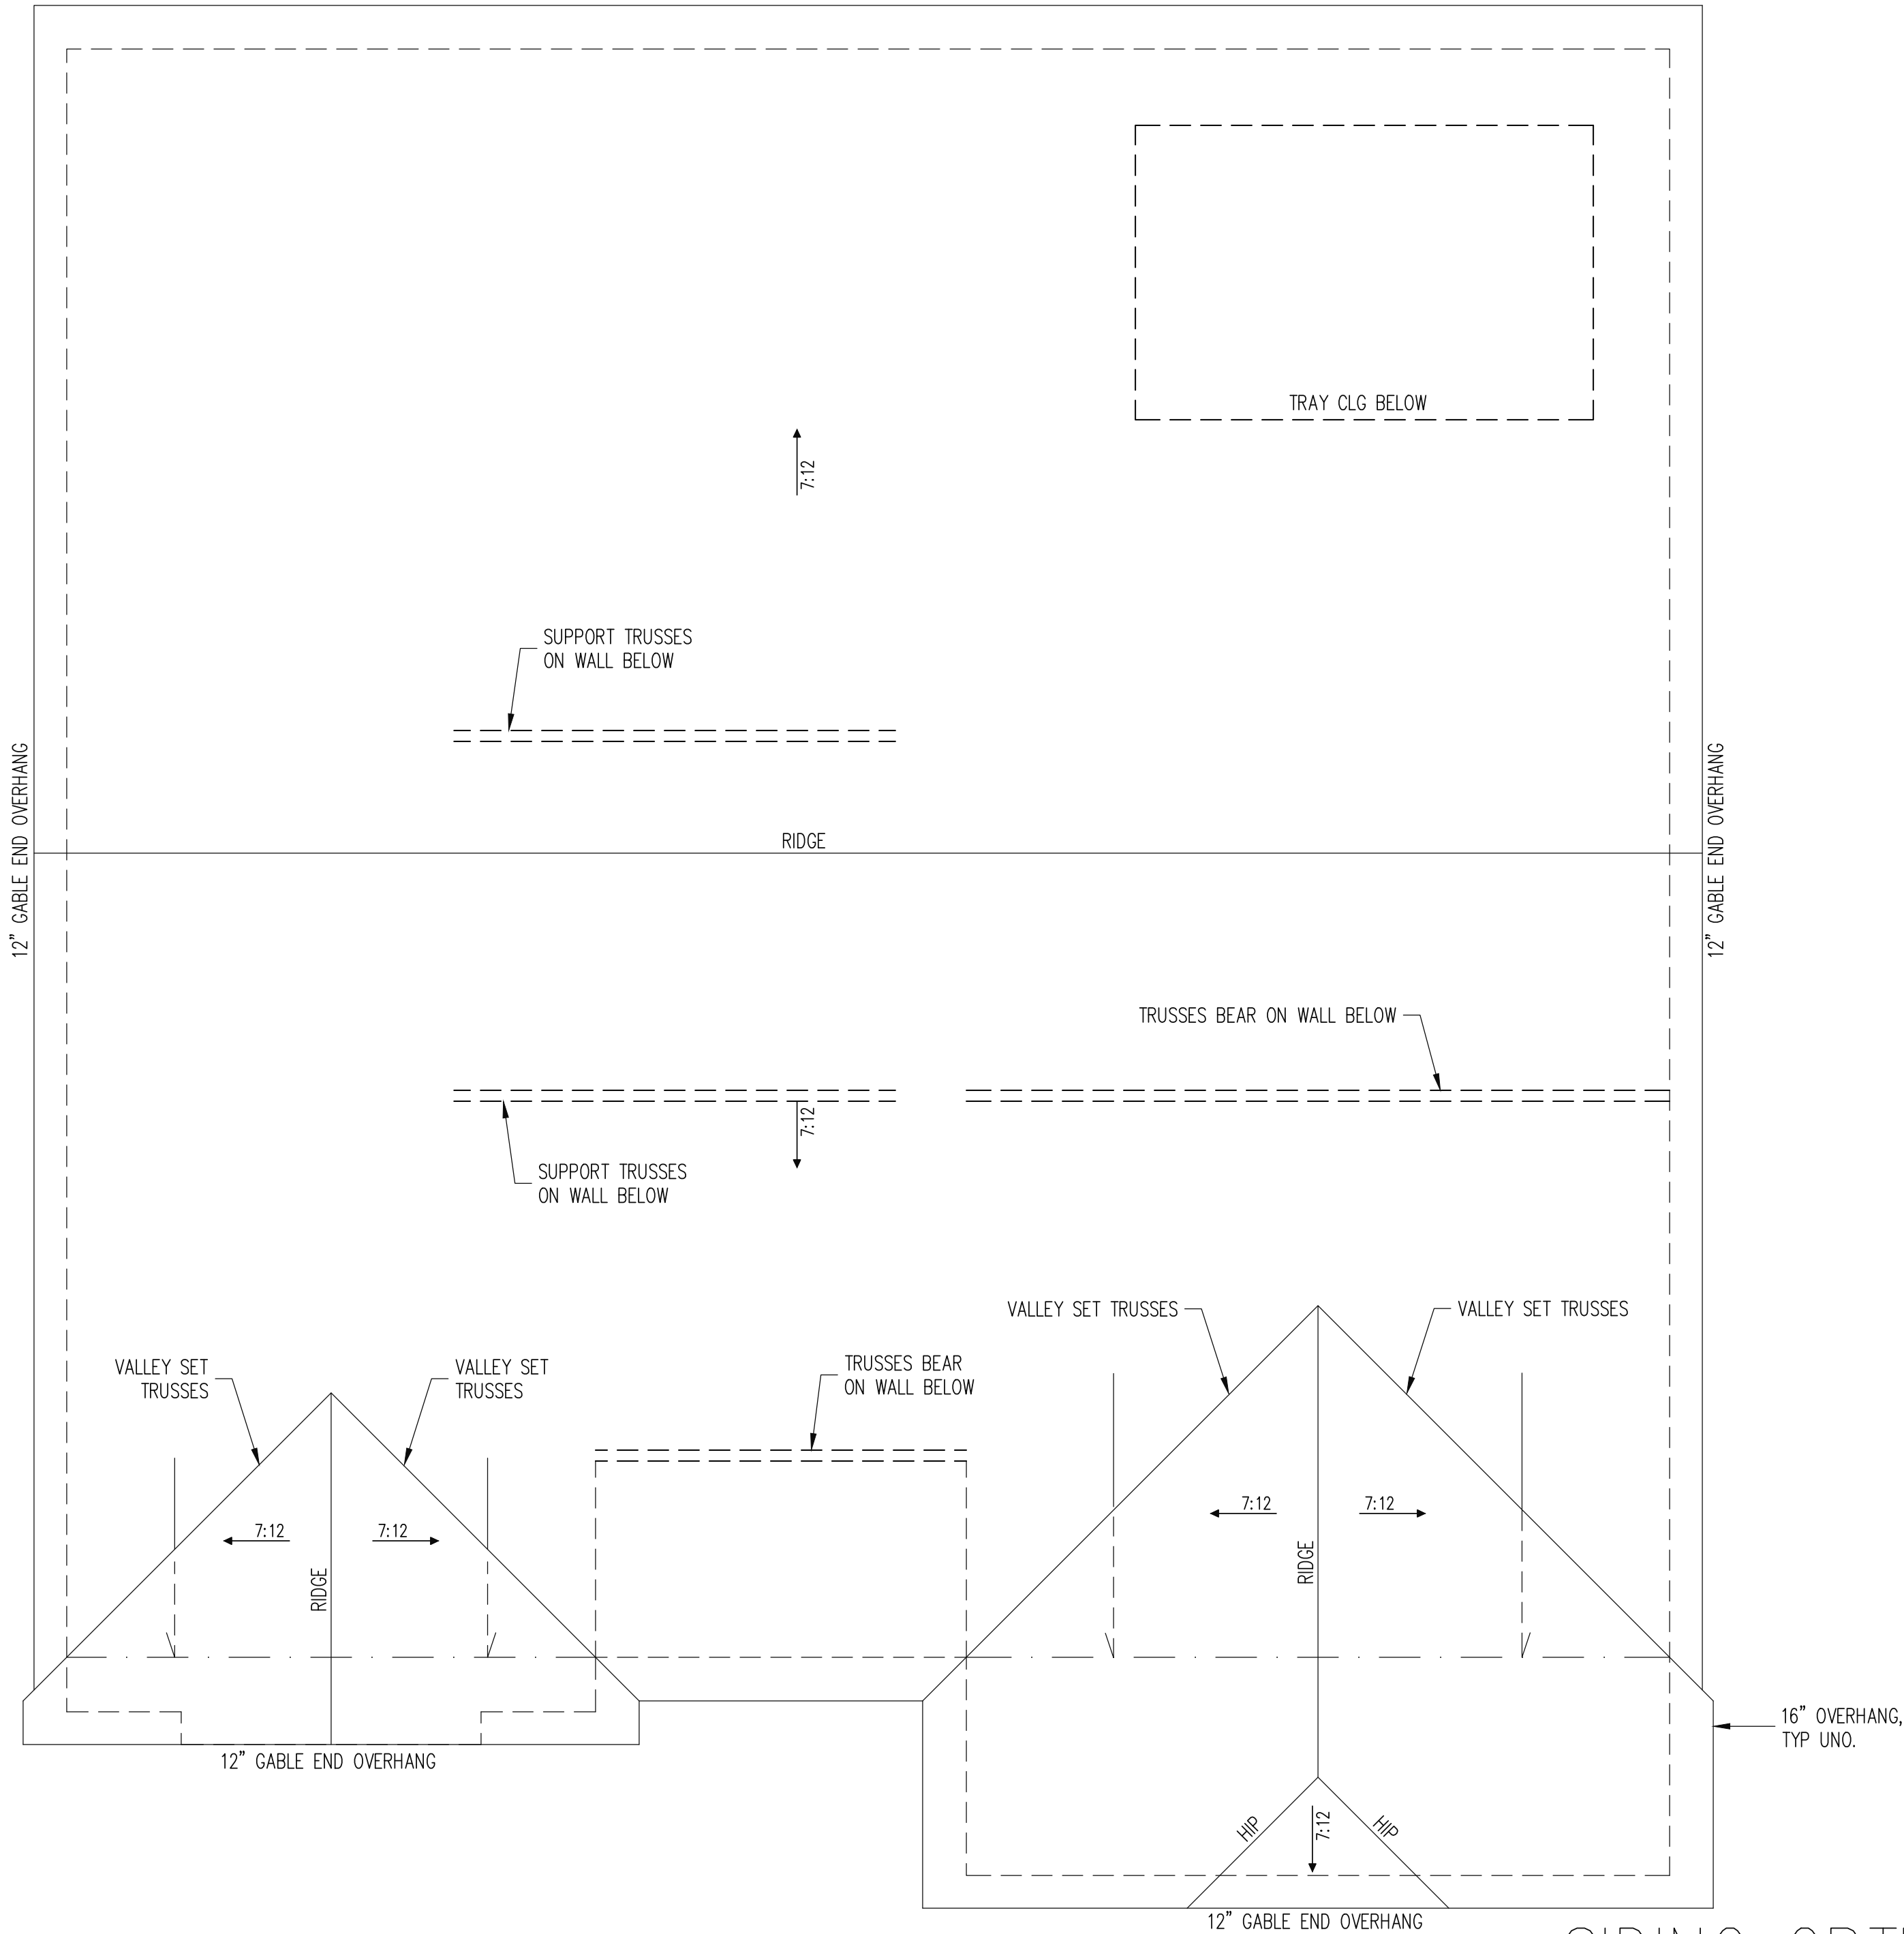

SIDING OPTION
ELEVATION A


The structural design of this plan is the property of Engineering Tech Associates, P.A. These plans are for the one time use at the location and for the client listed. Engineering Tech Associates, P.A. assumes no liability for these plans if they are reproduced, in whole or in part, for construction at any other location without written permission from Engineering Tech Associates, P.A.

TRUSS UPLIFT CONNECTORS

EXPOSURE B, 120 MPH, ANY PITCH, 24" O.C. MAX ROOF TRUSS SPACING
TRUSSES SHALL BE ATTACHED TO SUPPORT WALL FOR UPLIFT RESISTANCE. CONTINUOUS OSB WALL SHEATHING BELOW PROVIDES CONTINUOUS UPLIFT RESISTANCE TO FOUNDATION. ALL TRUSSES SUPPORTED BY INTERMEDIATE SUPPORT WALLS, KNEEWALLS OR BEAMS SHALL BE ATTACHED TO SUPPORTING MEMBER PER SCHEDULE BELOW.
ROOF SPAN IS MEASURED HORIZONTALLY BETWEEN FURTHEST SUPPORT POINTS.
ROOF SPAN UP TO 18' CONNECTOR NAILING PER TABLE 602.3(1) NCRBC 2018 EDITION
OVER 18' (1) SIMPSON H2.5A HURRICANE CLIP TO DBL TOP PLATE OR BEAM

FRAMING NOTES

ROOF ONLY
-ROOF TRUSSES PER MANU. TYPICAL U.N.O.
-ROOF PITCHES 7:12 TYP U.N.O.
-VERIFY ALL KNEEWALL HEIGHTS, ROOF PITCHES, AND ARCHITECTURAL OVERHANGS PRIOR TO CONSTRUCTION

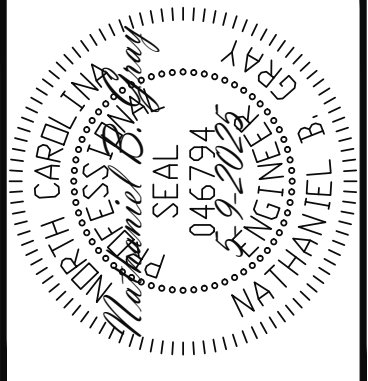

ADAMS HOMES			
STRUCTURAL ADDENDUM			
SCOPE			
LOT #:	57 KIPLING CREEK	ENG:	NBC/TSP
		REV:	
	2604 MASTER	DATE	5-9-2025


PLAN NO.
2604

PROJECT NO.
25-18-256




SHEET NO.
S4
4 of 7

STRUCTURAL ENGINEERS
License No. C-3870
318 W Millbrook Road, Unit 201
Raleigh, North Carolina 27609
Phone: (919) 844-1661


Engineering Tech
ASSOCIATES, P.A.

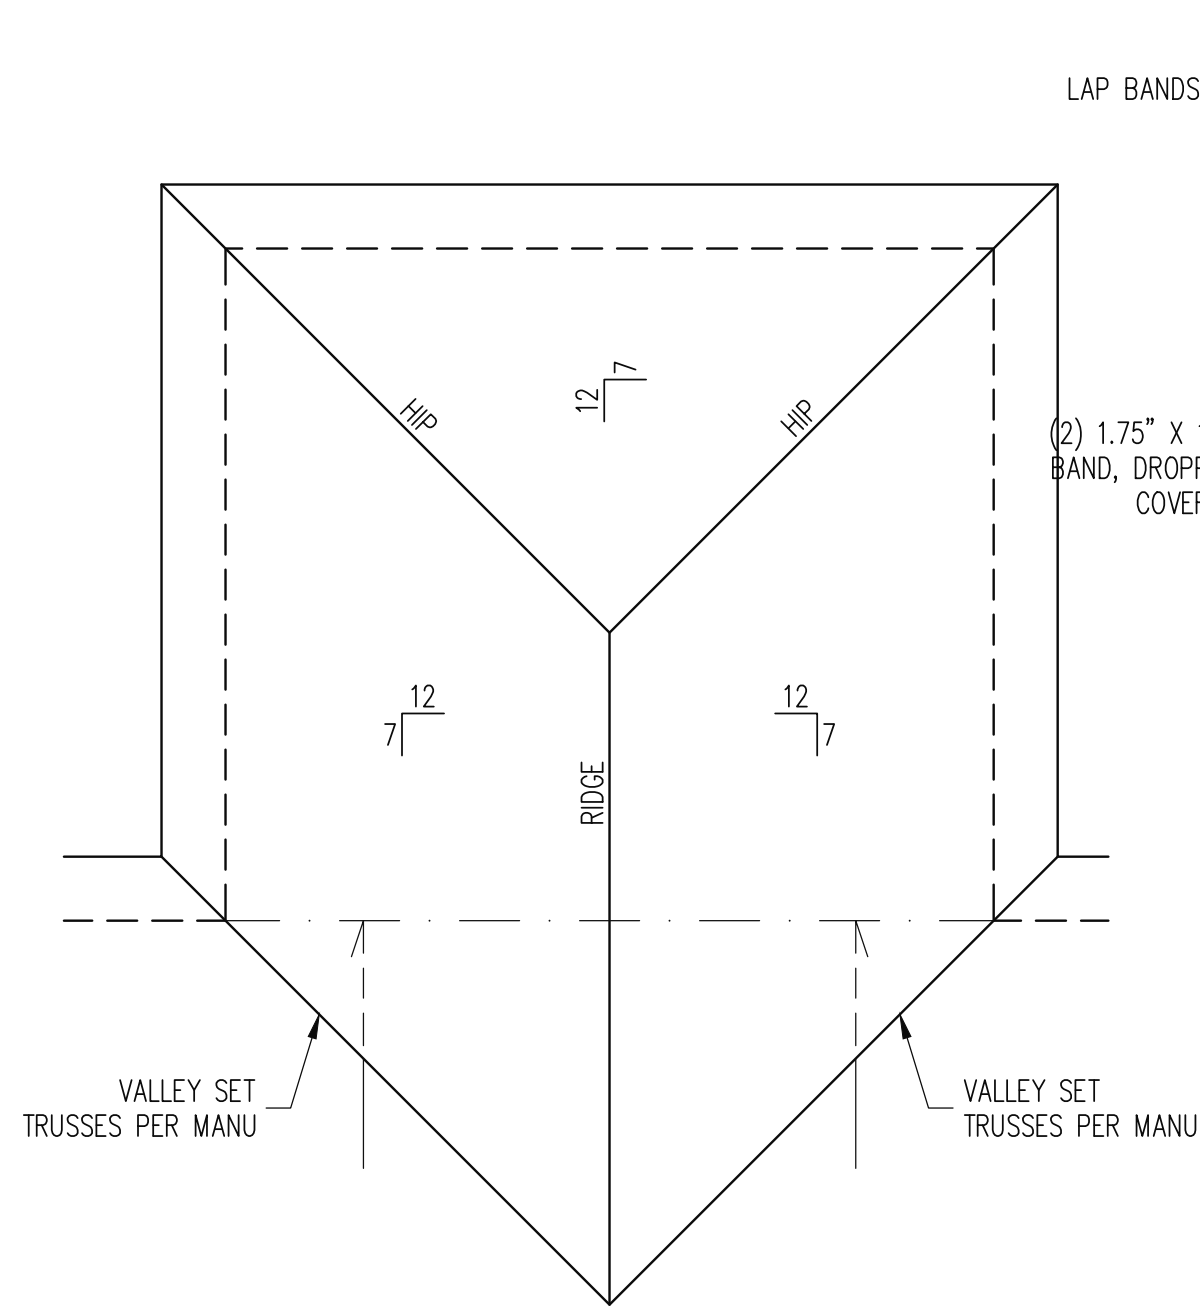


COVERED PORCH SCALE: 1/4"=1'-0"

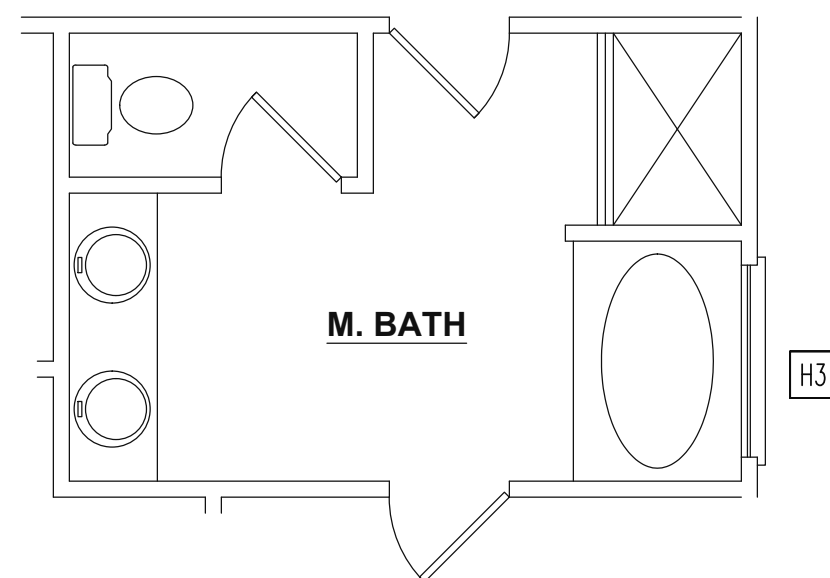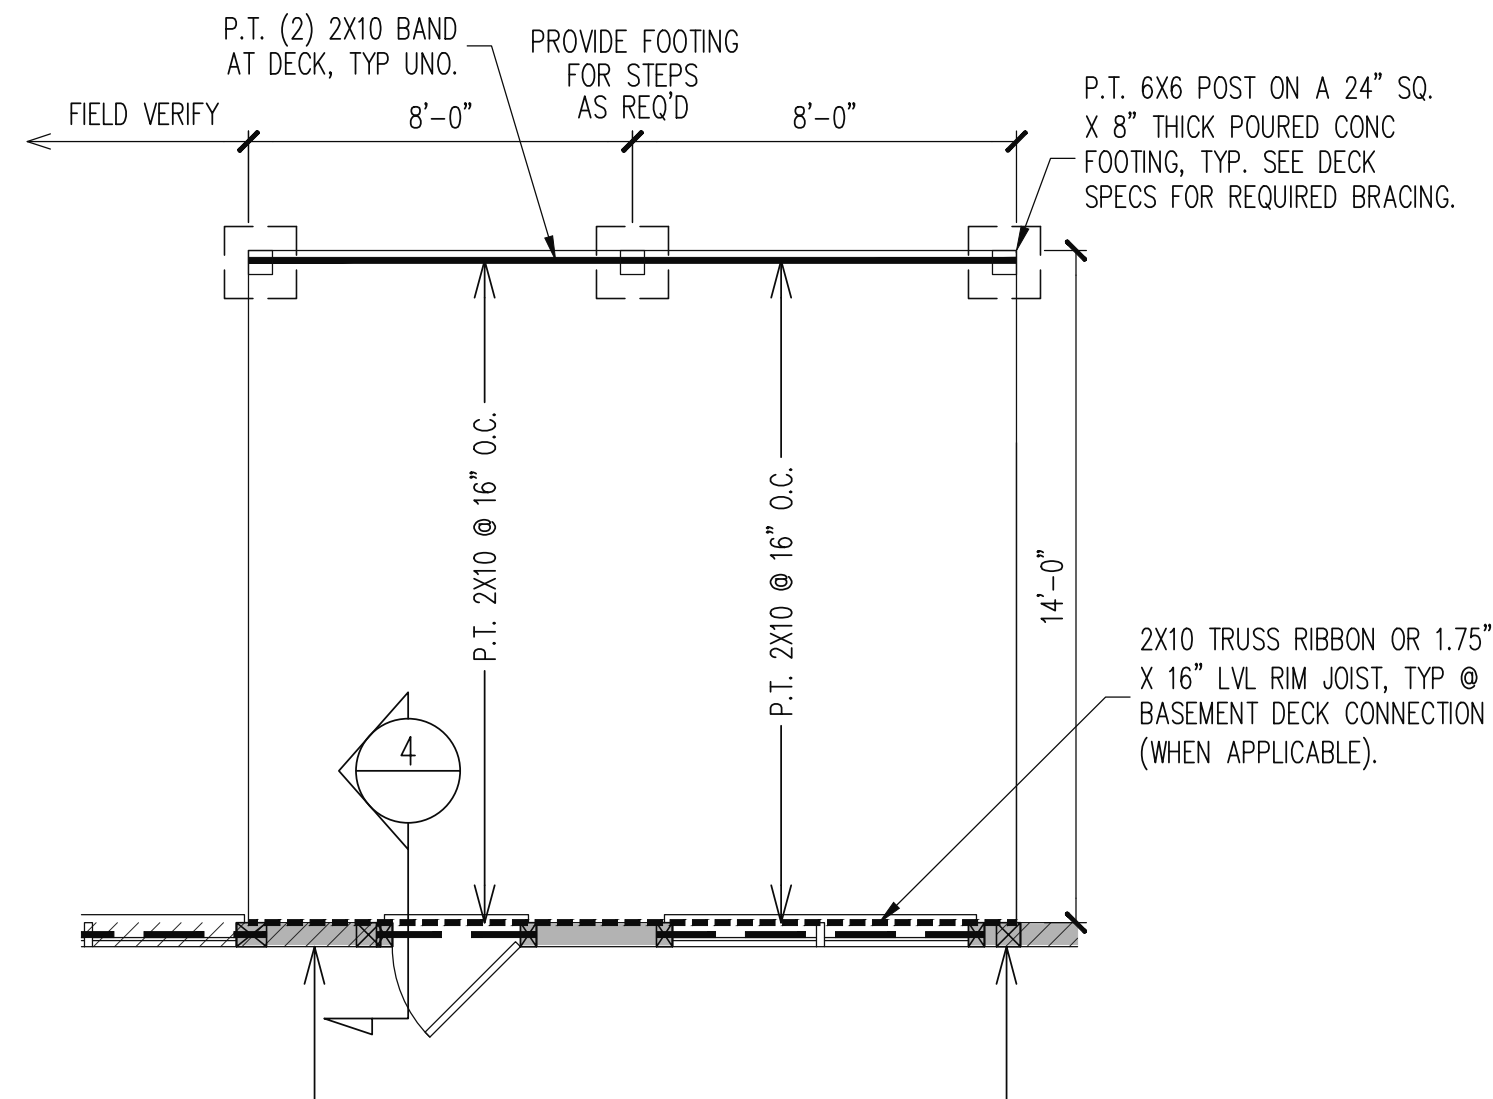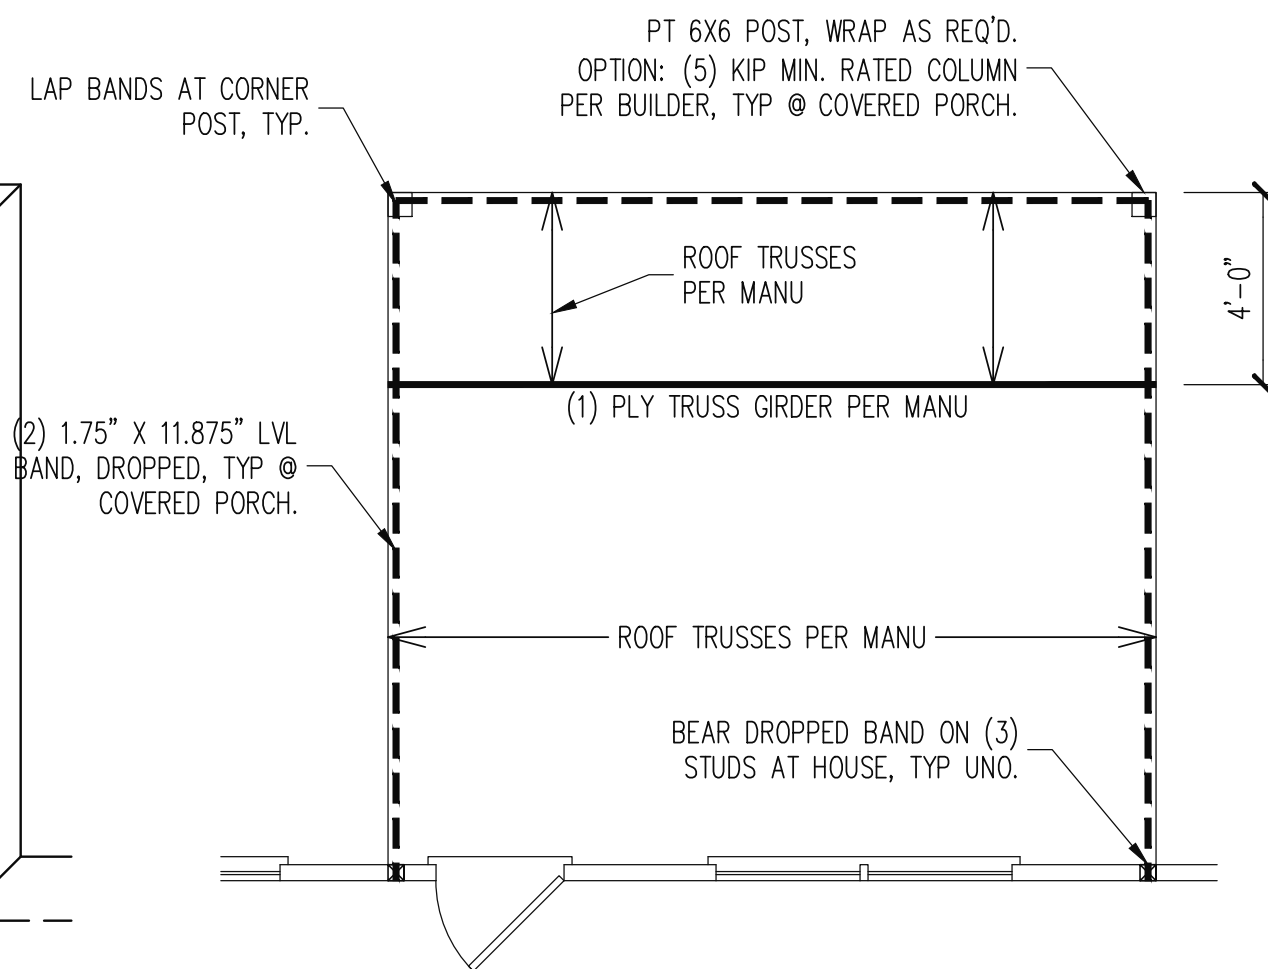


OPTIONAL MASTER BATH

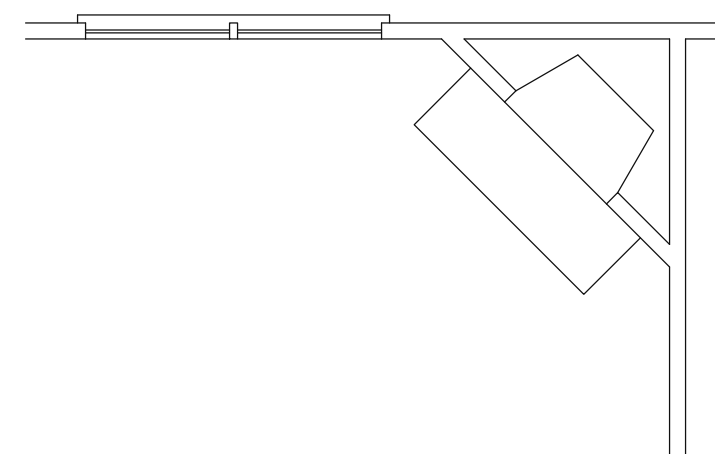

OPTIONAL FIREPLACE

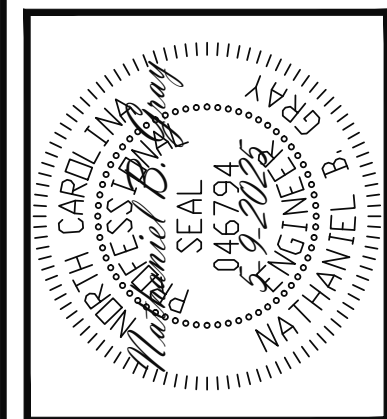

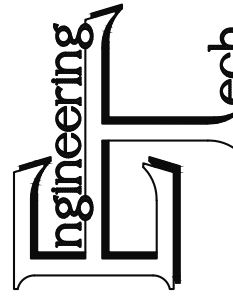

STRUCTURAL ENGINEERS
License No. C-3870
318 W Millbrook Road, Unit 201
Raleigh, North Carolina 27609
Phone: (919) 844-1661

ASSOCIATES, P.A.

ADAMS HOMES			
SCOPE	STRUCTURAL ADDENDUM		
	LOT #:	57 KIPLING CREEK	ENG: NBC/TSP
			REV:
		2604 MASTER	DATE: 5-9-2025

PLAN NO.
2604

PROJECT NO.
25-18-256

SHEET NO.
S7
7 of 7