

Residence for

Adams Homes AEC, LLC

Plan 2604 "A" FE (R) KC066

GENERAL NOTES:

- ALL WORK IS TO BE DONE IN STRICT ACCORDANCE WITH NORTH CAROLINA STATE RESIDENTIAL BUILDING CODE, 2018 EDITION (HEREWITH SHOWN AS N.C.S.R.B.C.).
- DIMENSIONS SHOWN ON DRAWINGS GOVERN OVER SCALE..
- STUD WALL DESIGN SHALL CONFORM TO ALL N.C.S.R.B.C. REQUIREMENTS.
- CONTRACTOR SHALL USE TEMPERED SAFETY GLASS IN ALL LOCATIONS AS REQUIRED BY N.C.S.R.B.C., SECTION R308.4
- ANY HABITABLE ROOM SHALL MEET ALL LIGHT/VENTILATION AND EGRESS AS REQUIRED BY N.C.S.R.B.C., SECTIONS R-303.1 AND R-310.1
- ALL WALLS SHOWN ON FLOOR PLANS ARE 2x4 FRAME UNLESS NOTED OTHERWISE.
- ALL ANGLED WALLS SHOWN ON FLOOR PLANS ARE 45° UNLESS NOTED OTHERWISE.
- ALL WINDOWS SHALL HAVE A MINIMUM DPI RATING OF 25. BUILDER SHALL VERIFY WITH WINDOW MANUFACTURER THAT UNITS INSTALLED MEET THESE REQUIREMENTS AS PER N.C.S.R.B.C., TABLE 301.2(6).
- ENERGY EFFICIENCY REQUIREMENTS FOR THE SPECIFIC CLIMATE ZONE WHERE STRUCTURE IS BEING BUILT SHALL BE IN ACCORDANCE WITH CHAPTER 11 OF THE NORTH CAROLINA RESIDENTIAL BUILDING CODE, AS SHOWN IN TABLES N1101.2 AND N1102.1.
- TERMITE TREATMENT - BORATE APPLIED TO ALL FRAME MEMBERS WITHIN 24" AFF.

INDEX TO DRAWINGS:

- COVER SHEET**
- 1 FRONT AND LEFT SIDE ELEVATIONS
2 REAR AND RIGHT SIDE ELEVATIONS
3 FIRST FLOOR PLAN
4 SECOND FLOOR PLAN
5 FIRST FLOOR ELECTRICAL PLAN
6 SECOND FLOOR ELECTRICAL PLAN
OPT1 FLOOR PLAN OPTIONS
OPT2 REAR PORCH OPTION
D1 CONSTRUCTION DETAILS
- S1 MONO SLAB FOUNDATION PLAN
S2 FIRST FLOOR CEILING FRAMING PLAN
S3 SECOND FLOOR CEILING FRAMING PLAN
S4 ROOF FRAMING PLAN
SD1 STRUCTURAL DETAILS
SPEC STRUCTURAL SPECIFICATIONS
S7 PLAN OPTIONS

RESIDENTIAL BUILDING CODE SUMMARY

- PLANS ARE DESIGNED TO THE 2018 NORTH CAROLINA RESIDENTIAL BUILDING CODE.
- HOUSE IS DESIGNED FOR 120 MPH, 3 SECOND GUST (93 MPH FASTEST WIND), EXPOSURE B.
- ANCHOR BOLTS SHALL BE MIN. 1/2" DIAMETER WITH STANDARD WASHER AND NUT AND SHALL EXTEND 7" MIN. INTO MASONRY OR CONCRETE. BOLTS TO BE NO MORE THAN 6' O.C. AND WITHIN 12" OF CORNERS. ALTERNATE ANCHOR STRAPS CAN BE USED INSTEAD OF ANCHOR BOLTS SPACED AT THE EQUIVALENT SPACING AND INSTALLED PER MANUFACTURER'S SPECIFICATION'S EXCEPT AT GARAGE LUG FTG.
- MEAN ROOF HEIGHT: 17'-6"
- COMPONENT & CLADDING DESIGNED FOR THE FOLLOWING LOADS:
MEAN ROOF HGT: UP TO 30' 30'-1" TO 35' 35'-1" TO 40' 40'-1" TO 45'
ZONE 1 16.5, -18.0 17.3, -18.9 18.0, -19.6 18.5, -20.2
ZONE 2 16.5, -21.0 17.3, -22.1 18.0, -22.9 18.5, -23.5
ZONE 3 16.5, -21.0 17.3, -22.1 18.0, -22.9 18.5, -23.5
ZONE 4 18.0, -19.5 18.9, -20.5 19.6, -21.3 20.2, -21.8
ZONE 5 18.0, -24.1 18.9, -25.3 19.6, -26.3 20.2, -27.0
- MINIMUM VALUES FOR ENERGY COMPLIANCE: ZONE 4
- MAXIMUM GLAZING U-FACTOR: 0.35
- INSULATING VALUES: CEILING: R-30* / WALLS: R-15 / FLOOR: R-19 / SLABS: R-10. CODE REFERENCE: TABLE N1102.1 (*R-30 ONLY IF UNCOMPRESSED, R-38 REQUIRED IF COMPRESSED)
- FLASHING SHALL BE INSTALLED IN ACCORDANCE WITH SECTION R703.8 OF THE N.C.R.B.C.
- FIREBLOCKING SHALL BE INSTALLED IN ACCORDANCE WITH SECTION R602.8 OF THE N.C.R.B.C.
- DRAFTSTOPPING SHALL BE INSTALLED IN ACCORDANCE WITH SECTION R302.12 OF THE N.C.R.B.C.

MATERIALS LEGEND

	EARTH/COMPACT FILL		FINISH WOOD
	CONCRETE		ROUGH WOOD
	BRICK		BLOCKING
	CONCRETE BLOCK/STONE		PLYWOOD
	STEEL		BATT INSULATION
	ALUMINUM		RIGID INSULATION

TOILET ACCESSORIES LEGEND

PROVIDE 2x4 BLOCKING IN THE WALL FOR THE FOLLOWING:

TB	TOWEL BAR
TP	TOILET PAPER HOLDER
TR	TOWEL RING
MC	MEDICINE CABINET
MR	MAGAZINE RACK

THE PURPOSE OF THESE DRAWINGS IS TO SHOW THE INTENT OF THE DESIGN AND CONSTRUCTION OF THIS HOME. ANY ERRORS AND/OR OMISSIONS FOUND IN THIS SET SHOULD IMMEDIATELY BE REPORTED TO ADAMS HOMES FOR CLARIFICATION OR CORRECTION. THE CONTRACTOR SHOULD VERIFY ALL CONDITIONS AND DIMENSIONS PRIOR TO CONSTRUCTION.

AREA CALCULATIONS


1ST FLOOR:	1987	GARAGE:	533
2ND FLOOR:	617	FRONT PORCH:	68
REC. ROOM:	0	PATIO:	140
TOTAL:	2604	BRICK:	0
		TOTAL:	741
WIDTH:	49'-0"		
DEPTH:	55'-10"	COV. PORCH OPTION:	224

FOUNDATION VENTING CALCULATIONS

NOT NEEDED WITH SLAB FOUNDATION

ATTIC VENTILATION REQUIREMENTS


NATURAL ROOF VENTILATION	MECHANICAL ROOF VENTILATOR
2500 SQ. FT.	2500 SQ. FT.
150 = 17.25 SQ. FT. VENT REQ'D	300 = 8.63 SQ. FT. VENT REQ'D
BUILDER TO PROVIDE APPROPRIATE VENTILATING AS REQUIRED PER CODE	

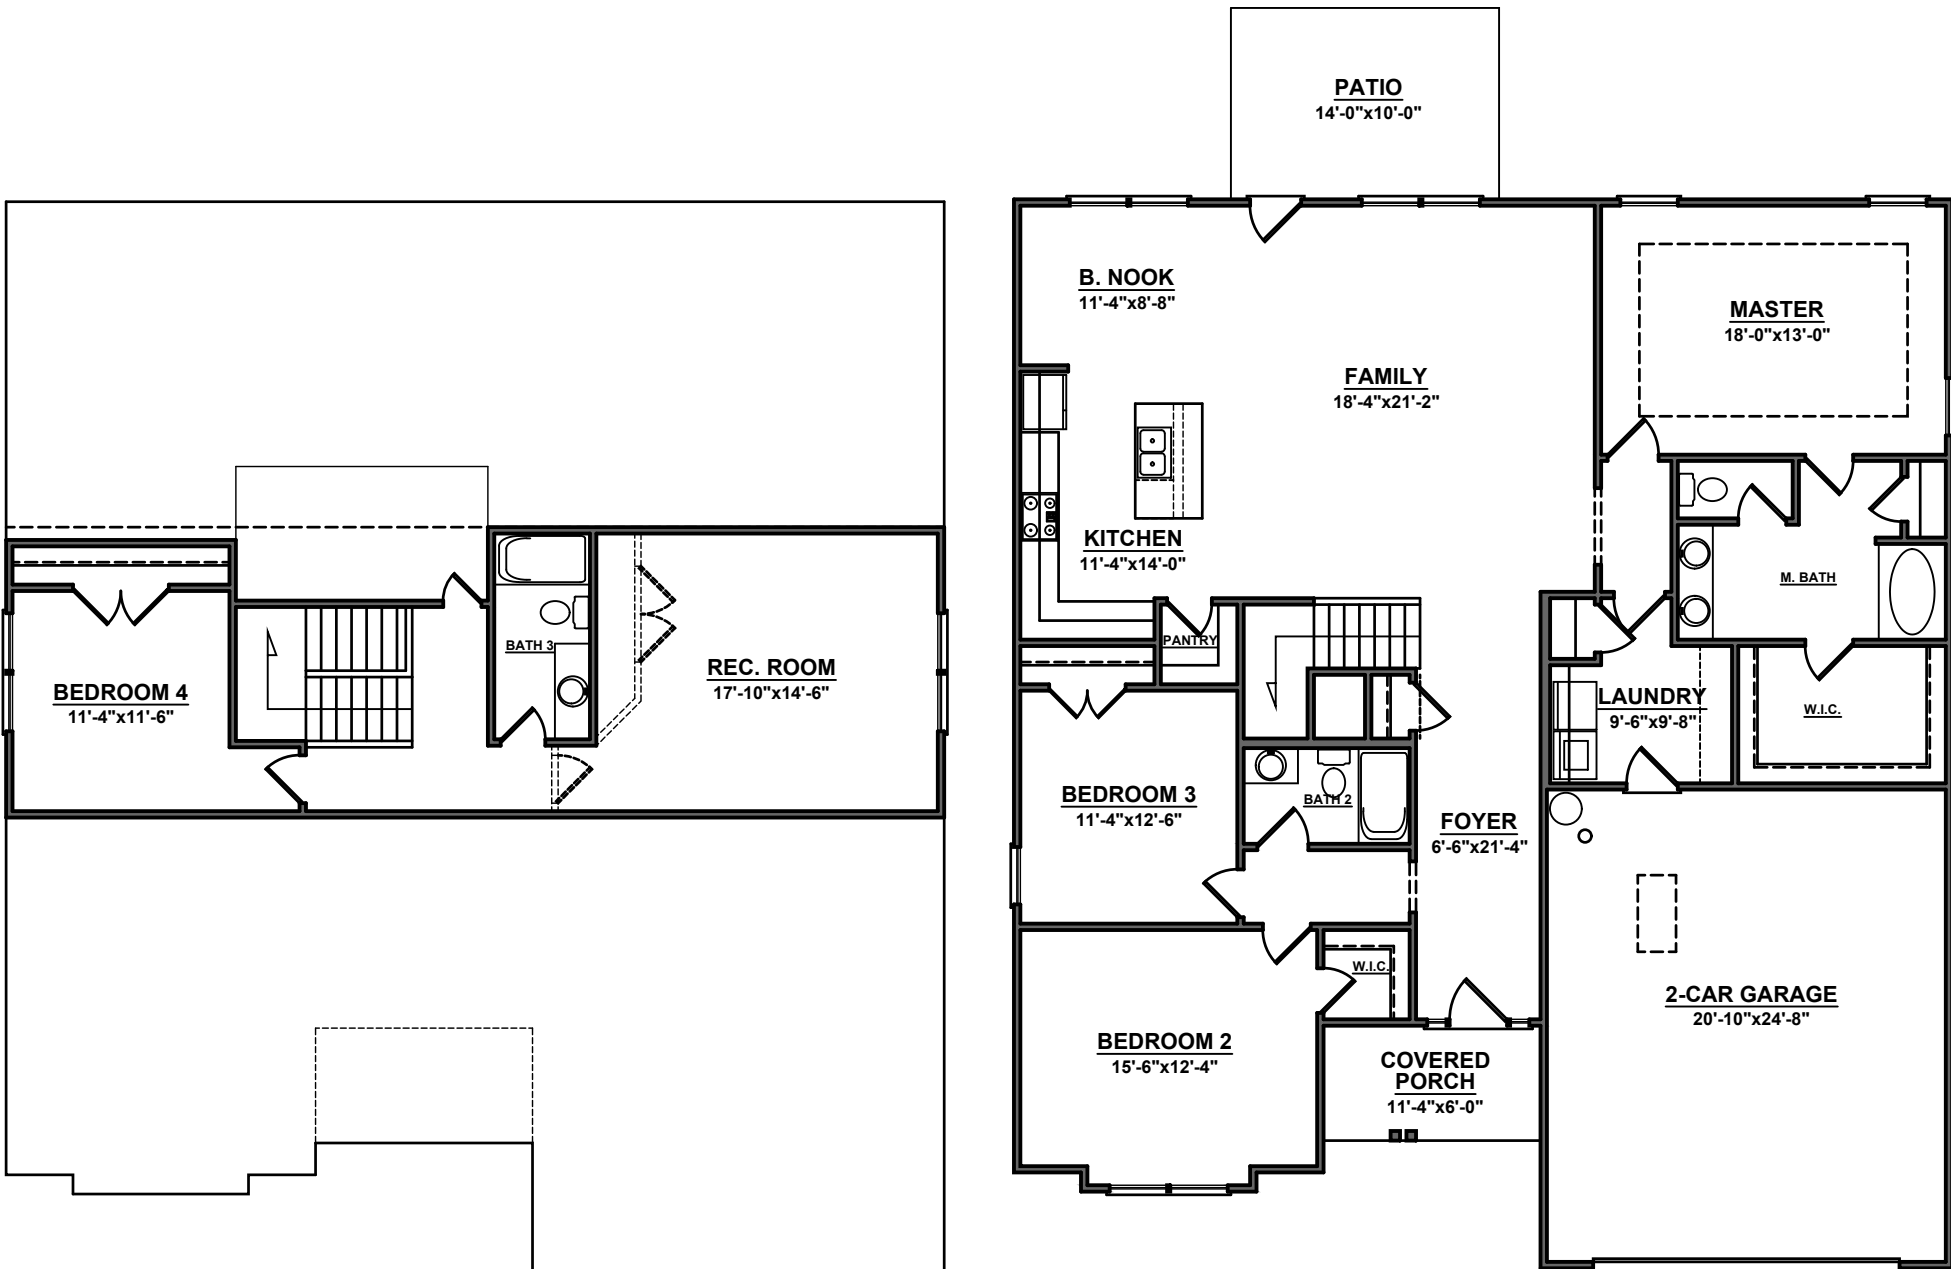


HOMES

AEC, LLC


7593

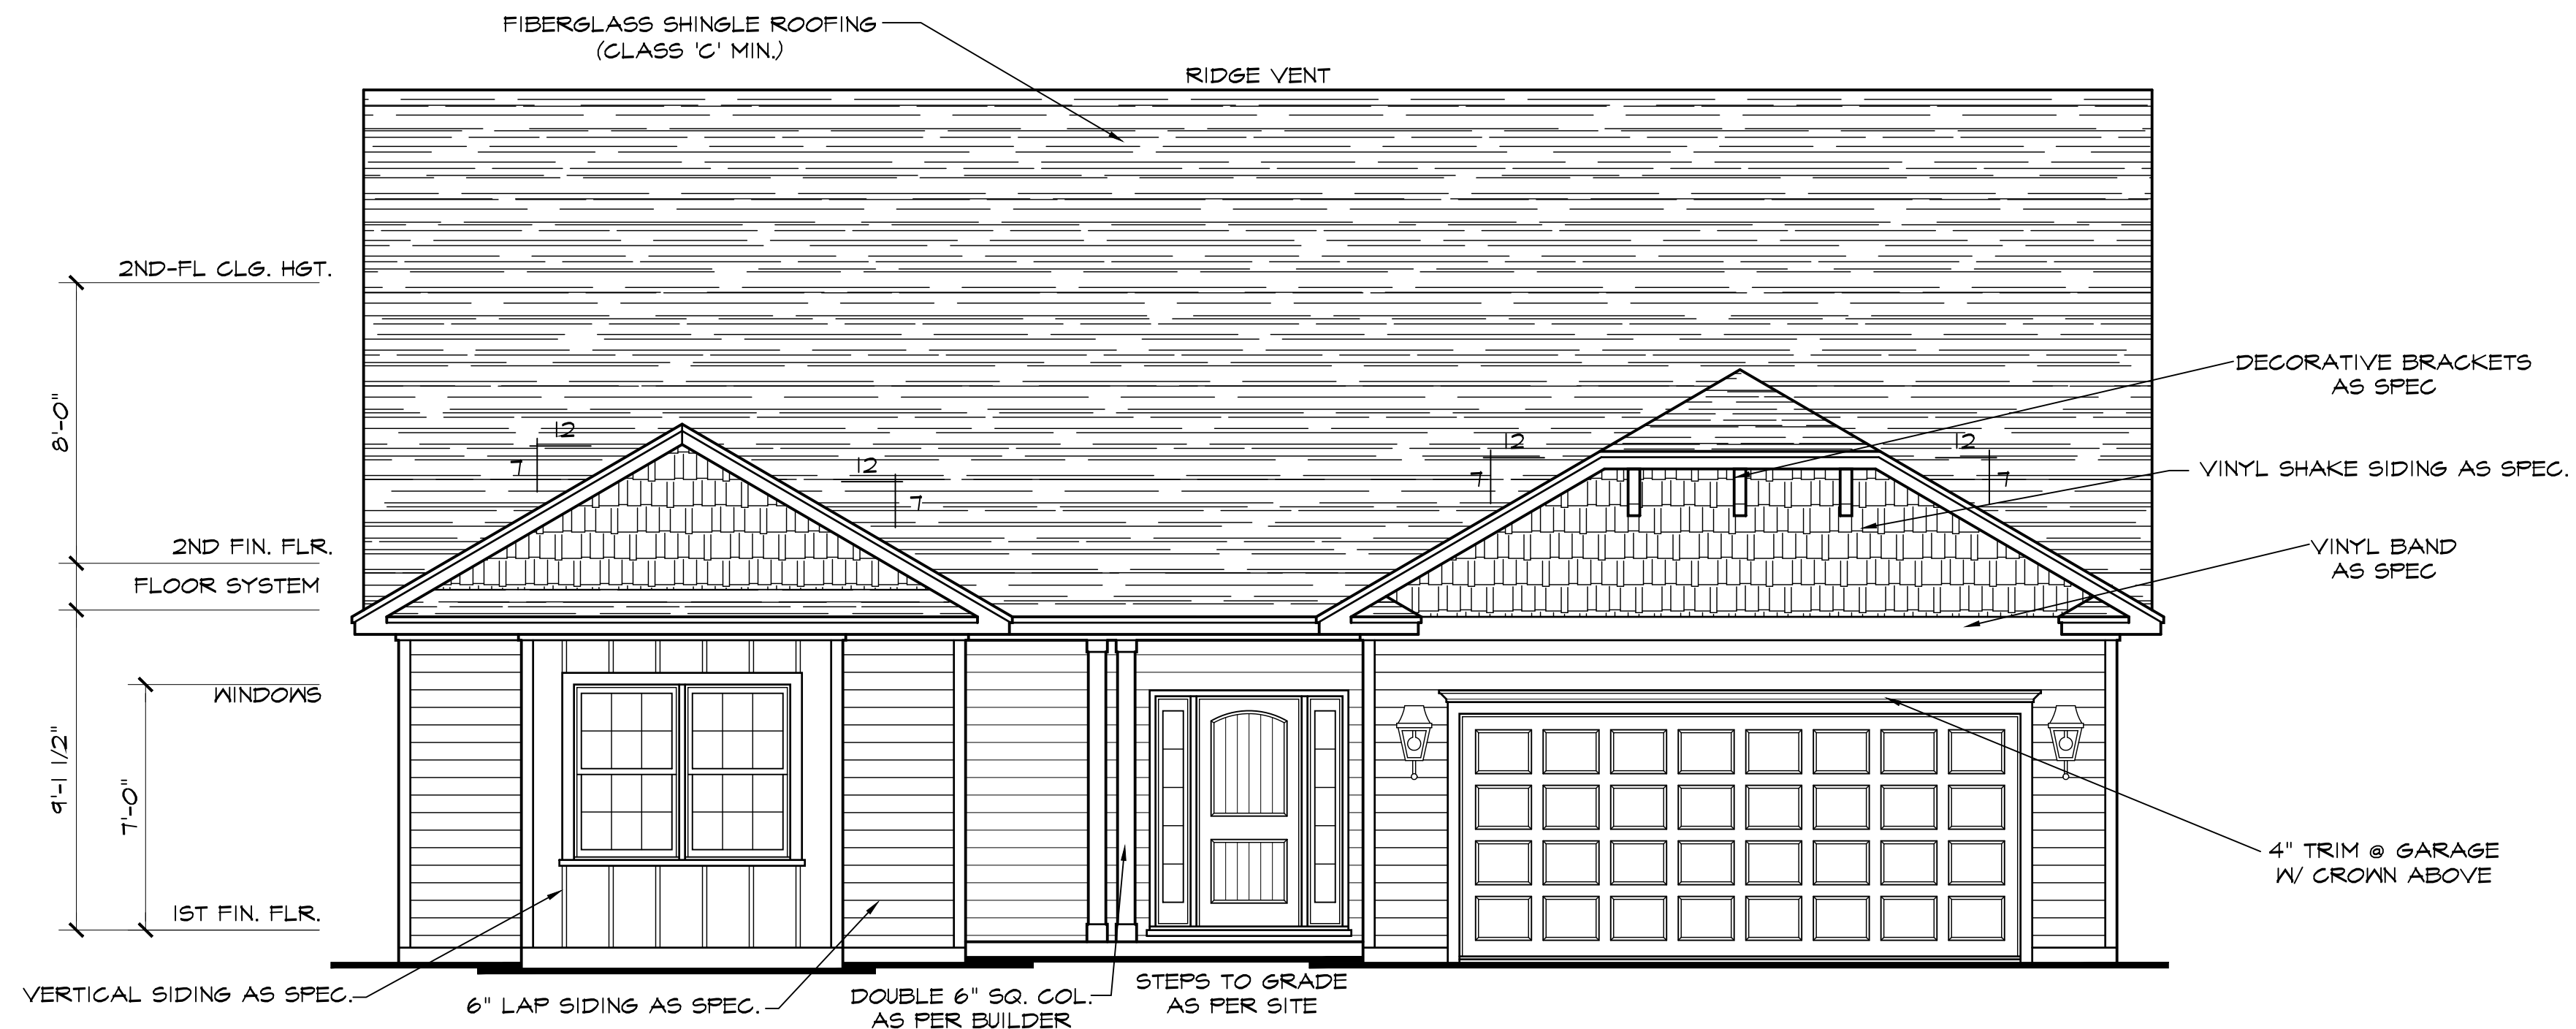


FRONT ELEVATION A SCALE: 1/4"=1'-0"
NOTE - SLOPE ALL GRADES AWAY FROM HOUSE FOR POSITIVE DRAINAGE

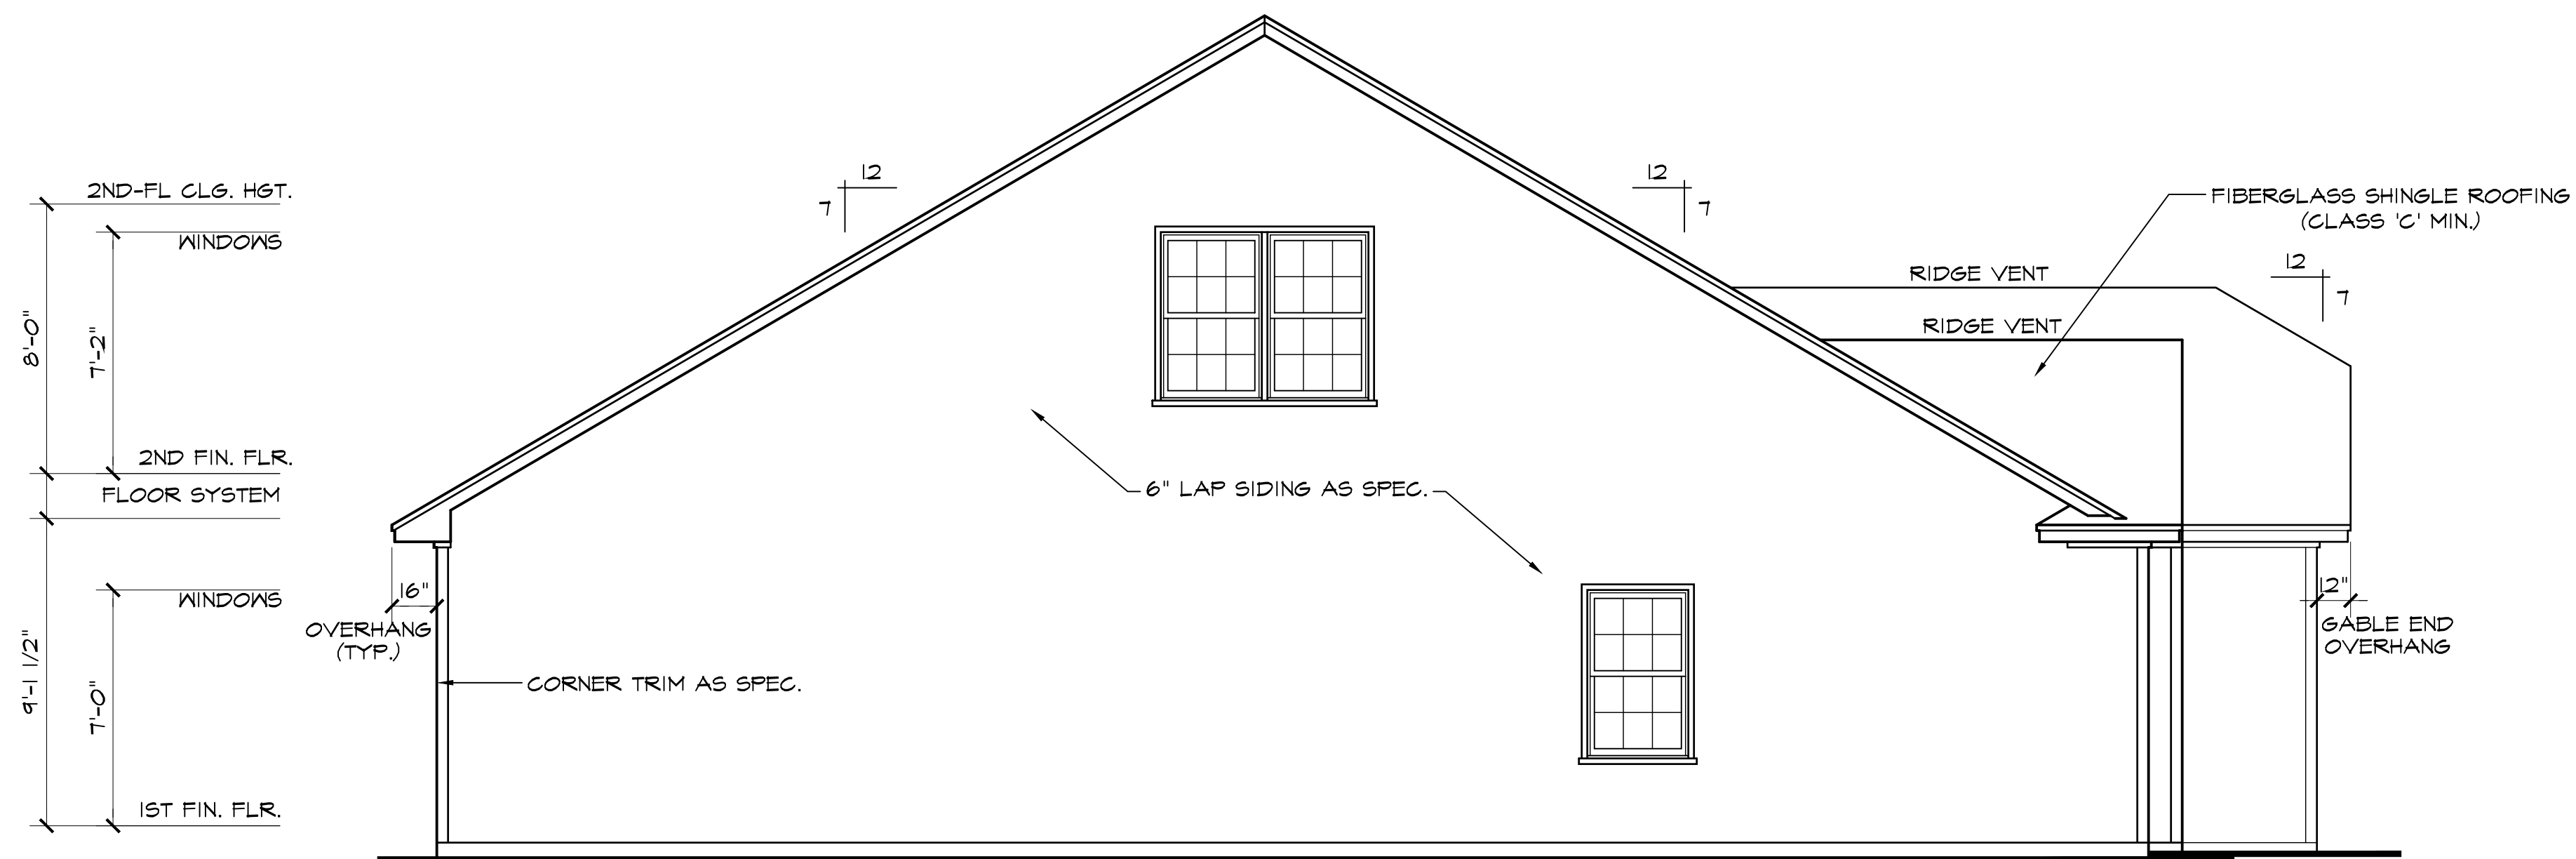

LEFT SIDE ELEVATION SCALE: 1/4"=1'-0"

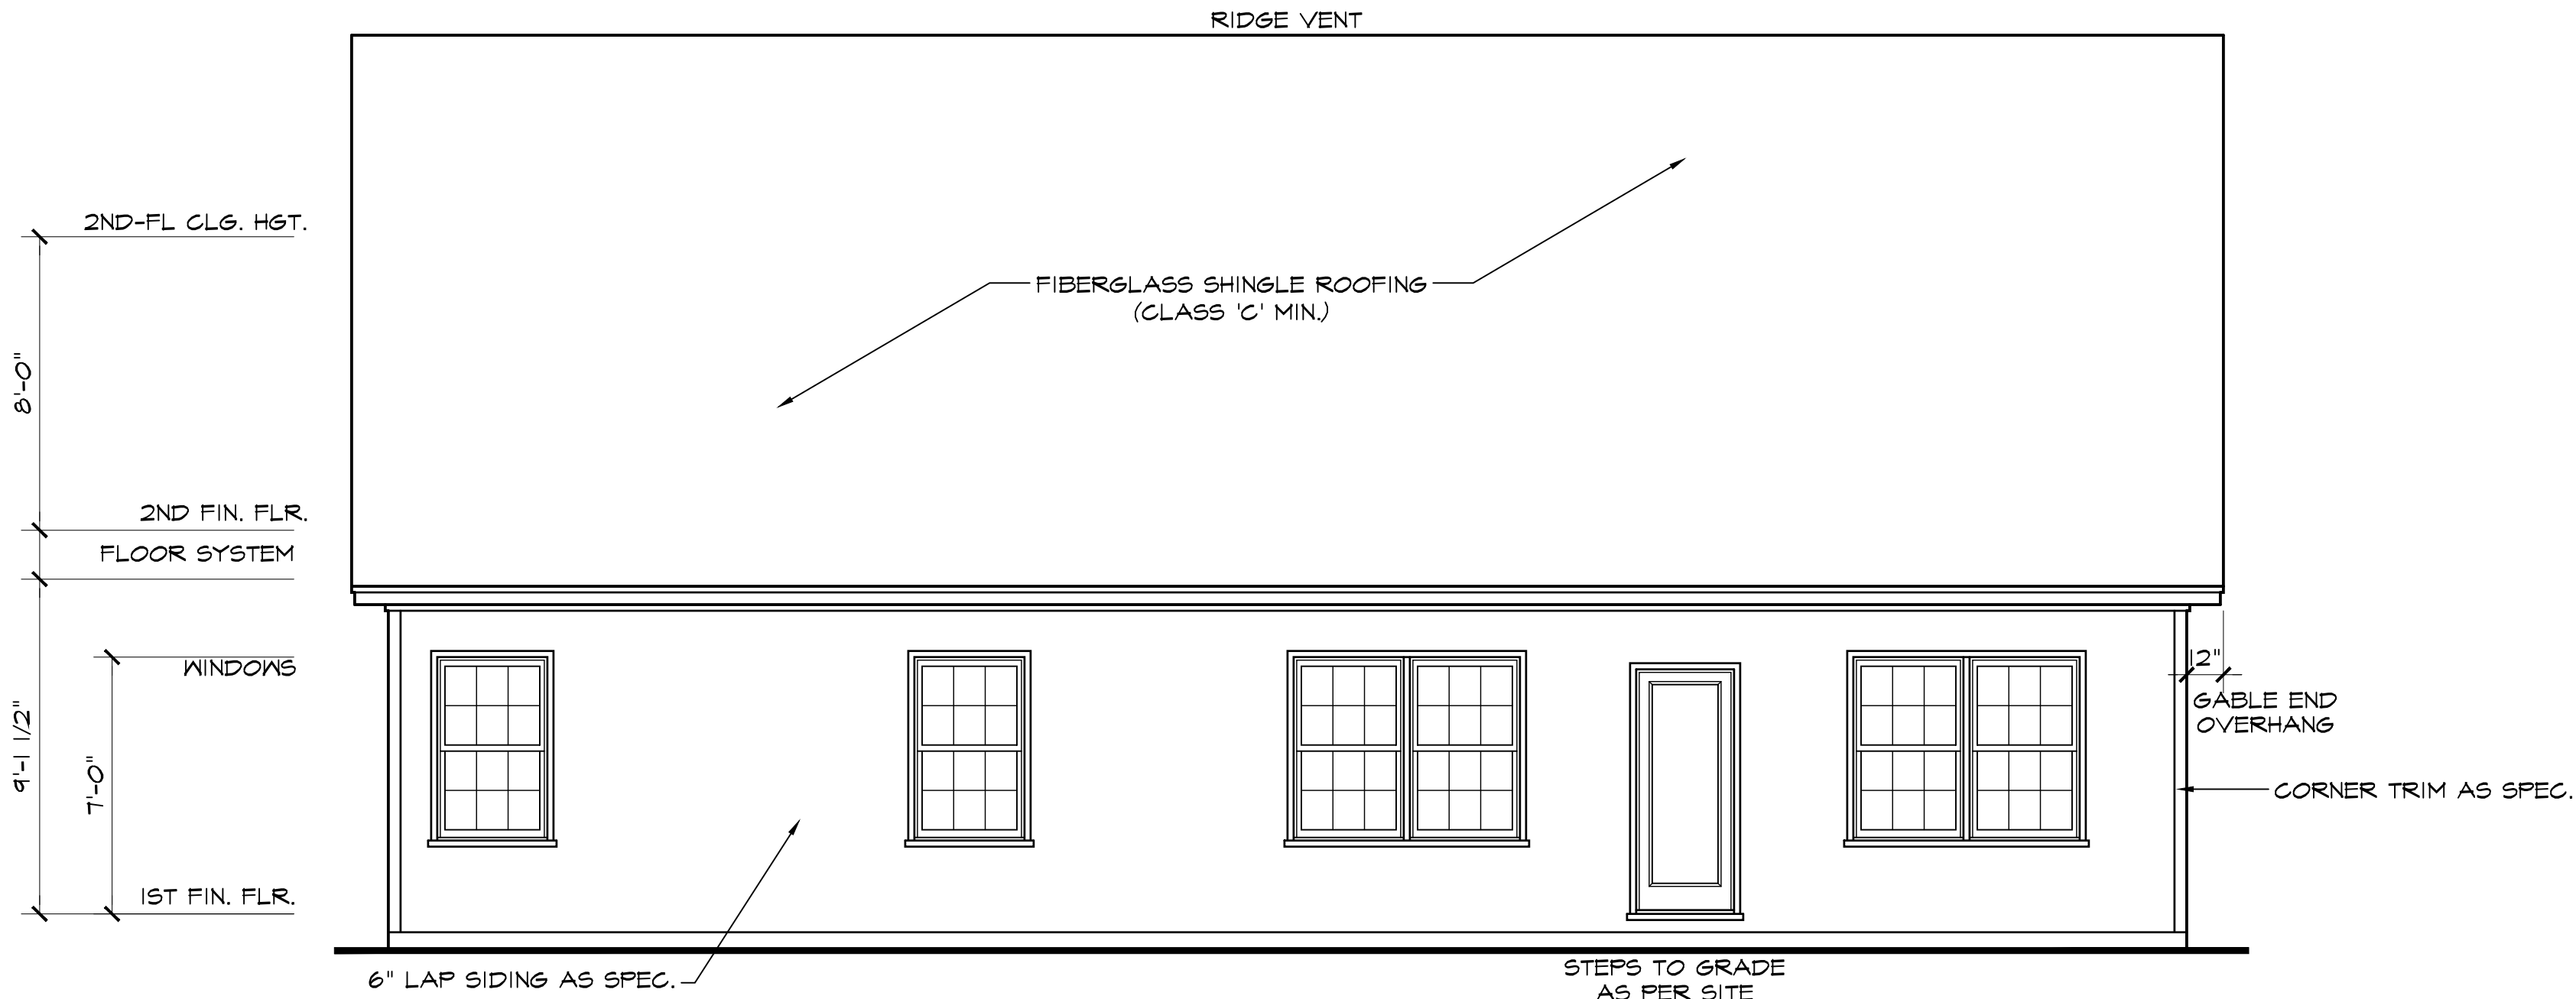


REAR ELEVATION SCALE: 1/4"=1'-0"
NOTE - SLOPE ALL GRADES AWAY FROM HOUSE FOR POSITIVE DRAINAGE

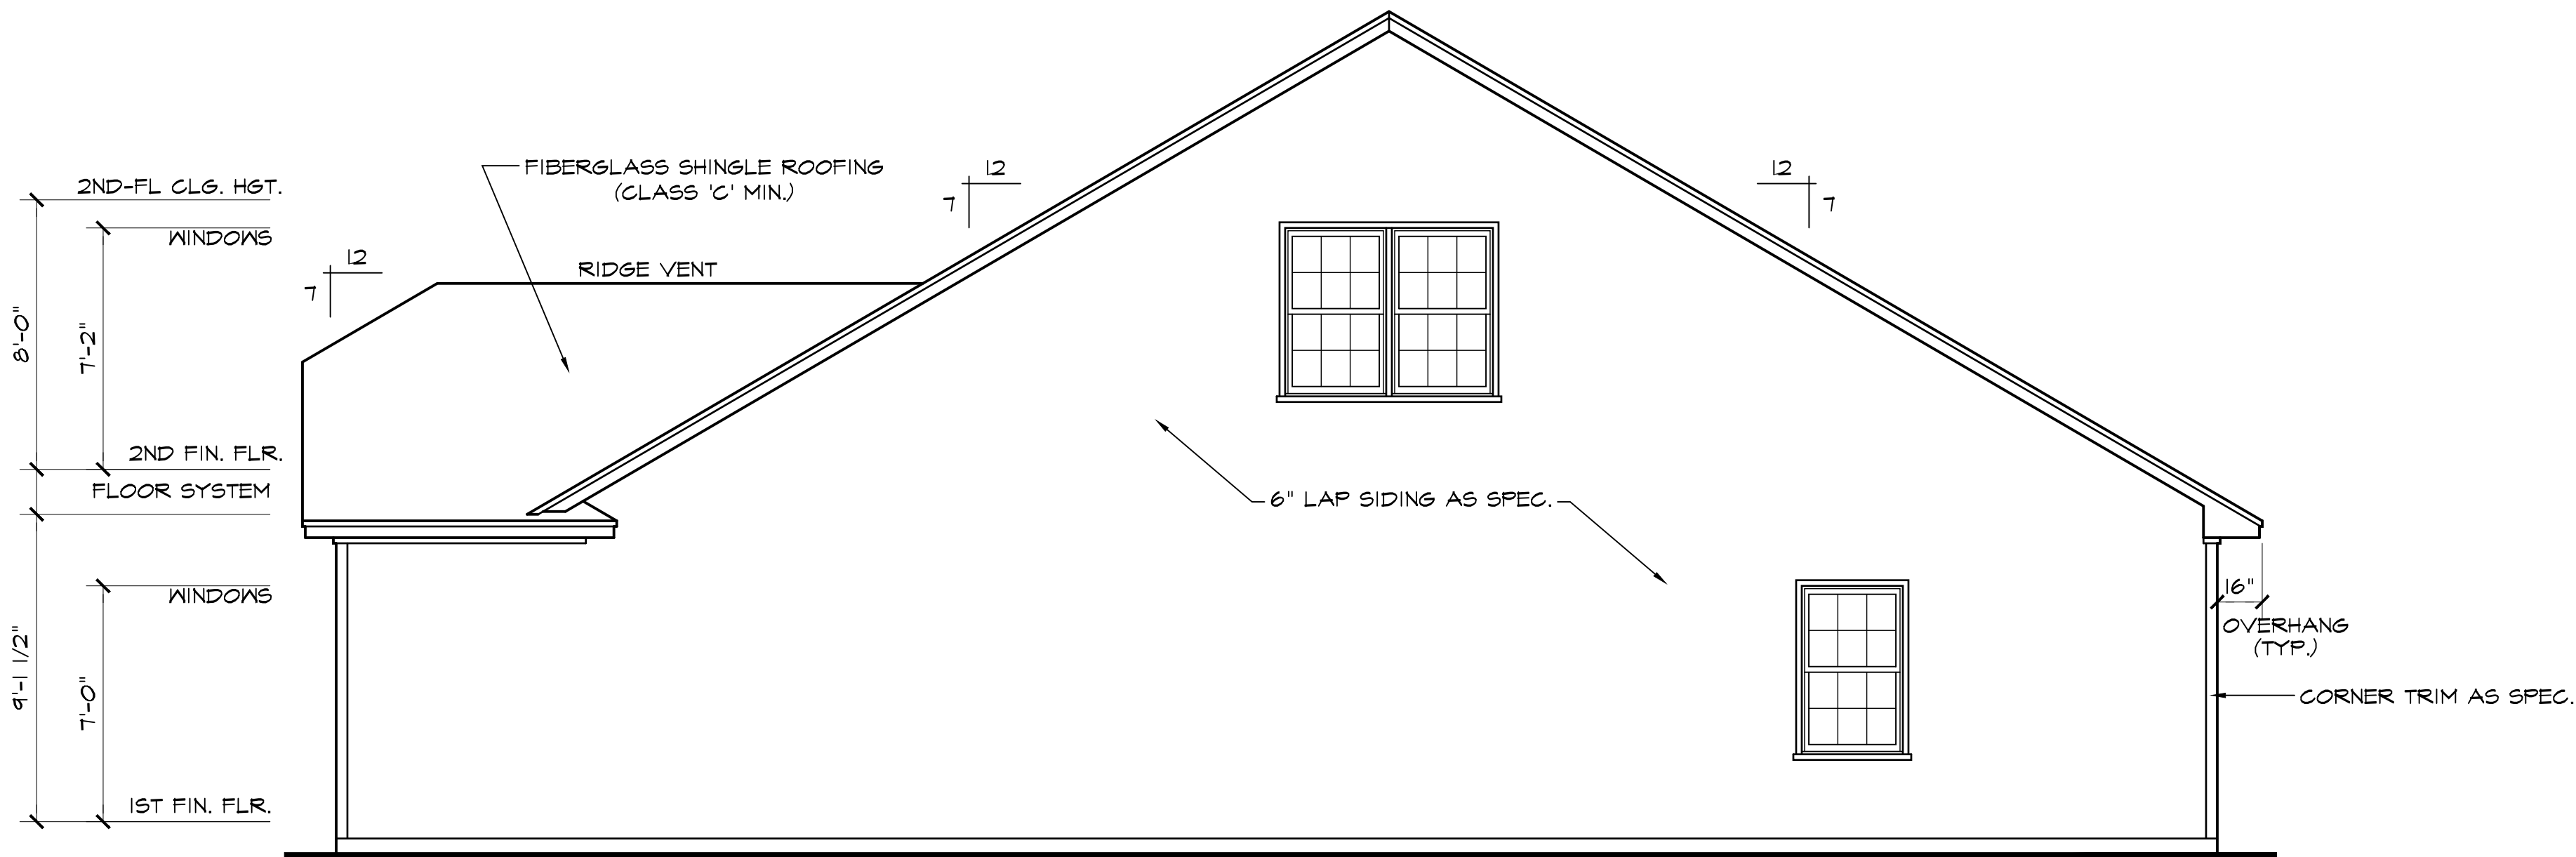

RIGHT SIDE ELEVATION SCALE: 1/4"=1'-0"

DATE DRAWN
5/1/2025
PROJECT
7593
REVISIONS

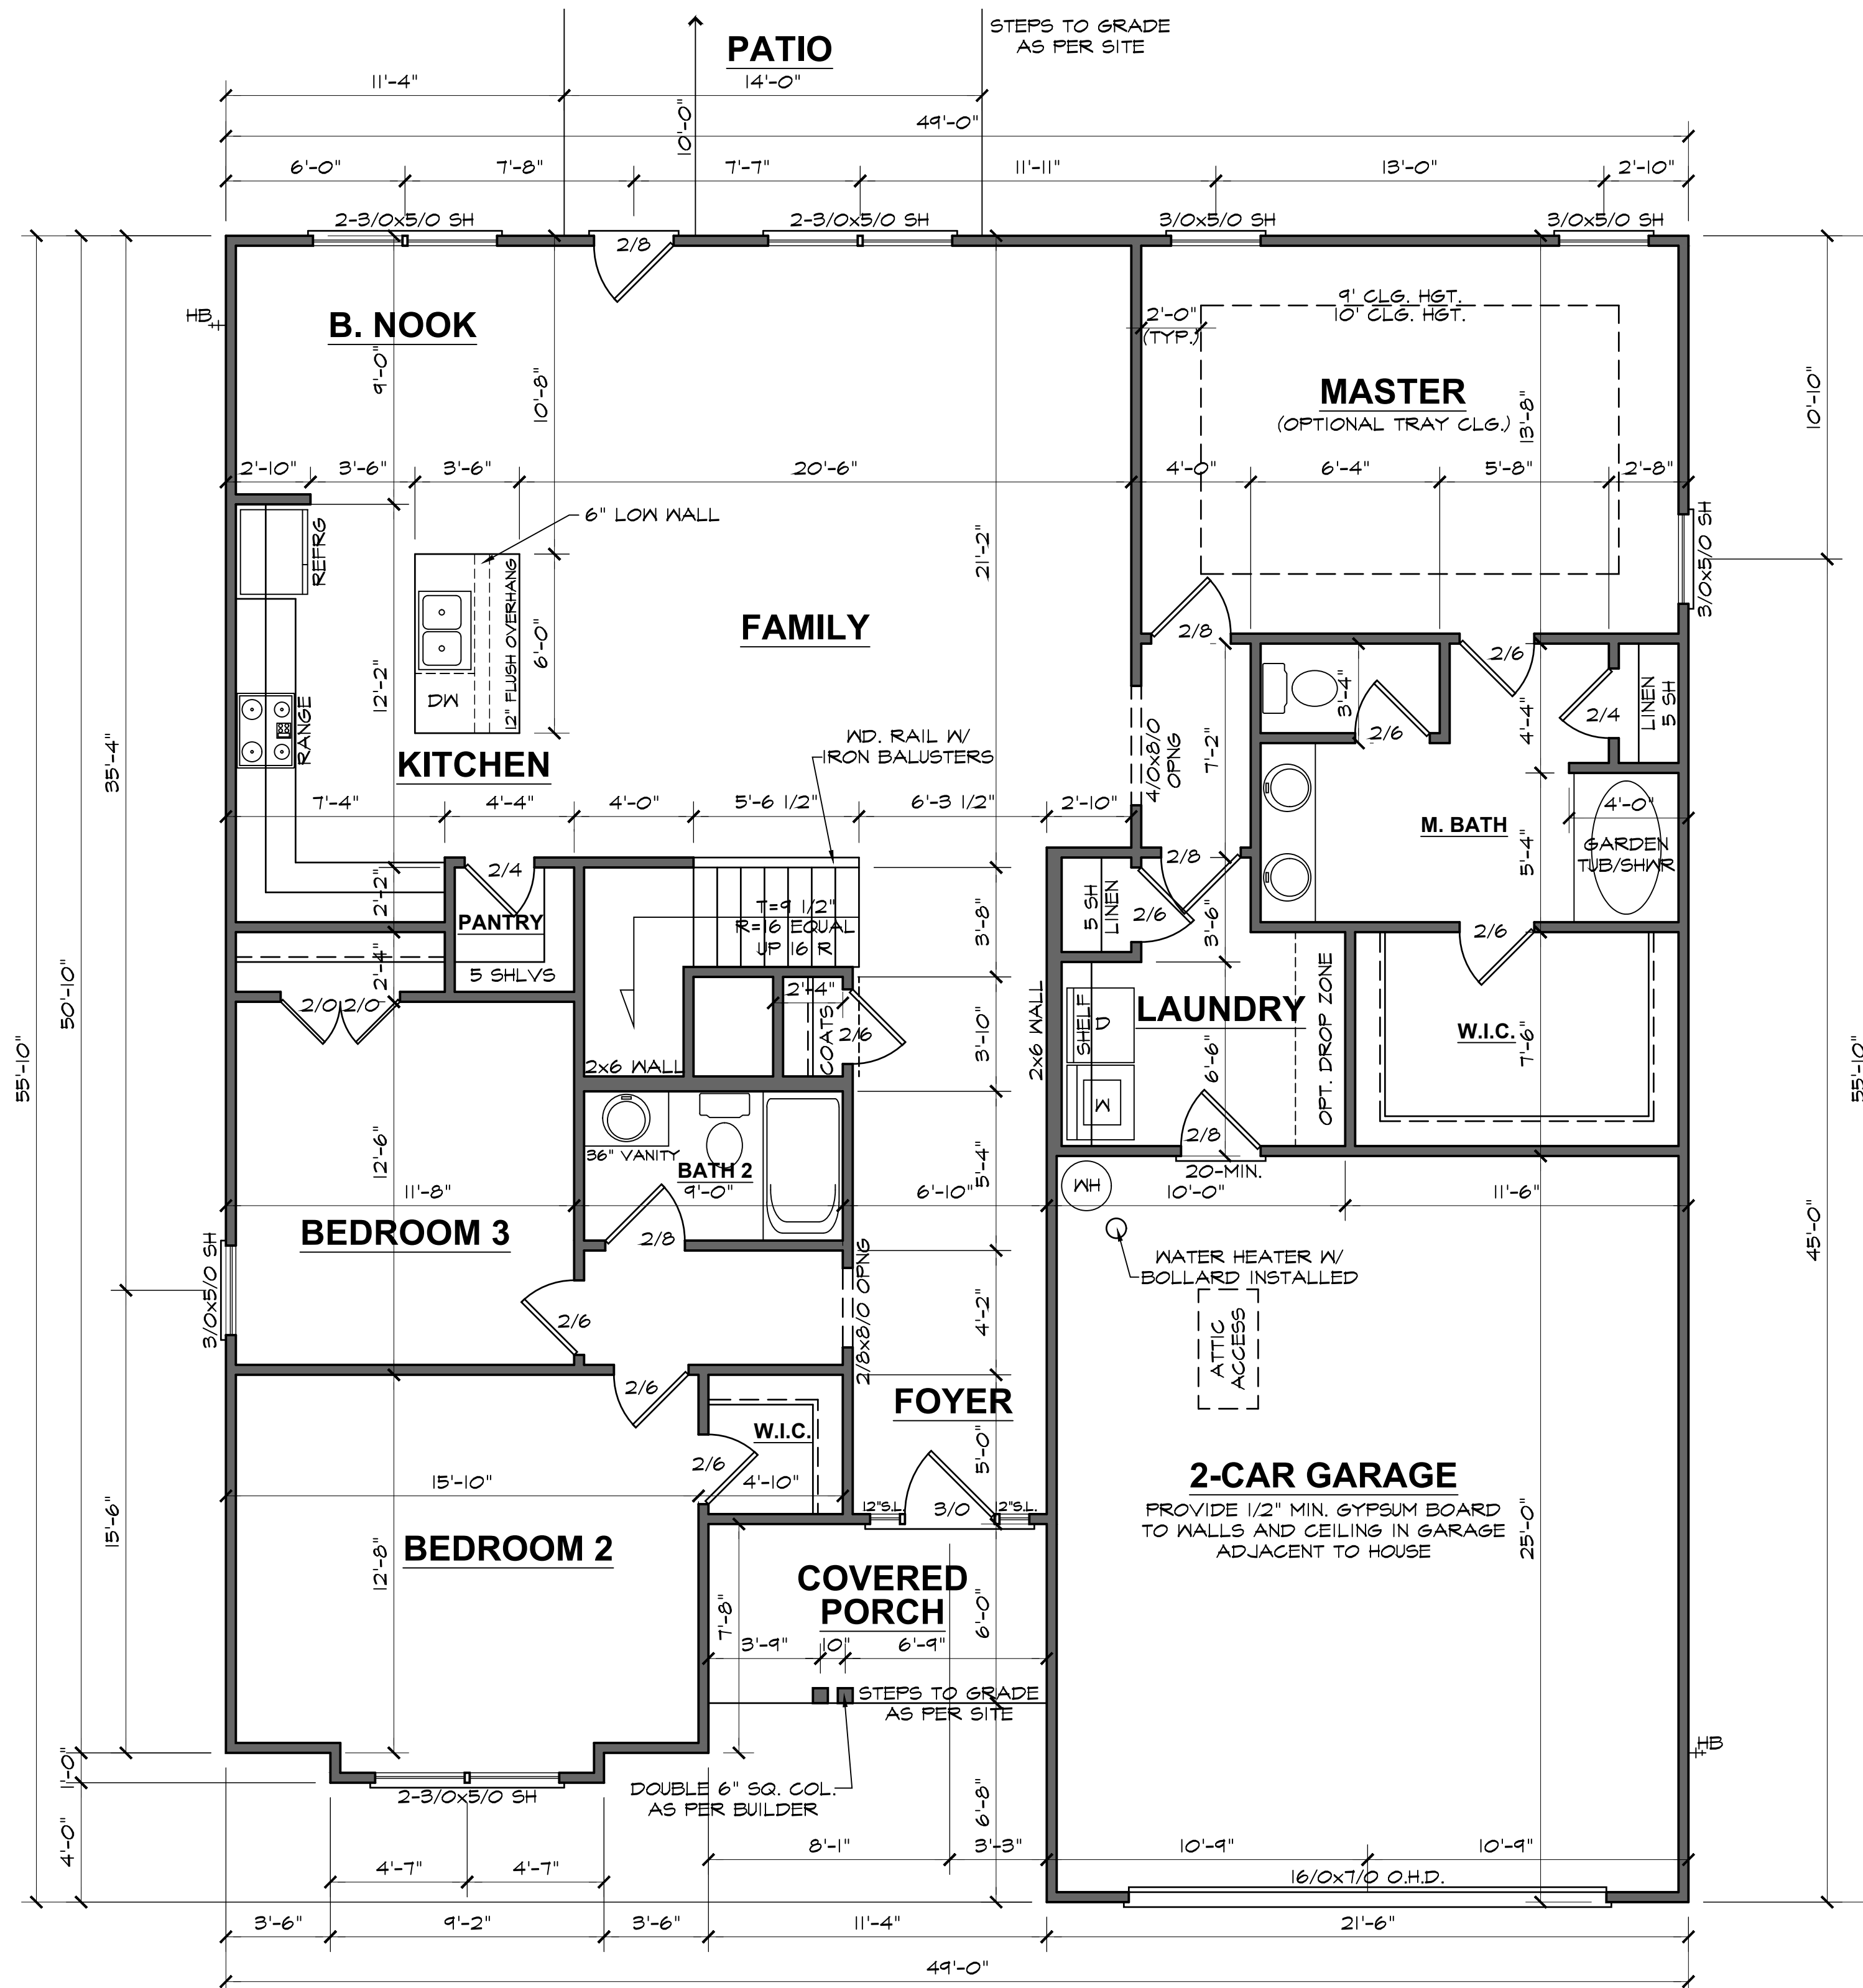


FIRST FLOOR PLAN
9'-0" (NOM.) CLG. HGT. U.N.O. SCALE: 1/4"=1'-0"
SET WINDOWS @ 7'-0" U.N.O.

2604 "A" FE (R) KC066

DATE DRAWN
5/1/2025
PROJECT
7593
REVISIONS



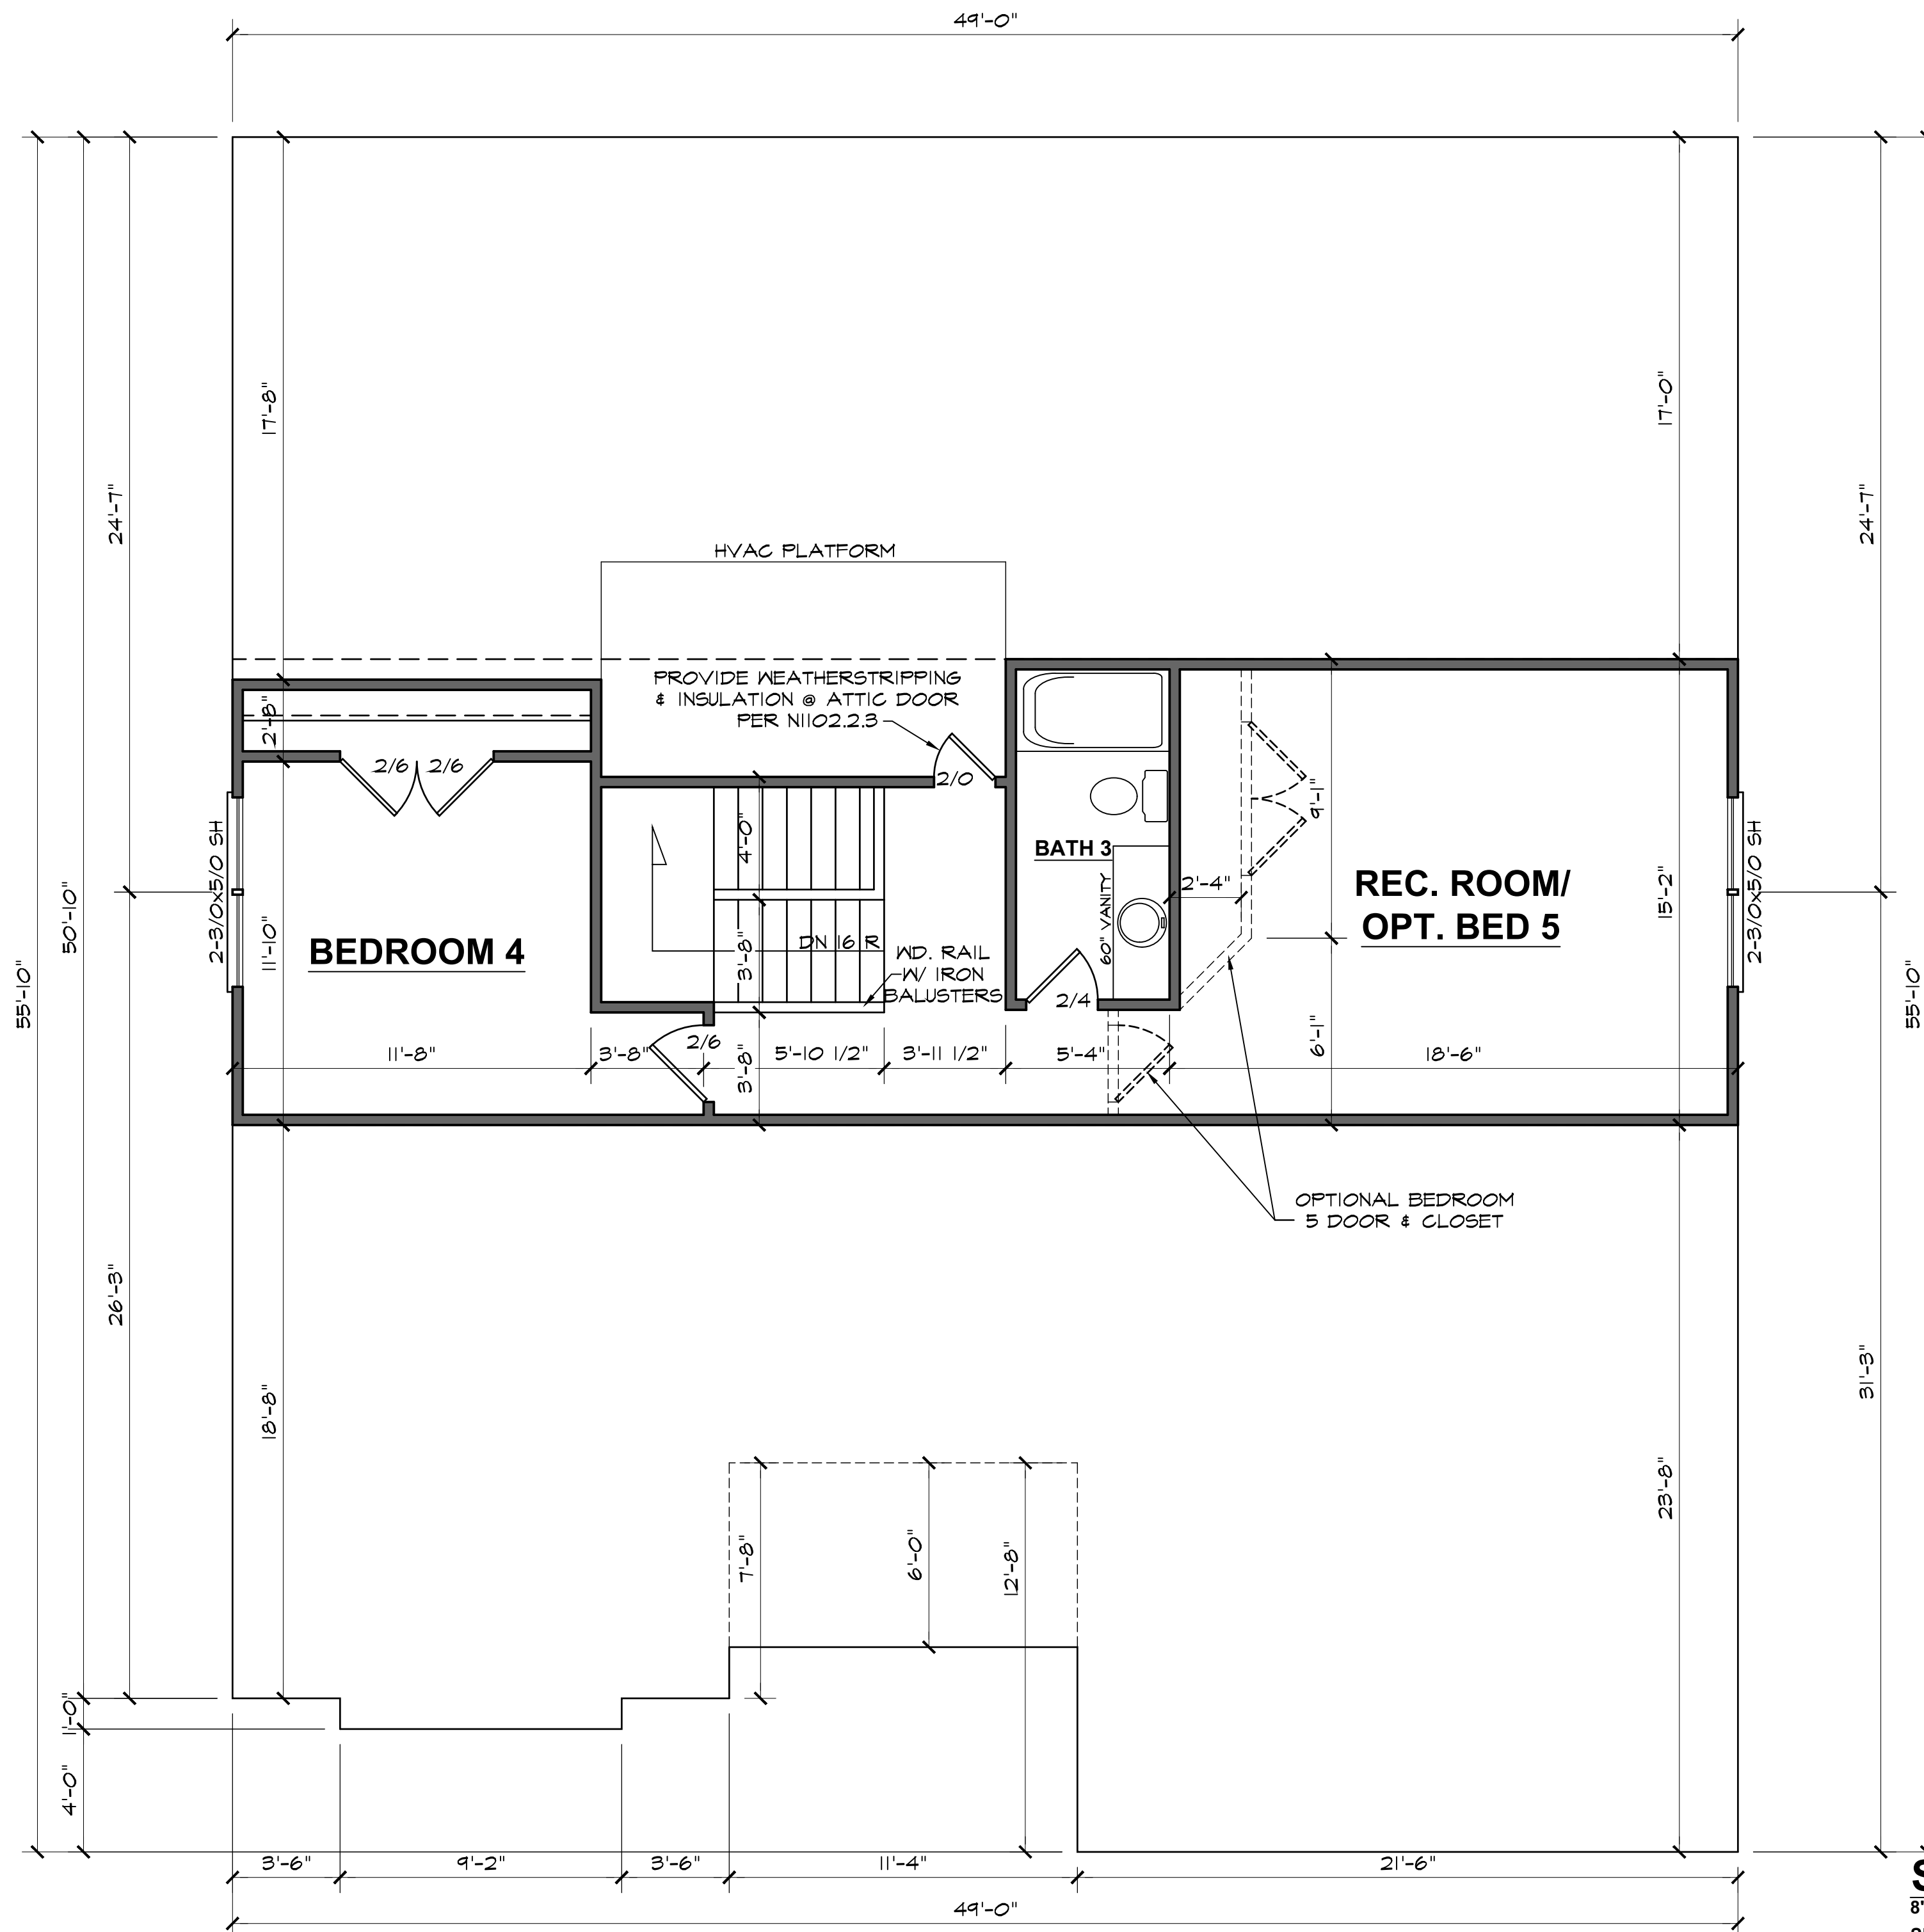


SECOND FLOOR PLAN

2604 "A" FE (R) KC066


DATE DRAWN	5/1/2025
PROJECT	7593
REVISIONS	

SHEET

4

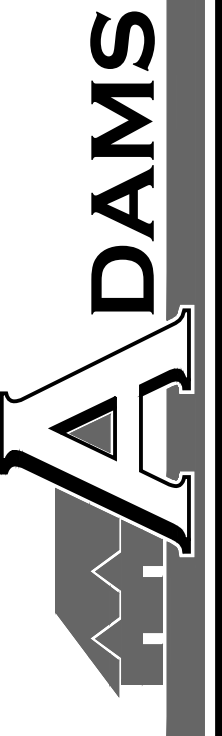

HOMES

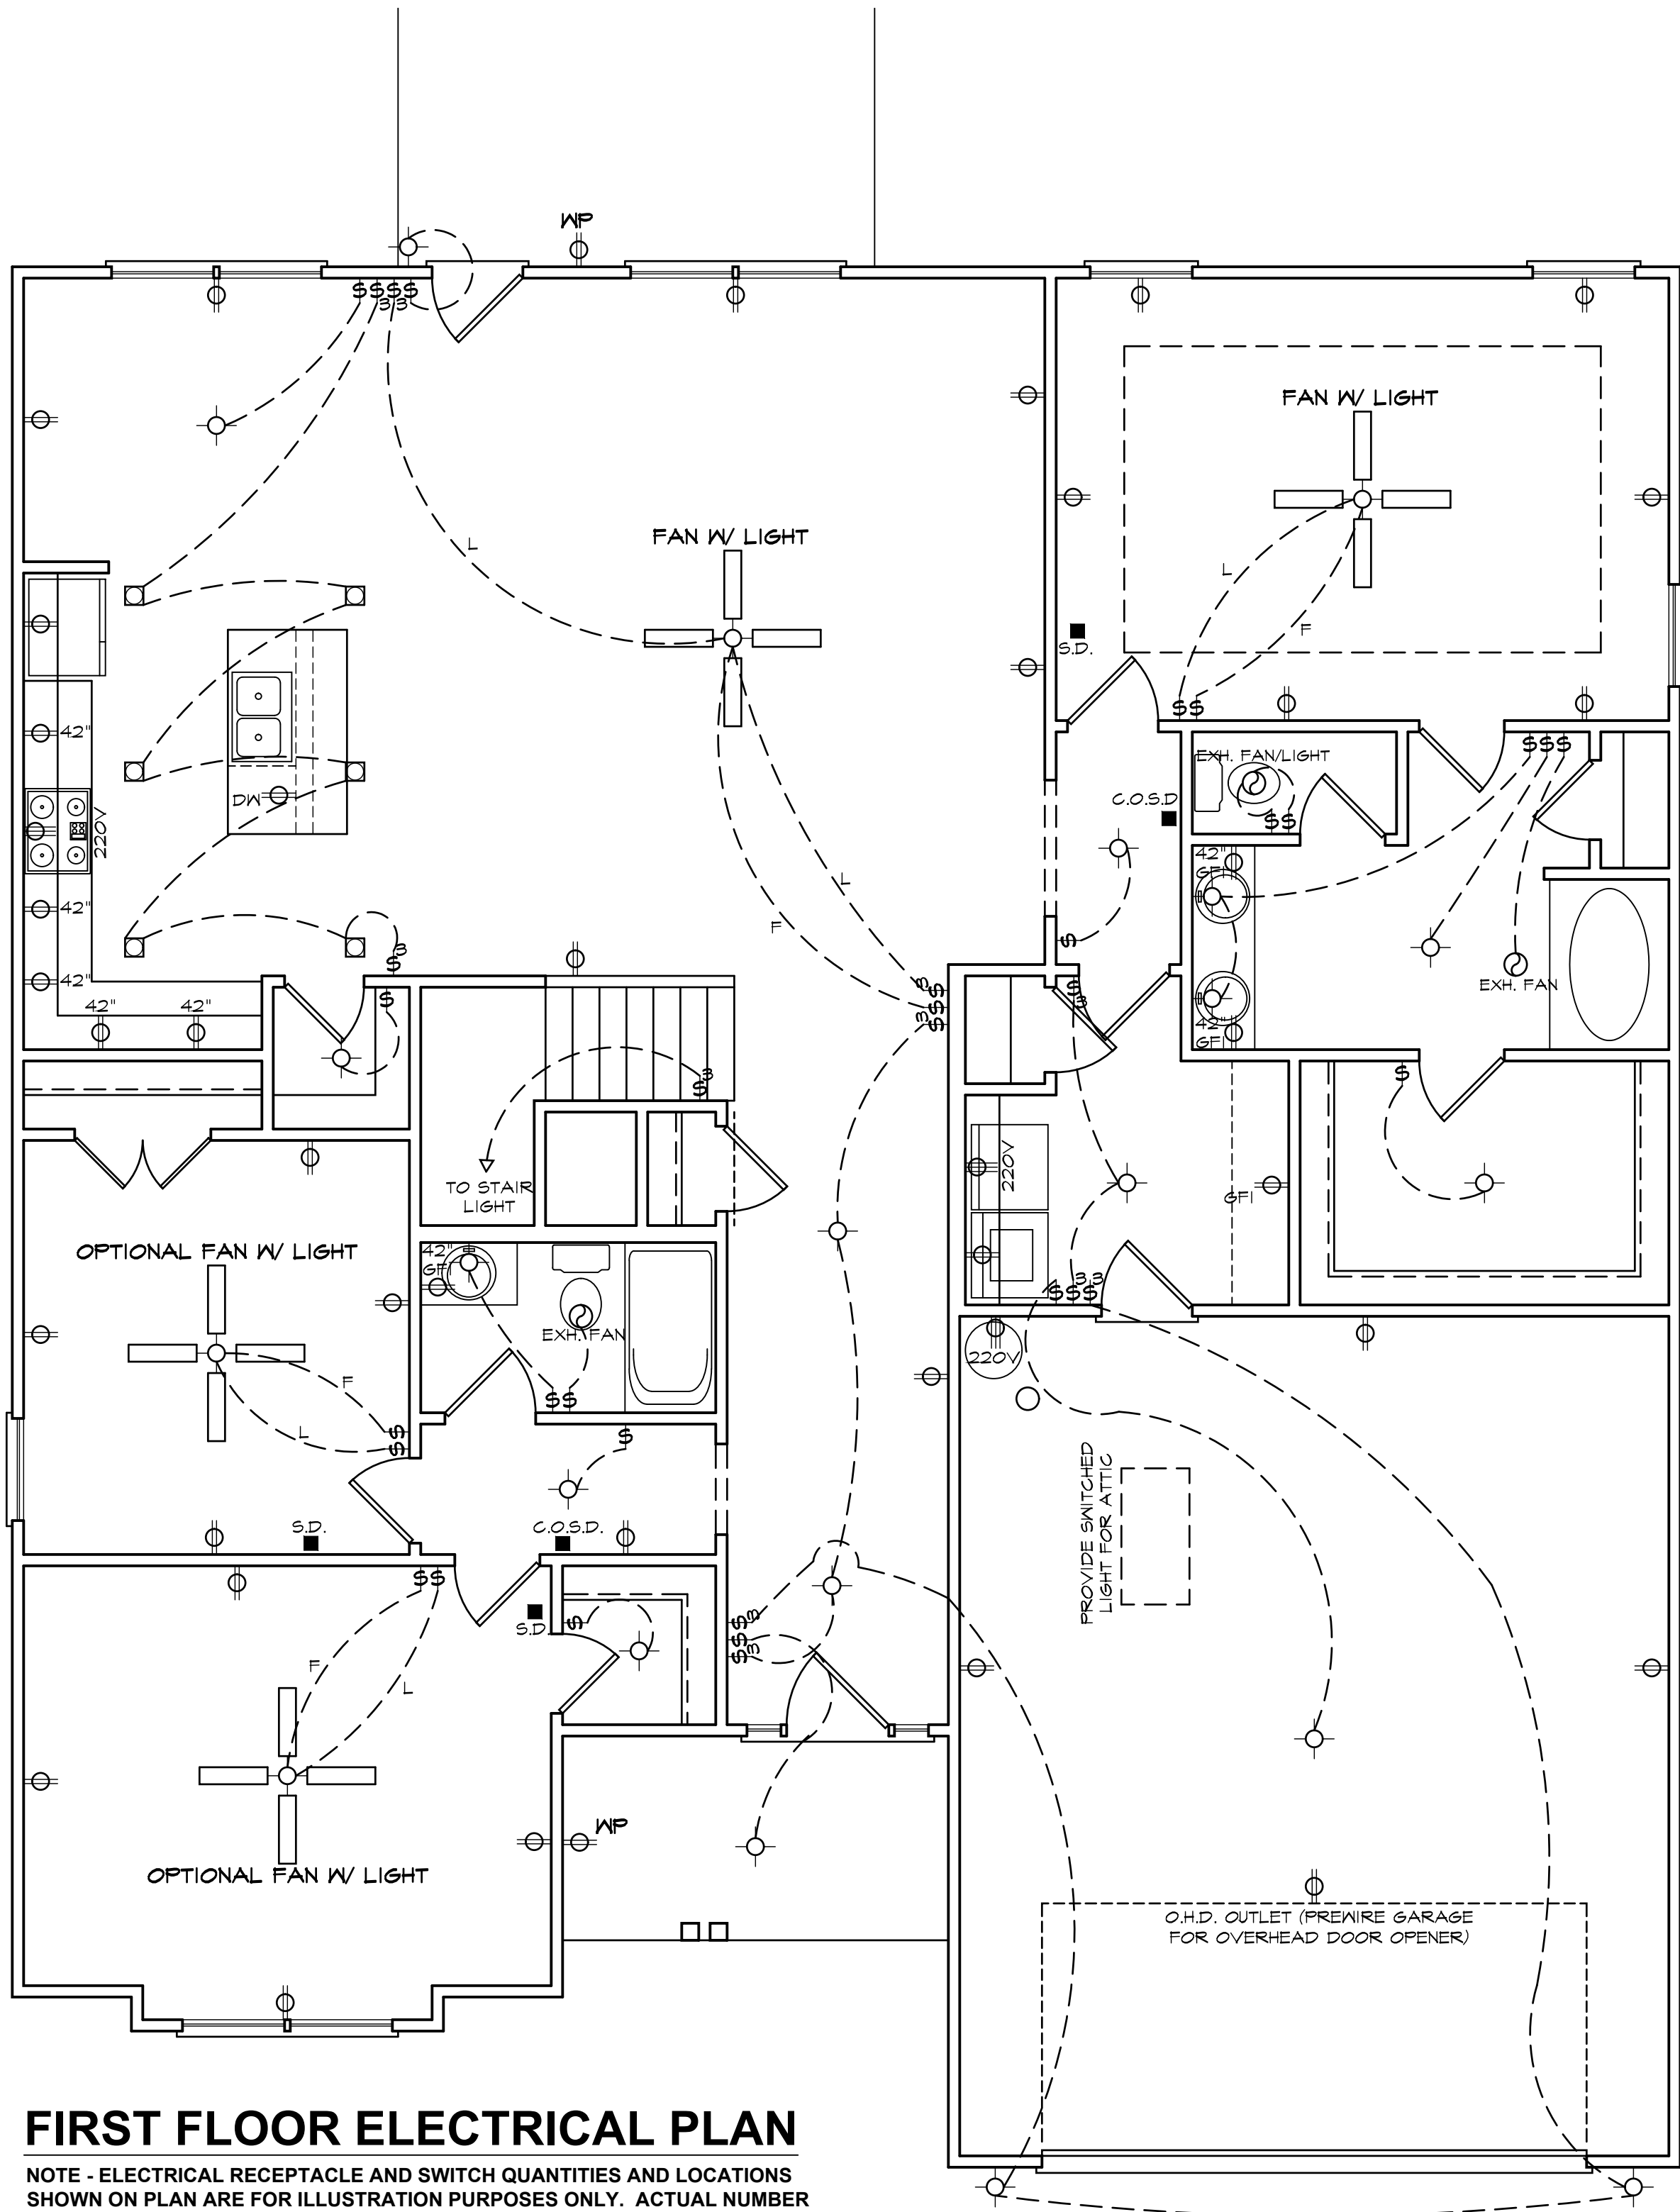

FIRST FLOOR ELECTRICAL PLAN

NOTE - ELECTRICAL RECEPTACLE AND SWITCH QUANTITIES AND LOCATIONS SHOWN ON PLAN ARE FOR ILLUSTRATION PURPOSES ONLY. ACTUAL NUMBER AND LOCATIONS SHALL BE FIELD DETERMINED AS PER CLIENT AND BUILDER EXCEPT WHERE CODE REQUIREMENTS APPLY.

ELECTRICAL LEGEND

 - LIGHT FIXTURE

 - FAN/LIGHT

 WP - WATERPROOF OUTLET

 - RECESSED LIGHTING

 - SINGLE PULL SWITCH

 - 3-WAY SWITCH

 - 4-WAY SWITCH

 - DIMMER SWITCH

 - SMOKE DETECTOR

 - FLOOD LIGHTS

 - EYEBALL SPOTS

 - DUPLEX RECEPTACLE (110V)

 - 220 VOLT RECEPTACLE

 - SWITCHED RECEPTACLE (TOP WIRE ONLY)

 - GROUND FAULT CIRCUIT INTERRUPTOR

 - CL6 FAN/LIGHTS

 - TRACK LIGHTS

 - FLUORESCENT LIGHTING

 - CABLE OUTLET

 - TELEPHONE OUTLET

 - COMPUTER DATA OUTLET

 - BURGLAR ALARM


 - INTERCOM

NOTE: ALL ELECTRICAL TO BE VERIFIED BY OWNER/BUILDER BEFORE ROUGH-IN.

2604 "A" FE (R) KC066

DATE DRAWN
5/1/2025
PROJECT
7593
REVISIONS

SHEET
5

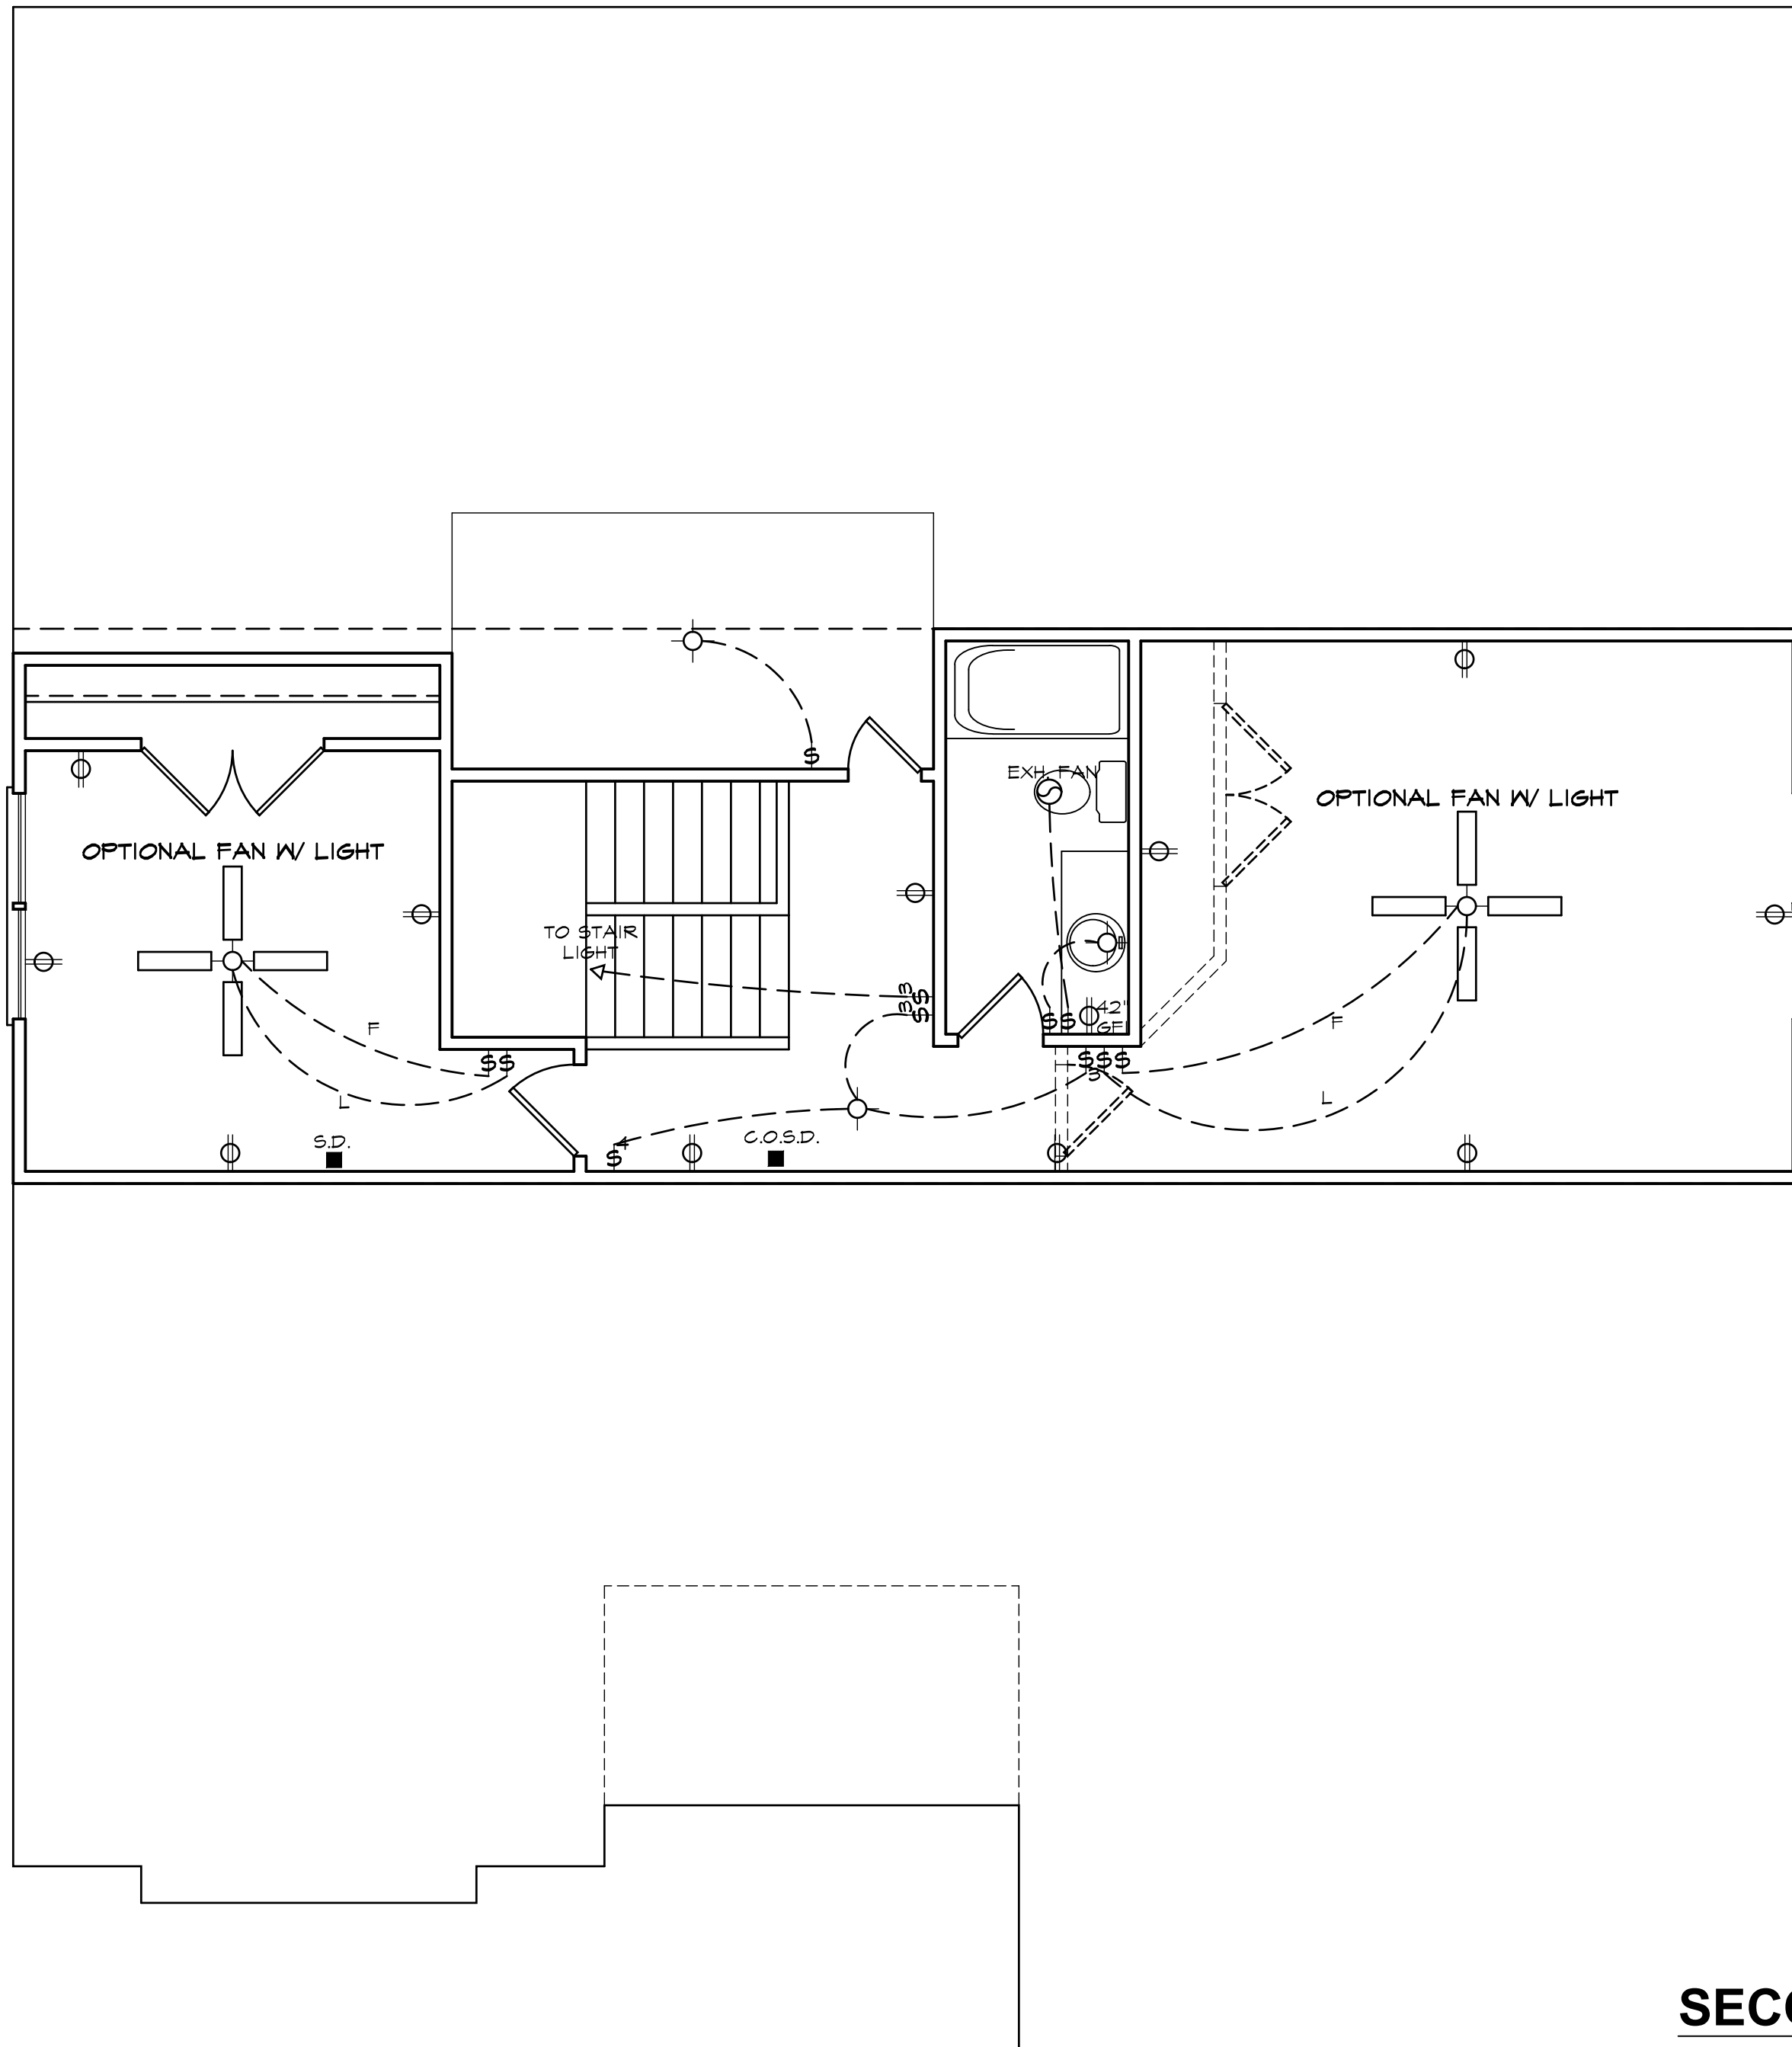


ELECTRICAL LEGEND

- LIGHT FIXTURE
 - FAN/LIGHT
 - WATERPROOF OUTLET
 - RECESSED LIGHTING
 - SINGLE PULL SWITCH
 - 3-WAY SWITCH
 - 4-WAY SWITCH
 - DIMMER SWITCH
 - SMOKE DETECTOR
 - FLOOD LIGHTS
 - EYEBALL SPOTS
 - DUPLEX RECEPTACLE (110V)
 - 220 VOLT RECEPTACLE
 - SWITCHED RECEPTACLE (TOP WIRE ONLY)
 - GROUND FAULT CIRCUIT INTERRUPTOR
 - CL6 FAN/LIGHTS
 - TRACK LIGHTS
 - FLUORESCENT LIGHTING
 - CABLE OUTLET
 - TELEPHONE OUTLET
 - COMPUTER DATA OUTLET
 - BURGLAR ALARM
 - INTERCOM
- NOTE: ALL ELECTRICAL TO BE VERIFIED BY OWNER/BUILDER BEFORE ROUGH-IN.

SECOND FLOOR ELECTRICAL PLAN

 NOTE - ELECTRICAL RECEPTACLE AND SWITCH QUANTITIES AND LOCATIONS SHOWN ON PLAN ARE FOR ILLUSTRATION PURPOSES ONLY. ACTUAL NUMBER AND LOCATIONS SHALL BE FIELD DETERMINED AS PER CLIENT AND BUILDER EXCEPT WHERE CODE REQUIREMENTS APPLY.




SEE FLOOR PLAN FOR TYPICAL NOTES & DIMENSIONS




2604 "A" FE (R) KC066

SHEET


opt1

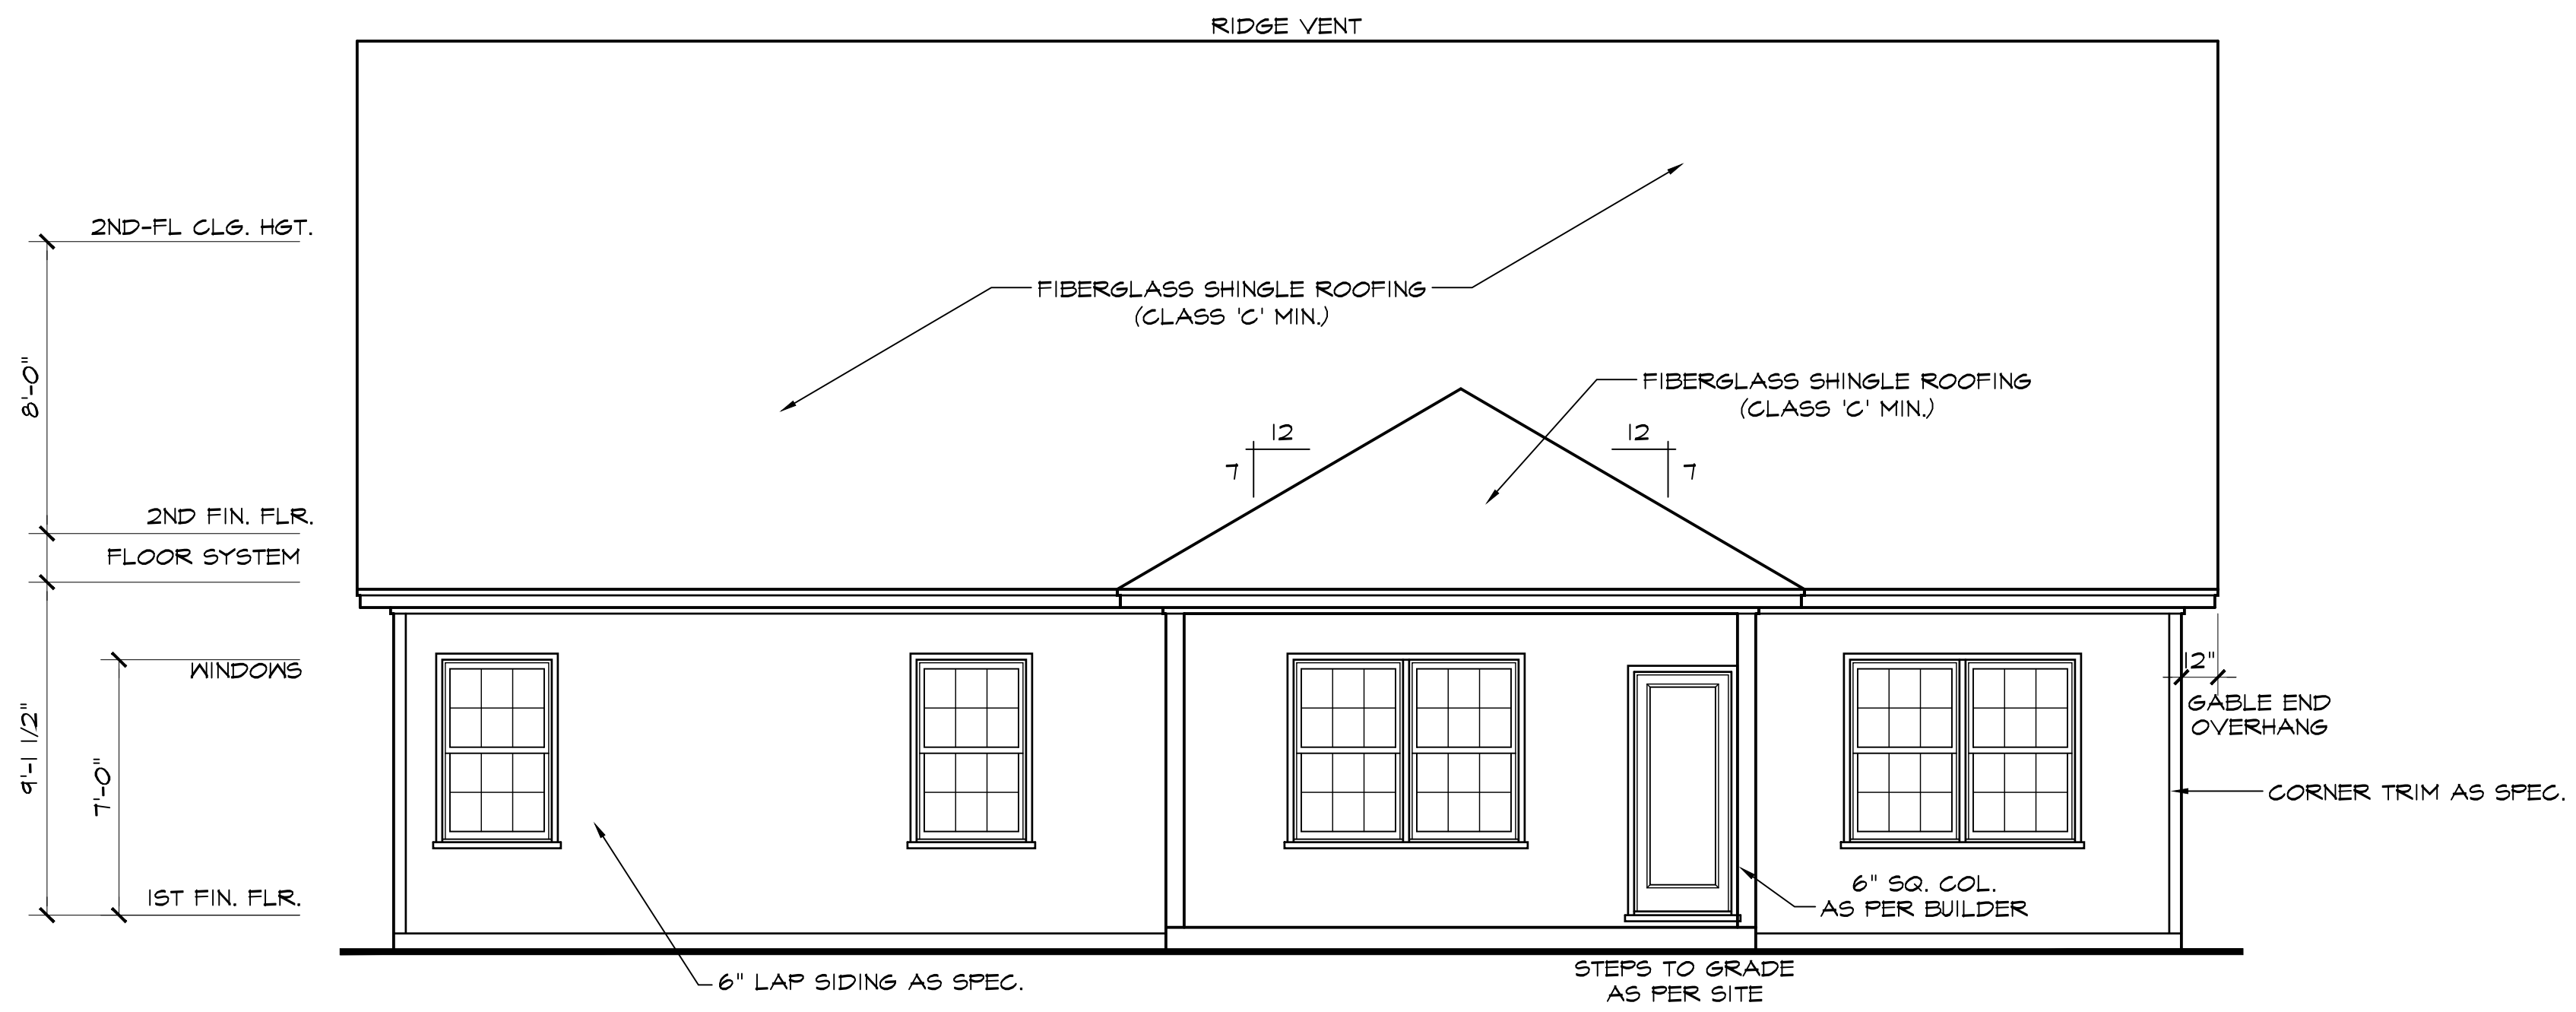

REAR ELEVATION SCALE: 1/4"=1'-0"
NOTE - SLOPE ALL GRADES AWAY FROM HOUSE FOR POSITIVE DRAINAGE

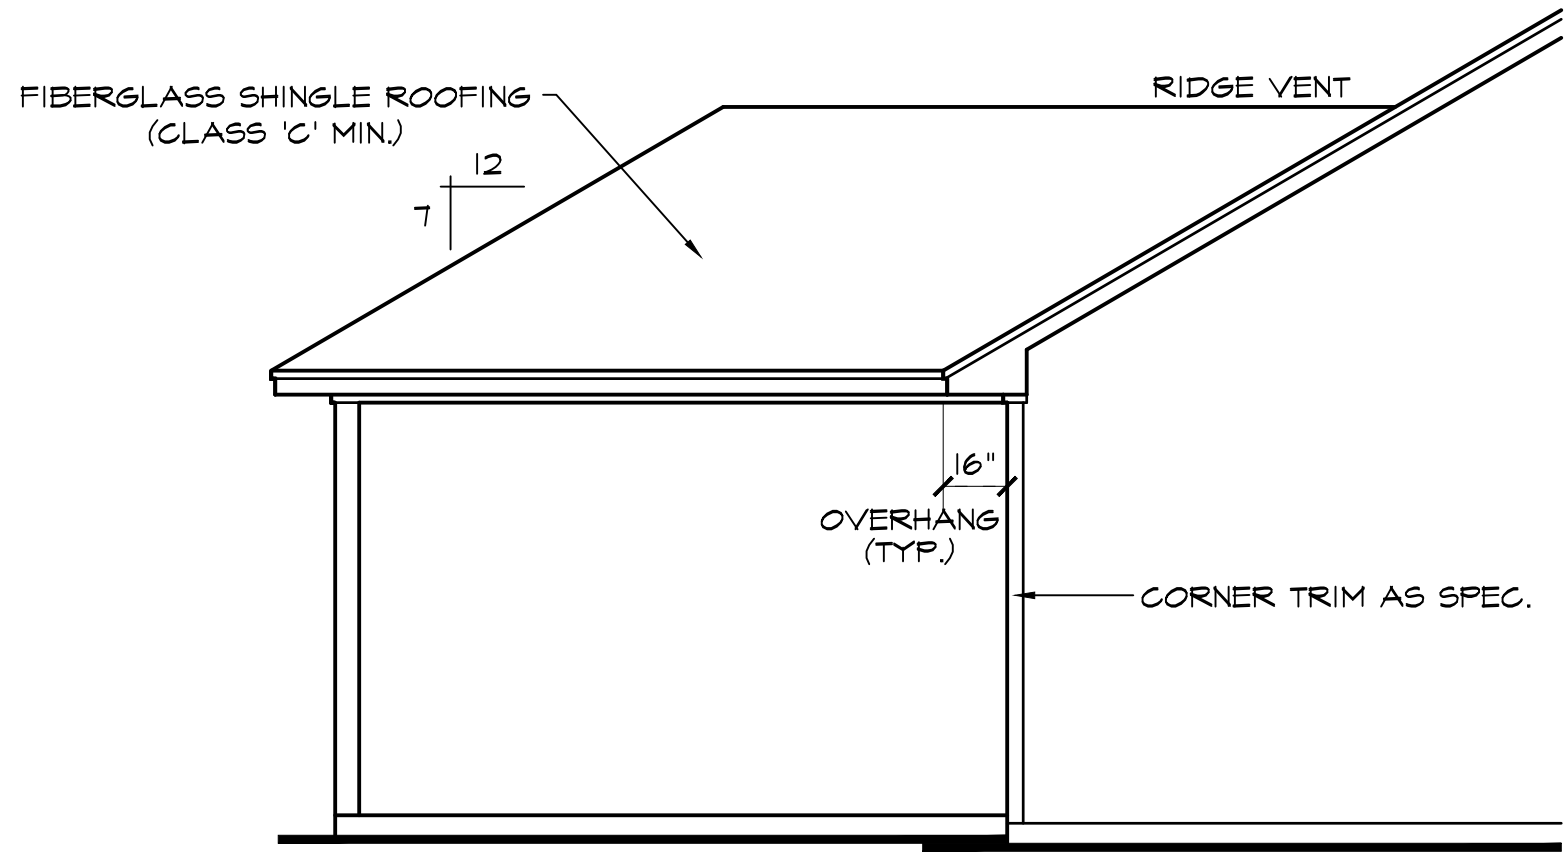

LEFT SIDE ELEVATION SCALE: 1/4"=1'-0"

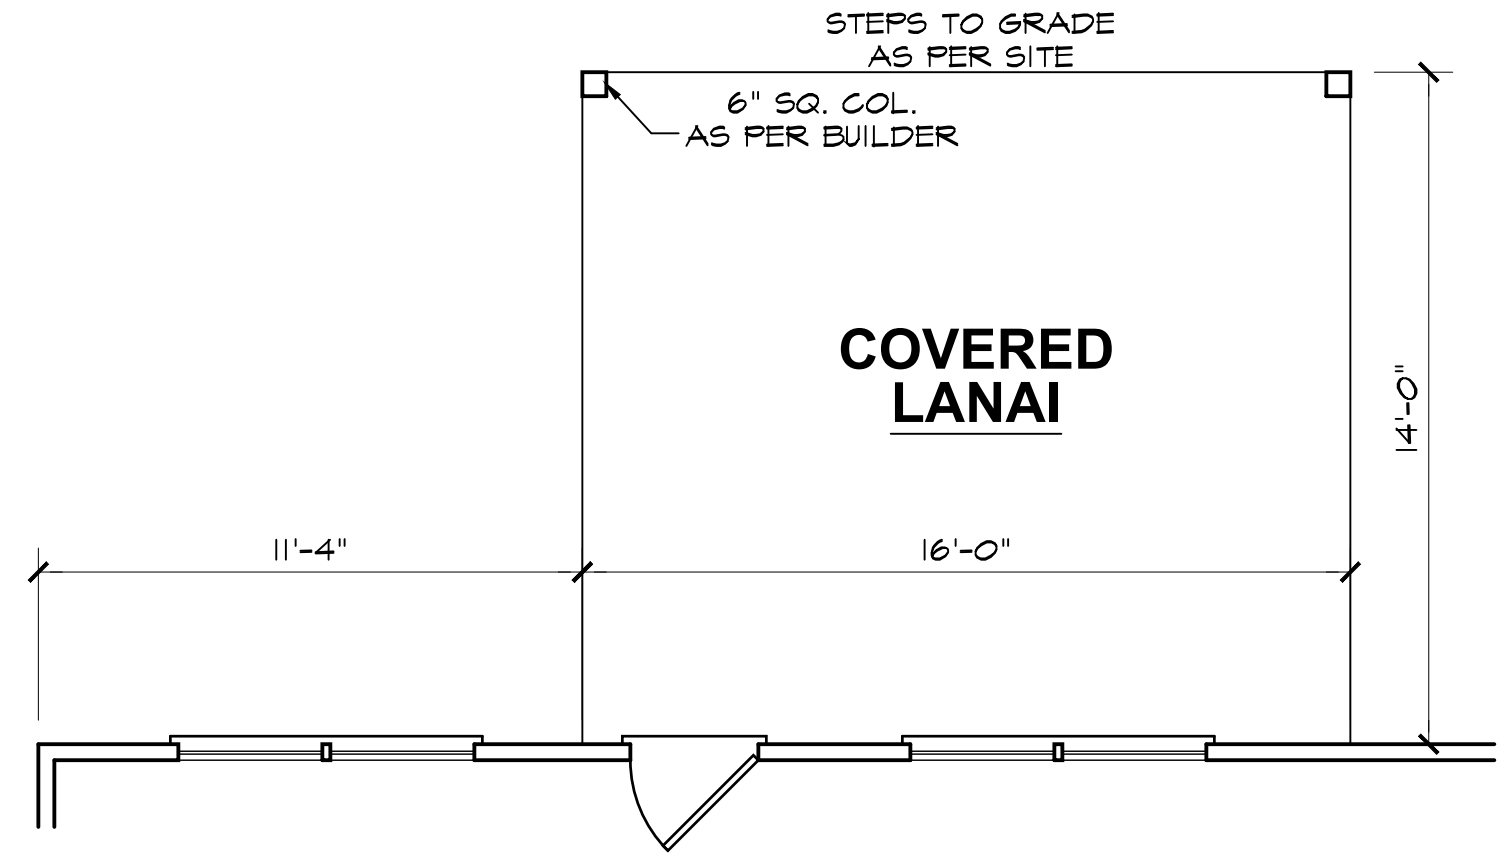

COVERED PORCH SCALE: 1/4"=1'-0"



REAR PORCH OPTION SHEET

2604 "A" FE (R) KC066



DATE DRAWN
5/1/2025
PROJECT
7593
REVISIONS

SHEET
opt2





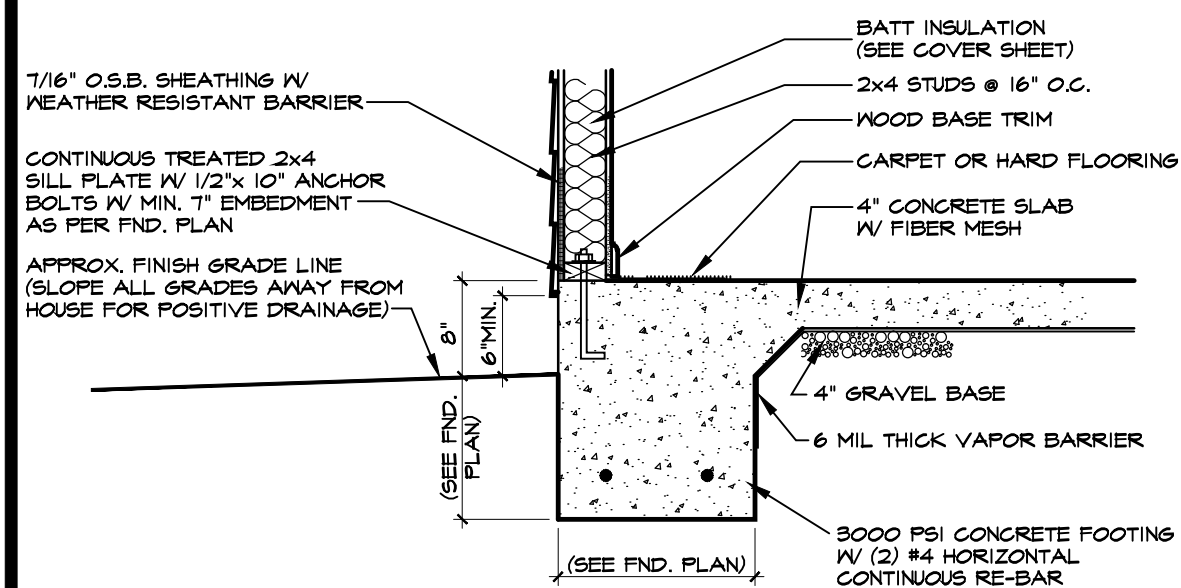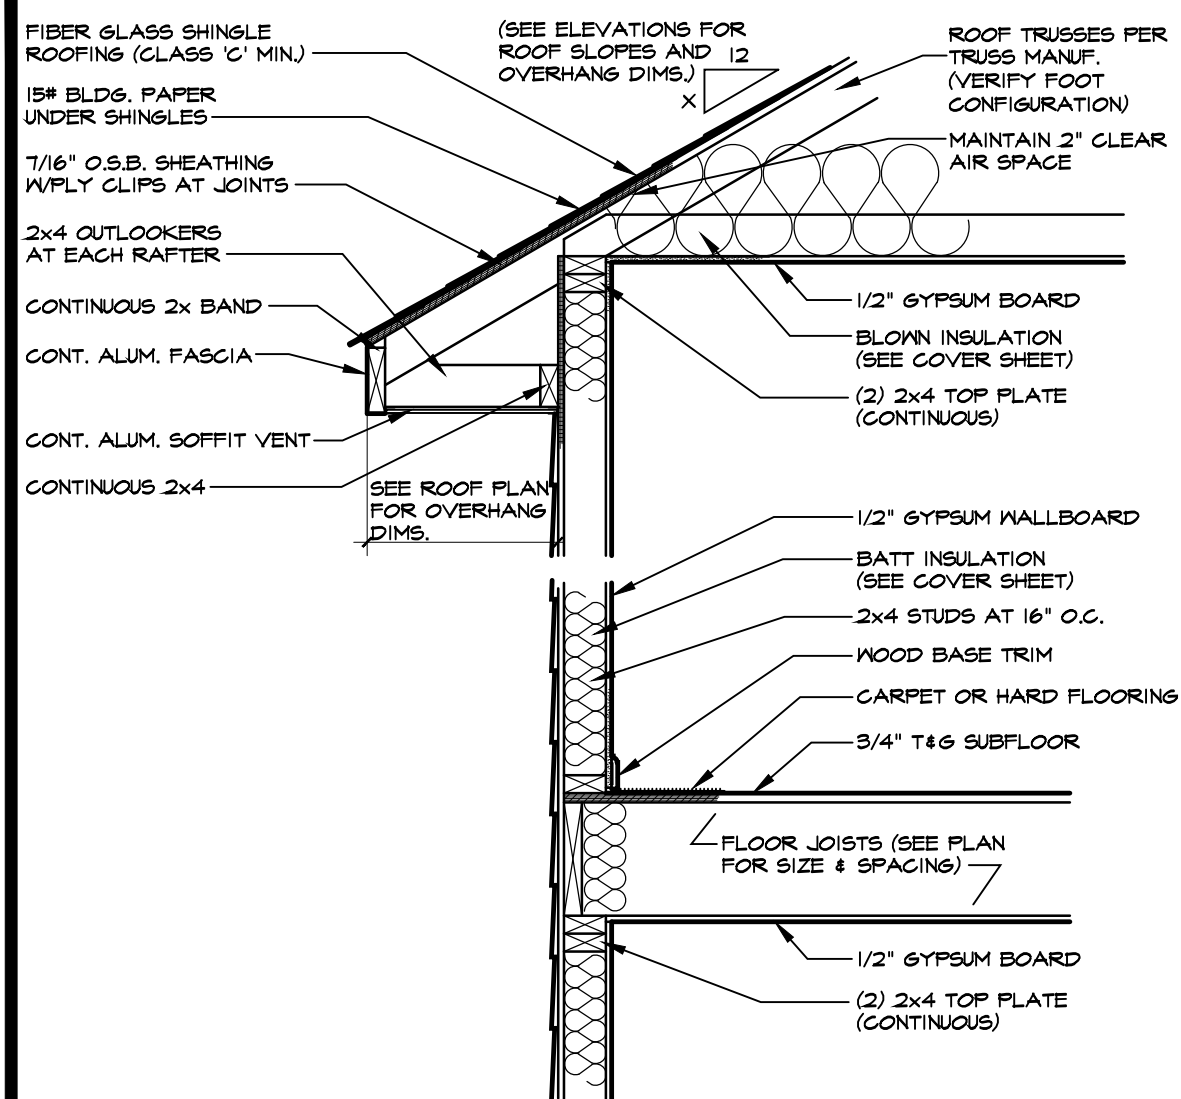


1 TWO-STORY WALL SECTION W/SIDING
SCALE: 3/4"=1'-0"

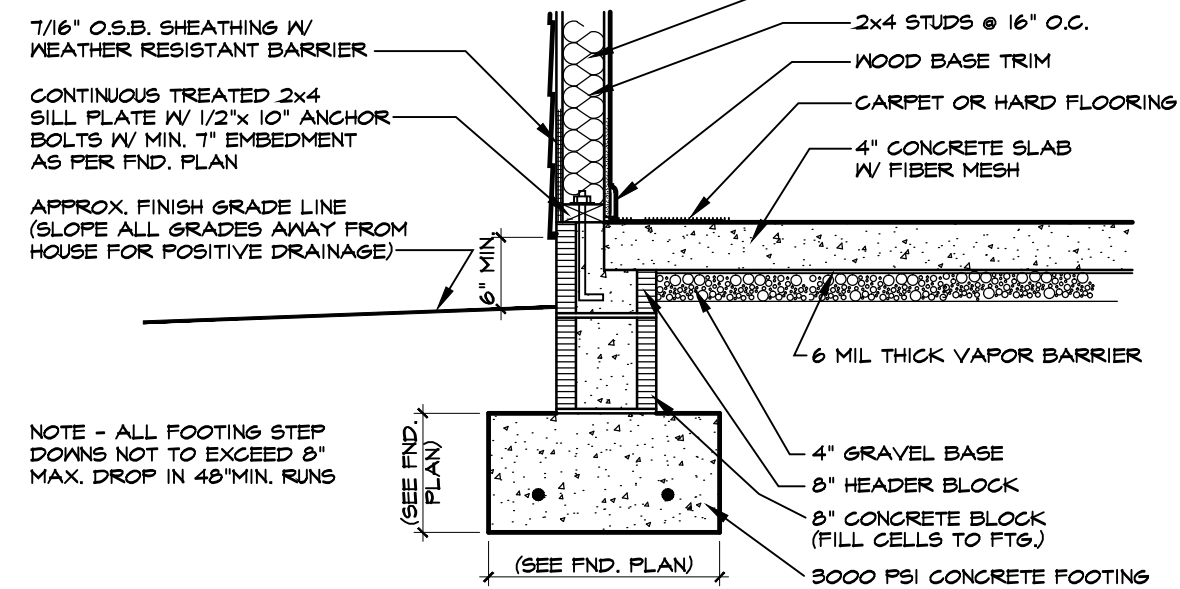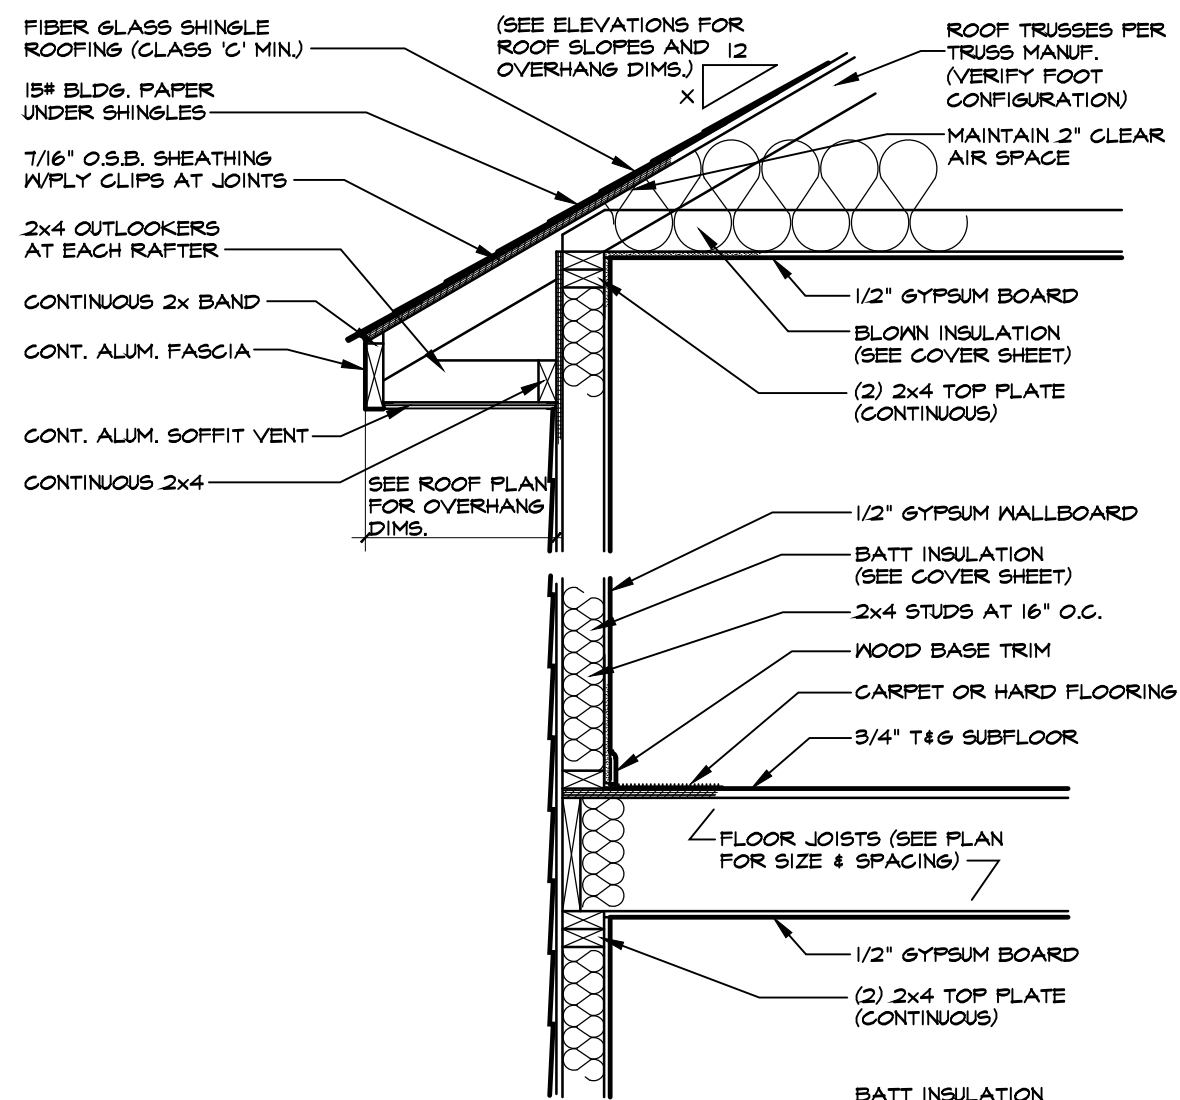

2 TWO-STORY WALL SECTION W/SIDING
SCALE: 3/4"=1'-0"

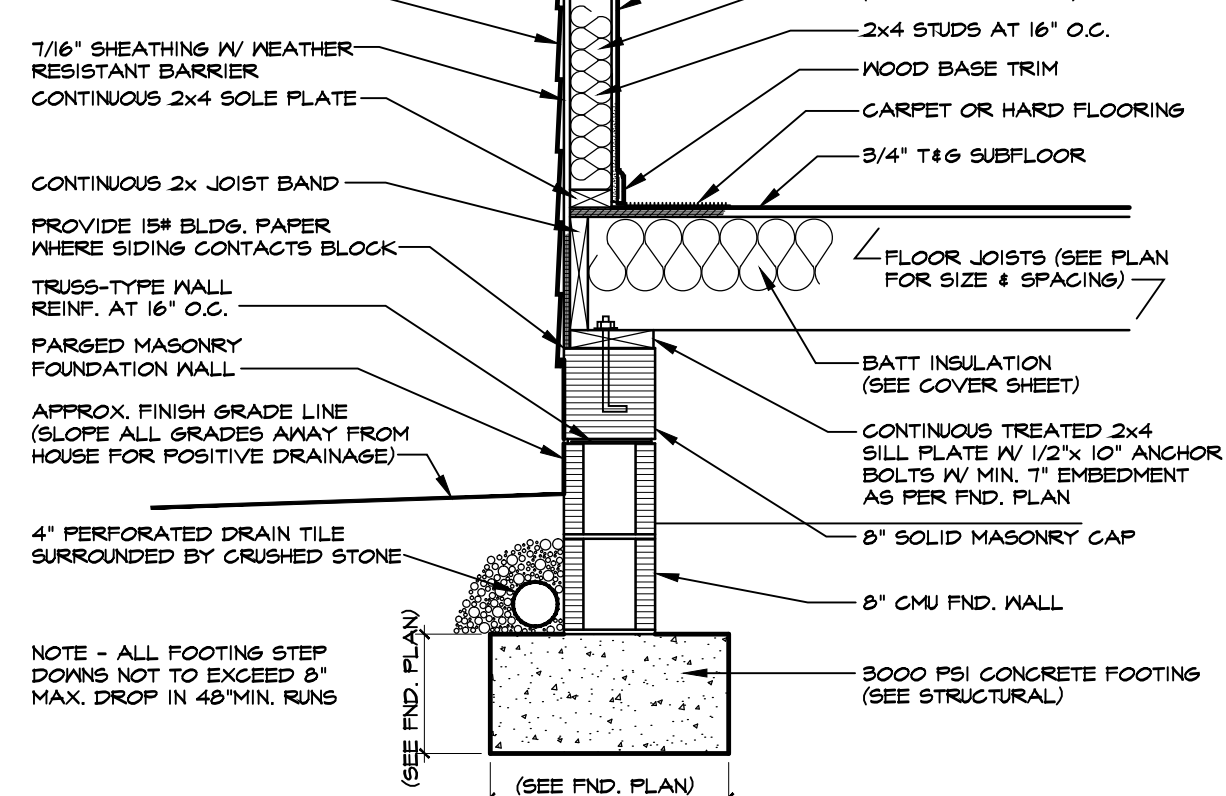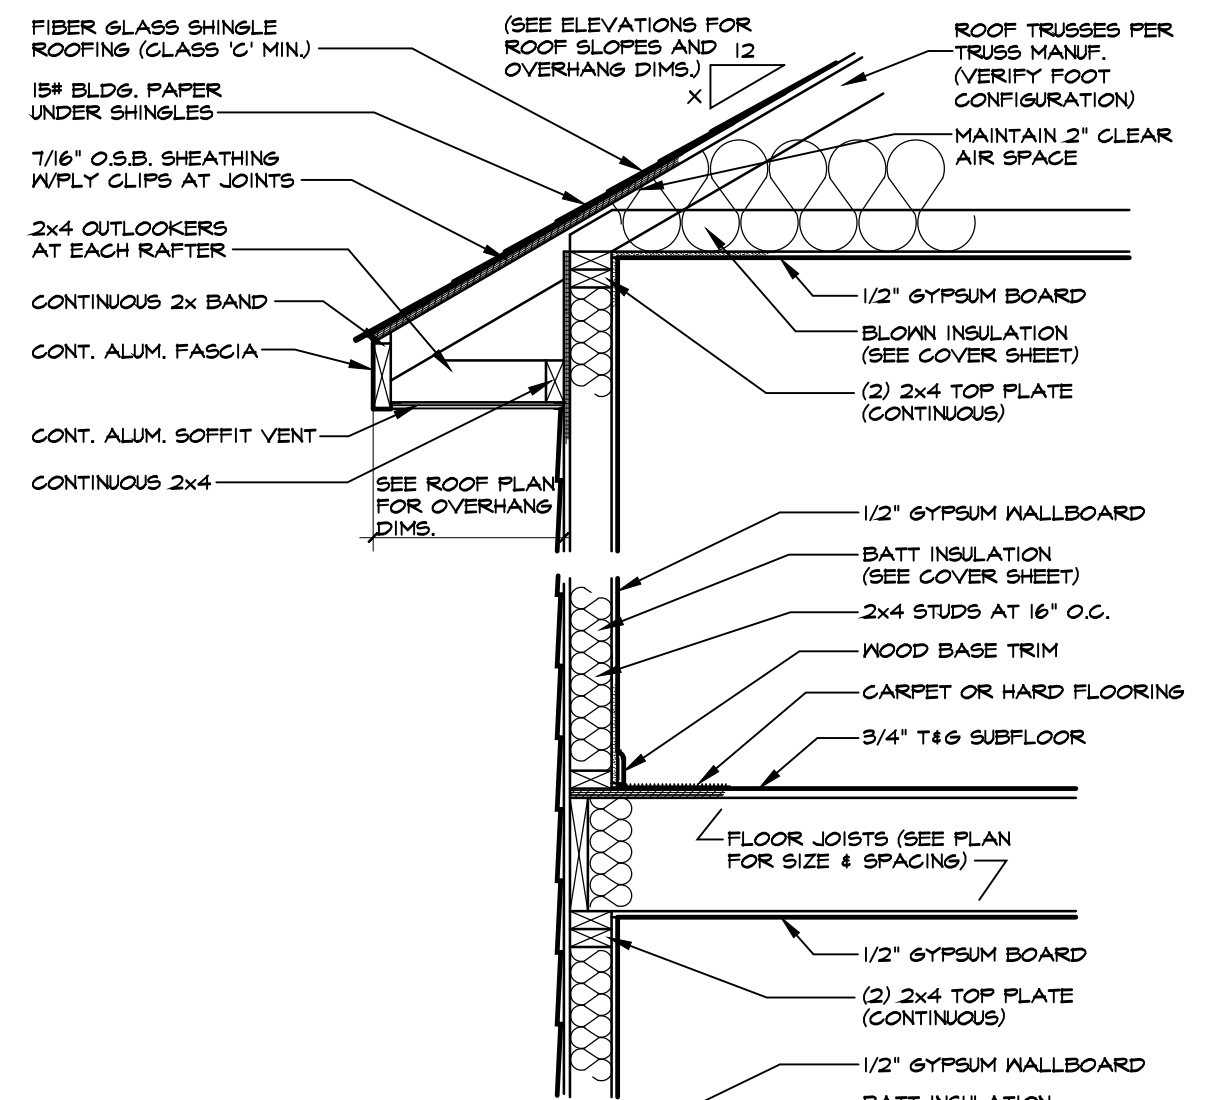


3 TWO-STORY WALL SECTION W/SIDING
SCALE: 3/4"=1'-0" (PARGE MASONRY FOUNDATION)

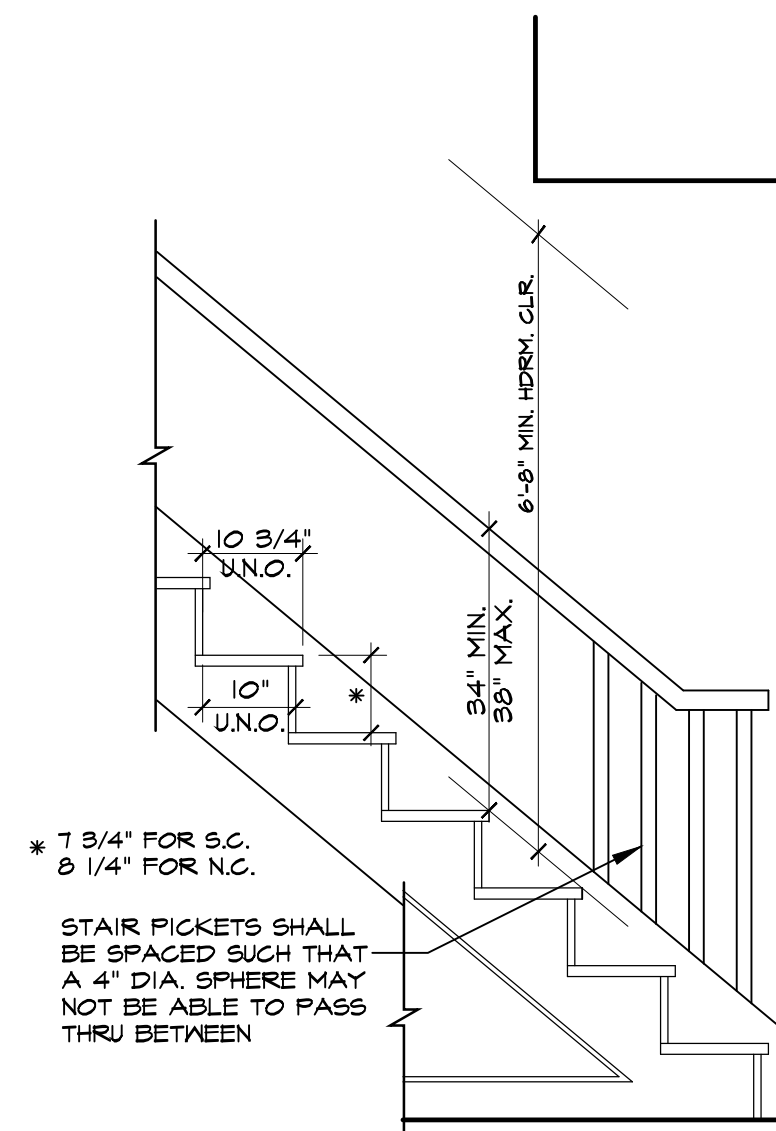

4 TYPICAL STAIR DETAIL

ENLARGED FOOTING SCHEDULE

- F1 12" THICK X 36" SQ. POURED CONCRETE FOOTING WITH (4) #4 X 30" REBAR @ 9" O.C.
BOTH DIRECTIONS 3" CLR FROM BOTTOM OF FOOTING.
F2 12" THICK X 24" SQ. POURED CONCRETE FOOTING WITH (3) #4 REBAR @ 9" O.C.
BOTH DIRECTIONS 3" CLR FROM BOTTOM OF FOOTING.

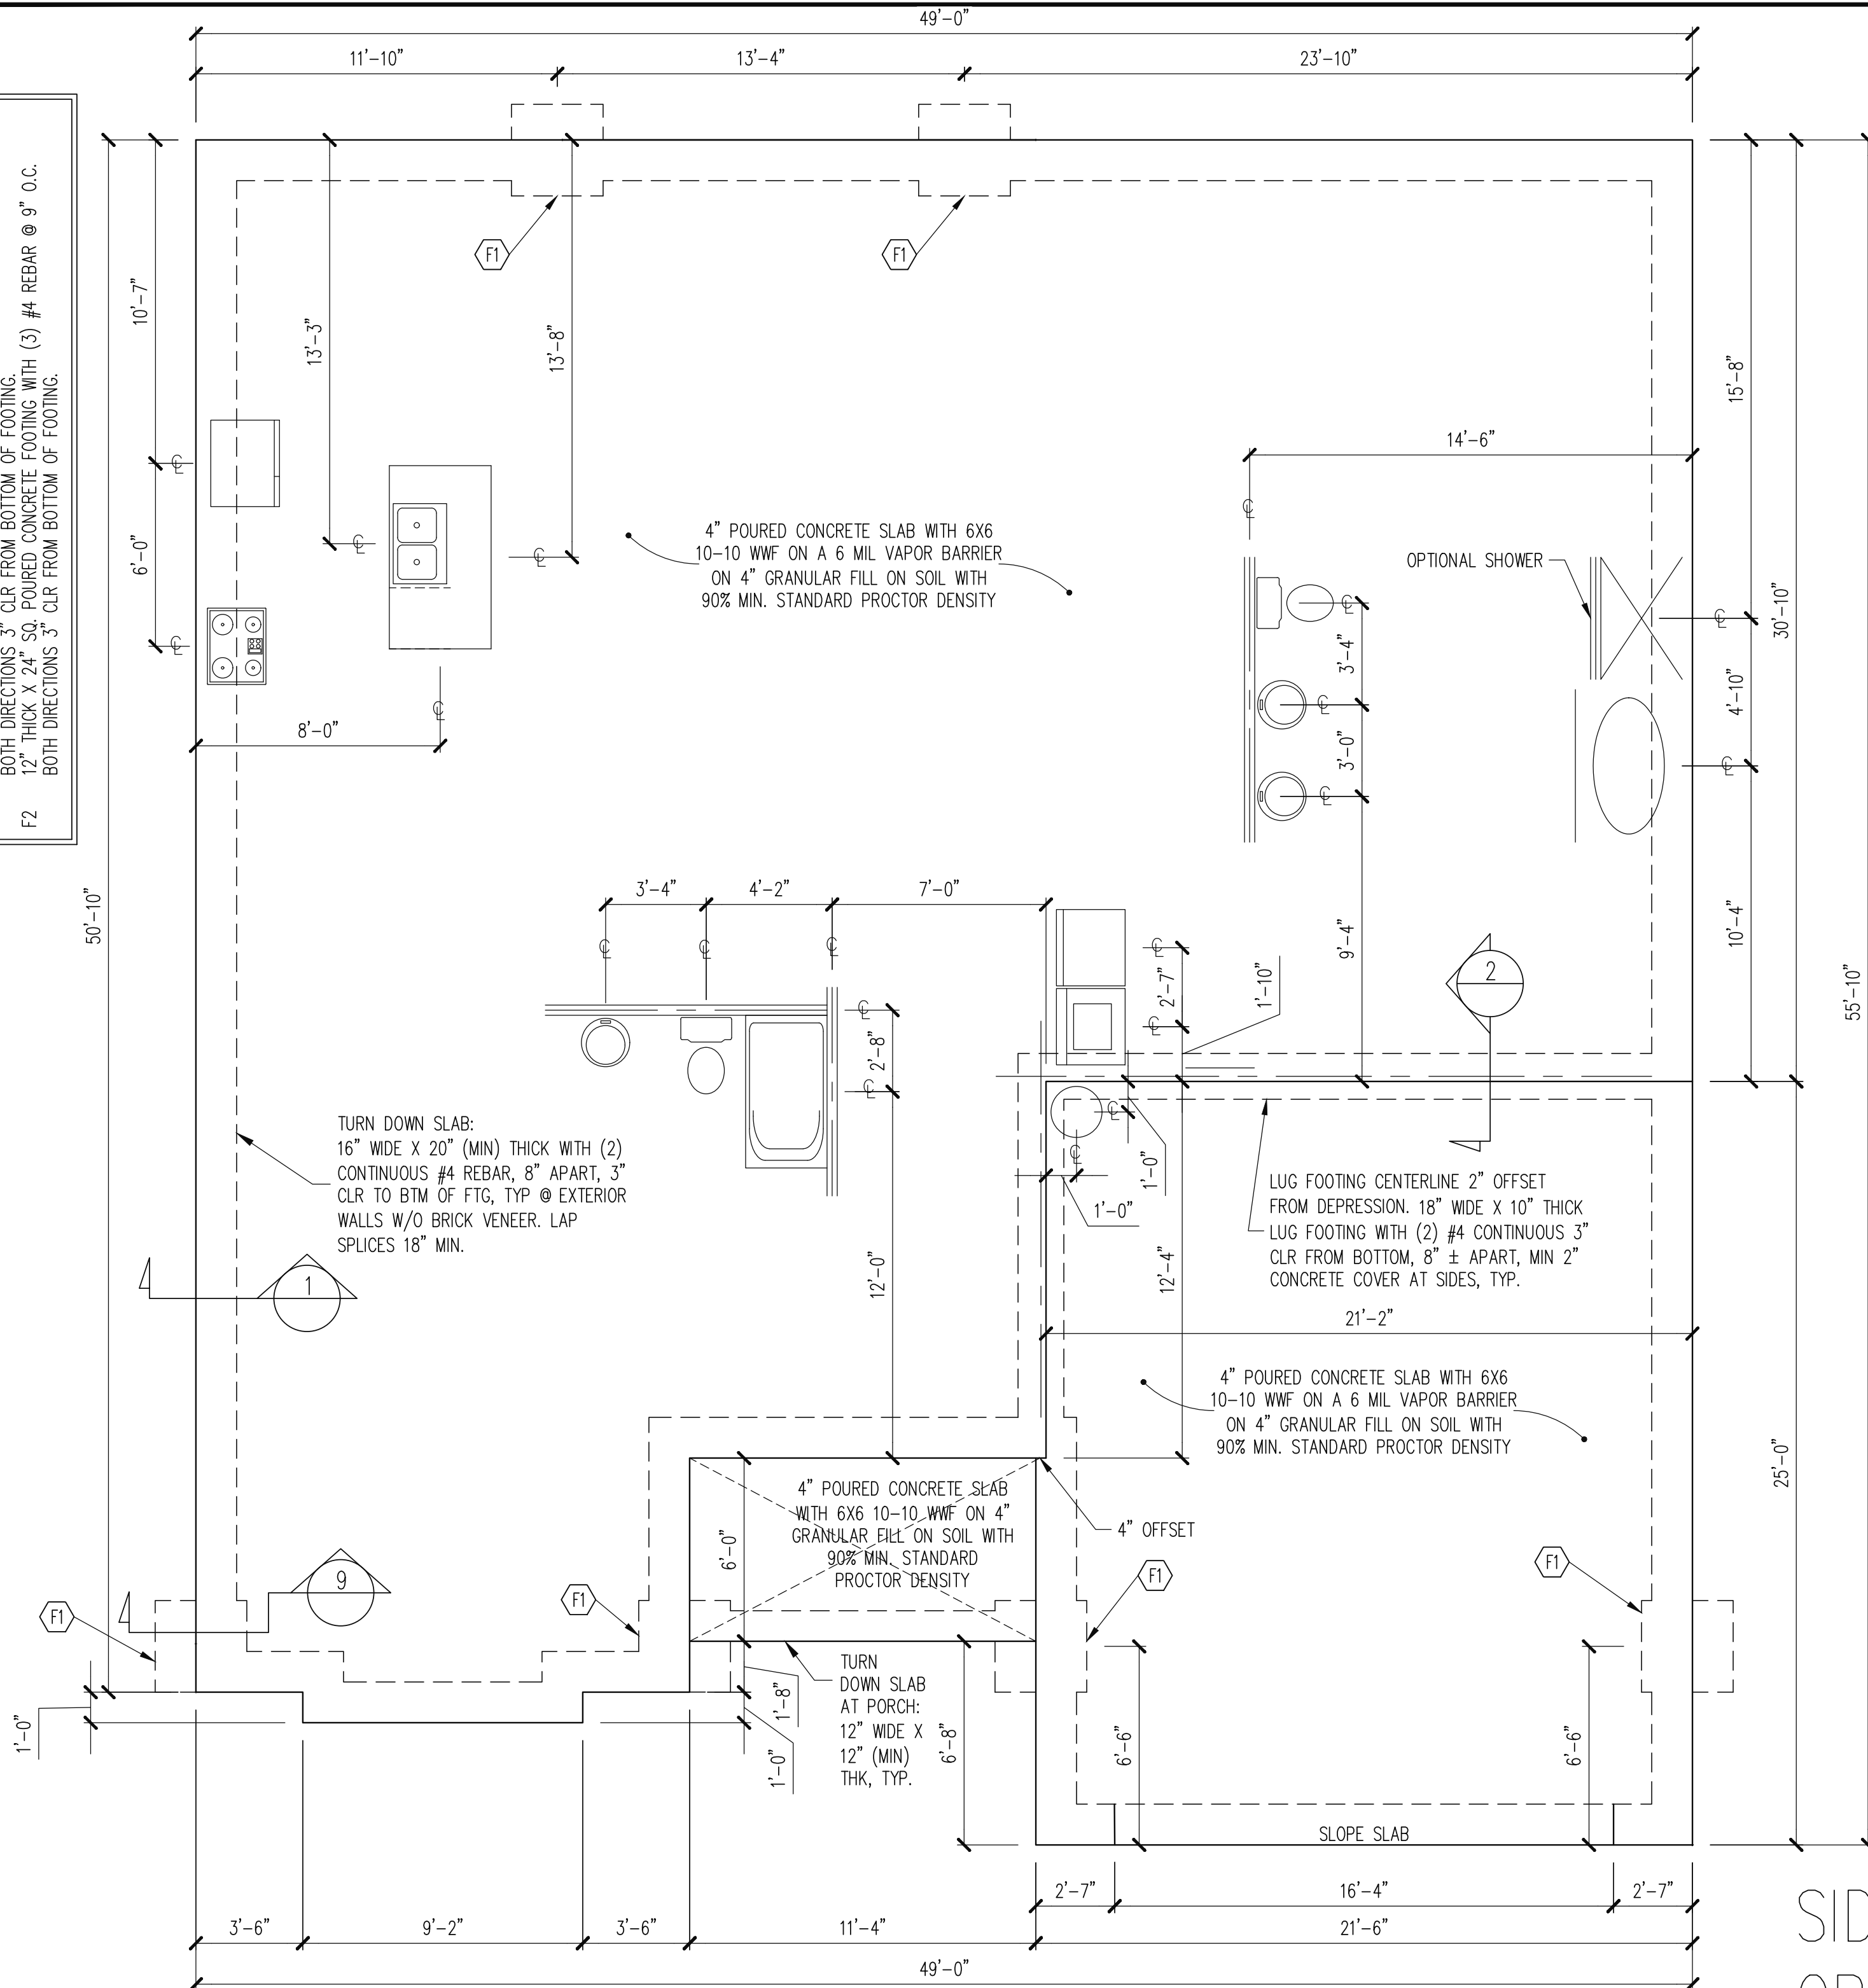

SIDING
OPTION

The structural design of this plan is the property of Engineering Tech Associates, P.A. These plans are for the one time use at the location and for the client listed. Engineering Tech Associates, P.A. assumes no liability for these plans if they are reproduced, in whole or in part, for construction at any other location without written permission from Engineering Tech Associates, P.A.

PLAN DESIGNED UNDER
2018 NORTH CAROLINA
RESIDENTIAL CODE

NOTES:
-HEIGHT AND BACKFILL LIMITATIONS FOR
FOUNDATION WALLS ARE TO BE GOVERNED
BY THE NCSBC, LATEST EDITION.

-FIBER MESH REINFORCED CONCRETE MAY BE
USED IN LIEU OF WELDED WIRE FABRIC. SEE
SECTION 6.01 OF THE CONSTRUCTION
SPECIFICATIONS FOR ALLOWABLE
SUBSTITUTION DETAILS.


- ALL APPLIANCE AND PLUMBING
LOCATIONS ARE FOR REFERENCE ONLY.
FINAL LOCATIONS MUST BE VERIFIED WITH
ARCHITECTURAL FLOOR PLANS.

FOUNDATION PLAN
MONO SLAB OPTION

1/4" = 1'-0"

STRUCTURAL ENGINEERS
License No. C-3870
318 W Millbrook Road, Unit 201
Raleigh, North Carolina 27609
Phone: (919) 844-1661

Engineering
Tech
ASSOCIATES, P.A.

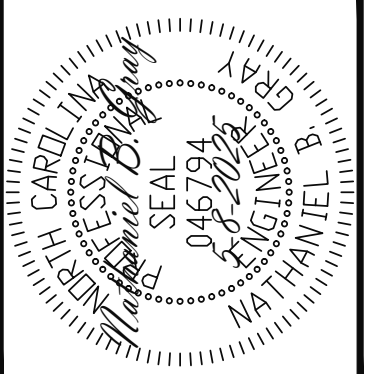

ADAMS HOMES				
STRUCTURAL ADDENDUM				
SCOPE:	66 KIPLING CREEK		ENG:	NBC/TSP
LOT #:			REV:	
	2604 MASTER		DATE:	5-8-2025

PLAN NO.
2604

PROJECT NO.
25-18-250

SHEET NO.
S1

1 of 7

(2) 1.75" X 9.25" LVL
HEADER ON (3) JACKS B.E.

ATTACH GIRDER WITH SIMP.
TBE4, BEAR ON (4) STUDS

ROOF TRUSSES
PER MANU

ATTACH GIRDER WITH SIMP.
TBE4, BEAR ON (4) STUDS

TRUSS GIRDER PER
MANU

SIMP. LUS210-2

2X10 @ 16" O.C.

(2) 2X10

(2) 2X10

TRUSS GIRDER PER MANU

ROOF TRUSSES
PER MANU

TRUSS GIRDER PER
MANU

ATTACH GIRDER WITH
SIMP. LGT3, BEAR ON
(5) CRIPPLE STUDS
ABOVE HEADER

(3) JACKS

(5) JACKS

BEAR DROPPED
BAND ON (3)
STUDS AT HOUSE,
TYP UNO.

PT 6X6 POST, WRAP AS REQ'D. OPTION:
(5) KIP MIN. RATED COLUMN PER
BUILDER, TYP @ FRONT PORCH. OFFSET
BAND AND POST 2" MAX FOR WRAP

ATTACH TRUSSES WITH SIMP.
H1 AND BEAR ON (2) STUDS
@ HATCHED WALL

NOTE ALL EXTERIOR WALLS
ARE BRACED WALLS PER
WALL BRACING NOTES

BUILDER FIELD
LOCATE PDS
BETWEEN TRUSSES

(3) PLY TRUSS GIRDER PER MANU

ROOF TRUSSES PER MANU

(2) 1.75" X 14" LVL PORTAL FRAME.
DBL STUDS @ DOOR OPENINGS

SIDING
OPTION

1ST FLOOR FRAMING PLAN

WALLS AND CEILING
1/4" = 1'-0"

REQUIRED STUDS FOR BEAM SUPPORT

REFER TO SECTIONS 5.02 - 5.06 OF THE
CONSTRUCTION SPECIFICATIONS FOR REQUIRED
NUMBER OF STUDS FOR BEAM SUPPORT, TYP UNO.

HEADER SCHEDULE

- H1 SINGLE 2X4 TURNED FLAT (A)
H2 (2) 2X4'S ON SINGLE JACKS (B)
H3 (2) 2X10'S ON SINGLE JACKS (C)
H4 (2) 1.75" X 9.25" LVL'S ON DBL JACKS
H5 (2) 2X10 HEADER ON DBL JACKS

- (A) TYPICAL FOR INTERIOR NON LOAD BEARING
WALLS ONLY, ROUGH OPENING 38" MAX.
(B) TYPICAL FOR INTERIOR NON LOAD BEARING
WALLS ONLY, ROUGH OPNG 38" TO 74" MAX.
(C) TYPICAL FOR ALL CONDITIONS NOT LISTED
IN (A) OR (B) UNO.

NOTES:

- HEADERS IN NON LOAD BEARING INTERIOR
WALLS ARE NOT LABELED.
-KING STUDS EXTERIOR WALLS:
SINGLE KING STUDS FOR 6' MAX OPENINGS.
DBL KING STUDS FOR 10' MAX OPENINGS.
TRPL KING STUDS FOR 14' MAX OPENINGS.
QUAD KING STUDS FOR 18' MAX OPENINGS.
FOR 2X6 WALLS, ONE HALF THE AMOUNT OF
KING STUDS REQUIRED (ROUND UP) UNO

WALL BRACING

ALL EXTERIOR STUD WALLS ARE TO BE
CONTINUOUSLY SHEATHED WITH 7/16 APA RATED
OSB NAILED TO STUDS WITH 8d NAILS @ 6" O.C. AT
PANEL EDGES, 12" O.C. IN PANEL FIELD.

SINGLE JOIST, CONTINUOUS RIM JOIST, OR BLOCKING
OF EQUAL DEPTH IS REQUIRED ABOVE AND BELOW
ALL BRACED WALLS. NAIL BLOCKING ABOVE WALL TO
TOP PLATE WITH 8d TOE NAILS @ 6" O.C. NAIL
SOLE PLATE OF BRACED WALL TO BLOCKING BELOW
WITH (3) 16d NAILS @ 16" O.C. BLOCKING AT
HORIZONTAL JOINTS IN BRACED WALL LINES ONLY
REQUIRED AT SHADED WALLS, UNO.


SHADED WALLS:

PROVIDED CONTINUOUS SHEATHING = 230' MIN.
-WALL BRACING IS BY ENGINEERED DESIGN AND
NOT PRESCRIPTIVE PER SECTION 602.10 OF THE
2018 NCR. CONTINUOUS SHEATHING HAS BEEN
PROVIDED, ALONG WITH ALTERNATIVE METHODS TO
INSURE THE MINIMUM INTENT OF SECTION 602.10 OF
THE 2018 NCR HAS BEEN MET AND EXCEEDED.

-BRACED WALL PANELS SHALL BE FASTENED IN
ACCORDANCE WITH TABLE 602.3(1) TO PROVIDE
CONTINUOUS PANEL UPLIFT RESISTANCE AND
COMPLIANCE WITH NCRBC R602.3.5 AND R802.11
UNLESS NOTED OTHERWISE ON STRUCTURAL PLANS.

STRUCTURAL ENGINEERS
License No. C-3870
318 W Millbrook Road, Unit 201
Raleigh, North Carolina 27609
Phone: (919) 844-1661

Engineering
Tech
ASSOCIATES, P.A.

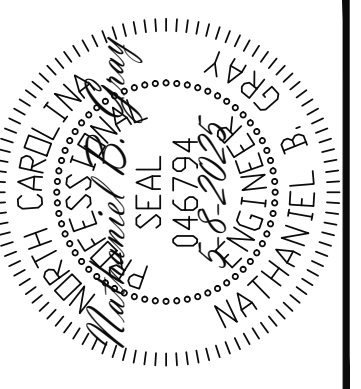

ADAMS HOMES

STRUCTURAL ADDENDUM

ENG: NBC/TSP

REV:

DATE: 5-8-2025

SCOPE

LOT #:

66 KIPLING CREEK

2604 MASTER

PLAN NO.

2604

PROJECT NO.


25-18-250

SHEET NO.

S2

2 of 7

NOTE ALL EXTERIOR
GABLE END WALLS
ARE CONTINUOUSLY
SHEATHED BRACED
WALLS PER WALL
BRACING NOTES

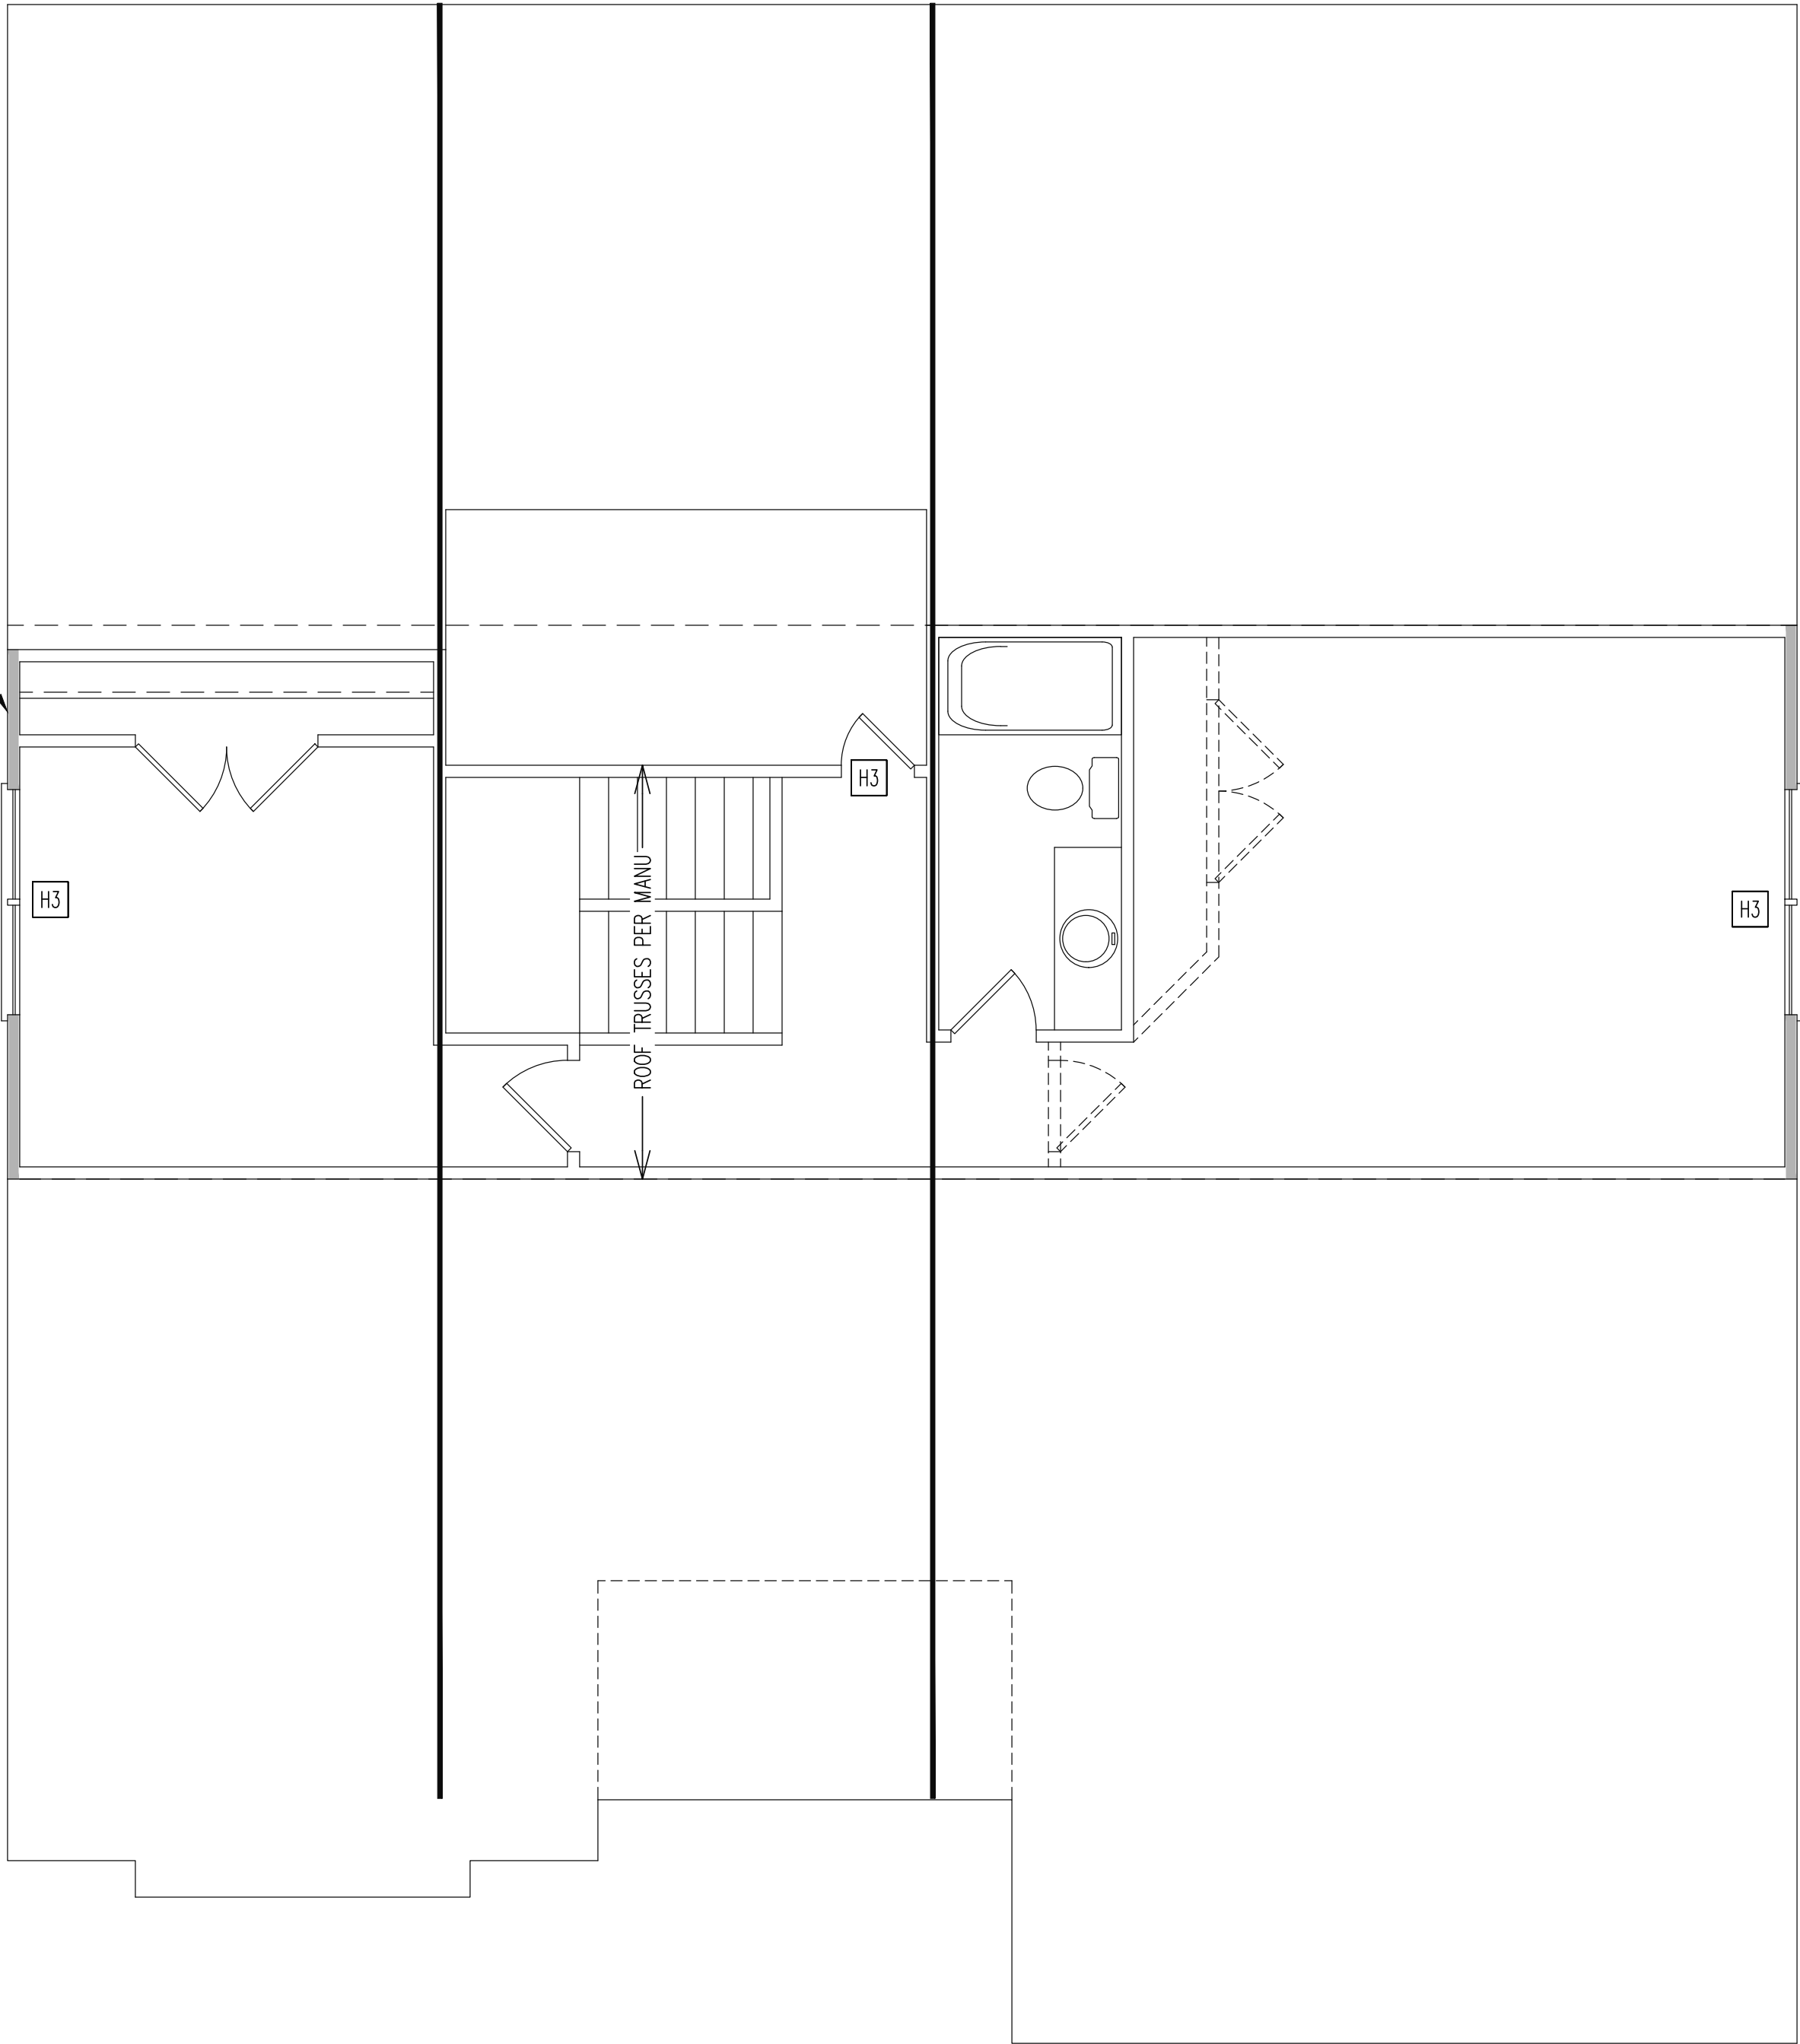

REQUIRED STUDS FOR
BEAM SUPPORT

REFER TO SECTIONS 5.02 – 5.06 OF THE
CONSTRUCTION SPECIFICATIONS FOR REQUIRED
NUMBER OF STUDS FOR BEAM SUPPORT, TYP UNO.

HEADER SCHEDULE

- H1 SINGLE 2X4 TURNED FLAT (A)
- H2 (2) 2X4'S ON SINGLE JACKS (B)
- H3 (2) 2X10'S ON SINGLE JACKS (C)
- H4 (2) 1.75" X 9.25" LVL'S ON DBL JACKS
-
- (A) TYPICAL FOR INTERIOR NON LOAD BEARING
WALLS ONLY, ROUGH OPENING 38" MAX.
- (B) TYPICAL FOR INTERIOR NON LOAD BEARING
WALLS ONLY, ROUGH OPNG 38" TO 74" MAX.
- (C) TYPICAL FOR ALL CONDITIONS NOT LISTED
IN (A) OR (B) UNO.

NOTES:
-HEADERS IN NON LOAD BEARING INTERIOR
WALLS ARE NOT LABELED.
-KING STUDS EXTERIOR WALLS:
SINGLE KING STUDS FOR 6' MAX OPENINGS.
DBL KING STUDS FOR 10' MAX OPENINGS.
TRPL KING STUDS FOR 14' MAX OPENINGS.
QUAD KING STUDS FOR 18' MAX OPENINGS.
FOR 2X6 WALLS, ONE HALF THE AMOUNT OF
KING STUDS REQUIRED (ROUND UP) UNO

WALL BRACING

ALL EXTERIOR STUD WALLS ARE TO BE
CONTINUOUSLY SHEATHED WITH 7/16 APA RATED
OSB NAILED TO STUDS WITH 8d NAILS @ 6" O.C. AT
PANEL EDGES, 12" O.C. IN PANEL FIELD.

SINGLE JOIST, CONTINUOUS RIM JOIST, OR BLOCKING
OF EQUAL DEPTH IS REQUIRED ABOVE AND BELOW
ALL BRACED WALLS. NAIL BLOCKING ABOVE WALL TO
TOP PLATE WITH 8d TOE NAILS @ 6" O.C. NAIL
SOLE PLATE OF BRACED WALL TO BLOCKING BELOW
WITH (3) 16d NAILS @ 16" O.C. BLOCKING AT
HORIZONTAL JOINTS IN BRACED WALL LINES ONLY
REQUIRED AT SHADED WALLS, UNO.

SHADED WALLS:




PROVIDED CONTINUOUS SHEATHING = 30' MIN.
-WALL BRACING IS BY ENGINEERED DESIGN AND
NOT PRESCRIPTIVE PER SECTION 602.10 OF THE
2018 NCR. CONTINUOUS SHEATHING HAS BEEN
PROVIDED, ALONG WITH ALTERNATIVE METHODS TO
INSURE THE MINIMUM INTENT OF SECTION 602.10 OF
THE 2018 NCR HAS BEEN MET AND EXCEEDED.

-BRACED WALL PANELS SHALL BE FASTENED IN
ACCORDANCE WITH TABLE 602.3(1) TO PROVIDE
CONTINUOUS PANEL UPLIFT RESISTANCE AND
COMPLIANCE WITH NCRBC R602.3.5 AND R802.11
UNLESS NOTED OTHERWISE ON STRUCTURAL PLANS.

2ND FLOOR
FRAMING PLAN

WALLS AND CEILING
1/4" = 1'-0"


STRUCTURAL ENGINEERS
License No. C-3870
318 W Millbrook Road, Unit 201
Raleigh, North Carolina 27609
Phone: (919) 844-1661

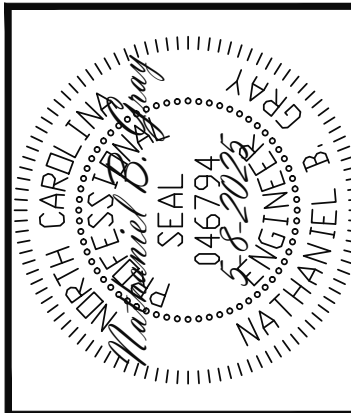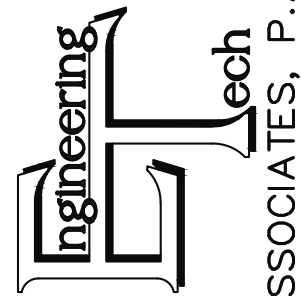

ADAMS HOMES				
STRUCTURAL ADDENDUM				
SCOPE:	66 KIPLING CREEK		ENG:	NBC/TSP
			REV:	
	2604 MASTER		DATE	5-8-2025

PLAN NO.
2604
PROJECT NO.
25-18-250

SHEET NO.
S3
3 of 7

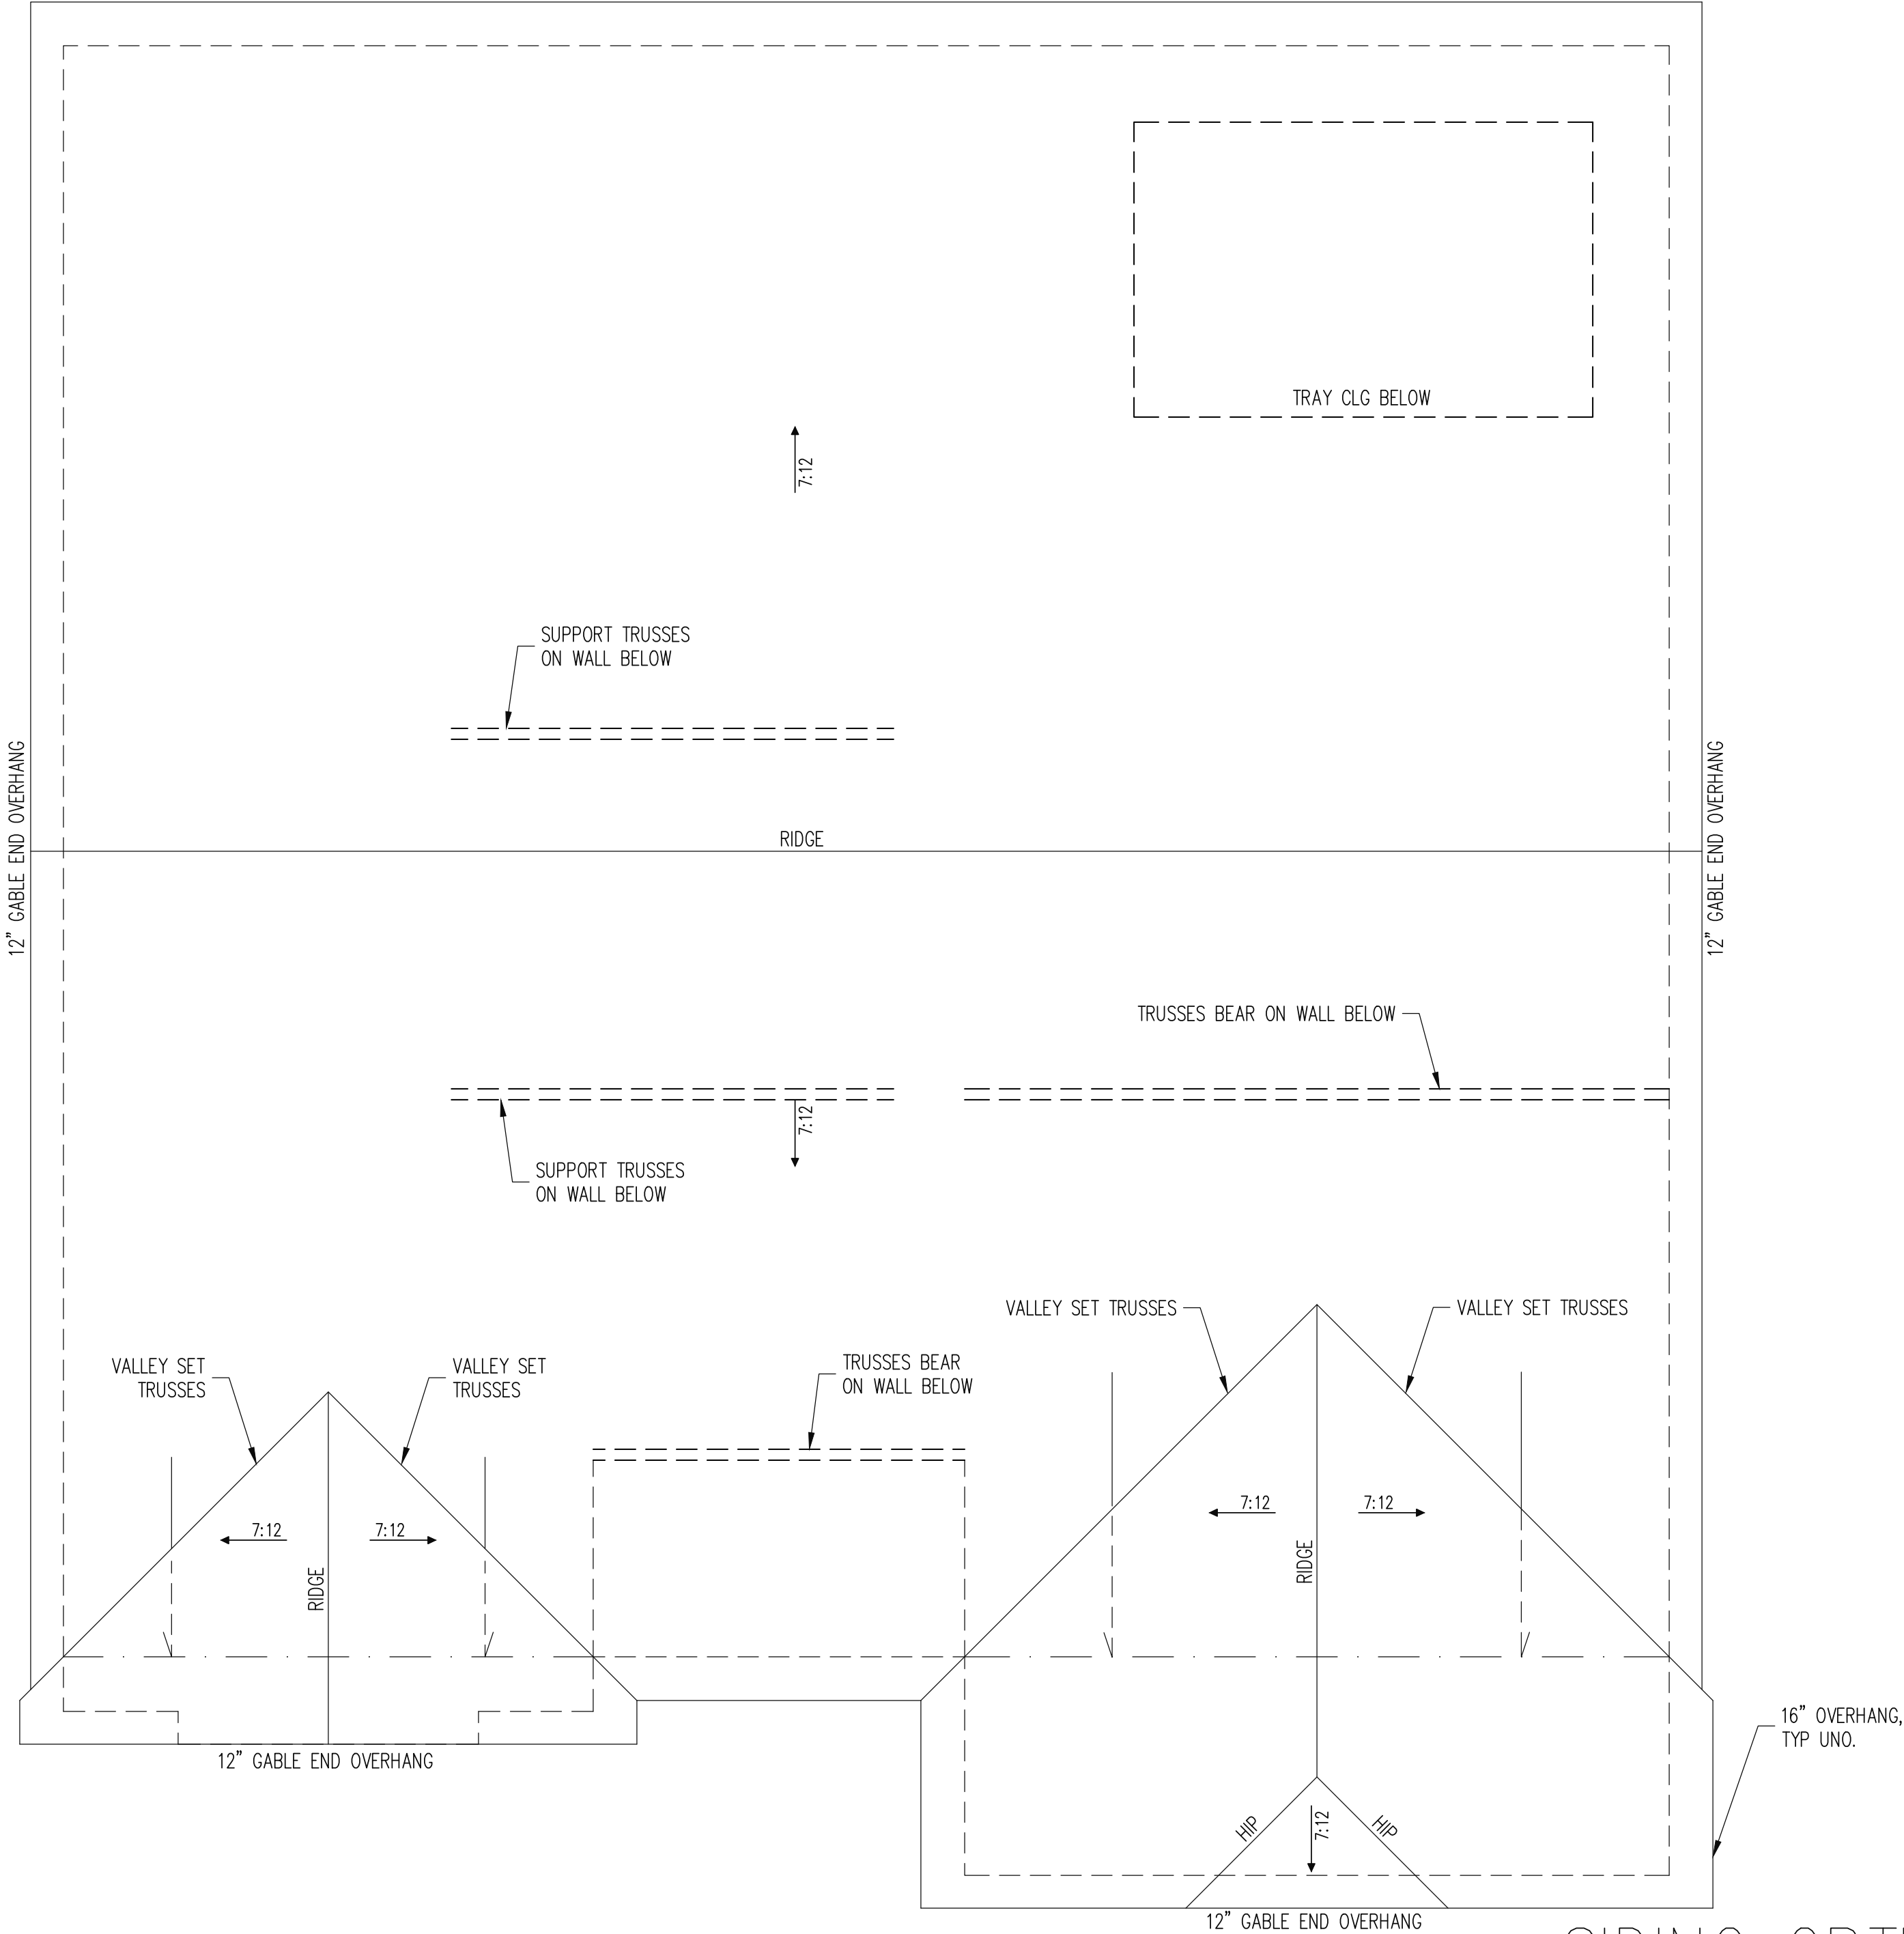

SIDING OPTION
ELEVATION A

The structural design of this plan is the property of Engineering Tech Associates, P.A. These plans are for the one time use at the location and for the client listed. Engineering Tech Associates, P.A. assumes no liability for these plans if they are reproduced, in whole or in part, for construction at any other location without written permission from Engineering Tech Associates, P.A.

TRUSS UPLIFT CONNECTORS

EXPOSURE B, 120 MPH, ANY PITCH, 24" O.C. MAX ROOF TRUSS SPACING
TRUSSES SHALL BE ATTACHED TO SUPPORT WALL FOR UPLIFT RESISTANCE. CONTINUOUS OSB WALL SHEATHING BELOW PROVIDES CONTINUOUS UPLIFT RESISTANCE TO FOUNDATION. ALL TRUSSES SUPPORTED BY INTERMEDIATE SUPPORT WALLS, KNEEWALLS OR BEAMS SHALL BE ATTACHED TO SUPPORTING MEMBER PER SCHEDULE BELOW.
ROOF SPAN IS MEASURED HORIZONTALLY BETWEEN FURTHEST SUPPORT POINTS.
ROOF SPAN UP TO 18' CONNECTOR NAILING PER TABLE 602.3(1) NCRBC 2018 EDITION
OVER 18' (1) SIMPSON H2.5A HURRICANE CLIP TO DBL TOP PLATE OR BEAM


FRAMING NOTES

- ROOF ONLY
- ROOF TRUSSES PER MANU. TYPICAL U.N.O.
 - ROOF PITCHES 7:12 TYP U.N.O.
 - VERIFY ALL KNEEWALL HEIGHTS, ROOF PITCHES, AND ARCHITECTURAL OVERHANGS PRIOR TO CONSTRUCTION

ADAMS HOMES			
STRUCTURAL ADDENDUM			
SCOPE			
LOT #:	66 KIPLING CREEK	ENG:	NBC/TSP
		REV:	
	2604 MASTER	DATE	5-8-2025






PLAN NO.
2604
PROJECT NO.
25-18-250

SHEET NO.
S4
4 of 7

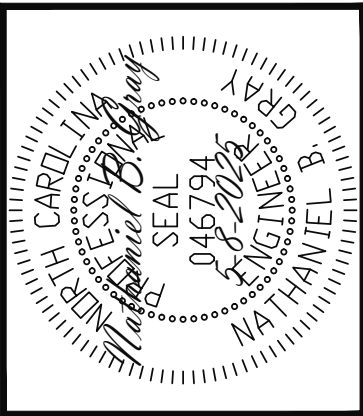

Engineering Tech Associates, P.A.


STRUCTURAL ENGINEERS
License No. C-3870
318 W Millbrook Road, Unit 201
Raleigh, North Carolina 27609
Phone: (919) 844-1661

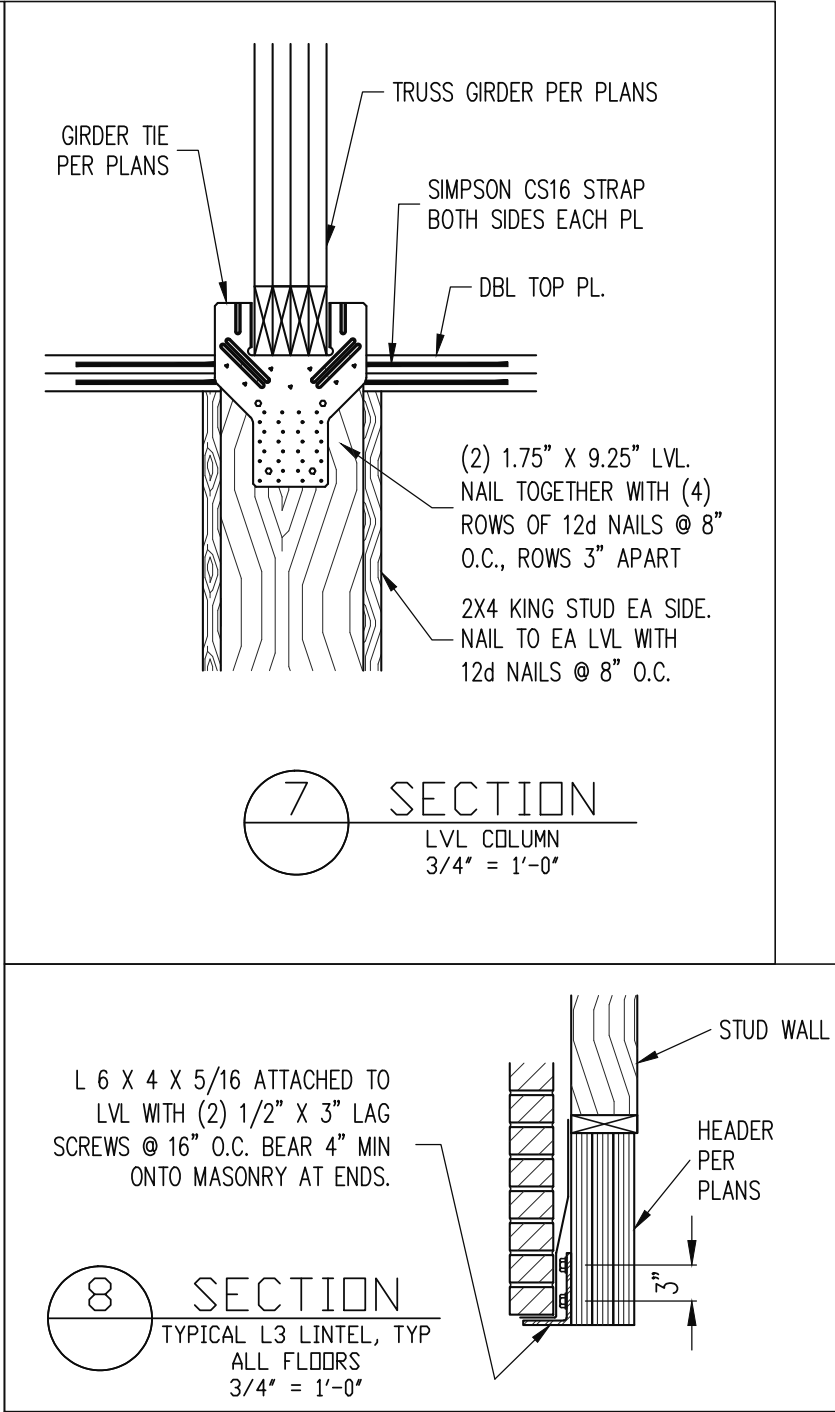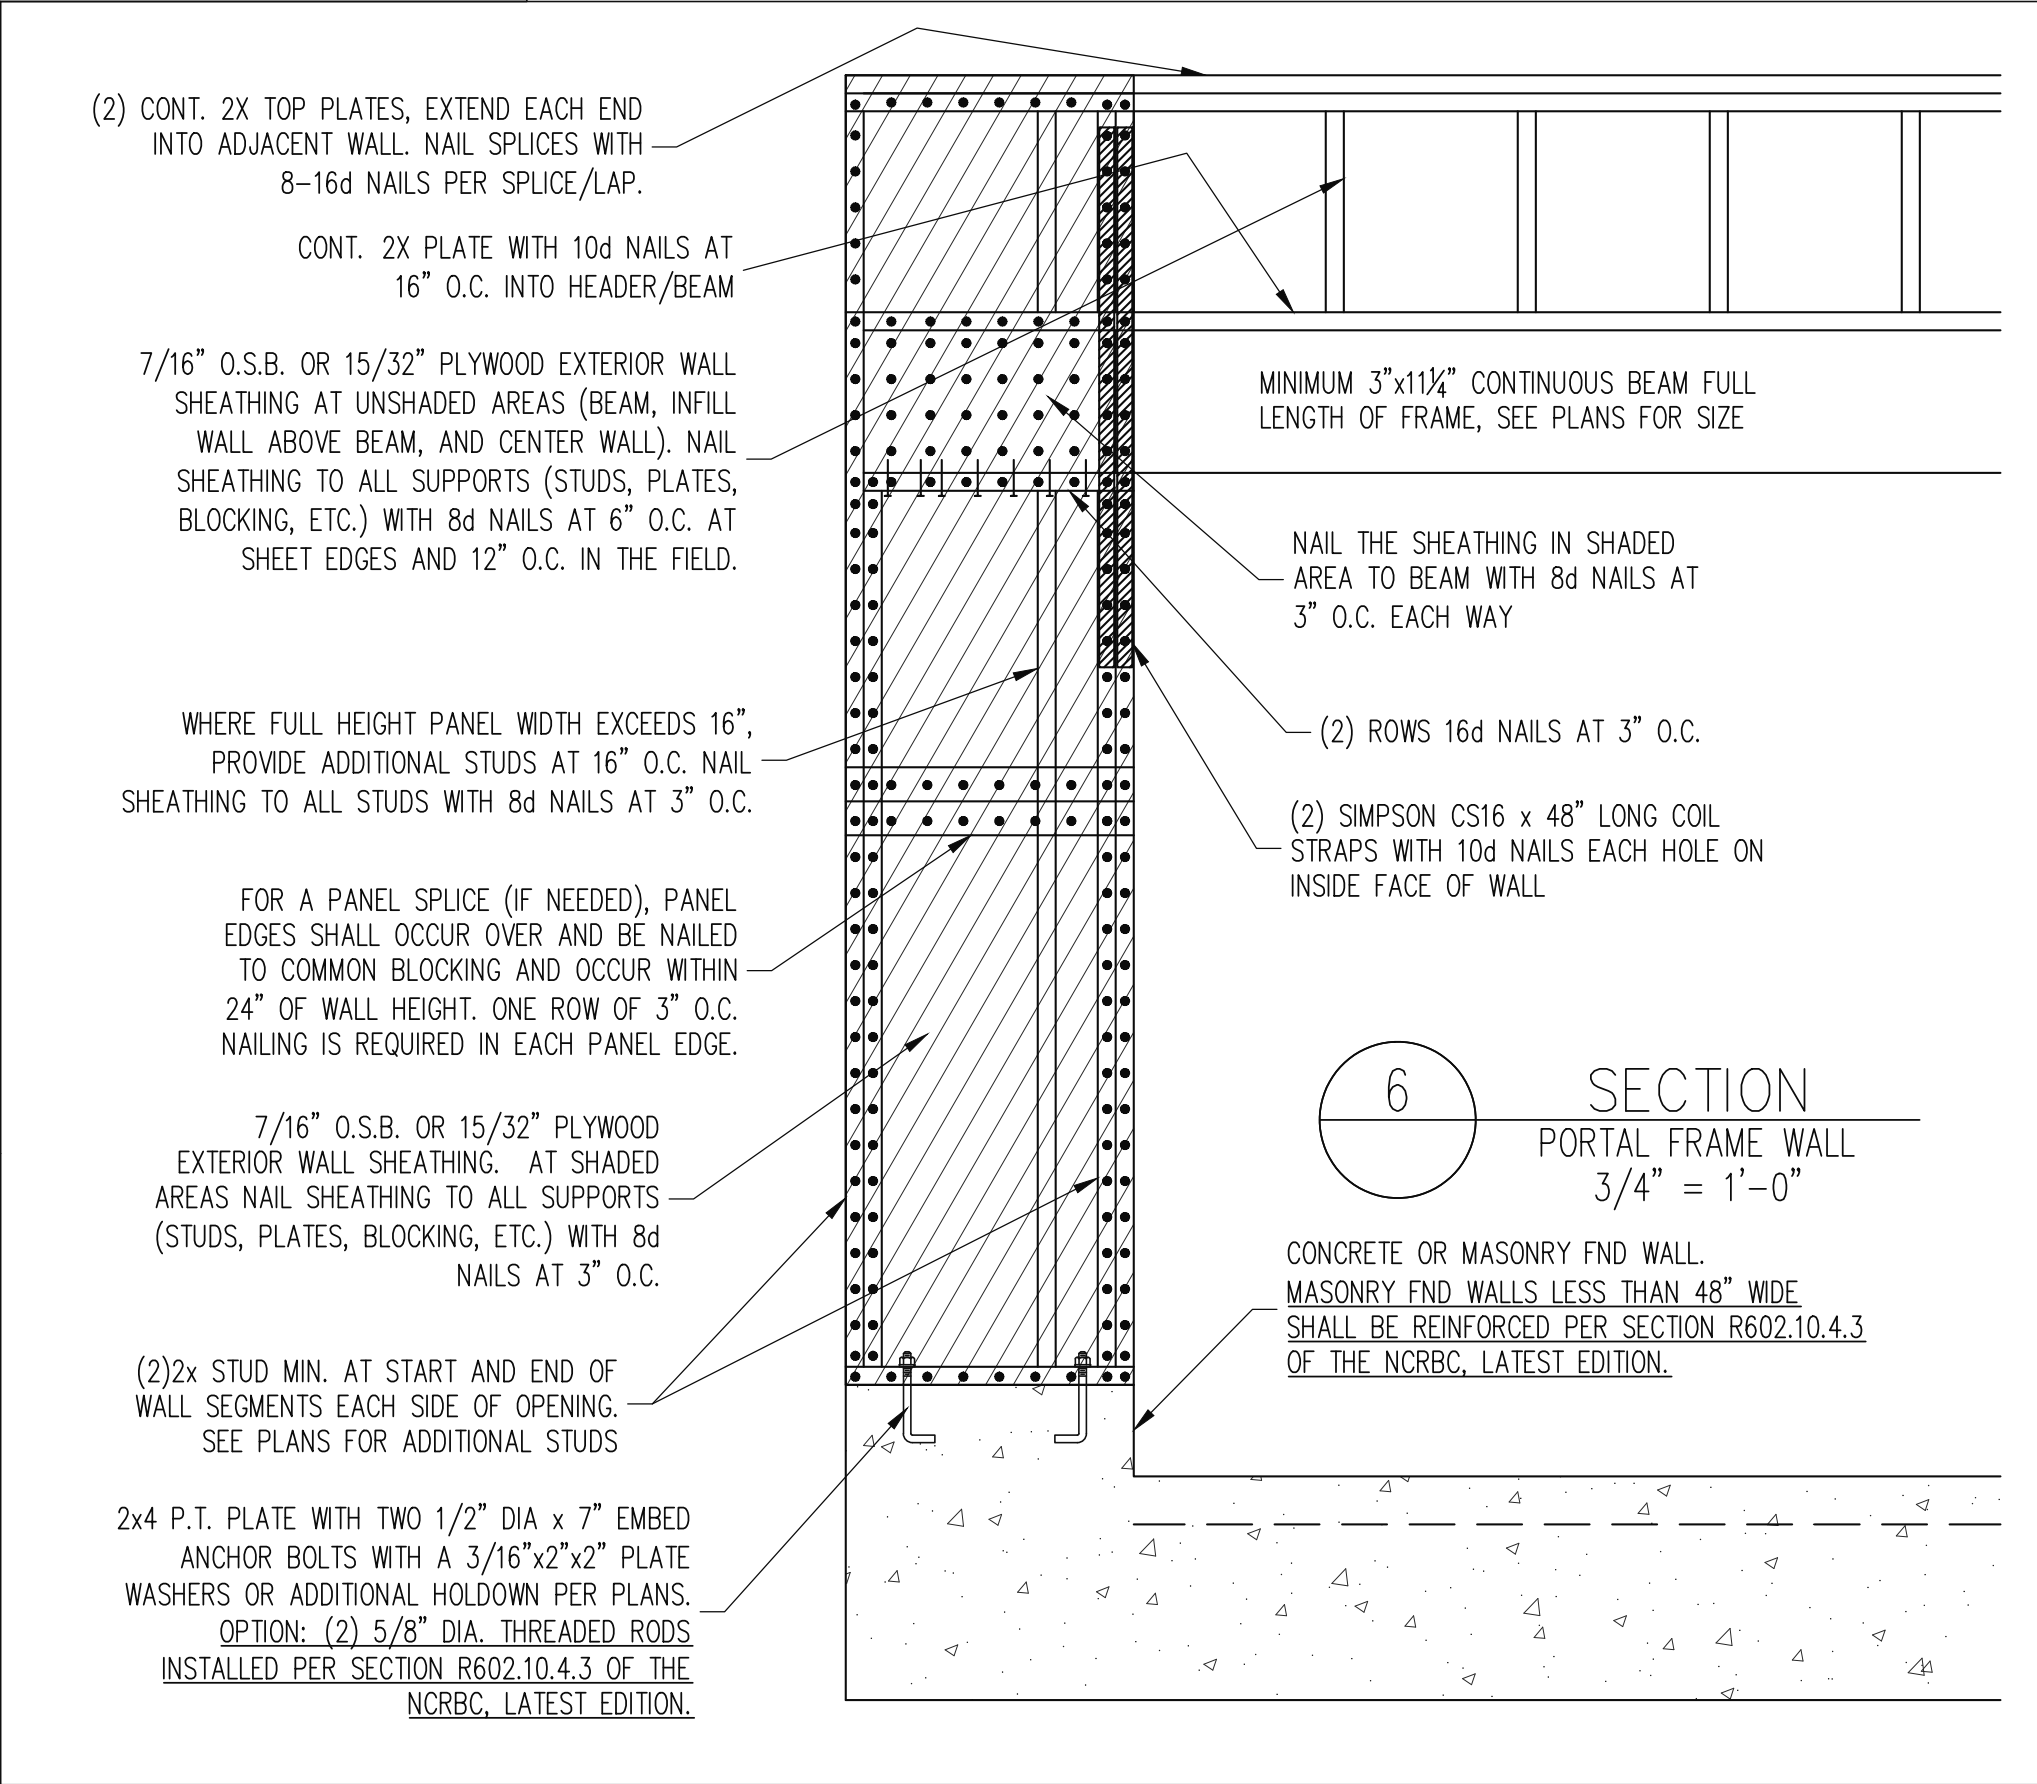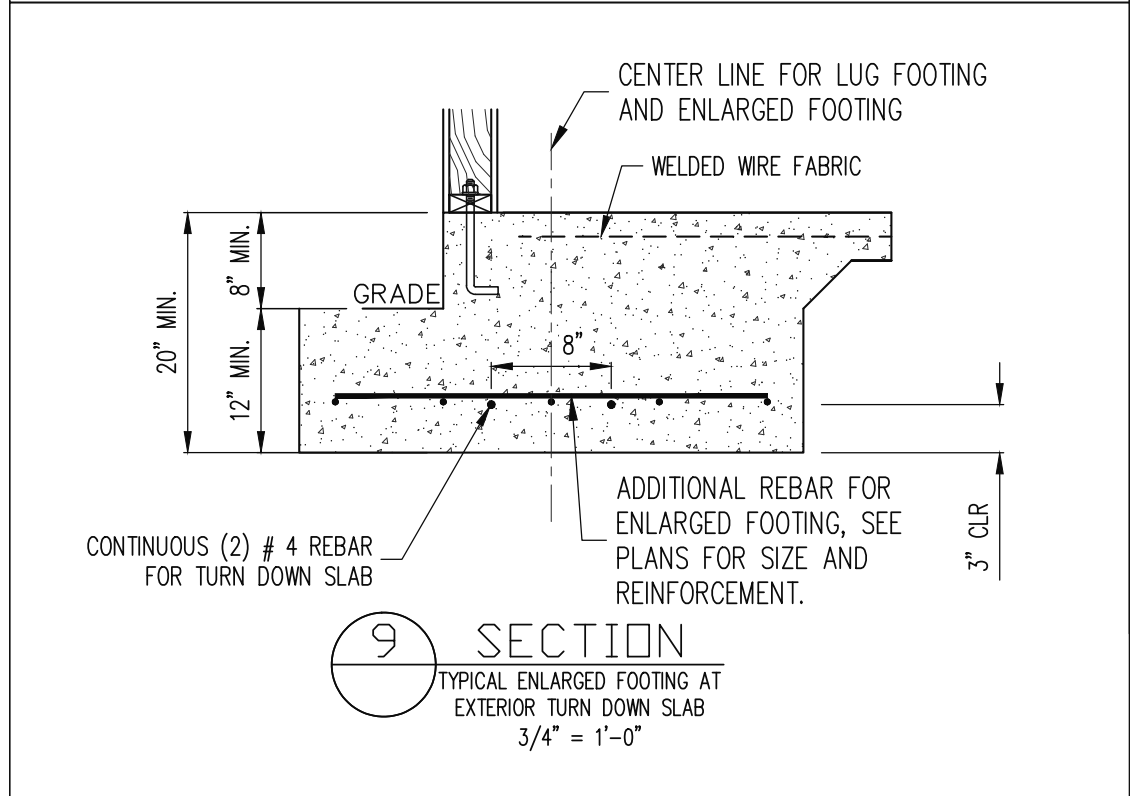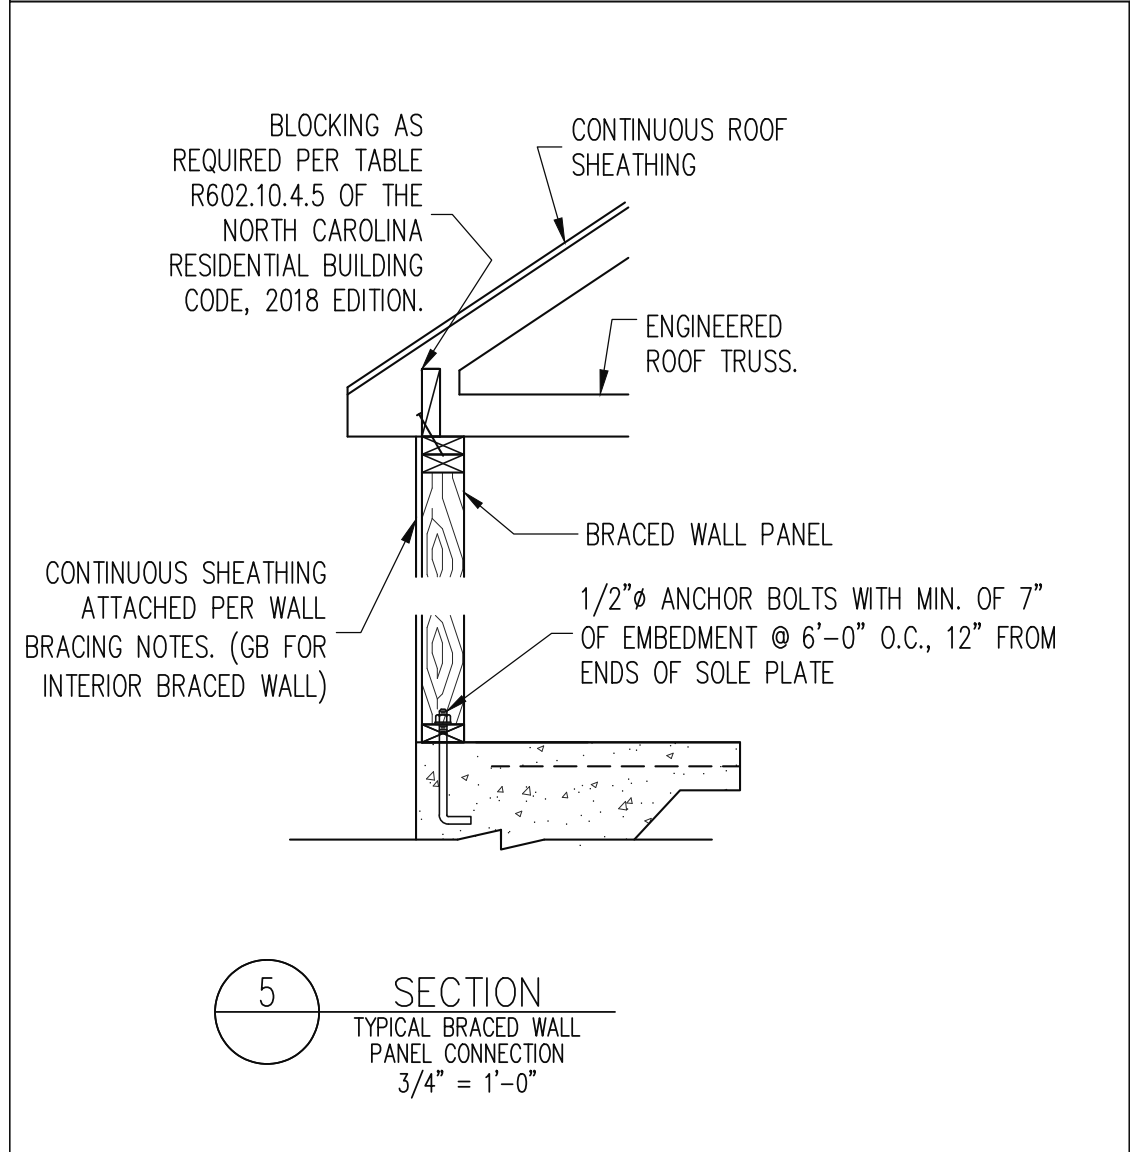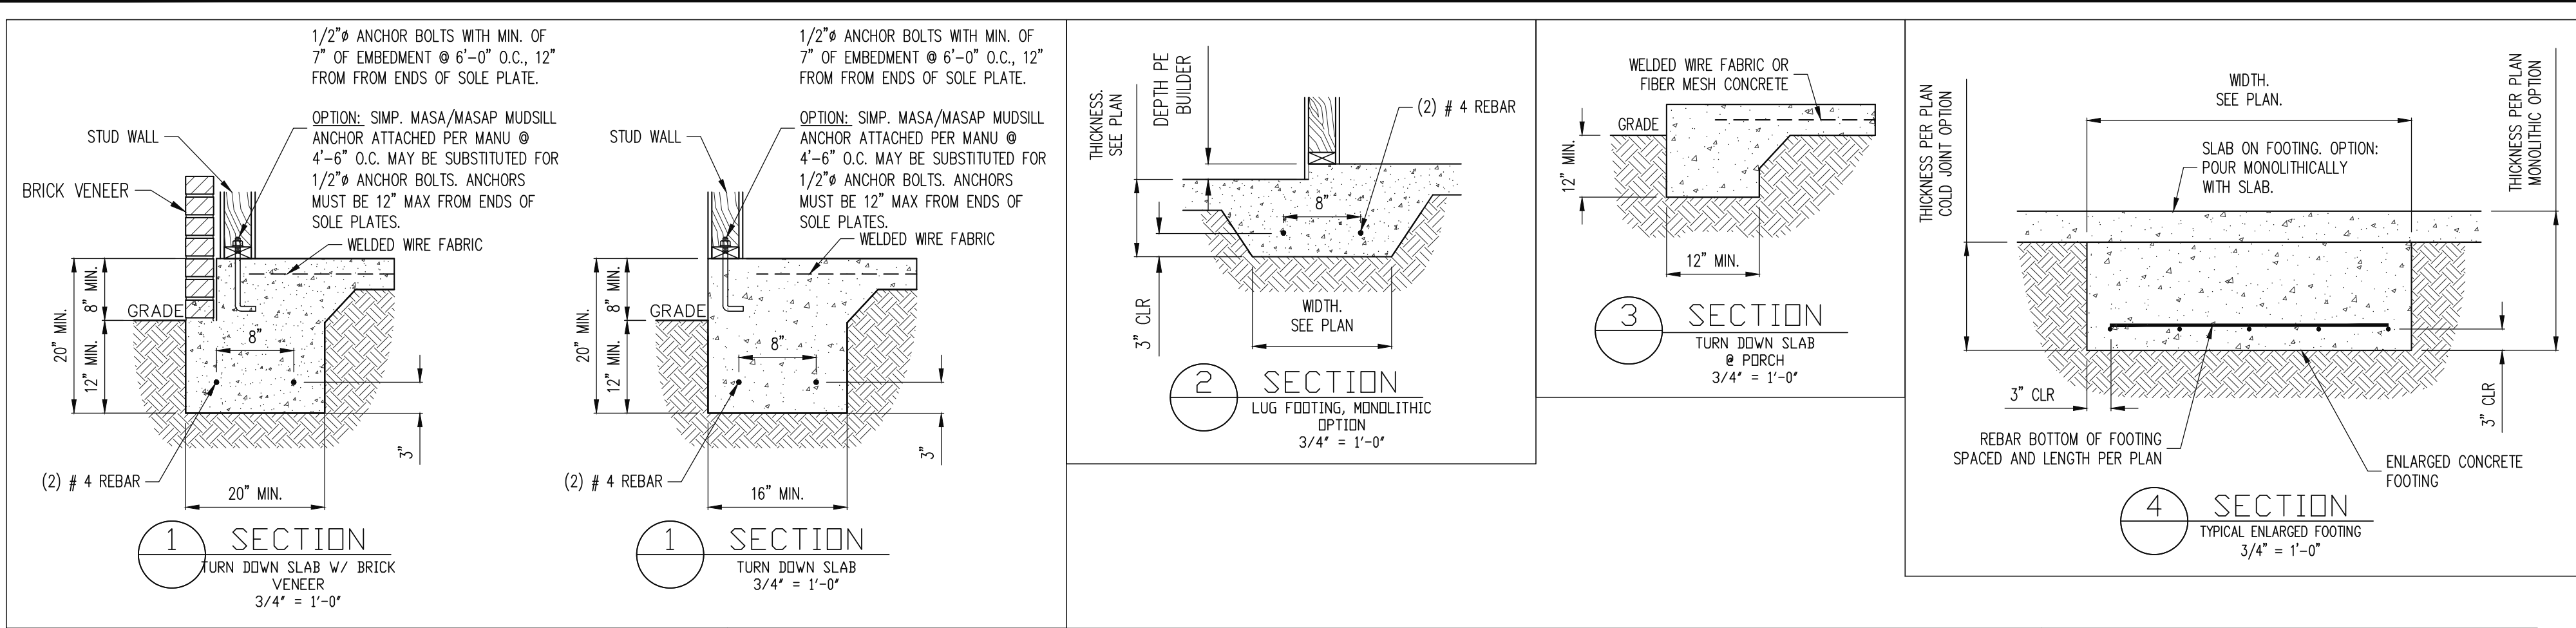

MONOSLAB


STRUCTURAL ENGINEERS
License No. C-3870
318 W Millbrook Road, Unit 201
Raleigh, North Carolina 27609
Phone: (919) 844-1661

Engineering Tech
ASSOCIATES, P.A.

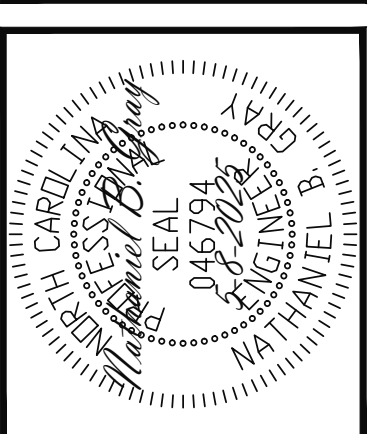


ADAMS HOMES	STRUCTURAL ADDENDUM		ENG: NBC/TSP	REV:	DATE: 5-8-2025
	SCOPE	LOT #:	66 KIPLING CREEK		2604 MASTER


PLAN NO.	
2604	
PROJECT NO.	
25-18-250	
SHEET NO.	
SD1	
5 of 7	

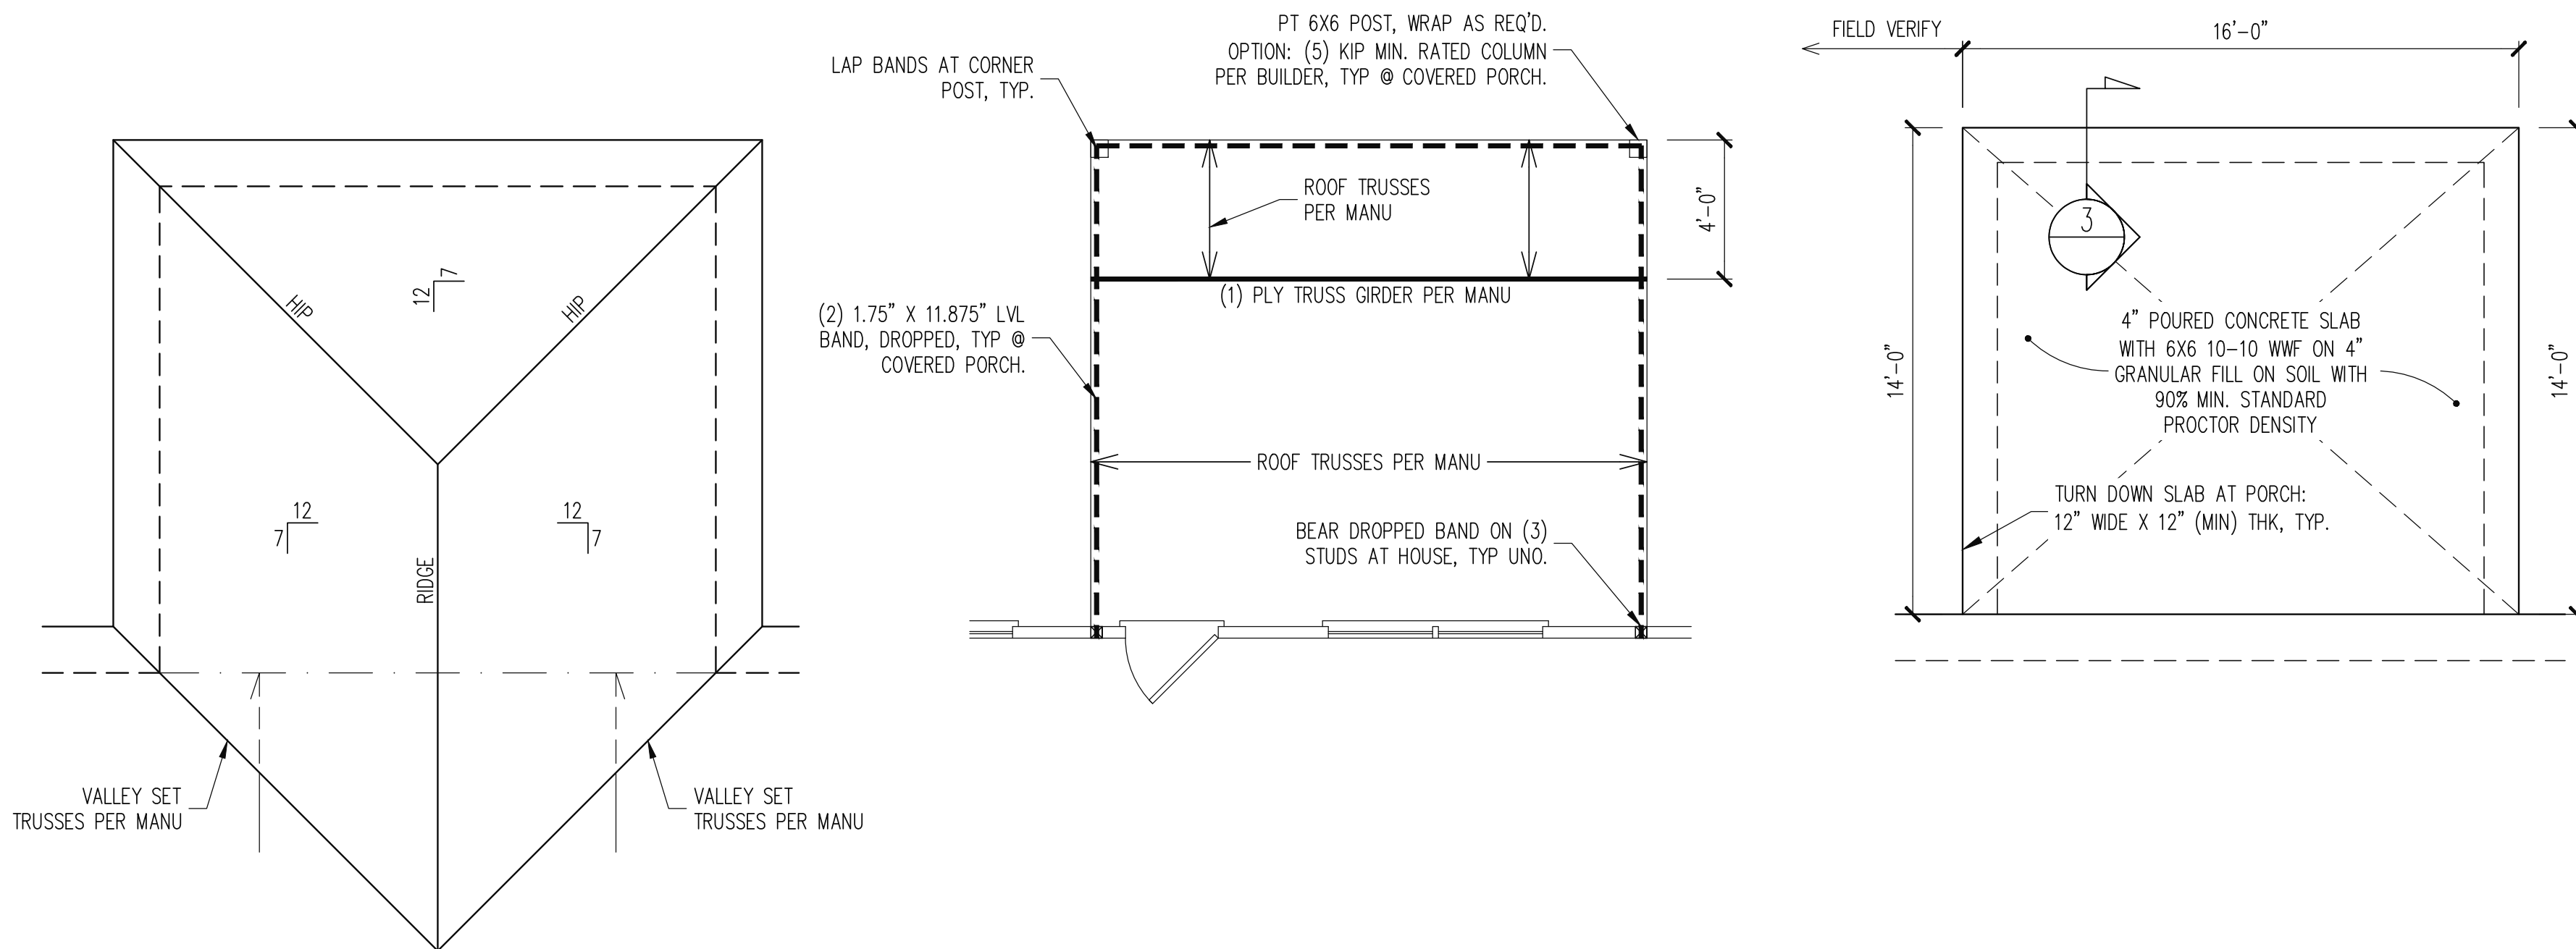


COVERED PORCH SCALE: 1/4"=1'-0"

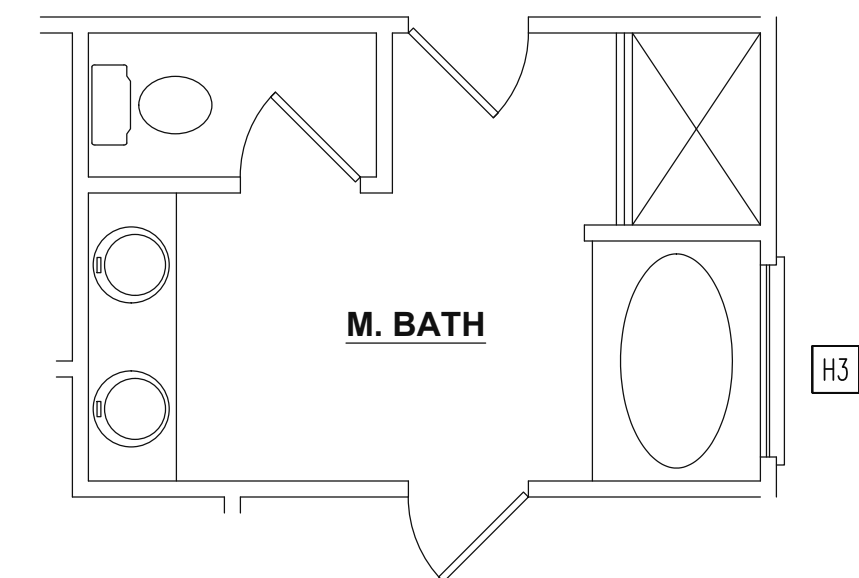

OPTIONAL MASTER BATH

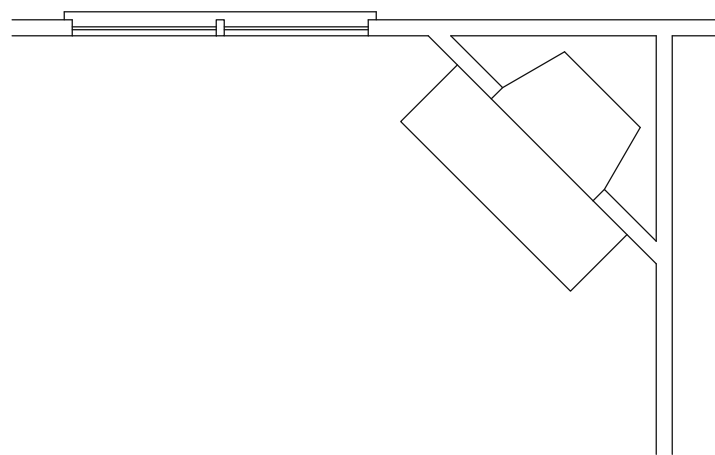

OPTIONAL FIREPLACE

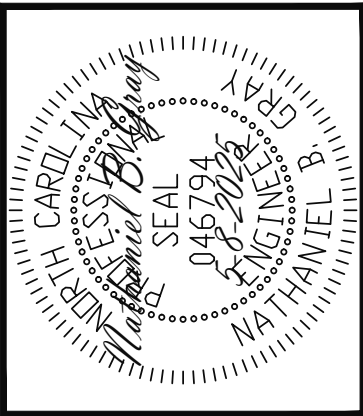


ADAMS HOMES			
SCOPE	STRUCTURAL ADDENDUM		
	LOT #:	66 KIPLING CREEK	ENG: NBC/TSP
			REV:
		2604 MASTER	DATE: 5-8-2025

PLAN NO.
2604

PROJECT NO.
25-18-250

SHEET NO.
S7
7 of 7

STRUCTURAL ENGINEERS
License No. C-3870
318 W Millbrook Road, Unit 201
Raleigh, North Carolina 27609
Phone: (919) 844-1661

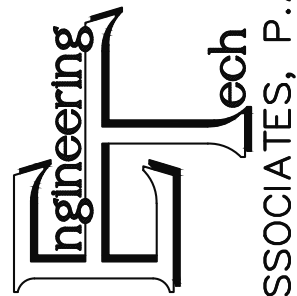

ASSOCIATES, P.A.