

\\C:\Content\3DSOUTHEAST\RALEIGH\STY6-0442-00\cansales\STY6-0442-00.rvt




https://autode.sk/3Gj34oG DISCLAIMER: 3D MODEL PROVIDED FOR VISUAL REFERENCE ONLY. IF THERE ARE DISCREPANCIES, REFER TO JOB PDF.

Architecture Plan Review: ☐ No Comments ☒ See Comments Items drawn on any drawings and not written in the contract selctions **WILL NOT** be included in the site specific drawings.

Customer Request:	Design Solution:	Reason For Modification:	Comments:
1. GAS LINE TO EXTERIOR	1. PROVIDED LOCATION	1. XXX	1. XXX
2. XXX	2. XXX	2. XXX	2. XXX
3. XXX	3. XXX	3. XXX	3. XXX
4. XXX	4. XXX	4. XXX	4. XXX

Square Footage		Division: Raleigh	
		Building Code: 2018 NC Building Code - Residential	
Living Areas		Index to the Drawings	
FIRST FLOOR	2273 SF	Sheet No.	Sheet Name
SECOND FLOOR	724 SF	0C.1	Cover Sheet
	2997 SF	0N.1	General Notes
		0P.1	Plot Plan
		1.01S	Foundation Plan
		2.01F	First Floor Framing Plan
		2.01S	First Floor Structural Plan
		2.02F	Second Floor Framing Plan
		2.02S	Second Floor Structural Plan
		2.04	Roof Plan
		3.02	Second Floor Subfloor Plan
		4.01	First Floor Mechanical Plan
		4.02	Second Floor Mechanical Plan
		5.01	Building Section
		6.01	Front Elevation
		6.02	Garage Side Elevation
		6.03	Rear Elevation
		6.04	Side Elevation
		7.01	House Specific Details
		7.02	House Specific Details
		SD-0-RAL	Structural Notes
		SD-1	Structural Notes
Redraws			
Plan Review: 7/22/2025			
-CHANGED PRIMARY SHOWER TO ZERO ENTRY/ADDED BENCH SEAT -ADDED FULL WALL AT ODL -REMOVED 9080 SGD, ADDED (2)3060 AND (1)5060 WINDOW -ADDED STANDARD SGD TO DINING AREA (REMOVED WINDOWS)			
Plan Review: XX/XX/XX			
Xxxxx			
		Space for Architect Seal	
		 The Drees Company 08/12/2025 1:10:16 PM	
		RESIDENCE FOR: KRAKAUER TBD SERENITY PHASE 6B	
Job Number:	Drawing Date:	Coord Name:	Coord Phone:
STY6-0442-00	6/12/2025	GREG P.	859-578-4355
House Name:		Drawing Scale: 1/8" = 1'0"	
		Contract Drawn By:	
		EWI	
		Series:	
		EXECUTIVE	
		Plan No.:	
Born on Date:		CDs Drawn By:	
07/11/23		CLM	
		Sheet Information	0C.1 Cover Sheet Elevation "E"
8521 Six Forks Road, Suite 500, Raleigh, NC 27615 Phone: (919) 844-9288			

7/22/2025 6:05:40 PM

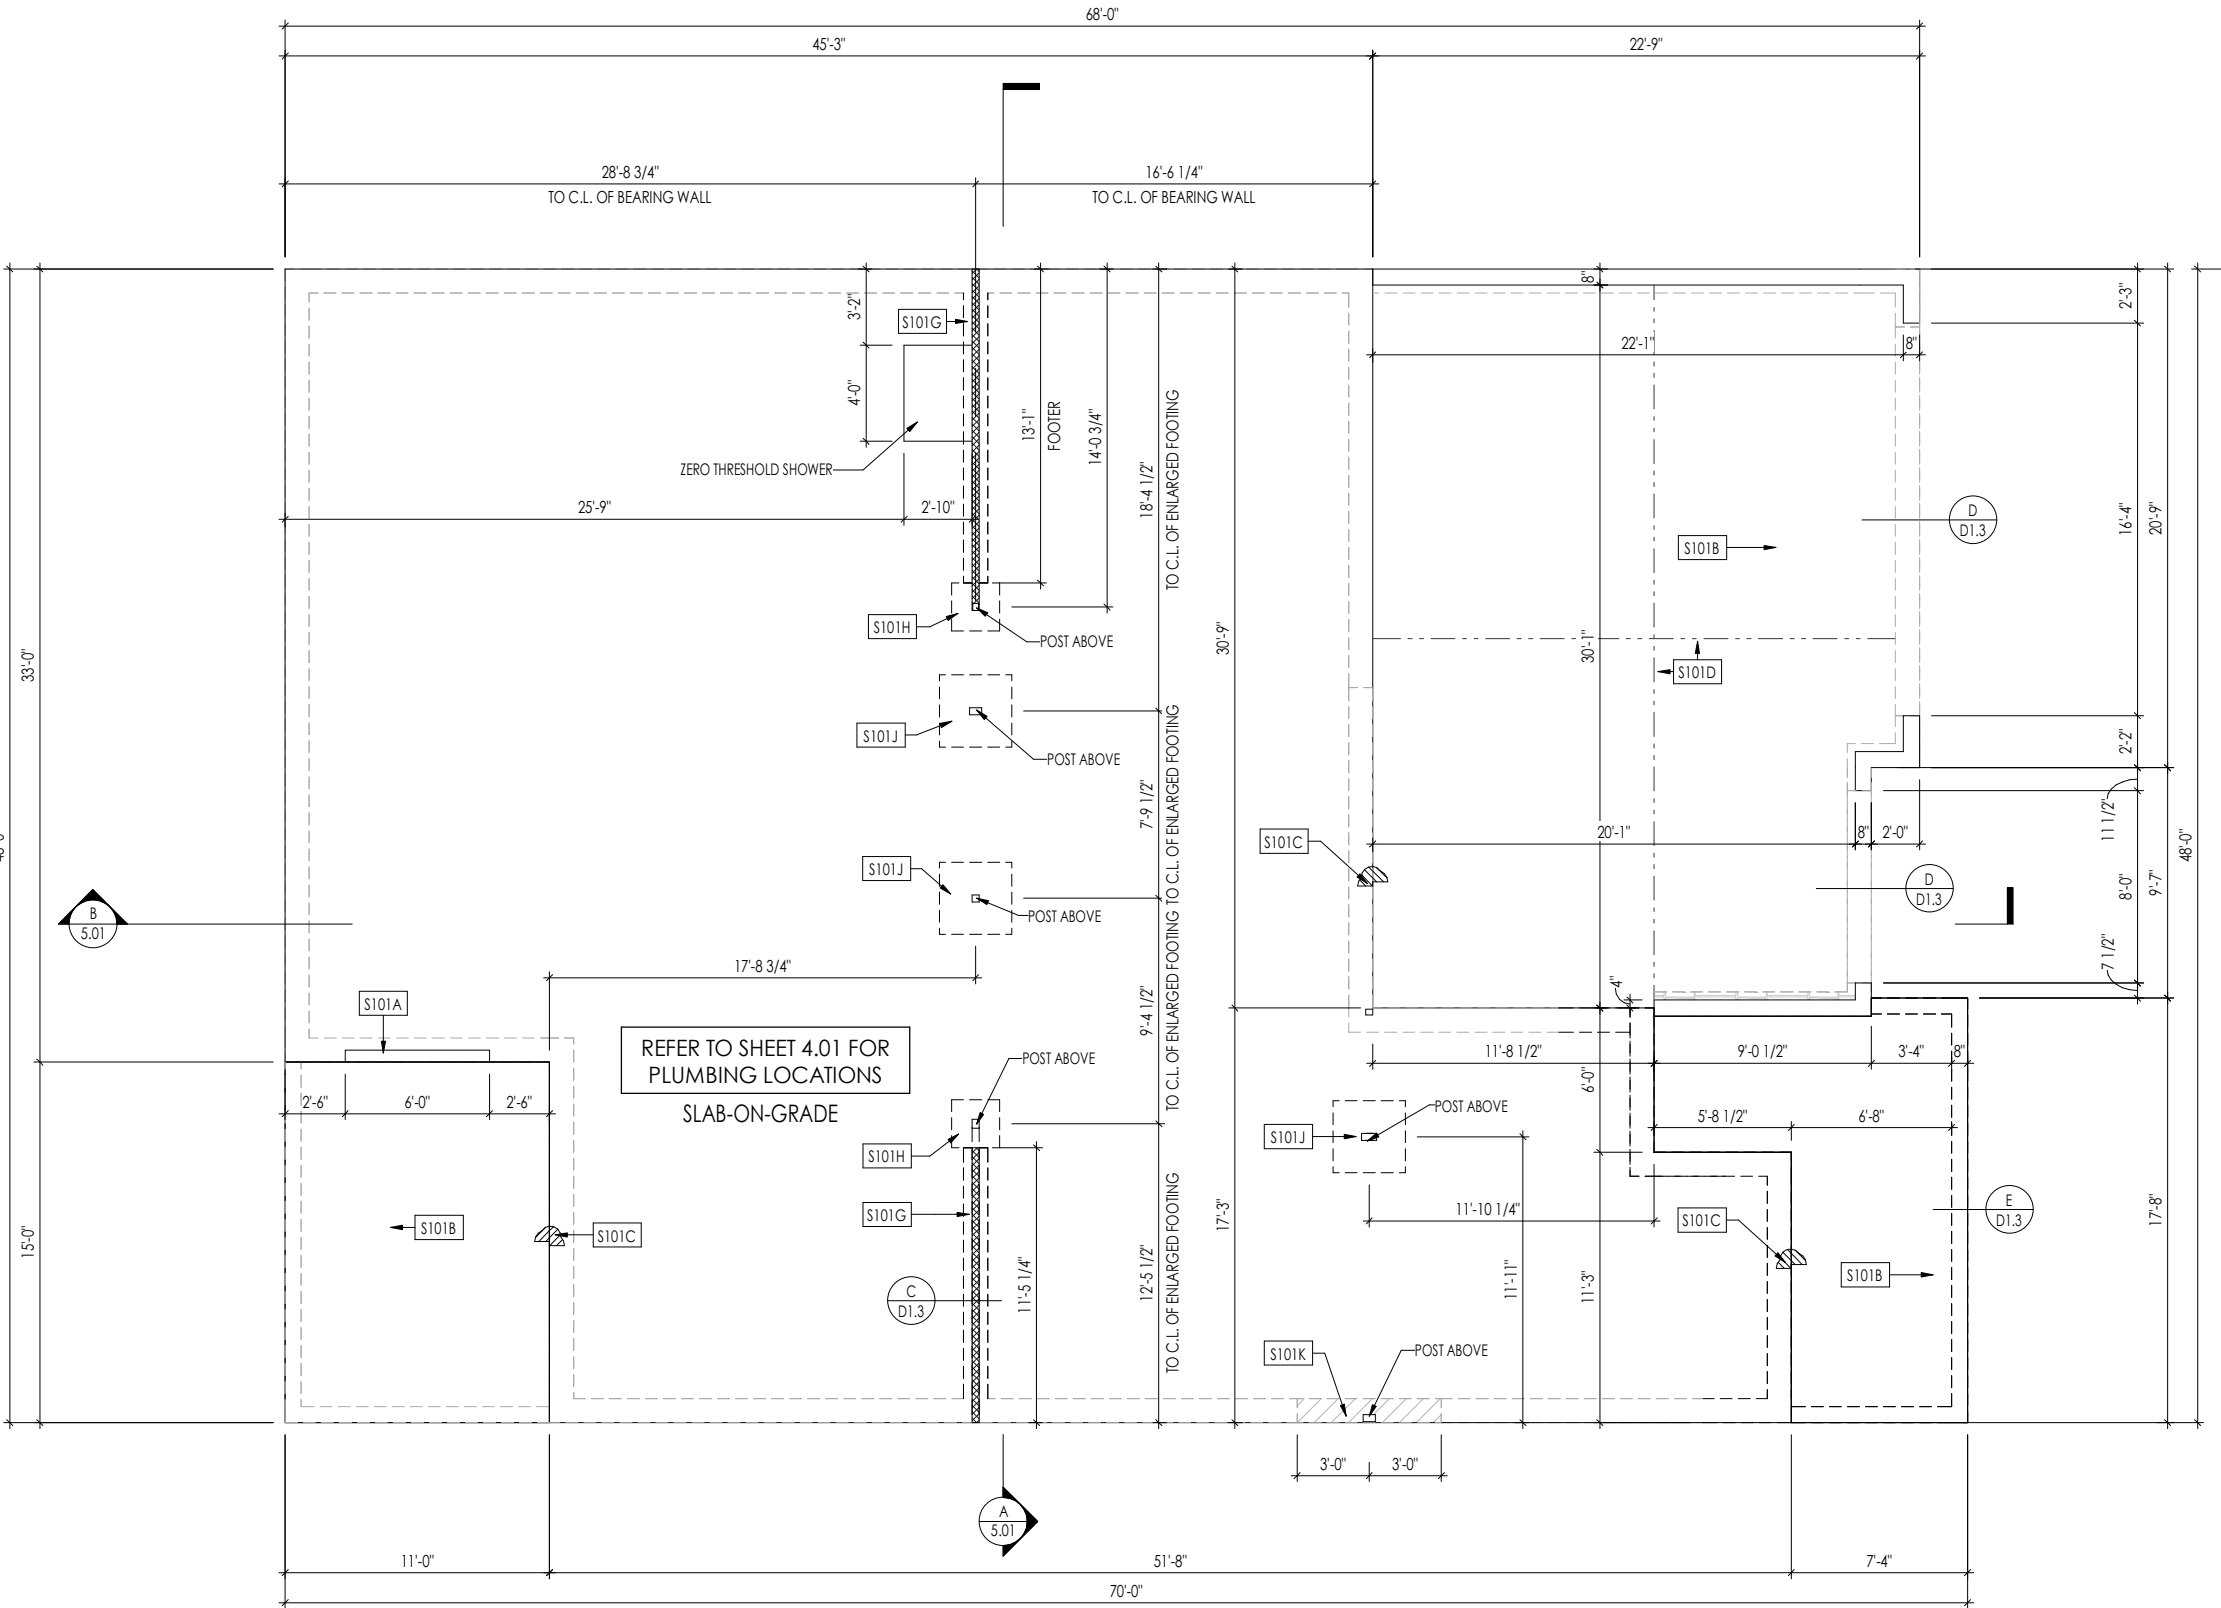

General Notes:	
1. REFER TO SHEET 0N.1 FOR GENERAL NOTES.	
2. REFER TO SHEET S-0 FOR STRUCTURAL DETAILS AND INFORMATION	
Key Notes:	
S101A	3/4" WEATHER LIP (1-1/2" @ SLIDING GLASS DOOR)
S101B	SLOPE SLAB 1/8" PER FOOT
S101C	DROP SLAB 3-1/2"
S101D	SLAB CONTROL JOINT
S101G	8"x16" THICKENED PLAIN CONCRETE FOOTING UNDER BEARING WALL ABOVE
S101H	24"x24"x12" PLAIN CONCRETE FOOTING UNDER POST ABOVE
S101J	36"x36"x12" PLAIN CONCRETE FOOTING UNDER POST ABOVE
S101K	36" DEEPENED CONCRETE FOOTING CENTERED UNDER POST ABOVE

Space for Architect Seal

The Drees Company
08/12/2025 1:10:16 PM


RESIDENCE FOR:
KRAKAUER
TBD
SERENITY PHASE 6B

Job Number: STY6-0442-00	Drawing Date: 6/12/2025	Coord Name: GREG P.	Coord Phone: 859-578-4355
House Name: the PARKETTE			Contract Drawn By: EWI
Born on Date: 07/11/23			CDs Drawn By: CLM

Copyright © 2023 (2023) The Drees Company. All Rights Reserved.
8521 Six Forks Road, Suite 500, Raleigh, NC. 27615
Phone: (919) 844-9288

Sheet Information

1.01S
Foundation Plan
Elevation "E"

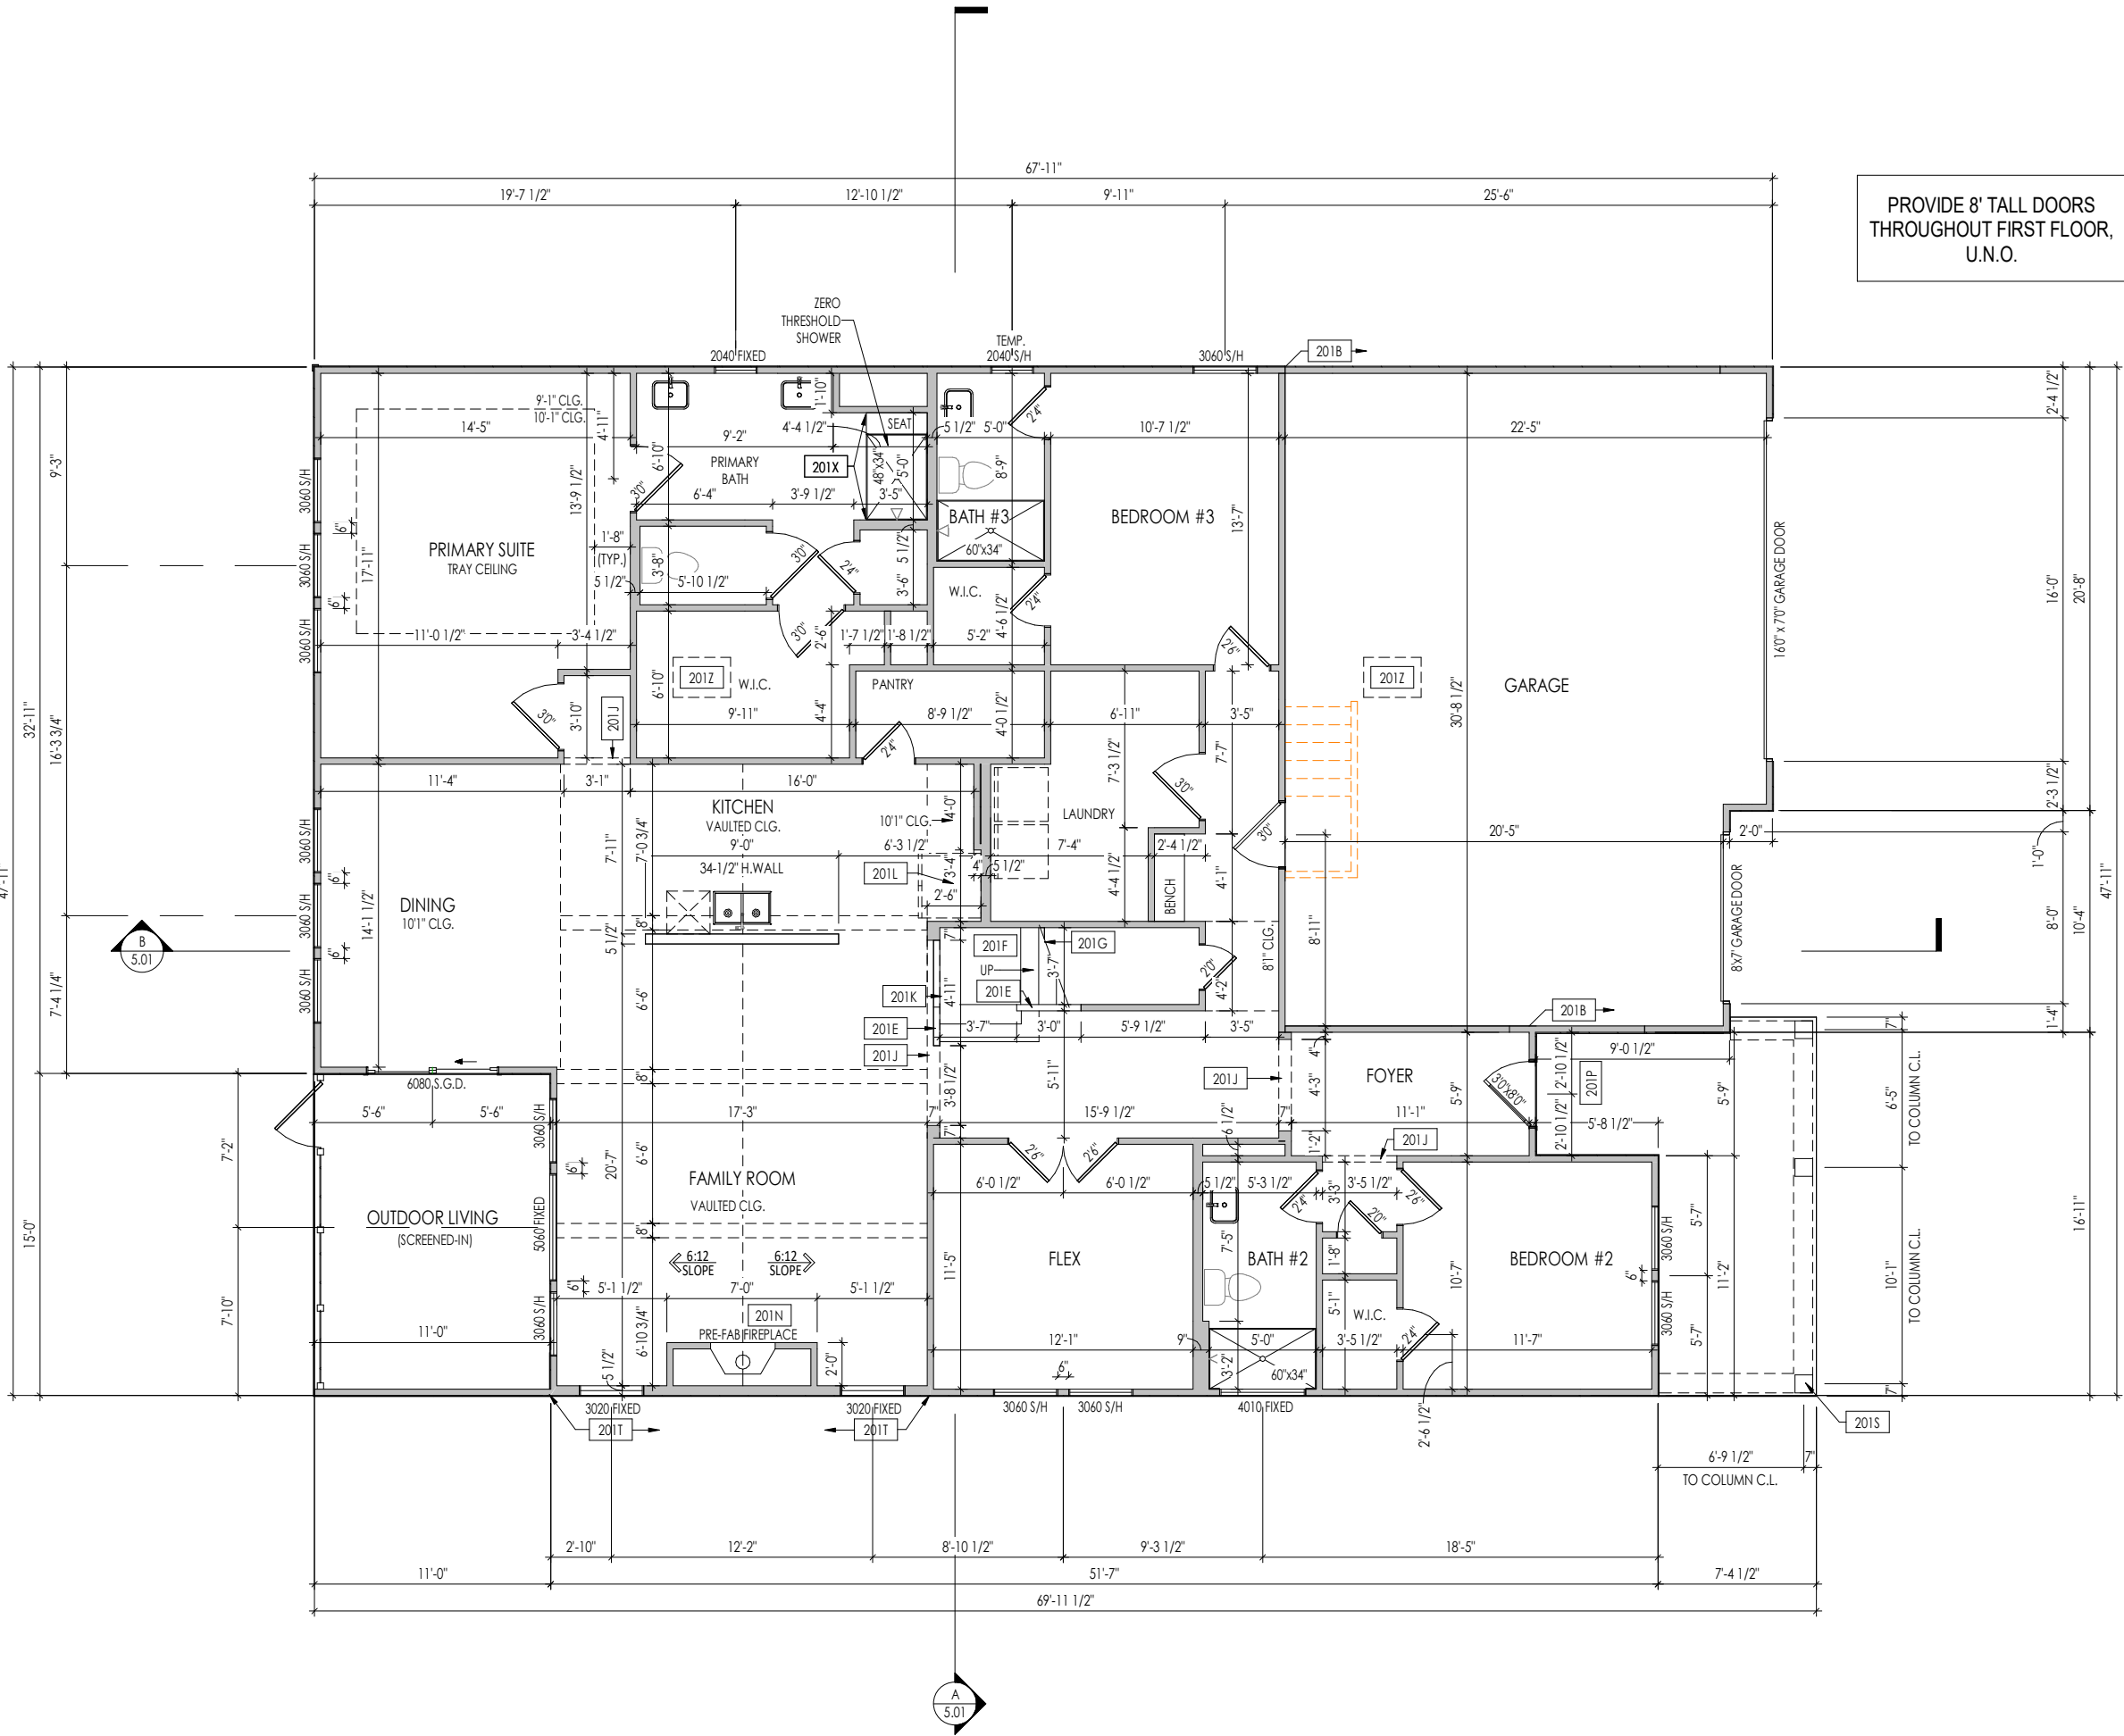

- General Notes:
1. REFER TO SHEET 0N.1 FOR GENERAL NOTES.
 2. ALL FIRST FLOOR CEILINGS TO BE 10'-1" ABOVE SUBFLOOR UNLESS OTHERWISE NOTED.
 3. FRAME TOP OF ALL WINDOWS AT 1'-10" BELOW TOP OF PLATE UNLESS OTHERWISE NOTED.
 4. ALL DROPPED, INTERIOR HEADERS (FALSE AND BEARING) ARE DROPPED 1'-3" FROM CEILING.
 5. REFER TO SELECTION SHEETS FOR FLOORING MATERIAL PRIOR TO CONSTRUCTING STAIRS TO DETERMINE RISER HEIGHTS.
 6. REFER TO SHEET 2.01S FOR STRUCTURAL INFORMATION.
 7. REFER TO SHEET S-0 FOR STRUCTURAL DETAILS AND INFORMATION

- Key Notes:
- | | |
|------|--|
| 201B | FRAME GARAGE WALL FULL HEIGHT STUDS AT 11'-5 1/4" WITH 2x4 STUDS AT 16" O.C. FROM TOP OF FOUNDATION WALL; IF ELECTRICAL PANEL LOCATED IN GARAGE, PAD OUT WALL FOR ELECTRICAL PANEL |
| 201E | SLOPE WALL EVEN WITH TOP OF STAIR STRINGER, RAILING ABOVE |
| 201F | SEE DETAIL C/7.02 FOR STAIR FRAMING DETAILS |
| 201G | APPROX. LOCATION OF 36" HIGH WALL UNDER STAIRS (FIELD VERIFY) |
| 201J | FRAME TOP OF OPENING AT HEIGHT SPECIFIED IN GENERAL NOTES ON THIS SHEET |
| 201K | 50" HIGH WALL |
| 201L | FRAME TOP OF OPENING AT REFRIGERATOR AT 6'-1 1/2" A.F.F. |
| 201N | PRE-FABRICATED FIREPLACE INSERT |
| 201P | CARPENTER TO DROP ELECTRICAL WIRE THROUGH PORCH CEILING FOR LIGHTS |
| 201S | COLUMN - SEE DETAIL B/7.01 |
| 201T | BALLOON FRAME WALL TO UNDERSIDE OF SCISSOR TRUSSES |
| 201X | PROVIDE BLOCKING FOR SHOWER DOOR/ENCLOSURE |
| 201Z | 22'-1/2" x 32" ATTIC ACCESS |



The Drees Company
08/12/2025 1:10:16 PM

RESIDENCE FOR:
KRAKAUER
TBD
SERENITY PHASE 6B


Job Number: STY6-0442-00	Drawing Date: 6/12/2025	Coord Name: GREG P.	Coord Phone: 859-578-4355
House Name:		Drawing Scale: 1/8" = 1'-0"	
the PARKETTE			Contract Drawn By: EWI
			Series: EXECUTIVE
			Plan No.:
Born on Date:	07/11/23	CDs Drawn By:	CLM

Copyright © 2023 (2023) The Drees Company. All Rights Reserved.
8521 Six Forks Road, Suite 500, Raleigh, NC. 27615
Phone: (919) 844-9288

Sheet Information

2.01F
First Floor Framing Plan
Elevation "E"

I:\Clients\SOUTHEASTRAL\EGH\STY6-0442-00_cancelled\STY6-0442-00.rvt

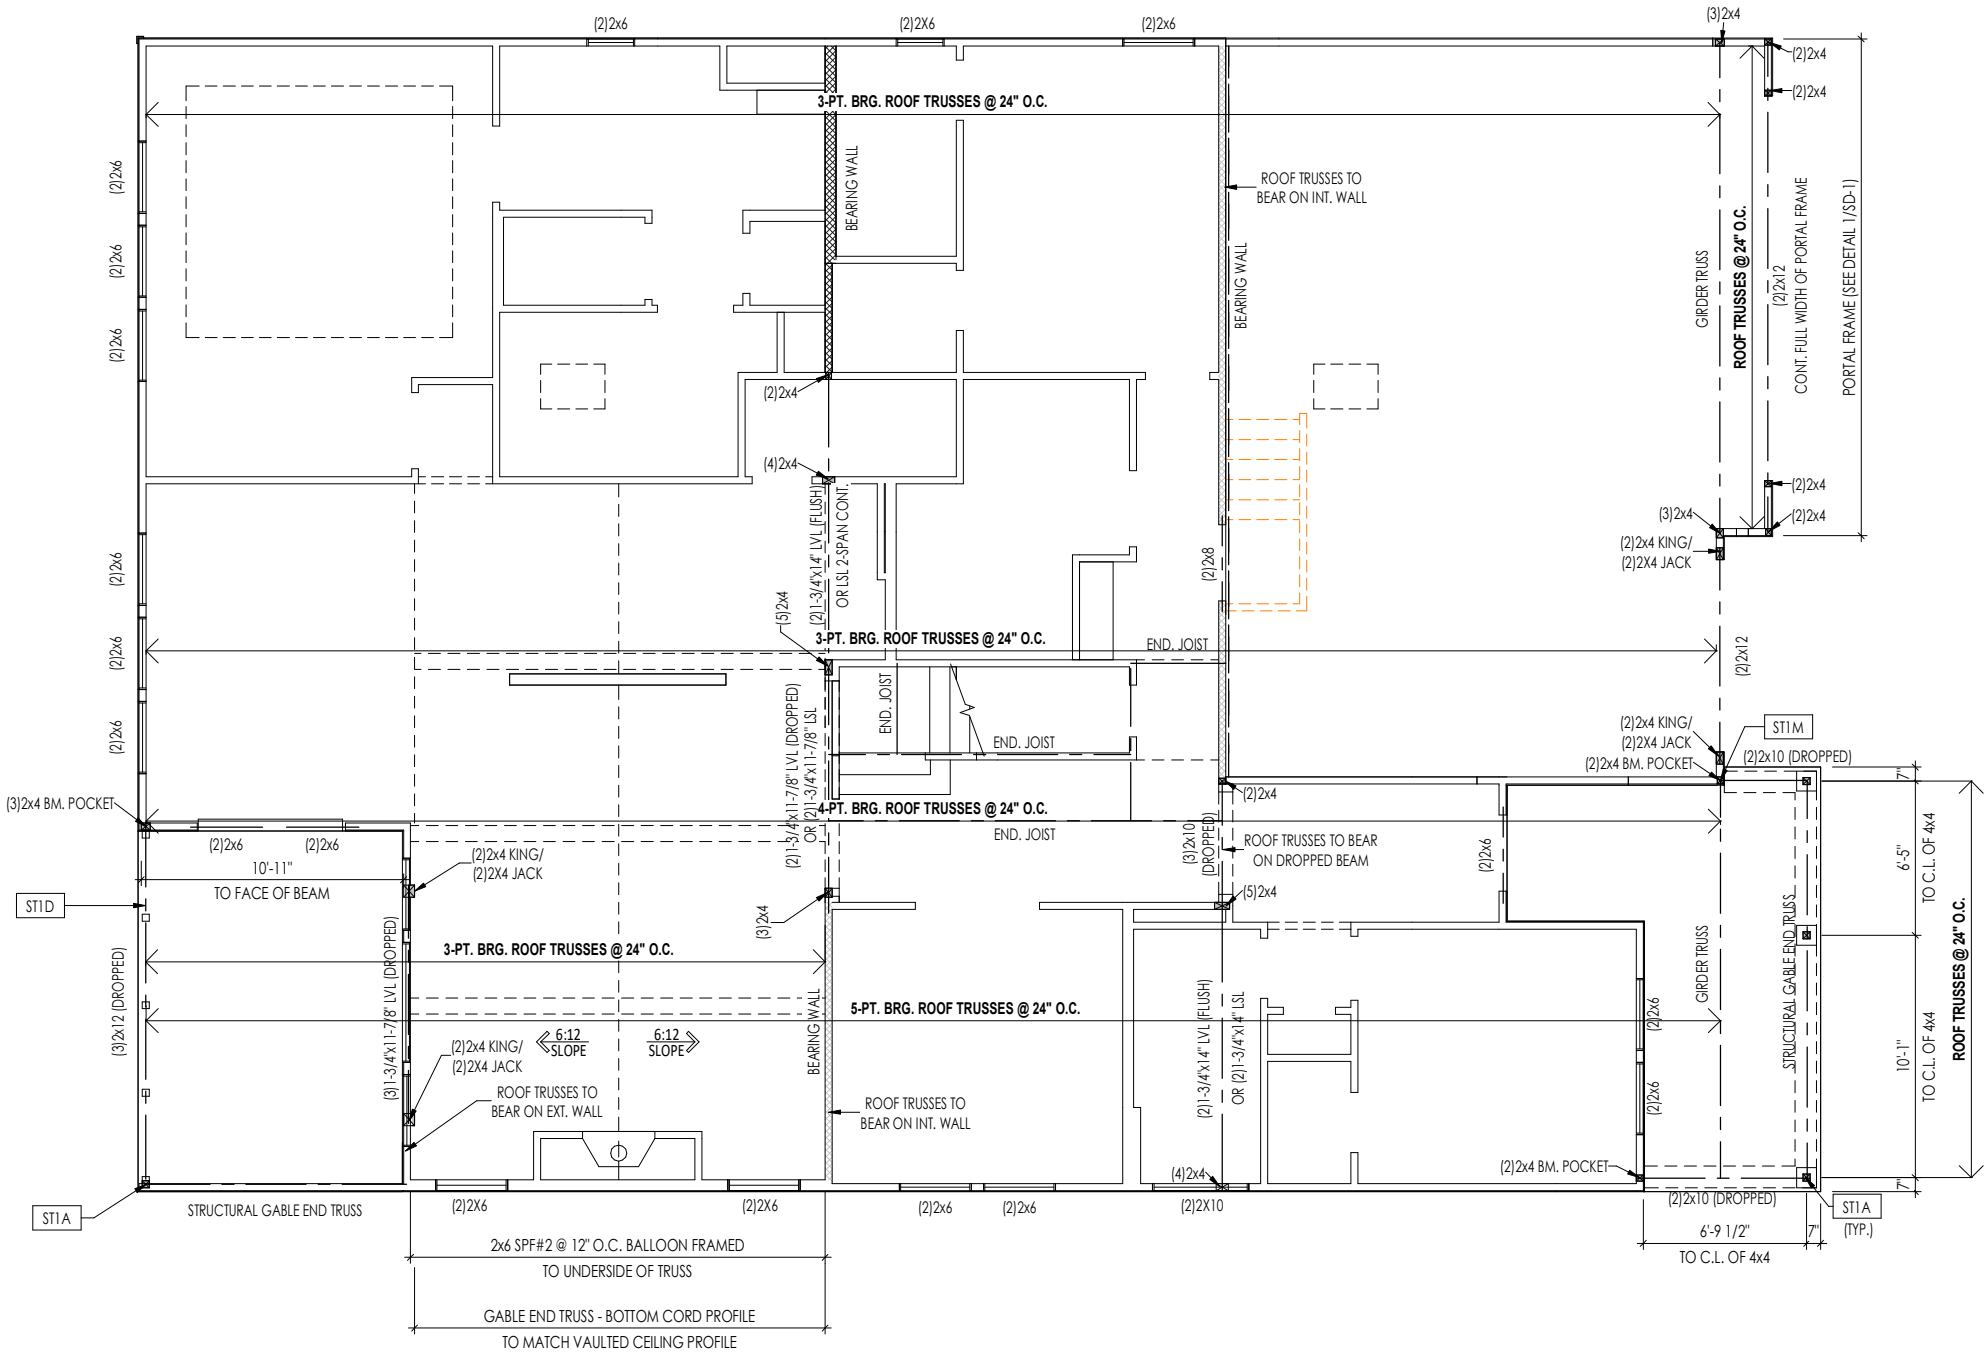

General Notes:

1. REFER TO SHEET ON.1 FOR GENERAL NOTES.
2. REFER TO SHEET S-0 FOR STRUCTURAL DETAILS AND INFORMATION

Key Notes:

ST1A	4x4 P.T. POST W/ SIMPSON BCS2-2/4 CAP & ABW44Z BASE
ST1D	FRAME TOP OF BEAM AT 10'-1\"
ST1M	HANG DROPPED BEAM TO POST w/ SIMPSON HUC210-2 HANGER

Space for Architect Seal



The Drees Company
08/12/2025 1:10:16 PM

RESIDENCE FOR:

KRAKAUER

TBD

SERENITY PHASE 6B

Job Number: STY6-0442-00	Drawing Date: 6/12/2025	Coord Name: GREG P.	Coord Phone: 859-578-4355
------------------------------------	-----------------------------------	-------------------------------	-------------------------------------

House Name:	Drawing Scale: 1/8" = 1'0"	Contract Drawn By: EWT
-------------	----------------------------	----------------------------------

the PARKETTE

Series:
EXECUTIVE

Born on Date:	07/11/23	CDs Drawn By:	CLM
---------------	----------	---------------	-----


Drees
HOMESSM

Copyright © 2023 (2023) The Drees Company. All Rights Reserved.
8521 Six Forks Road, Suite 500, Raleigh, NC. 27615
Phone: (919) 844-9288

Sheet Information

2.01S
First Floor Structural Plan
Elevation "E"

7/22/2025 5:05:42 PM

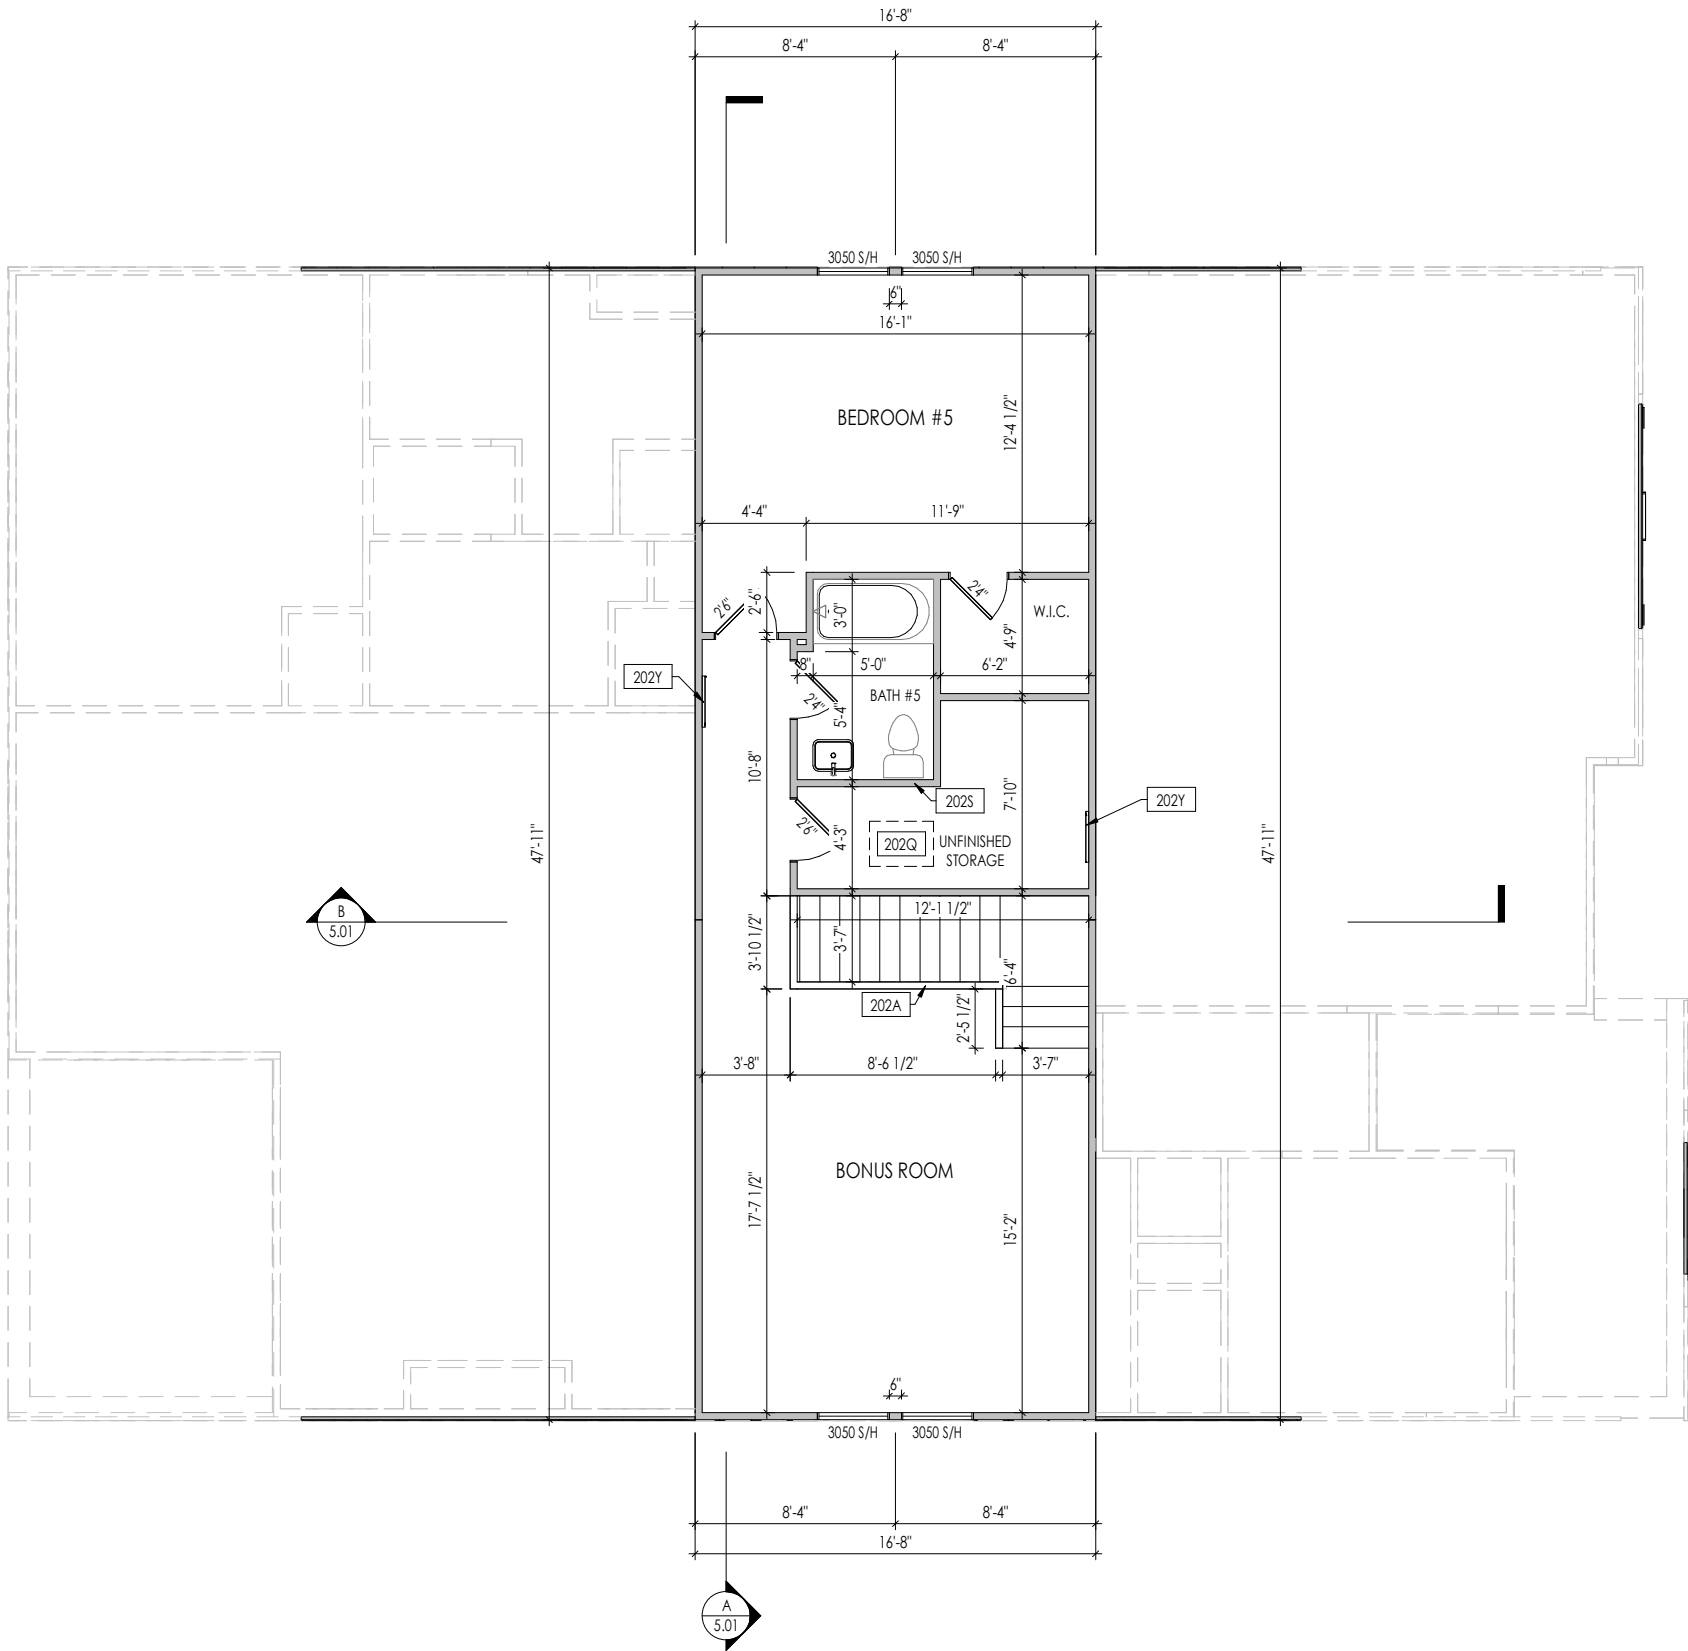

General Notes:	
1. REFER TO SHEET 0N.1 FOR GENERAL NOTES. 2. ALL SECOND FLOOR CEILINGS TO BE 9'-1" ABOVE SUBFLOOR UNLESS OTHERWISE NOTED. 3. FRAME TOP OF ALL WINDOWS AT 1'-0-1/4" BELOW TOP OF PLATE UNLESS OTHERWISE NOTED. 4. ALL DROPPED, INTERIOR HEADERS (FALSE AND BEARING) ARE DROPPED 1'-0" FROM CEILING. 5. REFER TO SELECTION SHEETS FOR FLOORING MATERIAL PRIOR TO CONSTRUCTING STAIRS TO DETERMINE RISER HEIGHTS. 6. REFER TO SHEET 2.02S FOR STRUCTURAL INFORMATION.	
Key Notes:	
202A	36" HIGH WALL
202Q	22-1/2" x 32" ATTIC ACCESS
202S	DO NOT LOCATE TRUSS ABOVE PLUMBING WALL
202Y	ATTIC ACCESS PANEL

Space for Architect Seal

The Drees Company
08/12/2025 1:10:16 PM

RESIDENCE FOR:
KRAKAUER
TBD
SERENITY PHASE 6B

Job Number: STY6-0442-00	Drawing Date: 6/12/2025	Coord Name: GREG P.	Coord Phone: 859-578-4355
House Name:		Drawing Scale: 1/8" = 1'0"	
the PARKETTE		Contract Drawn By: EWI	
		Series: EXECUTIVE	
Born on Date: 07/11/23		CDs Drawn By: CLM	

Copyright © 2023 (2023) The Drees Company. All Rights Reserved.
8521 Six Forks Road, Suite 500, Raleigh, NC. 27615
Phone: (919) 844-9288

Sheet Information

2.02F
Second Floor Framing Plan
Elevation "E"



General Notes:

- 1. REFER TO SHEET ON.1 FOR GENERAL NOTES.
- 2. REFER TO SHEET S-0 FOR STRUCTURAL DETAILS AND INFORMATION

Key Notes:

Space for Architect Seal



The Drees Company
08/12/2025 1:10:16 PM

RESIDENCE FOR:

KRAKAUER

TBD

SERENITY PHASE 6B

Job Number:	Drawing Date:	Coord Name:	Coord Phone:
STY6-0442-00	6/12/2025	GREG P.	859-578-4355

House Name:	Drawing Scale: 1/8" = 1'0"	Contract Drawn By:
		EWT

the PARKETTE

Born on Date:	07/11/23	CDs Drawn By:	CLM
Series:		EXECUTIVE	

Copyright © 2023 (2023) The Drees Company. All Rights Reserved.
8521 Six Forks Road, Suite 500, Raleigh, NC 27615
Phone: [919] 844-9288


Sheet Information

2.02S
Second Floor Structural Plan
Elevation "E"

HEEL CUT STANDARDS			
	OVERHANG		
	1'-0"	2'-0"	
ROOF PITCH	4:12	3-3/4"	7-3/4"
	5:12	4-3/4"	9-3/4"
	6:12	5-3/4"	11-3/4"
	7:12	6-3/4"	13-3/4"
	8:12	7-3/4"	N/A
	9:12	8-3/4"	N/A
	10:12	9-3/4"	N/A
	12:12	11-3/4"	N/A
	14:12	13-3/4"	N/A


ROOF VENTILATION	
CITY/SERIES:	RALEIGH
MAIN HOUSE	
TOTAL ATTIC AREA:	3,505
REQUIRED NET FREE VENTILATION (ATTIC AREA/300):	11.68
ACTUAL NET FREE VENTILATION (UPPER + LOWER):	12.26
DOWNSPOUT CALCULATION	
MAIN HOUSE	
TOTAL DRAINABLE ROOF AREA:	4556.5
MINIMUM # OF DOWNSPOUTS:	8

General Notes:	
1. REFER TO SHEET ON.1 FOR GENERAL NOTES. 2. REFER TO SHEET S-0 FOR STRUCTURAL DETAILS AND INFORMATION	
Key Notes:	
204A	VALLEY TRUSS OVER-FRAMING @ 24" O.C.
204B	NO ROOF DECKING UNDER OVER-FRAMING IN THIS AREA TO ALLOW FOR PROPER ATTIC VENTILATION

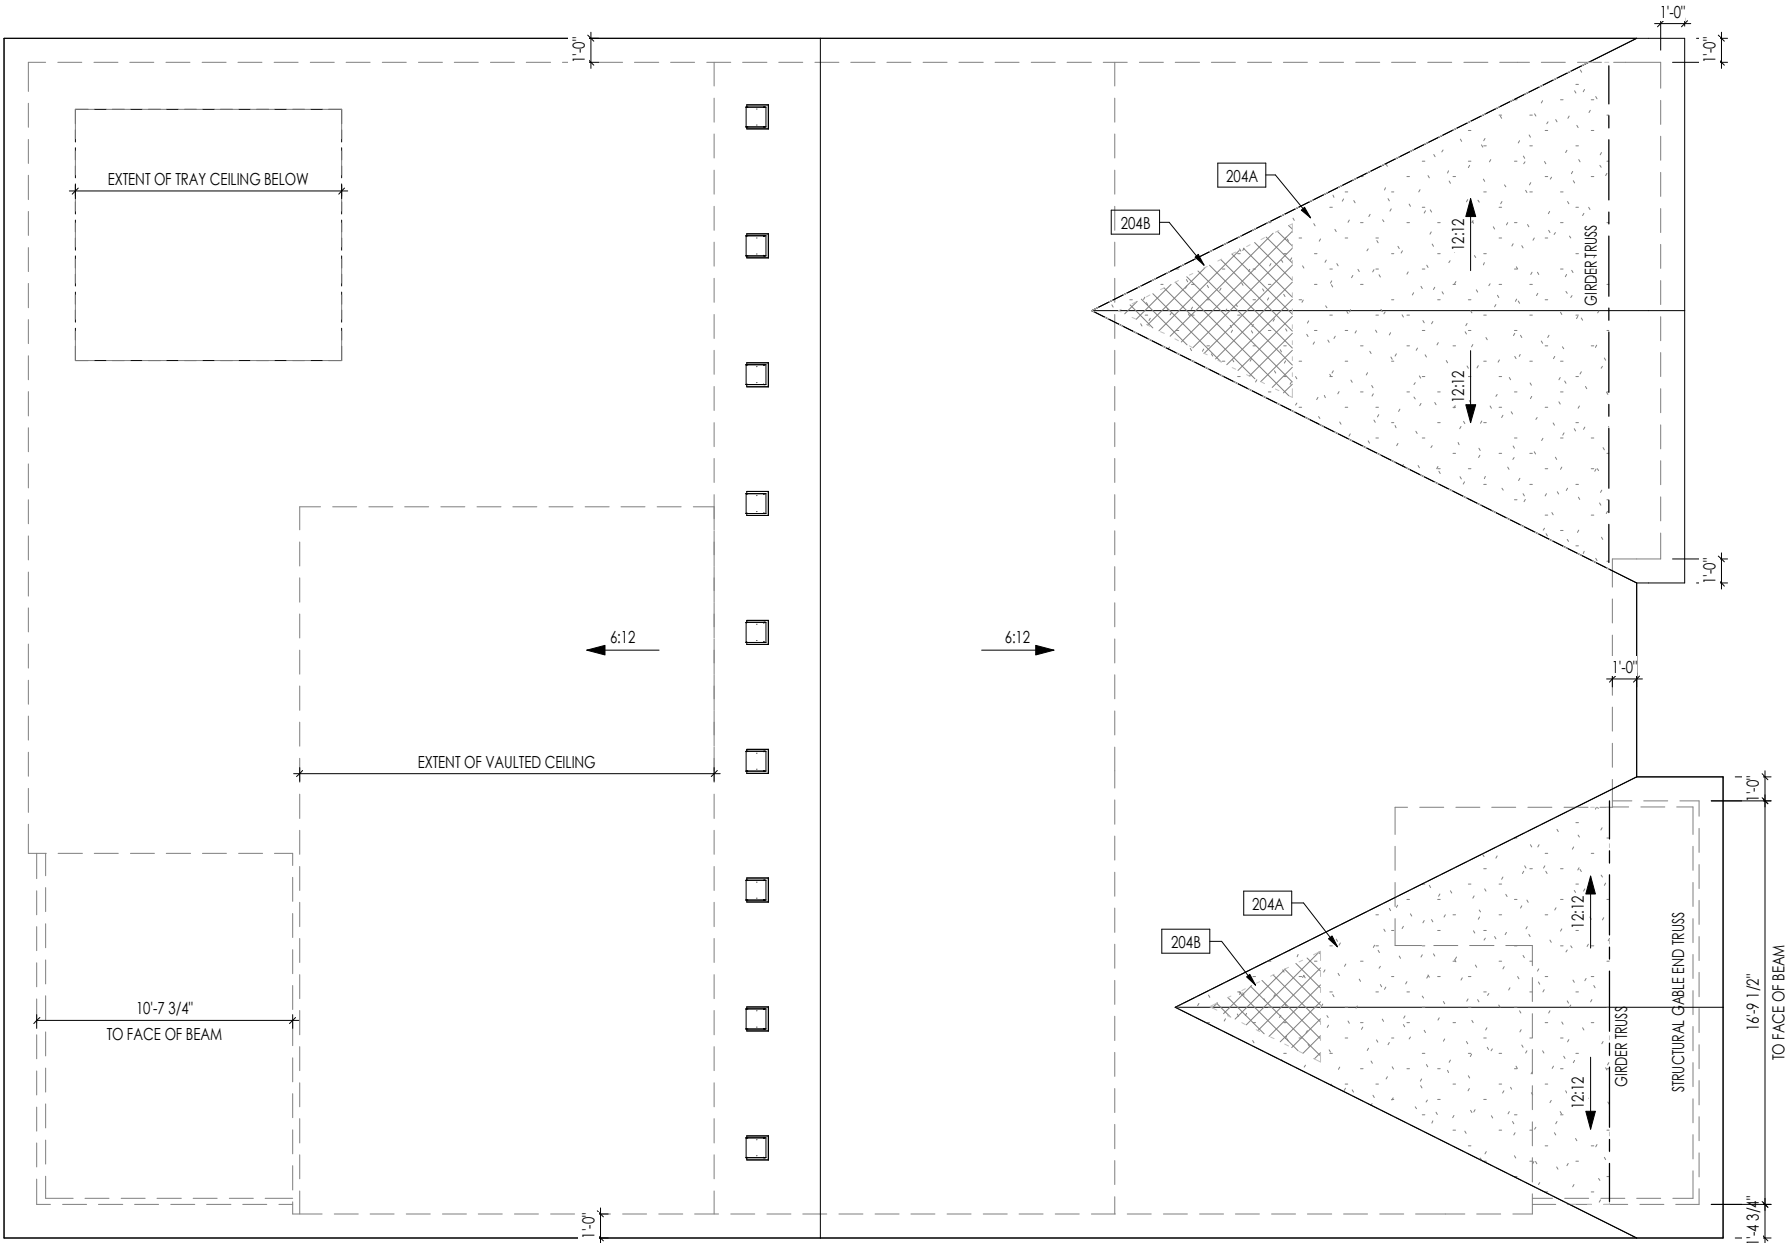



The Drees Company
08/12/2025 1:10:16 PM

RESIDENCE FOR: KRAKAUER TBD SERENITY PHASE 6B			
Job Number: STY6-0442-00	Drawing Date: 6/12/2025	Coord Name: GREG P.	Coord Phone: 859-578-4355
House Name:		Drawing Scale: 1/8" = 1'0"	Contract Drawn By: EWT
the PARKETTE			Series: EXECUTIVE
Born on Date: 07/11/23		CDs Drawn By: CLM	Plan No.:
 Copyright © 2023 (2023) The Drees Company. All Rights Reserved. 8521 Six Forks Road, Suite 500, Raleigh, NC 27615 Phone: [919] 844-9288		Sheet Information	2.04 Roof Plan Elevation "E"

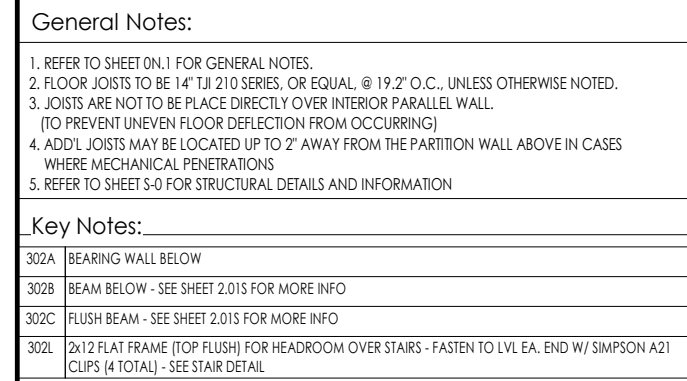


Drees HOMESSM Copyright © 2023 2023 The Drees Company. All Rights Reserved. 8521 Six Forks Road, Suite 500, Raleigh, NC 27615 Phone: (919) 844-9288	Sheet Information	3.02 Second Floor Subfloor Plan Elevation "E"
---	--------------------------	---

I:\Cortado\SouthEastRA\EGH\STY6\6442-00_cancel\STY6-0442-00.rvt

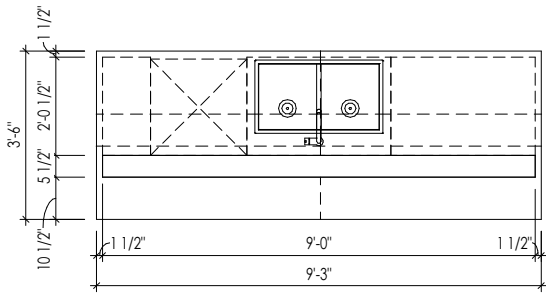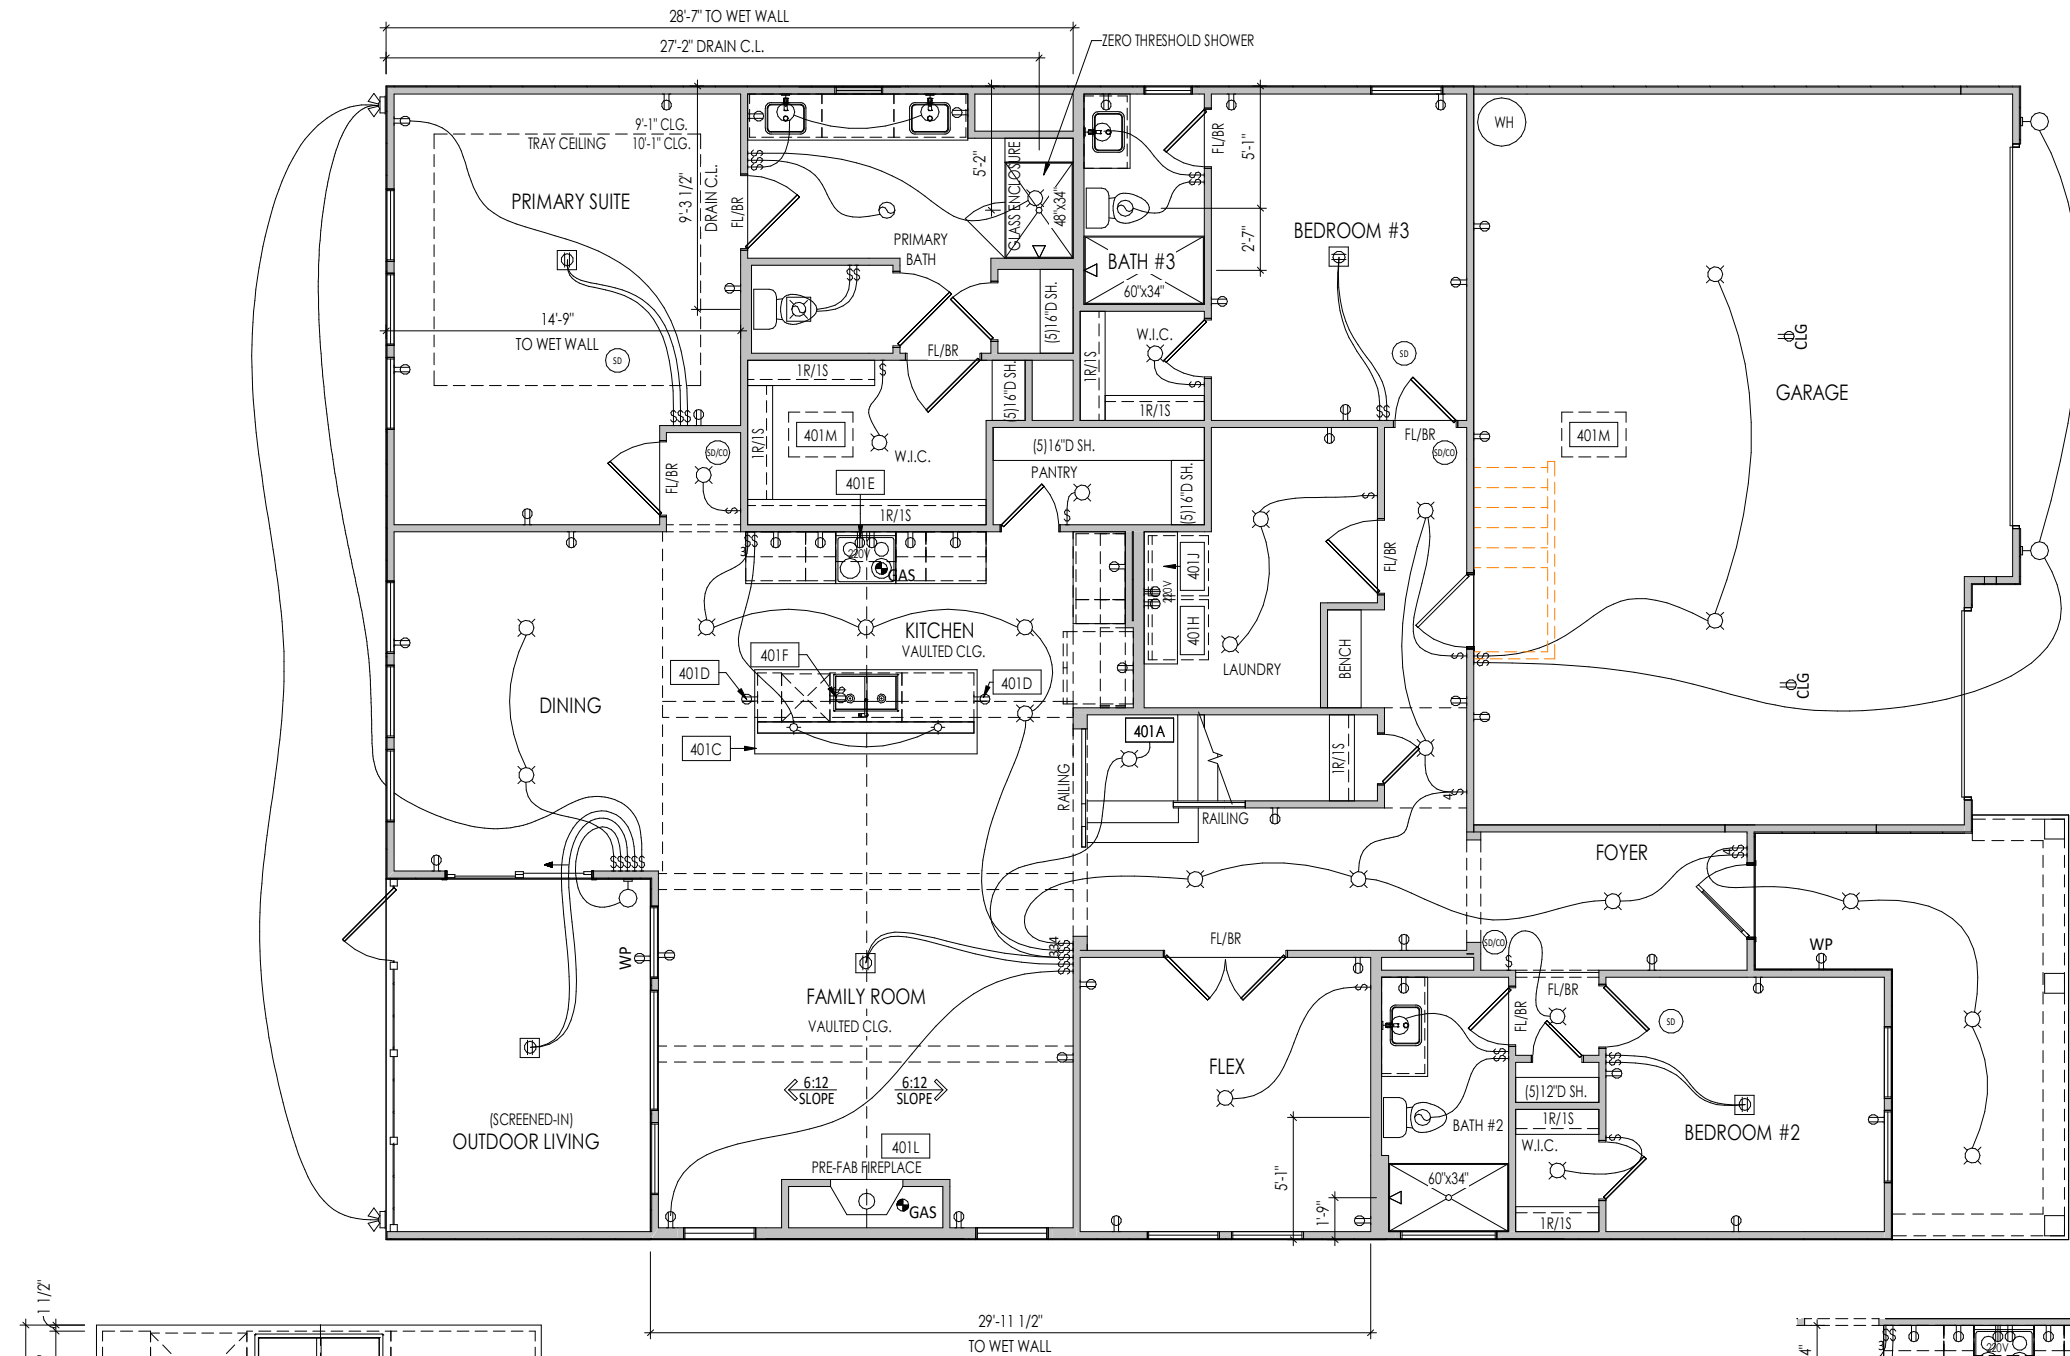

A
4.01
KITCHEN ISLAND DETAIL
1/4" = 1'-0"

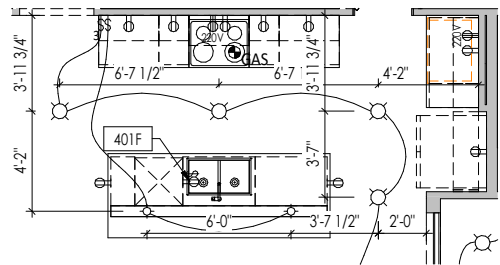

B
4.01
KITCHEN LIGHTING DETAIL
1/8" = 1'-0"

General Notes:

1. REFER TO SHEET ON.1 FOR GENERAL NOTES.

Key Notes:

401A	TO SWITCH OR LIGHT ABOVE
401C	SEE DETAIL A/4.01 FOR KITCHEN ISLAND COUNTERTOP DIMENSIONS
401D	HOLD OUTLET HIGH ON ISLAND
401E	OUTLET FOR RANGE HOOD/MICROWAVE HELD HIGH - VENT TO EXTERIOR
401F	OUTLET FOR DISHWASHER LOCATED IN SINK CABINET
401H	LOCATE WASHER TO LEFT OF DRYER
401J	UPPER WALL CABINETS OR 16" DEEP x 5'-6" LONG SHELF HELD AT 5'-7" A.F.F. - REFER TO SELECTIONS
401L	PRE-FABRICATED FIREPLACE INSERT
401M	22-1/2" x 32" ATTIC ACCESS PANEL IN CEILING

MECHANICAL LEGEND

⊖ WALL OUTLET	⊖ CLG. MOUNTED LIGHT FIXT.	⊕ HOSE BIB
⊖ WEATHERPROOF GFCI OUTLET	⊖ SURFACE MOUNT DISC LIGHT OR RECESSED CEILING LIGHT, PER SPECS.	⊖ SHOWER HEAD
⊖ 220 VOLT OUTLET	⊖ WALL MOUNTED LIGHT FIXT.	⊖ GAS GAS HOOK UP
⊖ GFCI OUTLET	⊖ DOUBLE SPOTLIGHT FIXT.	⊖ FLOOR DRAIN
⊖ FLOOR OUTLET	⊖ DIRECTIONAL CAN LIGHT	⊖ SMOKE DETECTOR
⊖ COUNTER POP-UP OUTLET	⊖ PIN LIGHT	⊖ SMOKE DETECTOR/CO DETECTOR COMBINATION
⊖ SINGLE POLE SWITCH	⊖ WALL SCONCE @ 5'-6" A.F.F.	⊖ EXHAUST FAN AND LIGHT COMBINATION
⊖ 3-WAY SWITCH	⊖ FLUORESCENT LIGHT	⊖ CLG. MTD. EXHAUST FAN
⊖ 4-WAY SWITCH	⊖ UNDER CABINET LIGHTING	⊖ DATA JACK
⊖ STAIR LIGHT		⊖ CABLE TELEVISION JACK
⊖ BLOCK, MOUNT, & SWITCH FOR FUTURE FAN/LIGHT COMBINATION (CENTER, UNLESS OTHERWISE NOTED)		

Space for Architect Seal



The Drees Company
08/12/2025 1:10:16 PM

RESIDENCE FOR:

KRAKAUER

TBD

SERENITY PHASE 6B

Job Number: STY6-0442-00	Drawing Date: 6/12/2025	Coord Name: GREG P.	Coord Phone: 859-578-4355
------------------------------------	-----------------------------------	-------------------------------	-------------------------------------

House Name:	Drawing Scale: 1/8" = 1'-0"	Contract Drawn By: EWT
-------------	-----------------------------	----------------------------------

the PARKETTE

Born on Date:	07/11/23	CDs Drawn By:	CLM	Series: EXECUTIVE
---------------	----------	---------------	-----	-----------------------------




Sheet Information

4.01

First Floor Mechanical Plan
Elevation "E"

7/22/2025 5:05:43 PM

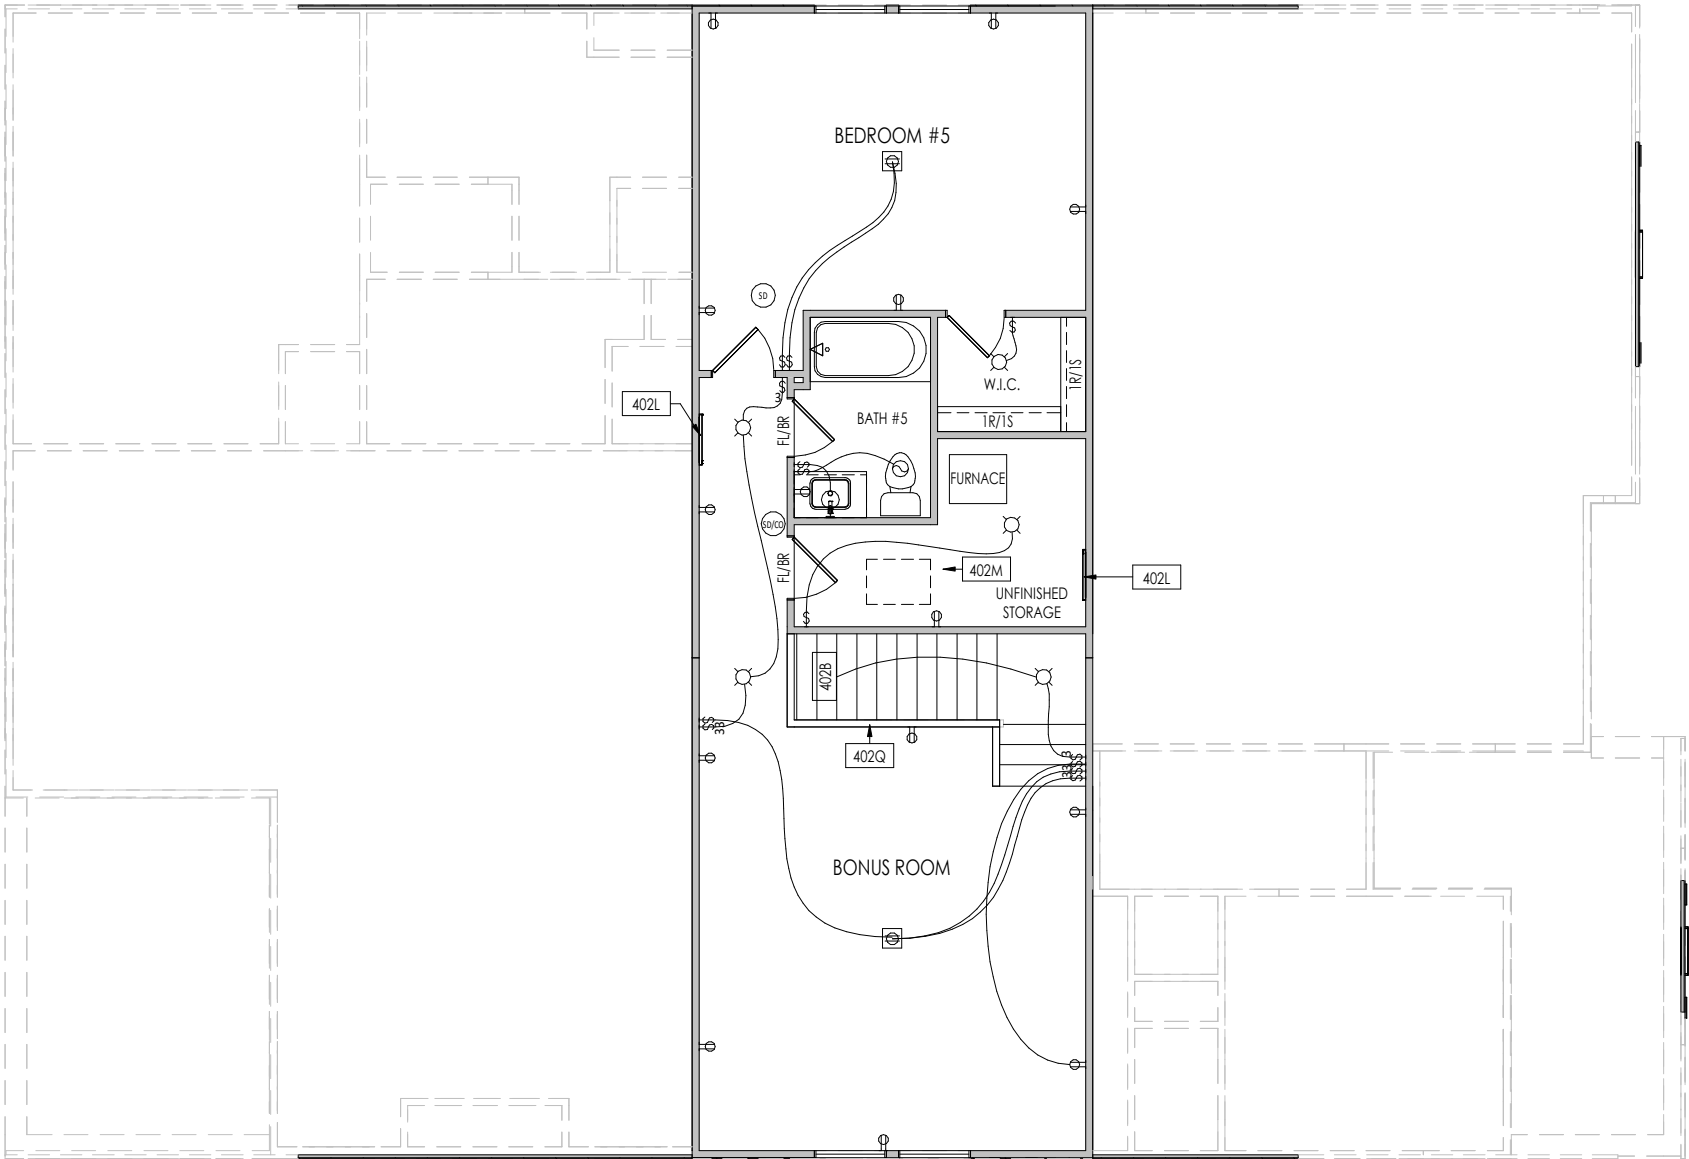

General Notes:

1. REFER TO SHEET ON.1 FOR GENERAL NOTES.

Key Notes:

402B TO SWITCH OR LIGHT BELOW

402L WALL ATTIC ACCESS. SEE DETAIL N/D2.1

402M 22-1/2" x 32" ATTIC ACCESS PANEL IN CEILING

402Q 36" HIGH WALL W/ WOOD CAP

MECHANICAL LEGEND

- ⊖

WALL OUTLET

⊖

WEATHERPROOF GFCI OUTLET

⊖

220 VOLT OUTLET

⊖

GFCI OUTLET

⊖

FLOOR OUTLET

⊖

COUNTER POP-UP OUTLET

↔

SINGLE POLE SWITCH

↔

3-WAY SWITCH

↔

4-WAY SWITCH

⬢

STAIR LIGHT

⊖

BLOCK, MOUNT, & SWITCH FOR FUTURE FAN/LIGHT COMBINATION (CENTER, UNLESS OTHERWISE NOTED)
- ⊖

CLG. MOUNTED LIGHT FIXT.

○

SURFACE MOUNT DISC LIGHT OR RECESSED CEILING LIGHT, PER SPECS.

○

WALL MOUNTED LIGHT FIXT.

⊖

DOUBLE SPOTLIGHT FIXT.

⊖

DIRECTIONAL CAN LIGHT

⊖

PIN LIGHT

⊖

WALL SCONCE @ 5'-6" A.F.F.

⊖

FLUORESCENT LIGHT

⊖

UNDER CABINET LIGHTING
- ⊖

HOSE BIB

⊖

SHOWER HEAD

⊖

GAS GAS HOOK UP

⊖

FLOOR DRAIN

⊖

SMOKE DETECTOR

⊖

SMOKE DETECTOR/CO DETECTOR COMBINATION

⊖

EXHAUST FAN AND LIGHT COMBINATION

⊖

CLG. MTD. EXHAUST FAN

⊖

DATA JACK

⊖

CABLE TELEVISION JACK

Space for Architect Seal



The Drees Company
08/12/2025 1:10:16 PM

RESIDENCE FOR:

KRAKAUER

TBD

SERENITY PHASE 6B

Job Number:	Drawing Date:	Coord Name:	Coord Phone:
STY6-0442-00	6/12/2025	GREG P.	859-578-4355

House Name:	Drawing Scale: 1/8" = 1'0"	Contract Drawn By:
		EWI

the PARKETTE	Series:
	EXECUTIVE

Born on Date:	07/11/23	CDs Drawn By:	CLM
Plan No.:			

Drees

HOMES

SM

Copyright © 2023 (2023) The Drees Company. All Rights Reserved.

8521 Six Forks Road, Suite 500, Raleigh, NC 27615

Phone: (919) 844-9288


Sheet Information

4.02


Second Floor Mechanical Plan

Elevation "E"

7/22/2025 5:06:43 PM

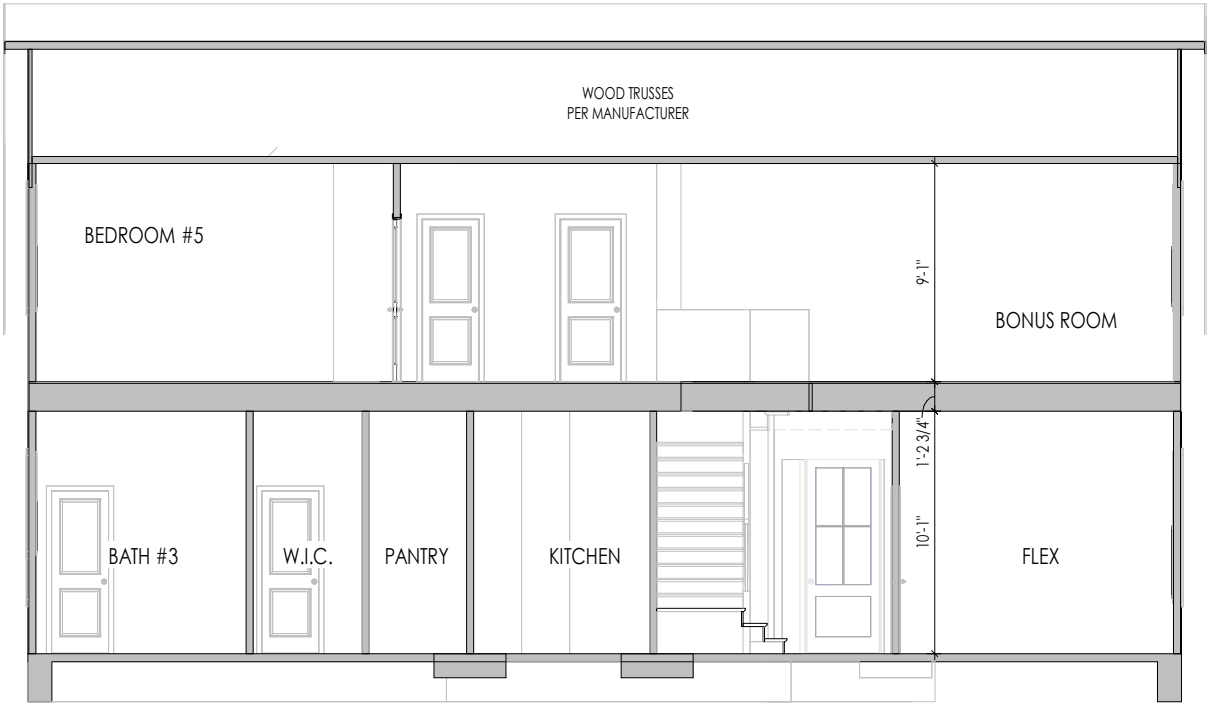

A
5.01
BUILDING SECTION THRU FAMILY ROOM
1/8" = 1'-0"

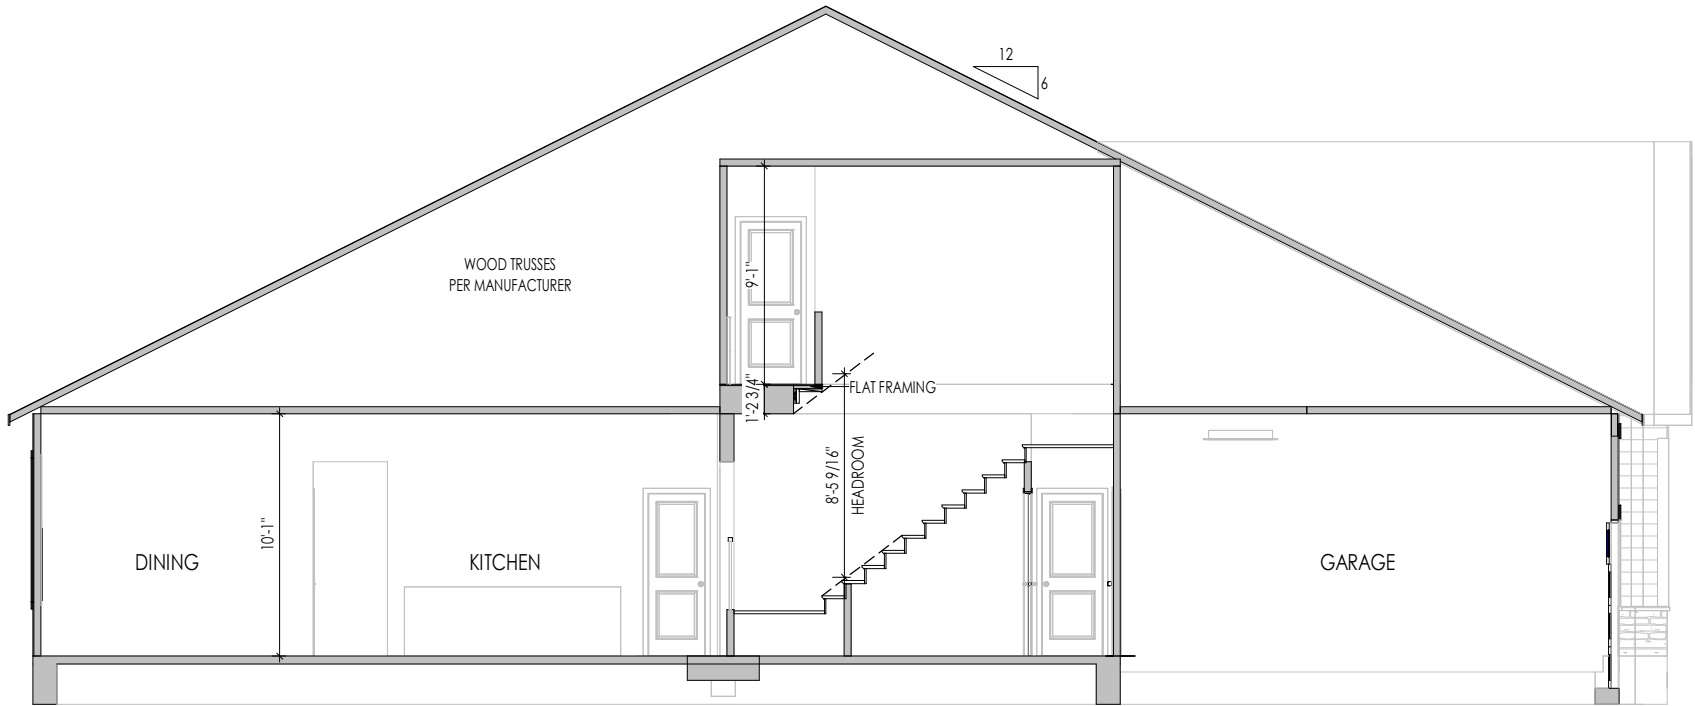

B
5.01
BUILDING SECTION THRU GARAGE
1/8" = 1'-0"

General Notes:

1. REFER TO SHEET ON.1 FOR GENERAL NOTES.
2. REFER TO SHEET S-0 FOR STRUCTURAL DETAILS AND INFORMATION

Key Notes:

Space for Architect Seal



The Drees Company
08/12/2025 1:10:16 PM

RESIDENCE FOR:
KRAKAUER
TBD
SERENITY PHASE 6B

Job Number:	Drawing Date:	Coord Name:	Coord Phone:
STY6-0442-00	6/12/2025	GREG P.	859-578-4355

House Name:	Drawing Scale: 1/8" = 1'-0"	Contract Drawn By:
		EWT

the PARKETTE

Born on Date:	07/11/23	CDs Drawn By:	CLM
---------------	----------	---------------	-----


 Copyright © 2023 (2023) The Drees Company. All Rights Reserved. 8521 Six Forks Road, Suite 500, Raleigh, NC 27615 Phone: [919] 844-9288	Sheet Information	5.01 Building Section Elevation "E"
--	--------------------------	---

TYPICAL TRIM:
6" FASCIA (ALL SIDES)
8" FRIEZE (FRONT ONLY, UNLESS OTHERWISE NOTED)

General Notes:

1. REFER TO SHEET ON.1 FOR GENERAL NOTES.
2. ROOFING MATERIAL PER SELECTIONS.
3. CONTACT M&K ENGINEERING FOR HEADER SIZE/BRICK SUPPORT IF GRADE DROPS AND THE AMOUNT OF BRICK OVER GARAGE DOOR SHOWN ON CURRENT ELEVATION IS NO LONGER ACCURATE
4. REFER TO SHEET S-0 FOR STRUCTURAL DETAILS AND INFORMATION

Key Notes:

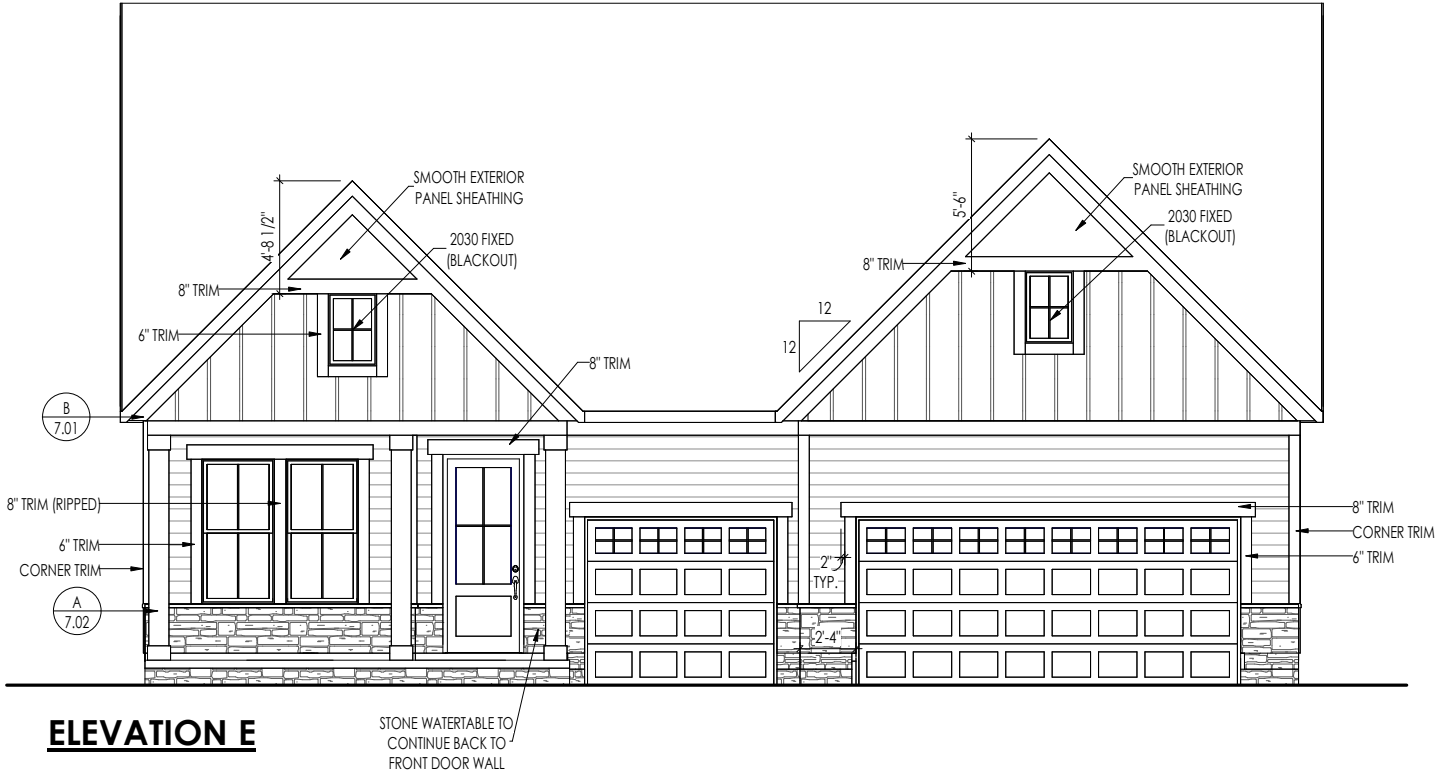

The Drees Company
08/12/2025 1:10:17 PM

RESIDENCE FOR:
KRAKAUER
TBD
SERENITY PHASE 6B

Job Number: STY6-0442-00	Drawing Date: 6/12/2025	Coord Name: GREG P.	Coord Phone: 859-578-4355
House Name:			Contract Drawn By: EWI
the PARKETTE			Series: EXECUTIVE
			Plan No.:
Born on Date: 07/11/23	CDs Drawn By: CLM		

Copyright © 2023 (2023) The Drees Company. All Rights Reserved.
8521 Six Forks Road, Suite 500, Raleigh, NC 27615
Phone: [919] 844-9288

Sheet Information

6.01
Front Elevation
Elevation "E"

I:\Content\15\01\ESTR\4\ESTR\6\ESTR\6-0442-00_cancelled\ESTR-0442-00.rvt



TYPICAL TRIM:
6" FASCIA (ALL SIDES)
8" FRIEZE (FRONT ONLY, UNLESS OTHERWISE NOTED)

General Notes:

1. REFER TO SHEET ON.1 FOR GENERAL NOTES.
2. ROOFING MATERIAL PER SELECTIONS.
3. REFER TO LINTEL SCHEDULE AS NEEDED ON SHEET 6.01.
4. REFER TO SHEET S-0 FOR STRUCTURAL DETAILS AND INFORMATION

Key Notes:

Space for Architect Seal



The Drees Company
08/12/2025 1:10:17 PM

RESIDENCE FOR:
KRAKAUER
TBD
SERENITY PHASE 6B

Job Number: STY6-0442-00	Drawing Date: 6/12/2025	Coord Name: GREG P.	Coord Phone: 859-578-4355
House Name: the PARKETTE			Contract Drawn By: EWT
Born on Date: 07/11/23			CDs Drawn By: CLM
Drees HOMES SM Copyright © 2023 (2023) The Drees Company. All Rights Reserved. 8521 Six Forks Road, Suite 500, Raleigh, NC 27615 Phone: [919] 844-9288			Sheet Information
6.02 Garage Side Elevation Elevation "E"			



TYPICAL TRIM:

6" FASCIA
(ALL SIDES)

8" FRIEZE
(FRONT ONLY, UNLESS OTHERWISE NOTED)

General Notes:

1. REFER TO SHEET 0N.1 FOR GENERAL NOTES.
2. ROOFING MATERIAL PER SELECTIONS.
3. REFER TO LINTEL SCHEDULE AS NEEDED ON SHEET 6.01.
4. REFER TO SHEET S-0 FOR STRUCTURAL DETAILS AND INFORMATION

Key Notes:

Space for Architect Seal



The Drees Company
08/12/2025 1:10:17 PM

RESIDENCE FOR:

KRAKAUER

TBD

SERENITY PHASE 6B

Job Number: STY6-0442-00	Drawing Date: 6/12/2025	Coord Name: GREG P.	Coord Phone: 859-578-4355
------------------------------------	-----------------------------------	-------------------------------	-------------------------------------

House Name:	Drawing Scale: 1/8" = 1'0"	Contract Drawn By: EWI
-------------	----------------------------	----------------------------------

the PARKETTE	Series: EXECUTIVE
---------------------	-----------------------------

Born on Date: 07/11/23	CDs Drawn By: CLM	Plan No.:
------------------------	-------------------	-----------





Sheet Information


6.04
Side Elevation
Elevation "E"

7/22/2025 5:05:45 PM

I:\Content\5\SOUTHEASTRALEIGH\STY6\STY6-0442-00_cancelled\STY6-0442-00.rvt

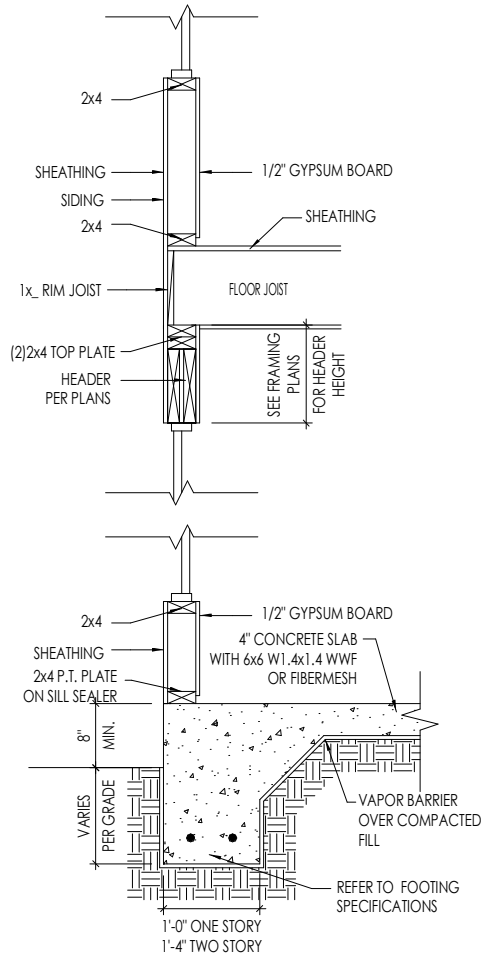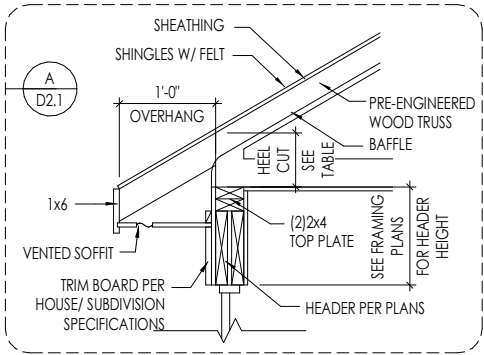

TYPICAL WALL SECTIONS
SCALE: 1/2" = 1'-0"

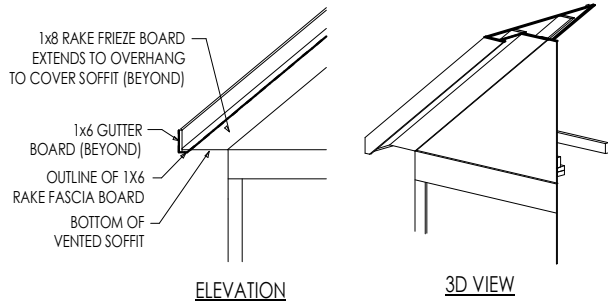

RAFTER TAIL DETAIL
SCALE: 1/4" = 1'-0"



The Drees Company
08/12/2025 1:10:17 PM

RESIDENCE FOR:
KRAKAUER
TBD
SERENITY PHASE 6B


Job Number:	Drawing Date:	Coord Name:	Coord Phone:
STY6-0442-00	6/12/2025	GREG P.	859-578-4355



House Name:	Drawing Scale: 1/8" = 1'-0"	Contract Drawn By:
		EWI

the PARKETTE


Series:	EXECUTIVE
Plan No.:	

Born on Date:	07/11/23	CDs Drawn By:	CLM
---------------	----------	---------------	-----

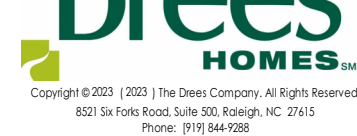
 Drees HOMESSM Copyright © 2023 (2023) The Drees Company. All Rights Reserved. 8521 Six Forks Road, Suite 500, Raleigh, NC 27615 Phone: [919] 844-9288	Sheet Information	7.01 House Specific Details Elevation "E"
---	--------------------------	---

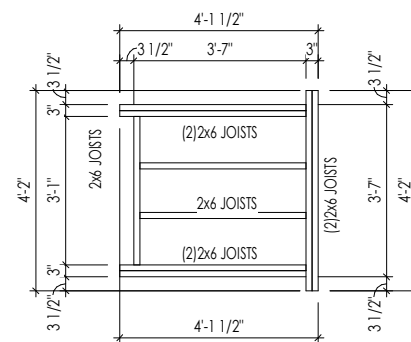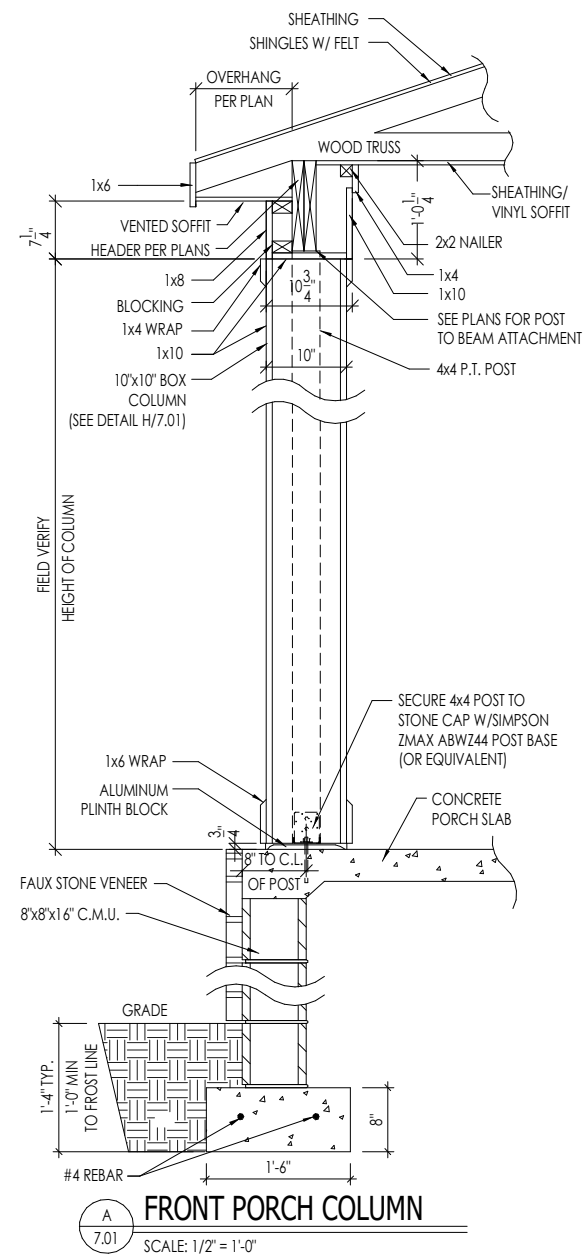

LANDING DETAIL A
1/4" = 1'-0"

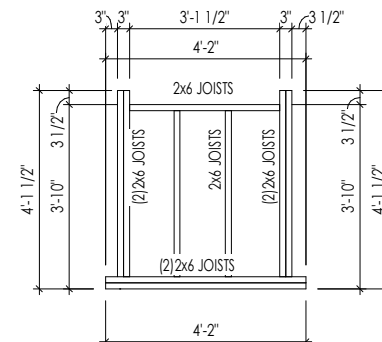

LANDING DETAIL B
1/4" = 1'-0"

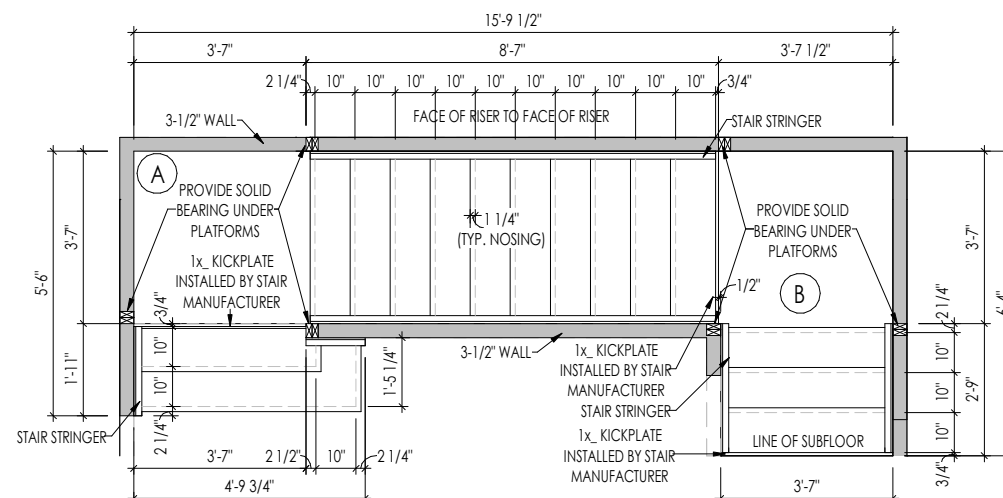

SEE STAIR SECTION B/5
FOR RISER HEIGHTS

2ND FLOOR STAIR DETAIL
1/4" = 1'-0"



The Drees Company
08/12/2025 1:10:17 PM

RESIDENCE FOR:
KRAKAUER
TBD
SERENITY PHASE 6B

Job Number: STY6-0442-00	Drawing Date: 6/12/2025	Coord Name: GREG P.	Coord Phone: 859-578-4355
House Name:		Drawing Scale: 1/8" = 1'0"	Contract Drawn By: EWT
the PARKETTE		Series:	EXECUTIVE
		Plan No.:	
Born on Date:	07/11/23	CDs Drawn By:	CLM



Sheet Information

7.02

House Specific Details

Elevation "E"

CONNECTION SPECIFICATIONS (TYP. U.N.O.)

NOTE: 10d NAIL = 3" x 0.131" GUN NAIL	
JOIST TO SOLE PLATE	(3)10d TOENAILS
SOLE PLATE TO JOIST/BLK'S	10d NAILS @ 6" o.c.
STUD TO SOLE PLATE	(3)10d TOENAILS
TOP OR SOLE PLATE TO STUD	(3)10d NAILS
RIM TO TOP PLATE	10d TOENAILS @ 6" o.c.
BLK'S, BTNN. JOISTS TO TOP PL.	(3)10d TOENAILS
RAFTER/TRUSS TO TOP PLATE	(3)10d TOENAILS + (1) SIMPSON H2.5A
GAB. END TRUSS TO DBL. TOP PL.	10d TOENAILS @ 8" o.c.
R.T. w/ HEEL HT. 9 1/4" TO 12"	2x10 BLK EVERY 3RD BAY FASTENED TO DBL. TOP PLATE w/ 10d TOENAILS @ 6" o.c.
R.T. w/ HEEL HT. 12" TO 16"	2x12 BLK EVERY 3RD BAY FASTENED TO DBL. TOP PLATE w/ 10d TOENAILS @ 6" o.c.
R.T. w/ HEEL HT. UP TO 24"	LAP WALL SHTG. w/ DBL. TOP PL. # INSTALL ON TRUSS VERT. - FASTEN w/ 8d NAILS @ 6" o.c.
R.T. w/ HEEL HT. 24" TO 48"	LAP WALL SHTG. w/ DBL. TOP PL. # INSTALL ON TRUSS VERT. - FASTEN w/ 8d NAILS @ 6" o.c. PROVIDE 2x BLK @ EA. BAY AT TOP OF HEEL
DOUBLE STUD	10d NAILS @ 24" o.c.
DOUBLE TOP PLATE	10d NAILS @ 24" o.c.
DOUBLE TOP PLATE LAP SPLICE	(10)10d NAILS IN LAPPED AREA
TOP PLATE LAP @ CORNERS & INTERSECTING WALLS	(2)10d NAILS
WALL TO FOUNDATION	WALL SHTG. LAP w/ SILL PL. & FASTENED PER SHEAR WALL FASTENING SPEC.

GARAGE SLAB

4" CONC. SLAB w/ 6x6-WI.4xWI.4
WNF ON 6 MIL VAPOR BARRIER
ON 4" MIN. GRANULAR FILL ON 95%
COMPACTED FILL/VIRGIN SOIL

PORCH SLAB

4" CONC. SLAB w/ 6x6-WI.4xWI.4 WNF ON
95% COMPACTED FILL/VIRGIN SOIL

BASEMENT SLAB

4" CONC. SLAB ON 6 MIL VAPOR BARRIER
ON 4" MIN. GRANULAR FILL ON
95% COMPACTED FILL/VIRGIN SOIL

SLAB ON GRADE

4" CONC. SLAB w/ 6x6-WI.4xWI.4 WNF ON 6
MIL VAPOR BARRIER ON 4" MIN. GRANULAR
FILL ON 95% COMPACTED FILL/VIRGIN SOIL

HOLD-DOWN SCHEDULE

SYMBOL	SPECIFICATION
➤ HD-1	SIMPSON HIT4 HOLD-DOWN *
➤ HD-2	SIMPSON HDU4-SDS2.5 HOLD-DOWN *
➤ HD-3	SIMPSON HDU5-SDS2.5 HOLD-DOWN *
➤ HD-4	SIMPSON STDH4RJ HOLD-DOWN
➤ HD-5	SIMPSON CSI6 STRAP TIE (14" END LENGTH)
➤ HD-6	SIMPSON MSTC40 STRAP TIE (CENTER STRAP ON FLOOR SYSTEM U.N.O.)
➤ HD-7	SIMPSON MSTC66 STRAP TIE (CENTER STRAP ON FLOOR SYSTEM U.N.O.)

ALTERNATIVE TO SSTB24 ANCHOR BOLT SPECIFICATION:

* UTILIZE SIMPSON "SET" EPOXY SYSTEM TO FASTEN 3/8"
DIA. THREADED ROD INTO CONCRETE FOUNDATION.
PROVIDE 12" MIN. EMBEDMENT INTO CONCRETE.
INSTALL PER MANUF. RECOMMENDATIONS. DO NOT
LOCATE ANCHORS WITHIN 1 3/4" OF EDGE OF FOUNDATION.

VENEER LINTEL SCHEDULE

SPAN (MAX)	HEIGHT OF VENEER ABOVE LINTEL	STEEL ANGLE SIZE
3'-0"	20 FT. MAX	L4x3 1/2x3/4"
6'-0"	3 FT. MAX	L4x3 1/2x3/4"
8'-0"	16 FT. MAX	L5x3 1/2x3/4"
9'-6"	6 FT. MAX	L5x3 1/2x3/4"
11'-6"	3 FT. MAX	L5x3 1/2x3/4"
12'-0"	2 FT. MAX	L5x3 1/2x3/4"

ALL LINTELS:
- SHALL SUPPORT 2 3/4" - 3 1/2" VENEER w/ 40 psf MAXIMUM HEIGHT.
- 1/8" SHALL HAVE 4" MIN BEARING
- 1/8" SHALL HAVE 2" MIN BEARING
- 1/8" SHALL NOT BE FASTENED BACK TO HEADER.
- 1/8" SHALL BE FASTENED BACK TO WOOD HEADERS IN WALL @48" o.c. w/ 1/2" DIA. x 3 1/2"
LONG LAG SCREWS IN 2" LONG VERTICALLY SLOTTED HOLES.
- MAX. VENEER HT. APPLIES TO ANY PORTION OF BRICK OVER THE OPENING.
- ALL LINTELS SHALL BE LONG LEB VERTICAL.
- ALL LINTELS SHALL BE MADE OF 36 KSI STEEL.
- WHEN SUPPORTING VENEER (3" MIN. THE EXTERIOR TOE OF THE HORIZONTAL LEB
MAY BE CUT IN THE FIELD TO BE 3/4" WIDE OVER THE BEARING LENGTH ONLY.
THIS IS TO ALLOW FOR MORTAR JOINT FINISHING.
- SEE STRUCTURAL PLANS FOR ANY LINTEL CONDITION NOT ENCOMPASSED BY THE
ABOVE PARAMETERS. MKS STD. - MAY 2006

LEGEND

- INTERIOR BEARING WALL
- BEARING WALL ABOVE
- BEAM / HEADER
- EXTENT OF OVERFRAMING
- JL METAL HANGER
- INDICATES EXTENT OF INT. OSB
SHEARWALL, BLOCKED PANEL EDGES,
AND/OR 3" O.C. EDGE NAILING
- INDICATES HOLDOWN
- INDICATES POST ABOVE (P.A.) PROVIDE
SOLID BLOCKING UNDER POST OR JAMB
ABOVE.

ADDITIONAL NOTES FOR TRUSS &
I-JOIST MANUFACTURER

ROOF TRUSS, FLOOR TRUSS AND ENGINEERED
JOISTS SHALL BE DESIGNED TO MEET THE
DEFLECTION CRITERIA BELOW, UNLESS NOTED
OTHERWISE ON PLAN. MULHERN & KULP CANNOT BE
HELD RESPONSIBLE FOR ANY STRUCTURAL ISSUES
RELATED TO ANY BUILDING COMPONENT IF
COMPONENT SHOP DRAWINGS ARE NOT SUBMITTED
TO MKK FOR REVIEW PRIOR TO FABRICATION,
DELIVERY, OR INSTALLATION.

TRUSSES/JOISTS SHALL BE DESIGNED SO THAT
DIFFERENTIAL DEFLECTION BETWEEN ADJACENT
PARALLEL TRUSSES/JOISTS OR GIRDER TRUSSES/FLUSH
BEAMS DO NOT EXCEED THE FOLLOWING:
A. ROOF TRUSSES:
1/4" DEAD LOAD
B. FLOOR TRUSSES, ATTIC TRUSSES, & I-JOISTS:
1/8" DEAD LOAD
ABSOLUTE DEAD LOAD DEFLECTION OF FLOOR
TRUSSES/ATTIC TRUSSES WHEN ADJACENT TO FLOOR
FRAMING BY OTHERS SHALL BE LIMITED TO 3/16". (NOT
DIFFERENTIAL DEFLECTION)

GENERAL STRUCTURAL NOTES

FOUNDATION

- DESIGN IS BASED ON 2018 NORTH CAROLINA RESIDENTIAL CODE.
- FOOTING DESIGN - 1500 PSF NET ALLOWABLE SOIL BEARING
PRESSURE IS ASSUMED. BUILDER/CONTRACTOR MUST VERIFY.
 - 1/2" DIA. ANCHOR BOLTS @ 6'-0" O.C., 7" MIN. EMBEDMENT
 - SIMPSON MAB STRAPS @ 32" O.C.
 - SIMPSON MASA ANCHOR STRAPS @ 6'-0" O.C.
- FASTEN 2x SILL PLATES TO CONC FND WITH A MINIMUM OF 2
ANCHORS PER PLATE, 12" MAX. FROM PLATE ENDS - UTILIZING:
 - 1/2" DIA. ANCHOR BOLTS @ 6'-0" O.C., 7" MIN. EMBEDMENT
 - SIMPSON MAB STRAPS @ 32" O.C.
 - SIMPSON MASA ANCHOR STRAPS @ 6'-0" O.C.

- ALL LUMBER EXPOSED TO WEATHER OR IN CONTACT w/ PERIMETER
FOUNDATION SHALL BE PRESERVATIVE TREATED SOUTHERN PINE #2.
- BUILDER TO VERIFY CORROSION-RESISTANCE COMPATIBILITY OF
HARDWARE & FASTENERS IN CONTACT w/ PRESERVATIVE-TREATED
WOOD. CONTACT LUMBER & HARDWARE SUPPLIERS TO COORD.


- FOUNDATION WALLS & FOOTINGS SHALL BE PLAIN CONCRETE, U.N.O.

- CONCRETE DESIGN BASED ON ACI 318. CONCRETE SHALL ATTAIN
THE FOLLOWING MIN. COMPRESSIVE STRENGTHS IN 28 DAYS, U.N.O.:
fc = 4,000 psi: FOUNDATION WALLS
3,000 psi: FOOTINGS & INTERIOR SLABS ON GRADE
3,500 psi: GARAGE & EXTERIOR SLABS ON GRADE
fy = 60,000 psi

- BASEMENT FOUNDATION WALL DESIGN BASED ON:
 - 8" OR 9" HEIGHT (AS NOTED ON PLANS)
 - TALLER WALLS MUST BE ENGINEERED.
 - NOMINAL WIDTH (8" FOR 8" WALL, 10" FOR 10" WALL).

- BASEMENT WALL DESIGN IS BASED ON 30 OR 45 PCF BACKFILL
SOIL TYPE CLASSIFICATIONS:
30 PCF TYPE (G1, G2, G3, G4, G1576, G1577

seal:

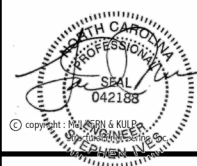

Mulhern+Kulp project number:
085-20015

project mgr: BSM
drawn by: BJD
issue date: 08-08-23

REVISIONS:
date: 05/30/2024 initial: DML
updated notes:




MULHERN+KULP
RESIDENTIAL STRUCTURAL ENGINEERING
300 Brookside Ave. Building 4 - Ambler, PA 19002
p. 215-546-9301 • mulhern+kulp.com



STRUCTURAL NOTES
PARKETTE MODEL


sheet:

SD-1

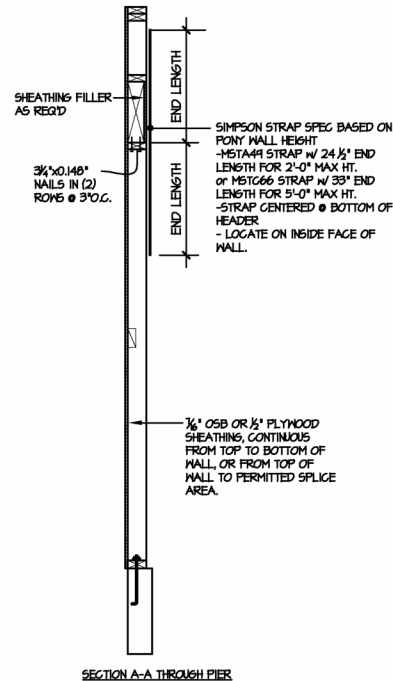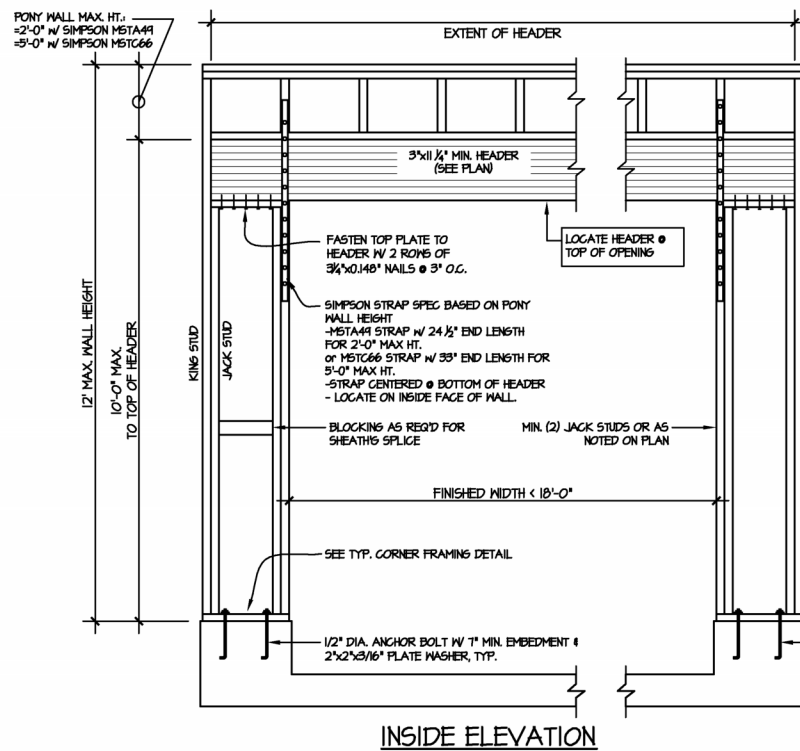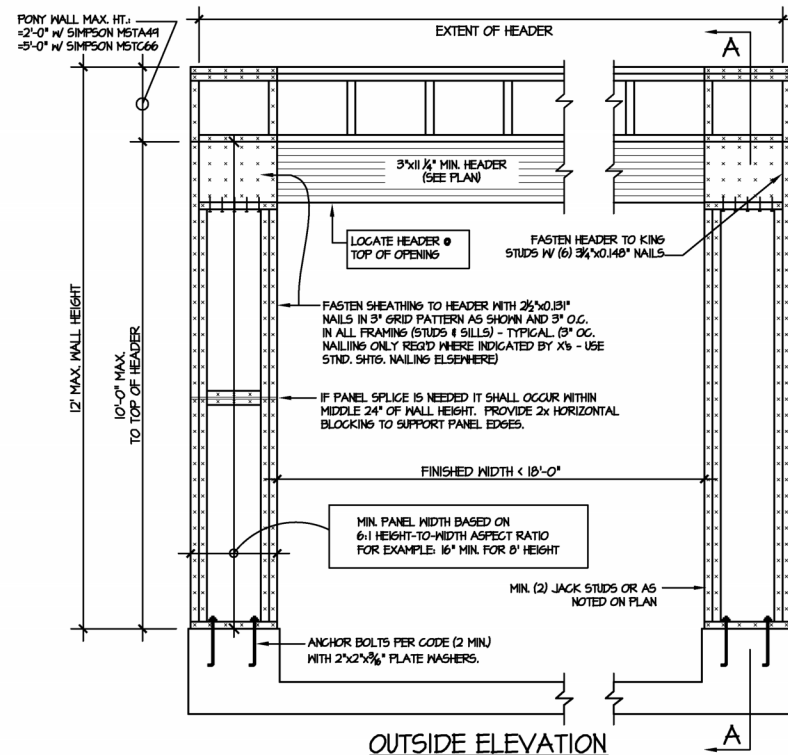

NOTE: ALL SHEATHABLE AREAS OF EXTERIOR WALL SHALL BE FULLY SHEATHED WITH 1/2" PLYWOOD OR 1/4" OSB


WALL FRAMING SPECIFICATION:
@ 2x4 WALL: USE #2 GRADE STUDS (OR BETTER)
@ 2x6 WALL: USE SFF STUD GRADE STUDS (OR BETTER)

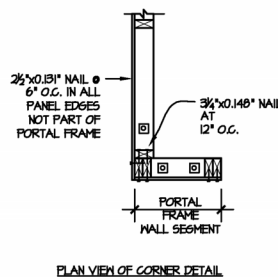

ALTERNATIVES TO 1/2" DIA. ANCHOR BOLT:
1) 1/2" DIA. x 6" LONG SIMPSON TITEN HD
2) 1/2" DIA. THREADED ROD EPOXY SET W/ 4 1/2" EMBED. (MIN UTILIZING HILTI HIT200 EPOXY ANCHORING SYSTEM OR EQUAL)


1/16" A.P.A. RATED O.S.B. SHEATHING (ONE SIDE) FASTEN TO ALL SUPPORTS W/ 2 1/2"x0.131" NAILS @ 3" O.C. - PROVIDE HORIZONTAL BLOCKING @ PANEL EDGES

NOTE: SHEAR TRANSFER DETAIL REQ'D @ 12" O.C. (AS SHOWN)

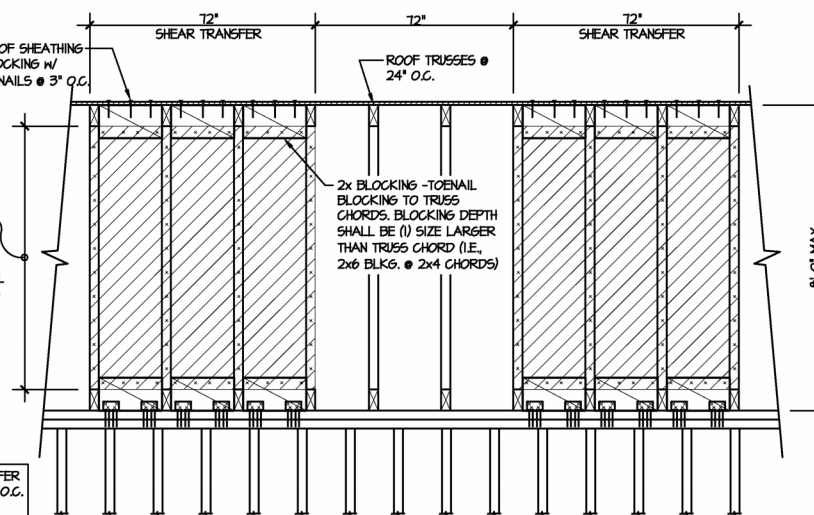

TYPICAL SHEAR TRANSFER DETAIL
@ INTERIOR SHEARWALL
SCALE: 3/4"=1'-0"
3/8"=1'-0" (1bft)

 
TYPICAL SHEAR TRANSFER DETAIL
@ INTERIOR SHEARWALL
SCALE: 3/4"=1'-0"
3/8"=1'-0" (1bft)




GARAGE PORTAL FRAME BRACING ELEVATION

SCALE: N.T.S.


BOTH SIDES OF GARAGE DOOR
115 MPH WIND SPEED (ULT)

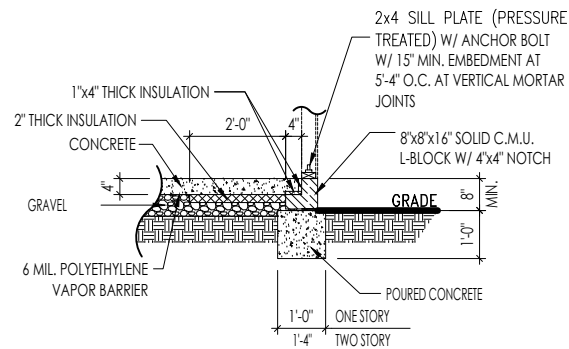


SLAB ON GRADE AT BLOCK FOUNDATION W/ SIDING
 SCALE: 1/4" = 1'-0"

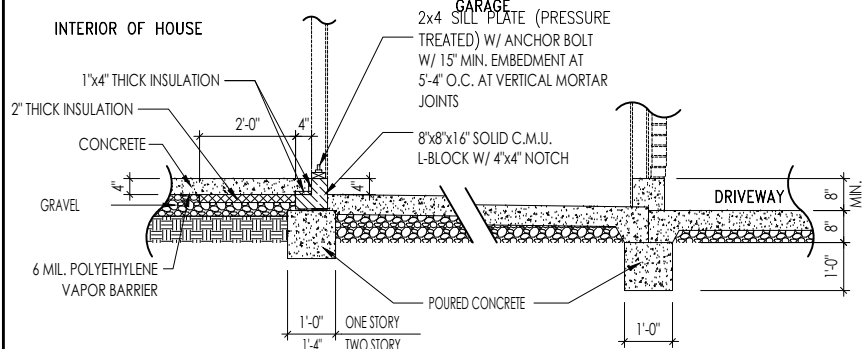


FOUNDATION DETAIL AT GARAGE
 SCALE: 1/4" = 1'-0"

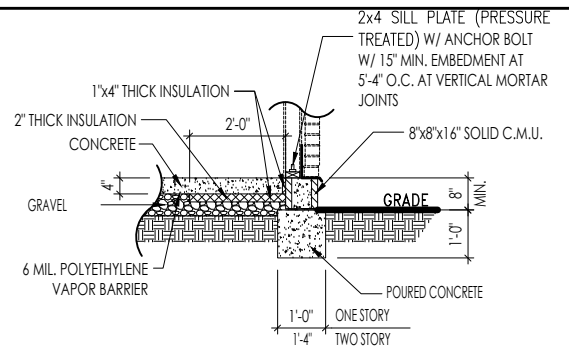

SLAB ON GRADE AT BLOCK FOUNDATION W/ BRICK
 SCALE: 1/4" = 1'-0"

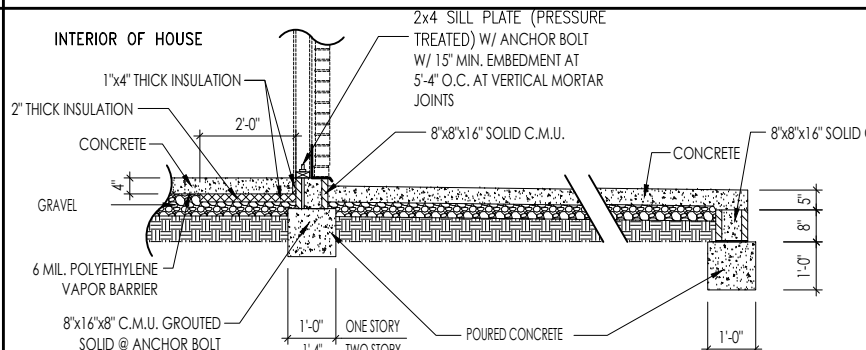

FOUNDATION DETAIL AT PORCH
 SCALE: 1/4" = 1'-0"

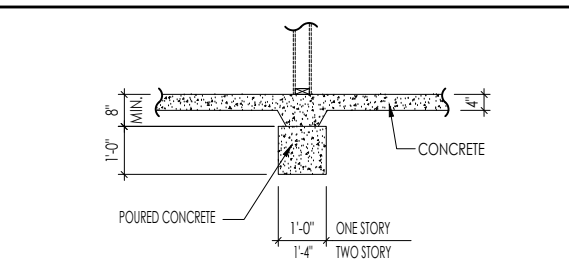

INTERIOR BEARING WALL DETAIL
 SCALE: 1/4" = 1'-0"



The Drees Company
 08/12/2025 1:10:04 PM



Drees Homes
 7701 Six Forks Road, Suite 132, Raleigh, NC 27615 PH: (919) 844-9288
 Copyright ©, 2005 The Drees Company. All rights reserved. These plans are protected by Copyright. No part of these plans may be reproduced in any form or by any means, including photocopying, without the written permission from the Copyright owner.

STD. DETAIL SHEET
 REGION:
RALEIGH















Std. By: ALL
 Chk. By: ARC
 Std. Date: 08/19/09
 Date of:

Sheet Description:
CONC. BLOCK SLAB ON GRADE DETAILS


RALEIGH - D-SHEETS.dwg Jul 31, 2023 - 4:07pm

Sheet No.

D1.3

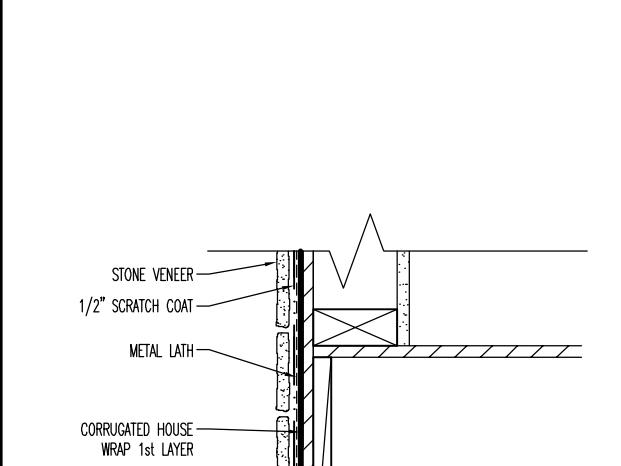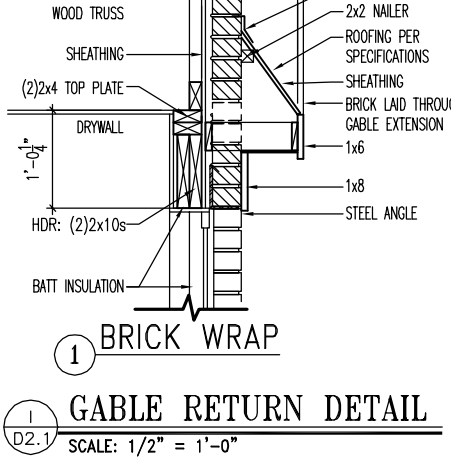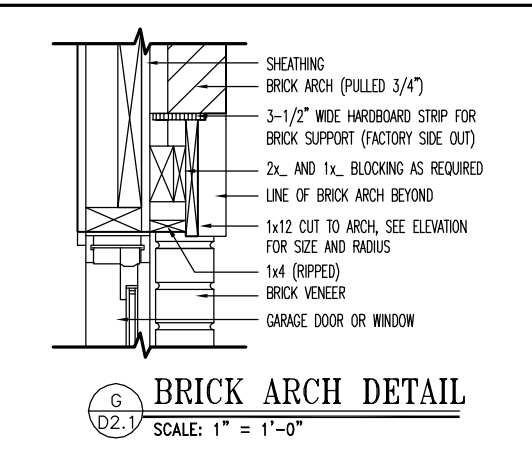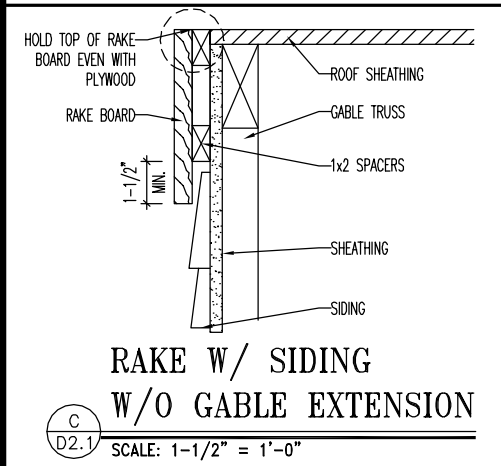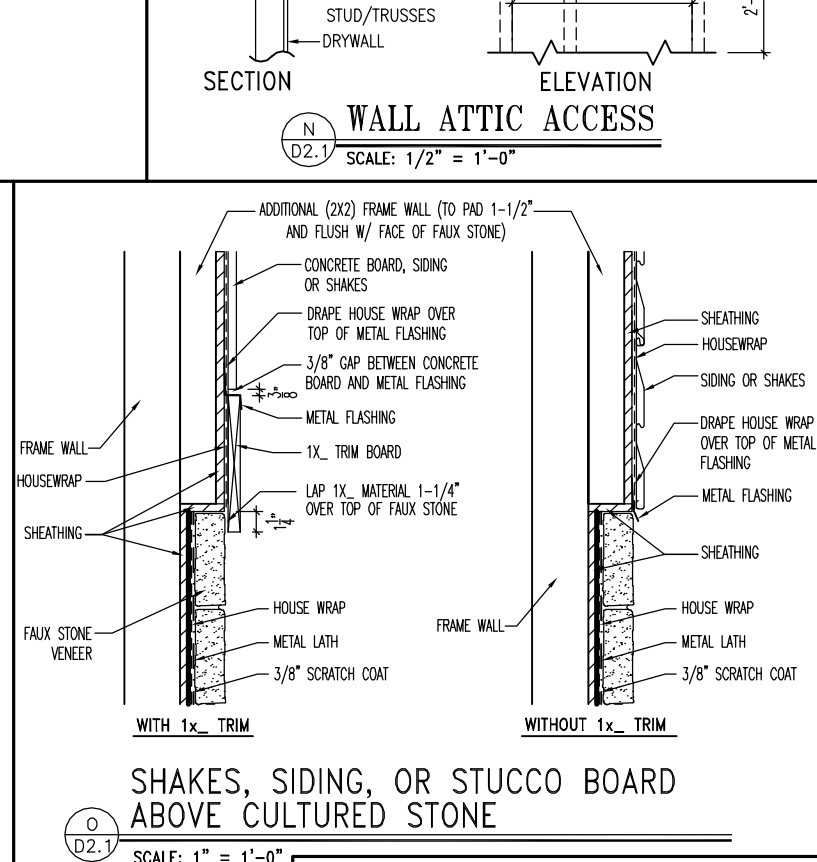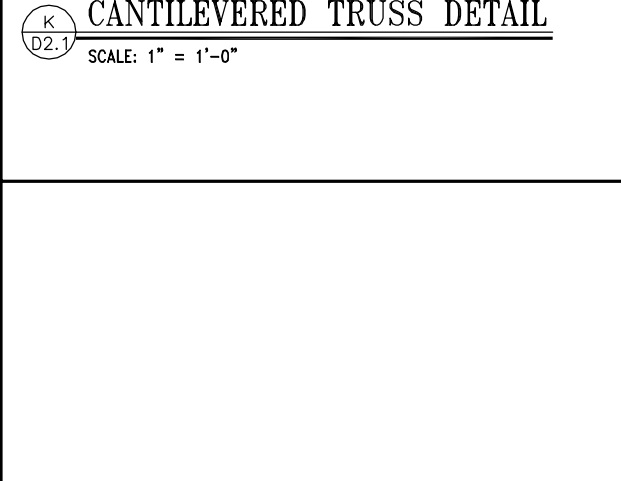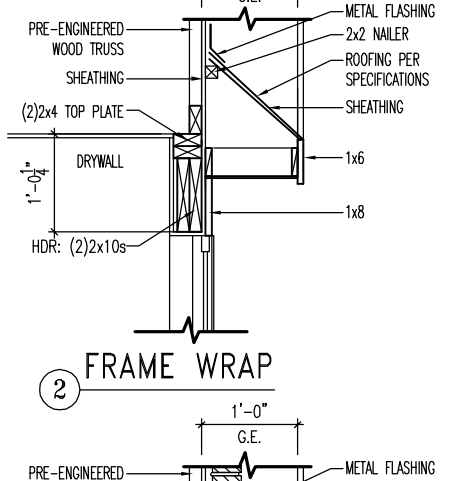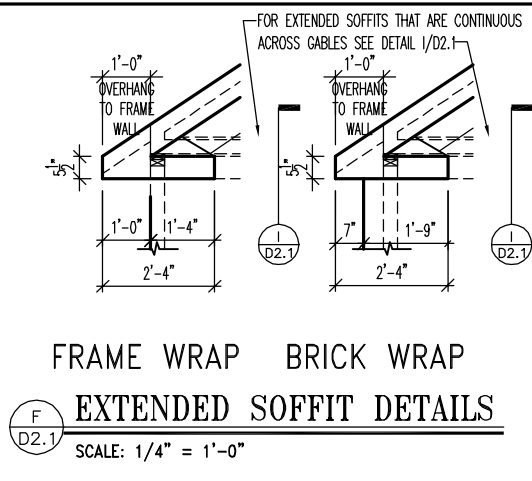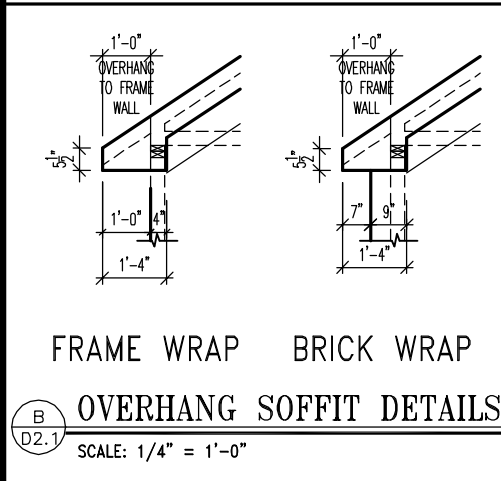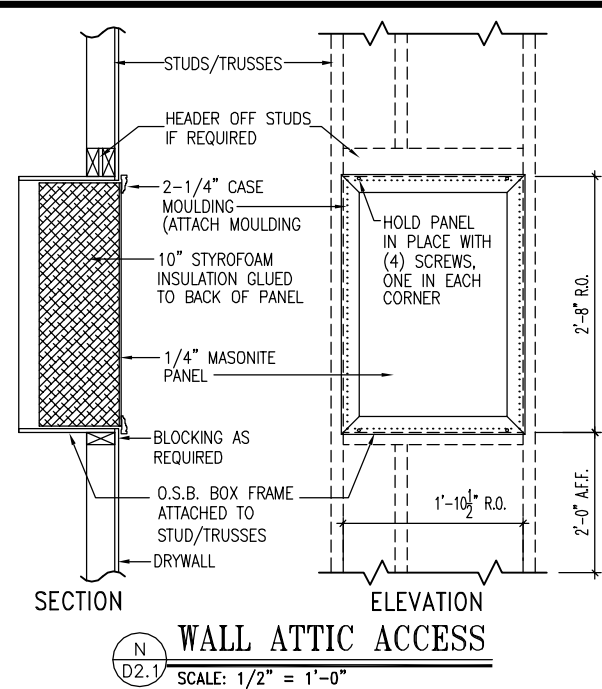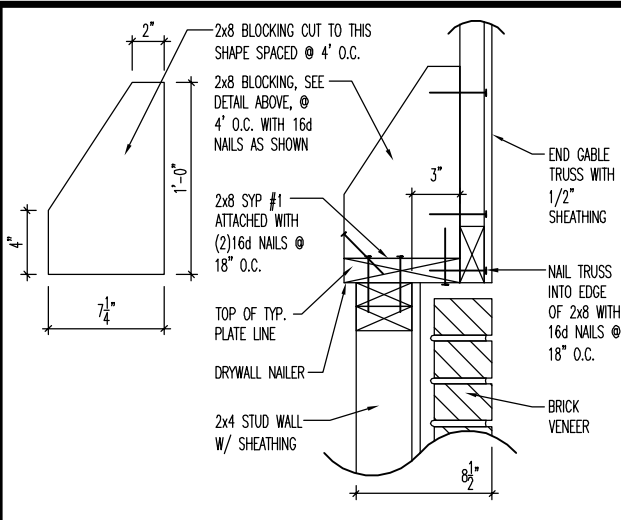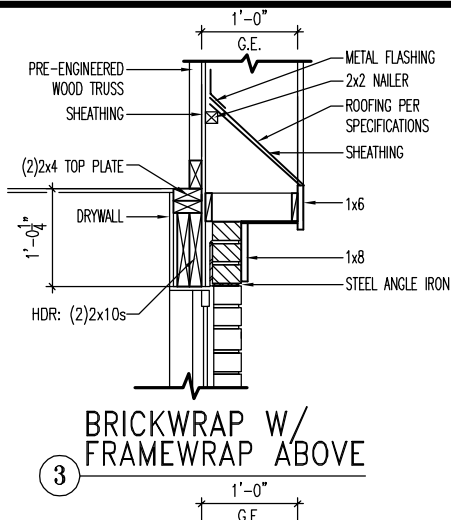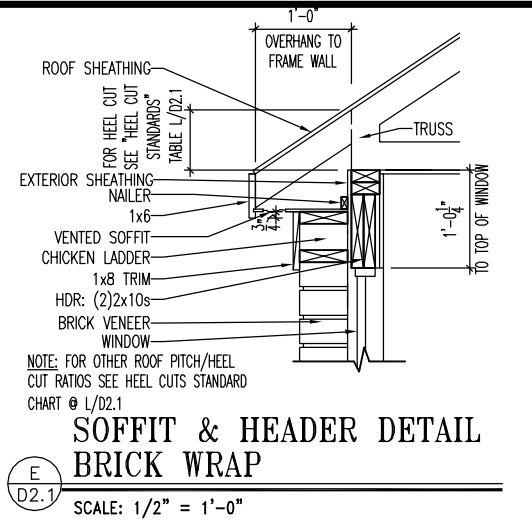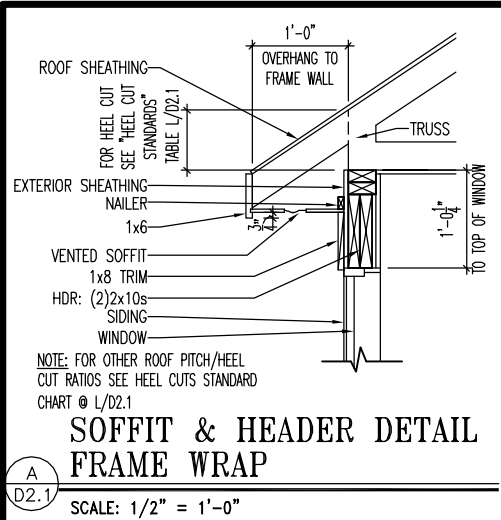

HEEL CUT STANDARDS	
ROOF PITCH	HEEL CUT
4/12	3-3/4"
5/12	4-3/4"
6/12	5-3/4"
7/12	6-3/4"
8/12	7-3/4"
9/12	8-3/4"
10/12	9-3/4"
12/12	11-3/4"
14/12	1'1-3/4"

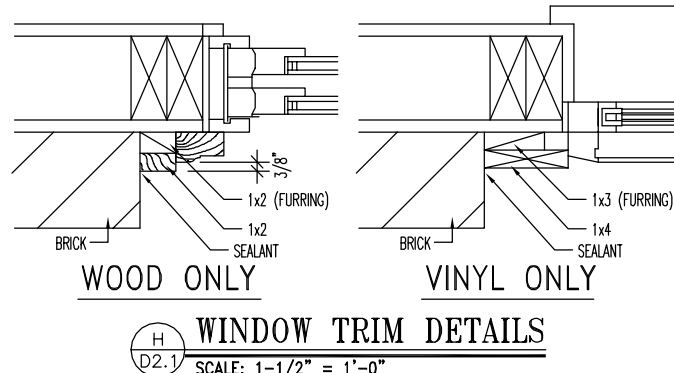

The Drees Company
08/12/2025 1:10:04 PM



Drees Homes
7701 Six Forks Road, Suite 132, Raleigh, NC 27615 PH(919) 844-9288
Copyright © 2005 The Drees Company. All rights reserved. These plans are protected by Copyright. No part of these plans may be reproduced in any form or by any means, including photocopying, without the written permission from the Copyright owner.

STD. DETAIL SHEET
REGION:
RALEIGH


Std. By: ALL
Chk. By: ARC
Std. Date: 10.11.06
Last Rev: 4/5/10 MSM

Sheet Description:


FRAMING DETAILS

DETAILS MAY NOT APPLY TO CONTRACT

Sheet No.
D2.1

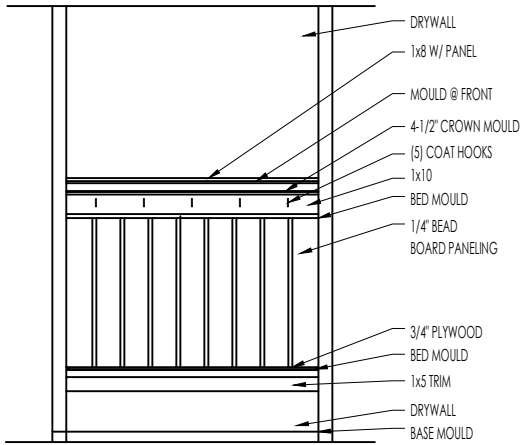


ELEVATION

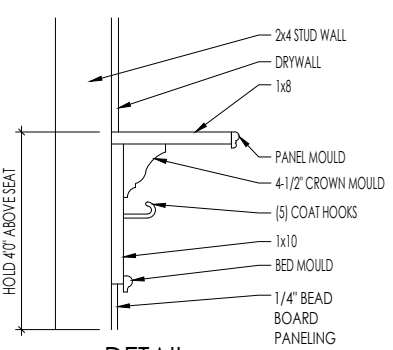


DETAIL

SCALE: 1/2" = 1'-0"

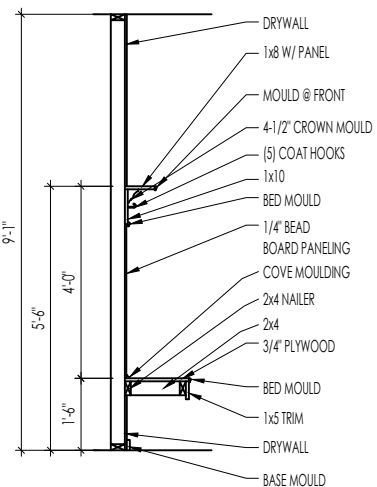

SECTION

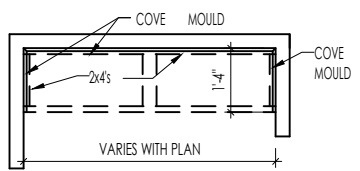

PLAN

F
D2.2

BENCH SEAT DETAILS

SCALE: AS NOTED



The Drees Company
08/12/2025 1:10:04 PM



STANDARD FRAMING DETAILS
RALEIGH DIVISION
SCALE: AS NOTED

SHEET NO.


ARCH

DATE OF DETAIL:


LAST REVISION:

01/27/15
Jan 10, 2023 - 1:47pm

D2.2

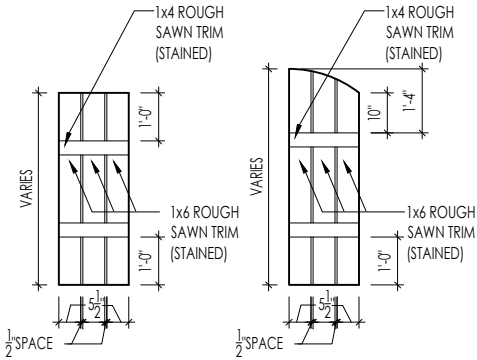

M
D2.4
SLAT SHUTTER DETAIL
SCALE: 1/4" = 1'-0"

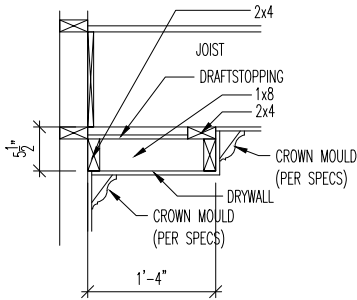

H
D2.4
SINGLE TRAY CEILING DETAIL
SCALE: 1/2" = 1'-0"



The Drees Company
08/12/2025 1:10:04 PM

STANDARD FRAMING DETAILS
RALEIGH DIVISION
SCALE: AS NOTED



Copyright © 2020, The Drees Company. All Rights Reserved. No portion of this material may be reproduced in any form or by any means, including photocopying, without the express written permission of The Drees Company. The Drees Company will vigorously prosecute any unauthorized use of this material.

DRAWN BY: ARCH


DATE OF DETAIL: 01/27/15

LAST REVISION:


Jan 10, 2023 - 1:46pm

SHEET NO.

D2.4

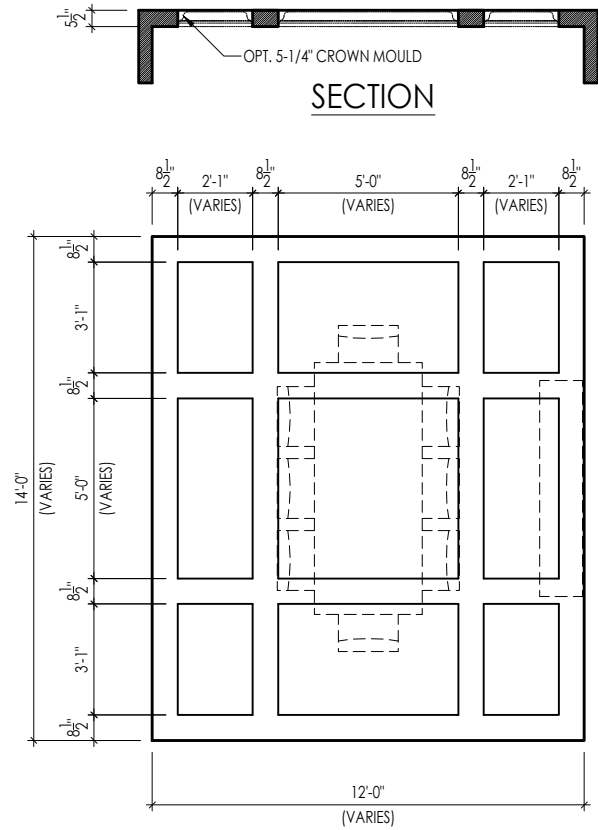


TYPICAL PLAN

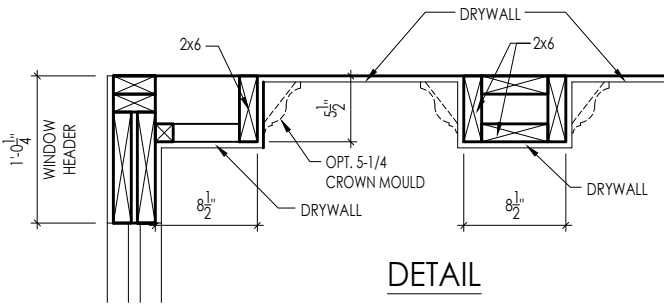


Note: Ceiling treatment details will tray down into space on enclosed rooms located on the 1st floor. On enclosed rooms on the 2nd floor, the ceiling treatment will tray up into the roof truss system. On 2-story spaces, the ceiling treatment will tray down into the space and require an appropriate sized header to capture the ceiling detail return.

01

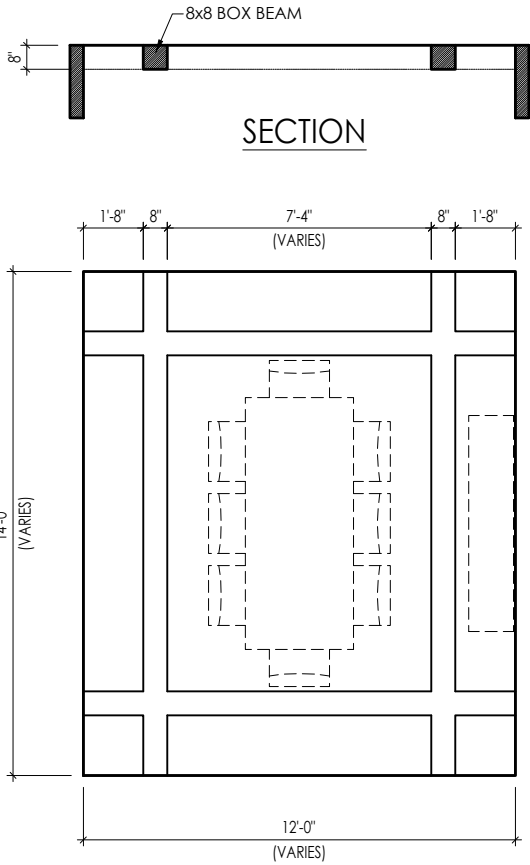


TYPICAL PLAN

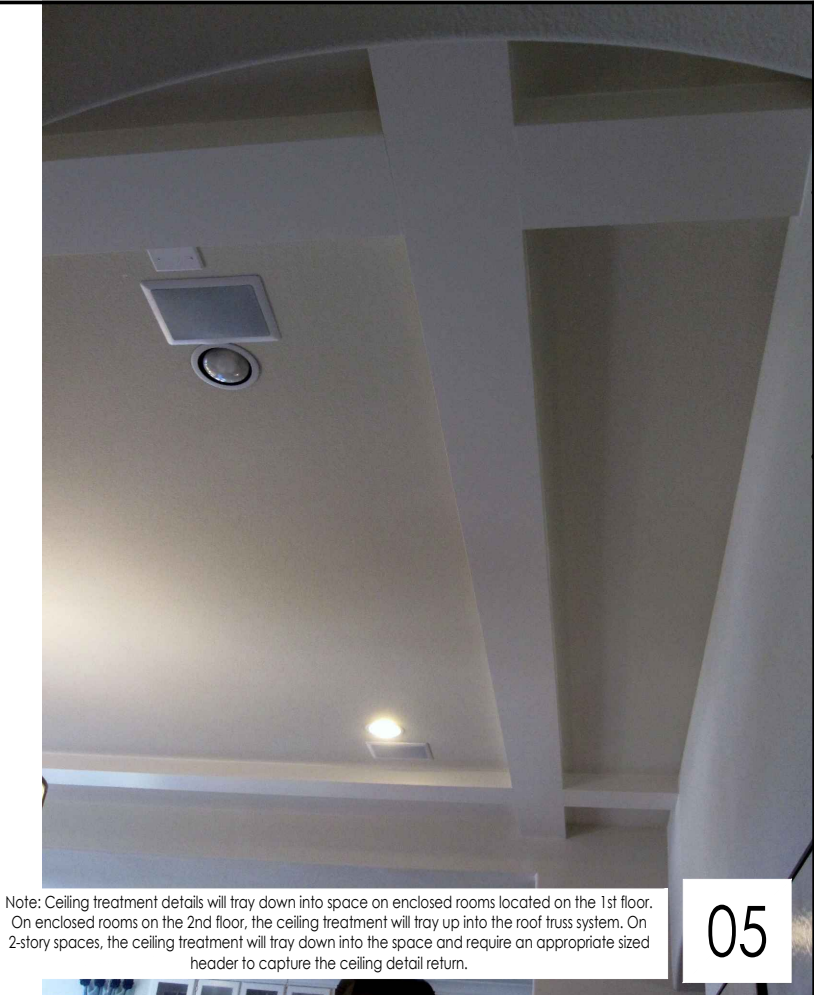

Note: Ceiling treatment details will tray down into space on enclosed rooms located on the 1st floor. On enclosed rooms on the 2nd floor, the ceiling treatment will tray up into the roof truss system. On 2-story spaces, the ceiling treatment will tray down into the space and require an appropriate sized header to capture the ceiling detail return.

05

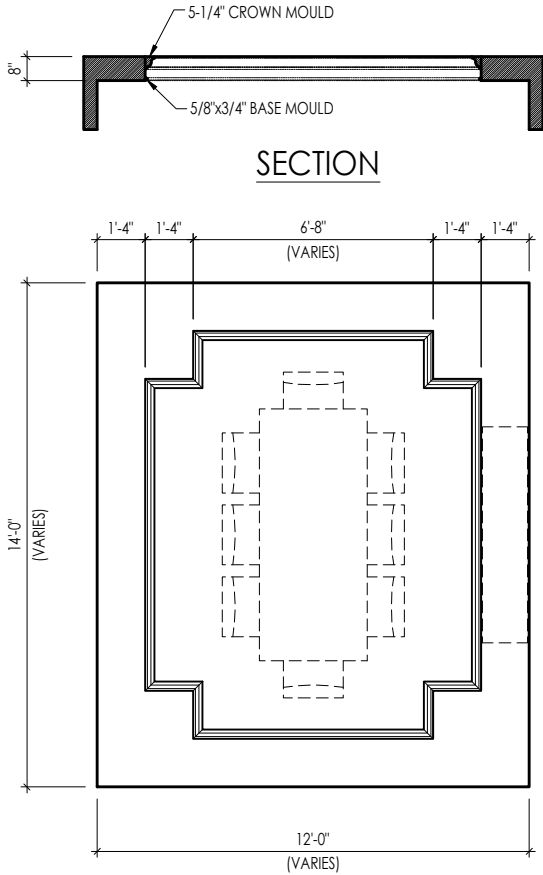


TYPICAL PLAN




Note: Ceiling treatment details will tray down into space on enclosed rooms located on the 1st floor. On enclosed rooms on the 2nd floor, the ceiling treatment will tray up into the roof truss system. On 2-story spaces, the ceiling treatment will tray down into the space and require an appropriate sized header to capture the ceiling detail return.

04

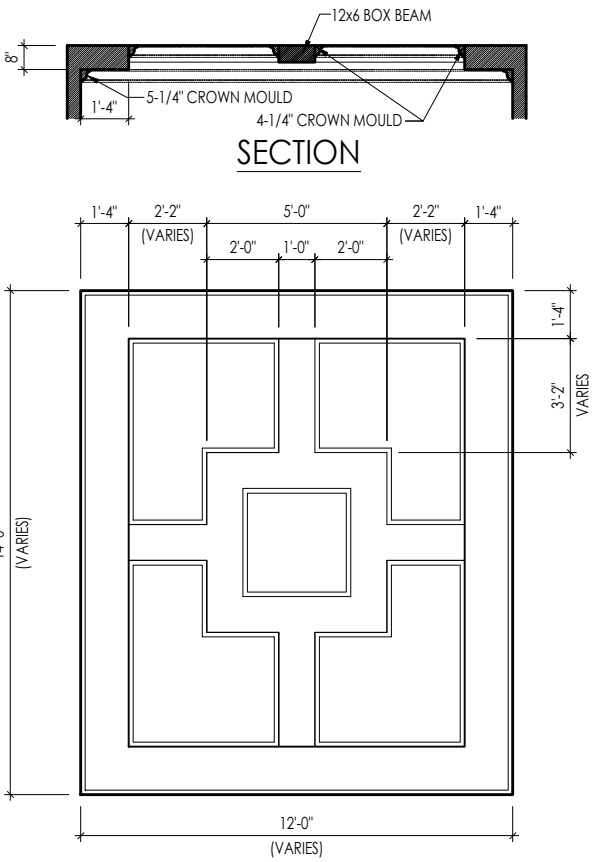

TYPICAL PLAN

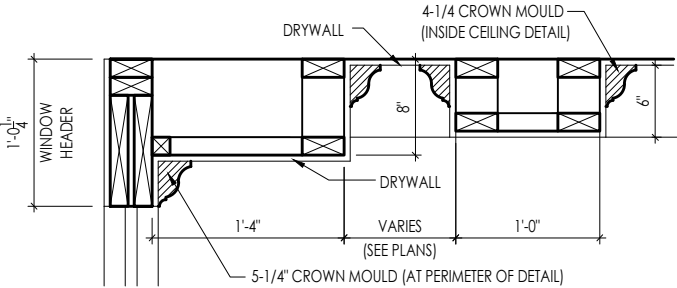

DETAIL




The Drees Company
08/12/2025 1:10:04 PM


Note: Ceiling treatment details will tray down into space on enclosed rooms located on the 1st floor. On enclosed rooms on the 2nd floor, the ceiling treatment will tray up into the roof truss system. On 2-story spaces, the ceiling treatment will tray down into the space and require an appropriate sized header to capture the ceiling detail return.

15

CEILING TREATMENTS
SCALE: AS NOTED

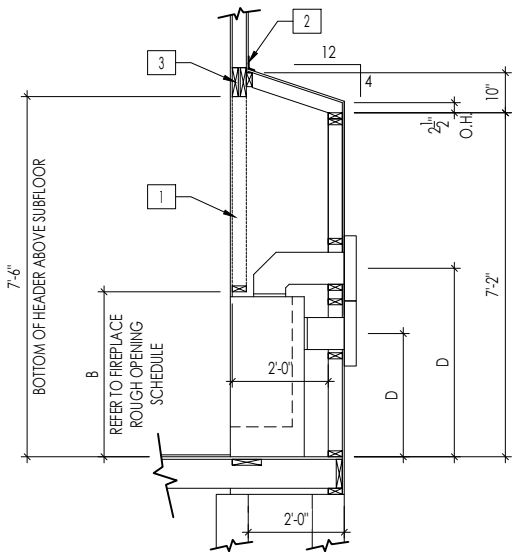


FRAMEWRAP
(SHOWN WITHOUT OPT. HEARTH)

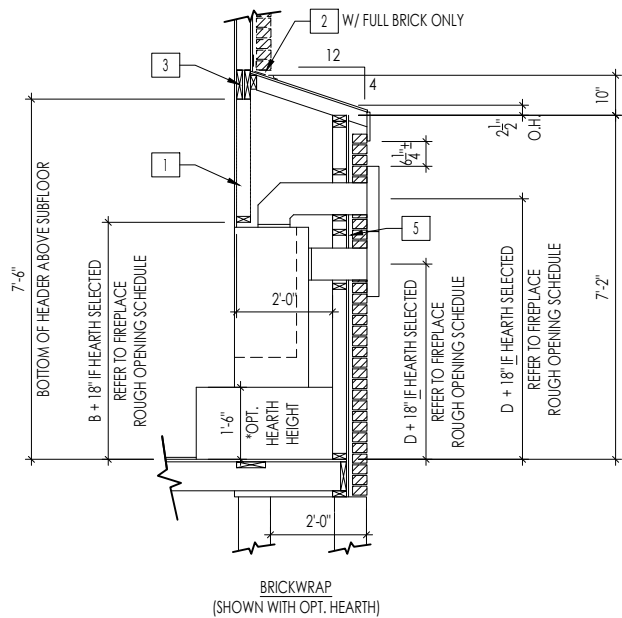

BRICKWRAP
(SHOWN WITH OPT. HEARTH)

FIREPLACE DOGHOUSE SECTIONS


SCALE: 1/4" = 1'-0"

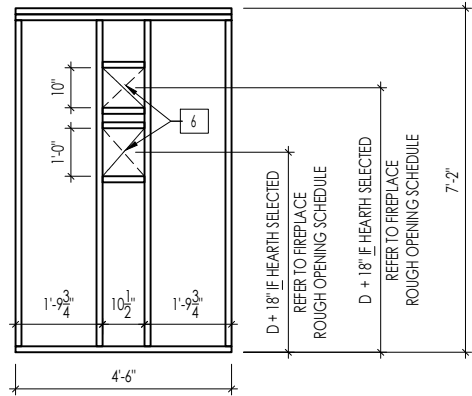

WITH HEARTH


DIRECT VENT REAR WALL FRAMING

SCALE: 1/4" = 1'-0"

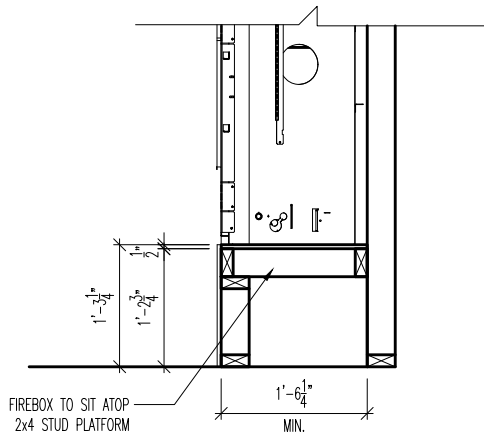

RAVE FIREPLACE PLATFORM DETAIL

SCALE: 1/2" = 1'-0"

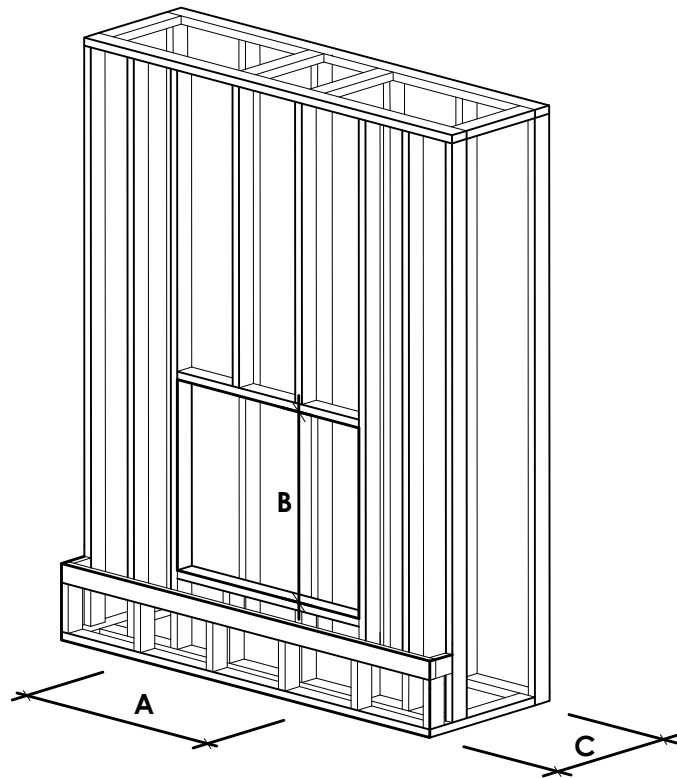

NOTE:
PROVIDE OSB SHEATHING WHEN
STONE VENEER SELECTED

FIREPLACE ROUGH OPENING SCHEDULE

FIREPLACE MANUFACTURER	MODEL	A	B	C	D
		(FIREBOX REQUIRED WIDTH)	(FIREBOX REQUIRED HEIGHT) *ADD 18" W/ OPT. HEARTH	(FIREBOX REQUIRED DEPTH - INTERIOR REAR WALL TO FRONT EXTERIOR WALL)	(VENT CENTERLINE HEIGHT) *ADD 18" W/ OPT. HEARTH
HEAT & GLO	SLIMLINE SL-7	42"	38-1/4"	16-1/4"	TOP 40" SIDE 26-7/8"
	COSMO 42	49"	32-3/4"	17-3/4"	TOP ONLY 47-1/16"
	NOVUS 33	39"	34-7/8"	19-5/8"	TOP 40" SIDE 23-1/2"
HEARTH & HOME	COURTYARD 36	43-3/8"	44-1/8"	18-3/8"	SEE MANUFACTURER'S SPECS
	COURTYARD 42	48-1/2"	34-1/4"	20-1/4"	SEE MANUFACTURER'S SPECS
	LANAI *(NOT IN CINCY/NKY)	57-3/4"	39-1/2"	17-5/8"	SEE MANUFACTURER'S SPECS
	RAVE	49"	32-3/4" *RAISED 15-1/4"	18-1/4"	TOP ONLY 46-1/2"
all dimensions are in inches					

General Notes

- REFER TO SHEET ON.1 FOR GENERAL NOTES.
- VERIFY FIREPLACE MODEL AND HEARTH SELECTION WITH CUSTOMER'S SELECTIONS.

Key Notes

- FUTURE FRAMING FOR F.P. OPENING AFTER INSULATION HAS BEEN INSTALLED IN EXT. WALLS
- FLASHING
- HEADER PER PLAN
-
- 1" AIRSPACE
- BOX OUT FOR FLUE (REFER TO SELECTIONS FOR FIREPLACE AND OPENING HEIGHT)



The Drees Company
08/12/2025 1:10:04 PM



The Drees Company

211 Grandview Drive Fort Mitchell, Kentucky 41017 PH:(859) 578-4200

Copyright © 2021, (2021) The Drees Company. All Rights Reserved. No portion of this material may be reproduced in any form or by any means, including photocopying, without the express written permission of the Drees Company. The Drees Company will vigorously prosecute any unauthorized use of this material.

FIREPLACE DETAILS

Std. Drawn By: MRP

Sheet Description:

SCALE: VARIES

Std. Date: 02.29.20

FIREPLACE DETAIL

Date of Last Rev: 7.10.2023

g:\architecture\cincinnati\cintl standard drawings\fireplace\fireplace detail sheets.dwg

Sheet No.

F-1

RALEIGH WINDOW SCHEDULE

*** MEETS EMERGENCY ESCAPE & RESCUE
OPENING REQUIREMENTS**

[illegible]

Drees Homes

Copyright © 2008, (2013) The Drees Company. All Rights Reserved. No portion of this material may be reproduced in any form or by any means, including photocopying, without the express written permission of the Drees Company. The Drees Company will vigorously prosecute any unauthorized use of this material.

Sheet Description:

WINDOW SCHEDULE

•

Sheet No.

SC-01

LAST REVISED 11/22/17

 Copyright © 2008, (2017) The Drees Company. All Rights Reserved. No portion of this material may be reproduced in any form or by any means, including photocopying, without the express written permission of the Drees Company. The Drees Company will vigorously prosecute any unauthorized use of this material.	Sheet Description:	Sheet No.
	MOULDED MILLWORK SCHEDULE	SC-02