



Square Footage	
FINISHED LOWER LEVEL (NET)	0
FIRST FLOOR (NET)	2798
SECOND FLOOR (GROSS) - VOLUME SPACE (GROSS)	949
SECOND FLOOR (NET)	0
TOTAL LIVING (NET)	949
UNFINISHED BASEMENT	0
UNFINISHED ATTIC STORAGE	80
GARAGE	802
COVERED FRONT PORCH	179
COVERED REAR PATIO	196
REAR DECK	0

PER ANSI Z765-2003

Redraws

Plan Review: 08/14/25

ADD MODEL SALES OFFICE, SHOW GARAGE BATH FIXTURES ON 1.01

Plan Review: 08/19/25

-ADDED WINDOW TRIM TO WINDOWS ON SIDES AND REAR
-ADDED 2FT OF BRICK WRAP AT FRONT CORNERS OF HOUSE
-CHANGED PRIMARY SUITE TRAY CLG TO DROP DOWN
-REMOVED 3040 S/H @ POCKET OFFICE

Plan Review: 8/26/25

REDRAW TO ADD WINDOW TO POCKET OFFICE, ADD REFRIGERATOR HOOK UP TO FAMILY READY ROOM

Division: Raleigh	
Building Code: 2018 NC Building Code - Residential	
Index to the Drawings	
Sheet No.	Sheet Name
0C.1	Cover Sheet
0N.1	General Notes
1.01	Foundation Plan
2.01F	First Floor Framing Plan
2.01S	First Floor Structural Plan
2.02F	Second Floor Framing Plan
2.02S	Second Floor Structural Plan
2.04	Roof Plan
3.01	First Floor Subfloor Plan
3.02	Second Floor Subfloor Plan
4.01	First Floor Mechanical Plan
4.02	Second Floor Mechanical Plan
5.01	Building Section
6.01	Front Elevation
6.02	Garage Side Elevation
6.03	Rear Elevation
6.04	Side Elevation
7.01	House Specific Details
7.02	House Specific Details
7.03	House Specific Details
7.04	House Specific Details



The Drees Company
09/10/2025 1:04:07 PM

RESIDENCE FOR:
MODEL
TBD
SERENITY HAVEN

Job Number: STYH-0124-00	Drawing Date: 8/4/2025	Coord Name: GREG P.	Coord Phone: 859.578.4355
House Name:			Drawn By: EWT
			Series:
			Plan No.:



7701 SIX FORKS ROAD, SUITE 132, RALEIGH, NC 27615
PHONE: (919) 844-9288

Sheet Information

0C.1
Cover Sheet
Elevation "K"

Architecture Plan Review: ☐ No Comments ☐ See Comments Items drawn on any drawings and not written in the contract selctions WILL NOT be included in the site specific drawings.			
Customer Request:	Design Solution:	Reason For Modification:	Comments:
1. Xxxxx	1. Xxxxx	1. Xxxxx	1. Xxxxx
2. Xxxxx	2. Xxxxx	2. Xxxxx	2. Xxxxx
3. Xxxxx	3. Xxxxx	3. Xxxxx	3. Xxxxx
4. Xxxxx	4. Xxxxx	4. Xxxxx	4. Xxxxx

Customer Plan Review Signature	
I understand that my new Drees home will be built in general comformance to the plans, specifications, selections and the Purchase Agreement, all of which I have reviewed and approved. This set of plans may not reflect the elevations or options for my house. Drees draws the standard plans complete with the most common options. The subcontractor's sets will show only the options I selected in my selection sheets. I have reviewed the plot plan for my house and understand that there may be some field adjustments as to the exact location of the house on the lot. I further understand that my home will not be built exactly like any other Drees home or Model and that some minor variations from my plans and specifications may occur since every home that is built has it's own set of unique construction problems that must be dealt with as the home is being built.	
Customer: _____	Date: _____
Customer: _____	Date: _____

GENERAL NOTES - RALEIGH

FOUNDATION NOTES

CRAWL SPACES:
- SLOPE CONCRETE SLAB 4" MINIMUM TOWARDS GARAGE DOOR
- EXTERIOR FLATWORK/GARAGES SHALL HAVE A MINIMUM CONCRETE SRENGTH OF 4,500 PSI
- FOOTINGS TO A MINIMUM CONCRETE STRENGTH OF 2500 PSI, UNLESS OTHERWISE NOTED
- ASSUMED ALLOWABLE SOIL BEARING PRESSURE: 2,000 p.s.f.
- WATERPROOF FOUNDATION WITH BITUMINOUS SPRAY.
- WALL TIES EMBEDDED IN THE HORIZONTAL MORTAR JOINT SHALL BE 16" ON CENTER. TIES IN ALTERNATE COURSES SHALL BE STAGGERED. THE MAXIMUM VERTICAL DISTANCE BETWEEN TIES SHALL NOT EXCEED 16" AND THE MAXIMUM HORIZONTAL DISTANCE SHALL NOT EXCEED 16" ADDITIONAL TIES SHALL BE PROVIDED AT ALL OPENINGS, AND WITHIN 12" OF THE OPENING.
- CORE FILL ENTIRE BLOCK WALL WHEN THE WALL IS 4'-0" TALL OR HIGHER. INSTALL #4 REBAR IN EACH HOLLOW AREA OF EACH BLOCK FROM FOOTING TO TOP OF WALL, ON THE ENTIRE WALL PRIOR TO CORE FILLING IT.
- TOP COURSE OF BLOCK ON ALL WALLS WILL BE FILLED SOLID WITH MORTAR PLACING THE FOUNDATION STRAPS OR BOLTS IN THE MORTAR 6'-0" ON CENTER, AND 12" FROM EACH CORNER.
- 12"x16" PIERS: HOLLOW MASONRY UP TO 48" HIGH, SOLID MASONRY UP TO 9'0" HIGH
- 16"x16" PIERS: HOLLOW MASONRY UP TO 64" HIGH, SOLID MASONRY UP TO 120" HIGH
- BLOCK PIERS SHOULD BE PLACED DIRECTLY ON CONCRETE FOOTINGS PER PLAN. THEY SHOULD BE PLUMBED AND SQUARE WITHIN 1/4".
- SILL PLATES TO BE A MINIMUM OF 2x4 NOMINAL LUMBER.

FRAMING NOTES

DESIGN LOADS:
FLOORS: 40 psf LIVE LOAD + 10 psf DEAD LOAD = 50 psf GARAGE FLOOR: 50 psf LIVE LOAD SEISMIC: "A" & "B"
ROOF: 18 psf LIVE LOAD + 17psf DEAD LOAD = 35 psf WIND SPEED: 120 MPH
DESIGN DEFLECTION LIMITS (BASED ON LIVE LOAD, EXCEPT MASONRY):
RAFTERS GREATER THAN 3:12 L/180 CEILINGS L/240
MASONRY VENEER L/600
NOMINAL LUMBER FLOORS: L/360
MANUFACTURED WOOD FLOORS: DESIGNED TO MINIMUM PRO RATING OF 35 (OR EQUIVALENT). NO MORE THAN 8 POINT DIFFERENCE BETWEEN ADJACENT SPANS.
L/480 FOR SPANS UP TO 16'-0" AND NO GREATER THAN 1/2" DEFLECTION
L/600 FOR SPANS OVER 16'-0" IF SIMPLE SPAN AND NO GREATER THAN 1/2" DEFLECTION
L/840 FOR SPANS OVER 16'-0" IF CONTINUOUS SPAN. AND NO GREATER THAN 1/2" DEFLECTION
-JOIST SPACING: 19.2" o.c. MAXIMUM SPACING
DOUBLE EVERY OTHER FLOOR JOIST UNDER KITCHEN ISLANDS
INSTALL UNCOUPLING MEMBRANE IN TILE FLOOR AREAS IF 19.2" o.c. FLOOR JOIST SPACING
GLUE AND MECHANICALLY FASTEN [SCREWS] WOOD FLOOR IF 19.2" o.c. FLOOR JOIST SPACING
- MANUFACTURED WOOD PRODUCTS (INCLUDING, BUT NOT LIMITED TO, STRUCTURAL WOOD BEAMS AND I-JOISTS) SHALL BE FABRICATED, HANDLED, AND INSTALLED IN ACCORDANCE WITH THE MANUFACTURER'S INSTRUCTIONS.
- JOISTS ARE NOT TO BE PLACED DIRECTLY OVER INTERIOR PARALLEL WALLS. (TO PREVENT UNEVEN FLOOR DEFLECTION FROM OCCURRING)
- ALL WOOD BEAMS/HEADERS: 2x6's TO BE SPF STUD GRADE OR BETTER/ 2x8 OR LARGER TO BE SYP #2 [PER NDS 2012] OR BETTER, U.O.N.
- ALL HEADERS SHALL BE SUPPORTED BY (1) 2x JACK STUD AND (1) 2x KING STUD MINIMUM. THE NUMBER OF STUDS SPECIFIED AT A SUPPORT INDICATES THE NUMBER OF JACKS REQUIRED, U.N.O. AT FLUSH OR DROPPED BEAMS, THE NUMBER OF STUDS SPECIFIED INDICATES THE TOTAL NUMBER OF STUDS REQUIRED TO SUPPORT THE BEAM.
- EXTERIOR WALLS TO BE 2x4 SPF STUD GRADE AT 16" o.c. UNLESS OTHERWISE NOTED (10'4-1/2" MAXIMUM WALL HEIGHT)
- ALL INTERIOR BEARING WALLS AND WALLS AT BASEMENT & FIRST FLOOR STAIRWELLS, KITCHEN, BATH, & GARAGE TO BE 2x4 SPF STUD GRADE @ 16" o.c.; ALL OTHER NON-BEARING INTERIOR WALLS TO BE 2x4 SPF STUD GRADE @ 24" o.c. U.O.N.
- ALL WALLS TO BE 3 1/2" UNLESS OTHERWISE NOTED.
- PROVIDE SOLID BEARING TO FOUNDATION OR BEAM BELOW FOR ALL BEAMS, HEADERS & GIRDER TRUSSES. PROVIDE BLOCKING BETWEEN JOISTS AS REQUIRED.
- SEE SELECTION SHEET FOR SIZE AND STYLE OF FIREPLACE. SEE FIREPLACE ELEVATION DETAIL FOR ADDITIONAL FRAMING REQUIREMENTS, IF ANY.
- CHECK SELECTION SHEETS FOR FLOOR COVERING AT TOP AND BOTTOM OF STAIR RISERS AND ADJUST RISERS AS REQ'D.
- PROVIDE BLOCKING AT ALL HANDRAIL TERMINATION AND BRACKET LOCATIONS.
- 20-MINUTE FIRE RATED DOOR BETWEEN GARAGE AND LIVING AREA.
- EXTERIOR WALL TO BE 2x4 SPF STUD G AT 16" o.c. UNLESS OTHERWISE NOTED (10'-0" MAXIMUM UNBRACED WALL HEIGHT).
- ALL EXTERIOR WALLS AND INTERIOR BEARING WALLS, FRAMED HIGHER THAN THE STANDARD PLATE HEIGHT, SHALL BE FRAMED WITH CONTINUOUS FULL HEIGHT STUDS TO THE HIGHEST CEILING (I.E. NO INTERMEDIATE BREAKS) TO PREVENT LATERAL HINGE CONDITIONS.
- IN THE GARAGE, PROVIDE 1/2" GYP. BOARD AT ALL WALLS COMMON TO LIVING SPACE AND ALL STRUCTURAL MEMBERS SUPPORTING FLOOR/CEILING ASSEMBLY. GARAGE CEILING TO BE 1/2" SAG RESISTANT GYP. BOARD WHEN THERE ARE NO HABITABLE SPACES ABOVE, OR 5/8" TYPE X GYP. BOARD WHEN HABITABLE SPACES ARE ABOVE.
- ALL EMERGENCY ESCAPE & RESCUE OPENINGS TO BE A MAXIMUM OF 44" OFF OF FINISHED FLOOR AND HAVE MINIMUM OPENING DIMENSIONS OF 24" IN HEIGHT, 20" IN WIDTH, & HAVE A MINIMUM OPENING AREA OF 5.7 S.F.
ALL DOORS TO BE 6'-8" TALL UNLESS OTHERWISE NOTED.
- ALL GLASS IN INTERIOR AND EXTERIOR DOORS TO BE TEMPERED (INCLUDING SIDELITES AND TRANSOMS)
- ALL LUMBER CONTACTING CONCRETE TO BE PRESSURE TREATED.
- ALL FASTENERS, HANGERS, AND OTHER CONNECTORS TO BE USED WITH PRESSURE TREATED WOOD ARE TO HAVE ZMAX COATING (OR EQUIVALENT) HOT-DIPPED GALVANIZED OR STAINLESS STEEL.
- AT STAIR HANDRAIL, ON ONE SIDE ONLY, SHALL BE CONTINUOUS FOR THE ENTIRE LENGTH OF THE STAIRWAY, AND ENDS SHALL BE RETURNED TO A WALL OR POST. THE HANDRAIL MAY BE INTERRUPTED AT A NEWEL POST AT A TURN.
- ALL HANDRAIL GRIP PORTIONS SHALL NOT EXCEED 2-1/4" IN CROSS SECTIONAL DIMENSION.
- HANDRAILS SHALL BE INSTALLED ON ALL STAIRS WITH 4 OR MORE RISERS, HANDRAIL HEIGHTS SHALL BE A MINIMUM OF 34" AND A MAXIMUM OF 38".
- ALL STAIRS TO BE CONSTRUCTED SO AS NOT TO ALLOW A 4" SPHERE TO PASS THROUGH THE RISER.
- GUARDRAILS MUST BE A MINIMUM OF 36" HIGH. GUARDRAILS AT THE OPEN SIDES OF STAIRS MUST BE A MINIMUM OF 34" HIGH MEASURED VERTICALLY FROM THE NOSING AT THE TREADS. THE HORIZONTAL SPACING OF THE VERTICAL BALUSTERS SHALL BE 4" O.C.
- GUARDRAIL DESIGN TO RESIST A MINIMUM OF 200 LBS LATERAL FORCE

BASEMENTS:
- SLOPE CONCRETE SLAB 4" MINIMUM TOWARDS GARAGE DOOR
- EXTERIOR FLATWORK/GARAGES SHALL HAVE A MINIMUM CONCRETE SRENGTH OF 4,500 PSI
- FOOTINGS TO A MINIMUM CONCRETE STRENGTH OF 2500 PSI, UNLESS OTHERWISE NOTED- ALL FOUNDATION WALLS TO BE CAST IN PLACE CONCRETE 3000 PSI MIN. UNLESS OTHERWISE NOTED.
- BASEMENT WINDOW LOCATIONS MAY VARY FROM DRAWING DUE TO LOT CONDITIONS.
- BACKFILL ADJACENT TO FOUNDATION WALLS SHALL NOT BE PLACED UNTIL THE WALL HAS SUFFICIENT STRENGTH AND HAS BEEN ANCHORED TO THE FLOOR OR HAS BEEN SUFFICIENTLY BRACED TO PREVENT DAMAGE BY THE BACKFILL.
- ASSUMED ALLOWABLE SOIL BEARING PRESSURE: 2,000 p.s.f.
- WATERPROOF FOUNDATION WITH BITUMINOUS SPRAY.
- VERTICAL CONTROL JOINTS IN BASEMENT FOUNDATION WALLS - STANDARD LOCATION GUIDELINES:
1) PLACE A CONTROL JOINT IN ALL UNBRACED WALLS OVER 30' IN LENGTH. (NOTE: "T" WALLS AND CORNERS COUNT AS A BRACE).
2) WINDOWS THAT ARE LARGER THAN THE STANDARD BASEMENT WINDOW REQUIRE A CONTROL JOINT.
3) CONTROL JOINTS ARE NOT REQUIRED AT EVERY WINDOW THAT IS STANDARD SIZE.
4) IF THERE IS A STANDARD WINDOW LOCATED IN A WALL SEGMENT THAT REQUIRES A CONTROL JOINT, THEN THE CONTROL JOINT SHOULD BE PLACED ON THE SIDE OF THE WINDOW THAT IS ADJACENT TO THE LONG SIDE OF THE WALL. IF THERE IS MORE THAN ONE WINDOW IN A WALL THEN ONLY ONE WINDOW SHOULD HAVE A CONTROL JOINT.
5) DOORS DO NOT GET CONTROL JOINTS.
6) CONTROL JOINTS SHOULD NOT BE LOCATED WITHIN 3' OF A BEAM POCKET.
7) CONTROL JOINTS ARE REQUIRED AT THE FIRST AND LAST STEP DOWN AT STEPPED BASEMENT FOUNDATION WALLS.
- INTERIOR FLATWORK SHALL HAVE A MINIMUM CONCRETE STRENGTH OF 3,000 PSI.
- ALL VERTICAL STEEL AND ALL STEEL IN STRUCTURAL SLABS TO BE GRADE 60. ALL HORIZONTAL STEEL IN FOUNDATION WALLS AND FOOTERS TO BE GRADE 40 STEEL.

SLAB ON GRADE:
- ALL CONCRETE SLABS ON GRADE SHALL BE THE THICKNESS AS INDICATED ON THE DETAILS OVER MINIMUM 6 MIL. POLYETHYLENE (VISQUEEN) VAPOR BARRIER. SLABS SHALL BE REINFORCED WITH 6x6 W1.4 WWF LAPPED 8" AT EDGES AND ENDS IN CONFORMANCE WITH ASTM-A 185, OR FIBERMESS REINFORCEMENT SHALL BE USED WITH A MINIMUM FIBER LENGTH OF 1/2" TO 2 1/2" COMPLYING WITH ASTM C 1116. THE DOSAGE AMOUNT SHALL BE 0.75 TO 3.0 POUNDS PER CUBIC YARD IN ACCORDANCE WITH MANUFACTURER'S RECOMMENDATIONS.
- SLABS ON GRADE SHALL BEAR ON STRUCTURAL FILL WHICH SHALL BE CLEAN SAND FREE OF DEBRIS AND OTHER DELETERIOUS MATERIAL. STRUCTURAL FILL SHALL BE COMPACTED TO A DENSITY OF AT LEAST 95% OF THE MODIFIED PROCTOR MAXIMUM DRY DENSITY (ASTM D1557). TERMITE PROTECTION SHALL BE PROVIDED IN ACCORDANCE WITH APPLICABLE CODE REQUIREMENTS. IF SOIL TREATMENT IS USED, THE TREATMENT SHALL BE DONE AFTER ALL EXCAVATION, BACKFILLING, AND COMPACTION IS COMPLETED.
- FOOTINGS MAY BEAR UPON UNDISTURBED SOIL OR UPON STRUCTURAL FILL. STRUCTURAL FILL SHALL BE COMPACTED TO A DENSITY OF AT LEAST 95% OF THE MODIFIED PROCTOR MAXIMUM DRY DENSITY (ASTM D1557) FOR A DEPTH OF AT LEAST TWO FEET (2'-0") BELOW THE BOTTOM OF THE FOOTING.
- THE FOLLOWING MINIMUM CONCRETE COVER SHALL BE PROVIDED FOR REINFORCEMENT:
3" CONCRETE CAST AGAINST AND PERMANENTLY EXPOSED TO EARTH
2" CONCRETE EXPOSED TO EARTH AND WEATHER
1 1/2" CONCRETE NOT EXPOSED TO EARTH OR WEATHER
- SLOPE CONCRETE SLAB 4" MINIMUM TOWARDS GARAGE DOOR
- EXTERIOR FLATWORK/GARAGES SHALL HAVE A MINIMUM CONCRETE SRENGTH OF 4,500 PSI
- ASSUMED ALLOWABLE SOIL BEARING PRESSURE: 2,000 p.s.f.
- INTERIOR FLATWORK SHALL HAVE A MINIMUM CONCRETE STRENGTH OF 3,000 PSI.
- ALL STEEL IN STRUCTURAL SLABS TO BE GRADE 60. ALL HORIZONTAL STEEL IN FOUNDATION WALLS AND FOOTERS TO BE GRADE 40 STEEL.

MECHANICAL/ELECTRICAL NOTES

- ANY GAS APPLIANCES MUST BE INSTALLED PER MANUFACTURER'S SPECIFICATIONS.
- HOLD THE CENTERLINE OF ALL EXTERIOR LIGHT FIXTURES AT 5'-8" OFF BOTTOM OF DOOR OPENING.
- ALL KITCHEN CABINET DIMENSIONS ARE CABINET TO CABINET.
- CABINET STYLES MAY VARY FROM INTERIOR ELEVATIONS DEPENDING ON STYLE, MANUFACTURER, ETC. FOR CABINET DETAILS SEE SHOP DRAWINGS.
- CABINET SIZES MAY VARY WITH FULL-OVERLAY CABINETS.
- GROUND FAULT INTERRUPTER (GFCI) OUTLETS TO BE INSTALLED PER NEC 2017, SECT. 210.8
- PROVIDE HOSE BIBS PER DIVISION SPEC. SHEET. EXACT LOCATION TO BE FIELD DETERMINED UNLESS OTHERWISE NOTED ON THE PLANS.
- MIN. 50 C.F.M. FOR ALL EXHAUST FANS IN BATHROOMS

INSULATION DETAILS
EXTERIOR STUD WALL CAVITY: (2x4) R-15
(2x6) R-19
FLOOR JOIST CAVITY AT STANDARD PERIMETER: R-19
FLOOR JOIST CAVITY AT CANTILEVER: R-19
OVER GARAGE: (OVER HORIZONTAL SPACE) R-38 BLOWN
(SLOPED AND VERTICAL SPACE) R-38 BATT

ELEVATION NOTES

- WINDOW STYLE AND MULLIONS MAY VARY FROM ELEVATION DEPENDING UPON MANUFACTURER, STYLE, PATTERN, TYPE, ETC.
- USE SECONDARY HEAT BARRIER ON ALL DIRECT VENT FIREPLACES 7' OR LESS ABOVE A WALKWAY.
- GRADE AWAY FROM FOUNDATION WALLS SHALL FALL A MINIMUM OF 6" WITHIN THE FIRST 10'.
- PROVIDE TYVEK OR EQUIVALENT HOUSE WRAP BEHIND BRICK AND STONE VENEER OVER WOOD SHEATHING.
- PROVIDE BRICK WEEP HOLES AT 24" O.C. WITH BRICK VENEER AND MORTAR NET BEHIND AND THROUGH WEEP HOLES.
- PROVIDE FLASHING AND WEEP HOLES ABOVE ALL BRICK ANGLE IRONS, BELOW ALL BRICK SILLS AND ABOVE SILL PLATE SEALERS.
- EXTERIOR STEPS TO HAVE A MAXIMUM 8" RISER. WHEN VERTICAL RISE EXCEEDS 30" OR FOUR OR MORE CONTINUOUS RISERS, A HANDRAIL IS REQUIRED.

ROOF PLAN NOTES

- ALL OVERHANGS TO HAVE (2) SOFFIT VENTS PER EACH 8' SOFFIT SECTION.
- PROVIDE BAFFLES AT EXTERIOR TRUSS BEARING FOR VENTILATION.
- PROVIDE 15# FELT PAPER UNDER SHINGLES.

Subdivision: SERENITY HAVEN		Customer Name: MODEL	
Job #: STYH-0124-00		Job Address: TBD	
Contract Drawn By: EW		Original Site Specific Dwg. & Effective Change Order Date: 8/4/2025	
Phone #:			
Coordinator's Name: GREG P.			
Coordinator's Phone #: 859-578-4355			
RGA-0443-00.dwg Aug 04, 2025 - 4:10pm			



Drees Homes

8521 Six Forks Road, Suite 500, Raleigh, NC 27615 PH:(919) 844-9288

Copyright ©, 2015, (2012) The Drees Company. All Rights Reserved. No portion of this material may be reproduced in any form or by any means, including photocopying, without the express written permission of the Drees Company. The Drees Company will vigorously prosecute any unauthorized use of this material.

SCALE: N/A

Sheet Description:

GENERAL NOTES

Std. Drawn By:

WLS

Std. Chk. By:

ARC

Std. Date:

8/31/12

Date of Last Rev:

REL_D1

House:

SEBASTIAN


Series:

Plan No.:

Sheet No.

ON.1

SEE SHEET ON.1 FOR VERTICAL FOUNDATION WALL
CONTROL JOINT LOCATION GUIDELINES.

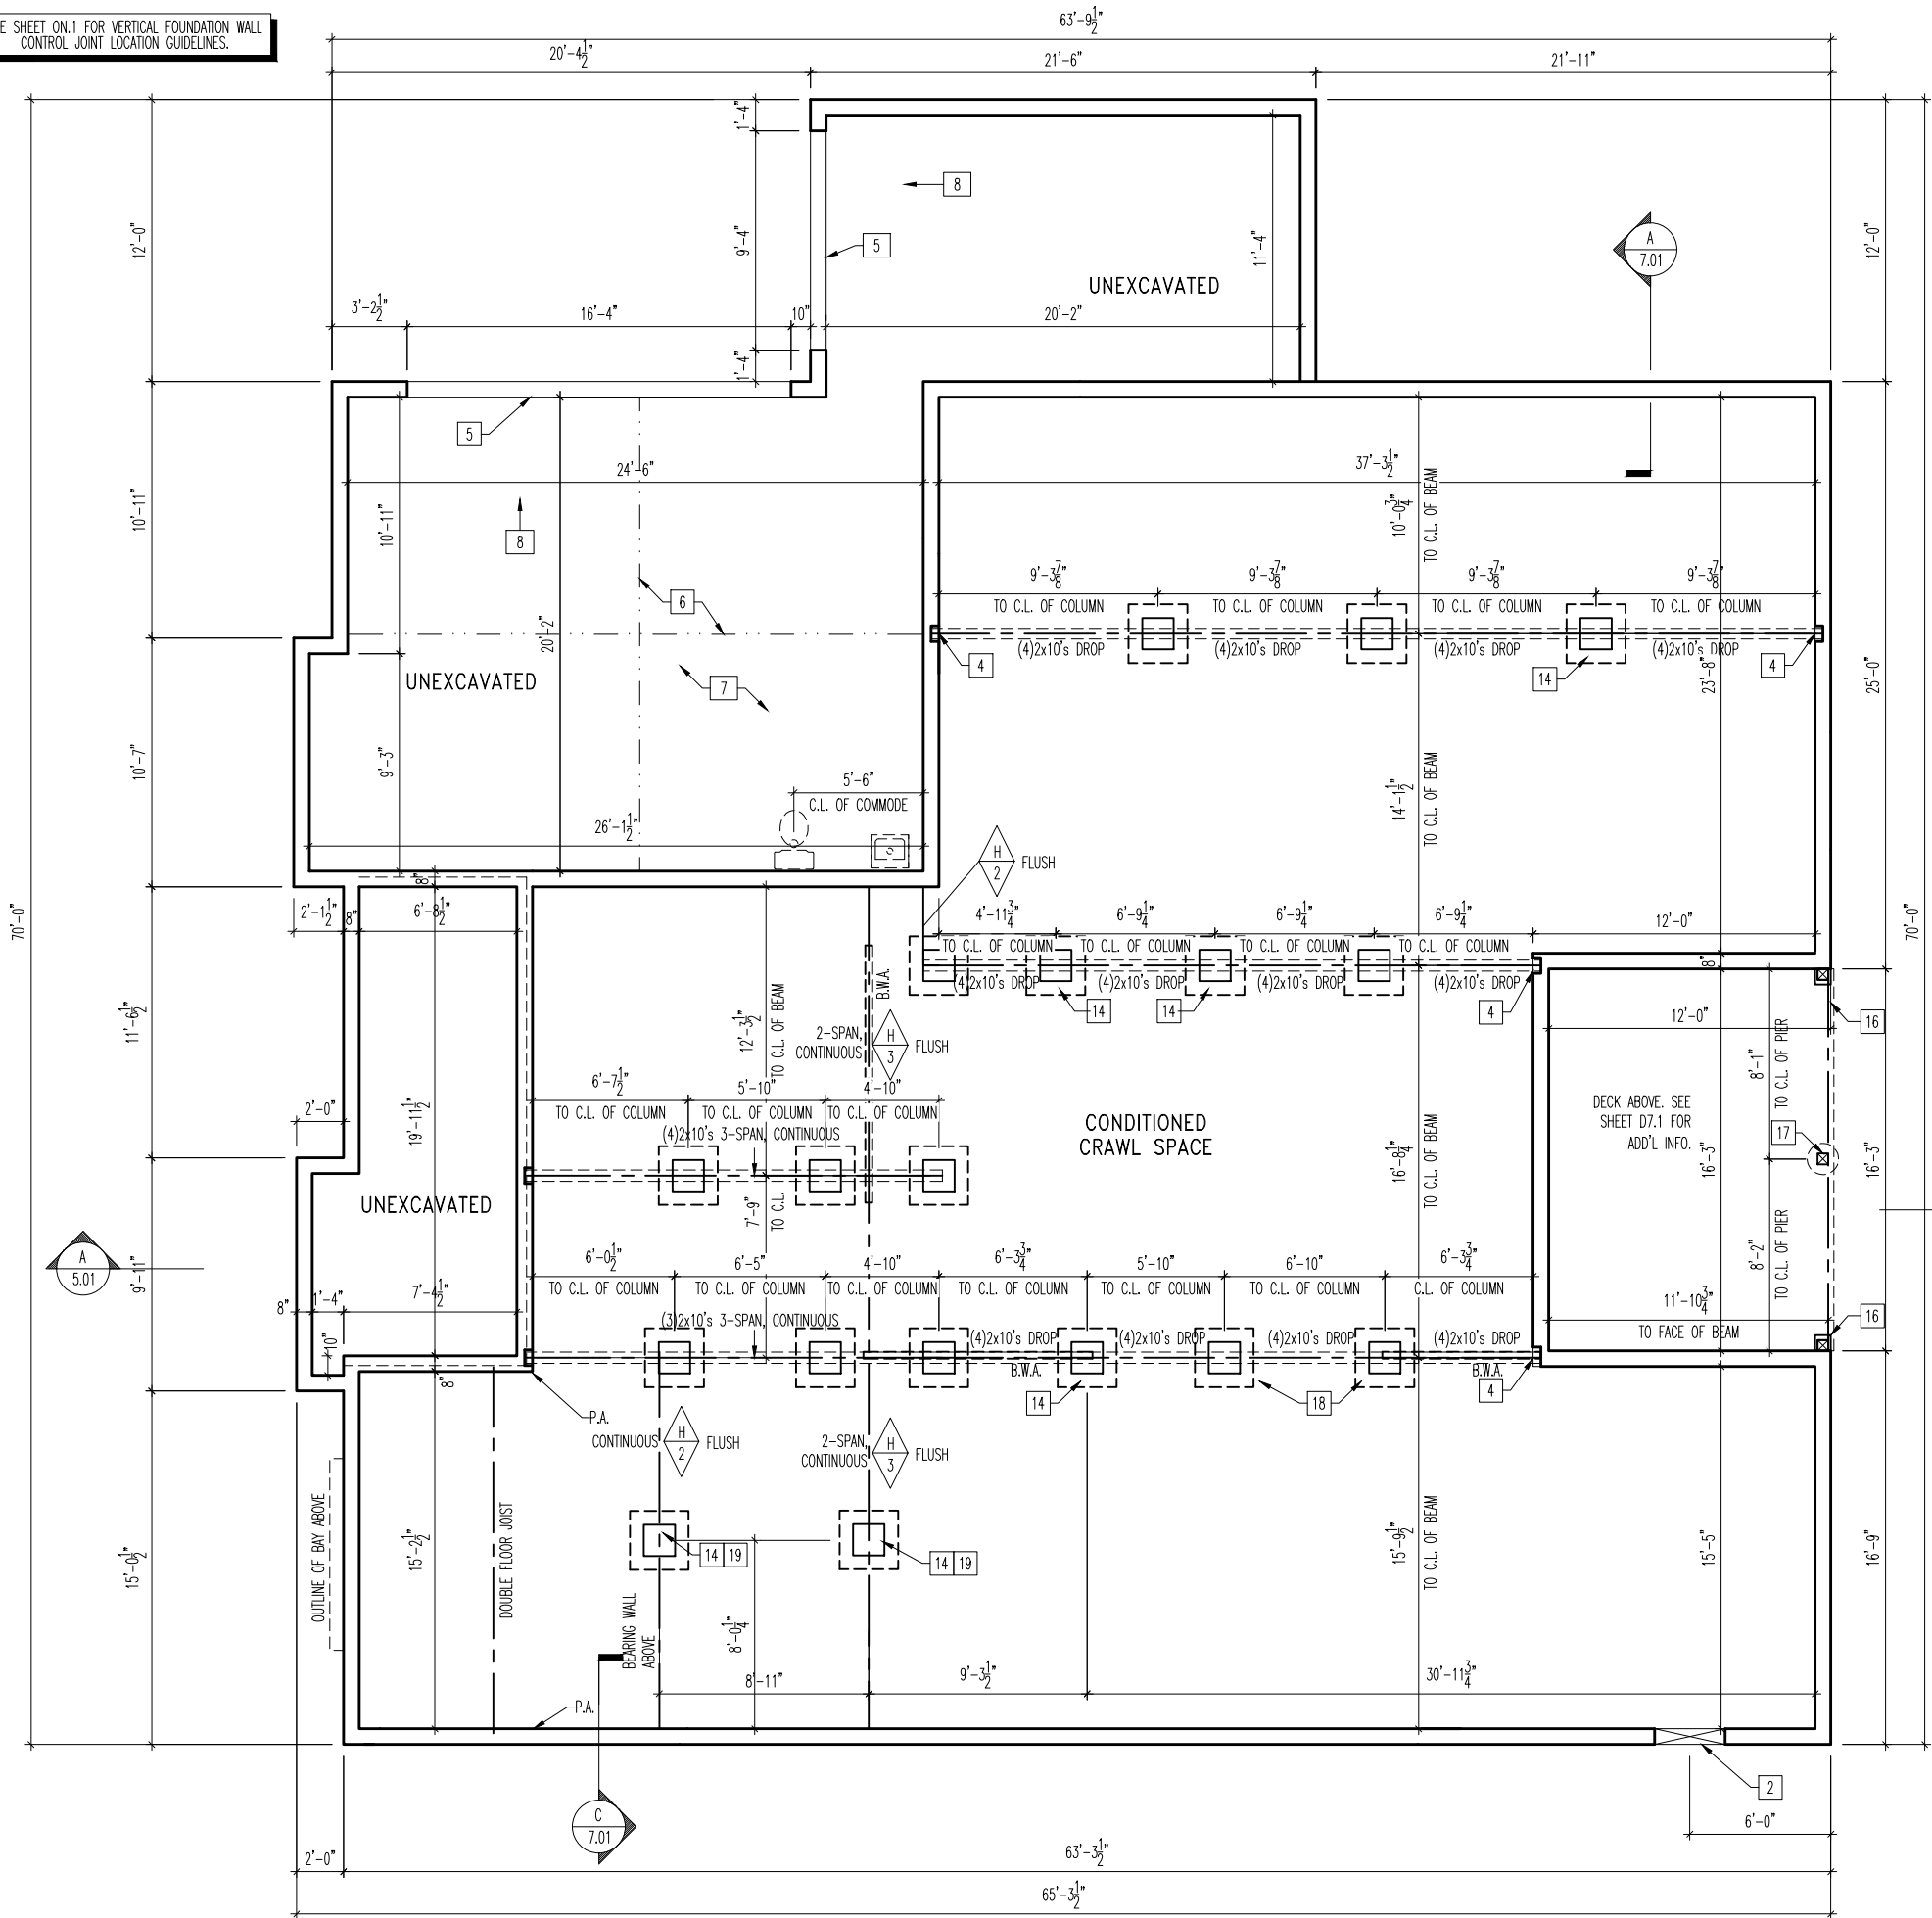

General Notes

- REFER TO SHEET ON.1 FOR GENERAL NOTES
- ALL FOUNDATION WALLS WITH SIDING ABOVE TO BE 8" BLOCK W/ 8" SOLID CAP
- ALL WALLS TO HAVE 18"Wx8"D CONTINUOUS FOOTING UNLESS OTHERWISE NOTED
- 12"x16" PIERS: HOLLOW MASONRY UP TO 48" HIGH, SOLID MASONRY UP TO 9'0" HIGH
- 16"x16" PIERS: HOLLOW MASONRY UP TO 64" HIGH, SOLID MASONRY UP TO 12'0" HIGH

Key Notes

- 1
- 2
- 3
- 4
- 5
- 6
- 7
- 8
- 9
- 10
- 11
- 12
- 13
- 14
- 15
- 16
- 17
- 18
- 19
- 20



The Drees Company
09/10/2025 1:04:08 PM

Subdivision: SERENITY HAVEN	Customer Name: MODEL
Job #: STYH-0124-00	Job Address: TBD
Contract Drawn By: Phone #:	Original Site Specific Dwg. & Effective Change Order Date:
Coordinator's Name: Coordinator's Phone #:	8/4/2025
RCA-0443-00.dwg Aug 14, 2025 - 3:56pm	

Drees
HOMES™

Drees Homes

8521 Six Forks Road, Suite 500, Raleigh, NC 27615 PH(919) 844-9288

Copyright © 2015, (2012) The Drees Company. All Rights Reserved. No portion of this material may be reproduced in any form or by any means, including photocopying, without the express written permission of the Drees Company. The Drees Company will vigorously prosecute any unauthorized use of this material.

SCALE: 1/8" = 1'-0"


Sheet Description:
FOUNDATION PLAN
ELEVATION "K"

Std. Drawn By:	WJS
Std. Chk. By:	ARC
Std. Date:	8/31/12
Date of Last Rev:	10/27/16 WJS

SEBASTIAN
House:
Series:

Sheet No.

1.01

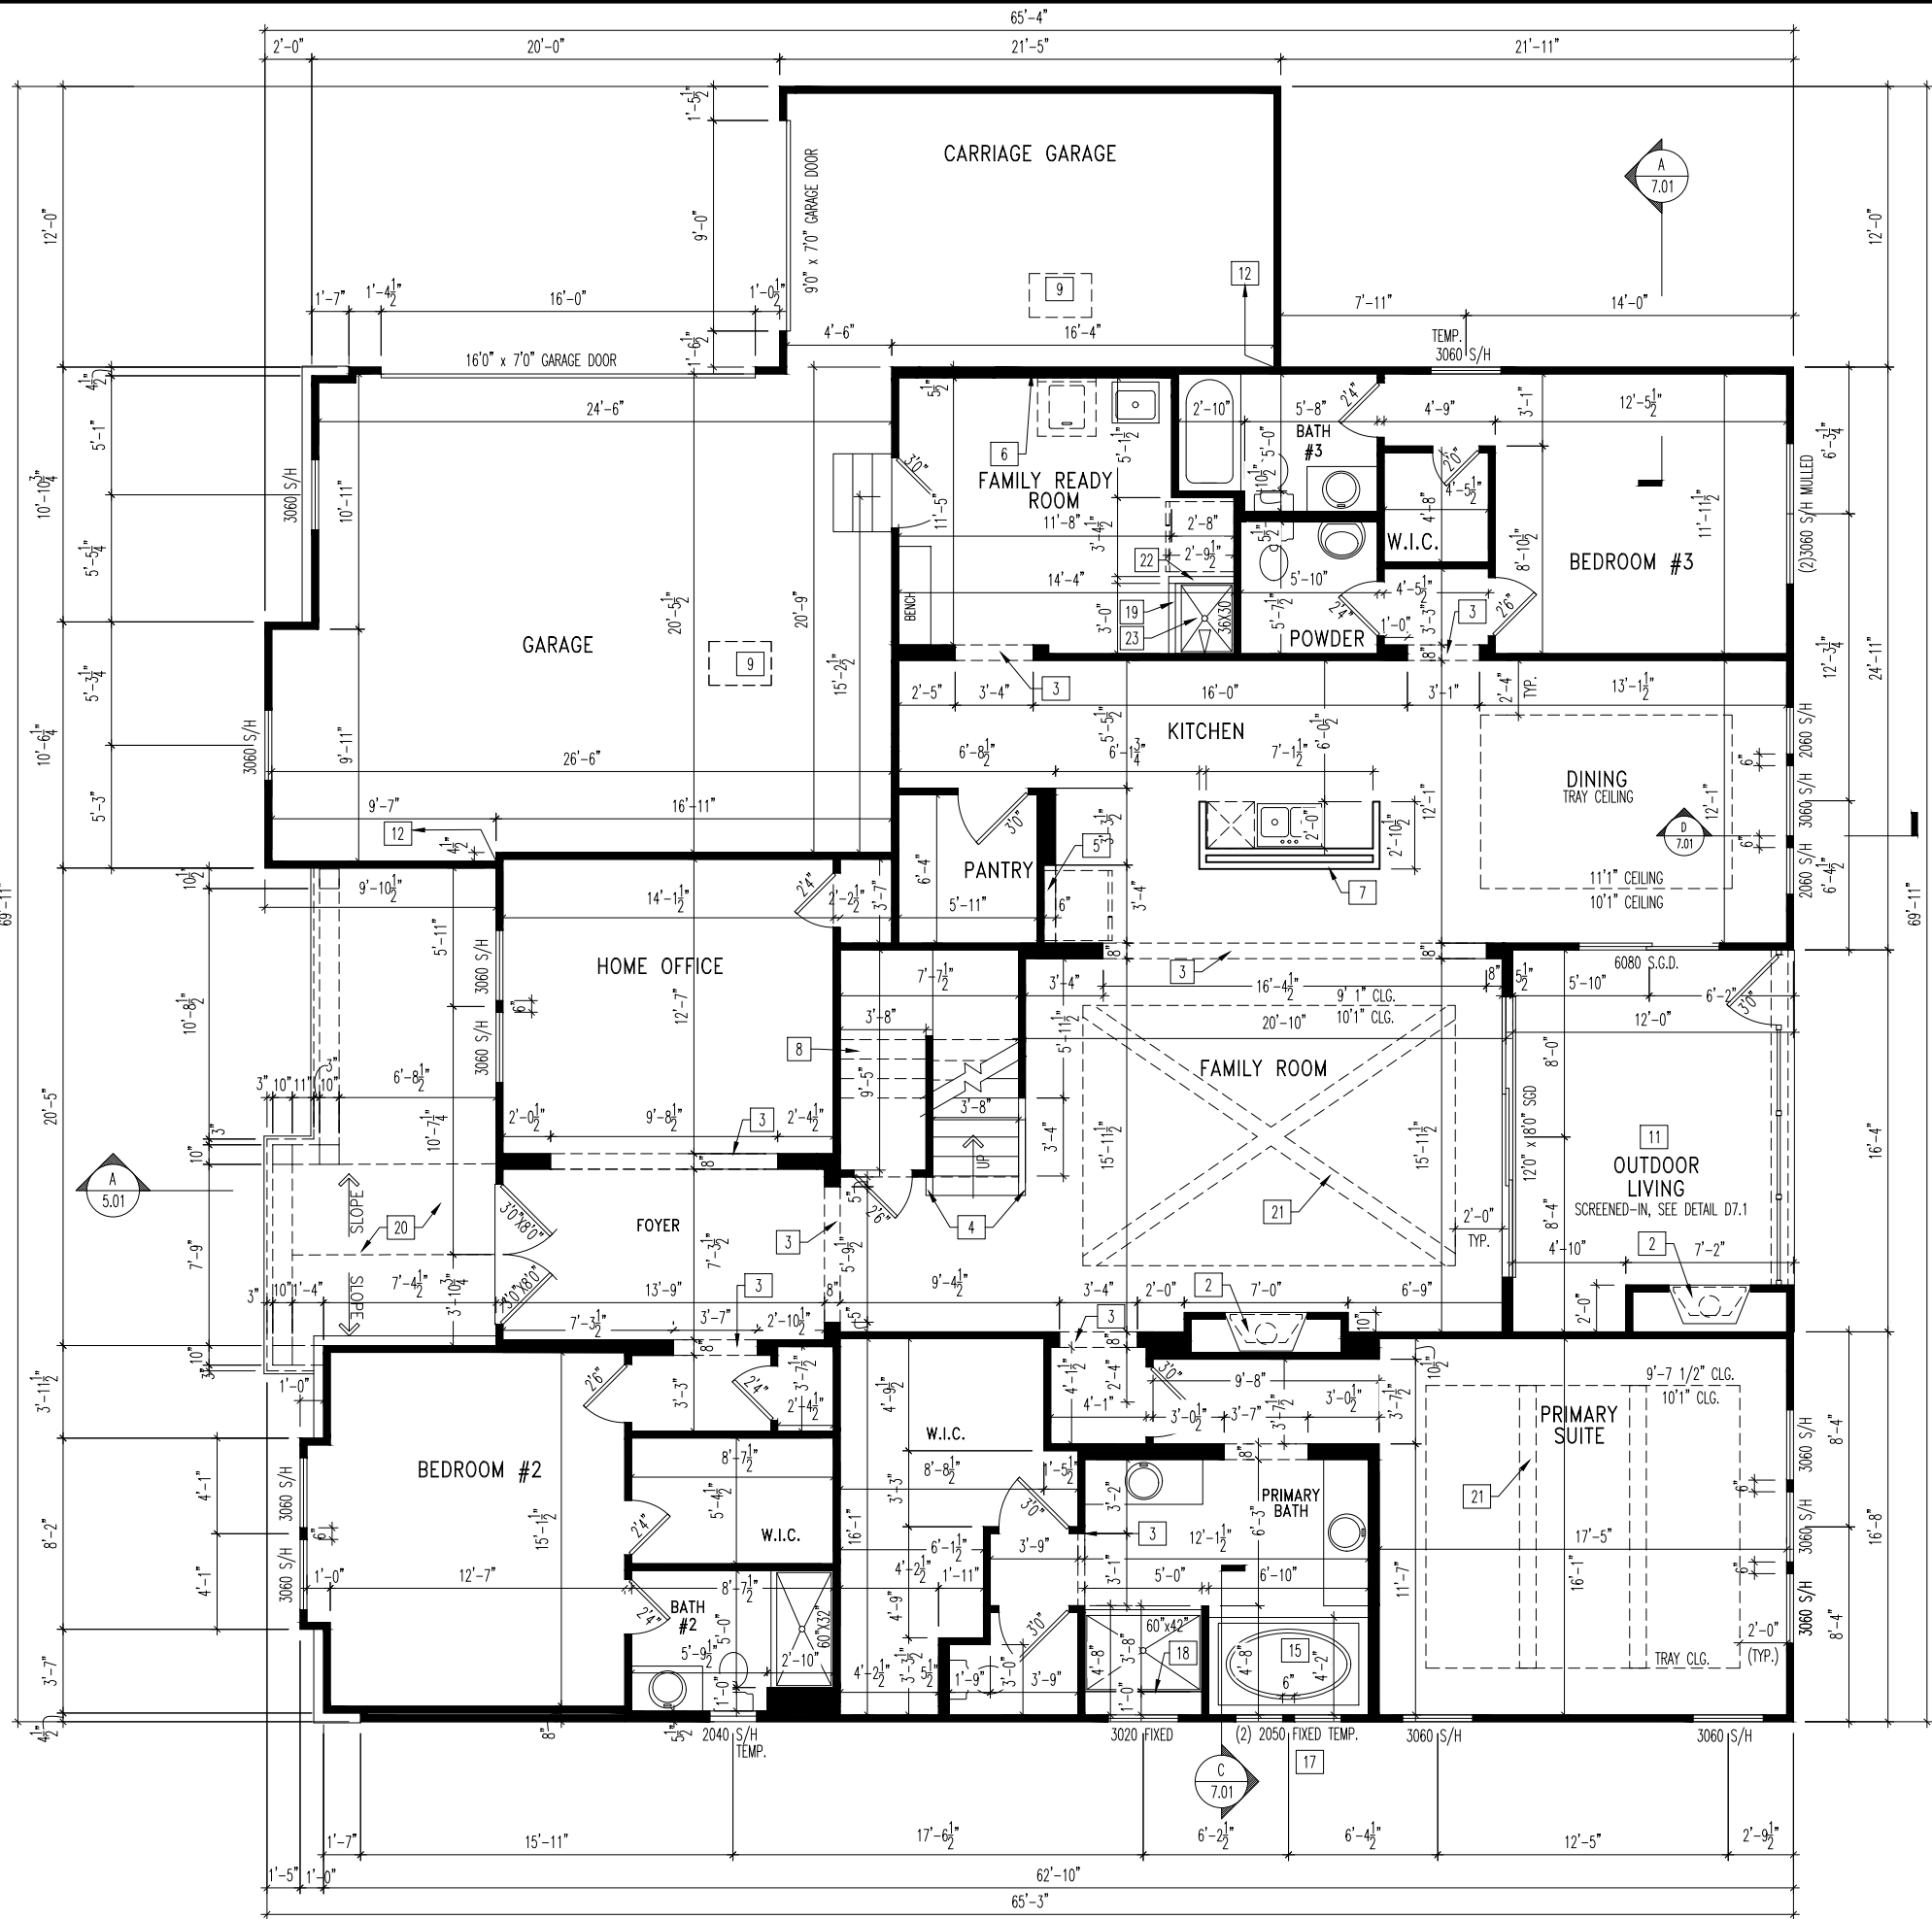

NOTE:
REFER TO SELECTION SHEETS FOR
FLOORING MATERIAL PRIOR TO
CONSTRUCTING STAIRS TO DETERMINE
RISER HEIGHTS

NOTE:
ALL FIRST FLOOR DOORS (INTERIOR AND
EXTERIOR) TO BE 8' TALL, U.N.O.

- General Notes**
- REFER TO SHEET ON.1 FOR GENERAL NOTES.
 - ALL FIRST FLOOR CEILINGS TO BE 10'1" ABOVE SUBFLOOR UNLESS OTHERWISE NOTED.
 - FRAME TOP OF ALL WINDOWS @ 1'10" BELOW TOP PLATE UNLESS OTHERWISE NOTED.
 - ALL FALSE HEADERS TO BE DROPPED 1'3" FROM CEILING UNLESS OTHERWISE NOTED.
- Key Notes**
- 1
 - 2 PRE-FABRICATED FIREPLACE INSERT
 - 3 FALSE HEADER
 - 4 SLOPE WALL WITH STAIR STRINGER
 - 5 TOP OF OPENING @ 6'-6" A.F.F.
 - 6 TAP AND DRAIN FOR WASHER
 - 7 34-1/2" HIGH WALL
 - 8 RE: DETAIL A/7.03 FOR STAIR FRAMING DETAILS
 - 9 22-1/2"x32" ATTIC ACCESS TO BE LOCATED A MIN. OF 9'6" FROM GARAGE DOOR
 - 10
 - 11 CARPENTER TO DROP ELECTRICAL WIRE THROUGH PORCH CEILING FOR LIGHTS
 - 12 FRAME GARAGE WALLS AT 11'-3 1/8" FROM FOUNDATION
 - 13 --
 - 14 42" HIGH WALL
 - 15 RE: DETAIL C/7.01 FOR TUB FRAMING DETAILS
 - 16 32" DIAGONAL SHOWER SEAT INSTALLED AT 18" HIGH BY TILE CONTRACTOR
 - 17 BOTTOM OF WINDOWS @ 3'-0 3/4" A.F.F.
 - 18 FRAME SHOWER SEAT AT 18" HIGH, WITH 2x4 STUDS AT 16" O.C. AND COVER TOP AND SIDES WITH 5/8" WOOD SHEATHING, SLOPE TOP 3/4" FROM BACK TO FRONT FOR WATER RUN OFF OVER FLEXIBLE POLYETHYLENE WATERPROOF MEMBRANE (CONTINUE OVER FRONT AND BACK OF SEAT)
 - 19 2'0" HIGH WALL
 - 20 VAULTED/RAFTER FRAMED PORCH IN GABLE AREA
 - 21 BOX BEAM, SEE DETAIL B/7.02
 - 22 5'0" HIGH WALL
 - 23 18" HIGH PLATFORM



The Drees Company
09/10/2025 1:04:08 PM

Subdivision: SERENITY HAVEN	Customer Name: MODEL
Job #: STYH-0124-00	Job Address: TBD
Contract Drawn By: Phone #:	Original Site Specific Dwg. & Effective Change Order Date:
Coordinator's Name: Coordinator's Phone #:	8/4/2025
STYH-0124-00.dwg Aug 26, 2025 - 3:32pm	

Drees Homes

8521 Six Forks Road, Suite 500, Raleigh, NC 27615 PH(919) 844-9288

SEBASTIAN

Plan No.:

Sheet No.

2.01

FRAMING

Scale: 1/8" = 1'-0"

First Floor Framing Plan

Elevation "K"

Sheet Description:

First Floor Framing Plan

Sta. Drawn By:

WJS

Sta. Chk. By:

ARC

Sta. Date:


08/26/16

Date of Last Rev.:

10/27/16 WJS

REISSUED: 08/26/2025

FRAME NON-LOAD BEARING
WALLS 16" O.C. WHEN HEIGHT
IS TALLER THAN 10'-3"

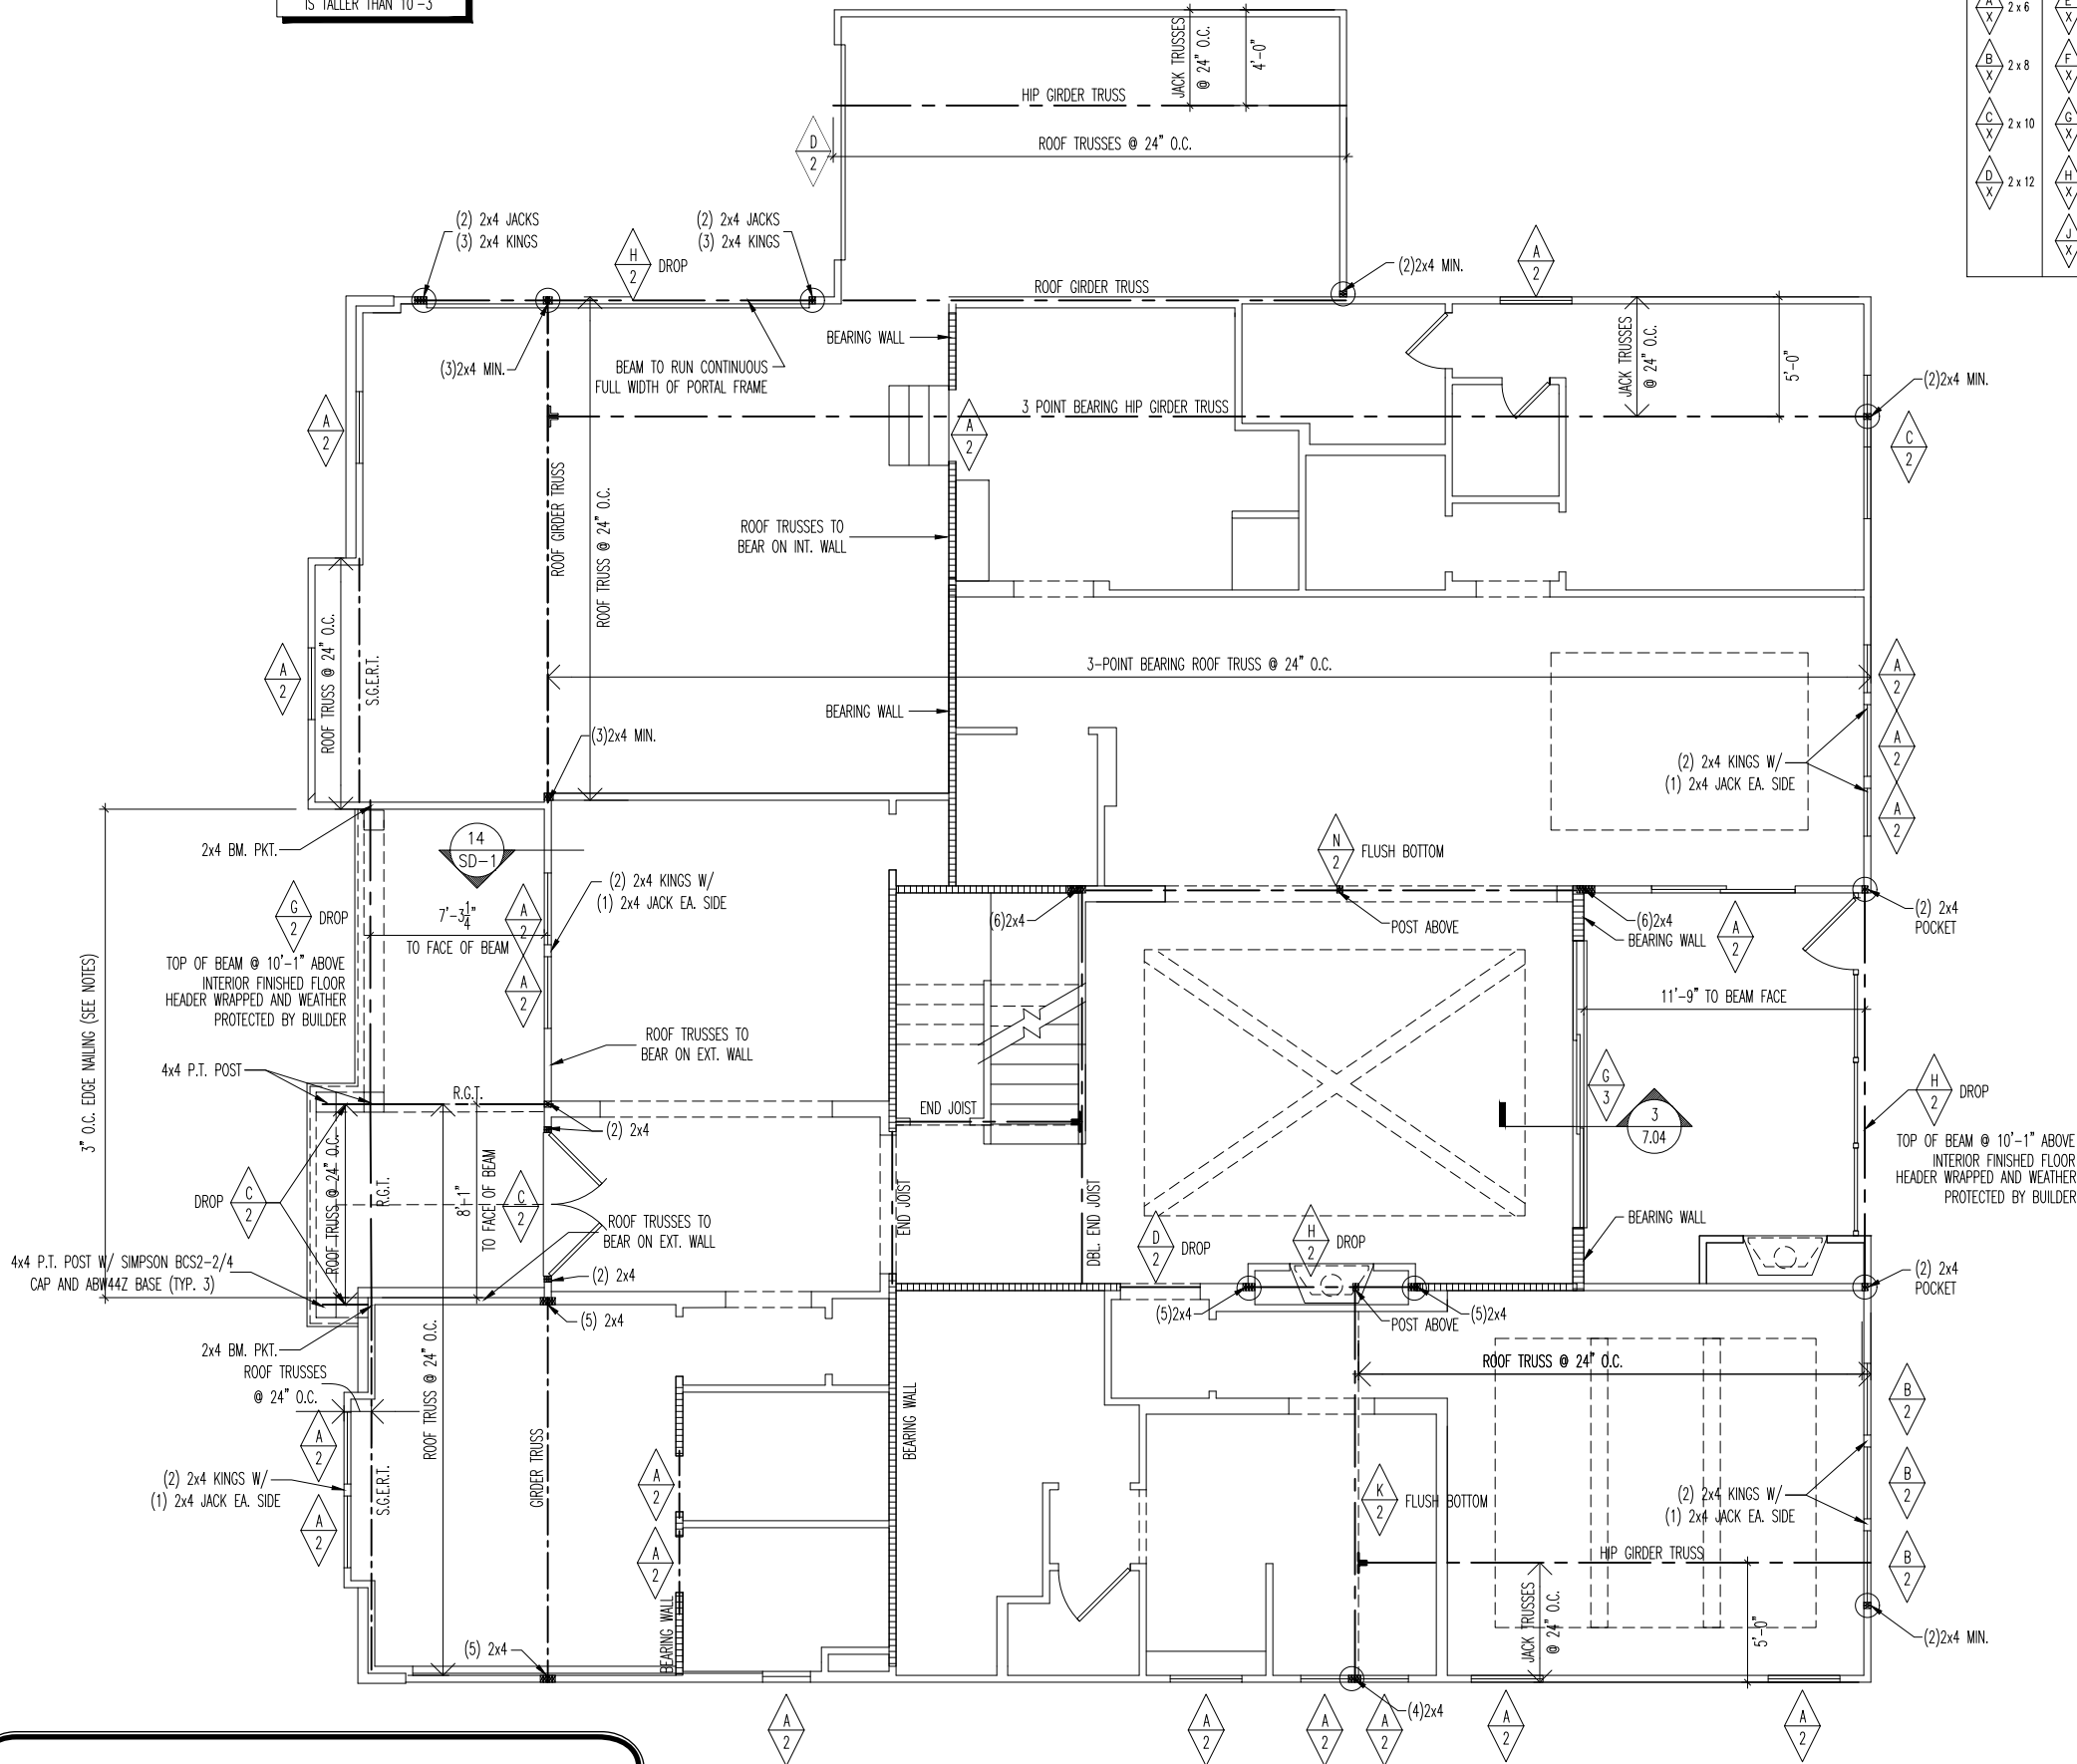

STRUCTURAL HEADER CHART

	2 x 6		1-3/4" x 7-1/4" LVL		1-3/4" x 16" LVL
	2 x 8		1-3/4" x 9-1/4" LVL		1-3/4" x 18" LVL
	2 x 10		1-3/4" x 11-1/4" LVL		1-3/4" x 20" LVL
	2 x 12		1-3/4" x 11-7/8" LVL		1-3/4" x 24" LVL
			1-3/4" x 14" LVL		

General Notes

- REFER TO SHEET ON.1 FOR GENERAL NOTES

LATERAL/WALL BRACING & WALL SHEATHING SPECIFICATIONS

THIS MODEL HAS BEEN DESIGNED TO RESIST LATERAL FORCES RESULTING FROM:

120 MPH WIND IN 2018 NCSBC MAP
(120 MPH WIND SPEED IN ASCE 7-10 WIND MAP, PER IRC R301.2.1.1)
EXP. B & SEISMIC CAT. A/B.

EXT. WALL SHEATHING SPECIFICATION

- 7/16" OSB OR 15/32" PLYWOOD:
FASTEN SHEATHING w/ 2-3/8"x 0.113 NAILS @ 6" O.C. AT EDGES & @ 12" O.C. IN THE PANEL FIELD. (TYP. U.N.O.)
- ALL SHEATHING PANELS SHALL BE ORIENTED AND INSTALLED FULL HEIGHT OF SHEAR WALL OR 2x HORIZONTAL BLOCKING SHALL BE PROVIDED TO SUPPORT ALL UNSUPPORTED PANEL EDGES & EDGE FASTENING.
- ALL EXT. WALLS SHALL BE CONTINUOUSLY SHEATHED AND ARE CONSIDERED SHEAR WALLS.
- ALT. STAPLE CONNECTION SPEC: 1 3/2" 16 GA STAPLES (1/8" CROWN) @ 3" O.C. AT EDGES & @ 6" O.C IN FIELD.

3" O.C. EDGE NAILING

- AT DESIGNATED AREAS - FASTEN PANEL EDGES OF WOOD STRUCTURAL WALL SHEATHING TO FRAMING w/ 2-3/8"x 0.113 NAILS @ 3" O.C. NO STAPLE ALTERNATIVE AVAILABLE AT THIS SPEC. ALL SHEATHING PANELS SHALL BE ORIENTED AND INSTALLED FULL HEIGHT OF SHEAR WALL OR 2x HORIZONTAL BLOCKING SHALL BE PROVIDED TO SUPPORT UNSUPPORTED PANEL EDGES AND 3" O.C. EDGE FASTENING.

NOTES

- SEE CONNECTION SPECIFICATIONS CHART FOR STANDARD SHEAR TRANSFER DETAILING. IF ADDITIONAL CAPACITY IS REQUIRED BY DESIGN, IT WILL BE SPECIFICALLY NOTED ON PLAN.
- DESIGN ASSUMES 16" O.C MAX. STUD SPACING, U.N.O.
- ALL STRUCTURAL PANELS ARE TO BE DIRECTLY APPLIED TO STUD FRAMING.
- PRE-MANUFACTURED PANELIZED WALLS:
FASTEN TOGETHER END STUDS OF WALL PANELS SHEATHED w/ OSB OR PLYWOOD w/ 10d NAILS @ 4" O.C. (THRU ONE SIDE ONLY)

- INDICATES EXTENT OF INT. OSB SHEARWALL, AND/OR 3" O.C. EDGE NAILING
- ▶ INDICATES HOLDOWN
- * INDICATES POST ABOVE (P.A.) PROVIDE SOLID BLOCKING UNDER POST OR JAMB ABOVE.

MAX. STND. - SEPT. 2018



The Drees Company
09/10/2025 1:04:08 PM

Subdivision: SERENITY HAVEN	Customer Name: MODEL
Job #: STYH-0124-00	Job Address: TBD
Contract Drawn By: EWT	Original Site Specific Dwg. & Effective Change Order Date: 8/4/2025
Phone #:	
Coordinator's Name: GREG P.	
Coordinator's Phone #: 859-578-4355	
RCA-0443-00.dwg Aug 19, 2025 - 10:51am	

Drees
HOMES

Drees Homes

8521 Six Forks Road, Suite 500, Raleigh, NC 27615 PH:(919) 844-9288
Copyright © 2015, (2012) The Drees Company. All Rights Reserved. No portion of this material may be reproduced in any form or by any means, including photocopying, without the express written permission of the Drees Company. The Drees Company will vigorously prosecute any unauthorized use of this material.

Sheet Description:
FIRST FLOOR STRUCTURAL PLAN
ELEVATION "K"
SCALE: 1/8" = 1'-0"


Sld. Drawn By: **WJS**
Sld. Chk. By: **ARC**
Sld. Date: **08/26/16**
Date of Last Rev: **10/27/16**

House:
SEBASTIAN
Series:
2.01

Sheet No.
2.01
STRUCTURE

REISSUED: 08/19/2025

REISSUED: 08/26/2025

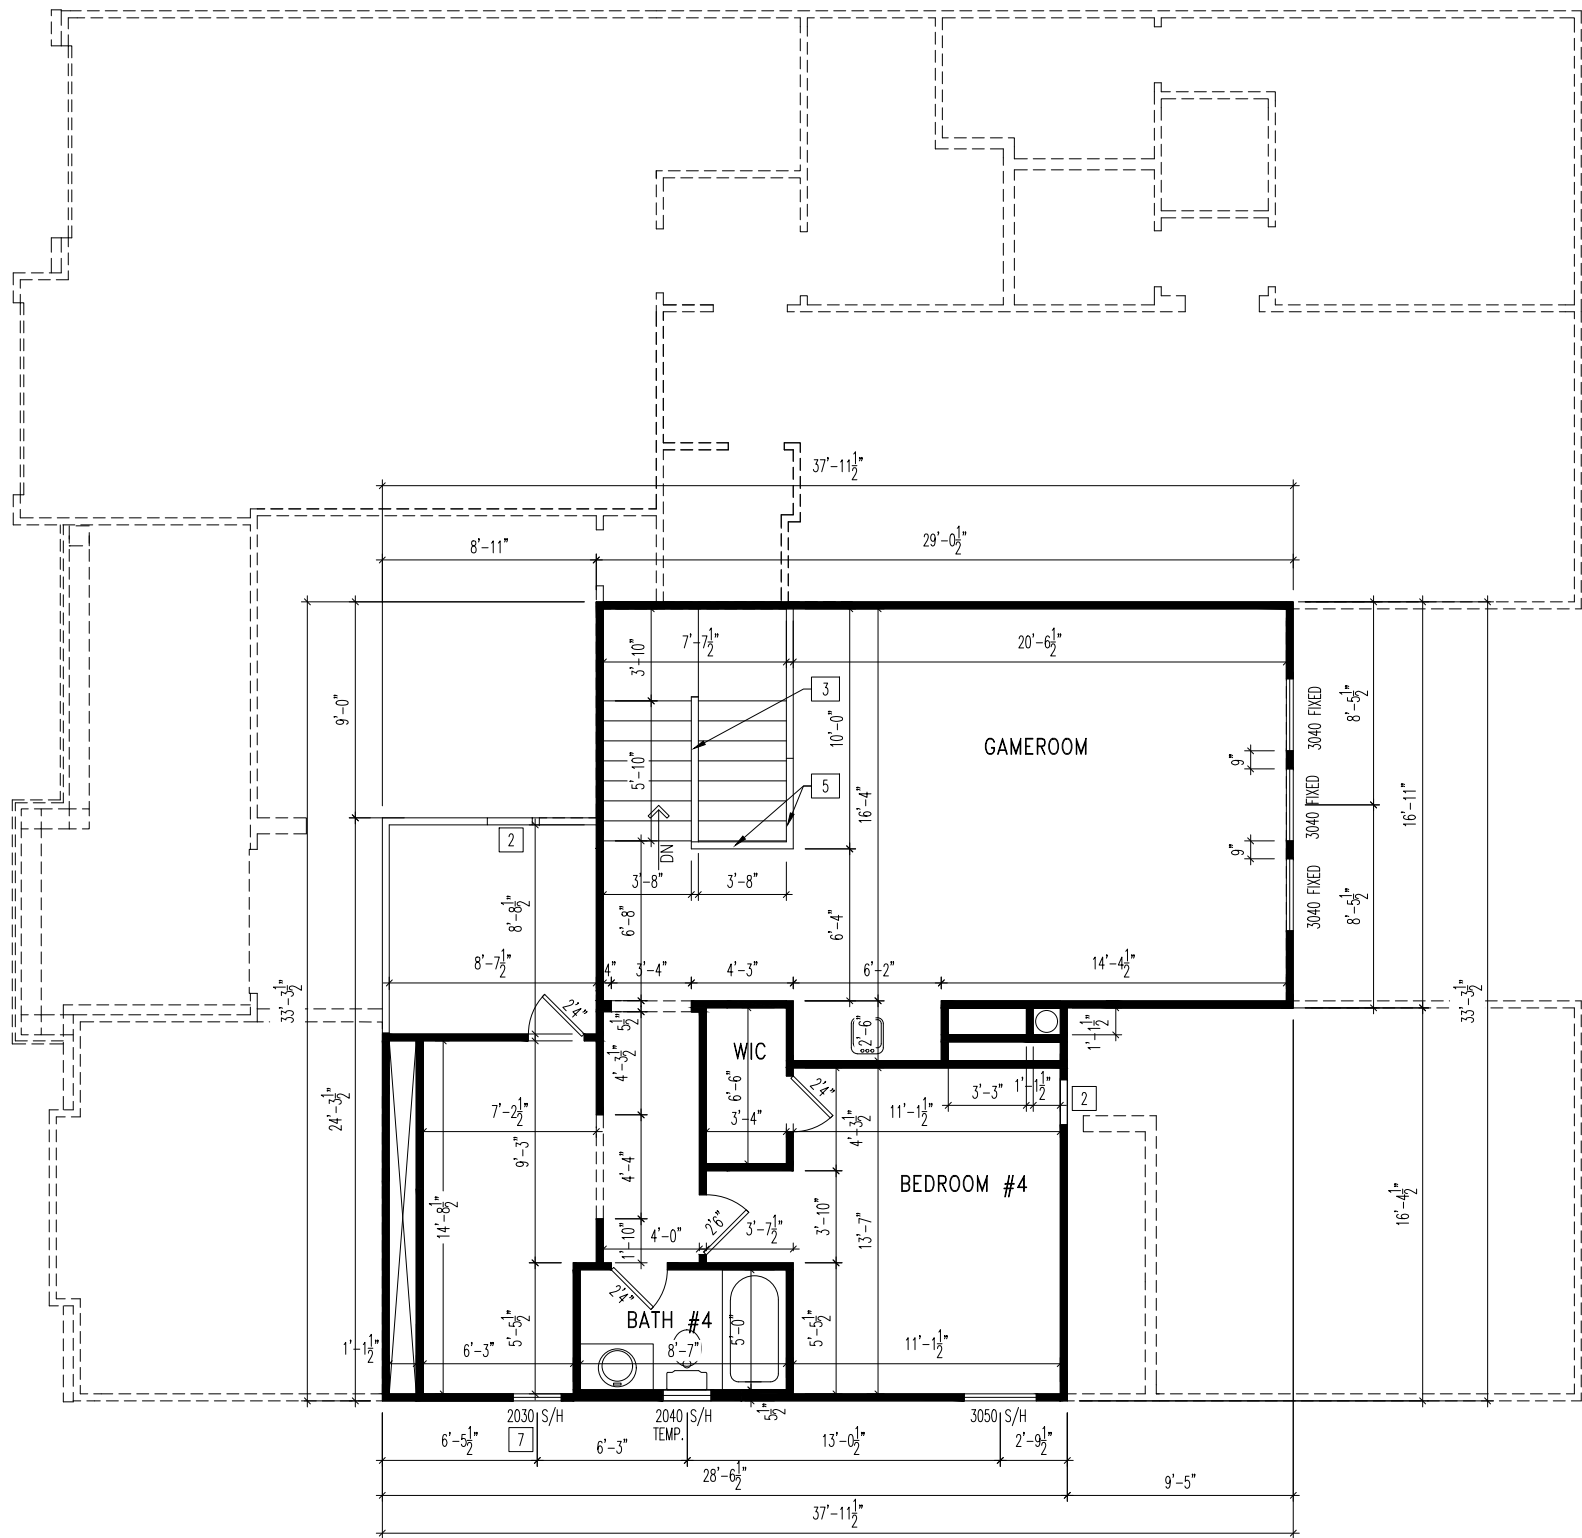

General Notes

- REFER TO SHEET ON.1 FOR GENERAL NOTES.
- ALL SECOND FLOOR CEILINGS TO BE 9'1" ABOVE SUBFLOOR UNLESS OTHERWISE NOTED.
- FRAME TOP OF ALL WINDOWS @ 1'0-1/4" BELOW TOP PLATE UNLESS OTHERWISE NOTED.
- ALL FALSE HEADERS TO BE DROPPED 1'-0" FROM CEILING UNLESS OTHERWISE NOTED.


Key Notes

- 1 DO NOT LOCATE TRUSS ABOVE PLUMBING WALL
- 2 22-1/2"x32" ATTIC ACCESS
- 3 SLOPED HALF WALL WITH STAIR STRINGER
- 4 RE: DETAIL A/7.03 FOR SECOND FLOOR STAIR FRAMING DETAILS
- 5 36" HIGH HALF WALL
- 6 --
- 7 FRAME TOP OF WINDOW @ 2'0-1/4" BELOW TOP PLATE
- 8 --
- 9 --
- 10 --
- 11 --
- 12 --
- 13 --
- 14 --
- 15 --



The Drees Company
09/10/2025 1:04:08 PM

Subdivision: SERENITY HAVEN	Customer Name: MODEL
Job #: STYH-0124-00	Job Address: TBD
Contract Drawn By: EWT	Original Site Specific Dwg. & Effective Change Order Date: 8/4/2025
Phone #:	
Coordinator's Name: GREG P.	
Coordinator's Phone #: 859-578-4355	
STYH-0124-00.dwg Aug 26, 2025 - 3:34pm	

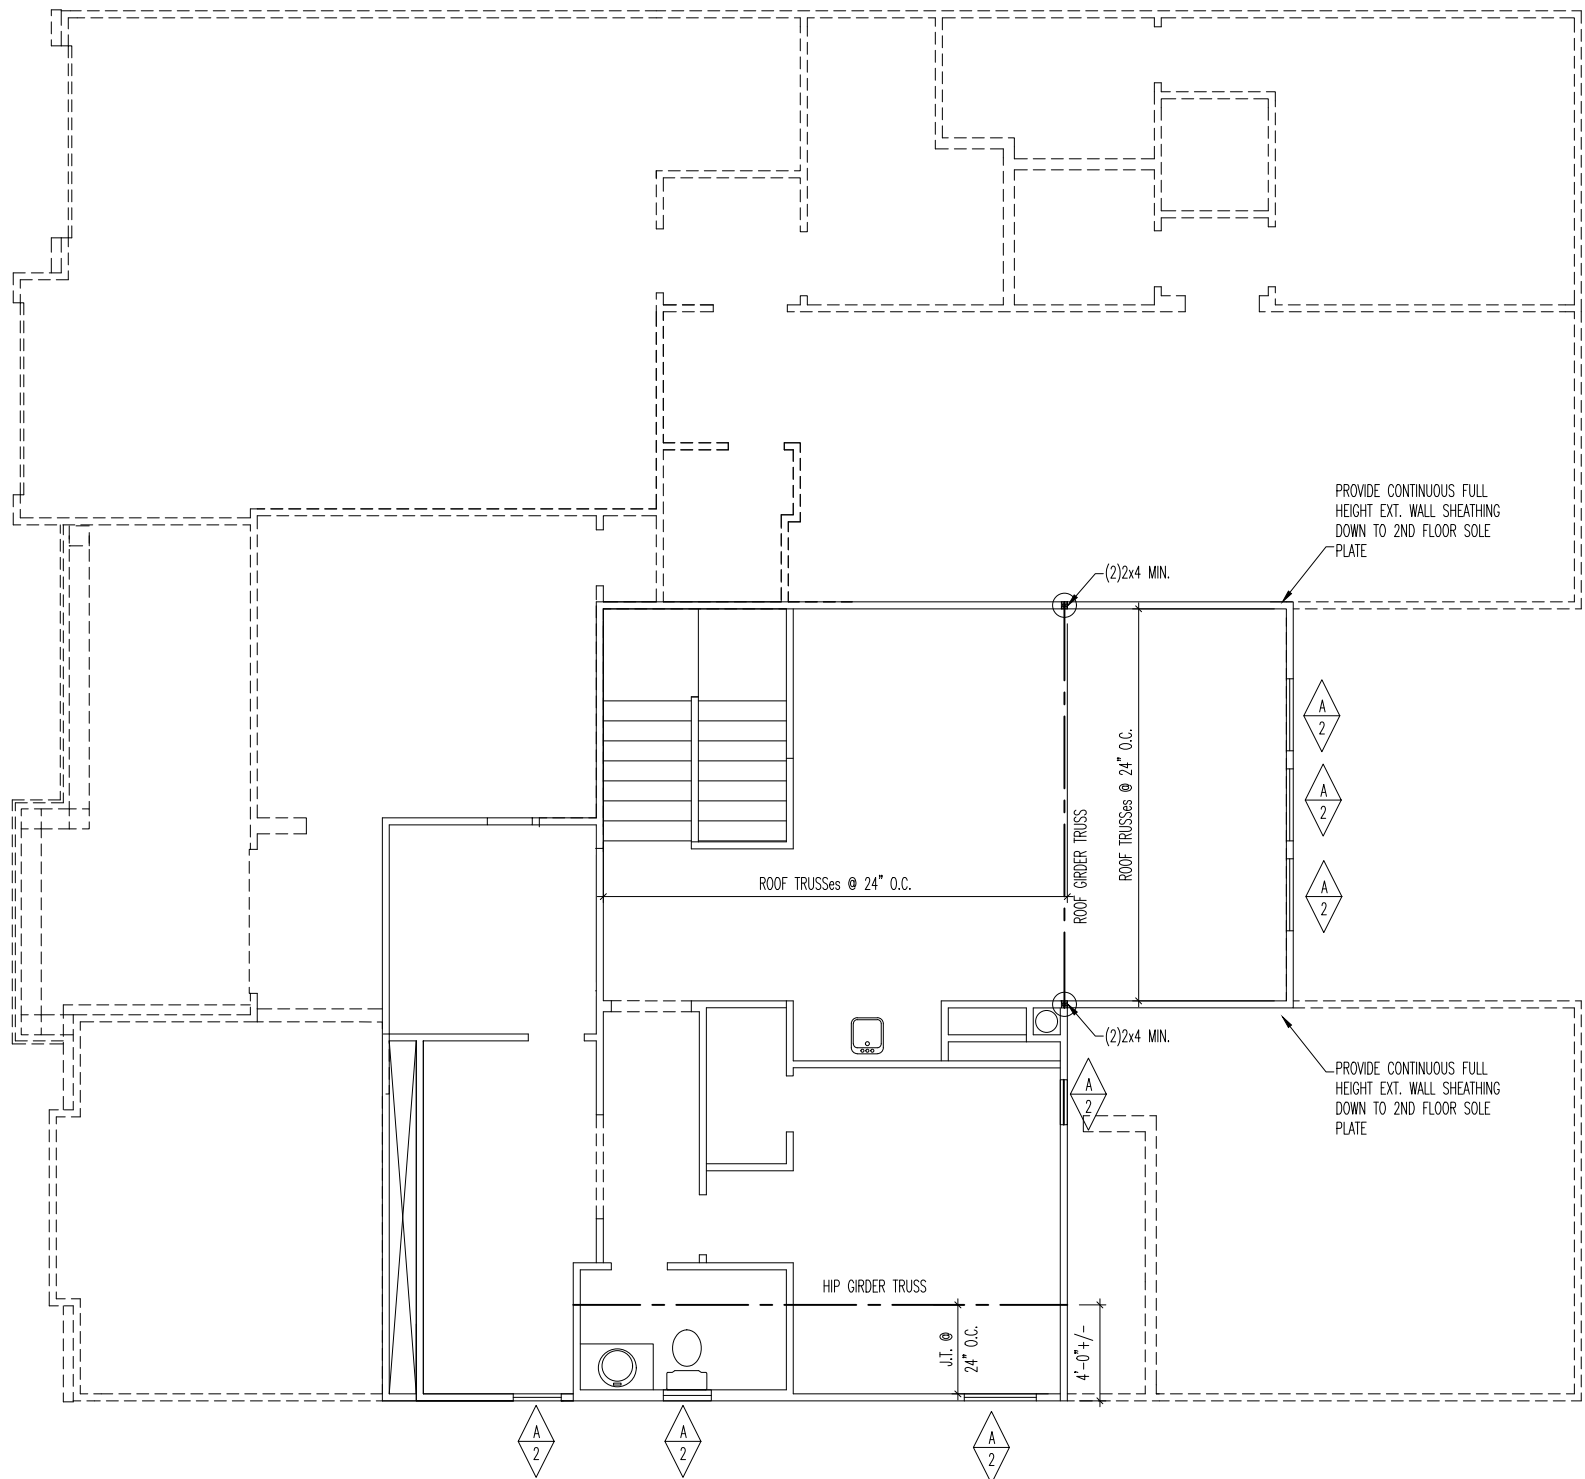

REISSUED: 08/26/2025

LATERAL/WALL BRACING & WALL SHEATHING SPECIFICATIONS

THIS MODEL HAS BEEN DESIGNED TO RESIST LATERAL FORCES RESULTING FROM:
120 MPH WIND IN 2018 NCSBC MAP
(120 MPH WIND SPEED IN ASCE 7-10 WIND MAP, PER IRC R301.2.1.1)
EXP. B & SEISMIC CAT. A/B.

EXT. WALL SHEATHING SPECIFICATION

- 7/16" OSB OR 15/32" PLYWOOD:
FASTEN SHEATHING w/ 2-3/8"x 0.113 NAILS @ 6" O.C. AT EDGES & @ 12" O.C. IN THE PANEL FIELD. (TYP, U.N.O.)
- ALL SHEATHING PANELS SHALL BE ORIENTED AND INSTALLED FULL HEIGHT OF SHEAR WALL OR 2x HORIZONTAL BLOCKING SHALL BE PROVIDED TO SUPPORT ALL UNSUPPORTED PANEL EDGES & EDGE FASTENING.
- ALL EXT. WALLS SHALL BE CONTINUOUSLY SHEATHED AND ARE CONSIDERED SHEAR WALLS.
- ALT. STAPLE CONNECTION SPEC: 1 3/4" 16 GA STAPLES (1/4" CROWN) @ 3" O.C. AT EDGES & @ 6" O.C IN FIELD.

3" O.C. EDGE NAILING

- AT DESIGNATED AREAS - FASTEN PANEL EDGES OF WOOD STRUCTURAL WALL SHEATHING TO FRAMING w/ 2-3/8"x 0.113 NAILS @ 3" O.C. NO STAPLE ALTERNATIVE AVAILABLE AT THIS SPEC. ALL SHEATHING PANELS SHALL BE ORIENTED AND INSTALLED FULL HEIGHT OF SHEAR WALL OR 2x HORIZONTAL BLOCKING SHALL BE PROVIDED TO SUPPORT UNSUPPORTED PANEL EDGES AND 3" O.C. EDGE FASTENING.

NOTES

- SEE CONNECTION SPECIFICATIONS CHART FOR STANDARD SHEAR TRANSFER DETAILING. IF ADDITIONAL CAPACITY IS REQUIRED BY DESIGN, IT WILL BE SPECIFICALLY NOTED ON PLAN.
- DESIGN ASSUMES 16" O.C MAX. STUD SPACING, U.N.O.
- ALL STRUCTURAL PANELS ARE TO BE DIRECTLY APPLIED TO STUD FRAMING.
- PRE-MANUFACTURED PANELIZED WALLS:
FASTEN TOGETHER END STUDS OF WALL PANELS SHEATHED w/ OSB OR PLYWOOD w/ 10d NAILS @ 4" O.C. (THRU ONE SIDE ONLY)

- INDICATES EXTENT OF INT. OSB SHEARWALL, AND/OR 3" O.C. EDGE NAILING
- ▶ INDICATES HOLDDOWN
- * INDICATES POST ABOVE (P.A.) PROVIDE SOLID BLOCKING UNDER POST OR JAMB ABOVE.

M&K STD. - SEPT. 2019

General Notes

- REFER TO SHEET ON.1 FOR GENERAL NOTES



The Drees Company
09/10/2025 1:04:08 PM


Subdivision: SERENITY HAVEN	Customer Name: MODEL
Job #: STYH-0124-00	Job Address: TBD
Contract Drawn By: EWT	Original Site Specific Dwg. & Effective Change Order Date: 8/4/2025
Phone #:	
Coordinator's Name: GREG P.	
Coordinator's Phone #: 859-578-4355	
STYH-0124-00.dwg Aug 26, 2025 - 3:34pm	

Sheet No.
2.02
STRUCTURE

Drees
HOMESSM

Drees Homes
8521 Six Forks Road, Suite 500, Raleigh, NC 27615 PH(919) 844-9288
Copyright ©, 2015, (2012) The Drees Company. All Rights Reserved. No portion of this material may be reproduced in any form or by any means, including photocopying, without the express written permission of the Drees Company. The Drees Company will vigorously prosecute any unauthorized use of this material.

Sheet Description: SECOND FLOOR STRUCTURAL PLAN	Scale: 1/8" = 1'-0"
Std. Drawn By: WJS	Std. Chk. By: ARC
Std. Date: 08/26/16	Date of Last Rev: REL_DT
House: SEBASTIAN	Plan No.:
Series:	

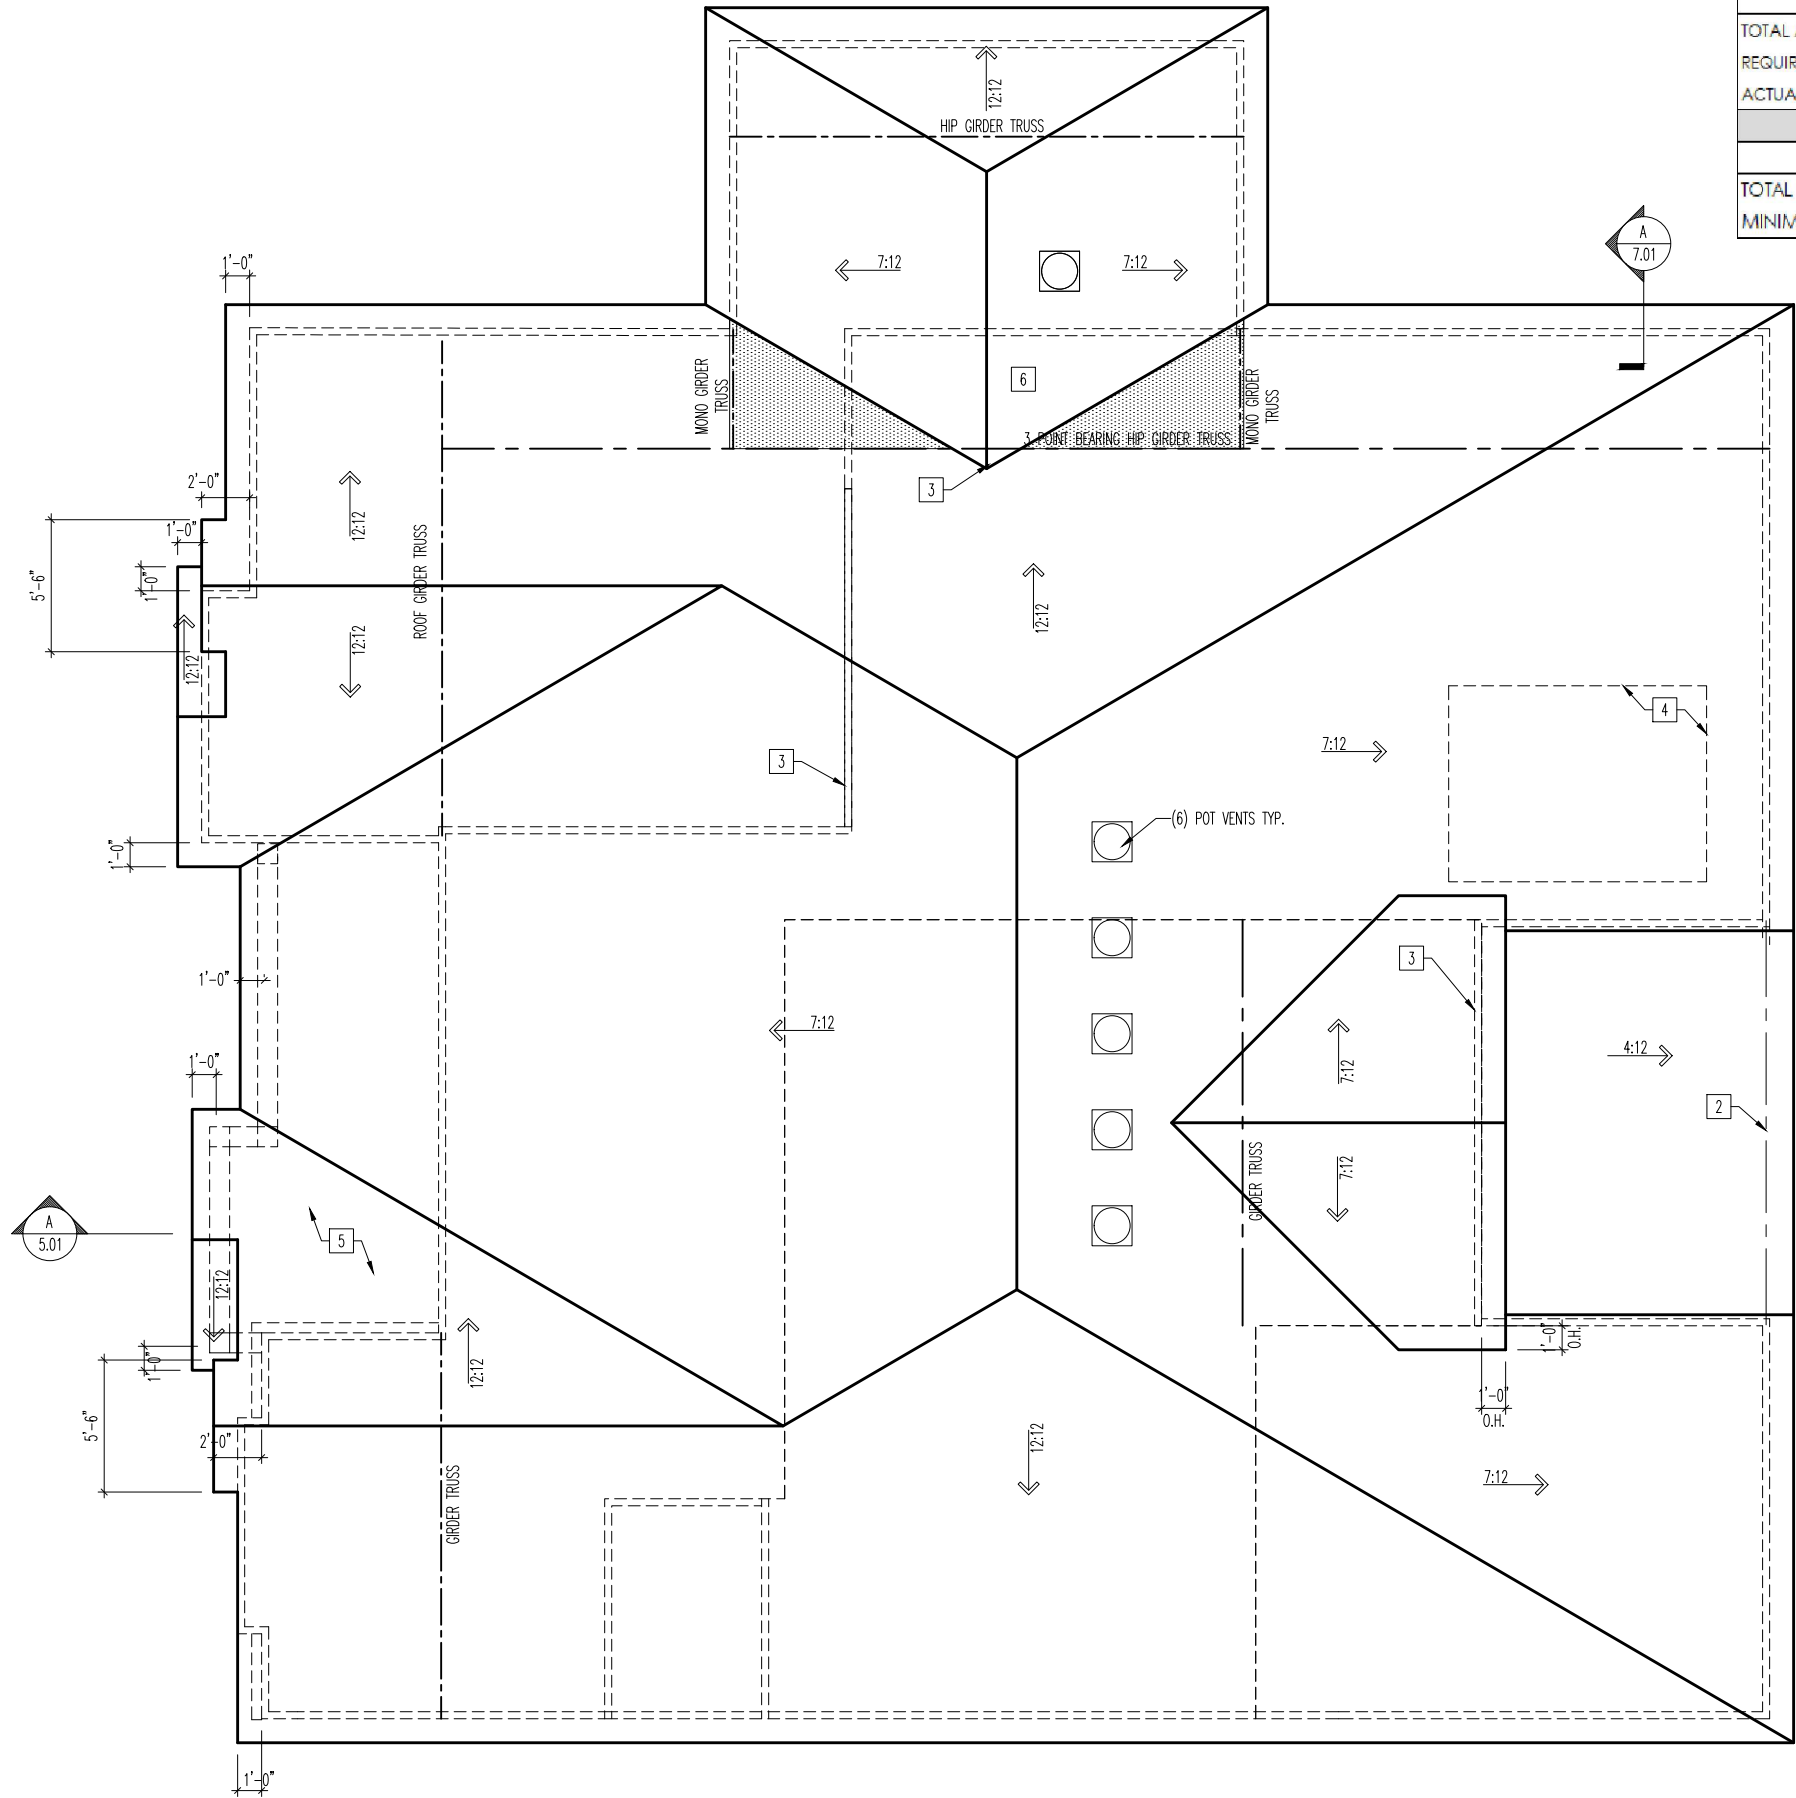

ROOF VENTILATION	
CITY/SERIES:	RALEIGH
MAIN HOUSE	
TOTAL ATTIC AREA:	4,238
REQUIRED NET FREE VENTILATION (ATTIC AREA/300):	14.13
ACTUAL NET FREE VENTILATION (UPPER + LOWER):	17.71
DOWNSPOUT CALCULATION	
MAIN HOUSE	
TOTAL DRAINABLE ROOF AREA:	5509.4
MINIMUM # OF DOWNSPOUTS:	10

REISSUED: 08/19/2025

HEEL CUT STANDARDS		
	OVERHANG	
	1'-6"	2'-0"
ROOF PITCH	4:12	5-3/4" 7-3/4"
	5:12	6-3/4" 9-3/4"
	6:12	7-3/4" 11-3/4"
	7:12	8-3/4" 13-3/4"
	8:12	9-3/4" N/A
	9:12	10-3/4" N/A
	10:12	11-3/4" N/A
	12:12	13-3/4" N/A
	14:12	15-3/4" N/A

- General Notes
- REFER TO SHEET ON.1 FOR GENERAL NOTES.
- Key Notes
- 1 --

2 BEAM BELOW -- RE: SHEET 2.01 STRUCTURE FOR SIZE

3 INTERMEDIATE TRUSS BEARING WALL

4 EXTENT OF TRAY CEILING

5 VAULTED/RAFTER FRAMED PORCH IN GABLE AREA

6 DO NOT REMOVE SHEATHING UNDER HIP-CARRIAGE GARAGE ROOF TO BE VENTED SEPERATELY FROM MAIN HOUSE

CONNECTION SPECIFICATIONS (TYP. U.N.O.)	
NOTE: 10d NAIL = 3" x 0.131" GUN NAIL	
JOIST TO SOLE PLATE	(3) 10d TOENAILS
SOLE PLATE TO JOIST/BLK'G.	10d NAILS @ 6" o.c.
STUD TO SOLE PLATE	(3) 10d TOENAILS
TOP OR SOLE PLATE TO STUD	(3) 10d NAILS
RIM TO TOP PLATE	10d TOENAILS @ 6" o.c.
BLK'G. BTWN. JOISTS TO TOP PL.	(3) 10d TOENAILS
RAFTER/TRUSS TO TOP PLATE	(3) 10d TOENAILS + (1) SIMPSON H2.5A
GAB. END TRUSS TO DBL. TOP PL.	10d TOENAILS @ 8" o.c.
R.T. w/ HEEL HT. 9 1/4" TO 12"	2x10 BLK EVERY 3RD BAY FASTENED TO DBL. TOP PLATE w/ 10d TOENAILS @ 6" O.C.
R.T. w/ HEEL HT. 12" TO 16"	2x12 BLK EVERY 3RD BAY FASTENED TO DBL. TOP PLATE w/ 10d TOENAILS @ 6" O.C.
R.T. w/ HEEL HT. UP TO 24"	LAP WALL SHTG. w/ DBL. TOP PL. & INSTALL ON TRUSS VERT. - FASTEN w/ 8d NAILS @ 6" O.C.
R.T. w/ HEEL HT. 24" TO 48"	LAP WALL SHTG. w/ DBL. TOP PL. & INSTALL ON TRUSS VERT. - FASTEN w/ 8d NAILS @ 6" O.C. PROVIDE 2x BLK @ EA. BAY AT TOP OF HEEL
DOUBLE STUD	10d NAILS @ 24" o.c.
DOUBLE TOP PLATE	10d NAILS @ 24" o.c.
DOUBLE TOP PLATE LAP SPLICE	(10) 10d NAILS IN LAPPED AREA
TOP PLATE LAP @ CORNERS & INTERSECTING WALLS	(2) 10d NAILS
WALL TO FOUNDATION	WALL SHTG. LAP w/ SILL PL. & FASTENED PER SHEAR WALL FASTENING SPEC.



The Drees Company
09/10/2025 1:04:08 PM

Subdivision: SERENITY HAVEN	Customer Name: MODEL
Job #: STYH-0124-00	Job Address: TBD
Contract Drawn By: EWT	Original Site Specific Dwg. & Effective Change Order Date: 8/4/2025
Phone #:	
Coordinator's Name: GREG P.	
Coordinator's Phone #: 859-578-4355	
RGA-0443-00.dwg Aug 19, 2025 - 11:06am	

Drees Homes

8521 Six Forks Road, Suite 500, Raleigh, NC 27615 PH:(919) 844-9288
Copyright © 2015, (2012) The Drees Company. All Rights Reserved. No portion of this material may be reproduced in any form or by any means, including photocopying, without the express written permission of the Drees Company. The Drees Company will vigorously prosecute any unauthorized use of this material.

SEBASTIAN

Roof Plan Elevation "K"

Scale: 1/8" = 1'-0"

Sheet Description:

Roof Plan Elevation "K"

Sheet No. 2.04

Sub. Drawn By: WJS


Std. Chk. By: ARC

Std. Date: 08/26/16

Date of 10/27/16 WJS

Cost. Rev.

REISSUED: 08/19/2025

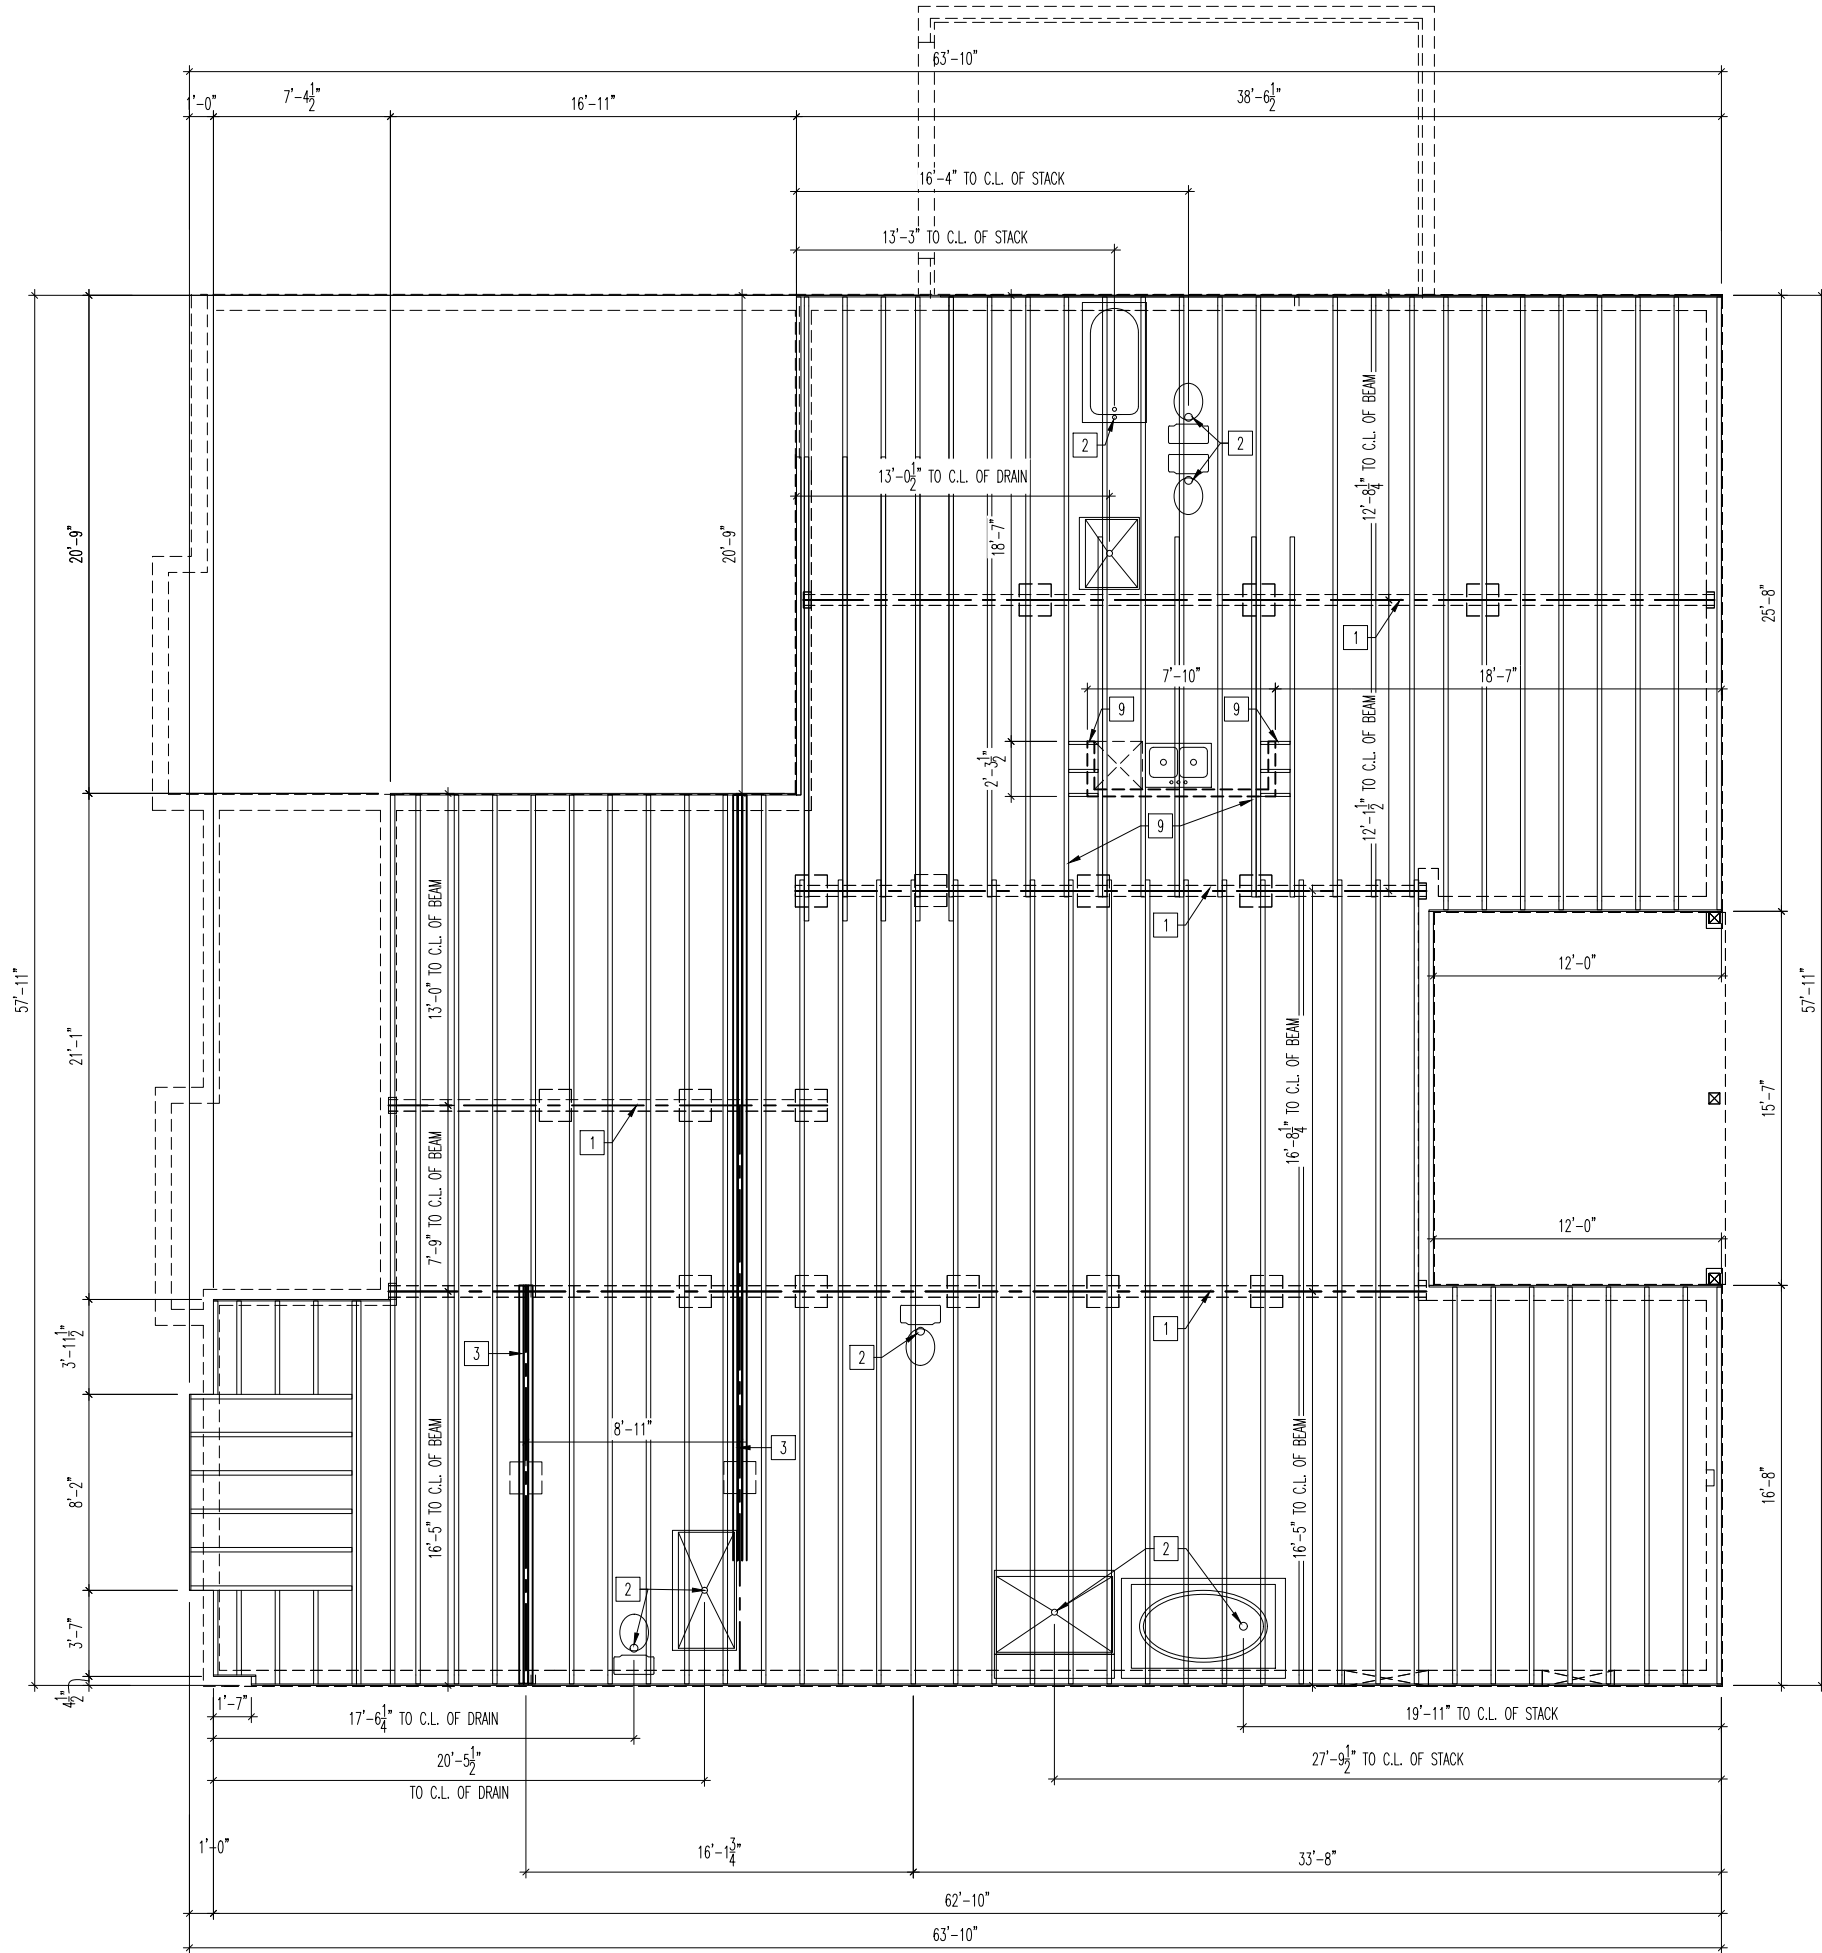

General Notes

- REFER TO SHEET ON.1 FOR GENERAL NOTES.
- ALL JOISTS TO BE 11-7/8" TJI 210 SERIES I-JOISTS, OR EQUAL, @ 19.2" o.c., UNLESS OTHERWISE NOTED.
- ALL BANDBOARDS PER ENGINEERED FLOOR SYSTEM, UNLESS OTHERWISE NOTED.
- ADJUST FRAMING FOR PLUMBING AS NEEDED.
- FLOOR JOISTS TO HAVE MINIMUM 3" BEARING ON BEAM/WALL BELOW AND 6" MAXIMUM JOIST OVERLAP.

Key Notes

- 1 BEAM BELOW - RE: SHEET 1.01 FOR SIZE
- 2 PLUMBING STACK
- 3 FLUSH BEAM - RE: SHEET 1.01 FOR SIZE
- 4 DOUBLE JOIST
- 5 LEDGER BELOW PER DETAIL B/7.05
- 6 END JOIST
- 7 --
- 8 --
- 9 DOUBLE EVERY OTHER JOIST AND BLOCKING UNDER KITCHEN ISLAND
- 10 --
- 11
- 12
- 13
- 14
- 15
- 16
- 17
- 18
- 19
- 20



The Drees Company
09/10/2025 1:04:08 PM

Subdivision: SERENITY HAVEN	Customer Name: MODEL
Job #: STYH-0124-00	Job Address: TBD
Contract Drawn By: EWT	Original Site Specific Dwg. & Effective Change Order Date: 8/4/2025
Phone #:	
Coordinator's Name: GREG P.	
Coordinator's Phone #: 859-578-4355	

RGA-0443-00.dwg Aug 19, 2025 - 11:06am

Drees
HOMESSM

Drees Homes

8521 Six Forks Road, Suite 500, Raleigh, NC 27615 PH(919) 844-9288
Copyright ©, 2015, (2012) The Drees Company. All Rights Reserved. No portion of this material may be reproduced in any form or by any means, including photocopying, without the express written permission of the Drees Company. The Drees Company will vigorously prosecute any unauthorized use of this material.

SCALE: 1/8" = 1'-0"


FIRST FLOOR SUBFLOOR PLAN
ELEVATION "K"

Std. Drawn By: WJS
Std. Chk. By: ARC
Std. Date: 08/26/16
Date of 10/27/16 WJS
Last Rev:

House:
SEBASTIAN
Series:

Sheet No.

3.01

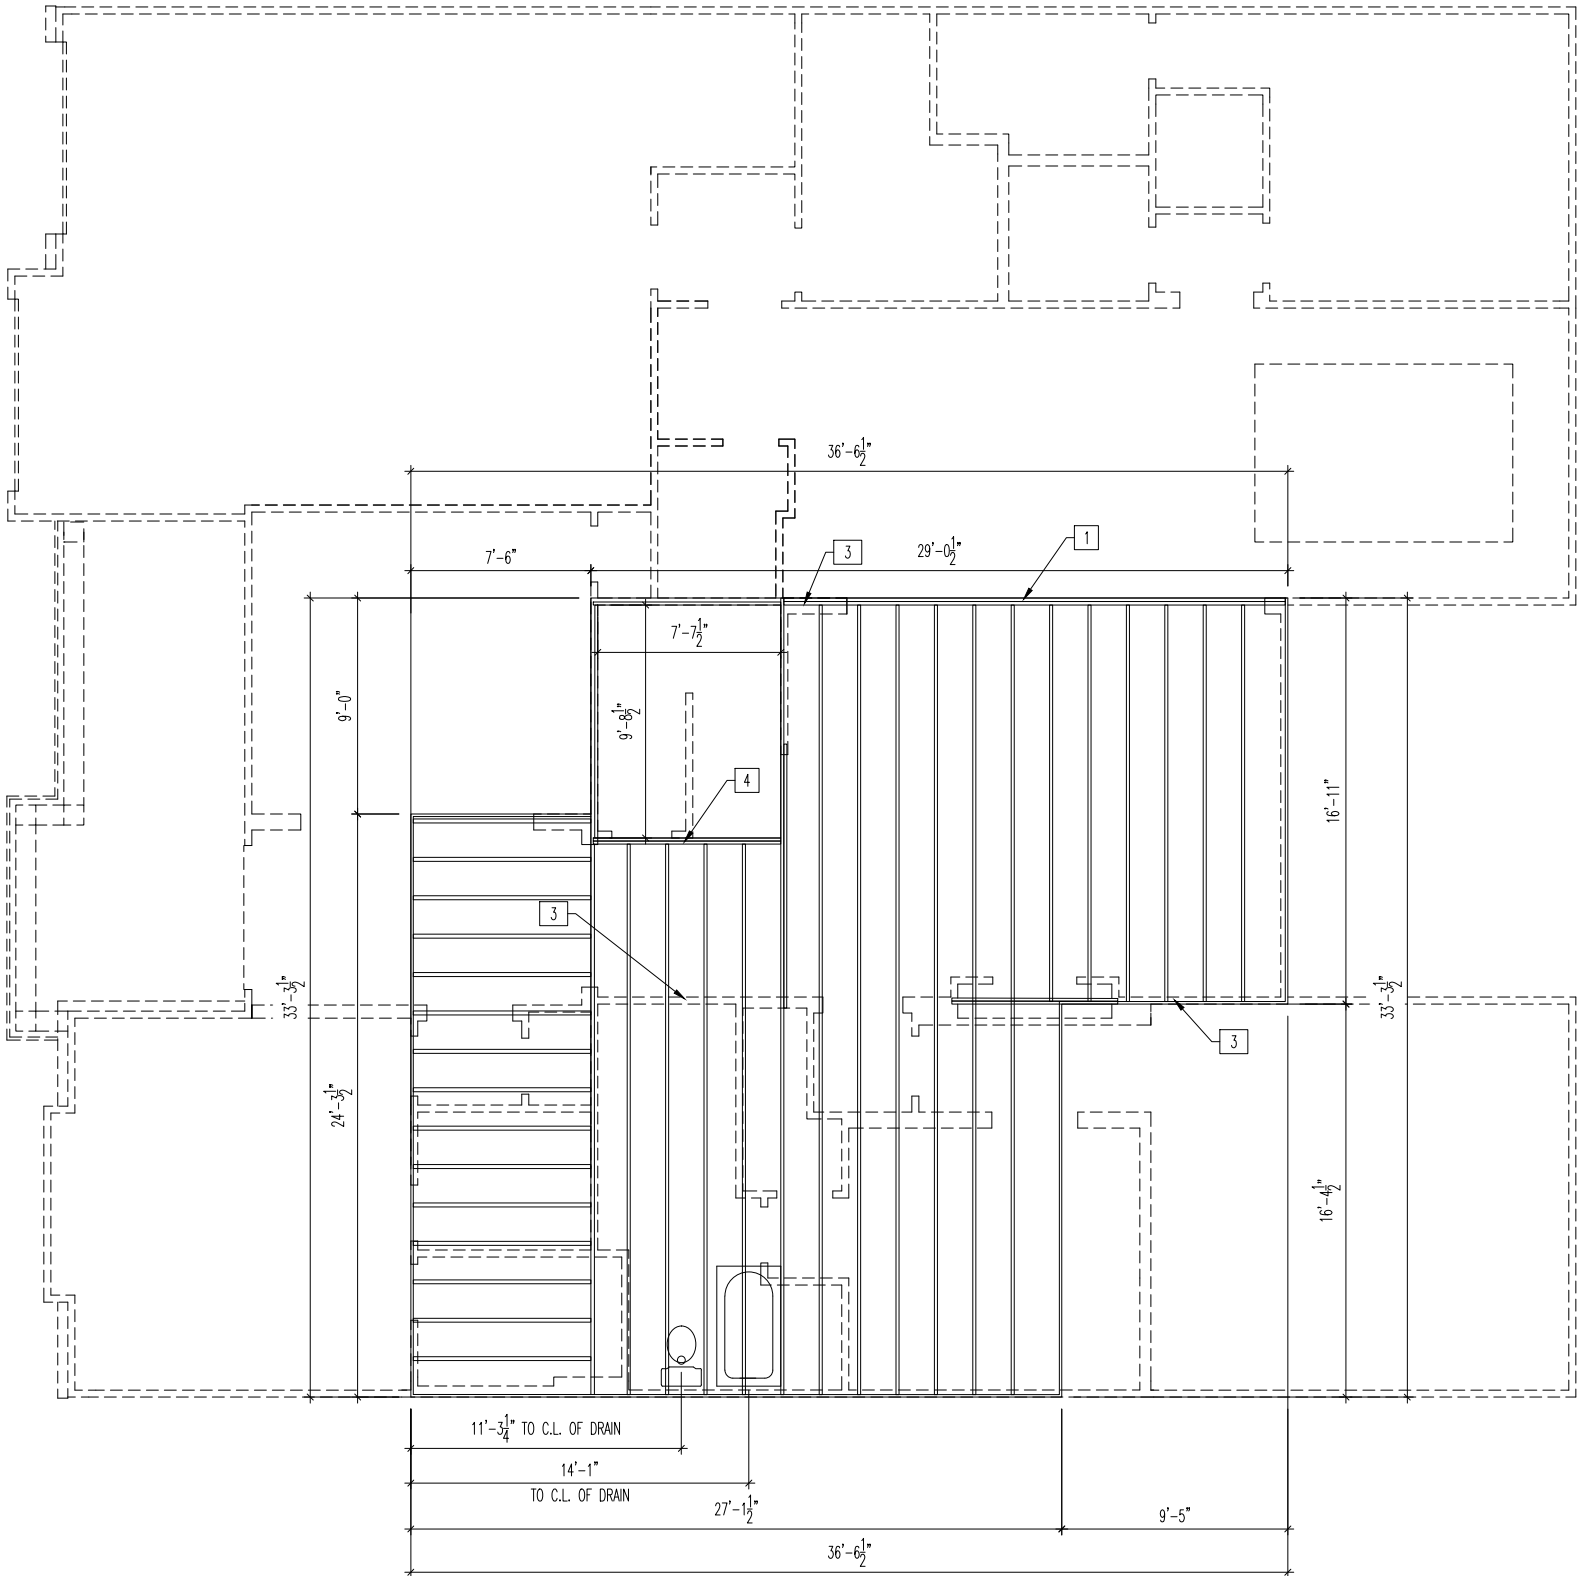

- General Notes
- REFER TO SHEET ON.1 FOR GENERAL NOTES.
 - ALL JOISTS TO BE 11-7/8" TJI 210 SERIES I-JOISTS, OR EQUAL, @ 19.2" o.c., UNLESS OTHERWISE NOTED.
 - ALL BANDBOARDS PER ENGINEERED FLOOR SYSTEM, UNLESS OTHERWISE NOTED.
 - ADJUST FRAMING FOR PLUMBING AS NEEDED.
 - FLOOR JOISTS TO HAVE MINIMUM 3" BEARING ON BEAM/WALL BELOW AND 6" MAXIMUM JOIST OVERLAP.


- Key Notes
- | | |
|----|--|
| 1 | BEAM BELOW - RE: SHEET 2.01 STRUCTURE FOR SIZE |
| 2 | PLUMBING STACK |
| 3 | BEARING WALL BELOW |
| 4 | FLUSH BEAM - RE: SHEET 2.01 STRUCTURE FOR SIZE |
| 5 | -- |
| 6 | -- |
| 7 | -- |
| 8 | -- |
| 9 | -- |
| 10 | -- |
| 11 | |
| 12 | |
| 13 | |
| 14 | |
| 15 | |
| 16 | |
| 17 | |
| 18 | |
| 19 | |
| 20 | |



The Drees Company
09/10/2025 1:04:09 PM

Subdivision: SERENITY HAVEN	Customer Name: MODEL
Job #: STYH-0124-00	Job Address: TBD
Contract Drawn By: Phone #:	Original Site Specific Dwg. & Effective Change Order Date: 8/4/2025
Coordinator's Name: Coordinator's Phone #:	

RCA-0443-00.dwg Aug 04, 2025 - 4:10pm

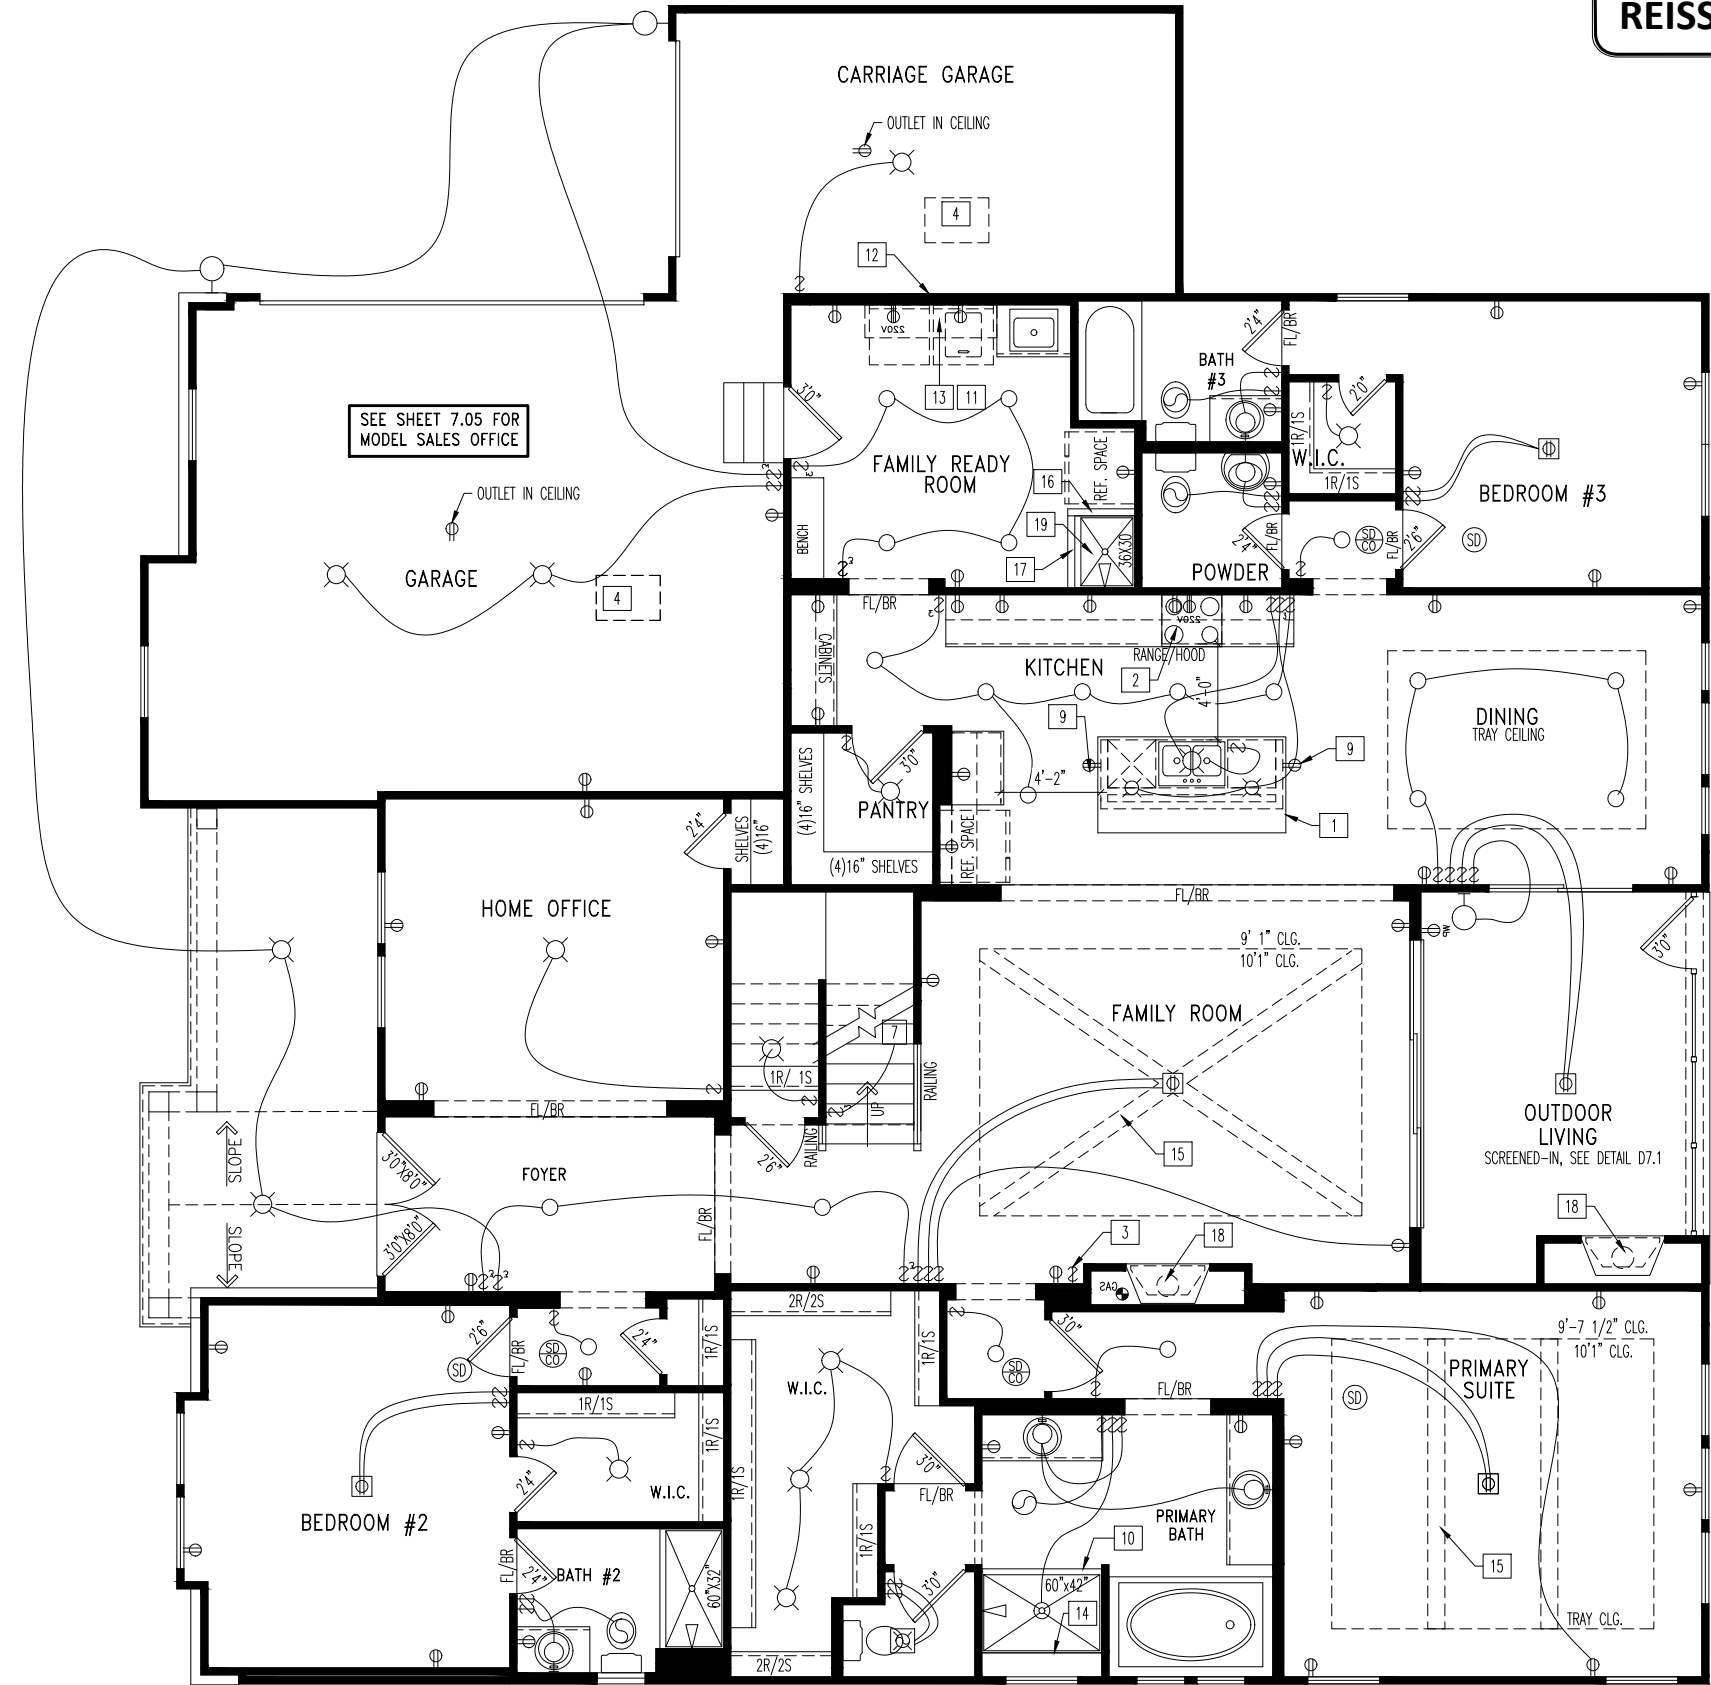

REISSUED: 08/26/2025

General Notes

- REFER TO SHEET ON.1 FOR GENERAL NOTES.

Key Notes

- | | |
|---|--|
| 1 KITCHEN ISLAND RE: DETAIL B/7.02 FOR COUNTERTOP DETAILS | 11 HOLD WASHER TO LEFT OF DRYER |
| 2 OUTLET FOR RANGE HOOD HELD HIGH | 12 TAP AND DRAIN |
| 3 SWITCH FOR DIRECT VENT FIREPLACE | 13 16" DEEP SHELF @ 5'7" A.F.F. |
| 4 22-1/2"x32" ATTIC ACCESS | 14 SHOWER SEAT INSTALLED AT 18" HIGH (SEE FRAMING NOTES FOR DETAILS) |
| 5 OUTLET FOR DISHWASHER LOCATED IN SINK CABINET | 15 BOX BEAM, SEE DETAIL B/7.02 |
| 6 TO SWITCH OR LIGHT BELOW | 16 5'0" HIGH WALL W/ WOOD CAP |
| 7 TO LIGHT OR SWITCH ABOVE | 17 2'0" HIGH WALL |
| 8 PRE-FABRICATED FIREPLACE INSERT | 18 PRE-FABRICATED WOOD BURNING FIREPLACE INSERT |
| 9 HOLD OUTLET HIGH ON ISLAND | 19 RAISED DOG WASH |
| 10 GLASS SHOWER ENCLOSURE | 20 -- |

Mechanical Legend

- | | |
|--|--|
| DATA JACK | FLUORESCENT LIGHT |
| WALL OUTLET | UNDER CABINET LIGHTING |
| WEATHERPROOF OUTLET | CLG. MOUNTED LIGHT FIXT. |
| 220 OUTLET | WALL MOUNTED LIGHT FIXT. |
| GROUND FAULT CIRCUIT INTERRUPT OUTLET | SURFACE MOUNT DISC LIGHT OR RECESSED CEILING LIGHT, PER SPECS. |
| FLOOR OUTLET | DOUBLE SPOTLIGHT FIXT. |
| COUNTER POP-UP OUTLET | DIRECTIONAL CAN LIGHT |
| CABLE TELEVISION JACK | PIN LIGHT |
| SINGLE POLE SWITCH | WALL SCONCE @ 5'-6" A.F.F. |
| 3-WAY SWITCH | STAIR LIGHT |
| 4-WAY SWITCH | CLG. MTD. EXHAUST FAN |
| SMOKE DETECTOR | WALL MTD. EXHAUST FAN |
| SMOKE DETECTOR/ CO DETECTOR COMBINATION | SHOWER HEAD |
| BLOCK, MOUNT, & SWITCH FOR FUTURE FAN/LIGHT COMBINATION (CENTER, UNLESS OTHERWISE NOTED) | HOSE BIB |
| EXHAUST FAN AND LIGHT COMBINATION | GAS HOOK UP |
| | FLOOR DRAIN |



The Drees Company
09/10/2025 1:04:09 PM

Subdivision: SERENITY HAVEN	Customer Name: MODEL
Job #: STYH-0124-00	Job Address: TBD
Contract Drawn By: EWT	Original Site Specific Dwg. & Effective Change Order Date: 8/4/2025
Phone #:	
Coordinator's Name: GREG P.	
Coordinator's Phone #: 859-578-4355	
STYH-0124-00.dwg Aug 26, 2025 - 3:33pm	

Drees
HOMES.

Drees Homes

8521 Six Forks Road, Suite 500, Raleigh, NC 27615 PH:(919) 844-9288
Copyright ©, 2015, (2012) The Drees Company. All Rights Reserved. No portion of this material may be reproduced in any form or by any means, including photocopying, without the express written permission of the Drees Company. The Drees Company will vigorously prosecute any unauthorized use of this material.

SCALE: 1/8" = 1'-0"
Sheet Description:
FIRST FLOOR MECHANICAL PLAN
ELEVATION "K"


Std. Drawn By:	WJS
Std. Chk. By:	ARC
Std. Date:	08/26/16
Date of Last Rev.	10/27/16 WJS

SEBASTIAN

Sheet No.

4.01

REISSUED: 08/26/2025

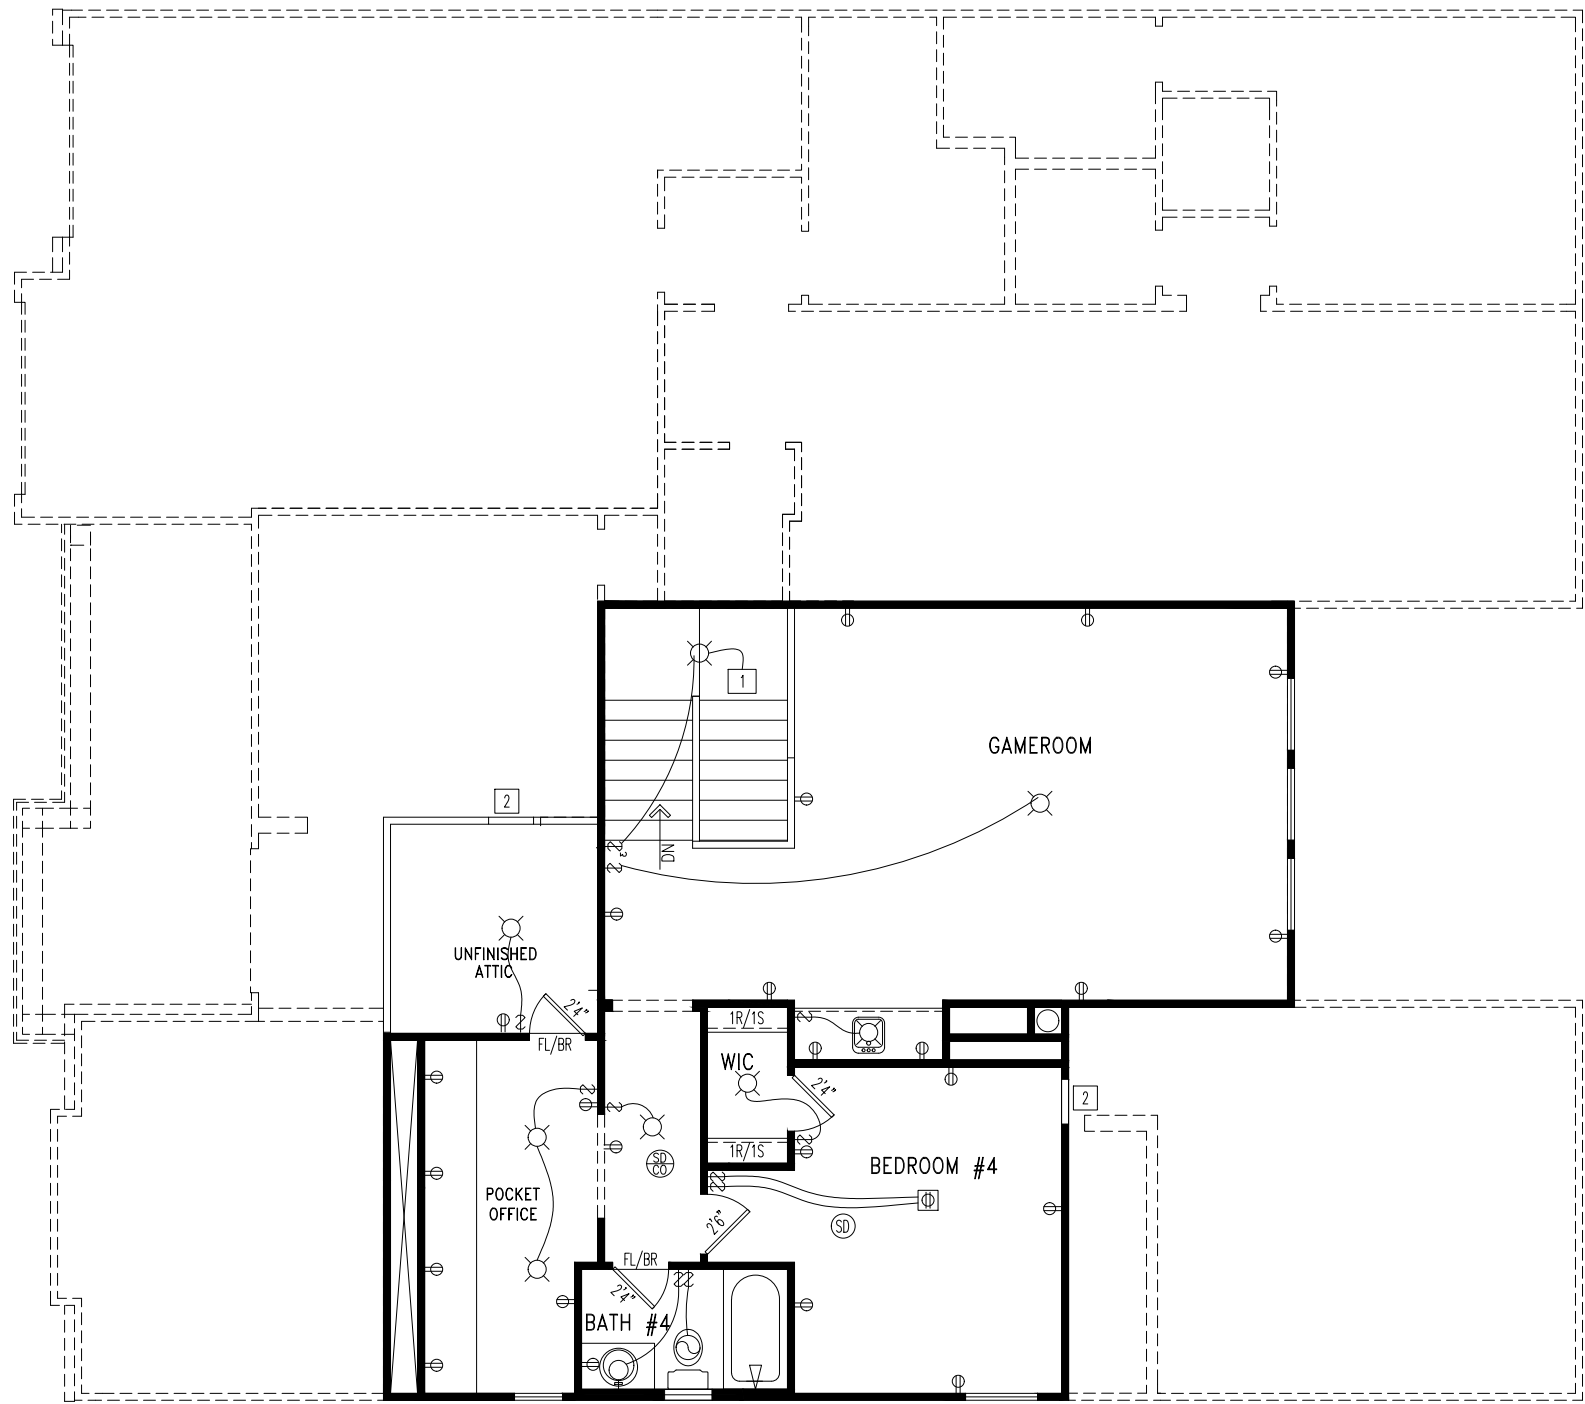

General Notes
- REFER TO SHEET ON.1 FOR GENERAL NOTES.

Key Notes

1	TO SWITCH OR LIGHT BELOW	11	--
2	22-1/2"x32" ATTIC ACCESS	12	--
3	--	13	--
4	--	14	--
5	--	15	--
6	--	16	--
7	--	17	--
8	--	18	--
9	--	19	--
10	--	20	--

Mechanical Legend

DATA JACK	FLUORESCENT LIGHT
WALL OUTLET	UNDER CABINET LIGHTING
WEATHERPROOF OUTLET	CLG. MOUNTED LIGHT FIXT.
220 OUTLET	WALL MOUNTED LIGHT FIXT.
GROUND FAULT CIRCUIT INTERRUPT OUTLET	SURFACE MOUNT DISC LIGHT OR RECESSED CEILING LIGHT, PER SPECS.
FLOOR OUTLET	DOUBLE SPOTLIGHT FIXT.
COUNTER POP-UP OUTLET	DIRECTIONAL CAN LIGHT
CABLE TELEVISION JACK	PIN LIGHT
SINGLE POLE SWITCH	WALL SCONCE @ 5'-6" A.F.F.
3-WAY SWITCH	STAIR LIGHT
4-WAY SWITCH	CLG. MTD. EXHAUST FAN
SMOKE DETECTOR	WALL MTD. EXHAUST FAN
SMOKE DETECTOR/ CO DETECTOR COMBINATION	SHOWER HEAD
BLOCK, MOUNT, & SWITCH FOR FUTURE FAN/LIGHT COMBINATION (CENTER, UNLESS OTHERWISE NOTED)	HOSE BIB
EXHAUST FAN AND LIGHT COMBINATION	GAS HOOK UP
	FLOOR DRAIN



The Drees Company
09/10/2025 1:04:09 PM

Subdivision: SERENITY HAVEN	Customer Name: MODEL
Job #: STYH-0124-00	Job Address: TBD
Contract Drawn By: Phone #: Coordinator's Name: Coordinator's Phone #:	EW GREG P. 859-578-4355
Original Site Specific Dwg. & Effective Change Order Date: 8/4/2025	
STYH-0124-00.dwg Aug 26, 2025 - 3:33pm	

drees
HOMESSM

Drees Homes
8521 Six Forks Road, Suite 500, Raleigh, NC 27615 PH:(919) 844-9288
Copyright ©, 2015, (2012) The Drees Company. All Rights Reserved. No portion of this material may be reproduced in any form or by any means, including photocopying, without the express written permission of the Drees Company. The Drees Company will vigorously prosecute any unauthorized use of this material.

SCALE: 1/8" = 1'-0"

SECOND FLOOR MECHANICAL PLAN


Std. Drawn By:	WJS
Std. Chk. By:	ARC
Std. Date:	08/26/16
Date of Last Rev:	REL_DT

House: SEBASTIAN

Series:

Sheet No.

4.02

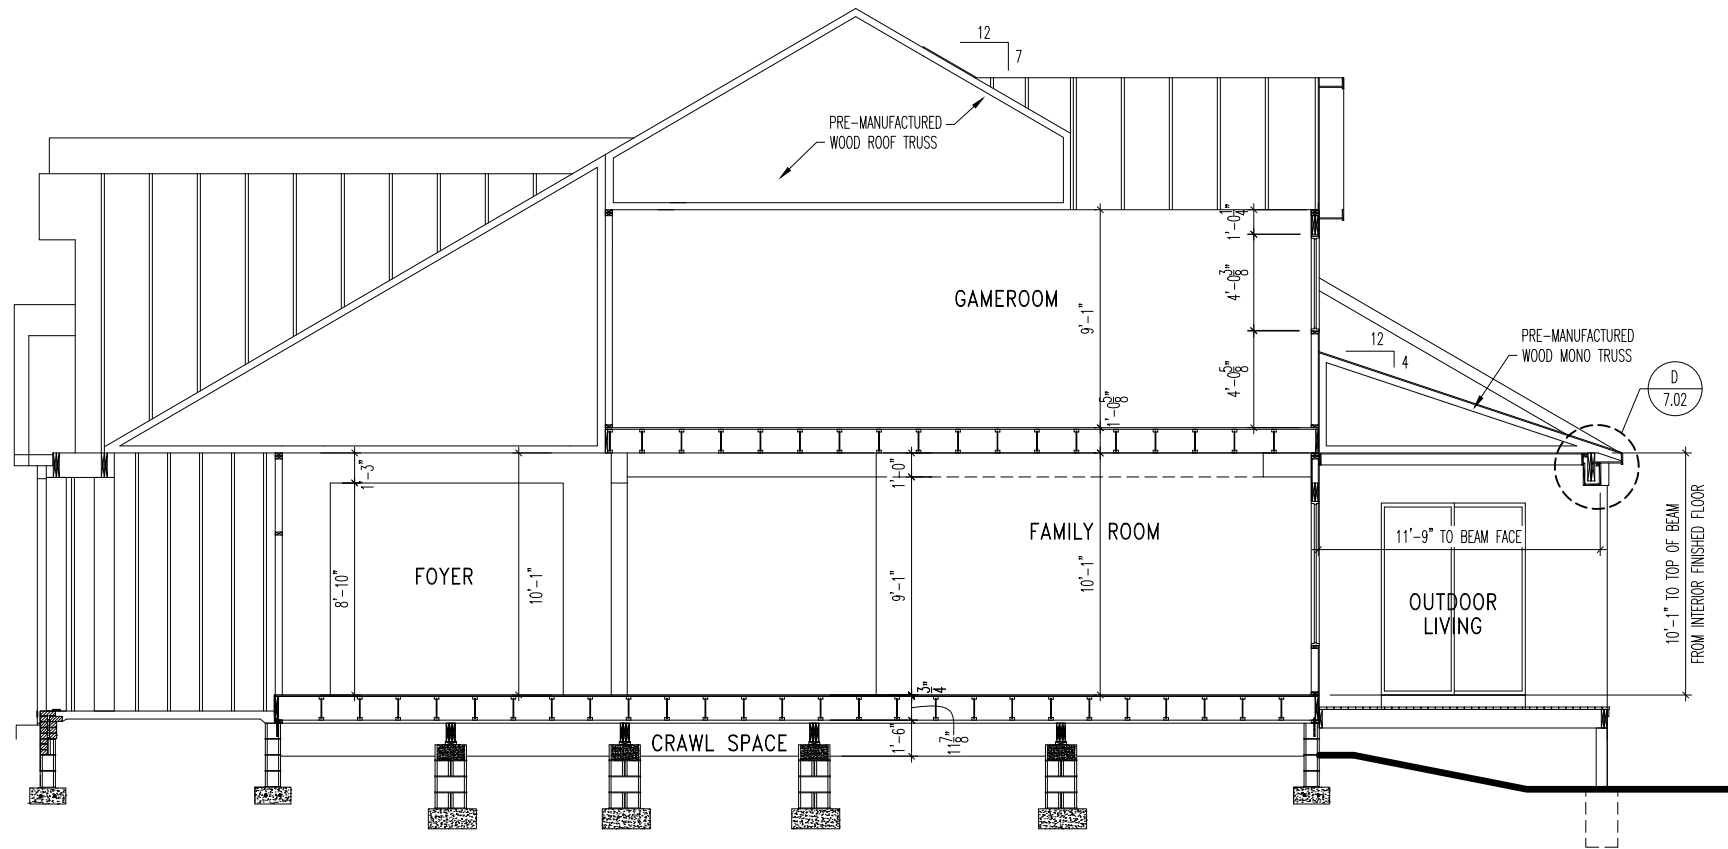

A
5.01

BUILDING SECTION THRU FOYER

SCALE: 1/8" = 1'-0"

General Notes

- REFER TO SHEET 0N.1 FOR GENERAL NOTES.

Key Notes

-
-
The Drees Company
09/10/2025 1:04:09 PM

Subdivision: SERENITY HAVEN		Customer Name: MODEL	
Job #: STYH-0124-00		Job Address: TBD	
Contract Drawn By: EWT		Original Site Specific Dwg. & Effective Change Order Date: 8/4/2025	
Phone #:		Coordinator's Name: GREG P.	
Coordinator's Phone #: 859-578-4355		RCA-0443-00.dwg Aug 04, 2025 - 4:10pm	

House:

SEBASTIAN

Sheet No.

5.01

Std. Drawn By: MJS

Std. Chk. By: ARC

Std. Date: 08/26/16

Date of 10/27/16 MJS

Last Rev:


SCALE: 1/8" = 1'-0"

BUILDING SECTIONS
ELEVATION "K"

Drees Homes

8521 Six Forks Road, Suite 500, Raleigh, NC 27615 PH:(919) 844-9288
Copyright © 2015, (2012) The Drees Company. All Rights Reserved. No portion of this material may be reproduced in any form or by any means, including photocopying, without the express written permission of the Drees Company. The Drees Company will vigorously prosecute any unauthorized use of this material.

Drees
HOMES.

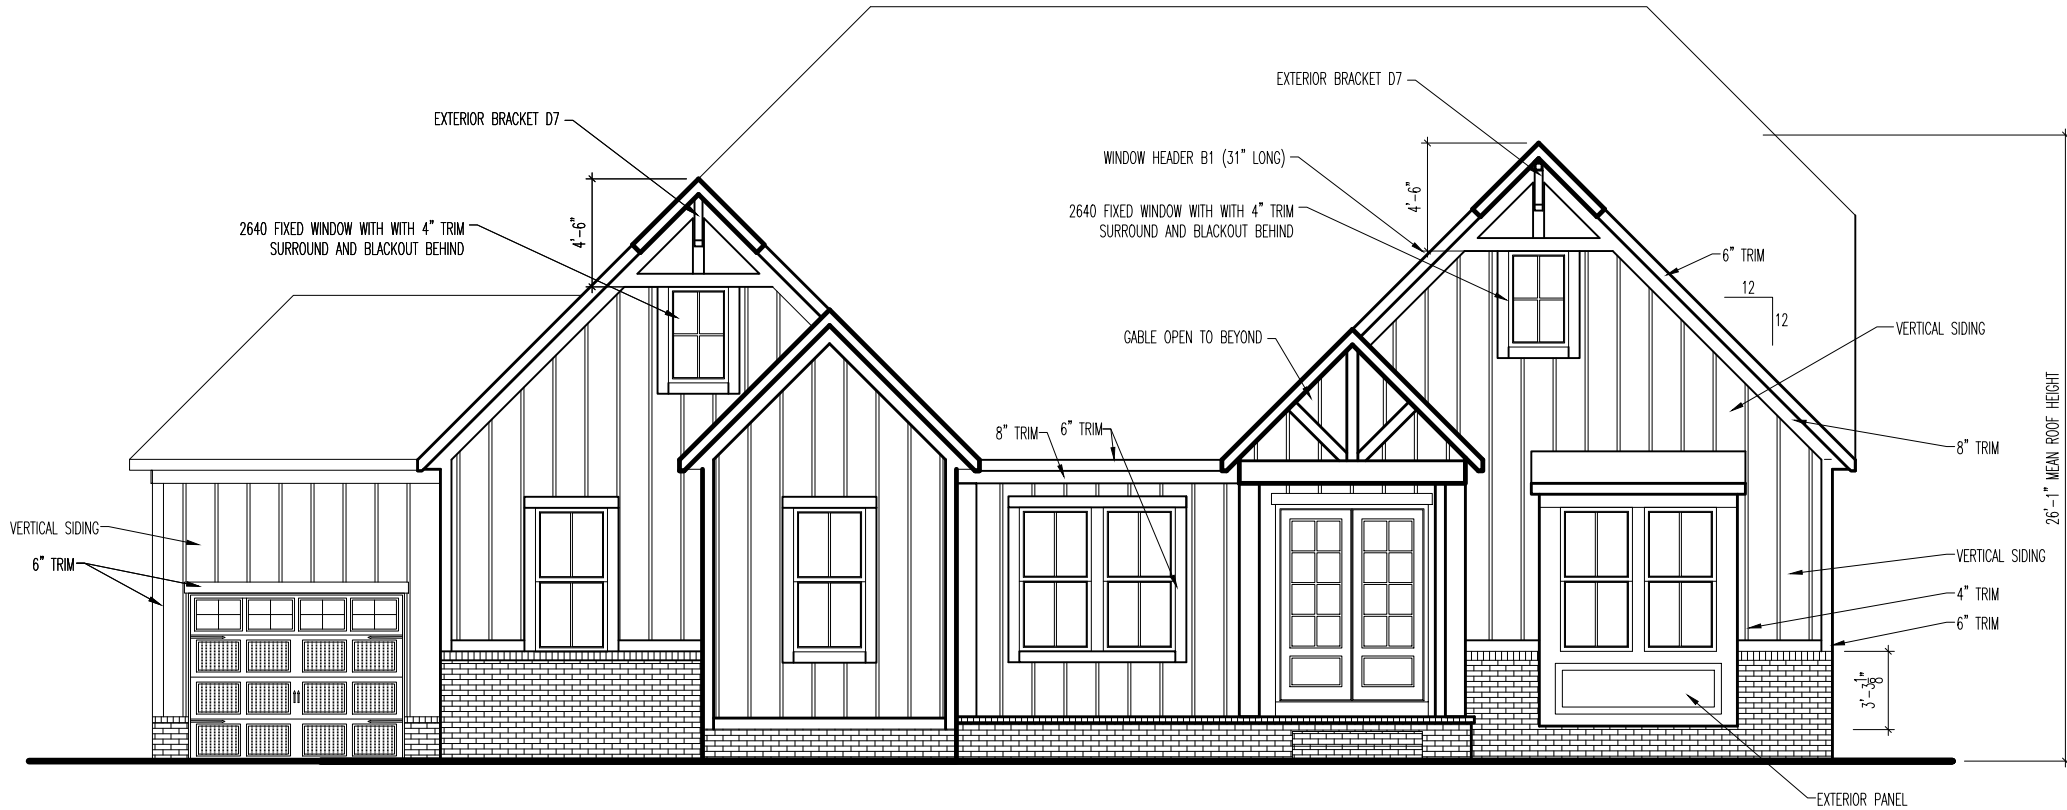

General Notes

- REFER TO SHEET ON.1 FOR GENERAL NOTES.
- ROOFING PER SPECIFICATIONS.

Key Notes

- 1
- 2
- 3
- 4
- 5
- 6
- 7
- 8
- 9
- 10
- 11
- 12
- 13
- 14
- 15



The Drees Company
09/10/2025 1:04:09 PM

Subdivision: SERENITY HAVEN	Customer Name: MODEL
Job #: STYH-0124-00	Job Address: TBD
Contract Drawn By: EWI	Original Site Specific Dwg. & Effective Change Order Date: 8/4/2025
Phone #:	
Coordinator's Name: GREG P.	
Coordinator's Phone #: 859-578-4355	
RGA-0443-00.dwg Aug 04, 2025 - 4:10pm	

drees

HOMESSM

Drees Homes

8521 Six Forks Road, Suite 500, Raleigh, NC 27615 PH:(919) 844-9288

Copyright © 2015, (2012) The Drees Company. All Rights Reserved. No portion of this material may be reproduced in any form or by any means, including photocopying, without the express written permission of the Drees Company. The Drees Company will vigorously prosecute any unauthorized use of this material.

SCALE: 1/8" = 1'-0"

Sheet Description:
**FRONT ELEVATION
ELEVATION "K"**


Sta. Drawn By: **WJS**
Sta. Chk. By: **ARC**
Sta. Date: **08/26/16**
Date of Last Rev.: **10/27/16**

SEBASTIAN

House:
SEBASTIAN

Series:
6.01

Sheet No.
6.01

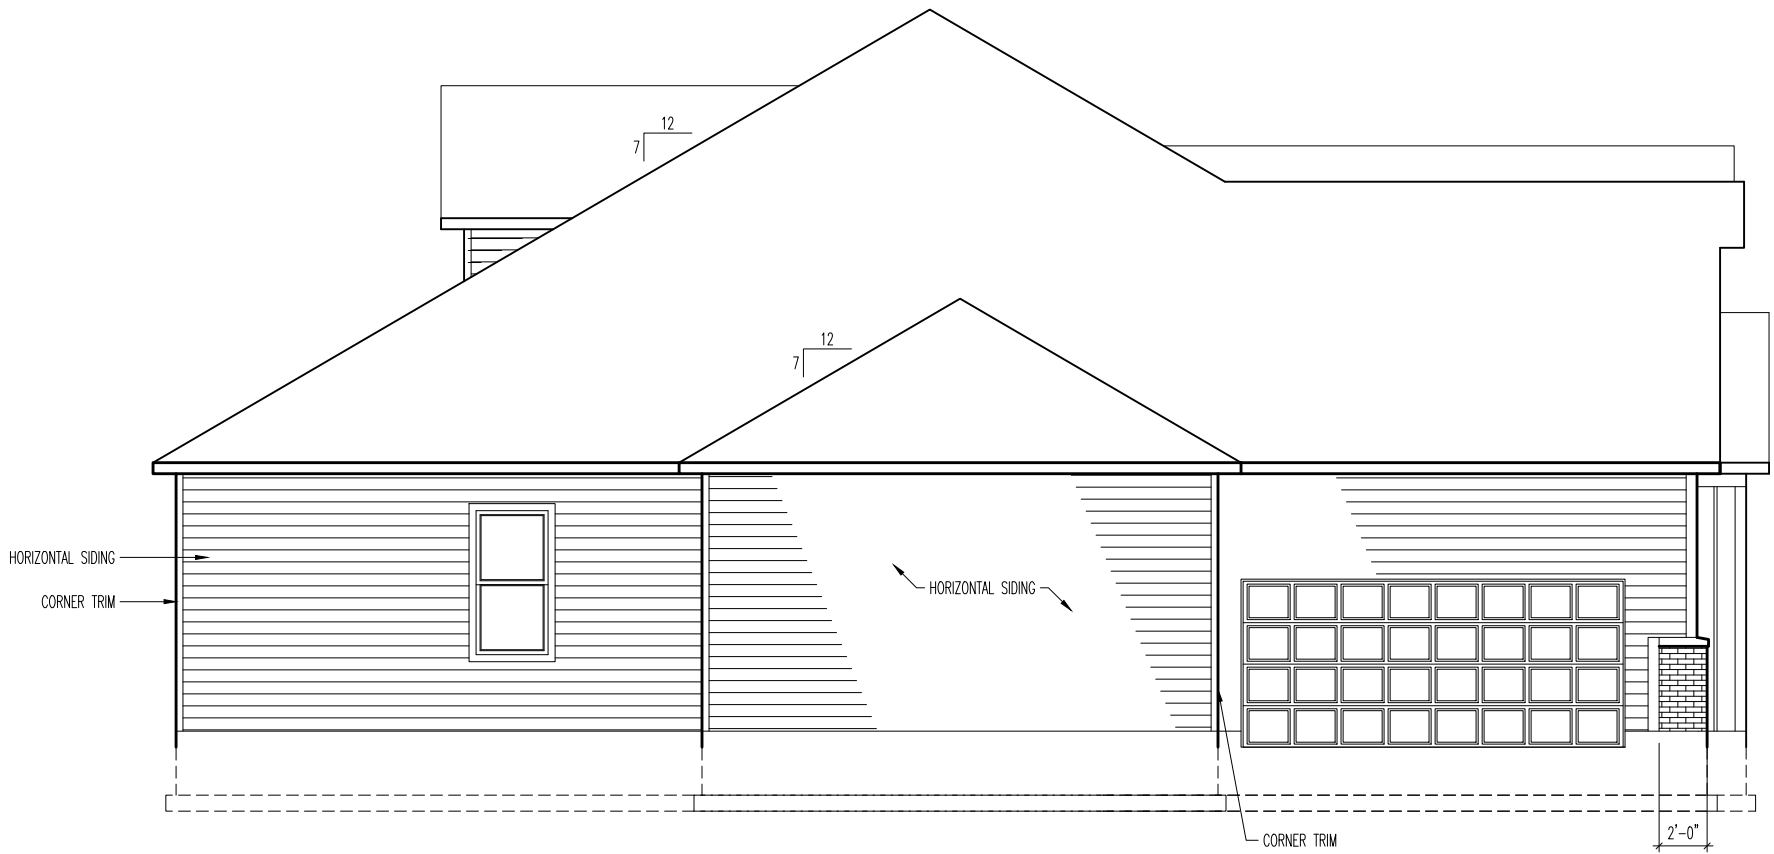

REISSUED: 08/19/2025

TYPICAL TRIM:
6" FASCIA - 8" w/ HARDIE SOFITT (ALL SIDES)
8" FRIEZE (FRONT ONLY UNLESS OTHERWISE NOTED)

General Notes

- REFER TO SHEET ON.1 FOR GENERAL NOTES.
- ROOFING PER SPECIFICATIONS.
- REFER TO SHEET 6.01 FOR LINTEL SCHEDULE, AS NEEDED.

Key Notes

- 1
-
- 2
-
- 3
-
- 4
-
- 5
-
- 6
-
- 7
-
- 8
-
- 9
-
- 10
-
- 11
-
- 12
-
- 13
-
- 14
-
- 15
-



The Drees Company
09/10/2025 1:04:09 PM

Subdivision: SERENITY HAVEN	Customer Name: MODEL
Job #: STYH-0124-00	Job Address: TBD
Contract Drawn By: EWI	Original Site Specific Dwg. & Effective Change Order Date: 8/4/2025
Phone #:	
Coordinator's Name: GREG P.	
Coordinator's Phone #: 859-578-4355	
RGA-0443-00.dwg Aug 19, 2025 - 10:51am	



Drees Homes
8521 Six Forks Road, Suite 500, Raleigh, NC 27615 PH:(919) 844-9288
Copyright ©, 2015, (2012) The Drees Company. All Rights Reserved. No portion of this material may be reproduced in any form or by any means, including photocopying, without the express written permission of the Drees Company. The Drees Company will vigorously prosecute any unauthorized use of this material.

SCALE: 1/8" = 1'-0"	SHEET DESCRIPTION:
	GARAGE SIDE ELEVATION
	ELEVATION "K"
Std. Drawn By: MJS	ARC
Std. Chk. By: ARC	
Std. Date: 08/26/16	
Date of 10/27/16	MJS
Last Rev:	

SEBASTIAN	Plan No.:
	Series:

Sheet No.

6.02



TYPICAL TRIM:
6" FASCIA - 8" w/ HARDIE SOFITT (ALL SIDES)
8" FRIEZE (FRONT ONLY UNLESS OTHERWISE NOTED)

General Notes
-- REFER TO SHEET ON.1 FOR GENERAL NOTES. -- ROOFING PER SPECIFICATIONS. -- REFER TO SHEET 6.01 FOR LINTEL SCHEDULE, AS NEEDED.
Key Notes
1 -- 2 -- 3 -- 4 -- 5 -- 6 -- 7 -- 8 -- 9 -- 10 -- 11 -- 12 -- 13 -- 14 -- 15 --

The Drees Company
09/10/2025 1:04:10 PM

Subdivision: SERENITY HAVEN	Customer Name: MODEL
Job #: TYH-0124-00	Job Address: TBD
Contract Drawn By: Phone #:	Original Site Specific Dwg. & Effective Change Order Date: 8/4/2025
Coordinator's Name: Coordinator's Phone #:	
GREG P. 859-578-4355	
GA-0443-00.dwg Aug 19, 2025 - 10:51am	



The Drees Company
09/10/2025 1:04:10 PM

Drees Homes

8521 Six Forks Road, Suite 500, Raleigh, NC 27615 PH:(919) 844-9288
Copyright © 2015, (2012) The Drees Company. All Rights Reserved. No portion of this material may be reproduced in any form or by any means, including photocopying, without the express written permission of the Drees Company. The Drees Company will vigorously prosecute any unauthorized use of this material.

SEBASTIAN

House: SEBASTIAN

Series:


Sheet No.

6.03

Scale: 1/8" = 1'-0"

Sheet Description: REAR ELEVATION
ELEVATION "K"

Std. Drawn By: WJS
Std. Chk. By: ARC
Std. Date: 08/26/16
Date of Last Rev: 10/27/16

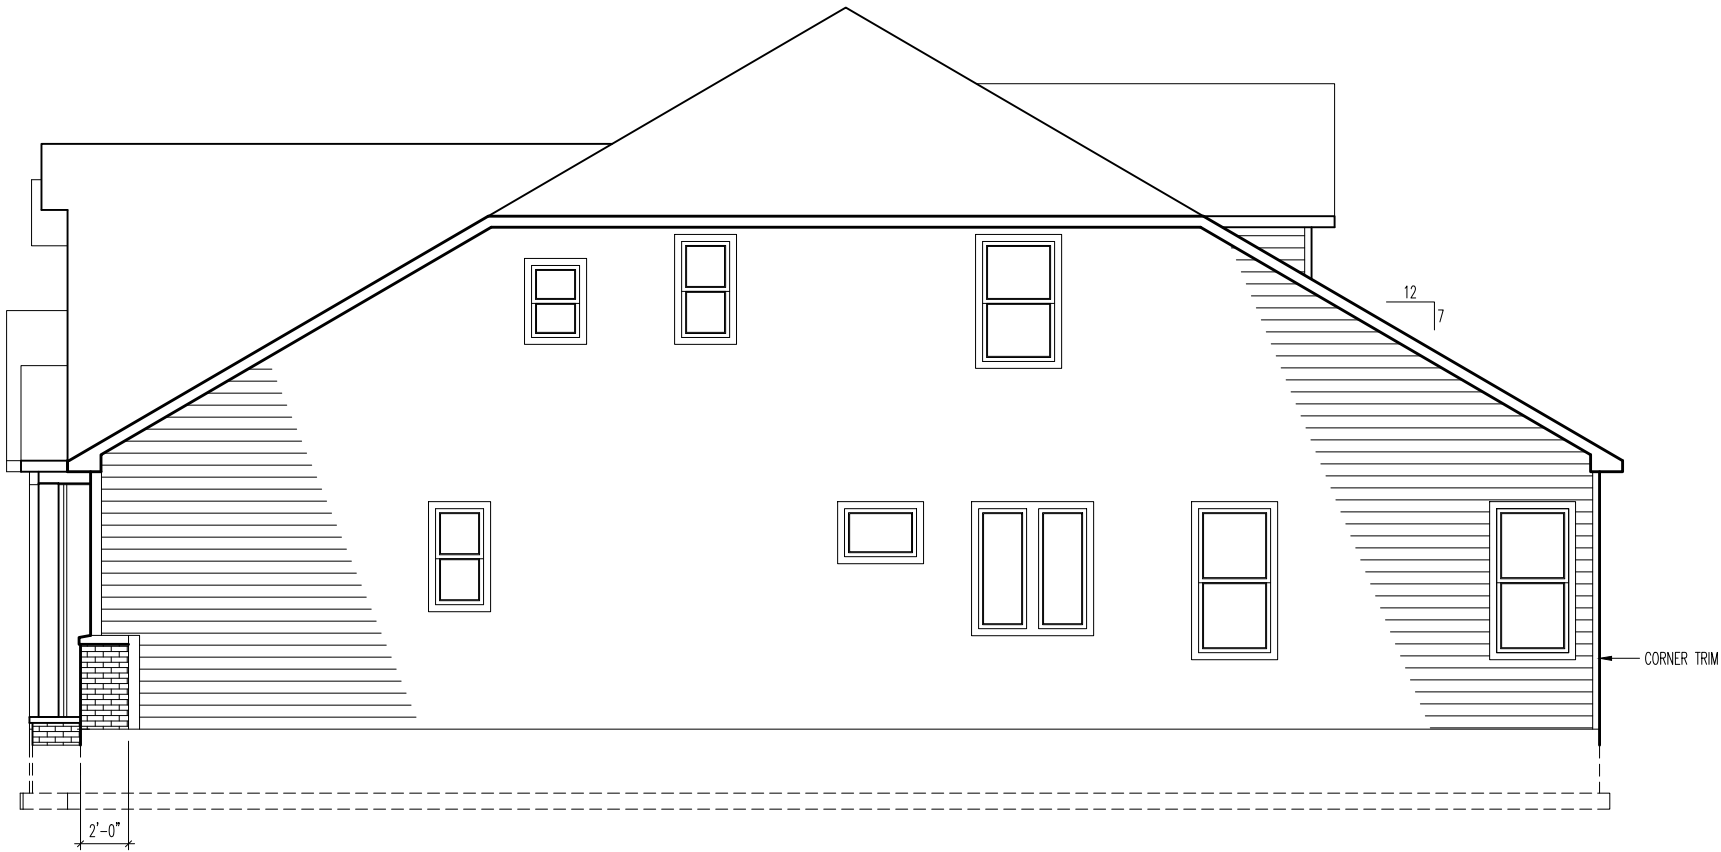

REISSUED: 08/26/2025

TYPICAL TRIM:
6" FASCIA - 8" w/ HARDIE SOFITT (ALL SIDES)
8" FRIEZE (FRONT ONLY UNLESS OTHERWISE NOTED)

General Notes

- REFER TO SHEET ON.1 FOR GENERAL NOTES.
- ROOFING PER SPECIFICATIONS.
- REFER TO SHEET 6.01 FOR UNTEL SCHEDULE, AS NEEDED.

Key Notes

-
-
The Drees Company
09/10/2025 1:04:10 PM

Subdivision: SERENITY HAVEN	Customer Name: MODEL
Job #: STYH-0124-00	Job Address: TBD
Contract Drawn By: EWI	Original Site Specific Dwg. & Effective Change Order Date: 8/4/2025
Phone #:	
Coordinator's Name: GREG P.	
Coordinator's Phone #: 859-578-4355	
STYH-0124-00.dwg Aug 26, 2025 - 3:33pm	

Drees
HOMES.

Drees Homes
8521 Six Forks Road, Suite 500, Raleigh, NC 27615 PH:(919) 844-9288
Copyright © 2015, (2012) The Drees Company. All Rights Reserved. No portion of this material may be reproduced in any form or by any means, including photocopying, without the express written permission of the Drees Company. The Drees Company will vigorously prosecute any unauthorized use of this material.

Std. Drawn By: WJS	Sheet Description: SIDE ELEVATION "K"	SCALE: 1/8" = 1'-0"
Std. Chk. By: ARC	ELEVATION	
Std. Date: 08/26/16		
Date of 10/27/16 WJS		
House: SEBASTIAN	Plan No.:	Series:

Sheet No.

6.04

General Notes

- REFER TO SHEET ON.1 FOR GENERAL NOTES.

Key Notes

- 1
-
- 2
-
- 3
-
- 4
-
- 5
-
- 6
-
- 7
-
- 8
-
- 9
-
- 10
-



The Drees Company
09/10/2025 1:04:10 PM

Subdivision: SERENITY HAVEN		Customer Name: MODEL	
Job #: STYH-0124-00		Job Address: TBD	
Contract Drawn By: EWT		Original Site Specific Dwg. & Effective Change Order Date: 8/4/2025	
Phone #:			
Coordinator's Name: GREG P.			
Coordinator's Phone #: 859-578-4355			
RGA-0443-00.dwg Aug 04, 2025 - 4:11pm			




Drees Homes
8521 Six Forks Road, Suite 500, Raleigh, NC 27615 PH:(919) 844-9288
Copyright © 2015, (2012) The Drees Company. All Rights Reserved. No portion of this material may be reproduced, stored in a retrieval system, or by any means, including photocopying, without the express written permission of the Drees Company. The Drees Company will vigorously prosecute any unauthorized use of this material.

Std. Drawn By:	WJS	Sheet Description:	SCALE: 1/8" = 1'-0"
Std. Ck. By:	ARC	HOUSE SPECIFIC DETAILS	
Std. Date:	08/26/16	ELEVATION "K"	
Date of Last Rev:	10/27/16	WJS	


House: SEBASTIAN	Plan No.:
	Series:

Sheet No.


7.01

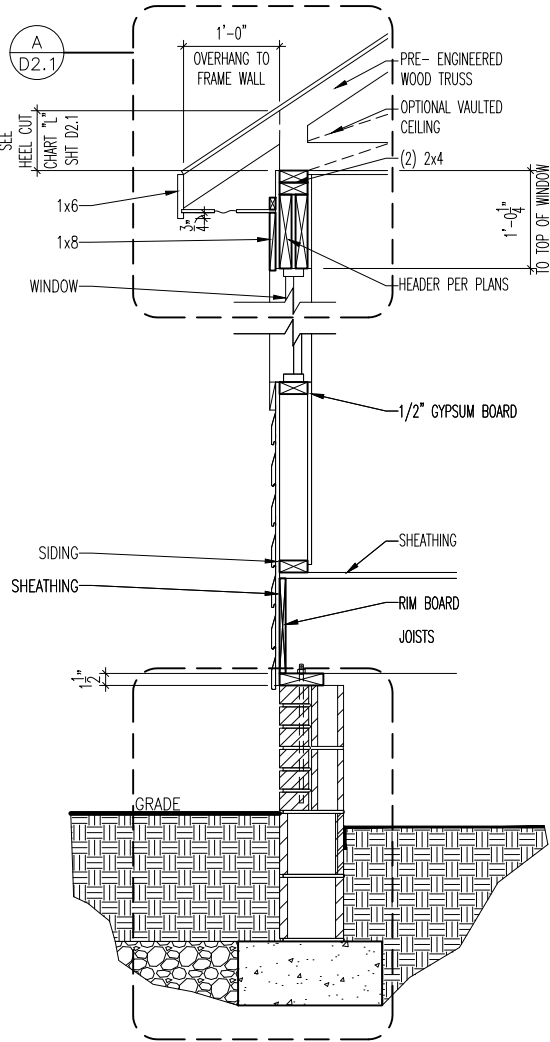


A
7.01
TYP. RANCH FRAME WRAP WALL SECTION
SCALE: 1/2" = 1'0"

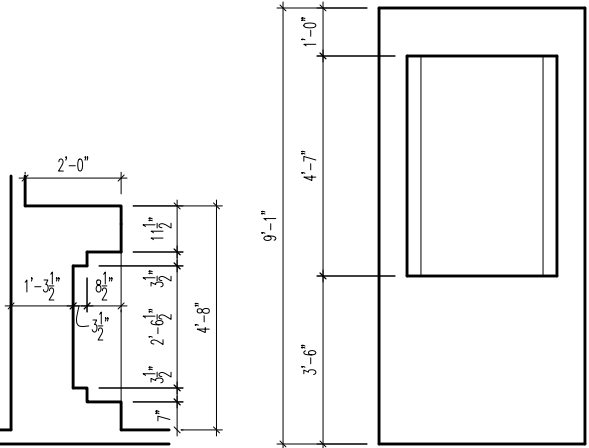


PLAN
ELEVATION
E
7.01
PRIMARY BATH NICHE DETAIL
SCALE: 1/4" = 1'-0"

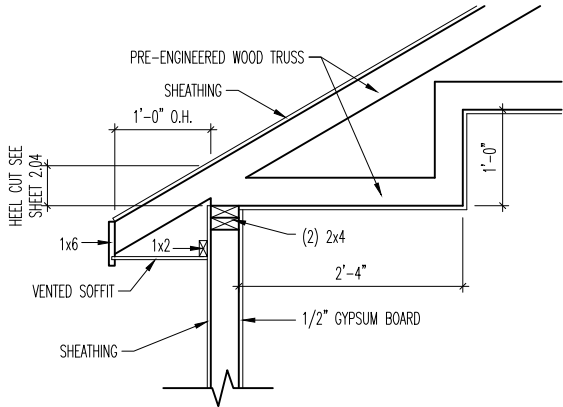


D
7.01
DINING ROOM TRAY CEILING DETAIL
SCALE: 1/2" = 1'-0"

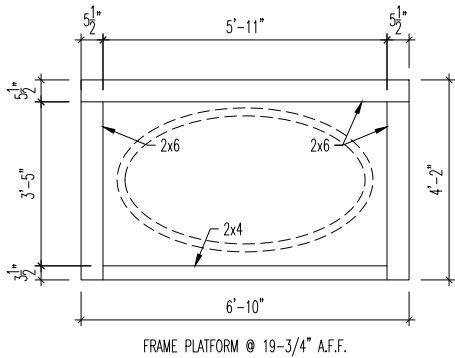

C
7.01
TUB FRAMING DETAIL
SCALE: 1/4" = 1'-0"

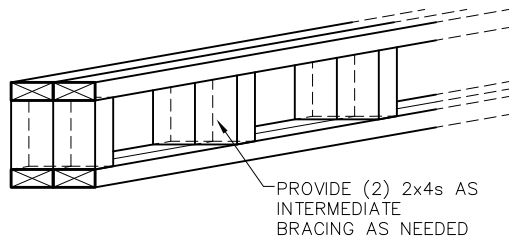


ISOMETRIC VIEW

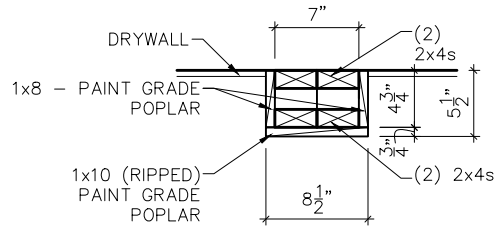

SECTION


SEE SHEET 2.01 FOR
ACTUAL LOCATIONS AND
ORIENTATION OF BEAMS

BOX BEAM CEILING DETAIL
SCALE: 1/4" = 1'-0"

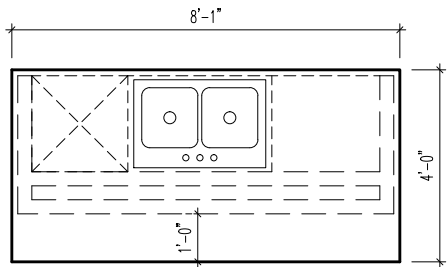

COUNTERTOP

KITCHEN ISLAND FRAMING DETAILS
SCALE: 1/4" = 1'-0"

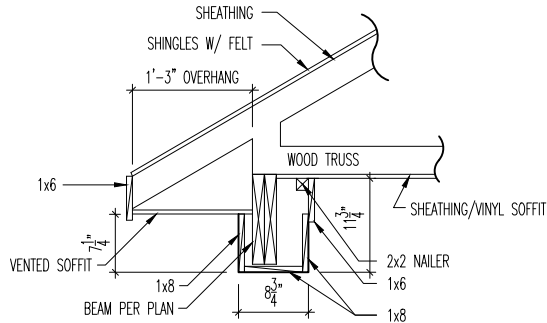

COVERED PATIO BEAM DETAIL
SCALE: 1/2" = 1'-0"

REISSUED: 08/19/2025

General Notes

- REFER TO SHEET 0N.1 FOR GENERAL NOTES.

Key Notes

- 1 --
- 2 --
- 3 --
- 4 --
- 5 --
- 6 --
- 7 --
- 8 --
- 9 --
- 10 --



The Drees Company
09/10/2025 1:04:10 PM

Subdivision: SERENITY HAVEN	Customer Name: MODEL
Job #: STYH-0124-00	Job Address: TBD
Contract Drawn By: EWT	Original Site Specific Dwg. & Effective Change Order Date: 8/4/2025
Phone #:	
Coordinator's Name: GREG P.	
Coordinator's Phone #: 859-578-4355	
STYH-0124-00.dwg Aug 19, 2025 - 2:09pm	

drees
HOMESSM


Drees Homes
8521 Six Forks Road, Suite 500, Raleigh, NC 27615 PH:(919) 844-9288
Copyright © 2015, (2012) The Drees Company. All Rights Reserved. No portion of this material may be reproduced in any form or by any means, including photocopying, without the express written permission of the Drees Company. The Drees Company will vigorously prosecute any unauthorized use of this material.

Sheet Description: HOUSE SPECIFIC DETAILS ELEVATION "K"	SCALE: 1/8" = 1'-0"
Std. Drawn By: MJS	Std. Chk. By: ARC
Std. Date: 08/26/16	Date of 10/27/16 MJS
Std. Rev.	


House: SEBASTIAN	Plan No.:
Series:	

Sheet No.


7.02

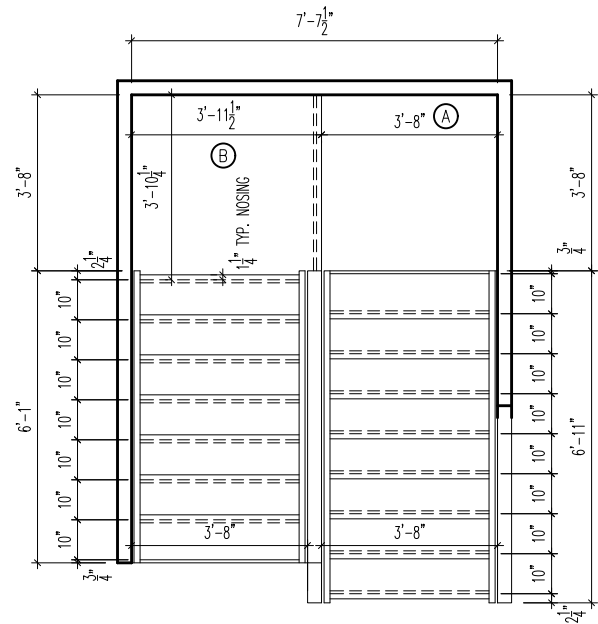

STAIR INFO.
18 RISERS @ 7-7/16"
17 TREADS @ 10"

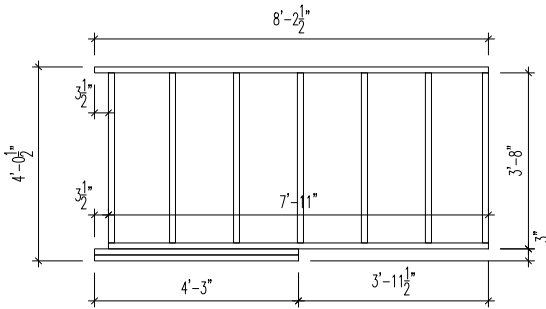

A LANDING DETAIL
SCALE: 1/4" = 1'-0"

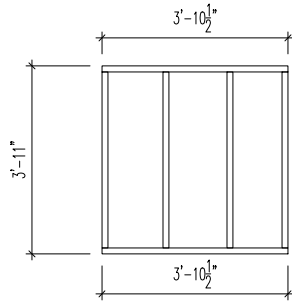


B LANDING DETAIL
SCALE: 1/4" = 1'-0"

A
7.03

SECOND FLOOR STAIR FRAMING DETAILS

SCALE: 1/4" = 1'-0"

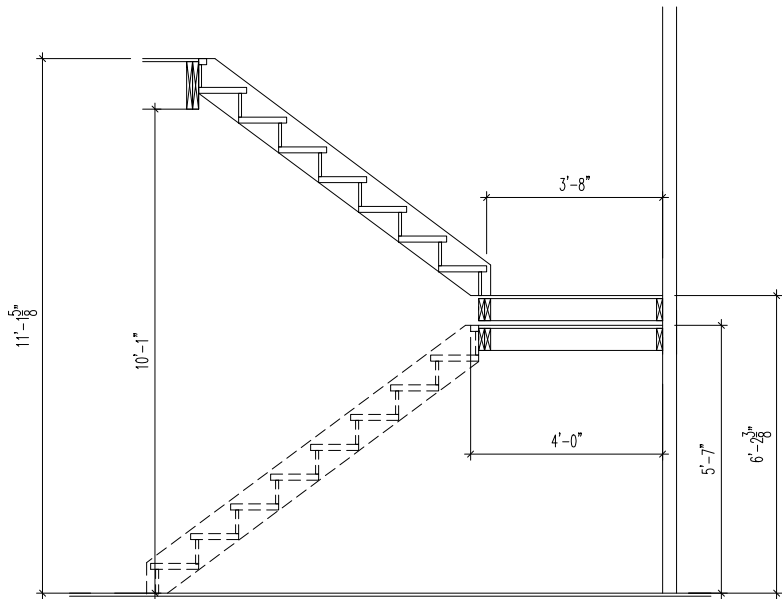

CRAWL SPACE

A
7.03

STAIR SECTION

SCALE: 1/4" = 1'-0"

General Notes

- REFER TO SHEET ON.1 FOR GENERAL NOTES.

Key Notes

-
-
The Drees Company
09/10/2025 1:04:10 PM

Subdivision: SERENITY HAVEN	Customer Name: MODEL
Job #: STYH-0124-00	Job Address: TBD
Contract Drawn By: Phone #:	Original Site Specific Dwg. & Effective Change Order Date:
Coordinator's Name: Coordinator's Phone #:	8/4/2025
RGA-0443-00.dwg Aug 04, 2025 - 4:11pm	




Drees
HOMES

Drees Homes
8521 Six Forks Road, Suite 500, Raleigh, NC 27615 PH:(919) 844-9288
Copyright ©, 2015, (2012) The Drees Company. All Rights Reserved. No portion of this material may be reproduced in any form or by any means, including photocopying, without the express written permission of the Drees Company. The Drees Company will vigorously prosecute any unauthorized use of this material.


Sta. Drawn By: MJS	Sheet Description: HOUSE SPECIFIC DETAILS ELEVATION K	SCALE: 1/8" = 1'-0"
Sta. Chk. By: ARC		
Sta. Date: 08/26/16		
Date of Last Rev: 10/27/16		
House: SEBASTIAN	Plan No.:	Series:

Sheet No.


7.03

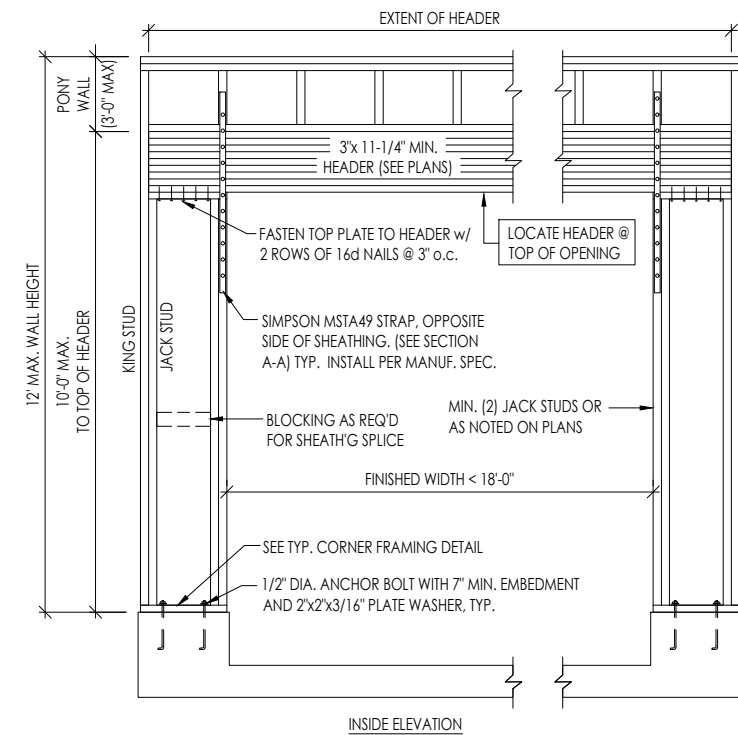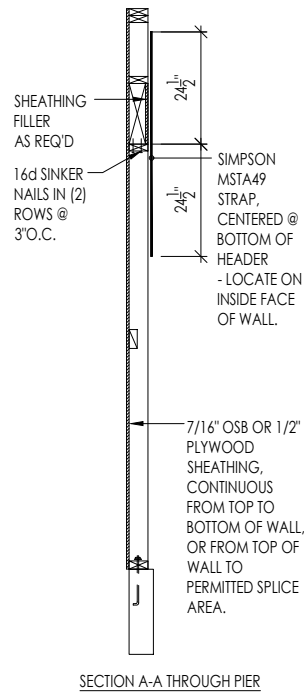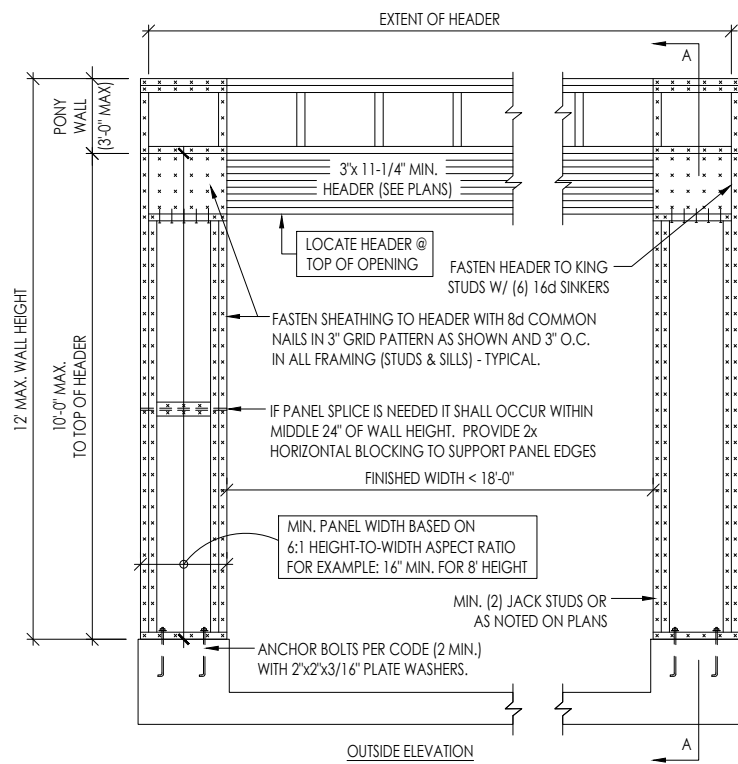


NOTE: ALL SHEATHABLE AREAS OF EXTERIOR WALL SHALL BE FULLY SHEATHED WITH 1/2" PLYWOOD OR 7/16" OSB

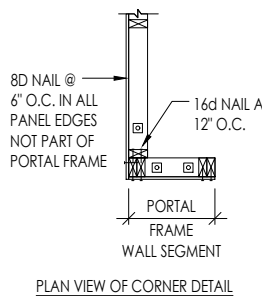


1
7.04
GARAGE PORTAL FRAME BRACING ELEVATION
NOT TO SCALE BOTH SIDES OF GARAGE DOOR

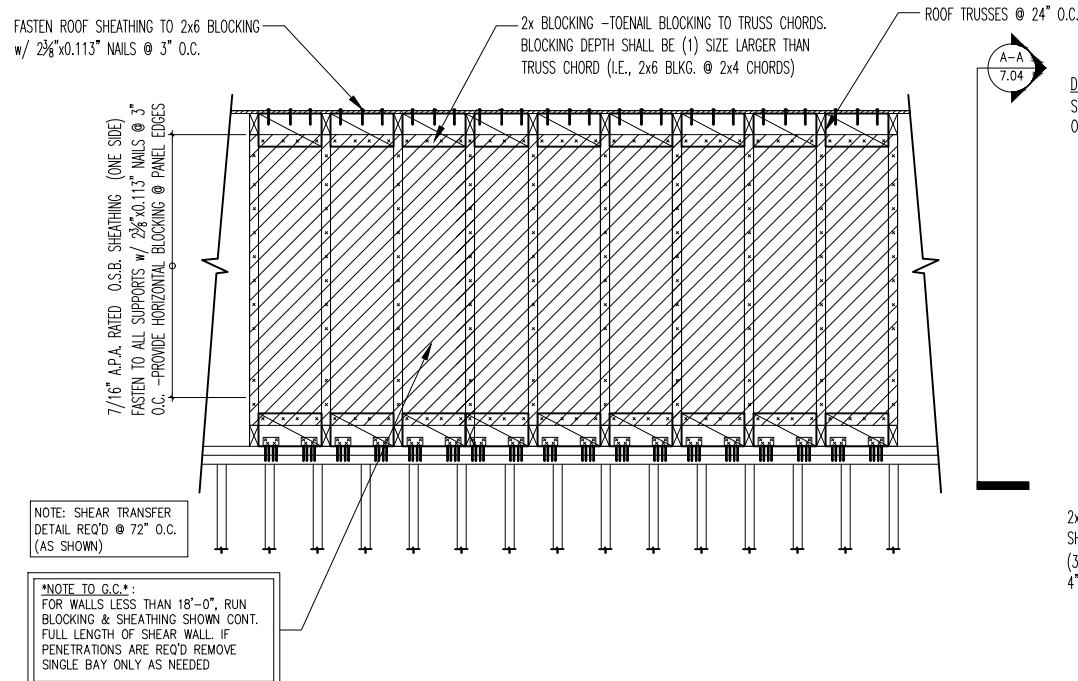

A-A
TYPICAL SHEAR TRANSFER DETAIL
@ INTERIOR SHEARWALL
SCALE: 3/8"=1'-0"

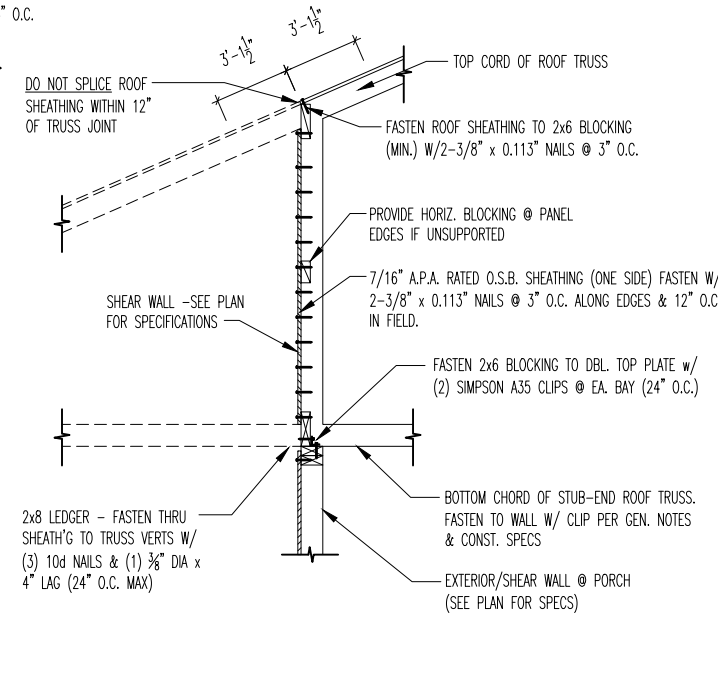

2
7.04
TYPICAL SHEAR TRANSFER DETAIL
@ INTERIOR SHEARWALL
SCALE: 3/8"=1'-0"

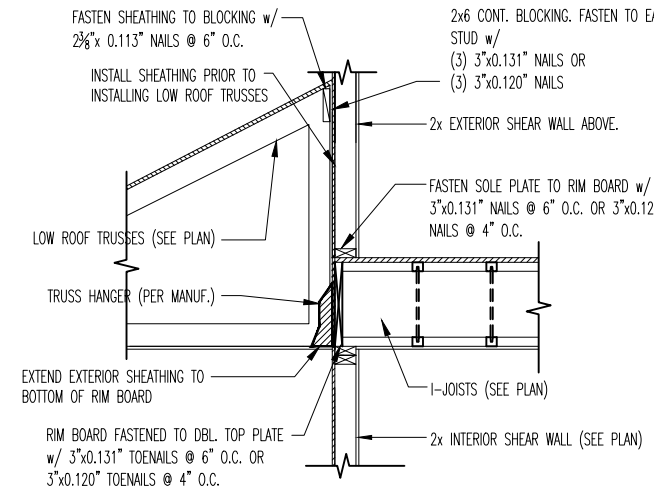

3
7.04
TYPICAL SHEAR TRANSFER DETAIL
BETWEEN FLOORS @ INTERIOR WALL
SCALE: 3/8"=1'-0"

General Notes

- REFER TO SHEET ON.1 FOR GENERAL NOTES.



The Drees Company
09/10/2025 1:04:11 PM


Subdivision: SERENITY HAVEN	Customer Name: MODEL
Job #: STYH-0124-00	Job Address: TBD
Contract Drawn By: EWT	Original Site Specific Dwg. & Effective Change Order Date: 8/4/2025
Phone #:	
Coordinator's Name: GREG P.	
Coordinator's Phone #: 859-578-4355	
RG4-0443-00.dwg Aug 04, 2025 - 4:11pm	

Drees Homes





Drees Homes

8521 Six Forks Road, Suite 500, Raleigh, NC 27615 PH:(919) 844-9288
Copyright ©, 2015, (2012) The Drees Company. All Rights Reserved. No portion of this material may be reproduced in any form or by any means, including photocopying, without the express written permission of the Drees Company. The Drees Company will vigorously prosecute any unauthorized use of this material.

Scale: 1/8" = 1'-0"	Sheet Description: HOUSE SPECIFIC DETAILS ELEVATION "K"
Std. Drawn By: MJS	Std. Chk. By: ARC
Std. Date: 08/26/16	Date of 10/27/16 MJS
House: SEBASTIAN	Plan No.:
Series:	Sheet No. 7.04

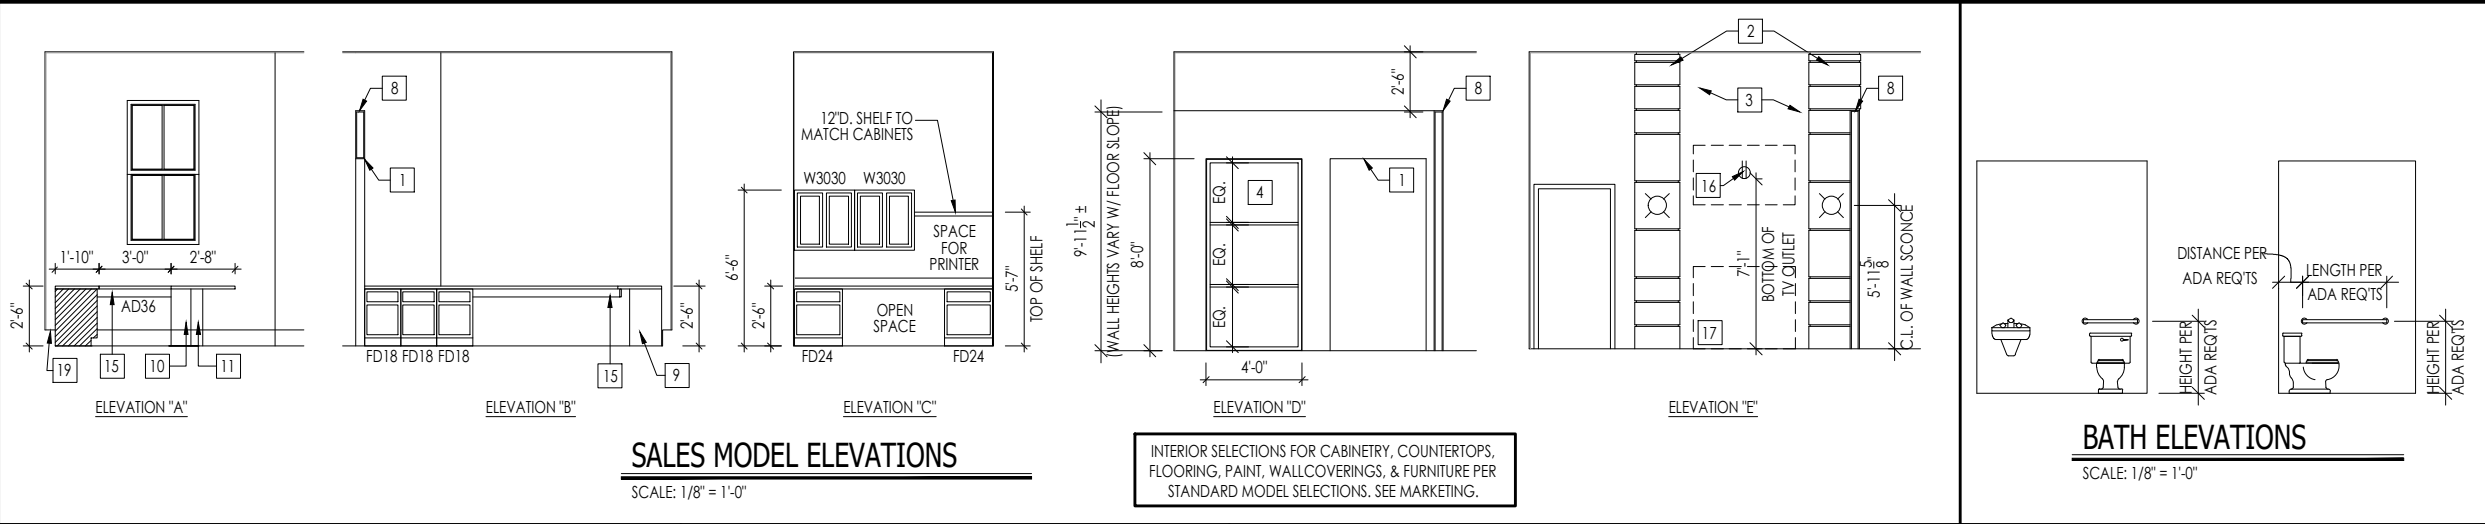

- General Notes:**
1. REFER TO SHEET ON.1 FOR GENERAL NOTES.
- Key Notes:**
- 1 FRAME TOP OF OPENING EVEN W/ TOP OF FIXED PANEL GLASS WINDOW AT OFFICE - NO CASING
 - 2 WRAPPED PILASTERS FRAMED TO CEILING AND PAINTED TO MATCH TRIM - SEE DETAIL THIS SHEET
 - 3 WALL BETWEEN PILASTERS TO BE PAINTED ACCENT COLOR - RE: STANDARD MODEL SELECTIONS
 - 4 FRAME ROUGH OPENING FOR 4'-0" WIDE x 8'-0" TALL FIXED PANEL GLASS WITH 3-LITES AND BLACK METAL MULLIONS, BOTTOM FLUSH TO FLOOR
 - 5 DREES LOGO SIGNAGE ON WALL WITH BACK LIGHTING - OUTLET TO BE CENTERED IN THE MIDDLE OF THE WALL WITH THE BOTTOM OF THE OUTLET 5'-6" A.F.F.
 - 6 OUTLET/ PHONE BELOW COUNTER.
 - 7 GROMMETS IN COUNTER FOR PHONE/ELECTRIC BELOW.
 - 8 FRAME TOP OF WALLS AT OFFICE AND STORAGE 2'-6" DOWN FROM GARAGE CEILING
 - 9 PLAS. LAMINATE SUPPORT PANEL 12"W. X 30" H. X 3/4" TH. PLASTIC LAM. ALL (4) SIDES.
 - 10 L-SHAPED PLAS. LAM. MODESTY PANEL. INTERIOR DIMENSIONS: 3'-0" WIDE x 1'-8" DEEP.
 - 11 6X6 PLAS. LAM. SUPPORT COLUMN FOR COUNTERTOP.
 - 12 3 BASE FILE CABINETS. SEE ELEVATION 'B'
 - 13 BROCHURE HOLDERS.
 - 14 OUTLET/ DATA JACK HELD HIGH
 - 15 VALANCE/ FILLER AS REQ'D.
 - 16 FLAT SCREEN TV ON WALL - PROVIDE CAT 5 AND OUTLET HELD HIGH (7'-1" A.F.F.)
 - 17 HOLD OUTLET AND CAT 5 LOW FOR INTERACTIVE DISPLAY KIOSK
 - 18 LIGHT AND OUTLET IN CEILING FOR FUTURE GARAGE DOOR OPENER.
 - 19 COVER EXPOSED FOUNDATION WALL LEDGE W/ 1x1 RIPPED WOOD CAP
 - 20
 - 21 FRAME WALLS AT STORAGE ROOM AND BATHROOM TO CEILING
 - 22 19" x 17" WALL HUNG SINK
 - 23 CLEAR SPACE PER CODE
 - 24 BLOCKING IN WALL FOR GRAB BARS - SEE BATH ELEVATIONS THIS SHEET

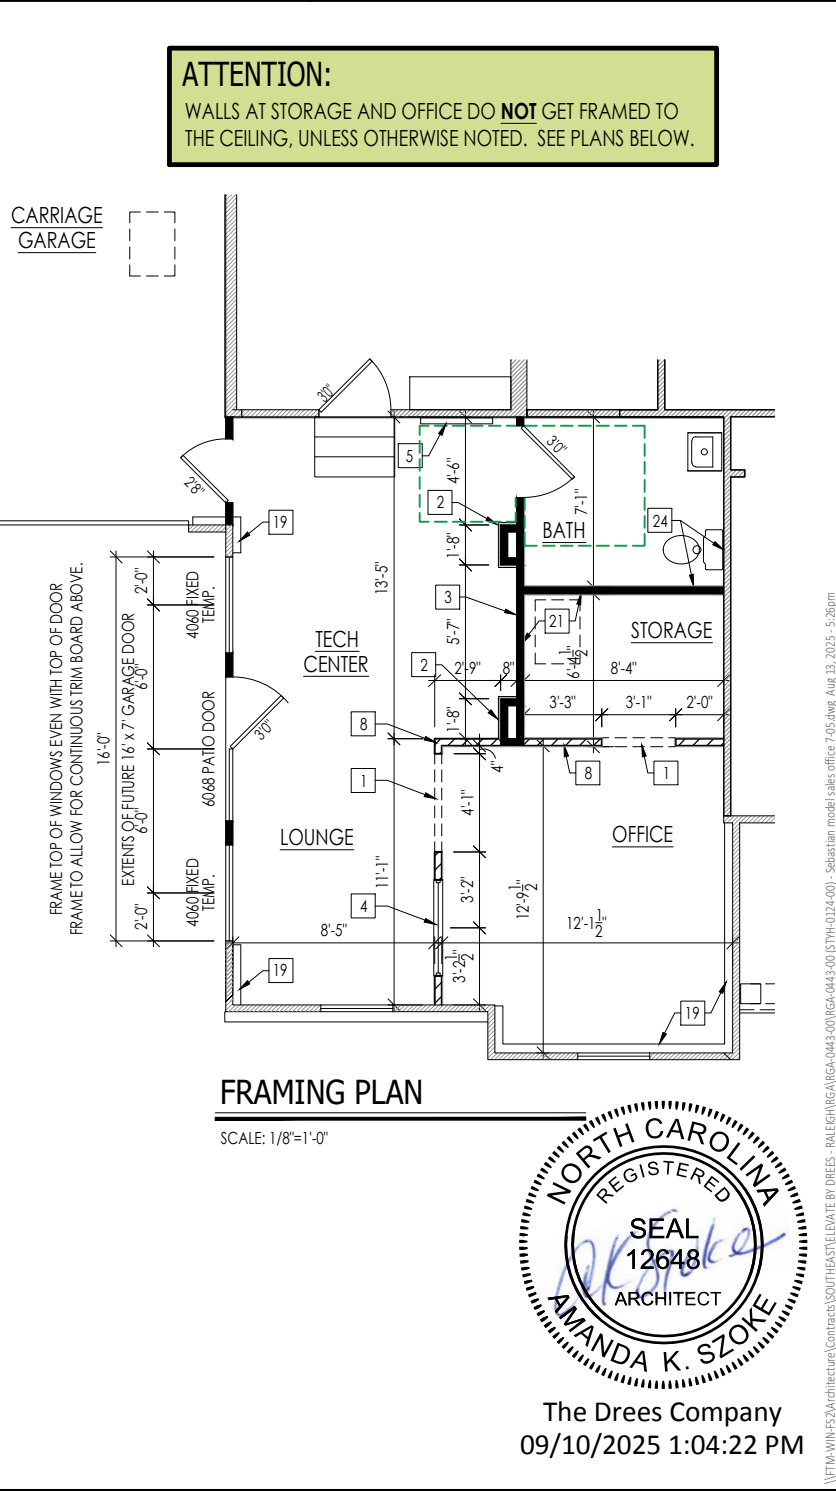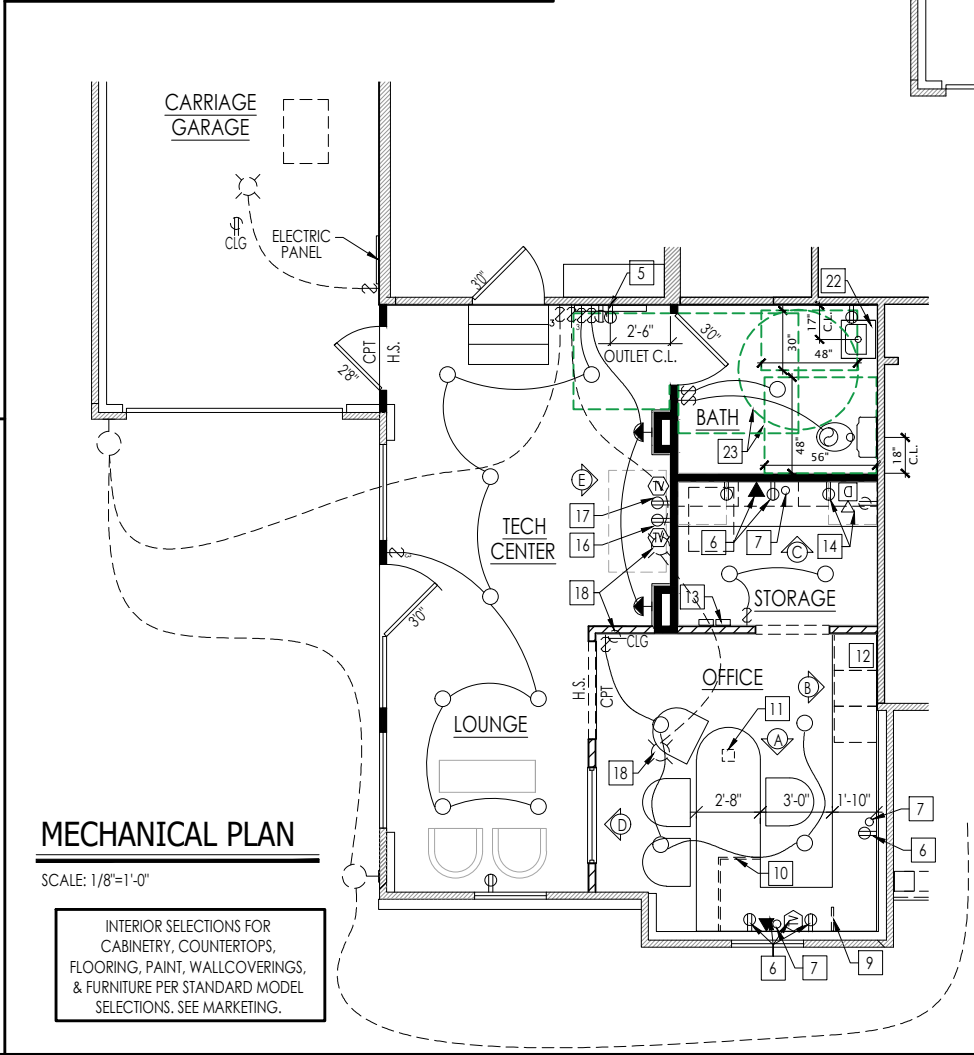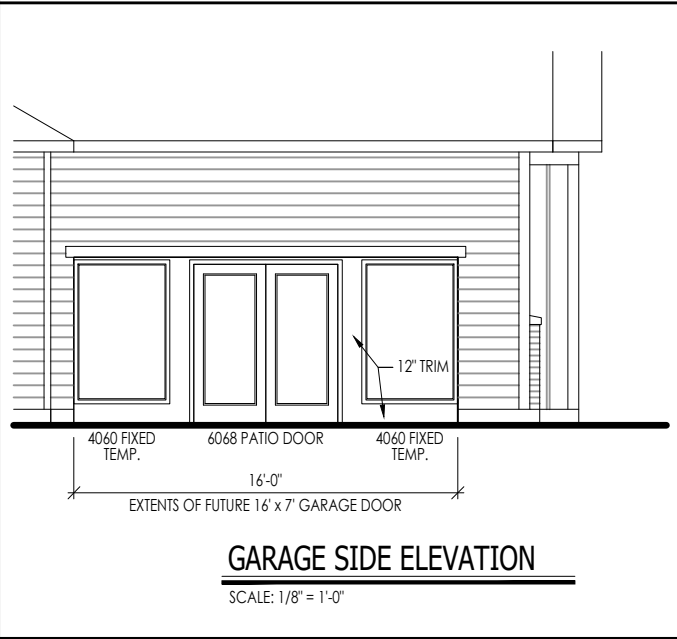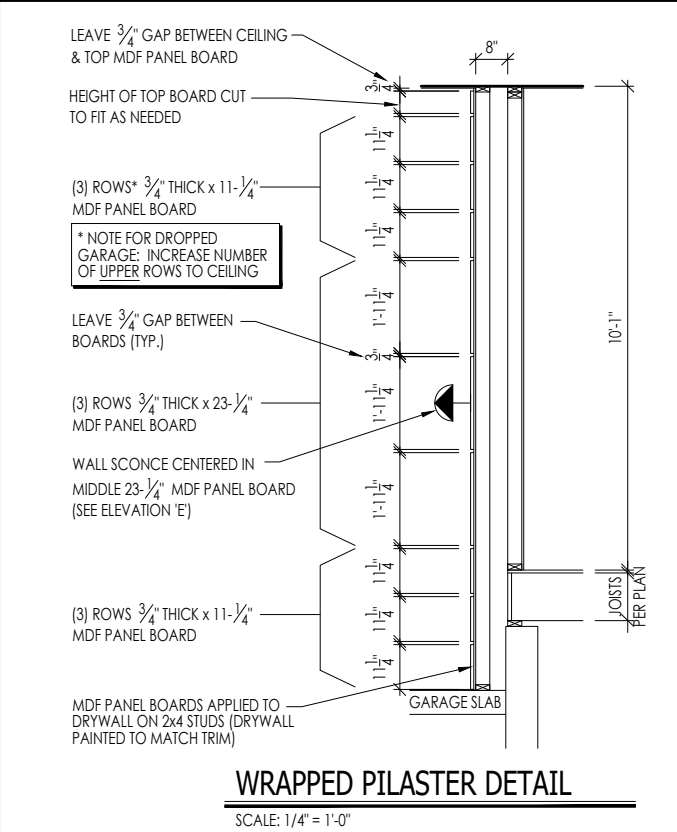

MECHANICAL LEGEND			
PHONE JACK	CLG. MOUNTED LIGHT FIXT.	STAIR LIGHT	
WALL OUTLET	SURFACE MOUNT DISC LIGHT OR RECESSED CEILING LIGHT, PER SPECS.	HOSE BIB	
WEATHERPROOF GFCI OUTLET	WALL MOUNTED LIGHT FIXT.	SHOWER HEAD	
220 VOLT OUTLET	DOUBLE SPOTLIGHT FIXT.	GAS HOOK UP	
GFCI OUTLET	DIRECTIONAL CAN LIGHT	FLOOR DRAIN	
FLOOR OUTLET	PIN LIGHT	SMOKE DETECTOR	
CABLE TELEVISION JACK	WALL SCONCE @ 5'-6" A.F.F.	CO DETECTOR	
SINGLE POLE SWITCH	FLUORESCENT LIGHT	SMOKE DETECTOR/ CO DETECTOR COMBINATION	
3-WAY SWITCH	UNDER CABINET LIGHTING	EXHAUST FAN AND LIGHT COMBINATION	
4-WAY SWITCH	BLOCK, MOUNT, & SWITCH FOR FUTURE FAN/LIGHT COMBINATION (CENTER, UNLESS OTHERWISE NOTED)	CLG. MTD. EXHAUST FAN	

**RESIDENCE FOR:
MODEL HOME
ADDRESS TBD
SERENITY HAVEN**

Job Number: STYH-0124-00	Drawing Date: 08/04/25	Coord Name: GREG P.	Coord Phone: 859-578-4355
House Name:			Contract Drawn By: EW
			Series:
			Plan No.:

the SEBASTIAN

Sheet Information

Drees HOMES


Copyright © 2015, (2012) The Drees Company. All Rights Reserved.
8521 SIX FORKS ROAD, SUITE 500, RALEIGH, NC 27615
PHONE: (919) 844-9288


7.05

Model Sales Office
Elevation "K"

Seal: 12648, AMANDA K. SZOKE, ARCHITECT, NORTH CAROLINA REGISTERED


The Drees Company
09/10/2025 1:04:22 PM

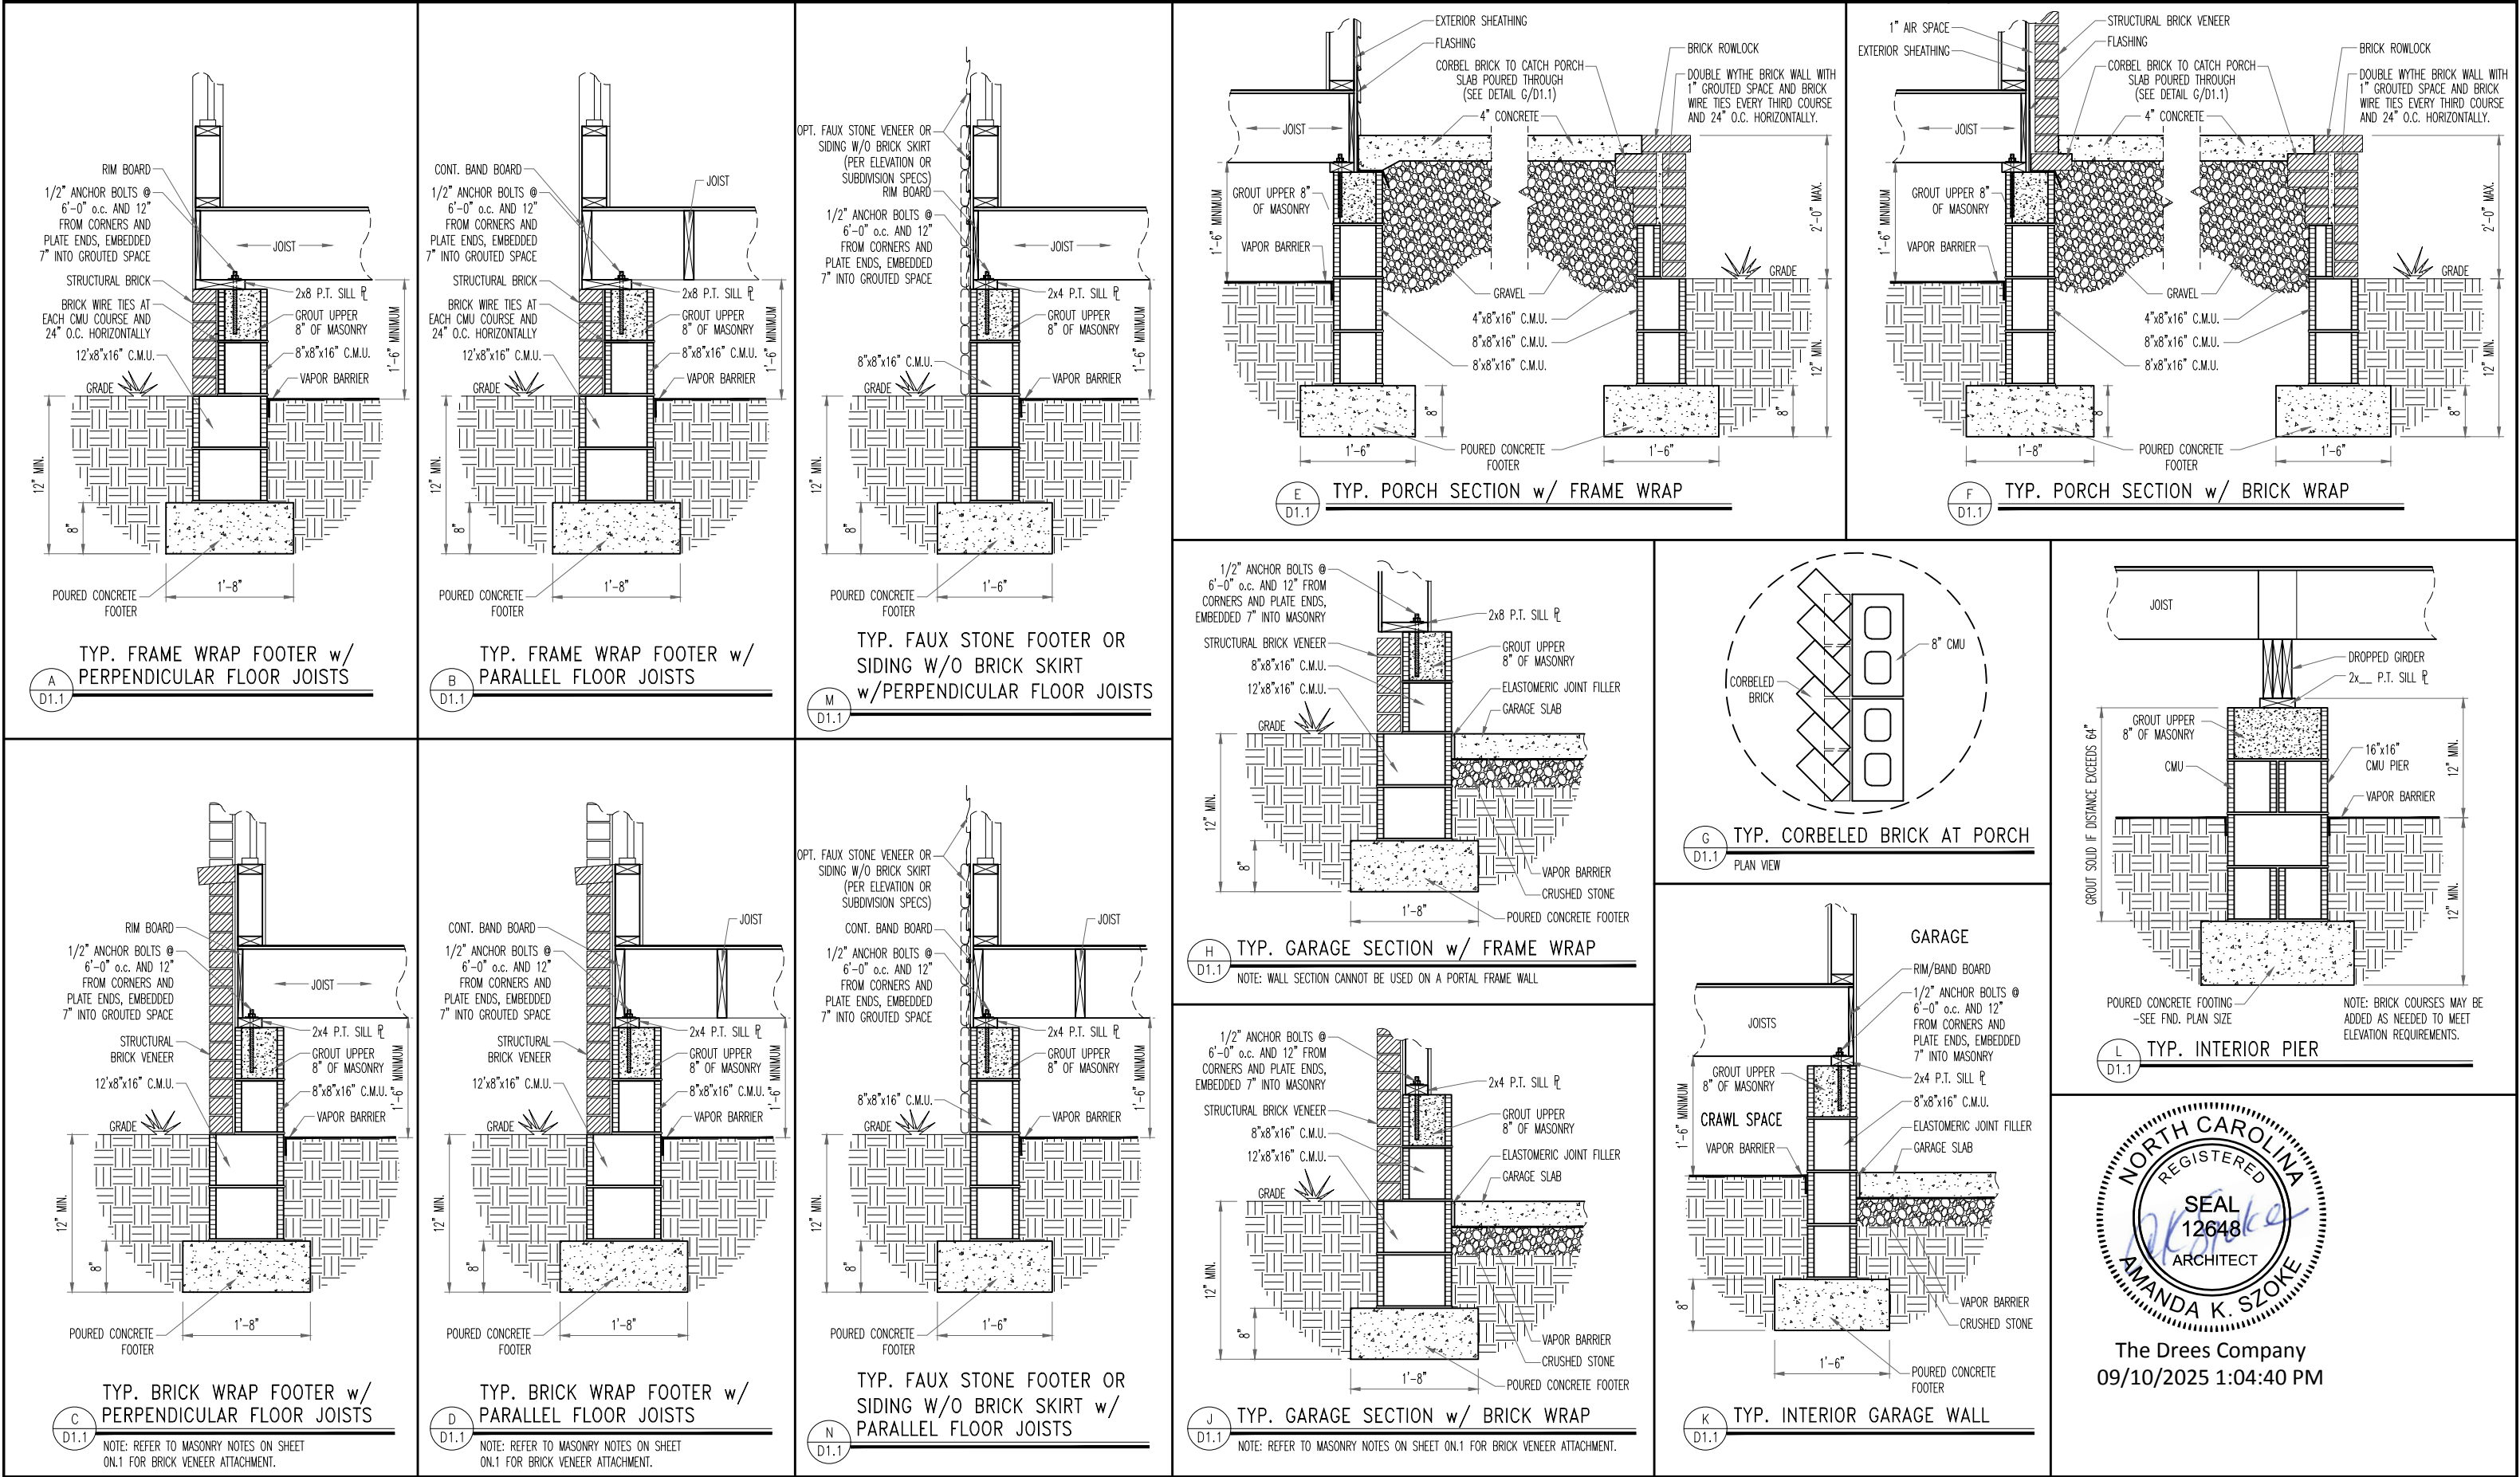

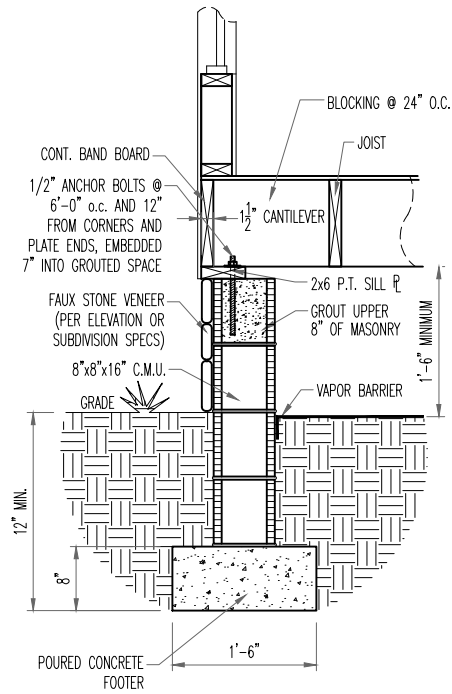


TYP. FAUX STONE SKIRT FOOTER w/
PARALLEL FLOOR JOISTS

A
D1.2

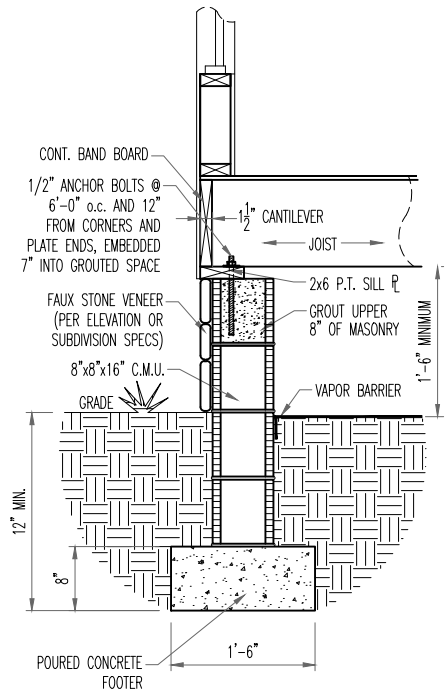


TYP. FAUX STONE SKIRT FOOTER w/
PERPENDICULAR FLOOR JOISTS

B
D1.2

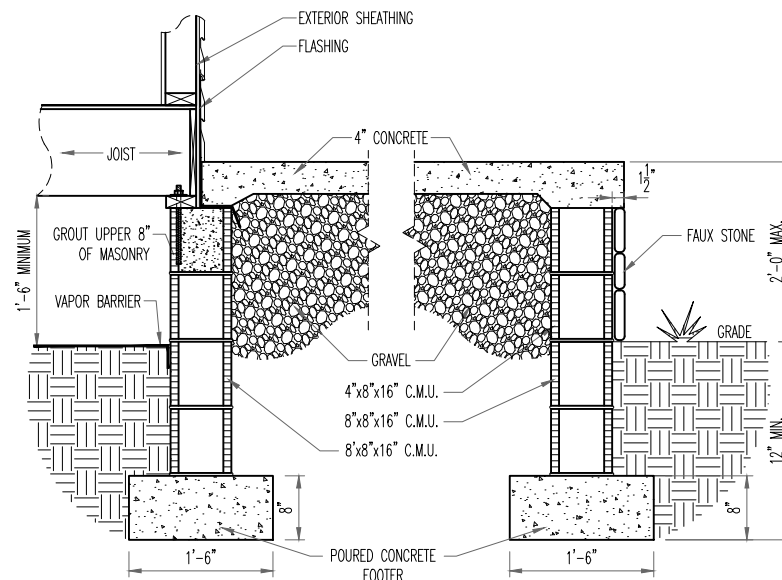


TYP. FAUX STONE SKIRT
TYP. PORCH SECTION w/ FRAME WRAP

C
D1.2

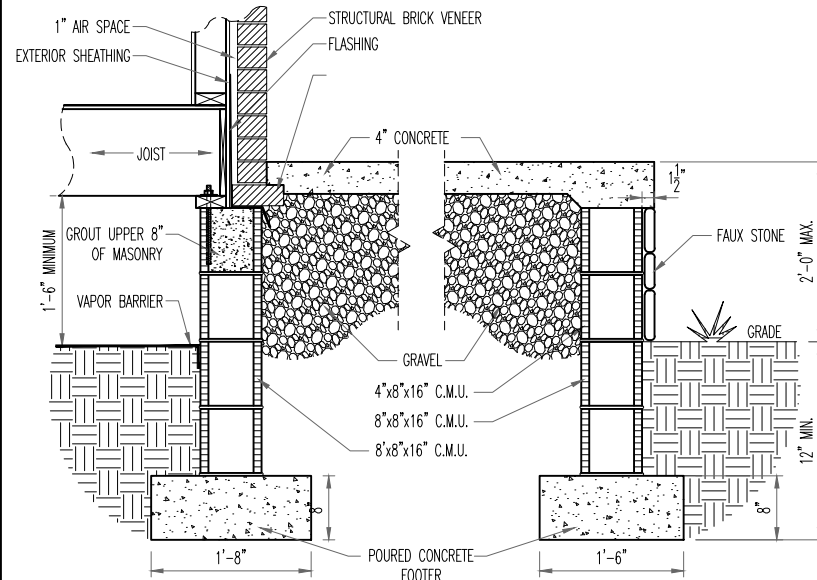


TYP. FAUX STONE SKIRT
TYP. PORCH SECTION w/ BRICK WRAP

D
D1.2

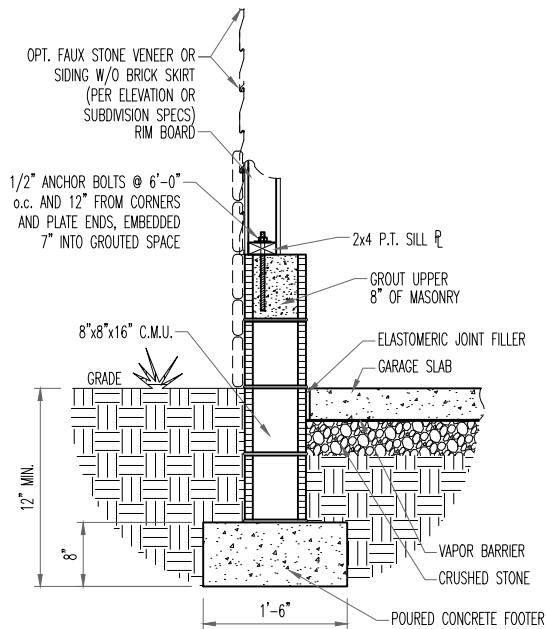

TYP. FAUX STONE FOOTER OR SIDING w/o
BRICK SKIRT
TYP. GARAGE SECTION w/ FRAME WRAP

E
D1.2

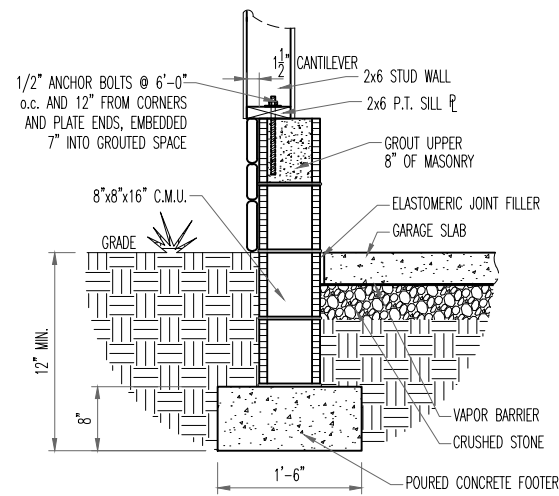

TYP. FAUX STONE SKIRT
TYP. GARAGE SECTION w/ FRAME WRAP

F
D1.2

NOTE: WALL SECTION CANNOT BE USED ON A PORTAL FRAME WALL



Drees Homes

7701 Six Forks Road, Suite 132, Raleigh, NC 27615 PH:(919) 844-9288

Copyright ©, 2005 The Drees Company, All rights reserved. These plans are protected by Copyright.
No part of these plans may be reproduced in any form or by any means, including photocopying,
without the written permission from the Copyright owner.

STD. DETAIL SHEET

REGION:

RALEIGH

Std. By: ALL

Chk. By: ARC

Std. Date: 08/19/09

Date of

Sheet Description:

FOUNDATION DETAILS















RALEIGH - D-SHEETS.dwg Sep 24, 2015 - 12:14pm





The Drees Company
09/10/2025 1:04:40 PM

Sheet No.

D1.2

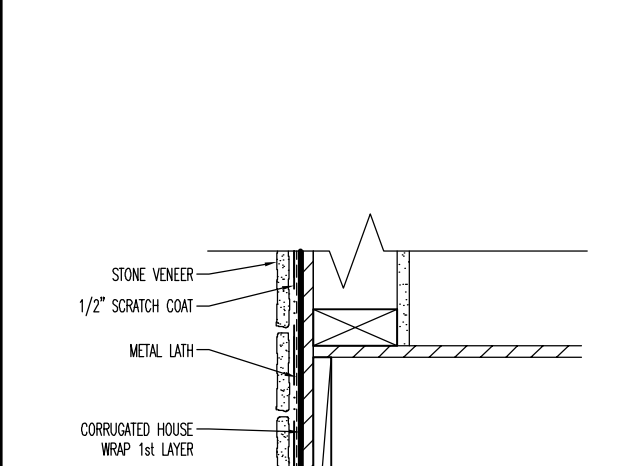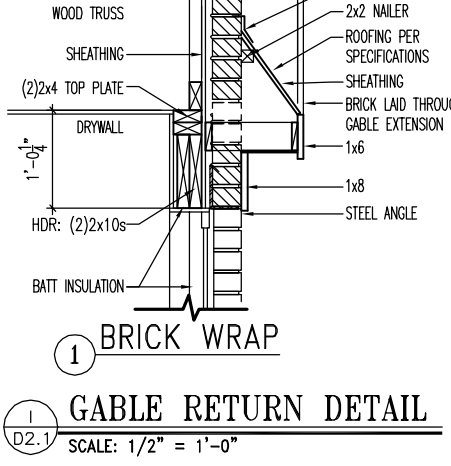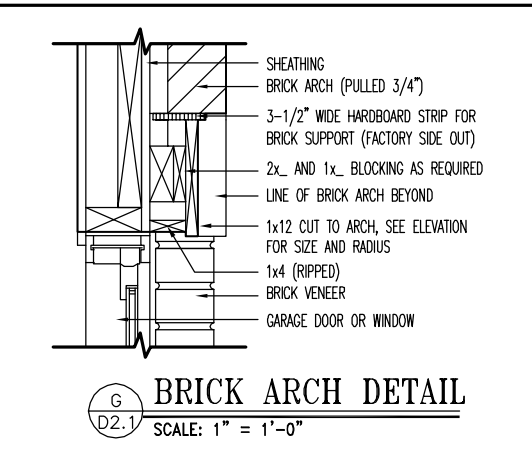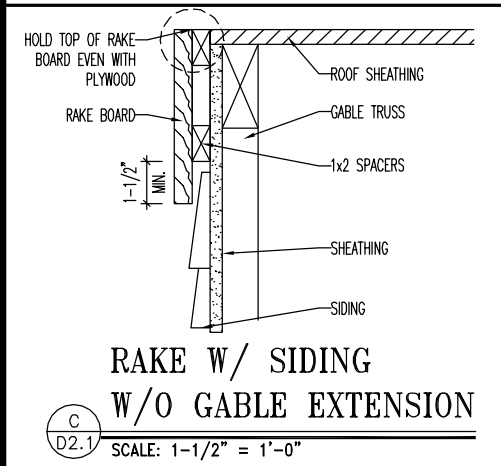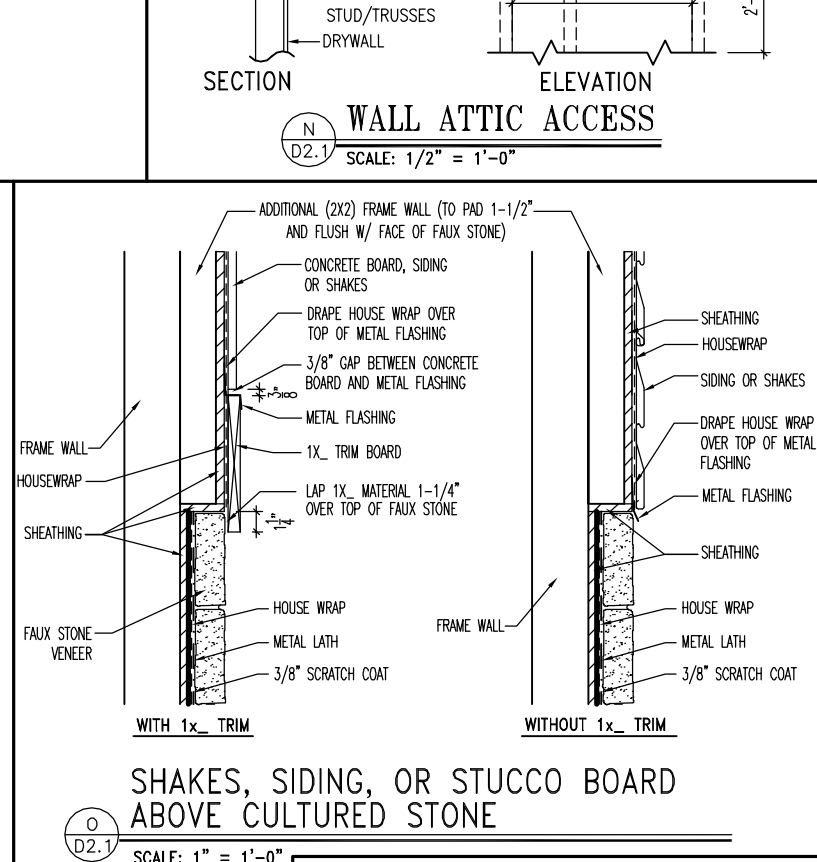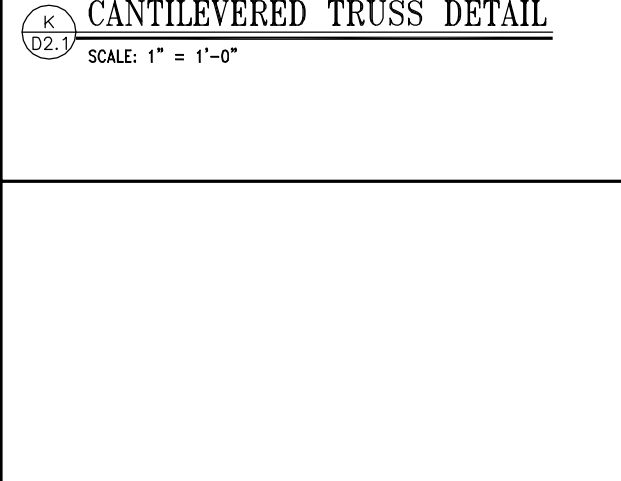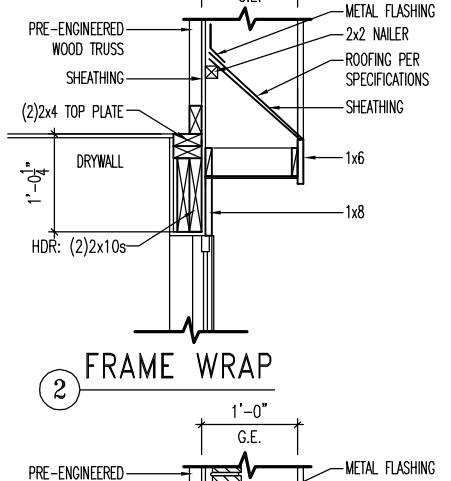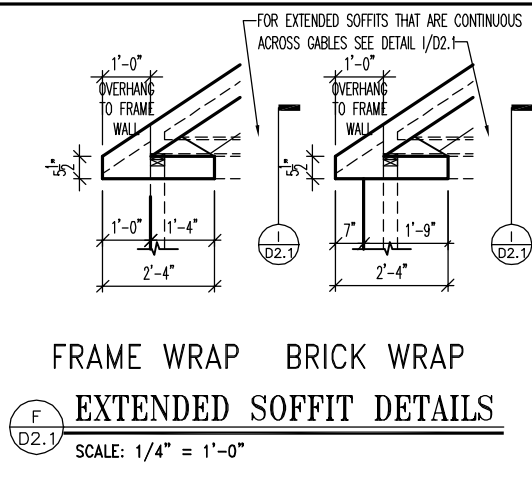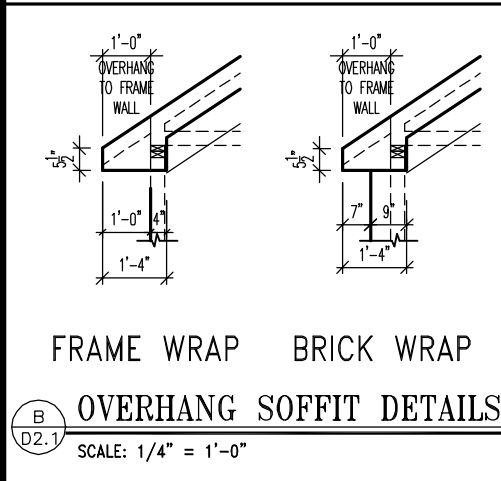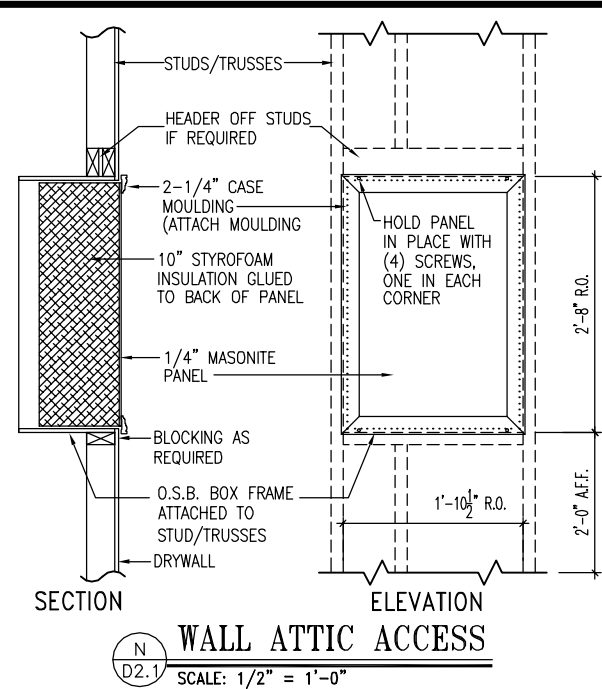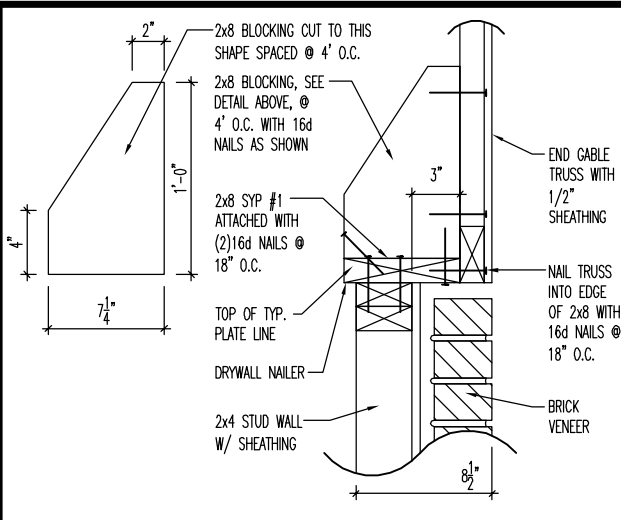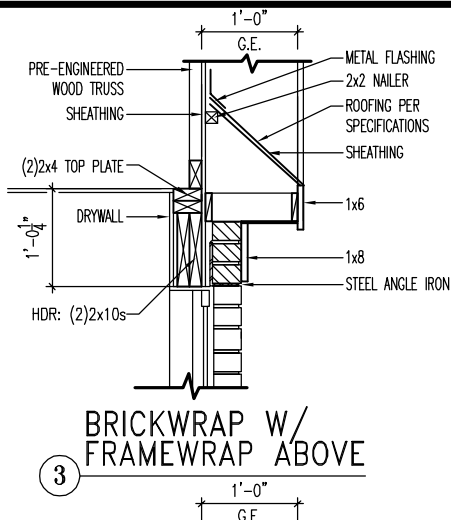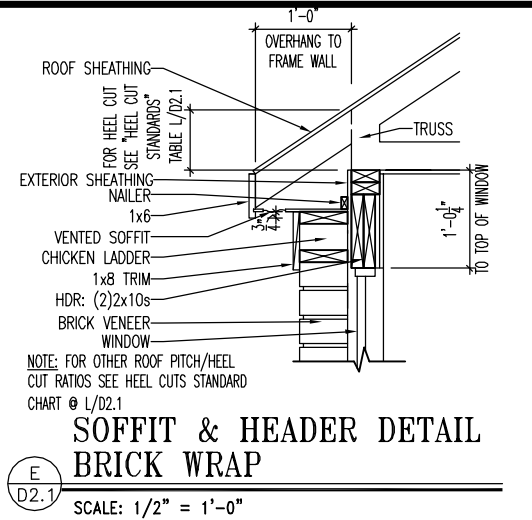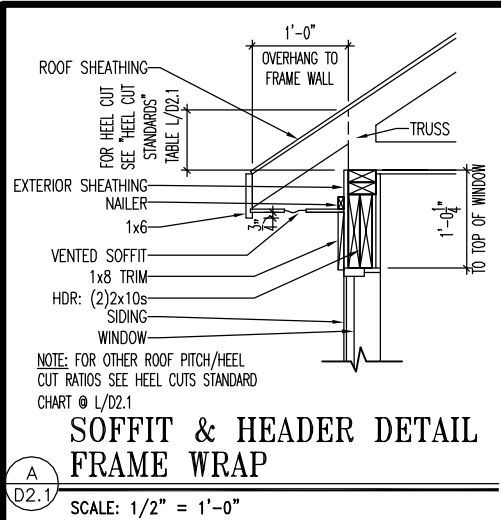

HEEL CUT STANDARDS	
ROOF PITCH	HEEL CUT
4/12	3-3/4"
5/12	4-3/4"
6/12	5-3/4"
7/12	6-3/4"
8/12	7-3/4"
9/12	8-3/4"
10/12	9-3/4"
12/12	11-3/4"
14/12	1'-1-3/4"

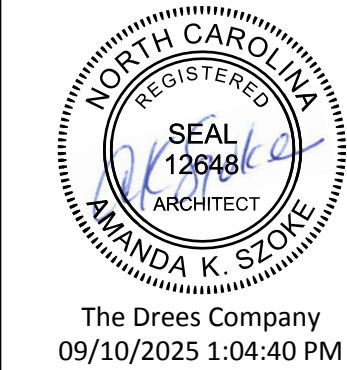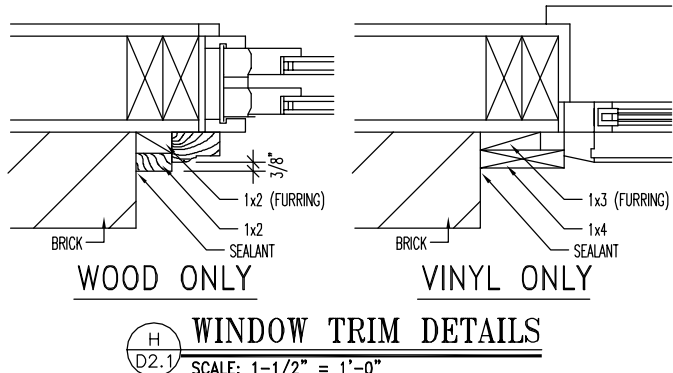

The Drees Company
09/10/2025 1:04:40 PM



Drees Homes
7701 Six Forks Road, Suite 132, Raleigh, NC 27615 PH(919) 844-9288
Copyright © 2005 The Drees Company. All rights reserved. These plans are protected by Copyright. No part of these plans may be reproduced in any form or by any means, including photocopying, without the written permission from the Copyright owner.

STD. DETAIL SHEET
REGION:
RALEIGH


Std. By: ALL
Chk. By: ARC
Std. Date: 10.11.06
Last Rev: 4/5/10 MSM

Sheet Description:

FRAMING DETAILS

DETAILS MAY NOT APPLY TO CONTRACT


Sheet No.
D2.1

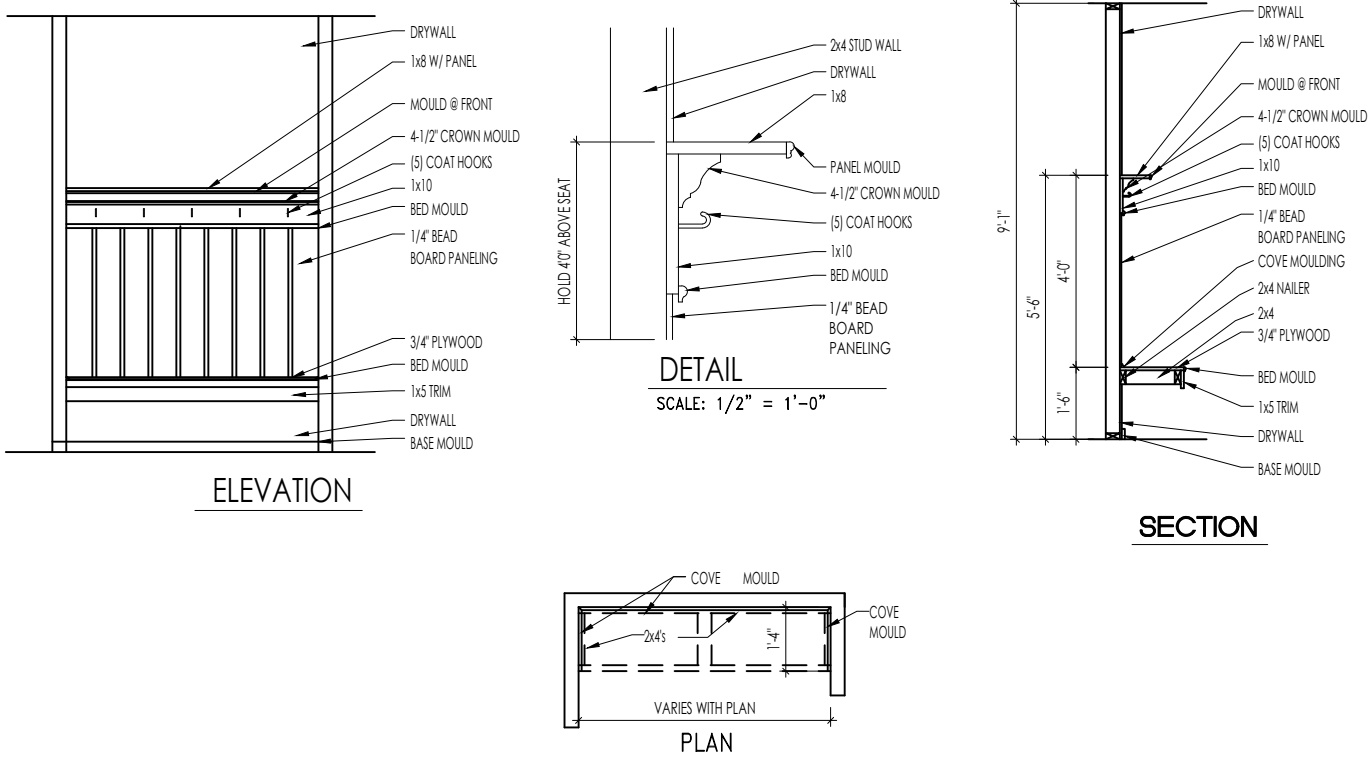


F
D2.2
BENCH SEAT DETAILS
SCALE: AS NOTED



The Drees Company
09/10/2025 1:04:41 PM

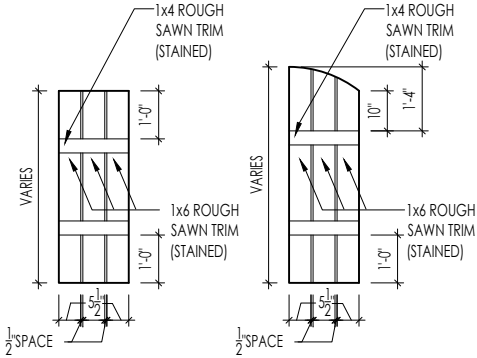

M
D2.4
SLAT SHUTTER DETAIL
SCALE: 1/4" = 1'-0"

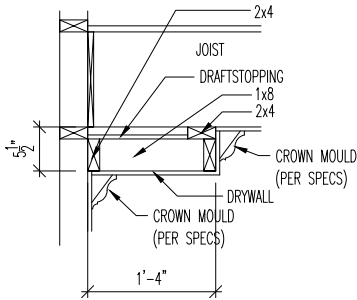

H
D2.4
SINGLE TRAY CEILING DETAIL
SCALE: 1/2" = 1'-0"



The Drees Company
09/10/2025 1:04:41 PM

STANDARD FRAMING DETAILS
RALEIGH DIVISION
SCALE: AS NOTED



Copyright © 2020, The Drees Company. All Rights Reserved. No portion of this material may be reproduced in any form or by any means, including photocopying, without the express written permission of The Drees Company. The Drees Company will vigorously prosecute any unauthorized use of this material.

DRAWN BY: ARCH


DATE OF DETAIL: 01/27/15

LAST REVISION:


Jan 10, 2023 - 1:46pm

SHEET NO.

D2.4

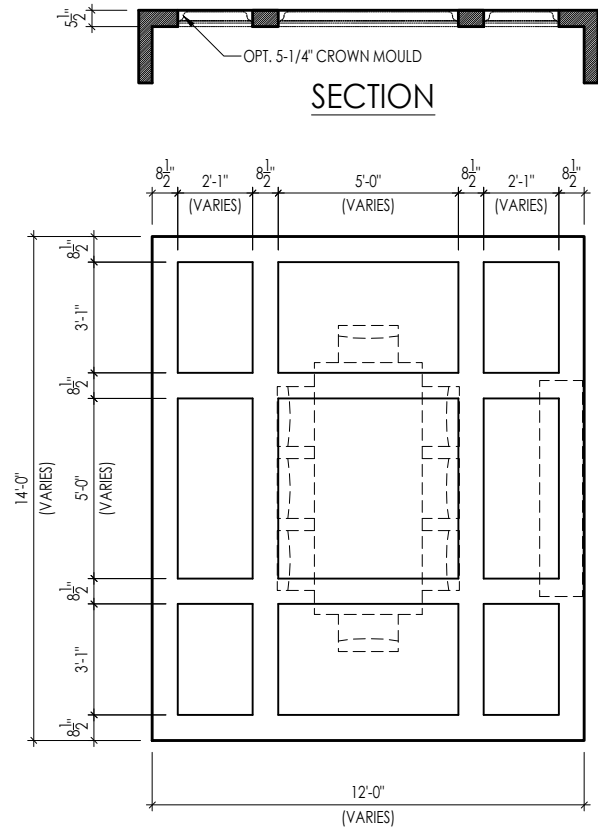


TYPICAL PLAN

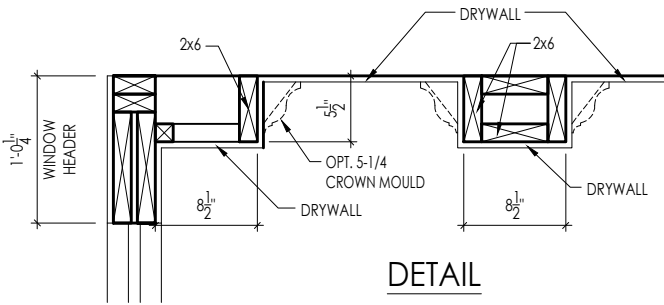


Note: Ceiling treatment details will tray down into space on enclosed rooms located on the 1st floor. On enclosed rooms on the 2nd floor, the ceiling treatment will tray up into the roof truss system. On 2-story spaces, the ceiling treatment will tray down into the space and require an appropriate sized header to capture the ceiling detail return.

01

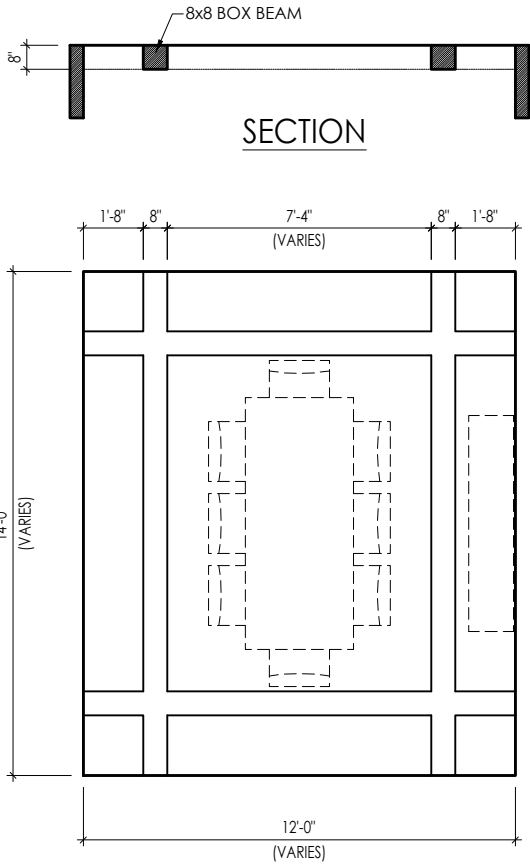


TYPICAL PLAN

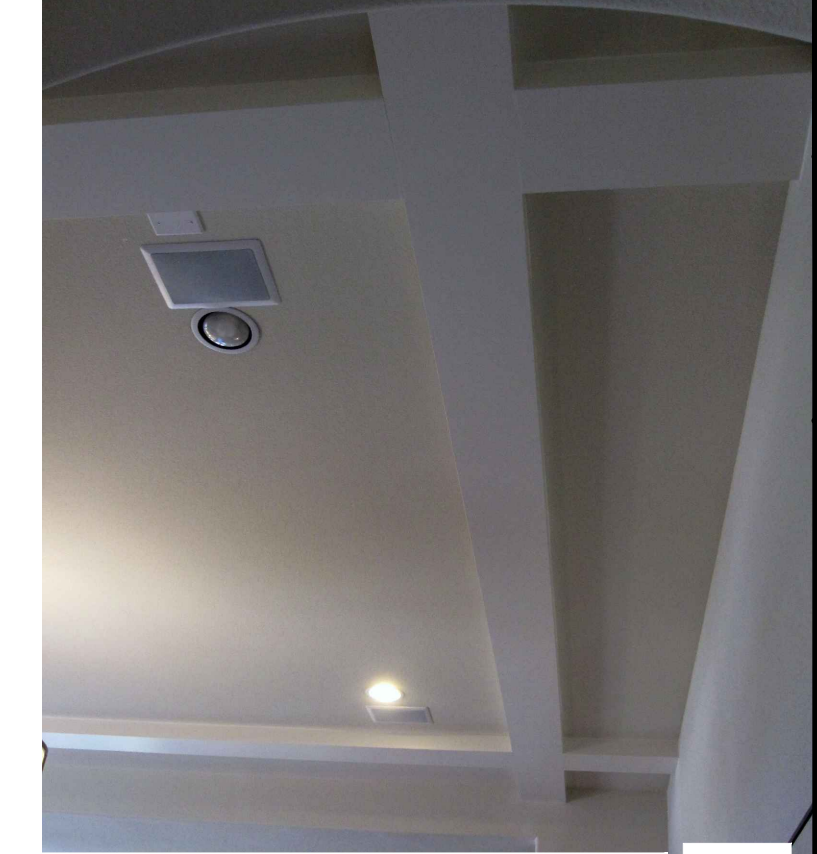

Note: Ceiling treatment details will tray down into space on enclosed rooms located on the 1st floor. On enclosed rooms on the 2nd floor, the ceiling treatment will tray up into the roof truss system. On 2-story spaces, the ceiling treatment will tray down into the space and require an appropriate sized header to capture the ceiling detail return.

05

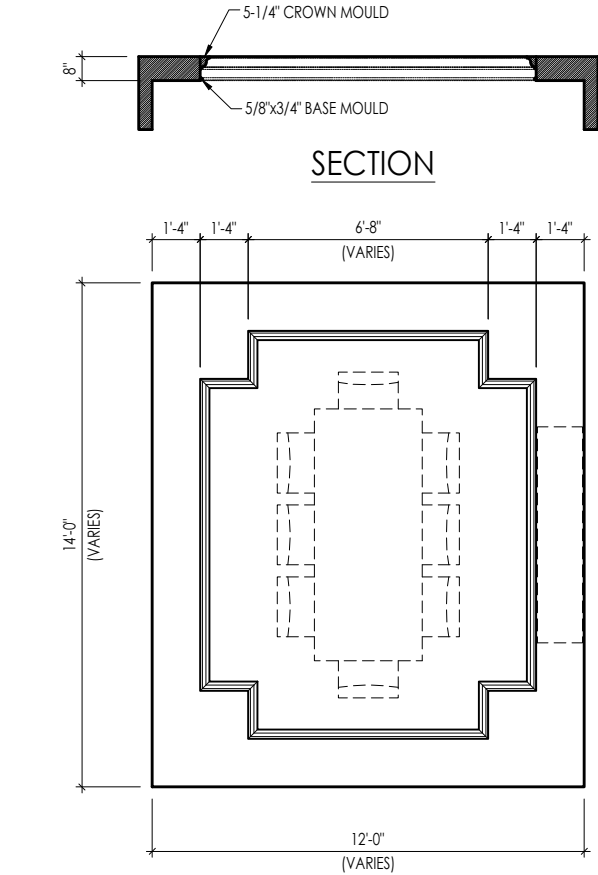


TYPICAL PLAN




Note: Ceiling treatment details will tray down into space on enclosed rooms located on the 1st floor. On enclosed rooms on the 2nd floor, the ceiling treatment will tray up into the roof truss system. On 2-story spaces, the ceiling treatment will tray down into the space and require an appropriate sized header to capture the ceiling detail return.

04

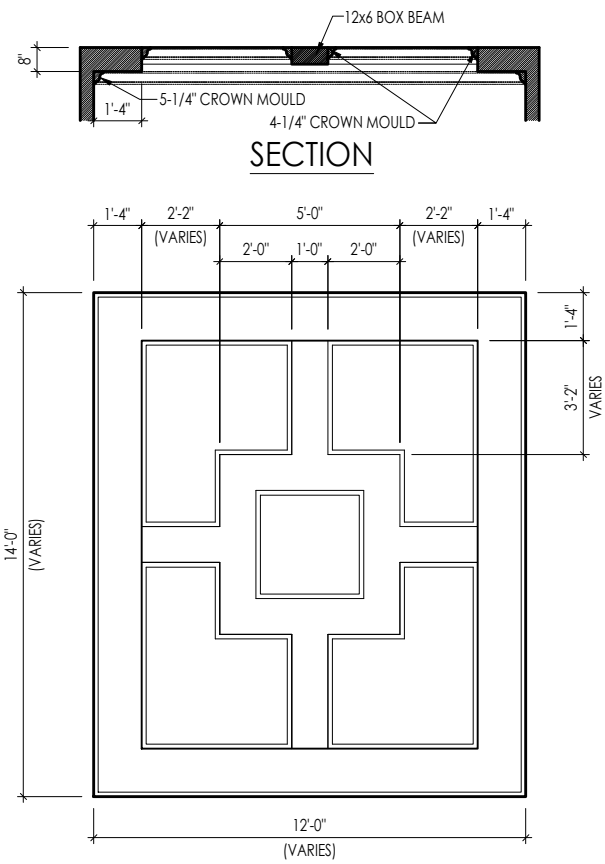

TYPICAL PLAN

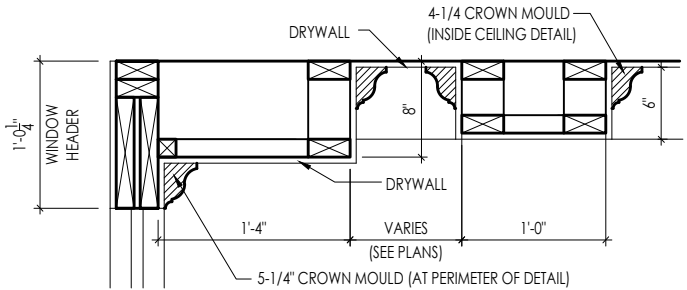

DETAIL

Note: Ceiling treatment details will tray down into space on enclosed rooms located on the 1st floor. On enclosed rooms on the 2nd floor, the ceiling treatment will tray up into the roof truss system. On 2-story spaces, the ceiling treatment will tray down into the space and require an appropriate sized header to capture the ceiling detail return.

15



The Drees Company
09/10/2025 1:04:41 PM

CEILING TREATMENTS
SCALE: AS NOTED



SHEET NO.	D4.1
DRAWN BY:	BLC
DATE OF DETAIL:	01/27/15
LAST REVISION:	Jan 10, 2023 - 1:42pm

- General Notes
1.

REFER TO SHEET ON.1 FOR GENERAL NOTES.
2.

SEE SHEET 4.01 FOR DECK LOCATION. FIELD DETERMINE LOCATION & NUMBER OF STAIRS.
3.

ALL DECK JOISTS AND BEAMS TO BE SYP#2 PRESSURE TREATED OR BETTER.
4.

ALL FASTENERS, HANGERS, AND OTHER CONNECTORS TO BE USED WITH PRESSURE TREATED WOOD ARE TO HAVE ZMAX COATING (OR EQUIVALENT) HOT-DIPPED GALVANIZED OR STAINLESS STEEL.
5.

GUARDRAIL & STEPS BY BUILDER.

- Key Notes
- 1

2x10 P.T. LEDGER FASTENED TO RIM w/ 1/4"x3-1/2" LONG SIMPSON SDS SCREWS @ 6" o.c., STAGGERED
- 2

REFER TO SHEET 1.01 FOR DECK BEAM SIZE
- 3

DOUBLE DECK JOIST
- 4

DECK RIM BOARD
- 5

DECK SUPPORT POST BELOW. REFER TO SHEET 1.01 FOR SIZE OF POST AND FOOTING
- 6
- 7

5/4 DECKING
- 8
- 9

LUS28-2Z @ END JOIST
- 10

FASTEN LAST TWO END JOISTS ON EACH SIDE OF DECK TO LEDGER W/SIMPSON H3 TIE.
- 11

LU210-Z @ INTERIOR DECK JOISTS
- 12

(2)2x10 PERIMETER BEAM WITH 1/2" FILLER (OSB OR PLYWOOD)
- 13

4x4 PRESSURE TREATED POST W/SIMPSON BCS2-2/4 CAP & ABW44Z BASE, (TYP.)
- 14

4x4 PRESSURE TREATED POST OR (2)2x4 POST (LOCATE JOISTS UNDER POST)
- 15
- 16
- 17
- 18
- 19
- 20



The Drees Company

09/10/2025 1:04:41 PM



Drees Homes

8521 Six Forks Road, Suite 500, Raleigh, NC 27615 PH:(919) 844-9288


Copyright © 2014, (2014) The Drees Company. All Rights Reserved. No portion of this material may be reproduced in any form or by any means, including photocopying, without the express written permission of the Drees Company. The Drees Company will vigorously prosecute any unauthorized use of this material.

STANDARD
SCREENED-IN DECK
DETAILS


Std. Drawn By:	AKS	Sheet Description:	SCALE: VARIES
Std. Chk. By:	MATT G.	16-4'x 12-0' SCREENED-IN DECK	
Std. Date:	08/21/12		
Date of Last Rev:	REV_DATE		

Contract Drawn By:	DWG_BY	Original Site Specific Dwg. & Effective Change Order Date:
Phone #:	DWG_PH	
Coordinator's Name:	COORD_NM	CT_DT
Coordinator's Phone #:	COORD_PH	
Raleigh - Deck Details.dwg Sep 10, 2025 - 11:29am		

Subdivision:	SUB_NM	Sheet No.
Job #:	JOB_NM	D7.1
Customer Name:	CUS_NM	
Job Address:	JOB_AD	

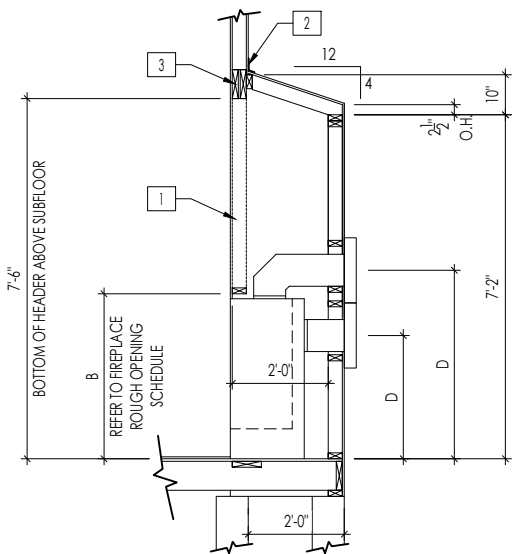


FRAMEWRAP
(SHOWN WITHOUT OPT. HEARTH)

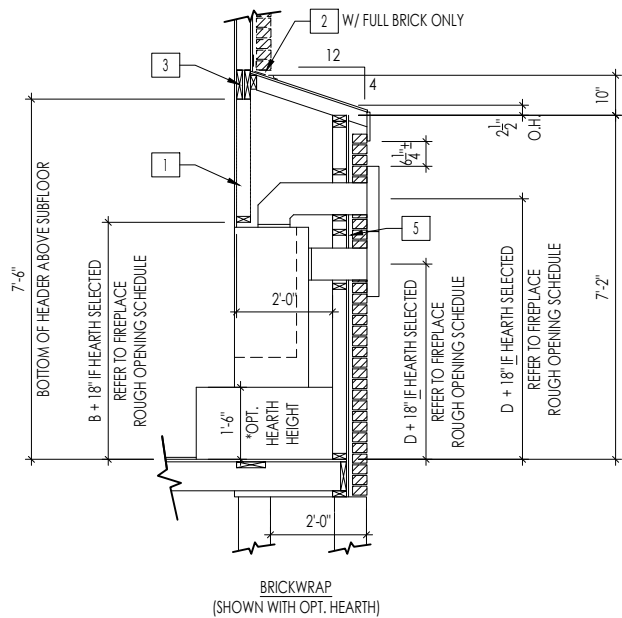

BRICKWRAP
(SHOWN WITH OPT. HEARTH)

FIREPLACE DOGHOUSE SECTIONS


SCALE: 1/4" = 1'-0"

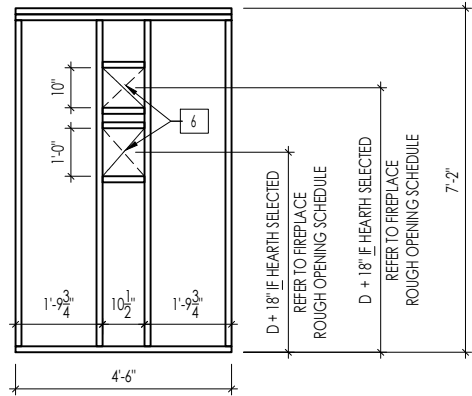

WITH HEARTH

DIRECT VENT REAR WALL FRAMING


SCALE: 1/4" = 1'-0"

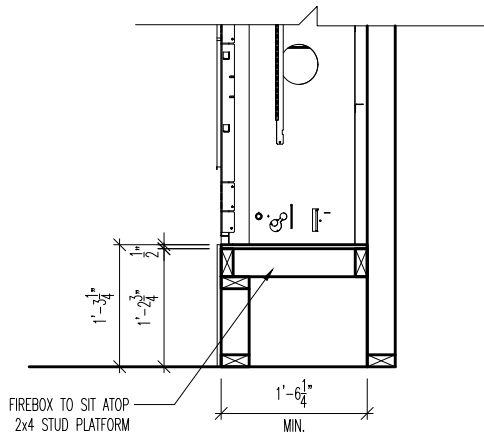

FIREBOX TO SIT ATOP
2x4 STUD PLATFORM

RAVE FIREPLACE PLATFORM DETAIL

SCALE: 1/2" = 1'-0"

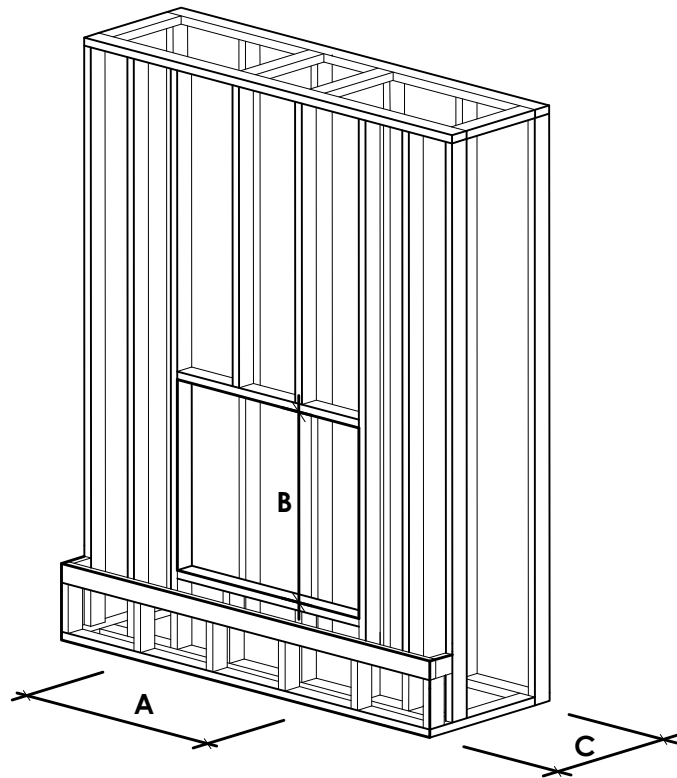

NOTE:
PROVIDE OSB SHEATHING WHEN
STONE VENEER SELECTED

FIREPLACE ROUGH OPENING SCHEDULE

FIREPLACE MANUFACTURER	MODEL	A	B	C	D
		(FIREBOX REQUIRED WIDTH)	(FIREBOX REQUIRED HEIGHT) *ADD 18" W/ OPT. HEARTH	(FIREBOX REQUIRED DEPTH - INTERIOR REAR WALL TO FRONT EXTERIOR WALL)	(VENT CENTERLINE HEIGHT) *ADD 18" W/ OPT. HEARTH
HEAT & GLO	SLIMLINE SL-7	42"	38-1/4"	16-1/4"	TOP 40" SIDE 26-7/8"
	COSMO 42	49"	32-3/4"	17-3/4"	TOP ONLY 47-1/16"
	NOVUS 33	39"	34-7/8"	19-5/8"	TOP 40" SIDE 23-1/2"
HEARTH & HOME	COURTYARD 36	43-3/8"	44-1/8"	18-3/8"	SEE MANUFACTURER'S SPECS
	COURTYARD 42	48-1/2"	34-1/4"	20-1/4"	SEE MANUFACTURER'S SPECS
	LANAI *(NOT IN CINCY/NKY)	57-3/4"	39-1/2"	17-5/8"	SEE MANUFACTURER'S SPECS
	RAVE	49"	32-3/4" *RAISED 15-1/4"	18-1/4"	TOP ONLY 46-1/2"
all dimensions are in inches					

General Notes

- REFER TO SHEET ON.1 FOR GENERAL NOTES.
- VERIFY FIREPLACE MODEL AND HEARTH SELECTION WITH CUSTOMER'S SELECTIONS.

Key Notes

- FUTURE FRAMING FOR F.P. OPENING AFTER INSULATION HAS BEEN INSTALLED IN EXT. WALLS
- FLASHING
- HEADER PER PLAN
-
- 1" AIRSPACE
- BOX OUT FOR FLUE (REFER TO SELECTIONS FOR FIREPLACE AND OPENING HEIGHT)



The Drees Company
09/10/2025 1:04:41 PM



The Drees Company

211 Grandview Drive Fort Mitchell, Kentucky 41017 PH:(859) 578-4200

Copyright © 2021, (2021) The Drees Company. All Rights Reserved. No portion of this material may be reproduced in any form or by any means, including photocopying, without the express written permission of the Drees Company. The Drees Company will vigorously prosecute any unauthorized use of this material.

FIREPLACE DETAILS

Std. Drawn By: MRP

Sheet Description:

SCALE: VARIES

FIREPLACE DETAIL

Std. Date: 02.29.20

Date of Last Rev: 7.10.2023

g:\architecture\cincinnati\cintl standard drawings\fireplace\fireplace detail sheets.dwg

Sheet No.

F-1

RALEIGH WINDOW SCHEDULE

*** MEETS EMERGENCY ESCAPE & RESCUE
OPENING REQUIREMENTS**

[illegible]

Drees Homes

Copyright © 2008, (2013) The Drees Company. All Rights Reserved. No portion of this material may be reproduced in any form or by any means, including photocopying, without the express written permission of the Drees Company. The Drees Company will vigorously prosecute any unauthorized use of this material.

Sheet Description:

WINDOW SCHEDULE

•

Sheet No.

SC-01

LAST REVISED 11/22/17

PILASTERS				
Drees General Callout		Nuwood	Fypon	
FLUTED PILASTER A1	PL7xxF	PIL7Xxx		
FLUTED PILASTER B1	PL9xxF	PIL9Xxx		
FLUTED PILASTER C1	PL11xxFM	PIL11Xxx		
PANEL PILASTER A2	PL7xxP	PIL7XxxDP		
PANEL PILASTER B2	PL9xxP	PIL9XxxDP		
PANEL PILASTER C2	PL11xxPM	PIL11XxxDP		
PILASTER D1	M311-9	PIL10XxxA		
PILASTER D2	M323-9	N/A		
PILASTER Z-E1-PIL	Z-E1-PIL	Z-E1-PIL		
PILASTER Z-E2-PIL	Z-E2-PIL	Z-E2-PIL		
PILASTER Z-E3-PIL	Z-E3-PIL	Z-E3-PIL		
PILASTER Z-PIL-EXT	Z-PIL-EXT	Z-PIL-EXT		
PLAIN PILASTER A3	PL7xxS	PIL7XxxP		
PLAIN PILASTER B3	PL9xxS	PIL9XxxP		
PLAIN PILASTER C3	PL11xxS	PIL11XxxP		
PLINTH D1	PF10	ADD "P" TO END OF PILASTER		
PLINTH D2	P14.5	N/A		
LOUVERS				
Drees General Callout		Nuwood	Fypon	Mid-America
CATHEDRAL LOUVER D1	CLV1224	CLV12X24	--	
CATHEDRAL LOUVER D1T	CLV1224TRIM4	CLV12X24X4F	--	
CATHEDRAL LOUVER D2	CLV1432	CLV14X32	--	
CATHEDRAL LOUVER D2T	CLV1432TRIM4	CLV14X32X4F	00 44 1422	
CATHEDRAL LOUVER D3	CLV2232	CLV22X32	--	
CATHEDRAL LOUVER D3T	CLV2232TRIM4	CLV22X32X4F	--	
HALF CIRCLE LOUVER D1	HRLV32	HRLV32X16	--	
HALF CIRCLE LOUVER D1T	HRLV32TRIM4	HRLV32X4F	--	
HALF CIRCLE LOUVER D2	HRLV36	HRLV36X18	--	
HALF CIRCLE LOUVER D2T	HRLV36TRIM4	HRLV36X4F	00 43 2234	
OCTAGONAL LOUVER D1	OLV24	OLV24	--	
OCTAGONAL LOUVER D12	OLV24TRIM4	OLV24X4F	--	
OVAL LOUVER D1	OLV2537	OLV37X25	--	
OVAL LOUVER D1T	OLV2537TRIM4	OLV37X25X4F	--	
RECTANGUAR LOUVER D1	LV1224V	LV12X24	00 45 1218	
RECTANGUAR LOUVER D1T	LV1224VTRIM4	LV12X24-4F	00 45 1218	
RECTANGUAR LOUVER D2	LV1636V	LV16X36	--	
RECTANGUAR LOUVER D2T	LV1636VTRIM4	LV16X36-4F	--	
RECTANGUAR LOUVER D3	LV2436V	LV24X36	--	
RECTANGUAR LOUVER D3T	LV2436VTRIM4	LV24X36-4F	--	
RECTANGUAR LOUVER D4	LV2424V	LV24X24	--	
RECTANGUAR LOUVER D4T	LV2424VTRIM4	LV24X24-4F	--	
ROUND LOUVER D1	RLV18	RLV18	--	
ROUND LOUVER D1T	RLV18TRIM4	RLV18X4F	--	
ROUND LOUVER D2	RLV22	RLV22	--	
ROUND LOUVER D2T	RLV22TRIM4	RLV22X4F	--	
TRIANGULAR LOUVER D1	--	TRLVxxX36	00 47 0x0x	
BRACKETS				
Drees General Callout		Nuwood	Fypon	
EXTERIOR BRACKET D1	BR437	N/A		
EXTERIOR BRACKET D2	DB102	DTLB6X4X6		
EXTERIOR BRACKET D3	BR304 (7" WIDE)	BKT24X24X7		
EXTERIOR BRACKET D4	BR455	N/A		
EXTERIOR BRACKET D5	BR300-1	BKT12X12X6		
EXTERIOR BRACKET D6	BR300	BKT12X12		
EXTERIOR BRACKET D7	BR409	BKT16X18X3		
EXTERIOR BRACKET D8	BR413	DTLB5X5X3		
EXTERIOR BRACKET D9	TBD	BKT11X20		
EXTERIOR BRACKET D10	TBD	BKT12X24X3		
EXTERIOR BRACKET D11	BR435	BKT25X27		
EXTERIOR BRACKET D12	BR404	BKT16X30X4		
EXTERIOR BRACKET D13	BR23.13x10.13x5.5	N/A		
GABLE BRACKET D1	TBD	DTLB6X4X6R(OR L)PITCH		
GABLE BRACKET D2	BR423-x:12	BKT5X20		
GABLE BRACKET D3	BR424-x:12	BKT5X20 (CUT 2" PROJECTION)		

MOULDINGS		
Drees General Callout	Nuwood	Fypon
BAND MOULD D1	M210-16	MLD612-12
BAND MOULD D2	M301-16	MLD220-16
BARGE MOULD D1	WM210	WM210
CASE MOULD D1	M320-16	MLD226-16
CASE MOULD D2	N/A	MLD244-12
CROWN MOULD D1	M404-16	MLD572-16
DENTIL MOULD D1	M105-16	MLD310-16
DENTIL MOULD D2	M108-8	MLD353-8
HALF ROUND MOULD D1	N/A	MLD605-12
PANEL MOULD D1	M310-8 OR 16	MLD612-12
PEDIMENTS / COMBO HEADERS		
Drees General Callout	Nuwood	Fypon
BROW COMBO D1	BCxx	CSAPxx
PEAK PEDIMENT D1	Pxx-4 (6:12)	PCPxx
PEAK PEDIMENT Z-E1-PED	Z-E1-PED	Z-E1-PED
PEAKED COMBO D1	PCxx-4	CPCPxx
RAMS HEAD PEDIMENT D1	Rxx	RHPxx00
ROUND PEDIMENT D1	Bxx-4	PSPxx
SUNRISE COMBO D1	SCxx-4	CSPxx
VICTORIAN PEDIMENT D1	VPxx	DVPxx w/ SWDHxxXxx
WINDOW DECORATION		
Drees General Callout	Nuwood	Fypon
HALF CIRCLE SUNBURST D1	SPxxxx	SWDHxxXxx
PALLADIAN WINDOW D1	H9AR10-xx xx" FL/FR	ARxxX10MFLxxx
PALLADIAN WINDOW D1K	H9AR10-xxK xx" FL/FR	ARxxX10MFLxxx with K10TM
PALLADIAN WINDOW D2	H9AR10SPxxxx	ARxxX10MFLxxx with SWDHxxXxx
PALLADIAN WINDOW D2K	H9AR10SPxxxxK	ARxxX10MFLxxx with SWDHxxXxx and K10TM
PEAKED CAP HEADER D1	N/A	CHPCxxX15
PLAIN SEGMENT D1	SPxxxxP	PSPxx
SEGMENT SUNBURST D1	SPxxxx	SWDHxxXxx
ACCESSORIES		
Drees General Callout	Nuwood	Fypon
GABLE D1	PGDx12	GPA (width X height)
KEystone D1	KY14F-3	KY14
KEystone D2	KYHM9F	K9M
WREATH D1	N/A	WAB34