


James Bates
09/19/2025

As directed by the North Carolina Board of Architecture and Registered Interior Designers, architectural seals are not required for - and should not be placed by NVR on - these plans and specifications. These plans and specifications are prepared solely by, and for the exclusive use of, NVR, Inc. and are solely for a family residence consisting of eight or fewer attached units with grade level exits and which is not part of or physically connected with any other buildings or residential units. NVR, Inc. does not provide any third party the opportunity to customize these plans. The respective drawings contained herein shall be used only as construction assembly drawings by NVR, Inc. and its subcontractors. Any unauthorized use of these plans without the written consent of NVR, Inc. is prohibited.

GRAND BAHAMA

DIV-COMM-LOT-UNIT

RLH-YK-0020

COMM-LOT

KIPLING VILLAGE - 0020

STREET ADDRESS

287 SOUTH BREEZE WAY

APT. NO.

CITY

FUQUAY VARINA

STATE

NC

ZIP

27526



NVR, Inc.
5285 Westview Drive,
Suite 100
Frederick, MD 21703

As directed by the North Carolina Board of Architecture and Registered Interior Designers, architectural seals are not required for – and should not be placed by NVR on – these plans and specifications.

[Signature]
James Bales
09/19/2025

Page	Sheet	Description	Page	Sheet	Description	Page	Sheet	Description
1	CS-1	COVERSHEET		WD-1	WINDOW DETAILS			
1.1	SS-1	SPEC. SHEET		WD-3	WINDOW DETAILS			
2	CA-1	CALCS		WS-1B	WALL SECTION DETAILS			
5	NC-1	ELEVATIONS						
7	NC-3	FOUNDATIONS						
9	NC-4	FOUNDATION HOLD DOWNS						
10	NC-5	PLUMBING						
12	NC-7	FIRST FLOOR PLAN						
13	NC-8	BUILDING SECTIONS						
14	NC-9	BUILDING SECTIONS						
21	S-2	ROOF FRAMING						
22	S-3	TRUSS BRACING						
23	S-4	WALL BRACING						
	AD-1	HOUSE SPECIFIC DETAILS						
	DR-1	DOOR DETAILS						
	DR-1B	DOOR DETAILS						
	DR-3	DOOR DETAILS						
	ET-1	EXTERIOR TRIM DETAILS						
	ET-1B	EXTERIOR TRIM DETAILS						
	ET-1C	EXTERIOR TRIM DETAILS						
	ET-1D	EXTERIOR TRIM DETAILS						
	ET-1G	EXTERIOR TRIM DETAILS						
	ET-1H	EXTERIOR TRIM DETAILS						
	ET-3	EXTERIOR TRIM DETAILS						
	ET-3B	EXTERIOR TRIM DETAILS						
	ET-3C	EXTERIOR TRIM DETAILS						
	F-1	FLASHING DETAILS						
	F-1B	FLASHING DETAILS						
	F-1D	FLASHING DETAILS						
	F-3	FLASHING DETAILS STONE						
	F-3B	FLASHING DETAILS STONE						
	FA-1B	FIRE ASSEMBLY DETAILS						
	FC-1	FRAMING/FASTENER DETAILS						
	FC-1B	FRAMING/FASTENER DETAILS						
	FC-2	FRAMING/FASTENER DETAILS						
	FC-4	FRAMING/FASTENER DETAILS						
	FC-5	FRAMING/FASTENER DETAILS						
	FD-1	FOUNDATION DETAILS						
	FD-1B	FOUNDATION DETAILS						
	FD-4	FOUNDATION DETAILS						
	IT-1	INTERIOR TRIM DETAILS						
	IT-1B	INTERIOR TRIM DETAILS						
	IT-1C	INTERIOR TRIM DETAILS						
	IT-2	INTERIOR TRIM DETAILS						
	IT-2B	INTERIOR TRIM DETAILS						
	KT-1	KITCHEN TRIM DETAILS						
	KT-1B	KITCHEN TRIM DETAILS						
	RF-1	ROOF FRAMING DETAILS						
	RF-1B	ROOF FRAMING DETAILS						
	RF-1C	ROOF FRAMING DETAILS						
	SEP-1	STANDARD ENERGY PACKAGE DETAILS						
	SEP-2	STANDARD ENERGY PACKAGE DETAILS						
	SEP-3	STANDARD ENERGY PACKAGE DETAILS						
	SEP-4	STANDARD ENERGY PACKAGE DETAILS						
	WB-1	WALL BRACING DETAILS						
	WB-2	WALL BRACING DETAILS						

STRUCTURAL DESIGN CRITERIA	
• ALL LOCAL AND STATE CODES	
• ROOF LIVE LOAD	20 psf
• ULTIMATE WIND SPEED	130 mph
• WIND EXPOSURE CATEGORY	B
• SEISMIC DESIGN CATEGORY	A / B

FIRST FLOOR SQUARE FOOTAGE	
DESCRIPTION	TOTAL SQ. FT.
1ST FLOOR CRAWL / SLAB FOUNDATION (BASE SF)	1338 SF
	1338 SF
GARAGE SQUARE FOOTAGE	
DESCRIPTION	TOTAL SQ. FT.
TWO CAR GARAGE CRAWL / SLAB FOUNDATION	431 SF
	431 SF
UNFINISHED SQUARE FOOTAGE	
DESCRIPTION	TOTAL SQ. FT.
FRONT COVERED PORCH	25 SF
	25 SF
TOTAL FINISHED SQUARE FOOTAGE	
DESCRIPTION	TOTAL SQ. FT.
1ST FLOOR CRAWL / SLAB FOUNDATION (BASE SF)	1338 SF
	1338 SF

SET NO. - VERSION

GBH00 - 01

SHEET NO.

CS-1

PAGE NO.

1

RELEASE NO. ----

V:\As-Bld\2-Jobs\ASD\2025\2ndHgt-Complete\RLH\DETACHED\GRAND BAHAMA_GBH00_01\ELL_R_YK_0020\1 CS-1 COVERSHEET.dwg 09/19/25 -- 10:29 am

1. These plans and specifications are designed for the exclusive use by NVR, Inc. for the purpose of residential construction. As such, these products are offered for sale in NVR, Inc. communities only. NVR, Inc. is a production homebuilder and does not intend to provide the opportunity to customize these plans. The respective drawings contained herein in shall only be used as construction assembly drawings by NVR, Inc., and their sub-contractors. Any unauthorized use of these plans without the written consent of NVR, Inc. is prohibited. All standard notes, section markers, elevation markers and title markers that reference "A-11" shall be considered "N-11" for sheet reference.
2. These plans are subjected to modification as necessary to meet code requirements or to facilitate mechanical/plumbing installations or to incorporate design improvements.
3. These plans are not to be scaled for construction purposes. Dimension lines and notes supersede all scale references.
4. Single Family Attached/Detached - Automatic residential fire sprinkler systems shall be installed in accordance with NCRBC P2204 or NFPA 13D where required.
5. This note shall only cover major code requirements. The plans are intended to comply with all current applicable codes or engineering design in accordance with Section 301.3.

1. This note sheet only covers major code requirements. The plans are intended to conform to all current applicable codes including, but not limited to:

NGRC 2018, NCMC 2018, NCPC 2018, NCF6C 2018, NEC 2020 w/ NC Amendments
NCEC 2018, NCCFC 2018

2. Constr. Type: V-B

3. Max Stories: 3

1. Insulation requirements per 2018 NCRS Chapter II, Energy Efficiency, or Chapter 4 of the 2018 North Carolina Energy Conservation Code (NCECC), or Chapter 4 of the 2015 International Energy Conservation Code (IECC), Residential Energy Efficiency by the prescriptive method. See NVR "Standard Energy Package" for field procedures and details.

R-values shown below are the minimum used.

CLIMATE ZONE	FENESTRATION U-FACTOR	GLAZED FENESTRATION SHGC	CEILING R-VALUE	FRAME WALL R-VALUE 2x4 / 2x6	FLOOR R-VALUE	BASEMENT WALL R-VALUE UNFIN. / FIN.	SLAB R-VALUE & DEPTH	CRAWL SPACE WALL R-VALUE
3	0.35	0.30	30	15 / 19	19	5 / 15	NA	5 / 15
4	0.35	0.30	30	15 / 19	19	10 / 15	10	10 / 15

- ## DESIGN LOADS

Table of Loads for House Structure. Per Table 301.5

Floor Living Areas - 40# P.S.F. (Live)
 - 10# P.S.F. (Dead) unless noted otherwise by calculations

Floor Sleeping Areas - 30# P.S.F. (Live) unless noted otherwise by calculations
 - 10# P.S.F. (Dead) unless noted otherwise by calculations

Garage Floors - 50# P.S.F. (Live)
 - 50# P.S.F. (Dead)

Roof Areas - Top Chord - 20# P.S.F. (Live)
 - 10# P.S.F. (Dead)
 - 10# P.S.F. (Live) (Attics without storage)
 - 20# P.S.F. (Live) (Attics with limited storage)
 - 10# P.S.F. (Dead)

Habitable Attics
Trusses - 30# P.S.F. (Live)
 Areas up to 130 mph ultimate wind speed per Table R301.2(4)

Walls - Exposure category 'B'
 - Areas up to 130 mph ultimate wind speed per Table R301.2(4)

Vult	115 mph	130 mph
Vasd	84 mph	101 mph

Note: Linear interpolation between contour lines permitted.

Stairs - 40# P.S.F. (Live)
 - 10# P.S.F. (Dead)

Allowable deflection of structural members per IRC Table R301.7

Design Criteria

- Design Codes:
1. National Design specification for Wood Construction by National Forest Products Association.
 2. Specification for the Design Fabrication and Erection of Structural Steel for Buildings by American Institute of Steel Construction.

Materials:

Headers*	Southern Pine (KD-19), No. 1 Grade
Studs	Spruce-Pine-Fir, Stud Grade
Jacks	Spruce-Pine-Fir, Stud Grade
Beams**	Southern Pine (KD-19), No. 1 Grade
Joints	2x10 Hem-Fir (KD-19), No. 2 Grade or better (NGLIB & WKPFA)
	2x8 Southern Pine (KD-19), No. 1 Grade or better
	2x10 Spruce-Pine-Fir (KD-19), No. 2 Grade or better (NLGA)
LVL	1.9E Minimum

- * Where required, Laminated Veneer Lumber may be used per Engineering
 ** Structural Steel - A.S.T.M. A36

5. All plan and reinforced concrete shall comply with requirements in **ACI 318**.
6. Concrete footings shall be poured a maximum 5' slump, 5 bags mix, and 2500 psi minimum strength per **Table R402.2**. Concrete walls shall be poured a maximum 5' slump, 5 1/2-bag mix, and 3000 psi minimum strength per **Foundation Wall Design table** below. Special soil and/or wall height conditions may require a higher psi mix.
7. Walls and footings designed as unreinforced unless otherwise specified on foundation plans or details. "Special soil and/or site conditions" may require the addition of reinforcing.
8. Footing frost depth to be no less than 12" per **R403.1.4** and **Table R301.2(1)**.
9. Minimum Soil Bearing Capacity shall be 2,000 PSF per **Table R401.4.1**.
10. Slab requirements:
 - Interior slabs on grade (excluding garage slabs) to be minimum 3-1/2" concrete (may be represented on plans as nominal 4") over 4" sub-base, with vapor barrier (6-mil polyethylene) as required per **Section 506** and a minimum 2500 PSI per **Table R402.2**.
 - Non-structural garage slabs shall be nominal 3-1/2" thick and shall be installed on compacted / undisturbed soil per **Table R402.2**. Slabs shall be 3500 PSI air-entrained concrete.
 - Structural garage slabs utilizing grade beams shall be nominal 4" thick. Slabs shall be 3500 PSI air-entrained concrete.
 - Porch slab and exterior concrete work shall be nominal 4" minimum 3500 PSI air-entrained concrete with 6x6 in. 4x4 mesh or equivalent fiber mesh reinforcement.
11. Unconditioned floor spaces shall have a minimum net area of ventilation not less than 1 square foot for each 150 square feet of area, unless the ground surface is covered by a Class I vapor retarder. To achieve the minimum net area of ventilation shall not be less than 1 square foot for each 1500 square feet of area. One such ventilating opening shall be within 3 feet (914 mm) of each corner of the building, per **R408.1.2**.
12. Drainage drains shall be located per local codes and according to local site conditions. Drain discharge by gravity or mechanical means to conform with approved site plan and installed per **Section R405.1**.
13. The top course of block of foundation walls shall be semi-solid block or open cores of hollow block shall be filled with mortar.
14. Block piers to be solid block or mortar-filled hollow block.
15. A poured concrete foundation wall designed to withstand an equivalent fluid weight of 30# per cubic ft. may be substituted where masonry units (block) are shown on plans.
16. Concrete and masonry foundation walls shall be dampproofed with min. 3/8" portland cement paring from footing to top of finished grade. The paring shall be covered with a coat of approved bituminous material applied at the recommended rate per **R406.1**.
17. Where required, concrete and masonry foundation walls shall be waterproofed with an approved membrane extending from footing to top of finished grade. The joints in the membrane shall be lapped and sealed with an adhesive compatible with the waterproofing membrane. Waterproofing to be in accordance with **R406.2**.
18. Reserved for future use.
19. Foundation framing anchors shall be 1/2"x18" anchor bolts with 7" minimum embedment or Simpson Strong-Tie MASA / USP FA3 (6 gauge steel, galvanized) or equivalent set in concrete or grouted cell, 1" o" maximum from corners and spaced at a maximum of 6' o" and in the middle third of the width of the plate. For walls connecting offset braced wall panels, those 24" in length or shorter shall have min. (1) anchor strap and those 12" or shorter can be replaced without. Towholes in seismic design category "C" shall require a .224" x 3" x 3" plate washer per **R403.1.6.1** and maximum anchor bolt spacing for buildings over two stories shall be 4'.
20. Steel columns and bases shall be given a shop coating of rust-inhibitive paint or equivalent to provide corrosion resistance per **R407.2**.
21. For masonry veneers:

Per **RT09.8.4.1** - Corrugated sheet metal veneer ties shall be a minimum of No. 22 U.S. gauge by 7/8 inch. Each tie shall be spaced not more than 32" o.c. horizontally and 24" o.c. vertically and shall support not more than 2.67 square feet of wall area. For townhouses in Seismic Design Category C and in wind areas of more than 30 pounds per square foot pressure, each tie shall support not more than 2 square feet of wall area.

Additional metal ties shall be provided around all wall openings greater than 16 inches (406 mm) in either dimension. Metal ties around the perimeter of openings shall be spaced not more than 3 feet (914 mm) on center and placed within 12 inches (305 mm) of the wall opening.

Per R103.2 - One layer of No. 15 asphalt felt or other approved water-resistive barrier shall be provided behind brick.

Per **R703.8.4** - Provide minimum 1-inch air space between brick veneer and sheathing.

Per **R703.8.6** - Provide minimum 3/16" diameter weep holes at 33" on center maximum, located immediately above the flashing.

Per R103.8.5 - When veneer of brick, clay tile, concrete, or natural or artificial stone are used, 6 mil plastic flashing shall be attached to the sheathing wherever necessary to prevent moisture penetration behind the veneer. See NVR Flashing Details.

18. Reserved for future use.
19. Foundation wall strip footing thickness to be 8" (or 6" with a single strip) unless otherwise noted as specified by engineering. Strip footing projections beyond the face of the foundation wall shall not exceed the footing thickness. Bump out footings, pier pads, and any other footing identified as being greater than 8" in thickness shall not be reduced.
20. Block foundation walls may be substituted for poured foundation walls shown on foundation plans provided all requirements of **Section R404** are met.
21. Termite treatment provided below slabs or at framing members per **R310**

20. Block foundation walls may be substituted for poured foundation walls shown on foundation plans provided all requirements of **Section R404** are met.

21. Termite treatment provided below slabs or to framing members per R318.1

FOUNDATION WALL DESIGN^(c)
 NCRBC PRESCRIPTIVE CODE OR ENGINEERED DESIGN PER ACI 332

	WALL HEIGHT	WALL THICKNESS	LATERAL SOIL LOAD (a)	UNBALANCED FILL	VERTICAL REINFORCING (b)	HORIZONTAL REINFORCING (b)
8'-0"	8"	45		6'-0"	NOT REQUIRED	2- #4 BARS (f)
				7'-0"	NOT REQUIRED (d)	3- #4 BARS (d,e)
		60		6'-0"	NOT REQUIRED (d)	3- #4 BARS (d,e)
				7'-0"	#4 @ 22" O.C. (d)	3- #4 BARS (d,e)
	10"	45		6'-0"	NOT REQUIRED	2- #4 BARS (f)
				7'-0"	NOT REQUIRED	2- #4 BARS (f)
		60		6'-0"	NOT REQUIRED	2- #4 BARS (f)
				7'-0"	NOT REQUIRED	2- #4 BARS (f)
9'-0"	8"	45		7'-0"	NOT REQUIRED (d)	4- #4 BARS (d,e)
				8'-0"	#4 @ 19" O.C. (d)	4- #4 BARS (d,e)
		60		7'-0"	#4 @ 19" O.C. (d)	4- #4 BARS (d,e)
				8'-0"	#4 @ 15" O.C. (d)	4- #4 BARS (d,e)
	10"	45		7'-0"	NOT REQUIRED	3- #4 BARS (g)
				8'-0"	NOT REQUIRED (d)	4- #4 BARS (d,e)
		60		7'-0"	NOT REQUIRED (d)	4- #4 BARS (d,e)
				8'-0"	#4 @ 19" O.C. (d)	4- #4 BARS (d,e)

NOTE: BACKFILLING OF THE FOUNDATION SHALL NOT TAKE PLACE BEFORE THE BASEMENT SLAB IS IN PLACE AND THE FLOOR FRAMING IS ERECTED OR UNLESS WALLS ARE ADEQUATELY BRACED.

- a. SOIL CLASSES GM, GC, SM, SM-SG AND ML - 45 PSF
- b. SOIL CLASSES SG, MH, ML-CL AND CL - 60 PSF
- c. SPACING SHOWN IS BASED UPON $F_u = 60,000$ PSI
STEEL FOR $F_u = 40,000$ PSI STEEL, REDUCE SPACING BY 0.67
- d. CONCRETE SHALL HAVE A COMPRESSIVE STRENGTH OF NOT LESS THAN 3000 PSI
- e. ENGINEERED DESIGN PER ACI 332-14, REQUIREMENTS FOR RESIDENTIAL CONCRETE CONSTRUCTION
- f. FOR ALL WALL HEIGHTS, ONE HORIZONTAL BAR SHALL BE LOCATED WITHIN THE TOP 24", ONE IN THE BOTTOM 24" WITH THE REMAINING BARS EQUALLY SPACED. MAINTAIN 2" OF CONCRETE COVER BETWEEN INSIDE FACE OF WALL AND FACE OF HORIZONTAL BARS.
- g. ONE BAR WITHIN 12" OF TOP AND AT MID-HEIGHT OF WALL PER TABLE R404.1(2)(i).
- h. ONE BAR WITHIN 12" OF TOP AND ONE EACH AT THIRD POINT OF WALL HEIGHT PER TABLE R404.1(2)(i).

3. Habitable attics and sleeping rooms shall have a window or door as a second means of egress that shall be minimum 5.7 sq. ft. operable area (5.0 sq. ft. if at grade level) with maximum sill height 44" above finish floor (min. hgt. 24", min. width 20") per **R310.1**.
4. All emergency escape and rescue openings shall have a minimum net clear operable area of 4 sq. ft. The minimum net clear opening height shall be 20" and a minimum net clear opening width of 20". Emergency escape and rescue openings must have a minimum total glazing area of not less than 5 sq. ft. in the case of a ground window and not less than 5.7 sq. ft. in the case of an upper story window per **R310.2.1**. Window wells where required, shall be installed per **R310.2.3** with a minimum of 9 sq ft and a minimum horizontal projection and width of 36". Wells with a greater depth of 44" shall have permanently affixed ladder or steps per **R310.2.3.1**.
5. Clear opening heights for exterior doors to be 6'-6" minimum per **R311.2**. All interior doors providing egress/escape routes shall have nominal trim dimensions of 2'-6" by 6'-8" per **R311.6.1**. Habitable rooms with double doors less than 5'-0" in total width (less than 2'-6" per door slab) shall have a total opening width of at least 2'-6" with no side bolts or locking devices installed on either door.
6. Sliding glass drs/patio drs/skds must be safety glazed per **R308.4**.
7. Interior stairways shall have minimum head room of 6'-8" per **311.7.1.2** and minimum tread depth of 4" and maximum riser height of 8 1/4". Handrails are required for stairs with four or more risers and shall have minimum height of 34" and maximum height of 38" above treads and landings. Handrail to have maximum 4 1/2" projection into width of stair per **Section R311.7**. Enclosed accessible space under stairs shall have vertical clear stair surface and any soffits protected on the enclosed side with 1/2" gypsum board per **R302.1**.
8. Guard rails to have minimum height of 36" and shall not have openings from the walking surface to the required guard height which allow passage of a sphere 4 inches in diameter per **R312**.
9. The triangular openings at the open side of stair, formed by the riser, tread and bottom rail of a guard, shall not allow passage of a sphere 6 inches (153 mm) in diameter per **R312.1.3**.
10. Where exterior landings or floors serving the required egress door are not at grade, they shall be provided with access to grade by means of a stairway in accordance with **Section R311.7** (see item #5 above) or a ramp in accordance with **Section R311.8**.
11. Handrails shall be installed on exterior stairs having (4) or more risers per **R311.7.8**. Guards shall be installed at exterior porches / decks that are located more than 30 inches (762 mm) measured vertically to the floor or grade below at any point within 36 inches (914 mm) horizontally to the edge of the open side. Insect screening shall not be considered as a guard.
12. All flashing used (including at windows, doors, and with stone or masonry veneer) shall be corrosion-resistant per **R103.4**. See NVR Flashing Details.
13. Wood framed bearing walls shall 2 x 6 at 24" o.c. maximum or 2 x 4 at 16" o.c. maximum per **Table R602.3(3)** and **Table R602.3(5)** unless otherwise noted on plans.
14. All exterior sheathing to be structural sheathing designed in accordance with **R602.10**.
15. An approved water-resistant barrier shall be applied over sheathing of exterior walls per **Section R103.2**.
16. Interior sheathing shall be 1/2" gypsum wall board unless otherwise noted. Exceptions may include, but are not limited to, special requirements for wall bracing and fire separation.
17. Screw fastening is typical for gypsum installation and nailing will only be permitted at the perimeter of the board.
 - All screws shall be corrosion-resistant Type W 1-1/4" drywall screws.


SCREW FASTENING SCHEDULE			
WITH ADHESIVE			
Framing Spacing	Ceilings	Load-brg. walls	Non-load-brg. walls
16	16	24	24
24	16	16	24
WITHOUT ADHESIVE			
Framing Spacing	Ceilings	Load-brg. walls	Non-load-brg. walls
16	12	16	16
24	12	12	12

- For 1/2" wallboard, nally shall be 1-1/4" long, 1/4" head and .048 diameter shanks with annular ring or acceptable equivalent and comply with ASTM C518.
- For 5/8" wallboard, nally shall be 1-3/8" long, 1/4" head and .048 diameter shanks.
- Garages shall be completely separated from the residence and attic area by not less than 1/2" gypsum board applied to the garage side. Garages beneath habitable rooms shall be separated from all habitable rooms above by not less than 5/8" type X gyp. board. Where a structure is supporting a floor-ceiling assembly due to living space above the garage, the structure shall also be protected by not less than 1/2" gypsum board per Section R302.6. Openings and penetrations through the separation shall be protected by sealing the area around the penetration per Section R302.5. The garage door shall be a 20-minute fire-rated door and be equipped with a self-closing device installed per Section R302.5.1.
- Asphalt shingles shall be installed per Section R405.2. For roof slopes of 2:12 through 4:12, in lieu of two layers of underlayment, a self-adhering polymer-modified bitumen underlayment shall be used per Section R405.1. Exception #1.
- Attic spaces shall be ventilated w/ ridge and soffit vents unless otherwise noted. Venting prohibited per R406.2.
- Fireblocking shall be installed between ceiling and floor openings per R302.11. Draftstopping to be installed in accordance with R302.12.
- Water closet, lavatory or bidet shall not be set closer than 15 inches from its center to any side wall, part of the floor or closet. Toilets shall be 36 inches center-to-center between adjacent fixtures. There shall be a clearance of not less than 21 inches in front of the water closet, lavatory or bidet to any wall, fixture or door per P2705.1.
- Heating and cooling equipment installation shall be in accordance with IRC Chapter 14 and the International Mechanical Code.
- Mechanical fireplaces shall be installed per Section R1004 and I005.
- Single family attached structures to have 2-hour dwelling unit separation wall continuous to roof deck. Roofing material to be minimum class "C" over approved fire retardant wood decking extending 4" each side of dwelling unit separation wall per R302.2 and R302.3.
- Untreated wood shall be minimum 8" above finish grade per R311. Item #2.
- Bottom plates on sills and any wood in contact w/ concrete or masonry to be pressure treated material per Section R317.
- Exterior egress swing doors shall open onto a landing not more than 8 1/4" below the top of the threshold when door swings in and 1 1/2" below the top of the threshold when the door swings out. The landing shall extend a minimum of 36" in the direction of travel and be at least the width of the doorway served per R311.3.
- Air exhaust and intake openings that terminate outdoors shall be protected with corrosion-resistant screens, louvers, or grills having a min. opening size of 1/4" and maximum of 1/2" in any dimension per R306.6.
- Fasteners and connectors for pressure preservative-treated wood shall be hot-dipped galvanized steel.
- Windows that have an operable opening more than 72" above finished grade or surface below, the lowest part of the clear opening of the window shall be a minimum of 24" above the finished floor of the room in which the window is located, glazing between the floor and 24" shall be fixed or have openings through which a 4" dia. sphere cannot pass per Section R312.2.
- The Final grade shall fall a minimum of 6 inches within the first 10 feet of the foundation per R401.3.
- One- and two-family dwelling construction (R302.11).**
Vinyl or aluminum soffit material shall be securely attached to framing members and use an underlayment material of either fire retardant treated wood, 3/4-inch wood sheathing or 5/8-inch gypsum board. Venting requirements shall apply to both soffit and underlayment and shall be per Section R406. Where the property line is 10 feet or more from the building face, the provisions of this code section shall not apply.
- Townhouse construction (R302.2.5).**
Projections extending into the fire-separation distance shall have not less than 1-hour fire-resistive construction on the underside. Vinyl or aluminum soffit material shall be securely attached to framing members and use an underlayment material of either fire retardant treated wood, 3/4-inch wood sheathing or 5/8-inch gypsum board. Venting requirements shall apply to both soffit and underlayment. Vents shall be nominal 2-inch continuous or equivalent intermittent and shall not exceed the minimum net free air requirements of Section R406.2 by more than 50%. Vents in soffit are not allowed within 4 feet of fire walls or property lines per R302.2.5 and R302.2.6.
- 1-hour fire-rated construction required on projections within 2' to 3' of lot line per R302.1. No projections allowed within 2' of property line.
- 1-hour fire-rated construction required on townhouse eaves within 3' of the property line.
- Note: Single Family Detached product will NOT be built with 3' of the property line.**
- Wall bracing is designed in compliance with Section R602.10. When wall bracing is beyond the criteria for a prescriptive approach, the structure is analyzed utilizing engineering in compliance with the North Carolina Building Code (NCBC). Refer to house-specific wall bracing detail sheets and wall bracing standard details. Adhesive attachment of wall sheathing, including Method GB, shall not be permitted in Seismic Design Category C.
- Minimum floor sheathing shall be 5/8" tongue & groove decking underlayment grade plumed and sanded, exterior glue, glued and nailed on joists to meet "American Plywood Association" approved glued floor system, unless otherwise specified.


1. Ground-fault and arc-fault circuit interrupter protection is provided per **NFPA 70** (National Electric Code).
2. Electric panel box installation to be in accordance with **NFPA 70, Article 408 Section III**. Location may vary by design.
3. Approved smoke detectors shall be installed in each sleeping room; outside each separate sleeping area in the immediate vicinity of the bedrooms; and on each additional story of the dwelling, including basements and habitable attics but not including crawl spaces and uninhabitable attics. Where more than one smoke detector is required, the detectors shall be installed in such a manner that the activation of one alarm will activate all of the alarms in the individual unit. All smoke detectors shall receive their primary power from the building wiring and be equipped with a battery backup.
4. Unless listed for installation in such locations, smoke detectors shall be installed at least 10 feet from a cooking appliance, at least 3 feet from the door to a bathroom containing a tub or shower, at least 3 feet from any air supply registers, and at least 3 feet from the tip of a ceiling fan blade. In sleeping rooms, smoke detectors should be located in the vicinity of the room entrance. They shall be installed at the highest portion of the ceiling (including tray or coffered ceilings) or within 12 inches vertically from the highest point in rooms with sloped ceilings.
5. Interior stairs shall be provided with an artificial light source in the vicinity of each landing or directly above each stair. The light source shall be located above each landing to a level not less than 1ft measured at the center of the tread or landing per **R303.7**.
6. Outlets within 6' of a sink must be GFI protected.
7. An approved carbon monoxide alarm shall be installed outside of each separate sleeping area in the immediate vicinity of the bedrooms. Where a fuel-burning appliance is located within a bedroom or its attached bathroom, a carbon monoxide alarm shall be installed within the bedroom. **R315.3**.
8. Outlets installed in laundry areas must be GFI protected.

As directed by the North Carolina Board of Architecture and Registered Interior Designers, architectural seals are not required for – and should not be placed by NVR on – these plans and specifications.

REV. NO.	DATE	REMARKS
1	1/6/19	MBT - CODE UPDATES FOR 2019 NCRCBC
2	3/1/19	MBT - UPDATED ENGRY NOTES
3	12/16/22	CAP - REVISE NOTE FOR 2X4 OR 2X6 EXTERIOR WALLS

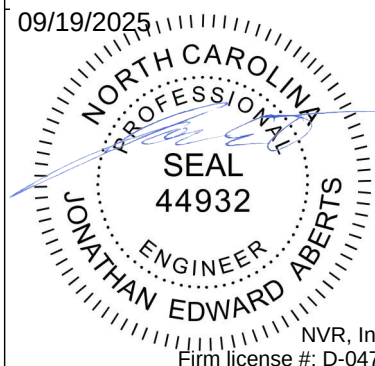

--

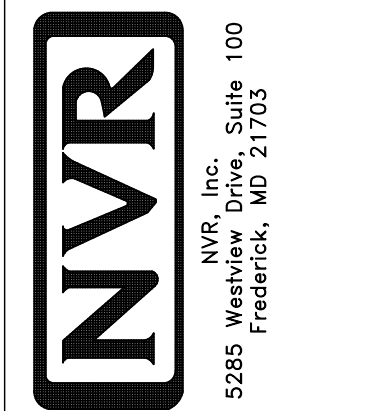



SHEET NO.	SS-1	MODEL NCRC 2018 SPEC SHEET	SET NO. VERSION
		DRAWING TITLE SINGLE FAMILY ATTACHED SINGLE FAMILY DETACHED	DRAWN BY
		OPTION DESCRIPTION NC State Building Code - Residential Code 2018	DATE:
			OPTION

James Bales
09/19/2025

COMM-LOT
KIPLING VILLAGE - 0020



  or




FOOTING/THICKENED SLAB SCHEDULE					
IDENTIFIER	LENGTH	WIDTH	HEIGHT	ENG. NUM.	REMARKS
FOOT	2'-0"	2'-0"	1'-0"	90002	

FOUNDATION DIAGONALS					
A			B		
A	0"	A	40'-2 3/8"		
B	40'-2 3/8"	B	0"		
C	20'-4 3/4"	C	20'-0"		
D	54'-5 1/16"	D	48'-0"		
E	44'-0"	E	62'-5 13/16"		

- FOUNDATION NOTES - SLAB**
- SEE STANDARD DETAIL CATEGORY "FD" SHEET(S).
 - CONCRETE SLAB ON VAPOR BARRIER OVER SUB-BASE (SEE SPEC SHEET FOR SLAB NOTES).
 - FOUNDATION UNDER GARAGE:
 - UNEXCAVATED WITH CONCRETE SLAB OVER SUB-BASE (SEE SPEC SHEET FOR SLAB NOTES) OR
 - STRUCTURAL CONCRETE SLAB OVER SUB-BASE (SEE SPEC SHEET FOR SLAB NOTES).
 - SEE FOUNDATION HOLD DOWN SHEET FOR CONNECTION INFORMATION.
 - SLAB LEDGE LOCATIONS VARY W/ GRADE BEAM(S) ORIENTATION. SEE GB-1 FOR DETAILS.
 - THE DIRECTION OF THE ARROW IS THE DIRECTION OF REBAR, AS REQUIRED.
 - ALL FOOTINGS ARE PLAIN, NON-REINFORCED CONCRETE UNLESS NOTES OTHERWISE.
 - SEE MS- DETAILS FOR FOOTER SLEEVE INFORMATION.
 - THICKENED SLAB DEPTHS MEASURE FROM TOP OF SLAB. PAD FOOTING DEPTHS MEASURE 4" BELOW TOP OF SLAB.


- LEGEND**
- BEARING WALL
 - NON BEARING WALL
 - MASONRY WALL
 - INDICATES BEARING FROM POINT-LOAD ABOVE
 - JACKS
 - BEAM/HEADER
 - FOOTING/THICKENED SLAB
 - STEEL COLUMN
 - TRUSS TIE DOWN
 - PORTAL FRAME
 - JOIST/TRUSS
 - LVL
 - ENGINEERING PAGE NUMBER
 - WINDOW/DOOR TAG
 - PRECAST LINTEL TAG
 - SEE FA DETAILS FOR FIRE ASSEMBLIES
 - SEE FC DETAILS FOR FRAMING CONNECTORS AND MATERIAL USAGE

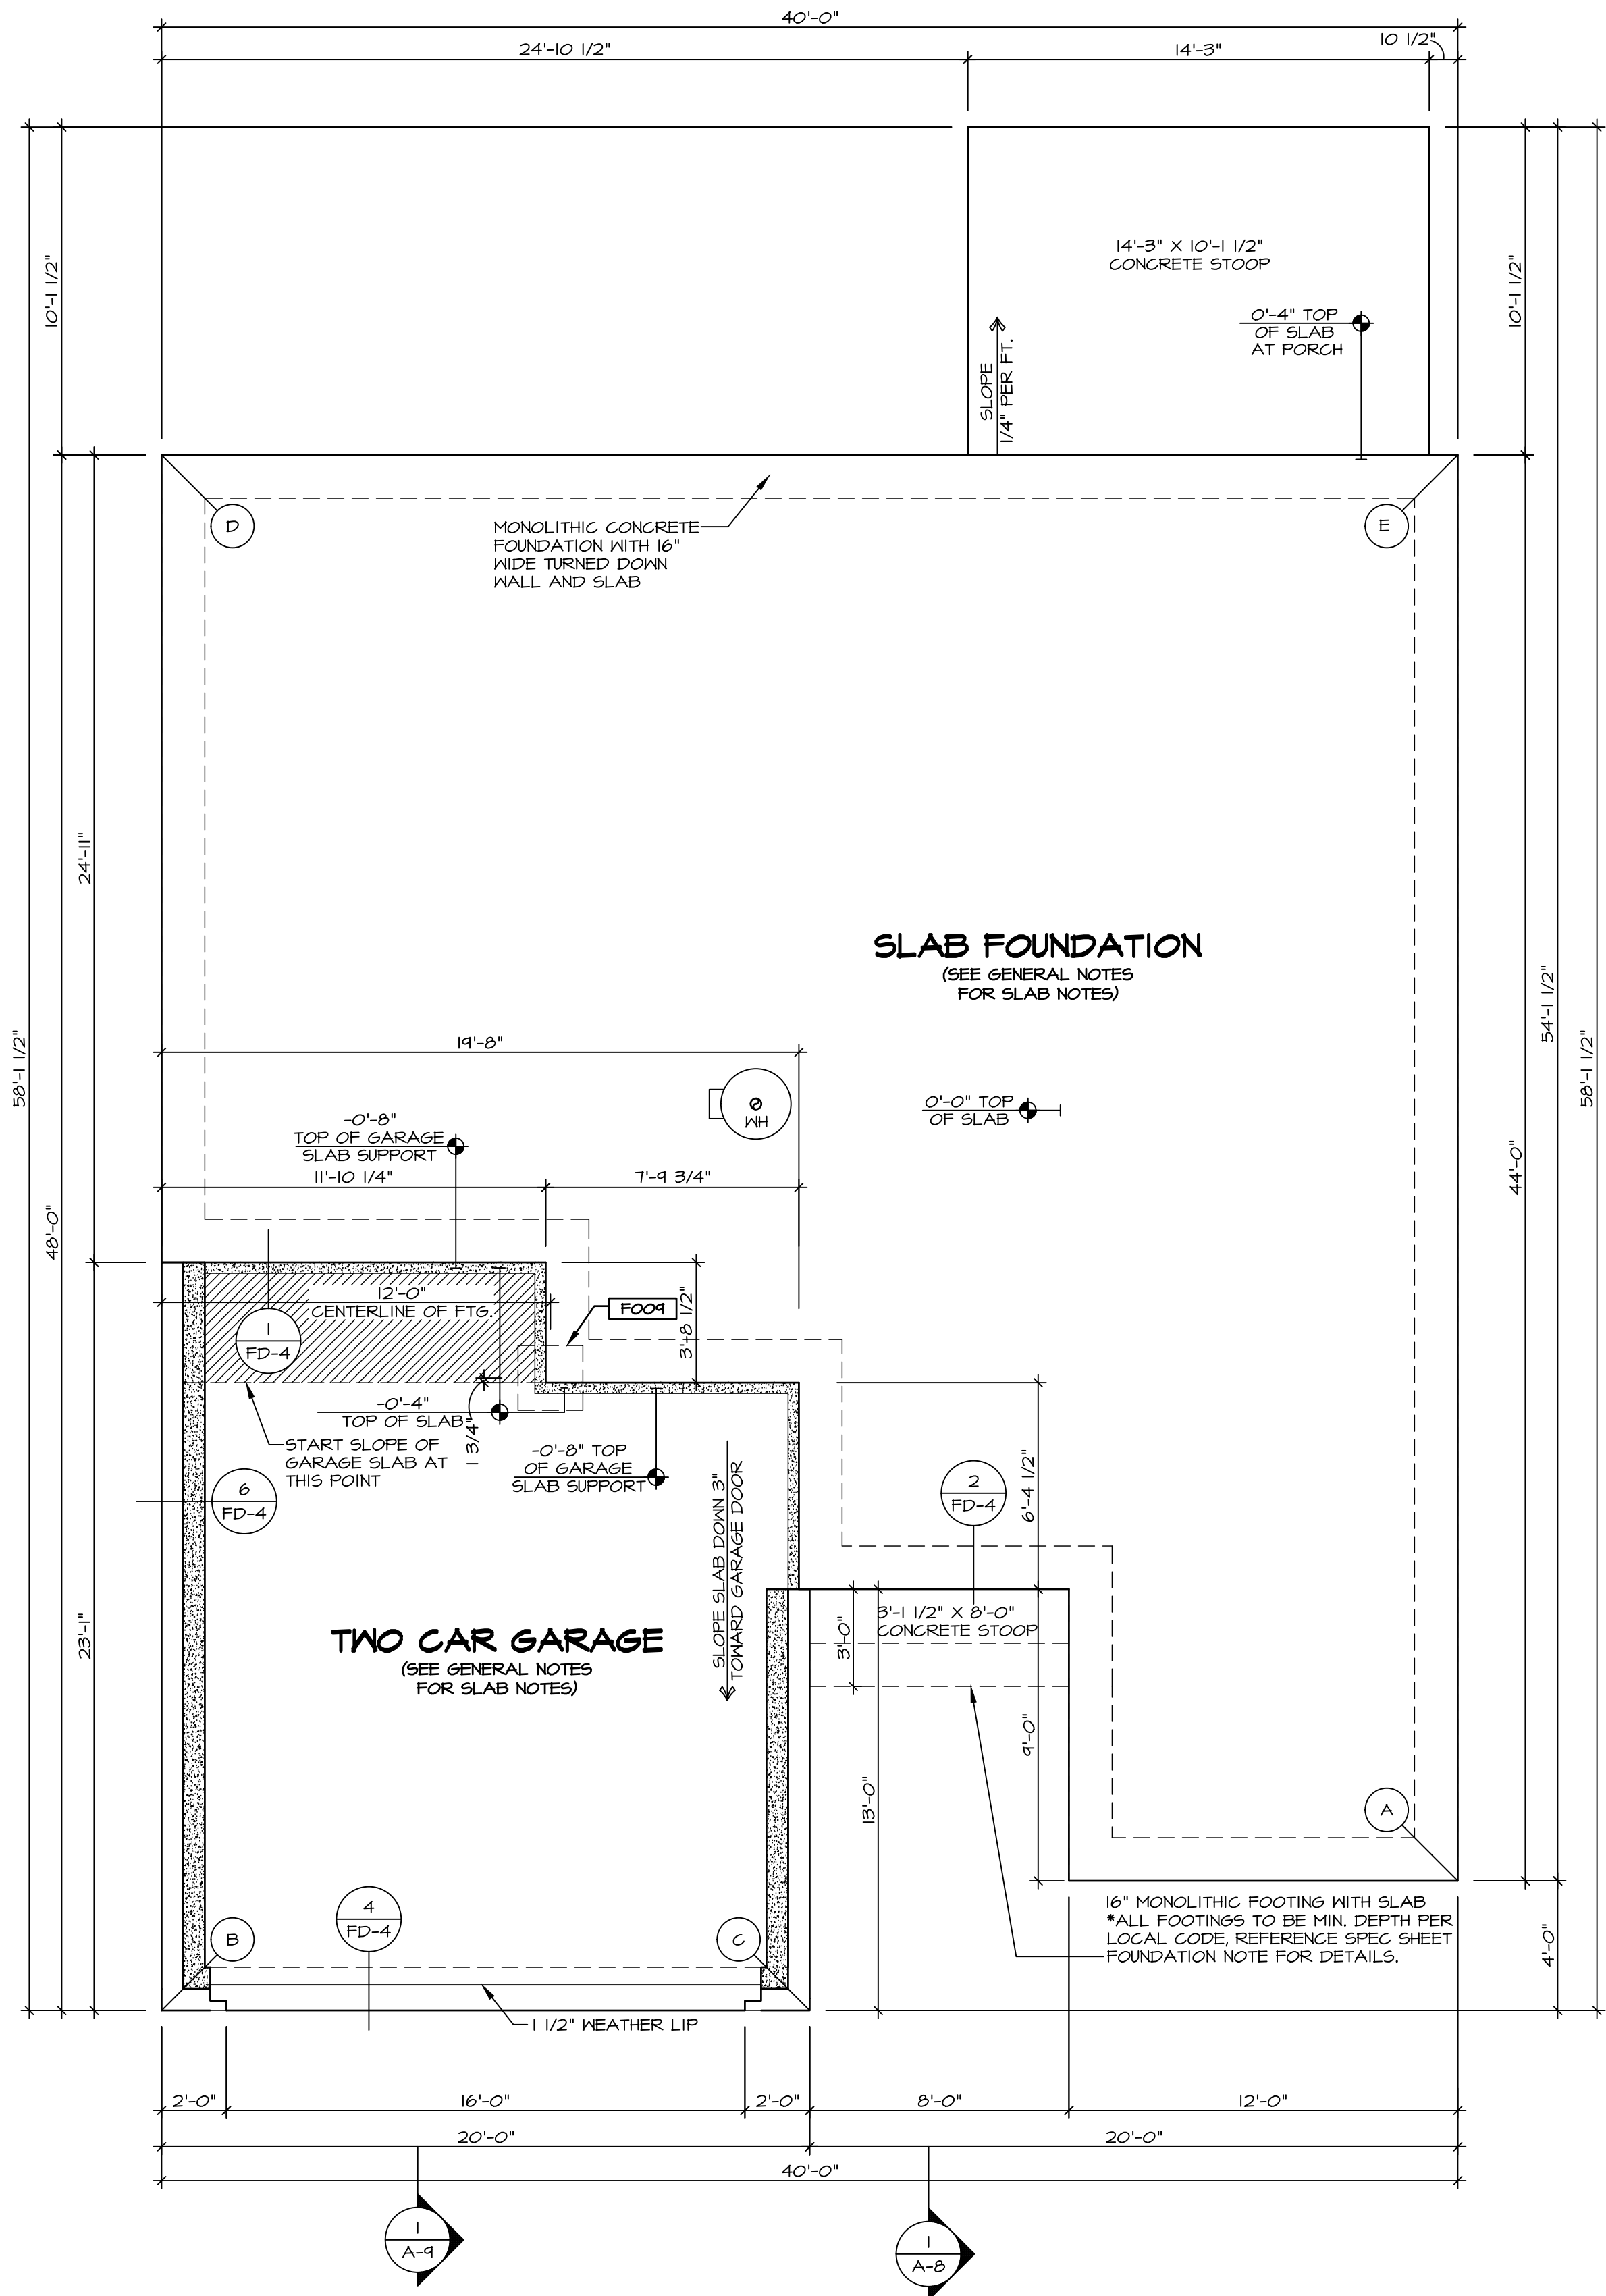


FOUNDATION PLAN
SCALE: 1/4" = 1'-0"

As directed by the North Carolina Board of Architecture and Registered Interior Designers, architectural seals are not required for – and should not be placed by NVR on – these plans and specifications.

PROJECT: RLH-YK-0020
SHEET: 7
DATE: 09/19/2025
DRAWN BY: NVR, Inc.
CHECKED BY: NVR, Inc.
APPROVED BY: NVR, Inc.

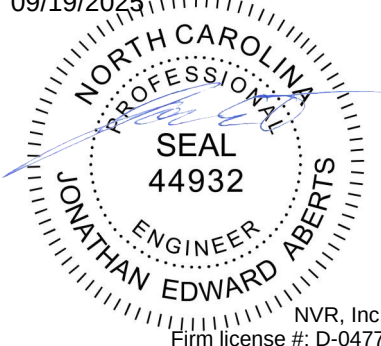

NVR, Inc. is a registered professional engineering firm. The plans are not to be used for any other project without the express written consent of NVR, Inc.

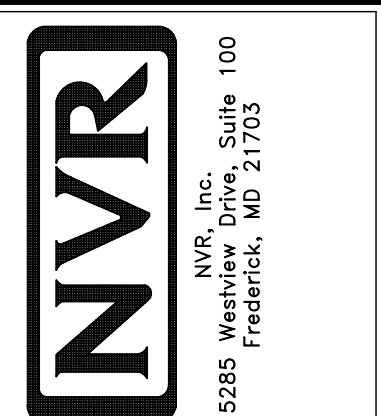


MODEL: GRAND BAHAMA
DRAWING TITLE: FOUNDATIONS
OPTION DESCRIPTION: 7
SHEET NO.: NC-3

PLUMBING NOTES:

- RADON REMEDIATION
RADON LOOP:
- (4") PERFORATED "LOOP"
 - MUST BE PLACED IN STONE BED SLIGHTLY HIGHER THAN ANY INTERIOR DRAINTILE
 - LOOP TO BE SEPARATE FROM ANY DRAINTILE ELEMENTS
 - TO BE CORRUGATED PIPE
 - SCREWS TO BE INSTALLED THROUGH LOOP AT TEE UP INTO STACK
- STACK REQUIREMENTS:
- 3" PVC STACK (4" IF BASEMENT IS GREATER THAN 2200 SQFT.)
 - NO PART OF STACK IS TO BE HORIZONTAL (45° ELBOWS PERMITTED AS REQUIRED)
 - PIPE TO BE PHYSICALLY LABELED IN THE FIELD AS "RADON VENT" OR OTHER JURISDICTIONALLY REQUIRED LANGUAGE (ON EVERY LEVEL OF HOUSE)
 - ROOF TERMINATION TO BE IN TOP 1/3 OF ROOF
 - SCREEN OR VENT CAP INSTALLED TO KEEP PESTS OUT OF RADON VENT AT ROOF TERMINATION.

INSTALLATION OF RADON STACK AND
LOOP TO BE DETERMINED BY DIVISION

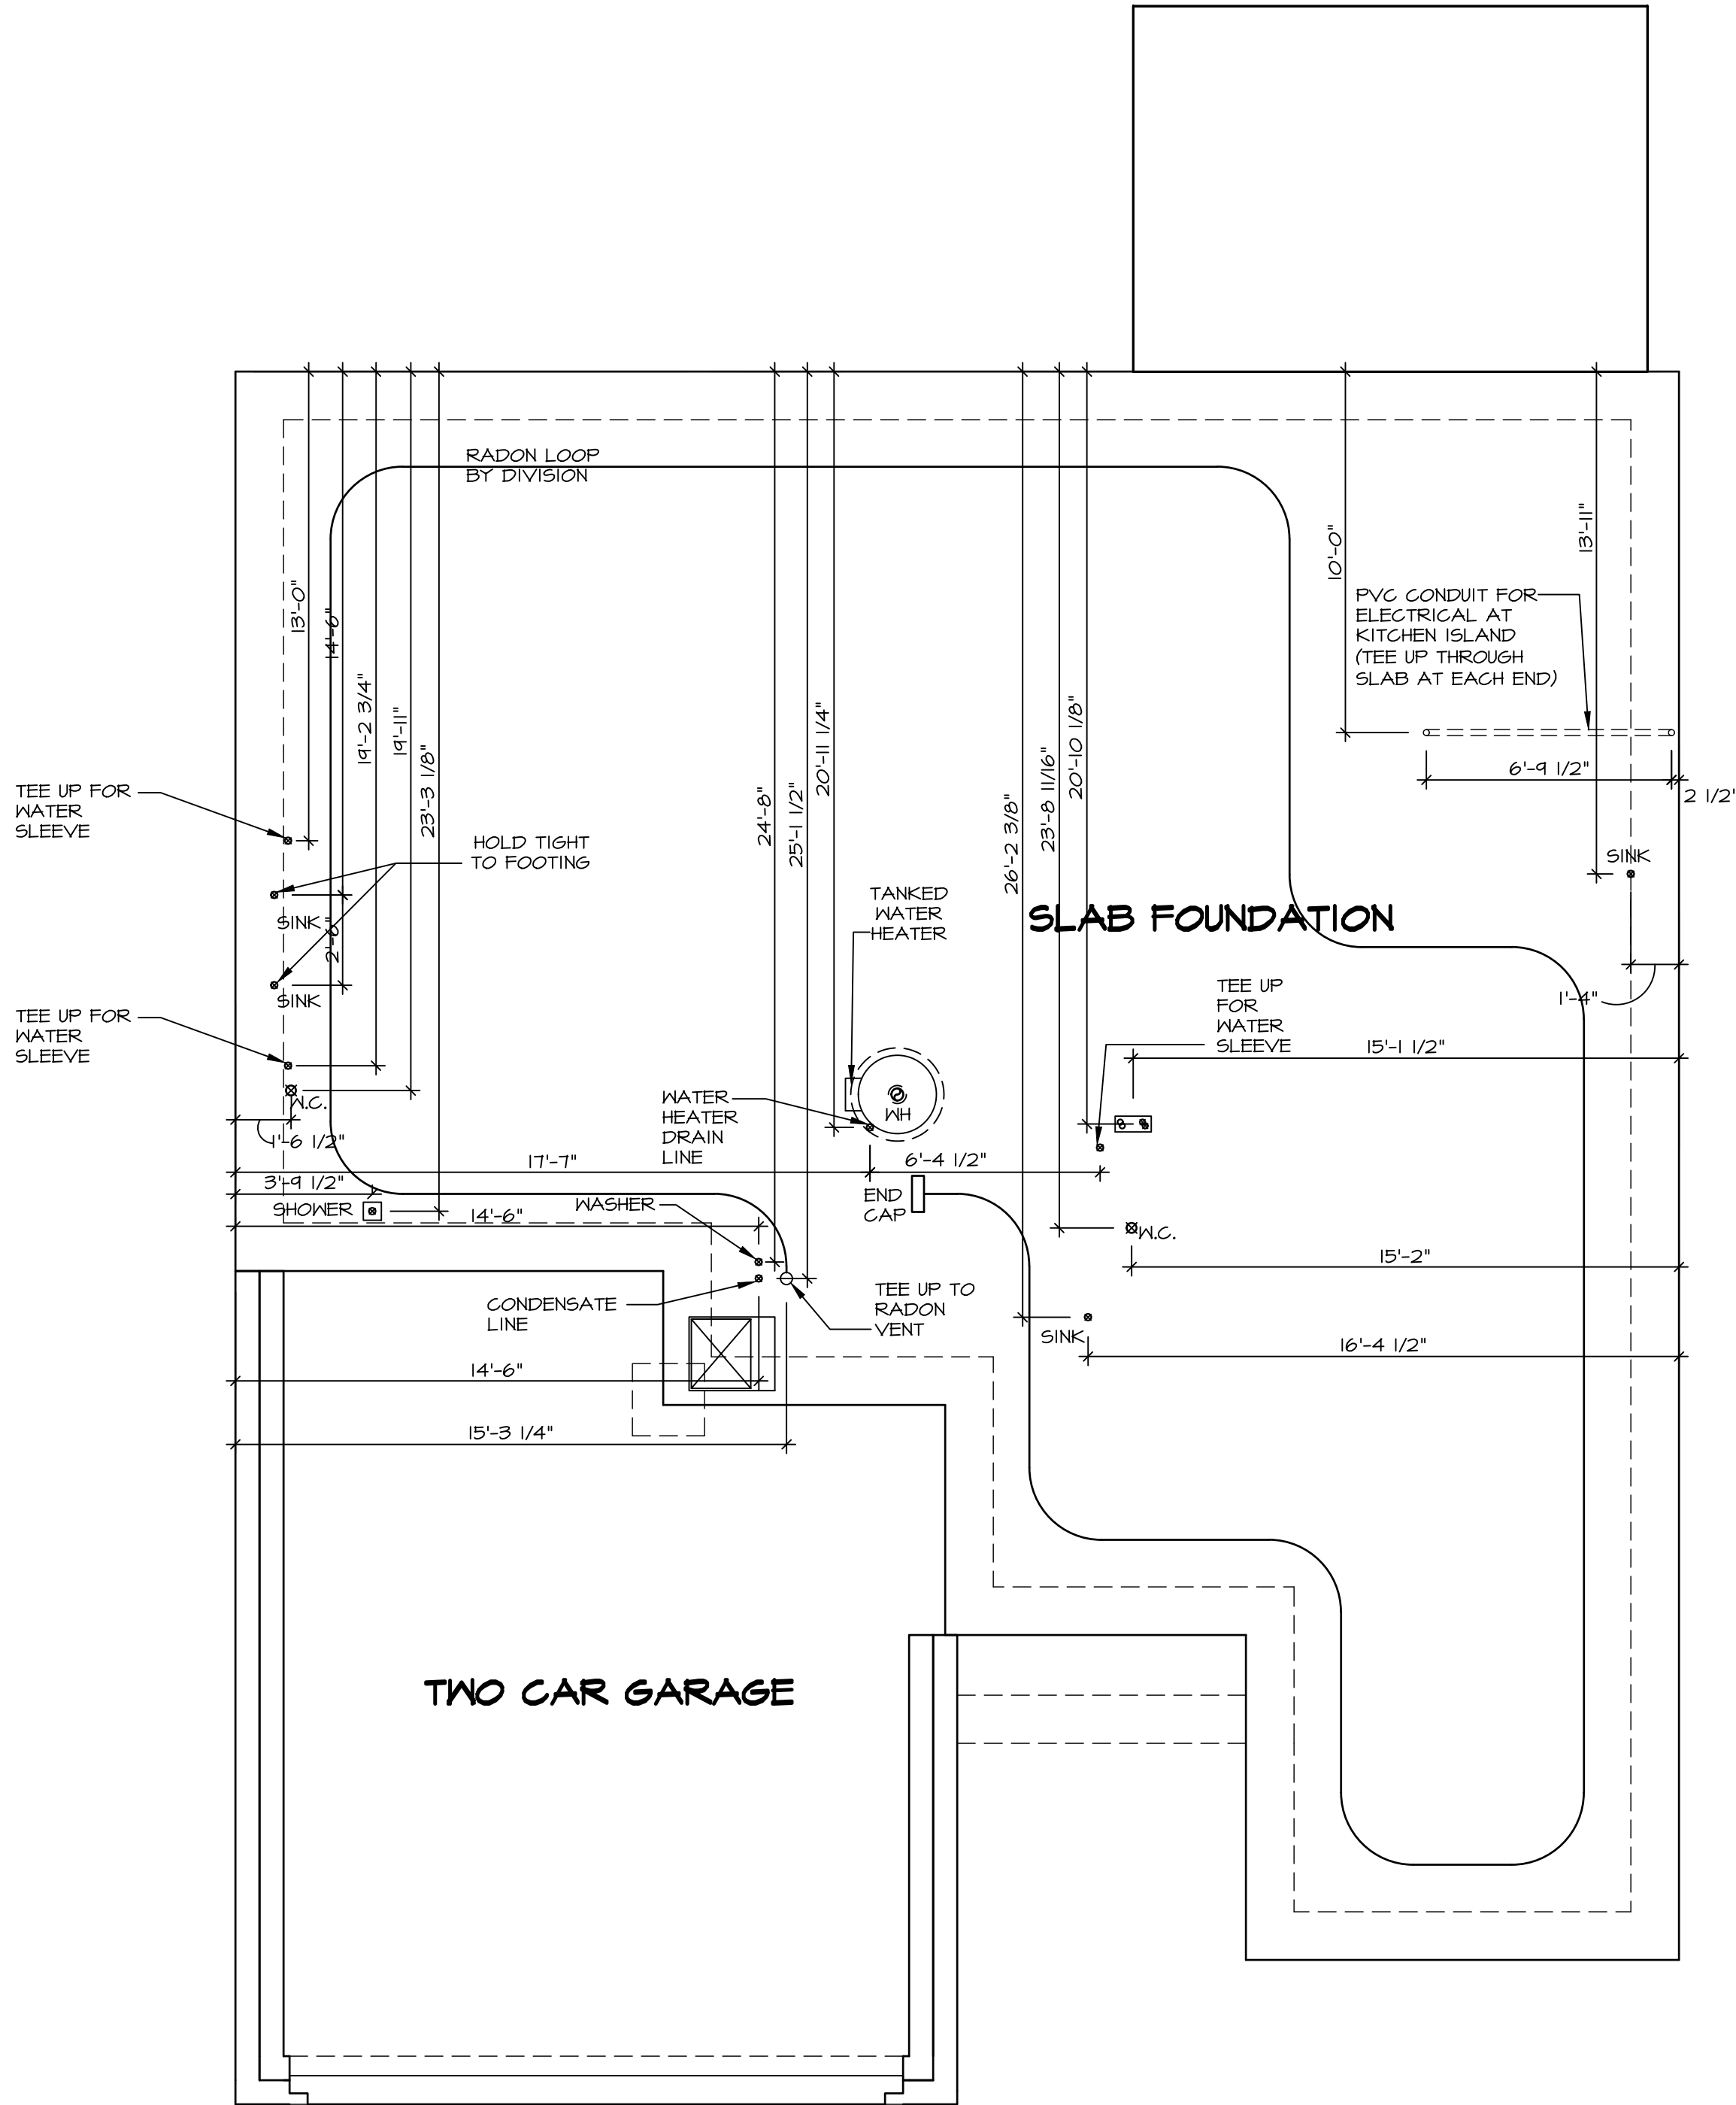

PLUMBING PLAN
SCALE: 1/4" = 1'-0"

As directed by the North Carolina Board of Architecture and Registered Interior Designers, architectural seals are not required for – and should not be placed by NVR on – these plans and specifications.

James Bates
09/19/2025

DIV-COMM-LOT-UNIT	RLH-YK-0020
COMM-LOT	KIPLING VILLAGE - 0020
STREET ADDRESS	2201 SOUTH BREEZE WAY
CITY	FUQUAY VARINA
STATE	NC
ZIP	27526

NVR, Inc., expressly reserves its copyright and other property rights in these plans. These plans are not to be reproduced, stored in a retrieval system, or transmitted in any form or manner whatsoever, nor are they to be used for any purpose other than that first obtaining the expressed written consent of NVR, Inc.

NVR
NVR, Inc., Suite 100
5285 Westwood Drive
Frederick, MD 21703

MODEL	SET NO. GBH00
GRAND BAHAMA	VERSION 01
NC-5	RELEASE NO. ----
PLUMBING	DRAWN BY
OPTION DESCRIPTION	DATE:
10	OPTION

FIRST FLOOR JACK SCHEDULE			
IDENTIFIER	DESCRIPTION	ENG. NUM.	REMARKS
J101	JACK - (3) 2X4 SPM	1000	EXTEND THRU TOP PLATE
J102	JACK - (3) 2X4 SPM	1000	EXTEND THRU TOP PLATE
J103	JACK - (2) 2X4 SPM STUD GRADE	1000	
J104	JACK - (2) 2X4 SPM STUD GRADE	1000	
J105	JACK - (2) 2X4 SPM STUD GRADE	1003	
J106	JACK - (2) 2X4 SPM STUD GRADE	1003	
J107	JACK - (2) 2X4 SPM STUD GRADE	1007	
J108	JACK - (2) 2X4 SPM STUD GRADE	1007	
J113	JACK - (2) 2X4 SPM STUD GRADE	1005	
J114	JACK - (2) 2X4 SPM STUD GRADE	1005	

LVL PLY TO PLY FASTENING SCHEDULE:		(WHERE APPLICABLE BASED ON LVL USAGE)
1.A	- (2) PLY UP TO AND INCLUDING 11 7/8" TALL; FASTEN PLYS W/ (2) ROWS 16D NAILS AT 12" O.C. OR ALT 1 1/2" WIDE LVL FASTEN PLYS W/ (3) ROWS 12D NAILS AT 12" O.C.	
2.A	- (2) PLY 14" UP TO AND INCLUDING 18" FASTEN PLYS W/ (3) ROWS 16D NAILS AT 12" O.C. OR ALT 1 1/2" WIDE LVL FASTEN PLYS W/ (4) ROWS 12D NAILS AT 12" O.C.	
3.A	- (2) PLY 20" TALL AND OVER; FASTEN PLYS W/ (4) ROWS 16D NAILS AT 12" O.C. OR ALT 1 1/2" WIDE LVL FASTEN PLYS W/ (5) ROWS 12D NAILS AT 12" O.C.	
4.A	- (3) PLY UP TO AND INCLUDING 11 7/8" TALL; FASTEN PLYS W/ (2) ROWS 16D NAILS AT 12" O.C. FROM EACH SIDE OR ALT 1 1/2" WIDE LVL FASTEN PLYS W/ (3) ROWS 12D NAILS AT 12" O.C. FROM EACH SIDE.	
5.A	- (3) PLY 14" UP TO AND INCLUDING 18" FASTEN PLYS W/ (3) ROWS 16D NAILS AT 12" O.C. FROM EACH SIDE OR ALT 1 1/2" WIDE LVL FASTEN PLYS W/ (4) ROWS 12D NAILS AT 12" O.C. FROM EACH SIDE.	
6.A	- (3) PLY 20" TALL AND OVER; FASTEN PLYS W/ (4) ROWS 16D NAILS AT 12" O.C. FROM EACH SIDE OR ALT 1 1/2" WIDE LVL FASTEN PLYS W/ (5) ROWS 12D NAILS AT 12" O.C. FROM EACH SIDE.	
7.A	- (4) PLY (ALL SIZES); FASTEN PLYS WITH (3) ROWS OF SDX22634 STRUCTURAL WOOD SCREWS, OR EQUIVALENT, AT 16" O.C. STAGGERED; SEE SHOP DRAWING FOR ADDITIONAL INFORMATION.	

FLOOR PLAN NOTES:

- ALL HEADERS ARE (2) 2x6 w/ 2x4 WALLS OR (3) 2x6 w/ 2x6 WALLS, UNLESS OTHERWISE NOTED.
- ALL HEADERS TO HAVE (1) 2x4 OR 2x6 JACK AND KING STUD EACH END, UNLESS OTHERWISE NOTED. MULTI-OPENING HEADERS TO HAVE (2) JACKS AT INTERMEDIATE BEARINGS, UNLESS OTHERWISE NOTED. NO ADDITIONAL FLOOR SYSTEM BLOCKING OR CONTINUOUS LOAD PATH JACKS ARE REQUIRED UNLESS OTHERWISE NOTED.
- ALL EXTERIOR WALLS TO BE 4" OR 6" AND ALL INTERIOR WALLS TO BE 3 1/2", UNLESS OTHERWISE NOTED. HATCHED AREAS INDICATE DROPPED CEILINGS. ALL DROPPED CEILINGS ARE 12" UNLESS OTHERWISE NOTED. SEE ARCHITECTURAL DETAIL 8/IT-1B FOR 3/4" FIRE STOPPING AT BULKHEAD / CEILING PANELS.
- SEE "BRACED WALL PANEL DETAIL SHEET" FOR SPECIAL WALL FRAMING LOCATIONS AND HEADER SIZES, IF APPLICABLE.
- SEE STANDARD DETAIL CATEGORY "IT" SHEET(S) FOR INTERIOR TRIM DETAILS.
- SEE DETAIL SHEET "AD" FOR HOUSE SPECIFIC INTERIOR TRIM OPTION TABLE.
- ALL HEADERS IN NON-BEARING WALLS SHALL BE A SINGLE FLAT 2x4 OR 2x6 ATTACHED TO CRIPPLES ABOVE, UNLESS OTHERWISE NOTED.
- TANKED WATER HEATER SHOWN AS BASE CONDITION. OPTIONAL TANKLESS WATER HEATER IS AVAILABLE IN LIEU OF TANKED WATER HEATER.
- INTERIOR HEADER HEIGHT FOR 8' CEILINGS WILL BE 6'-11", 9' CEILINGS WILL BE 7'-11", 10' CEILING WILL BE 8'-3", UNLESS OTHERWISE NOTED.
- BASEMENT WALL PANELS SHALL NOT BE HELD TIGHT TO FOUNDATION WALLS.
- ALL INTERIOR BEARING WALLS SHALL HAVE GYPSUM APPLIED TO AT LEAST ONE SIDE OR HAVE MID-HEIGHT BLOCKING INSTALLED.
- NON-BEARING WALLS OVER CONCRETE TO BE HELD 1/2" SHORT OF FRAMING ABOVE.

GYPSUM NOTES:

AT GARAGE:

GYPSUM BOARD AT COMMON WALLS, CEILING, BEAM WRAPS AND SUPPORTS PER STANDARD DETAIL FA-1(b) FIRE ASSEMBLIES OR AS REQUIRED BY LOCAL CODE.

AT STAIRS:


1/2" GYPSUM BOARD AT UNDERSIDE OF STAIRS AND WALLS IN CLOSET

ALL WINDOWS HAVE 7'-0 1/2" HEADER HEIGHT UNLESS OTHERWISE NOTED

LEGEND

- BEARING WALL
- NON BEARING WALL
- MASONRY WALL
- INDICATES BEARING FROM POINT-LOAD ABOVE
- JACKS
- BEAM/HEADER
- FOOTING/THICKENED SLAB
- STEEL COLUMN
- TRUSS TIE DOWN
- PORTAL FRAME
- JOIST/TRUSS
- LVL
- ENGINEERING PAGE NUMBER
- WINDOW/DOOR TAG
- PRECAST LINTEL TAG

SEE FA DETAILS FOR FIRE ASSEMBLIES
SEE FG DETAILS FOR FRAMING CONNECTORS AND MATERIAL USAGE

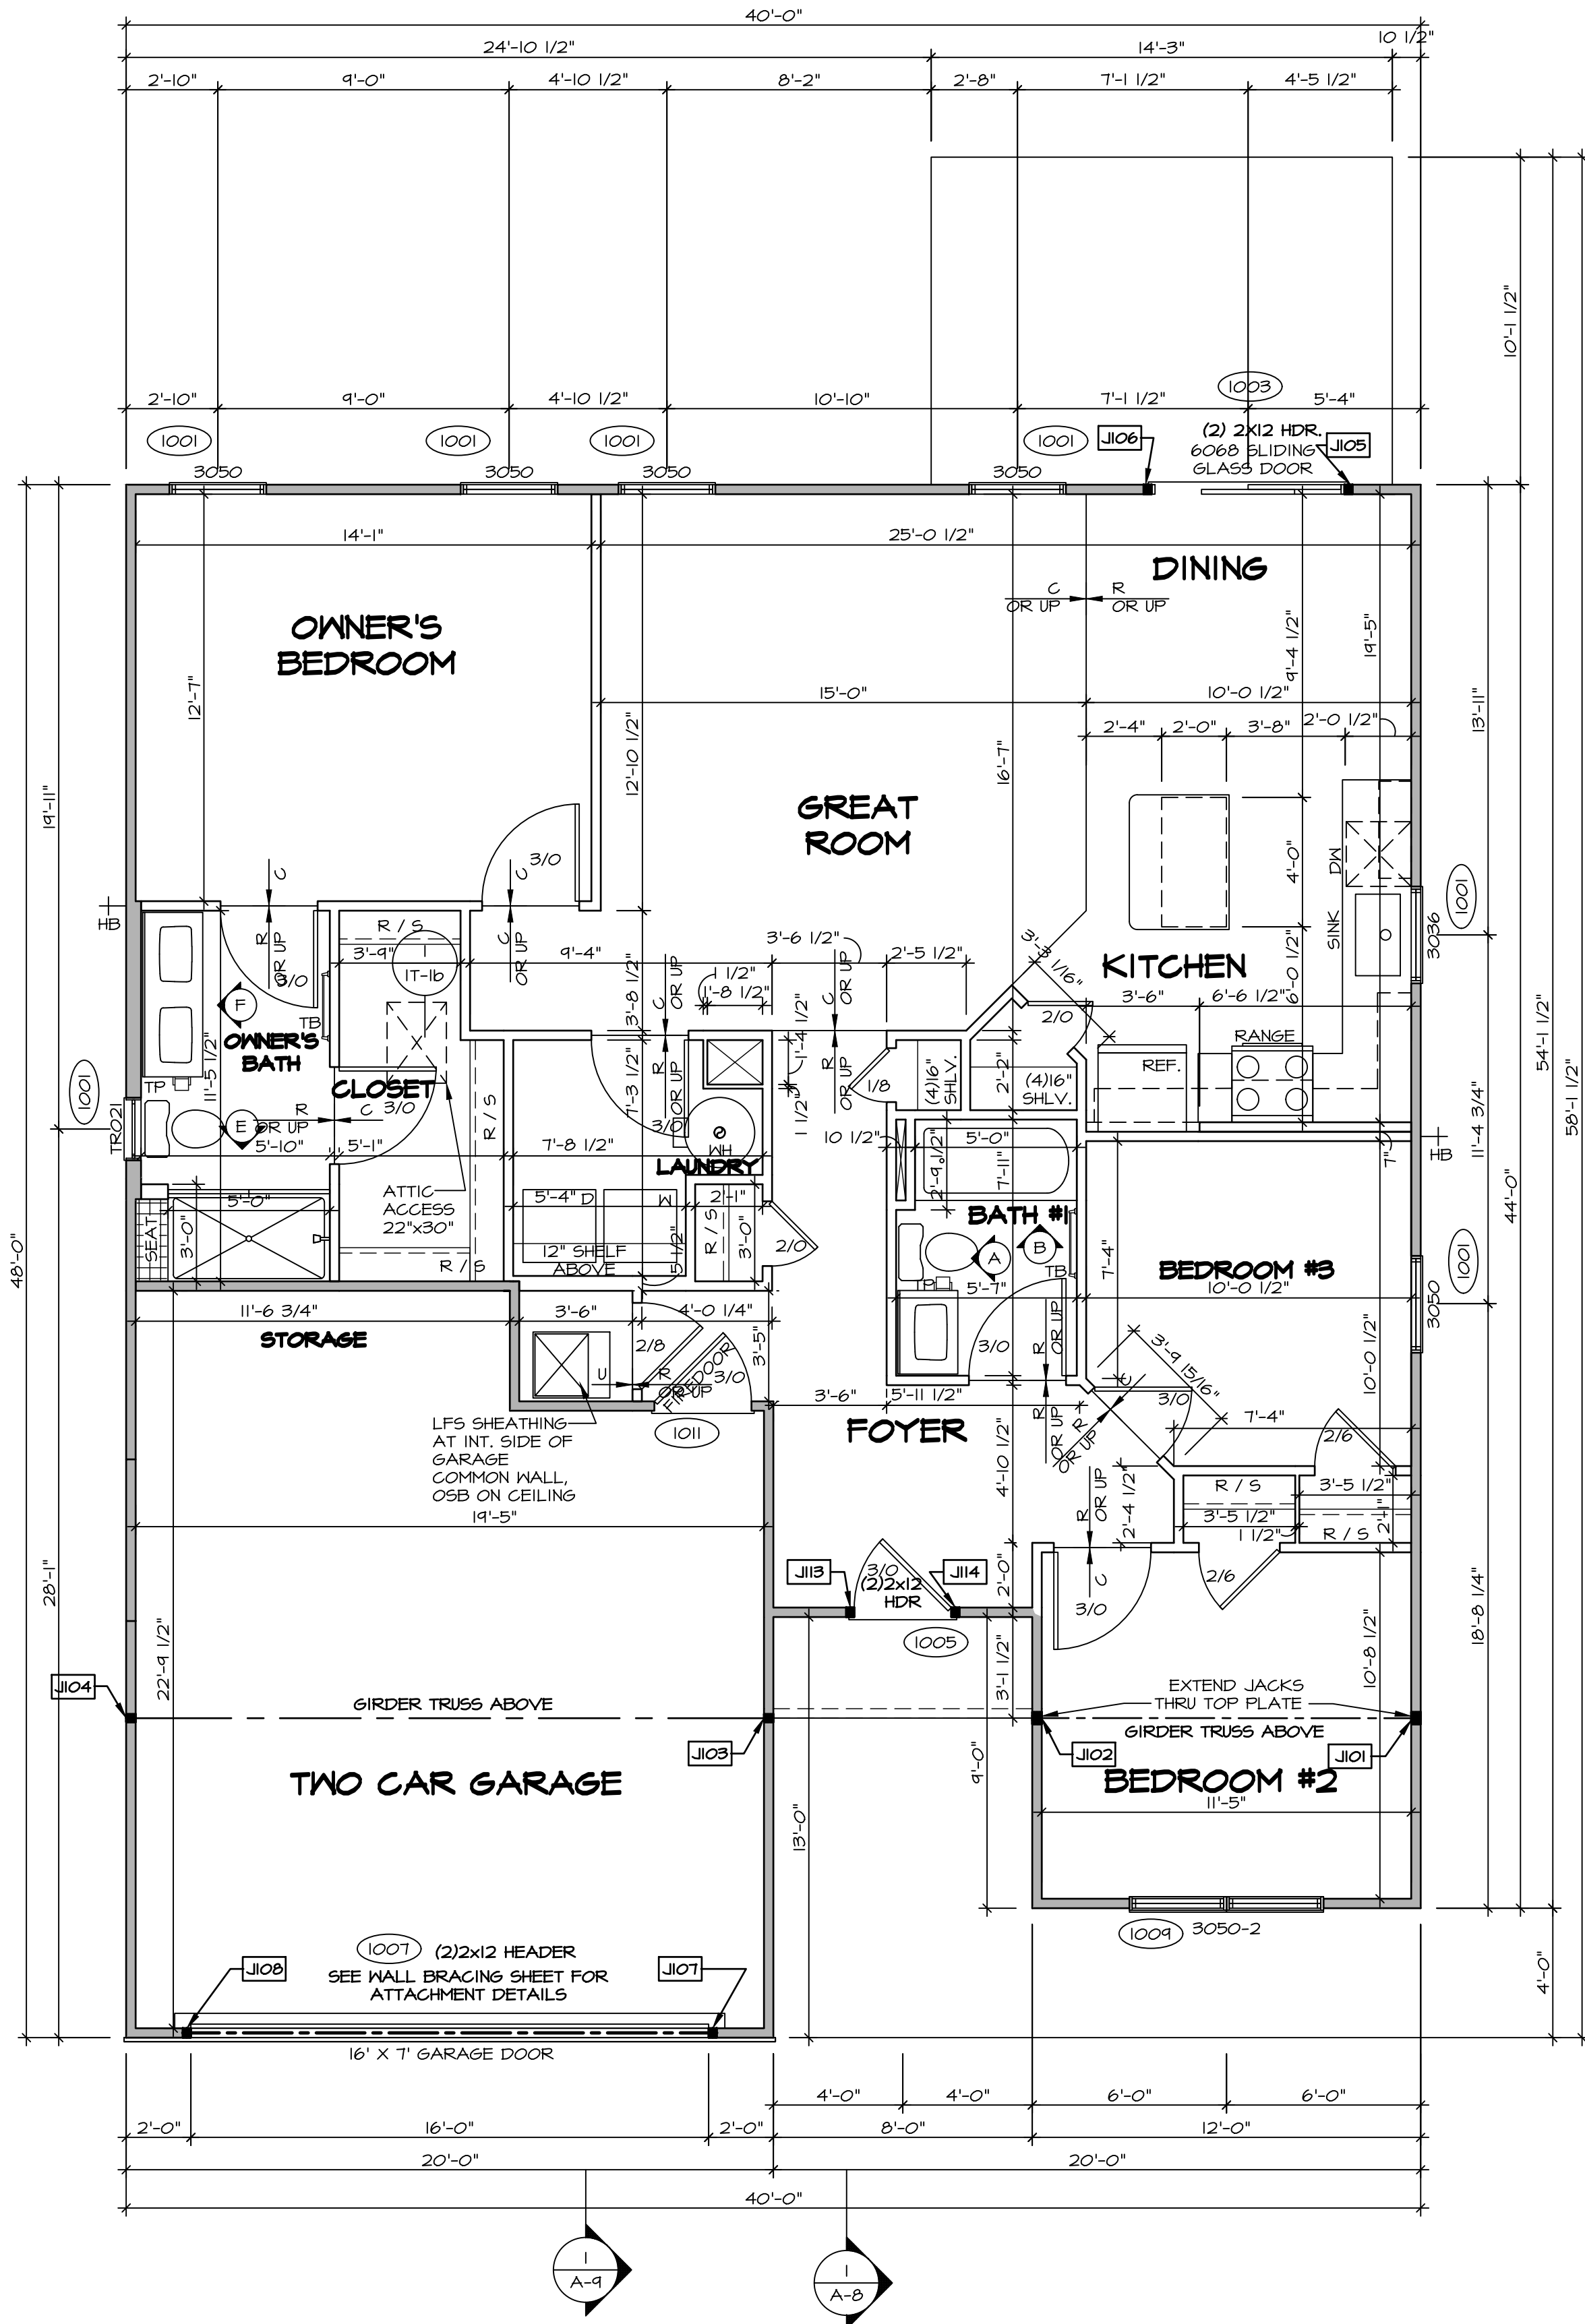

FIRST FLOOR PLAN

SCALE: 1/4" = 1'-0"


As directed by the North Carolina Board of Architecture and Registered Interior Designers, architectural seals are not required for – and should not be placed by NVR on – these plans and specifications.

RLH-YK-0020

09/19/2025





NVR, Inc. is a registered provider of continuing education for architects and interior designers. The information contained herein is for informational purposes only and does not constitute a contract. The user assumes all responsibility for the use of this information. NVR, Inc. is not responsible for any errors or omissions in this document.

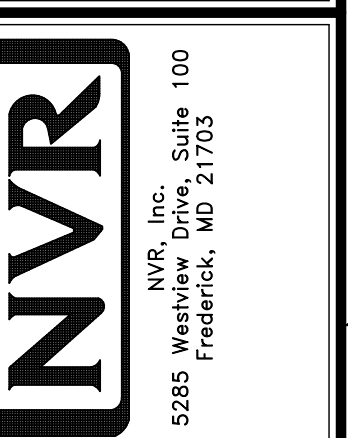

SET NO. 68H00
VERSION 01
RELEASE NO. ----
DRAWN BY
DATE:
OPTION

MODEL
GRAND BAHAMA
DRAWING TITLE
FIRST FLOOR PLAN
OPTION DESCRIPTION
12

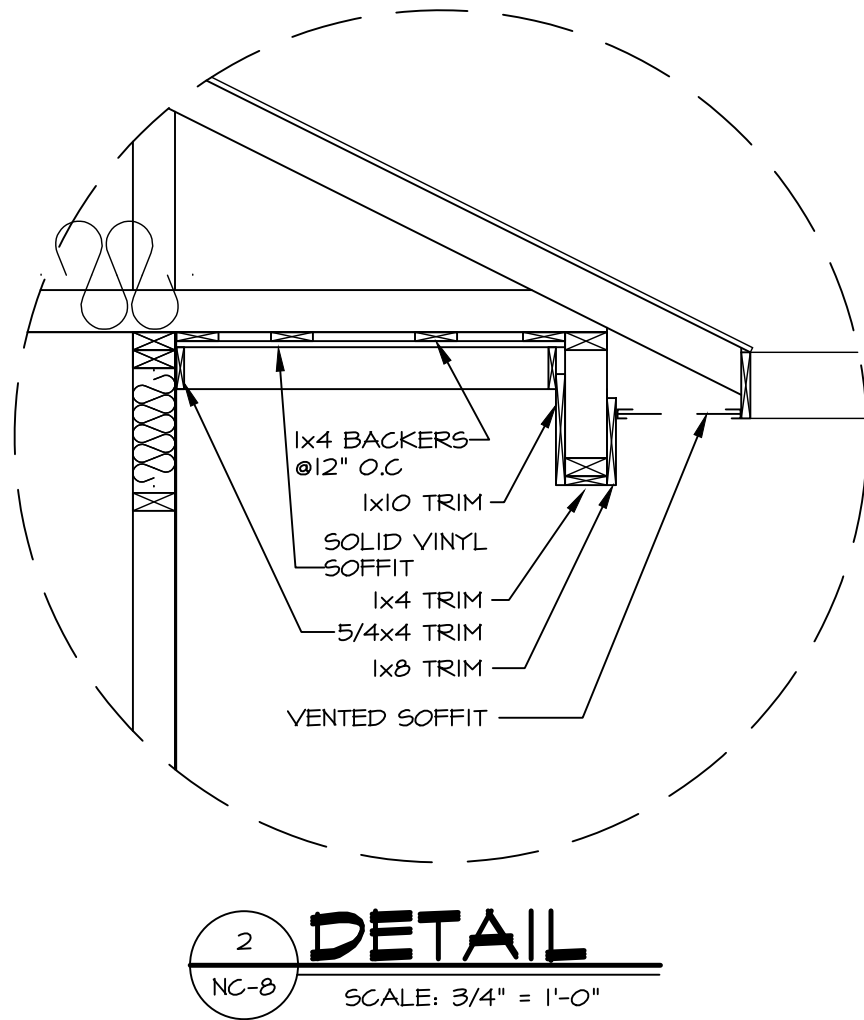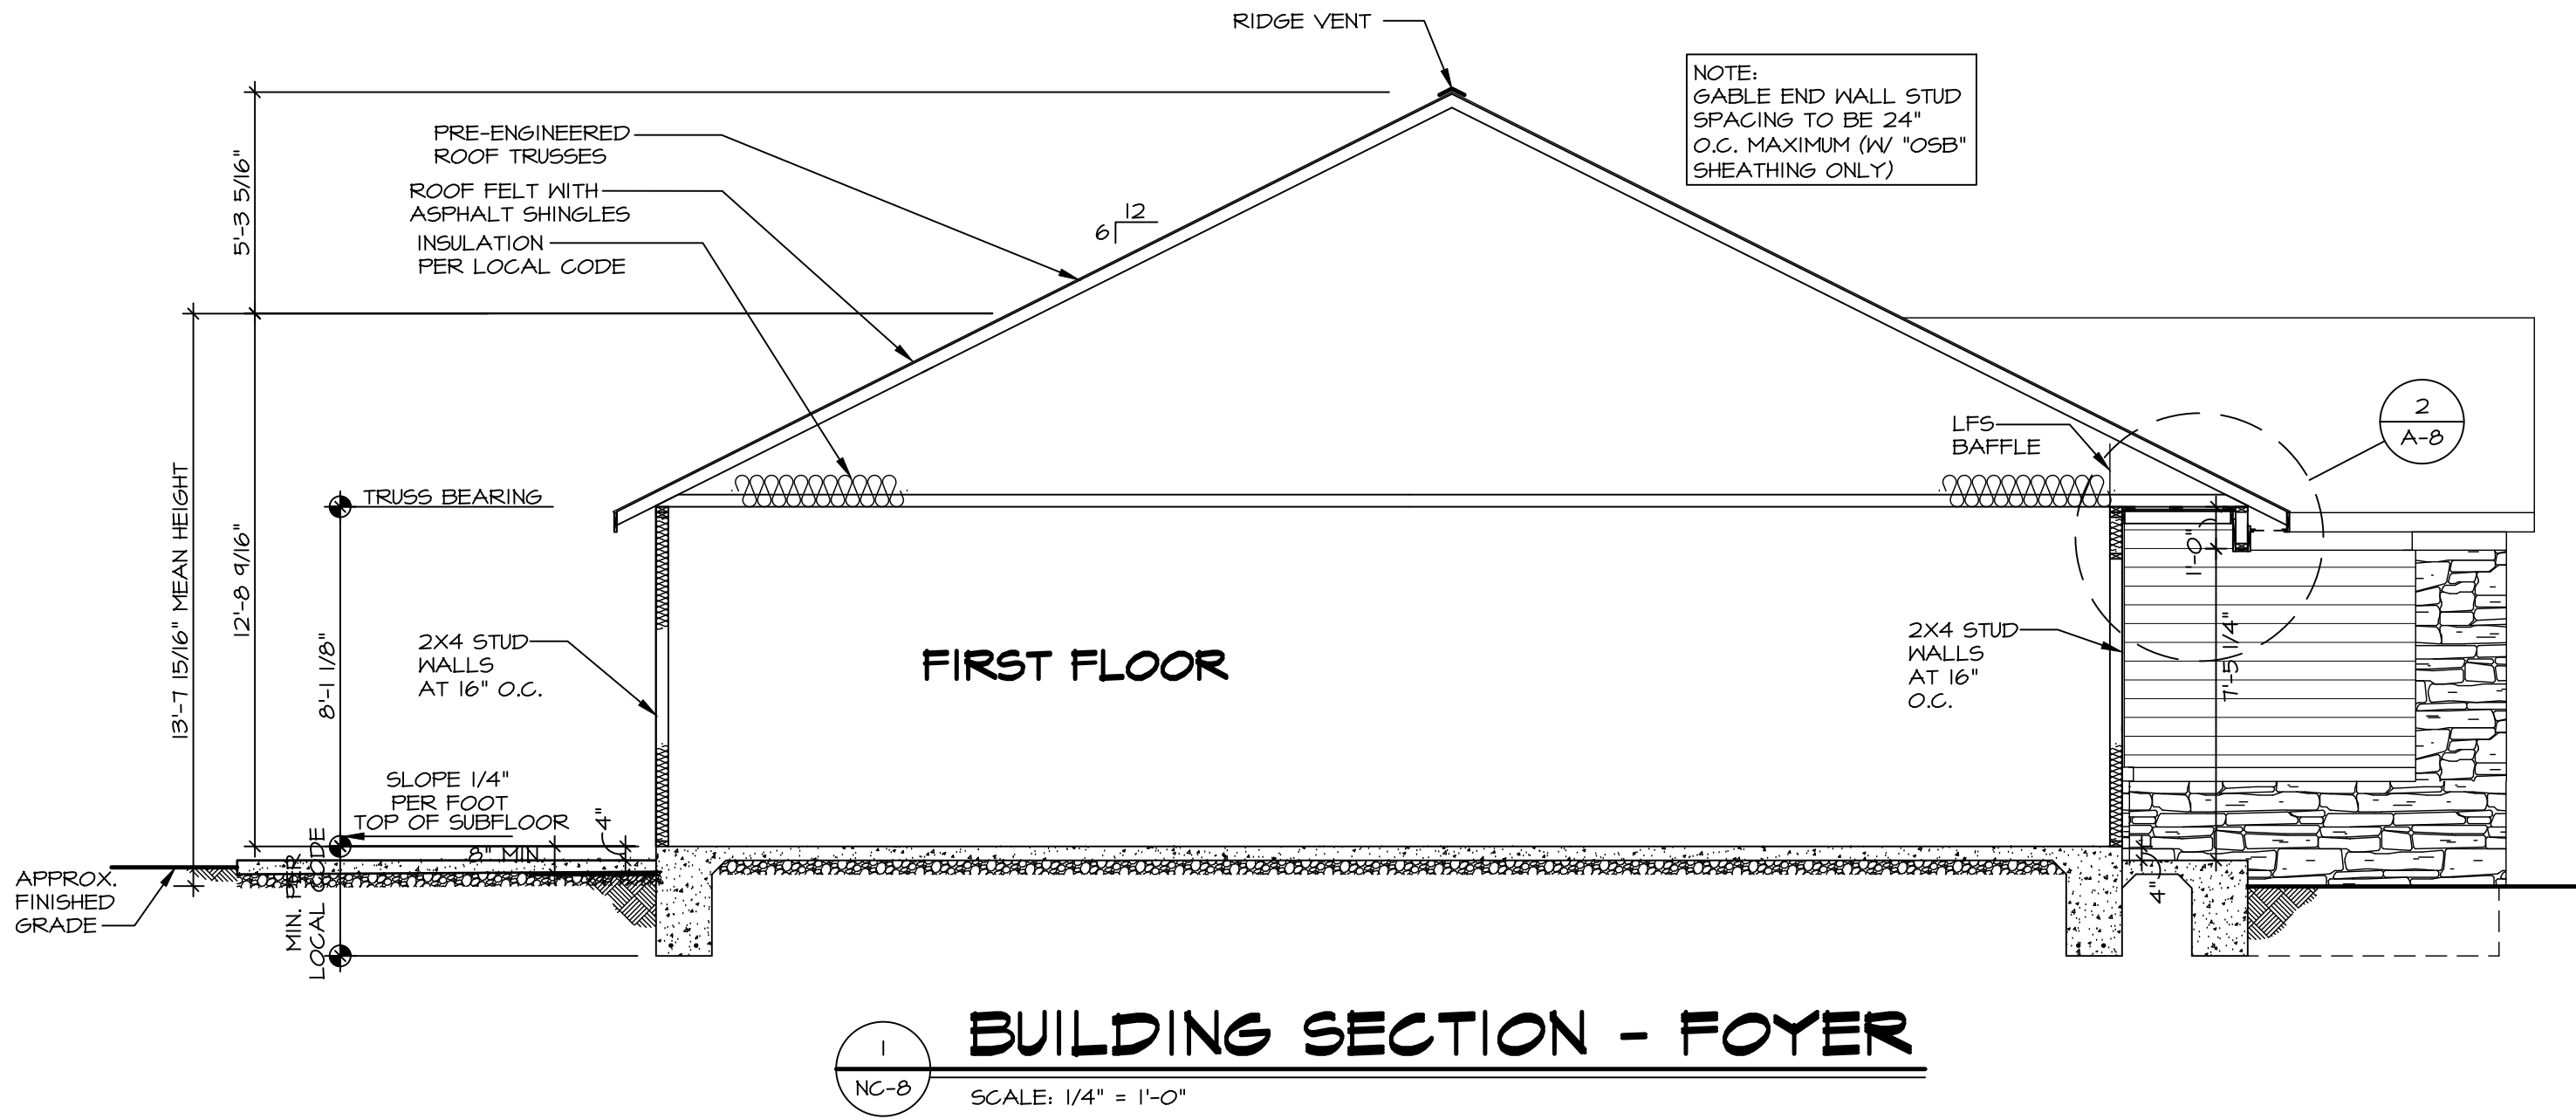

As directed by the North Carolina Board of Architecture and Registered Interior Designers, architectural seals are not required for – and should not be placed by NVR on – these plans and specifications.

James Bales
James Bales
09/19/2025


DIV-COMM-LOT-UNIT			
RLH-YK-0020			
COMM-LOT			
KIPLING VILLAGE - 0020			
STREET ADDRESS			
2871 SOUTH BREEZE WAY			
CITY			
FUGUAY VARINA			
STATE			
NC			
ZIP			
27526			

© NVR, Inc., expressly reserves its copyright and other property rights in these plans. These plans are not to be reproduced, stored in a retrieval system, or transmitted in any form or by any means, electronic, mechanical, photocopying, recording, or otherwise, without the prior written consent of NVR, Inc.

NVR

NVR, Inc., Suite 100
5285 Westwood Blvd.
Frederick, MD 21703

SHEET NO. NC-8	MODEL GRAND BAHAMA		SET NO. GBH00	
	DRAWING TITLE BUILDING SECTIONS		VERSION 01	
	OPTION DESCRIPTION		RELEASE NO. ----	
	13		DRAWN BY DATE: OPTION	

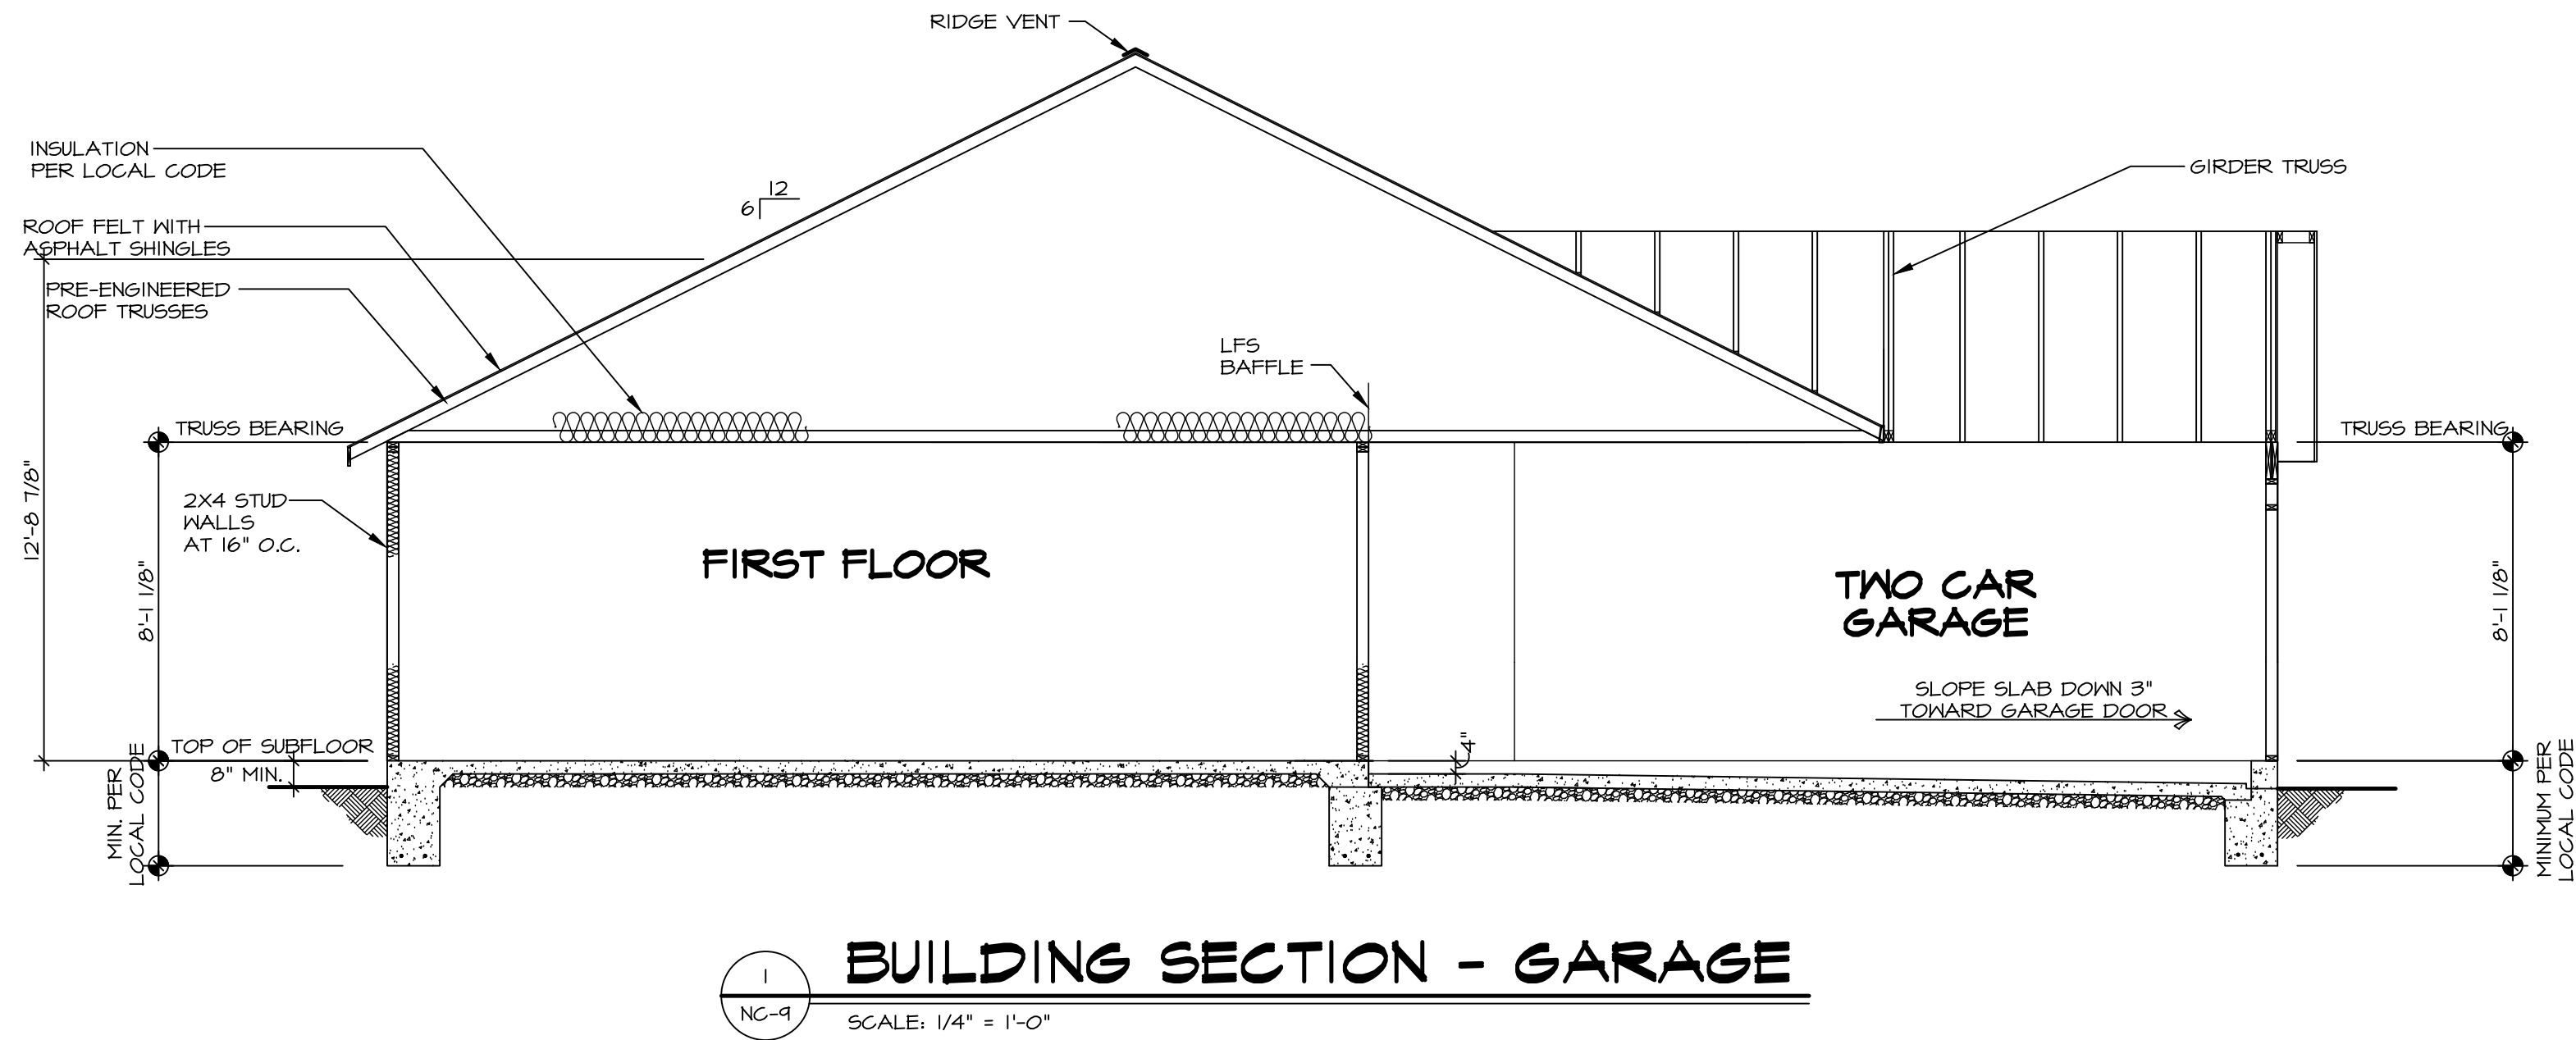

As directed by the North Carolina Board of Architecture and Registered Interior Designers, architectural seals are not required for – and should not be placed by NVR on – these plans and specifications.

James Bales
James Bales
09/19/2025

DIV-COMM-LOT-UNIT RLH-YK-0020			
COMM-LOT KIPFLING VILLAGE - 0020			
STREET ADDRESS 2201 SOUTH BREEZE WAY			
CITY FUGUAY	STATE NC	ZIP 27526	APT. NO. ----

© NVR, Inc., expressly reserves its copyright and other property rights in these plans. These plans are not to be reproduced, stored in a retrieval system, or copied in any form or manner whatsoever, nor are they to be used for any purpose other than that first obtaining the expressed written consent of NVR, Inc.

NVR

NVR, Inc., Suite 100
5285 Westwood Drive
Frederick, MD 21703

SHEET NO. NC-9	MODEL	SET NO. GBH00	
	GRAND BAHAMA DRAWING TITLE BUILDING SECTIONS	VERSION 01	RELEASE NO. ----
		DRAWN BY	DATE:
		OPTION	
	14	OPTION DESCRIPTION	

TRUSS SCHEDULE					
QUANTITY	SPECS	TRUSS NUMBER	LENGTH	ROOF PITCH (X/12)	REMARKS
2	SE	14544	12'-0"	8/12	COMMON
4	SE	14545	20'-0"	8/12	COMMON
1	SE	14546	12'-0"	8/12	COMMON
1	SE	14547	20'-0"	8/12	COMMON
1	SE	14544	12'-0"	8/12	COMMON
5	SE	18452	38'-0"	6/12	COMMON
3	SE	18453	38'-0"	6/12	COMMON
2	SE	18454	38'-0"	6/12	COMMON
4	SE	18455	38'-0"	6/12	COMMON
1	SE	18456	38'-0"	6/12	COMMON
1	SE	18457	38'-0"	6/12	COMMON
1	SE	19192	20'-0"	8/12	COMMON
2	VT	00861	3'-0"	8-6/12	COMMON
2	VT	00862	6'-0"	8-6/12	COMMON
2	VT	00863	9'-0"	8-6/12	COMMON
2	VT	00864	12'-0"	8-6/12	COMMON
1	VT	00865	15'-0"	8-6/12	COMMON
1	VT	00866	18'-0"	8-6/12	COMMON

LVL PLY TO PLY FASTENING SCHEDULE: (WHERE APPLICABLE BASED ON LVL USAGE)


- 1.A - (2) PLY UP TO AND INCLUDING 11 7/8" TALL: FASTEN PLYS W/ (2) ROWS 16D NAILS AT 12" O.C. OR ALT 1 1/2" WIDE LVL FASTEN PLYS W/ (3) ROWS 12D NAILS AT 12" O.C.
- 2.A - (2) PLY 14" UP TO AND INCLUDING 18": FASTEN PLYS W/ (3) ROWS 16D NAILS AT 12" O.C. OR ALT 1 1/2" WIDE LVL FASTEN PLYS W/ (4) ROWS 12D NAILS AT 12" O.C.
- 3.A - (2) PLY 20" TALL AND OVER: FASTEN PLYS W/ (4) ROWS 16D NAILS AT 12" O.C. OR ALT 1 1/2" WIDE LVL FASTEN PLYS W/ (5) ROWS 12D NAILS AT 12" O.C.
- 4.A - (3) PLY UP TO AND INCLUDING 11 7/8" TALL: FASTEN PLYS W/ (2) ROWS 16D NAILS AT 12" O.C. FROM EACH SIDE OR ALT 1 1/2" WIDE LVL FASTEN PLYS W/ (3) ROWS 12D NAILS AT 12" O.C. FROM EACH SIDE.
- 5.A - (3) PLY 14" UP TO AND INCLUDING 18": FASTEN PLYS W/ (3) ROWS 16D NAILS AT 12" O.C. FROM EACH SIDE OR ALT 1 1/2" WIDE LVL FASTEN PLYS W/ (4) ROWS 12D NAILS AT 12" O.C. FROM EACH SIDE.
- 6.A - (3) PLY 20" TALL AND OVER: FASTEN PLYS W/ (4) ROWS 16D NAILS AT 12" O.C. FROM EACH SIDE OR ALT 1 1/2" WIDE LVL FASTEN PLYS W/ (5) ROWS 12D NAILS AT 12" O.C. FROM EACH SIDE.
- 7.A - (4) PLY (ALL SIZES): FASTEN PLYS WITH (3) ROWS OF SDN22634 STRUCTURAL WOOD SCREWS, OR EQUIVALENT, AT 16" O.C. STAGGERED. SEE SHOP DRAWING FOR ADDITIONAL INFORMATION.

ROOF FRAMING NOTES:

1. REFER TO THE STANDARD DETAILS FOR THE FOLLOWING:
- 1.1. TRUSS TIE-DOWNS (1/RF-1)
- 1.2. PIGGYBACK TRUSS ATTACHMENT (2/RF-1)
- 1.3. VALLEY GABLE TRUSS BRACING (3/RF-1)
- 1.4. GABLE BRACING (1/RF-1C)
- 1.5. TURN GABLE BRACING (1/RF-1)
- 1.6. TRUSS LATERAL BRACING (2/RF-1C)
- 1.7. LIFELINE ATTACHMENT (5/RF-1)
- 1.8. FALL PROTECTION ON PLATFORM TRUSS (1/RF-1)
2. IF TRUSS DOES NOT APPEAR ON THE TRUSS BRACING SHEET, NO ADDITIONAL LATERAL BRACING REQUIRED.
3. ALL FINISHED ROOF OVERHANGS ARE TO BE 12" FROM FRAMED WALL UNLESS OTHERWISE NOTED.

LEGEND

- BEARING WALL
- MASONRY WALL
- INDICATES BEARING FROM POINT-LOAD ABOVE
- JACKS
- BEAM/HEADER
- FOOTING/THICKENED SLAB
- STEEL COLUMN
- TRUSS TIE DOWN
- PORTAL FRAME
- JOIST/TRUSS
- LVL
- ENGINEERING PAGE NUMBER
- WINDOW/DOOR TAG
- PRECAST LINTEL TAG
- SEE FA DETAILS FOR FIRE ASSEMBLIES
- SEE FC DETAILS FOR FRAMING CONNECTORS AND MATERIAL USAGE

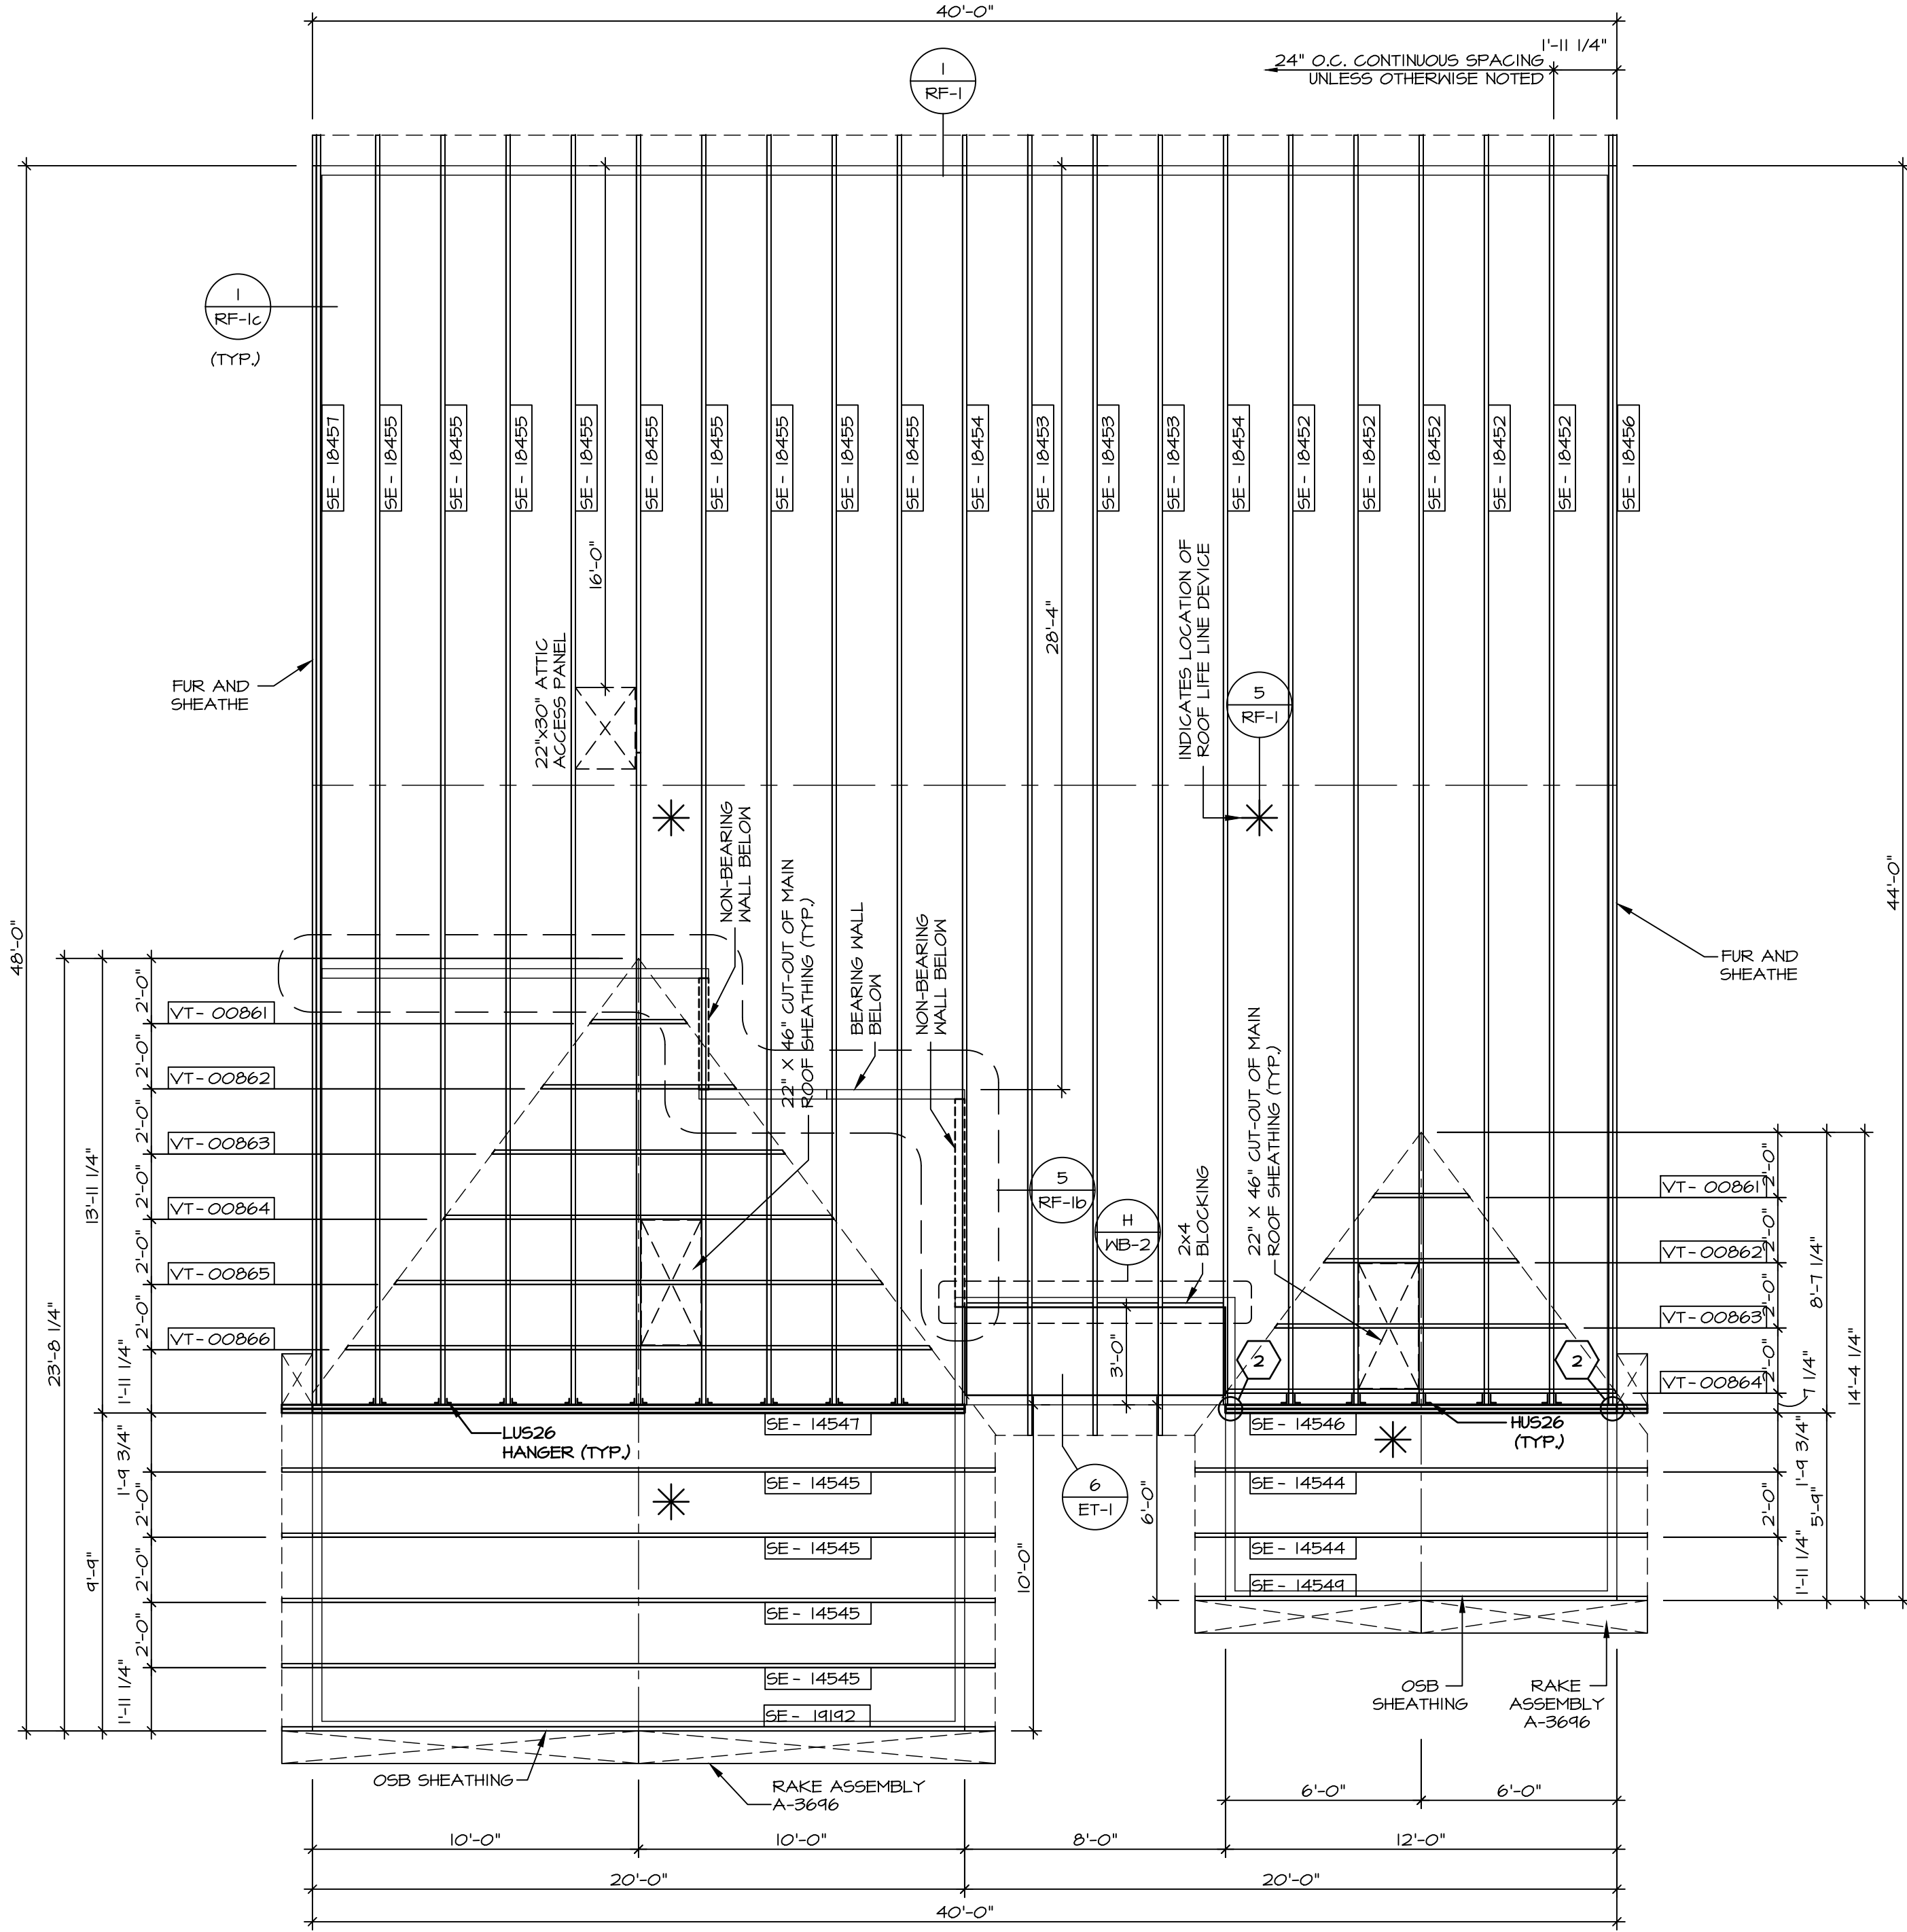

ROOF FRAMING
SCALE: 1/4" = 1'-0"

As directed by the North Carolina Board of Architecture and Registered Interior Designers, architectural seals are not required for – and should not be placed by NVR on – these plans and specifications.

IN COMM-LT-UNIT
RLH-YK-0020

OWN-LOT
SEILING VILLAGE - 0020
STREET ADDRESS
281 SOUTH BREEZE WAY
CITY
FLOUJAY VARINA
STATE
NC
ZIP
27526

09/19/2025
NORTH CAROLINA PROFESSIONAL SEAL
44932
ENGINEER
NATHAN EDWARD ALBERTS
NVR, Inc.
Firm license #: D-0477

NVR, Inc., expressly reserves its copyright and other property rights in these plans. These plans are not to be reproduced, stored in a retrieval system, or transmitted in any form or by any means, electronic, mechanical, photocopying, recording, or by any information storage and retrieval system, without the prior written consent of NVR, Inc.

 






NVR
NVR, Inc., Suite 100
5285 Westwood Drive
Frederick, MD 21703

SET NO. 6BHO0
VERSION 01
RELEASE NO. ----
DRAWN BY BN
DATE: 2/7/20
OPTION

MODEL
GRAND BAHAMA
DRAWING TITLE
ROOF FRAMING
OPTION DESCRIPTION

SHEET NO.
S-2
21

VA-As-Sold 2-Jobs\ASD\2025 2ndHalf-Complete\RLH\DETACHED\GRAND BAHAMA_GBH00_01\RLH_YK_0020\21 S-2 RFF LS.dwg 09/19/25 - 10:29 am

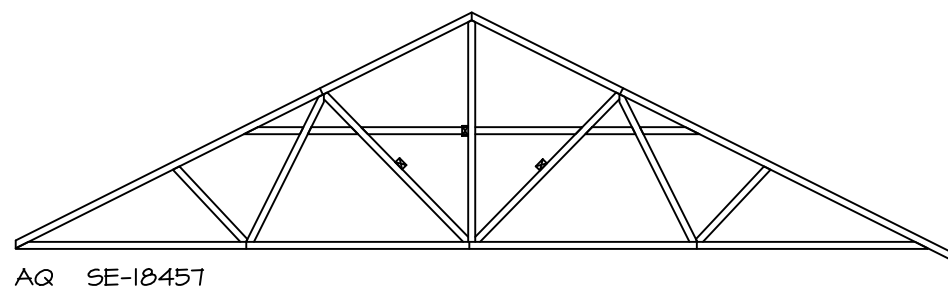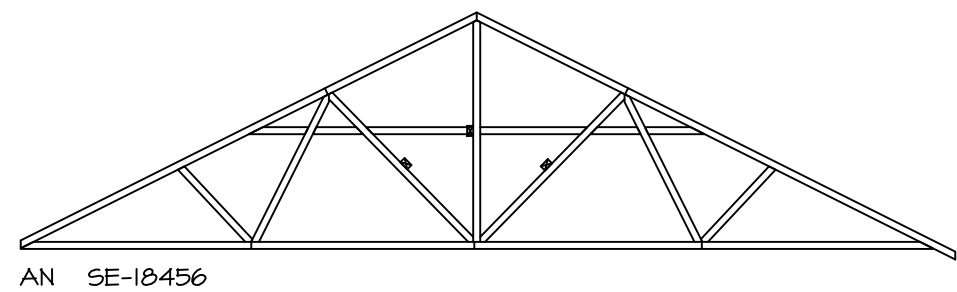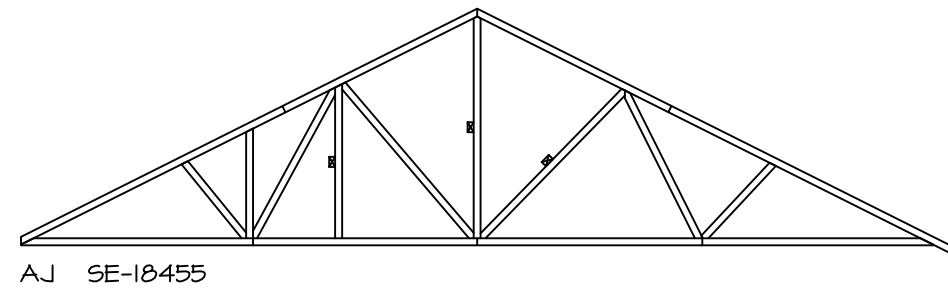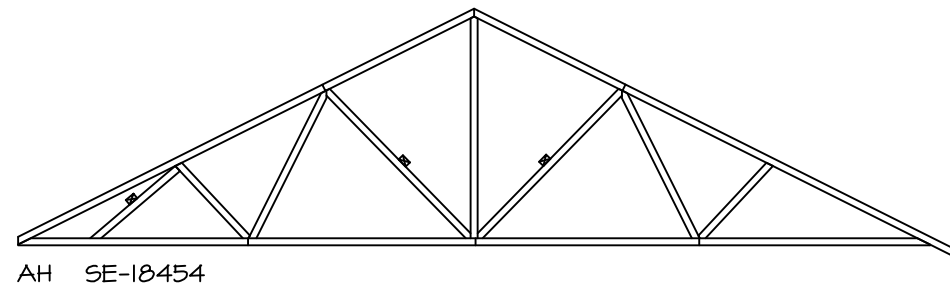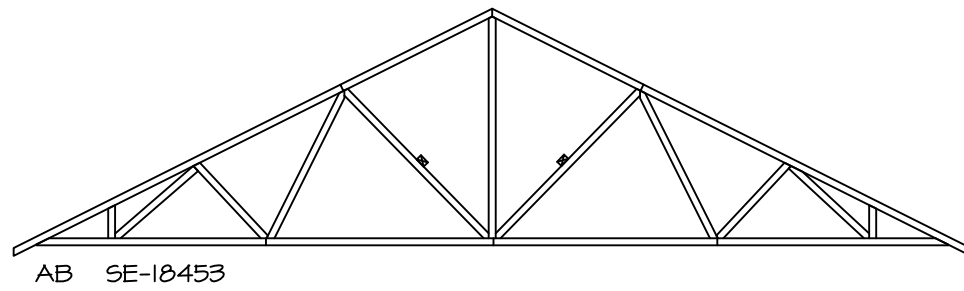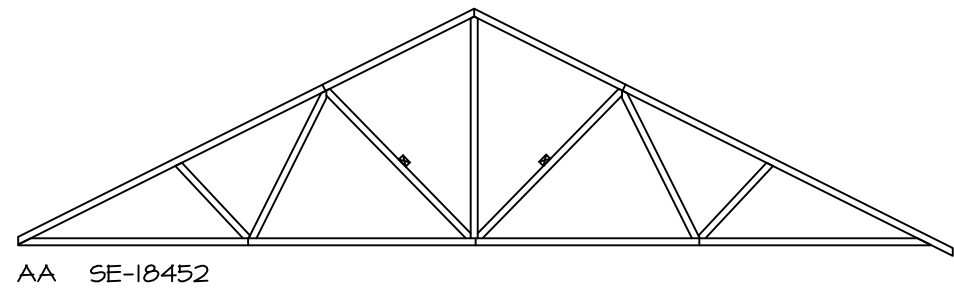

TRUSS BRACING DETAILS

SCALE: 1/4" = 1'-0"


TRUSS BRACING NOTES:

- IF TRUSS DOES NOT APPEAR ON THIS TRUSS BRACING SHEET, NO ADDITIONAL LATERAL BRACING IS REQUIRED.
- 2X4 SPF#2 LATERAL BRACES SHALL BE NAILED TO MINIMUM (3) TRUSS MEMBERS WITH MINIMUM (2) 10D NAILS. PROVISIONS MUST BE MADE AT ENDS OR SPECIFIED INTERVALS TO RESTRAIN OR ANCHOR LATERAL BRACING.
- WEB "T" BRACE, DETAIL 3/RP-1c, IS REQUIRED WHERE LATERAL BRACING IS NOT CONTINUOUS ACROSS THREE (3) OR MORE TRUSSES AND MAY BE USED IN LIEU OF 2X4 LATERAL BRACING.
- DIAGONAL BRACING REQUIRED WHEN LATERAL BRACING IS REQUIRED (4/RP-1c)
- STUDDED GABLE BRACING DETAIL (1/RP-1c) TO BE UTILIZED FOR TRUSSES 6'-4" IN HEIGHT OR GREATER.
- PARTIALLY SHEATHED GABLES, SEE (5/RP-1c) FOR "L" BRACING WHEN REQUIRED.
- LATERAL BRACING CAN BE APPLIED TO EITHER SIDE OF THE WEB MEMBER IDENTIFIED IN THE DRAWING.
- SHEATHING (OSB OR GYPSUM) REPLACES LATERAL AND DIAGONAL TRUSS BRACING.


As directed by the North Carolina Board of Architecture and Registered Interior Designers, architectural seals are not required for – and should not be placed by NVR on – these plans and specifications.

NW-COMM-LOT-UNIT			
RLH-YK-0020			
00M-LOT			
SIPILING VILLAGE - 0020			
STREET ADDRESS			
2871 SOUTH BREEZE WAY			
CITY			
FLOUJAY VARINA			
STATE			
NC			
APT. NO.			

ZIP			
27526			

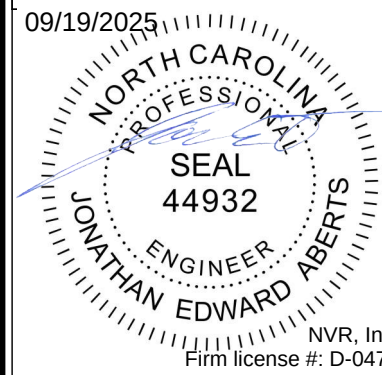

NVR, Inc. expressly reserves its copyright and other property rights in these plans. These plans are not to be reproduced, stored in a retrieval system, or copied in any form or manner whatsoever, nor are they to be used for any purpose other than that first obtaining the expressed written consent of NVR, Inc.

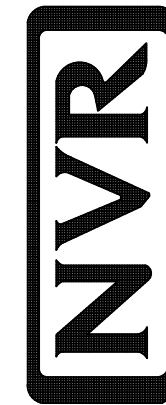


NVR, Inc. Suite 100
5285 Westview Drive
Frederick, MD 21703

SHEET NO. S-3	MODEL GRAND BAHAMA		SET NO. GBH00
	DRAWING TITLE TRUSS BRACING		VERSION 01
	OPTION DESCRIPTION		RELEASE NO. ----
	22		DRAWN BY DATE: OPTION

FASTENING SCHEDULE			
SHEATHING	FASTENER	SPACING	
		EDGES	FIELD
PRESCRIPTIVE 7/16" WOOD STRUCTURAL PANELS OR EQUIVALENT (W METHOD WSP, CS-WSP, CS-G)	8d COMMON NAILS	6" O.C.	6" O.C.
	ALTERNATIVE FASTENER 1-3/4" 16-GAUGE CORROSION RESISTANT STAPLES	3" O.C.	6" O.C.
ENGINEERED 7/16" WOOD STRUCTURAL PANELS (W METHOD ENG-WSP-A, ENG-WSP-B, ENG-WSP-C)	A - 8d COMMON NAILS	4" O.C.	6" O.C.
	A - 1-3/4" 16-GAUGE CORROSION RESISTANT STAPLES	3" O.C.	6" O.C.
	B - 8d COMMON NAILS*	3" O.C.	6" O.C.
	B - 1-3/4" 16-GAUGE CORROSION RESISTANT STAPLES	N/A	6" O.C.
	C - 8d COMMON NAILS* SHEATHING ON BOTH SIDES OF THE WALL	3" O.C.	6" O.C.
	C - 1-3/4" 16-GAUGE CORROSION RESISTANT STAPLES SHEATHING ON BOTH SIDES OF THE WALL	N/A	6" O.C.
1/2" GYPSUM WALLBOARD (W METHOD GB-1, GB-2, ENG-GB1-A)	1-1/4" LONG, 1/4" HEAD, .098" DIA. ANNULAR-RINGED NAILS	7" O.C.	7" O.C.
	CORROSION RESISTANT TYPE W 1-1/4" DRYWALL SCREWS	7" O.C.	7" O.C.
1/2" GYPSUM WALL BOARD BLOCKED AT THE EDGES (W METHOD GB-BW1, GB-BW2, ENG-BW)	BLOCKING REQUIRED AT ALL GYPSUM EDGES. USE CORROSION RESISTANT TYPE W 1-1/4" DRYWALL SCREWS	4" O.C.	12" O.C.
NOTES: 1. MINIMUM 7/16" CROWN WIDTH FOR STAPLES IN WOOD STRUCTURAL PANEL. 2. SPECIFIED GYPSUM FASTENING REQUIRED ONLY WHERE METHOD GB IS IDENTIFIED. SEE PHASE SPECS FOR TYPICAL GYPSUM FASTENER SPACING. 3. USE OF STAPLES IN WOOD STRUCTURAL PANEL AS FASTENING METHOD ON WALLS PER ENGINEERED ALTERNATIVE. * STAPLE ALTERNATIVE FOR USE IN FIELD ONLY 4. WALL PANELS NOT IDENTIFIED AS BRACED WALL PANELS SHALL BE FASTENED IN ACCORDANCE WITH THE WSP/ENG-WSP-A METHOD.			

BRACING LEGEND	
BWL XXX.XX	BRACED WALL LINE I.D.
—	BRACED WALL LINE
—	HOUSE WALL
▨	BRACED WALL PANEL
(X)	ENGINEERING PAGE NUMBER
WSP	WOOD STRUCTURAL PANEL
GB	GYPSUM BOARD (1) SIDED OR (2) SIDED
GB-BW	GYPSUM BOARD BLOCKED WALL CONSTRUCTION (1) SIDED OR (2) SIDED (SEE STANDARD DETAIL 6 /WB-2)
LIB	LET-IN BRACING (SEE STANDARD DETAIL F /WB-2)
CS-WSP	CONTINUOUS SHEATHING - WOOD STRUCTURAL PANEL
CS-PF	CONTINUOUS SHEATHING - PORTAL FRAME, SEE FLOOR PLANS FOR PORTAL FRAME HEADER INFORMATION (SEE STANDARD DETAIL A, C /WB-2)
CS-G	CONTINUOUS SHEATHING - WOOD STRUCTURAL PANEL ADJACENT TO GARAGE OPENINGS
ENG-WSP-A	ENGINEERED DESIGN W/ WALL STRUCTURAL PANEL SHEATHING TYPE 'A' FASTENING REQUIREMENTS (NO HOLD DOWNS REQUIRED UNLESS NOTED)
ENG-WSP-B	ENGINEERED DESIGN W/ WALL STRUCTURAL PANEL SHEATHING TYPE 'B' FASTENING REQUIREMENTS (NO HOLD DOWNS REQUIRED UNLESS NOTED)
ENG-WSP-C	ENGINEERED DESIGN W/ WALL STRUCTURAL PANEL SHEATHING ON BOTH SIDES OF THE WALL TYPE 'C' FASTENING REQUIREMENTS (NO HOLD DOWNS REQUIRED UNLESS NOTED)
ENG-PF	ENGINEERED DESIGN W/ PORTAL FRAME, SEE FLOOR PLANS FOR PORTAL FRAME HEADER INFORMATION (SEE STANDARD DETAIL PAGE WB-1)
ENG-GB1-A	ENGINEERED DESIGN W/ (1) SIDED GYPSUM BOARD TYPE 'A' FASTENING REQUIREMENTS
ENG-GB1-B	ENGINEERED DESIGN W/ (1) SIDED GYPSUM BOARD TYPE 'B' FASTENING REQUIREMENTS
ENG-BW	ENGINEERED DESIGN W/ (1) SIDED GYPSUM BOARD W/ BLOCK WALL CONSTRUCTION (SEE STANDARD DETAIL 17/WB-1)
HD	HOLD-DOWN: 1. SEE SHEET WB-2 FOR "P-" INDICATOR SCHEDULE AND DETAILS 2. SEE SHEET WB-4 FOR "L-" INDICATOR SCHEDULE AND DETAILS 3. ARROW INDICATES LOCATION.
NOTES: HOUSE HAS BEEN ANALYZED UTILIZING A PRESCRIPTIVE METHOD IN COMPLIANCE WITH INTERNATIONAL RESIDENTIAL CODES (IRC) UNLESS OTHERWISE NOTED. ENGINEERED WALL LINES ARE IN COMPLIANCE WITH INTERNATIONAL BUILDING CODES (IBC).	


BRACED WALL LINE SCHEDULE				
WIND SPEED (ULT)	IDENTIFIER	REQUIRED (FT)	ACTUAL (FT)	METHOD
130 MPH	BWL 100.00	3.81'	6.00'	CONTINUOUS (WITH GNB)
130 MPH	BWL 101.00	8.38'	38.00'	WSP (WITH GNB)
130 MPH	BWL 102.00	11.75'	16.46'	CONTINUOUS (WITH GNB)
130 MPH	BWL 103.00	4.70'	34.00'	WSP (WITH GNB)
130 MPH	BWL 104.00	7.38'	6.00'	ENGINEERED
130 MPH	BWL 105.00	5.40'	13.00'	WSP (WITH GNB)
130 MPH	BWL 106.00	6.21'	8.16'	CONTINUOUS (WITH GNB)
130 MPH	BWL 107.00	2.33'	4.00'	WSP (WITH GNB)

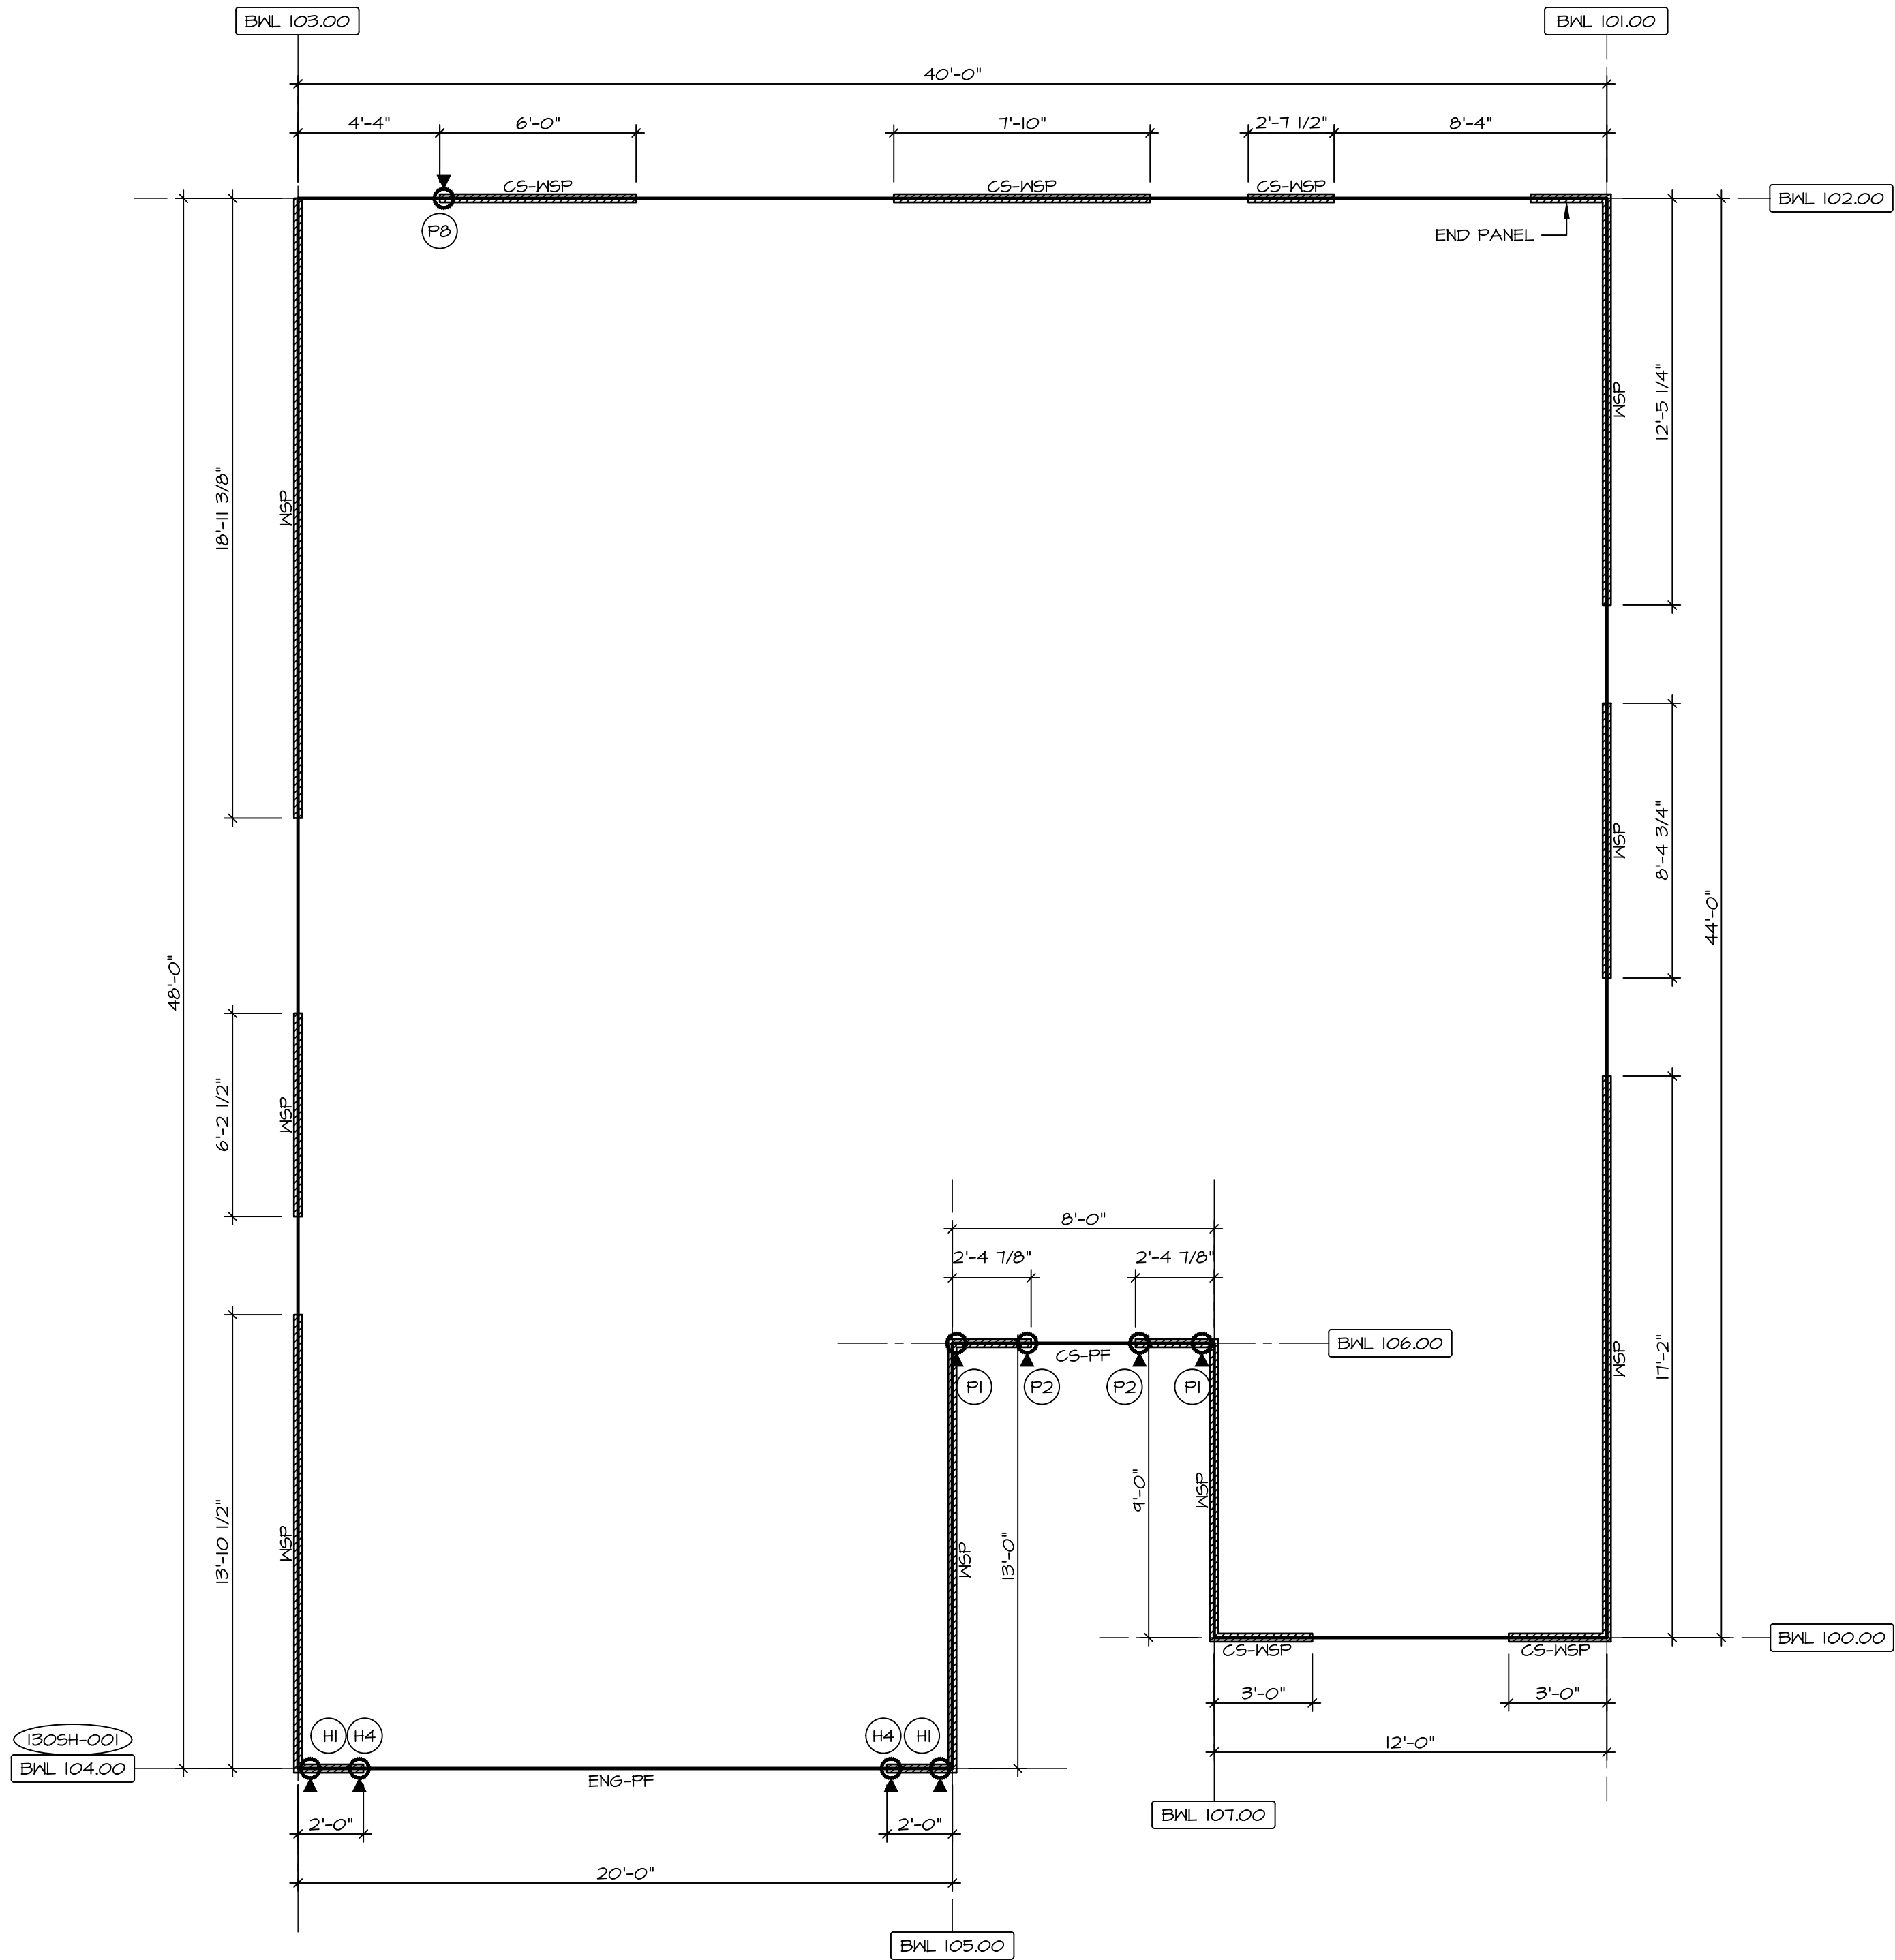


1
S-4
FIRST FLOOR BRACED WALL DETAIL
SCALE: 1/8" = 1'-0"

As directed by the North Carolina Board of Architecture and Registered Interior Designers, architectural seals are not required for – and should not be placed by NVR on – these plans and specifications.


NW-COMM-LOT-UNIT		RLH-YK-0020	
0MM-LOT		SIPLING VILLAGE - 0020	
STREET ADDRESS		APT. NO. ----	
281 SOUTH BREEZE WAY		ZIP 27526	
CITY		STATE NC	
FLOJAY VARIANA			

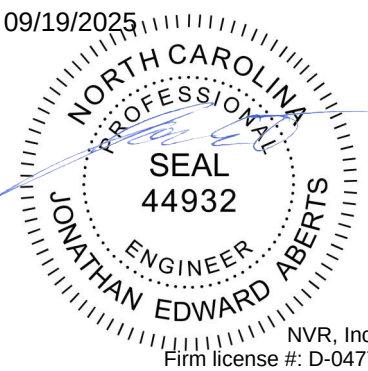

NVR, Inc., expressly reserves its copyright and other property rights in these plans. These plans are not to be reproduced, stored in a retrieval system, or copied in any form or manner whatsoever, nor are they to be used for any purpose other than that first obtaining the express written consent of NVR, Inc.

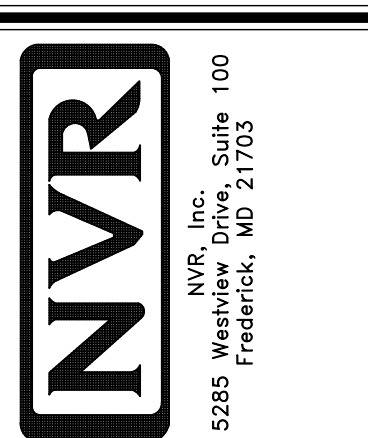

MODEL GRAND BAHAMA	SET NO. GBH00	VERSION 01	RELEASE NO. ----
	DRAWN BY	DATE:	OPTION
DRAWING TITLE WALL BRACING	OPTION DESCRIPTION		
SHEET NO. S-4	23		

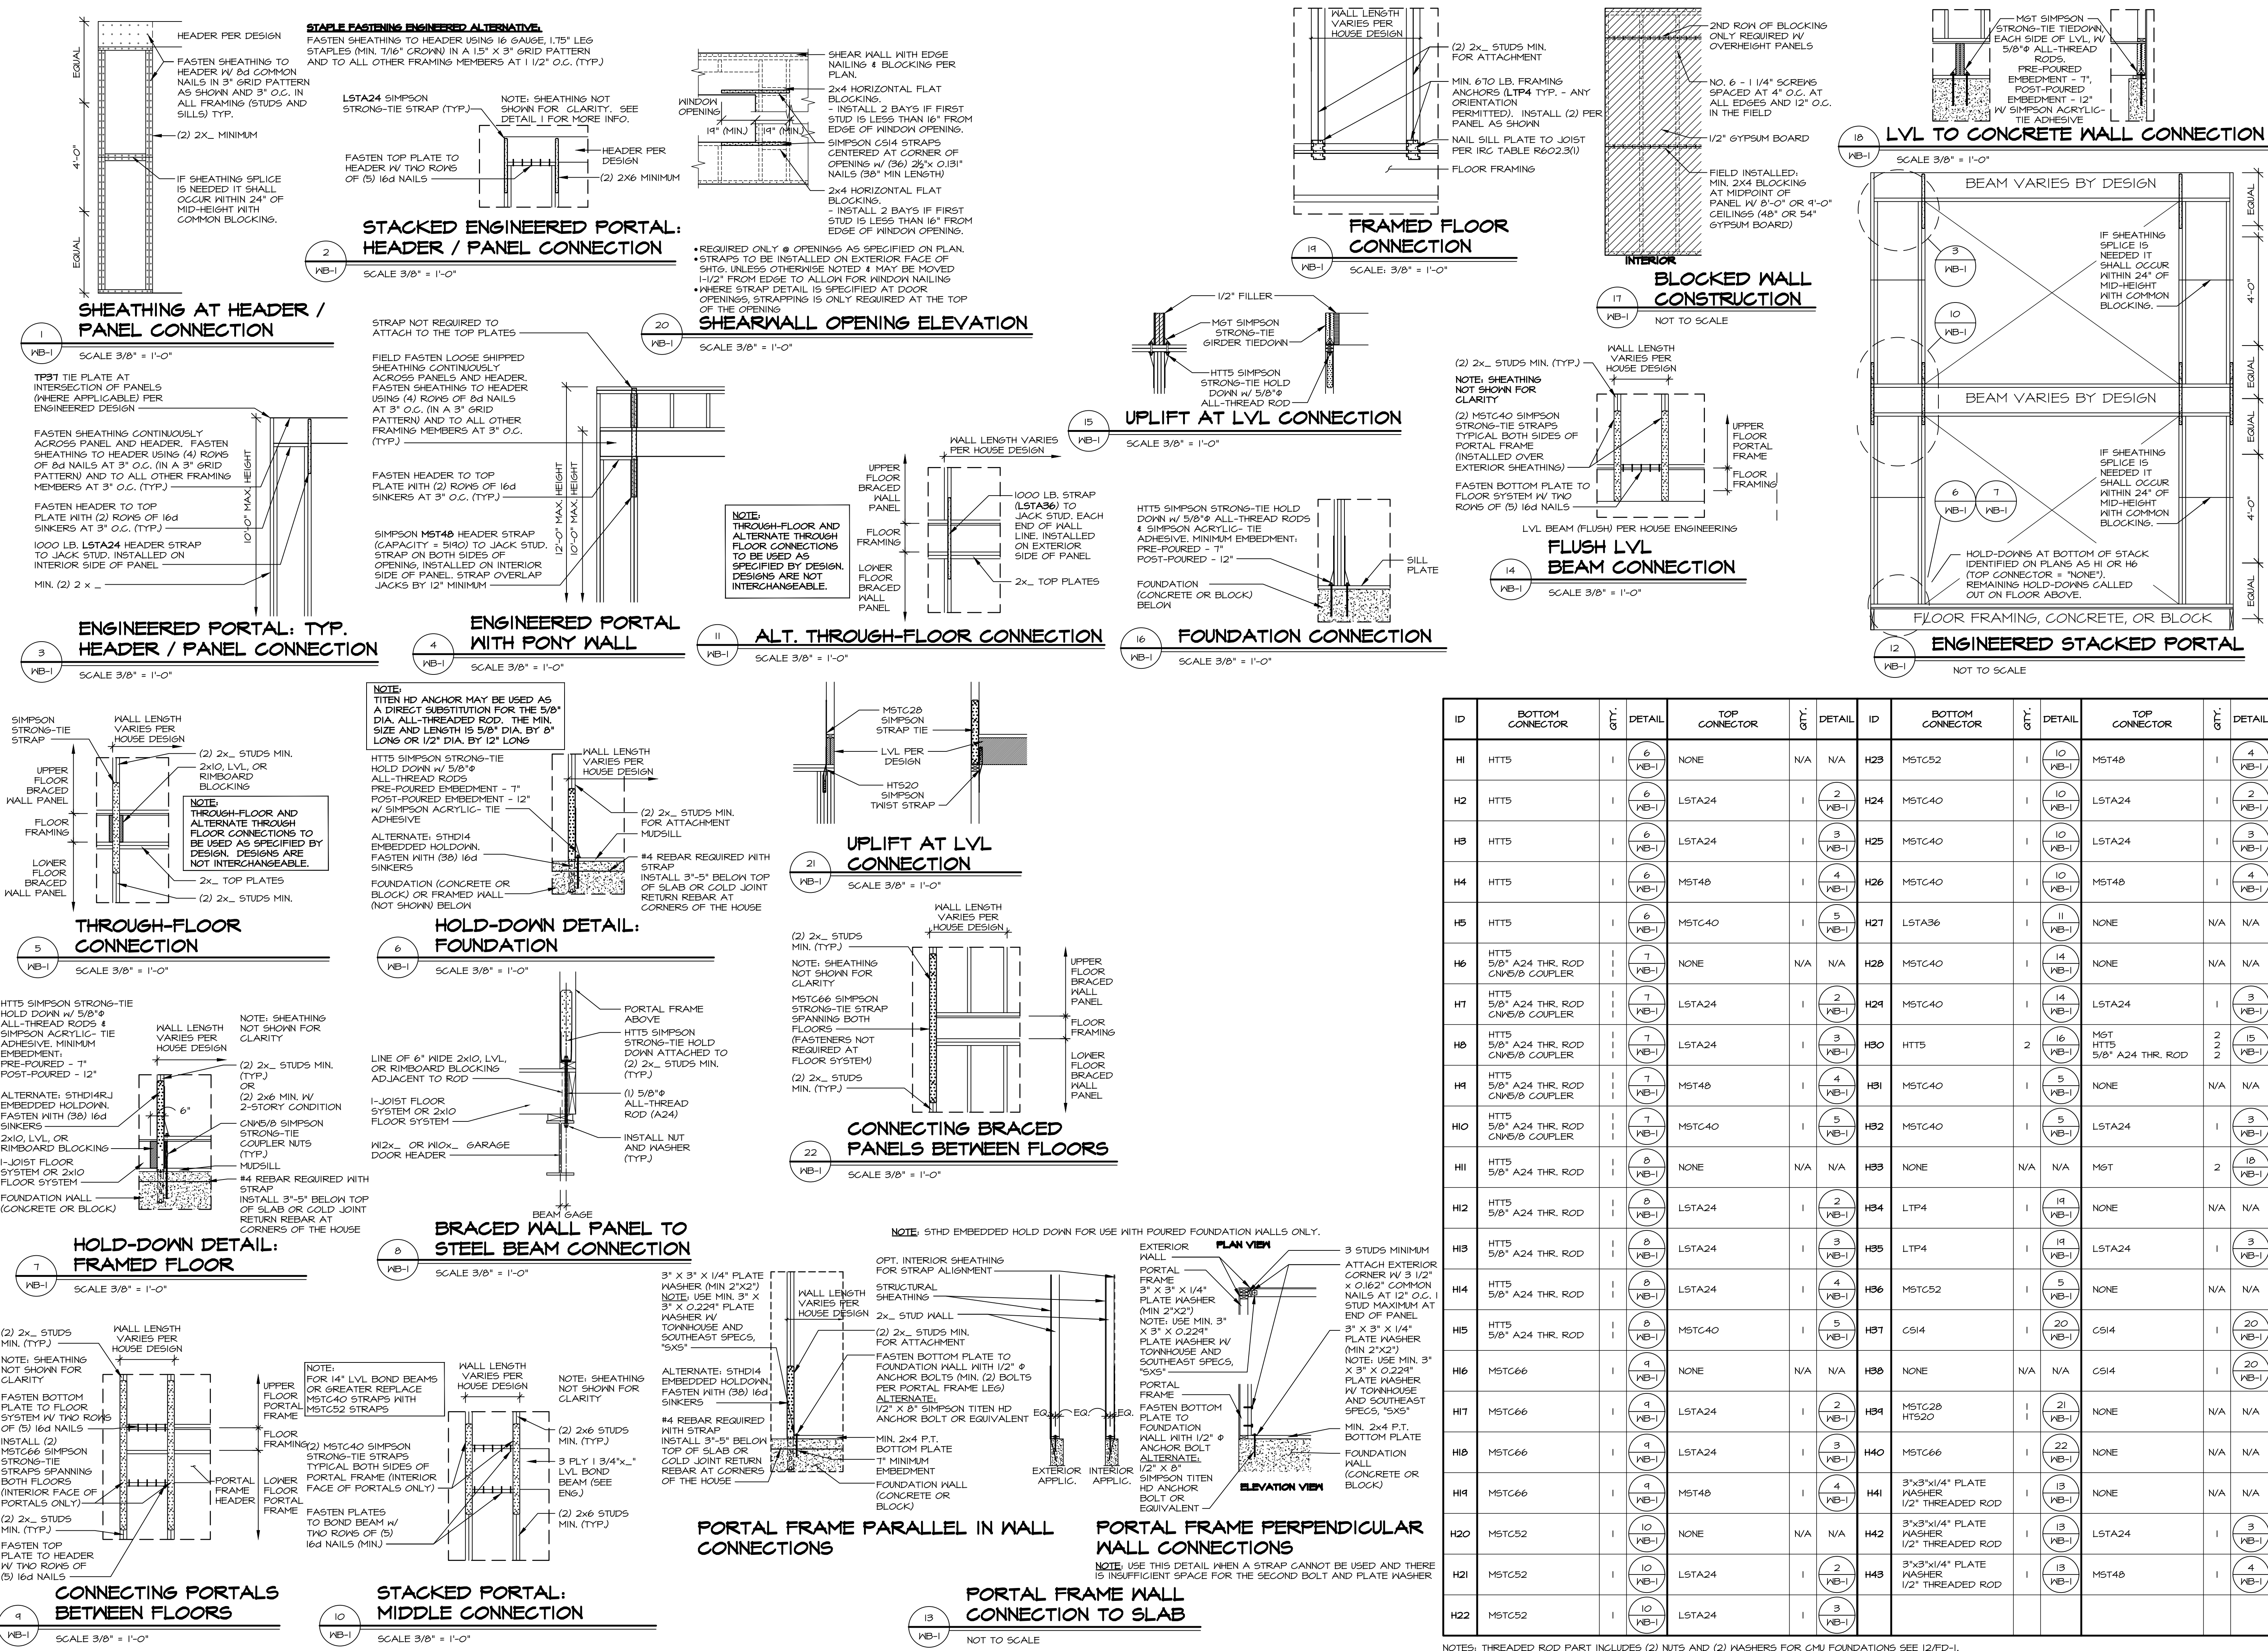

NOTES: THREADED ROD PART INCLUDES (2) NUTS AND (2) WASHERS FOR CMU FOUNDATIONS SEE 12/FD-1.

As directed by the North Carolina Board of Architecture and Registered Interior Designers, architectural seals are not required – and should not be placed by NVR on these plans and specifications.

REV.	NO.	DATE	REMARKS
18	18	2/6/22	NE - REVISED DETAIL 5/WB-1, ADDED H66
19	19	2/6/22	ADN - (CG) H74G9) REVISED DETAILS UTILIZING STUDS TO INCLUDE REBAR
20	20	2/6/22	ADN - (CG) H74G9) REVISED DETAILS UTILIZING STUDS TO INCLUDE REBAR
21	21	4/6/23	CEL - REVISED DETAIL 21, H51
22	22	4/6/23	DLR - REVISED DETAIL 21, H51
23	23	4/6/23	DLR - REVISED DETAIL 21, H51
24	24	11/2/24	DLR - REVISED DETAIL 22, H40
25	25	11/2/24	DLR - REVISED DETAIL 22, H40
26	26	5/4/25	ASB - DETAIL 13 AND HOLD DOWN TAG 141, 142, 143 (ARC-20440 - PH-55446)
19	19	11/2/25	CEL - REVISED DETAIL 2/WB-1 TO REFERENCE 9/WB-1

09/19/2025

NORTH CAROLINA PROFESSIONAL SEAL
44932
NVR, Inc.
Firm license #: D-0477

The owner, NVR, Inc., expressly reserves its copyright and other property rights in this drawing and all information contained herein. No part of this drawing may be reproduced, stored in a retrieval system, or transmitted in any form or by any means, electronic, mechanical, photocopying, recording, or by any information storage and retrieval system, without the prior written consent of NVR, Inc.



NVR
NVR, Inc.
5285 Westview Drive, Suite 100
Frederick, MD 21703

SET NO.	VERSION	DRAWN BY	DATE	OPTION
1	1	KFT	2/16/12	

WALL BRACING DETAILS
ENGINEERED WALL BRACING DESIGN
















WB-1

SHEET NO. PROJECT DETAILS: NVR - Wall Bracing WB-1 - BRACED WALL - ENG.dwg 08/15/25 - 3:01 PM

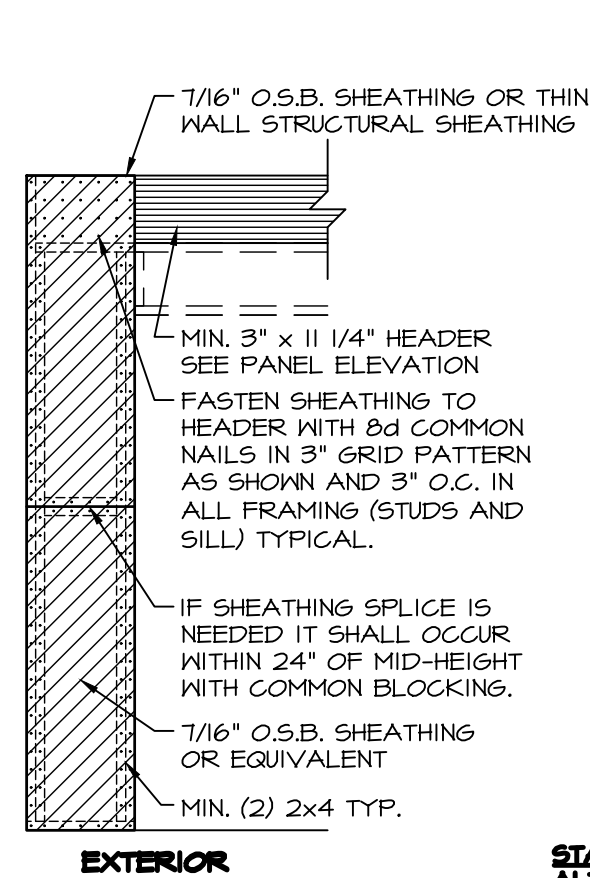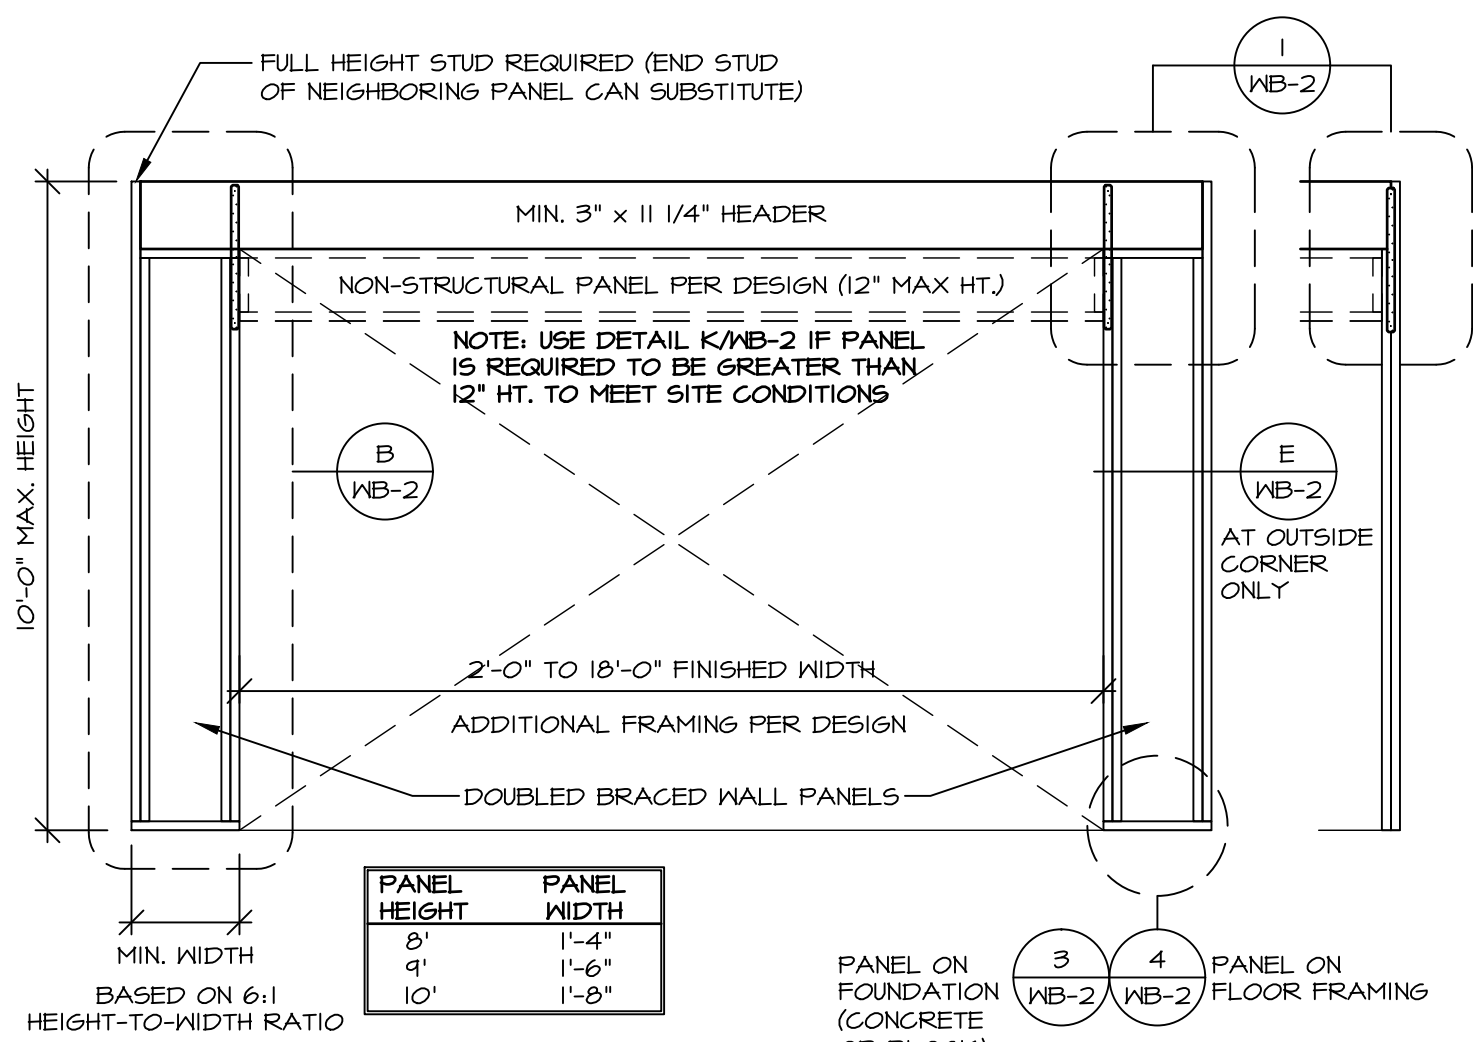

STAPLE FASTENER ENGINEERED ALTERNATIVE FOR OSB.

FASTEN SHEATHING TO HEADER USING 16 GAUGE, 1 3/4" LEG STAPLES (MIN. 15/16" CROWN) IN A 3" x 1 1/2" GRID PATTERN AND TO ALL OTHER FRAMING MEMBERS AT 1 1/2" O.C. (TYP.)

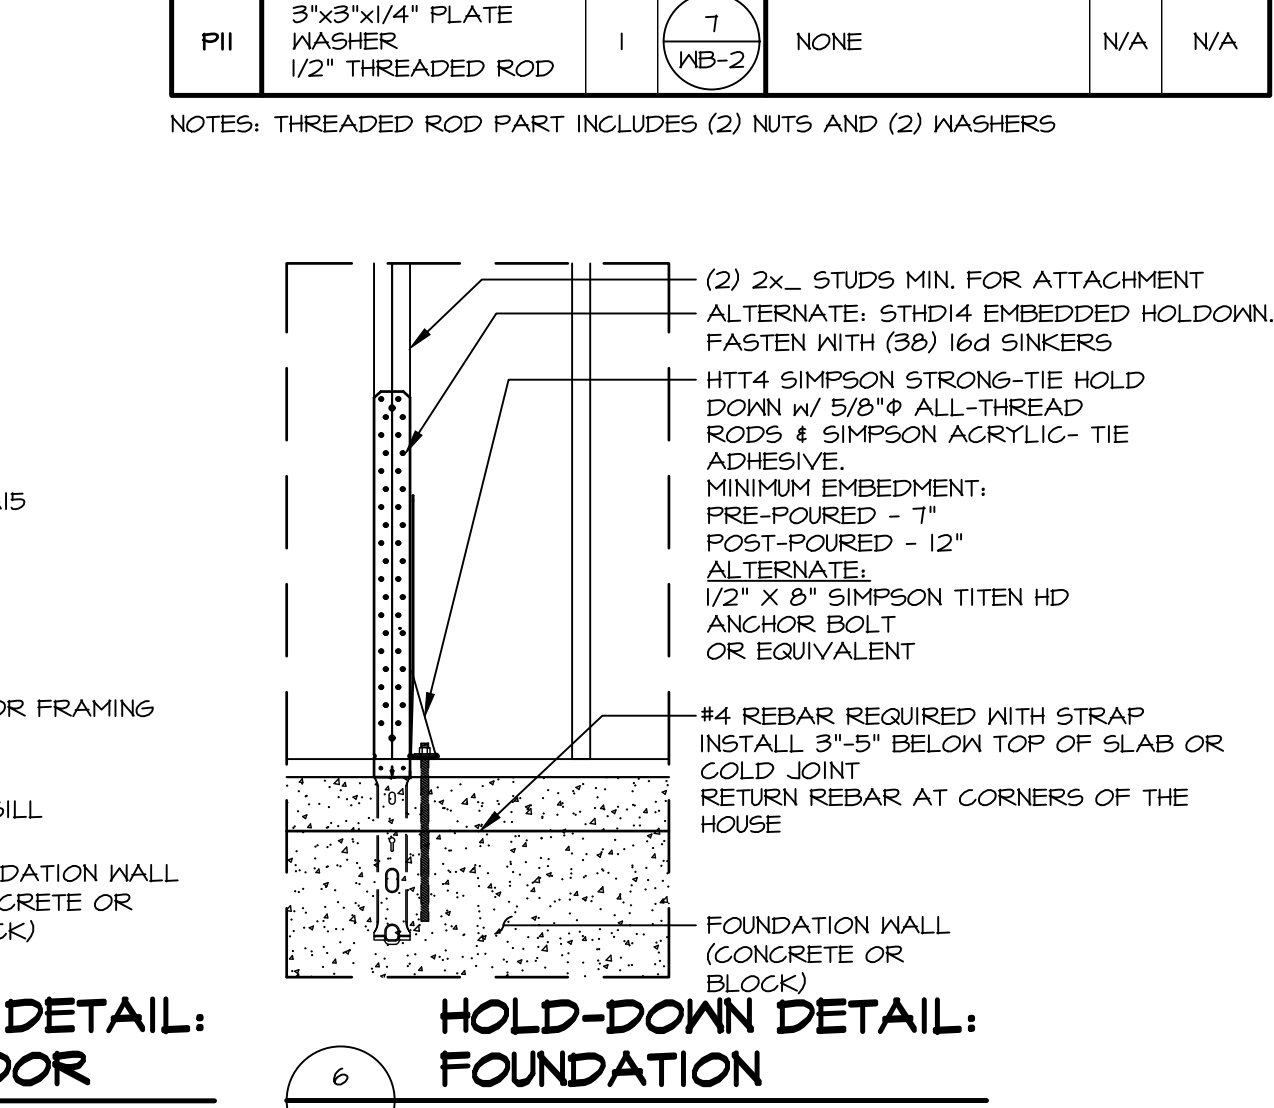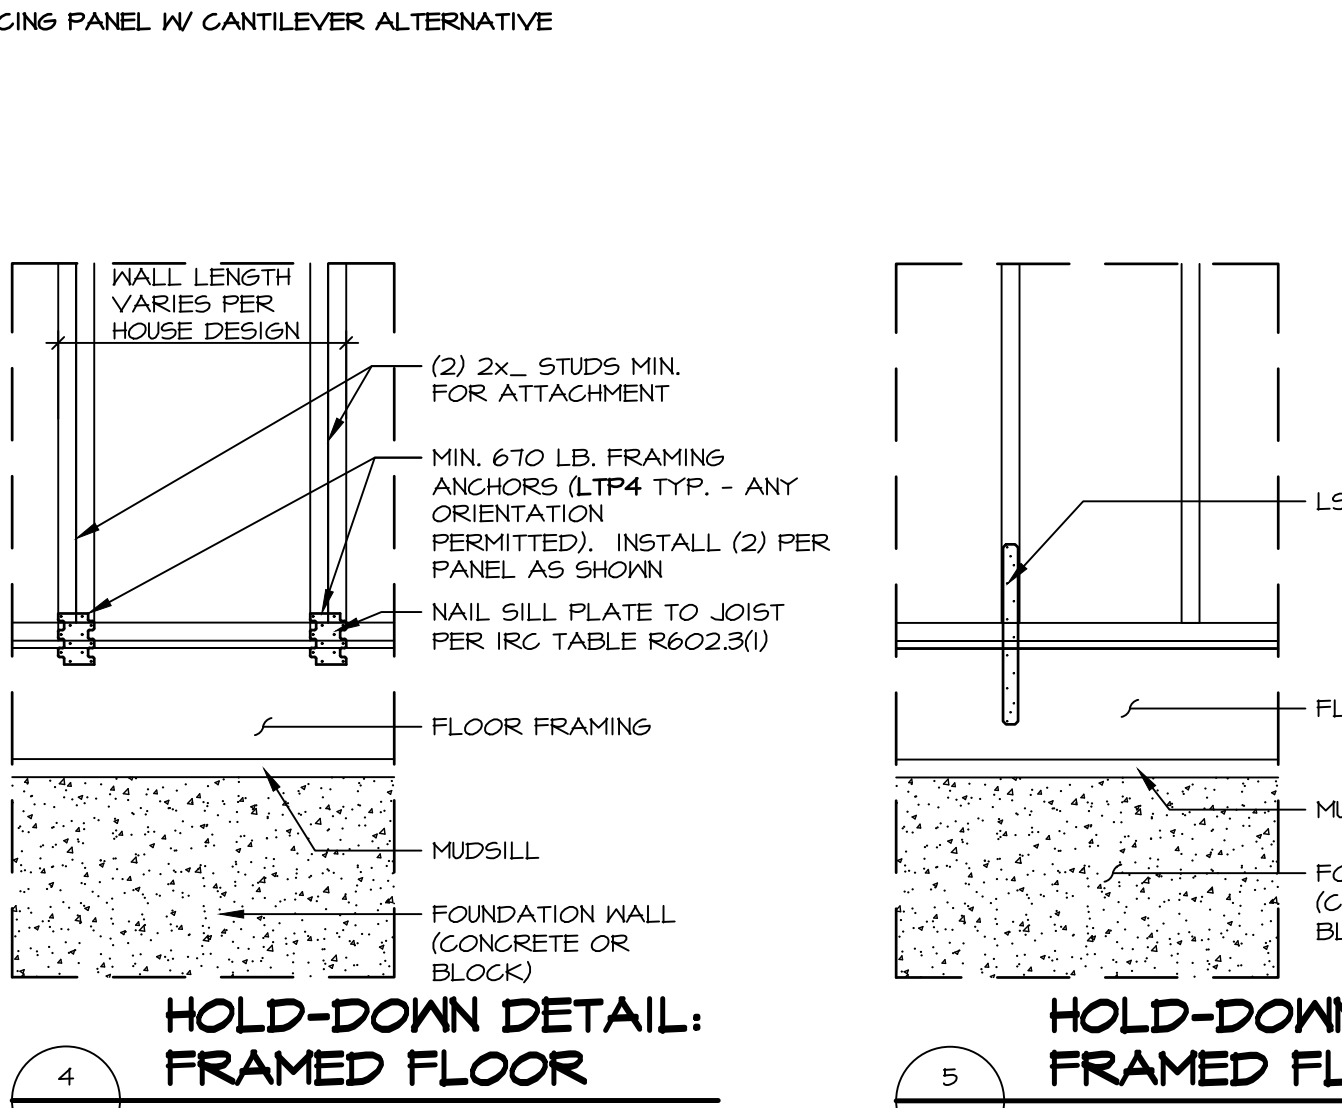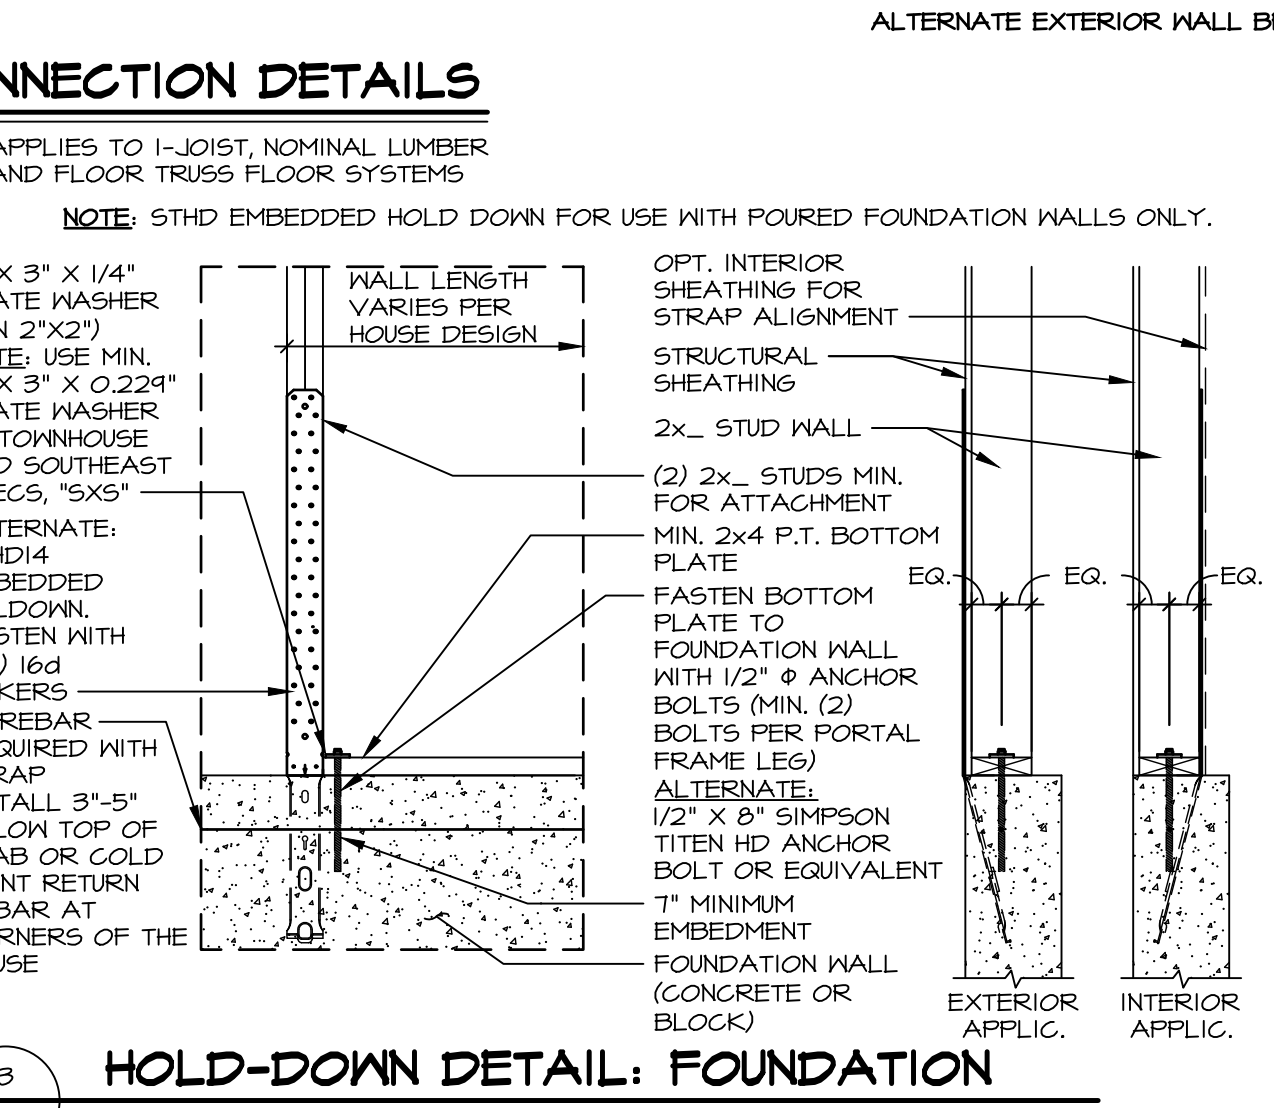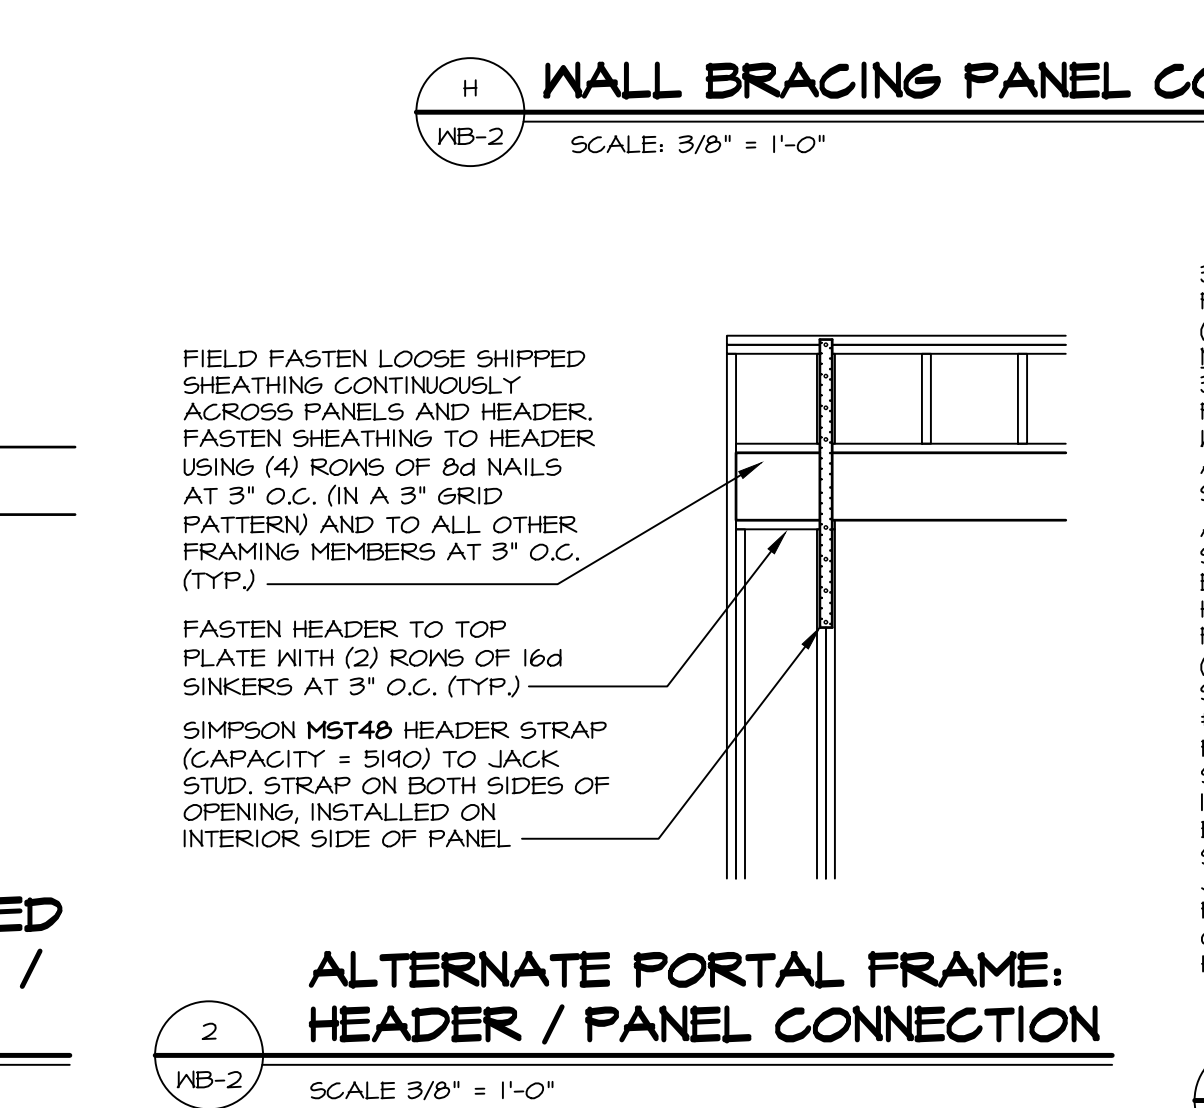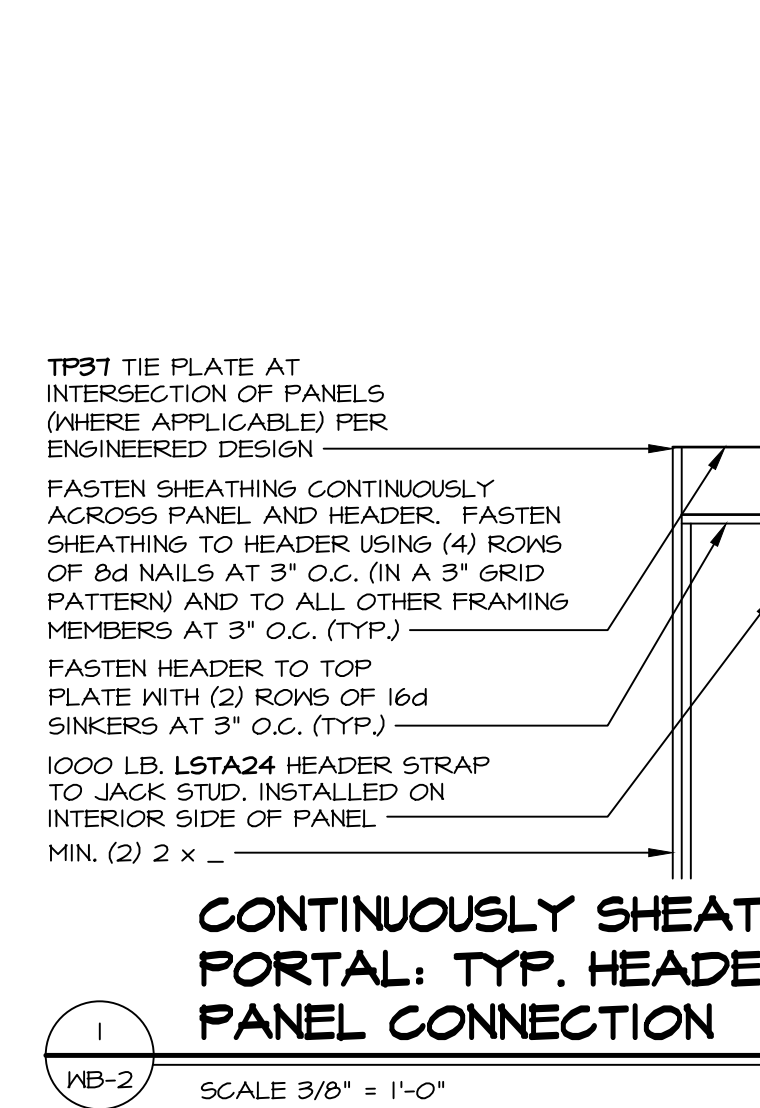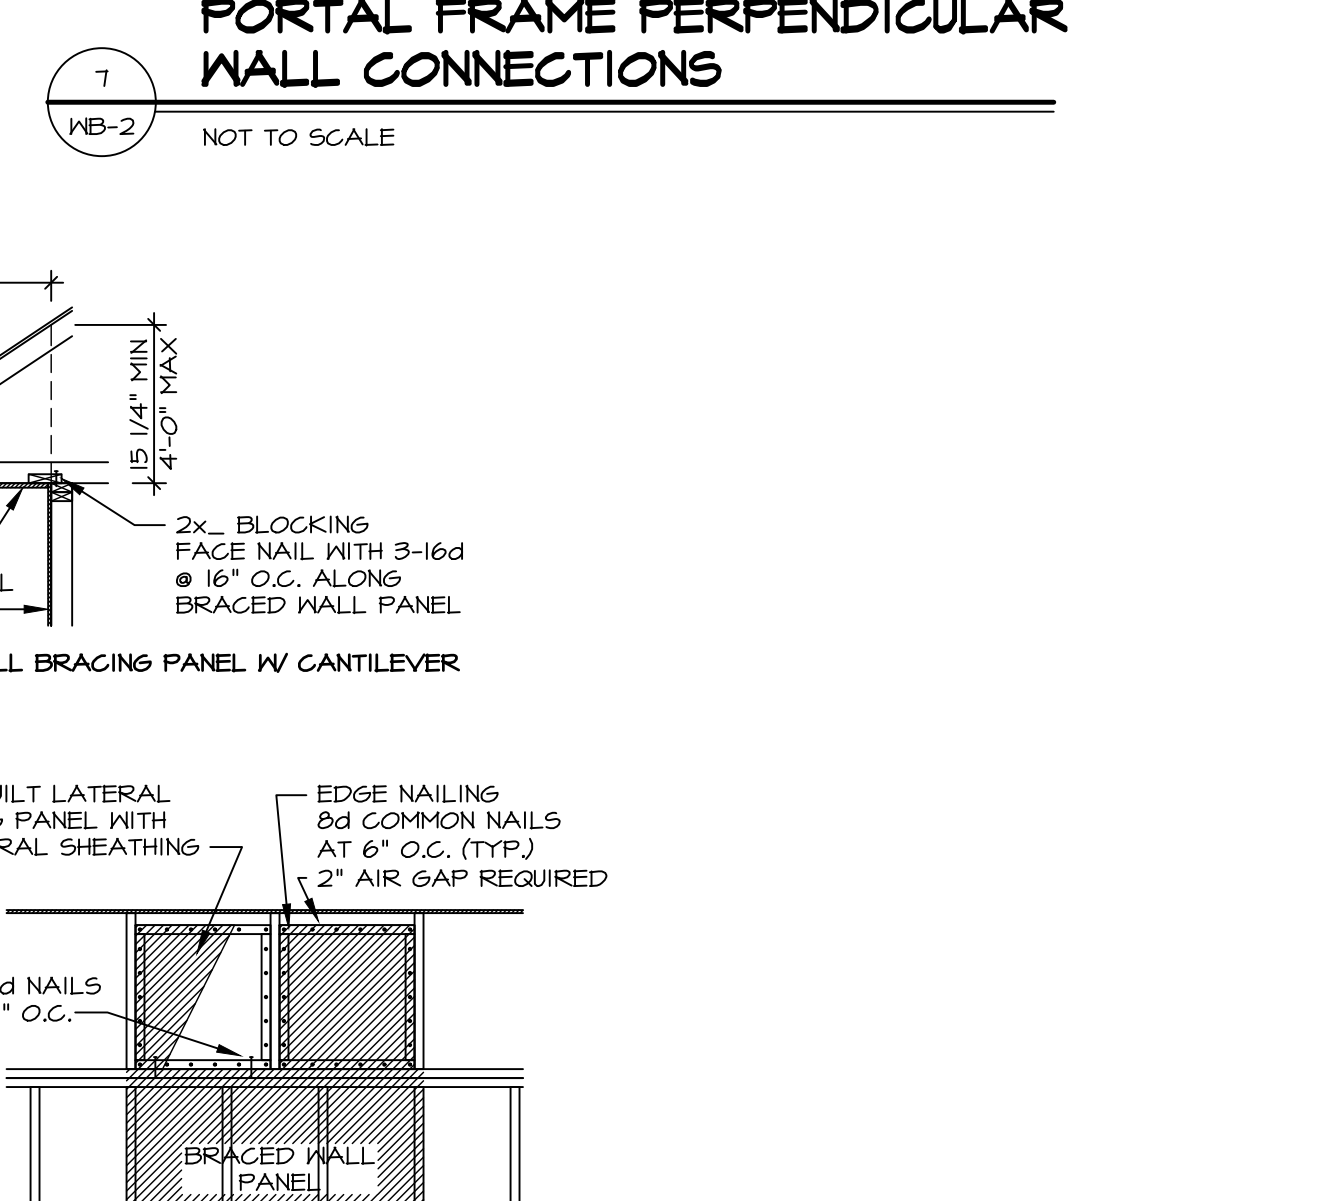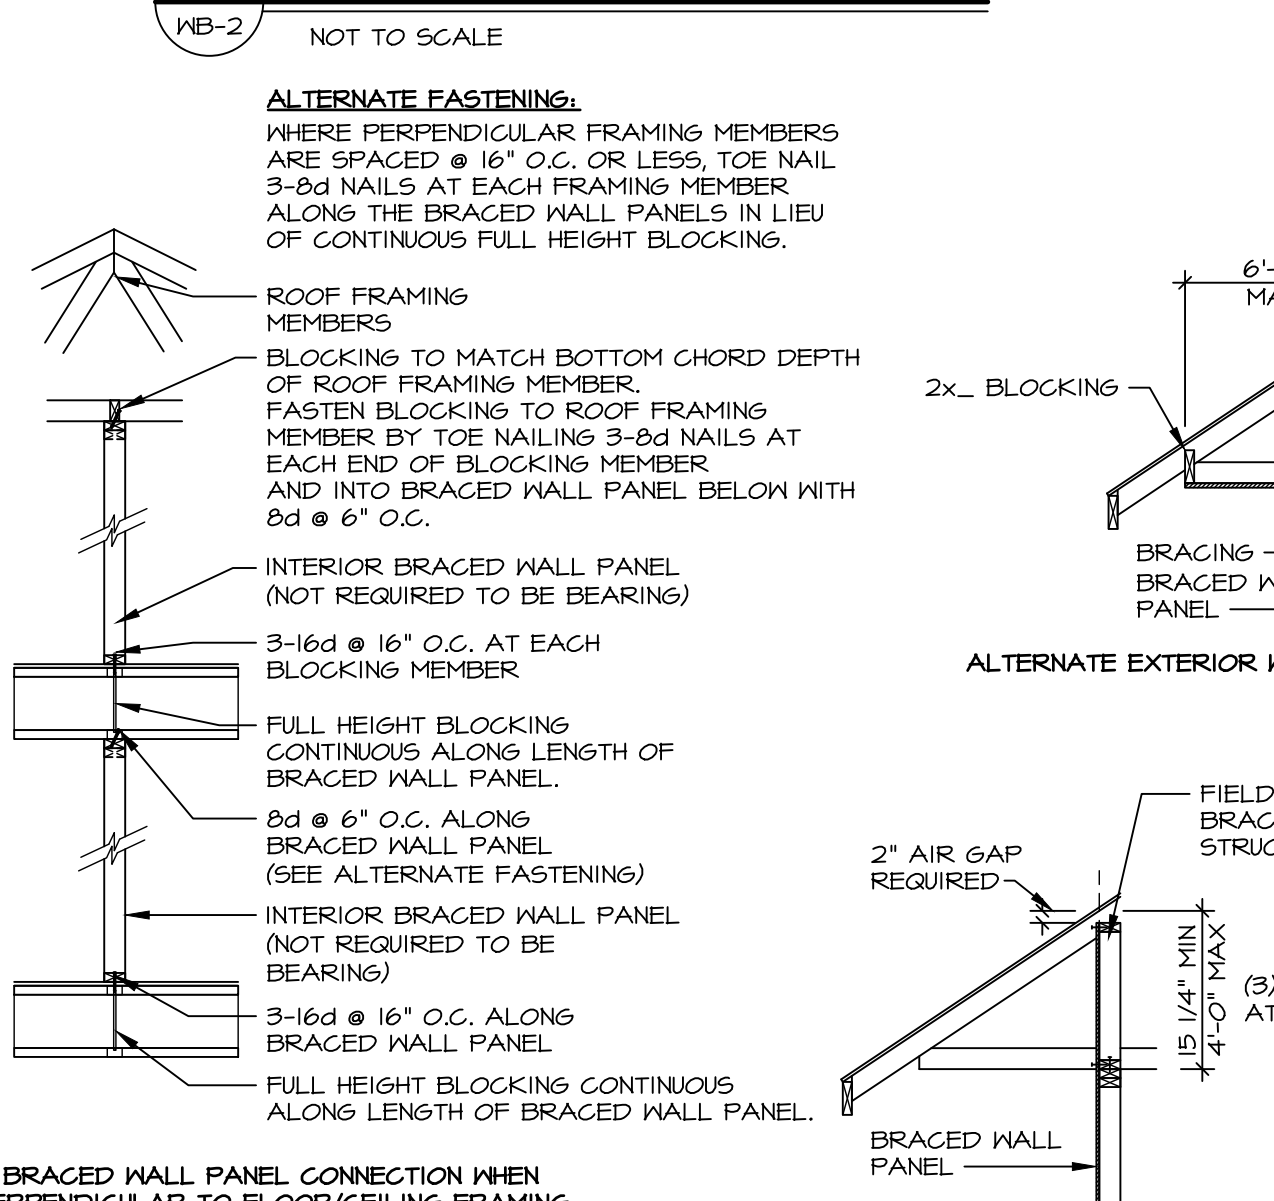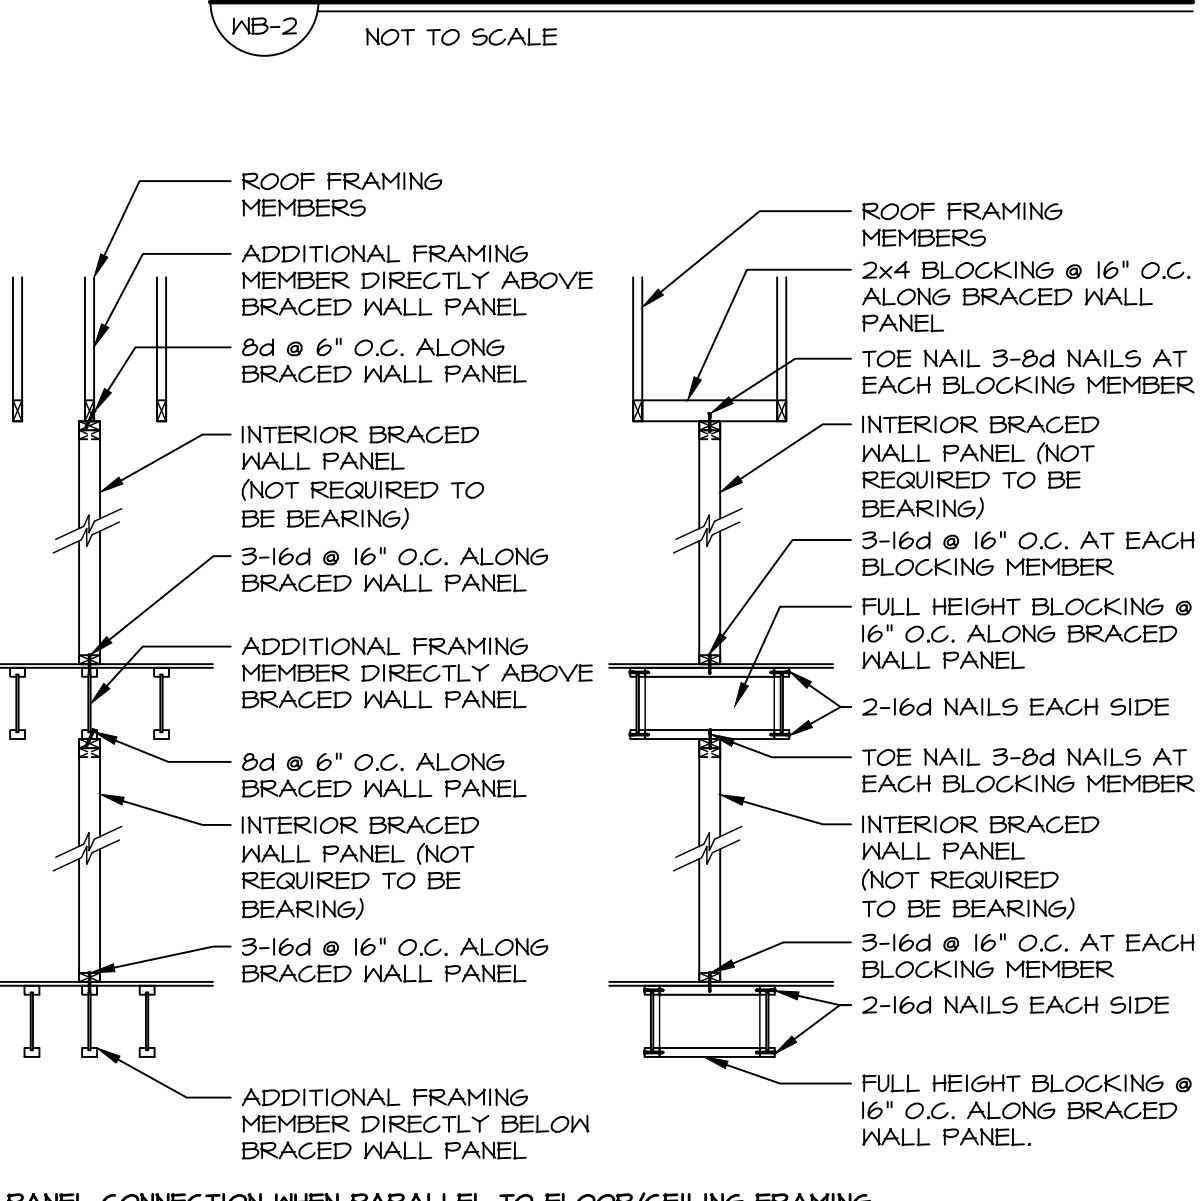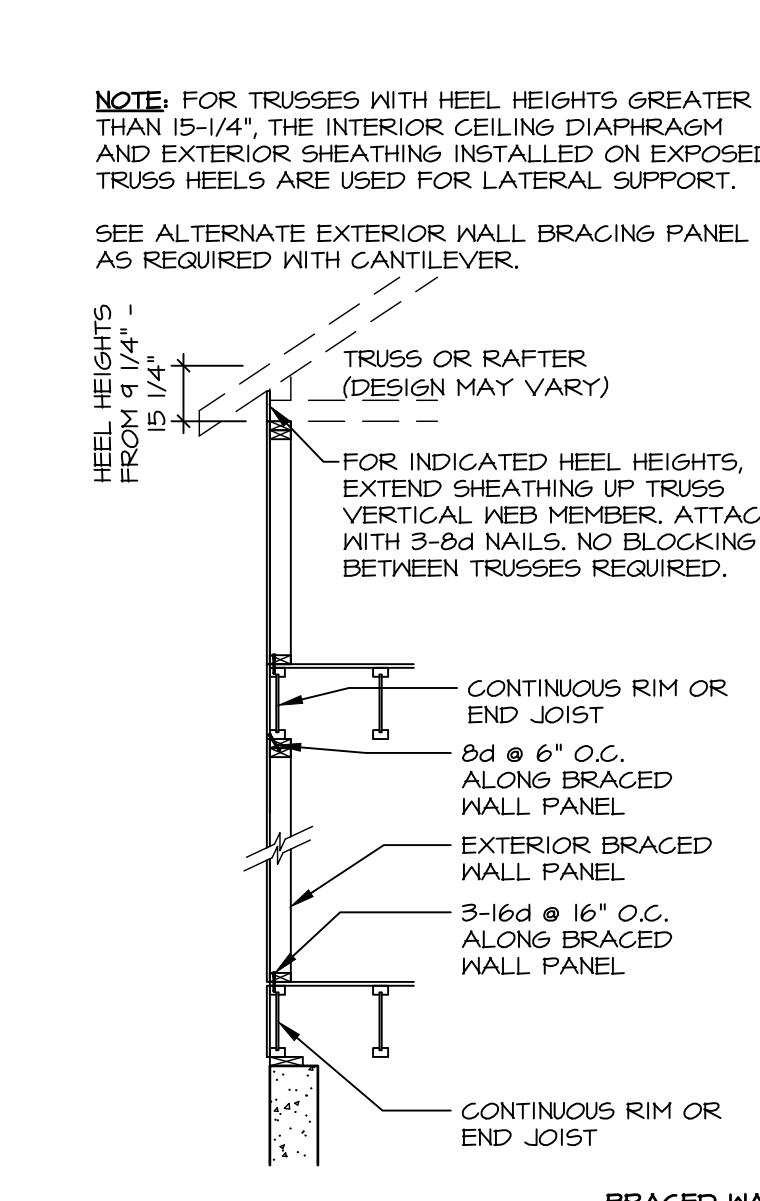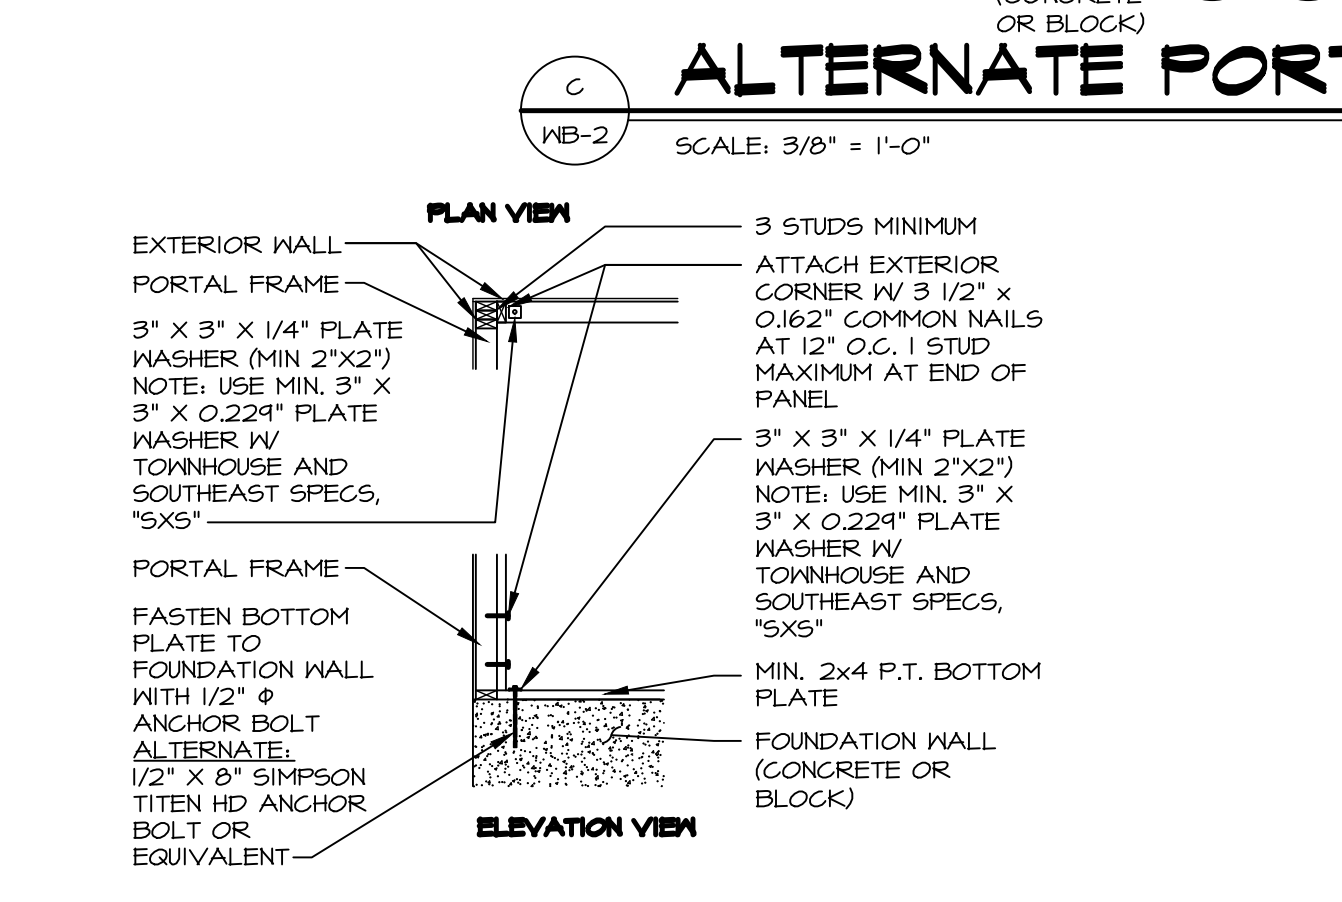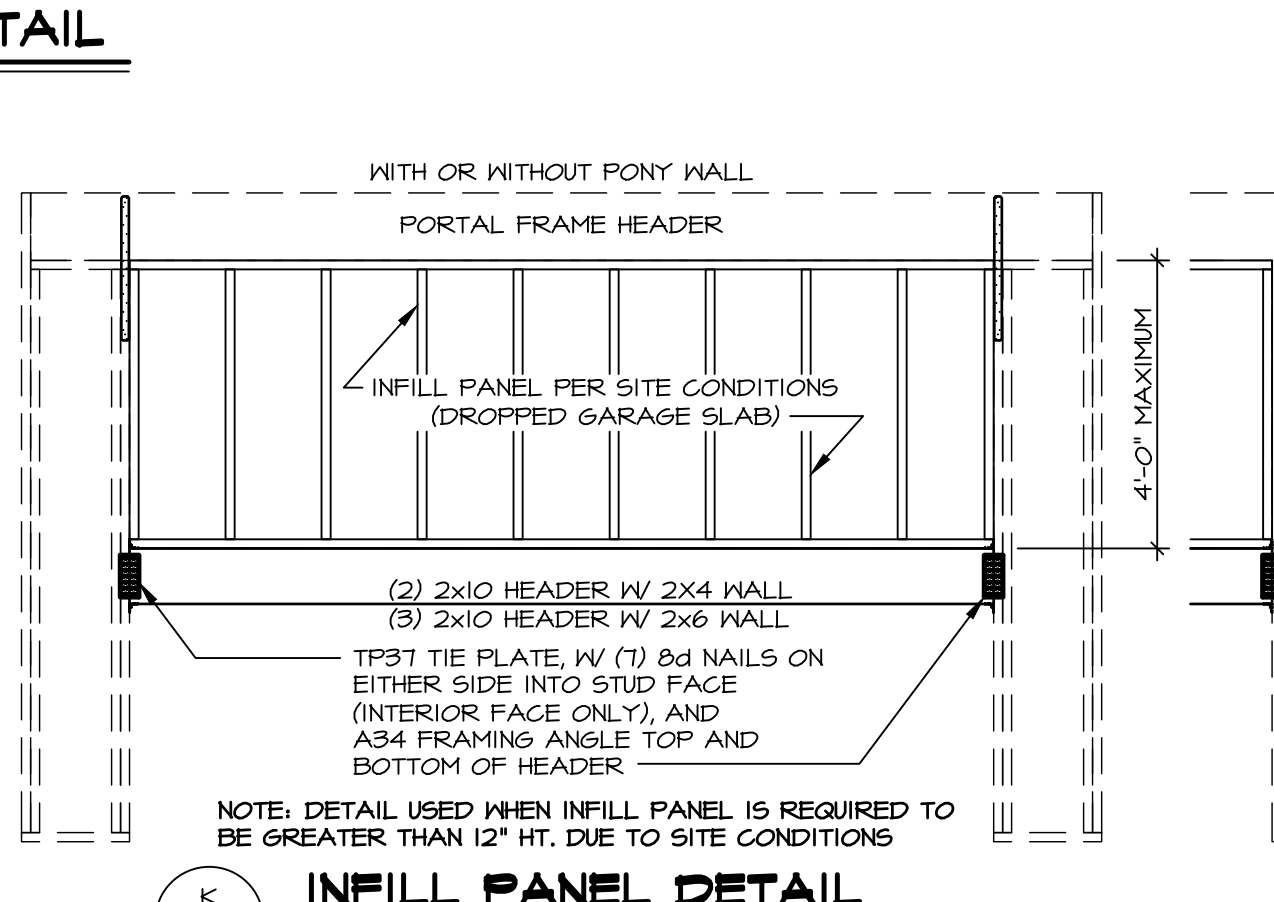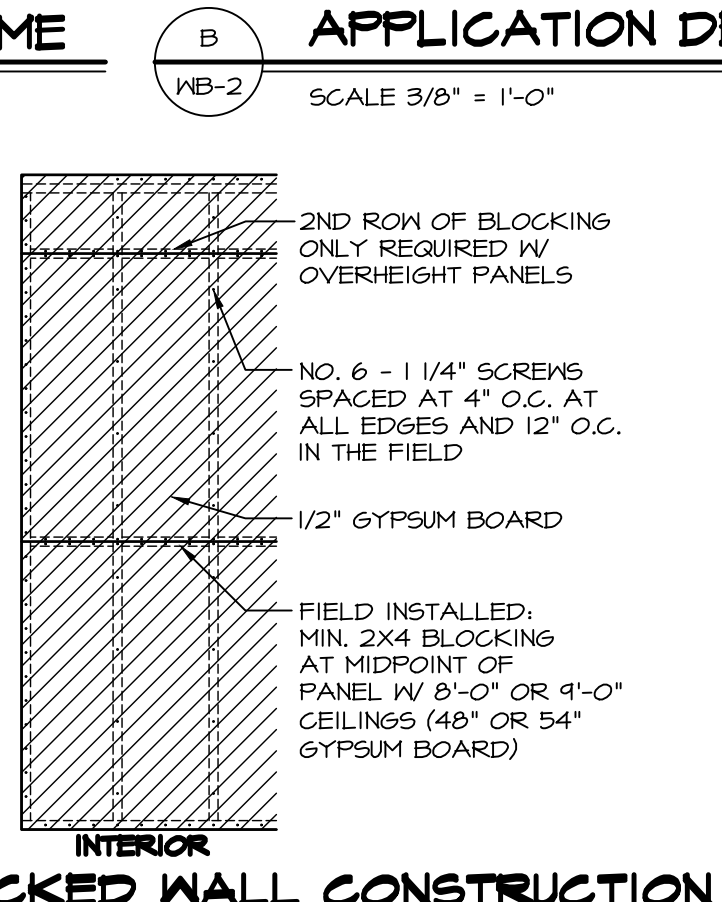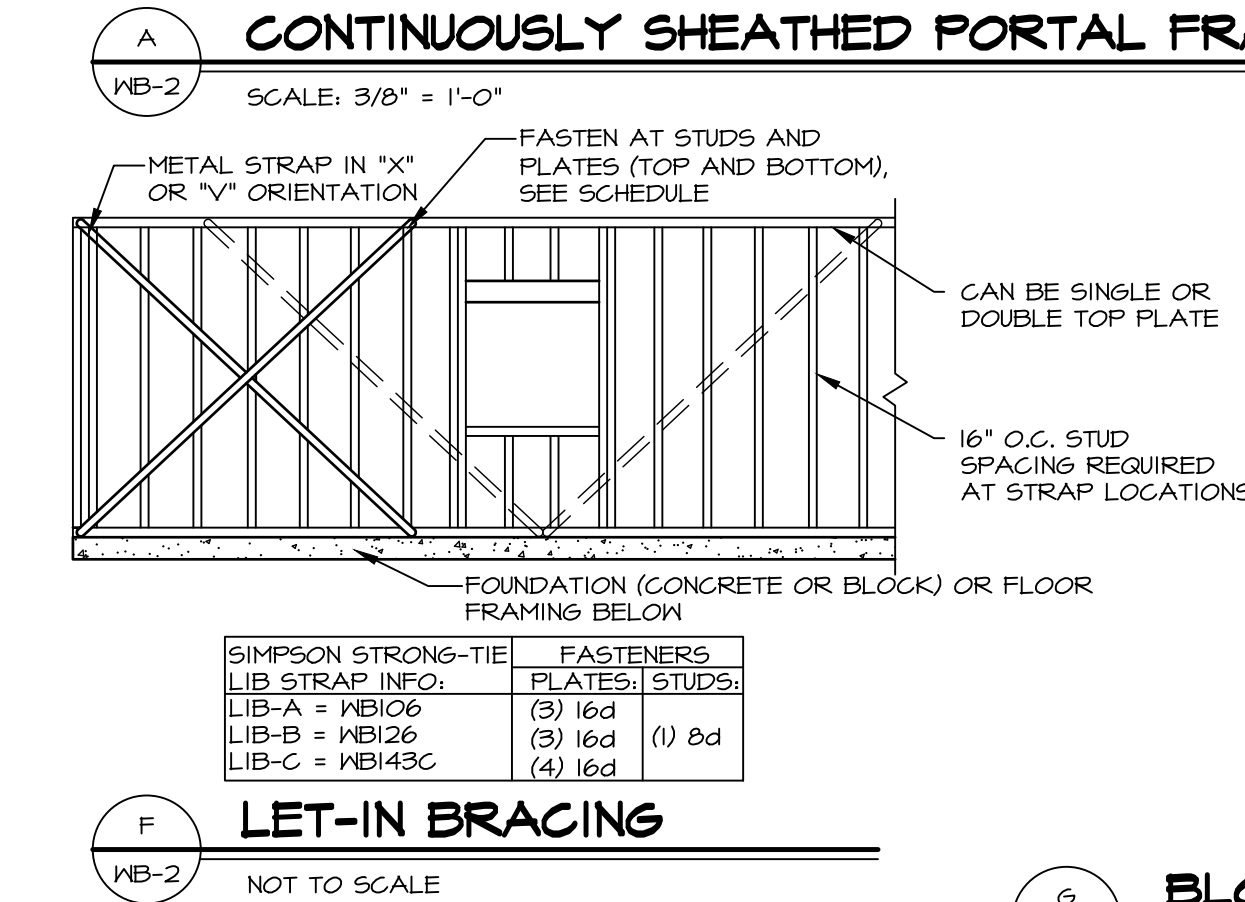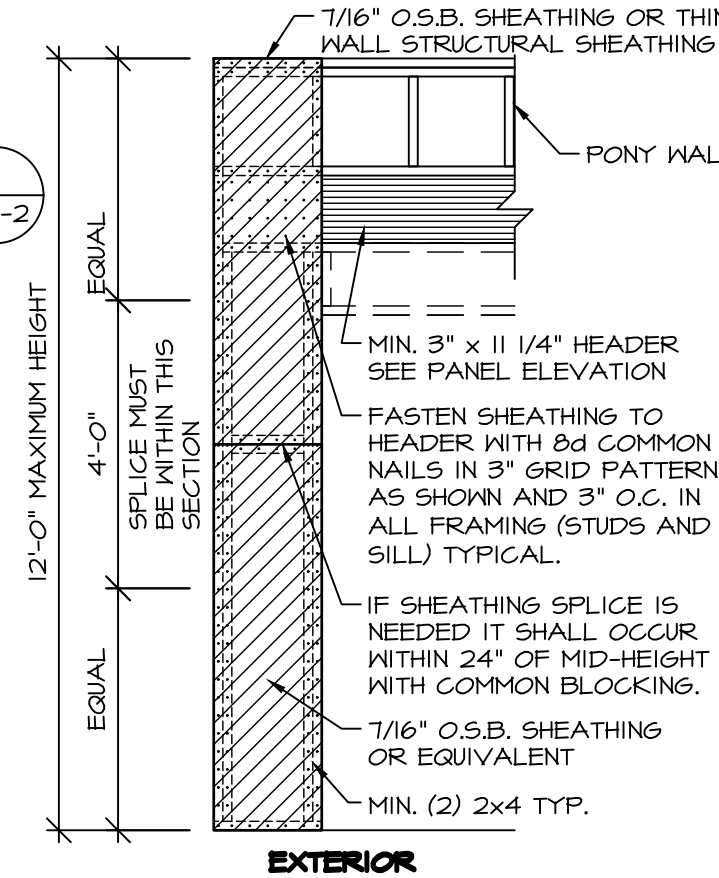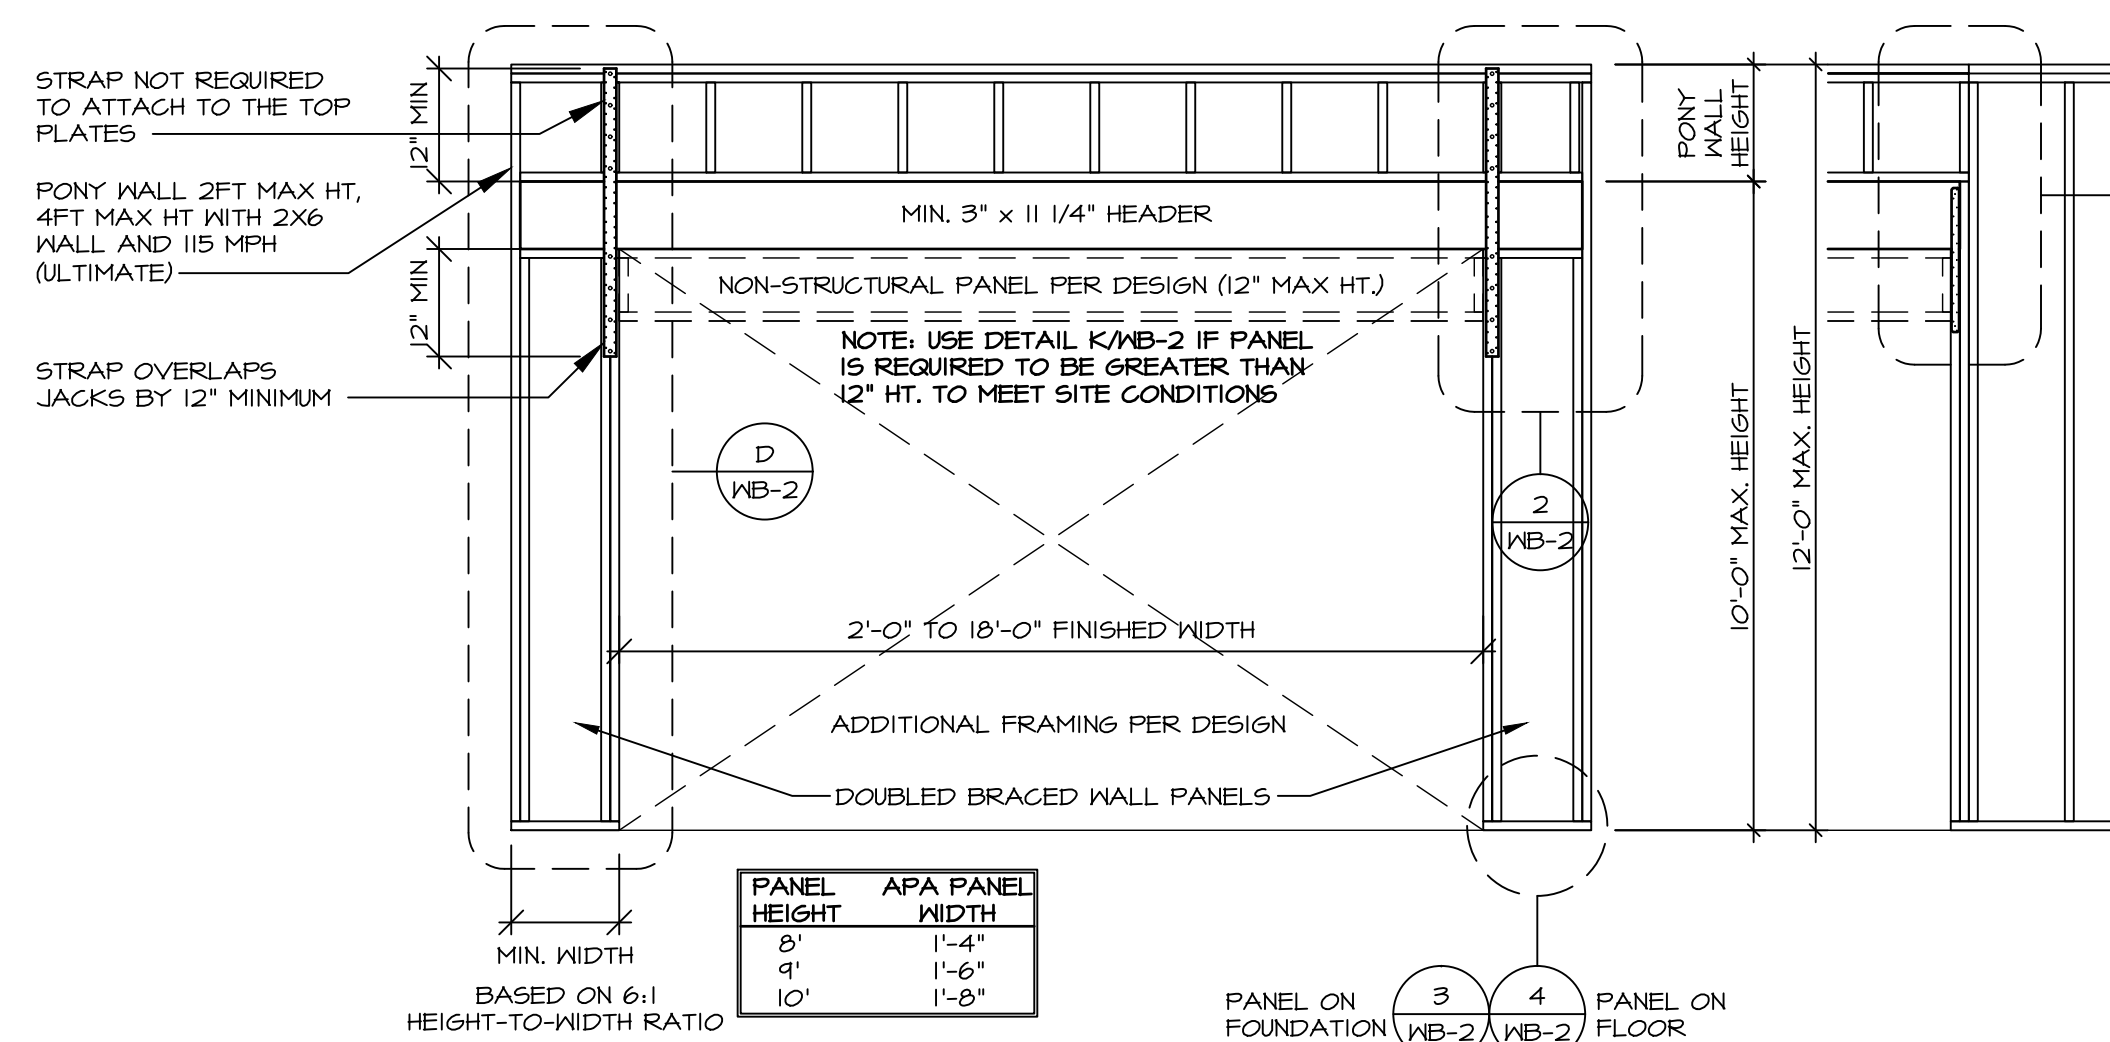

ID	BOTTOM CONNECTOR	DETAIL	TOP CONNECTOR	DETAIL
P1	3"x3"x1/4" PLATE WASHER 1/2" THREADED ROD	(3) MB-2	NONE	N/A
P2	3"x3"x1/4" PLATE WASHER 1/2" THREADED ROD	(3) MB-2	LSTA24	(1) MB-2
P3	3"x3"x1/4" PLATE WASHER 1/2" THREADED ROD	(3) MB-2	MST48	(2) MB-2
P4	LTP4	(4) MB-2	NONE	N/A
P5	LTP4	(4) MB-2	LSTA24	(1) MB-2
P6	LTP4	(4) MB-2	MST48	(2) MB-2
P7	LSTA15	(5) MB-2	NONE	N/A
P8	HTT4 5/8" A24 THR. ROD	(6) MB-2	NONE	N/A
P9	NONE	N/A	LSTA24	(1) MB-2
P10	NONE	N/A	MST48	(2) MB-2
P11	3"x3"x1/4" PLATE WASHER 1/2" THREADED ROD	(7) MB-2	NONE	N/A

NOTES: THREADED ROD PART INCLUDES (2) NUTS AND (2) WASHERS

As directed by the North Carolina Board of Architecture and Registered Interior Designers, architectural seals are not required for – and should not be placed by NVR on – these plans and specifications.

REMARKS

DATE

EV. NO.

31

32

33

34

35

36

09/19/2025

NORTH CAROLINA PROFESSIONAL SEAL 44932

JOHNTAN EDWARD ALBERTS

ENGINEER

NVR, Inc.

Firm license #: D-0477

5285 Westview Drive, Suite 100 Frederick, MD 21704

SET NO.

VERSION

DRAWN BY

ELH

DATE:

4/8/14

OPTION

MODEL

WALL BRACING DETAILS

DRAWING TITLE

PRESCRIPTIVE WALL BRACING DESIGN

SHEET NO.

WB-2

OPTION DESCRIPTION