

E:\Autodesk Projects 2015\My Projects\CAVINNESS LAND\CL 2862 8-5-19.dwg, 8/5/2019 12:36:30 PM


 
 
 


LIST OF SYMBOLS			
	SECTION MARK		DATUM ELEVATION
	DETAIL MARK		SLOPE UP
	TITLE MARK		EARTH
	INTERIOR BEARING WALL		INSULATION
	NUMBER OF GANG STUDS IN WALL		

TABLE OF CONTENTS	
1	ELEVATIONS
2	ELEVATIONS
3	FOUNDATION PLAN
4	1st FLOOR PLAN
5	2nd FLOOR PLAN
E1	1st FLOOR ELECTRICAL PLAN
E2	2nd FLOOR ELECTRICAL PLAN

SPACE DATA	
FIRST FLOOR, HEATED:	1444 SF
SECOND FLOOR, HEATED:	1418 SF
TOTAL HEATED:	2862 SF
GARAGE:	
3rd CAR GARAGE OPTION:	266 SF
FRONT PORCH:	96 SF
REAR PORCH:	154 SF

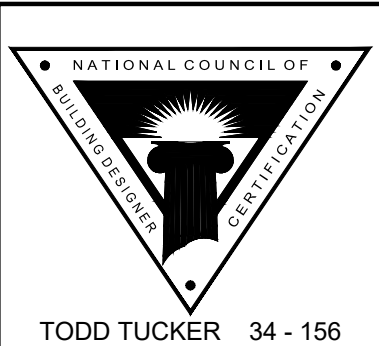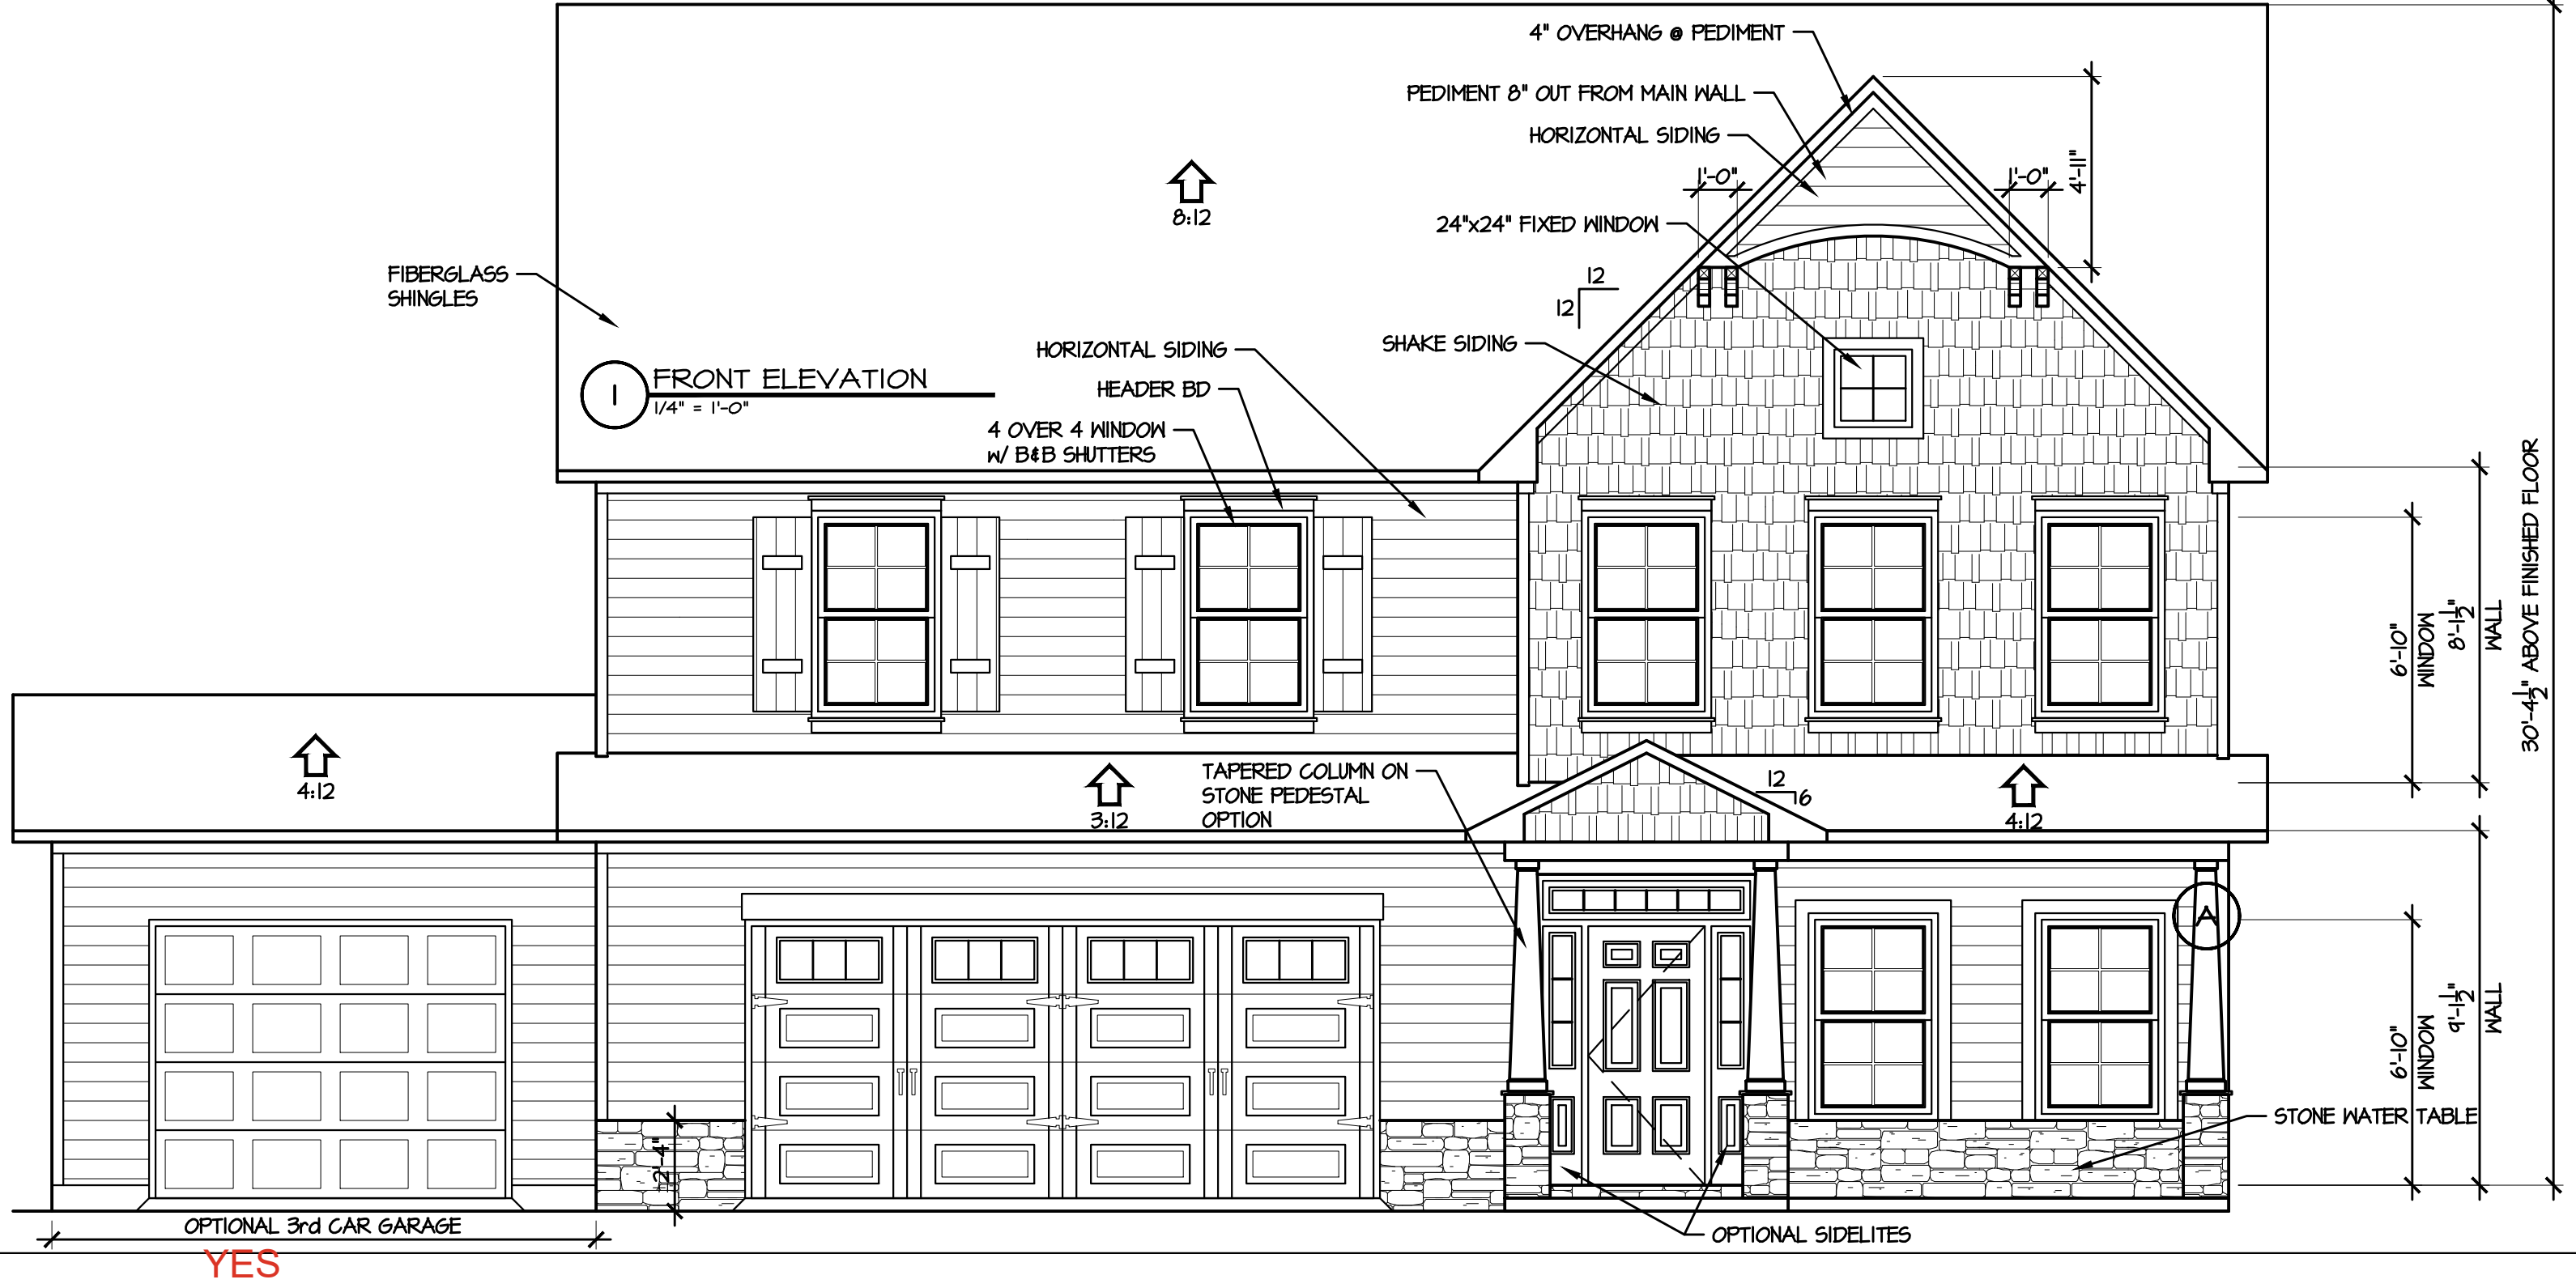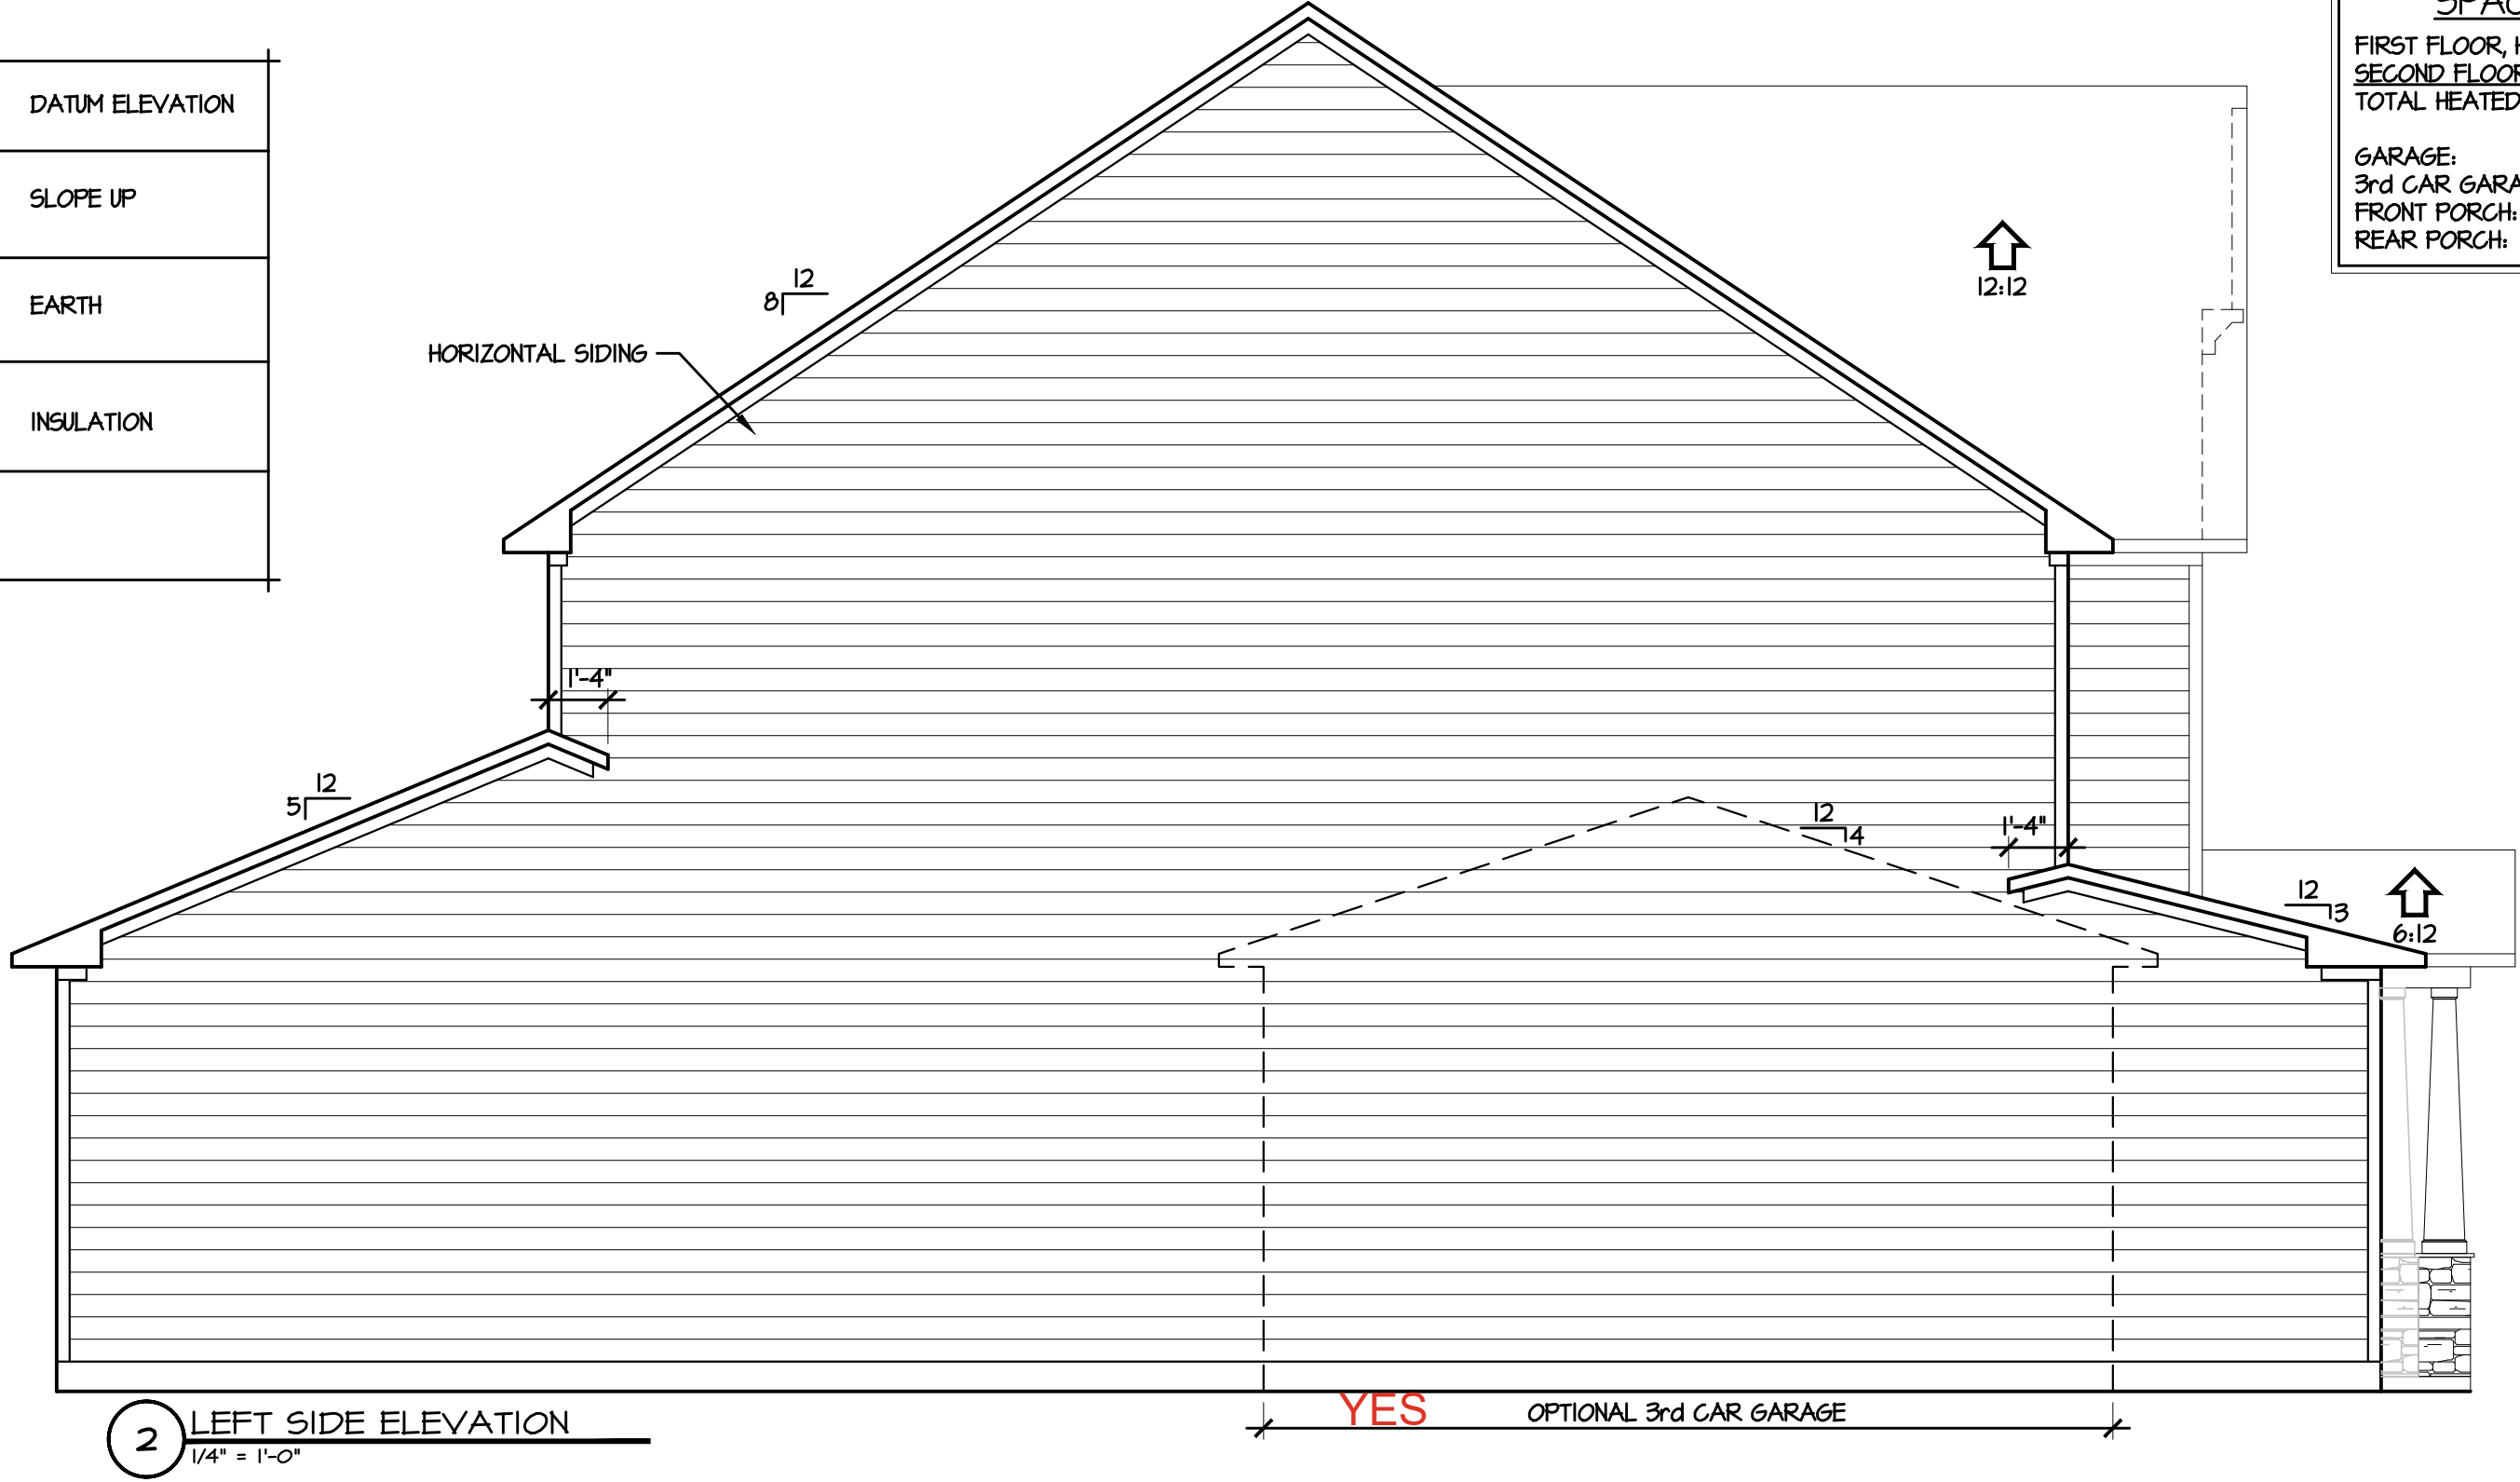

© 2019 CavLand
1041-B Robeson St
Fayetteville, NC 28305
Office: 910-339-6330
Fax: 910-339-6333


CL 2862
ELEVATIONS

SCALE:	AS NOTED
DATE:	APRIL 2019
PLAN:	CL 2862
LOT NO:	
SHEET NO:	1

LIST OF ABBREVIATIONS

ACCESS	ACCESS TO ATTIC OR CRAWL SPACE	DW	DISH WASHER	POCKET DOOR	T.C.	TOP CHORD
AFF	ABOVE FLOOR	EQ	EQUAL	PERFORATED	TOW	TOP OF WALL
BDRM	BEDROOM	FDN	FOUNDATION	PLATE	TRANS	TRANSOM
BM	BEAM	FV	FOUNDATION VENT	POINT LOAD (SOLID BLOCK)	TYP	TYPICAL
CAB	CABINETS / CABINETRY	GL	GLASS (DOOR)	PRESSURE TREATED FOR EXPOSURE	UON	UNLESS OTHERWISE NOTED
CJ	CONTROL JOINT	HB	HOSE BIB	ROD & SHELF (CLOSETS)	V.B.	VAPOR BARRIER
CL	CENTERLINE	HDR	DOOR / WINDOW / OPENING HEADER	REFRIGERATOR	VAN	VANITY
CO	CONCRETE MASONRY UNIT	HVAC	HEATING, VENTING & AIR CONDITION	REINFORCEMENT	W	WIDE
CONC	CONCRETE	KWALL	KNEEWALL	ROOM	W	WITH
CSMT	CEMENT	LVL	LAMINATED VENEER LUMBER	SEGMENTED	#SP	NUMBER OF STUD POCKETS @ WINDOW/DOOR JAMB
DBL	DOUBLE	MANF	MANUFACTURED	SHOWER		
DIAM	DIAMETER	MAS	MASONRY	SHELVE(S)		
DH/SH	DOUBLE HUNG / SINGLE HUNG WINDOW	NIC	NOT IN CONTRACT	SPEC(T/D)		
DN	DOWN	OC	ON CENTER	SQ		
DP	DEEP	OPNG	OVERHANG OPENING	SST		
				SUBFLR		
				SYP		

1 REAR ELEVATION
1/4" = 1'-0"

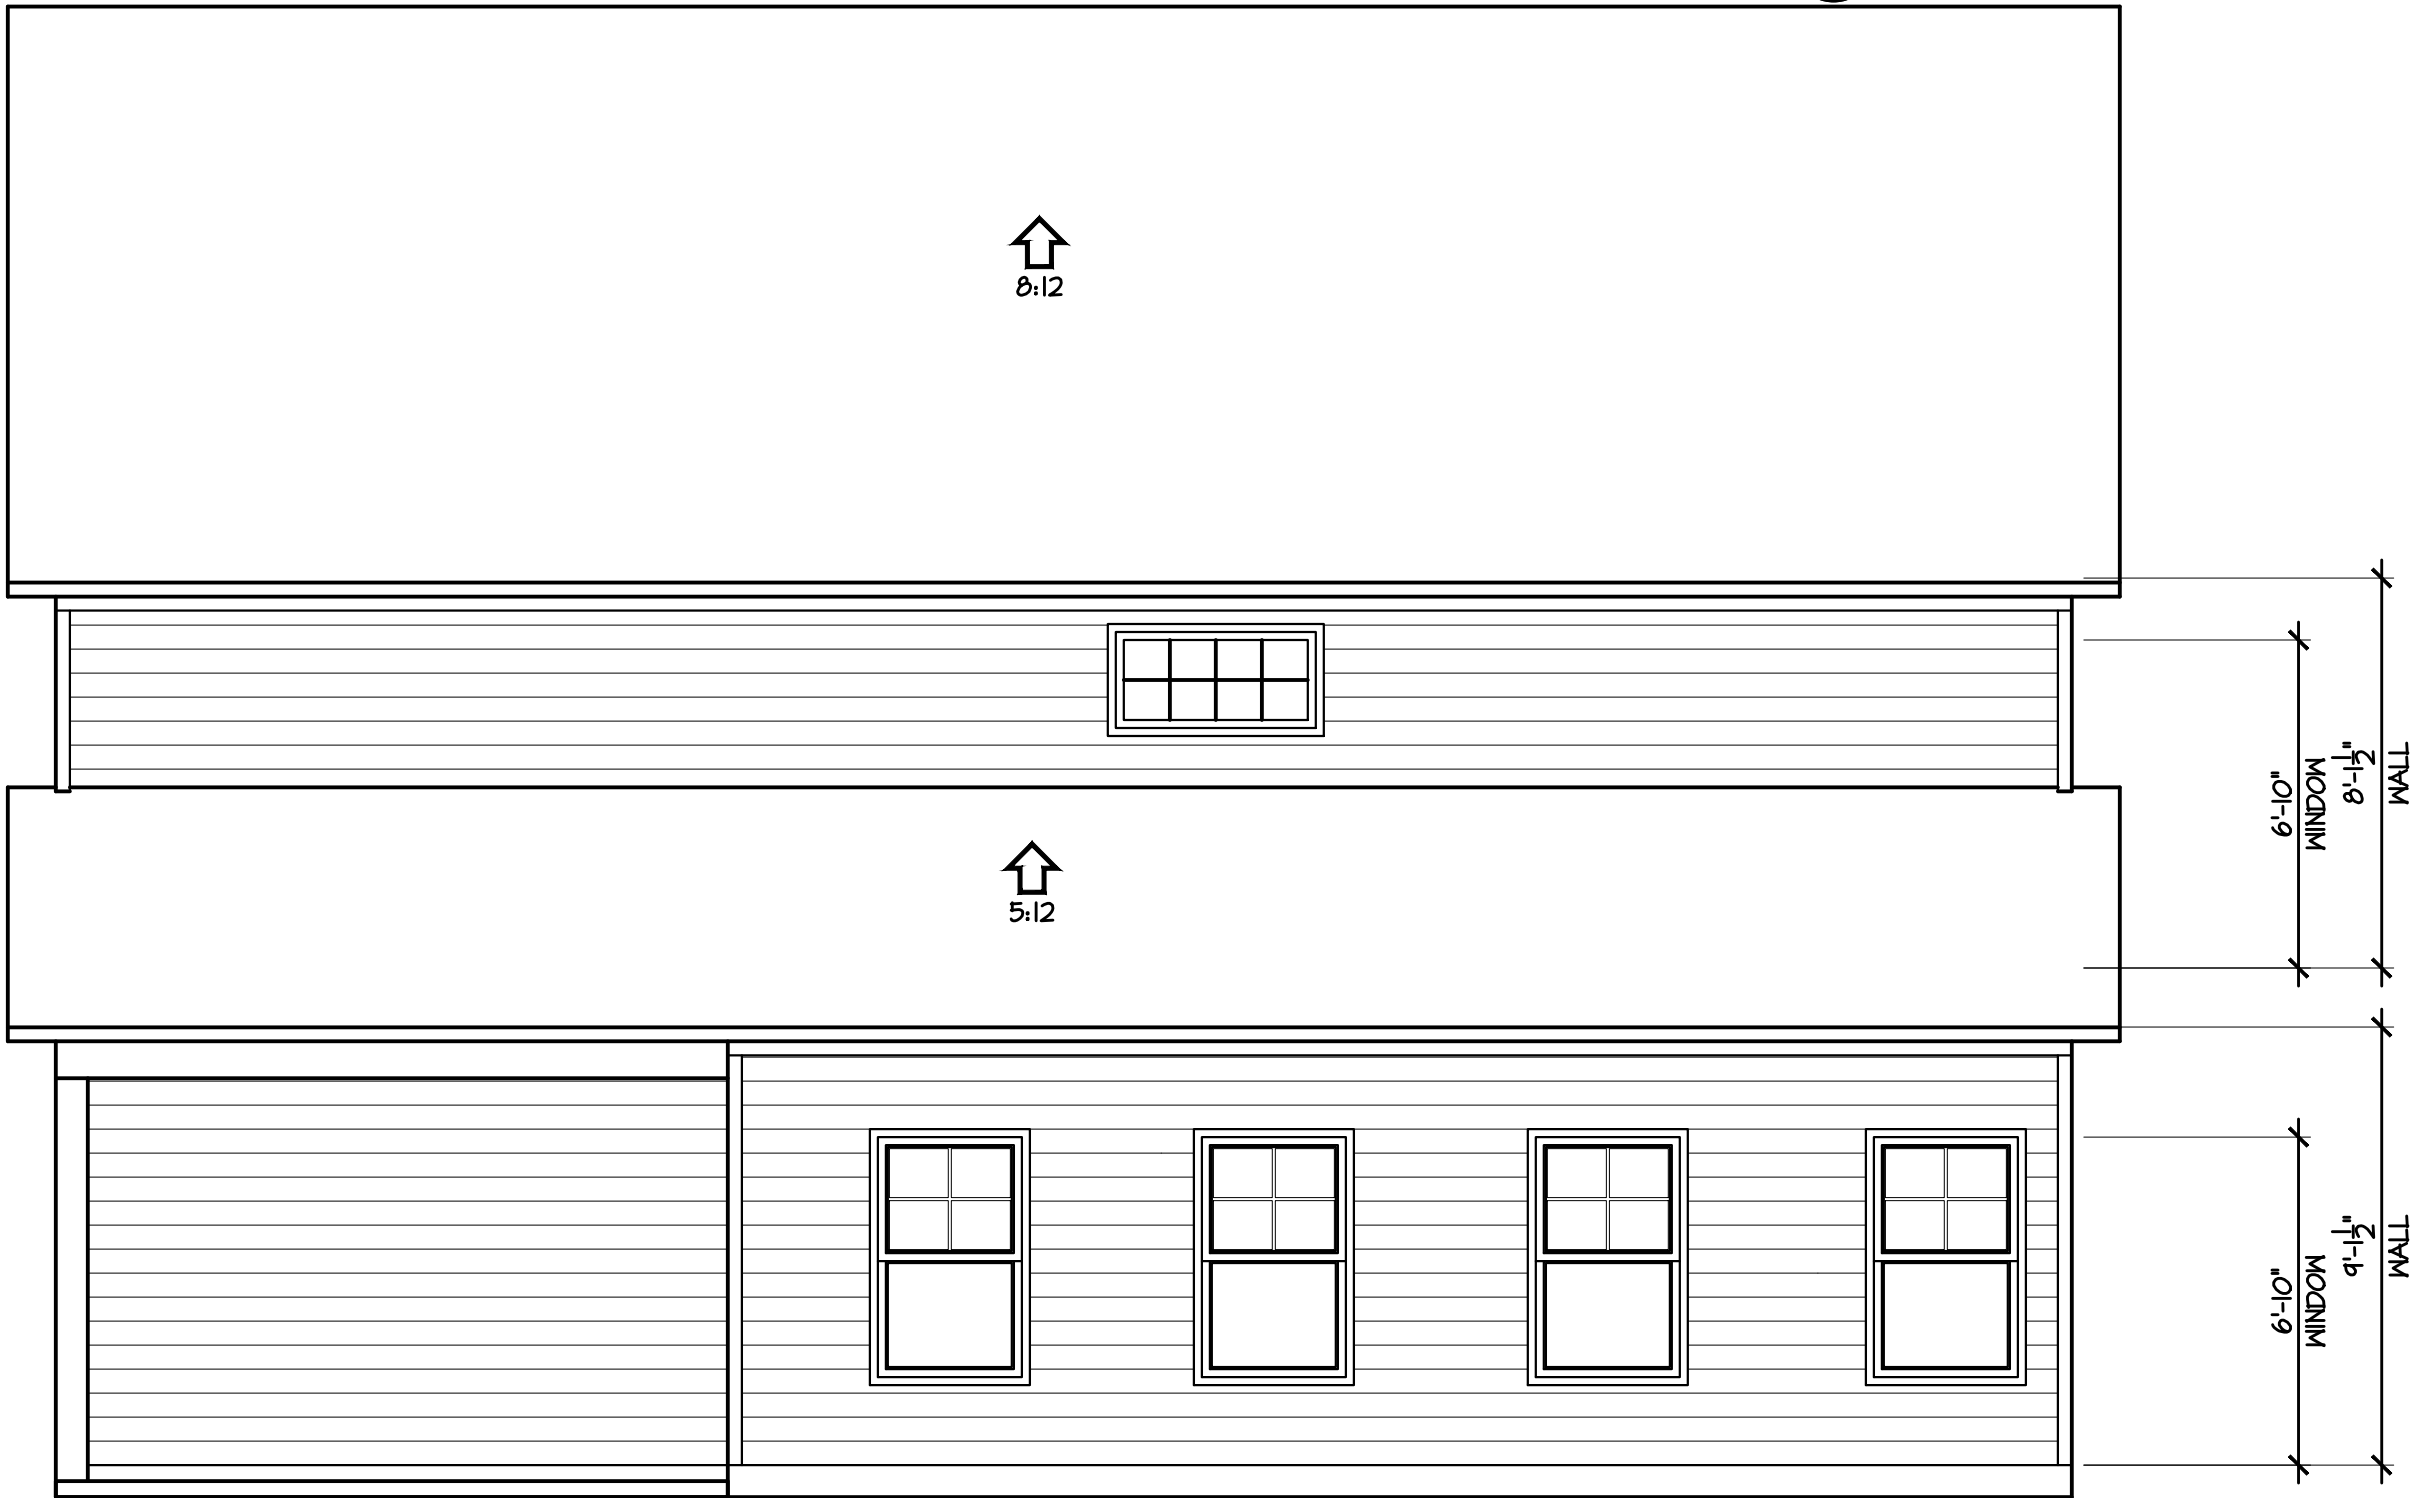

2 RIGHT SIDE ELEVATION
1/4" = 1'-0"

TODD TUCKER 34 - 156

© 2019 CavLand
1041-B Robeson St
Fayetteville, NC 28305
Office: 910-339-6330
Fax: 910-339-6333

CL 2862

ELEVATIONS

SCALE:
AS NOTED

DATE:
APRIL 2019

PLAN:
CL 2862

LOT NO:

SHEET NO:
2

SPACE DATA	
FIRST FLOOR, HEATED:	1444 SF
<u>SECOND FLOOR, HEATED:</u>	<u>1418 SF</u>
TOTAL HEATED:	2862 SF
GARAGE:	514 SF
3rd CAR GARAGE OPTION:	266 SF
FRONT PORCH:	96 SF
REAR PORCH:	154 SF



© 2019 CavLand
1041-B Robeson St
Fayetteville, NC 28305
Office: 910-339-6330
Fax: 910-339-6333

2627

SECOND FLOOR-4

SCALE:
AS NOTED

DATE:
APRIL 2019

PLAN: CL 2862

LOT NO:

SHEET NO:

5-4

1 SECOND FLOOR PLAN
1/4" = 1'-0"