

CURTIS PETERMAN

1845

Southeast

BARNDOMINIUMS

1845 CONSTRUCTION
HALLSVILLE, TX
(903) 935-9436

PROJECT NAME AND ADDRESS

CURTIS PETERMAN

SHEET CONTENTS

GENERAL INFORMATION, TOTAL SQ. FT.,
COLORS AND FRONT ELEVATION

REMARKS

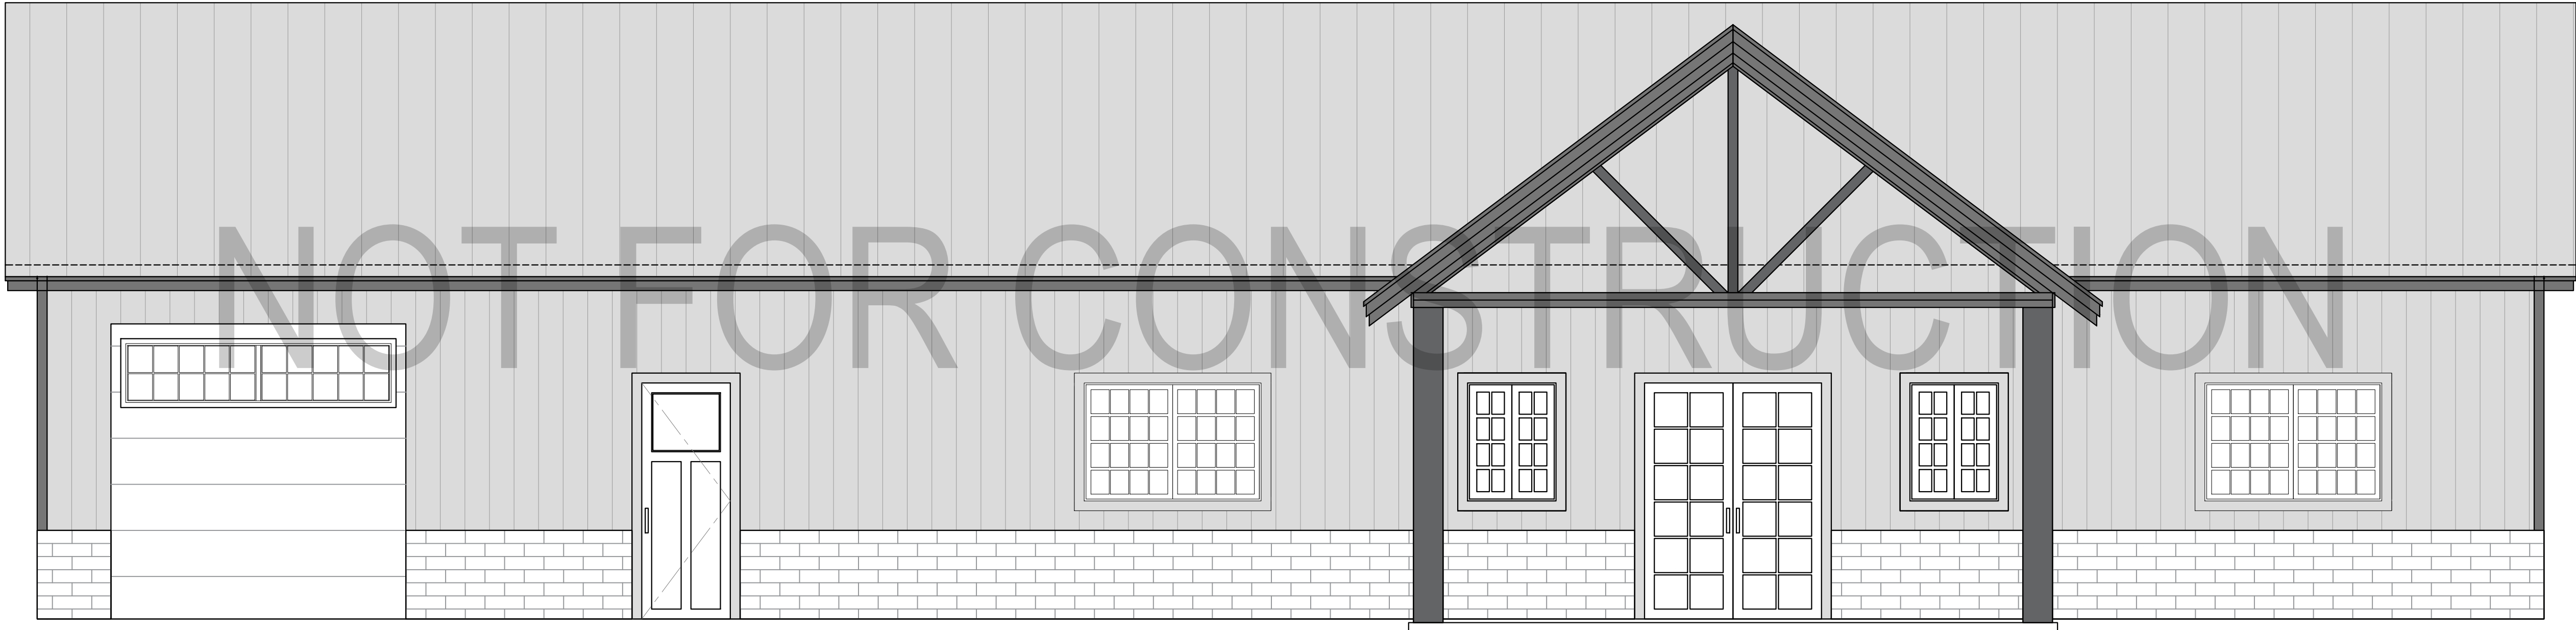
- BASED ON CLIENT/REQUEST
DOCUMENT WITH MARK-UPS
UPLOADED ON BARNDOMINIUMS
GOOGLE DRIVE

REV 2	SEE REMARKS	09-24 2025
NO.	REVISION/ISSUE	DATE

APPROVED BY:

CURTIS PETERMAN
OWNER

PROJECT	00000	SHEET 1 OF 12
DATE	9/24/25	
SCALE	CUSTOM	



GENERAL INFORMATION	TOTAL SQ. FT.		COLORS
WINDOW COLOR -	HEATED / COOLED	= 1,909 SQ. FT.	WALLS -
WINDOW MATERIAL -	FRONT PORCH	= 179 SQ. FT.	ROOF -
GRID PATTERN -	BACK PORCH	= 473 SQ. FT.	WINDOW TRIM -
EXTERIOR WALLS -	SCREENED PORCH	= 215 SQ. FT.	DOOR TRIM -
ROOF PANELS -	SHOP	= 1,066 SQ. FT.	CORNER TRIM -
EXTERIOR WAINSCOTING -	TOTAL	= 3,842 SQ. FT.	RAKE TRIM -
			EAVE TRIM -
			SOFFITS -

PROJECT NAME AND ADDRESS

CURTIS PETERMAN

SHEET CONTENTS

PROPOSED FLOOR PLAN

REMARKS:


- BASED ON CLIENT/REQUEST
DOCUMENT WITH MARK-UPS
UPLOADED ON BARNDOMINIUMS
GOOGLE DRIVE

REV	2	SEE REMARKS	09-24 2025
NO.		REVISION/ISSUE	DATE

APPROVED BY:

CURTIS PETERMAN
OWNER

PROJECT	000000	SHEET	
DATE	9/24/25		2 OF 12
SCALE	1/4" = 1'-0"		

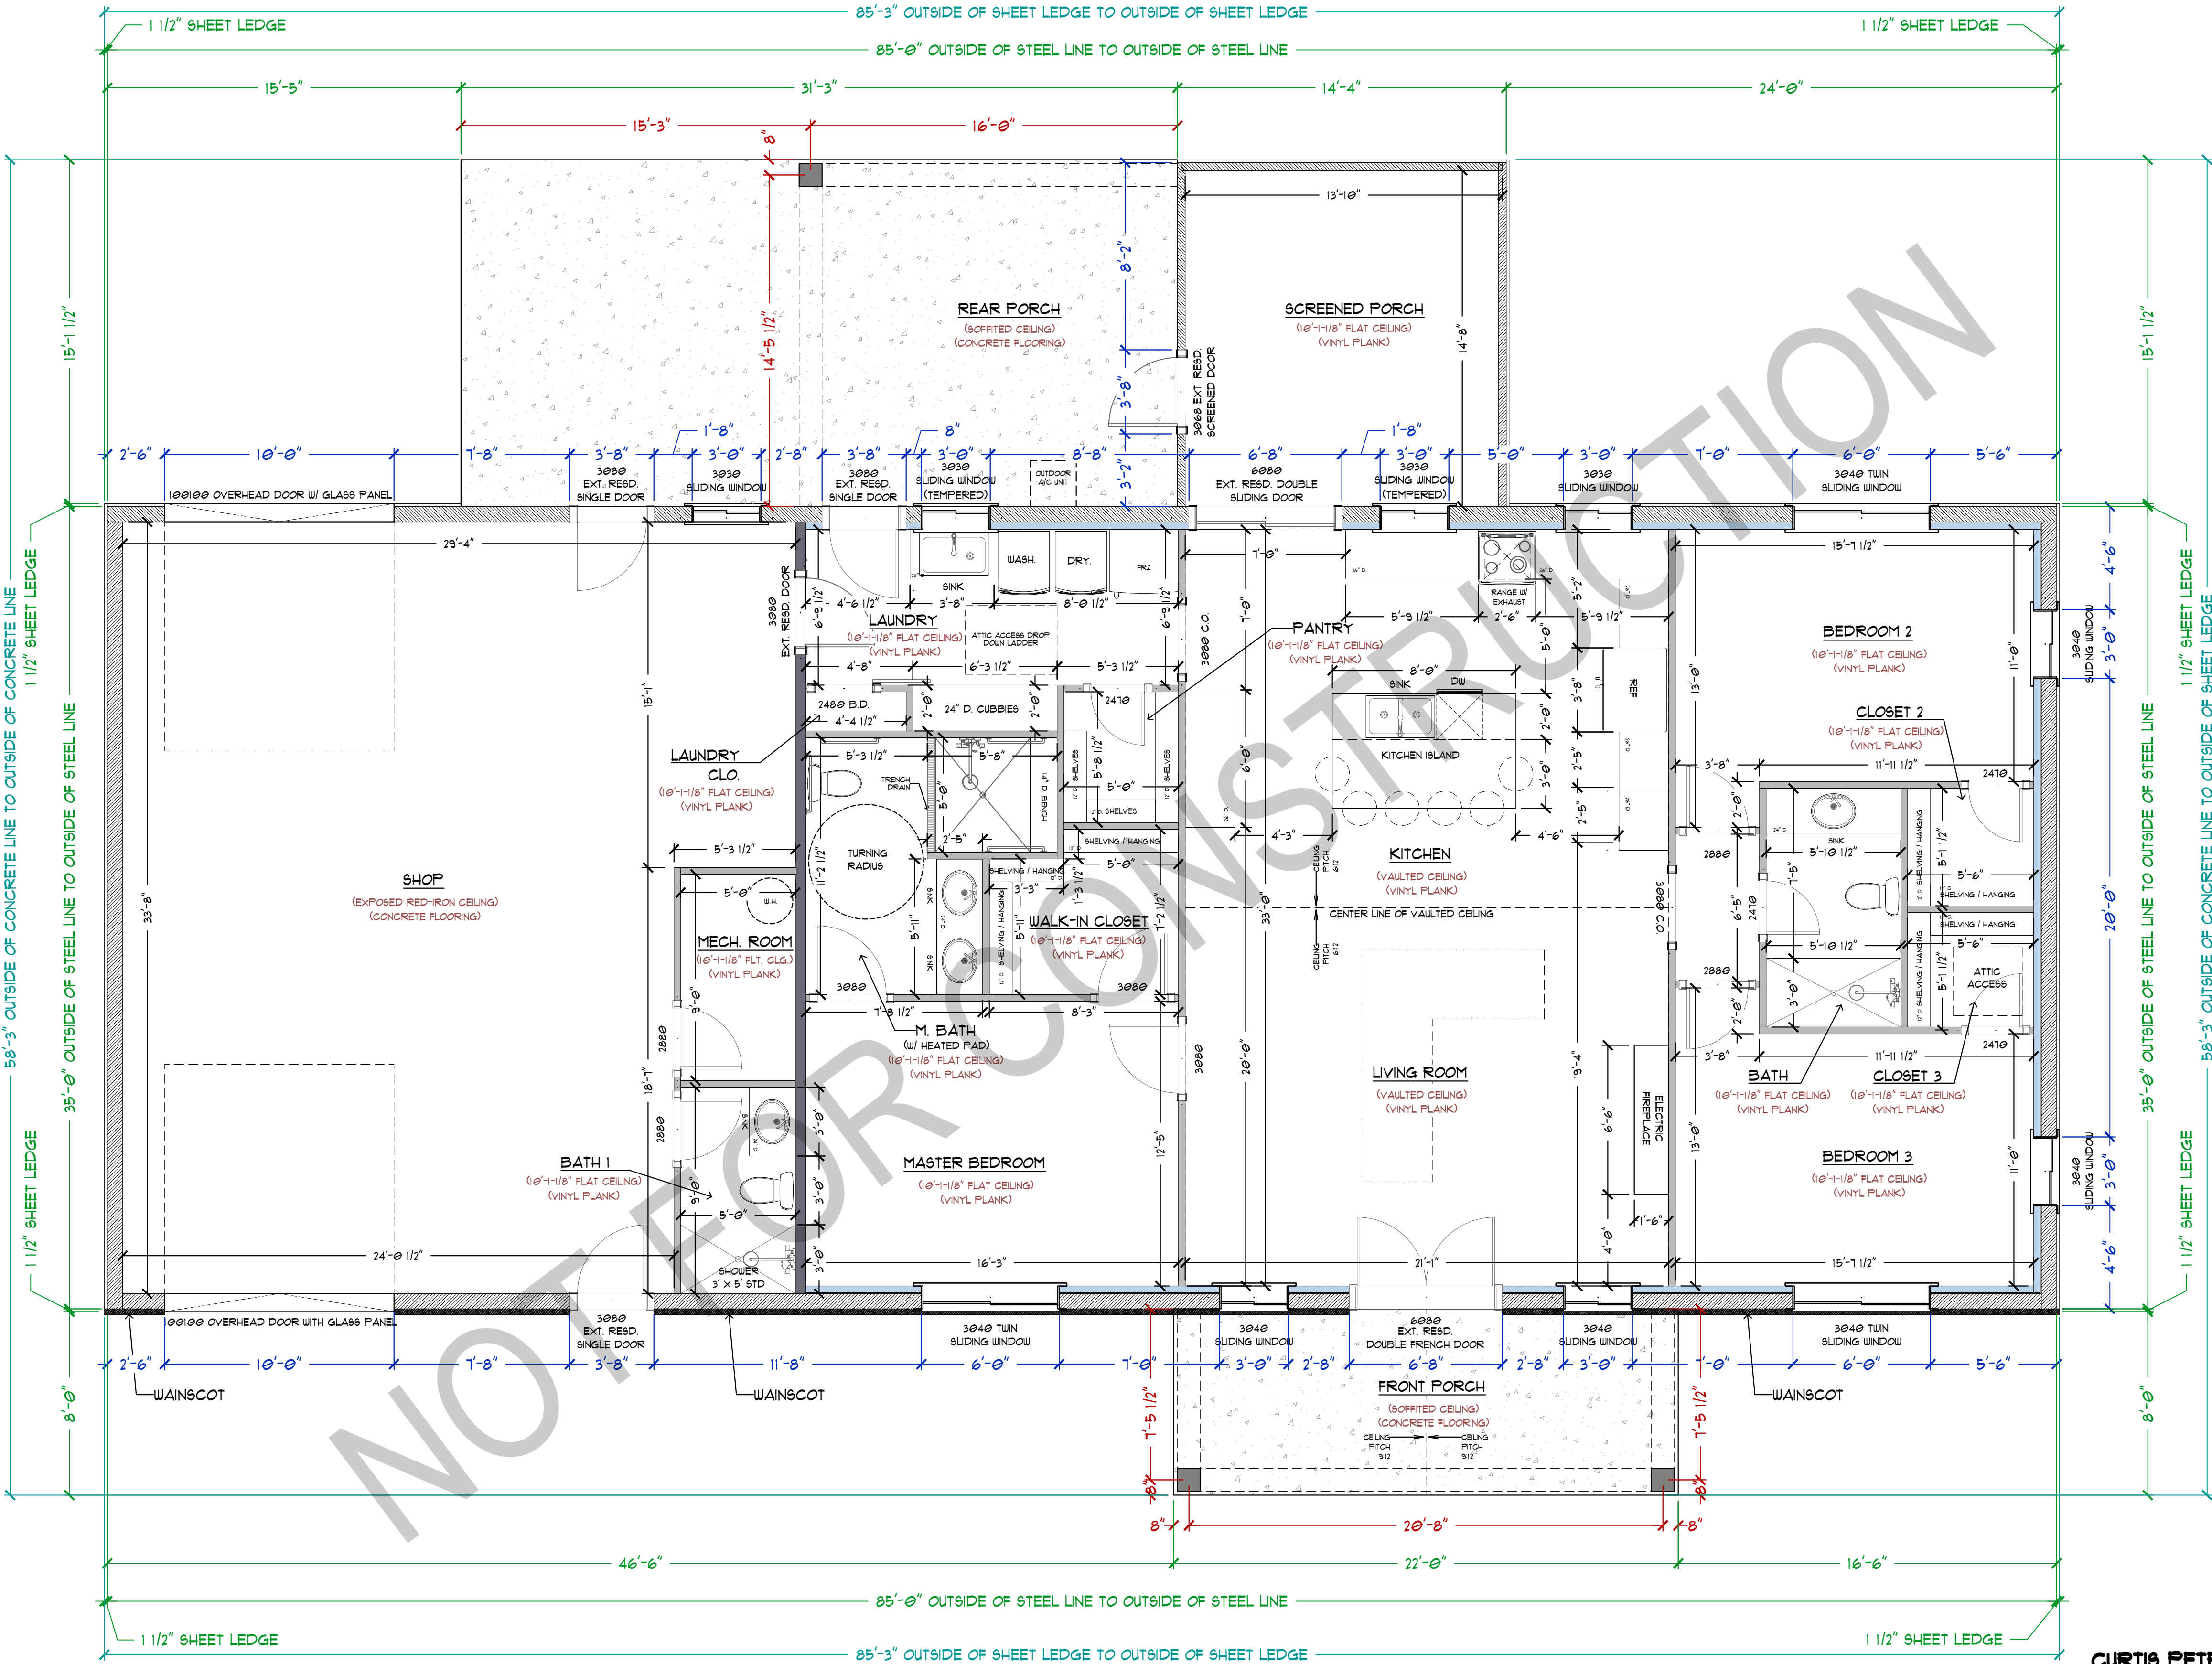

CURTIS PETERMAN

HEATED / COOLED
FRONT PORCH = 1,909 SQ. FT.
BACK PORCH = 179 SQ. FT.
SCREENED PORCH = 473 SQ. FT.
SHOP = 215 SQ. FT.
TOTAL = 3,842 SQ. FT.

PROPOSED GROUND FLOOR PLAN

SCALE: 1/4" = 1'-0"

PROJECT NAME AND ADDRESS

CURTIS PETERMAN

SHEET CONTENTS

PROPOSED ELEVATIONS

REMARKS


- BASED ON CLIENT/REQUEST
DOCUMENT WITH MARK-UPS
UPLOADED ON BARNDOMINIUMS
GOOGLE DRIVE

REV	2	SEE REMARKS	09-24 2025
NO.	REVISION/ISSUE		DATE


APPROVED BY:

CURTIS PETERMAN
OWNER

PROJECT	00000	SHEET
DATE	9/24/25	3 OF 12
SCALE	1/4" = 1'-0"	

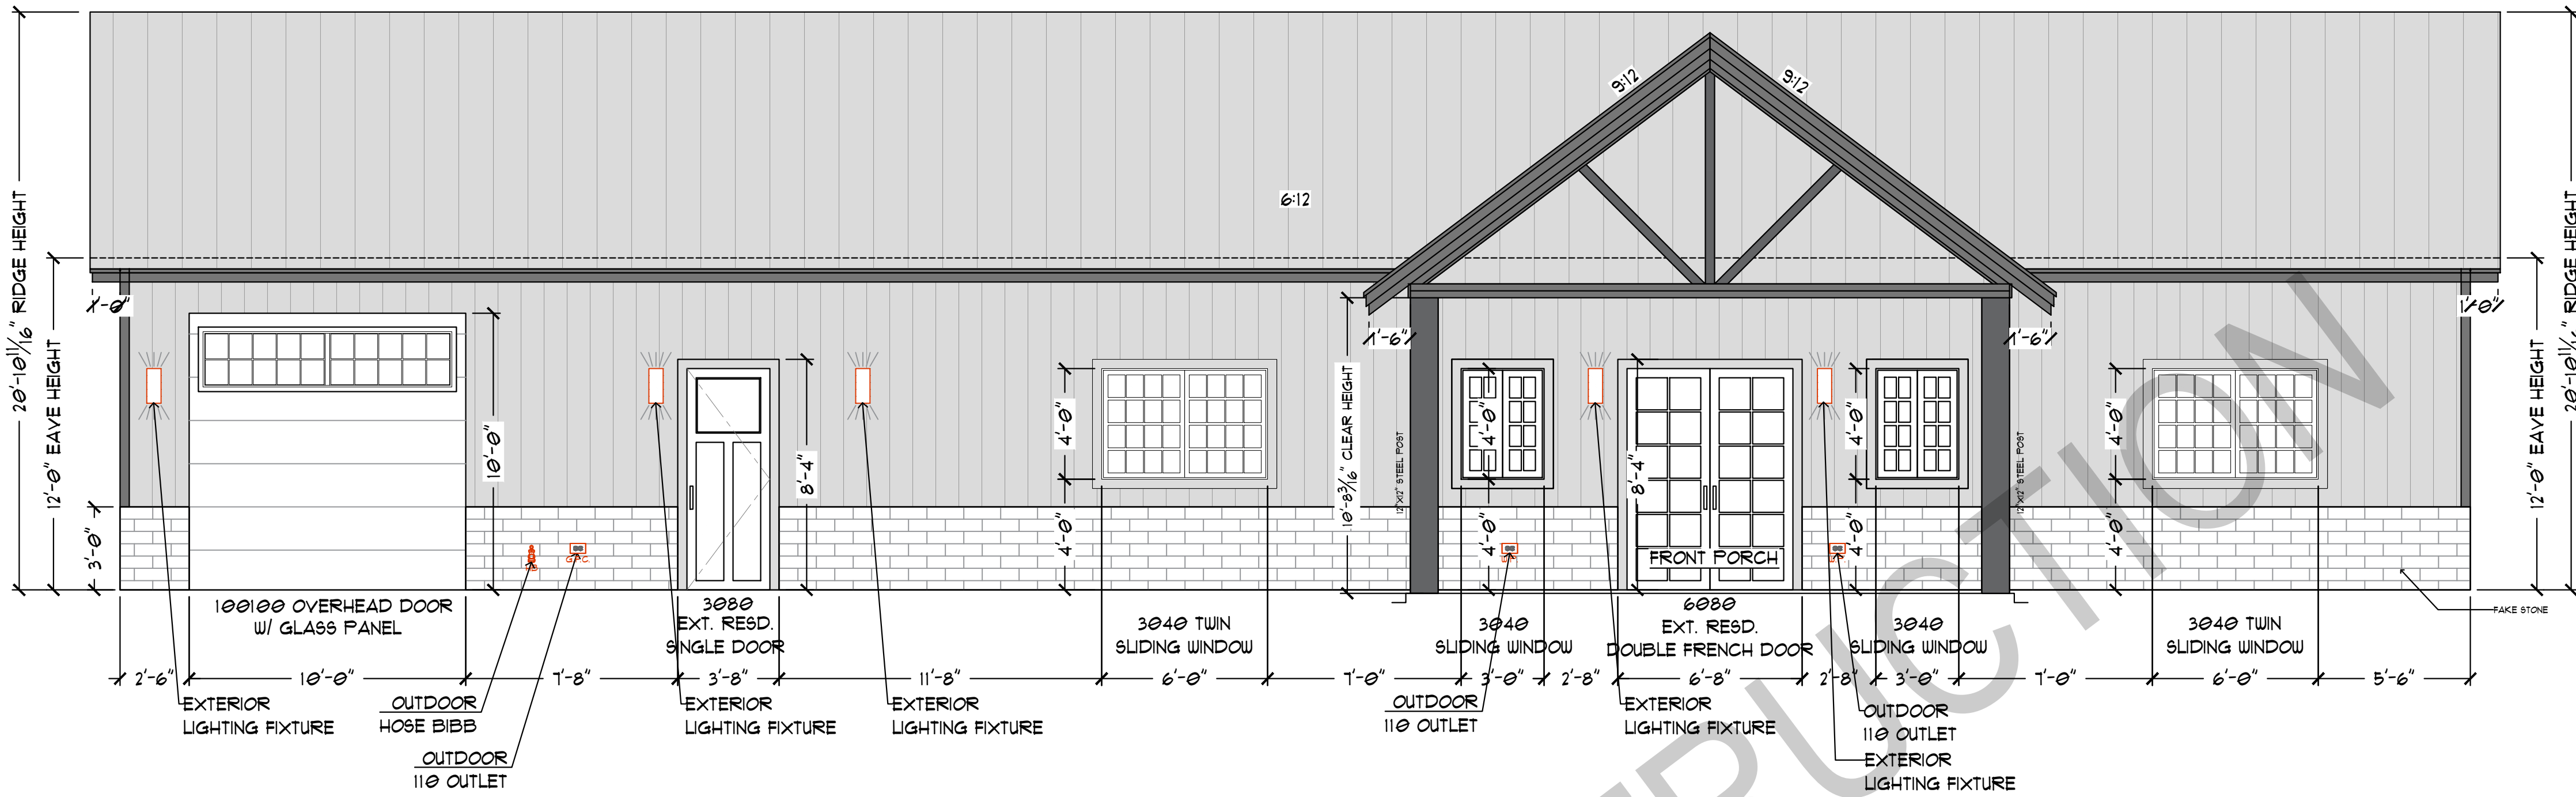


FRONT ELEVATION
SCALE: 1/4" = 1'-0"

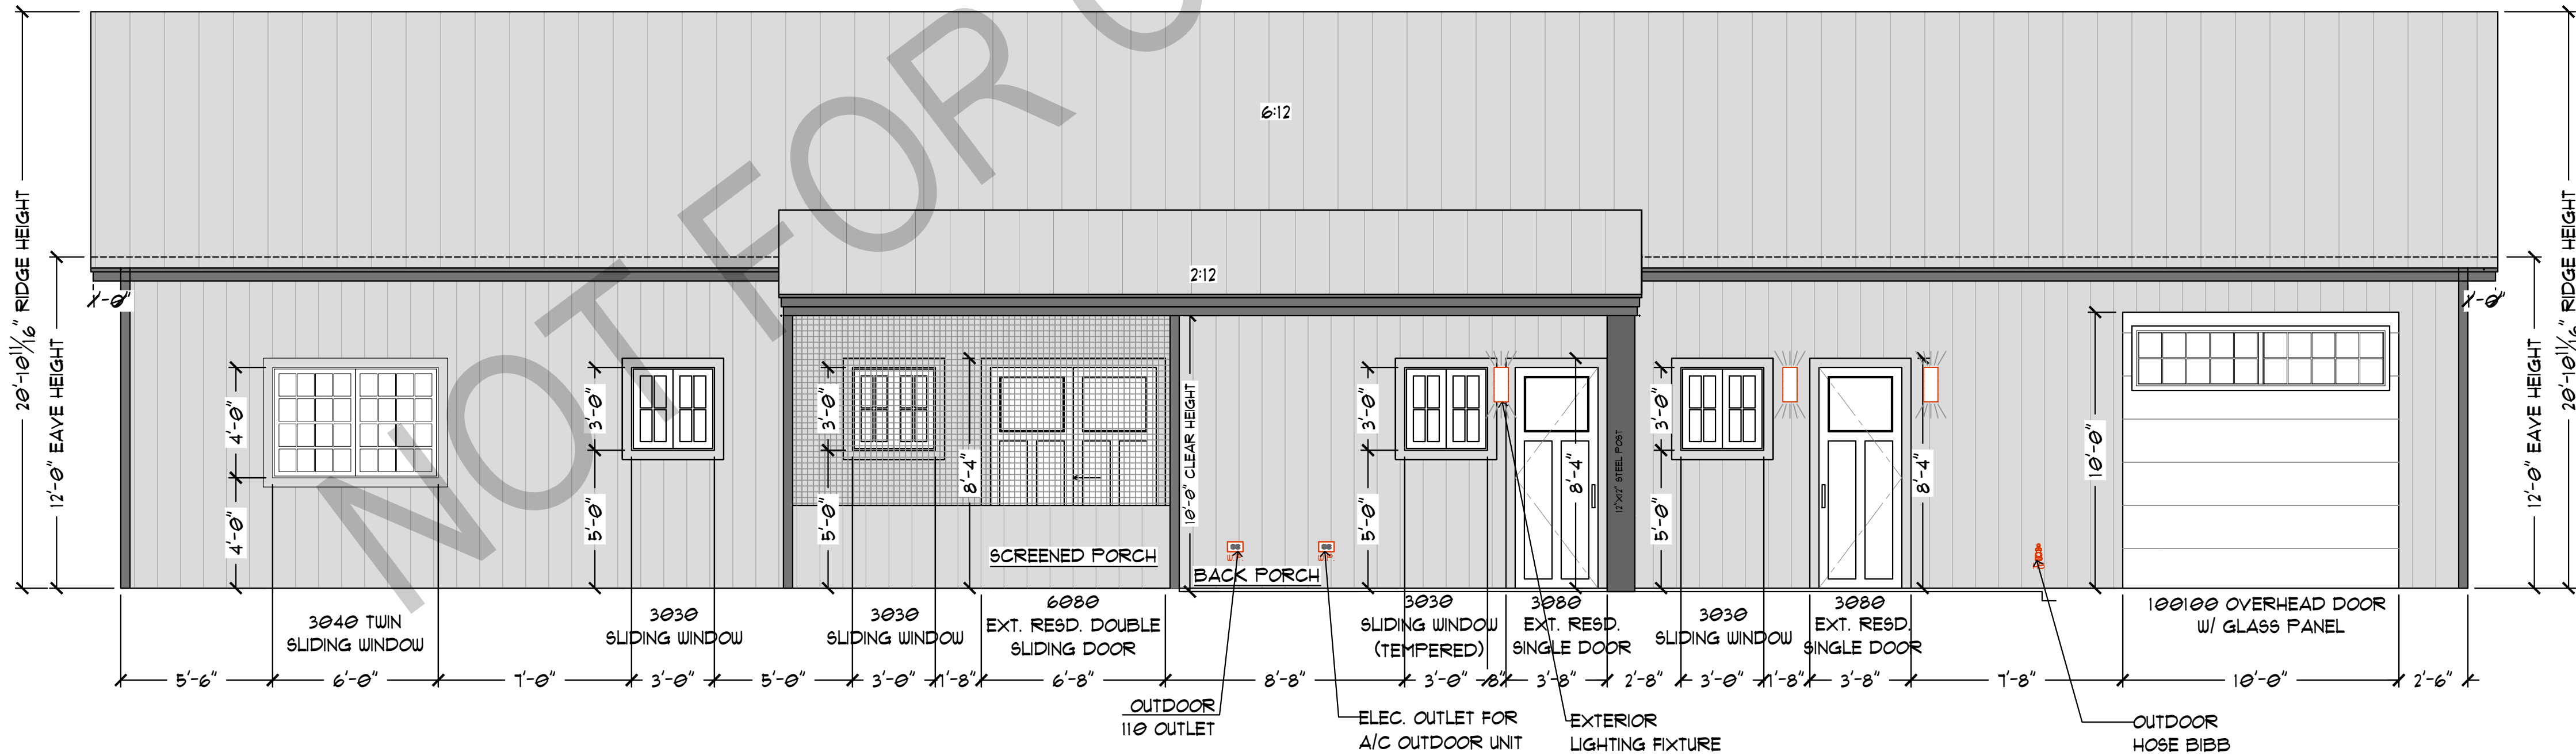


REAR ELEVATION
SCALE: 1/4" = 1'-0"



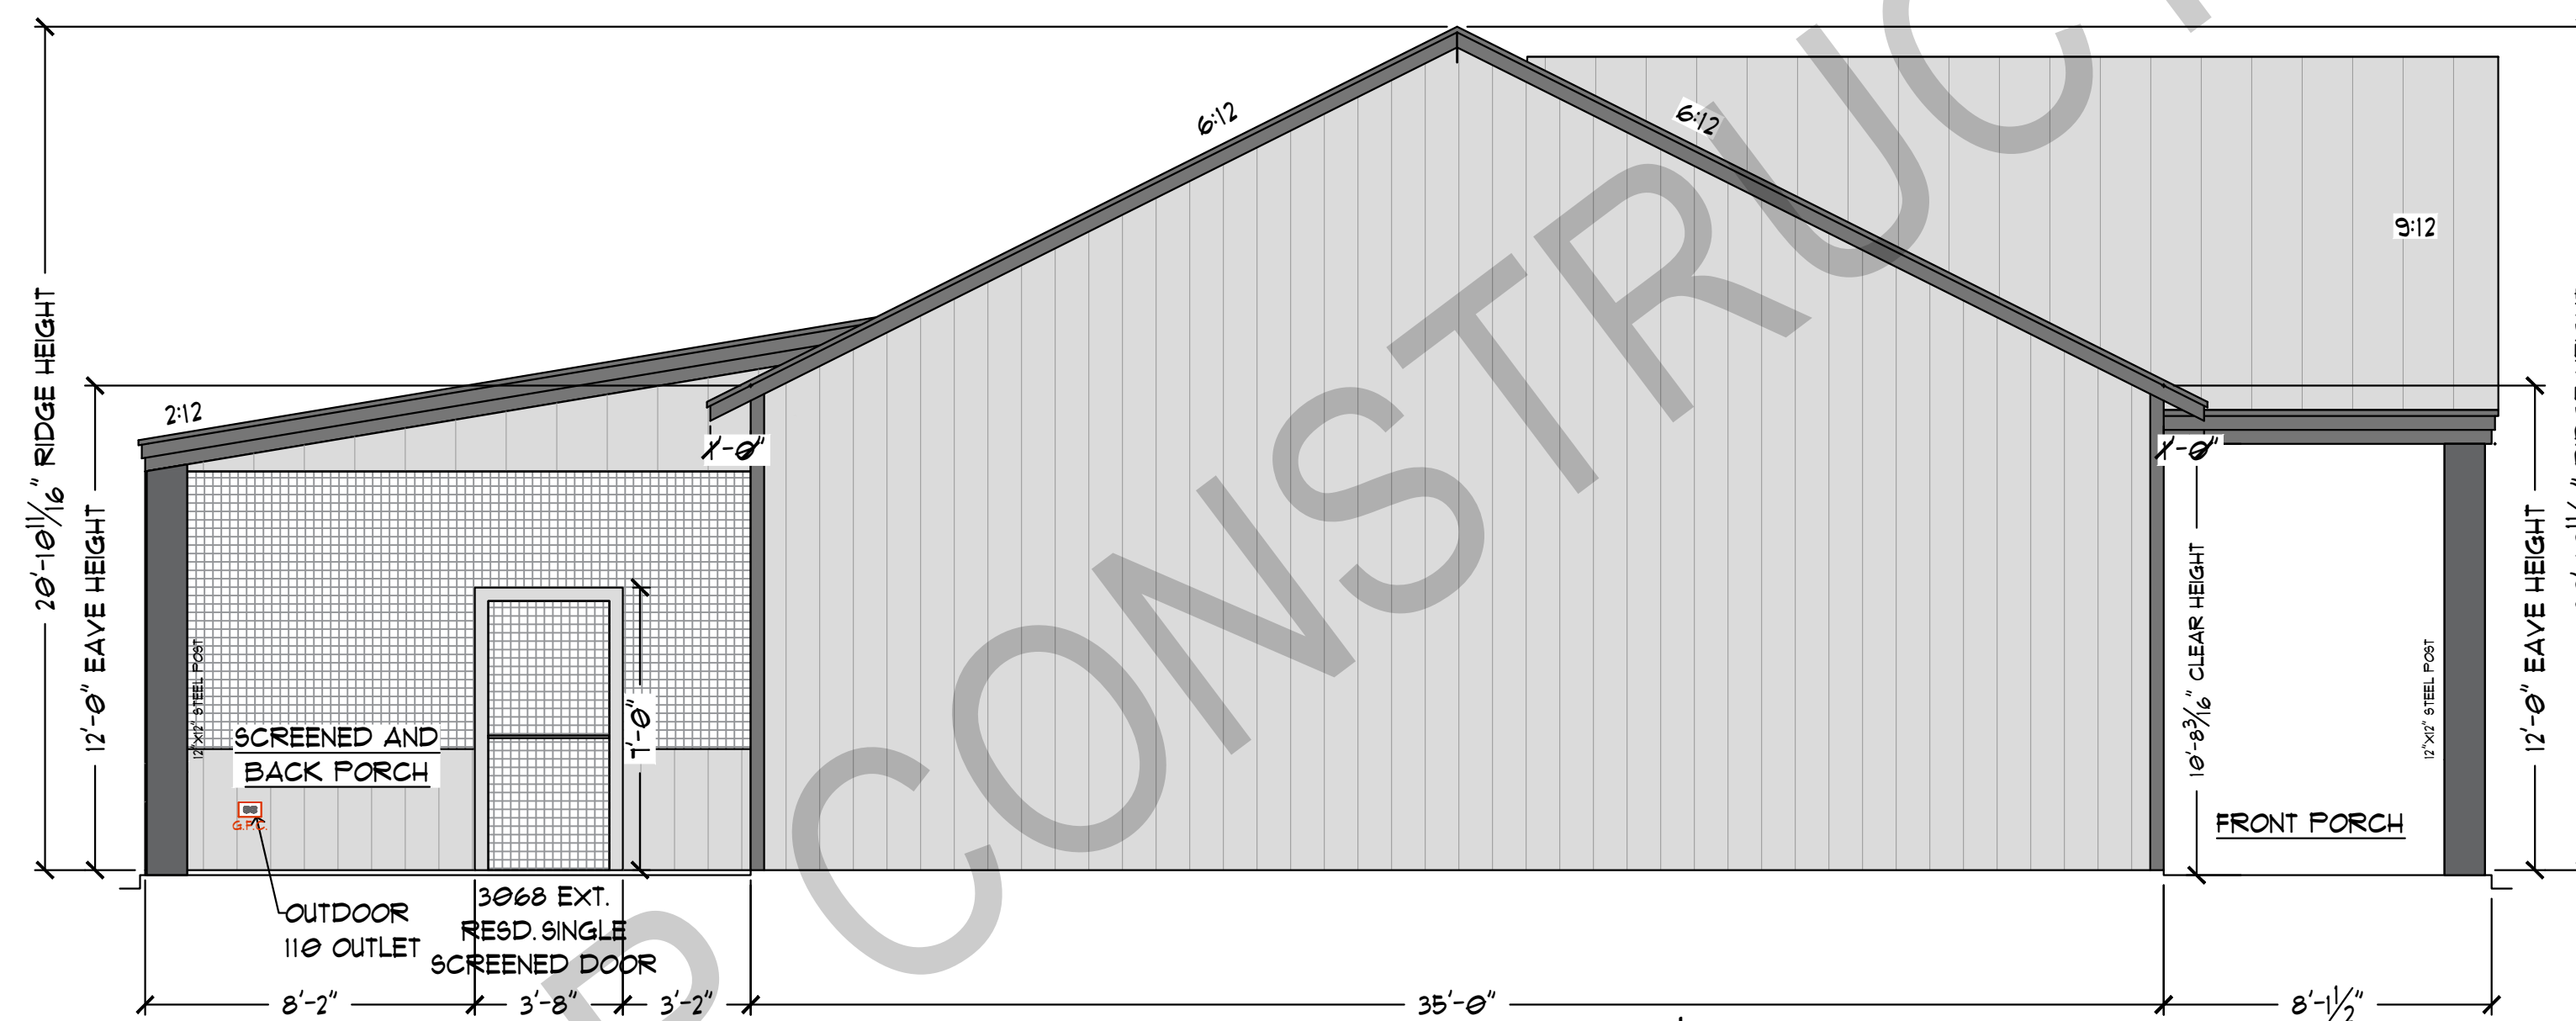RIGHT SIDE ELEVATION
SCALE: 1/4" = 1'-0"



LEFT SIDE ELEVATION
SCALE: 1/4" = 1'-0"

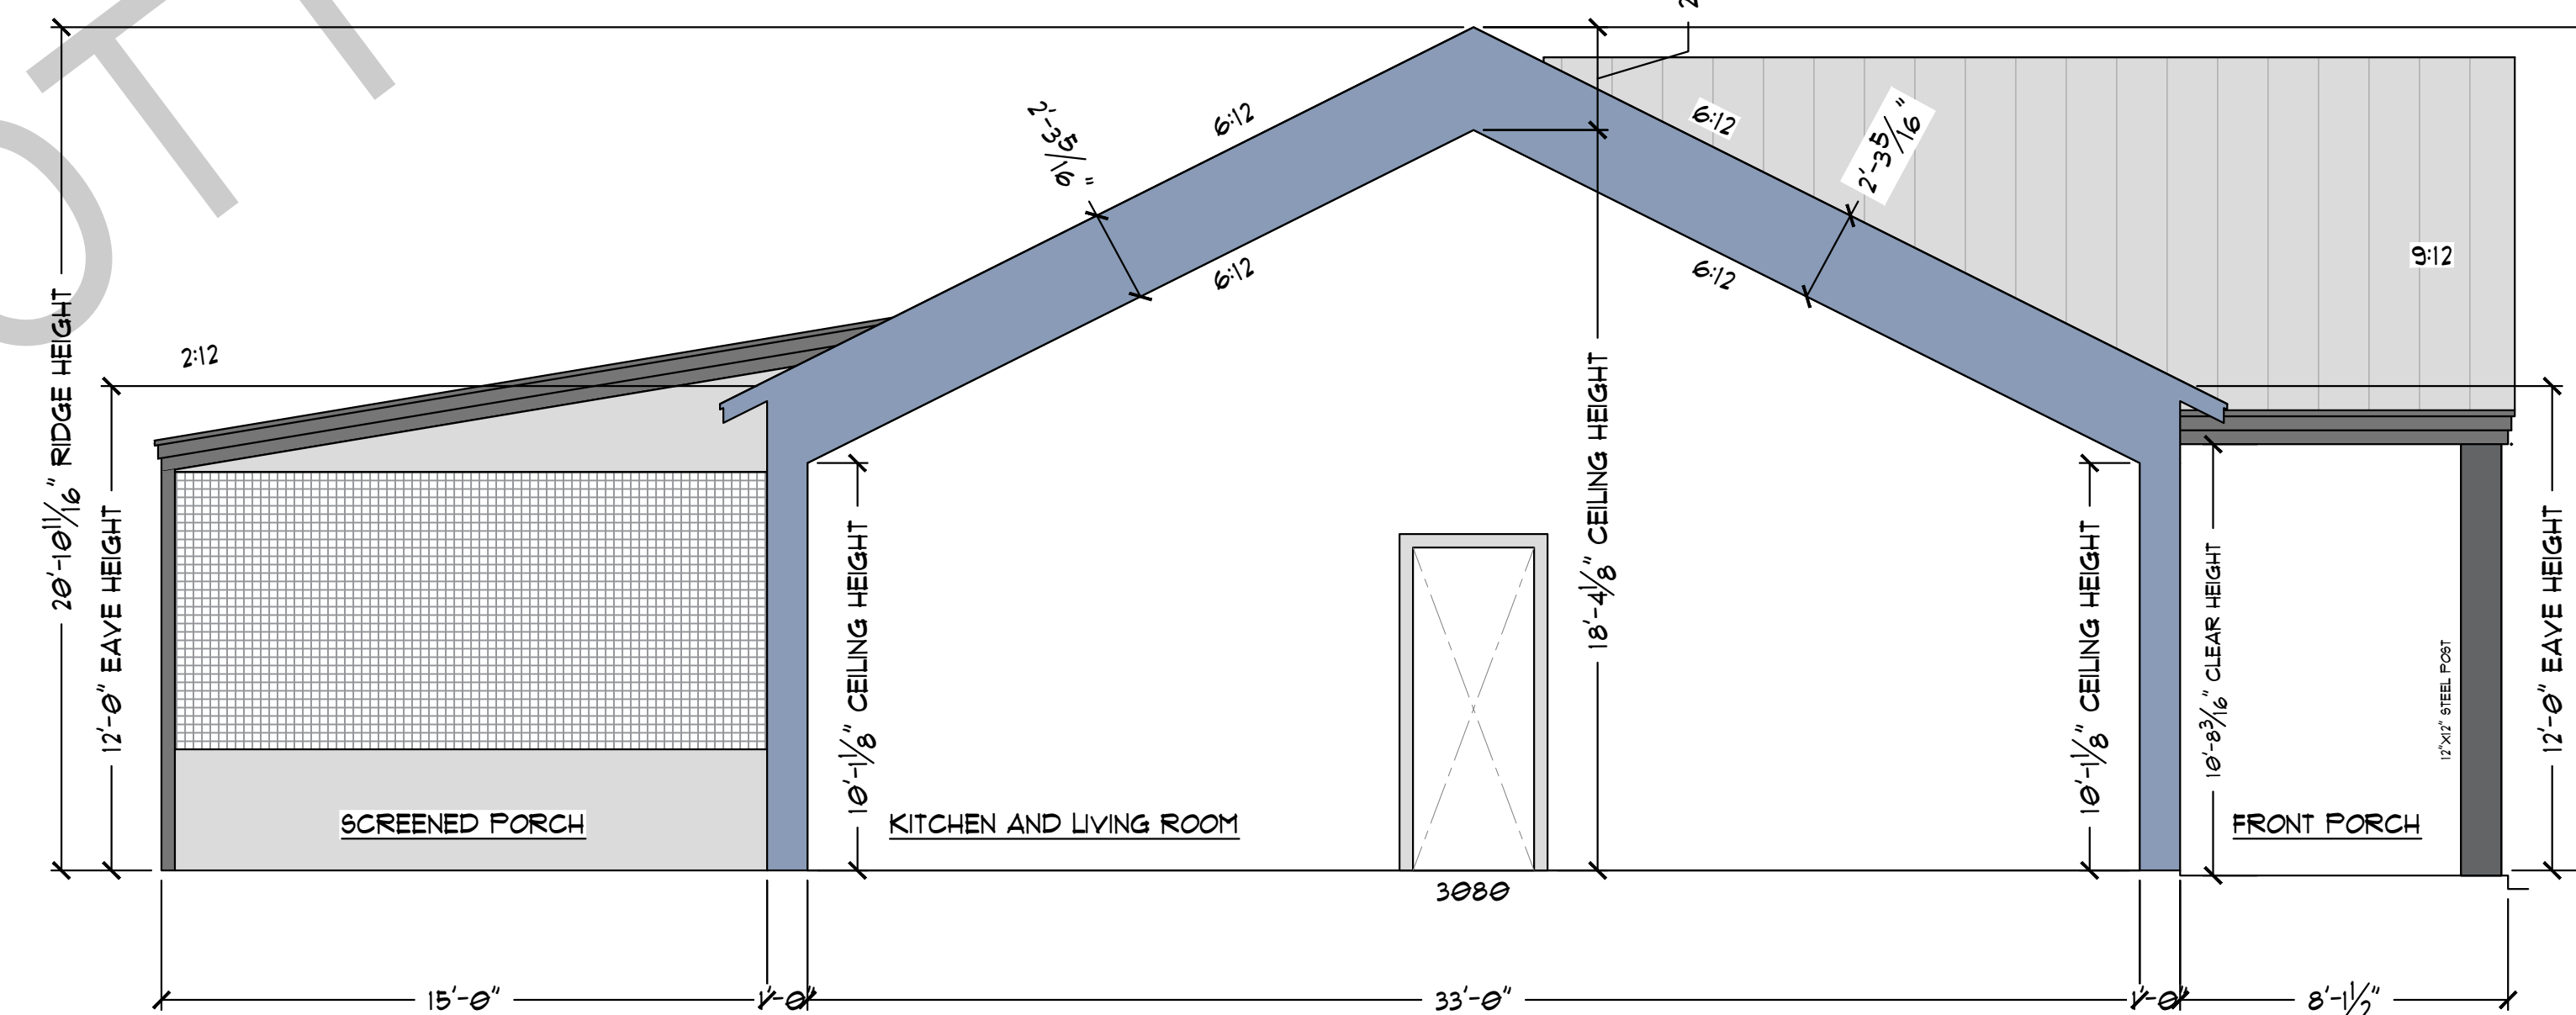

PROPOSED CROSS SECTION
SCALE: 1/4" = 1'-0"

PROJECT NAME AND ADDRESS

CURTIS PETERMAN

SHEET CONTENTS

PROPOSED ELEVATIONS
AND SECTIONS

REMARKS:


- BASED ON CLIENT/REQUEST
DOCUMENT WITH MARK-UPS
UPLOADED ON BARNDOMINIUMS
GOOGLE DRIVE

REV 2	SEE REMARKS	03-24 2025
NO.	REVISION/ISSUE	DATE

APPROVED BY:

CURTIS PETERMAN
OWNER

PROJECT 00000	SHEET
DATE 9/24/25	4 OF 12
SCALE 1/4" = 1'-0"	

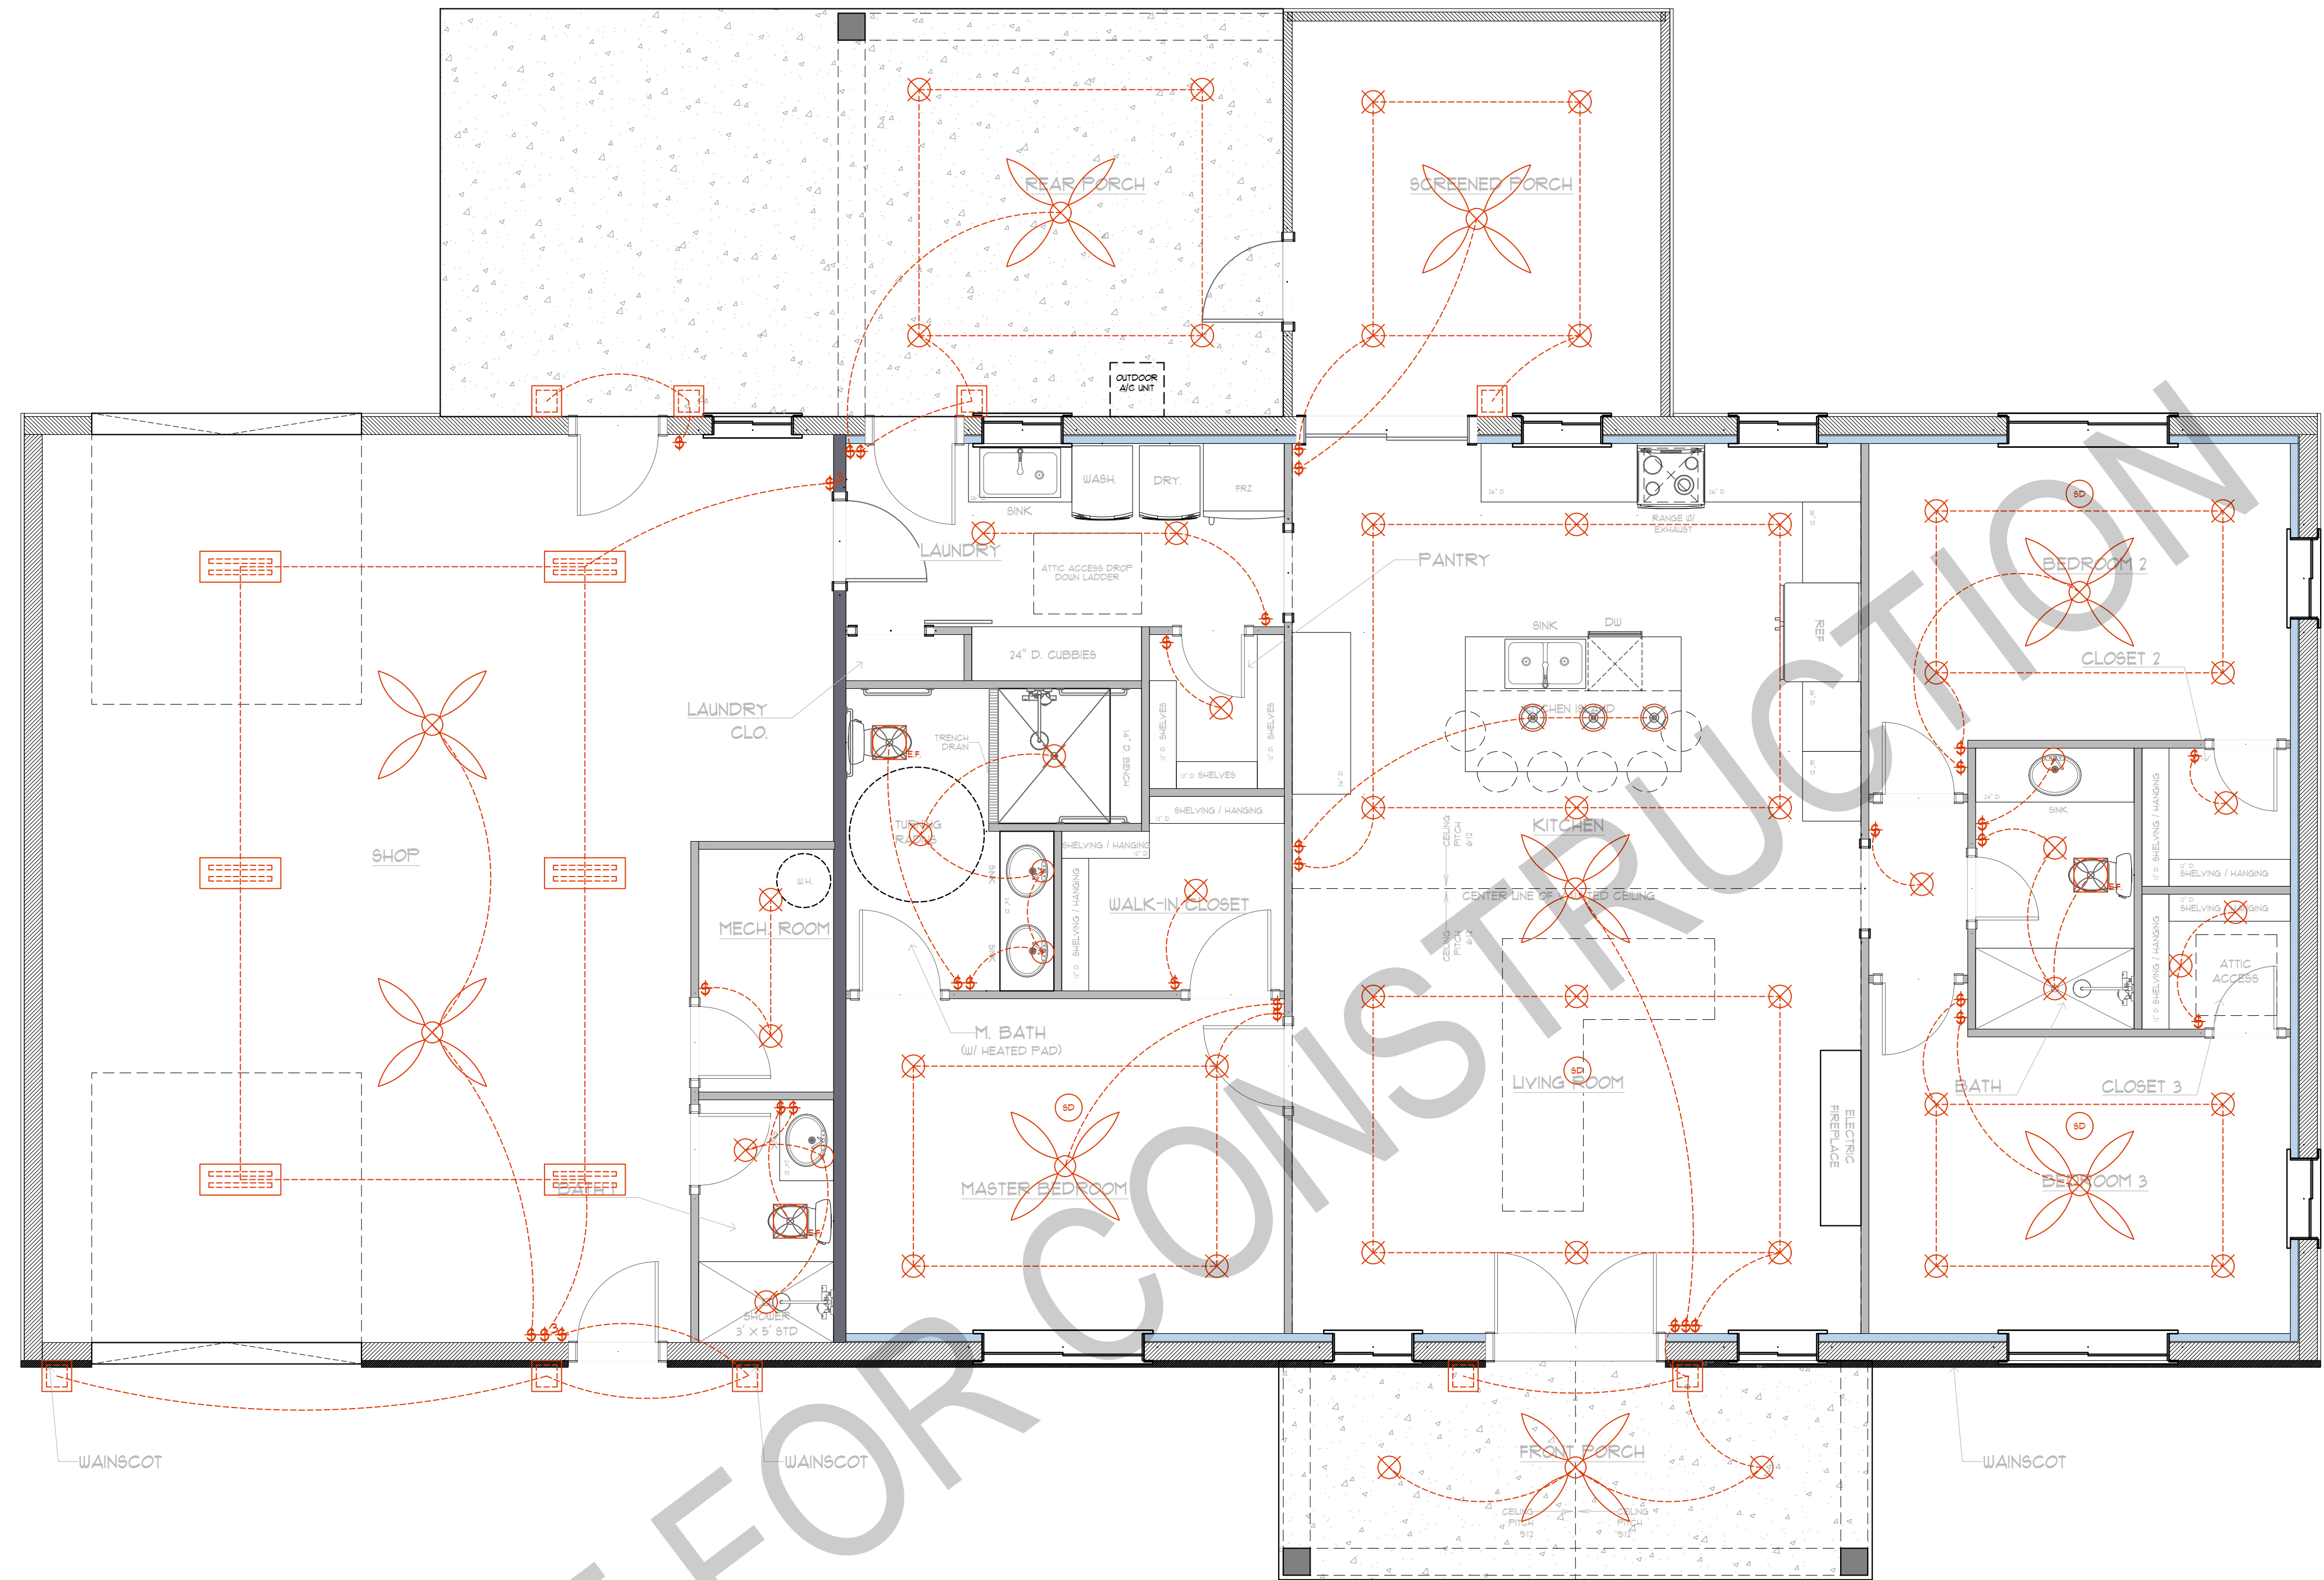

	ELECTRICAL OUTLET		LIGHT SWITCH		CEILING FAN (AS SELECTED BY OWNER)		VANITY LIGHTS
	WATERPROOF ELECTRICAL OUTDOOR OUTLET		THREE-WAY SWITCH		EXHAUST FAN (AS SELECTED BY OWNER)		LIGHT FIXTURE (AS SELECTED BY OWNER)
	ELECTRICAL OUTLET-GROUND FAULT CIRCUIT INTERRUPTER		FOUR-WAY SWITCH		SMOKE DETECTOR		DOUBLE HEAD SPOTLIGHT EXTERIOR LIGHT FIXTURE (AS SELECTED BY OWNER)
	ELEC. OUTLET MOUNTED HIGH FOR CATS/TV. VERIFY LOC. WITH OWNER		CAN LIGHTS		PENDANT LIGHTS		DOORBELL
	COUNTERTOP OUTLET		CHANDELIER LIGHT FIXTURE (AS SELECTED BY OWNER)				

PROPOSED LIGHTING LAYOUT
SCALE: 1/4" = 1'-0"

1845
Southeast

BARNDOMINIUMS
1845 CONSTRUCTION
HALLSVILLE, TX
(903) 935-9436

PROJECT NAME AND ADDRESS

CURTIS PETERMAN

SHEET CONTENTS

PROPOSED LIGHTING LAYOUT

REMARKS:

- BASED ON CLIENT/REQUEST DOCUMENT WITH MARK-UPS
UPLOADED ON BARNDOMINIUMS
GOOGLE DRIVE

REV 2	SEE REMARKS	09-24 2025
NO.	REVISION/ISSUE	DATE

APPROVED BY:

CURTIS PETERMAN
OWNER

PROJECT	000000	SHEET
DATE	9/24/25	5 OF 12
SCALE	1/4" = 1'-0"	

PROJECT NAME AND ADDRESS

CURTIS PETERMAN


SHEET CONTENTS

PROPOSED POWER LAYOUT

REMARKS:

- BASED ON CLIENT/REQUEST DOCUMENT WITH MARK-UPS
UPLOADED ON BARNDOMINIUMS
GOOGLE DRIVE



REV 2	SEE REMARKS	09-24 2025
NO.	REVISION/ISSUE	DATE
APPROVED BY:		
CURTIS PETERMAN OWNER		
PROJECT	00000	SHEET
DATE	9/24/25	6 OF 12
SCALE	1/4" = 1'-0"	

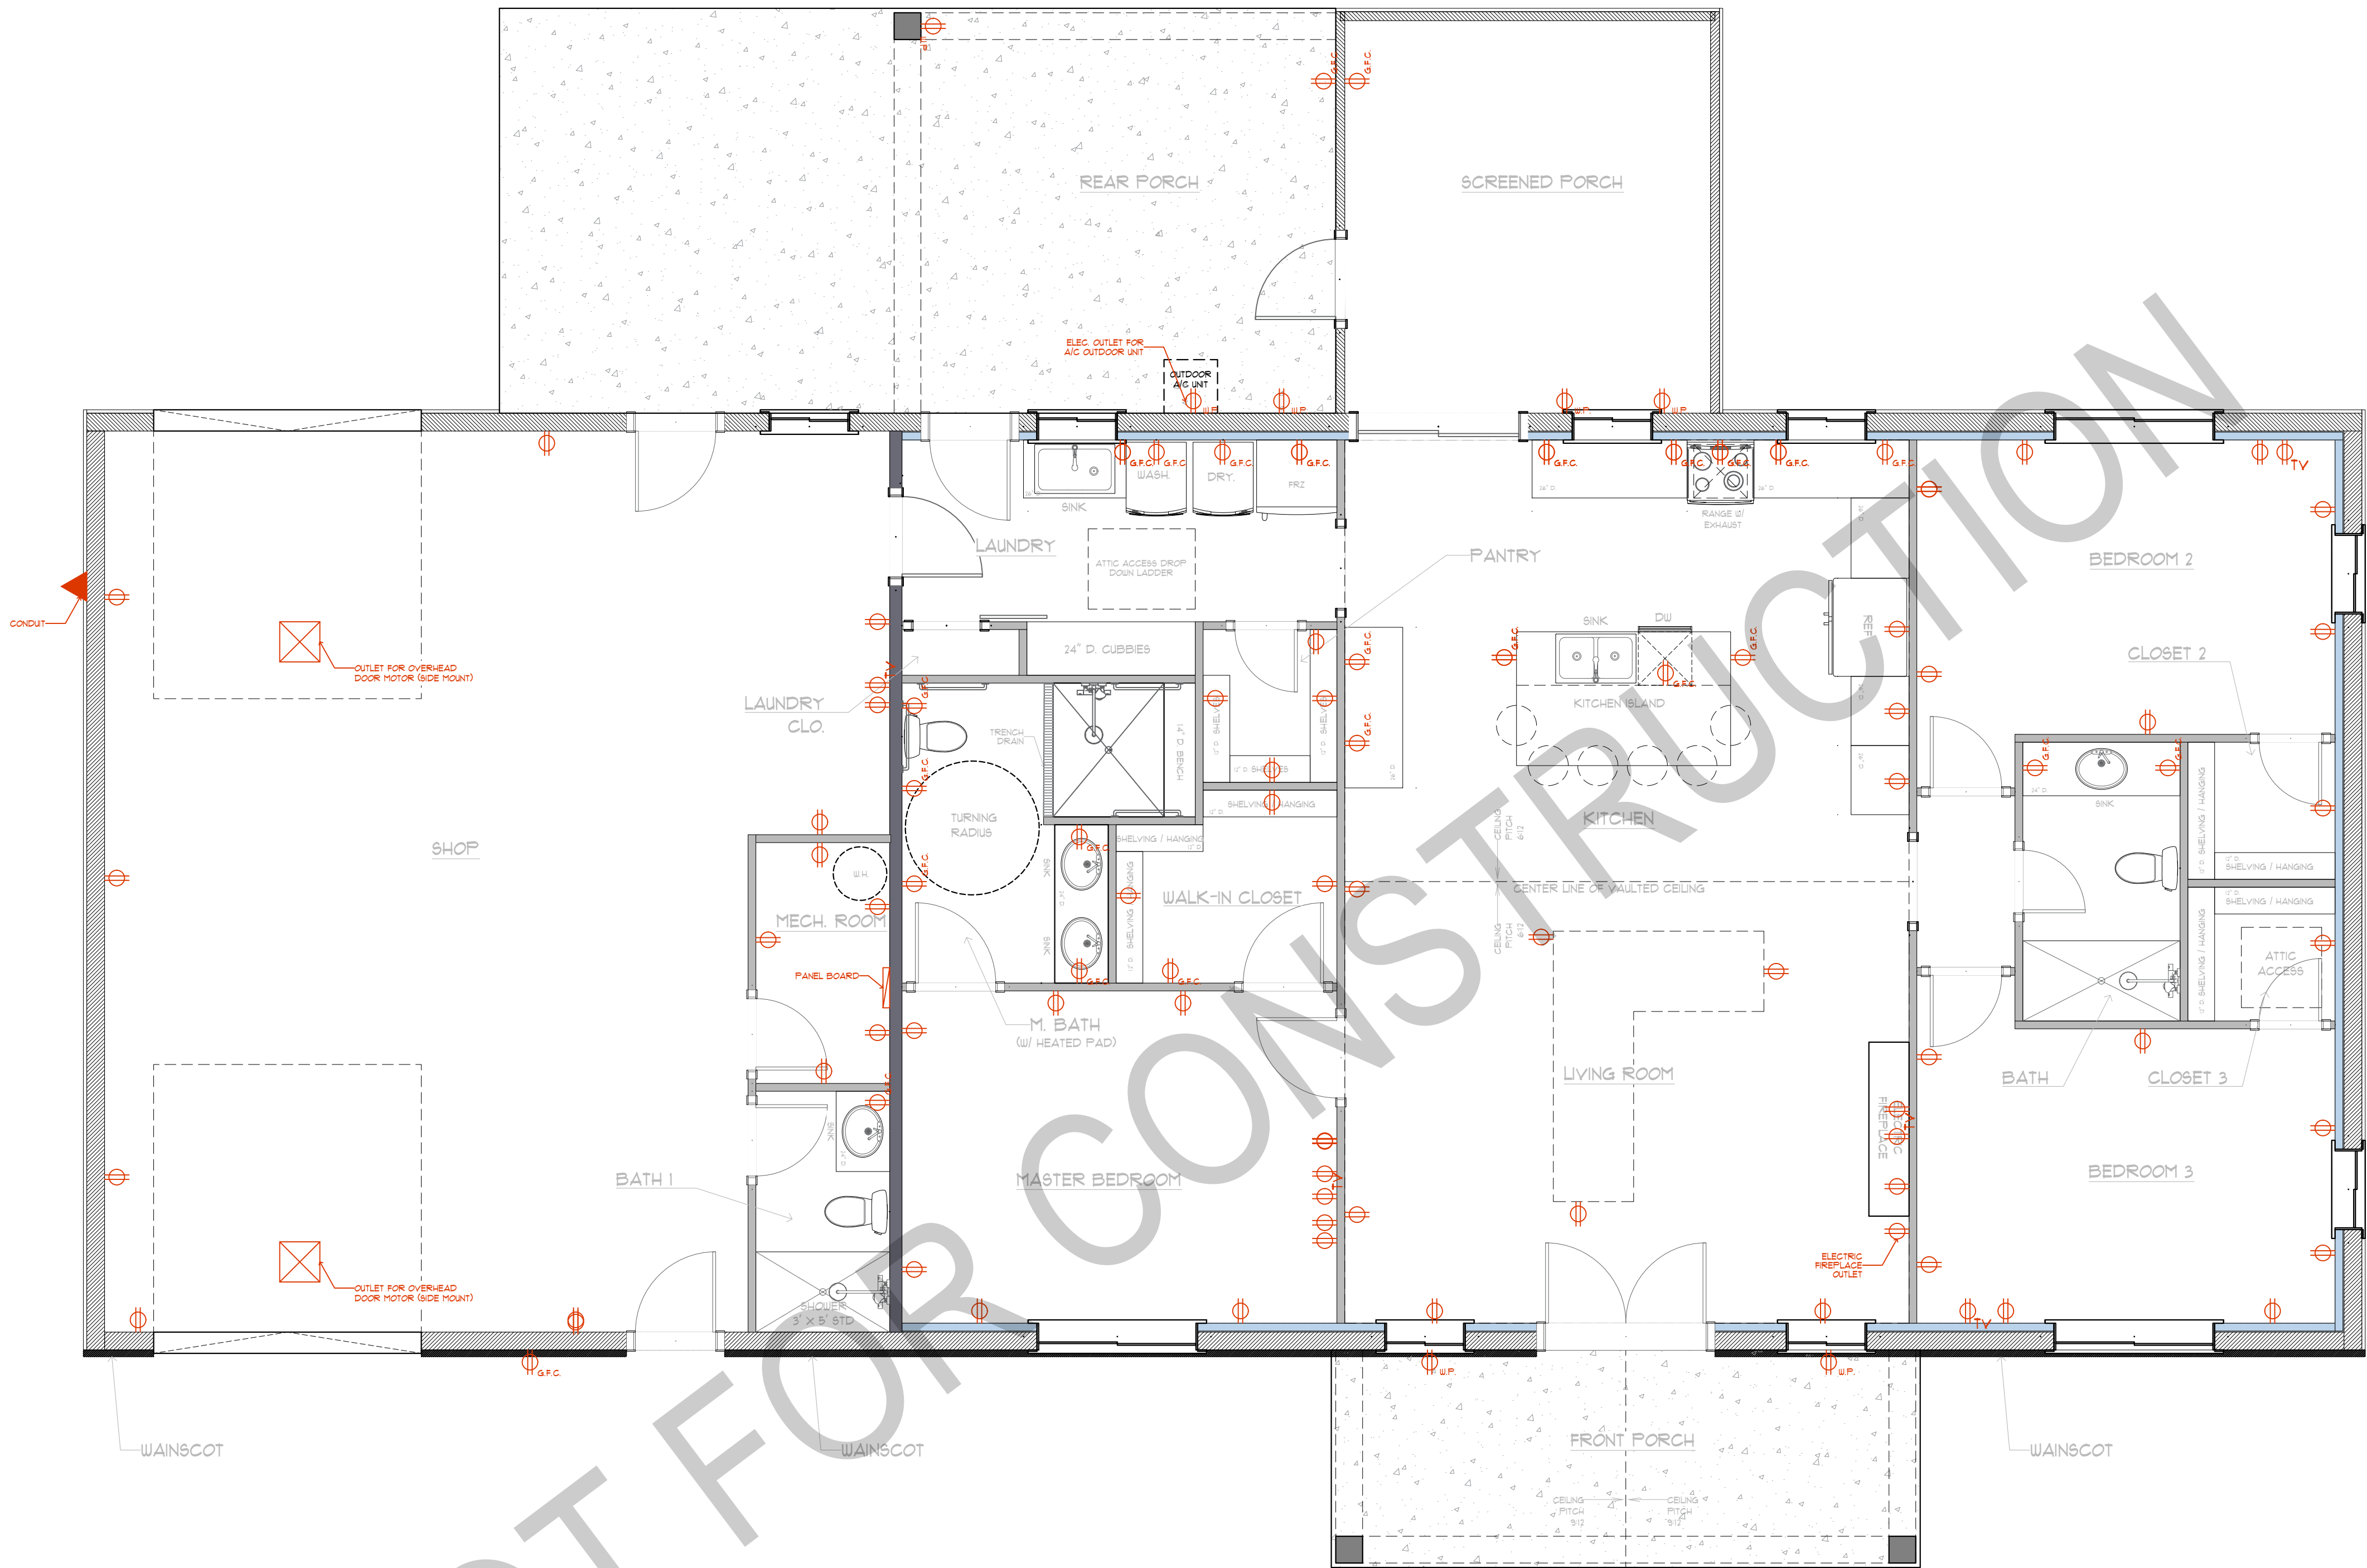


	ELECTRICAL OUTLET		LIGHT SWITCH		CEILING FAN (AS SELECTED BY OWNER)		VANITY LIGHTS
	WATERPROOF ELECTRICAL OUTDOOR OUTLET		THREE-WAY SWITCH		EXHAUST FAN (AS SELECTED BY OWNER)		LIGHT FIXTURE (AS SELECTED BY OWNER)
	ELECTRICAL OUTLET-GROUND FAULT CIRCUIT INTERRUPTER		FOUR-WAY SWITCH		SMOKE DETECTOR		DOUBLE HEAD SPOTLIGHT EXTERIOR LIGHT FIXTURE (AS SELECTED BY OWNER)
	ELEC. OUTLET MOUNTED HIGH FOR CATS/TV. VERIFY LOC. WITH OWNER		CAN LIGHTS		PENDANT LIGHTS		DOORBELL
	COUNTERTOP OUTLET		CHANDELIER LIGHT FIXTURE (AS SELECTED BY OWNER)				

PROPOSED POWER LAYOUT

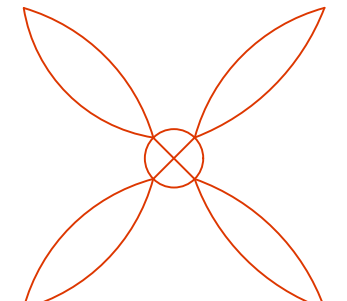 SCALE: 1/4" = 1'-0"

PLAN SYMBOL	DESCRIPTION	QUANTITY/PCS
	LIGHT SWITCH	31
	THREE-WAY SWITCH	2
	FOUR-WAY SWITCH	0
	CAN LIGHTS (INDOOR)	40
	CAN LIGHTS (OUTDOOR)	10
	CEILING FAN (AS SELECTED BY OWNER)	8
	EXHAUST FAN CONNECTED TO ERV (AS SELECTED BY OWNER)	3
	SMOKE DETECTOR	4
	PENDANT LIGHTS	3
	VANITY LIGHTS	4
	WALL LAMP (AS SELECTED BY OWNER)	9
	FLUORESCENT LIGHT (AS SELECTED BY OWNER)	6
	DOUBLE HEAD SPOTLIGHT EXTERIOR LIGHT FIXTURE (AS SELECTED BY OWNER)	0
	DOORBELL	0

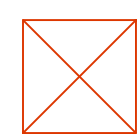PLAN SYMBOL	DESCRIPTION	QUANTITY/PCS
	ELECTRICAL OUTLET	60
	ELECTRICAL OUTLET (20 AMP)	0
	WATERPROOF ELECTRICAL OUTDOOR OUTLET	6
	DOUBLE GFCI OUTLET	0
	ELECTRICAL OUTLET-GROUND FAULT CIRCUIT INTERRUPTER	26
	ELEC. OUTLET MOUNTED HIGH (FOR CAT5/TV. VERIFY LOC. WITH OWNER)	5
	COUNTERTOP OUTLET	0
	OUTDOOR AC UNIT	1
	TANKLESS WATER HEATER	0
	ELECTRICAL SUB-PANEL	0
	HVAC OUTLET	1
	WATER HEATER OUTLET	1
	OVERHEAD DOOR OUTLET	2

PROPOSED LIGHTING AND POWER SCHEDULE

SCALE: CUSTOM



PROJECT NAME AND ADDRESS

CURTIS PETERMAN

-

SHEET CONTENTS

PROPOSED LIGHTING
AND POWER SCHEDULE

REMARKS:

- BASED ON CLIENT/REQUEST
DOCUMENT WITH MARK-UPS
UPLOADED ON BARNDOMINIUMS
GOOGLE DRIVE

REV 2	SEE REMARKS	03-24 2025
NO.	REVISION/ISSUE	DATE
APPROVED BY:		
CURTIS PETERMAN OWNER		
PROJECT	00000	SHEET 1 OF 12
DATE	9/24/25	
SCALE	CUSTOM	

PROJECT NAME AND ADDRESS
CURTIS PETERMAN

SHEET CONTENTS

PROPOSED PLUMBING PLAN

REMARKS
- BASED ON CLIENT/REQUEST
DOCUMENT WITH MARK-UPS
UPLOADED ON BARNDOMINIUMS
GOOGLE DRIVE


REV	2	SEE REMARKS	03-24 2025
NO.	REVISION/ISSUE		DATE






APPROVED BY:








CURTIS PETERMAN
OWNER




PROJECT	000000	SHEET	8 OF 12
DATE	9/24/25		
SCALE	1/4" = 1'-0"		

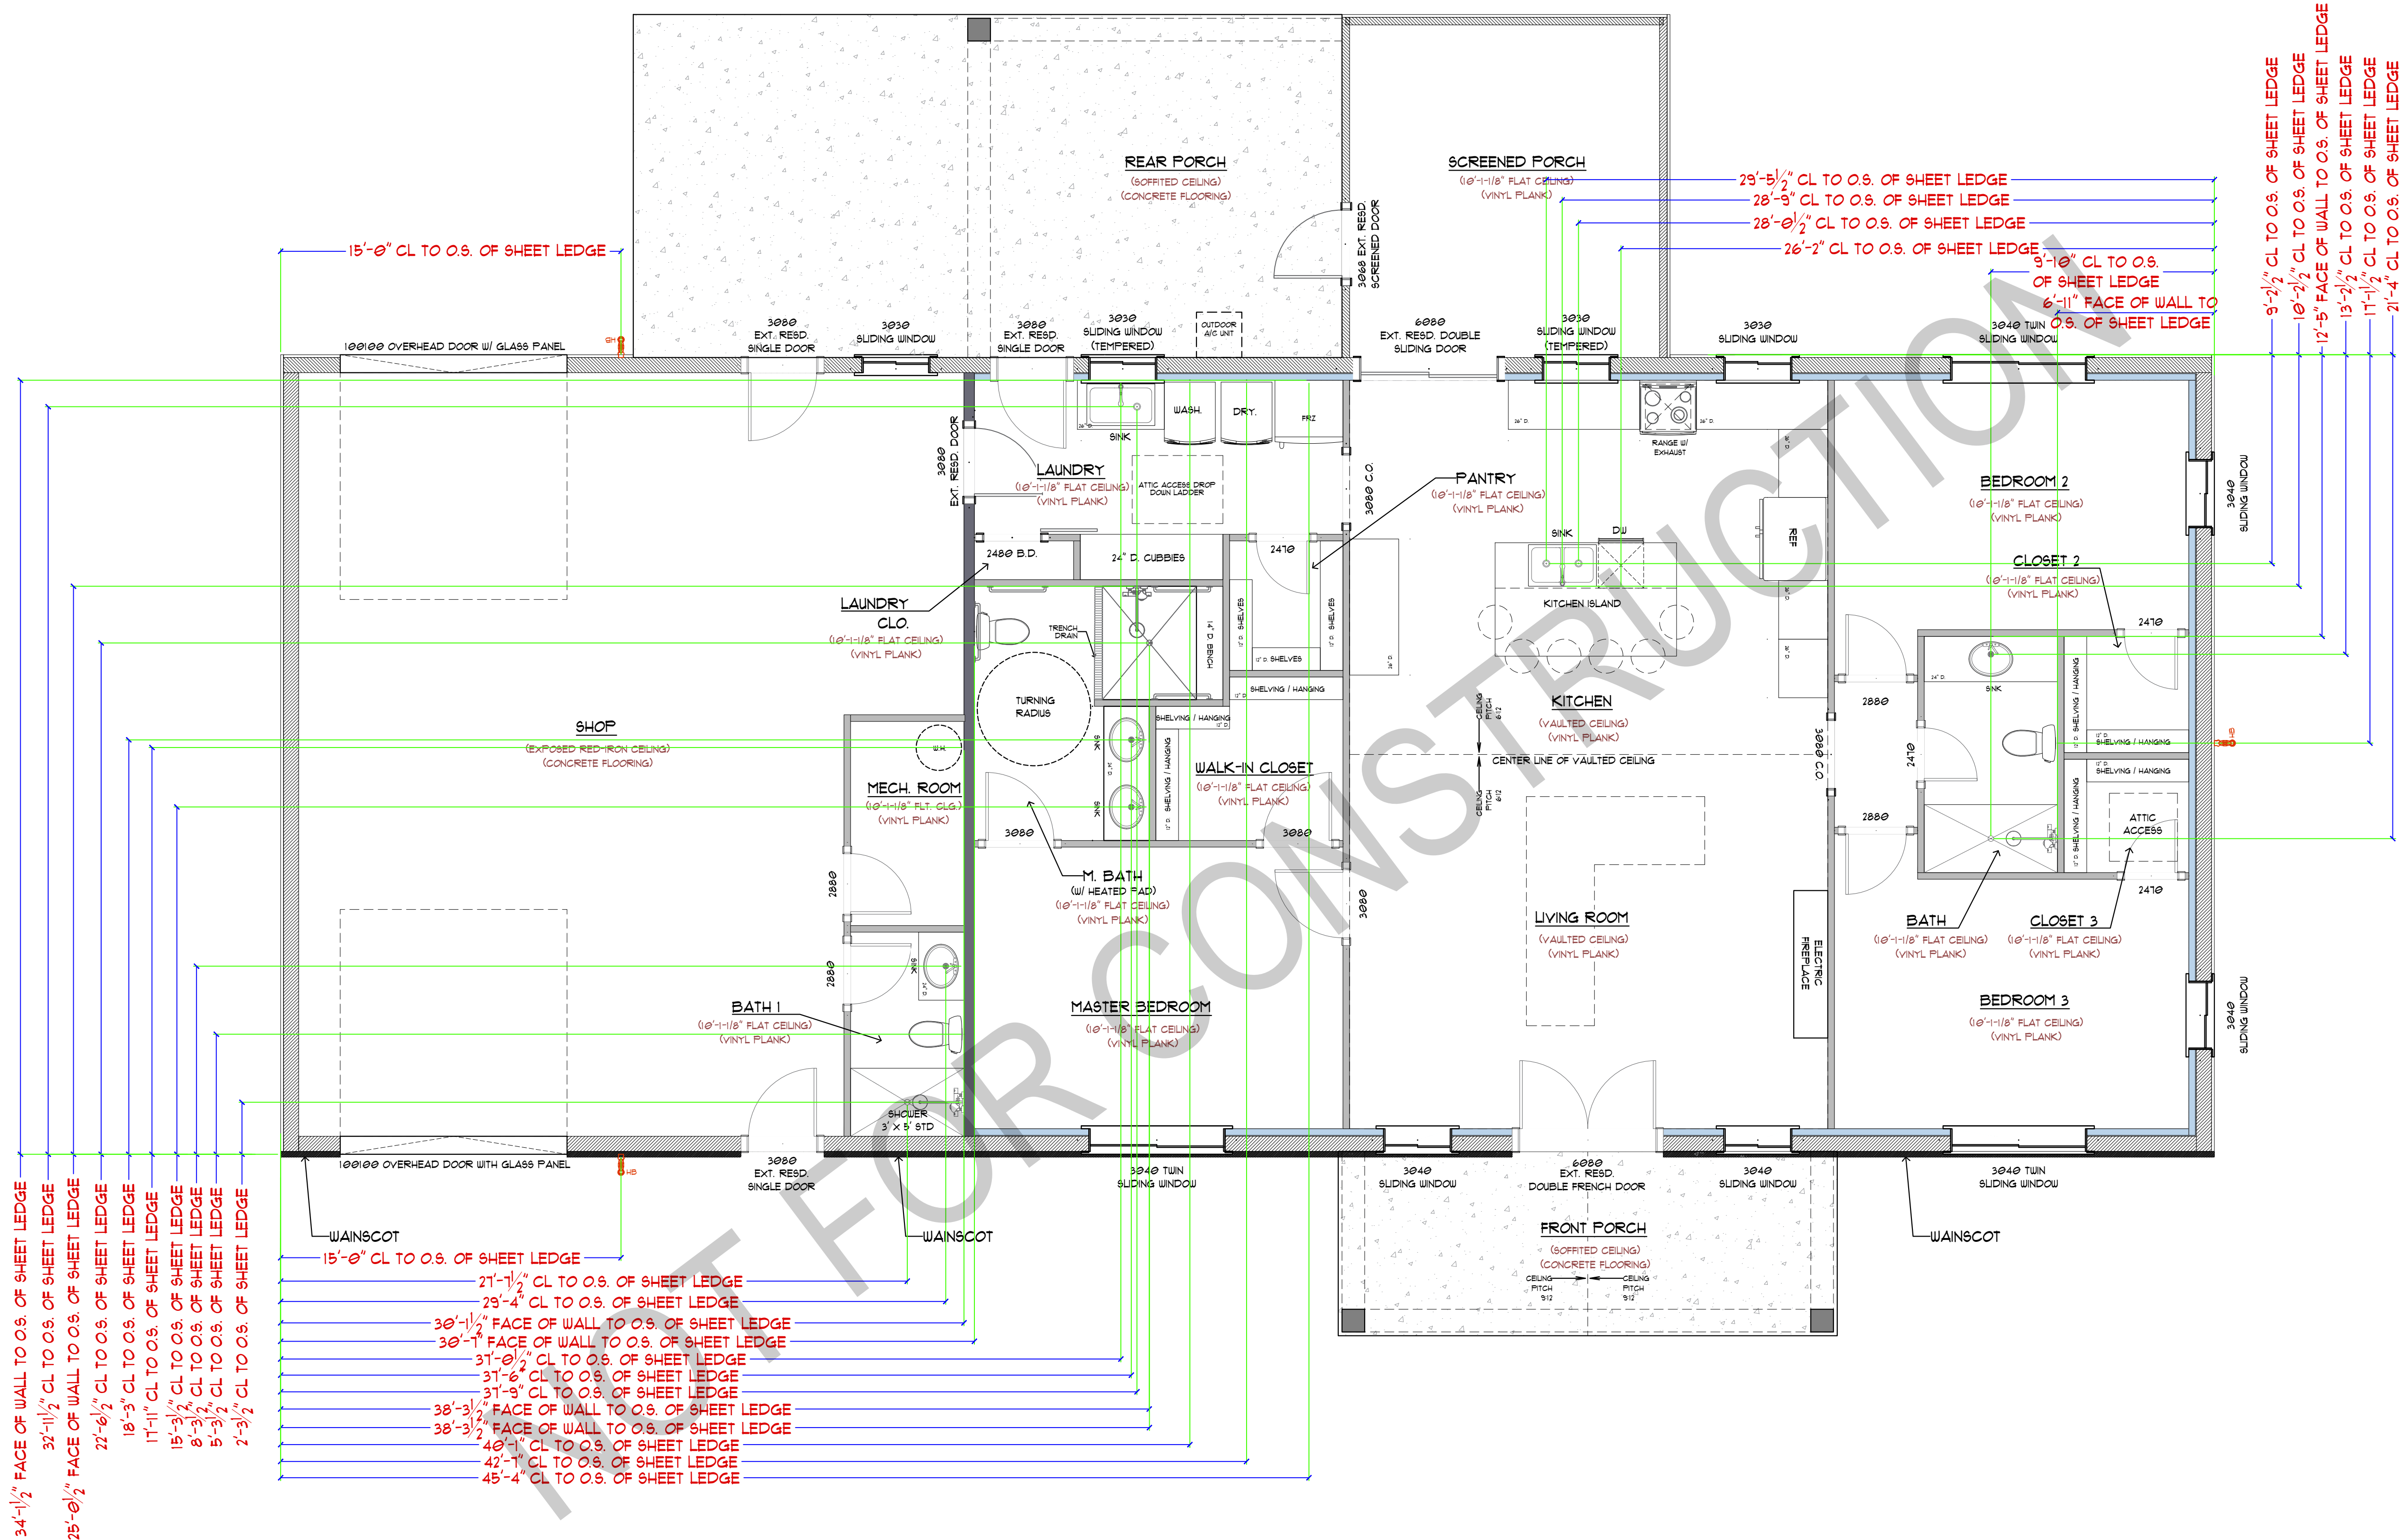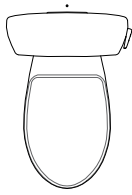 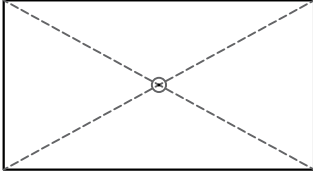 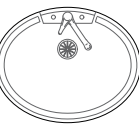PROPOSED PLUMBING PLAN
SCALE: 1/4" = 1'-0"



PLAN SYMBOL	DESCRIPTION	QUANTITY/PCS
	TOILET	3
	SHOWER SET	3
	SHOWER DRAIN	3
	SHOWER DRAIN (TROUGH TYPE)	1
	WASHER	1
	DRYER	1
	TANKLESS WATER HEATER	0
	VANITY SINK/LAVATORY	4

 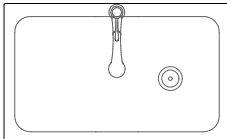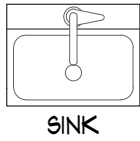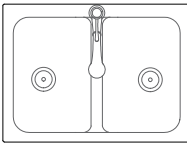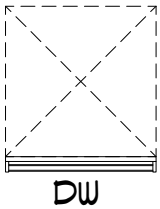 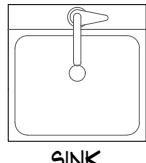PLAN SYMBOL	DESCRIPTION	QUANTITY/PCS
	VANITY SINK/LAVATORY (VESSEL TYPE)	0
	SINK (FARMHOUSE TYPE)	1
	WALL MOUNTED SINK	0
	DOUBLE SINK	1
	DISHWASHER	1
	WATER HYDRANT	0
	RV WATER HYDRANT AND SEWER HOOKUP	0
	RECTANGULAR SINK	0

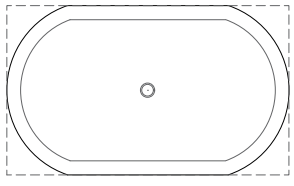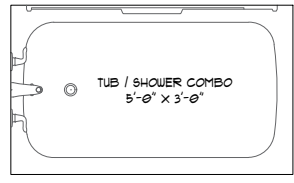 PLAN SYMBOL	DESCRIPTION	QUANTITY/PCS
	FREE STANDING TUB	0
	TUB/SHOWER COMBO	0
	REFRIGERATOR WITH ICE MAKER (DOUBLE DOOR)	0
	REFRIGERATOR WITH ICE MAKER (SINGLE DOOR)	0
	POT FILLER	0
	HOSE BIBB	3
	GAS STUB OUT	0
	WATER STUB OUT	1

PROPOSED PLUMBING SCHEDULE
SCALE: CUSTOM



PROJECT NAME AND ADDRESS

CURTIS PETERMAN

SHEET CONTENTS

PROPOSED PLUMBING SCHEDULE


REMARKS:
- BASED ON CLIENT/REQUEST DOCUMENT WITH MARK-UPS
UPLOADED ON BARNDOMINIUMS
GOOGLE DRIVE

REV 2	SEE REMARKS	09-24 2025
NO.	REVISION/ISSUE	DATE
APPROVED BY: CURTIS PETERMAN OWNER		
PROJECT	00000	9 OF 12
DATE	9/24/25	
SCALE	CUSTOM	

PROPOSED DOORS SCHEDULE


SCALE: 1/2" = 1'-0"

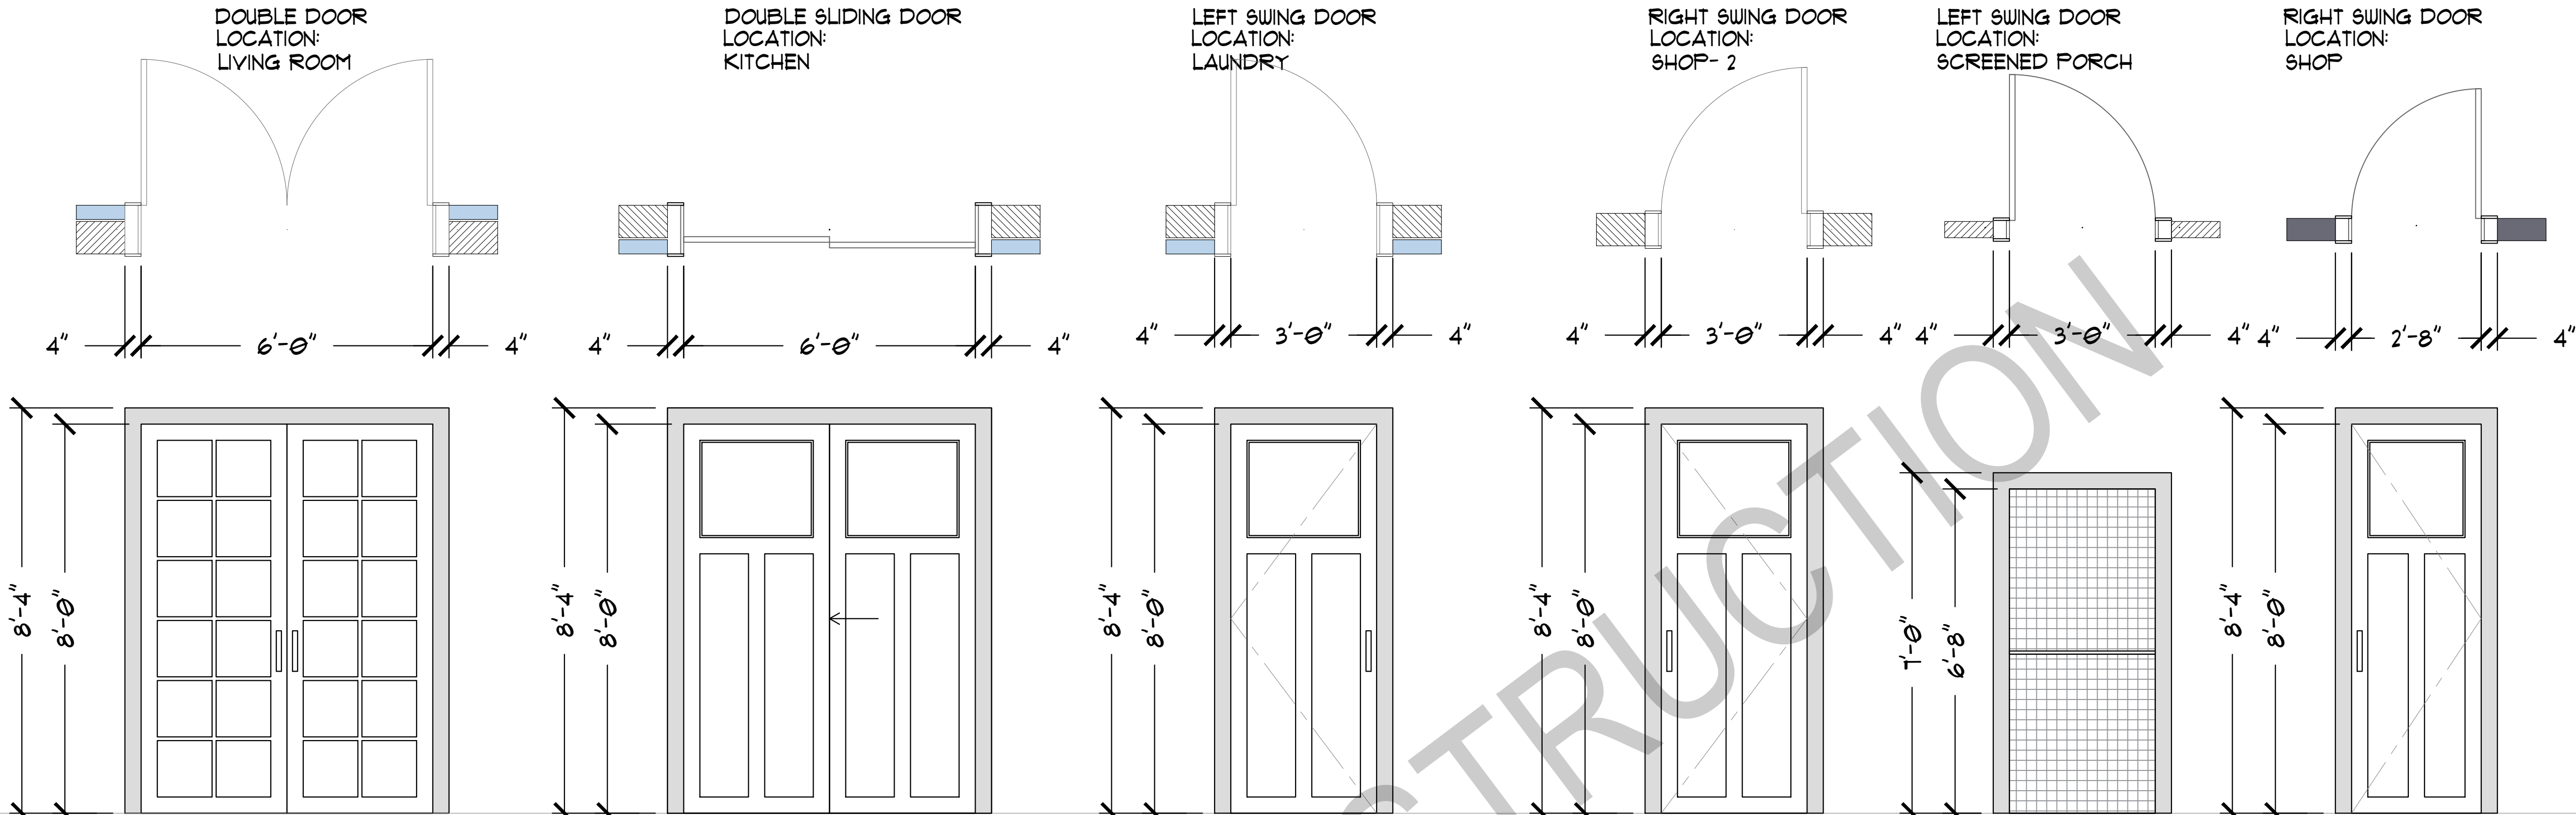*PLANS



DOOR TYPE:	DOUBLE PANEL DOOR (EXT.)	DOUBLE SLIDING DOOR (EXT.)	SINGLE PANEL DOOR (EXT.)	SINGLE PANEL DOOR (EXT.)	SINGLE SCREENED DOOR	SINGLE PANEL DOOR
DOOR TAG	6080	6080	3080	3080	3080	3080
NUMBER OF PCS:	1 PC	1 PC	1 PC	2 PCS	1 PC	1 PC
DOOR TRIM:	-	-	-	-	-	-

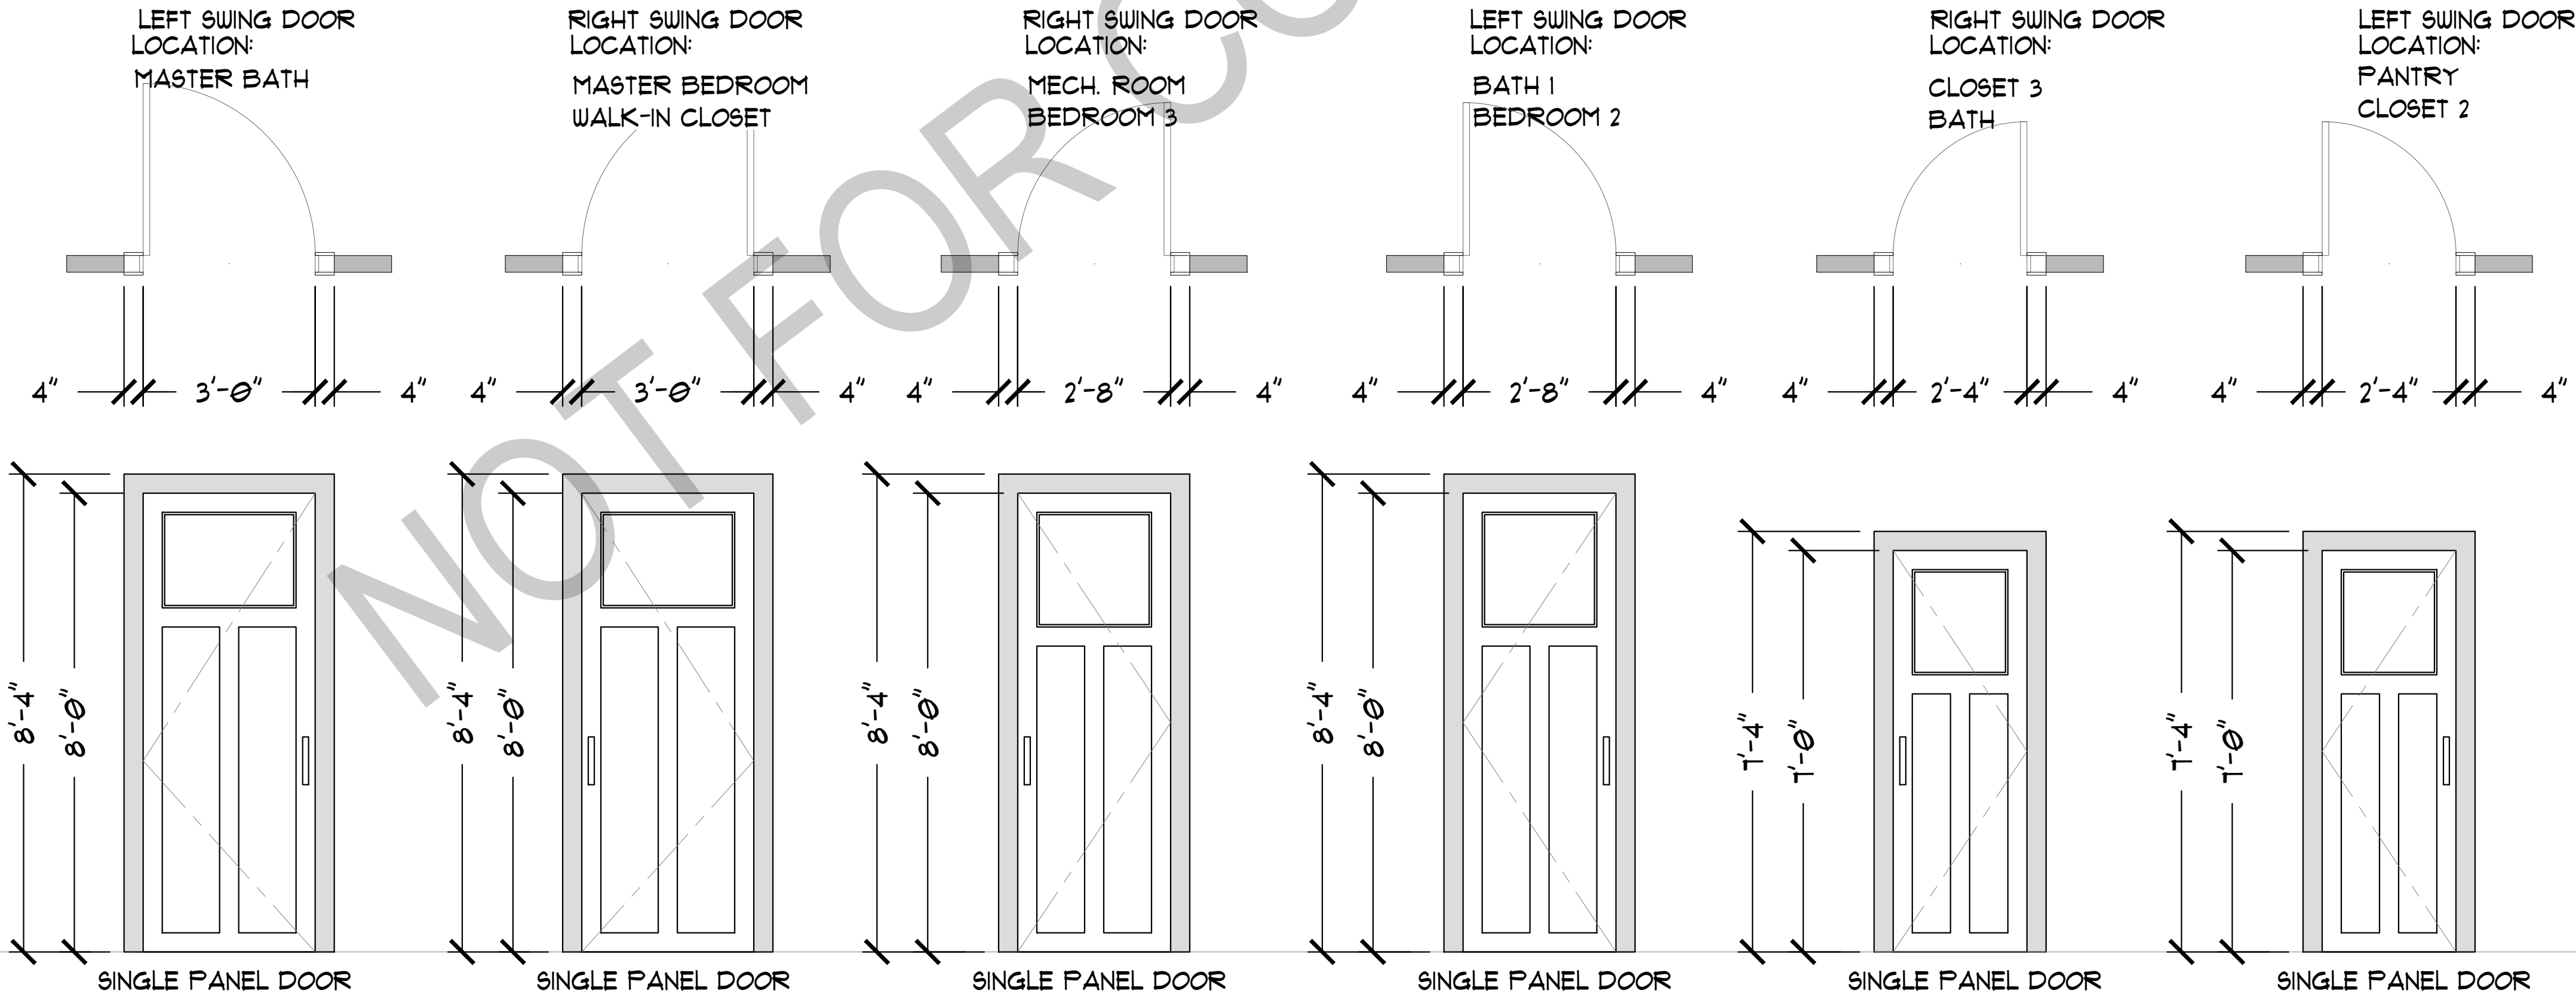*PLANS



DOOR TYPE:	SINGLE PANEL DOOR	SINGLE PANEL DOOR	SINGLE PANEL DOOR	SINGLE PANEL DOOR	SINGLE PANEL DOOR	SINGLE PANEL DOOR
DOOR TAG	3080	3080	2880	2880	2470	2470
NUMBER OF PCS:	1 PC	2 PCS	2 PCS	2 PCS	2 PCS	2 PCS
DOOR TRIM:	-	-	-	-	-	-



PROJECT NAME AND ADDRESS

CURTIS PETERMAN

SHEET CONTENTS

PROPOSED DOORS SCHEDULE

REMARKS:

- BASED ON CLIENT/REQUEST DOCUMENT WITH MARK-UPS
UPLOADED ON BARNDOMINIUMS
GOOGLE DRIVE

REV 2	SEE REMARKS	09-24 2025
NO.	REVISION/ISSUE	DATE

APPROVED BY:


CURTIS PETERMAN
OWNER

PROJECT	00000	SHEET
DATE	9/24/25	10 OF 12
SCALE	1/2" = 1'-0"	

PROPOSED DOORS SCHEDULE

SCALE: 1/2" = 1'-0"

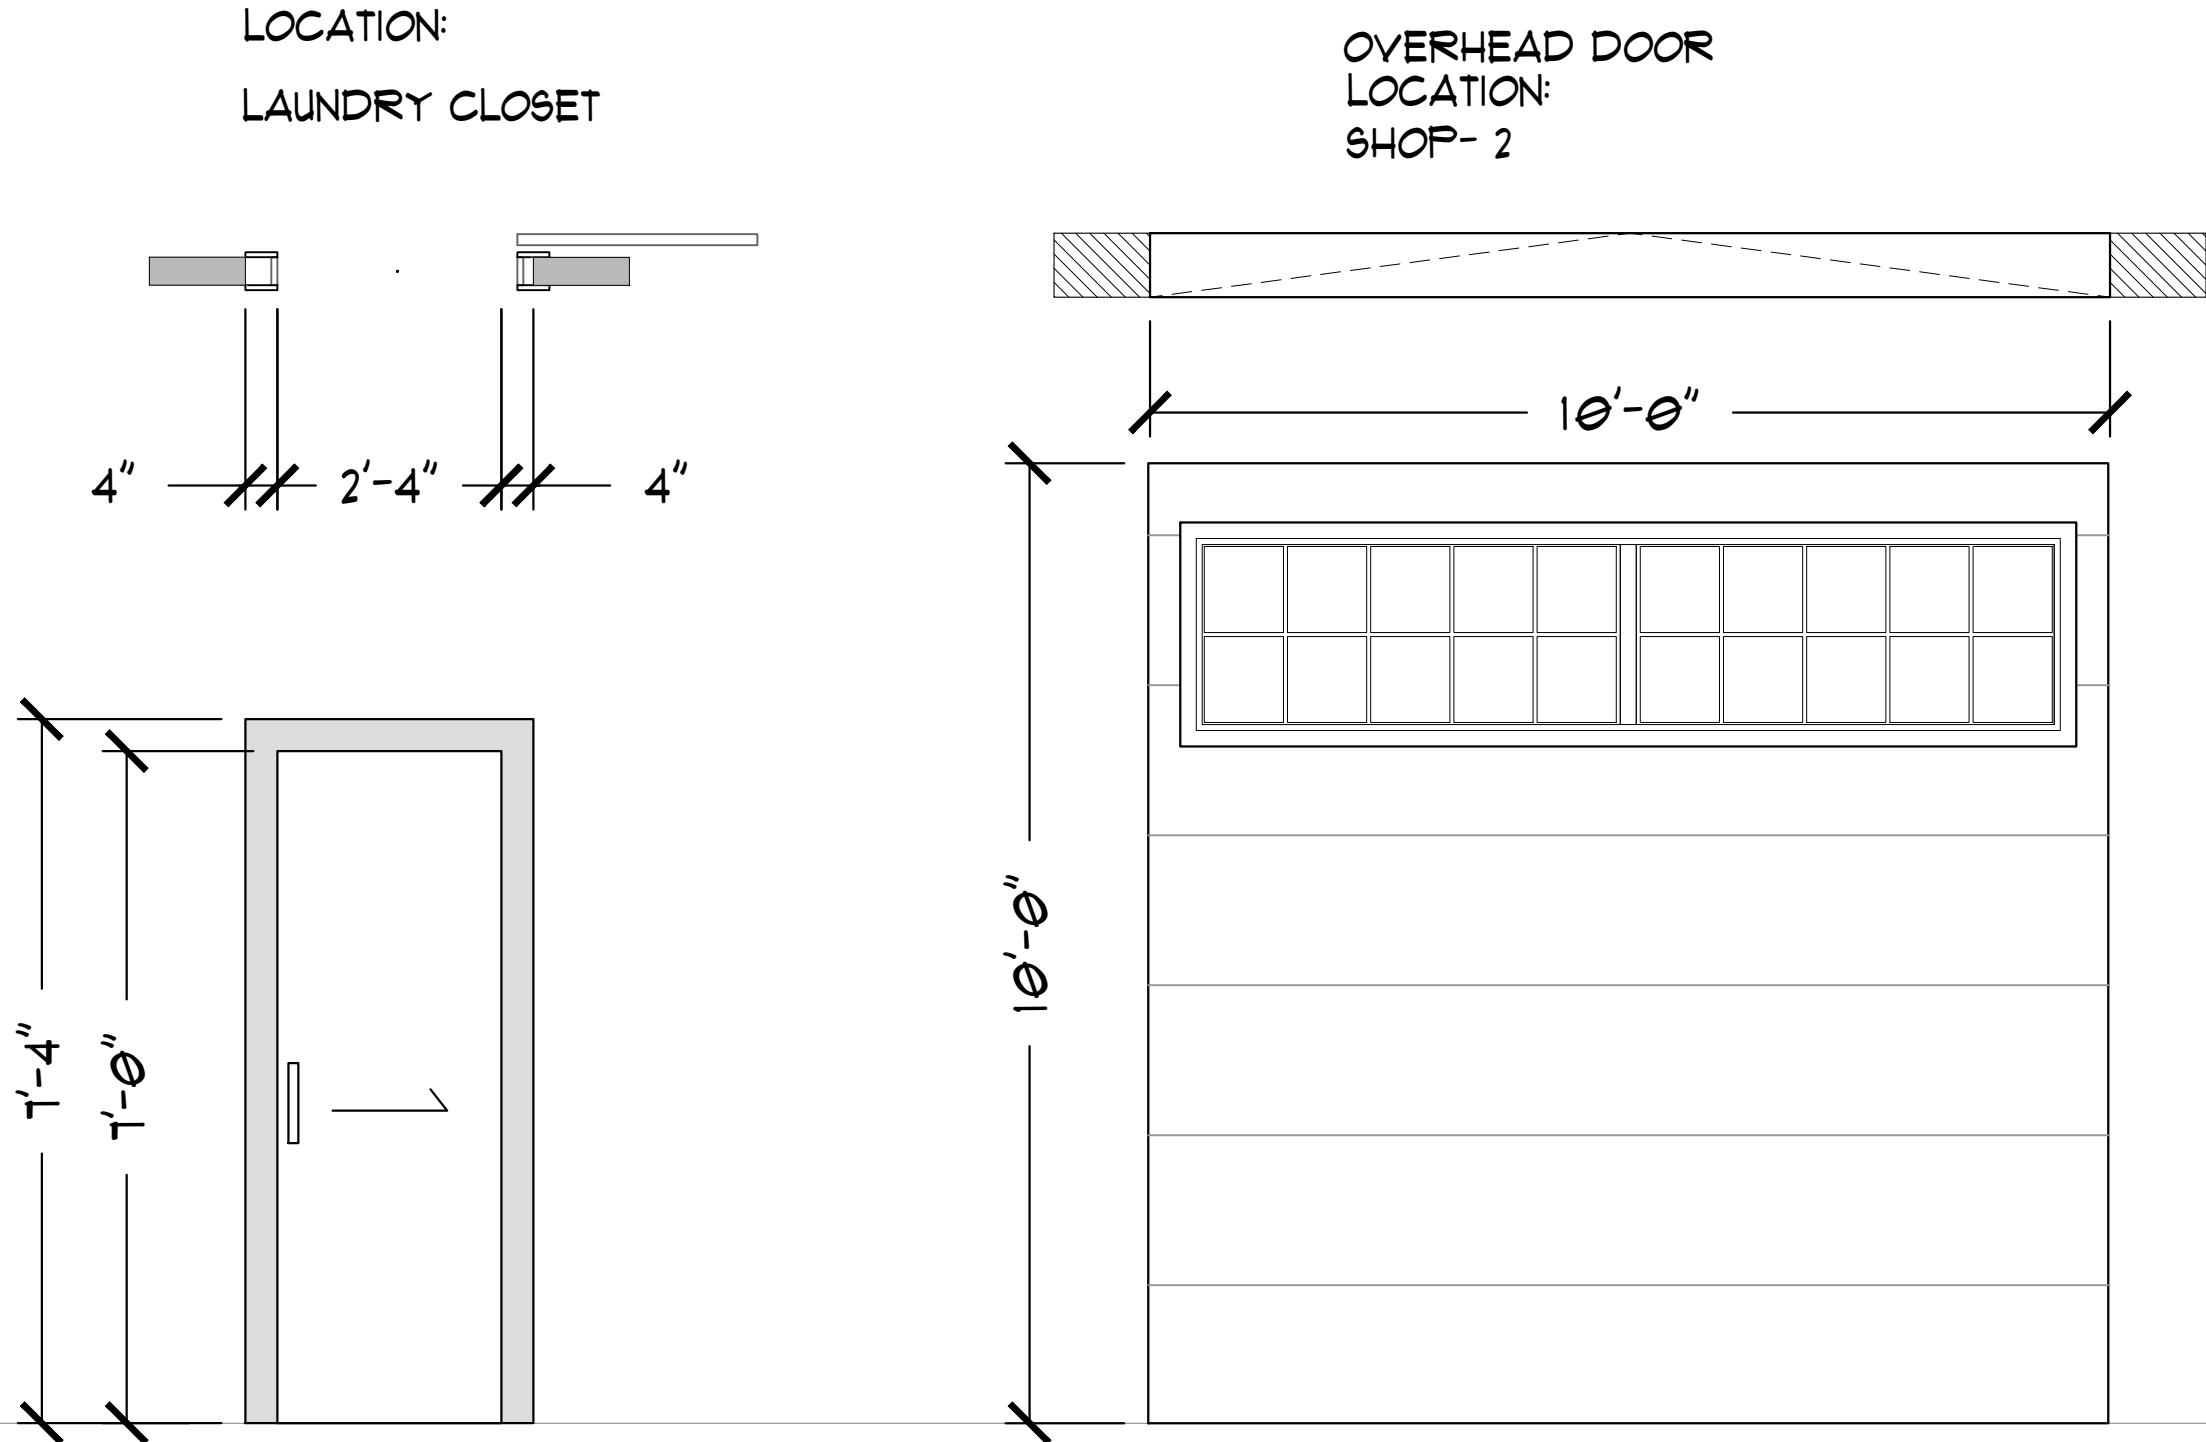*PLANS




TOTAL DOORS: 19
TOTAL OHD: 2

DOOR TYPE:	BARN DOOR	OVERHEAD DOOR WITH GLASS PANELS
DOOR TAG	2480	100100 OHD
NUMBER OF PCS:	1 PC	2 PCS
DOOR TRIM:	-	-

PROPOSED WINDOWS SCHEDULE

SCALE: 1/2" = 1'-0"

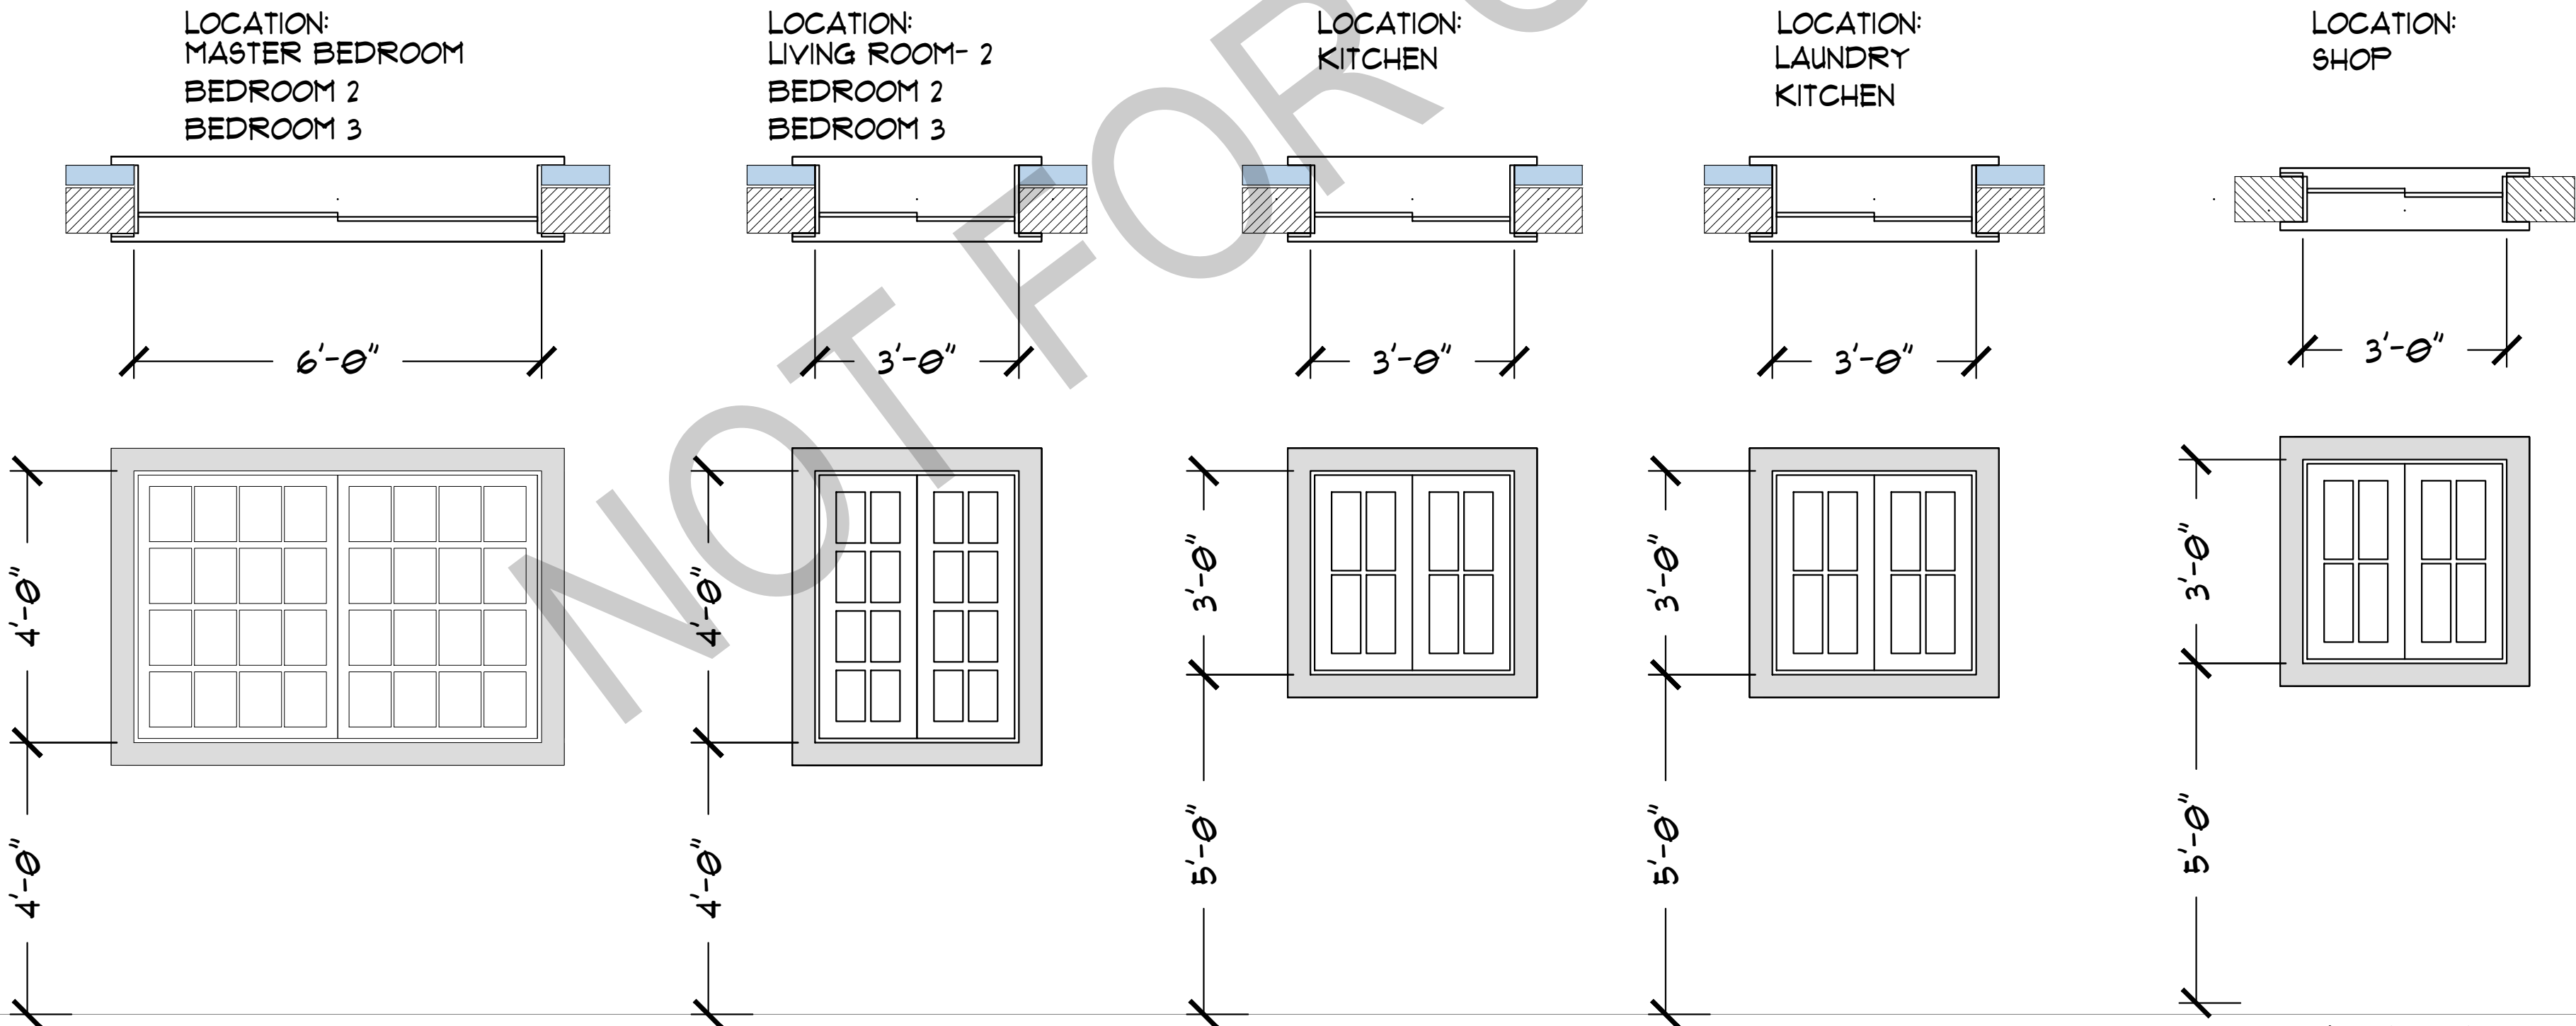*PLANS



TOTAL WINDOWS: 11

WINDOW TYPE:	SLIDING WINDOW	SLIDING WINDOW	SLIDING WINDOW	SLIDING WINDOW (TEMPERED)	SLIDING WINDOW
WINDOW TAG	3040 TWIN	3040	3030	3030	3030
NUMBER OF PCS:	3 PCS	4 PCS	1 PC	2 PCS	1 PC
WINDOW TRIM:	-	-	-	-	-



PROJECT NAME AND ADDRESS

CURTIS PETERMAN


SHEET CONTENTS

PROPOSED DOORS AND
WINDOWS SCHEDULE

REMARKS

- BASED ON CLIENT/REQUEST
DOCUMENT WITH MARK-UPS
UPLOADED ON BARNDOMINIUMS
GOOGLE DRIVE

REV 2	SEE REMARKS	03-24 2025
NO.	REVISION/ISSUE	DATE
APPROVED BY:		
CURTIS PETERMAN OWNER		
PROJECT	00000	SHEET 11 OF 12
DATE	9/24/25	
SCALE	1/2" = 1'-0"	

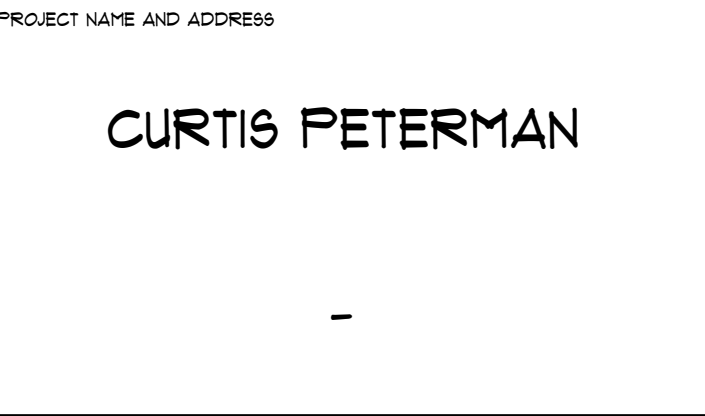

- BASED ON CLIENT/REQUEST DOCUMENT WITH MARK-UPS
- UPLOADED ON BARNDOMINIUMS GOOGLE DRIVE

REV 2	SEE REMARKS	09-24 2025
NO.	REVISION/ISSUE	DATE

APPROVED BY:

CURTIS PETERMAN

OWNER

PROJECT	SHEET 12 OF 12
DATE	
SCALE	

00000

9/24/25

1" = 1'-0"