


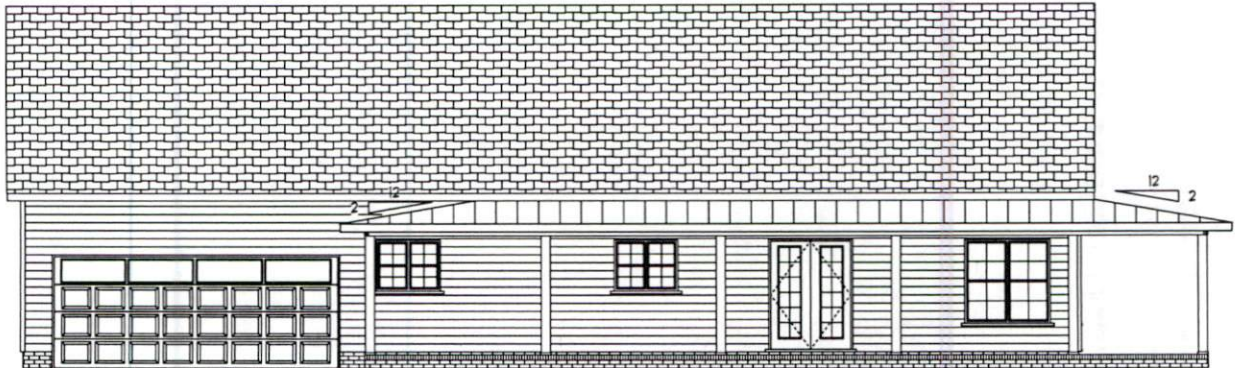


Front Elevation

Scale: 3/16" = 1'0"




Left Elevation

Scale: 3/16" = 1'0"

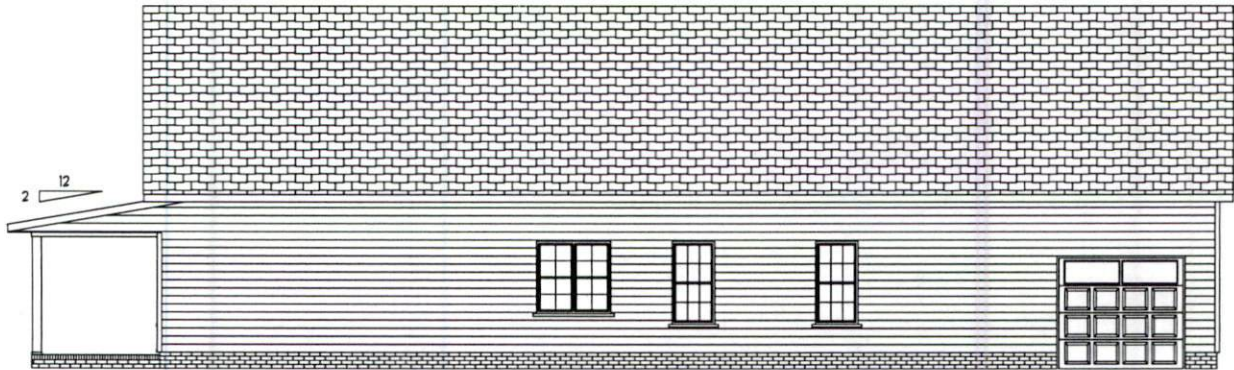

Right Elevation

Scale: 3/16" = 1'0"

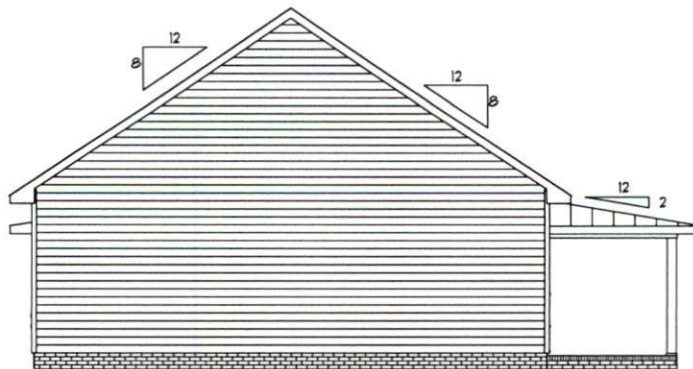

Rear Elevation

Scale: 3/16" = 1'0"

Delacruz Home Plans

SCALE: 1/4"

DRAWN BY


APPROVED

DATE: 10/14/2025


REVISED

DRAWING*

Base Design
2121 Chimney Pt.
Linden, N.C. 28356
910-263-0403

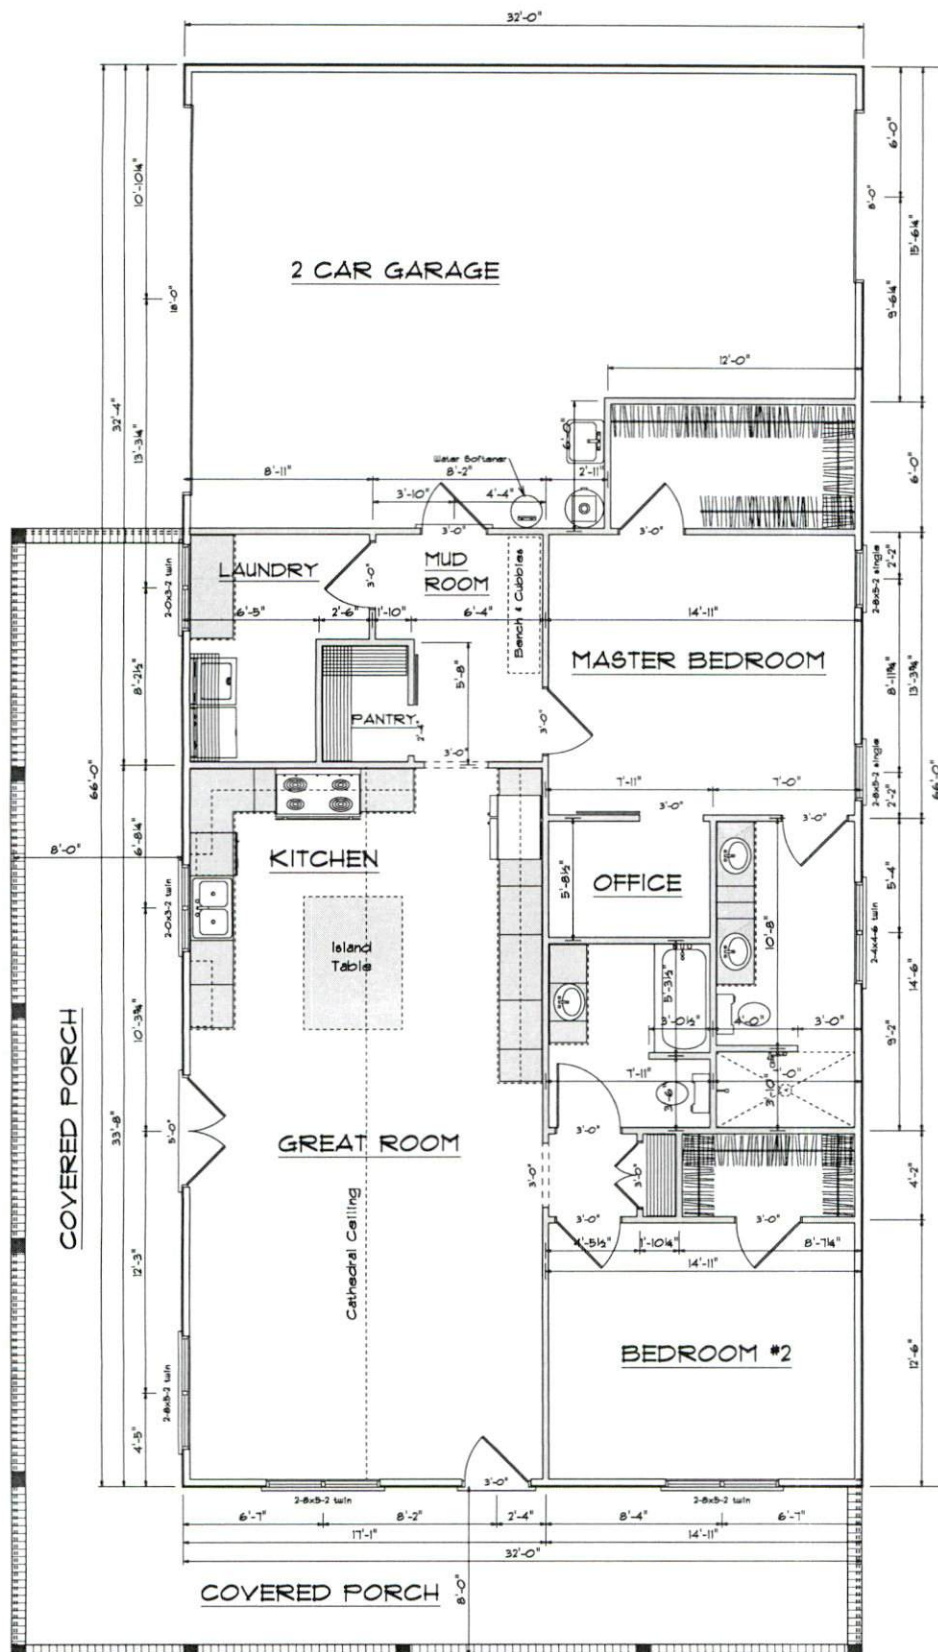

Kitchen Cabinets

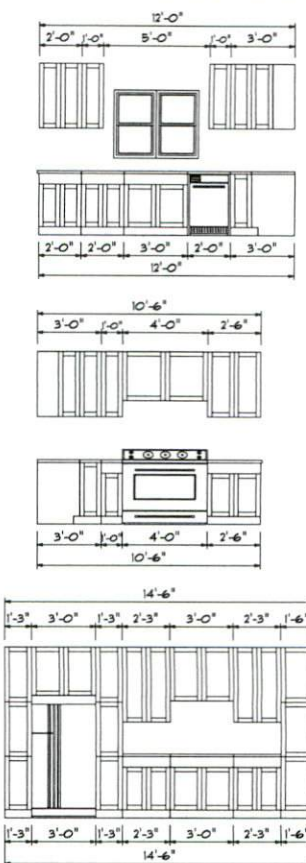

OPENING SCHEDULE			
PRODUCT CODE	SIZE	HINGE	COUNT
20x32 twin	4'-0" x 3'-2"	NN	3
24x46 twin	4'-8" x 4'-6"	NN	1
28x52 single	2'-8" x 5'-2"	N	2
28x52 twin	5'-4" x 5'-2"	NN	3
3-0 Door Unit	3'-0"	L	5
3-0 Door Unit	3'-0"	R	3
3-0 Doublehung Door Unit	3'-0"	LR	1
28x80 BARN DOOR	2'-4"	L	1
36x80 BARN DOOR	3'-0"	L	1
36x80 FRENCH A 1	3'-0"	R	1
60x80 FRENCH A 2	5'-0"	LR	1
96X84 - 4 PANEL - GARAGE DOOR	8'-0"	N	1
192X84 - 8 PANEL GARAGE DOOR	18'-0"	N	1

Areas

1509 Heated Sq.Ft.
613 Garage Sq.Ft.
683 Covered Porch Sq.Ft.

Floor Plan


Scale: 1/4" = 1'-0"

Delacruz Home Plans

SCALE: 1/4"
DRAWN BY
APPROVED

DATE: 10/14/2025
REVISED
DRAWING*


Base Designs
2121 Chimney Pt.
Linden, N.C. 28356
910-263-0403

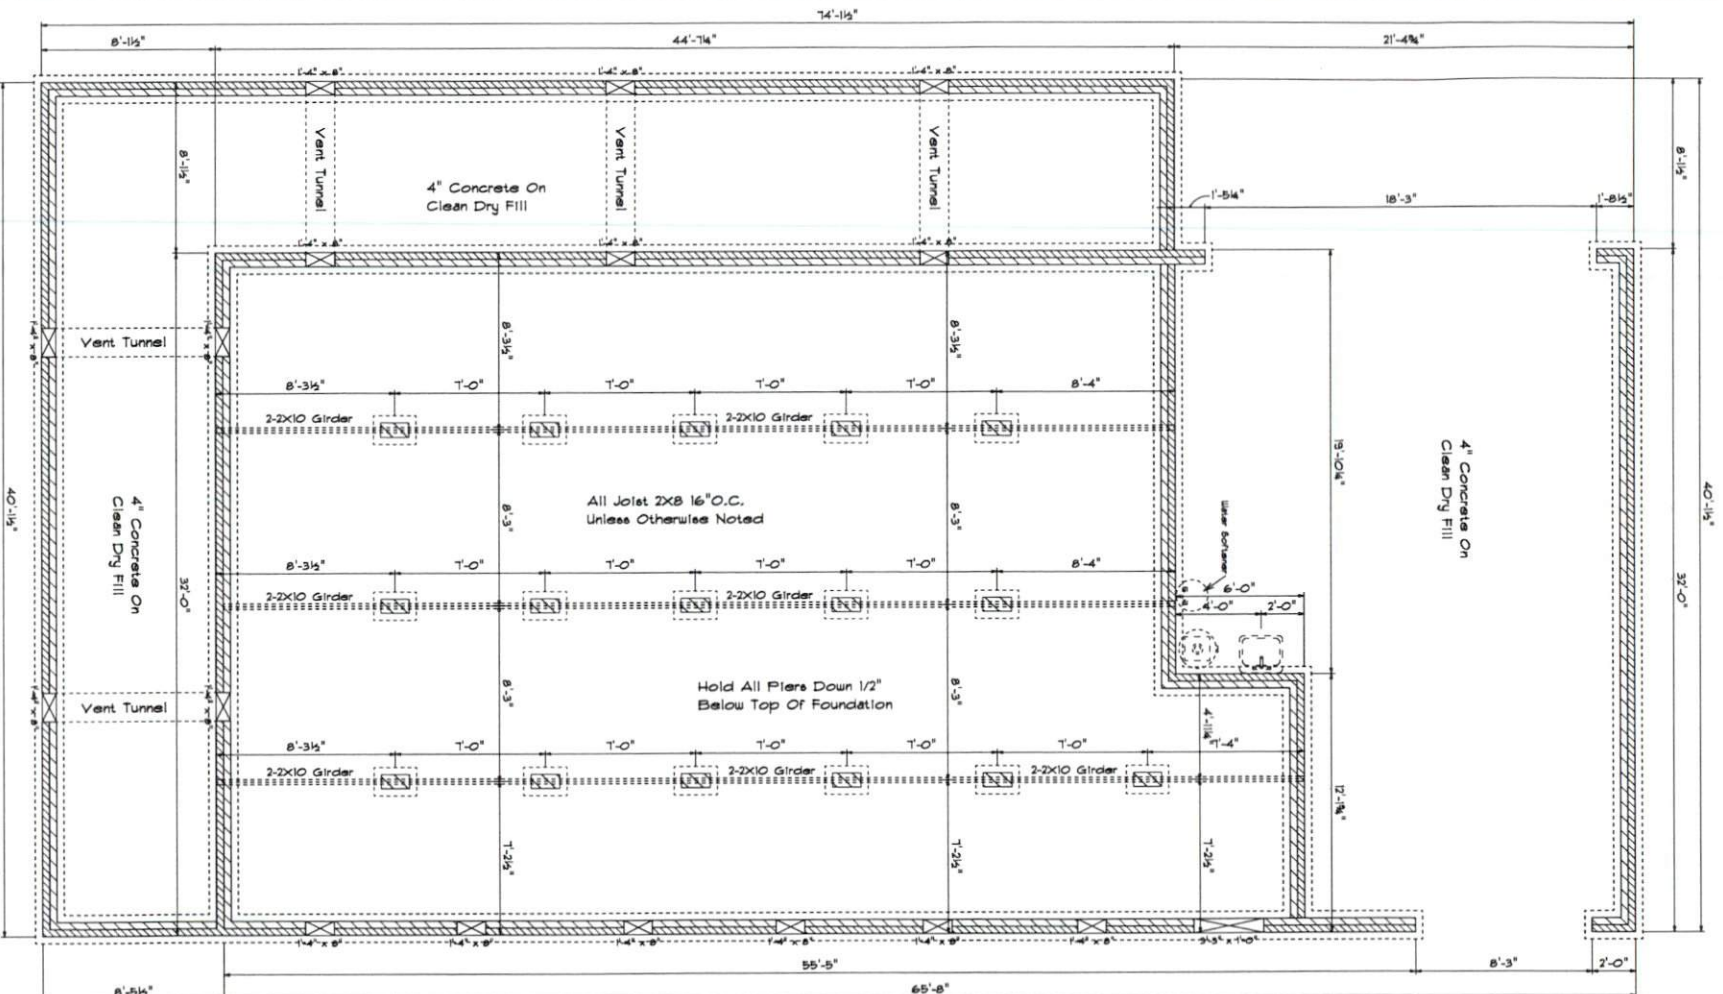


Foundation Plan

Scale: 1/4" = 1'-0"

Foundation Detail

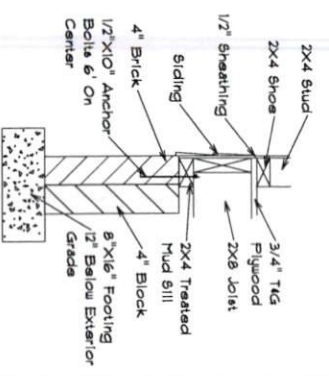


Footing & Pier Detail

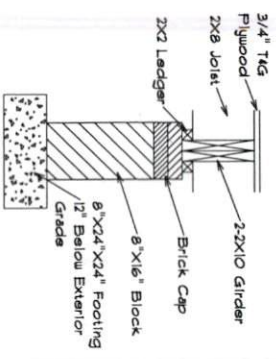


FOUNDATION VENTILATION

1509 Sq.Ft. Foundation Area
Requires 10,06 Sq.Ft. Ventilation.
With 6 Mill. Poly. Plans Indicate
Vents For Adequate Cross
Ventilation.

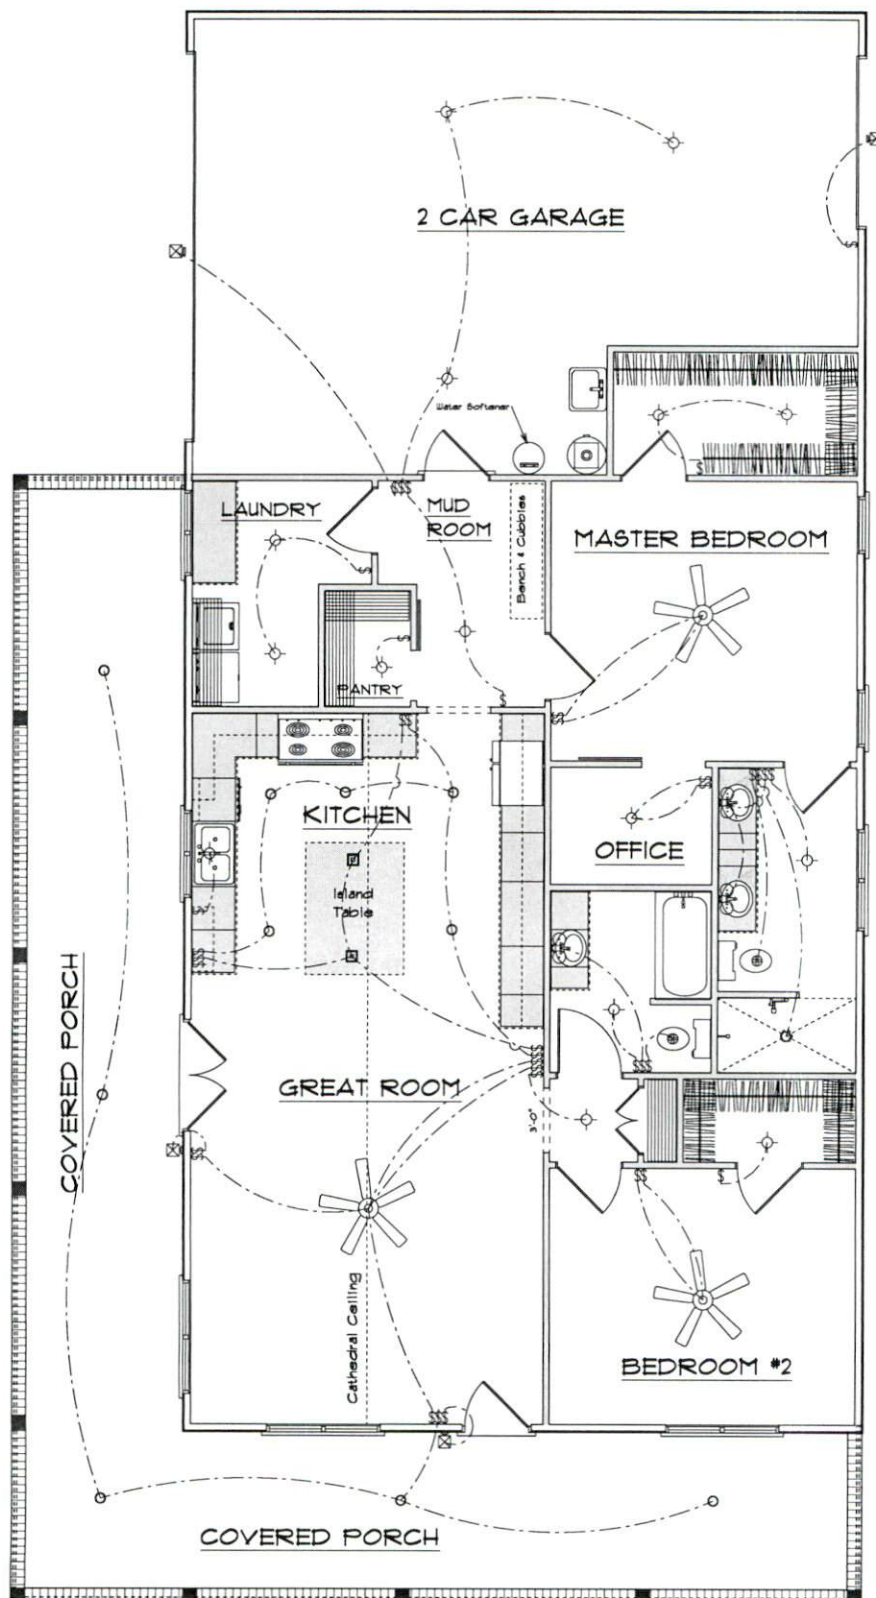


ELECTRICAL LEGEND		
ELECTRICAL	COUNT	SYMBOL
can light 6inch	11	○
ceiling fan 5 bladed 01	3	⊗
exterior light 02	6	⊗
fan	2	⊗
light	15	○
pendant large	2	⊗
switch	8	⊗
switch double	5	⊗
switch quad	2	⊗
switch triple	4	⊗
wall mounted 01 2 lights	3	⊗

Electrical Plan

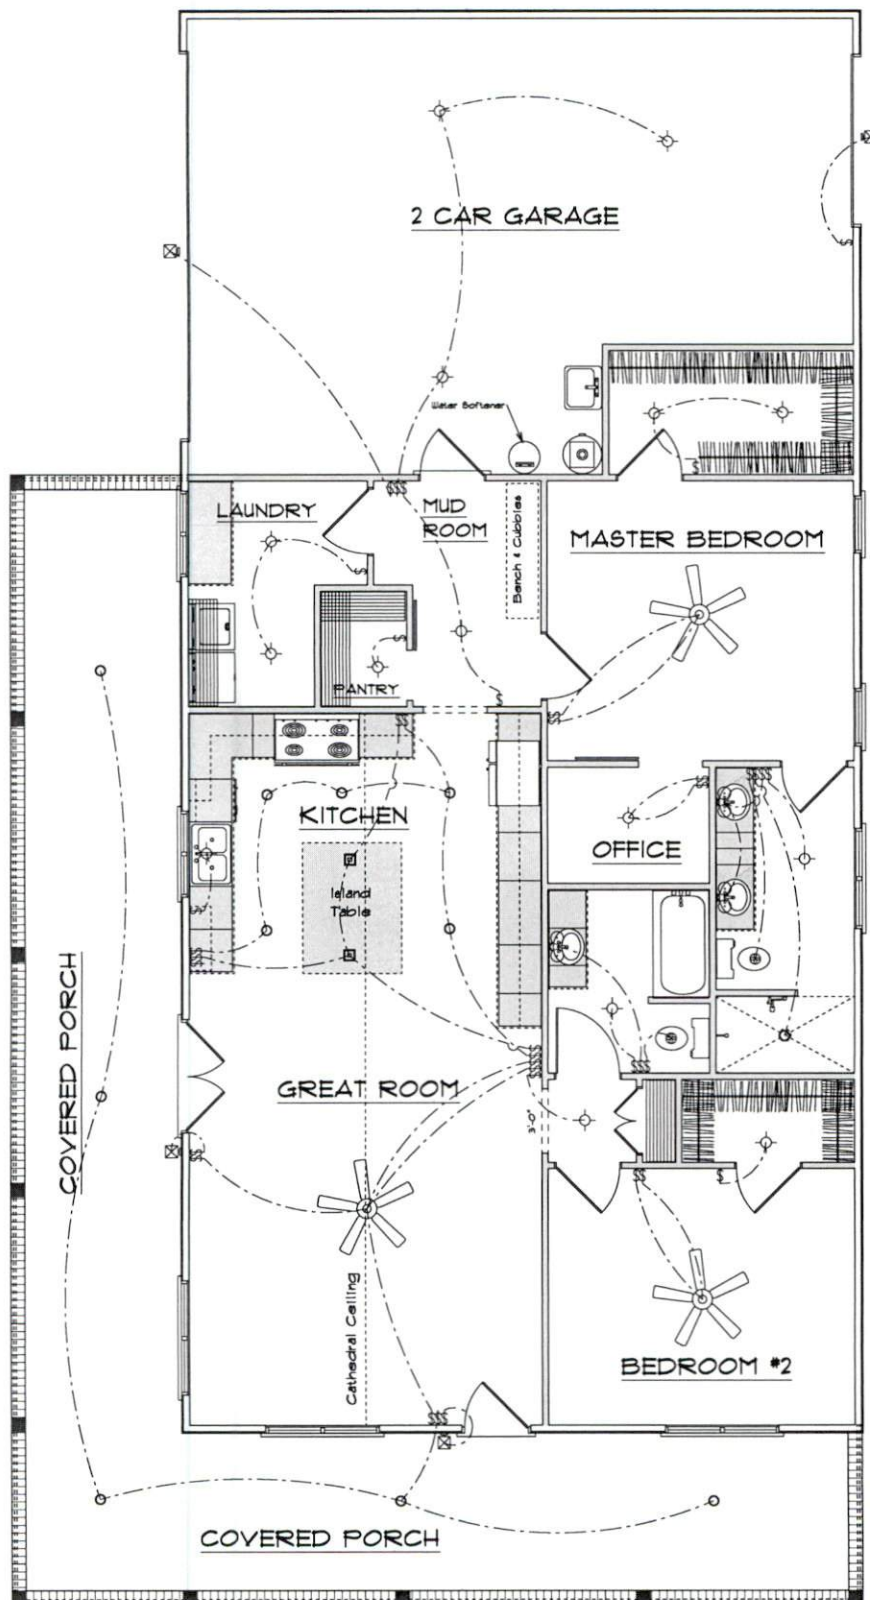

ELECTRICAL LEGEND		
ELECTRICAL	COUNT	SYMBOL
can light 6inch	11	○
ceiling fan 5 bladed 01	3	⊗
exterior light 02	6	⊗
fan	2	⊗
light	15	○
pendant large	2	⊗
switch	8	\$
switch double	5	SS
switch quad	2	SSSS
switch triple	4	SSS
wall mounted 01 2 lights	3	⊗


Electrical Plan

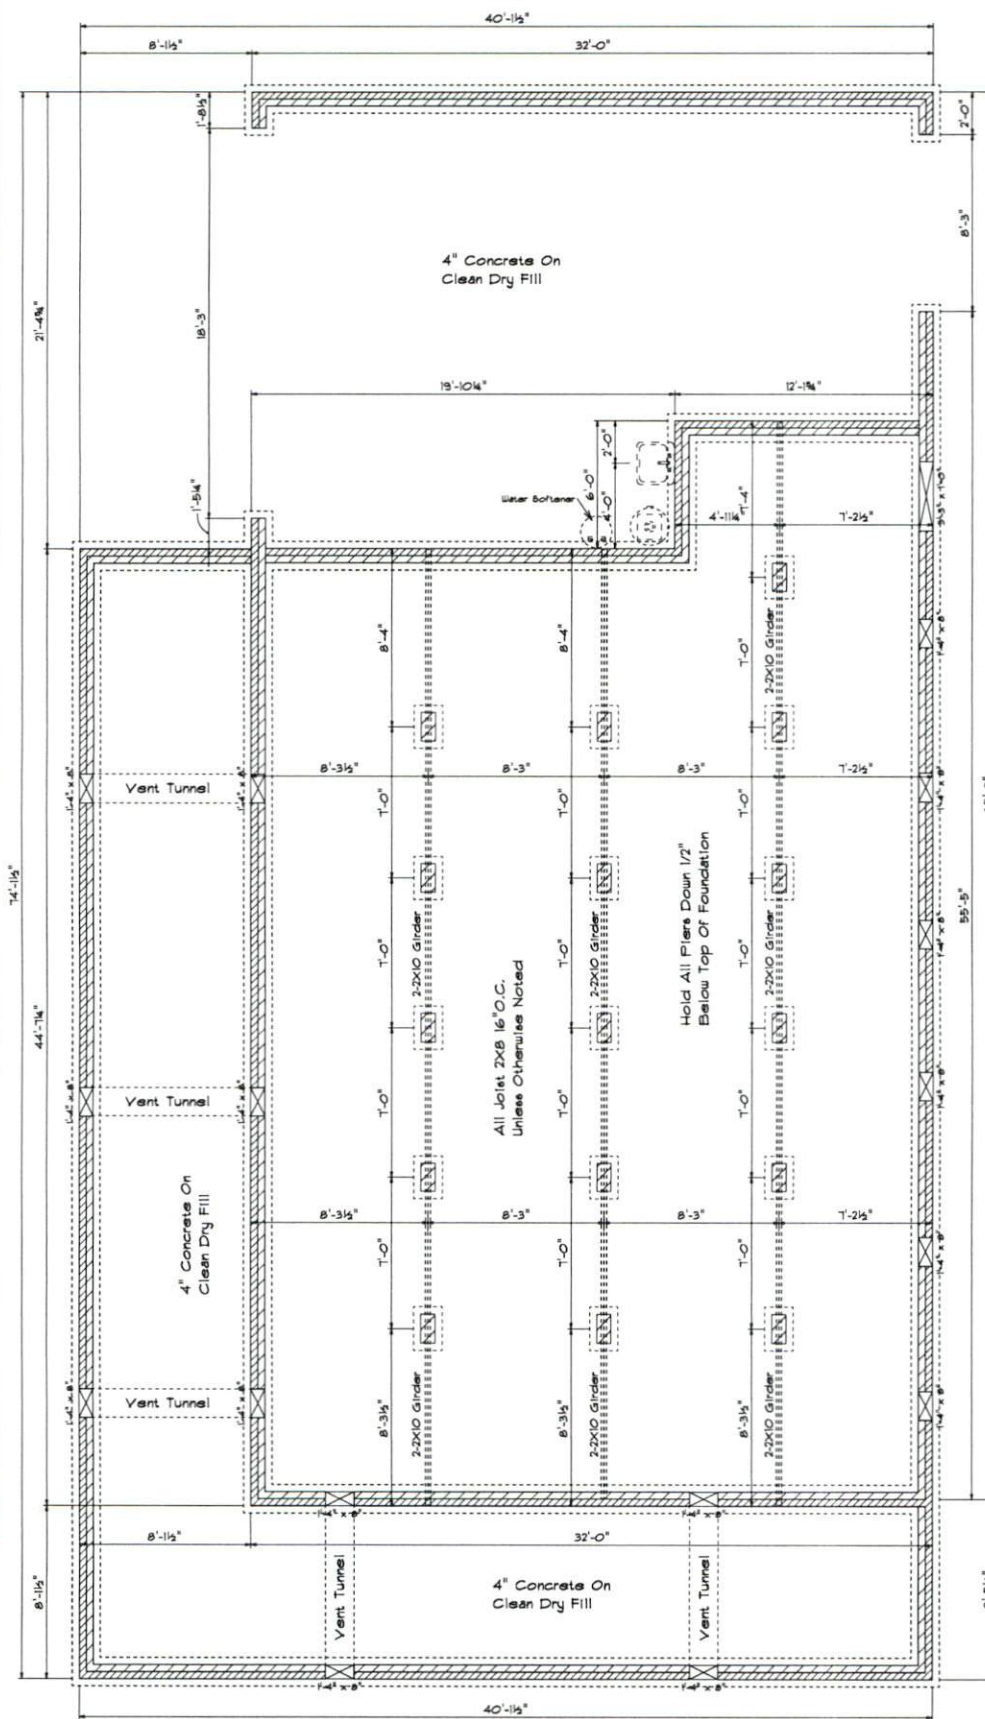


Foundation Plan

Scale: 1/4" = 1'-0"

Foundation Detail

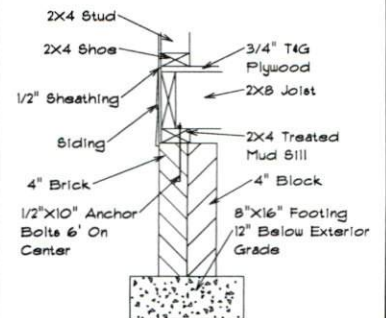


Footing & Pier Detail

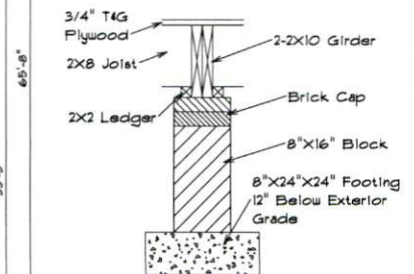


FOUNDATION VENTILATION

1509 Sq.Ft. Foundation Area
Requires 10.06 Sq.Ft. Ventilation.
With 6 Mil. Poly. Plans Indicate
Vents For Adequate Cross
Ventilation.

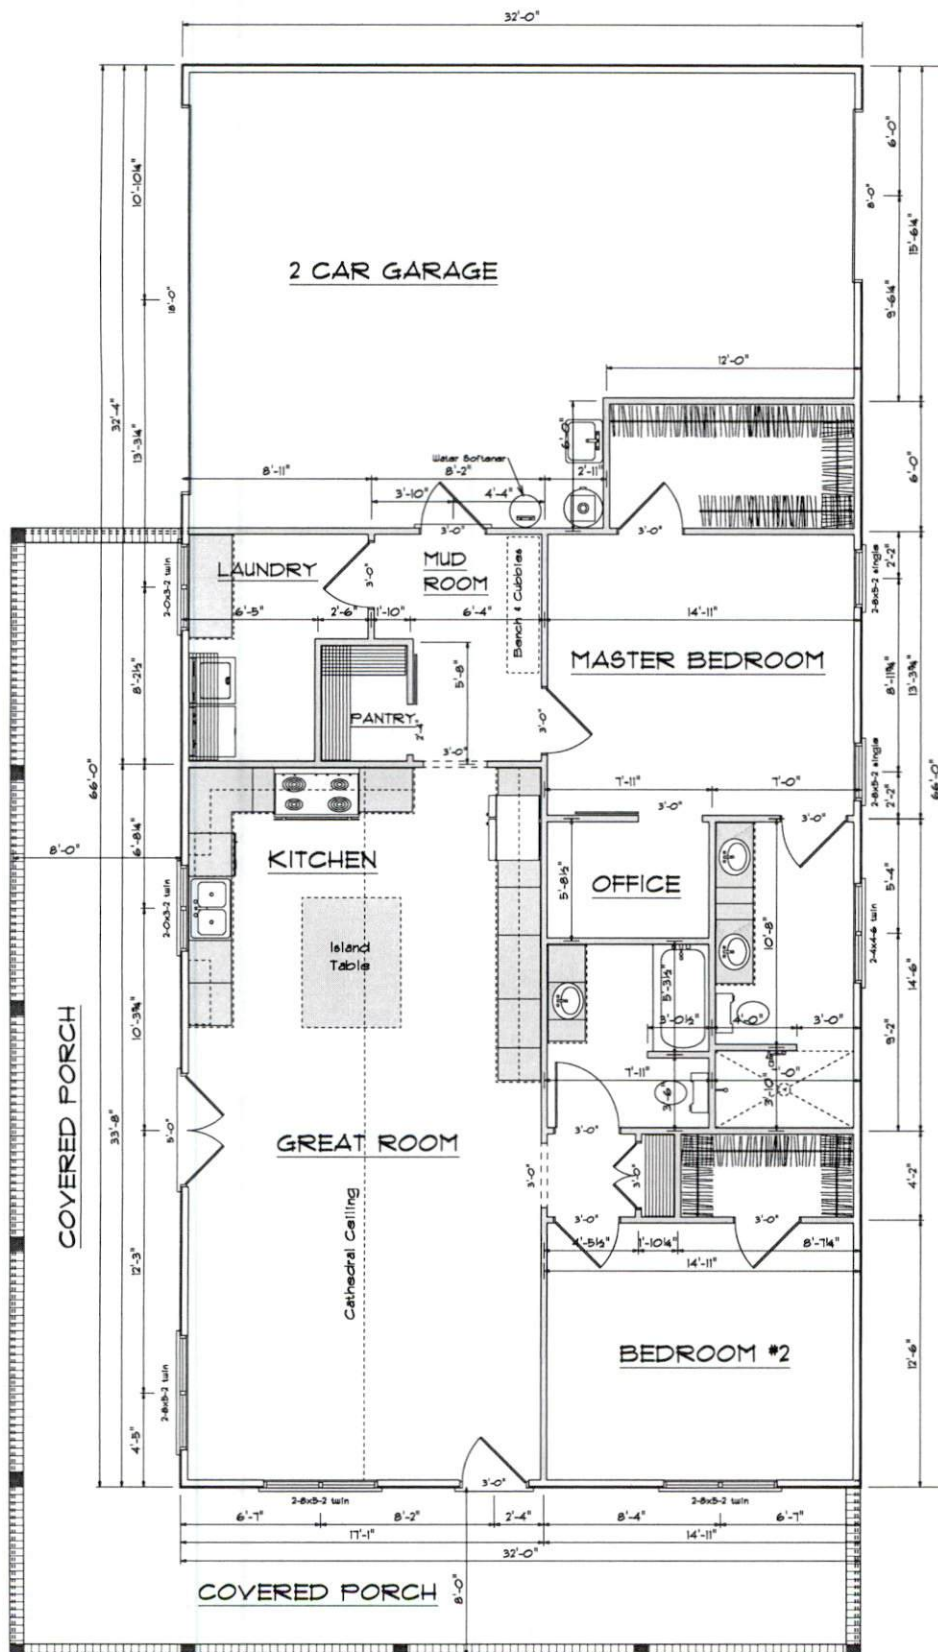

Kitchen Cabinets

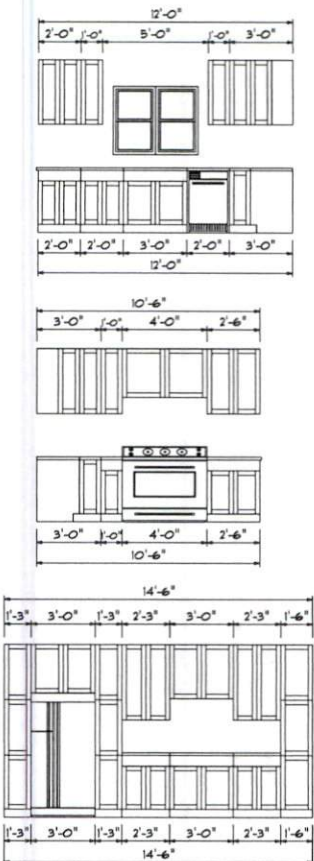

OPENING SCHEDULE			
PRODUCT CODE	SIZE	HINGE	COUNT
2-0x3-2 twin	4'-0" x 3'-2"	NN	3
2-4x6-8 twin	4'-8" x 4'-8"	NN	1
2-8x5-2 single	2'-8" x 5'-2"	N	2
2-8x5-2 twin	5'-4" x 5'-2"	NN	3
3-0 Door Unit	3'-0"	L	5
3-0 Door Unit	3'-0"	R	3
3-0 Doublehung Door Unit	3'-0"	LR	1
28x80 BARN DOOR	2'-4"	L	1
36x80 BARN DOOR	3'-0"	L	1
36x80 FRENCH A 1	3'-0"	R	1
60x80 FRENCH A 2	5'-0"	LR	1
96X84 - 4 PANEL - GARAGE DOOR	8'-0"	N	1
192X84 - 8 PANEL GARAGE DOOR	18'-0"	N	1

Areas

1509 Heated Sq.Ft.
613 Garage Sq.Ft.
683 Covered Porch Sq.Ft.


Floor Plan
Scale: 1/4" = 1'-0"




Front Elevation
Scale: 3/16" = 1'0"



Left Elevation
Scale: 3/16" = 1'0"

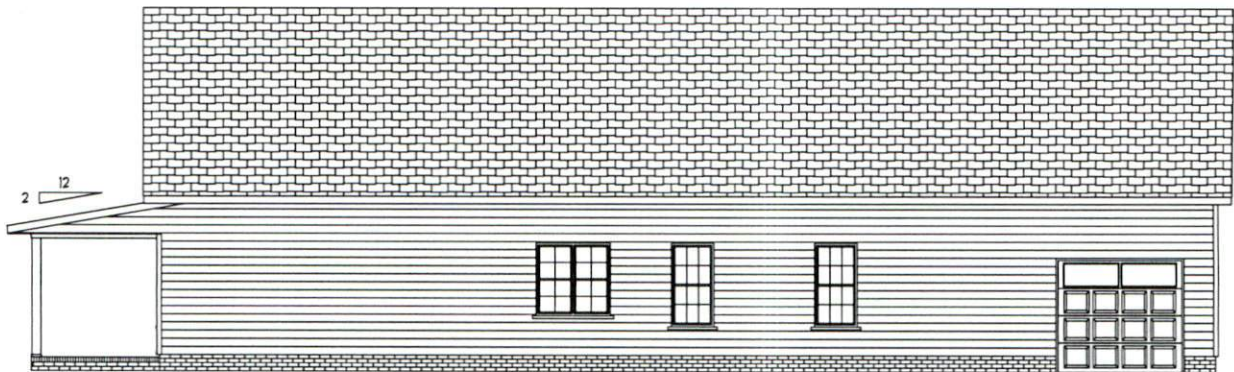

Right Elevation
Scale: 3/16" = 1'0"

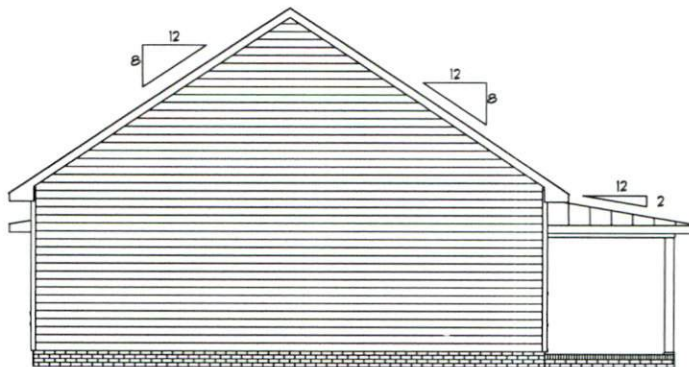

Rear Elevation
Scale: 3/16" = 1'0"

Delacruz Home Plans

SCALE: 1/4"

DRAWN BY

APPROVED

DATE: 10/14/2025

REVISED

DRAWING*

Base Designs
2121 Chimney Pt.
Linden, N.C. 28356
910-263-0403