





CYPRESS COVE					
ABBREVIATIONS					
ABV	ABOVE	HDR	HEADER	A.A.	PRESSURE TREATED WD
AFF	ABOVE FINISH FLOOR	HGT	HEIGHT	PWD	POWDER
C	CARPET	H.R.	HALF ROUND	R	RISER
CAB	CABINET	HS	HARD SURFACE	RAD	RADIUS
CL	CENTER LINE	HWD	HARDWOOD (FLOORS)	REF	REFRIGERATOR
CLG	CEILING	I.L.O.	IN LIEU OF	REV	REVISION
COL	COLUMN	ISUL	INSULATED(TION)	R&M	RANGE W/MICROWAVE
CONC	CONCRETE	INT	INTERIOR	RM	ROOM
CPT	CARPET	ITC	IN THE CLEAR	R.O.	ROUGH OPENING
DBL	DOUBLE	KIT	KITCHEN	R/S	ROD & SHELF(S)
DIM	DIMENSION	K/S	KNEE SPACE	SD	SMOKE DETECTOR
DN	DOWN (STAIRS)	LIV	LIVING	SEC	SECTION
DRY	DRYER MACHINE	LTL	LINTEL	SQ.FT.	SQUARE FOOTAGE
DYL	DETAIL	LVR	LOUVER	SH	SINGLE HUNG
EA	EACH	MAX	MAXIMUM	STD	STANDARD
EB	EYEBROW	MIN	MINIMUM	TEMP	TEMPERED (GLASS)
ELEV	ELEVATION	MISC	MISCELLANEOUS	TR	TRANSOM
ELEC	ELECTRIC(AL)	MULL	MULLION(ED)	TYP	TYPICAL
EQ	EQUAL	N/A	NOT APPLICABLE	UNF	UNFINISHED
EXT	EXTERIOR	OA	OVERALL	U.N.O.	UNLESS NOTED OTHERWISE
F.F.	FINISH FLOOR (LINE)	OBS	OBSOURE (GLASS)	VB	VANITY BASE
FXD	FIXED GLASS	O.C.	ON CENTER	W	WASHER
FIN	FINISH	O.H.	OVERHANG	WD	WOOD
FLR	FLOOR(ING)	OPNG	OPENING	WH	WATER HEATER
FP	FIREPLACE	OPT	OPTIONAL	WC	WALK-IN CLOSET
FUR	FURRED(ING)	PED	PEDESTAL (SINK)	W/ W/O	WITH or WITHOUT
GFI	GROUND FAULT CIRCUIT INTERRUPT	OSB	ORIENTED STRAND BOARD	WP	WATERPROOF(ING)
HB	HOSE BIB	PL	PLATE (HEIGHT)		

GENERAL NOTES	
1 - GENERAL BUILDING & DESIGN REQUIREMENTS	15 - MECHANICALS
1) THE ATTACHED PLANS & SPECIFICATIONS ARE THE SOLE PROPERTY OF TRI POINTE HOMES ANY UNAUTHORIZED USE OF THESE PLANS WITHOUT PRIOR WRITTEN CONSENT OF TRI POINTE HOMES IS STRICTLY PROHIBITED. 2) TRI POINTE HOMES DESIGNS & BUILDS HOUSING AS SET FORTH BY THE FORMAT AND PROVISIONS OF THE INTERNATIONAL RESIDENTIAL CODE (IRC), AND THE NATIONAL ELECTRIC CODE (NEC). ANY NON-CONFORMING DOCUMENTS DISCOVERED BY THE CONTRACTOR OR HIS AGENTS SHALL BE CALLED TO THE IMMEDIATE ATTENTION OF TRI POINTE HOMES BY CALLING (469)329-0470. 3) THESE PLANS ARE SUBJECT TO MODIFICATIONS TO MEET CODE REQUIREMENTS AND/OR TO FACILITATE MECHANICAL/ ELECTRICAL/ PLUMBING INSTALLATION AND/ OR TO IMPLEMENT DESIGN IMPROVEMENTS. ANY INTENTION TO MODIFY THESE PLANS MUST BE APPROVED IN WRITING BY TRI POINTE HOMES 4) CONTRACTOR SHALL BE RESPONSIBLE FOR VERIFYING ALL DIMENSIONS AFFECTING CONTRACTOR'S PRODUCTS, INSTALLATIONS, OR FABRICATIONS IN THE FIELD PRIOR TO EXPEDITING THE CONSTRUCTION OF SUCH WORK. FIELD VERIFY ALL DIMENSIONS -- DO NOT SCALE DRAWINGS!! CONTRACTOR IS RESPONSIBLE FOR SURVEYING THE PROJECT AND BECOMING FAMILIAR WITH THE EXISTING CONDITIONS AND SCOPE OF WORK INCLUDING BUT NOT LIMITED TO SITE AND SOIL BEARING CONDITIONS. 5) ERRORS AND OMISSIONS WHICH MAY OCCUR IN THE CONTRACT DOCUMENTS SHALL BE BROUGHT TO THE ATTENTION OF THE ARCHITECT, IN WRITING, AND WRITTEN INSTRUCTION SHALL BE OBTAINED PRIOR TO PROCEEDING WITH CONSTRUCTION. THE CONTRACTOR SHALL BE HELD RESPONSIBLE FOR ANY ERRORS, DISCREPANCIES, OR OMISSIONS FOR WHICH THE CONTRACTOR FAILED TO NOTIFY THE ARCHITECT PRIOR TO CONSTRUCTION AND/ OR FABRICATION OF THE WORK.	1) WOOD BUILT CHIMNEYS AND FIREPLACES SHALL BE INSTALLED PER MANUFACTURER'S INSTRUCTIONS, AND ARE SUBJECT TO MECHANICAL INSPECTION PER IRC SECTION R1002.1. 2) EXTERIOR AIR INTAKE FOR COMBUSTION AIR PER IRC SECTION AS REQUIRED BY LOCAL MUNICIPALITY
2 - SITE CONSTRUCTION	16 - ELECTRICAL
1) BACK FILL SHALL BE FREE FROM VEGETATION AND CONSTRUCTION DEBRIS. 2) BACK FILL SHALL BE PLACED IN LIFTS AND COMPACTED IN SUCH A MANNER AS BACKFILL TO NOT DAMAGE THE FOUNDATION WALLS OR ANY WATERPROOFING/ DAMPROOFING MATERIALS.	1) ALL ELECTRICAL INSTALLATION SHALL MEET THE REQUIREMENTS OF THE NATIONAL ELECTRIC CODE (NEC). ALL MATERIAL AND EQUIPMENT SHALL BEAR THE LABEL OF APPROVAL OF THE UNDERWRITERS LABORATORIES, INC. 2) ELECTRICAL CONTRACTOR SHALL VERIFY SPACE REQUIRED FOR METER INSTALLATION BEFORE CONSTRUCTION AND SHALL NOTIFY GENERAL CONTRACTOR OF ANY DISCREPANCIES. 3) VERIFY LOCATION OF ALL RECEPTACLES FOR APPLIANCES WITH MANUFACTURER SPECIFICATIONS. 4) GROUND FAULT INTERRUPTS SHALL BE LOCATED PER THE NEC. 5) ALL SWITCHES SHALL BE INSTALLED AT 3'-6" ABOVE FINISHED FLOOR TO CENTERLINE OF SWITCH UNLESS NOTED OTHERWISE. 6) ALL CONVENIENCE OUTLETS SHALL BE INSTALLED W/ CENTERLINE OF OUTLET LOCATED 1'-3" ABOVE FINISHED FLOOR UNLESS NOTED OTHERWISE. 7) ALL CONVENIENCE OUTLETS WITH SWITCHES TO BE SWITCH AT TOP ONLY. 8) ALL EXTERIOR WALL BRACKET FIXTURES SHALL BE INSTALLED AS NOTED ON PLANS. 9) APPROVED SMOKE DETECTORS SHALL BE LOCATED ON EVERY STORY OF THE DWELLING UNIT AS PER IRC SECTION R317 (SEE SHEET B1.1 FOR LOCATIONS). WHERE MORE THAN ONE DETECTOR IS REQUIRED THEY SHALL BE INTERCONNECTED. POWER SOURCE SHALL BE BUILDING POWER w/ BATTERY BACKUP. 10) CONDUCTORS SHALL BE OF COPPER.
3 - CONCRETE	GENERAL FRAMING SPECS AND CONSTRUCTION NOTES STAIRS:
1) SLOPE ON GARAGE SLAB SHALL BE 1/8" PER FOOT TOWARDS VEHICLE DOOR. SLOPE ON PORCH AND PATIOS SHALL BE 1/8" PER FOOT AWAY FROM HOUSE.	1) THE MAXIMUM RISER HEIGHT SHALL BE 7 3/4 INCHES AND THE MINIMUM TREAD DEPTH SHALL BE 10 INCHES IN ACCORDANCE WITH SECTION I.R.C. 2) HANDRAILS HAVING MINIMUM AND MAXIMUM HEIGHTS OF 34 INCHES AND 38 INCHES SHALL BE PROVIDED ON AT LEAST ONE SIDE OF STAIRWAYS IN ACCORDANCE WITH SECTION R315.1 -- I.R.C. 3) HANDRAIL AND BALUSTRADE (WHERE PRESENT) SHALL BE CONSTRUCTED ACCORDING TO IRC. 4) ALL REQUIRED HAND RAILS SHALL BE CONTINUOUS THE FULL LENGTH OF THE STAIRS W/ 2 OR MORE RISERS FROM A POINT ABOVE THE THE TOP RISER OF A FLIGHT TO A POINT ABOVE THE LOWEST RISER OF THE FLIGHT. ENDS SHALL BE RETURNED OR SHALL TERMINATE AT NEWEL POSTS OR SAFETY TERMINALS. HANDRAILS ADJACENT TO A WALL SHALL HAVE A SPACE OF NOT LESS THAN 1.5" BETWEEN THE WALL AND HAND RAIL.
4 - MASONRY	WALLS:
1) ALL EXTERIOR BRICK MUST MEET ASTM C-216 FOR "SM" CONDITIONS 2) MASONRY VENEER SHALL BE ATTACHED TO SUPPORTING WALLS W/ CORRUGATED METAL TIES IN ACCORDANCE WITH R703.7.4.1 -- I.R.C. OR LOCAL CODE REQUIREMENTS 3) WEEPHOLES SHALL BE PROVIDED ALONG THE OUTSIDE WYTHE OF EXTERIOR MASONRY WALLS AT 33" O.C. MAX. SHALL BE A MIN. OF 3/16" IN DIAMETER, AND LOCATED IMMEDIATELY ABOVE THE FLASHING PER R703.7.6 -- I.R.C.	1) ALL DIMENSIONS ARE FROM FACE OF STUD TO FACE OF STUD. ALL STUDS ARE 3 1/2" UNLESS NOTED. ALL DIMENSIONS PRESENTED HERE ARE FRAME DIMENSIONS ONLY. 2) SEPARATION BETWEEN THE RESIDENCE AND THE GARAGE SHALL BE MAINTAINED BY INSTALLATION OF 1/2" GYPSUM BOARD ON ALL COMMON WALLS. 2-STORY HOMES REQUIRE 5/8" TYPE X GYPSUM BOARD AT GARAGE CEILINGS WHERE HABITABLE ROOMS ARE PRESENT ABOVE.
5 - METALS	FLOORS:
	1) STRUCTURAL FLOOR MEMBERS SHALL NOT BE CUT, BORED, OR NOTCHED IN EXCESS OF THE LIMITATIONS SPECIFIED IN IRC. 2) THE ENDS OF EACH JOIST, BEAM, OR GIRDER SHALL HAVE NOT LESS THAN 1.5 INCHES OF BEARING ON WOOD OR METAL AND NOT LESS THAN 3 INCHES ON MASONRY OR CONCRETE OR AS OTHERWISE SPECIFIED IN IRC. 3) ALL DIMENSIONAL FLOOR JOISTS TO BE PER ENGINEER STRUCTURAL PLANS.
6 - WOOD AND PLASTICS	FRAMING:
	1) ALL FRAMING DIMENSIONS TO FACE OF MEMBER. 2) ALL BEARING HEADERS TO BE PER ENGINEERING PLANS. 3) FIRE STOPPING AND/ OR DRAFT STOPPING SHALL MEET THE REQUIREMENTS OF IRC R602.8.
7 - THERMAL & MOISTURE PROTECTION	ROOF:
1) FIRE STOPPING AND/ OR DRAFT STOPPING SHALL MEET THE REQUIREMENTS OF IRC R602.8. 2) ATTIC VENTILATION SHALL BE PROVIDED AT 1/300 th OF THE AREA OF THE SPACE VENTILATED. CROSS VENTILATION WITH HALF OF THE VENTILATED AREA SHALL BE PROVIDED BY ROOF VENTS AND THE OTHER HALF BY SOFFIT VENTS. VENTS SHALL BE PLACED SO AS TO NOT ALLOW INFILTRATION OF RAIN OR SNOW. 3) PROVIDE APPROVED TILE BACKER DRYWALL FOR ALL SHOWER AND BATH SPACE 4) PROVIDE ATTIC VENTILATION PER IRC-R806.1	1) HIP AND VALLEY RAFTERS SHALL BE SUPPORTED AT RIDGE DOWN TO BEARING PARTITION. CUT ENDS OF RAFTERS SHALL BE FULLY SUPPORTED WALL AND RIDGE. 2) REQUIRED VENTILATION AREAS CALCULATED AT 1/300 RATIO.
8 - DOORS AND WINDOWS	
1) REVIEW ALL WINDOW HDR HEIGHTS PER PLATE HT. AND VERIFY W/ ELEVATIONS AND CORNICE DETAILS 2) TEMPERED GLASS SHALL BE USED IN HAZARDOUS AREAS AS DESCRIBED IN SECTION R308.4 -- I.R.C. 3) FRONT DOOR WIDTH PER IRC-R311.3 4) GARAGE DOOR PER IRC-R309.1 5) EMERGENCY EGRESS SHALL MEET REQUIREMENTS OF SECTION R310 -- I.R.C. 2018 -- SLEEPING ROOMS SHALL HAVE AT LEAST ONE EGRESS OPENING OF NOT LESS THAN 5.7 SF AND A CLEAR OPENING OF NOT LESS THAN 20" WIDE X 24" HIGH AND SHALL NOT BE MORE THAN 44" ABOVE THE FLOOR.	

SQUARE FOOTAGE	
Elevation "A"	
(Slab S.F.)	
Slab Area	Sq. Ft.
FIRST FLOOR	1767
2 BAY GARAGE	428
PORCH	172
COVERED OUTDOOR LIVING	153
Total Slab Area	2520
(Outside of Frame S.F.)	
A/C Area	Sq. Ft.
FIRST FLOOR	1767
Total A/C Area	1767
Non-A/C Area	Sq. Ft.
2 BAY GARAGE	428
PORCH	172
COVERED OUTDOOR LIVING	153
Total Non-A/C Area	753
(Inside of Frame S.F.)	
A/C Area	Sq. Ft.
FIRST FLOOR	1718
Total A/C Area	1718
NOTE: ALL OPTIONAL SQUARE FOOTAGES LISTED ARE INDEPENDENT OF AND IN ADDITION TO BASE SQUARE FOOTAGES.	
OPTIONS	
LOFT	+569
UNDER 9,000 FT² - FIRE-RATED WALL REQUIRED AT GARAGE SIDE & NON-GARAGE SIDE	
BUILDING CODE COMPLIANCE	
CONSTRUCTION PLANS DESIGNED TO MEET OR EXCEED MINIMUM CODE REQUIREMENTS OF 2018 I.R.C.	
ELECTRICAL PLANS DESIGNED TO MEET OR EXCEED MINIMUM CODE REQUIREMENTS OF 2020 N.E.C.	

TABLE OF CONTENTS	
SHEET LEGEND	
SHEET NO.	TYPE OF SHEET/LAYOUT
"G0.01"	COVER SHEET & GEN. NOTES
"G0.11"	REVISIONS & SYMBOLS
"S1.10A"	BASE FOUNDATION PLAN -- ELEVATION 'A'
"A1.10A"	FIRST FLOOR PLAN -- ELEVATION 'A'
"01.A10"	FLOOR PLAN OPTIONS
"01.A20"	2ND FLOOR PLAN OPTION
"A2.01A"	EXTERIOR ELEVATIONS -- 'A'
"A2.02A"	EXTERIOR ELEVATIONS -- 'A'
"A2.03A"	EXTERIOR ELEVATIONS OPTION -- 'A'
"A2.04A"	EXTERIOR ELEVATIONS OPTION -- 'A'
"A3.01A"	ROOF PLAN -- ELEVATION 'A'
"A4.01"	INTERIOR DETAIL SHEET
"E1.10A"	1ST FLR. ELECTRICAL PLAN -- ELEVATION 'A'
"E1.11A"	1ST FLR. ELECTRICAL PLAN UPGRADE OPTIONS -- ELEVATION 'A'
"01.E10"	1ST FLR. ELECTRICAL PLAN OPTIONS
"01.E20"	2ND FLR. ELECTRICAL PLAN OPTION
"01.E11"	1ST FLR. ELECTRICAL PLAN UPGRADE OPTIONS
"01.E21"	2ND FLR. ELECTRICAL PLAN UPGRADE OPTION
"D1.0"	DETAILS
"D2.0"	GRAB BAR PARTIAL PLANS
SYMBOLS	
	ELEVATION KEY OR SECTION KEY
	CENTERLINE
	CEILING TRANSITION LINE
	HOSE BIB (FREEZE PROOF)
	GAS LINE STUB
	TOWEL BAR
	PAPER HOLDER
	TOWEL RING
	SHOWER HEAD
	SHOWER CONTROLS
	TUB/SHOWER
	LAVATORY
	DBL SINK
	LAUNDRY SINK
	PEDESTAL SINK
	WATER CLOSET
	PLYWOOD
	INSULATING SHEATHING
	BATT INSULATION
	RIGID INSULATION
	CONCRETE
	SAND OR GRAVEL FILL
	STONE
	2x FRAME WALL
	BRICK VENEER
	STONE VENEER

 trí pointe
H O M E S

5440 WADE PARK BLVD, SUITE 400, RALEIGH, NC 27607

Business Operations

5440 Wade Park Blvd
Suite 400
Raleigh, NC 27607

© 2022

COVER SHEET & GENERAL NOTES

SUBDIVISION: ALTIS AT SERENITY
ADDRESS: 98 SHADY CREEK WAY,
FUQUAY-VARINA, NC 27526
LOT: 370 BLOCK:

Issue Date: 10-13-24
Drawn By: ACC


PLAN #: 5920-04

PLAN NAME: CYPRESS COVE

SHEET #: G0.01

Lot 370
 5920-04 Cypress Cove
 Elevation A
 Right-Hand Garage

UNDER 9,000 FT² -
 FIRE-RATED WALL
 REQUIRED AT
 GARAGE SIDE &
 NON-GARAGE SIDE

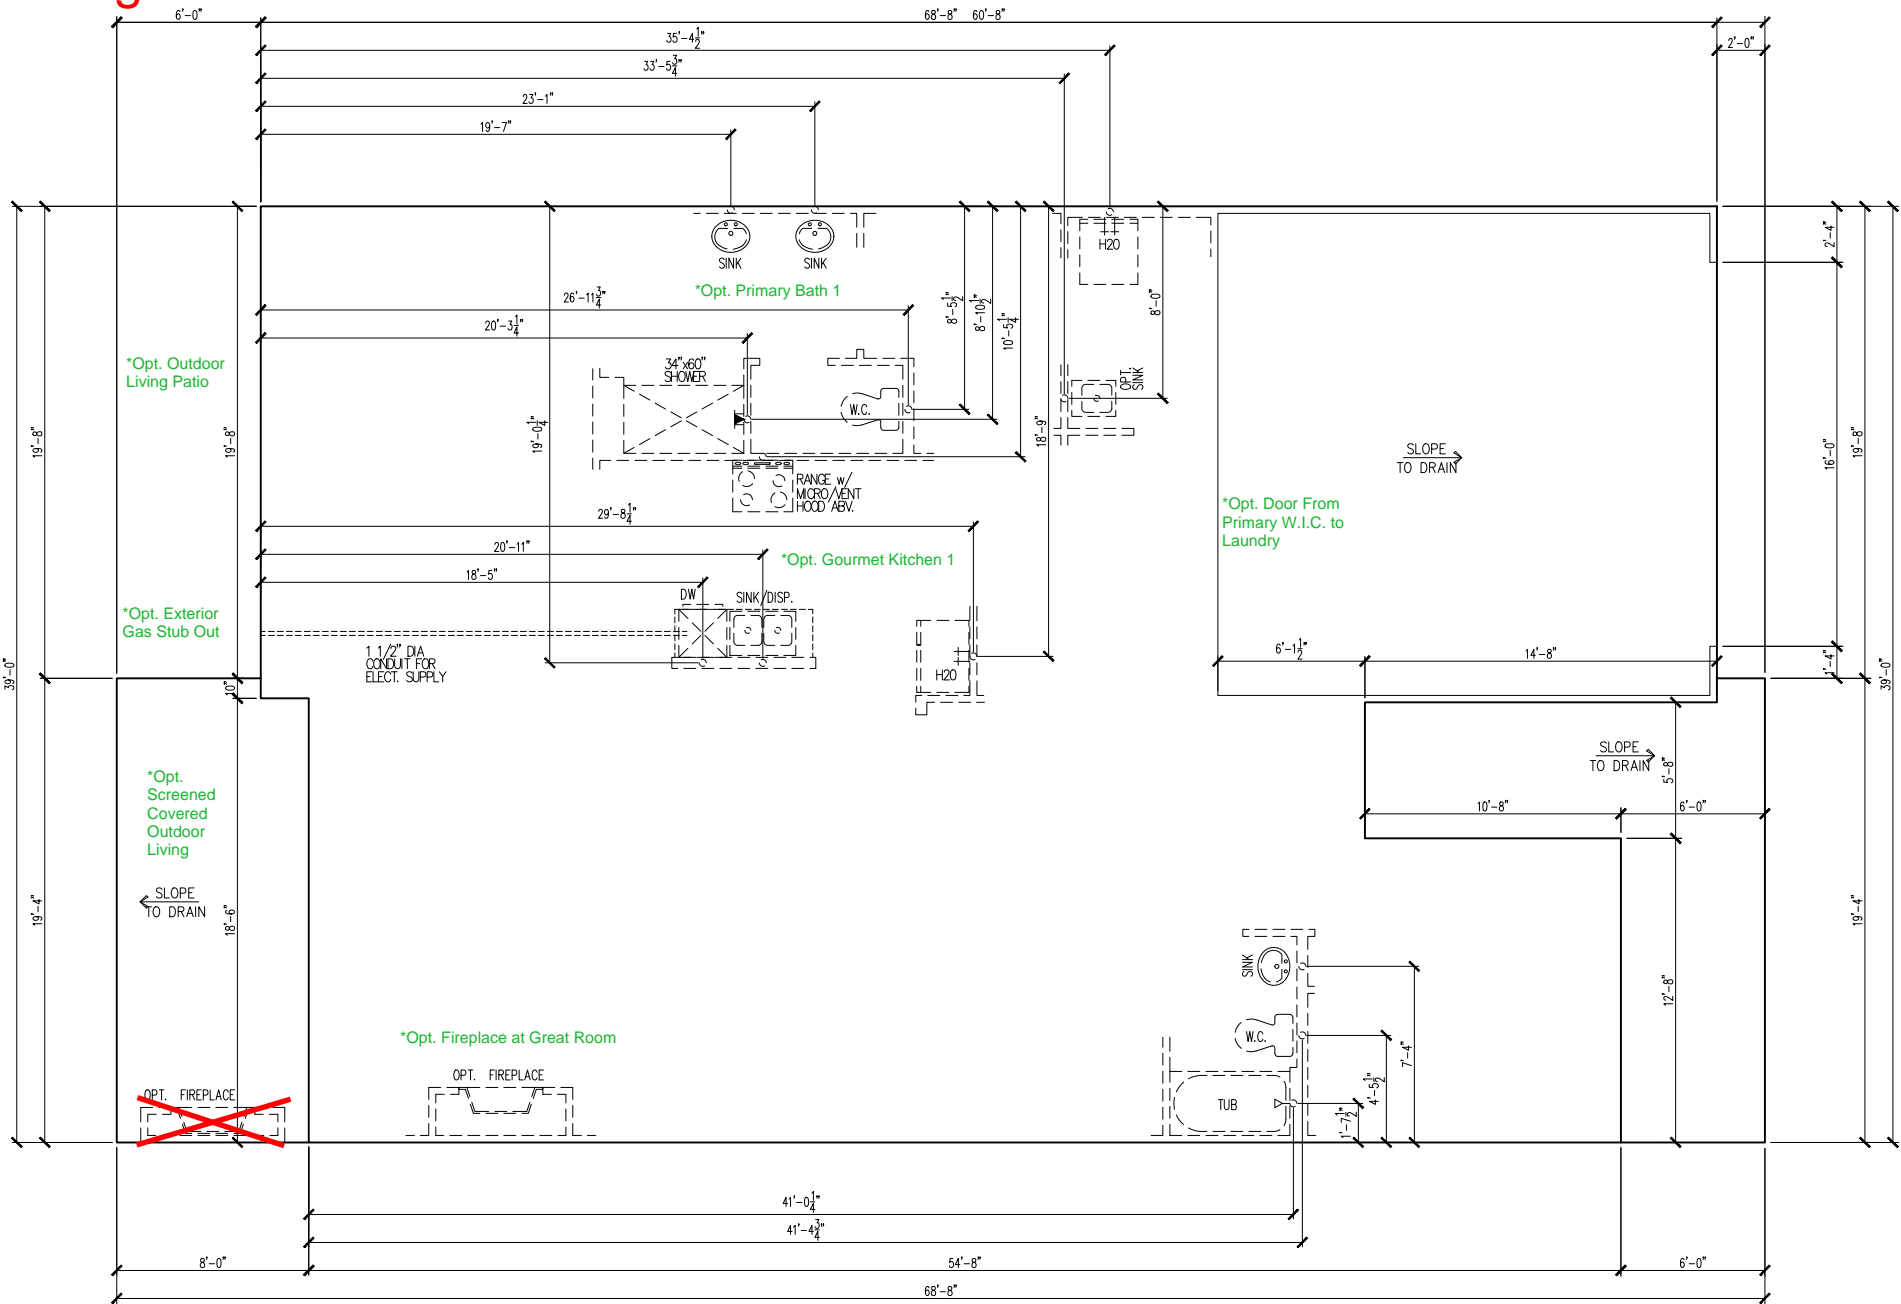

- *Opt. Gourmet Kitchen 1
- *Opt. Primary Bath 1
- *Opt. Fireplace at Great Room
- *Opt. Door From Primary W.I.C. to Laundry
- *Opt. Screened Covered Outdoor Living
- *Opt. Outdoor Living Patio
- *Opt. Exterior Gas Stub Out
- *Opt. Fire-Rated Garage Side
- *Opt. Fire-Rated Non-Garage Side

tri pointe
 HOMES
 5440 WADE PARK BLVD, SUITE 400, RALEIGH, NC 27607

Business Operations
 5440 Wade Park Blvd
 Suite 400
 Raleigh, NC 27607
 © 2022

BASE FOUNDATION PLAN
 SUBDIVISION: ALTIS AT SERENITY
 ADDRESS: 98 SHADY CREEK WAY,
 FUQUAY-VARINA, NC 27526
 LOT: 370 BLOCK:

Issue Date: 10-13-24
 Drawn By: ACC

PLAN #:
 5920-04


PLAN NAME:
 CYPRESS COVE

SHEET #:
 S1.10A

#	EXPLANATION
1.	ALL NON-DIMENSIONED PARTITIONS ARE 3-1/2" ROUGH
2.	ALL ANGLED PARTITIONS ARE 45 DEGREES UNLESS NOTED OTHERWISE (U.N.O.)
3.	PROVIDE MIN. 2-2x12's w/ 1/2" PLYWD. FLITCH PLATE AT ALL EXTERIOR WALL OPENINGS & INTERIOR BEARING WALL OPENINGS U.N.O.
4.	ALL EXTERIOR DIM'S ARE TO FACE OF STUDS U.N.O.
5.	ALL TRUSSES TO BEAR ON EXTERIOR WALLS AND/OR GIRDER TRUSS U.N.O.
6.	TRUSS MFG. TO SIZE MEMBERS, FASTENERS, HANGERS & SET SPACING FOR ALL TRUSSES
7.	WINDOW SUPPLIER TO VERIFY AT LEAST ONE WINDOW IN ALL BEDROOMS TO HAVE A CLEAR EGRESS OPENING OF 5.7 SQ. FT. w/MIN DIM'S OF 24" IN HT AND 20" IN WIDTH; SILL HT NOT TO EXCEED 44" AFF
8.	ALL BALUSTER TO BE SPACED SUCH THAT A 4" SPHERE CANNOT PASS BETWEEN BALUSTER
9.	ALL ELEC. & MECH. EQUIPMENT & METERS ARE SUBJECT TO RELOCATION DUE TO FIELD CONDITIONS; CONTRACTOR TO VERIFY
10.	FOR ADDITIONAL NOTES, SEE GENERAL NOTES ON TITLE SHEET & DETAILS
11.	ALL TYP. WINDOWS 6'-0" IN HT AND SMALLER, THE HEAD HEIGHT SHALL BE 8'-10" ABOVE FINISHED FLOOR (U.N.O.)
12.	STRUCTURAL ENGINEERING PROVIDED BY OTHERS
13.	REFER TO INTERIOR ELEVATIONS SHEET TO VIEW BUBBLE CALLOUTS
14.	INTERIOR DOOR HEIGHTS ARE AS FOLLOWS - PRIMARY SUITE, PRIMARY BATH, & PRIMARY CLOSET ARE 8' TALL DOORS. ALL OTHER DOORS ARE 6'-8".
15.	BATH ACCESSORY INSTALLATION HEIGHTS ARE MEASURED TO CENTER OF ACCESSORY: TB - 60" A.F.F. TR - 20" ABV. VANITY COUNTER-TOP TH - 60" A.F.F. TP - 26" A.F.F. OPT. GRAB BAR (GB) - 36" A.F.F.
16.	SHUT-OFF VALVE TO BE LOCATED IN GARAGE
17.	ROD AND SHELF HEIGHTS ARE MEASURED TO TOP OF ROD AND BOTTOM OF SHELVES - SEE D-1.0 FOR DETAILS: 1R1S - ROD - 5'-8" 2R2S - TOP ROD - 6'-8" SHELF - 5'-10" TOP SHELF - 6'-10" BOTTOM ROD - 3'-4" BOTTOM SHELF - 3'-6"

*Opt. Fire-Rated
Garage Side

UNDER 9,000 FT² -
FIRE-RATED WALL
REQUIRED AT GARAGE
SIDE & NON-GARAGE SIDE

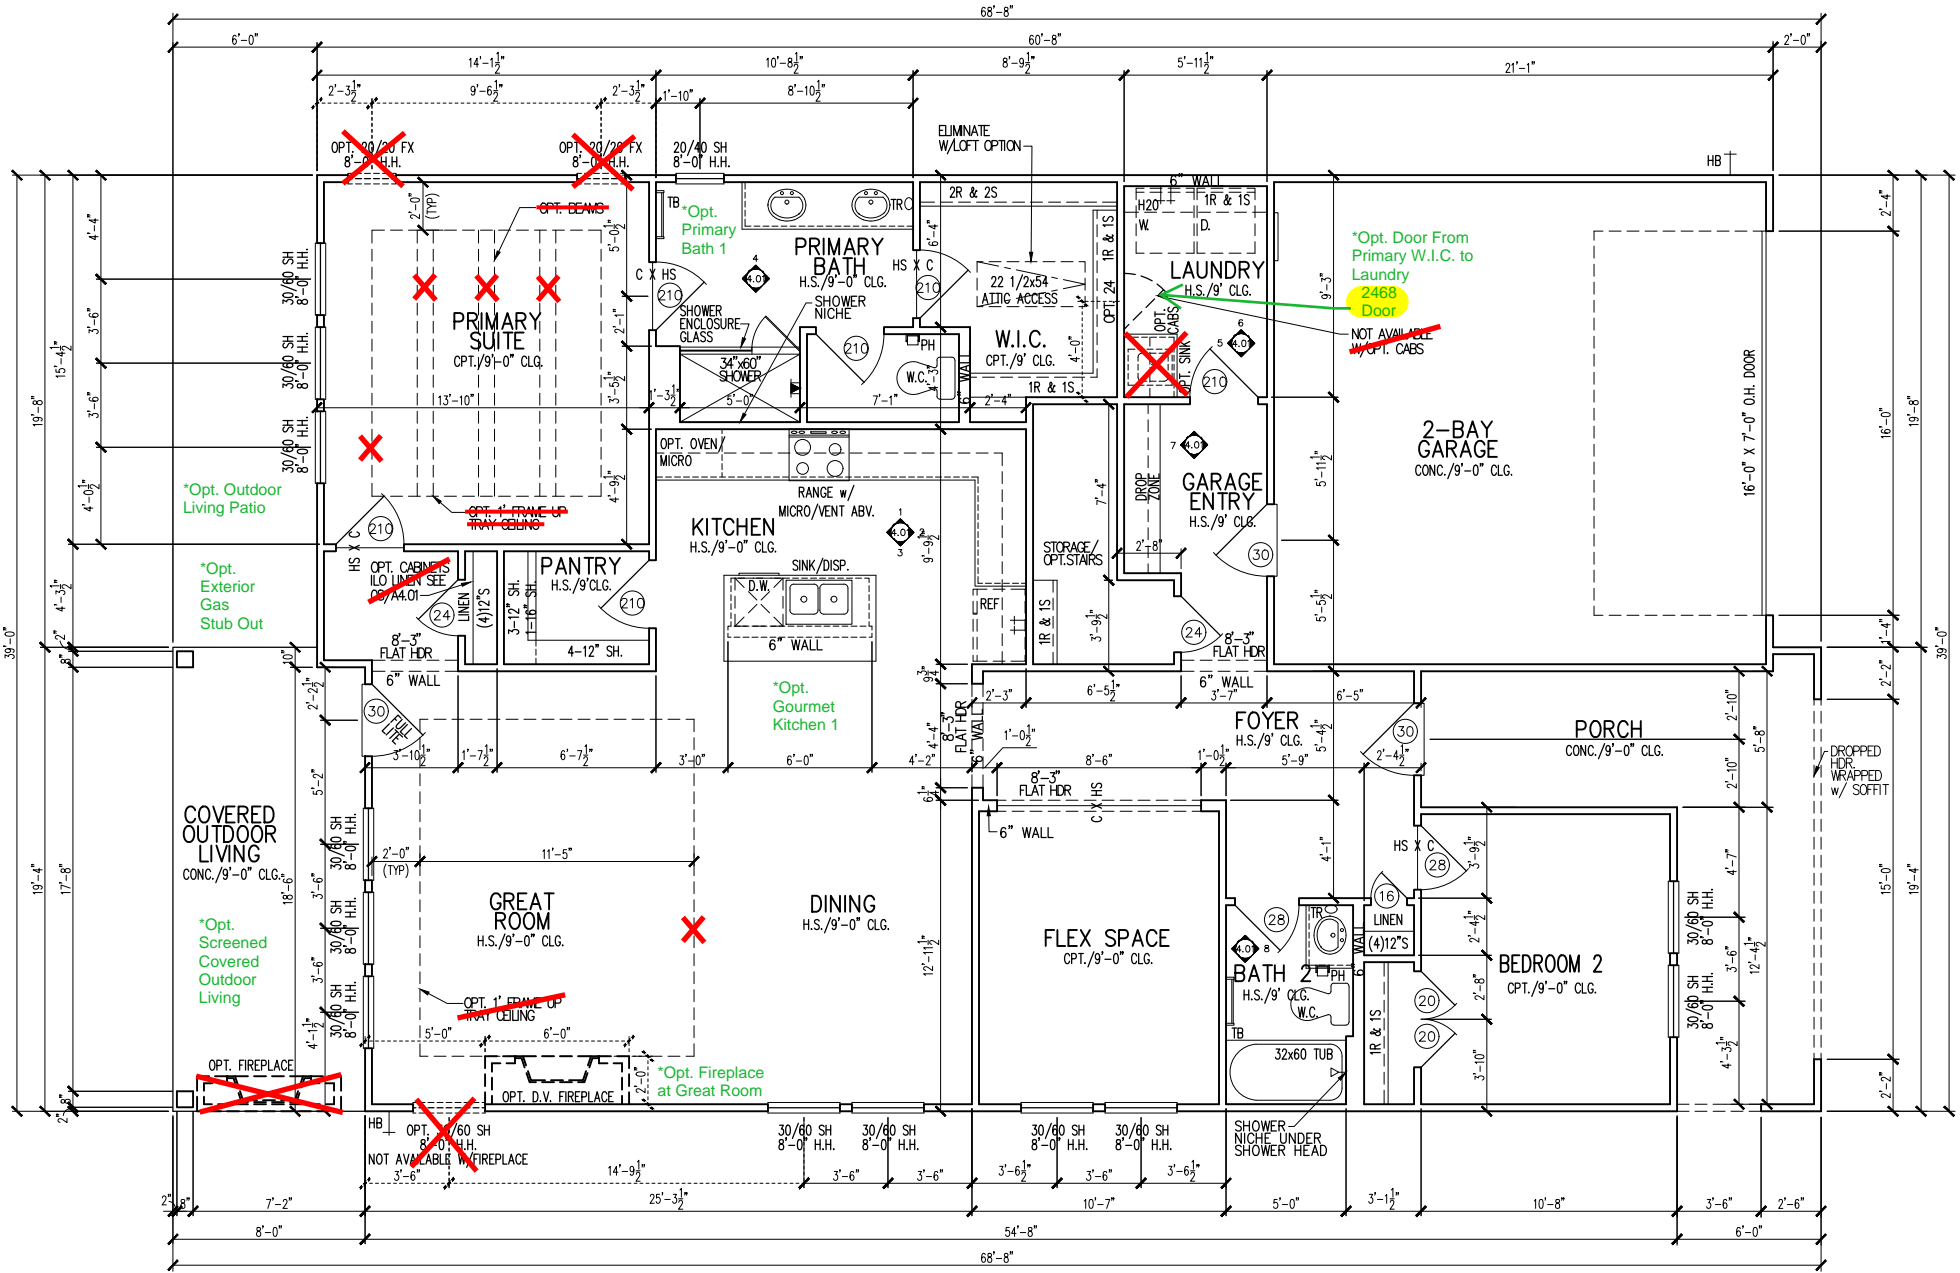

*Opt. Fire-Rated
Non-Garage Side

Lot 370
5920-04 Cypress Cove
Elevation A
Right-Hand Garage

- *Opt. Gourmet Kitchen 1
- *Opt. Primary Bath 1
- *Opt. Fireplace at Great Room
- *Opt. Door From Primary W.I.C. to Laundry
- *Opt. Screened Covered Outdoor Living
- *Opt. Outdoor Living Patio
- *Opt. Exterior Gas Stub Out
- *Opt. Fire-Rated Garage Side
- *Opt. Fire-Rated Non-Garage Side

tri pointe
H O M E S

Business Operations
5440 Wade Park Blvd
Suite 400
Raleigh, NC 27607


1st FLOOR PLAN
SUBDIVISION: **ALTIS AT SERENITY**
ADDRESS: **98 SHADY CREEK WAY,**
FUQUAY-VARINA, NC 27526
LOT: **370** BLOCK:

Issue Date: 10-13-24
Drawn By: ACC

PLAN #:
5920-04


PLAN NAME:
CYPRESS COVE

SHEET #:
A1.10

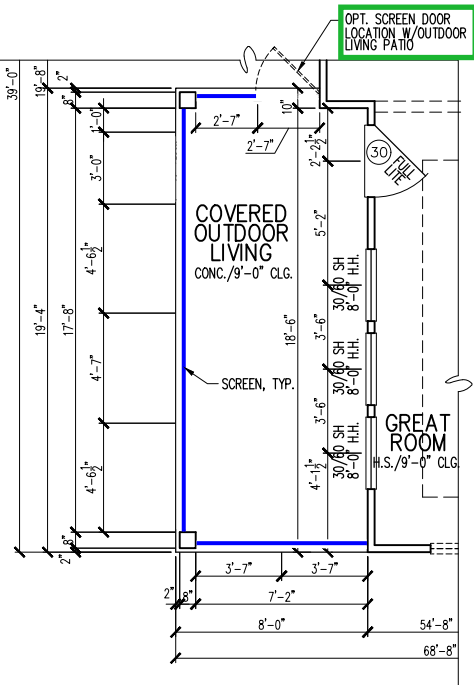


OPT. SCREENED
COVERED OUTDOOR LIVING
PARTIAL FLOOR PLAN

1/8"=1'-0"

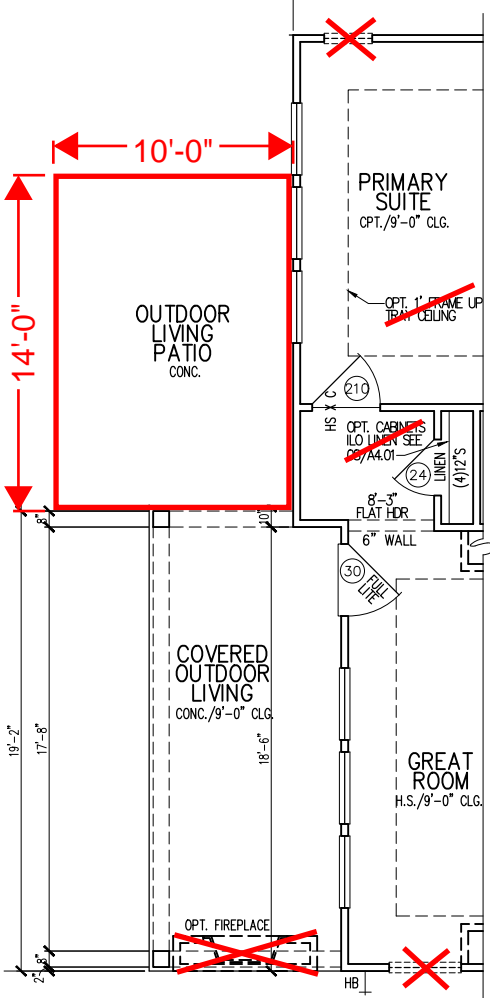


OPT. OUTDOOR LIVING PATIO
PARTIAL FLOOR PLAN

1/8"=1'-0"

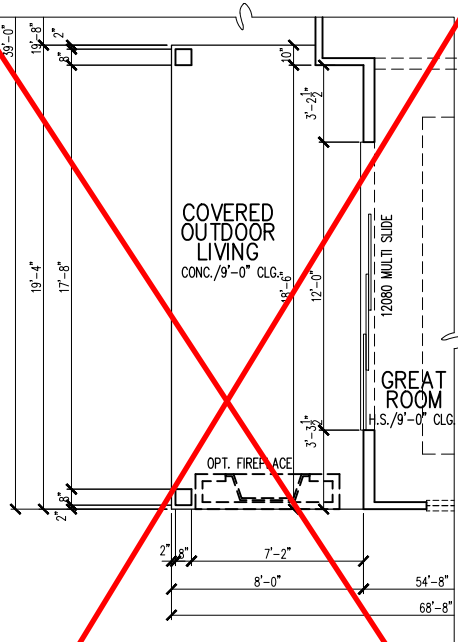


OPT. 12080 MULTI SLIDE
DOOR AT GREAT ROOM
PARTIAL FLOOR PLAN

1/8"=1'-0"

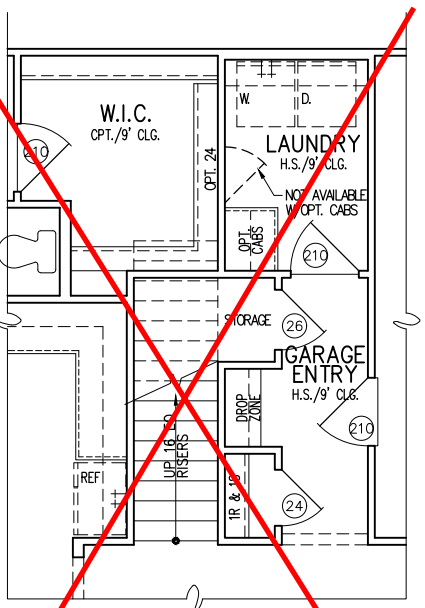


OPT.
SECOND FLOOR STAIR
PARTIAL FLOOR PLAN

1/8"=1'-0"

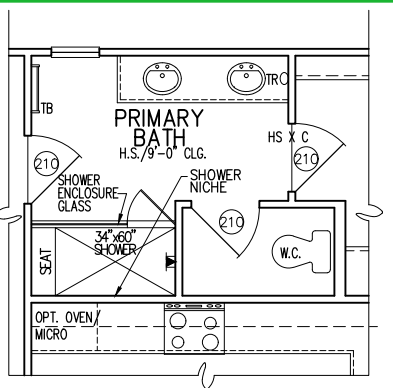


OPT. PRIMARY BATH 1
PARTIAL FLOOR PLAN

1/8"=1'-0"

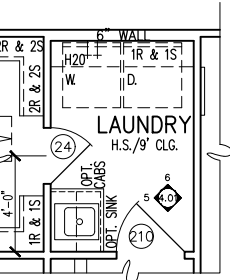


OPT. DOOR FROM
PRIM. W.I.C TO LAUNDRY
PARTIAL FLOOR PLAN

3/16"=1'-0"

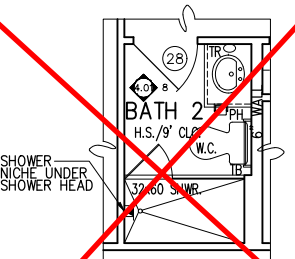


OPT. SHOWER
ILO TUB AT BATH 2
PARTIAL FLOOR PLAN

1/8"=1'-0"

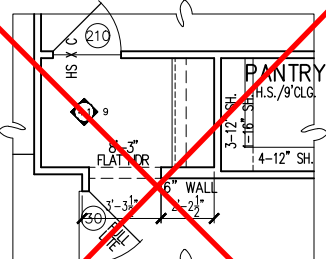


OPT. CABINETS
ILO LINEN CLOSET
PARTIAL FLOOR PLAN

1/8"=1'-0"

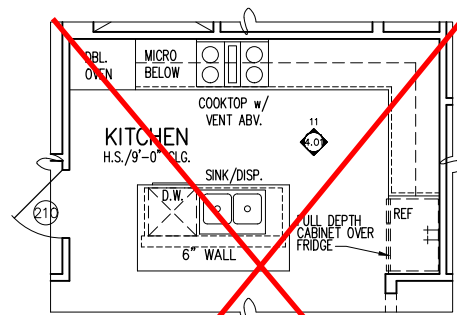


OPT. GOURMET 2
KITCHEN - PARTIAL
PARTIAL FLOOR PLAN

1/8"=1'-0"

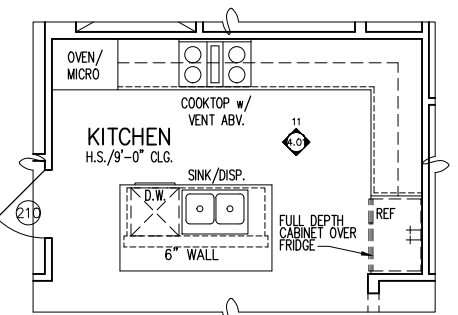


OPT. GOURMET 1
KITCHEN - PARTIAL
PARTIAL FLOOR PLAN

1/8"=1'-0"

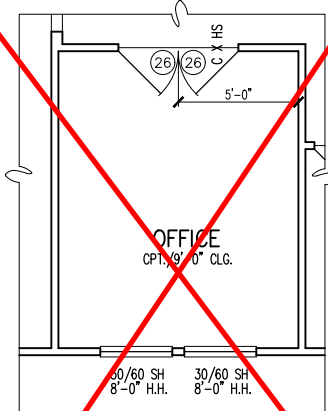

OPT. OFFICE
ILO FLEX SPACE
PARTIAL FLOOR PLAN

1/8"=1'-0"

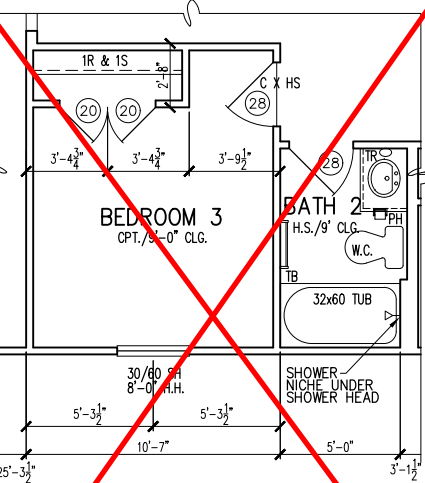

OPT. BEDROOM 3
ILO FLEX SPACE
PARTIAL FLOOR PLAN

1/8"=1'-0"

MAIN FLOOR NOTES	
#	EXPLANATION
1.	ALL NON-DIMENSIONED PARTITIONS ARE 3-1/2" ROUGH
2.	ALL ANGLED PARTITIONS ARE 45 DEGREES UNLESS NOTED OTHERWISE (U.N.O.)
3.	PROVIDE MIN. 2-2x12's w/ 1/2" PLYWD. FITCH PLATE AT ALL EXTERIOR WALL OPENINGS & INTERIOR BEARING WALL OPENINGS U.N.O.
4.	ALL EXTERIOR DIM'S ARE TO FACE OF STUDS U.N.O.
5.	ALL TRUSSES TO BEAR ON EXTERIOR WALLS AND/OR GIRDER TRUSS U.N.O.
6.	TRUSS MFG. TO SIZE MEMBERS, FASTENERS, HANGERS & SET SPACING FOR ALL TRUSSES
7.	WINDOW SUPPLIER TO VERIFY AT LEAST ONE WINDOW IN ALL BEDROOMS TO HAVE A CLEAR EGRESS OPENING OF 5.7 SQ. FT. w/ MIN DIM'S OF 24" IN HT AND 20" IN WIDTH; SILL HT NOT TO EXCEED 44" AFF
8.	ALL BALUSTER TO BE SPACED SUCH THAT A 4" SPHERE CANNOT PASS BETWEEN BALUSTER
9.	ALL ELEC. & MECH. EQUIPMENT & METERS ARE SUBJECT TO RELOCATION DUE TO FIELD CONDITIONS; CONTRACTOR TO VERIFY
10.	FOR ADDITIONAL NOTES, SEE GENERAL NOTES ON TITLE SHEET & DETAILS
11.	ALL TYP. WINDOWS 6'-0" IN HT AND SMALLER, THE HEAD HEIGHT SHALL BE 8'-10" ABOVE FINISHED FLOOR (U.N.O.)
12.	STRUCTURAL ENGINEERING PROVIDED BY OTHERS
13.	REFER TO INTERIOR ELEVATIONS SHEET TO VIEW BUBBLE CALLOUTS
14.	INTERIOR DOOR HEIGHTS ARE AS FOLLOWS - PRIMARY SUITE, PRIMARY BATH, & PRIMARY CLOSET ARE 8' TALL DOORS. ALL OTHER DOORS ARE 6'-8". BATH ACCESSORY INSTALLATION HEIGHTS ARE MEASURED TO CENTER OF ACCESSORY: TB - 60" A.F.F. TR - 20" ABV. VANITY COUNTER-TOP TH - 60" A.F.F. TP - 26" A.F.F. OPT. GRAB BAR (GB) - 36" A.F.F.
15.	SHUT-OFF VALVE TO BE LOCATED IN GARAGE
16.	ROD AND SHELF HEIGHTS ARE MEASURED TO TOP OF ROD AND BOTTOM OF SHELVES - SEE D-1.0 FOR DETAILS: 1R1S - ROD - 5'-8" 2R2S - TOP ROD - 6'-8" SHELF - 5'-10" TOP SHELF - 6'-10" BOTTOM ROD - 3'-4" BOTTOM SHELF - 3'-6"
17.	

tri pointe
HOMES

5440 WADE PARK BLVD, SUITE 400, RALEIGH, NC 27607

Business Operations
5440 Wade Park Blvd
Suite 400
Raleigh, NC 27607

© 2022

FLOOR PLAN - OPTIONS

SUBDIVISION: ALTIS AT SERENITY
ADDRESS: 98 SHADY CREEK WAY,
FUQUAY-VARINA, NC 27526
LOT: 370 BLOCK:

Issue Date: 10-13-24
Drawn By: ACC

PLAN #:
5920-04


PLAN NAME:
CYPRESS COVE

SHEET #:
01.A10

MAIN FLOOR NOTES	
#	EXPLANATION
1.	ALL NON-DIMENSIONED PARTITIONS ARE 3-1/2" ROUGH
2.	ALL ANGLED PARTITIONS ARE 45 DEGREES UNLESS NOTED OTHERWISE (U.N.O.)
3.	PROVIDE MIN. 2-2x12's w/ 1/2" PLYWD. FITCH PLATE AT ALL EXTERIOR WALL OPENINGS & INTERIOR BEARING WALL OPENINGS U.N.O.
4.	ALL EXTERIOR DIM'S ARE TO FACE OF STUDS U.N.O.
5.	ALL TRUSSES TO BEAR ON EXTERIOR WALLS AND/OR GIRDER TRUSS U.N.O.
6.	TRUSS MFG. TO SIZE MEMBERS, FASTENERS, HANGERS & SET SPACING FOR ALL TRUSSES
7.	WINDOW SUPPLIER TO VERIFY AT LEAST ONE WINDOW IN ALL BEDROOMS TO HAVE A CLEAR EGRESS OPENING OF 5.7 SQ. FT. w/MIN DIM'S OF 24" IN HT AND 20" IN WIDTH; SILL HT NOT TO EXCEED 44" AFF
8.	ALL BALUSTER TO BE SPACED SUCH THAT A 4" SPHERE CANNOT PASS BETWEEN BALUSTER
9.	ALL ELEC. & MECH. EQUIPMENT & METERS ARE SUBJECT TO RELOCATION DUE TO FIELD CONDITIONS; CONTRACTOR TO VERIFY
10.	FOR ADDITIONAL NOTES, SEE GENERAL NOTES ON TITLE SHEET & DETAILS
11.	ALL TYP. WINDOWS 6'-0" IN HT AND SMALLER, THE HEAD HEIGHT SHALL BE 8'-10" ABOVE FINISHED FLOOR (U.N.O.)
12.	STRUCTURAL ENGINEERING PROVIDED BY OTHERS
13.	REFER TO INTERIOR ELEVATIONS SHEET TO VIEW BUBBLE CALLOUTS
14.	INTERIOR DOOR HEIGHTS ARE AS FOLLOWS - PRIMARY SUITE, PRIMARY BATH, & PRIMARY CLOSET ARE 8' TALL DOORS. ALL OTHER DOORS ARE 6'-8".
15.	BATH ACCESSORY INSTALLATION HEIGHTS ARE MEASURED TO CENTER OF ACCESSORY: TB - 60" A.F.F. TR - 20" ABV. VANITY COUNTER-TOP TH - 60" A.F.F. TP - 26" A.F.F. OPT. GRAB BAR (GB) - 36" A.F.F.
16.	SHUT-OFF VALVE TO BE LOCATED IN GARAGE
17.	ROD AND SHELF HEIGHTS ARE MEASURED TO TOP OF ROD AND BOTTOM OF SHELVES - SEE D-1.0 FOR DETAILS: 1R1S - ROD - 5'-8" 2R2S - TOP ROD - 6'-8" SHELF - 5'-10" TOP SHELF - 6'-10" BOTTOM ROD - 3'-4" BOTTOM SHELF - 3'-6"

Lot 370
5920-04 Cypress Cove
Elevation A
Right-Hand Garage

- *Opt. Gourmet Kitchen 1
- *Opt. Primary Bath 1
- *Opt. Fireplace at Great Room
- *Opt. Door From Primary W.I.C. to Laundry
- *Opt. Screened Covered Outdoor Living
- *Opt. Outdoor Living Patio
- *Opt. Exterior Gas Stub Out
- *Opt. Fire-Rated Garage Side
- *Opt. Fire-Rated Non-Garage Side

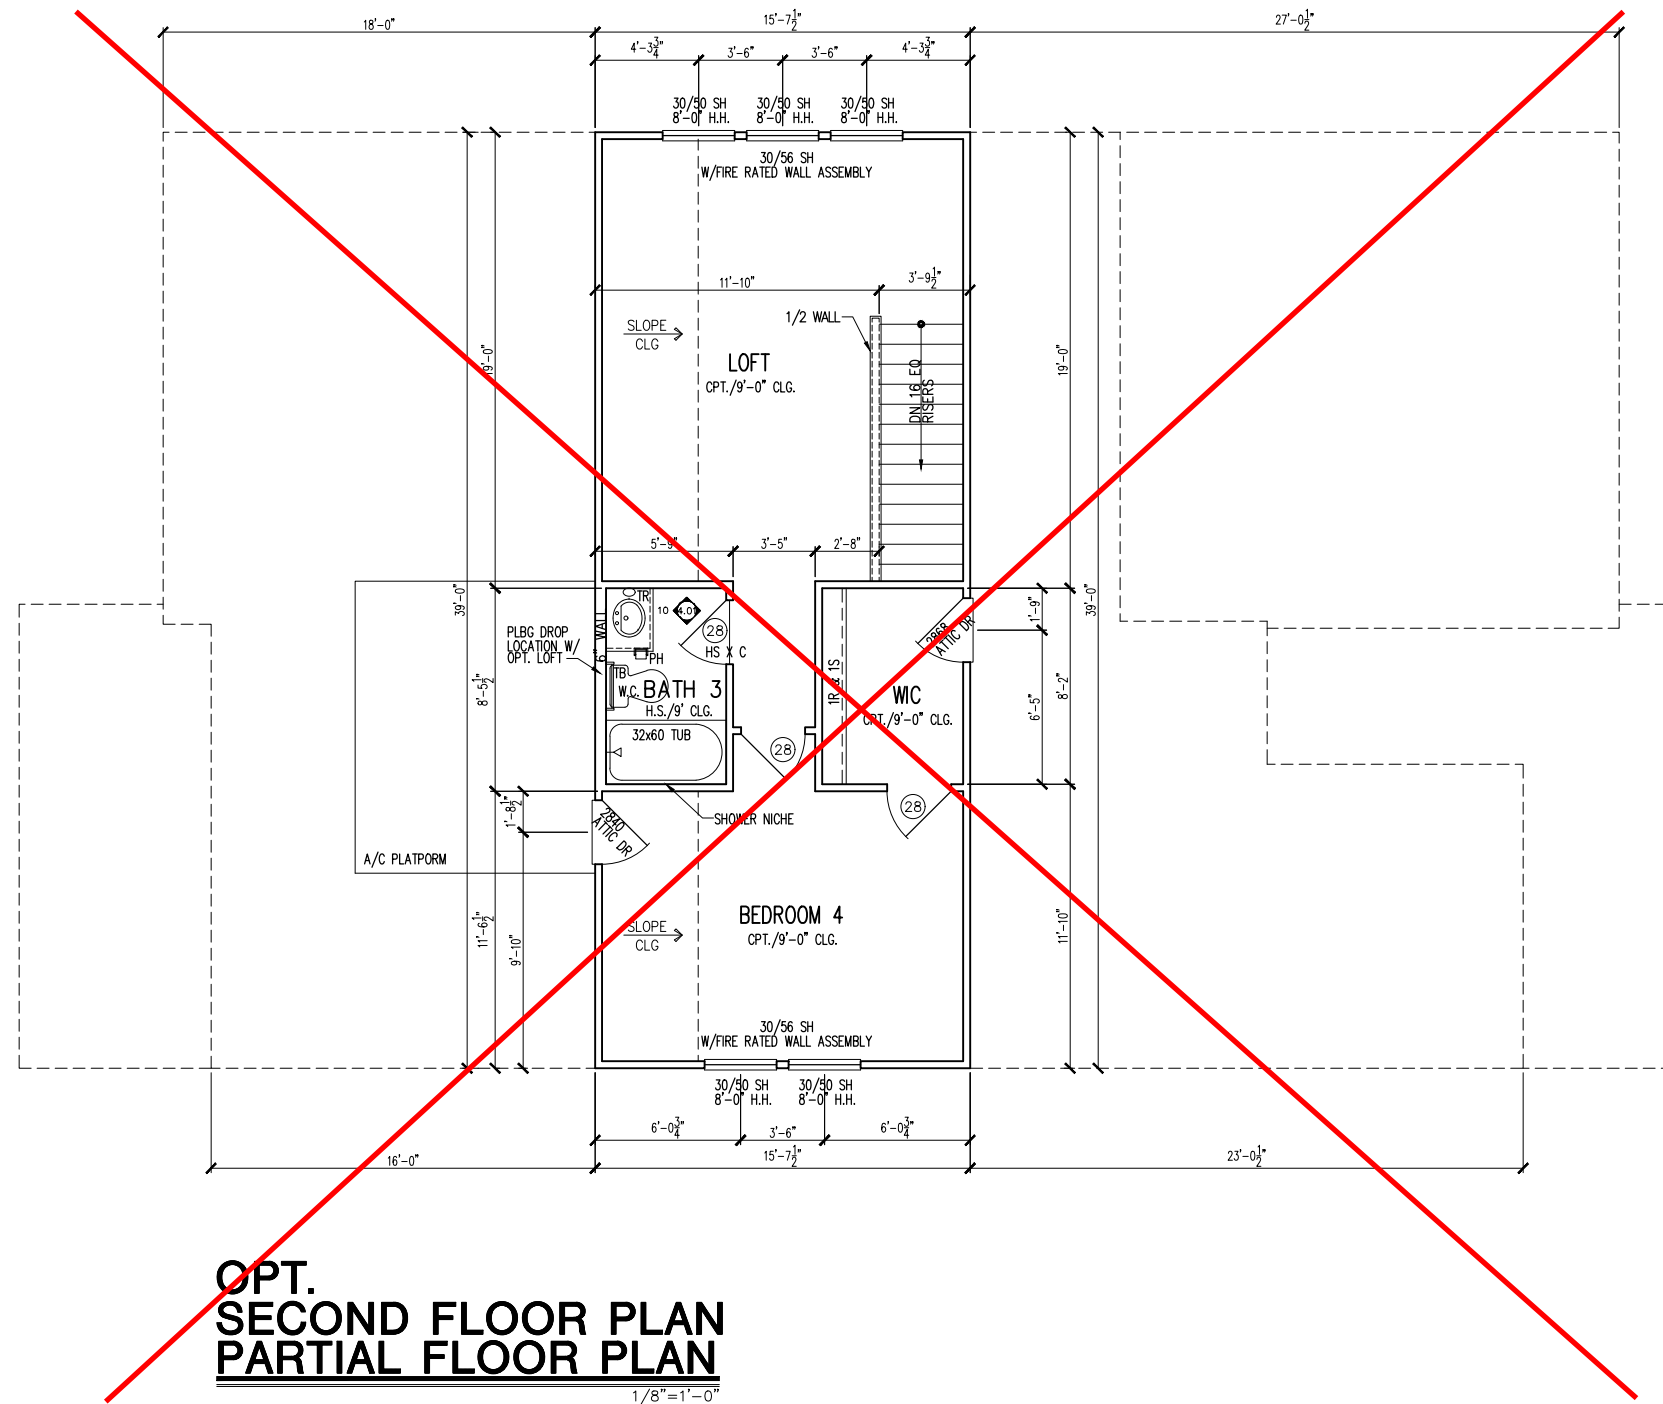

**UNDER 9,000 FT² -
FIRE-RATED WALL
REQUIRED AT
GARAGE SIDE &
NON-GARAGE SIDE**

tri pointe
H O M E S

5440 WADE PARK BLVD, SUITE 400, RALEIGH, NC 27607

Business Operations
5440 Wade Park Blvd
Suite 400
Raleigh, NC 27607

© 2022

2ND FLOOR PLAN - OPTION


SUBDIVISION: **ALTIS AT SERENITY**
ADDRESS: **98 SHADY CREEK WAY,
FUQUAY-VARINA, NC 27526**
LOT: **370** BLOCK:

Issue Date: **10-13-24**
Drawn By: **ACC**


PLAN #:
5920-04

PLAN NAME:
CYPRESS COVE


SHEET #:
01.A20

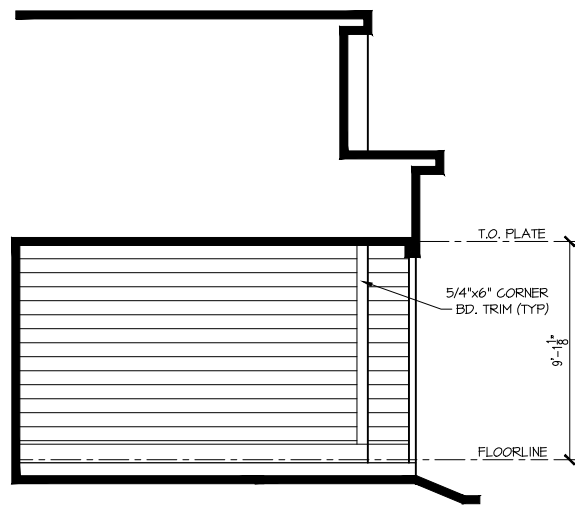


**LEFT INSIDE
PORCH ELEV. "A"**
1/8"=1'-0"

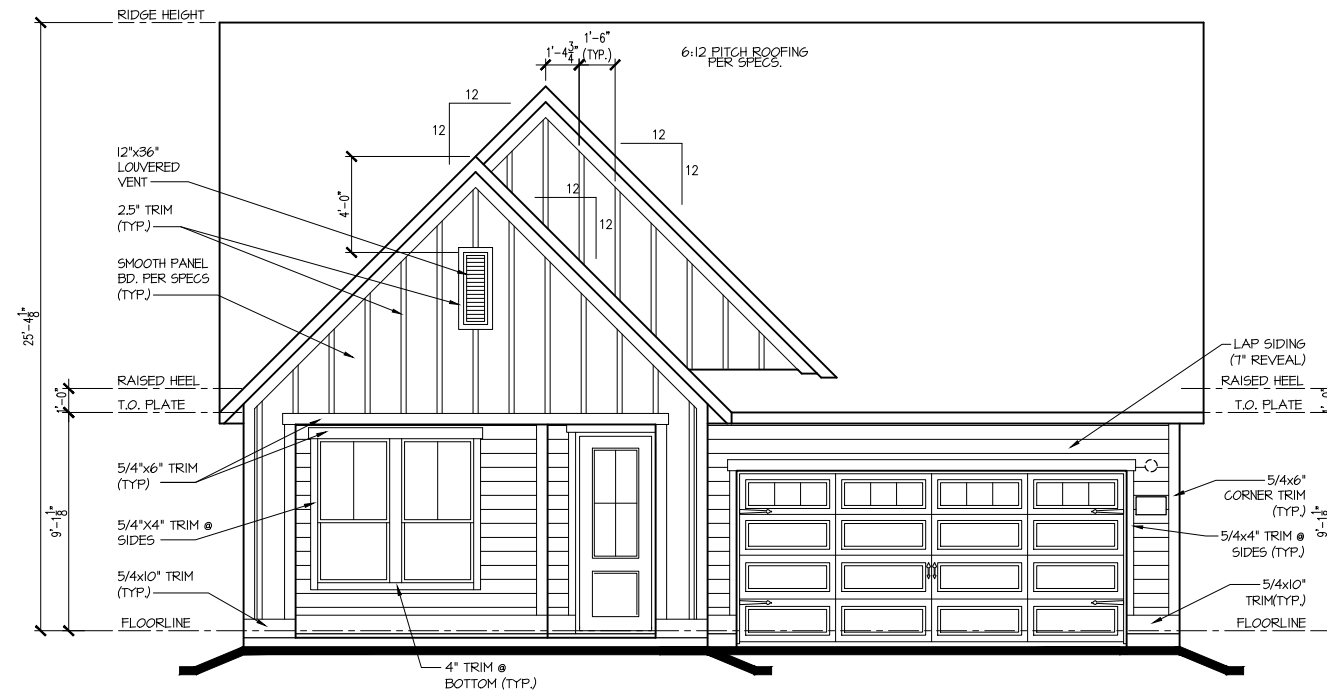


FRONT ELEV. "A"
1/8"=1'-0"

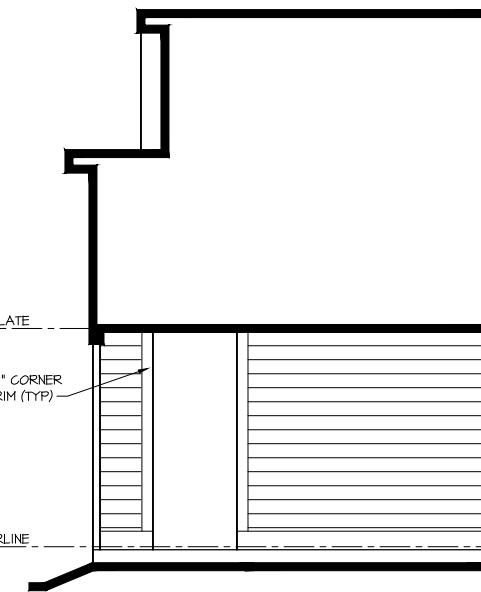

**RIGHT INSIDE
PORCH ELEV. "A"**
1/8"=1'-0"

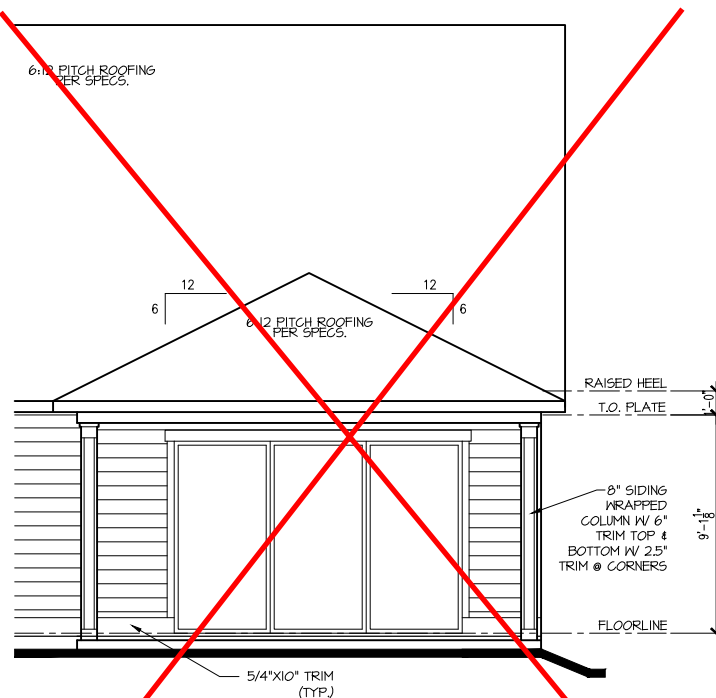

**OPT. 12'x8' SLIDING GLASS
DOOR @ GREAT ROOM / DINING
PARTIAL REAR ELEVATION**
1/8"=1'-0"

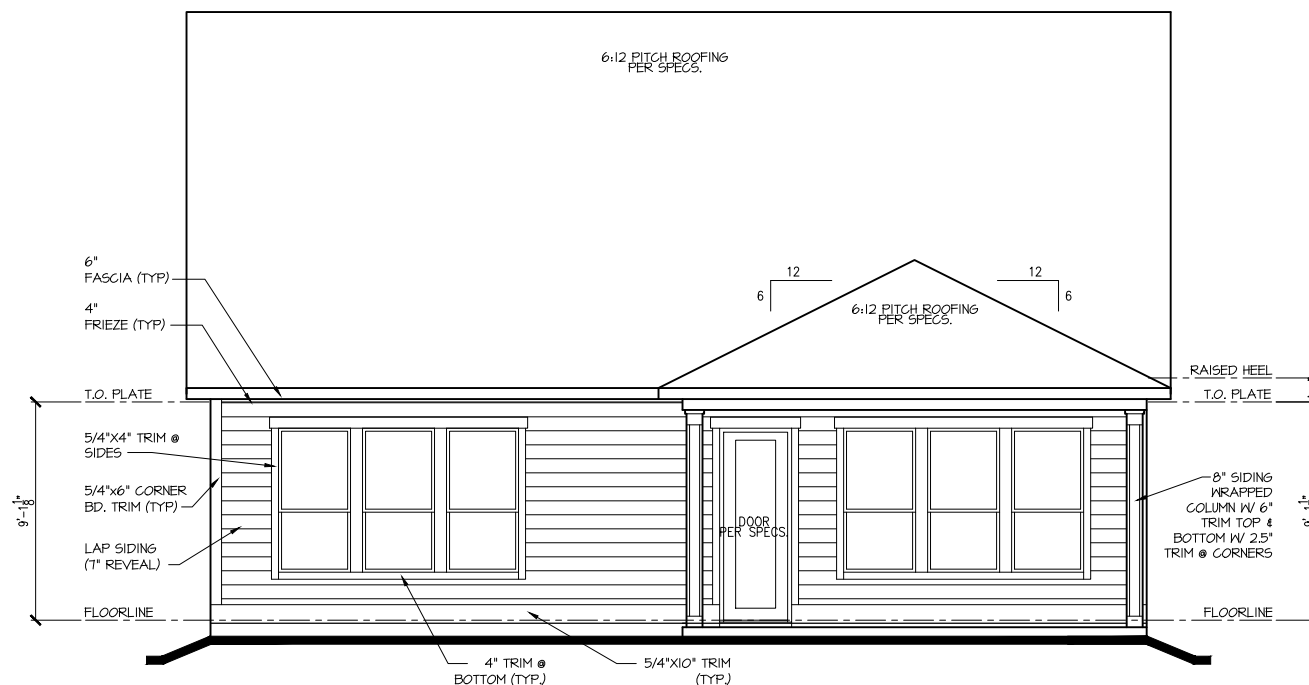

REAR ELEV. "A"
1/8"=1'-0"

*Opt. Screened
Covered Outdoor Living

Lot 370
5920-04 Cypress Cove
Elevation A
Right-Hand Garage

**UNDER 9,000 FT² -
FIRE-RATED WALL
REQUIRED AT
GARAGE SIDE &
NON-GARAGE SIDE**

tri pointe
HOMES
5440 WADE PARK BLVD., SUITE 400, RALEIGH, NC 27607

Business Operations
5440 Wade Park Blvd
Suite 400
Raleigh, NC 27607
© 2022

EXTERIOR ELEVATIONS
SUBDIVISION: ALTIS AT SERENITY
ADDRESS: 98 SHADY CREEK WAY,
LOT: 370 BLOCK:


Issue Date: 10-13-24
Drawn By: ACC

PLAN #: 5920-04

PLAN NAME: CYPRESS COVE

SHEET #: A2.01A


*Opt. Screened
Covered Outdoor Living

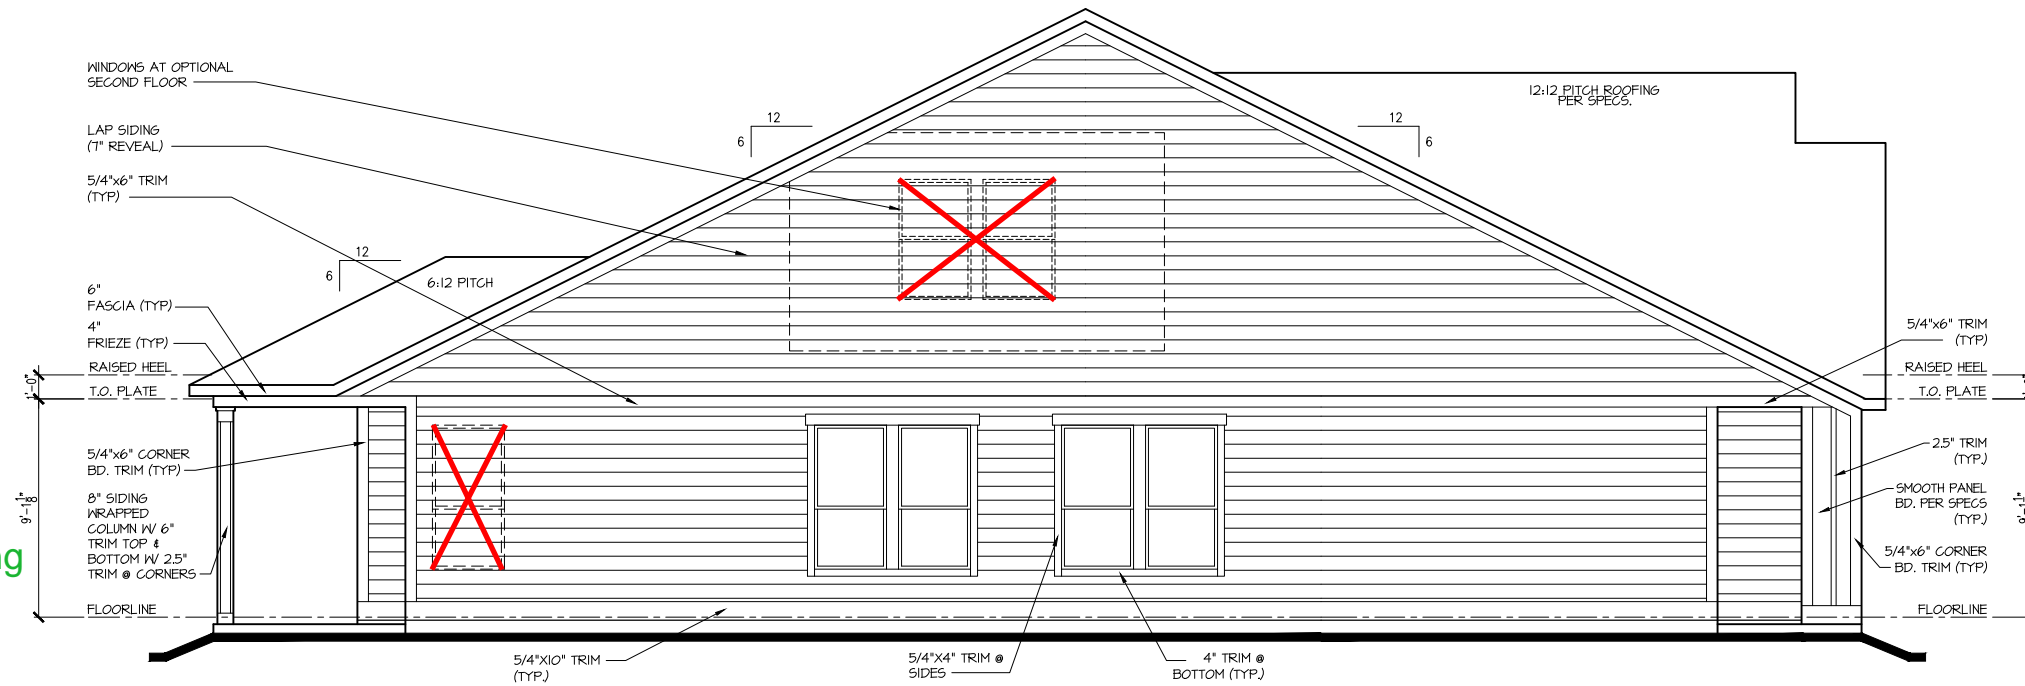

LEFT ELEV. "A"
1/8"=1'-0"

*Opt. Fire-Rated
Non-Garage Side

*Opt. Screened
Covered Outdoor Living

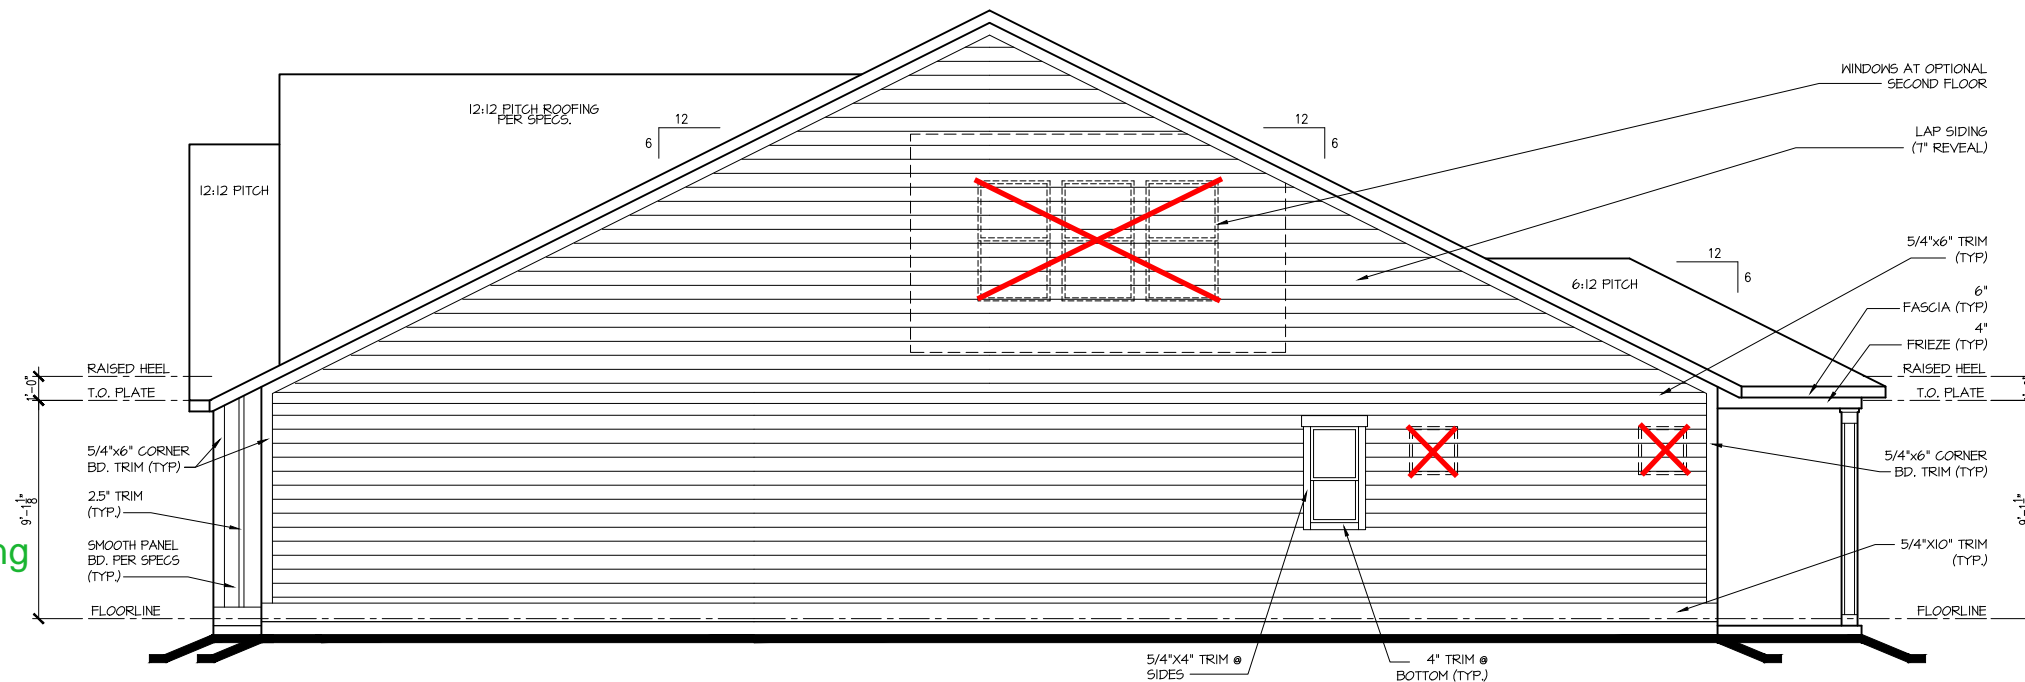

RIGHT ELEV. "A"
1/8"=1'-0"

*Opt. Fire-Rated
Garage Side

Lot 370
5920-04 Cypress Cove
Elevation A
Right-Hand Garage

**UNDER 9,000 FT² -
FIRE-RATED WALL
REQUIRED AT GARAGE
SIDE & NON-GARAGE SIDE**

tri pointe
H O M E S
5440 WADE PARK BLVD, SUITE 400, RALEIGH, NC 27607

Business Operations
5440 Wade Park Blvd
Suite 400
Raleigh, NC 27607
© 2022

EXTERIOR ELEVATIONS

SUBDIVISION: **ALTIS AT SERENITY**
ADDRESS: **98 SHADY CREEK WAY,
FUQUAY-VARINA, NC 27526**
LOT: **370** BLOCK:


Issue Date: **10-13-24**
Drawn By: **ACC**

PLAN #:
5920-04

PLAN NAME:
CYPRESS COVE


SHEET #:
A2.02A

UNDER 9,000 FT² -
FIRE-RATED WALL
REQUIRED AT
GARAGE SIDE &
NON-GARAGE SIDE

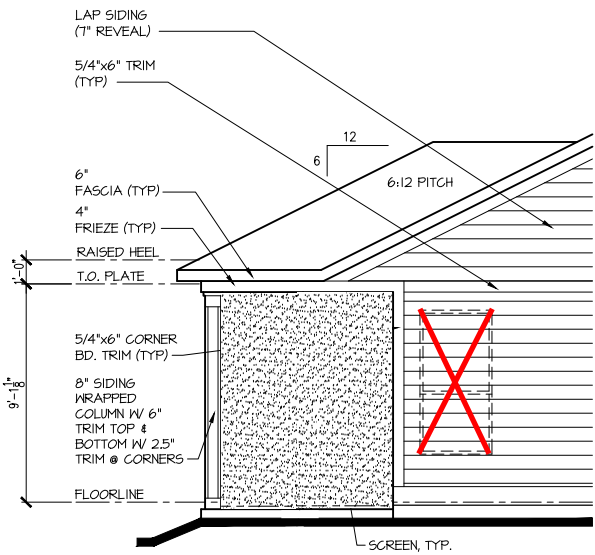

OPT. SCREENED
COVERED OUTDOOR LIVING
PARTIAL LEFT ELEVATION


1/8"=1'-0"

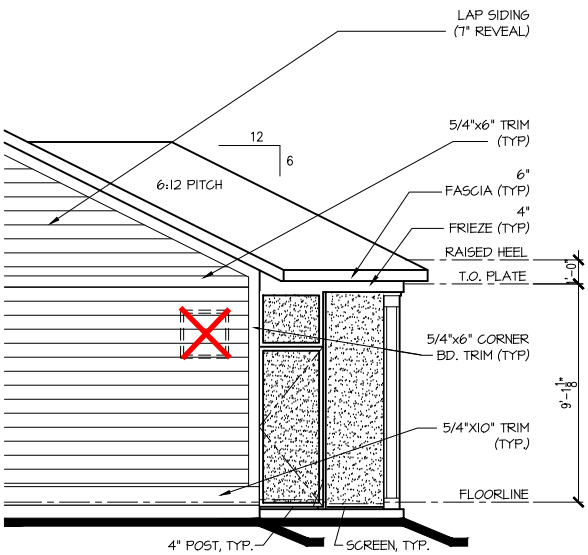

OPT. SCREENED
COVERED OUTDOOR LIVING
PARTIAL RIGHT ELEVATION

1/8"=1'-0"

Lot 370
5920-04 Cypress Cove
Elevation A
Right-Hand Garage

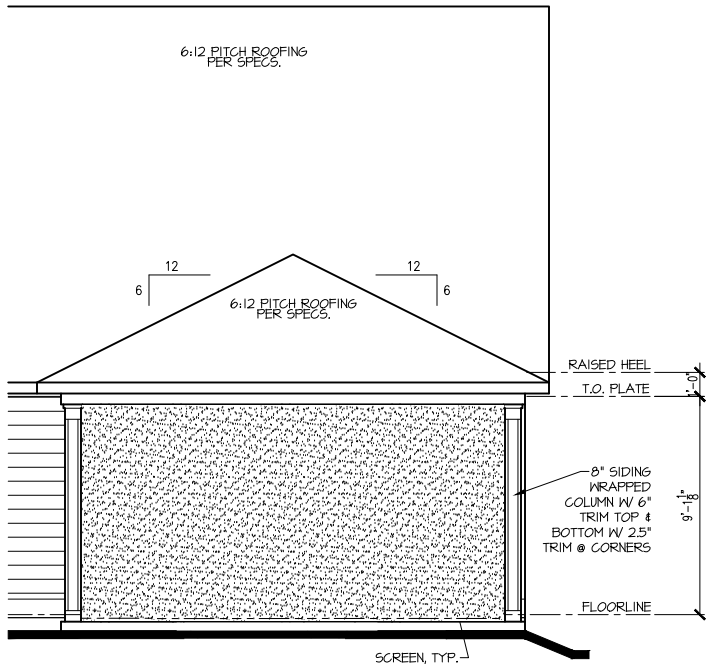

OPT. SCREENED
COVERED OUTDOOR LIVING
PARTIAL REAR ELEVATION

1/8"=1'-0"

*Screens Per
Manufacturer

EXTERIOR ELEVATIONS OPTION

SUBDIVISION: ALTIS AT SERENITY
ADDRESS: 98 SHADY CREEK WAY,
FUQUAY-VARINA, NC 27526
LOT: 370 BLOCK:

Issue Date: 10-13-24
Drawn By: ACC


PLAN #:
5920-04

PLAN NAME:
CYPRESS COVE

SHEET #:
A2.03A

Business Operations
5440 Wade Park Blvd
Suite 400
Raleigh, NC 27607
© 2022

tri pointe
HOMES
5440 WADE PARK BLVD, SUITE 400, RALEIGH, NC 27607

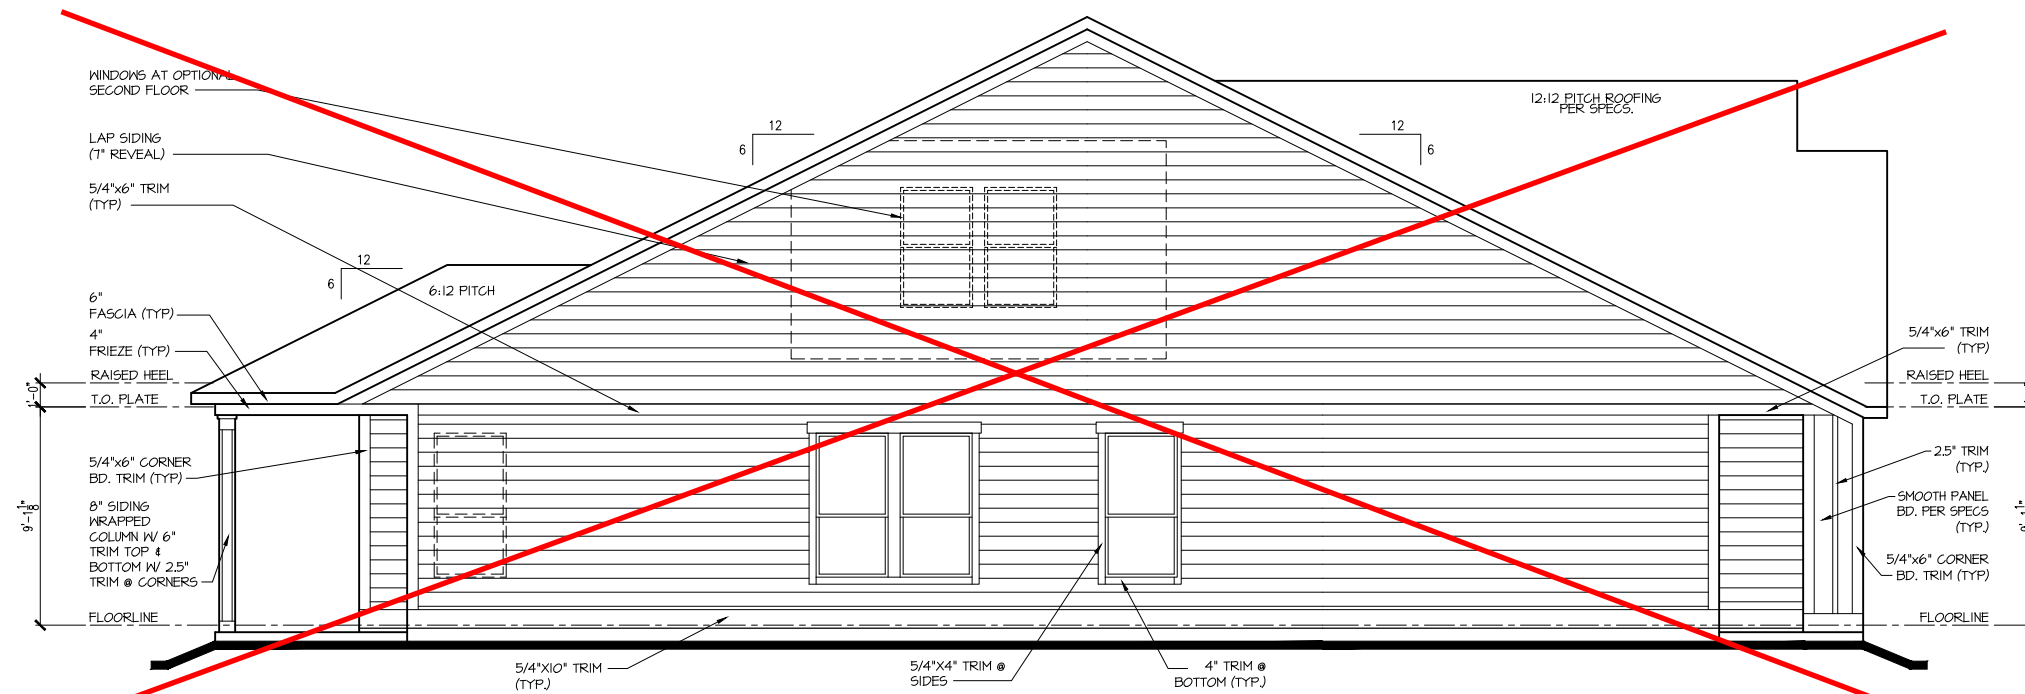

LEFT ELEV. "A" - OPT. BEDROOM 3 ILO FLEX

Lot 370
5920-04 Cypress Cove
Elevation A
Right-Hand Garage

UNDER 9,000 FT² -
FIRE-RATED WALL
REQUIRED AT
GARAGE SIDE &
NON-GARAGE SIDE

tri pointe
HOMES
5440 WADE PARK BLVD, SUITE 400, RALEIGH, NC 27607

Business Operations
5440 Wade Park Blvd
Suite 400
Raleigh, NC 27607
© 2022

EXTERIOR ELEVATIONS OPTION

SUBDIVISION: **ALTIS AT SERENITY**
ADDRESS: **98 SHADY CREEK WAY,**
FUQUAY-VARINA, NC 27526
LOT: **370** BLOCK:

Issue Date: **10-13-24**
Drawn By: **ACC**

PLAN #:
5920-04

PLAN NAME:
CYPRESS COVE


SHEET #:
A2.04A

Lot 370
5920-04 Cypress Cove
Elevation A
Right-Hand Garage

UNDER 9,000 FT² -
FIRE-RATED WALL
REQUIRED AT
GARAGE SIDE &
NON-GARAGE SIDE

Attic Venting Calculations Elev. "A"	
ROOF INFORMATION	BASE
TOTAL SF ROOF AREA	2763
AVAILABLE L.F. ROOF SOFFIT	70
AVAILABLE L.F. ROOF RIDGE	62
VENT TYPES	QTY VENTS REQ'D
LOWER VENTS CONTINUOUS SOFFIT VENTING @ 5 S/LF	133 LF
UPPER VENTS SLANT 150 VENTS @ 150 S/LVENT	4
UPPER VENTS RIDGE VENTS @ 72 S/LVENT	9

NOTE:
QTY OF UPPER VENTS SHOWN COVERS 100% OF UPPER VENTING. NO MIXING
OF VENT TYPES FOR UPPER VENTING IS FIGURED FOR IN THIS TABLE.

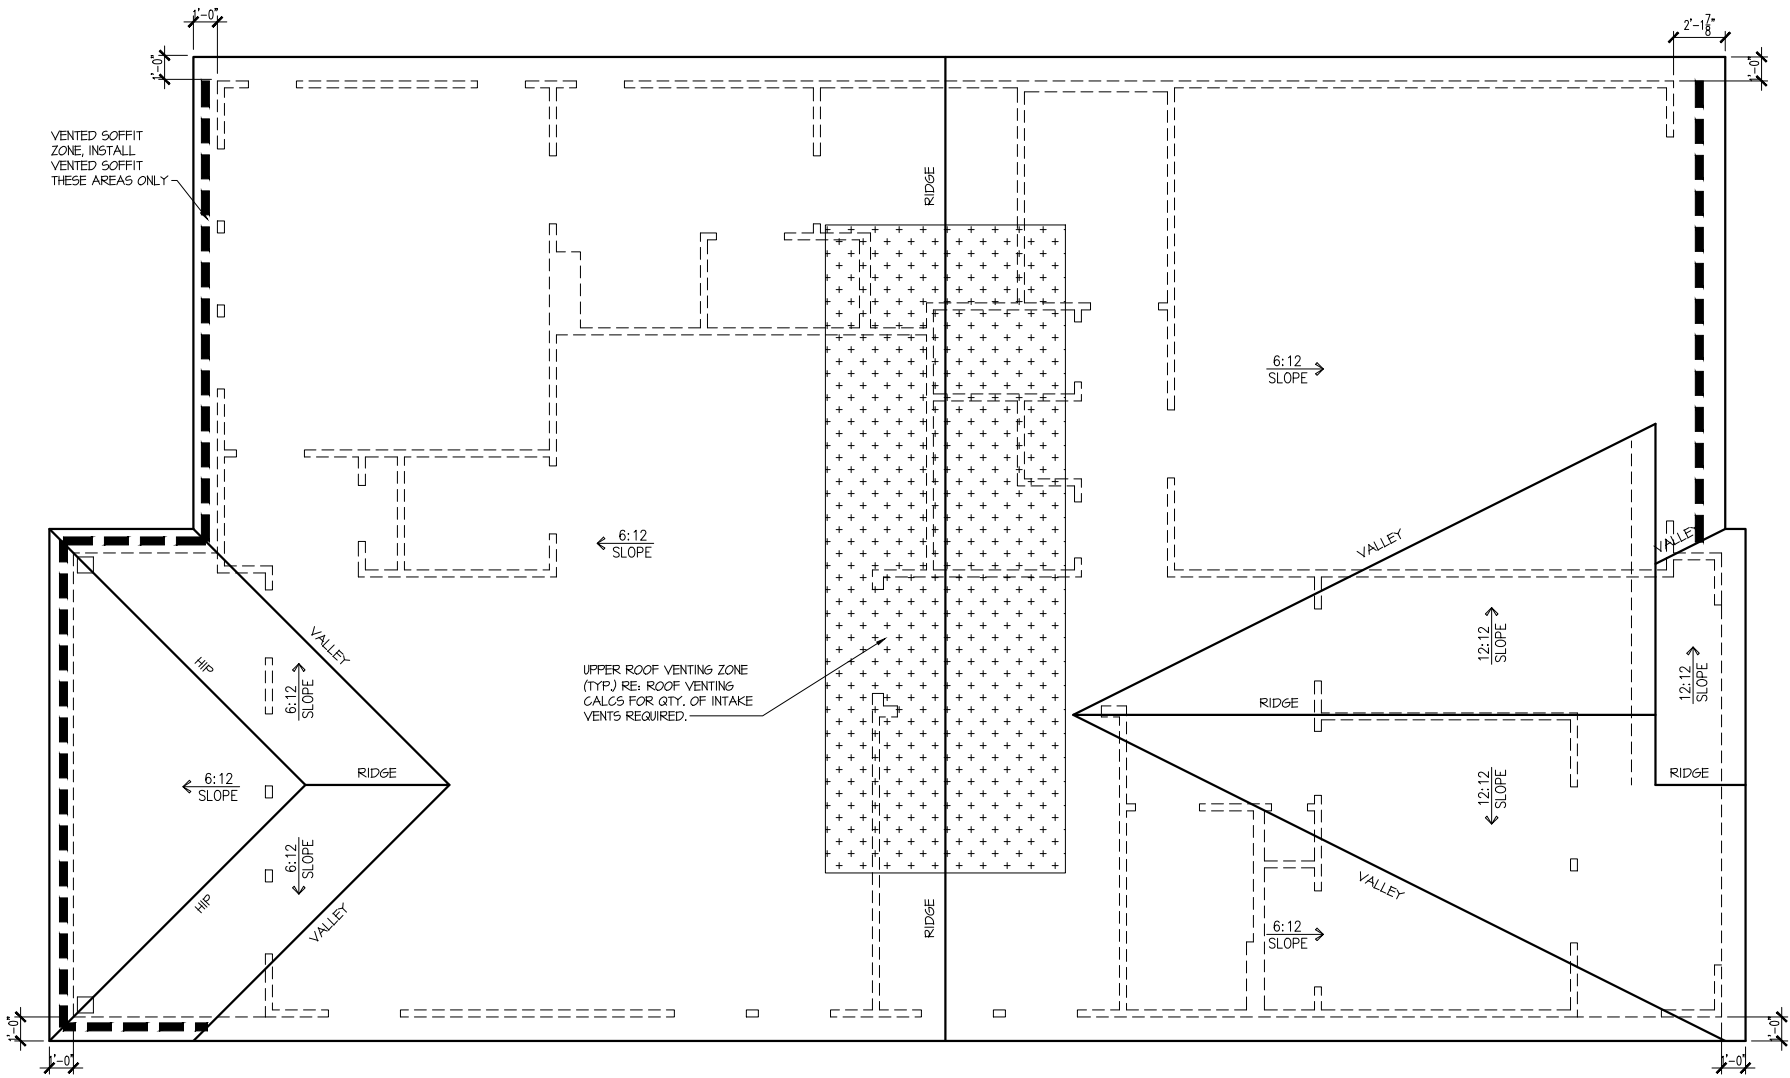

ROOF PLAN 'A'

SCALE: 1/8" = 1'-0"

tri pointe
H O M E S

5440 WADE PARK BLVD, SUITE 400, RALEIGH, NC 27607

Business Operations
5440 Wade Park Blvd
Suite 400
Raleigh, NC 27607

© 2022

ROOF PLAN


SUBDIVISION: ALTIS AT SERENITY
ADDRESS: 98 SHADY CREEK WAY,
FUQUAY-VARINA, NC 27526
LOT: 370 BLOCK:

Issue Date: 10-13-24
Drawn By: ACC


PLAN #:
5920-04

PLAN NAME:
CYPRESS COVE


SHEET #:
A3.01A

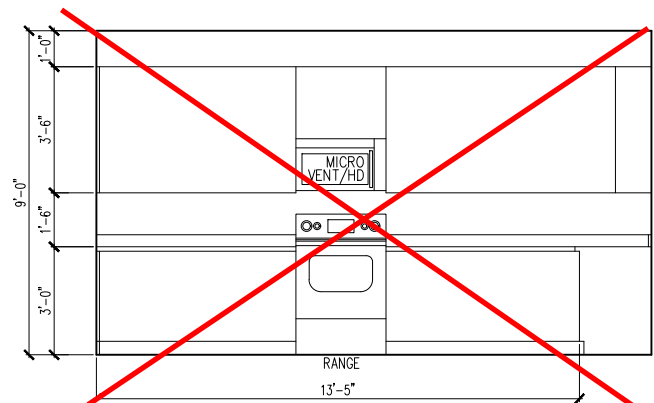


1 KITCHEN

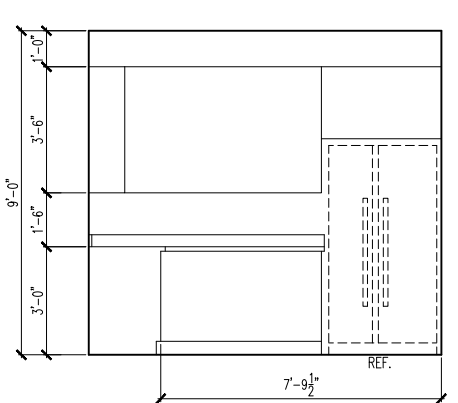


2 KITCHEN

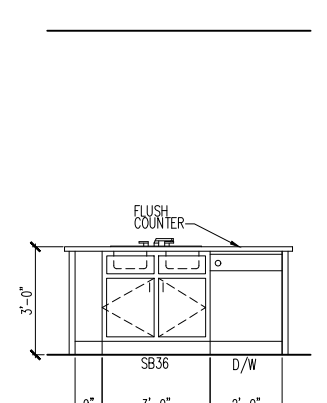


3 KITCHEN ISLAND

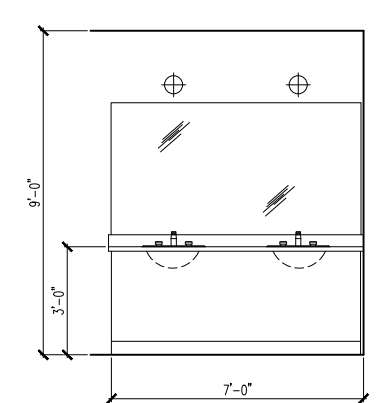


4 PRIMARY BATH

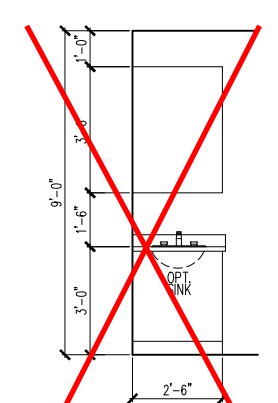

5 LAUNDRY ROOM

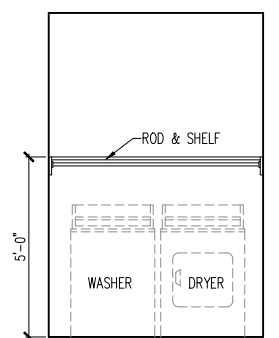


6 LAUNDRY ROOM

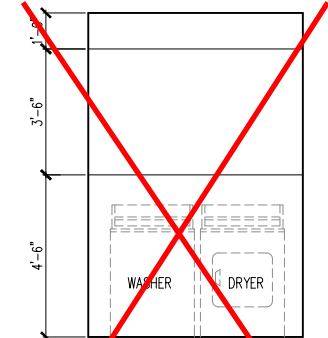


7 LAUNDRY ROOM w/ OPT CABINETS

FRONT VIEW

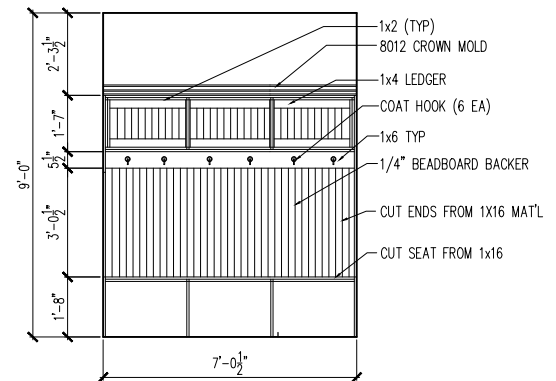


7 TYPICAL BENCH DETAIL (DROP ZONE)


SIDE VIEW

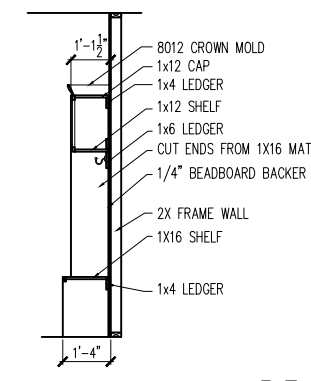


FRONT VIEW

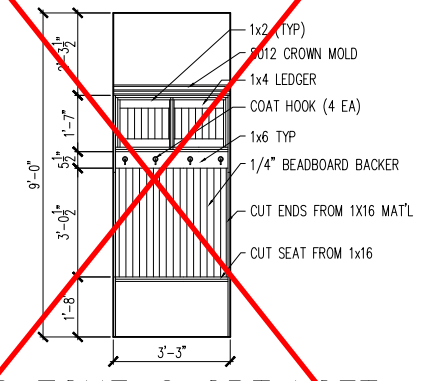


DROP ZONE @ OPT LOFT

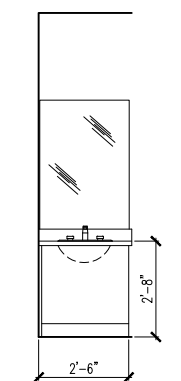


9 BATH 2

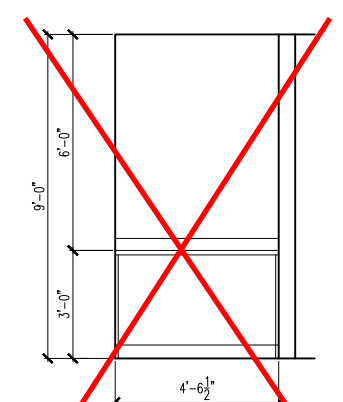


8 PRIMARY SUITE HALL 1 w/ OPT CABINETS

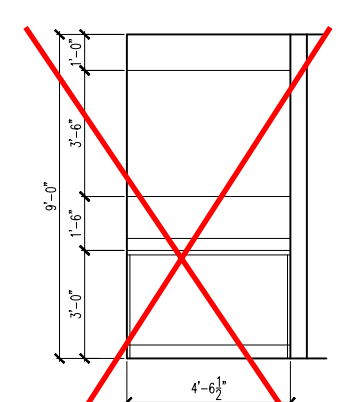


9 PRIMARY SUITE HALL 2 w/ OPT CABINETS

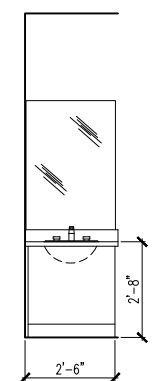

10 BATH 3 w/ OPT LOFT

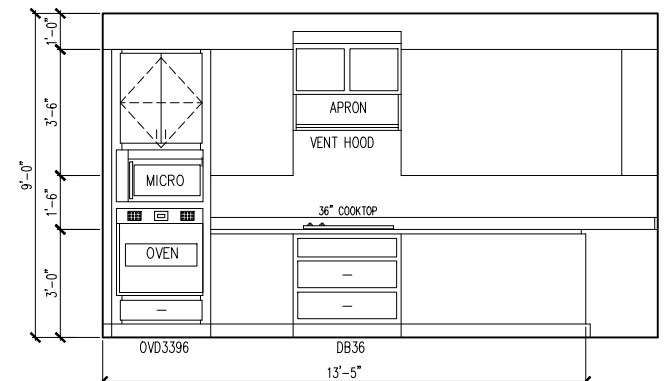

11 OPT. GOURMET KITCHEN 1 w/ OPT OVEN/MICRO

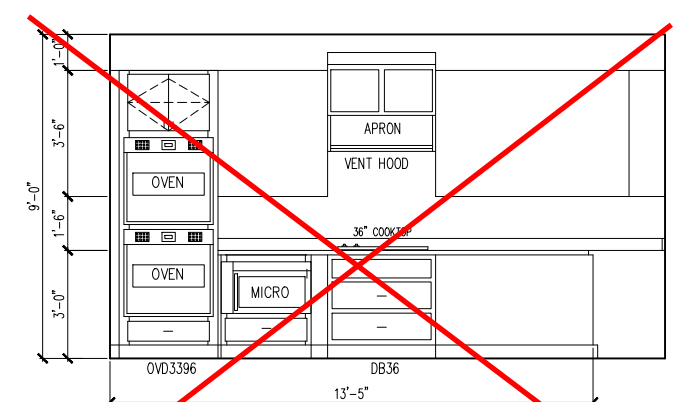

12 OPT. GOURMET KITCHEN 2 w/ OPT DBL OVEN

INTERIOR DETAIL SHEET

SUBDIVISION: **ALTIS AT SERENITY**
ADDRESS: **98 SHADY CREEK WAY,**
FUQUAY-VARINA, NC 27526
LOT: **370** BLOCK:

Issue Date: **10-13-24**
Drawn By: **ACC**

PLAN #:
5920-04

PLAN NAME:
CYPRESS COVE

SHEET #:
A4.01

tri pointe
HOMES
5440 WADE PARK BLVD, SUITE 400, RALEIGH, NC 27607

Business Operations
5440 Wade Park Blvd
Suite 400
Raleigh, NC 27607
© 2022

ELECTRICAL FIXTURE SCHEDULE	
DESCRIPTION	SYMBOL
110V OUTLET	⊕
220V OUTLET	⊕ 220
1/2 HOT OUTLET	⊕
GFI OUTLET	⊕ GFI
WP GFI OUTLET	⊕ WP/GFI
GARAGE DOOR OPENER OUTLET	⊕ GDO
SECURITY SYSTEM	⊕ SEC SYS
DISHWASHER	⊕ DW
JUNCTION BOX	⊕
CEILING MOUNTED LIGHT	⊕
CEILING FAN w/ LIGHT KIT	⊕ PROVIDE BRACING
RECESSED CEILING LIGHT	⊕
RECESSED WATER PROOF LIGHT	⊕ WP
WALL MOUNTED LIGHT	⊕
WALL MOUNTED PUSH BUTTON	⊕ PB
TWO WAY SWITCH	⊕
THREE WAY SWITCH	⊕
FOUR WAY SWITCH	⊕
DIMMER SWITCH	⊕ DIM
EXHAUST VENTS	⊕ VENT TO EXT
LOW VOLTAGE PANEL	⊕
PHONE OUTLET	⊕ PH
TV OUTLET	⊕ TV
DATA & RG6 COMBO BOX	⊕
SMOKE DETECTOR	⊕
CARBON MONOXIDE SMOKE DETECTOR COMBO	⊕ CM/SD
DOOR CHIMES	⊕ CHIMES
ELECTRICAL PANEL	⊕ EP
SURFACE MOUNT LED	⊕
EXTERIOR WALL MOUNT UPLIGHT	⊕
SOFFIT MOUNT FLOOD LIGHT	⊕
UNDER COUNTER LIGHTING	⊕ UCL
SMURF TUBE

ELECTRICAL NOTES:

1. PROVIDE AND INSTALL LOCALLY CERTIFIED SMOKE AND CARBON MONOXIDE DETECTORS AS REQUIRED BY NATIONAL FIRE PROTECTION ASSOCIATION (NFPA) AND MEETING THE REQUIREMENTS OF ALL GOVERNING CODES

2. PROVIDE AND INSTALL GROUND FAULT CIRCUIT-INTERRUPTERS (GFI) AS REQUIRED BY NATIONAL ELECTRIC CODE (NEC) AND MEETING THE REQUIREMENTS OF ALL GOVERNING CODES.

3. ELECTRICAL CONTRACTOR TO PROVIDE REQUIRED DIRECT HOOK-UPS/CUTOFFS.

4. HVAC CONTRACTOR TO VERIFY THERMOSTAT LOCATIONS.

5. ALL ELECTRICAL AND MECHANICAL EQUIPMENT (I.E. FURNACES, A/C UNITS, ELECTRICAL PANELS, SANITARY SUMP PITS, DRAIN TILE SUMP, AND WATER HEATERS) ARE SUBJECT TO RELOCATION DUE TO FIELD CONDITIONS.
- ELECTRICAL DEVICES:

ABOVE FINISHED FLOOR:

SWITCHES OVER COUNTER. 48". TO CL

WALL OUTLETS OVER COUNTER.

+42" TO BOTTOM OF HORIZONTAL OUTLET(TYP. @ COUNTER)

REMAINING SWITCHES. 48". TO CL

WALL OUTLETS. 12". TO CL . .

BATH VANITY BRACKET OUTLET. 1.2

(1" ABOVE TOP OF VANITY)

WATER SOFTENER AND SUMP OUTLETS. 48" TO CL

EXTERIOR GFI OUTLETS. 12". TO CL

GARAGE GFI (ABOVE GARAGE FLOOR). 48" TO CL

FRONT DOOR COACH LIGHT. 80". TO CL

GARAGE DOOR COACH LIGHT. 84". TO CL

(ABOVE GARAGE FLOOR).

THERMOSTAT. 54". TO CL . .

DOORBELL CHIMES. 84". TO CL

LEVEL W/ DR HANDLE

DOORBELL BUTTON.

KITCHEN HOOD FAN "WHIP". 66". TO CL

KITCHEN WALL HUNG MICROWAVE OUTLET 72". TO CL

KITCHEN DISHWASHER RECEPTACLE. UNDER SINK

KITCHEN RANGE. 24". TO CL . .

KITCHEN REFRIGERATOR. 48". TO CL

WASHER/DRYER OUTLET. 48". TO CL

CL = CENTER LINE


1 = FIELD VERIFY

2 = MASTER BATH STANDARD 30" HIGH VANITY TO BE RAISED 4"

Lot 370
5920-04 Cypress Cove
Elevation A
Right-Hand Garage

- *Opt. Gourmet Kitchen 1
- *Opt. Primary Bath 1
- *Opt. Fireplace at Great Room
- *Opt. Door From Primary W.I.C. to Laundry
- *Opt. Screened Covered Outdoor Living
- *Opt. Outdoor Living Patio
- *Opt. Exterior Gas Stub Out
- *Opt. Fire-Rated Garage Side
- *Opt. Fire-Rated Non-Garage Side

UNDER 9,000 FT² -
FIRE-RATED WALL
REQUIRED AT
GARAGE SIDE &
NON-GARAGE SIDE

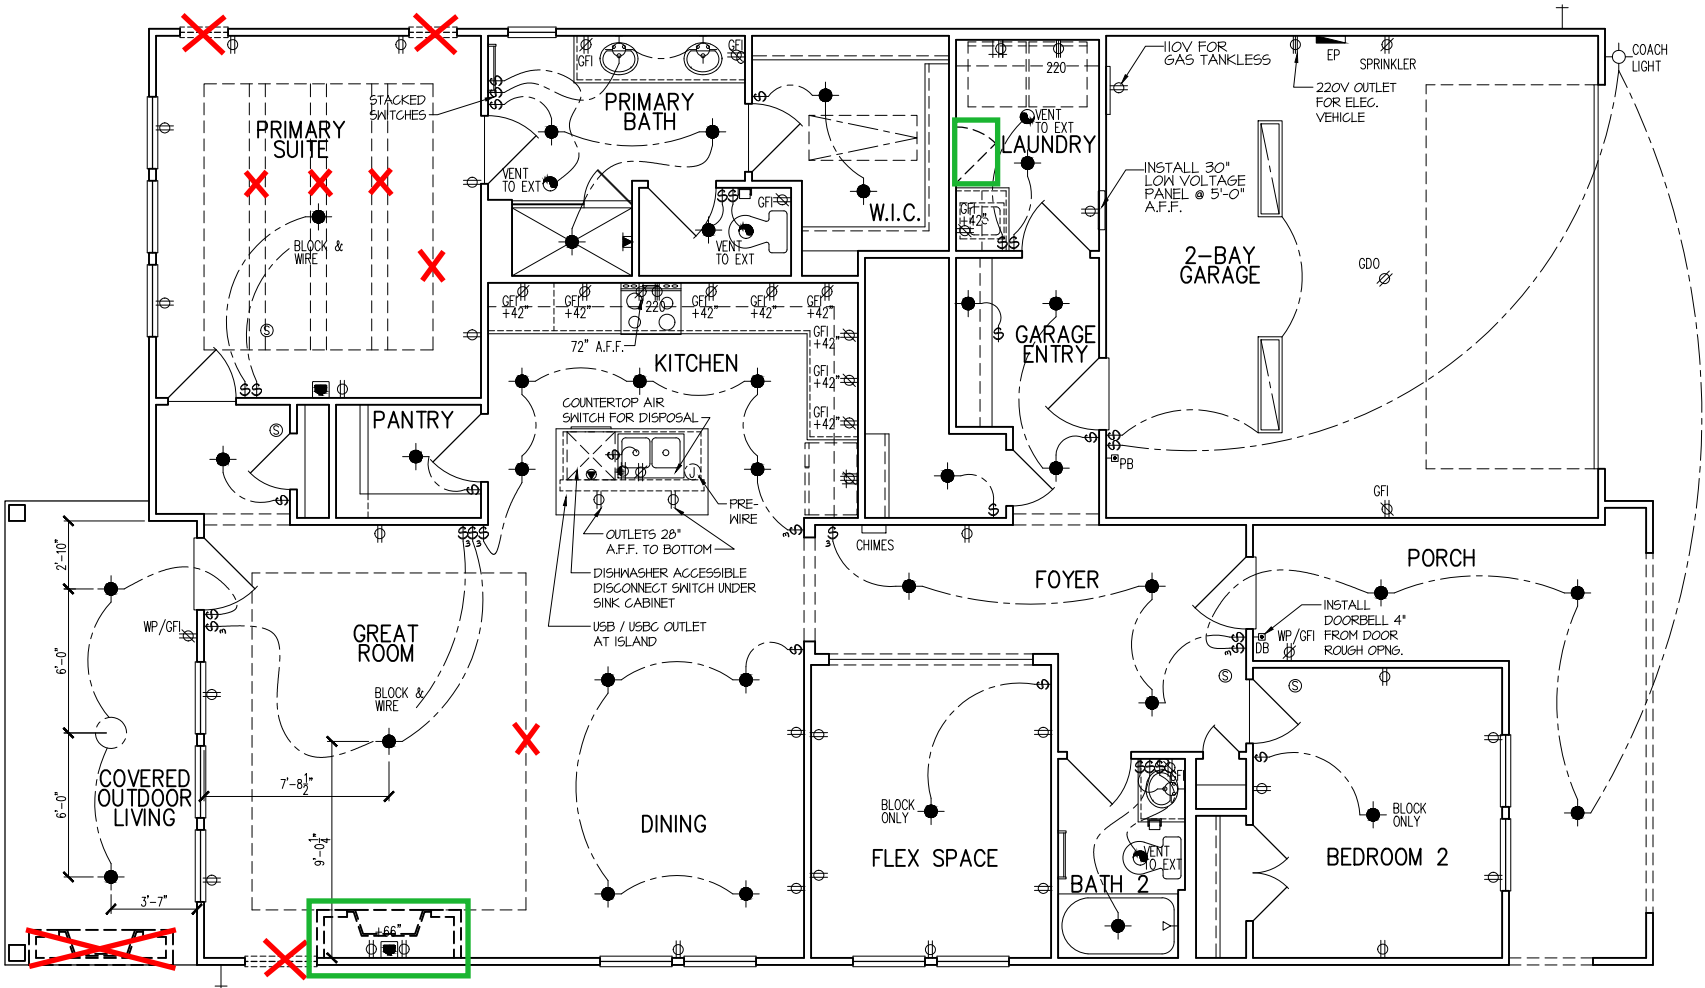

tri pointe
HOMES

Business Operations
5440 Wade Park Blvd
Suite 400
Raleigh, NC 27607

1st FLOOR ELECTRICAL PLAN

SUBDIVISION: ALTIS AT SERENITY
ADDRESS: 98 SHADY CREEK WAY,
FUQUAY-VARINA, NC 27526
LOT: 370 BLOCK:

Issue Date: 10-13-24
Drawn By: ACC

PLAN #:
5920-04

PLAN NAME:
CYPRESS COVE

SHEET #:
E1.10A

ELECTRICAL FIXTURE SCHEDULE	
DESCRIPTION	SYMBOL
110V OUTLET	⌀
220V OUTLET	⌀ 220
1/2 HOT OUTLET	⌀
GFI OUTLET	⌀ GFI
WP GFI OUTLET	⌀ WP/GFI
GARAGE DOOR OPENER OUTLET	⌀ GDO
SECURITY SYSTEM	⌀ SEC SYS
DISHWASHER	⌀ DW
JUNCTION BOX	⌀
CEILING MOUNTED LIGHT	⌀
CEILING FAN w/ LIGHT KIT	⌀ PROVIDE BRACING
RECESSED CEILING LIGHT	⌀
RECESSED WATER PROOF LIGHT	⌀ WP
WALL MOUNTED LIGHT	⌀
WALL MOUNTED PUSH BUTTON	⌀ PB
TWO WAY SWITCH	⌀
THREE WAY SWITCH	⌀
FOUR WAY SWITCH	⌀
DIMMER SWITCH	⌀ DIM
EXHAUST VENTS	⌀ VENT TO EXT
LOW VOLTAGE PANEL	⌀
PHONE OUTLET	⌀ PH
TV OUTLET	⌀ TV
DATA & RG6 COMBO BOX	⌀
SMOKE DETECTOR	⌀
CARBON MONOXIDE SMOKE DETECTOR COMBO	⌀ CM/SD
DOOR CHIMES	CHIMES
ELECTRICAL PANEL	⌀ EP
SURFACE MOUNT LED	⌀
EXTERIOR WALL MOUNT UP LIGHT	⌀
SOFFIT MOUNT FLOOD LIGHT	⌀
UNDER COUNTER LIGHTING	⌀ UCL
SMURF TUBE	⌀

ELECTRICAL NOTES:

1. PROVIDE AND INSTALL LOCALLY CERTIFIED SMOKE AND CARBON MONOXIDE DETECTORS AS REQUIRED BY NATIONAL FIRE PROTECTION ASSOCIATION (NFPA) AND MEETING THE REQUIREMENTS OF ALL GOVERNING CODES.
2. PROVIDE AND INSTALL GROUND FAULT CIRCUIT-INTERRUPTERS (GFI) AS REQUIRED BY NATIONAL ELECTRIC CODE (NEC) AND MEETING THE REQUIREMENTS OF ALL GOVERNING CODES.
3. ELECTRICAL CONTRACTOR TO PROVIDE REQUIRED DIRECT HOOK-UPS/CUTOFFS.
4. HVAC CONTRACTOR TO VERIFY THERMOSTAT LOCATIONS.
5. ALL ELECTRICAL AND MECHANICAL EQUIPMENT (I.E. FURNACES, A/C UNITS, ELECTRICAL PANELS, SANITARY SUMP PITS, DRAIN TILE SUMP, AND WATER HEATERS) ARE SUBJECT TO RELOCATION DUE TO FIELD CONDITIONS.


ELECTRICAL DEVICES:	ABOVE FINISHED FLOOR:
SWITCHES OVER COUNTER	48" TO CL
WALL OUTLETS OVER COUNTER	42" TO BOTTOM OF HORIZONTAL OUTLET(TYP. @ COUNTER)
REMAINING SWITCHES	48" TO CL
WALL OUTLETS	12" TO CL
BATH VANITY BRACKET OUTLET	1,2 (1" ABOVE TOP OF VANITY)
WATER SOFTENER AND SUMP OUTLETS	48" TO CL
EXTERIOR GFI OUTLETS	12" TO CL
GARAGE GFI (ABOVE GARAGE FLOOR)	48" TO CL
FRONT DOOR COACH LIGHT	80" TO CL
GARAGE DOOR COACH LIGHT, (ABOVE GARAGE FLOOR)	84" TO CL
THERMOSTAT	54" TO CL
DOORBELL CHIMES	84" TO CL
DOORBELL BUTTON	LEVEL W/ DR. HANDLE
KITCHEN HOOD FAN "WHIP"	66" TO CL
KITCHEN WALL HUNG MICROWAVE OUTLET	72" TO CL
KITCHEN DISHWASHER RECEPTACLE	UNDER SINK
KITCHEN RANGE	24" TO CL
KITCHEN REFRIGERATOR	48" TO CL
WASHER/DRYER OUTLET	48" TO CL

CL = CENTER LINE
1 = FIELD VERIFY
2 = MASTER BATH STANDARD 30" HIGH VANITY TO BE RAISED 4"

Lot 370
5920-04 Cypress Cove
Elevation A
Right-Hand Garage

- *Opt. Gourmet Kitchen 1
- *Opt. Primary Bath 1
- *Opt. Fireplace at Great Room
- *Opt. Door From Primary W.I.C. to Laundry
- *Opt. Screened Covered Outdoor Living
- *Opt. Outdoor Living Patio
- *Opt. Exterior Gas Stub Out
- *Opt. Fire-Rated Garage Side
- *Opt. Fire-Rated Non-Garage Side

UNDER 9,000 FT² -
FIRE-RATED WALL
REQUIRED AT
GARAGE SIDE &
NON-GARAGE SIDE

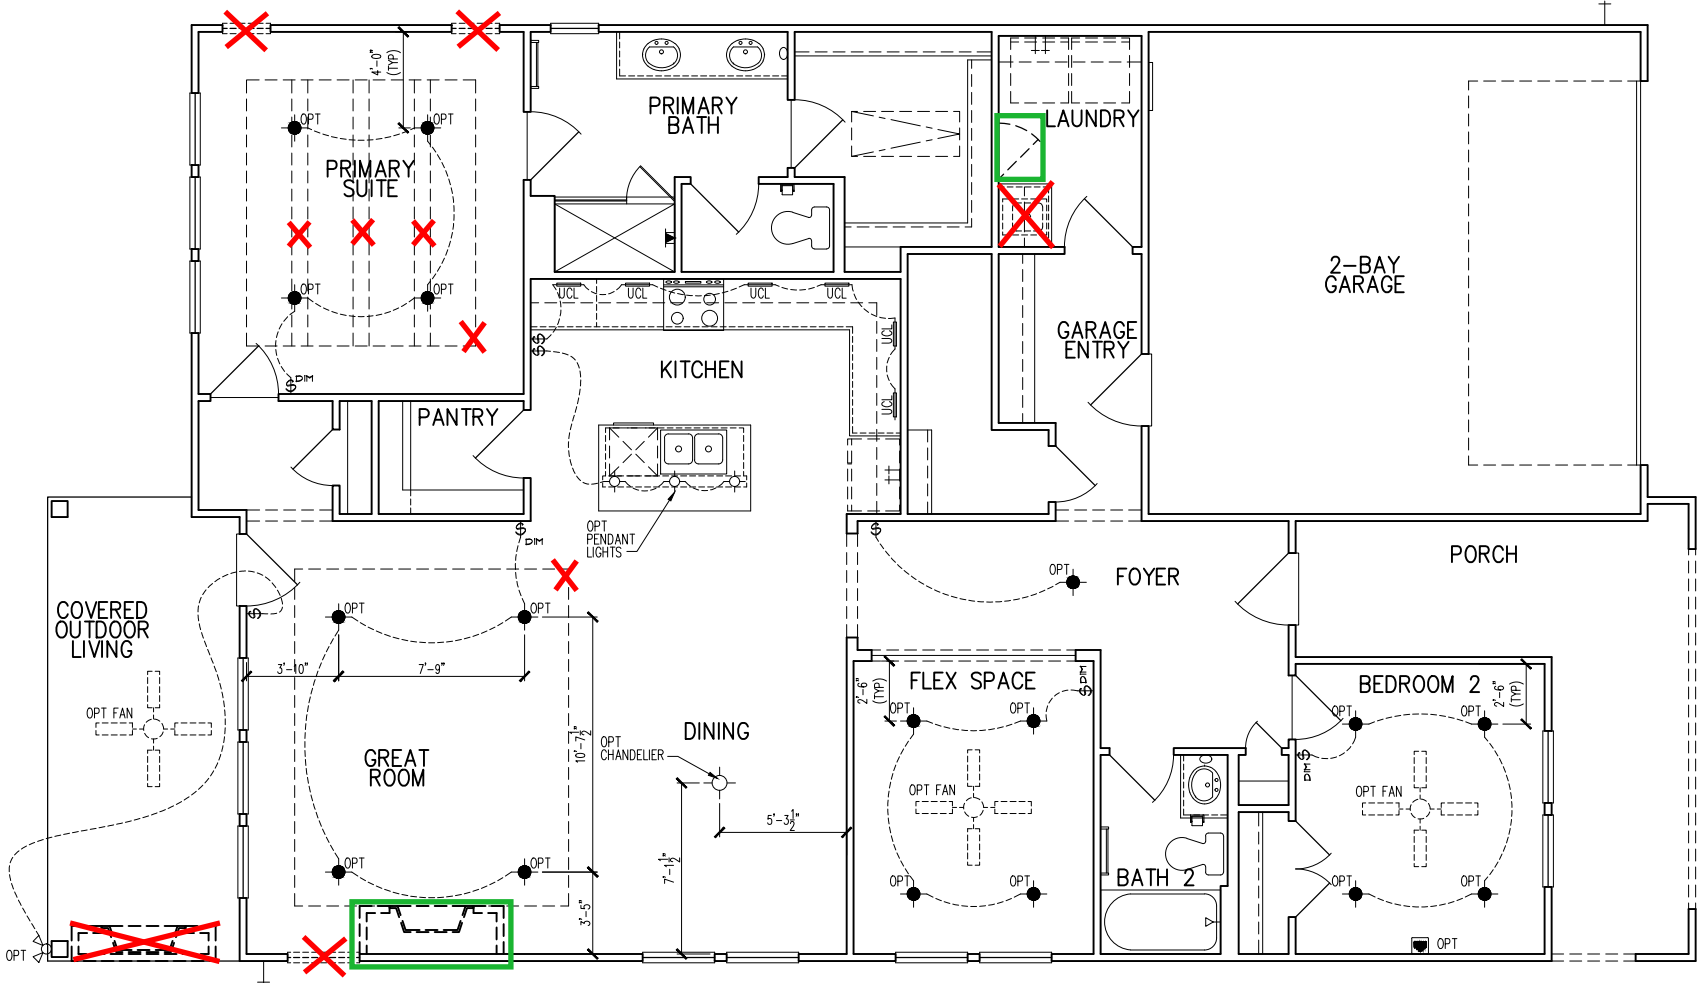

Check BOO for Selected Electrical Options

tri pointe
H O M E S
5440 WADE PARK BLVD, SUITE 400, RALEIGH, NC 27607

Business Operations
5440 Wade Park Blvd
Suite 400
Raleigh, NC 27607
© 2022


1st FLOOR ELEC. PLAN - OPITONS
SUBDIVISION: ALTIS AT SERENITY
ADDRESS: 98 SHADY CREEK WAY, FUQUAY-VARINA, NC 27526
LOT: 370 BLOCK:

Issue Date: 10-13-24
Drawn By: ACC

PLAN #:
5920-04


PLAN NAME:
CYPRESS COVE

SHEET #:
E1.11A

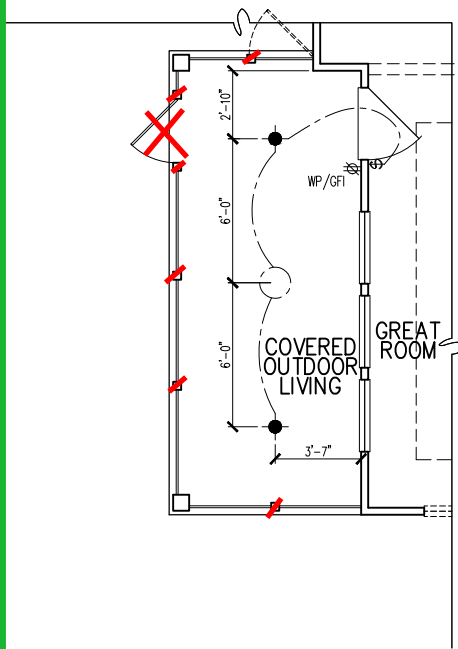

OPT. SCREENED
COVERED OUTDOOR LIVING
PARTIAL ELECTRICAL PLAN

1/8"=1'-0"

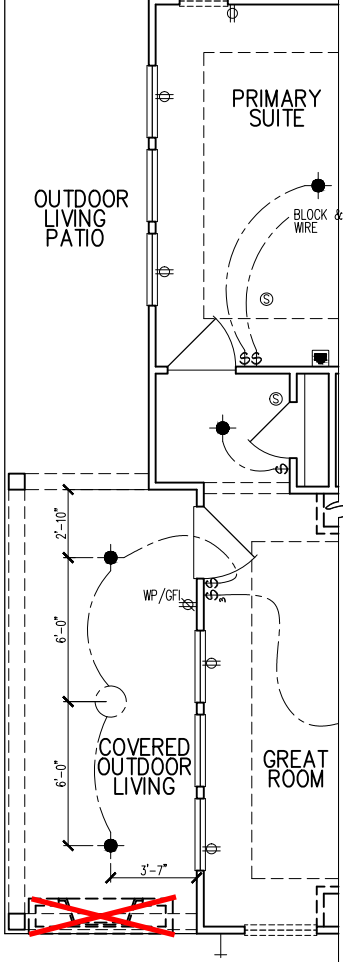


OPT. OUTDOOR LIVING PATIO
PARTIAL ELECTRICAL PLAN

1/8"=1'-0"

ELECTRICAL FIXTURE SCHEDULE	
DESCRIPTION	SYMBOL
110V OUTLET	⊕
220V OUTLET	⊕ 220
1/2 HOT OUTLET	⊕ 1/2
GFI OUTLET	⊕ GFI
WP GFI OUTLET	⊕ WP/GFI
GARAGE DOOR OPENER OUTLET	⊕ GDO
SECURITY SYSTEM	⊕ SEC SYS
DISHWASHER	⊕ DW
JUNCTION BOX	⊕
CEILING MOUNTED LIGHT	⊕
CEILING FAN w/ LIGHT KIT	⊕ PROVIDE BRACINGS
RECESSED CEILING LIGHT	⊕
RECESSED WATER PROOF LIGHT	⊕ WP
WALL MOUNTED LIGHT	⊕
WALL MOUNTED PUSH BUTTON	⊕ PB
TWO WAY SWITCH	⊕
THREE WAY SWITCH	⊕
FOUR WAY SWITCH	⊕
DIMMER SWITCH	⊕ PH
EXHAUST VENTS	⊕ VENT TO EXT
LOW VOLTAGE PANEL	⊕
PHONE OUTLET	⊕ PH
TV OUTLET	⊕ TV
DATA & RGS COMBO BOX	⊕
SMOKE DETECTOR	⊕
CARBON MONOXIDE SMOKE DETECTOR COMBO	⊕ CM/SD
DOOR CHIMES	⊕ CHIMES
ELECTRICAL PANEL	⊕ EP
SURFACE MOUNT LED	⊕
EXTERIOR WALL MOUNT UP LIGHT	⊕
SOFFIT MOUNT FLOOD LIGHT	⊕
UNDER COUNTER LIGHTING	⊕ UCL
SMURF TUBE	⊕


ELECTRICAL NOTES:

1. PROVIDE AND INSTALL LOCALLY CERTIFIED SMOKE AND CARBON MONOXIDE DETECTORS AS REQUIRED BY NATIONAL FIRE PROTECTION ASSOCIATION (NFPA) AND MEETING THE REQUIREMENTS OF ALL GOVERNING CODES.
 2. PROVIDE AND INSTALL GROUND FAULT CIRCUIT-INTERRUPTERS (GFI) AS REQUIRED BY NATIONAL ELECTRIC CODE (NEC) AND MEETING THE REQUIREMENTS OF ALL GOVERNING CODES.
 3. ELECTRICAL CONTRACTOR TO PROVIDE REQUIRED DIRECT HOOK-UPS/CUTOFFS.
 4. HVAC CONTRACTOR TO VERIFY THERMOSTAT LOCATIONS.
 5. ALL ELECTRICAL AND MECHANICAL EQUIPMENT (I.E. FURNACES, A/C UNITS, ELECTRICAL PANELS, SANITARY SUMP PITS, DRAIN TILE SUMP, AND WATER HEATERS) ARE SUBJECT TO RELOCATION DUE TO FIELD CONDITIONS.
- ELECTRICAL DEVICES: ABOVE FINISHED FLOOR:
- SWITCHES OVER COUNTER: 48" TO CL
 - WALL OUTLETS OVER COUNTER: 48" TO CL
 - WALL OUTLETS: 48" TO CL
 - REMAINING SWITCHES: 48" TO CL
 - WALL OUTLETS: 12" TO CL
 - BATH VANITY BRACKET OUTLET: 12" TO CL (1" ABOVE TOP OF VANITY)
 - WATER SOFTENER AND SUMP OUTLETS: 48" TO CL
 - EXTERIOR GFI OUTLETS: 12" TO CL
 - GARAGE GFI (ABOVE GARAGE FLOOR): 48" TO CL
 - FRONT DOOR COACH LIGHT: 80" TO CL
 - GARAGE DOOR COACH LIGHT (ABOVE GARAGE FLOOR): 84" TO CL
 - THERMOSTAT: 54" TO CL
 - KITCHEN DISHWASHER RECEPTACLE: 24" TO CL
 - KITCHEN REFRIGERATOR: 48" TO CL
 - WASHER/DRYER OUTLET: 48" TO CL
- LEVEL W/ DR. FINISH
- KITCHEN HOOD FAN "WHF": 66" TO CL
 - KITCHEN WALL HUNG MICROWAVE OUTLET: 72" TO CL
 - KITCHEN SINK: 24" TO CL
 - KITCHEN REFRIGERATOR: 48" TO CL
 - WASHER/DRYER OUTLET: 48" TO CL
- CL = CENTER LINE
1 = FIELD VERIFY
2 = MASTER BATH STANDARD 30" HIGH
VANITY TO BE RAISED 4"

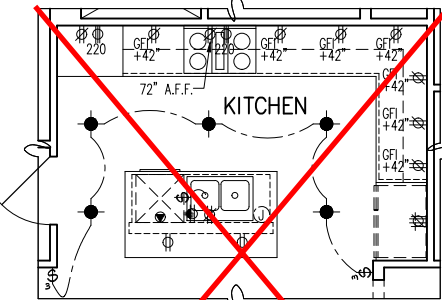

OPT. GOURMET 2
KITCHEN - PARTIAL
ELECTRICAL PLAN


1/8"=1'-0"

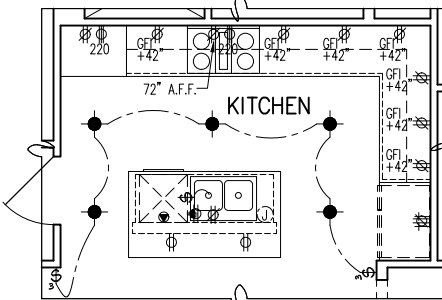

OPT. GOURMET 1
KITCHEN - PARTIAL
ELECTRICAL PLAN

1/8"=1'-0"

Check BOO for Selected Electrical Options

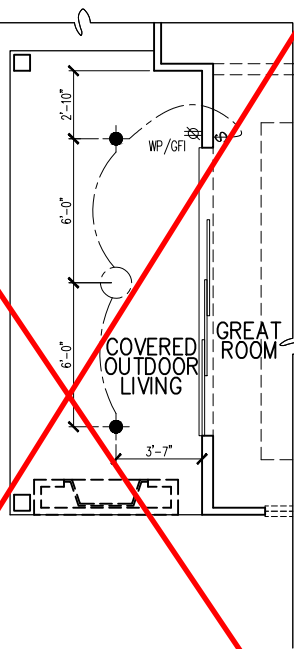


OPT. 12080 MULTI SLIDE
DOOR AT GREAT ROOM
PARTIAL ELECTRICAL PLAN

1/8"=1'-0"




OPT. SHOWER ILO TUB
AT BATH 2 - PARTIAL
ELECTRICAL PLAN

1/8"=1'-0"

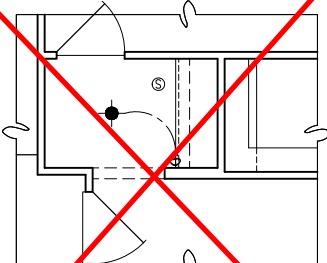


OPT. CABINETS ILO
LINEN CABINETS -
PARTIAL ELECT. PLAN

1/8"=1'-0"

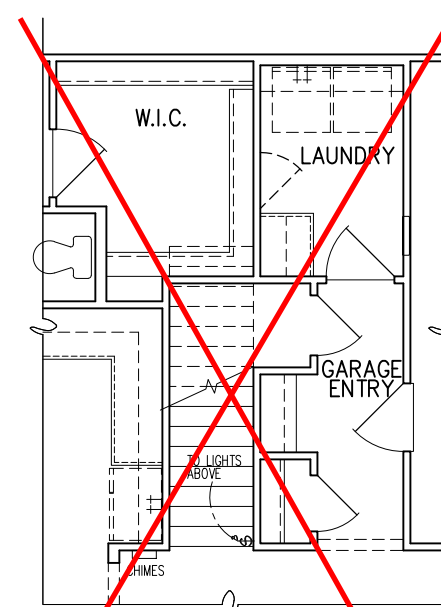


OPT. SECOND FLOOR STAIR
PARTIAL ELECTRICAL PLAN

1/8"=1'-0"

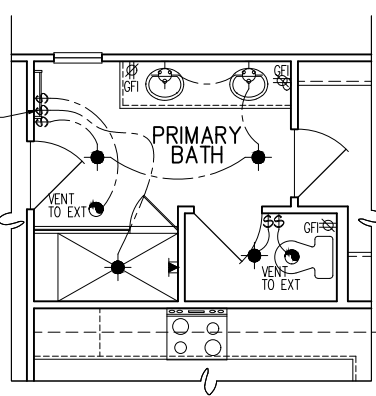


OPT. PRIMARY BATH 1
PARTIAL ELECTRICAL PLAN

1/8"=1'-0"

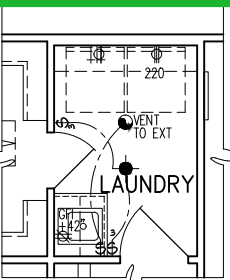


OPT. DOOR FROM
PRIM. W.I.C TO LAUNDRY
PARTIAL ELECT. PLAN

1/8"=1'-0"

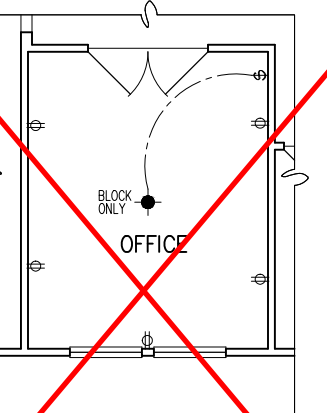

OPT. OFFICE ILO
FLEX SPACE - PARTIAL
ELECTRICAL PLAN

1/8"=1'-0"

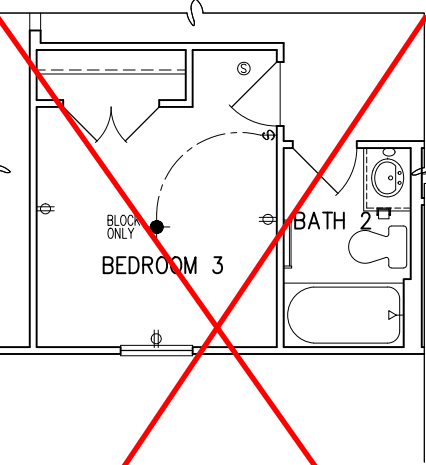

OPT. BEDROOM 3 ILO
FLEX SPACE - PARTIAL
ELECTRICAL PLAN

1/8"=1'-0"

tri pointe
H O M E S

5440 WADE PARK BLVD, SUITE 400, RALEIGH, NC 27607

Business Operations
5440 Wade Park Blvd
Suite 400
Raleigh, NC 27607

© 2022

ELEC. PLAN - OPTIONS

SUBDIVISION: ALTIS AT SERENITY
ADDRESS: 98 SHADY CREEK WAY,
FUQUAY-VARINA, NC 27526
LOT: 370 BLOCK:

Issue Date: 10-13-24
Drawn By: ACC

PLAN #:
5920-04

PLAN NAME:
CYPRESS COVE

SHEET #:
01.E10

ELECTRICAL FIXTURE SCHEDULE	
DESCRIPTION	SYMBOL
110V OUTLET	⌀
220V OUTLET	⌀ 220
1/2 HOT OUTLET	⌀
GFI OUTLET	⌀ GFI
WP GFI OUTLET	⌀ WP/GFI
GARAGE DOOR OPENER OUTLET	⌀ GDO
SECURITY SYSTEM	⌀ SEC SYS
DISHWASHER	● DW
JUNCTION BOX	Ⓜ
CEILING MOUNTED LIGHT	⊙
CEILING FAN w/ LIGHT KIT	⊙ PROVIDE BRACING
RECESSED CEILING LIGHT	⊙
RECESSED WATER PROOF LIGHT	⊙ WP
WALL MOUNTED LIGHT	⊙
WALL MOUNTED PUSH BUTTON	⊙ PB
TWO WAY SWITCH	Ⓢ
THREE WAY SWITCH	Ⓢ
FOUR WAY SWITCH	Ⓢ
DIMMER SWITCH	Ⓢ DIM
EXHAUST VENTS	● VENT TO EXT
LOW VOLTAGE PANEL	Ⓢ
PHONE OUTLET	● PH
TV OUTLET	● TV
DATA & RG6 COMBO BOX	Ⓢ
SMOKE DETECTOR	Ⓢ
CARBON MONOXIDE SMOKE DETECTOR COMBO	Ⓢ CM/SD
DOOR CHIMES	CHIMES
ELECTRICAL PANEL	Ⓢ EP
SURFACE MOUNT LED	●
EXTERIOR WALL MOUNT UPLIGHT	Ⓢ
SOFFIT MOUNT FLOOD LIGHT	Ⓢ
UNDER COUNTER LIGHTING	Ⓢ UCL
SMURF TUBE

ELECTRICAL NOTES:

1.

PROVIDE AND INSTALL LOCALLY CERTIFIED SMOKE AND CARBON MONOXIDE DETECTORS AS REQUIRED BY NATIONAL FIRE PROTECTION ASSOCIATION (NFPA) AND MEETING THE REQUIREMENTS OF ALL GOVERNING CODES
2.

PROVIDE AND INSTALL GROUND FAULT CIRCUIT-INTERRUPTERS (GFI) AS REQUIRED BY NATIONAL ELECTRIC CODE (NEC) AND MEETING THE REQUIREMENTS OF ALL GOVERNING CODES. ELECTRICAL CONTRACTOR TO PROVIDE REQUIRED DIRECT HOOK-UPS/CUTOFFS.
3.

ELECTRICAL CONTRACTOR TO PROVIDE REQUIRED DIRECT HOOK-UPS/CUTOFFS.
4.

HVAC CONTRACTOR TO VERIFY THERMOSTAT LOCATIONS.
5.

ALL ELECTRICAL AND MECHANICAL EQUIPMENT (I.E. FURNACES, A/C UNITS, ELECTRICAL PANELS, SANITARY SUMP PITS, DRAIN TILE SUMP, AND WATER HEATERS) ARE SUBJECT TO RELOCATION DUE TO FIELD CONDITIONS.
- ELECTRICAL DEVICES:

ABOVE FINISHED FLOOR:

SWITCHES OVER COUNTER. 48" TO CL

WALL OUTLETS OVER COUNTER. 48" TO CL

+42" TO BOTTOM OF HORIZONTAL OUTLET(TYP. @ COUNTER)

REMAINING SWITCHES. 48" TO CL

WALL OUTLETS. 12" TO CL . . .

BATH VANITY BRACKET OUTLET. 1,2

(1" ABOVE TOP OF VANITY)

WATER SOFTENER AND SUMP OUTLETS. . . . 48" TO CL

EXTERIOR GFI OUTLETS. 12" TO CL

GARAGE GFI (ABOVE GARAGE FLOOR). . . . 48" TO CL

FRONT DOOR COACH LIGHT. 80" TO CL

GARAGE DOOR COACH LIGHT, (ABOVE GARAGE FLOOR). 84" TO CL

THERMOSTAT. 54" TO CL . . .

DOORBELL CHIMES. 84" TO CL

DOORBELL BUTTON. LEVEL W/ DR. HANDLE

KITCHEN HOOD FAN "WHIP". 66" TO CL

KITCHEN WALL HUNG MICROWAVE OUTLET . . . 72" TO CL

KITCHEN DISHWASHER RECEPTACLE. UNDER SINK

KITCHEN RANGE. 24" TO CL . . .

KITCHEN REFRIGERATOR. 48" TO CL

WASHER/DRYER OUTLET. 48" TO CL


CL = CENTER LINE

1 = FIELD VERIFY

2 = MASTER BATH STANDARD 30" HIGH VANITY TO BE RAISED 4"

Lot 370
5920-04 Cypress Cove
Elevation A
Right-Hand Garage

UNDER 9,000 FT² -
FIRE-RATED WALL
REQUIRED AT
GARAGE SIDE &
NON-GARAGE SIDE

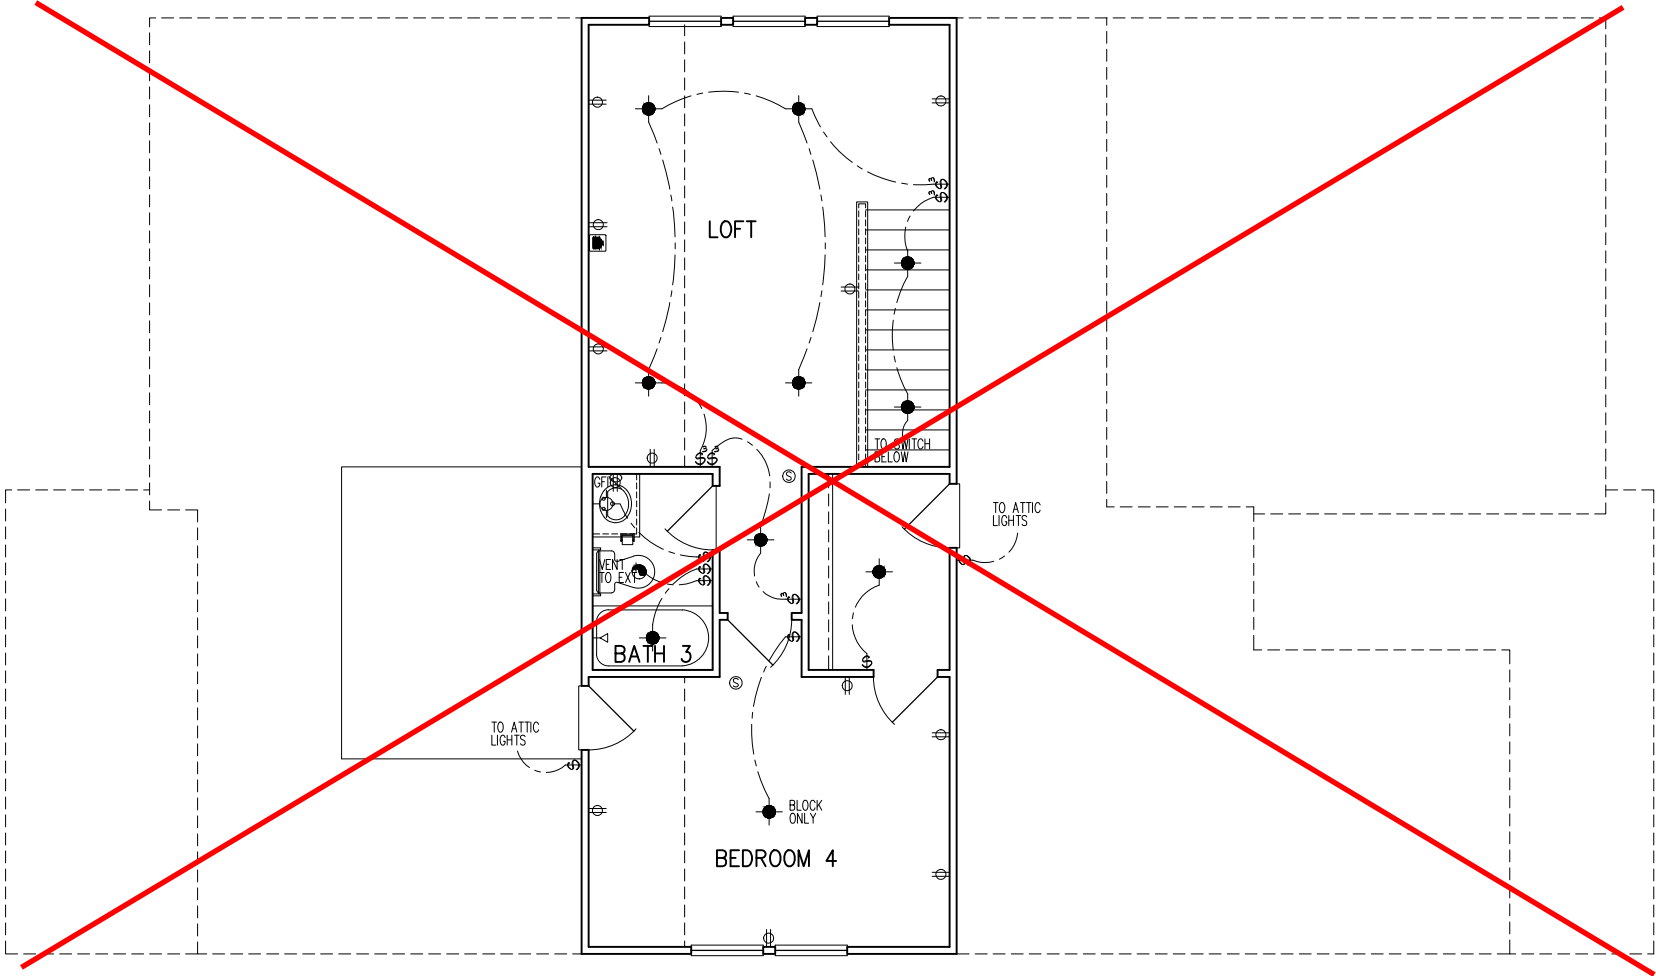

OPT.
SECOND FLOOR PLAN
PARTIAL ELECTRICAL PLAN

1/8"=1'-0"

tri pointe
H O M E S
5440 WADE PARK BLVD, SUITE 400, RALEIGH, NC 27607

Business Operations
5440 Wade Park Blvd
Suite 400
Raleigh, NC 27607
© 2022

2nd FLR ELEC. PLAN - OPTION


SUBDIVISION:ALTIS AT SERENITY
ADDRESS: 98 SHADY CREEK WAY,
FUQUAY-VARINA, NC 27526
LOT:370 BLOCK:

Issue Date: 10-13-24
Drawn By: ACC


PLAN #:
5920-04

PLAN NAME:
CYPRESS COVE


SHEET #:
01.E20

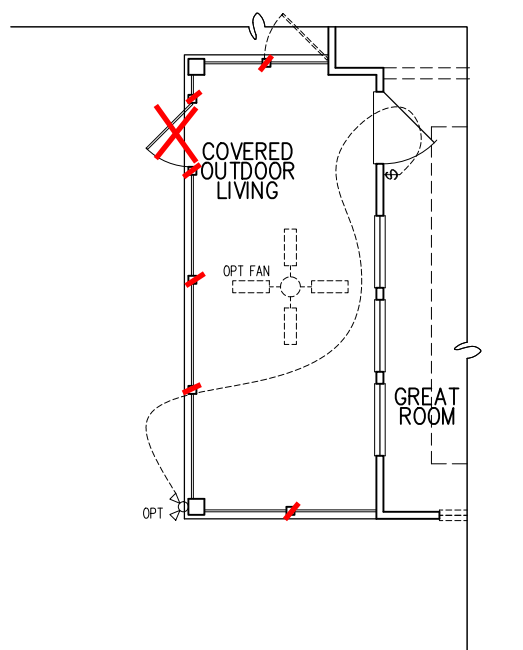

**OPT. SCREENED
COVERED OUTDOOR LIVING
PARTIAL ELECTRICAL PLAN**
1/8"=1'-0"

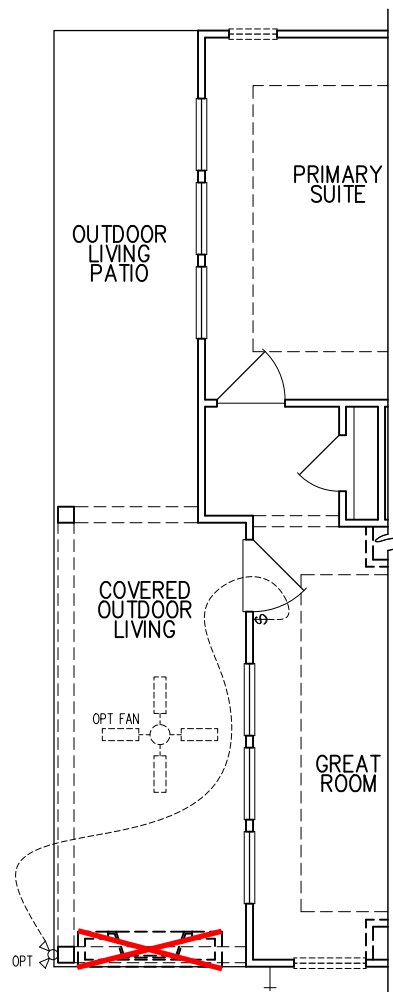

**OPT. OUTDOOR LIVING PATIO
PARTIAL ELECTRICAL PLAN**
1/8"=1'-0"

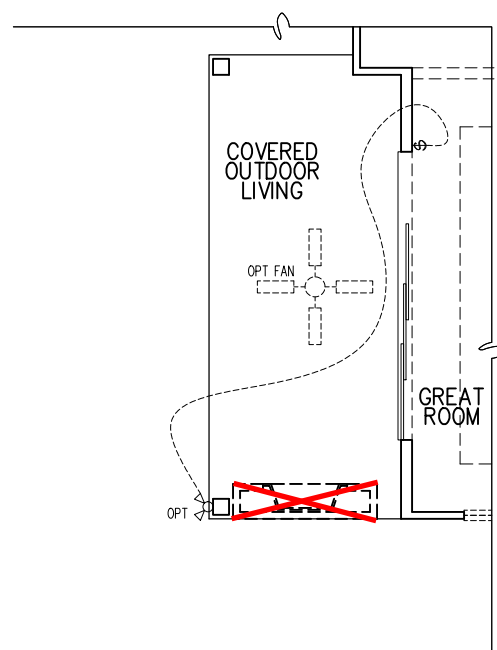


**OPT. 12080 MULTI SLIDE
DOOR AT GREAT ROOM
PARTIAL ELECTRICAL PLAN**
1/8"=1'-0"

Lot 370
5920-04 Cypress Cove
Elevation A
Right-Hand Garage


- *Opt. Gourmet Kitchen 1
- *Opt. Primary Bath 1
- *Opt. Fireplace at Great Room
- *Opt. Door From Primary W.I.C. to Laundry
- *Opt. Screened Covered Outdoor Living
- *Opt. Outdoor Living Patio
- *Opt. Exterior Gas Stub Out
- *Opt. Fire-Rated Garage Side
- *Opt. Fire-Rated Non-Garage Side

**UNDER 9,000 FT² -
FIRE-RATED WALL
REQUIRED AT
GARAGE SIDE &
NON-GARAGE SIDE**


Check BOO for Selected Electrical Options

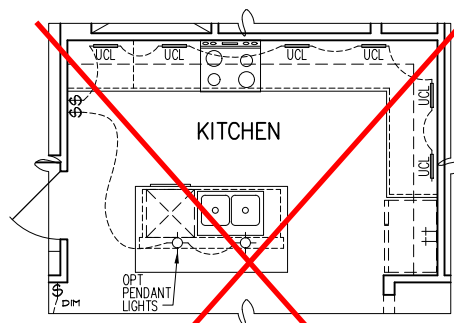


**OPT. 2-PACK PENDANTS
AT KITCHEN - PARTIAL
ELECTRICAL PLAN**
1/8"=1'-0"

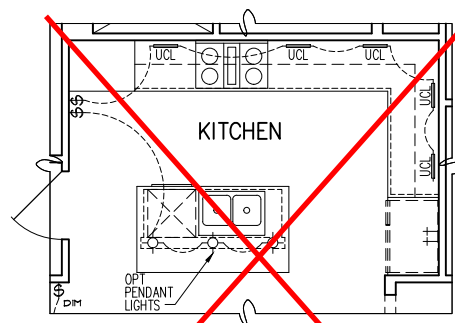


**OPT. GOURMET 2
KITCHEN - PARTIAL
ELECTRICAL PLAN**
1/8"=1'-0"

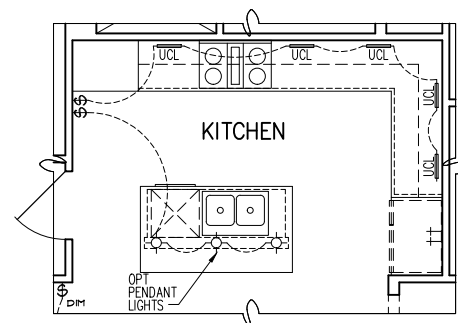

**OPT. GOURMET 1
KITCHEN - PARTIAL
ELECTRICAL PLAN**
1/8"=1'-0"

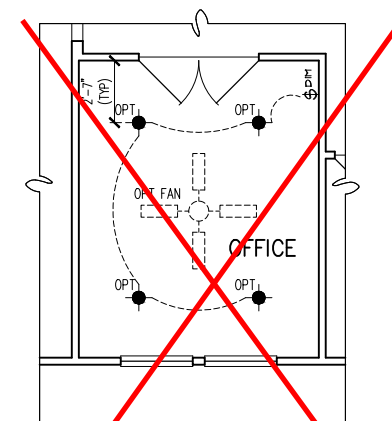

**OPT. OFFICE ILO
FLEX SPACE - PARTIAL
ELECTRICAL PLAN**
1/8"=1'-0"

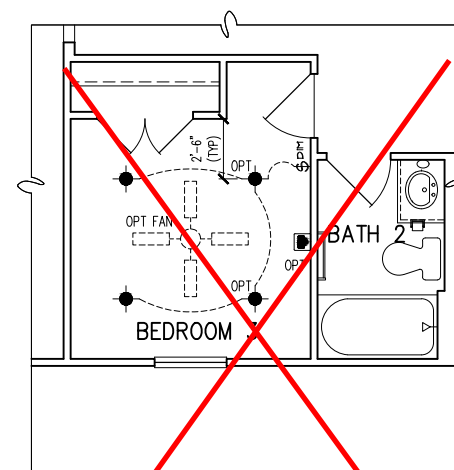

**OPT. BEDROOM 3 ILO
FLEX SPACE - PARTIAL
ELECTRICAL PLAN**
1/8"=1'-0"

1st FLOOR ELEC. PLAN - OPTIONS

SUBDIVISION: **ALTIS AT SERENITY**
ADDRESS: **98 SHADY CREEK WAY,**
FUQUAY-VARINA, NC 27526
LOT: **370** BLOCK:

Issue Date: 10-13-24
Drawn By: ACC

PLAN #:
5920-04

PLAN NAME:
CYPRESS COVE


SHEET #:
01.E11

Business Operations
5440 Wade Park Blvd
Suite 400
Raleigh, NC 27607
© 2022

tri pointe
HOMES
5440 WADE PARK BLVD, SUITE 400, RALEIGH, NC 27607

Lot 370
5920-04 Cypress Cove
Elevation A
Right-Hand Garage

**UNDER 9,000 FT² -
FIRE-RATED WALL
REQUIRED AT
GARAGE SIDE &
NON-GARAGE SIDE**

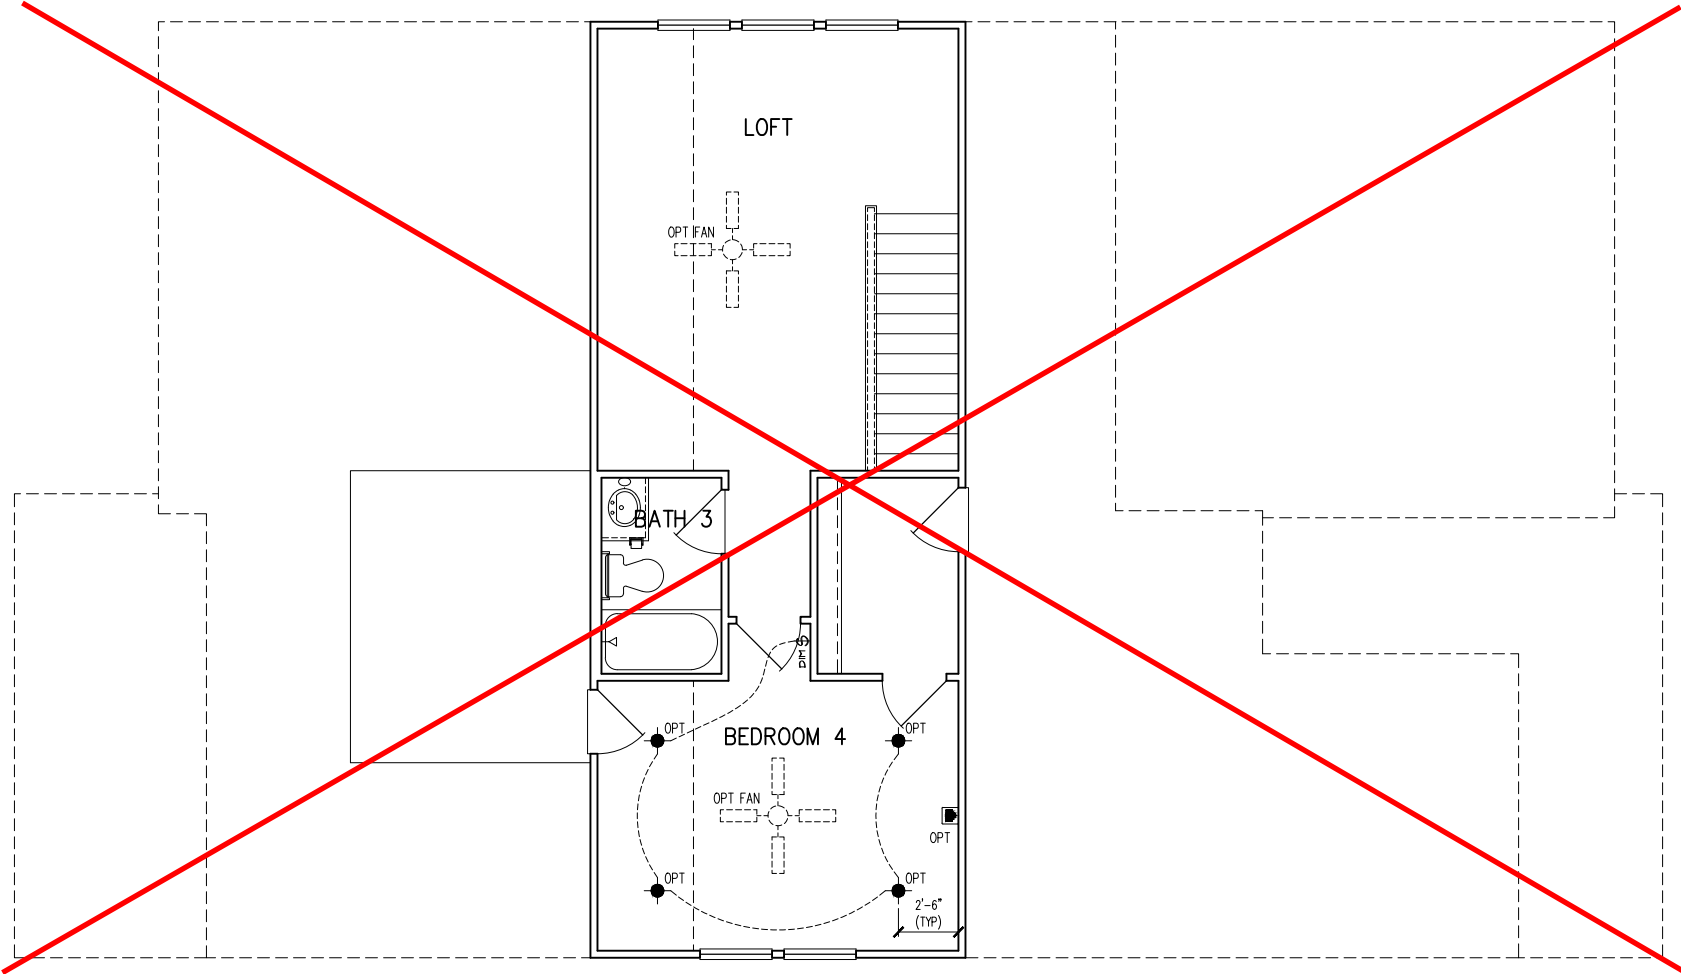

**OPT.
SECOND FLOOR PLAN
PARTIAL ELECTRICAL PLAN**
1/8"=1'-0"

tri pointe
H O M E S
5440 WADE PARK BLVD, SUITE 400, RALEIGH, NC 27607

Business Operations
5440 Wade Park Blvd
Suite 400
Raleigh, NC 27607
© 2022

2nd FLOOR ELEC. PLAN - OPTION
SUBDIVISION: **ALTIS AT SERENITY**
ADDRESS: **98 SHADY CREEK WAY,**
FUQUAY-VARINA, NC 27526
LOT: **370** BLOCK:

Issue Date: 10-13-24
Drawn By: ACC


PLAN #:
5920-04

PLAN NAME:
CYPRESS COVE


SHEET #:
01.E21

UNDER 9,000 FT² -
FIRE-RATED WALL
REQUIRED AT
GARAGE SIDE &
NON-GARAGE SIDE


Lot 370
5920-04 Cypress Cove
Elevation A
Right-Hand Garage

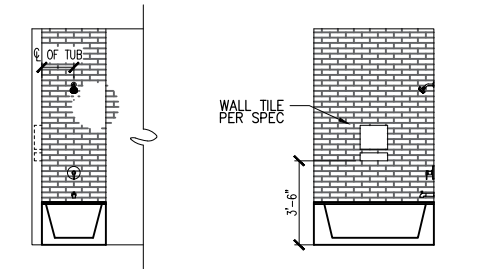



TYPICAL SHOWER NICHE
AT TUB SHOWER DETAIL
3/16"=1'-0"

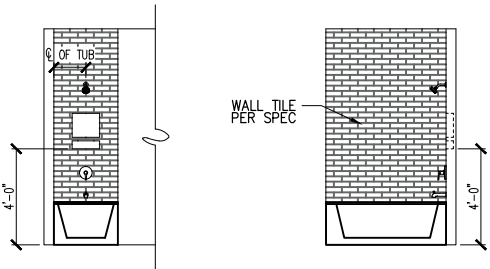



TYPICAL SHOWER NICHE
AT TUB SHOWER DETAIL
3/16"=1'-0"

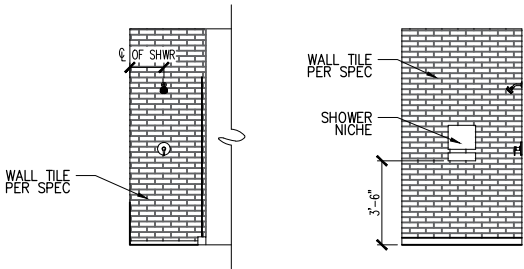


TYPICAL SHOWER NICHE AT SHOWER DETAIL
3/16"=1'-0"

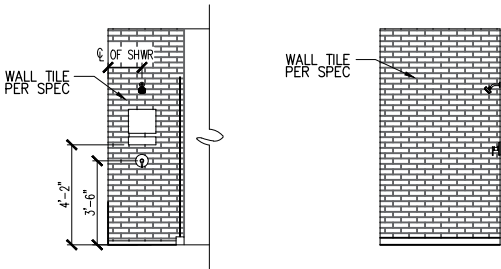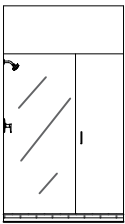


TYPICAL SHOWER NICHE AT SHOWER DETAIL
3/16"=1'-0"

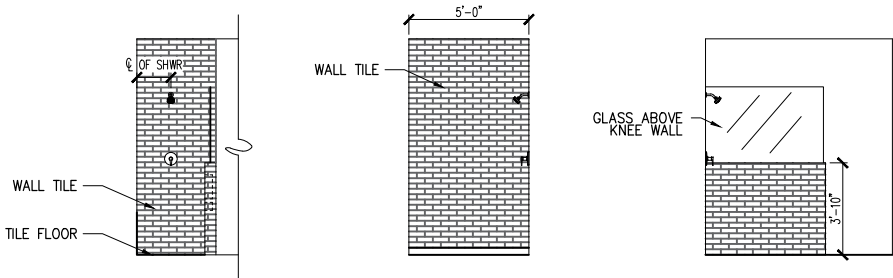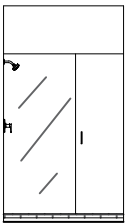

TYPICAL SHOWER DETAIL W/
SHOWER NICHE IN KNEE WALL
3/16"=1'-0"

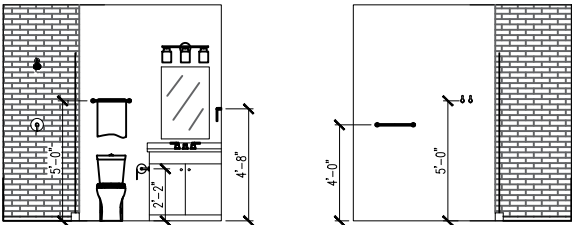

TYPICAL HEIGHTS FOR
BATH FIXTURES DETAIL
3/16"=1'-0"

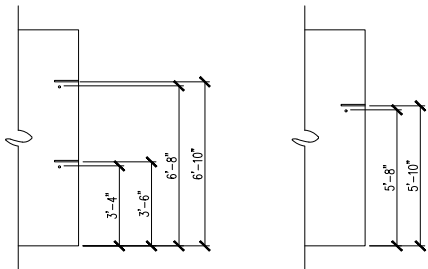

TYPICAL CLOSET RODS
& SHELVES DETAIL
3/16"=1'-0"

tri pointe
H O M E S
5440 WADE PARK BLVD, SUITE 400, RALEIGH, NC 27607

Business Operations
5440 Wade Park Blvd
Suite 400
Raleigh, NC 27607
© 2022

DETAILS

SUBDIVISION: ALTIS AT SERENITY
ADDRESS: 98 SHADY CREEK WAY,
FUQUAY-VARINA, NC 27526
LOT: 370 BLOCK:



Issue Date: 10-13-24
Drawn By: ACC

PLAN #: 5920-04

PLAN NAME: CYPRESS COVE

SHEET #: D1.0

NOTE:
1. FIREWALL COMPIES WITH UL DESIGN #U364 FOR 1 HR. FIREWALL ASSEMBLY
GLASS BLOCK IS NOT TO EXCEED 100 SQ. FT.
60 MIN. FIRE-RATED GLASS BLOCK ONLY

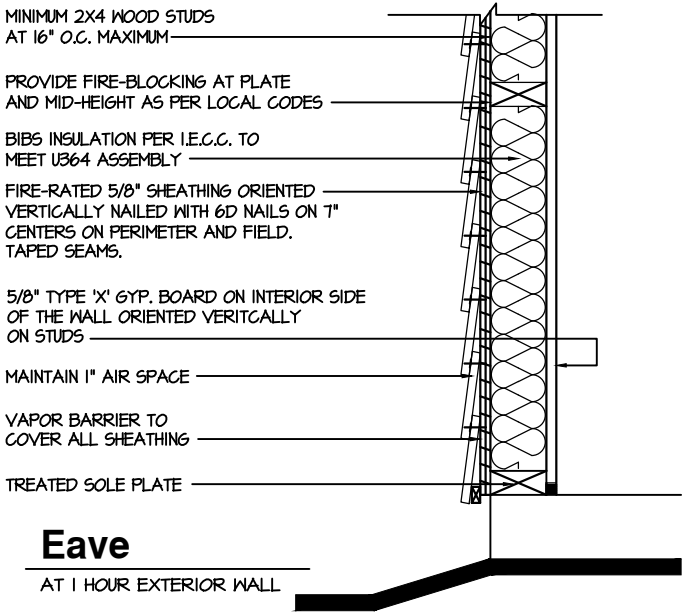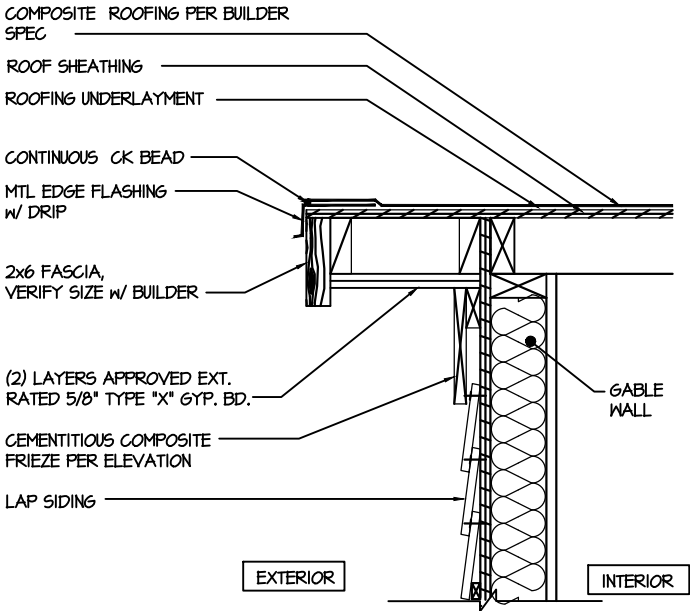

Eave



AT 1 HOUR EXTERIOR WALL

2 1 Hour Wall

AT EXTERIOR WALL

1 HOUR FIRE-RESISTIVE CONSTRUCTION
(PROPERTY LINE)

NOTE:
1. FIREWALL COMPIES WITH UL DESIGN #U364 FOR 1 HR. FIREWALL ASSEMBLY
GLASS BLOCK IS NOT TO EXCEED 100 SQ. FT.
60 MIN. FIRE-RATED GLASS BLOCK ONLY

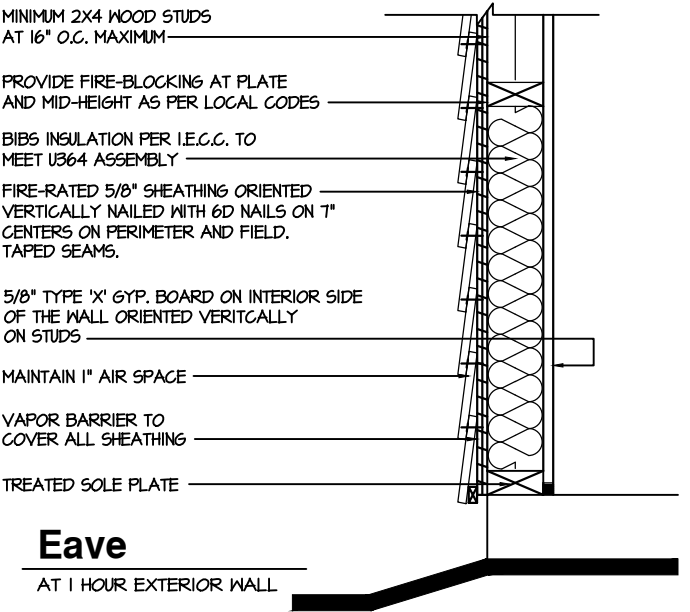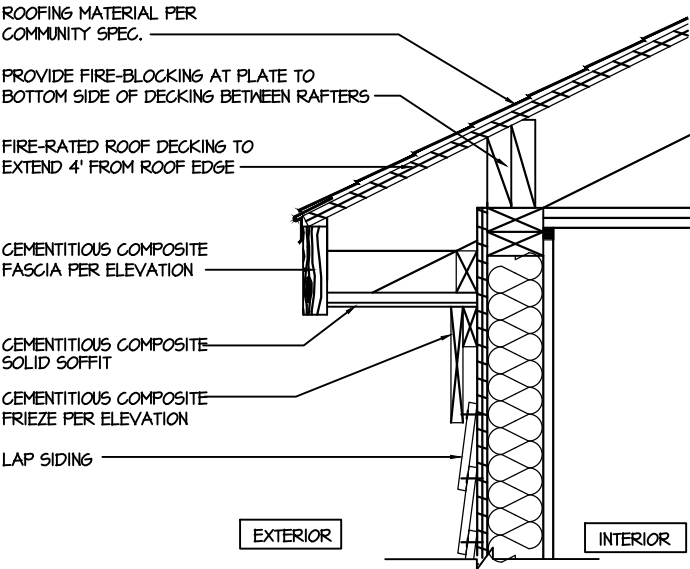

Eave

AT 1 HOUR EXTERIOR WALL

1 1 Hour Wall

AT EXTERIOR WALL

1 HOUR FIRE-RESISTIVE CONSTRUCTION
(PROPERTY LINE)

tri pointe
H O M E S

5440 WADE PARK BLVD, SUITE 400, RALEIGH, NC 27607

Business Operations
5440 Wade Park Blvd
Suite 400
Raleigh, NC 27607

© 2022

DETAILS

SUBDIVISION: **ALTIS AT SERENITY**
ADDRESS: **98 SHADY CREEK WAY,**
FUQUAY-VARINA, NC 27526
LOT: **370**

Issue Date: **10-13-24**
Drawn By: **ACC**

PLAN #:
5920-04

PLAN NAME:
CYPRESS COVE

SHEET #:
D1.1

Lot 370
5920-04 Cypress Cove
Elevation A
Right-Hand Garage

UNDER 9,000 FT² -
FIRE-RATED WALL
REQUIRED AT
GARAGE SIDE &
NON-GARAGE SIDE

tri pointe
HOMES

Business Operations
5440 Wade Park Blvd
Suite 400
Raleigh, NC 27607
© 2022





PRIMARY CLOSET PARTIALS
SUBDIVISION: ALTIS @ SERENITY
ADDRESS: 98 SHADY CREEK WAY,
FUQUAY-VARINA, NC 27526
LOT: 370 BLOCK:

Issue Date: **10-08-24**
Drawn By: **ACC**

PLAN #:
5920-04

PLAN NAME:
CYPRESS COVE

SHEET #:
D2.0

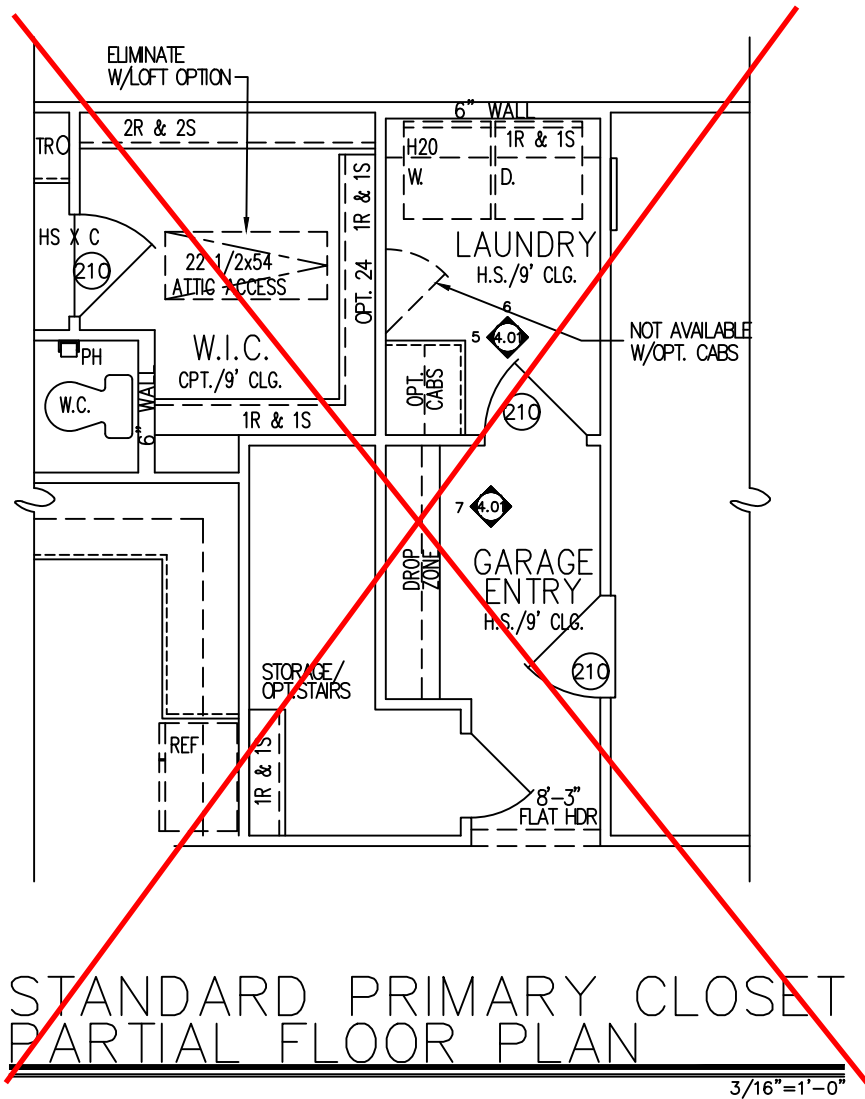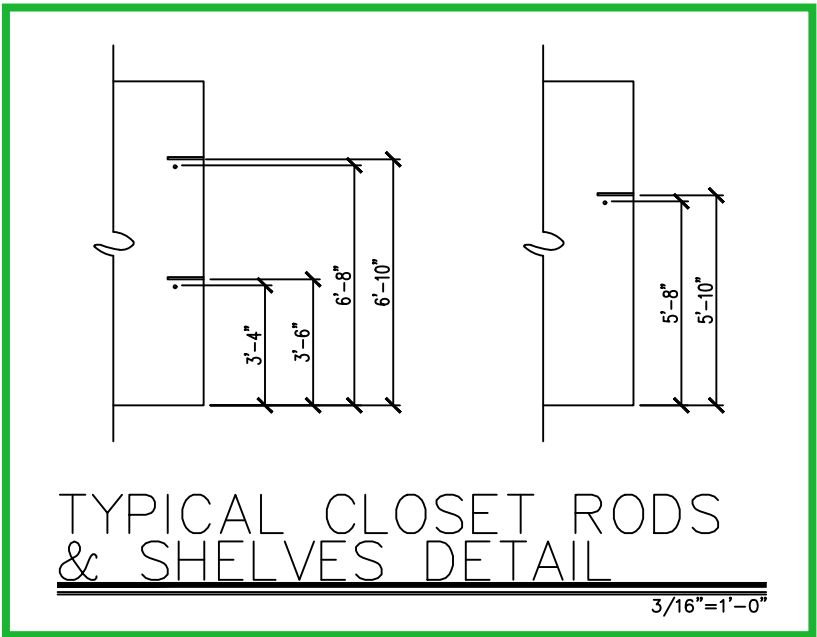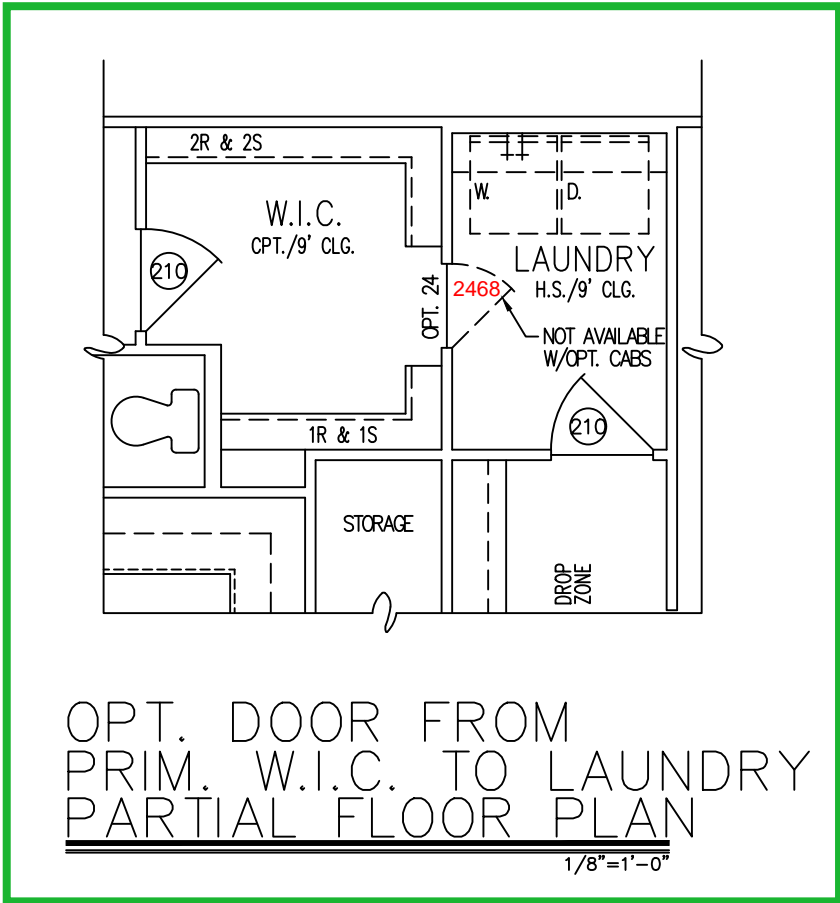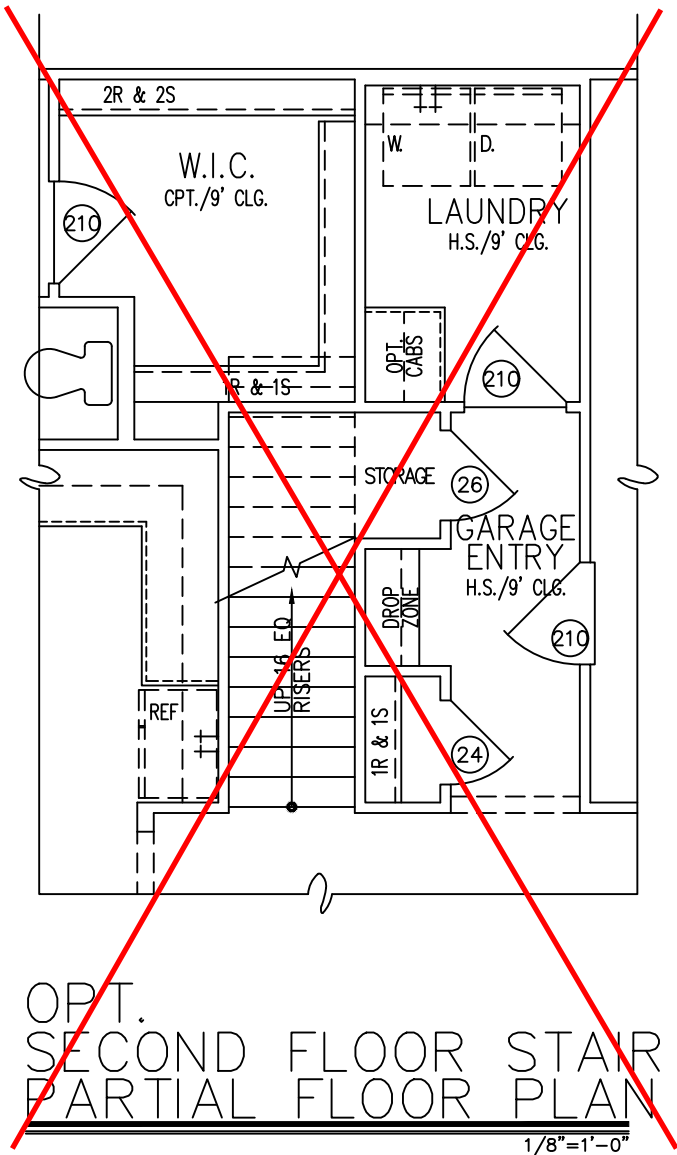

GENERAL STRUCTURAL NOTES
FLOOR FRAMING
<ul style="list-style-type: none">• I-JOISTS/TRUSSES SHALL BE DESIGNED BY MANUF. TO MEET OR EXCEED L/480 LIVE LOAD DEFLECTION CRITERIA. (EXCLUDES STONE/MARBLE OR NET BED CONSTRUCTED FLOORS - CONTACT MKK FOR EXCLUDED FLOOR DESIGNS)• PER THE GUIDELINES OF THE TILE COUNCIL OF NORTH AMERICA (TCNA HANDBOOK), IT SHALL BE THE FLOOR FINISH INSTALLER'S RESPONSIBILITY TO VERIFY THAT THE FINISHES TO BE INSTALLED MATCH THE DESIGN CRITERIA NOTED ABOVE (UNDER "DESIGN LOADS").• FLOOR SYSTEMS & SHEATHING HAVE BEEN DESIGNED TO SUPPORT ADDITIONAL DEAD LOAD FROM CERAMIC TILE (EXCLUDING MARBLE OR STONE). HOWEVER, IT SHALL BE THE FLOOR FINISH INSTALLER'S RESPONSIBILITY TO PROVIDE PROPER UNDERLAYMENT, UNCOUPLING MEMBRANE AND MORTAR/GROUT PER THE ASSEMBLY DESIGNATIONS IN THE TCNA HANDBOOK (TILE COUNCIL OF NORTH AMERICA).• AT I-JOIST FLOORS, PROVIDE 1 1/8" MIN. OSB RIM BOARD.• METAL HANGERS SHALL BE SPECIFIED BY MANUFACTURER, U.N.O.• I-JOIST/TRUSS SHOP DWGS. SHALL BE SUBMITTED TO ARCH. & ENG. FOR REVIEW AND APPROVAL PRIOR TO FABRICATION OR DELIVERY.• FLOOR SHEATHING SHALL BE 23/32" A.P.A. RATED "STURD-I-FLOOR" 24" O.C. EXPOSURE 1 (OR APPROVED EQUAL) WITH TONGUE AND GROOVE EDGES. FASTEN TO FRAMING MEMBERS W/ GLUE AND<ul style="list-style-type: none">- 2 1/2" x 0.131" NAILS @ 6" O.C. @ PANEL EDGES @ 12" O.C. FIELD.- 2 3/8" x 0.120" NAILS @ 4" O.C. @ PANEL EDGES @ 8" O.C. FIELD.- 2 3/8" x 0.113" NAILS @ 3" O.C. @ PANEL EDGES @ 6" O.C. IN FIELD.
ROOF FRAMING
<ul style="list-style-type: none">• ROOF SHEATHING SHALL BE 7/16" A.P.A. RATED SHEATHING 24/16 EXPOSURE 1 (OR APPROVED EQUAL). FASTEN TO FRAMING MEMBERS<ul style="list-style-type: none">- W/ 2 1/2" x 0.131" NAILS @ 6" O.C. @ PANEL EDGES @ 12" O.C. FIELD.- W/ 2 3/8" x 0.120" NAILS @ 4" O.C. @ PANEL EDGES @ 8" O.C. FIELD.- W/ 2 3/8" x 0.113" NAILS @ 3" O.C. @ PANEL EDGES @ 6" O.C. FIELD.• WITHIN 48" OF ALL ROOF EDGES, RIDGES, & HIPS FASTEN ROOF SHEATHING FIELDS PER EDGE NAILING SPEC.• FASTEN EACH ROOF TRUSS TO TOP PLATE W/ SIMPSON H2.5T CLIP (OR APPROVED EQUAL) @ ALL BEARING POINTS. PROVIDE (2) H2.5T CLIPS AT 2-PLY GIRDER TRUSSES, (3) H2.5T CLIPS AT 3-PLY GIRDER TRUSSES & ROOF BEAMS - AT ALL BEARING POINTS.• METAL HANGERS SHALL BE SPECIFIED BY THE MANUFACTURER, U.N.O.• ROOF TRUSS SHOP DWGS. SHALL BE SUBMITTED TO ARCH. & ENG. FOR REVIEW AND APPROVAL PRIOR TO FABRICATION OR DELIVERY.• ERECT AND INSTALL ROOF TRUSSES PER ITCA & TPI'S BC51 I "GUIDE TO GOOD PRACTICE FOR HANDLING, INSTALLING & BRACING OF METAL PLATE CONNECTED WOOD TRUSSES."• SUPPORT SHORT SPAN ROOF TRUSSES W/2x4 LEDGER FASTENED TO FRAMING W/ (2) 3" x 0.120" NAILS @ 16" O.C. (UP TO 1" SPAN).

CONNECTION SPECIFICATIONS (TYP. U.N.O.)

DESCRIPTION OF BLDG. ELEMENT	3"x0.131" NAILS	3"x0.120" NAILS
JOIST TO SOLE PLATE	(3) TOENAILS	(3) TOENAILS*
SOLE PL. TO JOIST/RIM OR BLK'G STUD TO PLATE	NAILS @ 4" O.C.	NAILS @ 4" O.C.
RIM TO TOP PLATE	(4) TOENAILS/ (3) END NAILS	(4) TOENAILS/ (4) END NAILS*
BLK'G. BTWN. JOISTS TO TOP PL.	TOENAILS @ 6" O.C.	TOENAILS @ 4" O.C.*
DOUBLE STUD	(3) TOENAILS EA. END	(3) TOENAILS EA. END*
DOUBLE TOP PLATE	NAILS @ 16" O.C.	NAILS @ 16" O.C.
DOUBLE TOP PLATE LAP SPLICE	NAILS @ 12" O.C.	NAILS @ 8" O.C.
TOP PLATE LAP @ CORNERS & INTERSECTING WALLS	(12) NAILS IN LAPPED AREA (24" MIN.)	(15) NAILS IN LAPPED AREA (24" MIN.)
RAFTER/TRUSS TO TOP PLATE	(3) NAILS	(3) NAILS
GAB. END TRUSS TO DBL. TOP PL.	(4) TOENAILS + (1) SIMPSON H2.5T TOENAILS @ 8" O.C.	(4) TOENAILS + (1) SIMPSON H2.5T TOENAILS @ 6" O.C.
R.T. w/ HEEL HT. 9 1/4" TO 12"	2x10 BLK EVERY 3RD BAY FASTENED TO DBL. TOP PLATE W/ TOENAILS @ 6" O.C.	2x10 BLK EVERY 3RD BAY FASTENED TO DBL. TOP PLATE W/ TOENAILS @ 4" O.C.
R.T. w/ HEEL HT. 12" TO 16"	2x12 BLK EVERY 3RD BAY FASTENED TO DBL. TOP PLATE W/ TOENAILS @ 6" O.C.	2x12 BLK EVERY 3RD BAY FASTENED TO DBL. TOP PLATE W/ TOENAILS @ 4" O.C.
R.T. w/ HEEL HT. UP TO 24"	LAP WALL SHTG. W/ DBL. TOP PL. & INSTALL ON TRUSS VERT. - FASTEN W/ NAILS @ 6" O.C.	LAP WALL SHTG. W/ DBL. TOP PL. & INSTALL ON TRUSS VERT. - FASTEN W/ NAILS @ 6" O.C.*
R.T. w/ HEEL HT. 24" TO 48"	LAP WALL SHTG. W/ DBL. TOP PL. & INSTALL ON TRUSS VERT. - FASTEN W/ NAILS @ 6" O.C. PROVIDE 2x BLK @ EA. BAY AT TOP OF HEEL	LAP WALL SHTG. W/ DBL. TOP PL. & INSTALL ON TRUSS VERT. - FASTEN W/ NAILS @ 6" O.C. PROVIDE 2x BLK @ EA. BAY AT TOP OF HEEL.*
WALL TO FOUNDATION	WALL SHTG. LAP W/ SILL PL. & FASTENED PER SHEAR WALL FASTENING SPEC.	

* 2 1/2"x0.113 IS AN ACCEPTABLE ALTERNATIVE TO A 3"x0.120", SAME SPACING OR NUMBER OF NAILS. (ONLY ACCEPTABLE WHERE * ARE SHOWN)

GENERAL STRUCTURAL NOTES
DESIGN LOADING
<ul style="list-style-type: none">• DESIGN IS BASED ON 2018 NORTH CAROLINA STATE BUILDING CODE: RESIDENTIAL CODE.• WOOD FRAME ENGINEERING IS BASED ON NDS, "NATIONAL DESIGN SPECIFICATION FOR WOOD CONSTRUCTION" - LATEST EDITION.• DESIGN LOADS:<ul style="list-style-type: none">ROOF<ul style="list-style-type: none">SNOW = 15 PSF (12 PSF GROUND SNOW, TRUSSES)LIVE = 20 PSF (REDUCIBLE BASED ON ROOF PITCH)DEAD = 1 PSF T.C., 10 PSF B.C.LOAD DURATION FACTOR = 1.25FLOOR<ul style="list-style-type: none">LIVE = 40 PSF (30 PSF @ SLEEPING AREAS)DEAD = 10 PSF (1-JOISTS), 15 PSF (FLOOR TRUSSES)ADD'L 10 PSF @ CERAMIC TILE IN KITCHEN, SUNROOMS, BATHS, FOYER, LAUND. & MUDRMSSOIL 2,000 PSF ASSUMED ALLOWABLE BEARING PRESSURE (TO BE VERIFIED BY BUILDER)WIND 115 MPH, EXPOSURE B
GENERAL FRAMING
<ul style="list-style-type: none">• ALL TYP. NAIL FASTENER REQUIREMENTS ARE NOTED IN STANDARD CONNECTIONS TABLE (IRC TABLE R602.3.11) OR ON PLANS. ALL NAILS SPECIFIED ARE MIN DIAMETER AND LENGTH REQUIRED FOR CONNECTION. ALL HANGER NAILS SHALL BE INSTALLED PER MANUFACTURER'S REQUIREMENTS FOR MAX CHARTED CAPACITY. NOTE: HANGERS USE COMMON NAIL DIAMETERS NOT TYPICAL FRAMING GUN NAILS.• EXT. & INT. BEARING WALLS SHALL BE 2x4 OR 2x6 (AS SHOWN ON PLANS) @ 16" O.C. SFF/SP #2 GRADE LUMBER, OR BETTER, U.N.O..<ul style="list-style-type: none">• WALLS OVER 12' TALL SHALL BE PER PLAN.• ALL INTERIOR BEARING WALLS ARE ASSUMED TO BE SHEATHED W/ GYP WALL BOARD (ONE SIDE MIN.) OR PROVIDE MID HT. BLOCKING.• ALL HEADERS, BEAMS & OTHER STRUCTURAL MEMBERS SHALL BE SPRUCE-PINE-FIR #2 (SPF) OR SOUTHERN PINE #2 (SP) LUMBER, OR BETTER. SUPPORT ALL HEADERS/ BEAMS W/ (1)2x JACK STUD & (1)2x KING STUD, MINIMUM.<ul style="list-style-type: none">- THE NUMBER OF STUDS SPECIFIED AT A SUPPORT INDICATES THE NUMBER OF JACK STUDS REQUIRED, U.N.O..• ALL NON-BEARING INTERIOR STUD WALLS SHALL BE CONSTRUCTED WITH 2x STUD/ GRADE MEMBERS SPACED @ 24" O.C. (MAX., U.N.O.)<ul style="list-style-type: none">• HEADERS IN NON-LOAD BEARING WALLS SHALL BE: (1)2x4/6 FLAT @ OPENINGS UP TO 4'; (2)2x4/6 FLAT UP TO 8'.• ALL FRAMING LUMBER SHALL BE DRIED TO 15% MC (KD-15).• ENGINEERED LUMBER BEAMS TO MEET OR EXCEED THE FOLLOWING:<ul style="list-style-type: none">• LVL' - Fb=2600 psi; Fv=285 psi; E=2.0x10⁶ psi• ENGINEERED LUMBER POSTS TO MEET OR EXCEED THE FOLLOWING:<ul style="list-style-type: none">• LVL' - Fb=2400 psi; FcII=2500 psi; E=1.8x10⁶ psi• FOR 2 & 3 PLY BEAMS OF EQUAL 1 3/4" MAX. WIDTH, FASTEN PLYS TOGETHER WITH 3 ROWS OF 3"x0.120" NAILS @ 8" O/C OR 2 ROWS 1/2"x3/8" SIMPSON SDS SCREWS (OR 3/4" TRUSSLOK SCREWS) @ 16" O/C. USE A MINIMUM OF 4 ROWS FOR BEAM DEPTHS OF 14" OR GREATER. APPLY FASTENING AT BOTH FACES FOR 3-PLY CONDITION. LOCATE TOP & BOTTOM NAILS/SCREWS 2" FROM EDGE. SOLID 3 1/2" OR 5 1/4" BEAMS ARE ACCEPTABLE. USE 2 ROWS OF NAILS FOR 2x6 & 2x8 MEMBERS.• FOR 4 PLY BEAMS OF EQUAL 1 3/4" MAX. WIDTH, FASTEN PLYS TOGETHER WITH 3 ROWS OF 1/2"x6" SIMPSON SDS SCREWS (OR 6 3/4" TRUSSLOK SCREWS) @ 16" O/C. USE A MINIMUM OF 4 ROWS FOR BEAM DEPTHS OF 14" OR GREATER. APPLY FASTENING AT BOTH FACES (ONE SIDE ONLY FOR TRUSSLOK SCREWS). LOCATE TOP AND BOTTOM SCREWS 2" FROM EDGE. A SOLID 1" BEAM IS ACCEPTABLE.• PROVIDE SOLID BLOCKING IN FLOOR SYSTEM UNDER ALL POSTS CONTINUOUS TO FND/BEARING. BLOCKING TO MATCH POST ABOVE.• ALL EXTERIOR 4x4 WOOD POSTS SHALL HAVE SIMPSON BC52-2/4 CAP & ABW44 BASE, U.N.O.• CORROSION NOTES:<ul style="list-style-type: none">• BUILDER RESPONSIBLE TO DETERMINE CORROSION-RESISTANCE REQUIREMENTS AND COMPATIBILITY OF HARDWARE, FASTENERS AND CONNECTORS FOR ENVIRONMENTAL EXPOSURE AND IN CONTACT W/ PRESERVATIVE-TREATED WOOD OF ACTUAL FINAL CONDITIONS AND SOURCED MATERIALS. CONTACT LUMBER & HARDWARE SUPPLIERS TO COORD.

UNDER 9,000 FT² -
FIRE-RATED WALL
REQUIRED AT
GARAGE SIDE &
NON-GARAGE SIDE

GENERAL STRUCTURAL NOTES
FOUNDATION
<ul style="list-style-type: none">• DESIGN IS BASED ON 2018 NORTH CAROLINA STATE BUILDING CODE: RESIDENTIAL CODE.• FOOTING DESIGN - 2,000 PSF ALLOWABLE SOIL BEARING PRESSURE IS ASSUMED. BUILDER/CONTRACTOR MUST VERIFY.• FASTEN 2x4/6 SILL PLATES TO CONC FND WITH A MINIMUM OF 2 ANCHORS PER PLATE, 12" MAX. FROM PLATE ENDS - UTILIZING:<ul style="list-style-type: none">• 1/2" DIA. ANCHOR BOLTS @ 6'-0" O.C.," MIN. EMBEDMENT• 1/2" DIA. x 6" LONG SIMPSON TITEN HD @ 6'-0" O.C.• SIMPSON MASA ANCHOR STRAPS @ 6'-0" O.C. (CONCRETE)• ALL LUMBER EXPOSED TO WEATHER OR IN CONTACT W/ PERIMETER FOUNDATION SHALL BE PRESERVATIVE TREATED SOUTHERN PINE #2.• BUILDER TO VERIFY CORROSION-RESISTANCE COMPATIBILITY OF HARDWARE & FASTENERS IN CONTACT W/ PRESERVATIVE-TREATED WOOD. CONTACT LUMBER & HARDWARE SUPPLIERS TO COORD.• FOOTINGS SHALL BE PLAIN CONCRETE, U.N.O.• CONCRETE DESIGN BASED ON ACI 318. CONCRETE SHALL ATTAIN THE FOLLOWING MIN. COMPRESSIVE STRENGTHS IN 28 DAYS, U.N.O.:<ul style="list-style-type: none">Fc = 3,000 psi: FOOTINGS & INTERIOR SLABS ON GRADE3500 psi: GARAGE & EXTERIOR SLABS ON GRADEfy = 60,000 psi• ALL CONCRETE EXPOSED TO THE WEATHER SHALL NOT HAVE LESS THAN 5% OR MORE THAN 1% AIR ENTRAINMENT.• ALL FOOTINGS SHALL BEAR BELOW FROST LINE (TYP.) OR 12" MIN IN REGIONS WHERE CODE FROST DEPTH IS NOT APPLICABLE. CONSULT SOILS REPORT OR BUILDING DEPT. FOR MINIMUM DEPTH BELOW GRADE.• FOOTINGS AND SLABS ON GRADE SHALL BEAR ON VIRGIN SOIL OR 95% COMPACTED FILL.• PROVIDE CONTROL JOINTS AT ALL INSIDE CORNERS OF SLAB EDGES, AND OTHER LOCATIONS WHERE SLAB CRACKS ARE LIKELY TO DEVELOP.<ul style="list-style-type: none">• JOINTS SHALL BE LOCATED @ 10'-0" O.C. (RECOMMENDED) OR 15'-0" O.C. (MAXIMUM)• JOINT GRID PATTERN SHALL BE AS CLOSE TO SQUARES AS POSSIBLE (1:1 RATIO), WITH A MAXIMUM OF 1:1.5 RATIO• CONTROL JOINTS SHALL NOT BE INSTALLED IN STRUCTURAL SLABS• DIMENSIONS BY OTHERS, BUILDER TO VERIFY.

MKK SIND. - MAY 2002

HOLD-DOWN SCHEDULE

SYMBOL	SPECIFICATION
▶ HD-1	SIMPSON C516 STRAP TIE W/ 14" END LENGTH
▶ HD-2	SIMPSON MSTC66 STRAP TIE W/ 24" END LENGTH
▶ HD-3	SIMPSON HTT4 HOLD-DOWN *
▶ HD-4	SIMPSON HDJ5-SDS2.5 HOLD-DOWN *
▶ HD-5	SIMPSON STHD14RJ HOLD-DOWN *
* UTILIZE SIMPSON "SET-36" EPOXY SYSTEM TO FASTEN 3/8" DIA. THREADED ROD INTO CONCRETE FOUNDATION. PROVIDE 12" MIN. EMBEDMENT INTO CONCRETE. INSTALL PER MANUF. RECOMMENDATIONS. DO NOT LOCATE ANCHORS WITHIN 1 3/4" OF EDGE OF FOUNDATION.	

MEANS & METHODS NOTES
<p>THE STRUCTURE IS DESIGNED TO BE SELF SUPPORTING AND STABLE AFTER THE BUILDING IS FINISHED AND ALL PLAN, DETAIL, AND NOTE SPECIFICATIONS HAVE BEEN COMPLETED. IT IS THE CONTRACTOR'S SOLE RESPONSIBILITY TO DETERMINE THE ERECTION PROCEDURES AND SEQUENCE TO INSURE THE SAFETY OF THE BUILDING AND ITS COMPONENTS DURING CONSTRUCTION. THIS INCLUDES, BUT IS NOT LIMITED TO, THE ADDITION OF NECESSARY SHORING, SHEETING, TEMPORARY BRACING, GUYS, AND TIE-DOWNS. CONTRACTOR SHALL BE RESPONSIBLE FOR ALL SHORING AND BRACING REQUIRED TO STABILIZE AND PROTECT EXISTING AND ADJACENT STRUCTURES AND SYSTEMS DURING COURSE OF DEMOLITION AND CONSTRUCTION OF THE PROJECT.</p> <p>STRUCTURAL DESIGN AND SPECIFICATIONS ASSUME THAT ALL SUPPORTING AND NON-SUPPORTING ELEMENTS IN CONTACT WITH FLOOR FRAMING ARE LEVEL, INCLUDING, BUT NOT LIMITED TO: FOUNDATIONS, SLABS ON GRADE, BEAMS, WALLS, AND NON-BEARING ELEMENTS. IT IS THE CONTRACTOR'S RESPONSIBILITY TO VERIFY LEVELNESS AND MAKE ADJUSTMENTS AS NECESSARY, INCLUDING CONSIDERATION OF THOSE AREAS THAT MAY BE WITHIN CONTRACTUAL, INDUSTRY, OR WARRANTY TOLERANCES.</p>

VENEER LINTEL SCHEDULE		
SPAN (MAX)	HEIGHT OF VENEER ABOVE LINTEL	STEEL ANGLE SIZE
3'-0"	20 FT. MAX	L3"x3"x1/4"
6'-0"	3 FT. MAX	L3"x3"x1/4"
	12 FT. MAX	L4"x3"x1/4"
8'-0"	20 FT. MAX	L5"x3 1/2"x3/8"
	12 FT. MAX	L4"x4"x1/4" *
9'-6"	16 FT. MAX	L5"x3 1/2"x3/8"
	12 FT. MAX	L6"x3 1/2"x3/8"
16'-0"	12 FT. MAX	L7"x4"x3/8" **
	3 FT. MAX	L8"x4"x1/2" **
<small>ALL LINTELS: - SHALL SUPPORT 2 3/8" - 3 1/2" VENEER W/ 40 psf MAXIMUM HEIGHT. - 6" SHALL HAVE 4" MIN BEARING - 10" SHALL HAVE 8" MIN BEARING - 10" SHALL NOT BE FASTENED BACK TO HEADER - 10" SHALL BE FASTENED BACK TO WOOD HEADER IN WALL @ 48" O.C. W/ 1/2" DIA. x 3 1/2" LONG LAG SCREWS IN 2" LONG VERTICALLY SLOTTED HOLES. - MAX. VENEER HT. APPLIES TO ANY PORTION OF BRICK OVER THE OPENING. - ALL LINTELS SHALL BE LONG LESS VERTICAL - WHEN SUPPORTING VENEER < 3" WIDE THE EXTERIOR TOE OF THE HORIZONTAL LEG MAY BE CUT IN THE FIELD TO BE 3 1/2" WIDE OVER THE BEARING LENGTH ONLY. THIS IS TO ALLOW FOR MORTAR JOINT FINISHING. - SEE STRUCTURAL PLANS FOR ANY LINTEL CONDITION NOT ENCOMPASSED BY THE ABOVE PARAMETERS. * FOR GREEN VENEER USE 1/4x3/4" ** FOR 3 1/2" VENEER ONLY, SEE PLAN FOR VENEER SUPPORT IF VENEER < 3/8" THICK.</small>		

MKK SIND. - MAY 2006

ADDITIONAL NOTES FOR TRUSS & I-JOIST MANUFACTURER
<p>ROOF TRUSS, FLOOR TRUSS AND ENGINEERED JOISTS SHALL BE DESIGNED TO MEET THE DEFLECTION CRITERIA BELOW, UNLESS NOTED OTHERWISE ON PLAN. MULHERN & KULP CANNOT BE HELD RESPONSIBLE FOR ANY STRUCTURAL ISSUES RELATED TO ANY BUILDING COMPONENT IF COMPONENT SHOP DRAWINGS ARE NOT SUBMITTED TO MKK FOR REVIEW PRIOR TO FABRICATION, DELIVERY, OR INSTALLATION.</p> <p>TRUSSES/JOISTS SHALL BE DESIGNED SO THAT DIFFERENTIAL DEFLECTION BETWEEN ADJACENT PARALLEL TRUSSES/JOISTS OR GIRDER TRUSSES/FLUSH BEAMS DO NOT EXCEED THE FOLLOWING:</p> <p>A. ROOF TRUSSES: 1/4" DEAD LOAD B. FLOOR TRUSSES, ATTIC TRUSSES, & I-JOISTS: 1/8" DEAD LOAD</p> <p>ABSOLUTE DEAD LOAD DEFLECTION OF FLOOR TRUSSES/ATTIC TRUSSES WHEN ADJACENT TO FLOOR FRAMING BY OTHERS SHALL BE LIMITED TO 3/16". (NOT DIFFERENTIAL DEFLECTION)</p>
FLOOR JOIST NOTES
<ul style="list-style-type: none">- ALL FLOOR JOISTS SHALL BE THE DEPTH SPECIFIED ON PLAN- FLOOR JOISTS SERIES & SPACING IS PER THE FLOOR JOIST MANUF.- SPACING SHALL NOT EXCEED 19.2" O.C. (MAX.)- @ LOCATION OF TILE, SPACING SHALL NOT EXCEED 16" O.C. (MAX.)

LATERAL/WALL BRACING & WALL SHEATHING SPECIFICATIONS
<p>THIS MODEL HAS BEEN DESIGNED TO RESIST LATERAL FORCES RESULTING FROM:</p> <p>115 MPH WIND IN 2018 NCSEBG:RC</p> <p>(115 MPH WIND SPEED IN ASCE 7-10 WIND MAP, PER IRC R301.2.1.1) EXP. B, RISK CAT. 2 & SEISMIC CAT. A/B.</p> <p>THE DESIGN WAS COMPLETED PER 2015 IBC (SECTION 1609) & ASCE 7-10, AS PERMITTED BY R301.1.3 OF THE 2018 NCSEBG:RC. ACCORDINGLY, THIS MODEL, AS DOCUMENTED AND DETAILED HEREWITHIN, IS ADEQUATE TO RESIST THE CODE REQUIRED LATERAL FORCES.</p> <p>DESIGN WIND UPLIFT LOADS HAVE BEEN CALCULATED UTILIZING ASCE 7-10 (ACCEPTED ENGINEERING PRACTICE) AS ALLOWED PER 2018 NCSEBG:RC SECTION R802.11.1.1. THIS MODEL HAS BEEN DETAILED WHERE REQUIRED & ENGINEERED TO RESIST THE WIND UPLIFT LOAD PATH PER SECTIONS R602.3.5 & R802.11.</p>
EXT. WALL SHEATHING SPECIFICATION
<ul style="list-style-type: none">• 7/16" OSB OR 15/32" PLYWOOD:<ul style="list-style-type: none">FASTEN SHEATHING W/ 2 3/8"x0.113 NAILS @ 6" O.C. AT EDGES & @ 12" O.C. IN THE PANEL FIELD. (TYP, U.N.O.)• ALL SHEATHING PANELS SHALL BE ORIENTED VERTICALLY (LONG DIRECTION PARALLEL TO STUDS) AND INSTALLED FULL HEIGHT OF SHEAR WALL - OR - 2x HORIZONTAL BLOCKING SHALL BE PROVIDED TO SUPPORT ALL UNSUPPORTED PANEL EDGES & EDGE FASTENING.• ALL EXT. WALLS SHALL BE CONTINUOUSLY SHEATHED AND ARE CONSIDERED SHEAR WALLS.• ALT. STAPLE CONNECTION SPEC: 1 3/8" 16 GA STAPLES (1/6" CROWN) @ 3" O.C. AT EDGES & @ 6" O.C. IN FIELD.
3" O.C. EDGE NAILING
<ul style="list-style-type: none">• AT DESIGNATED AREAS - FASTEN PANEL EDGES OF WOOD STRUCTURAL WALL SHEATHING TO FRAMING W/ 2 3/8" x 0.113" NAILS @ 3" O.C. AND 12" O.C. IN THE PANEL FIELD NO STAPLE ALTERNATIVE AVAILABLE AT THIS SPEC. ALL SHEATHING PANELS SHALL BE ORIENTED VERTICALLY (LONG DIRECTION PARALLEL TO STUD) AND INSTALLED FULL HEIGHT OF SHEAR WALL - OR - 2x HORIZONTAL BLOCKING SHALL BE PROVIDED TO SUPPORT UNSUPPORTED PANEL EDGES AND 3" O.C. EDGE FASTENING.
TYP. UNIT SEPARATION WALL SHEATHING SPECIFICATION
<ul style="list-style-type: none">• 1/2" OR 5/8" GYPSUM WALL BOARD:<ul style="list-style-type: none">FASTEN GWB SHEATHING TO FRAMING W/ 1 5/8"x0.086" COOLER NAILS OR 1 1/4" DRYWALL SCREWS @ 1" O.C. TO PANEL EDGES & PANEL FIELD (INCLUDING T&B PLATES).
NOTES
<ul style="list-style-type: none">• SEE CONNECTION SPECIFICATIONS CHART FOR STANDARD SHEAR TRANSFER DETAILING. IF ADDITIONAL CAPACITY IS REQUIRED BY DESIGN, IT WILL BE SPECIFICALLY NOTED ON PLAN.• DESIGN ASSUMES 16" O.C. MAX. STUD SPACING, U.N.O.• ALL STRUCTURAL PANELS ARE TO BE DIRECTLY APPLIED TO STUD FRAMING.• PRE-MANUFACTURED PANELIZED WALLS:<ul style="list-style-type: none">FASTEN TOGETHER END STUDS OF WALL PANELS SHEATHED W/ OSB OR PLYWOOD W/ 3" x 0.120" NAILS @ 4" O.C. (THRU ONE SIDE ONLY)
<p>--- INDICATES EXTENT OF INT. OSB SHEARNALL, BLOCKED PANEL EDGES, AND/OR 3" O.C. EDGE NAILING</p> <p>▶ INDICATES HOLDOWN</p>

MKK SIND. - MAR 2016



MULHERN+KULP
RESIDENTIAL STRUCTURAL ENGINEERING
3605 Boulevard Parkway, Suite 250 - Alpharetta, GA 30022
978-777-4874 • mulhern+kulp.com
NC License # C-3625



Mulhern+Kulp project number:

243-24030

project mgr: **SMK**
drawn by: **SMM**
issue date: **11-07-24**

REVISIONS:
date: initial:
05-16-25 JPP
PER UPDATED ARCH

tri pointe
HOMES


GENERAL NOTES

5920-04 MODEL

SERENITY
MASTER SET
RALEIGH, NC

sheet:

S0.0

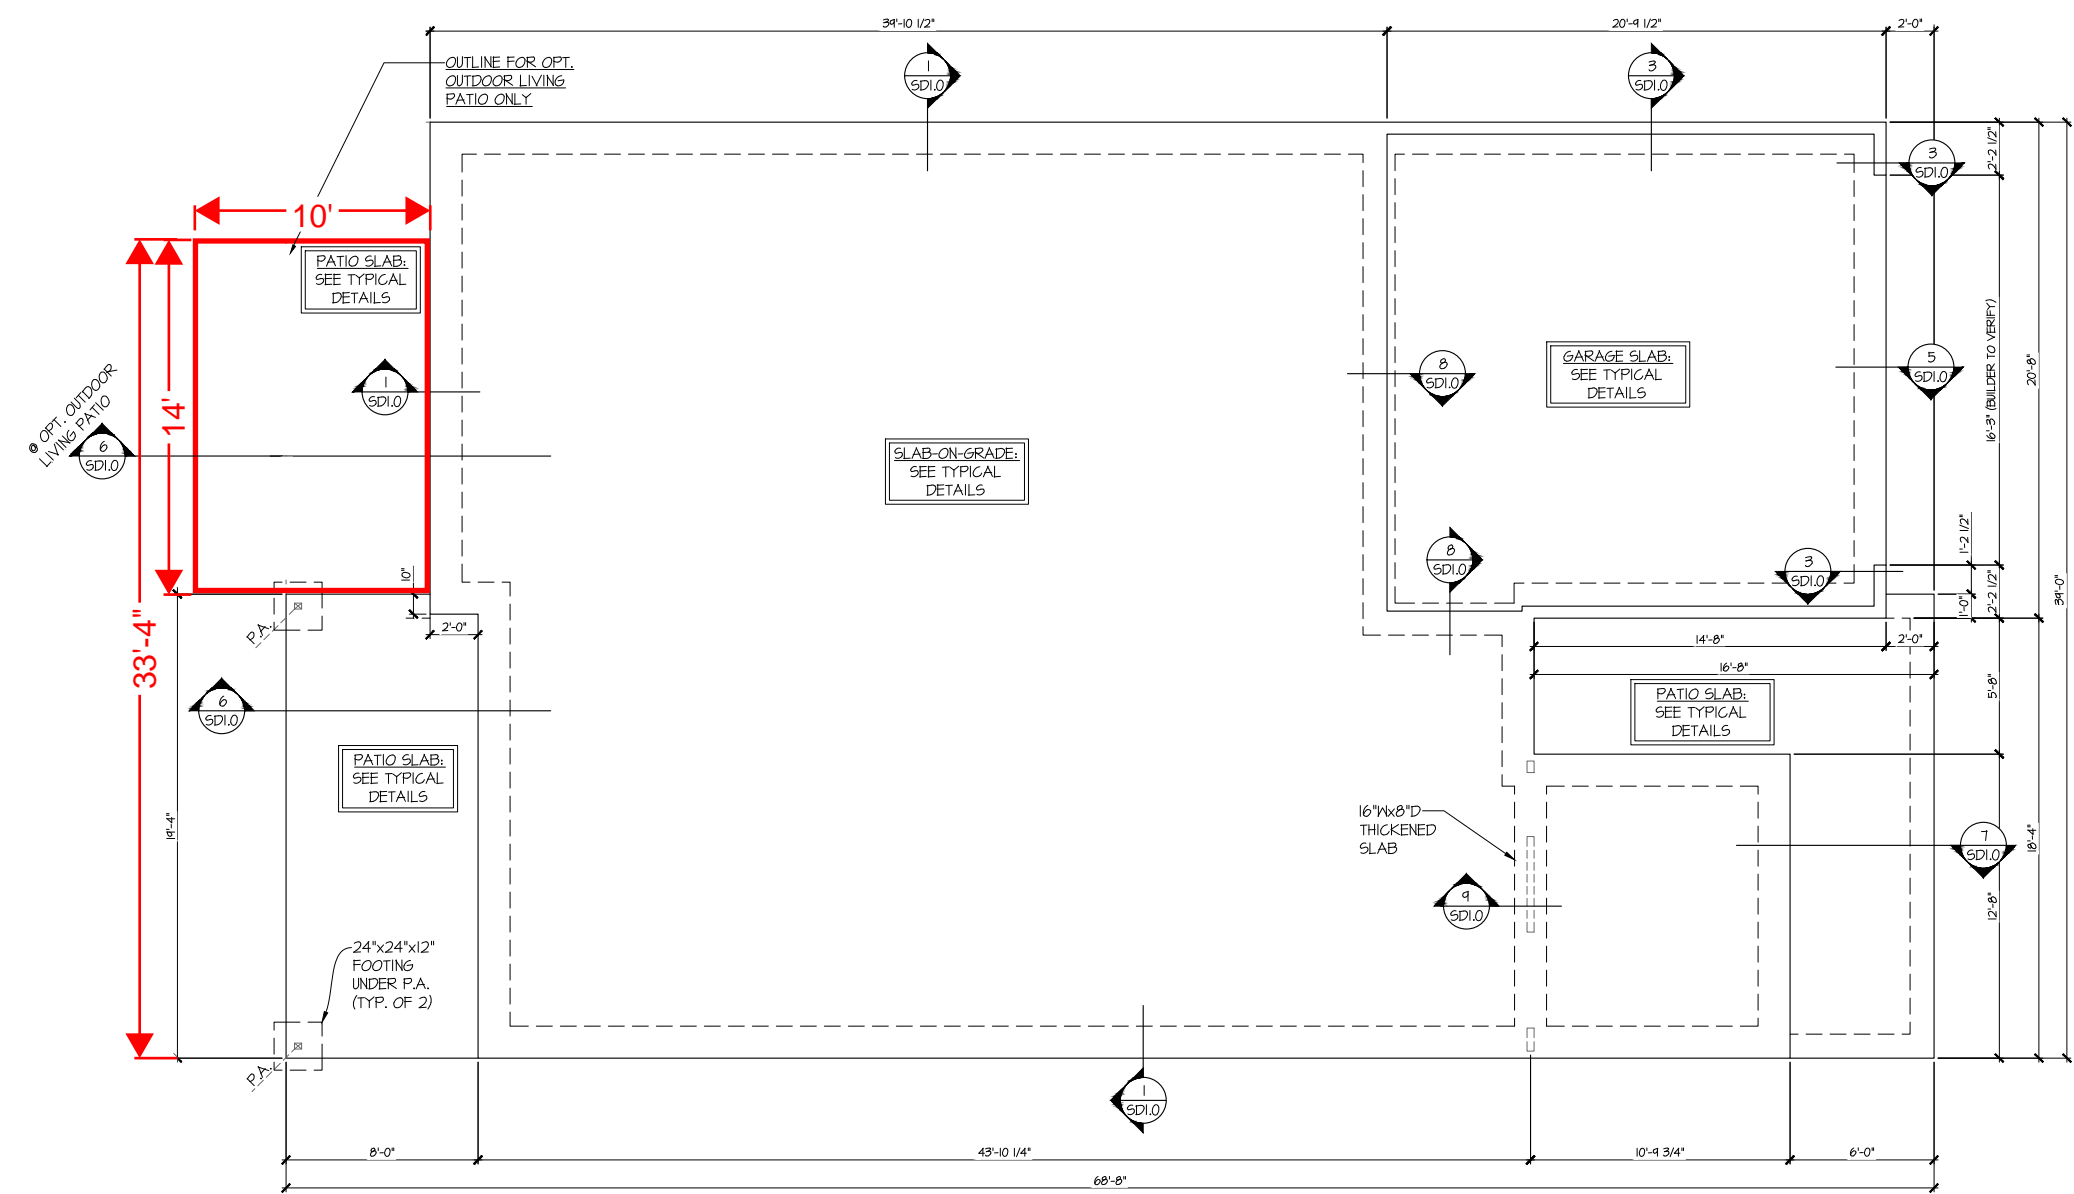

ELEVATION A


1 SLAB FOUNDATION PLAN
SCALE: 1/4"=1'-0" (22x24 SHEET)
1/8"=1'-0" (11x17 SHEET)
ELEV. A

LEGEND	
• [Symbol]	INTERIOR BEARING WALL
• [Symbol]	BEARING WALL ABOVE (B.W.A.)
• [Symbol]	BEAM / HEADER
• [Symbol]	INDICATES EXTENT OF INT. OSB SHEARWALL AND/OR 3" O.C. EDGE NAILING
• [Symbol]	EXTENT OF VALLEY TRUSS OVERFRAMING @ 24" O.C. (MAX.)
• [Symbol]	EXTENT OF FLOOR SYSTEM TO BE DESIGNED FOR TILE
▶ [Symbol]	INDICATES HOLDOWN
⊥ [Symbol]	METAL HANGER
* [Symbol]	INDICATES POST ABOVE. PROVIDE SOLID BLOCKING UNDER POST OR JAMB ABOVE.


REFER TO S.O. FOR
TYPICAL STRUCTURAL NOTES
& SCHEDULES

UNDER 9,000 FT² -
FIRE-RATED WALL
REQUIRED AT
GARAGE SIDE &
NON-GARAGE SIDE


Lot 370
5920-04 Cypress Cove
Elevation A
Right-Hand Garage

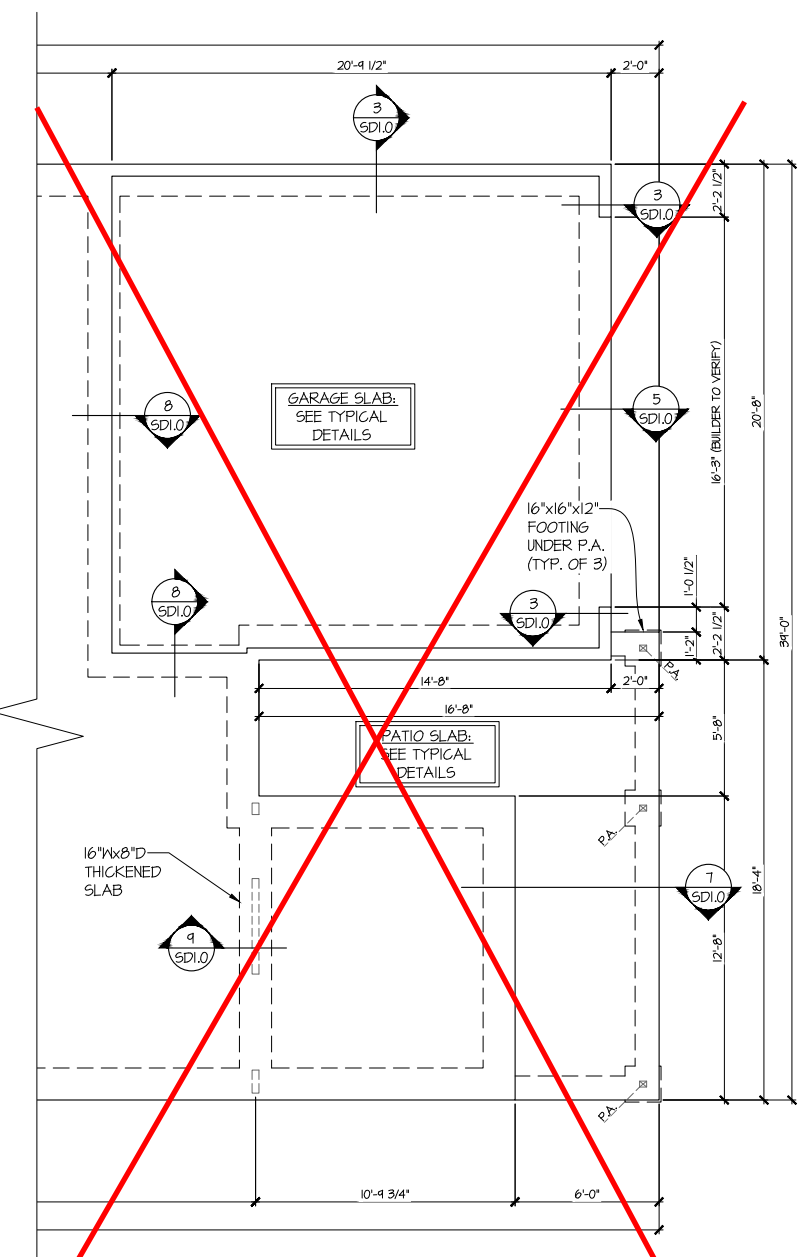

1 PARTIAL SLAB FOUNDATION PLAN
 SCALE: 1/4"=1'-0" (22x24 SHEET)
 1/8"=1'-0" (11x17 SHEET)
 ELEV. B
 SEE ELEV. A FOR MORE INFO

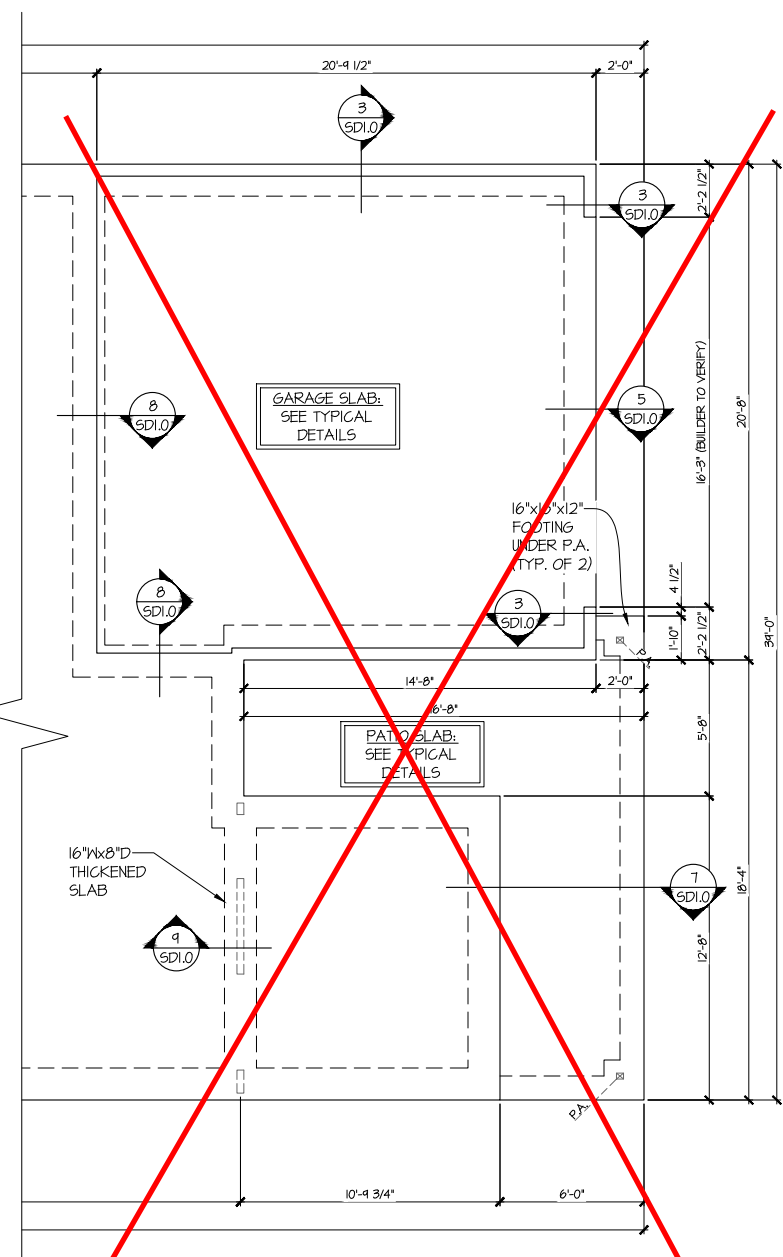

2 PARTIAL SLAB FOUNDATION PLAN
 SCALE: 1/4"=1'-0" (22x24 SHEET)
 1/8"=1'-0" (11x17 SHEET)
 ELEV. C
 SEE ELEV. A FOR MORE INFO

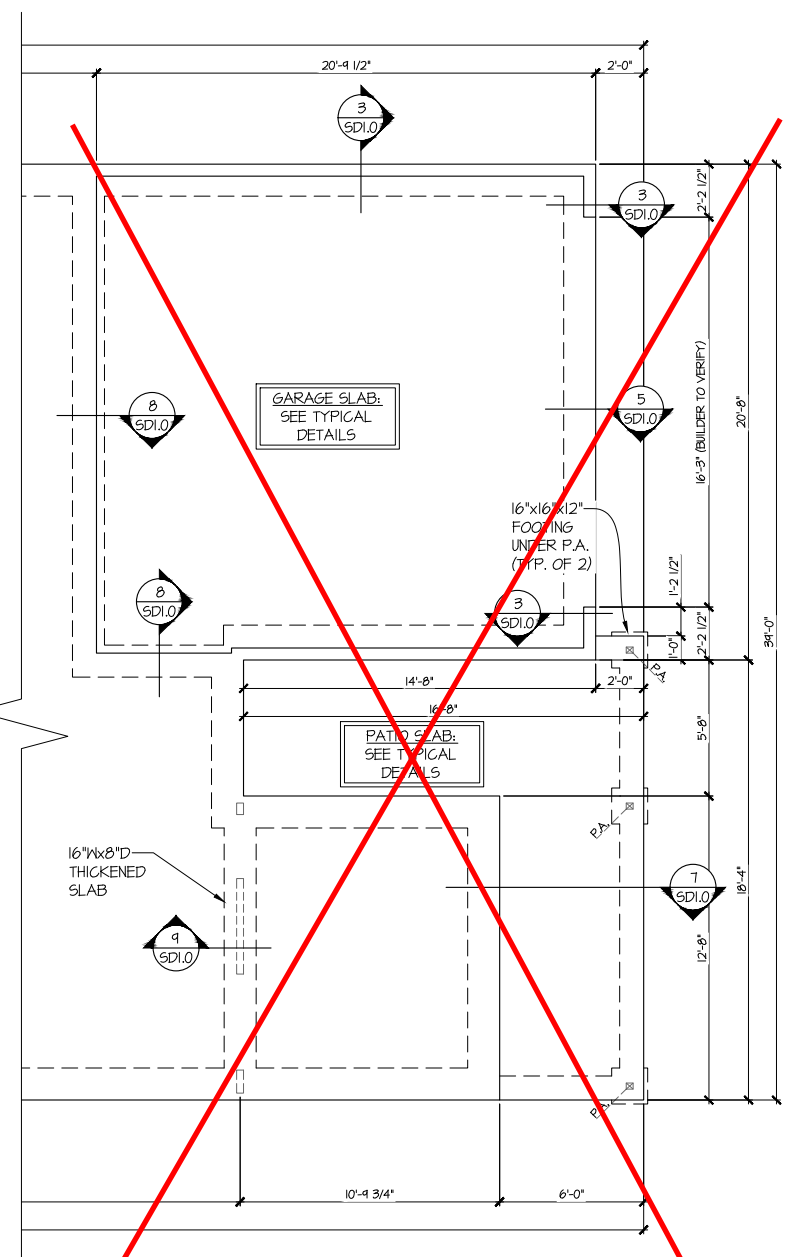


3 PARTIAL SLAB FOUNDATION PLAN
 SCALE: 1/4"=1'-0" (22x24 SHEET)
 1/8"=1'-0" (11x17 SHEET)
 ELEV. D
 SEE ELEV. A FOR MORE INFO

LEGEND	
• [Symbol]	INTERIOR BEARING WALL
• [Symbol]	BEARING WALL ABOVE (B.W.A.)
• [Symbol]	BEAM / HEADER
• [Symbol]	INDICATES EXTENT OF INT. OSB SHEARWALL AND/OR 3" O.C. EDGE NAILING
• [Symbol]	EXTENT OF VALLEY TRUSS OVERFRAMING @ 24" O.C. (MAX.)
• [Symbol]	EXTENT OF FLOOR SYSTEM TO BE DESIGNED FOR TILE
▶	INDICATES HOLDDOWN
⌈	METAL HANGER
✱	INDICATES POST ABOVE. PROVIDE SOLID BLOCKING UNDER POST OR JAMB ABOVE.

REFER TO S.O. FOR
 TYPICAL STRUCTURAL NOTES
 & SCHEDULES

**UNDER 9,000 FT² -
 FIRE-RATED WALL
 REQUIRED AT
 GARAGE SIDE &
 NON-GARAGE SIDE**

Lot 370
5920-04 Cypress Cove
Elevation A
Right-Hand Garage

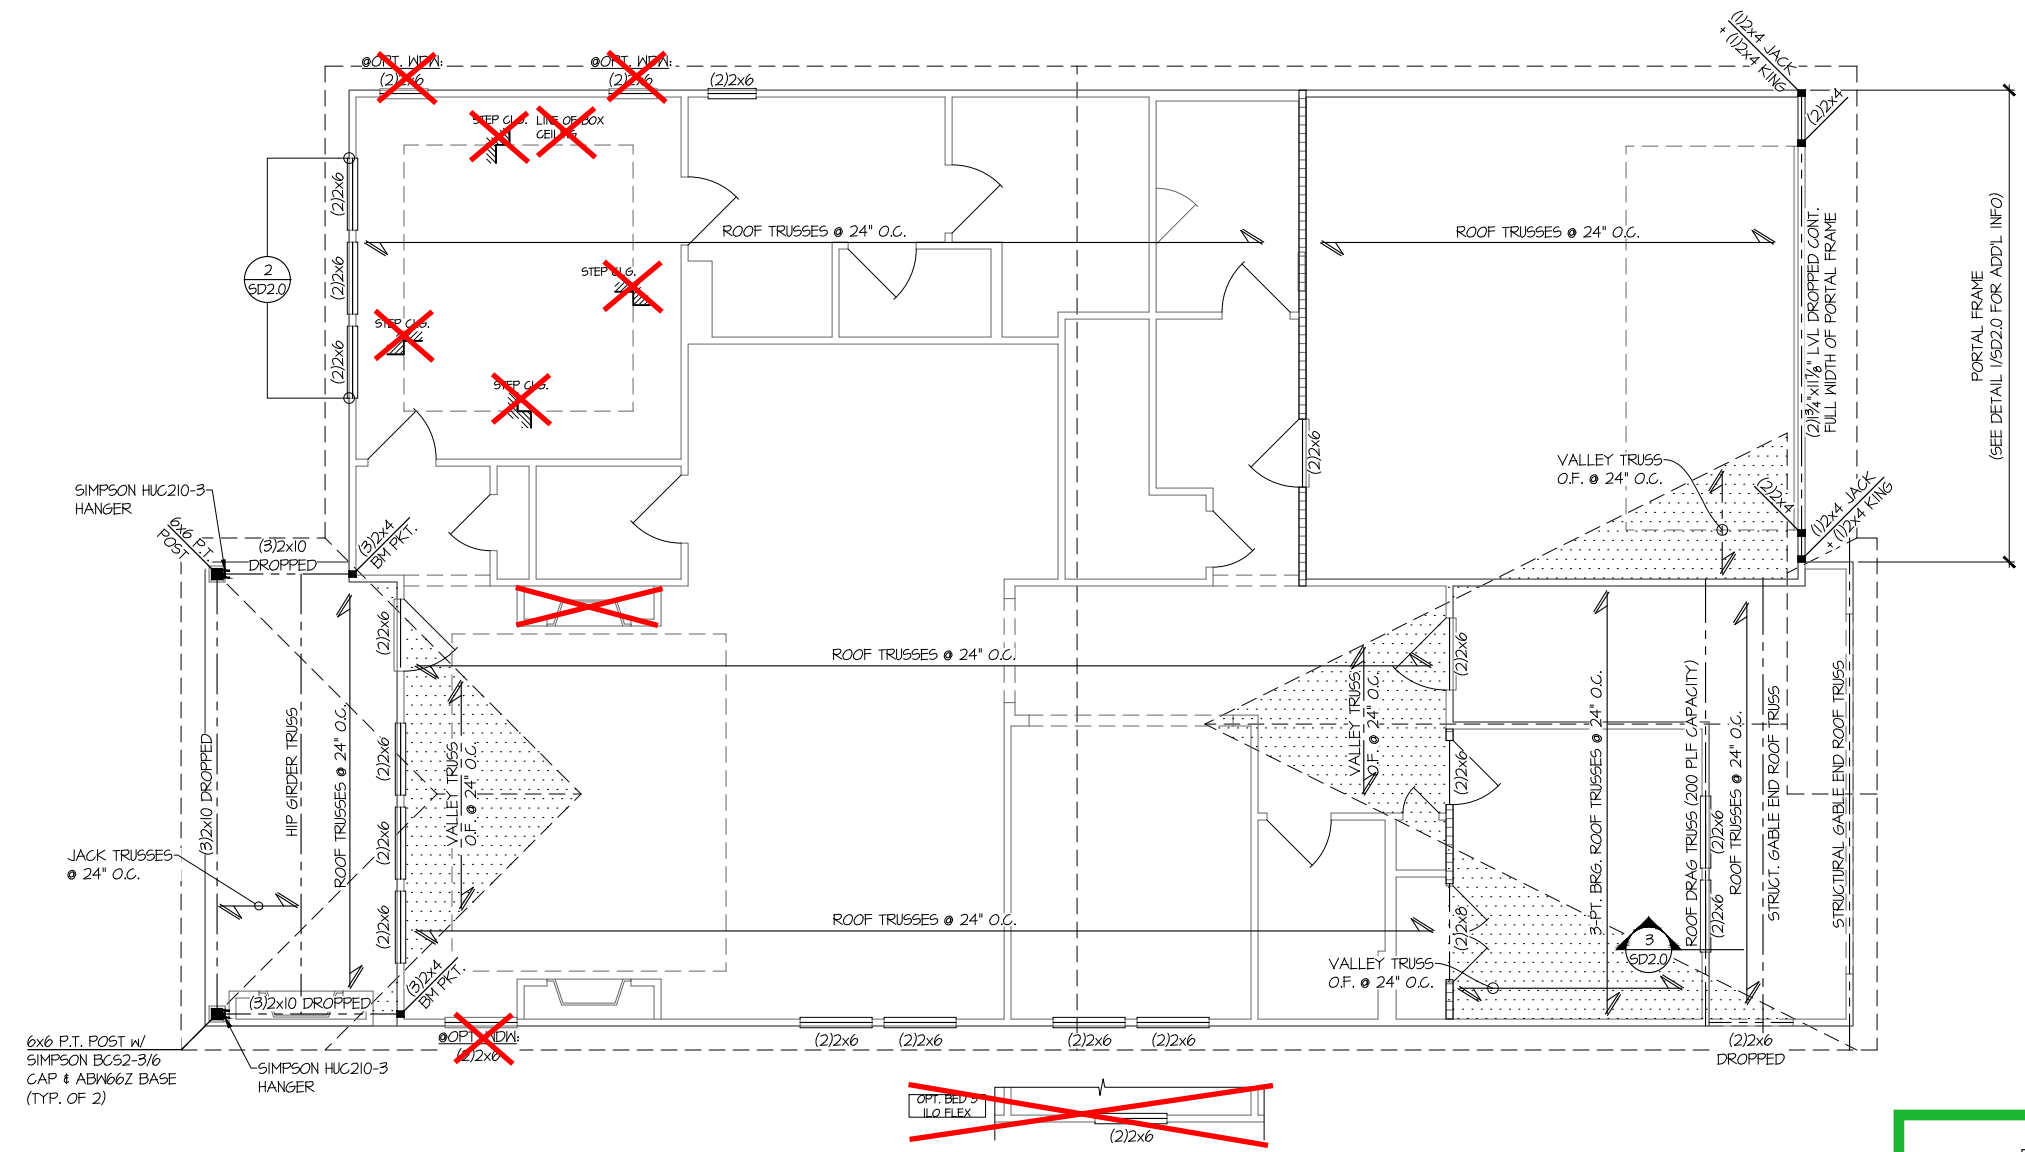

ELEVATION A

ROOF FRAMING PLAN
SCALE: 1/4"=1'-0" (22x24 SHEET)
1/8"=1'-0" (11x17 SHEET)
ELEV. A




THIS LEVEL HAS BEEN DESIGNED
FOR 9'-1" PLATE HEIGHT

LEGEND	
•	INTERIOR BEARING WALL
•	BEARING WALL ABOVE (B.W.A.)
•	BEAM / HEADER
•	INDICATES EXTENT OF INT. OSB SHEARWALL AND/OR 3" O.C. EDGE NAILING
•	EXTENT OF VALLEY TRUSS OVERFRAMING @ 24" O.C. (MAX.)
•	EXTENT OF FLOOR SYSTEM TO BE DESIGNED FOR TILE
▶	INDICATES HOLDOWN
⊥	METAL HANGER
*	INDICATES POST ABOVE. PROVIDE SOLID BLOCKING UNDER POST OR JAMB ABOVE.

REFER TO S0.0 FOR
TYPICAL STRUCTURAL NOTES
& SCHEDULES

UNDER 9,000 FT² -
FIRE-RATED WALL
REQUIRED AT
GARAGE SIDE &
NON-GARAGE SIDE

Lot 370
5920-04 Cypress Cove
Elevation A
Right-Hand Garage

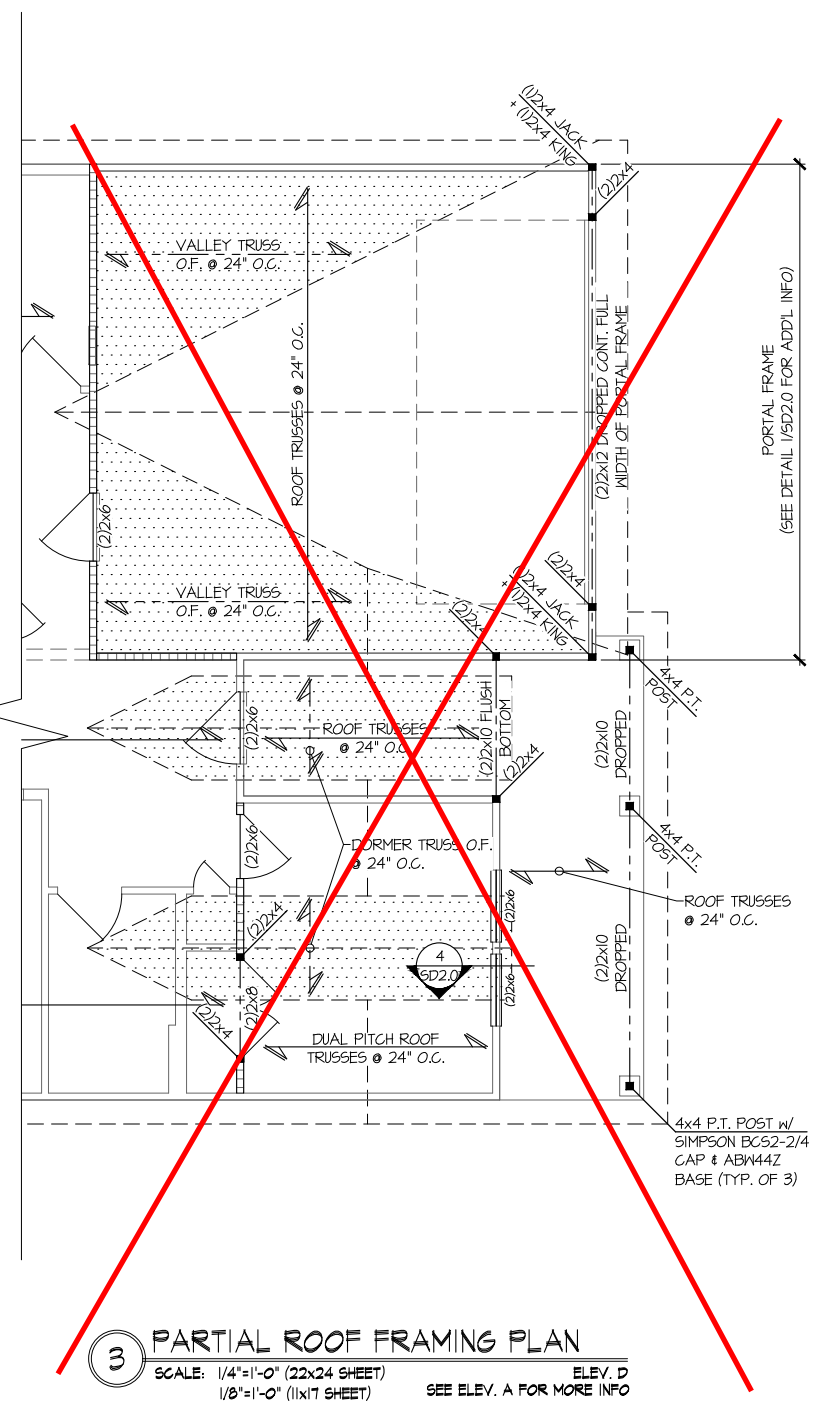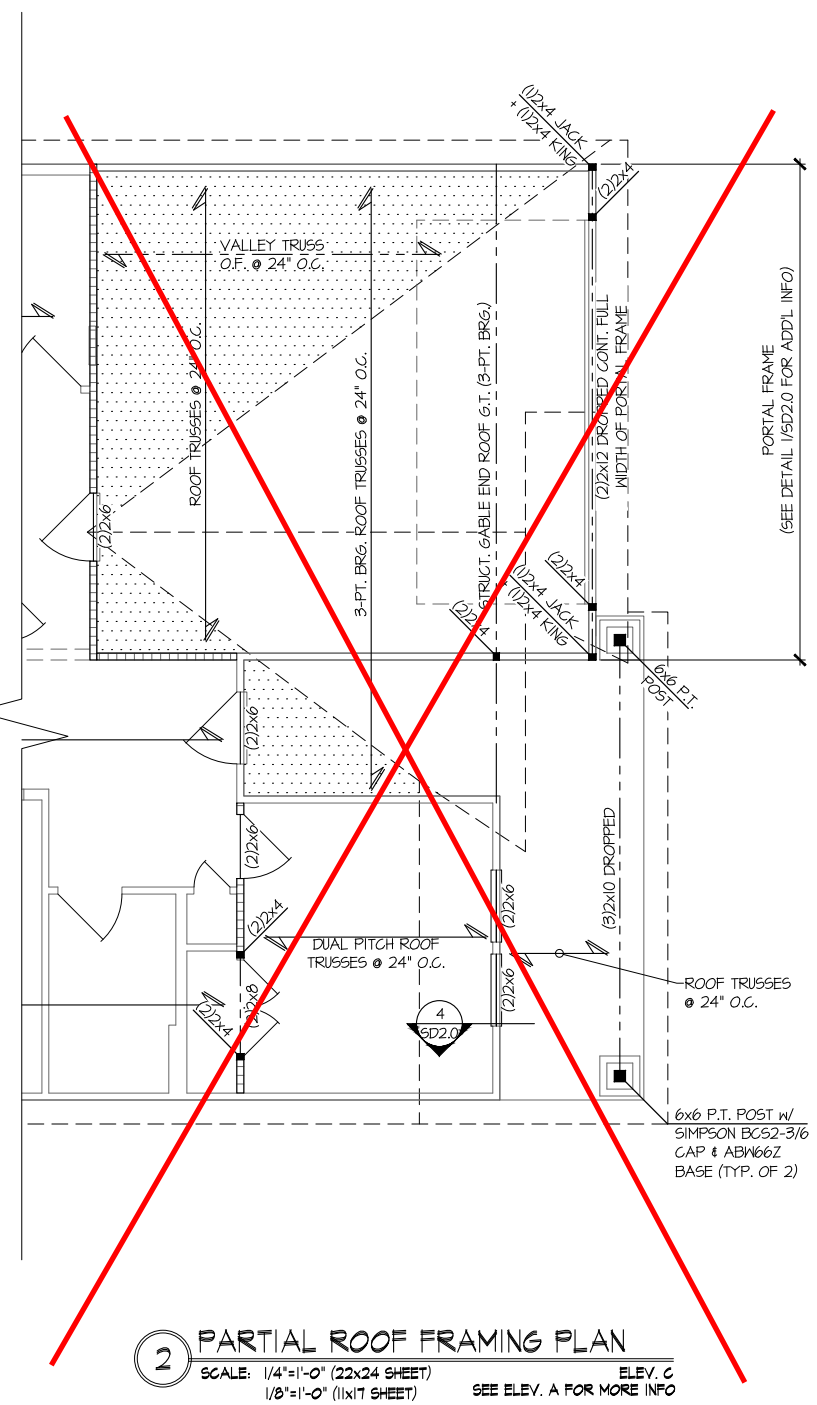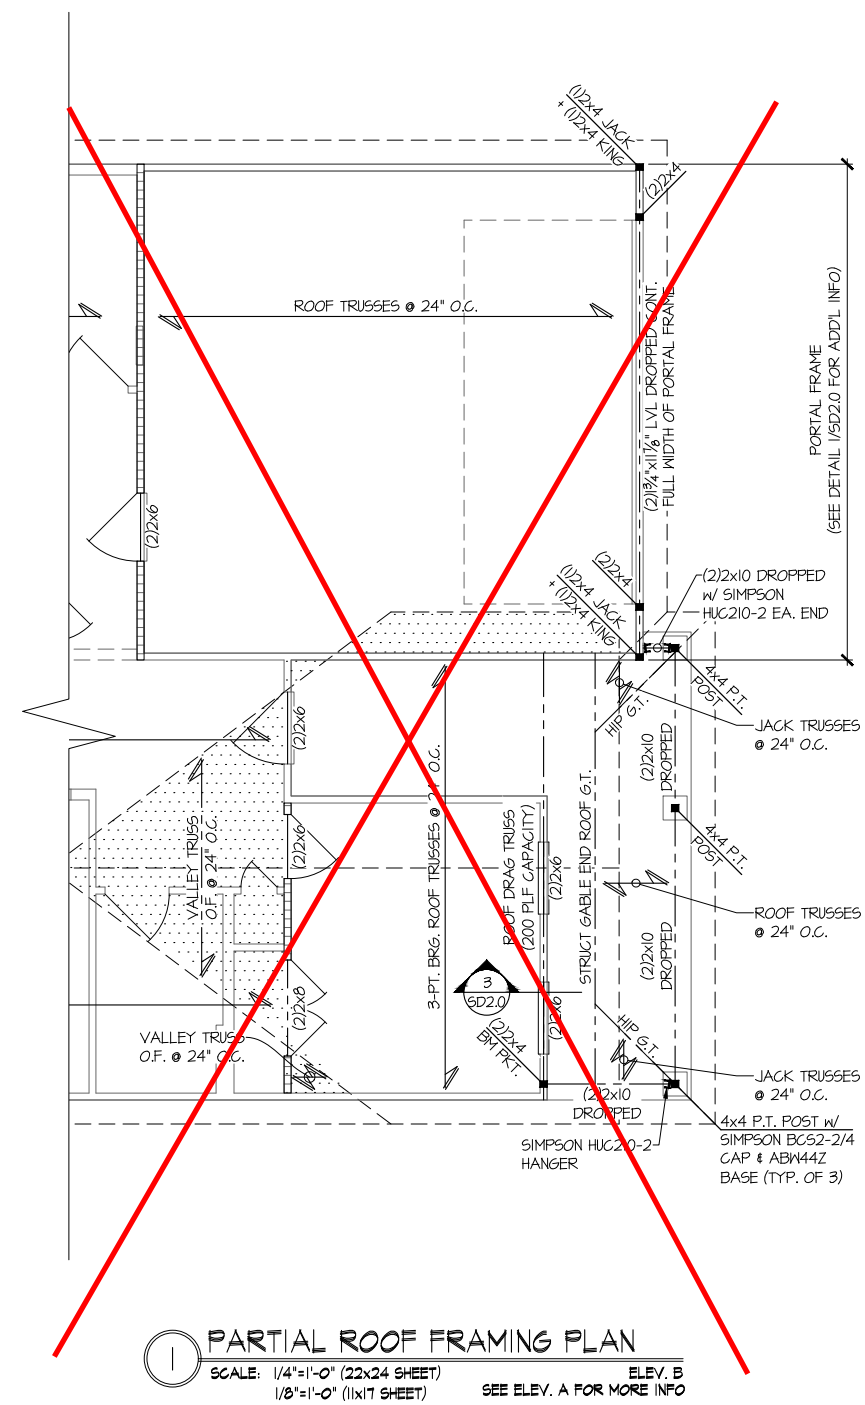


LEGEND	
•	INTERIOR BEARING WALL
•	BEARING WALL ABOVE (B.W.A.)
•	BEAM / HEADER
•	INDICATES EXTENT OF INT. OSB SHEARWALL AND/OR 3" O.C. EDGE NAILING
•	EXTENT OF VALLEY TRUSS OVERFRAMING 24" O.C. (MAX)
•	EXTENT OF FLOOR SYSTEM TO BE DESIGNED FOR TILE
▶	INDICATES HOLDDOWN
HL	METAL HANGER
*	INDICATES POST ABOVE. PROVIDE SOLID BLOCKING UNDER POST OR JAMB ABOVE.

THIS LEVEL HAS BEEN DESIGNED FOR 9'-1" PLATE HEIGHT

REFER TO S.O. FOR TYPICAL STRUCTURAL NOTES & SCHEDULES

UNDER 9,000 FT² - FIRE-RATED WALL REQUIRED AT GARAGE SIDE & NON-GARAGE SIDE

Lot 370
5920-04 Cypress Cove
Elevation A
Right-Hand Garage

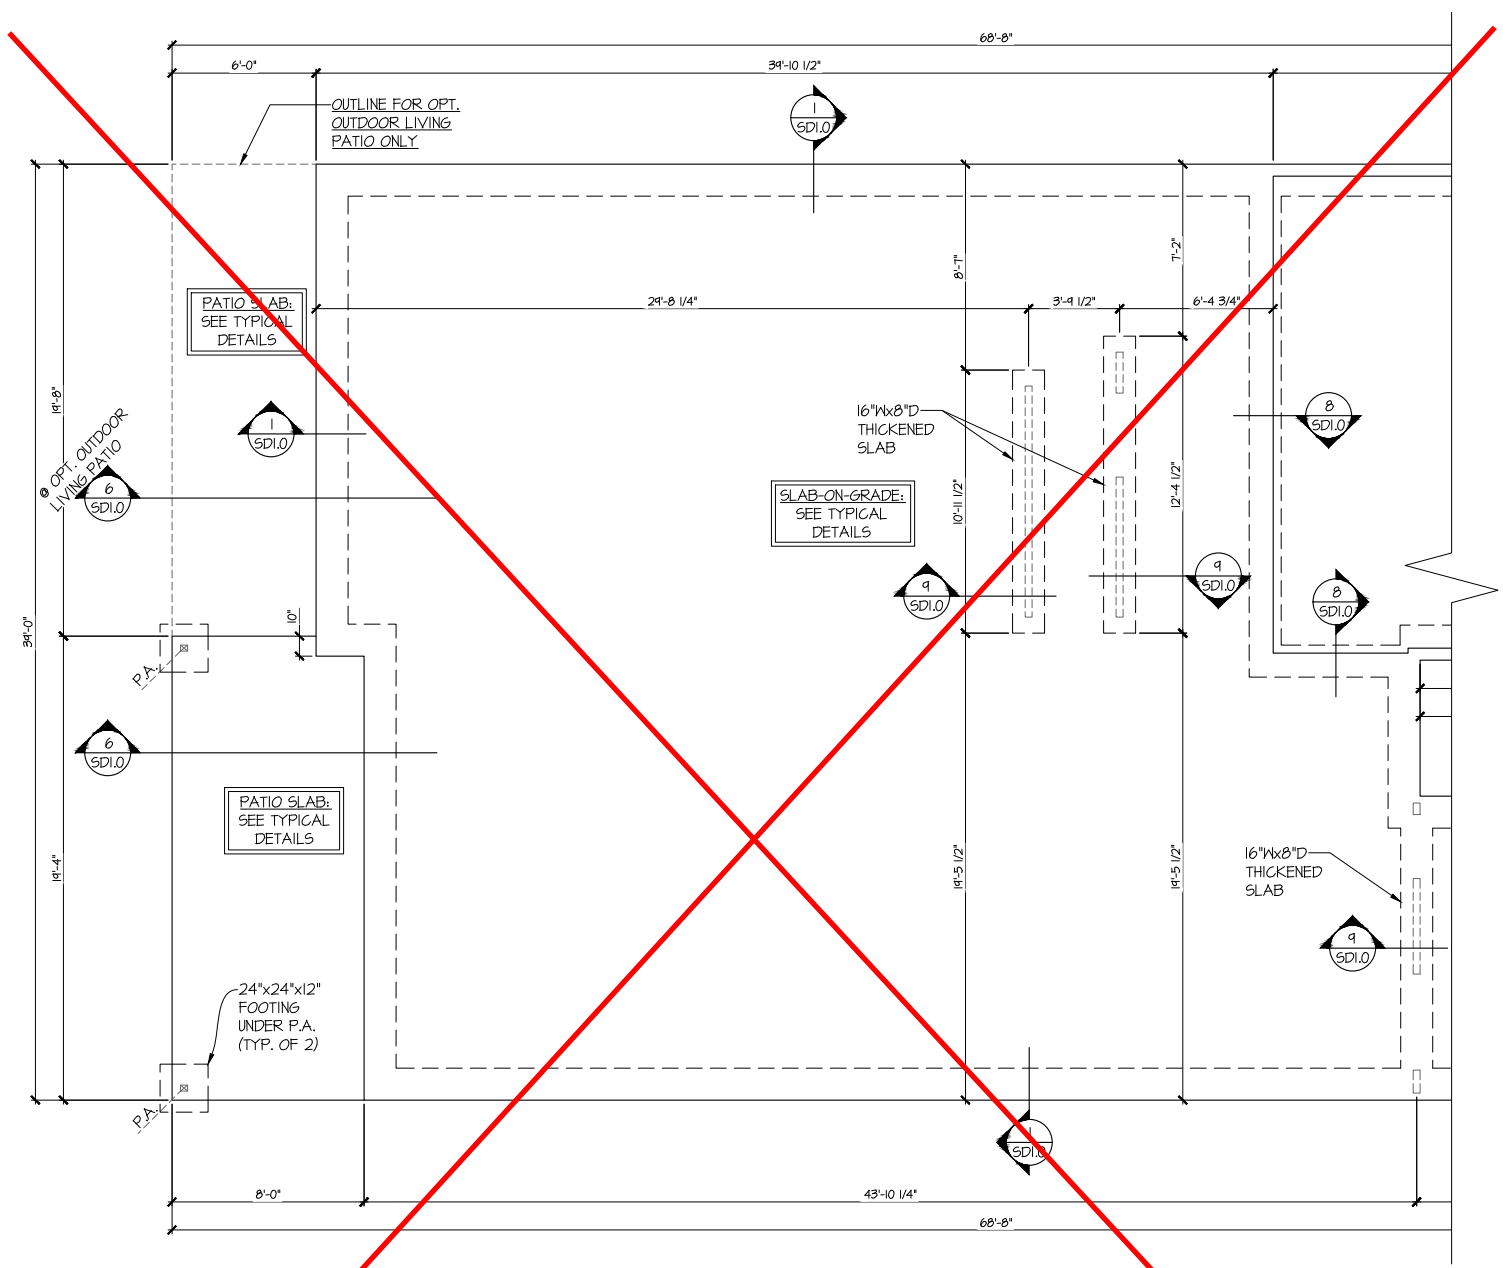


PARTIAL SLAB FOUNDATION PLAN
SCALE: 1/4"=1'-0" (22x34 SHEET)
1/8"=1'-0" (11x17 SHEET)
OPT. 2ND FLOOR
ELEV. A SHOWN
ALL ELEV. SIM.

**UNDER 9,000 FT² -
FIRE-RATED WALL
REQUIRED AT
GARAGE SIDE &
NON-GARAGE SIDE**

Lot 370
5920-04 Cypress Cove
Elevation A
Right-Hand Garage

LEGEND	
• [dashed line]	INTERIOR BEARING WALL
• [dashed line]	BEARING WALL ABOVE (B.W.A.)
• [solid line]	BEAM / HEADER
• [dashed line]	INDICATES EXTENT OF INT. OSB SHEARWALL AND/OR 3" O.C. EDGE NAILING
• [hatched box]	EXTENT OF VALLEY TRUSS OVERFRAMING @ 24" O.C. (MAX.)
• [diagonal lines]	EXTENT OF FLOOR SYSTEM TO BE DESIGNED FOR TILE
▶	INDICATES HOLDOWN
⊥	METAL HANGER
✱	INDICATES POST ABOVE. PROVIDE SOLID BLOCKING UNDER POST OR JAMB ABOVE.

REFER TO S0.0 FOR
TYPICAL STRUCTURAL NOTES
& SCHEDULES

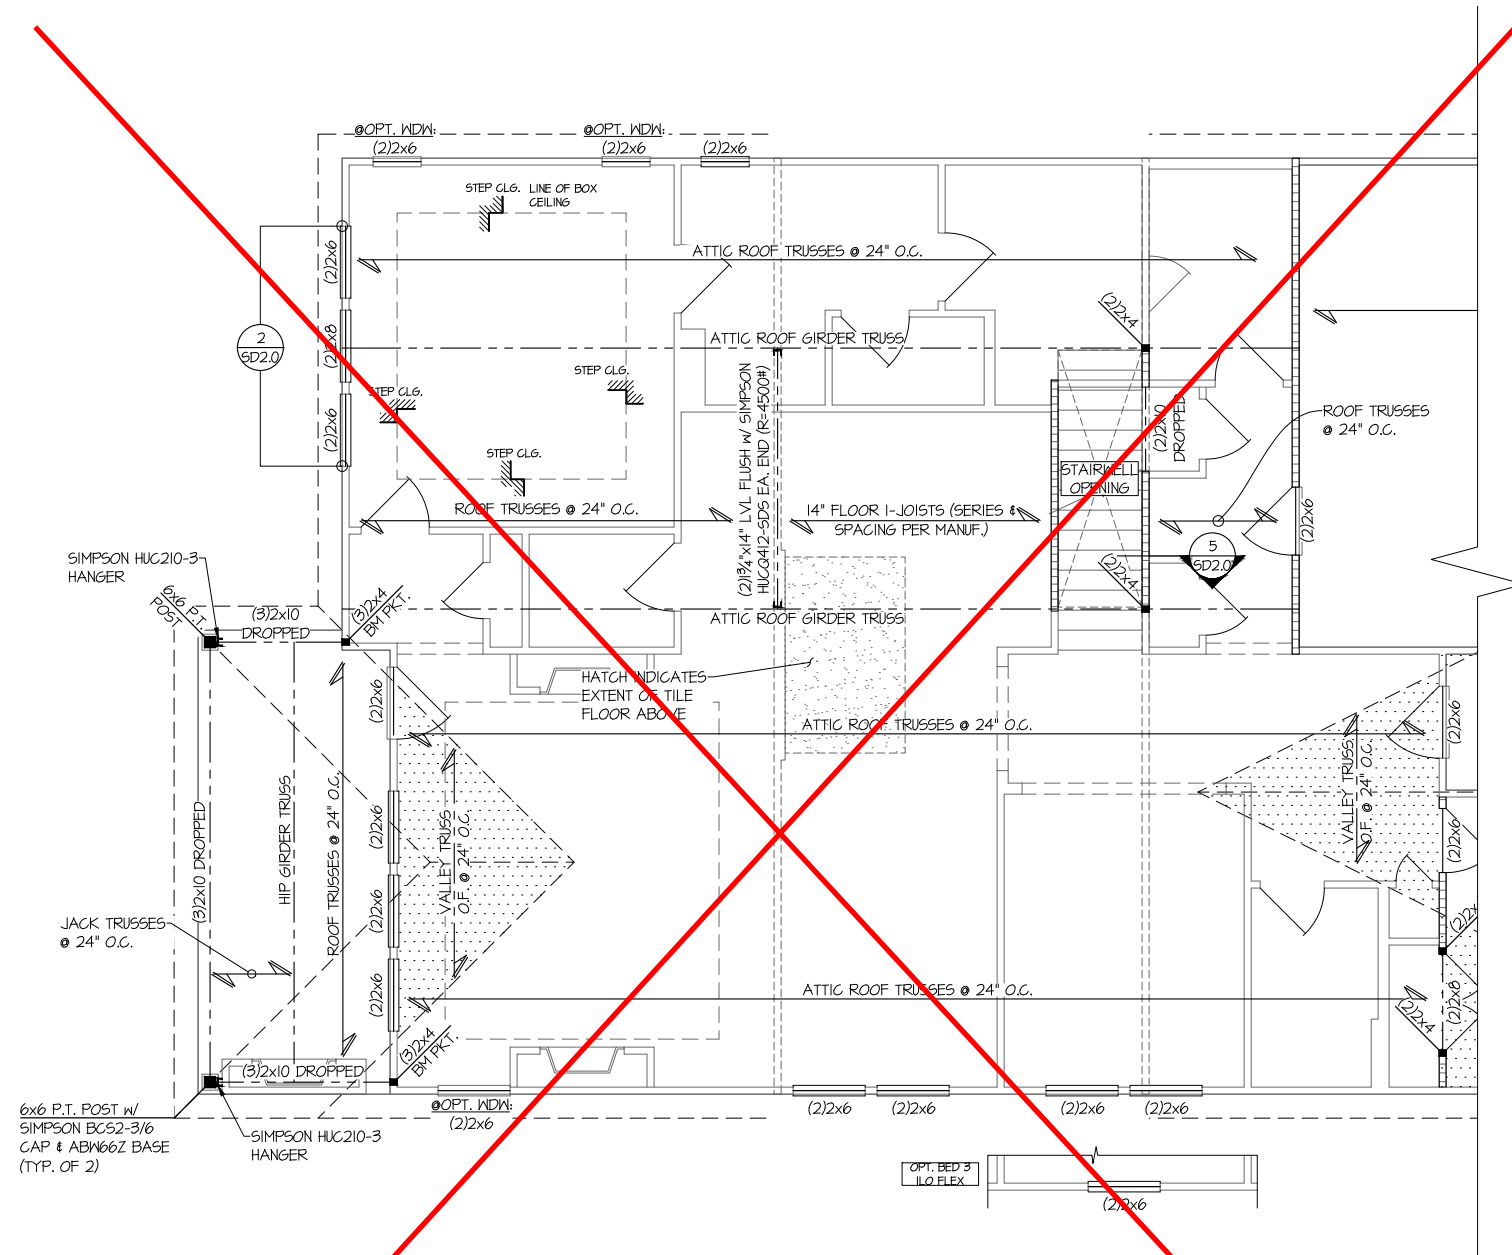

1 PARTIAL LOW ROOF FRAMING PLAN
 SCALE: 1/4"=1'-0" (22x24 SHEET)
 1/8"=1'-0" (11x17 SHEET)
 OPT. 2ND FLOOR
 ELEV. A SHOWN
 ALL ELEV. SIM.

**UNDER 9,000 FT² -
 FIRE-RATED WALL
 REQUIRED AT
 GARAGE SIDE &
 NON-GARAGE SIDE**

Lot 370
5920-04 Cypress Cove
Elevation A
Right-Hand Garage

THIS LEVEL HAS BEEN DESIGNED FOR 9'-1" PLATE HEIGHT

LEGEND	
• [Symbol]	INTERIOR BEARING WALL
• [Symbol]	BEARING WALL ABOVE (B.W.A.)
• [Symbol]	BEAM / HEADER
• [Symbol]	INDICATES EXTENT OF INT. OSB SHEARWALL AND/OR 3" O.C. EDGE NAILING
• [Symbol]	EXTENT OF VALLEY TRUSS OVERFRAMING @ 24" O.C. (MAX.)
• [Symbol]	EXTENT OF FLOOR SYSTEM TO BE DESIGNED FOR TILE
▶ [Symbol]	INDICATES HOLDOWN
⌈ [Symbol]	METAL HANGER
* [Symbol]	INDICATES POST ABOVE. PROVIDE SOLID BLOCKING UNDER POST OR JAMB ABOVE.

**REFER TO S.O. FOR
 TYPICAL STRUCTURAL NOTES
 & SCHEDULES**

seal: 5/19/25

MULHERN+KULP
 RESIDENTIAL STRUCTURAL ENGINEERING
 3805 Boulevard Parkway, Suite 250 - Alpharetta, GA 30022
 770-777-4874 • mulhern+kulp.com
 NC License # C-3625

Mulhern + Kulp project number:
243-24030

project mgr: **SMK**
 drawn by: **SMM**
 issue date: **11-07-24**


REVISIONS:
 date: 05-16-25 initial: JPP
 PER UPDATED ARCH.

tri pointe
 HOMES

STRUCTURAL OPTIONS

5920-04 MODEL
 SERENITY
 MASTER SET
 RALEIGH, NC

sheet:
S3.1

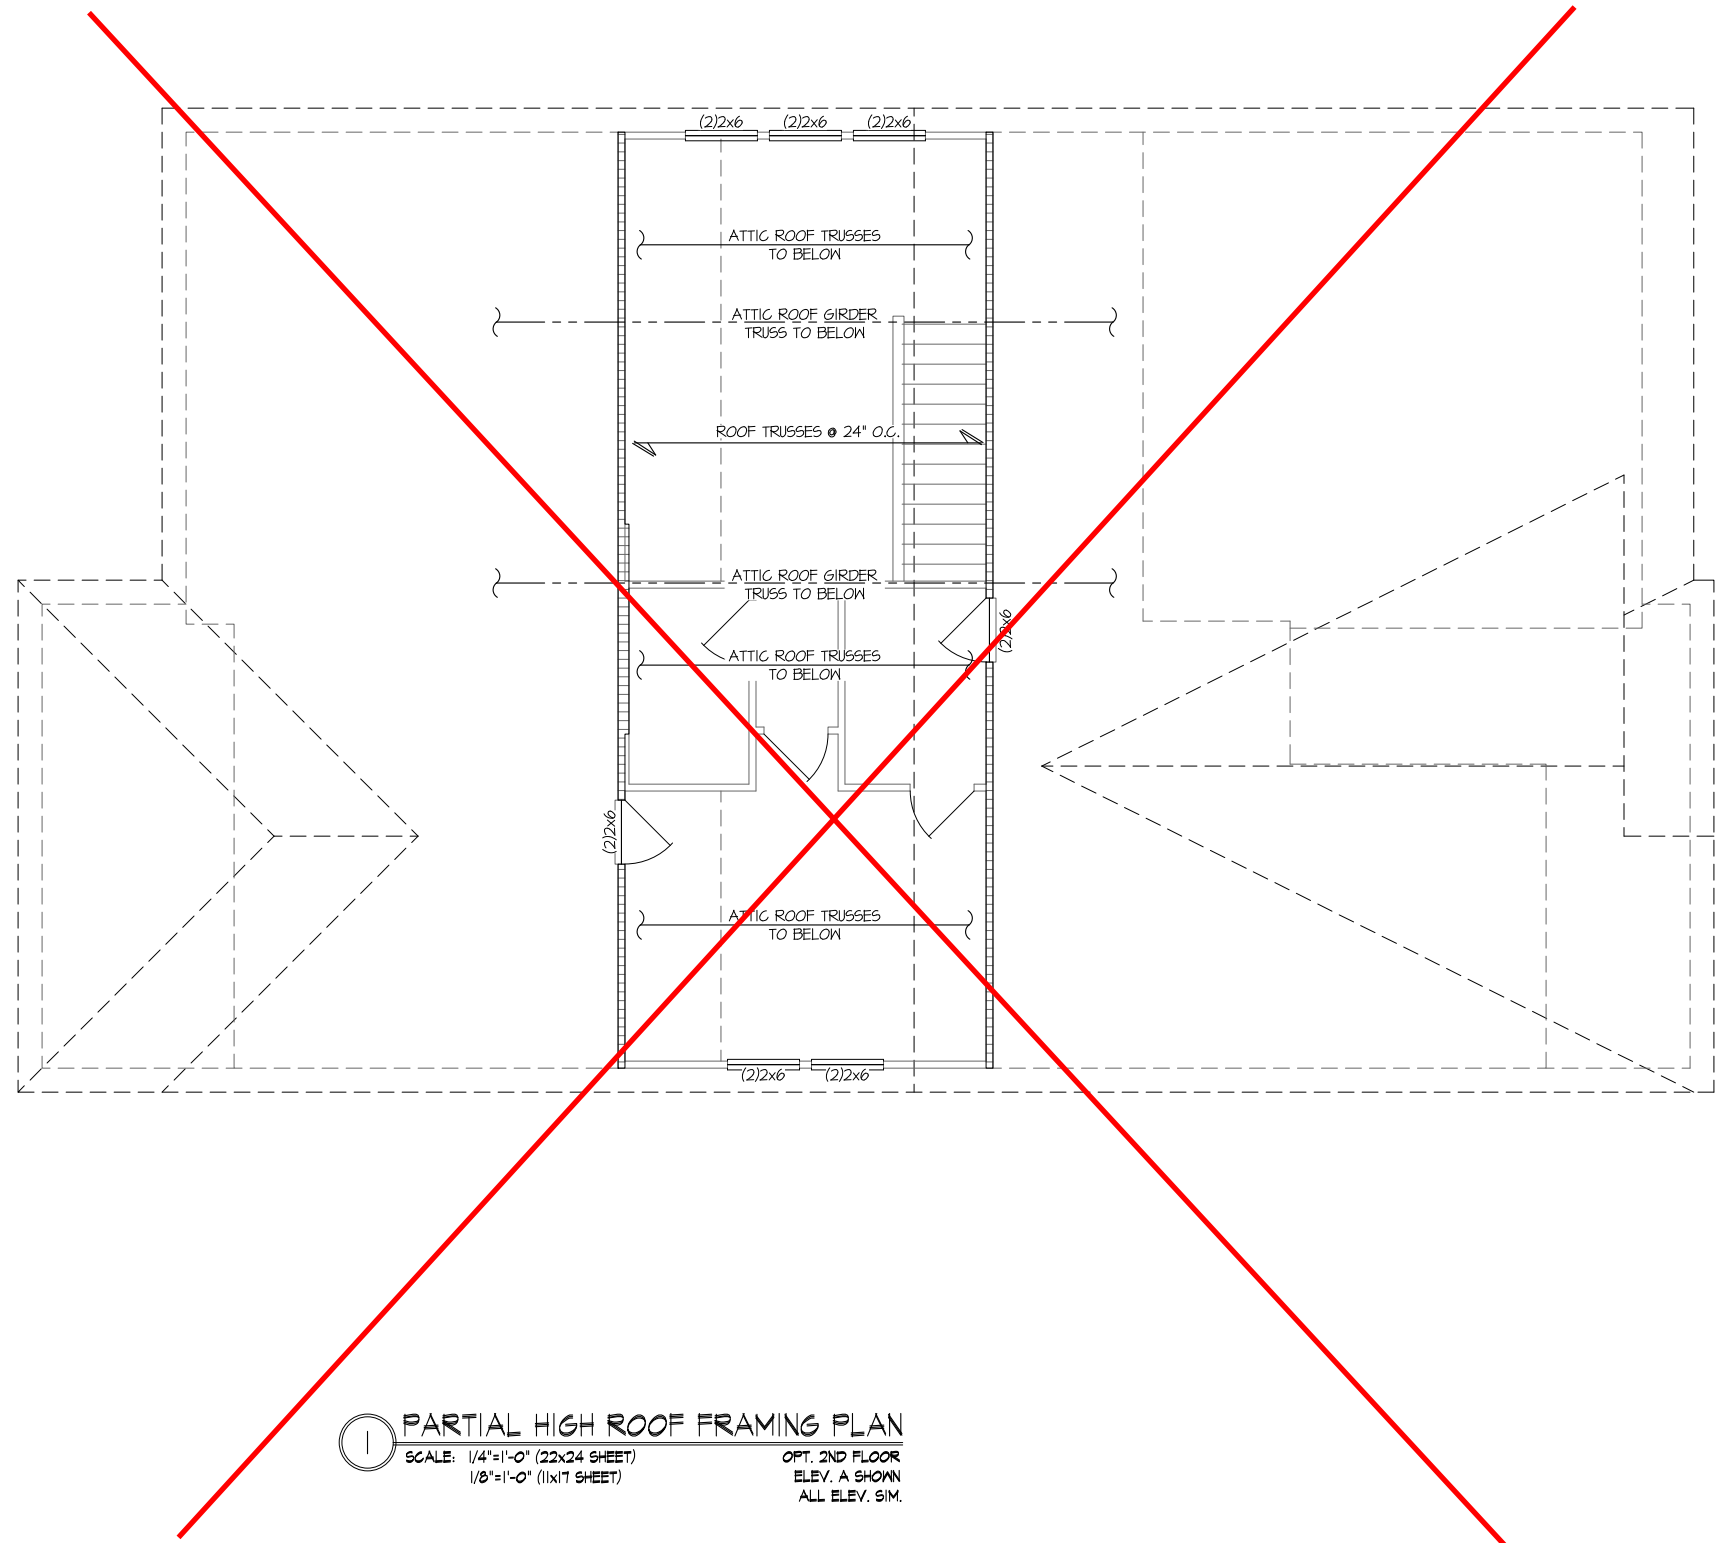

1 PARTIAL HIGH ROOF FRAMING PLAN
SCALE: 1/4"=1'-0" (22x34 SHEET)
1/8"=1'-0" (11x17 SHEET)
OPT. 2ND FLOOR
ELEV. A SHOWN
ALL ELEV. SIM.

UNDER 9,000 FT² -
FIRE-RATED WALL
REQUIRED AT
GARAGE SIDE &
NON-GARAGE SIDE

Lot 370
5920-04 Cypress Cove
Elevation A
Right-Hand Garage

THIS LEVEL HAS BEEN DESIGNED
FOR 9'-1" PLATE HEIGHT

LEGEND

- INTERIOR BEARING WALL
- BEARING WALL ABOVE (B.W.A.)
- BEAM / HEADER
- INDICATES EXTENT OF INT. OSB SHEARWALL AND/OR 8" O.C. EDGE NAILING
- EXTENT OF VALLEY TRUSS OVERFRAMING @ 24" O.C. (MAX.)
- EXTENT OF FLOOR SYSTEM TO BE DESIGNED FOR TILE
- INDICATES HOLDOWN
- METAL HANGER
- INDICATES POST ABOVE. PROVIDE SOLID BLOCKING UNDER POST OR JAMB ABOVE.

REFER TO S.O. FOR
TYPICAL STRUCTURAL NOTES
& SCHEDULES

seal: 5/19/25
NORTH CAROLINA
REGISTERED PROFESSIONAL
SEAL 017622
ENGINEER
STALIN KREIDEL
© MULHERN + KULP
Structural Engineering, Inc.

MULHERN+KULP
RESIDENTIAL STRUCTURAL ENGINEERING
3905 Buckle Up Parkway, Suite 250 • Alpharetta, GA 30022
970-777-4874 • mulhernkulp.com
NC License # C-3625

Mulhern+Kulp project number:
243-24030


project mgr: SMK
drawn by: SMM
issue date: 11-07-24

REVISIONS:
date: 05-16-25 initial: JPP
PER UPDATED ARCH.

tri pointe
HOMES

STRUCTURAL OPTIONS
5920-04 MODEL
SERENITY
MASTER SET
RALEIGH, NC

sheet:
S3.2

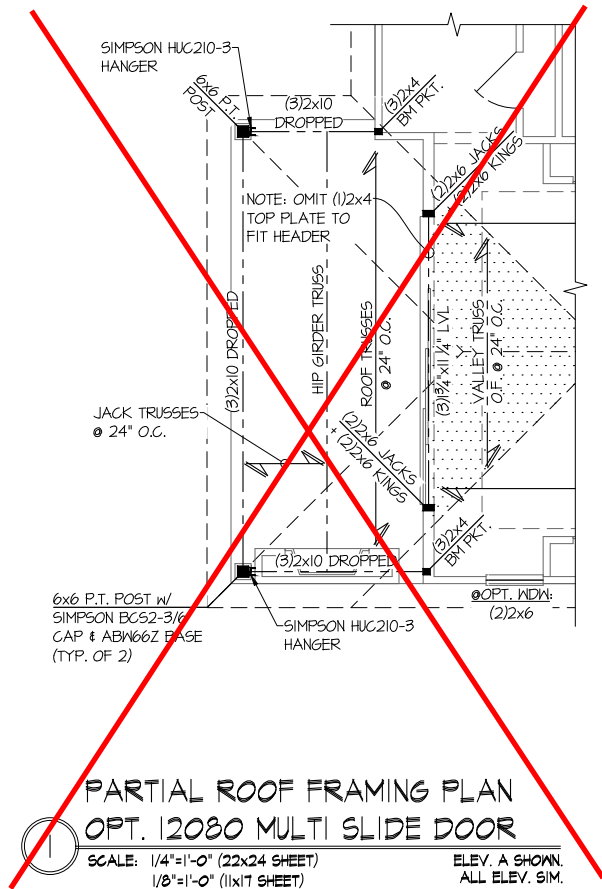

UNDER 9,000 FT² -
FIRE-RATED WALL
REQUIRED AT
GARAGE SIDE &
NON-GARAGE SIDE

Lot 370
5920-04 Cypress Cove
Elevation A
Right-Hand Garage

LEGEND

- INTERIOR BEARING WALL
- BEARING WALL ABOVE (B.W.A.)
- BEAM / HEADER
- INDICATES EXTENT OF INT. OSB SHEARWALL AND/OR 3" O.C. EDGE NAILING
- EXTENT OF VALLEY TRUSS OVERFRAMING @ 24" O.C. (MAX.)
- EXTENT OF FLOOR SYSTEM TO BE DESIGNED FOR TILE
- INDICATES HOLDOWN
- METAL HANGER
- INDICATES POST ABOVE. PROVIDE SOLID BLOCKING UNDER POST OR JAMB ABOVE.

REFER TO S.O. FOR
TYPICAL STRUCTURAL NOTES
& SCHEDULES

seal: 5/19/25

MULHERN+KULP
RESIDENTIAL STRUCTURAL ENGINEERING

3805 Boudade Parkway, Suite 250 • Alpharetta, GA 30022
970-777-4874 • mulhernkulp.com
NC License # C-3625

Mulhern+Kulp project number:
243-24030







project mgr: SMK
drawn by: SMM
issue date: 11-07-24

REVISIONS:
date: 05-16-25 initial: JPP
PER UPDATED ARCH

STRUCTURAL OPTIONS

5920-04 MODEL
SERENITY
MASTER SET
RALEIGH, NC

sheet:
S3.3

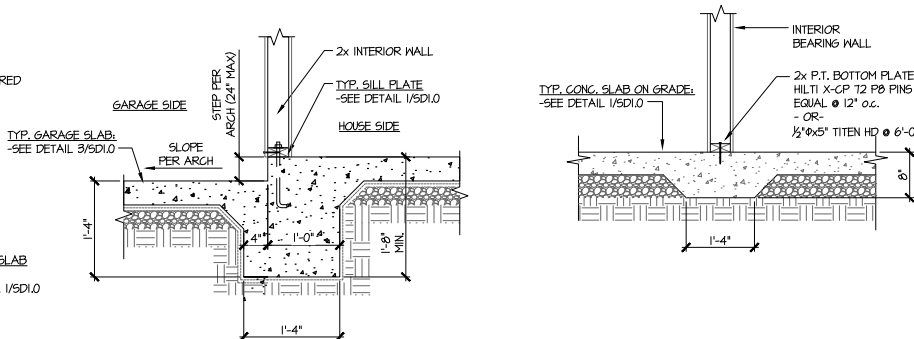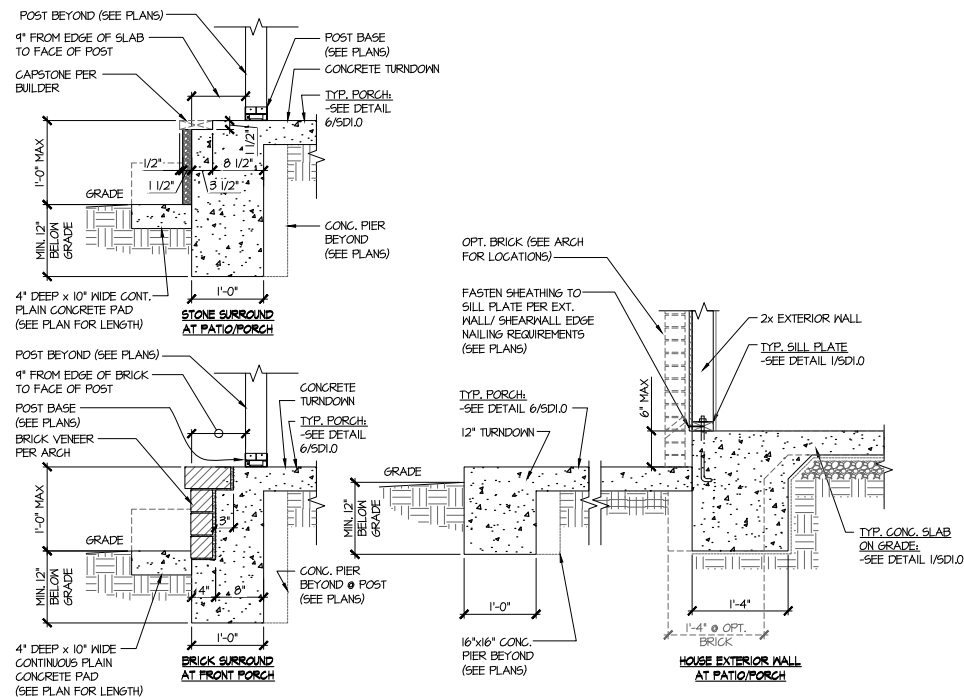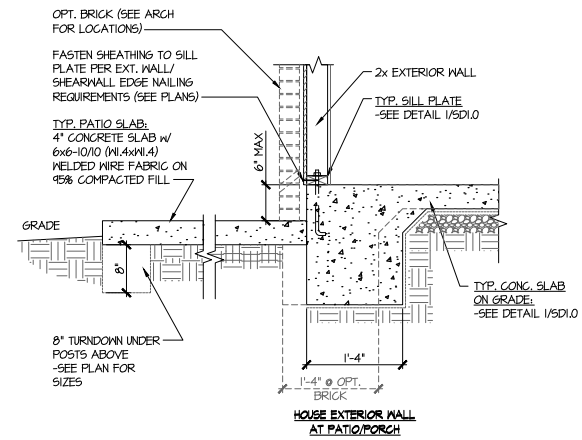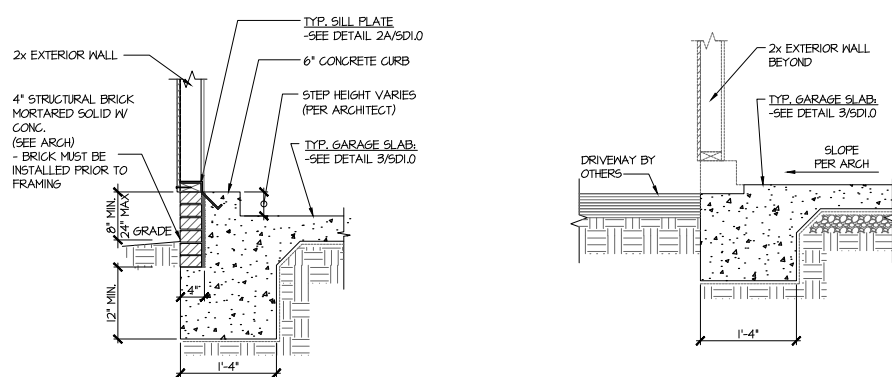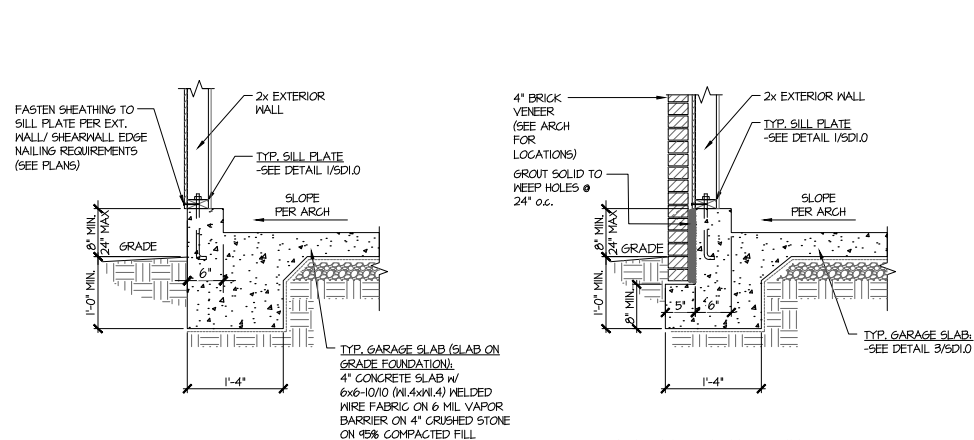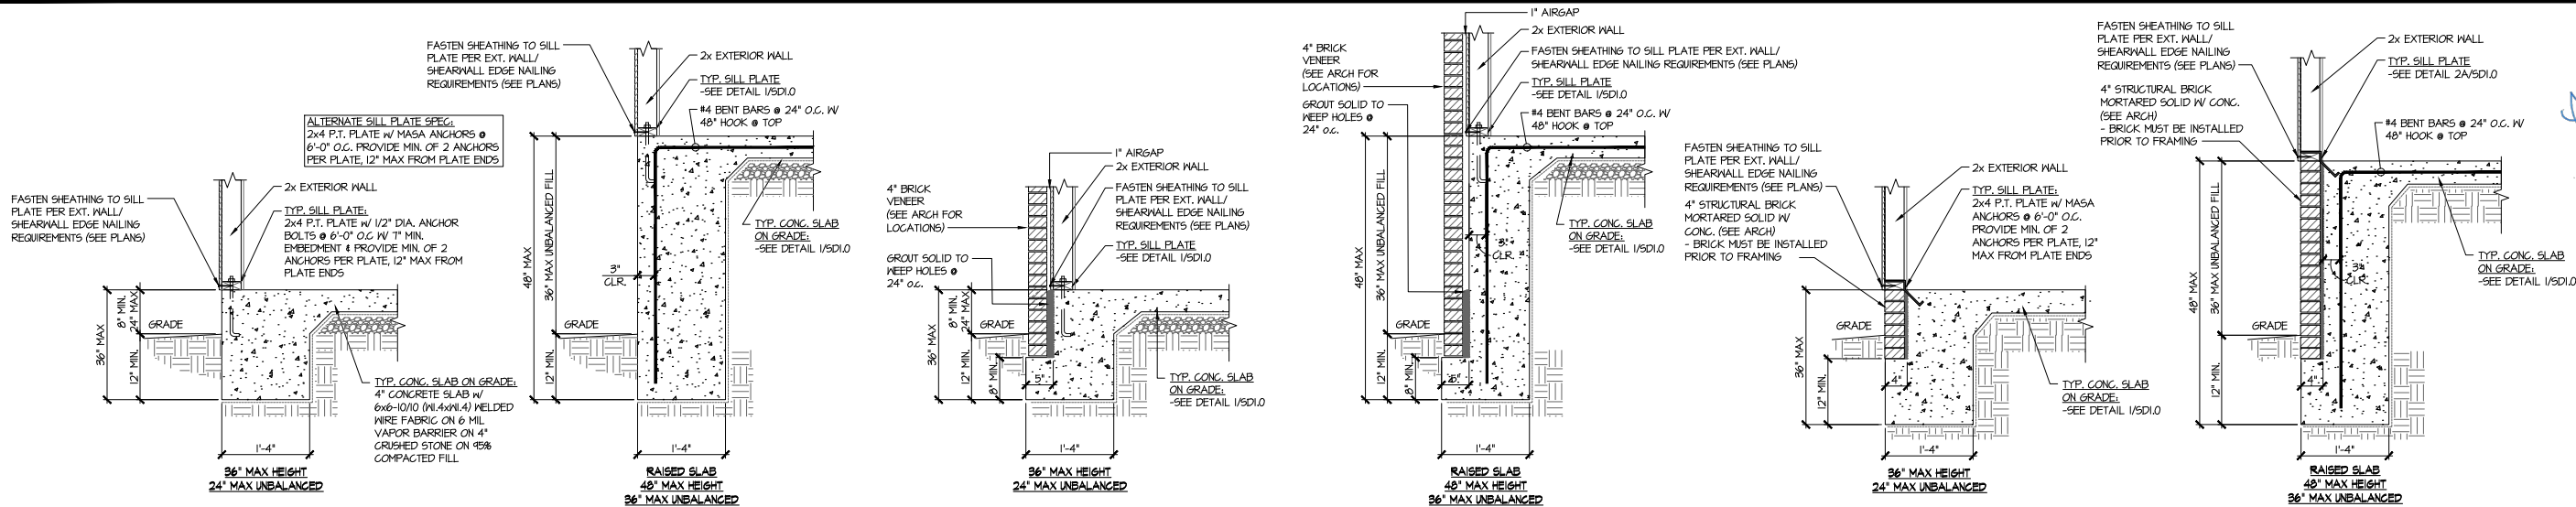

seal: 5/19/25
MOORE CAROLINA
SEAL
017622
ENGINEER
STALIN KREIDEL
© copyright: MULHERN & KULP
Structural Engineering, Inc.

MULHERN+KULP
RESIDENTIAL STRUCTURAL ENGINEERING
3605 Sandcastle Parkway, Suite 250 - Alpharetta, GA 30022
978-777-4874 • mulhern+kulp.com
NC License # C-3625

Mulhern+Kulp project number:
243-24030




project mgr: **SMK**
drawn by: **SMM**
issue date: **11-07-24**

REVISIONS:
date: initial:
05-16-25 JPP
PER UPDATED ARCH.


tri pointe
HOMES

FOUNDATION DETAILS
5920-04 MODEL
SERENITY
MASTER SET
RALEIGH, NC


sheet:
SD1.0

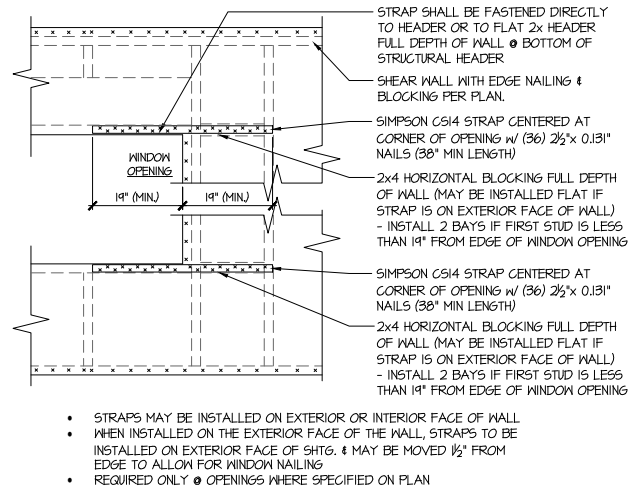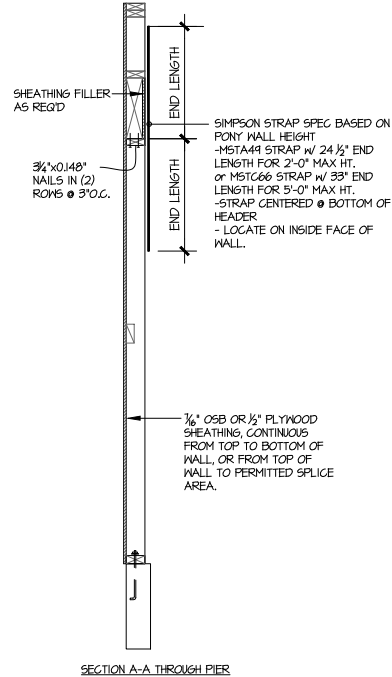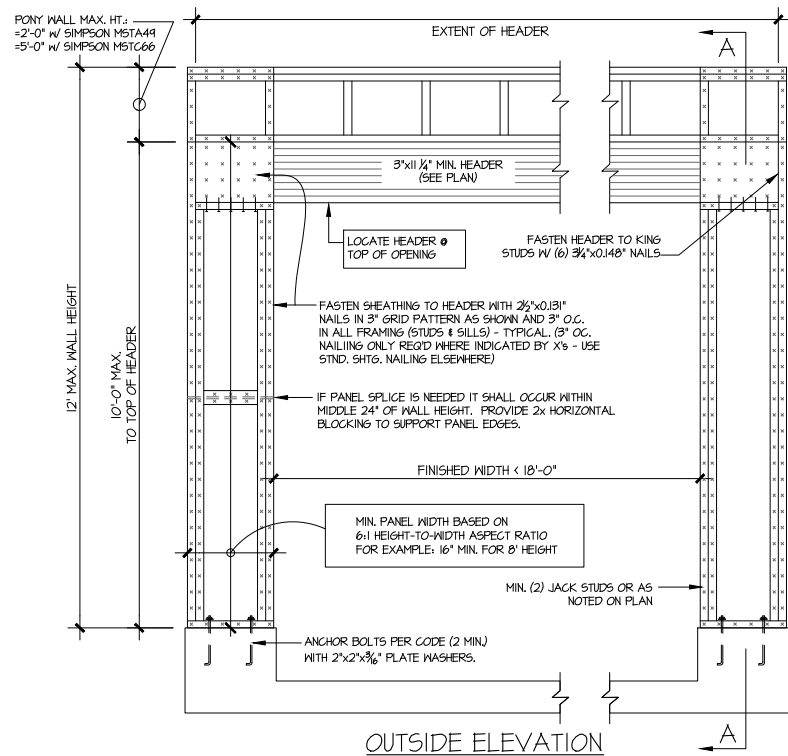



2 TYPICAL EXT. WALL & INT. SHEARWALL OPENING ELEVATION
SCALE: N.T.S.

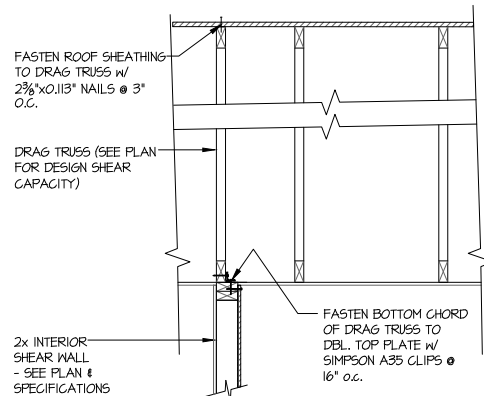

3 DRAG TRUSS DETAIL
SCALE: 3/4"=1'-0"

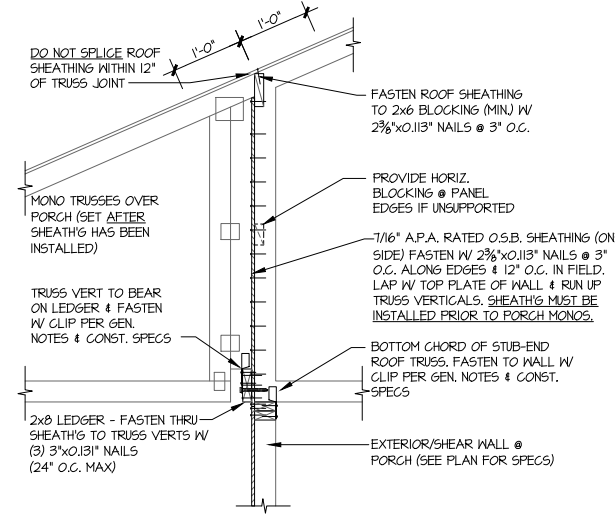


4 SHEAR TRANSFER DETAIL @ BREAK IN TRUSSES OVER SHEAR WALL
SCALE: 3/4"=1'-0" - 22x34
3/8"=1'-0" - 11x17

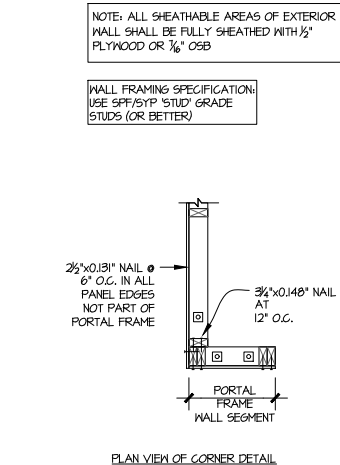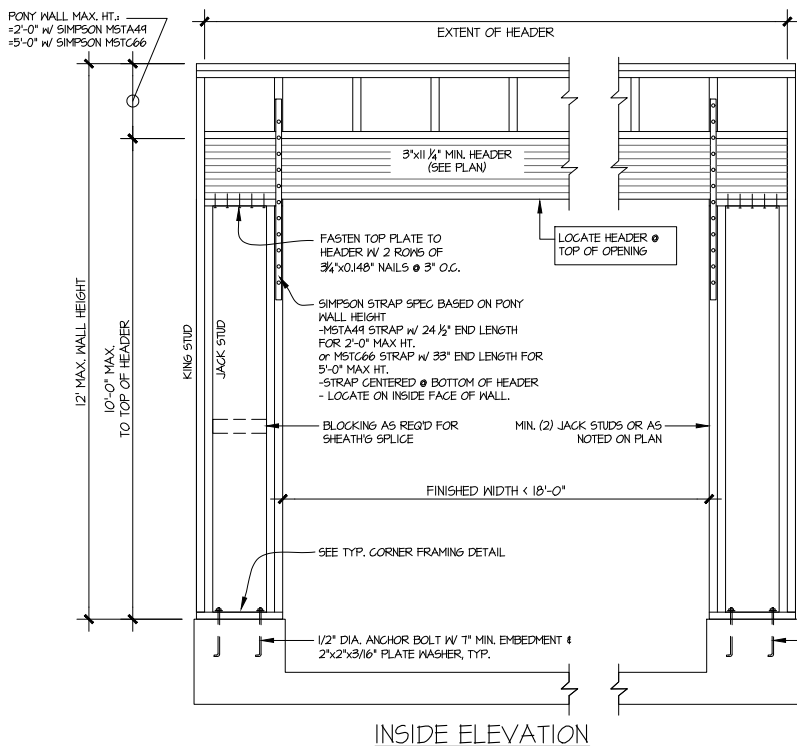

ALTERNATIVES TO 1/2" DIA. ANCHOR BOLT:
1) 1/2" DIA. x 6" LONG SIMPSON TITEN HD
2) 1/2" DIA. THREADED ROD EPOXY SET w/4 1/2" EMBED.
(MIN) UTILIZING HILTI HY200 EPOXY ANCHORING SYSTEM
(OR EQUAL)

1 GARAGE PORTAL FRAME BRACING ELEVATION
SCALE: N.T.S. BOTH SIDES OF GARAGE DOOR
115 MPH WIND SPEED (ULT)

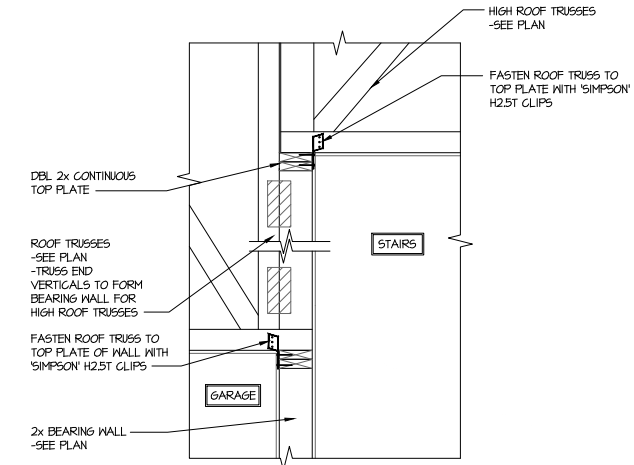

5 DETAIL
SCALE: 3/4"=1'-0"

seal: 5/19/25
MULHERN+KULP
STRUCTURAL ENGINEERING
INC.




MULHERN+KULP
RESIDENTIAL STRUCTURAL ENGINEERING
3805 Boulevard Parkway, Suite 250 - Alpharetta, GA 30022
978-777-4874 - mulhern+kulp.com
NC License # C-3625

Mulhern+Kulp project number:
243-24030
project mgr: SMK
drawn by: SMM
issue date: 11-07-24
REVISIONS:
date: initial:
05-16-25 JPP
PER UPDATED ARCH

tri pointe
HOMES


FRAMING DETAILS
5920-04 MODEL
SERENITY
MASTER SET
RALEIGH, NC

sheet:
SD2.0

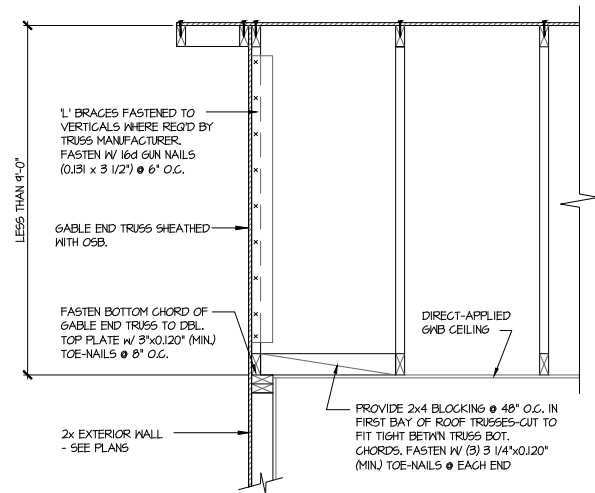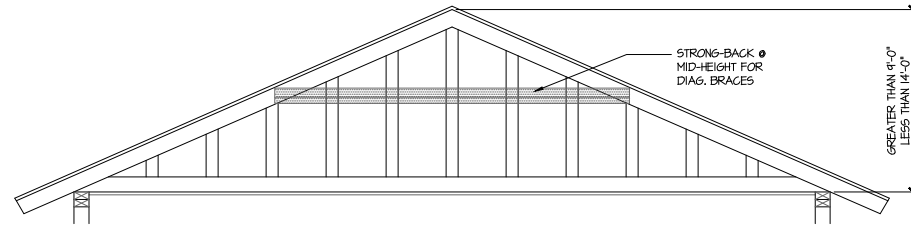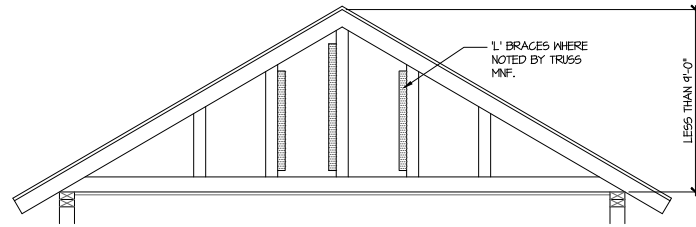


A TYPICAL GABLE END BRACING DETAIL
SCALE: NONE
REQ'D @ GABLE END TRUSS
HEIGHT UP TO 9'-0"

BRACE GABLE END TRUSSES PER ABOVE DETAIL WHEN GABLE HEIGHT IS LESS THAN 9'-0". 1" BRACES REQUIRED WHERE NOTED BY TRUSS MANUFACTURER.

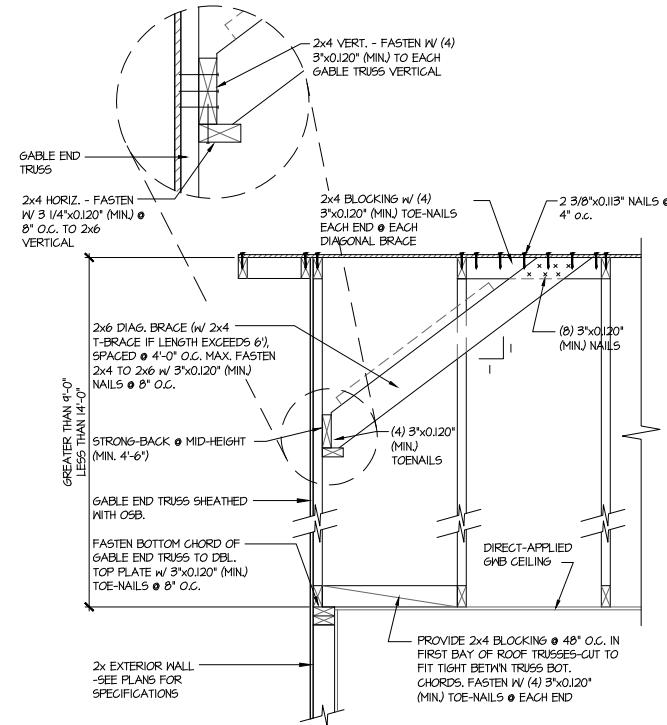

B TYPICAL GABLE END BRACING DETAIL
SCALE: NONE
REQ'D @ GABLE END TRUSS
HEIGHT BETWEEN 9'-0" TO 14'-0"

BRACE GABLE END TRUSSES PER ABOVE DETAIL WHEN GABLE HEIGHT EXCEEDS 9'-0". 1" BRACES NOT REQUIRED.

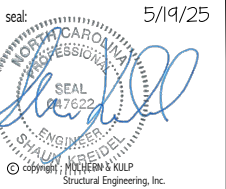

MULHERN+KULP
RESIDENTIAL STRUCTURAL ENGINEERING
3905 Bunkle Park, Suite 250 - Alpharetta, GA 30022
970-777-4874 • mulhern+kulp.com
NC License # C-3625

Mulhern+Kulp project number:
243-24030

project mgr: SMK
drawn by: SMM
issue date: 11-07-24

REVISIONS:
date: 05-16-25 initial: JPP
PER UPDATED ARCH

tri pointe
HOMES

FRAMING DETAILS
5920-04 MODEL
SERENITY
MASTER SET
RALEIGH, NC

sheet:
SD2.1