



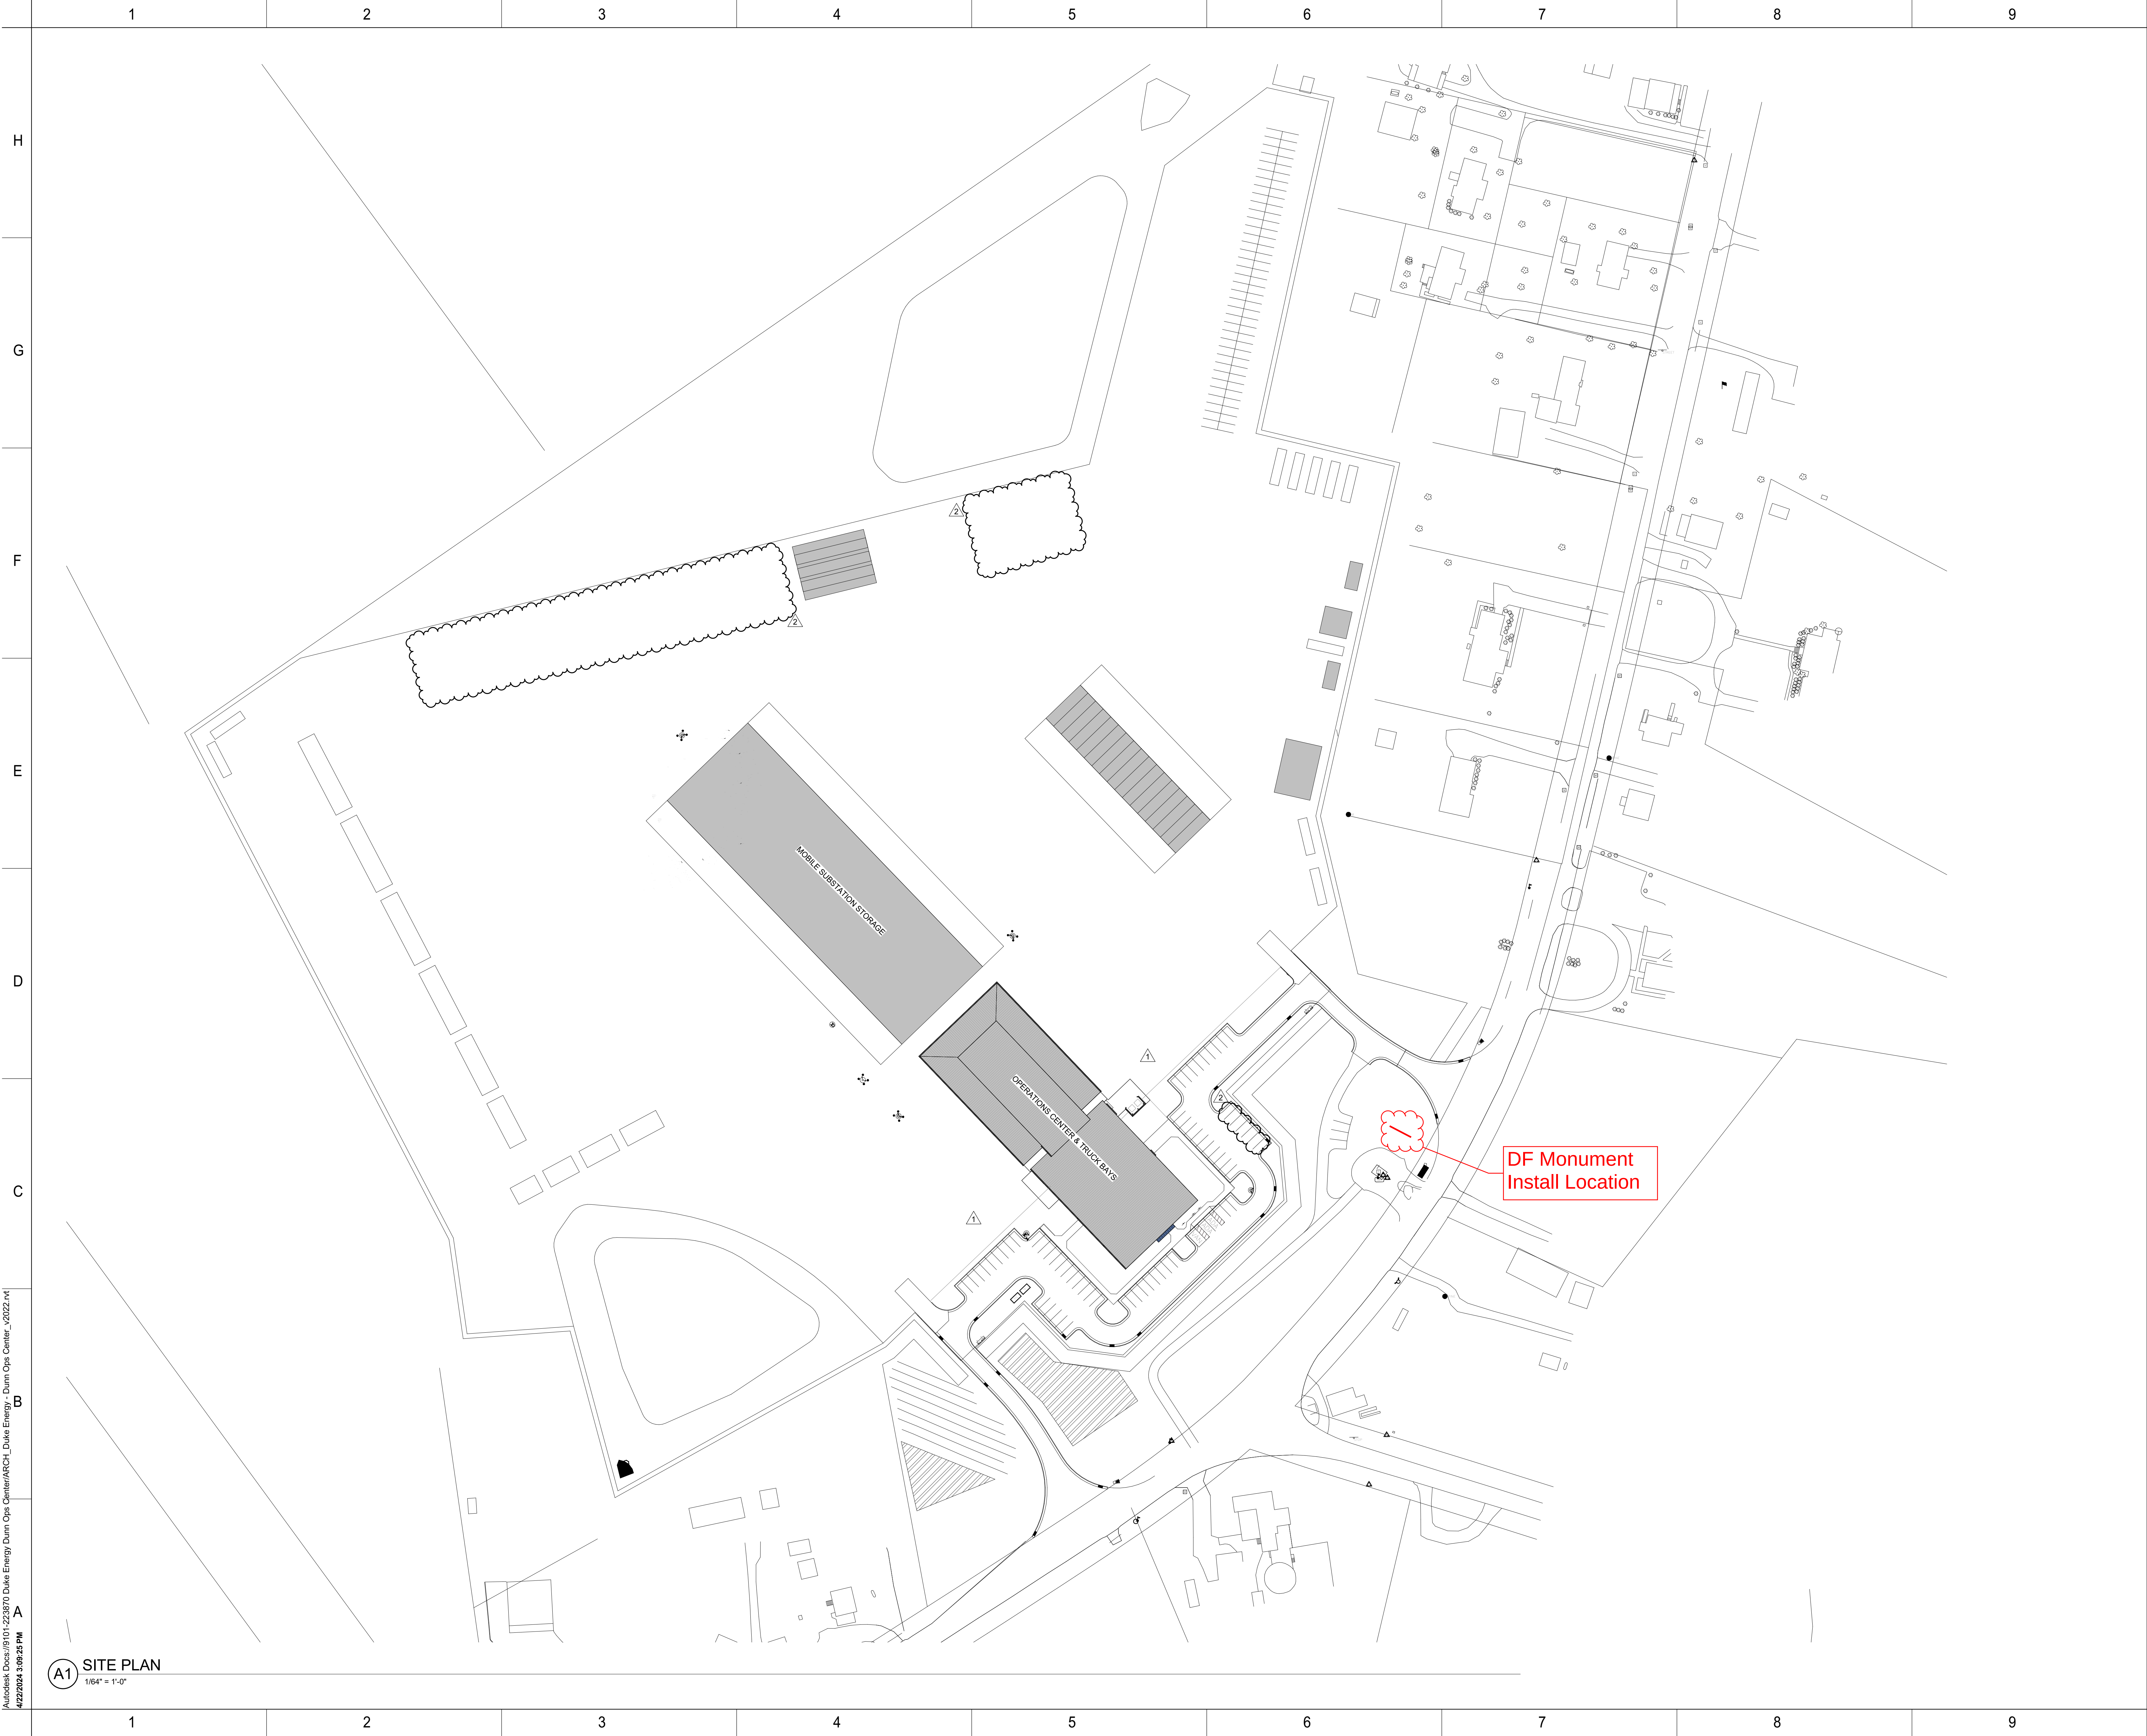

Autodesk Docs\\9101-223870 Duke Energy\\Dunn Ops Center\\ARCH\\Dunn Ops Center_02022.rvt
4/22/2024 3:09:25 PM

DRAWING NO.
CFD-####-AS-0110-41CC2B

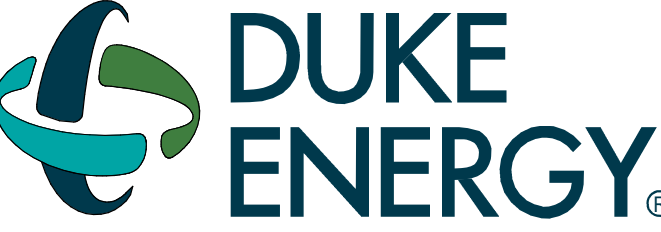

MAILING ADDRESS:
P.O. BOX 1007
CHARLOTTE, NC 28201

Safety Expectations:

ILLNESS
ZERO
INJURY
2022

Reduce Risk
Remove Exposures to Hazards
Reinforce Safe Behavior



LEAP ASSOCIATES P.C.
REGISTERED PROFESSIONAL ARCHITECT
CERT. NO. 60417
CHARLOTTE, NORTH CAROLINA

NORTH CAROLINA
REGISTERED ARCHITECT
ARCHITECT
LEAP ASSOCIATES P.C.
LEAP KINKADELL
CHARLOTTE, NORTH CAROLINA

SEAL05.24.2023

DUNN OPERATIONS
CENTER

1269 Jonesboro Rd.
Harnett County, NC 28334

OPERATIONS
BUILDING

MARK	DATE	DRN BY	REVISION	OWNER	VE	CLIENT	CHANGES	ISSUED FOR CONSTRUCTION
9								
8								
7								
6								
5								
4								
3	03.27.24							
2	09.22.23							
1	05.24.23							

PROJECT NO: 9101-223870

DRAWING NUMBER

CFD-####-AS-0110-41CC2B

ELECTRONIC FILE NAME:

DRAWN BY: Author

CHKD BY: CheckerDATE: 05.24.2023

E-MAIL: JOHNKINCHELOE@LS3P.COM

THIS DESIGN DRAWING IS THE EXCLUSIVE PROPERTY OF DUKE ENERGY CORPORATION AND IS CONSIDERED CONFIDENTIAL. IT SHALL NOT BE REPRODUCED, COPIED, OR DISTRIBUTED WITHOUT PRIOR APPROVAL. THIS INFORMATION SHOULD ONLY BE USED FOR THE SPECIFIC PROJECT INTENDED.

SHEET TITLE:

ARCHITECTURAL
SITE PLAN

SHEET NO.

A-001

ISSUED FOR CONSTRUCTION